



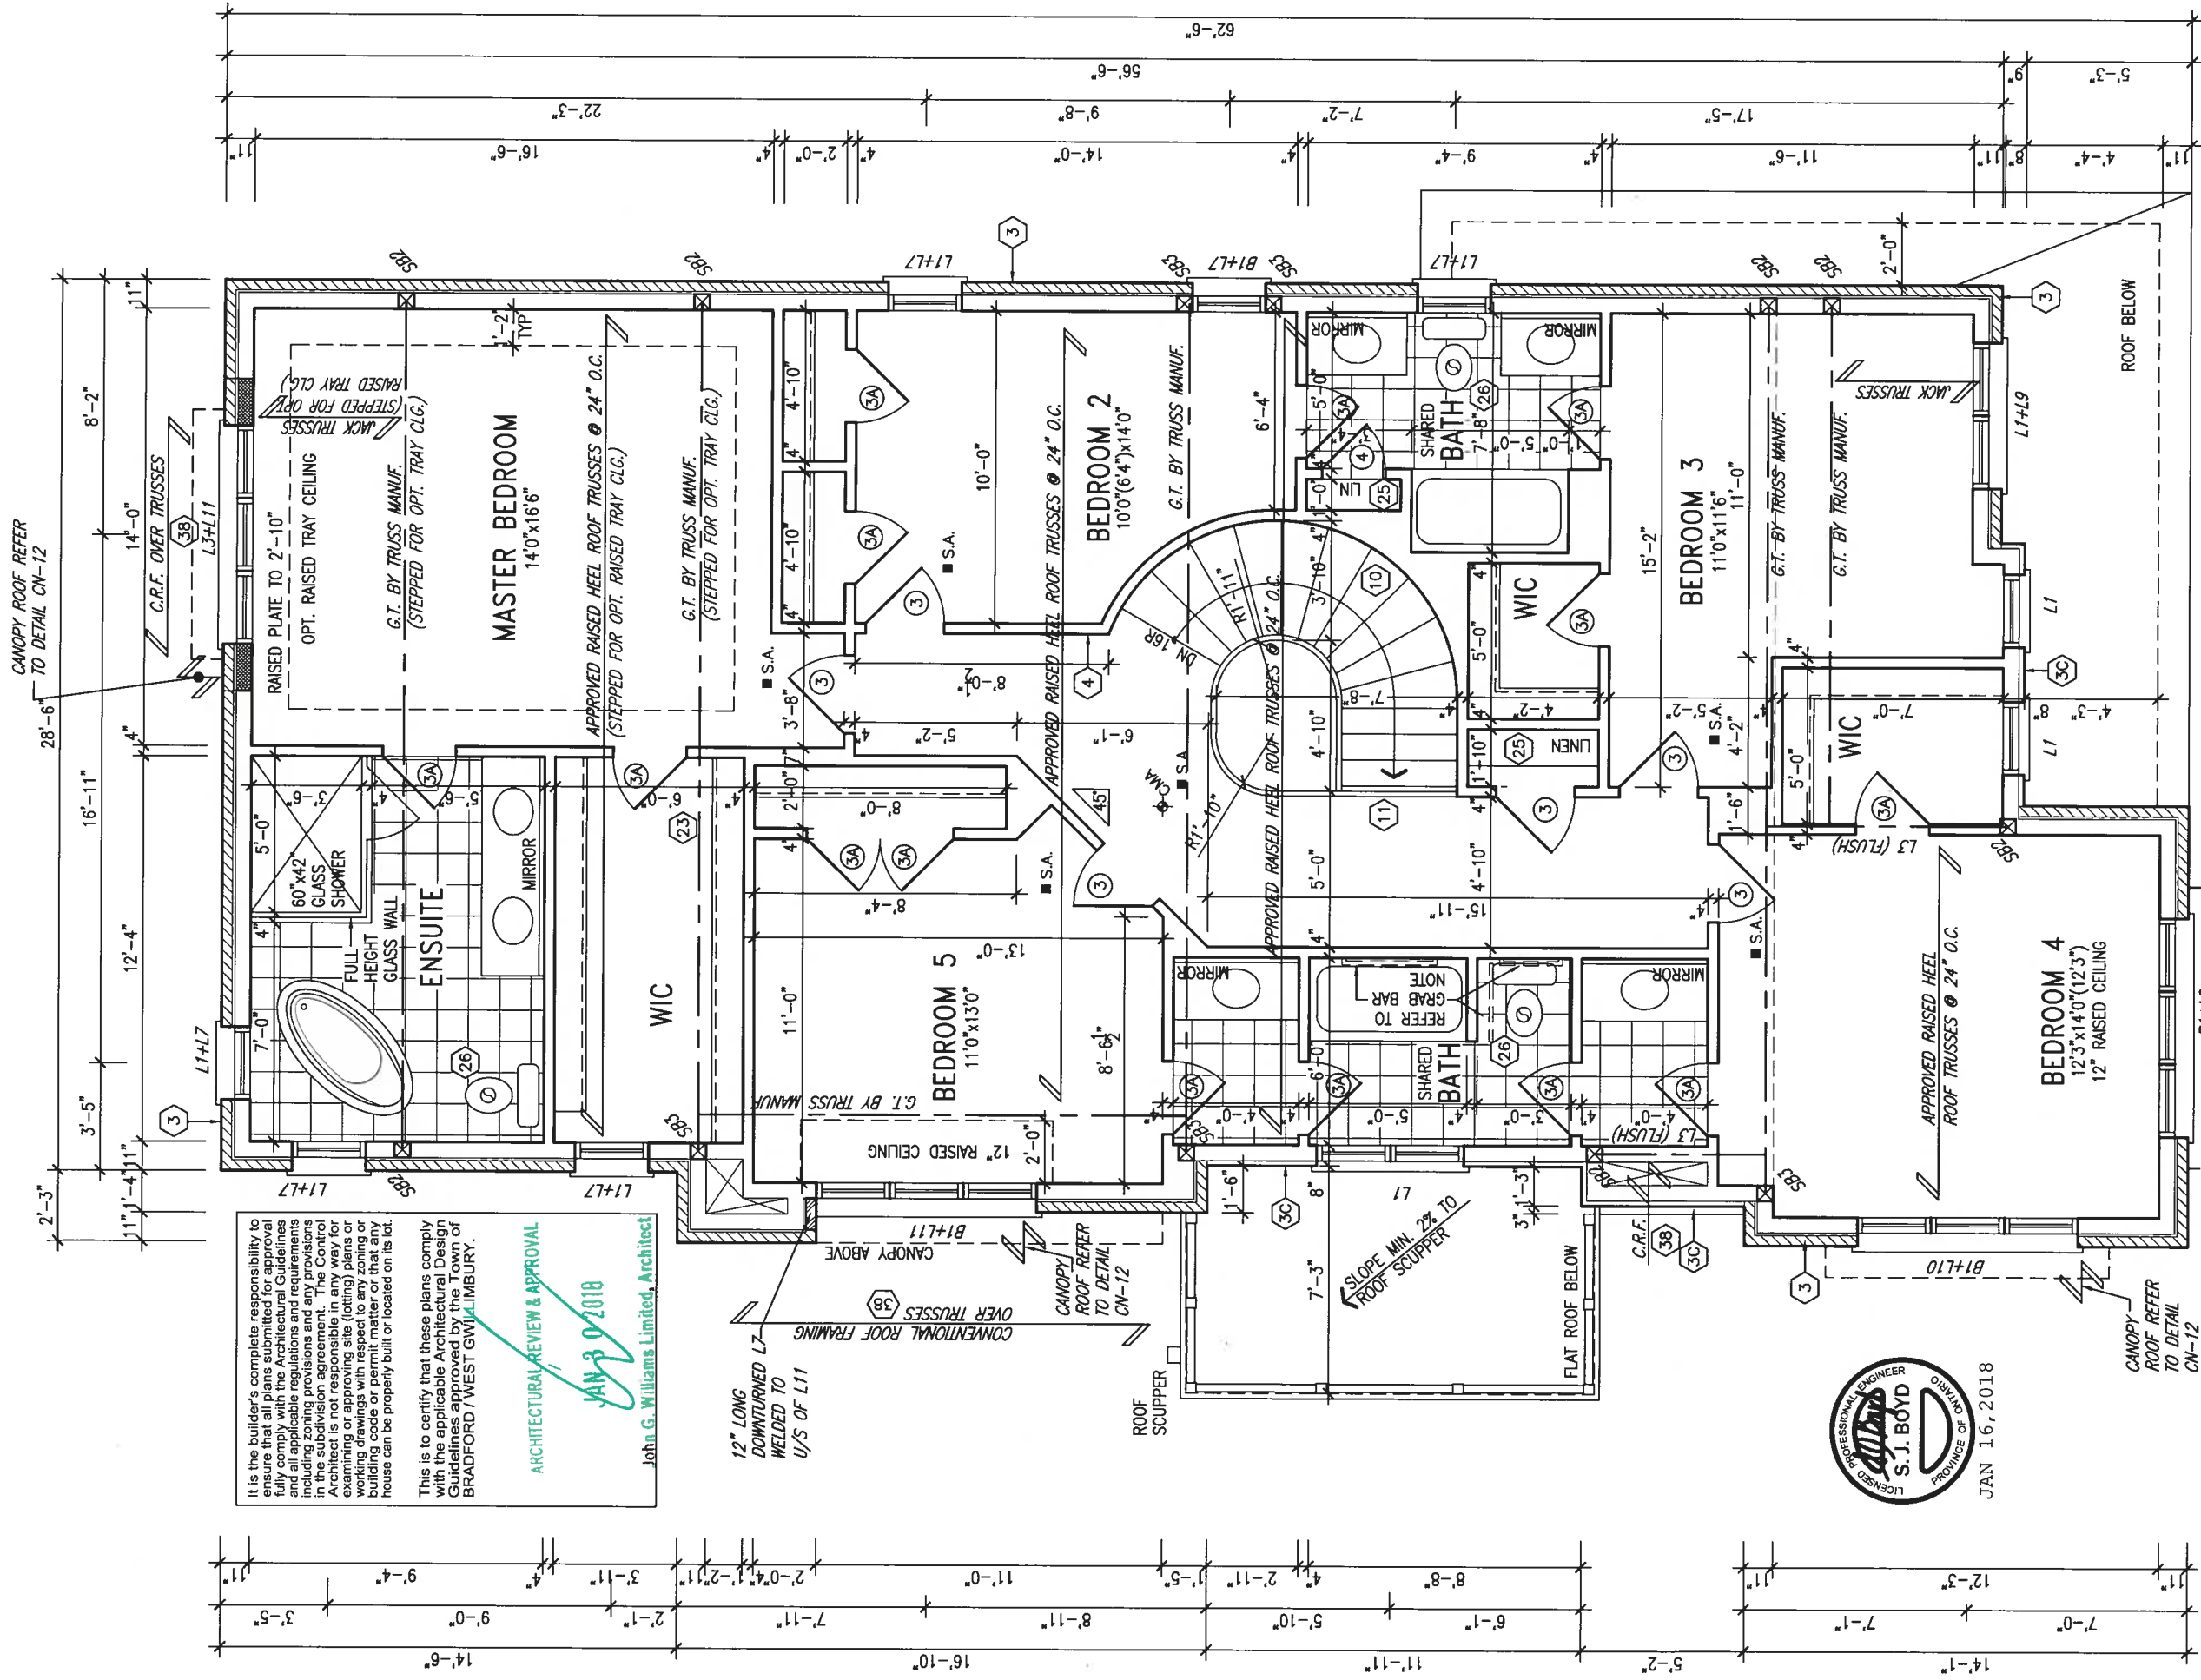

GB NOTE:
STUD WALL REINFORCEMENT FOR FUTURE GRAB BARS IN MAIN BATHROOM
REINFORCEMENT OF STUD WALLS SHALL BE INSTALLED ADJACENT TO WATER CLOSETS AND SHOWER OR BATHTUB IN MAIN BATHROOM. REFER TO OBC, 9.5.2.3, 3.8.3.8.(1)(d) & 3.8.3.13.(1)(f), AND DETAILS PROVIDED

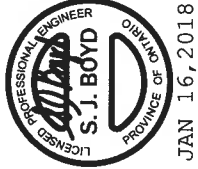

It is the builder's complete responsibility to ensure that all plans submitted for approval fully comply with the Architectural Guidelines including zoning regulations and requirements in the subdivision agreement. The Control Architect is not responsible in any way for examining or approving site (lotting) plans or working drawings with respect to any zoning or building code or permit matter or that any house can be properly built or located on its lot.


This is to certify that these plans comply with the applicable Architectural Design Guidelines approved by the Town of BRADFORD / WEST GUILDFORD.

ARCHITECTURAL REVIEW & APPROVAL
JAN 30 2018
John G. Williams Limited, Architect

OPT. SECOND FLOOR PLAN 'C'

no. description		date	by
2	REVISED AS PER ENG'S COMMENTS	JAN 12-18 RC	
1	ISSUED FOR CLIENT REVIEW		
The undersigned has reviewed and takes responsibility for this design and has the qualifications and meets the requirements set out in the Ontario Building Code to be a Designer.			
qualification information			
6	Wellington Jno-Baptiste	25591	
5	name	registration information	BCN
4	VA3 Design Inc.	42658	
Contractor must verify all dimensions on the job and report any discrepancy to the Designer before proceeding with the work. All drawings and specifications are instruments of service and the property of the Designer which must be returned at the completion of the work. Drawings are not to be scaled.			
project name		project no.	drawing no.
GREEN VALLEY EAST		16023	4C
municipality		BRADFORD, ONT.	
file name		16023-S38-8C	
scale		3/16" = 1'-0"	
checked by		RC	
drawn by		WT	
date		JANUARY, 2017	
project no.		S38-8C	
drawing no.		BAROSSA 8	

1-MAIN ENTRY DOOR & BASEMENT WINDOW EXCLUDED FROM SB-12 CALCULATIONS PER SB-12 3.1.1.6.(4).

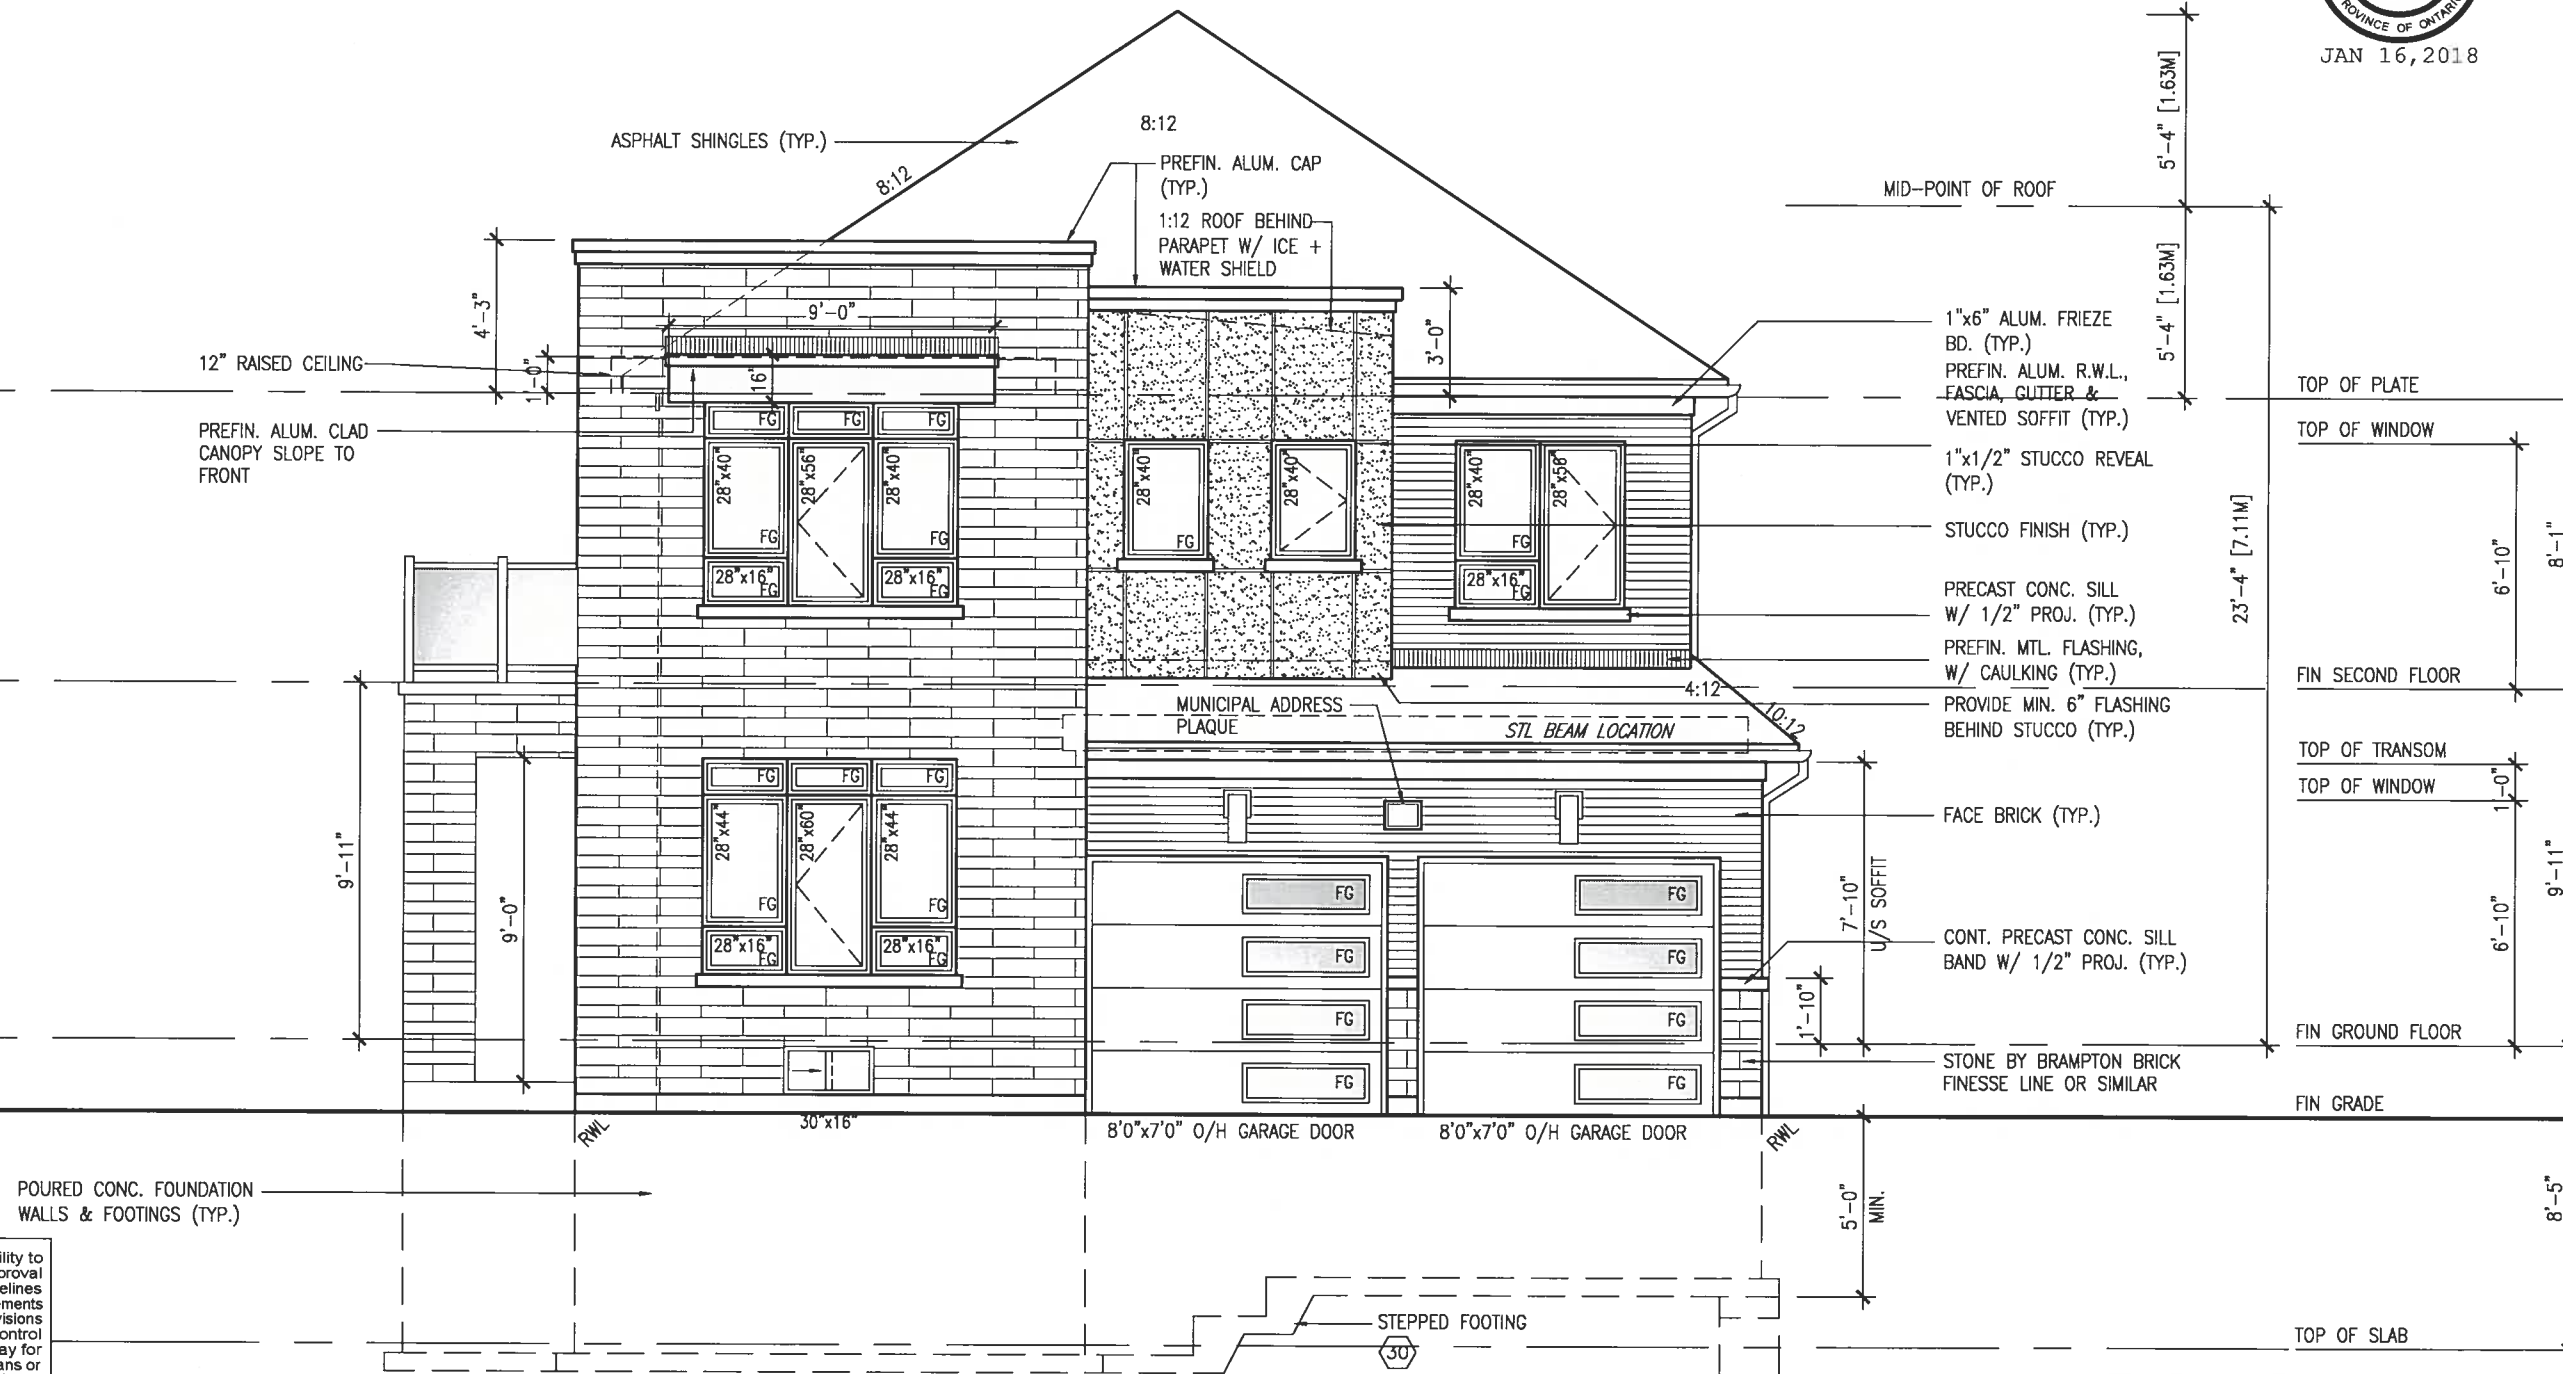

It is the builder's complete responsibility to ensure that all plans submitted for approval fully comply with the Architectural Guidelines and all applicable regulations and requirements including zoning provisions and any provisions in the subdivision agreement. The Control Architect is not responsible in any way for examining or approving site (lotting) plans or working drawings with respect to any zoning or building code or permit matter or that any house can be properly built or located on its lot.

This is to certify that these plans comply with the applicable Architectural Design Guidelines approved by the Town of BRADFORD / WEST GUILMBURY.

ARCHITECTURAL REVIEW & APPROVAL

JAN 30 2018

John G. Williams Limited, Architect

FRONT ELEVATION 'C'

ELECTRIC VEHICLE CHARGING SYSTEM (EVCS)
ROUGH-IN FOR FUTURE ELECTRIC VEHICLE SUPPLY EQUIPMENT (CHARGING SYSTEM) TO BE INSTALLED.
ROUGH-IN SHALL INCLUDE:
• A minimum 200 amp Panelboard,
• Conduit that is not less than 1 1/16" (27mm) trade size,
• A square 4 11/16" (119mm) trade size electrical outlet box.
• Flameproofed Electrical outlet box to be installed in the Garage or carport or adjacent to driveway.
REFER TO 2012 OBC. 9.34.4.

BAYVIEW WELLINGTON		S38-8C BAROSSA 8	
project name GREEN VALLEY EAST		municipality BRADFORD, ONT.	
project no. 16023		drawing no. 5C	
date JANUARY, 2017		checked by RC	
drawn by WT		scale 3/16" = 1'-0"	
file name 16023-S38-8C		front elevation 'C'	
RICHARD - H:\ARCHIVE\WORKING\2016\16023.BW Units\38\16023-S38-8C.dwg - Tue - Jan 16 2018 - 12:07 PM			
All drawings specifications, related documents and design are the copyright property of VA3 DESIGN. Reproduction of this property in whole or in part is strictly prohibited without VA3 DESIGN's written permission.			

VA3 DESIGN
255 Consumers Rd Suite 120
Toronto ON M2J 1R4
t 416.630.2255 f 416.630.4782
va3design.com

no.	description	date	by
9			
8			
7			
6			
5			
4			
3			
2	REVISED AS PER ENG'S COMMENTS	JAN 12-18	RC
1	ISSUED FOR CLIENT REVIEW		

REFER TO FRONT ELEVATION FOR
TYPICAL NOTES.

It is the builder's complete responsibility to ensure that all plans submitted for approval fully comply with the Architectural Guidelines and all applicable regulations and requirements including zoning provisions and any provisions in the subdivision agreement. The Control Architect is not responsible in any way for examining or approving site (lotting) plans or working drawings with respect to any zoning or building code or permit matter or that any house can be properly built or located on its lot.

This is to certify that these plans comply with the applicable Architectural Design Guidelines approved by the Town of BRADFORD / WEST GWILLIMBURY.

ARCHITECTURAL REVIEW & APPROVAL

JAN 30 2018

John G. Williams Limited, Architect

S38-8C
BAROSSA 8

BAYVIEW WELLINGTON

project name	project no.
GREEN VALLEY EAST	16023
municipality	
BRADFORD, ONT.	
date	drawing no.
11/11/2017	16023



255 Consumers Rd Suite 120
Toronto ON M2J 1R4
t 416.630.2255 f 416.630.4782
va3design.com


qualification information Wellington Jno-Baptiste		25591
name	signature	BCIN
registration information MA3 Design Inc.		42658

Contractor must verify all dimensions on the job and report any discrepancy to the Designer before proceeding with the work. All drawings and specifications are instruments of service and the property of the Designer which must be returned at the completion of the work. Drawings are not to be scaled.

8	*	*
7		
6	*	*
5	*	*
4	*	*
3	*	*

2	REVISED AS PER ENG'S COMMENTS	JAN 12-18	RC
1	ISSUED FOR CLIENT REVIEW	.	.
no.	description	date	by

All drawings specifications, related documents and design are the copyright property of VAZ DESIGN. Reproduction of this property in whole or in part is strictly prohibited without VAZ DESIGN's written permission.

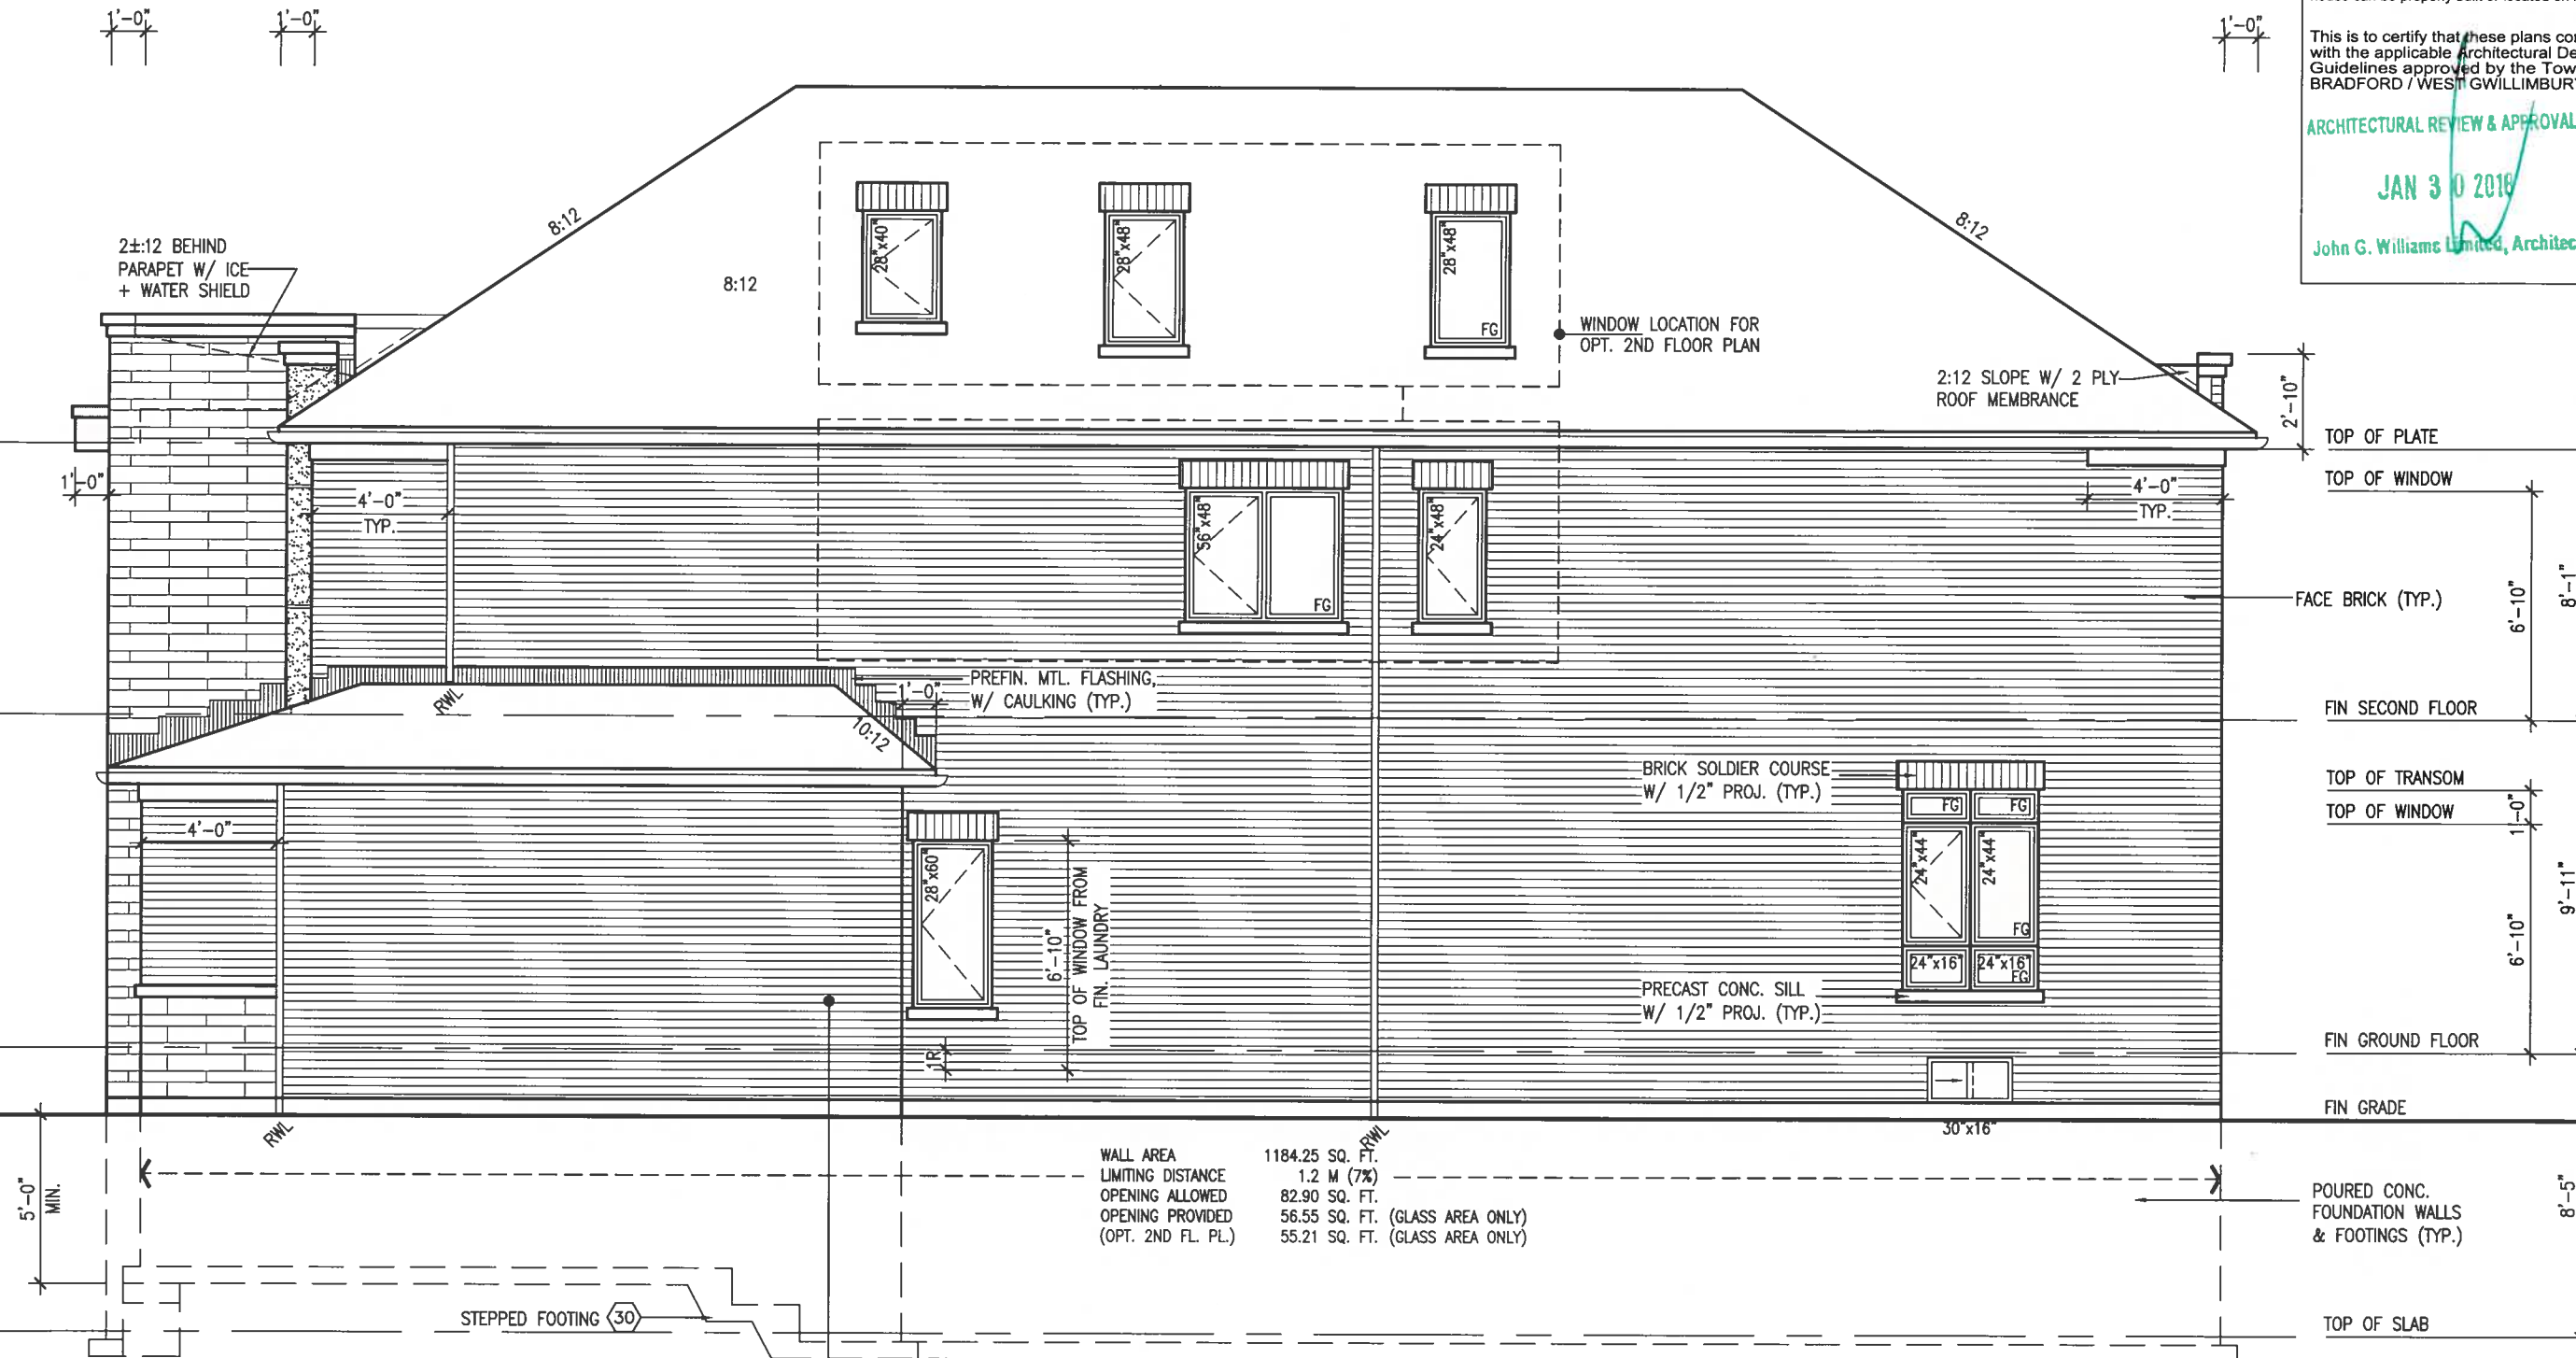

RIGHT SIDE ELEVATION 'C'

BRICK VENEER CONSTRUCTION

(FOR WALLS LESS THAN 1.2M (3'-11") FROM THE LOT LINE)

45 MINUTE FIRE RATED WALL


PROVIDE A CONTINUOUS LAYER OF 12.7mm (1/2") TYPE 'X' GYPSUM BOARD (INTERIOR SIDE) INSTALLED SO THAT ALL EDGES ARE SUPPORTED, TAPED AND FILLED. SPACE BETWEEN WOOD STUDS TO BE FILLED WITH INSULATION CONFORMING TO CAN/ULC-S702, "MINERAL FIBRE THERMAL INSULATION FOR BUILDINGS" WITH A MASS OF NOT LESS THAN 1.22 Kg/SQ.M. AND MUST FILL AT LEAST 90% OF THE CAVITY THICKNESS. THE TYPE 'X' & INSULATION MUST BE RUN CONTINUOUSLY BEHIND ALL INTERSECTING PARTITIONS, MECHANICAL CHASES, BATHTUBS, SHOWERS, ETC. ENSURE INSULATION & TYPE 'X' IS INSTALLED IN GARAGE EXTERIOR WALLS.

(REFER TO SECTION SB-2 OF OBC 2012-SUPPLEMENTARY STANDARDS)



JAN 16, 2018

REFER TO FRONT ELEVATION FOR
TYPICAL NOTES.

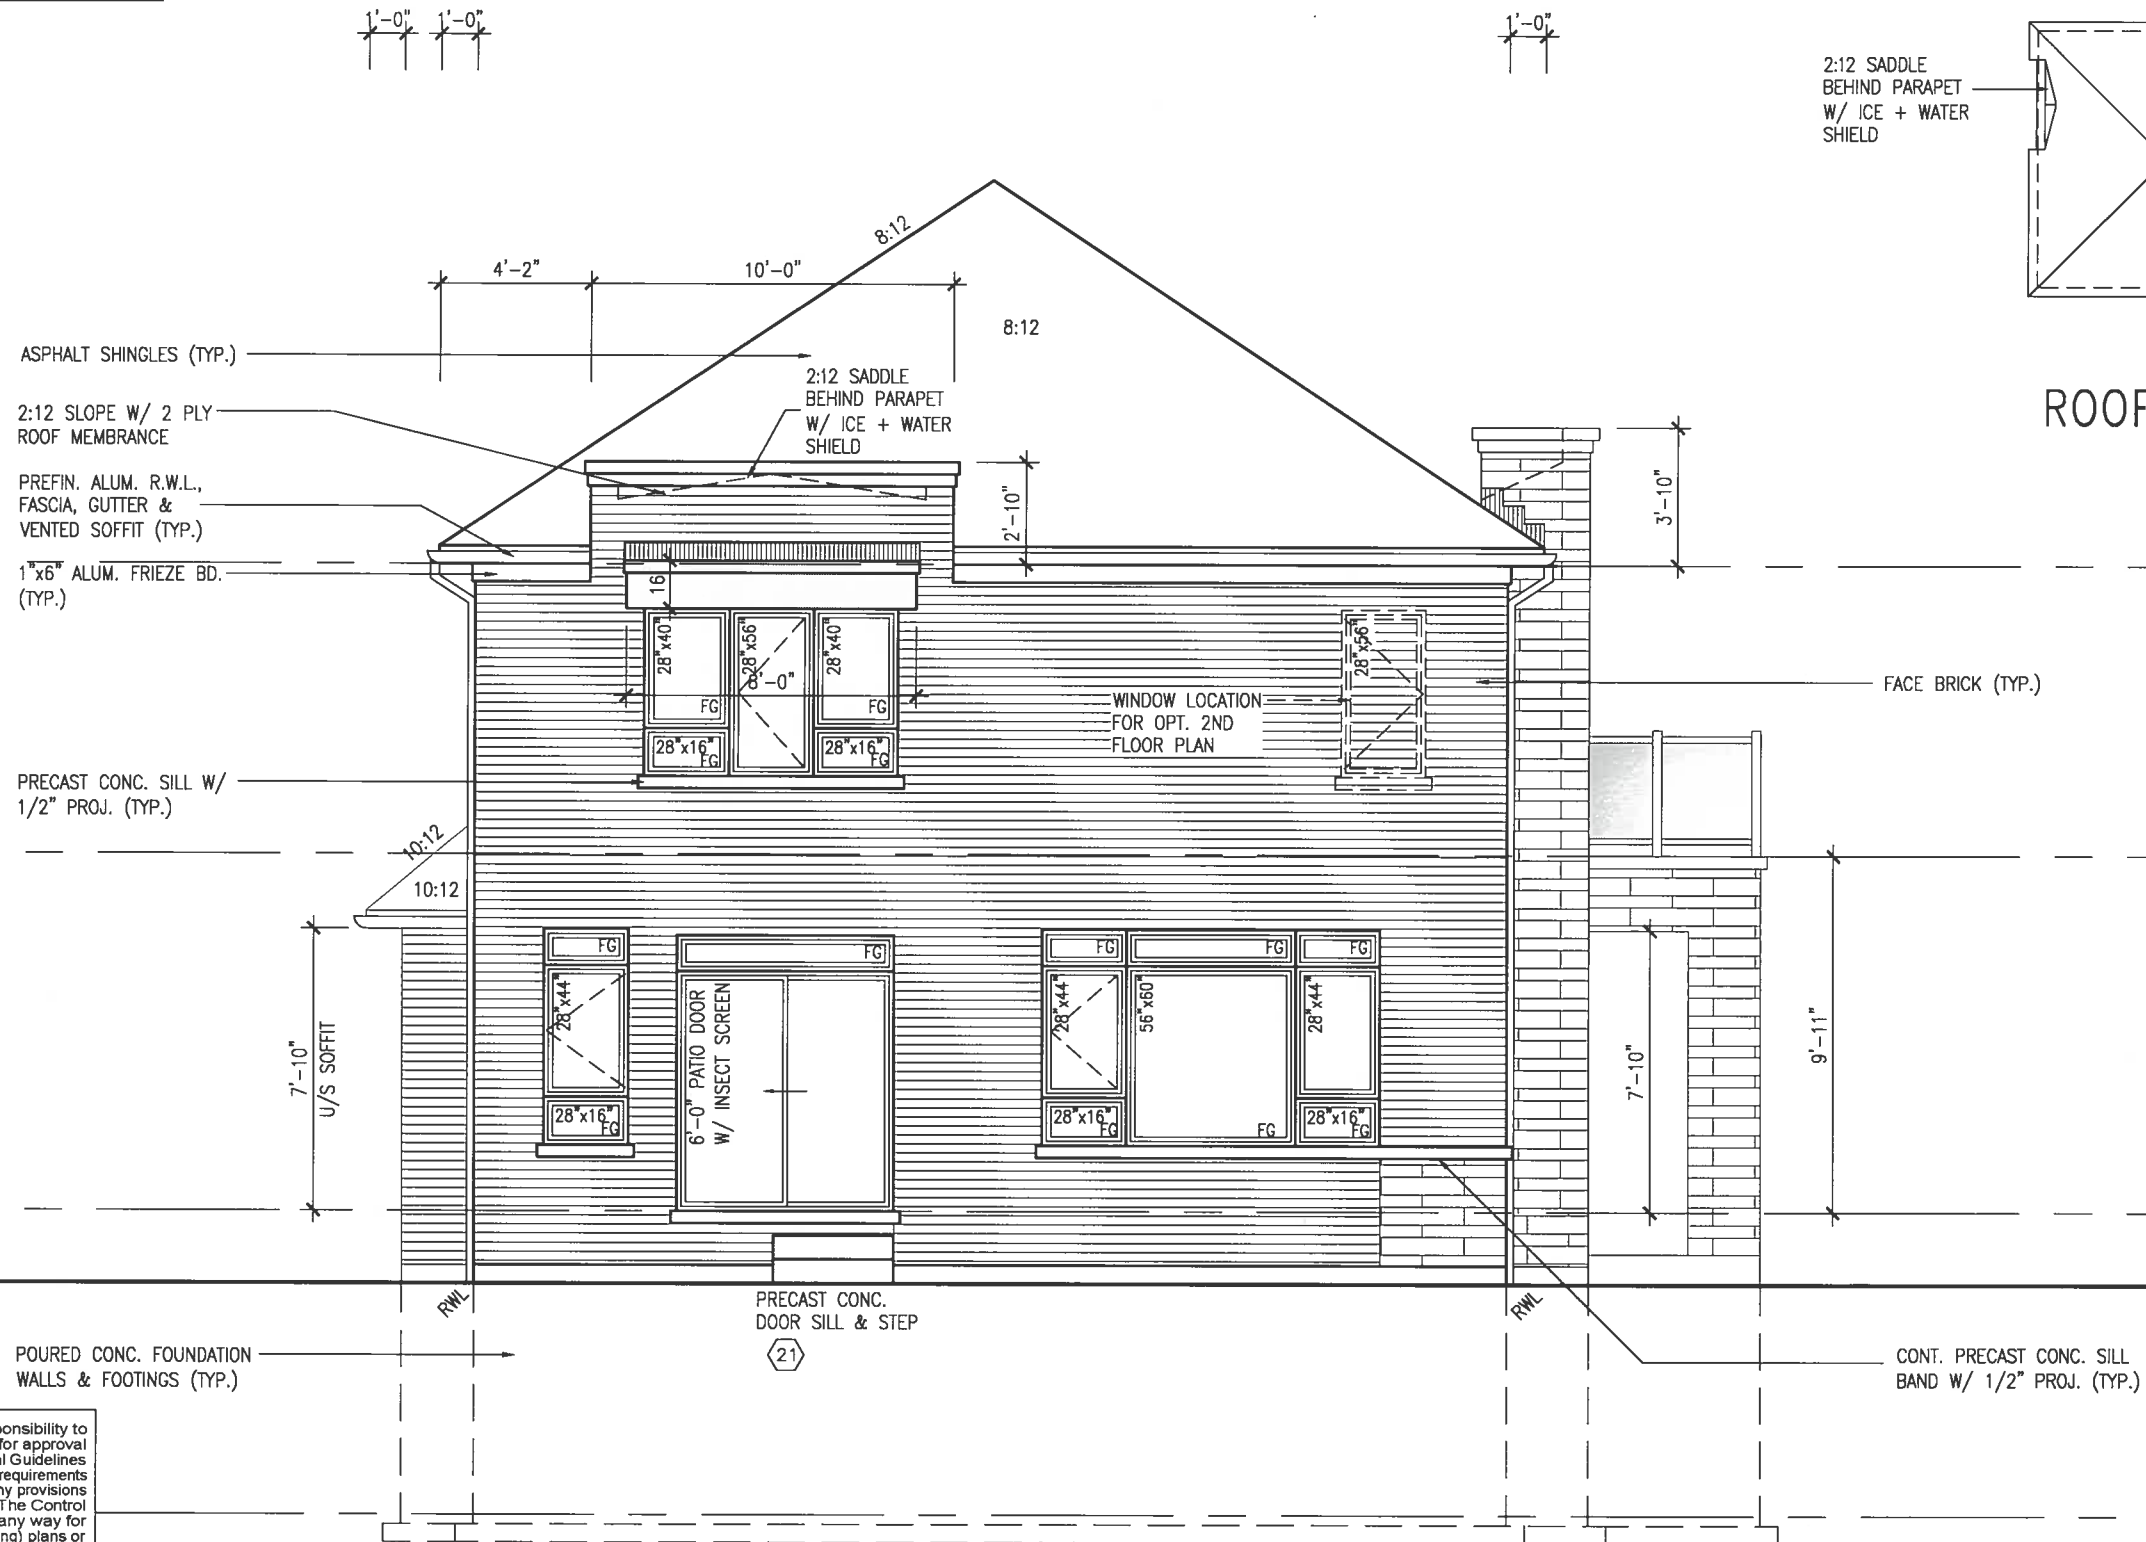

REAR ELEVATION 'C'

It is the builder's complete responsibility to ensure that all plans submitted for approval fully comply with the Architectural Guidelines and all applicable regulations and requirements including zoning provisions and any provisions in the subdivision agreement. The Control Architect is not responsible in any way for examining or approving site (lotting) plans or working drawings with respect to any zoning or building code or permit matter or that any house can be properly built or located on its lot.

This is to certify that these plans comply with the applicable Architectural Design Guidelines approved by the Town of BRADFORD/WEST GUILDFORD.

ARCHITECTURAL REVIEW & APPROVAL

JAN 30 2018

John G. Williams Limited, Architect



JAN 16, 2018

ROOF PLAN ELEVATION 'C'

BAYVIEW WELLINGTON

S38-8C
BAROSSA 8

project name
GREEN VALLEY EAST

municipality
BRADFORD, ONT.

project no.
16023

date
JANUARY, 2017

checked by
RC

scale
3/16" = 1'-0"

drawing no.
8C

drawn by
WT

checked by
RC

scale
3/16" = 1'-0"

drawing no.
8C

drawn by
WT

checked by
RC

scale
3/16" = 1'-0"

drawing no.
8C



255 Consumers Rd Suite 120
Toronto ON M2J 1R4
t 416.630.2255 f 416.630.4782
va3design.com

The undersigned has reviewed and takes responsibility for this design and has the qualifications and meets the requirements set out in the Ontario Building Code to be a Designer.


Wellington Jno-Baptiste
signature
25591
BCN
42658
name
registration information
VA3 Design Inc.

Contractor must verify all dimensions on the job and report any discrepancy to the Designer before proceeding with the work. All drawings and specifications are instruments of service and the property of the Designer. They must be returned at the completion of the work. Drawings are not to be scaled.


no.	description	date	by
9			
8			
7			
6			
5			
4			
3			
2	REVISED AS PER ENG'S COMMENTS	JAN 12-18 RC	
1	ISSUED FOR CLIENT REVIEW		

UNINSULATED OPENINGS (PER OBC. SB-12,3.1.1(7))			
S38-8C ELEVATION C	ENERGY EFFICIENCY - OBC SB12		
ELEVATION	WALL AREA S.F.	OPENING S.F.	PERCENTAGE
FRONT	617 S.F.	145.50 S.F.	23.58 %
LEFT SIDE	1250 S.F.	275.80 S.F.	22.06 %
RIGHT SIDE	1250 S.F.	62.33 S.F.	4.99 %
REAR	615 S.F.	148.66 S.F.	24.17 %
* OPENINGS OMITTED AS PER SB-12 3.1.1.9(4) MAX 19.9 S.F. REFER TO ELEVATION FOR LOCATION		0.00 S.F.	
TOTAL SQ. FT.	3732.00 S.F.	632.29 S.F.	16.94 %
TOTAL SQ. M.	346.71 S.M.	58.74 S.M.	16.94 %

UNINSULATED OPENINGS (PER OBC. SB-12,3.1.1(7))			
S38-8C ELEV. C OPT. PLAN	ENERGY EFFICIENCY - OBC SB12		
ELEVATION	WALL AREA S.F.	OPENING S.F.	PERCENTAGE
FRONT	617 S.F.	145.50 S.F.	23.58 %
LEFT SIDE	1250 S.F.	257.30 S.F.	20.58 %
RIGHT SIDE	1250 S.F.	62.11 S.F.	4.97 %
REAR	615 S.F.	159.55 S.F.	25.94 %
* OPENINGS OMITTED AS PER SB-12 3.1.1.9(4) MAX 19.9 S.F. REFER TO ELEVATION FOR LOCATION		0.00 S.F.	
TOTAL SQ. FT.	3732.00 S.F.	624.46 S.F.	16.73 %
TOTAL SQ. M.	346.71 S.M.	58.01 S.M.	16.73 %

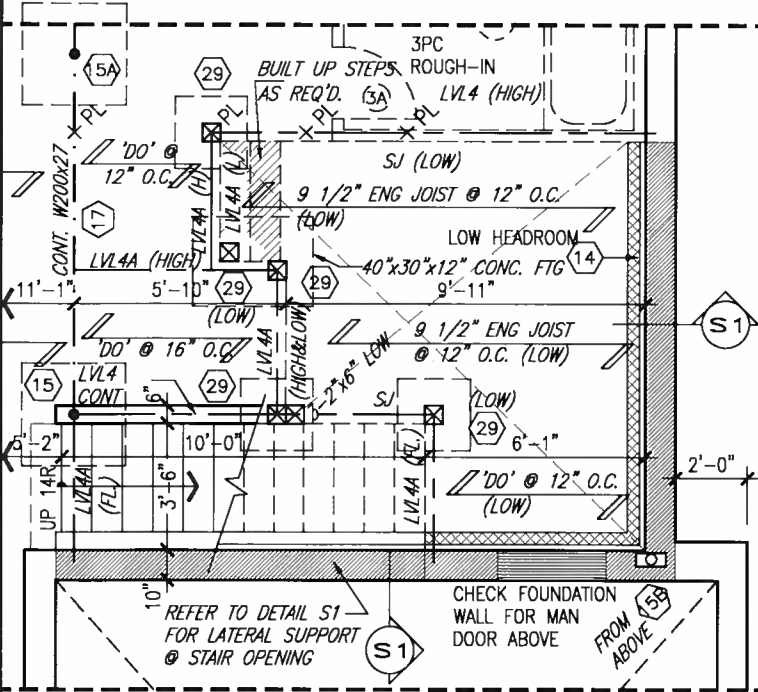

PART. BASEMENT PLAN
W/ SUNKEN LAUNDRY
(-2R TO -3R COND.)

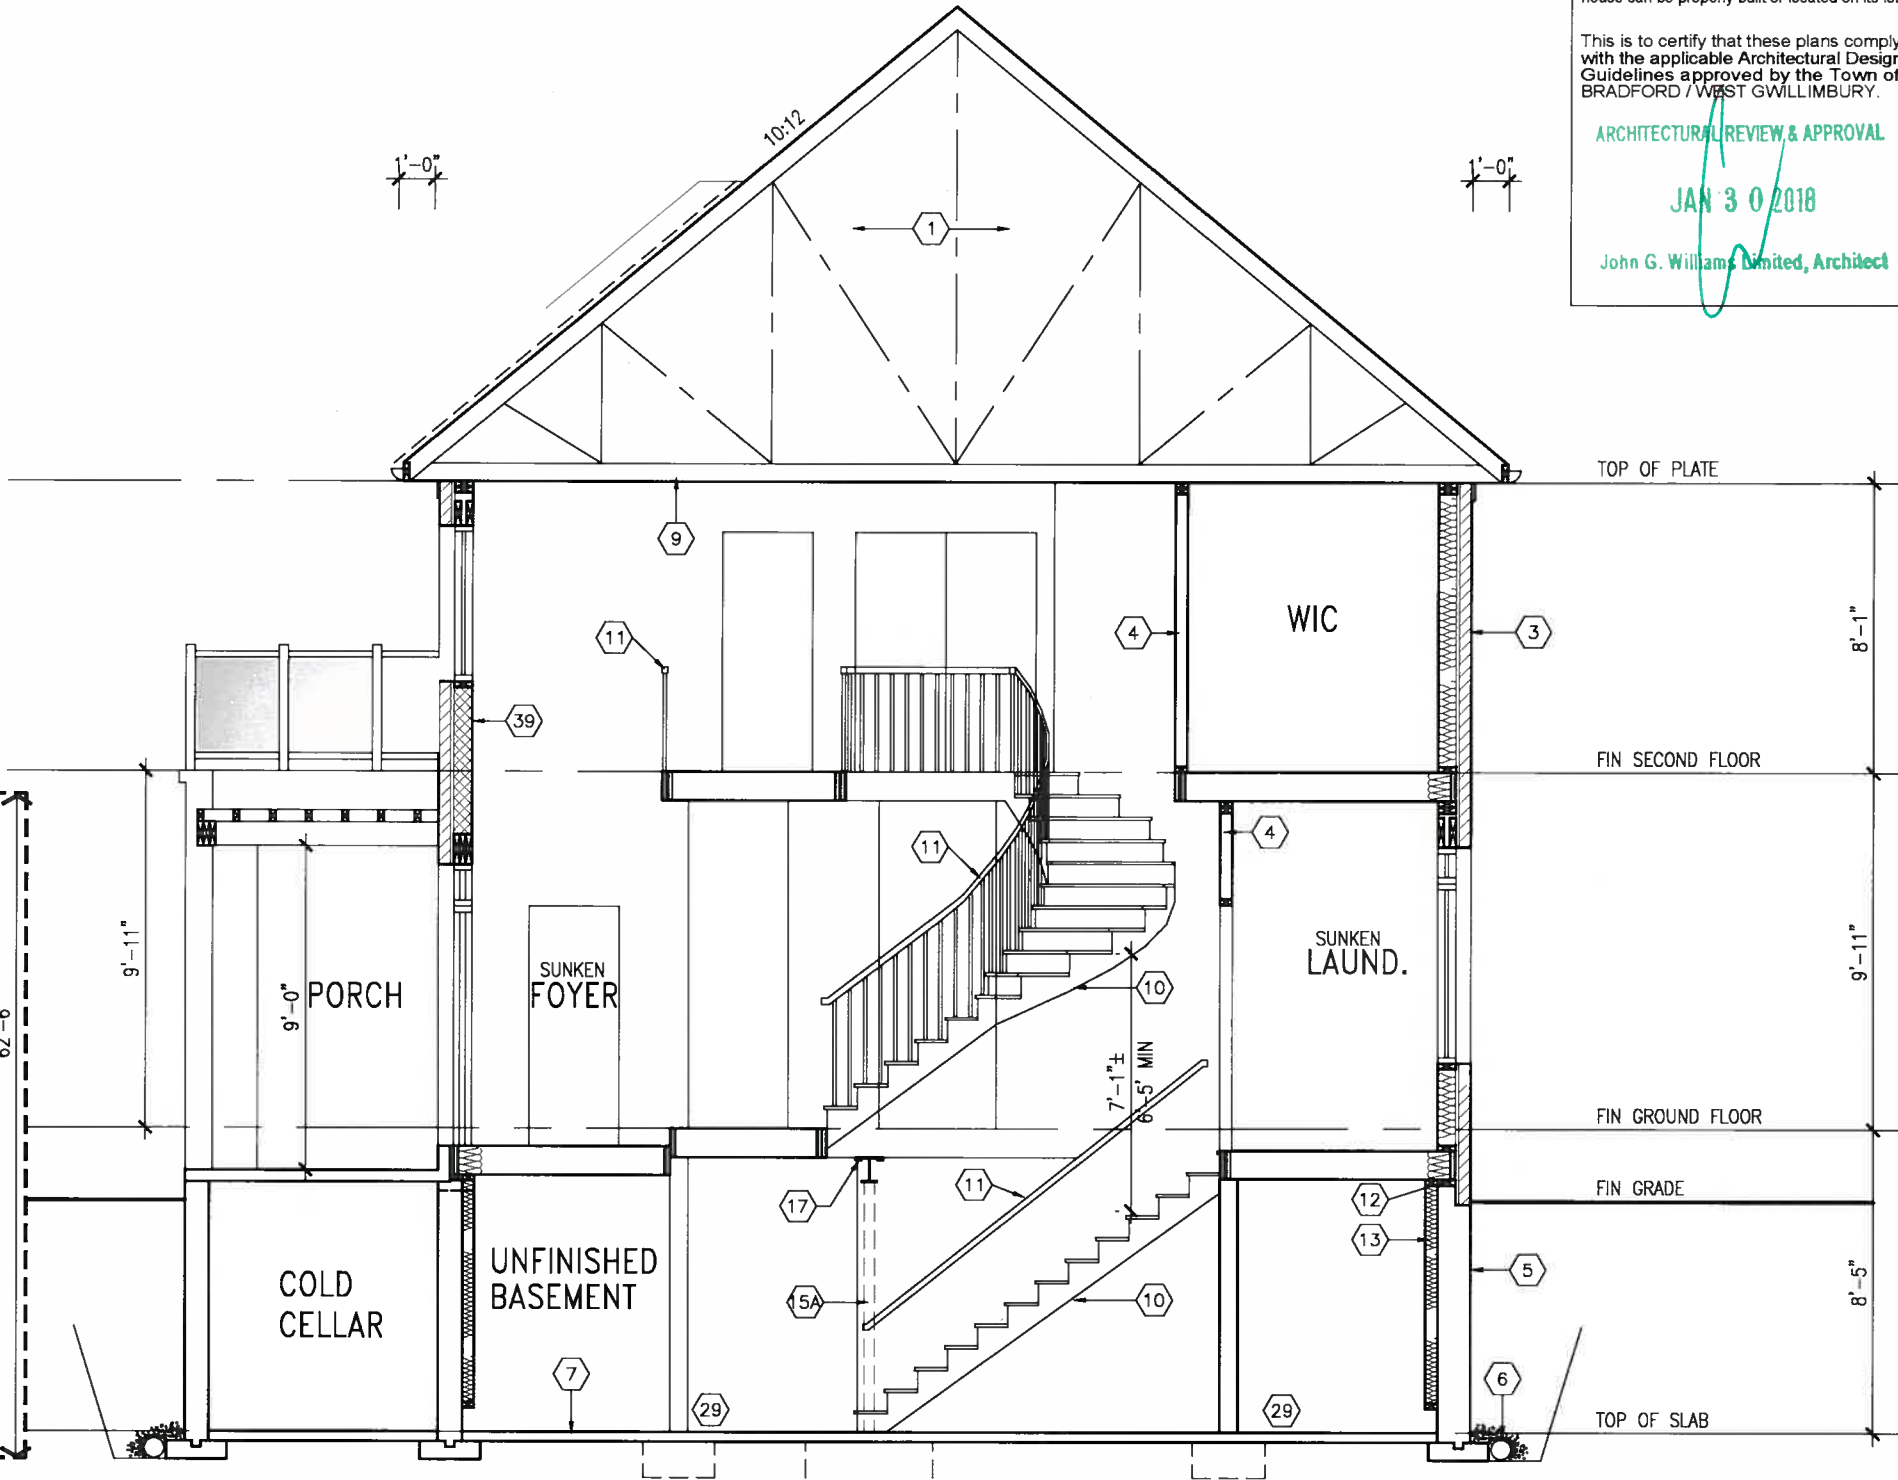

CROSS SECTION 'A-A'

It is the builder's complete responsibility to ensure that all plans submitted for approval fully comply with the Architectural Guidelines and all applicable regulations and requirements including zoning provisions and any provisions in the subdivision agreement. The Control Architect is not responsible in any way for examining or approving site (lotting) plans or working drawings with respect to any zoning or building code or permit matter or that any house can be properly built or located on its lot.

This is to certify that these plans comply with the applicable Architectural Design Guidelines approved by the Town of BRADFORD / WEST GWILLIMBURY.

ARCHITECTURAL REVIEW & APPROVAL
JAN 30 2018
John G. Williams Limited, Architect

S38-8C

BAROSSA 8

BAYVIEW WELLINGTON

GREEN VALLEY EAST

BRADFORD, ONT.

CROSS SECTION A-A

project no. 16023

drawing no. 9C

checked by RC

scale 3/16" = 1'-0"

drawn by WT

date JANUARY, 2017

checked by RC

drawn by WT

project name

file name

checked by

scale

drawn by

date

VA3 DESIGN

255 Consumers Rd Suite 120

Toronto ON M2J 1R4

t 416.630.2255 f 416.630.4782

va3design.com

The undersigned has reviewed and takes responsibility for this design and has the qualifications and meets the requirements set out in the Ontario Building Code to be a Designer.

qualification information

Wellington Jno-Baptiste

25591

BCN

42558

name

registration information

VA3 Design Inc.

Contractor must verify all dimensions on the job and report any discrepancy to the Designer before proceeding with the work. All drawings and specifications are instruments of service and the property of the Designer, which must be returned at the completion of the work. Drawings are not to be used.

no. 9

8

7

6

5

4

3

2

1

no. description

date

by

12-18

JAN 12-18

RC

REVISED AS PER ENG'S COMMENTS

ISSUED FOR CLIENT REVIEW

Professional Engineer Seal for S. J. Boyd, Province of Ontario. The seal is circular with 'PROVINCE OF ONTARIO' around the bottom and 'S. J. BOYD' in the center. The text 'LICENSED PROFESSIONAL ENGINEER' is around the top.

JAN 16, 2018

TO TELL PLANS FOR
TYPICAL NOTES.


It is the builder's complete responsibility to ensure that all plans submitted for approval fully comply with the Architectural Guidelines and all applicable regulations and requirements including zoning provisions and any provisions in the subdivision agreement. The Control Architect is not responsible in any way for examining or approving site (lotting) plans or working drawings with respect to any zoning or building code or permit matter or that any house can be properly built or located on its lot.

This is to certify that these plans comply with the applicable Architectural Design Guidelines approved by the Town of BRADFORD / WEST GWILIMBURY.


ARCHITECTURAL REVIEW & APPROVAL

JAN 30 2018



John G. Williams, Architect

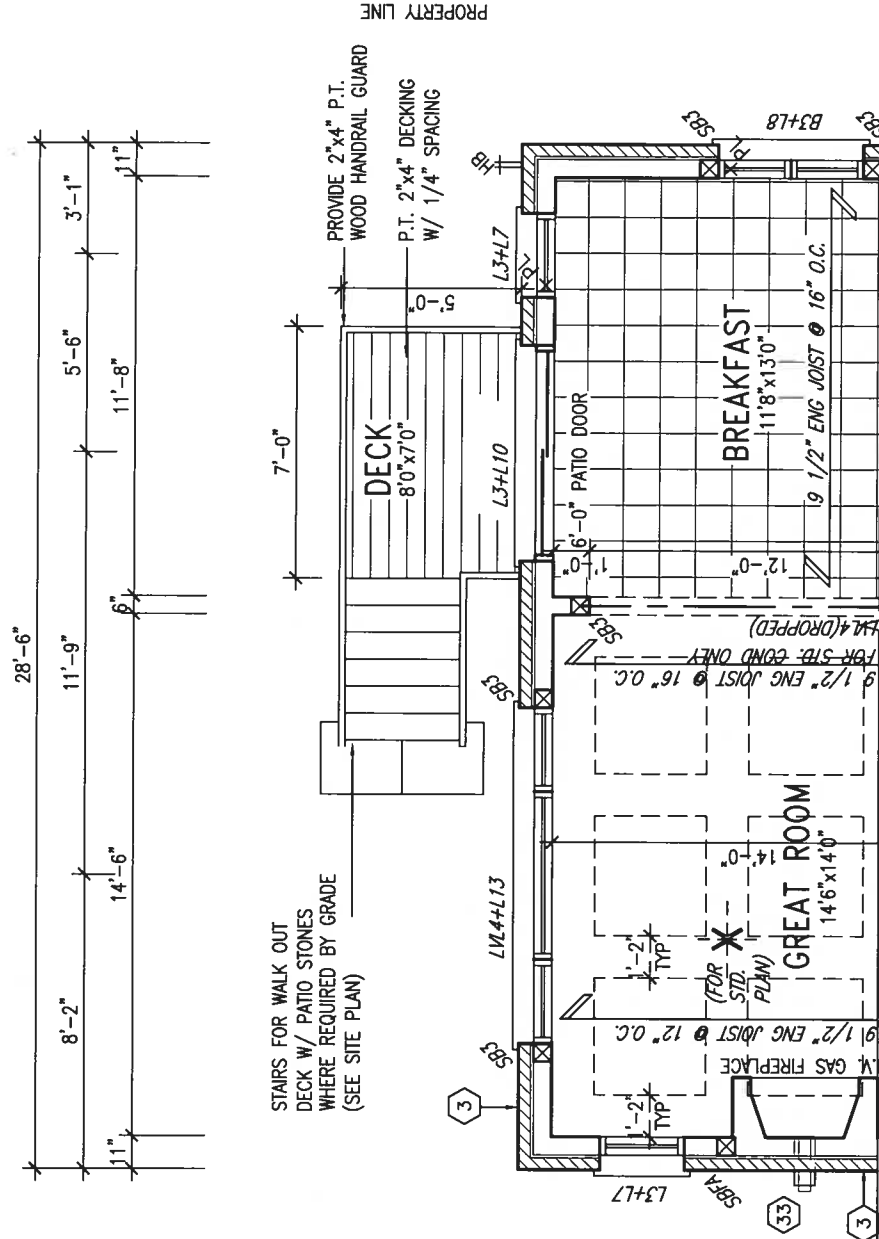

PART. GROUND FLOOR PLAN 'C' - W.O.D. CONDITION

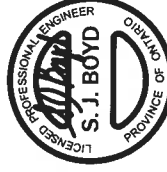

JAN 16, 2018

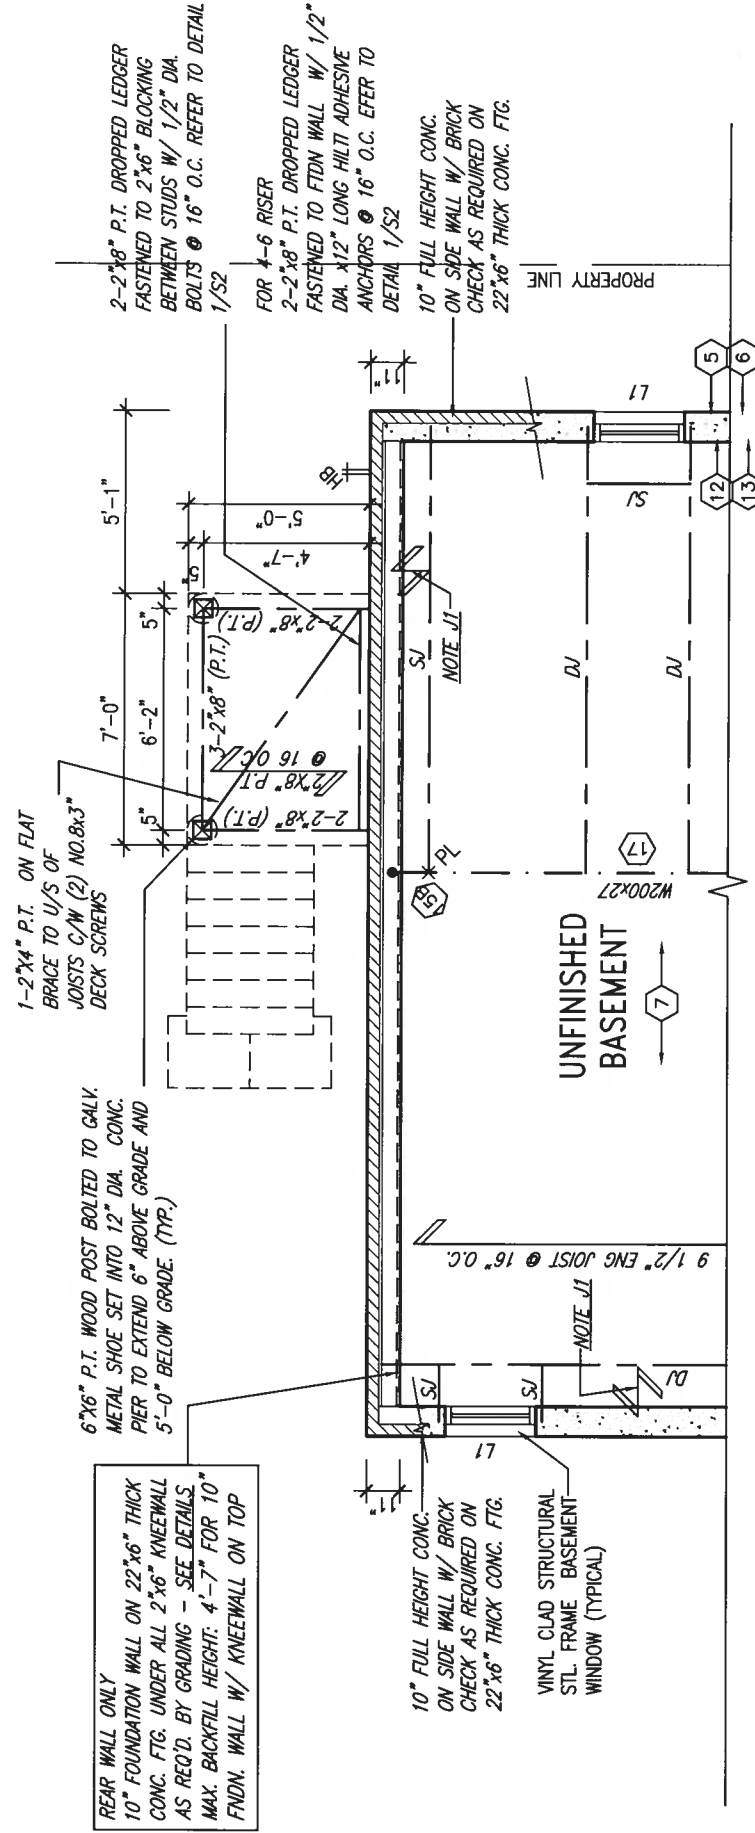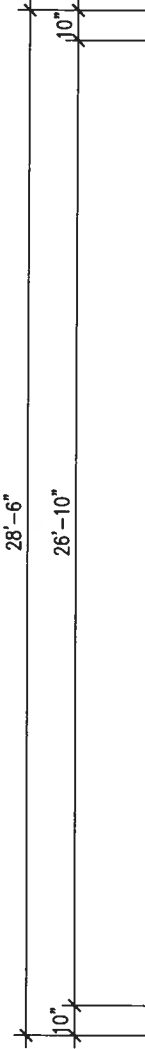

PART. BASEMENT PLAN 'C' - W.O.D. CONDITION

NOTE: J.I. PROVIDE SOLID BLOCKING @ 24" O.C. WHERE FLOOR JOISTS ARE PARALLEL TO FOUNDATION WALL (TYP.)	NOTE: SPACE ALL FLOOR JOISTS @ 12" O.C. UNDER ALL CERAMIC TILE AREAS.	NOTE: ALL LVL'S SUPPORTING FLOOR LOADS ARE TO BE SPECIFIED BY FLOOR TRUSS MANUFACTURER.	NOTE: FLOOR FRAMING INFO REFER TO SHOP DRAWINGS FOR ALL TRUSS-JOIST INFORMATION AND DETAILS. UNLESS OTHERWISE NOTED.
--	---	---	--

UNINSULATED OPENINGS (PER OBC. SB-12,3.1.1(7))				UNINSULATED OPENINGS (PER OBC. SB-12,3.1.1(7))			
S38-8C ELEVATION C WOD		ENERGY EFFICIENCY – OBC SB12		S38-8C ELEV. C OPT. PLAN WOD		ENERGY EFFICIENCY – OBC SB12	
ELEVATION		WALL AREA S.F.		ELEVATION		WALL AREA S.F.	
FRONT		617 S.F.		FRONT		617 S.F.	
LEFT SIDE		1250 S.F.		LEFT SIDE		1250 S.F.	
RIGHT SIDE		1250 S.F.		RIGHT SIDE		1250 S.F.	
REAR		714 S.F.		REAR		714 S.F.	
* OPENINGS OMITTED AS PER SB-12 3.1.1.9(4) MAX 19.9 S.F. REFER TO ELEVATION FOR LOCATION		0.00 S.F.		* OPENINGS OMITTED AS PER SB-12 3.1.1.9(4) MAX 19.9 S.F. REFER TO ELEVATION FOR LOCATION		0.00 S.F.	
TOTAL SQ. FT.		3831.00 S.F.		TOTAL SQ. FT.		3831.00 S.F.	
TOTAL SQ. M.		355.91 S.M.		TOTAL SQ. M.		355.91 S.M.	

[illegible]

VAB
DESIGN
255 Consumers Rd Suite 120
Toronto, ON M2J 1R4
t 416.630.2255 f 416.630.4782
vab3design.com

BAYVIEW WELLINGTON		S38-8C BAROSSA 8	
project name GREEN VALLEY EAST	municipality BRADFORD, ONT.	project no. 16023	
date drawn by JANUARY, 2017 WT	checked by RC	scale 3/16" = 1'-0"	file name 16023-S38-8C
title PARTIAL PLANS ELEV. 'C'		W.O.D. COND	drawing no. 10C

All drawings specifications, related documents and design are the copyright property of VAS DESIGN. Reproduction of this property in whole or in part is strictly prohibited without VAS DESIGN's written permission.

REFER TO FRONT ELEVATION FOR
TYPICAL NOTES.

It is the builder's complete responsibility to ensure that all plans submitted for approval fully comply with the Architectural Guidelines and all applicable regulations and requirements including zoning provisions and any provisions in the subdivision agreement. The Control Architect is not responsible in any way for examining or approving site (lotting) plans or working drawings with respect to any zoning or building code or permit matter or that any house can be properly built or located on its lot.

This is to certify that these plans comply with the applicable Architectural Design Guidelines approved by the Town of BRADFORD / WEST GWILLIMBURY.

ARCHITECTURAL REVIEW & APPROVAL

JAN 30 2018

John G. Williams Limited, Architect



TOP OF PLATE

TOP OF WINDOW

FIN SECOND FLOOR

TOP OF TRANSOM

TOP OF WINDOW

FIN GROUND FLOOR


FIN GRADE

TOP OF SLAB

REAR ELEVATION 'C' - 9R OR MORE W.O.D. CONDITION

BASEMENT WINDOW SIZES
4R-8R USE 30"x24" VINYL
CLAD STRUCTURAL STEEL
FRAME BASEMENT WINDOWS


S38-8C		BAROSSA 8	
BAYVIEW WELLINGTON		BRADFORD, ONT.	
project no.	16023	project name	GREEN VALLEY EAST
drawing no.	11C	date	JANUARY, 2017
scale	3/16" = 1'-0"	checked by	RC
drawn by	WT	drawn by	WT
REAR ELEVATION 'C' W.O.D. COND		16023-S38-8C	
JAN 16 2018 - 12:07 PM		16023-S38-8C.dwg - Tue - Jan 16 2018 - 12:07 PM	
The undersigned has reviewed and takes responsibility for this design and has the qualifications and meets the requirements set out in the Ontario Building Code to be a Designer.			
qualification information			
Wellington Jno-Baptiste 25591			
name			
registration information			
VA3 Design Inc. 42658			
Contractor must verify all dimensions on the job and report any discrepancy to the Designer before proceeding with the work. All drawings and specifications are instruments of service and the property of the Designer which must be returned at the completion of the work. Drawings are not to be scaled.			
no.	description	date	by
2	REVISED AS PER ENG'S COMMENTS	JAN 12-18 RC	
1	ISSUED FOR CLIENT REVIEW		

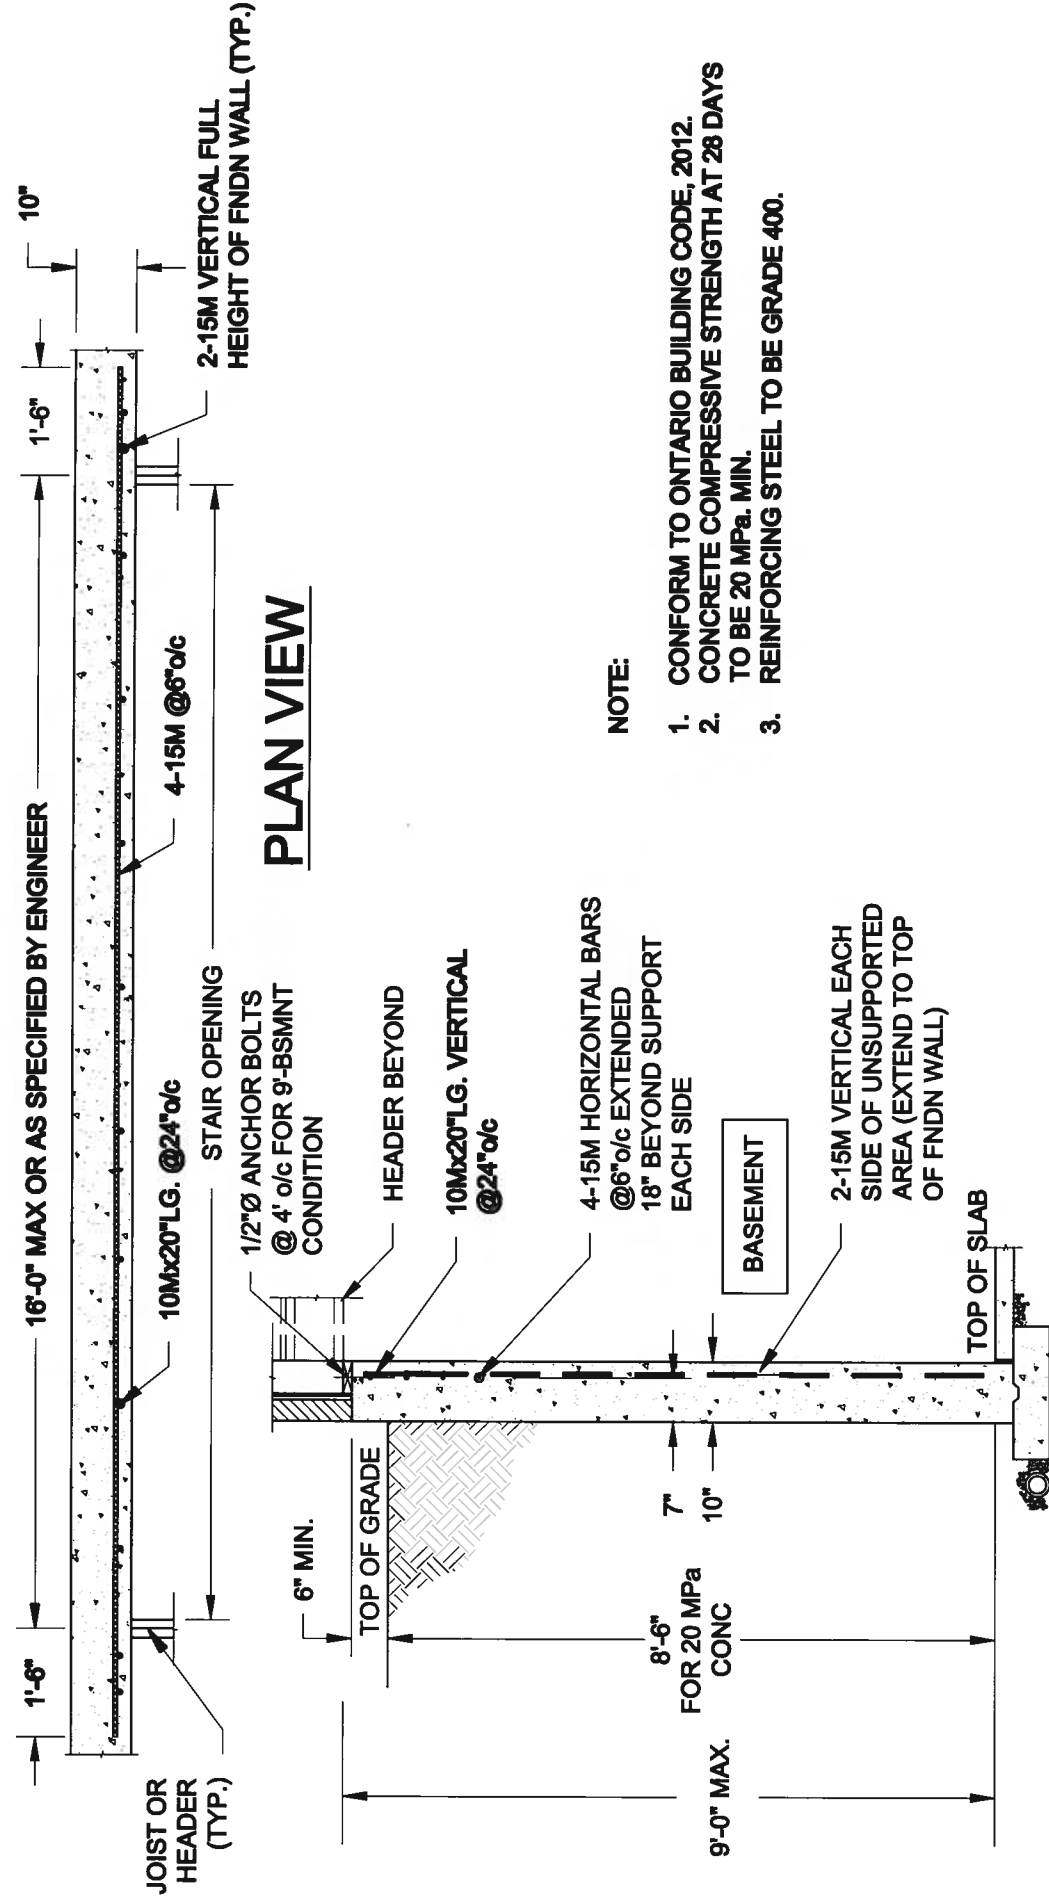


NOTE:

1. CONFORM TO ONTARIO BUILDING CODE, 2012.
2. CONCRETE COMPRESSIVE STRENGTH AT 28 DAYS TO BE 20 MPa. MIN.
3. REINFORCING STEEL TO BE GRADE 400.


1 **S1** **LATERALLY UNSUPPORTED WALL** SCALE: 3/8" = 1'-0"

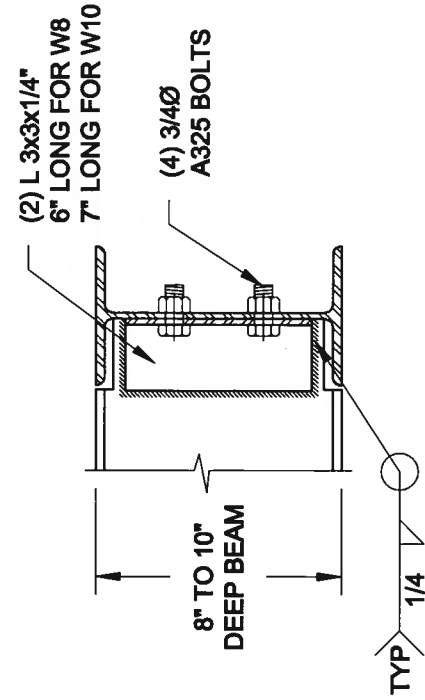




2 **S1** **STEEL BEAM CONNECTION DETAIL** SCALE: 1-1/2" = 1'-0"

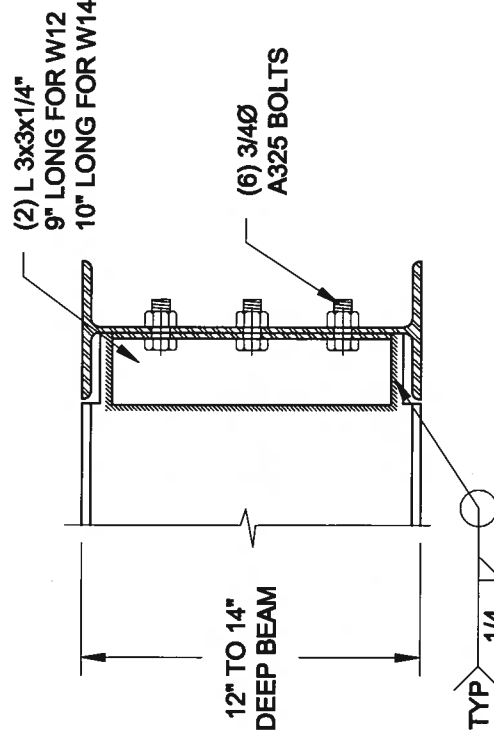


Scale: AS NOTED	QUAILE ENGINEERING LTD.		 38 Parkside Drive, UNIT 7 Newmarket, ON L3Y 8J9 T: 905-853-8547 E: quaile.eng@rogers.com	Engineer's Seal  S. J. BOYD PROFESSIONAL ENGINEER PROVINCE OF ONTARIO JAN 16, 2018	Project: BAYVIEW WELLINGTON HOMES - GREEN VALLEY BEATS - SINGLES BRADFORD, ONTARIO
	Date: OCT-20-2017	TYPICAL STRUCTURAL DETAILS			
Drawn: SC	Checked: SJB	Project No.: 17-215	Drawing No.: S1		

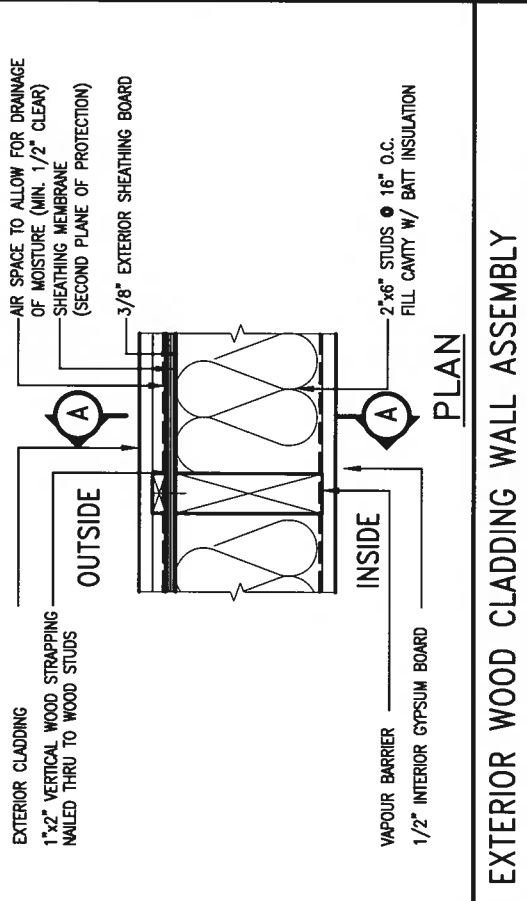

STUD WALL REINFORCEMENT FOR FUTURE GRAB BARS IN MAIN BATHROOM
REINFORCEMENT OF STUD WALLS SHALL BE INSTALLED ADJACENT TO WATER CLOSETS AND SHOWER OR BATHTUB IN MAIN BATHROOM.
FUTURE GRAB BARS TO BE MOUNTED TO RESIST HORIZ. AND VERT. LOADS OF 1.3 KN (300 lb)
REFER TO OBC. DN. B- 9.5.2.3. WATER CLOSET 3.8.3.8.8.(3)(c) & 3.8.3.8.8.(3)(c). SHOWER 3.8.3.13.2.(2)(f). BATHTUB & 3.8.3.13.4.(c). AND DETAILS PROVIDED.

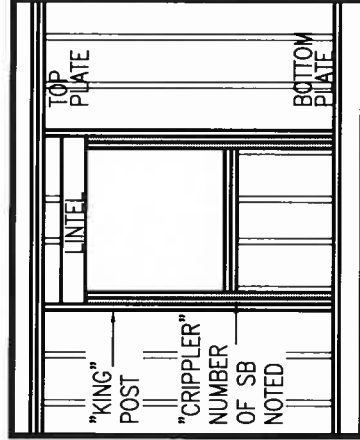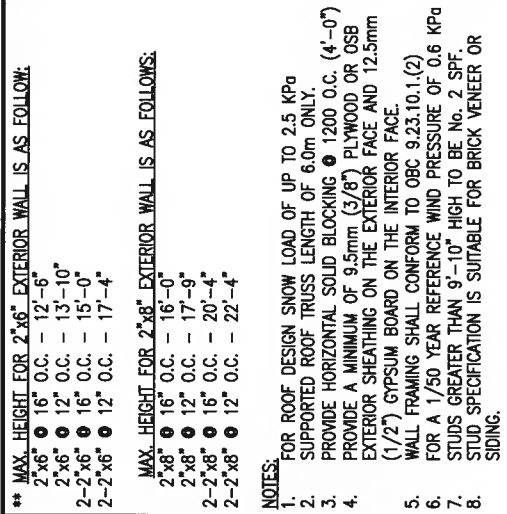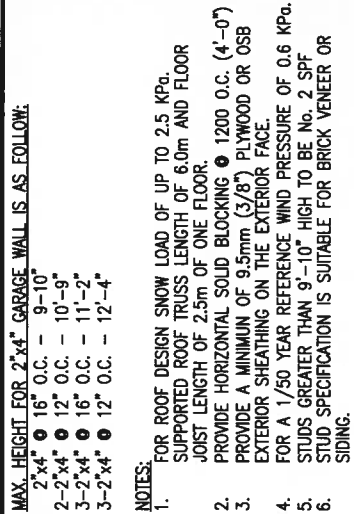

"CRIPPLE" DETAIL

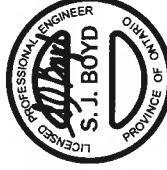

JAN 11, 2018

9 .		The undersigned has reviewed and takes responsibility for this design and for the specifications and meets the requirements set out in the Ontario Building Code to be a Designer. qualification information Wellington Jno-Baptiste 25591 name BCON registration information VA3 Design Inc. 42658 signature	
8 .			
7 .			
6 .			
5 .			
4 .			
3 .			
2 UPDATE TO 2018		JAN 11-18	RC
1 ISSUE FOR CLIENT REVIEW		AUG 04-17	RC
no.	description	date	by

VA3

DESIGN

255 Consumers Rd Suite 120
Toronto ON M2J 1R4
t 416.630.2255 f 416.630.4782
va3design.com

BAYVIEW WELLINGTON

project name GREEN VALLEY EAST

municipality BRADFORD

project no. 16023

date MAY 2016

drawn by RC

checked by -

scale 3/16" = 1'-0"


CONSTRUCTION NOTES

file name 16023-CN-A1

drawing no. CN2


RICHARD - H:\ARCHIVE\WORKING\2016\16023-BW\Units\CN NOTES\16023-CN-A1.dwg Thu - Jan 11 2018 - 10:08 AM

All drawings specifications, related documents and design are the copyright property of VA3 DESIGN. Reproduction of this property in whole or in part is strictly prohibited without VA3 DESIGN's written permission.

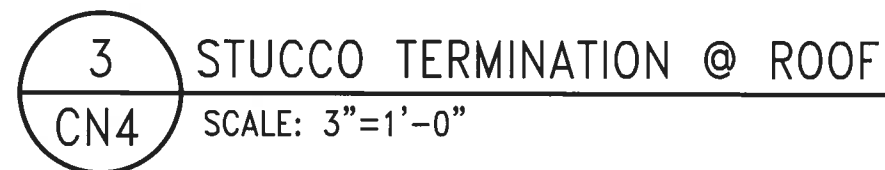

4 HORIZONTAL EXPANSION JOINT
CN4 SCALE: 3"=1'-0"

[illegible]

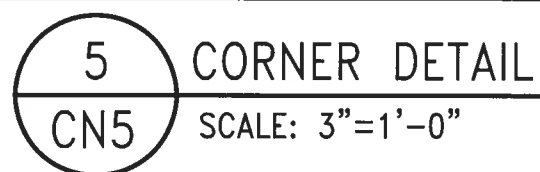

APPROVED EXTERIOR SHEATHING

DuROCK "POLAR BEAR" AIR/MOISTURE BARRIER

PUCCS INSULATION BOARD

MECHANICAL FASTENER

DuROCK FINISH COAT

DuROCK FIBER MESH EMBEDDED IN DuROCK PREP COAT

DuROCK STARTER MESH (BACKWRAPPED)

BACKER ROD AND SEALANT (VENTED)

FLASHING

PRECAST SILL ON GROUT

WEPPHOLES ② 32"(800) O.C.


TRANSITION MEMBRANE. EXTEND MEMBRANE 6" ABOVE AND BELOW SILL. ENSURE TRANSITION MEMBRANE IS OVER BUILDING PAPER

BUILDING PAPER

6 STUCCO / MASONRY PLINTH CONNECTION
CN5 SCALE: 3"=1'-0"

[illegible]

SB12-COMPLIANCE PACKAGE 'A1'

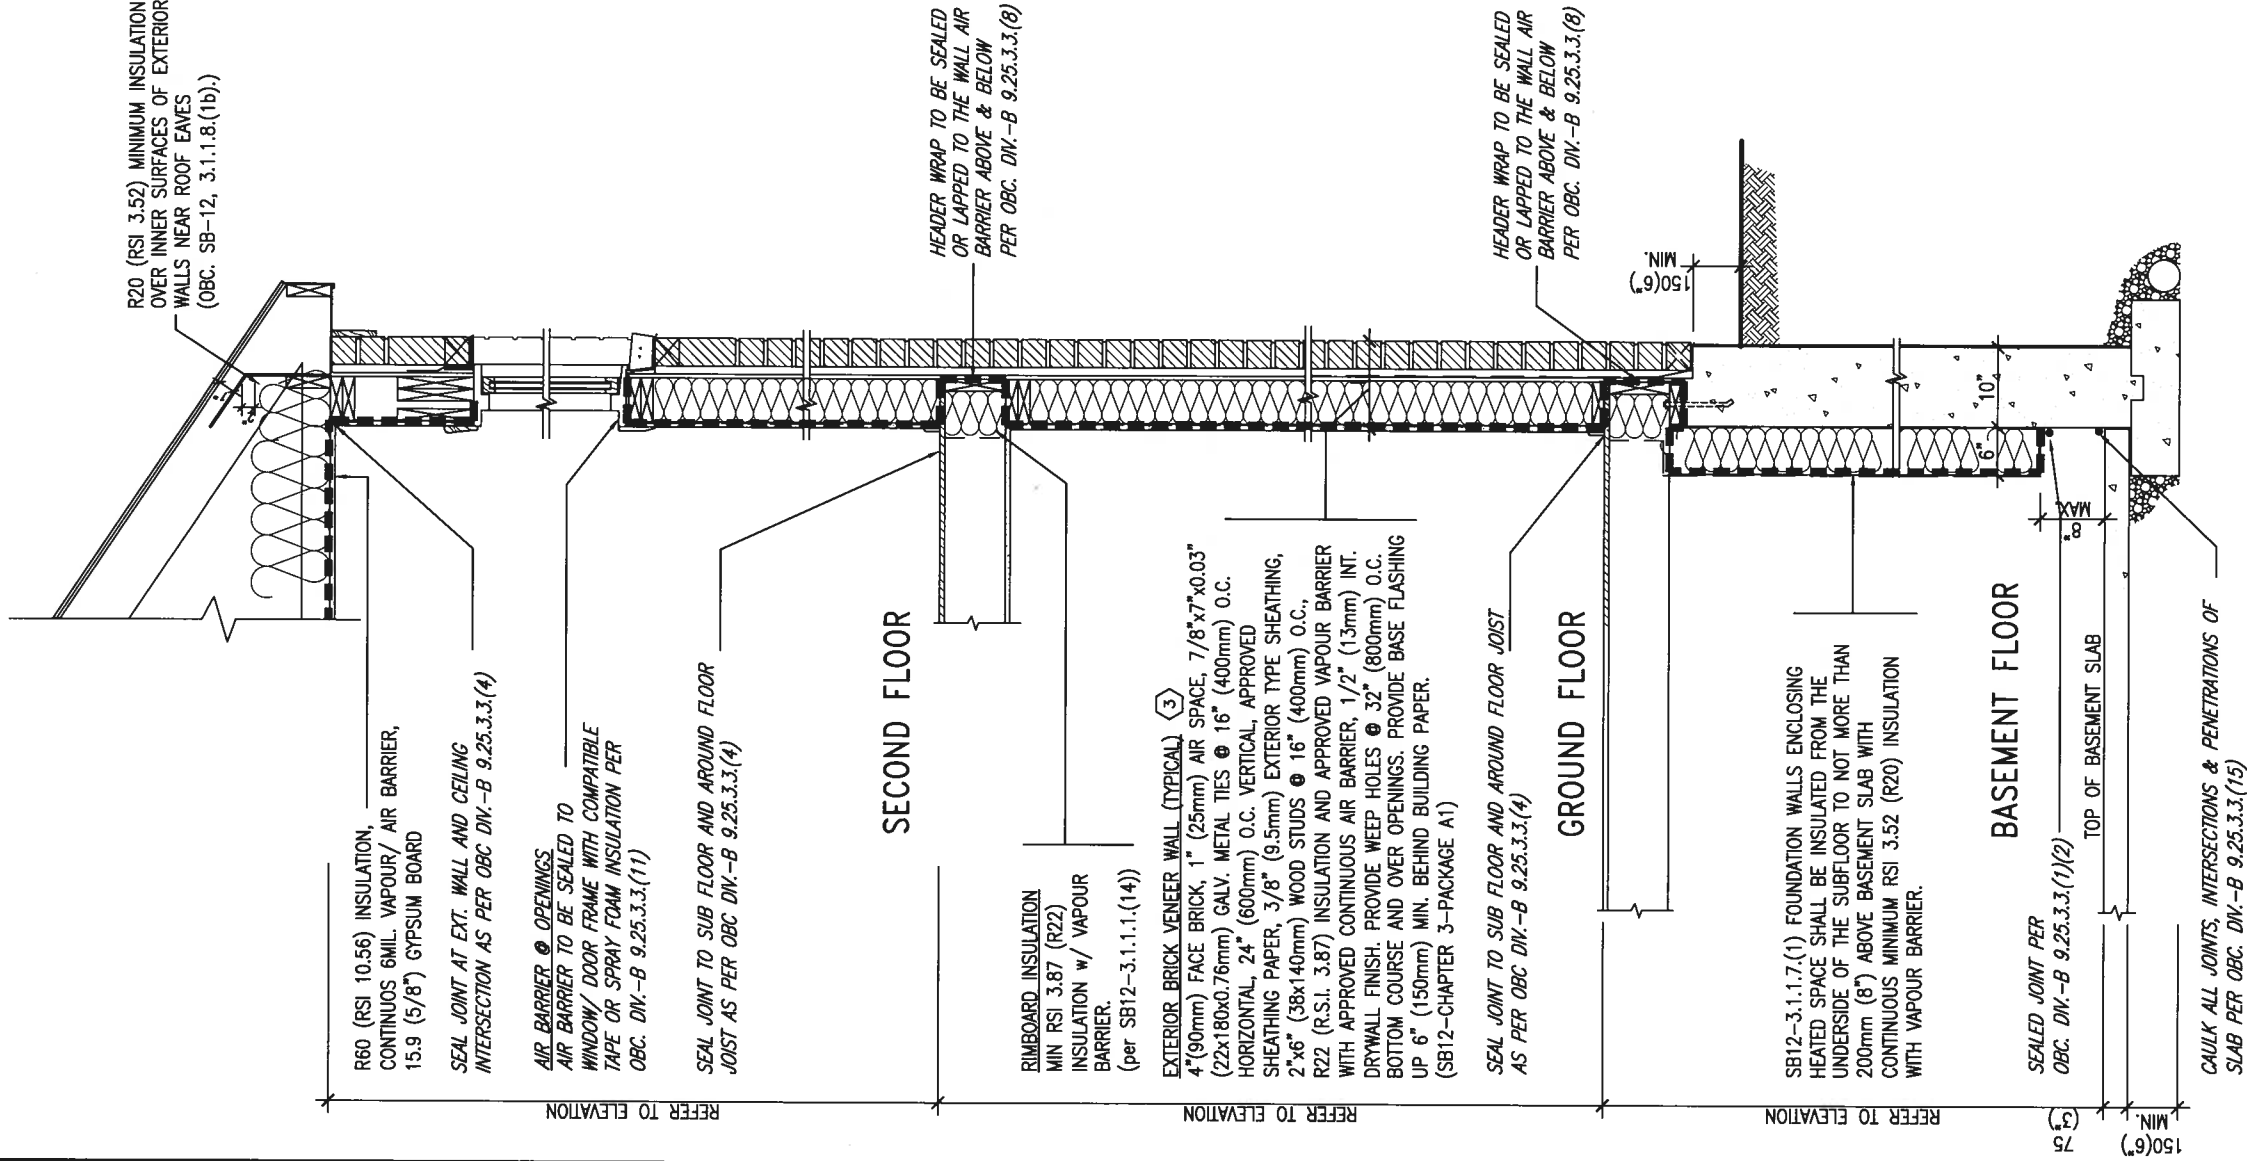

EW TYPICAL EXT. WALL AIR BARRIER CONTINUITY SECTION w/ BRICK VENEER (PACKAGE A1) 10" FOUNDATION WALL SCALE: N.T.S.

INSULATION REQUIREMENTS
REFER TO OBC SB-12, CHAPTER 3,
ZONE 1 - COMPLIANCE PACKAGE A1.


AIR BARRIER SYSTEMS
AIR BARRIER TO BE INSTALLED IN
CONFORMANCE WITH OBC DIV. B-9.25.3

REFER TO ADDITIONAL
DETAILS FOR STRUCTURAL
COMPONENTS

THE MINIMAL THERMAL PERFORMANCE OF BUILDING ENVELOPE AND EQUIPMENT SHALL CONFORM TO THE FOLLOWING SB-12 COMPLIANCE PACKAGE AS PER OBC SUPPLEMENTARY STANDARD SB-12, SECTION 3.1.1.1.

USE SB-12 COMPLIANCE PACKAGE (A1):		
COMPONENT	A1	Notes:
Ceiling with Attic Space	10.56 (R60)	R20 at inner face of exterior walls
Ceiling without Attic Space	5.46 (R31)	BATT or SPRAY
Exposed Floor	5.46 (R31)	BATT or SPRAY
Minimum RSI (R) value Walls Above Grade	3.87 (R22)	6" R22 BATT
Minimum RSI (R) value Basement Walls	3.52ci (R20ci)	OPTION TO USE R12+R10ci.
Edge of Below Grade Slab ≤600mm below grade	1.76 (R10)	RIGID INSUL
Minimum RSI (R) value Windows & Sliding glass Doors	1.6	
Maximum U-value Skylights	2.8U	
Space Heating Equipment Minimum AFUE	96% Min.	NATURAL GAS
Hot Water Heater Minimum EF	0.8	NATURAL GAS
HRV Minimum Efficiency	75%	-
Drain Water Heat Recovery Unit (DWHR)	Minimum 1 OR Maximum 2 Required. Dependent on number of showers installed. Refer to SB12-3.1.1.12 for information	

ci- Denotes Continuous Insulation without framing interruption.

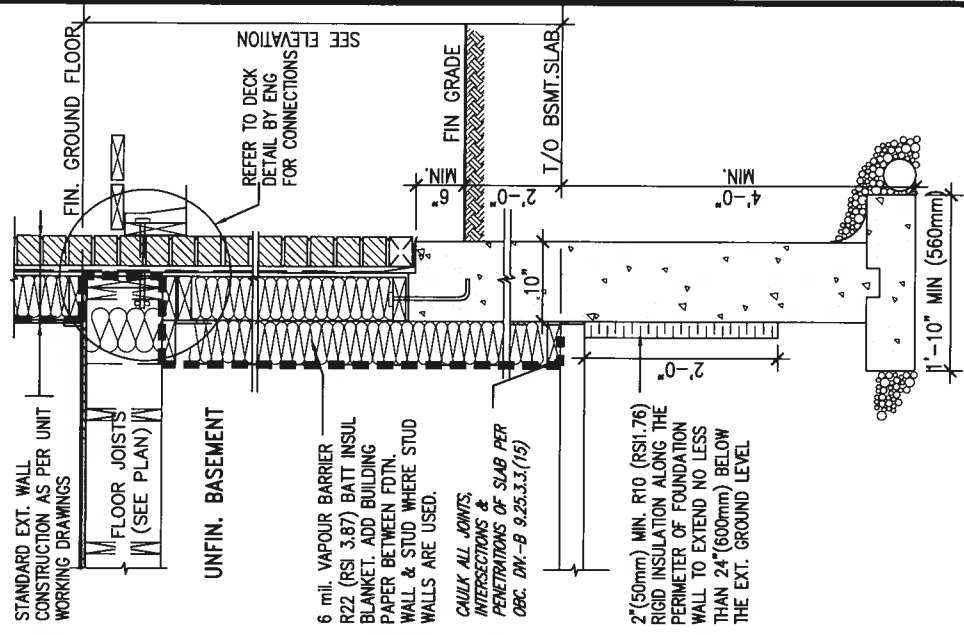

* REVISED-FEB 2017

SECTION AT W.O.D/W.O.B.


9.		The undersigned has reviewed and takes responsibility for this design and has the qualifications and meets the requirements set out in the Ontario Building Code to be a Designer.		project name		project no.	
8.		qualification information		GREEN VALLEY EAST		16023	
7.		Wellington Jno-Baptiste		signature		drawing no.	
6.		name		VA3 Design Inc.		CN6	
5.		registration information		25591		CONSTRUCTION NOTES	
4.		date		JAN 11-18 RC		16023-CN-A1	
3.		by		AUG 04-17 RC		file name	
2.		no. description		1		16023-CN-A1	
1.		date		JAN 11-18 RC		scale	
						3/16" = 1'-0"	
						checked by	
						drawn by	
						RC	
						MAY 2016	
						date	
						GREEN VALLEY EAST	
						municipality	
						BRADFORD	
						project no.	
						16023	

VA3 DESIGN
255 Consumers Rd Suite 120
Toronto ON M2J 1R4
t 416.630.2255 f 416.630.4782
va3design.com

Richard - H:\ARCHITECT\WORKING\2016\16023.BN\VA3-CN-A1.dwg - Thu - Jan 11 2018 - 10:10 AM

All drawings specifications, related documents and design are the copyright property of VA3 DESIGN. Reproduction of this property in whole or in part is strictly prohibited without VA3 DESIGN's written permission.

SB12-COMPLIANCE PACKAGE 'A1'

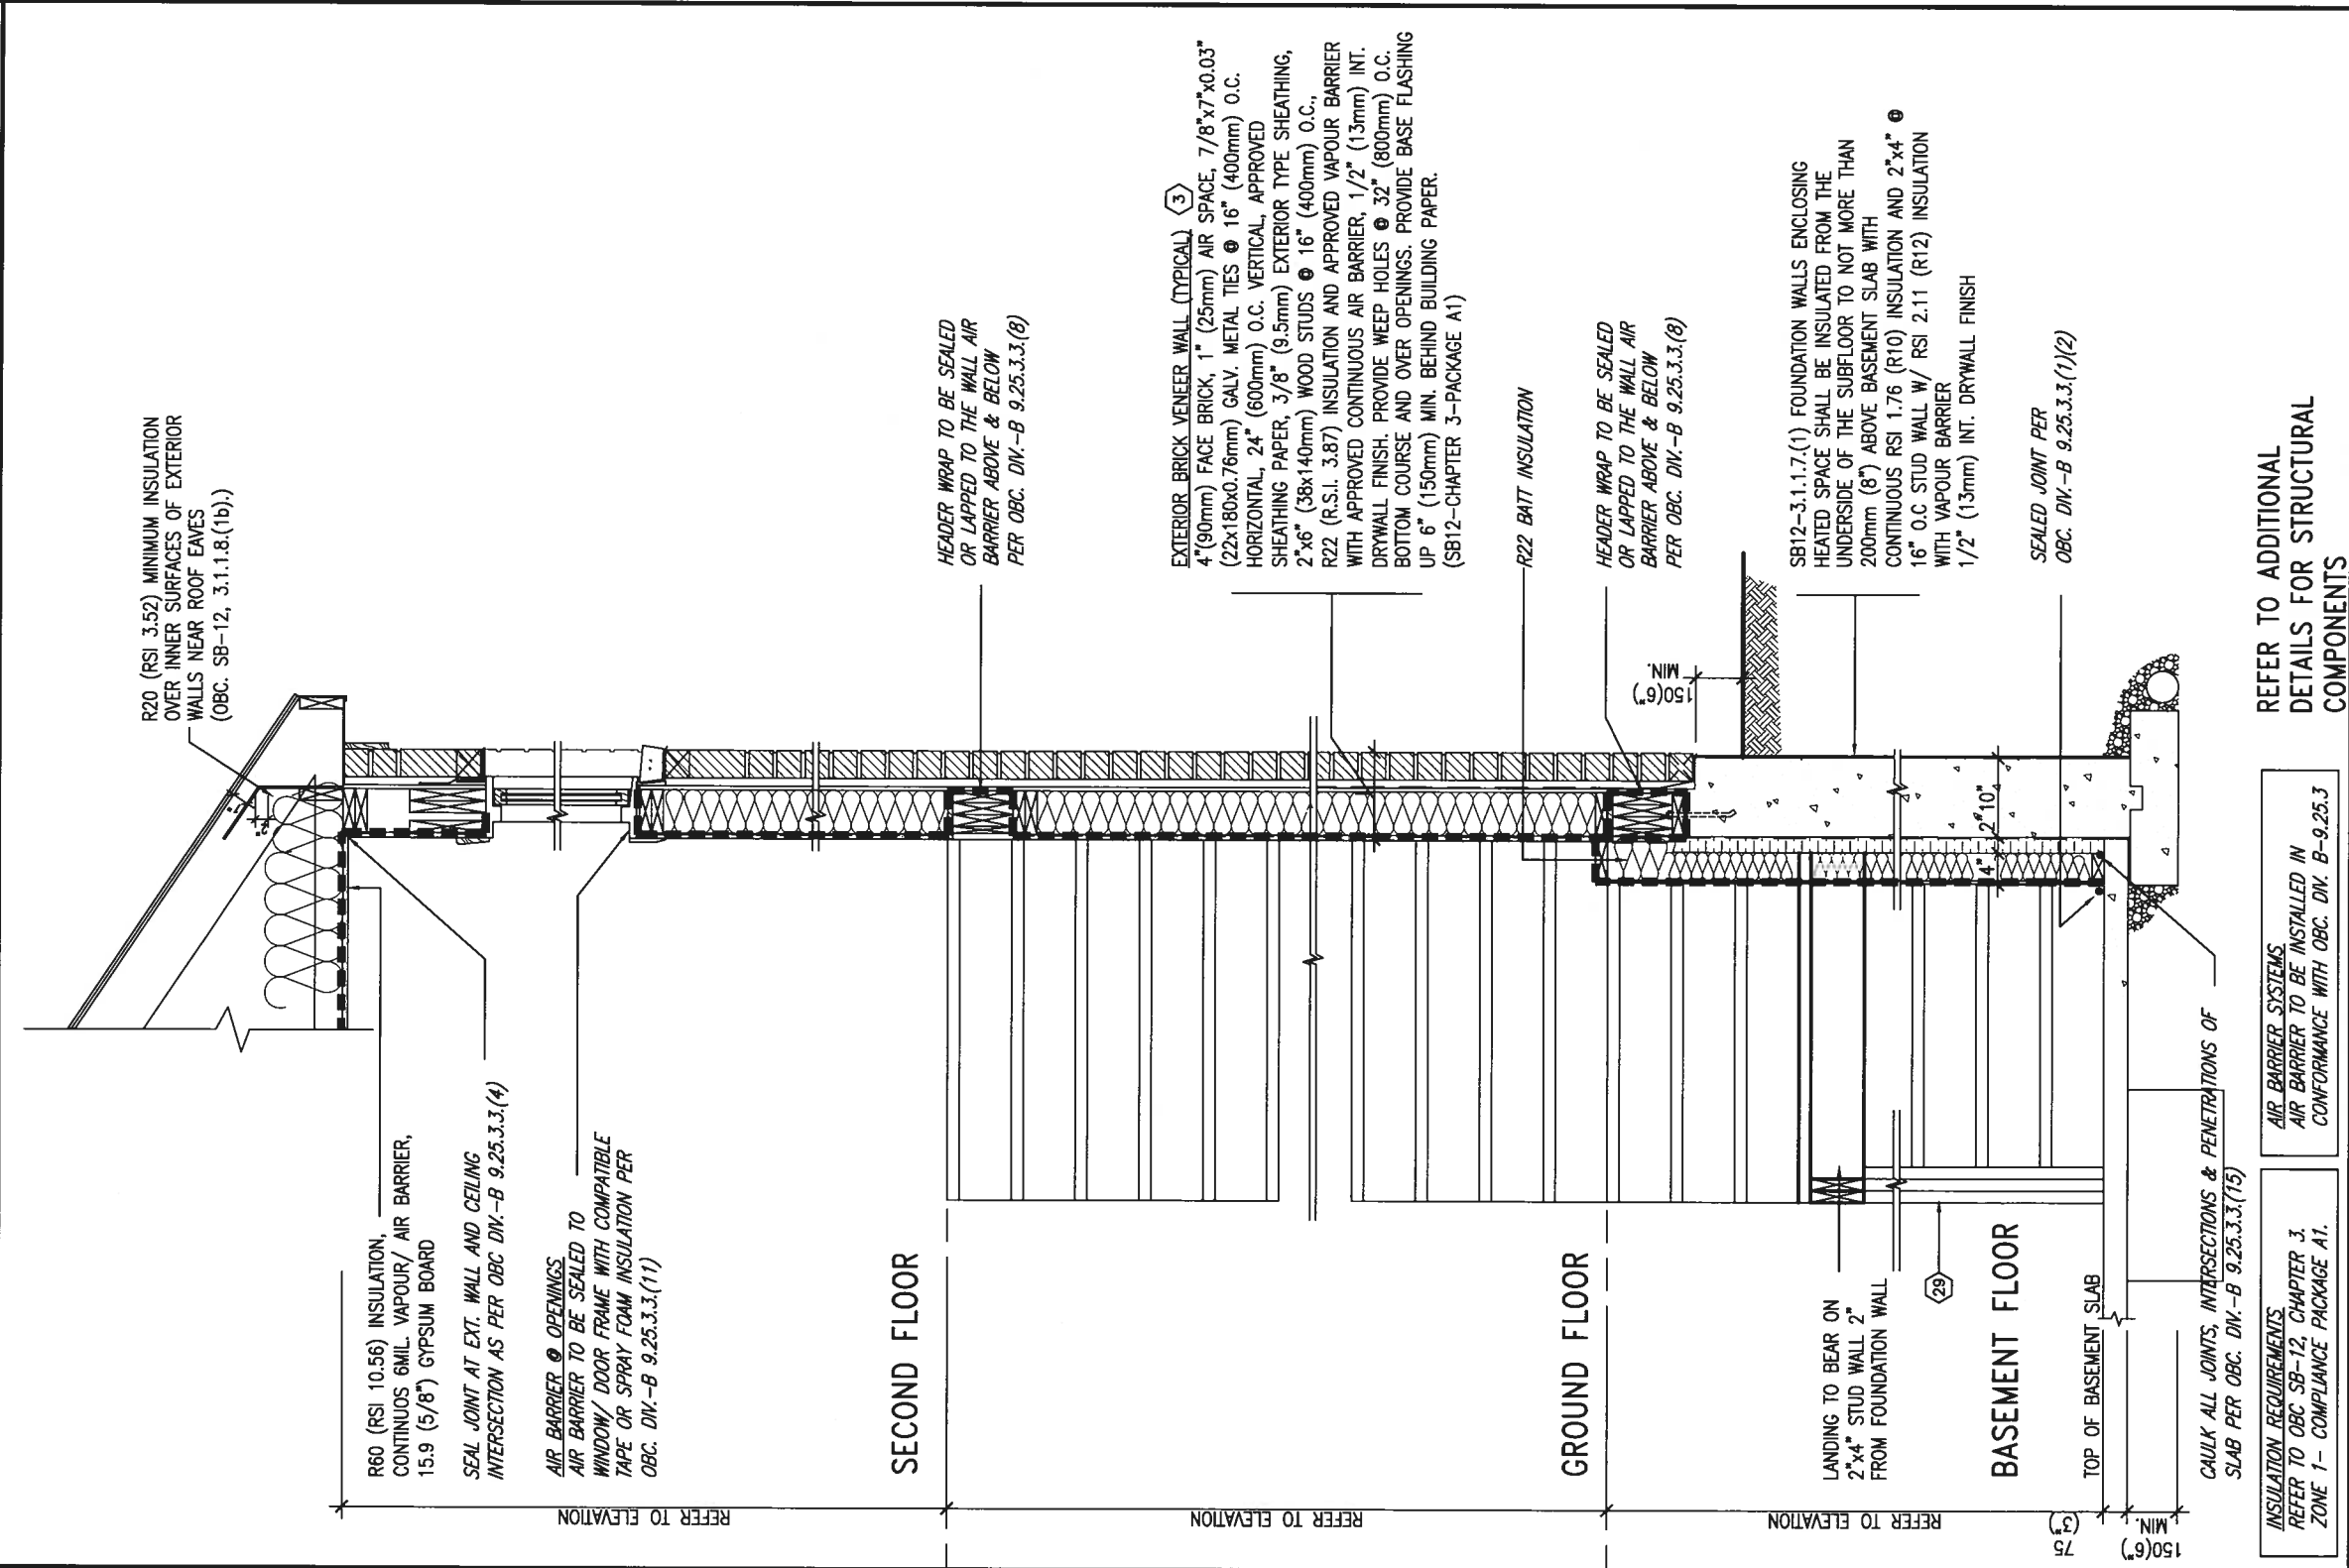

EW
STR

TYPICAL EXT. WALL AIR BARRIER CONTINUITY SECTION w/
BRICK VENEER AT STAIR AND SUNKEN COND (PACKAGE A1)

10" FOUNDATION WALL

SCALE: N.T.S.

[illegible]


COMPLIANCE TO CBC SB-12 2.1.1.1(11)

W X X

Diagram illustrating a fire alarm system loop configuration, showing a horizontal line with a vertical branch at the left end and a vertical branch at the right end. The left vertical branch has an upward arrow. The right vertical branch has a downward arrow. A 'W' is on the left horizontal segment, and two 'X's are on the main horizontal segment. A break symbol is on the bottom wire. A bell symbol is on the right vertical branch.




WOB PLAN

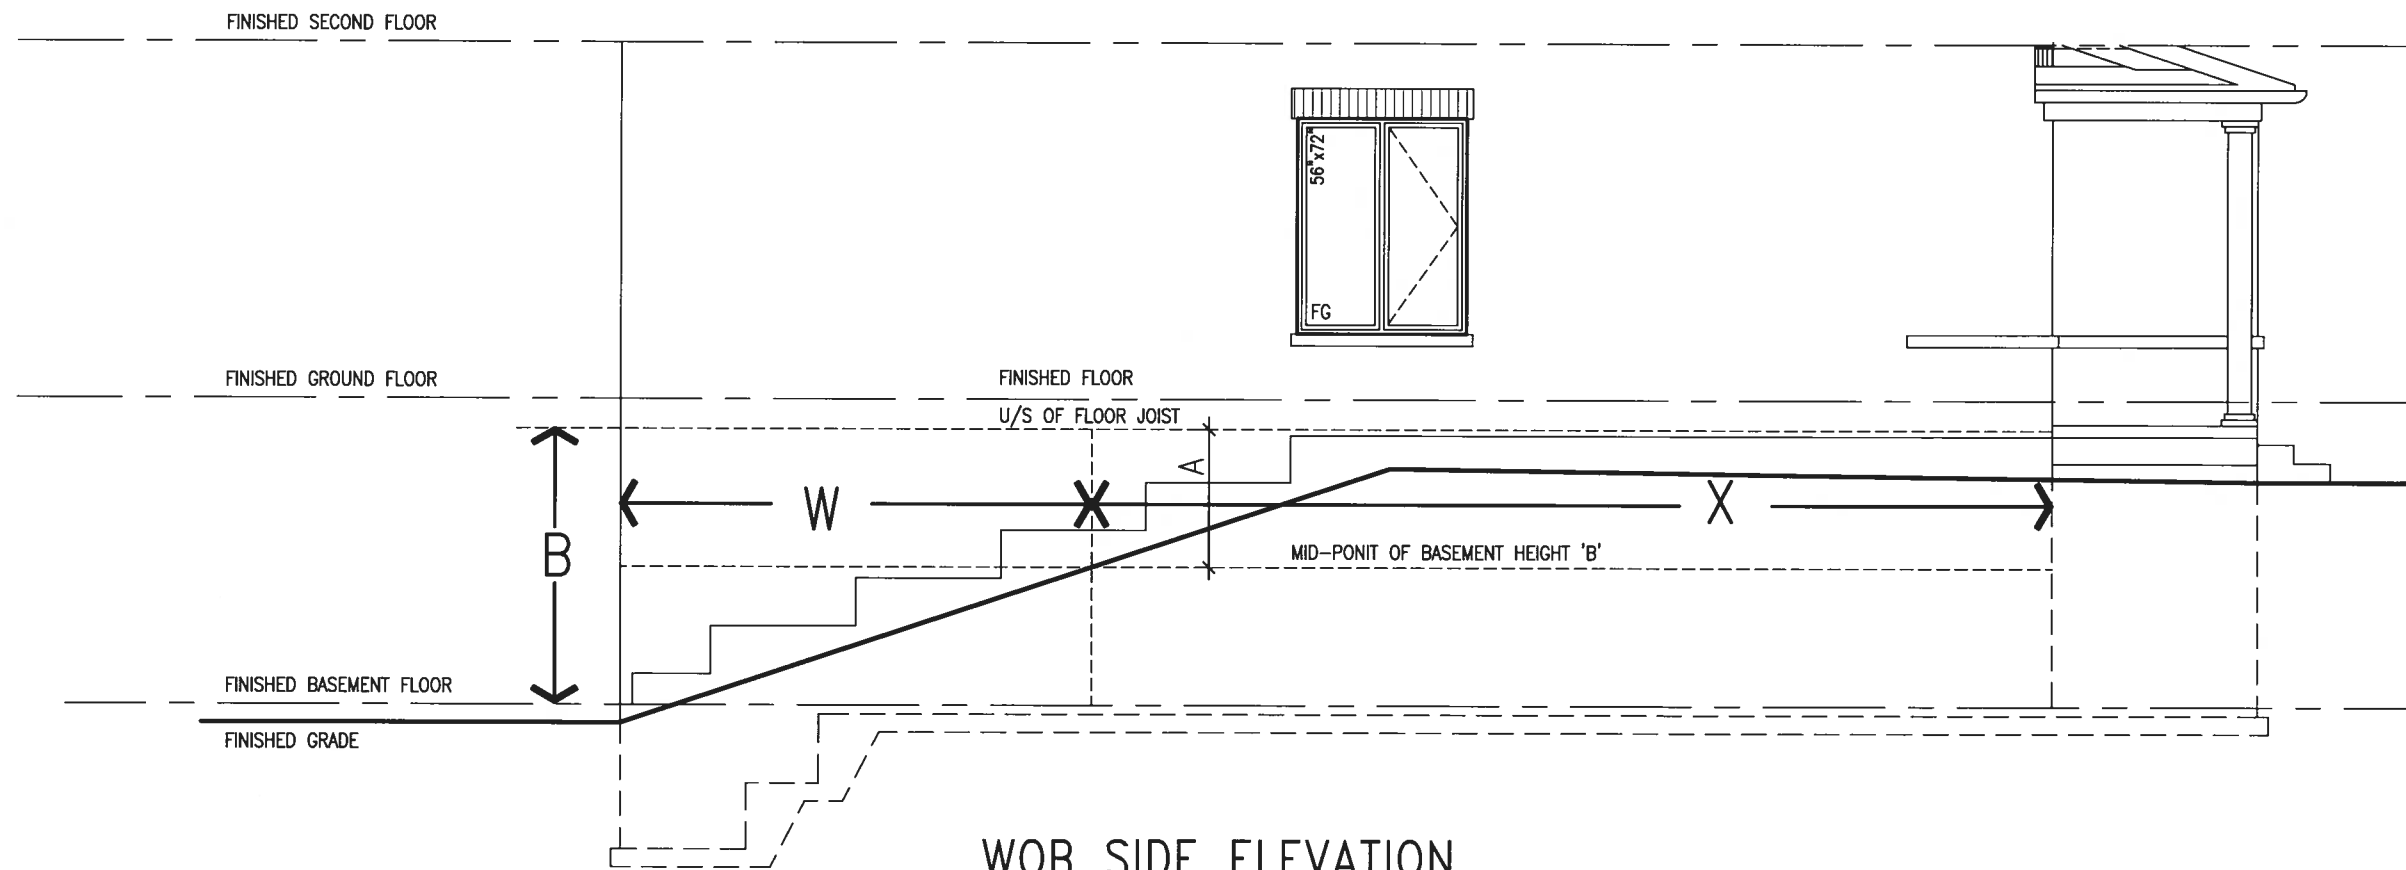


WHEN EXPOSED WALL "A" IS LESS THAN 50%
OF BASEMENT WALL HEIGHT "B"
INSULATION VALUE FOR WALL IN SECTION "X"
IS NOT LESS THAN BASEMENT WALL AS
REQUIRED BY TABLE 2.1.1.2A


[illegible]

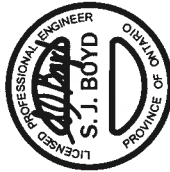

JAN 11, 2018

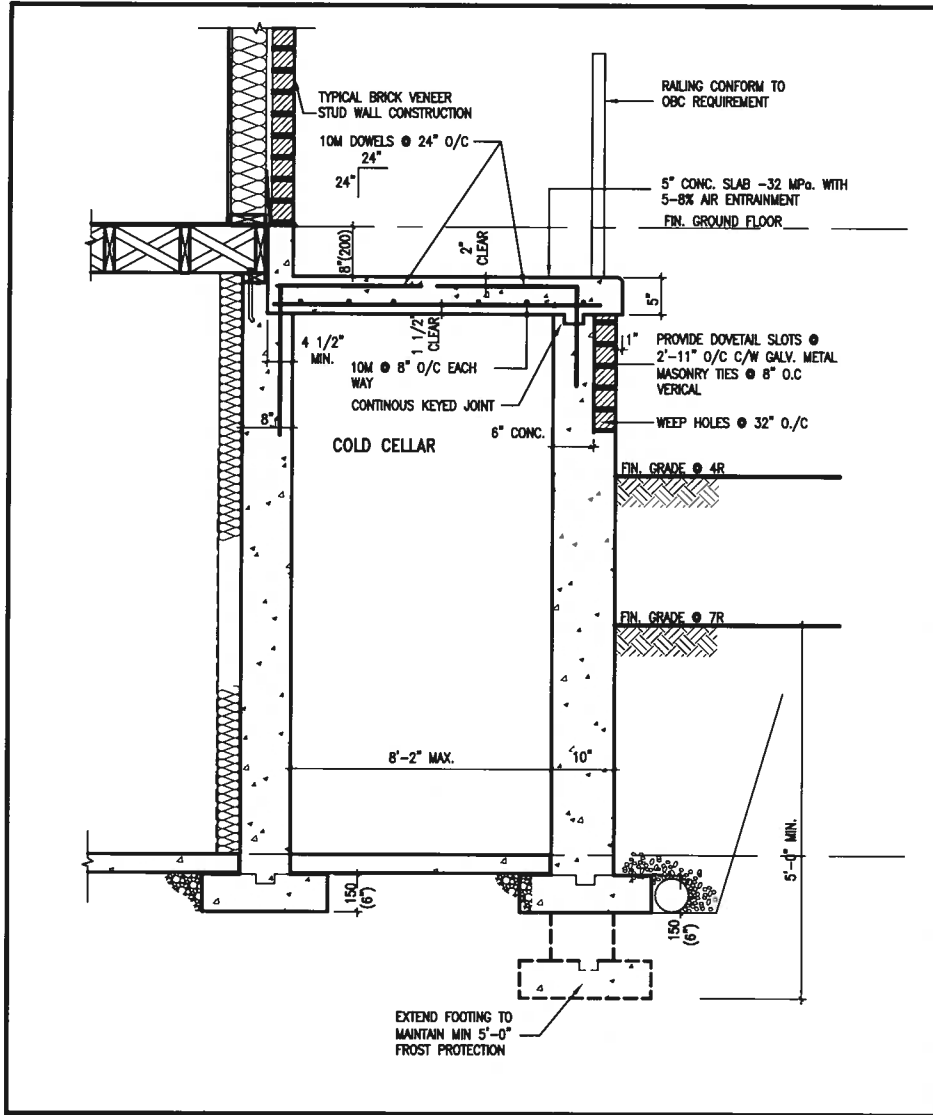

X1 SECTION AT PORCH FOR 4-7R CONDITION
SCALE: N.T.S.

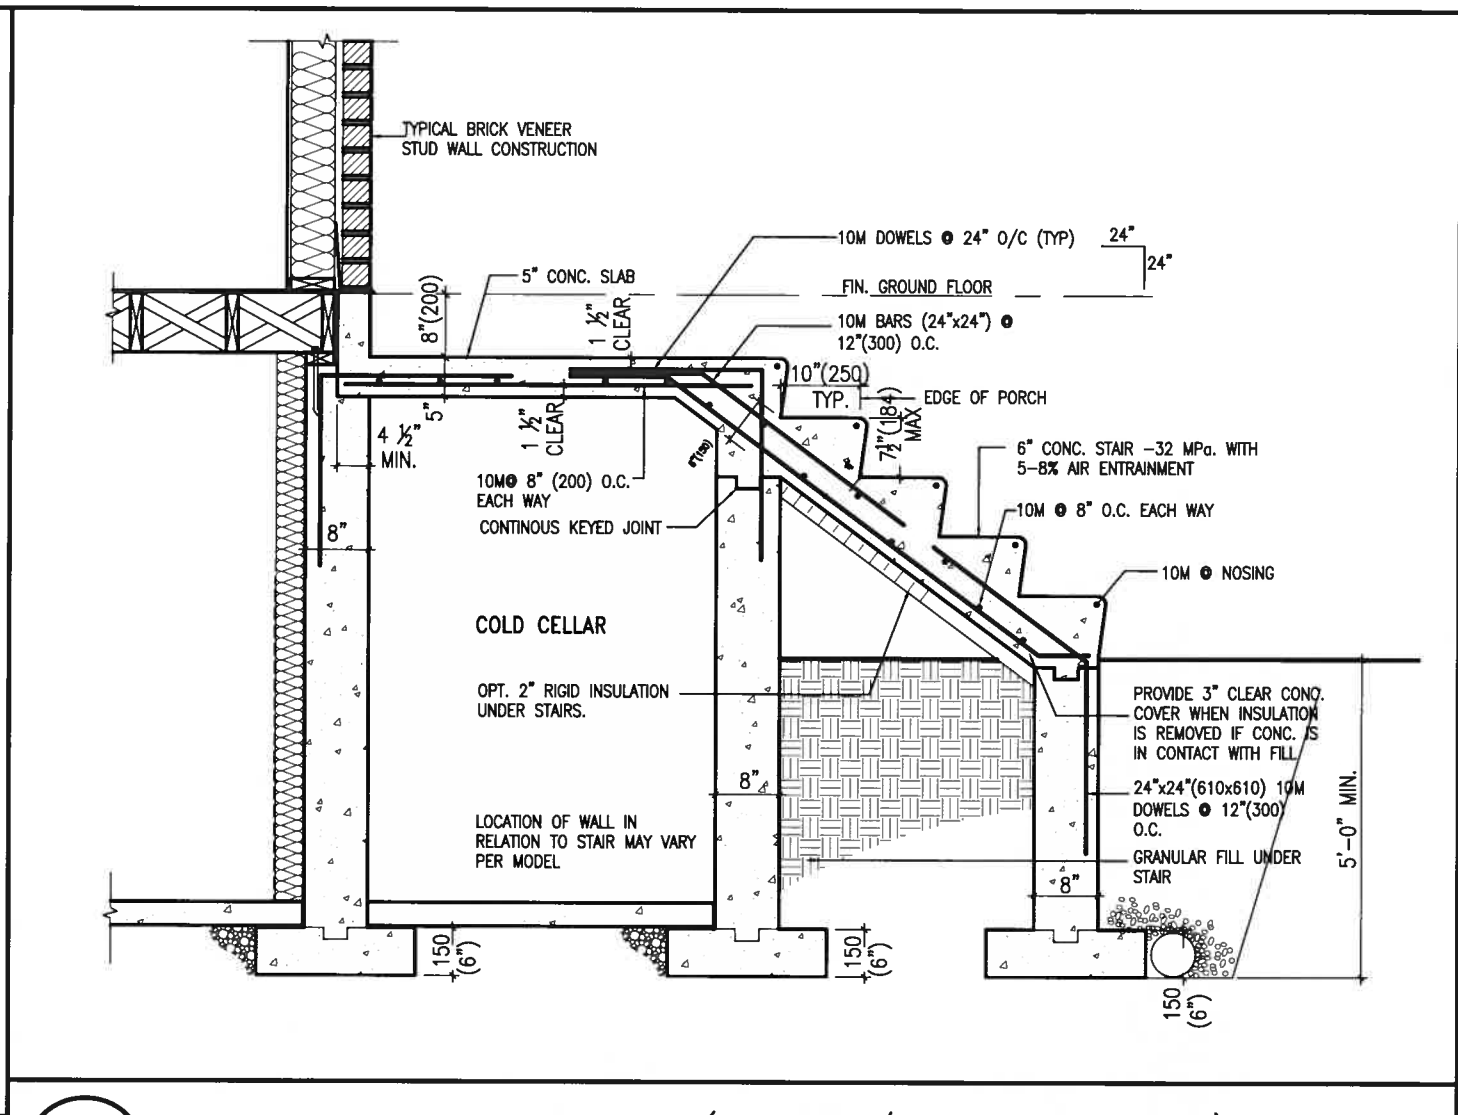

X2 EXTERIOR CONC. STAIR DETAIL (6 RISERS/ 7 RISERS SIMILAR)
SCALE: N.T.S.




The undersigned has reviewed and takes responsibility for this design and has the qualifications and meets the requirements set out in the Ontario Building Code to be a Designer.
qualification information
Wellington Jno-Baptiste 25591
name
registration information
VA3 Design Inc. 42658
BCN
Contractor must verify all dimensions on the job and report any discrepancy to the Designer before proceeding with the work. All drawings and specifications are instruments of service and the property of the Designer which must be returned at the completion of the work. Drawings are not to be scaled.
JAN 11-18 RC
AUG 04-17 RC
no. description
date by


BAYVIEW WELLINGTON
GREEN VALLEY EAST
BRADFORD
project name
project no.
16023
drawing no.
CN9
CONSTRUCTION NOTES
file name
16023-CN-A1
date
MAY 2016
checked by
RC
scale
3/16\"/>

VA3 DESIGN
255 Consumers Rd Suite 120
Toronto ON M2L 1R4
t 416.630.2255 f 416.630.4782
va3design.com

Richard - H. ARCHIVE WORKING 2016 \16023\BAYVIEW\CN NOTES\16023-CN-A1.dwg - Thu - Jan 11 2018 - 10:09 AM
All drawings specifications, related documents and design are the copyright property of VA3 DESIGN. Reproduction of this property in whole or in part is strictly prohibited without VA3 DESIGN's written permission.

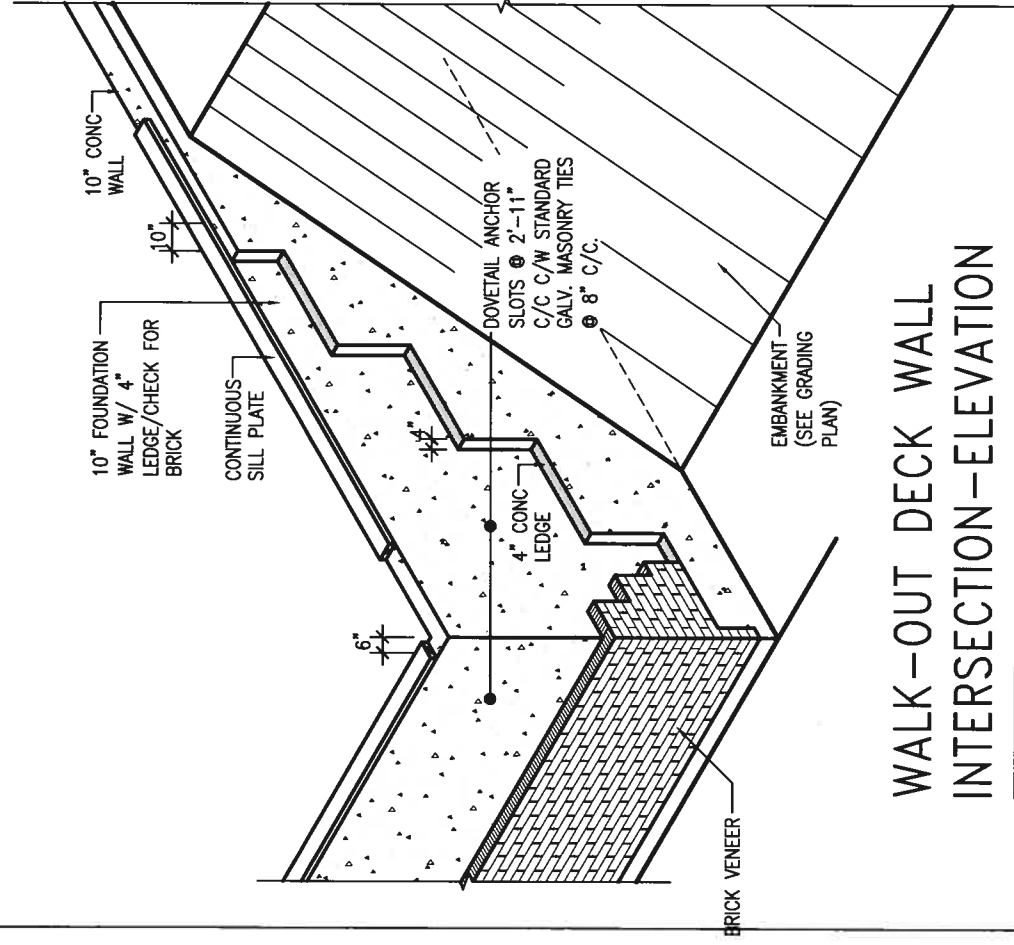


WALK-OUT DECK WALL INTERSECTION-ELEVATION

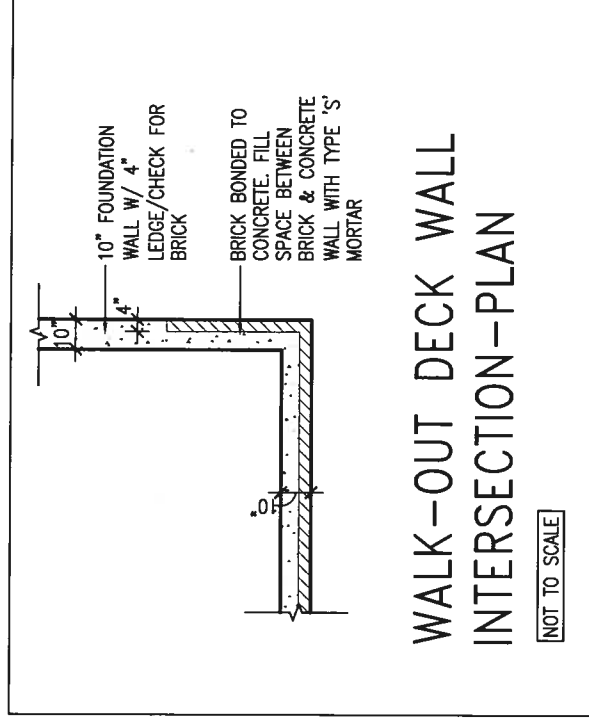


WALK-OUT DECK WALL INTERSECTION-PLAN

NOT TO SCALE

(10" FOUNDATION WALL)

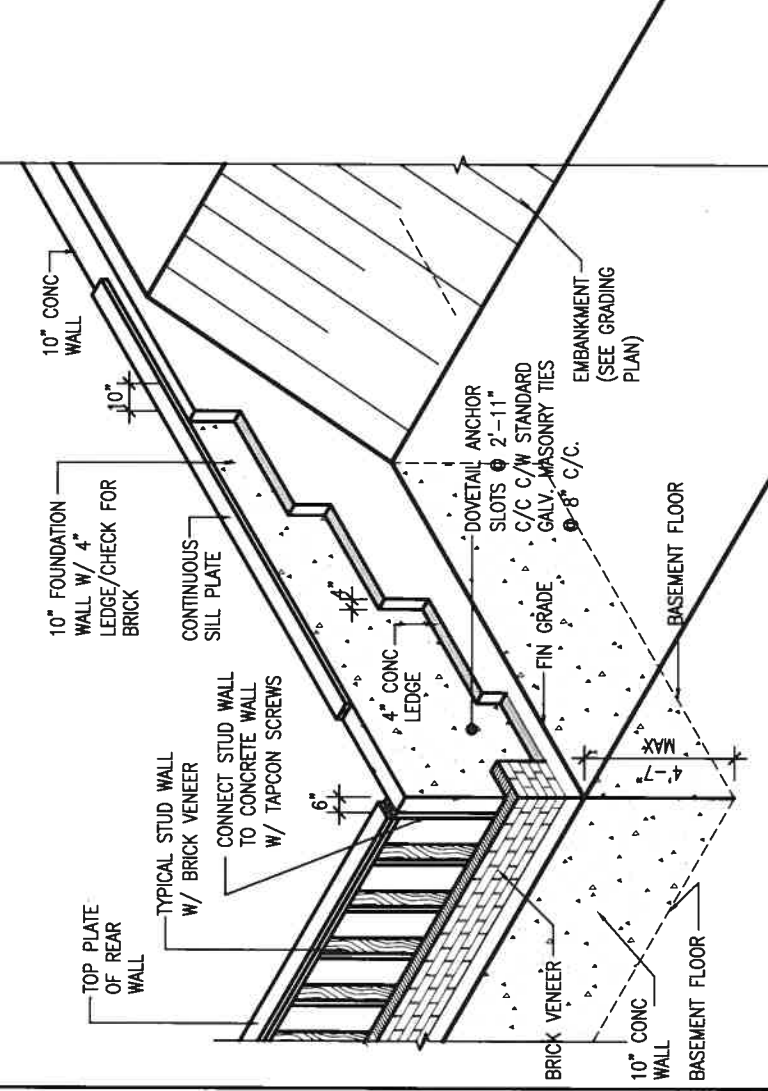


WALK-OUT DECK WALL
INTERSECTION-ELEVATION MAX
4'-7" BACKFILL

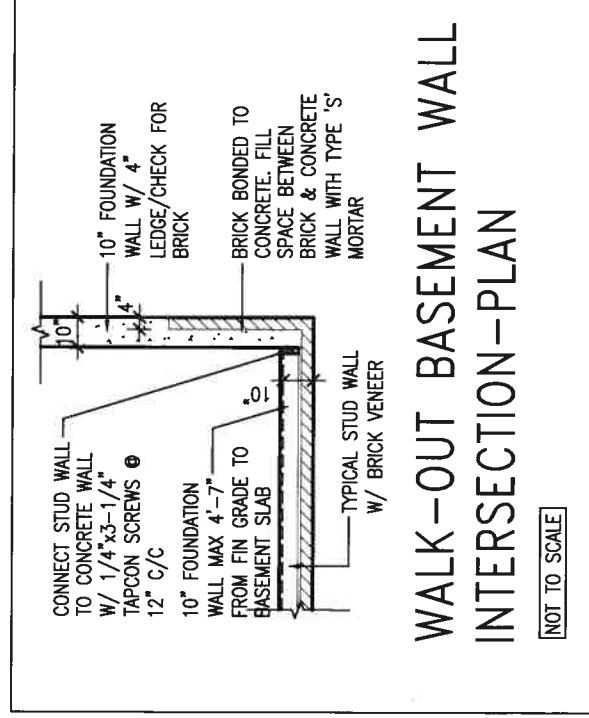

WALK-OUT BASEMENT WALL INTERSECTION-PLAN

NOT TO SCALE

(10" FOUNDATION WALL)

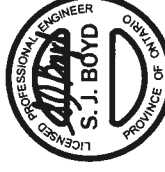



JAN 11, 2018

9	.	.	.	The undersigned has reviewed and takes responsibility for this design and has the qualifications and meets the requirements set out in the Ontario Building Code to be a Designer.
8	.	.	.	qualification information
7	.	.	.	
6	.	.	.	Wellington Jno-Baptiste
5	.	.	.	name
4	.	.	.	registration information
3	.	.	.	VA3 Design Inc.
2	UPDATE TO 2018	JAN 11-18	RC	Contractor must verify all dimensions on the job and report any discrepancy to the Designer before proceeding with the work. All drawings and specifications are instruments of service and the property of the Designer which must be returned at the completion of the work. Drawings are not to be scaled.
1	ISSUE FOR CLIENT REVIEW	AUG 04-17	RC	
no.	description	date	by	

V3
DESIGN
255 Consumers Rd Suite 120
Toronto ON M2J 1R4
t 416.630.2255 f 416.630.4782
va3design.com

BAYVIEW WELLINGTON		CONST NOTE	
project name	GREEN VALLEY EAST	municipality	BRADFORD
date	MAY 2016	project no.	16023
drawing by	RC	drawing no.	CN10
checked by	—	CONSTRUCTION NOTES	
scale	3/16" = 1'-0"	file name	16023-CN-A1
RICHARD — H:\ARCHIVE WORKING\2016\16023\BWP Units\CN NOTES\16023-CN-A1.dwg — Thu — Jun 11 2016 — 10:09 AM			


All drawings specifications, related documents and design are the copyright property of VA3 DESIGN. Reproduction of this property in whole or in part is strictly prohibited without VA3 DESIGN's written permission.

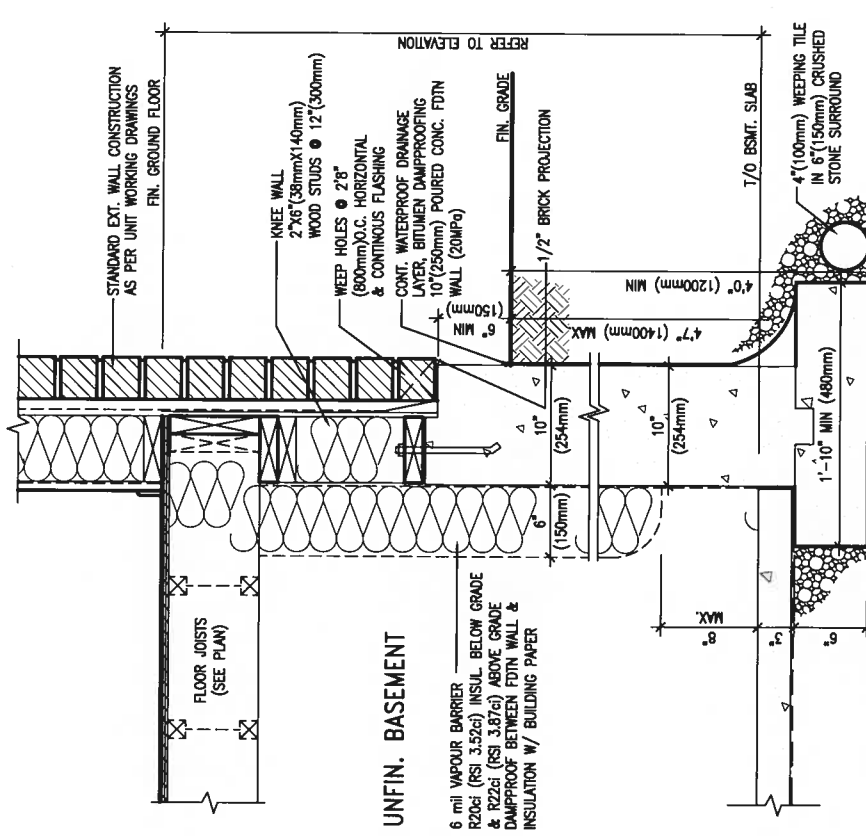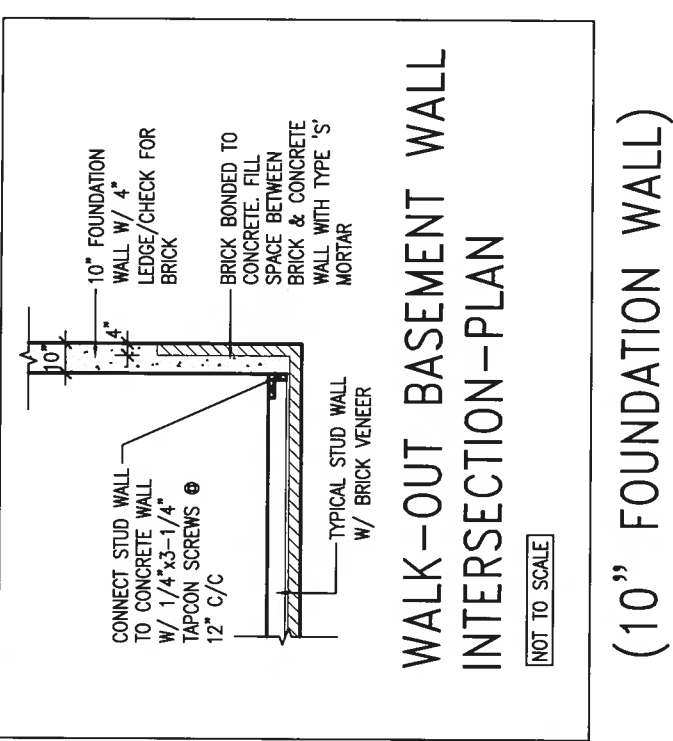


EW3.07x
PKG A1

WALL SECTION FOR GRADE TO BASEMENT
SLAB 4'7" (1400mm)
MAX. HEIGHT DIFFERENCE

SCALE: N.T.S.

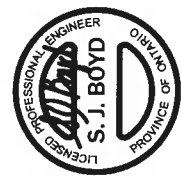[illegible]

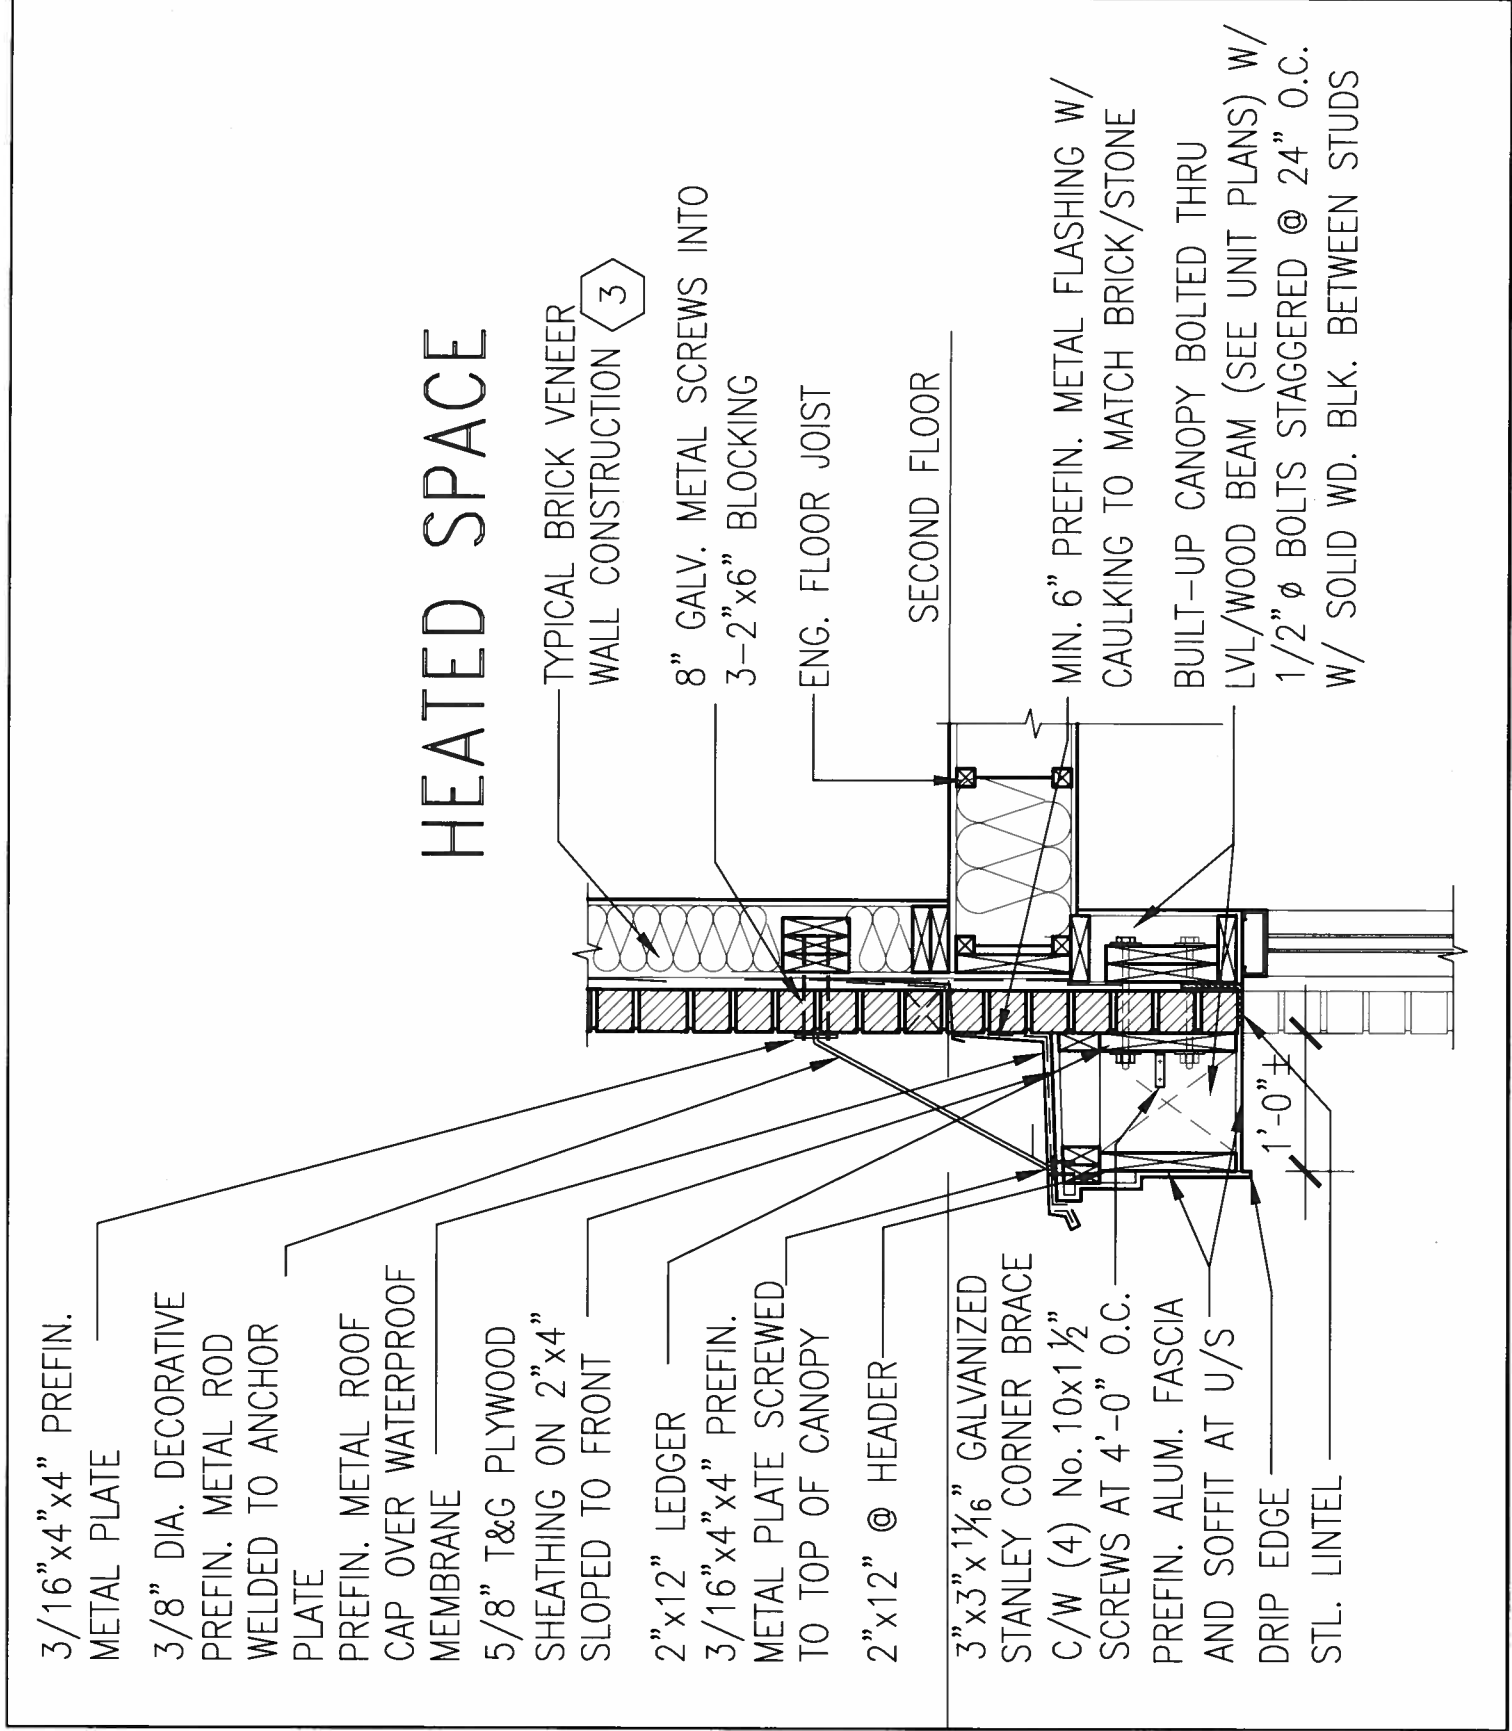


1

CN13

SECTION THROUGH CANOPY

W/ DECORATIVE ROD

SCALE 1/2" = 1'-0"

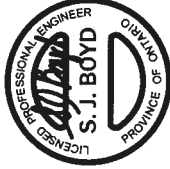

9	.	.	.	.	The undersigned has reviewed and taken responsibility for this design and has no further comments or requirements set out in the Ontario Building Code to be a Designer.	25591	BCN
8	.	.	.	.	qualification information		
7	.	.	.	.	Wellington Jno-Baptiste		
6	.	.	.	.	signature		
5	.	.	.	.	name		
4	.	.	.	.	registration information		
3	.	.	.	.	VAL3 Design Inc.	42658	
2	UPDATE TO 2018	JAN 11-18	RC		Contractor must verify all dimensions on the job and report any discrepancy to the Designer before proceeding with the work. All drawings and specifications are instruments of service and the property of the Designer which must be returned at the completion of the work. Drawings are not to be scaled.		
1	ISSUE FOR CLIENT REVIEW	AUG 04-17	RC				
no.	description	date	by				

VA3

DESIGN

255 Consumers Rd Suite 120
Toronto, ON M2J 1R4
t 416.630.2255 f 416.630.4782
vo3design.com

BAYVIEW WELLINGTON		CONST NOTE	
project name	GREEN VALLEY EAST	municipality	BRADFORD
project no.	16023	project no.	16023
date	MAY 2016	checked by	RC
drawn by	RC	scale	3/16" = 1'-0"
CONSTRUCTION NOTES		file name	16023-CN-A1
		drawing no.	CN13
RICHARD - H:\ARCHIVE\WORKING\2016\16023.BW\Units\CN NOTES\16023-CN-A1.dwg - Thu - Jan 11 2018 - 10:11 AM			

