

Use one form for each individual who reviews and takes responsibility for design activities with respect to the project.

A. Project Information					
Building number, street name Rideau 5 S42-5 Alt. 2nd FLR				Lot: Lot/con.	
Municipality Bradford		Postal code	Plan number/ other description		
B. Individual who reviews and takes responsibility for design activities					
Name David DaCosta			Firm gtaDesigns Inc.		
Street address 2985 Drew Road, Suite 202				Unit no.	Lot/con.
Municipality Mississauga		Postal code L4T 0A4	Province Ontario	E-mail dave@gtadesigns.ca	
Telephone number (905) 671-9800		Fax number (647) 494-9643		Cell number (416) 268-6820	
C. Design activities undertaken by individual identified in Section B. [Building Code Table 3.5.2.1 of Division C]					
☐ House ☒ HVAC – House ☐ Building Structural ☐ Small Buildings ☐ Building Services ☐ Plumbing – House ☐ Large Buildings ☐ Detection, Lighting and Power ☐ Plumbing – All Buildings ☐ Complex Buildings ☐ Fire Protection ☐ On-site Sewage Systems					
Description of designer's work			Model Certification		Project #:
					PJ-00204
					Layout #:
					JB-04609
Heating and Cooling Load Calculations		Main		Builder	Bayview Wellington
Air System Design		Alternate x		Project	Green Valley East
Residential mechanical ventilation Design Summary		Area Sq ft: 3330		Model	Rideau 5
Residential System Design per CAN/CSA-F280-12					S42-5 Alt. 2nd FLR
Residential New Construction - Forced Air				SB-12	Package A1
D. Declaration of Designer					
I, <u>David DaCosta</u> declare that (choose one as appropriate): (print name)					
☐ I review and take responsibility for the design work on behalf of a firm registered under subsection 3.2.4 Division C of the Building Code. I am qualified, and the firm is registered, in the appropriate classes/categories. Individual BCIN: _____ Firm BCIN: _____					
☒ I review and take responsibility for the design and am qualified in the appropriate category as an "other designer" under subsection 3.2.5 of Division C, of the Building Code. Individual BCIN: <u>32964</u> Basis for exemption from registration: <u>Division C 3.2.4.1. (4)</u>					
☐ The design work is exempt from the registration and qualification requirements of the Building Code. Basis for exemption from registration and qualification:					
I certify that:					
1. The information contained in this schedule is true to the best of my knowledge.					
2. I have submitted this application with the knowledge and consent of the firm.					
<u>April 3, 2018</u> Date			 Signature of Designer		

NOTE:

- For the purposes of this form, "individual" means the "person" referred to in Clause 3.2.4.7(1) d), of Division C, Article 3.2.5.1. of Division C and all other persons who are exempt from qualifications under Subsections 3.2.4 . and 3.2.5. of Division C.
- Schedule 1 does not require to be completed a holder of a license, temporary license, or a certificate of authorization, issued by the Ontario Association of Architects. Schedule 1 is also not required to be completed by a holder of a license to practise, a limited licence to practise, or a certificate of authorization, issued by the Association of Professional Engineers of Ontario.

Heat loss and gain calculation summary sheet				CSA-F280-M12 Standard Form No. 1	
These documents issued for the use of Bayview Wellington				Layout No.	
and may not be used by any other persons without authorization. Documents for permit and/or construction are signed in red.				JB-04609	
Building Location					
Address (Model): S42-5 Alt. 2nd FLR			Site: Green Valley East		
Model: Rideau 5			Lot:		
City and Province: Bradford			Postal code:		
Calculations based on					
Dimensional information based on:			VA3 Design Jan/2018		
Attachment: Detached			Front facing: East/West		Assumed? Yes
No. of Levels: 3		Ventilated? Included	Air tightness: 1961-Present (ACH=3.57)		Assumed? Yes
Weather location: Bradford			Wind exposure: Sheltered		
HRV? LifeBreath		RNC155	Internal shading: Light-translucent		Occupants: 6
Sensible Eff. at -25C 71%		Apparent Effect. at -0C 84%	Units: Imperial		Area Sq ft: 3330
Sensible Eff. at -0C 75%					
Heating design conditions			Cooling design conditions		
Outdoor temp -9.4 Indoor temp: 72 Mean soil temp: 48			Outdoor temp 86 Indoor temp: 75 Latitude: 44		
Above grade walls			Below grade walls		
Style A: As per OBC SB12 Package A1 R 22			Style A: As per OBC SB12 Package A1 R 20ci		
Style B: Existing Walls (When Applicable) R 12			Style B:		
Style C:			Style C:		
Style D:			Style D:		
Floors on soil			Ceilings		
Style A: As per Selected OBC SB12 Package A1			Style A: As per Selected OBC SB12 Package A1 R 60		
Style B:			Style B: As per Selected OBC SB12 Package A1 R 31		
Exposed floors			Style C:		
Style A: As per Selected OBC SB12 Package A1 R 31			Doors		
Style B:			Style A: As per Selected OBC SB12 Package A1 R 4.00		
Windows			Style B:		
Style A: As per Selected OBC SB12 Package A1 R 3.55			Style C:		
Style B: Existing Windows (When Applicable) R 1.99			Skylights		
Style C:			Style A: As per Selected OBC SB12 Package A1 R 2.03		
Style D:			Style B:		
Attached documents: As per Shedule 1		Heat Loss/Gain Caculations based on CSA-F280-12 Effective R-Values			
Notes: Residential New Construction - Forced Air					
Calculations performed by					
Name: David DaCosta			Postal code: L4T 0A4		
Company: gtaDesigns Inc.			Telephone: (905) 671-9800		
Address: 2985 Drew Road, Suite 202			Fax: (416) 268-6820		
City: Mississauga			E-mail dave@gtadesigns.ca		

Builder: **Bayview Wellington**

Date: **April 3, 2018**

Project: **Green Valley East**

Model: **S42-5 Alt. 2nd FLR**

System 1

I review and take responsibility for the design work and am qualified in the appropriate category as an "other designer" under Division C subsection 3.2.5. of the Building Code.

Individual BCIN: 32964

David DaCosta

David DaCosta

Project # **PJ-00204**

Layout # **JB-04609**

Page 3

DESIGN LOAD SPECIFICATIONS		AIR DISTRIBUTION & PRESSURE		FURNACE/AIR HANDLER DATA:		BOILER/WATER HEATER DATA:		A/C UNIT DATA:	
Level 1 Net Load	18,118 btu/h	Equipment External Static Pressure	0.5 "w.c.	Make	Amana	Make	Type	Amana	3.0 Ton
Level 2 Net Load	19,878 btu/h	Additional Equipment Pressure Drop	0.225 "w.c.	Model	AMEC960803BNA	Model		Cond.-----	3.0
Level 3 Net Load	19,468 btu/h	Available Design Pressure	0.275 "w.c.	Input Btu/h	80000	Input Btu/h		Coil -----	3.0
Level 4 Net Load	0 btu/h	Return Branch Longest Effective Length	300 ft	Output Btu/h	76800	Output Btu/h			
Total Heat Loss	57,465 btu/h	R/A Plenum Pressure	0.138 "w.c.	E.s.p.	0.50 " W.C.	Min.Output Btu/h	AWH		
Total Heat Gain	31,921 btu/h	S/A Plenum Pressure	0.14 "w.c.	Water Temp	deg. F.	Blower DATA:			
Combo System HL + 10%	63,211 Btu/h	Heating Air Flow Proportioning Factor	0.0204 cfm/btuh	AFUE	96%	Blower Speed Selected:	W2	Blower Type	ECM
Building Volume Vb	39388 ft³	Cooling Air Flow Proportioning Factor	0.0367 cfm/btuh	Aux. Heat				(Brushless DC OBC 12.3.1.5.(2))	
Ventilation Load	1,342 Btu/h.	R/A Temp	70 deg. F.	SB-12 Package	Package A1	Heating Check	1172 cfm	Cooling Check	1172 cfm
Ventilation PVC	95.4 cfm	S/A Temp	131 deg. F.						
Supply Branch and Grill Sizing		Diffuser loss	0.01 "w.c.	Temp. Rise>>>	61 deg. F.	Selected cfm>	1172 cfm	Cooling Air Flow Rate	1172 cfm

	Level 1														Level 2													
S/A Outlet No.	1	2	3	4											5	6	7	8	9	10	11	12	13	14				
Room Use	BASE	BASE	BASE	BASE											KIT	KIT	GRT	GRT	LAUN	FOY	WIC 2	STUDY	LIV/DIN	LIV/DIN				
Btu/Outlet	4530	4530	4530	4530											2060	2060	1863	1863	3410	2750	1193	2062	1309	1309				
Heating Airflow Rate CFM	92	92	92	92											42	42	38	38	70	56	24	42	27	27				
Cooling Airflow Rate CFM	18	18	18	18											83	83	67	67	55	45	24	66	63	63				
Duct Design Pressure	0.13	0.13	0.13	0.13	0.13	0.13	0.13	0.13	0.13	0.13	0.13	0.13	0.13	0.13	0.13	0.13	0.13	0.13	0.13	0.13	0.13	0.13	0.13	0.13	0.13	0.13	0.13	
Actual Duct Length	44	51	30	21											51	54	63	52	41	33	22	11	5	42				
Equivalent Length	120	160	120	70	70	70	70	70	70	70	70	70	70	70	110	150	110	180	120	120	90	100	80	70	70	70	70	
Total Effective Length	164	211	150	91	70	70	70	70	70	70	70	70	70	70	161	204	173	232	161	153	112	111	85	112	70	70	70	
Adjusted Pressure	0.08	0.06	0.09	0.14	0.19	0.19	0.19	0.19	0.19	0.19	0.19	0.19	0.19	0.19	0.08	0.06	0.08	0.06	0.08	0.08	0.12	0.12	0.15	0.12	0.19	0.19	0.19	
Duct Size Round	6	6	6	6											6	6	6	6	6	6	4	5	5	5				
Outlet Size	4x10	4x10	4x10	4x10	4x10	4x10	4x10	4x10	4x10	4x10	4x10	4x10	4x10	4x10	4x10	4x10	4x10	4x10	4x10	4x10	3x10	3x10	3x10	3x10	4x10	4x10	4x10	
Trunk	C	B	A	D											C	B	B	B	A	E	E	D	A	A				

	Level 3														Level 4													
S/A Outlet No.	15	16	17	18	19	20	21	22	23	24	25	26	27	28														
Room Use	MAST	MAST	ENS	WC	BED 2	BATH	BED 3	BED 3	BED 4	BED 4	ENS 2	BED 5	WIC	ENS 3														
Btu/Outlet	1657	1657	1250	902	1323	1685	2154	2154	1917	1917	766	1483	496	108														
Heating Airflow Rate CFM	34	34	25	18	27	34	44	44	39	39	16	30	10	2														
Cooling Airflow Rate CFM	49	49	30	26	30	15	49	49	63	63	13	41	5	2														
Duct Design Pressure	0.13	0.13	0.13	0.13	0.13	0.13	0.13	0.13	0.13	0.13	0.13	0.13	0.13	0.13	0.13	0.13	0.13	0.13	0.13	0.13	0.13	0.13	0.13	0.13	0.13	0.13	0.13	
Actual Duct Length	65	75	71	76	64	63	53	50	52	46	42	51	62	31														
Equivalent Length	125	190	160	140	120	135	140	120	140	120	100	130	140	160	70	70	70	70	70	70	70	70	70	70	70	70	70	
Total Effective Length	190	265	231	216	184	198	193	170	192	166	142	181	202	191	70	70	70	70	70	70	70	70	70	70	70	70	70	
Adjusted Pressure	0.07	0.05	0.06	0.06	0.07	0.07	0.07	0.08	0.07	0.08	0.09	0.07	0.06	0.07	0.19	0.19	0.19	0.19	0.19	0.19	0.19	0.19	0.19	0.19	0.19	0.19	0.19	
Duct Size Round	5	5	4	4	4	4	6	6	6	6	3	5	3	2														
Outlet Size	3x10	3x10	3x10	3x10	3x10	3x10	4x10	4x10	4x10	4x10	3x10	3x10	3x10	3x10	4x10	4x10	4x10	4x10	4x10	4x10	4x10	4x10	4x10	4x10	4x10	4x10	4x10	
Trunk	C	B	B	B	A	A	D	D	E	E	D	A	C	A														

Return Branch And Grill Sizing												Return Trunk Duct Sizing					Supply Trunk Duct Sizing				
Grill Pressure Loss												Grill Pressure Loss					Grill Pressure Loss				
R/A Inlet No.	1R	2R	3R	4R	5R	6R	7R	8R	9R	10R	11R	Trunk	CFM	Press.	Round	Rect. Size	Trunk	CFM	Press.	Round	Rect. Size
Inlet Air Volume CFM	185	440	150	150	97	150						Drop	1172	0.05	17.0	24x12	A	775	0.05	14.5	24x8 18x10
Duct Design Pressure	0.12	0.12	0.12	0.12	0.12	0.12	0.12	0.12	0.12	0.12	0.12	Z	1172	0.05	17.0	26x10 22x12	B	288	0.05	10.0	12x8 10x10
Actual Duct Length	13	28	41	41	51	55						Y	335	0.05	11.0	14x8 10x10	C	178	0.06	8.5	8x8
Equivalent Length	110	165	155	165	160	170	50	50	50	50	50	X	247	0.06	9.5	10x8	D	397	0.07	11.0	14x8 10x10
Total Effective Length	123	193	196	206	211	225	50	50	50	50	50	W					E	159	0.07	7.5	8x8
Adjusted Pressure	0.10	0.06	0.06	0.06	0.06	0.05	0.24	0.24	0.24	0.24	0.24	V					F				
Duct Size Round	8.0	11.5	8.0	8.0	6.0	8.0						U					G				
Inlet Size	FLC	8	8	8	8	8						T					H				
" "	x	x	x	x	x	x	x	x	x	x	x	S					I				
Inlet Size	9x6	30	14	14	14	14						R					J				
												O					K				
Trunk	Y	Z	Z	X	X	Y															

2012 OBC

Builder: Bayview Wellington

Date: April 3, 2018

Project: Green Valley East

Model: Rideau 5 S42-5 Alt. 2nd FLR

System 1

Weather Data Bradford 44 -9.4 86 22 48.2

Heat Loss ^T 81.4 deg. F Ht gain ^T 11 deg. F GTA: 3330

Project # PJ-00204
Layout # JB-04609

Level 1

Run ft. exposed wall A	175	A	A	A	A	A	A	A	A	A	A	A	A
Run ft. exposed wall B	B	B	B	B	B	B	B	B	B	B	B	B	B
Ceiling height	3.6	AG	3.6	AG	3.6	AG	3.6	AG	3.6	AG	3.6	AG	3.6
Floor area	1382	Area	Area	Area	Area	Area	Area	Area	Area	Area	Area	Area	Area
Exposed Ceilings A	A	A	A	A	A	A	A	A	A	A	A	A	A
Exposed Ceilings B	B	B	B	B	B	B	B	B	B	B	B	B	B
Exposed Floors	Flr	Flr	Flr	Flr	Flr	Flr	Flr	Flr	Flr	Flr	Flr	Flr	Flr
Gross Exp Wall A	635												
Gross Exp Wall B													

Components	R-Values	Loss	Gain	Loss	Gain	Loss	Gain	Loss	Gain	Loss	Gain	Loss	Gain	Loss	Gain	Loss	Gain
North Shaded	3.55	22.93	10.91	6	138	65											
East/West	3.55	22.93	27.35	29	665	793											
South	3.55	22.93	20.89	6	138	125											
WOB Windows	3.15	25.84	28.32														
Skylight	2.03	40.10	88.23														
Doors	4.00	20.35	2.75	21	427	58											
Net exposed walls A	21.12	3.85	0.52	573		299											
Net exposed walls B	14.49	5.62	0.76														
Exposed Ceilings A	59.22	1.37	0.64														
Exposed Ceilings B	22.86	3.56	1.66														
Exposed Floors	29.80	2.73	0.17														
Foundation Conductive Heatloss	On Grade () or Above			7267													
Total Conductive	Heat Loss			8634													
Air Leakage	Heat Loss/Gain	1.0624	0.0394	9173		53											
Ventilation	Case 1	0.08	0.07														
	Case 2	14.07	11.88														
	Case 3	x	0.04	0.07	311	98											
Heat Gain People			239														
Appliances Loads	1 = .25 percent		5597														
Duct and Pipe loss			10%														
Level 1 HL Total	18,118		Total HL for per room	18118													
Level 1 HG Total	1,938		Total HG per room x 1.3		1938												

Level 2

Run ft. exposed wall A	37	A	KIT	33	A	GRT	32	A	LAUN	22	A	FOY	11	A	WIC 2	21	A	STUDY	20	A	LIV/DIN	A	A	A	A
Run ft. exposed wall B	B	B	B	B	B	B	B	B	B	B	B	B	B	B	B	B	B	B	B	B	B	B	B	B	B
Ceiling height	10.0		10.0		10.0		12.0		11.0		11.0		11.0		10.0		10.0		10.0		10.0		10.0		10.0
Floor area	303	Area	226	Area	196	Area	83	Area	28	Area	161	Area	378	Area	Area	Area	Area	Area	Area	Area	Area	Area	Area	Area	Area
Exposed Ceilings A	A	A	5	A	A	A	A	A	A	A	A	A	A	A	A	A	A	A	A	A	A	A	A	A	A
Exposed Ceilings B	B	B	B	B	B	B	B	B	B	B	B	B	B	B	B	B	B	B	B	B	B	B	B	B	B
Exposed Floors	Flr	Flr	Flr	Flr	Flr	Flr	Flr	Flr	Flr	Flr	Flr	Flr	Flr	Flr	Flr	Flr	Flr	Flr	Flr	Flr	Flr	Flr	Flr	Flr	Flr
Gross Exp Wall A	370		330		384		242		121		210		200												
Gross Exp Wall B																									

Components	R-Values	Loss	Gain	Loss	Gain	Loss	Gain	Loss	Gain	Loss	Gain	Loss	Gain	Loss	Gain	Loss	Gain	Loss	Gain	Loss	Gain	Loss	Gain	Loss	Gain
North Shaded	3.55	22.93	10.91	61	1399	1669				28	642	306				12	275	131							
East/West	3.55	22.93	27.35							28	642	766								24	550	656			
South	3.55	22.93	20.89																						
Existing Windows	1.99	40.90	22.15																						
Skylight	2.03	40.10	88.23																						
Doors	4.00	20.35	2.75																						
Net exposed walls A	17.03	4.78	0.65	309	1477	200				274	1310	177				351	1678	227		197	942	127			
Net exposed walls B	8.50	9.58	1.29																						
Exposed Ceilings A	59.22	1.37	0.64							5	7	3													
Exposed Ceilings B	22.86	3.56	1.66																						
Exposed Floors	29.80	2.73	0.17																						
Foundation Conductive Heatloss	On Grade () or Above		x																						
Total Conductive	Heat Loss									2876		1868				2601		1252		2380		1919		832	
Air Leakage	Heat Loss/Gain	0.3967	0.0394							1141	74					1032	49			944	16	761	33		
Ventilation	Case 1	0.03	0.07																						
	Case 2	14.07	11.88																						
	Case 3	x	0.04	0.07						104	136					94	91			86	30	69	61		
Heat Gain People			239																						
Appliances Loads	1 = .25 percent		5597							1.0		1399				1.0		1399		0.5		700		0.5	
Duct and Pipe loss			10%																						
Level 2 HL Total	19,878		Total HL for per room	4120		4520				3726		3629				3410		1510		2750		1193		654	
Level 2 HG Total	16,748		Total HG per room x 1.3																						

I review and take responsibility for the design work and am qualified in the appropriate category as an "other designer" under

Division C subsection 3.2.5. of the Building Code. Individual BCIN:

32964

Dave DaCosta

Dave DaCosta

SB-12 Package

Package A1

Total Heat Loss	57,465	btu/h
Total Heat Gain	31,921	btu/h

I review and take responsibility for the design work and am qualified in the appropriate category as an "other designer" under Division C subsection 3.2.5. of the Building Code.

Individual BCIN: 32964



David DaCosta

Package: Package A1
Project: Bradford
Model: S42-5 Alt. 2nd FLR

RESIDENTIAL MECHANICAL VENTILATION DESIGN SUMMARY

For systems serving one dwelling unit & conforming to the Ontario Building Code, O.reg 332/12

Location of Installation	
Lot #	Plan #
Township	Bradford
Roll #	Permit #
Address	

Builder	
Name	Bayview Wellington
Address	
City	
Tel	Fax

Installing Contractor	
Name	
Address	
City	
Tel	Fax

Combustion Appliances 9.32.3.1(1)		
a)	x	Direct vent (sealed combustion) only
b)		Positive venting induced draft (except fireplaces)
c)		Natural draft, B-vent or induced draft fireplaces
d)		Solid fuel (including fireplaces)
e)		No combustion Appliances

Heating System		
x	Forced air	Forced air
		Non forced air
		Electric space heat (if over 10% of heat load)

House Type 9.32.3.1(2)		
I	x	Type a) or b) appliances only, no solid fuel
II		Type I except with solid fuel (including fireplace)
III		Any type c) appliance
IV		Type I or II either electric space heat
Other		Type I, II or IV no forced air

System Design Option		
1	Exhaust only / forced air system	Exhaust only / forced air system
2		HRV WITH DUCTING / forced air system
3	x	HRV simplified connection to forced air system
4		HRV full ducting/not coupled to forced air system
		Part 6 design

Total Ventilation Capacity 9.32.3.3(1)				
Bsmt & Master Bdrm	2 @	21.2 cfm	42.4	cfm
Other Bedrooms	4 @	10.6 cfm	42.4	cfm
Bathrooms & Kitchen	6 @	10.6 cfm	63.6	cfm
Other rooms	6 @	10.6 cfm	63.6	cfm
Total			212	

Principal Ventilation Capacity 9.32.3.4(1)				
Master bedroom	1 @	31.8 cfm	31.8	cfm
Other bedrooms	4 @	15.9 cfm	63.6	cfm
Total			95.4	

 
Principal Exhaust Fan Capacity				
Make	Model		Location	
LifeBreath	RNC155		Base	
132 cfm			Sones	or Equiv.

Heat Recovery Ventilator				
Make	LifeBreath			
Model	RNC155			
	132 cfm high		80 cfm low	
Sensible efficiency @ -25 deg C			71%	
Sensible efficiency @ 0 deg C			75%	

Note: Installer to balance HRV/ERV to within 10 percent of PVC

Supplemental Ventilation Capacity		
Total ventilation capacity	212.0	
Less principal exhaust capacity	95.4	
REQUIRED supplemental vent. Capacity	116.6	cfm

Supplemental Fans 9.32.3.5.			
Location	cfm	Model	Sones
Ens	50	XB50	0.3
Bath	50	XB50	0.3
Ens 2	50	XB50	0.3
all fans HVI listed		Make	Broan or Equiv.

Designer Certification			
I hereby certify that this ventilation system has been designed in accordance with the Ontario Building Code.			
Name	David DaCosta		
Signature			
HRAI #	5190	BCIN #	32964
Date	April 3, 2018		



2985 Drew Road, Suite 202, Mississauga, Ontario
 L4T 0A4 Tel: 905-671-9800 Fax: 647-494-9643
 e-mail dave@gtadesigns.ca

Energy Efficiency Design Summary: Prescriptive Method (Building Code Part 9, Residential)

Page 7
 Project # PJ-00204
 Layout # JB-04609

This form is used by a designer to demonstrate that the energy efficiency design of a house complies with the building code using the prescriptive method described in Subsection 3.1.1. of SB-12. This form is applicable where the ratio of gross area of windows/sidelights/skylights/glazing in doors and sliding glass doors to the gross area of peripheral walls is not more than 22%.

For use by Principal Authority

Application No:

Model/Certification Number

A. Project Information

Building number, street name Rideau 5 S42-5 Alt. 2nd FLR		Unit number	Lot/Con
Municipality Bradford	Postal code	Reg. Plan number / other description	

B. Prescriptive Compliance [indicate the building code compliance package being employed in the house design]

SB-12 Prescriptive (input design package):

Package A1

Table: 3.1.1.2.A

C. Project Design Conditions

Climatic Zone (SB-1):	Heat. Equip. Efficiency	Space Heating Fuel Source		
☒ Zone 1 (< 5000 degree days) ☐ Zone 2 (≥ 5000 degree days)	☒ ≥ 92% AFUE ☐ ≥ 84% < 92% AFUE	☒ Gas ☐ Oil	☐ Propane ☐ Electric	☐ Solid Fuel ☐ Earth Energy
Ratio of Windows, Skylights & Glass (W, S & G) to Wall Area		Other Building Characteristics		
Area of Walls = <u>377.01</u> m ² or <u>4058.2</u> ft ²	W, S & G % = <u>13%</u>	☐ Log/Post&Beam ☐ Slab-on-ground ☒ Air Conditioning ☐ Air Sourced Heat Pump (ASHP) ☐ Ground Source Heat Pump (GSHP)		
Area of W, S & G = <u>47.565</u> m ² or <u>512.0</u> ft ²	Utilize Window Averaging ☐ Yes ☒ No	☐ ICF Above Grade ☐ Walkout Basement ☐ Combo Unit		

D. Building Specifications [provide values and ratings of the energy efficiency components proposed]

Energy Efficiency Substitutions			
☐ ICF (3.1.1.2.(5) & (6) / 3.1.1.3.(5)) ☐ Combined space heating and domestic water heating systems (3.1.1.2(7) / 3.1.1.3.(7))			
☐ Airtightness substitution(s) Airtightness test required (Refer to Design Guide Attached)	☐ Table 3.1.1.4.B Required:		Permitted Substitution:
	☐ Table 3.1.1.4.C Required:		Permitted Substitution:
Building Component	Minimum RSI/R-Values or Maximum U-Value ¹		Efficiency Ratings
Thermal Insulation	Nominal	Effective	Windows & Doors Provide U-Value ⁽¹⁾ or ER rating
Ceiling with Attic Space	60		Windows/Sliding Glass Doors 1.6
Ceiling without Attic Space	31		Skylights 2.8
Exposed Floor	31		Mechanicals
Walls Above Grade	22		Heating Equip.(AFUE) 96%
Basement Walls	20.0ci		HRV Efficiency (SRE% at 0°C) 75%
Slab (all >600mm below grade)	x		DHW Heater (EF) 0.80
Slab (edge only ≤600mm below grade)	10		DWHR (CSA B55.1 (min. 42% efficiency)) #Showers 2
Slab (all ≤600mm below grade, or heated)	10		Combined Heating System

(1) U value to be provided in either W/(m²·K) or Btu/(h·ft²·F) but not both.

E. Designer(s) [name(s) & BCIN(s), if applicable, of person(s) providing information herein to substantiate that design meets building code]

Name David DaCosta	BCIN 32964	Signature
------------------------------	----------------------	---------------

Package: Package A1 System: System 1
Project: Bradford Model: S42-5 Alt. 2nd FLR

Air Leakage Calculations

Building Air Leakage Heat Loss				
B	LRairh	Vb	HL^T	HLleak
0.018	0.318	39388	81.4	18346

Building Air Leakage Heat Gain				
B	LRairh	Vb	HG^T	HG Leak
0.018	0.079	39388	11	614

Air Leakage Heat Loss/Gain Multiplier Table (Section 11)				
Level	Level Factor (LF)	Building Air	Level Conductive Heat Loss	Air Leakage Heat Loss Multiplier
Level 1	0.5	18346	8634	1.0624
Level 2	0.3		13875	0.3967
Level 3	0.2		14737	0.2490
Level 4	0		0	0.0000

Levels			
1	2	3	4
(LF)	(LF)	(LF)	(LF)
1.0	0.6	0.5	0.4
	0.4	0.3	0.3
		0.2	0.2
			0.1

HG LEAK		Air Leakage Heat Gain	
	614		0.0394
BUILDING CONDUCTIVE HEAT GAIN			15578

Levels this Dwelling	
3	

Ventilation Calculations

Ventilation Heat Loss

Ventilation Heat Loss				
C	PVC	HL^T	(1-E) HRV	HLbvent
1.08	95.4	81.4	0.16	1342

Ventilation Heat Gain

Ventilation Heat Gain			
C	PVC	HG^T	HGbvent
1.1	95.4	11	1133

Case 1

Ventilation Heat Loss (Exhaust only Systems)

Case 1 - Exhaust Only				
Level	LF	HLbvent	LVL Cond. HL	Multiplier
Level 1	0.5	1342	8634	0.08
Level 2	0.3		13875	0.03
Level 3	0.2		14737	0.02
Level 4	0		0	0.00

Case 1

Ventilation Heat Gain (Exhaust Only Systems)

Case 1 - Exhaust Only		Multiplier	
HGbvent	1133	0.07	
Building	15578		

Case 2

Ventilation Heat Loss (Direct Ducted Systems)

C	HL^T	(1-E) HRV	Multiplier
1.08	81.4	0.16	14.07

Case 2

Ventilation Heat Gain (Direct Ducted Systems)

C	HG^T	Multiplier
1.08	11	11.88

Case 3

Ventilation Heat Loss (Forced Air Systems)

HLbvent		Multiplier
Total Ventilation Load	1342	0.04

Case 3

Ventilation Heat Gain (Forced Air Systems)

Vent Heat Gain		Multiplier
HGbvent	HG*1.3	1133
1133	1	

Foundation Conductive Heatloss Level 1

2130 Watts 7267 Btu/h

Foundation Conductive Heatloss Level 2

Watts Btu/h


Envelope Air Leakage Calculator


Supplemental tool for CAN/CSA-F280


Weather Station Description				
Province:	Ontario ▼			
Region:	Bradford ▼			
Weather Station Location:	Open flat terrain, grass ▼			
Anemometer height (m):	10			
Local Shielding				
Building Site:	Suburban, forest ▼			
Walls:	Heavy ▼			
Flue:	Heavy ▼			
Highest Ceiling Height (m):	6.59			
Building Configuration				
Type:	Detached			
Number of Stories:	Two			
Foundation:	Full			
House Volume (m ³):	1115.47			
Air Leakage/Ventilation				
Air Tightness Type:	Present (1961-) (ACH=3.57)			
Custom BDT Data:	ELA @ 10 Pa. ▼ 322.44 cm ²			
	3.57 ACH @ 50 Pa			
Mechanical Ventilation (L/s):	Total Supply:		Total Exhaust:	
	47.7		47.7	
Flue #:	#1	#2	#3	#4
Diameter (mm):	0	0	0	0
Heating Air Leakage Rate (ACH/H):		0.318		
Cooling Air Leakage Rate (ACH/H):		0.079		



Residential Foundation Thermal Load Calculator


Supplemental tool for CAN/CSA-F280

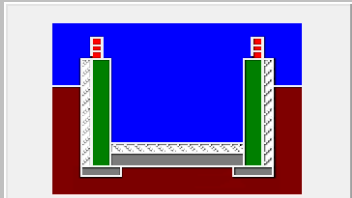Weather Station Description		
Province:	Ontario	▼
Region:	Bradford	▼
Site Description		
Soil Conductivity:	High conductivity: moist soil	▼
Water Table:	Normal (7-10 m, 23-33 Ft)	▼
Foundation Dimensions		
Floor Length (m):	20.37	 Insulation Configuration
Floor Width (m):	6.30	
Exposed Perimeter (m):	53.34	
Wall Height (m):	2.74	
Depth Below Grade (m):	1.64	
Window Area (m ²):	3.81	
Door Area (m ²):	1.95	
Radiant Slab		
Heated Fraction of the Slab:	0	
Fluid Temperature (°C):	33	
Design Months		
Heating Month	1	
Foundation Loads		
Heating Load (Watts):		2130

 	FLEX DUCT		LOW/HIGH WALL/KICK SUPPLY DIFFUSER		DUCT CONNECTION TO JOIST LINING		RETURN AIR GRILLE (SIZE INDICATED ON DRAWING)	S.A.	SUPPLY AIR
	RIGID ROUND DUCT		HRV EXHAUST GRILLE		RETURN AIR PIPE RISER		RETURN AIR RISER UP TO FLOOR ABOVE	R.A.	RETURN AIR
	SUPPLY DIFFUSER		SUPPLY AIR PIPE RISER VOLUME DAMPER		RETURN ROUND DUCT		RETURN AIR FROM BASEMENT SECOND FLOOR		THERMOSTAT
									PRINCIPAL EXHAUST FAN SWITCH W/R & PRINCIPAL EXHAUST FAN

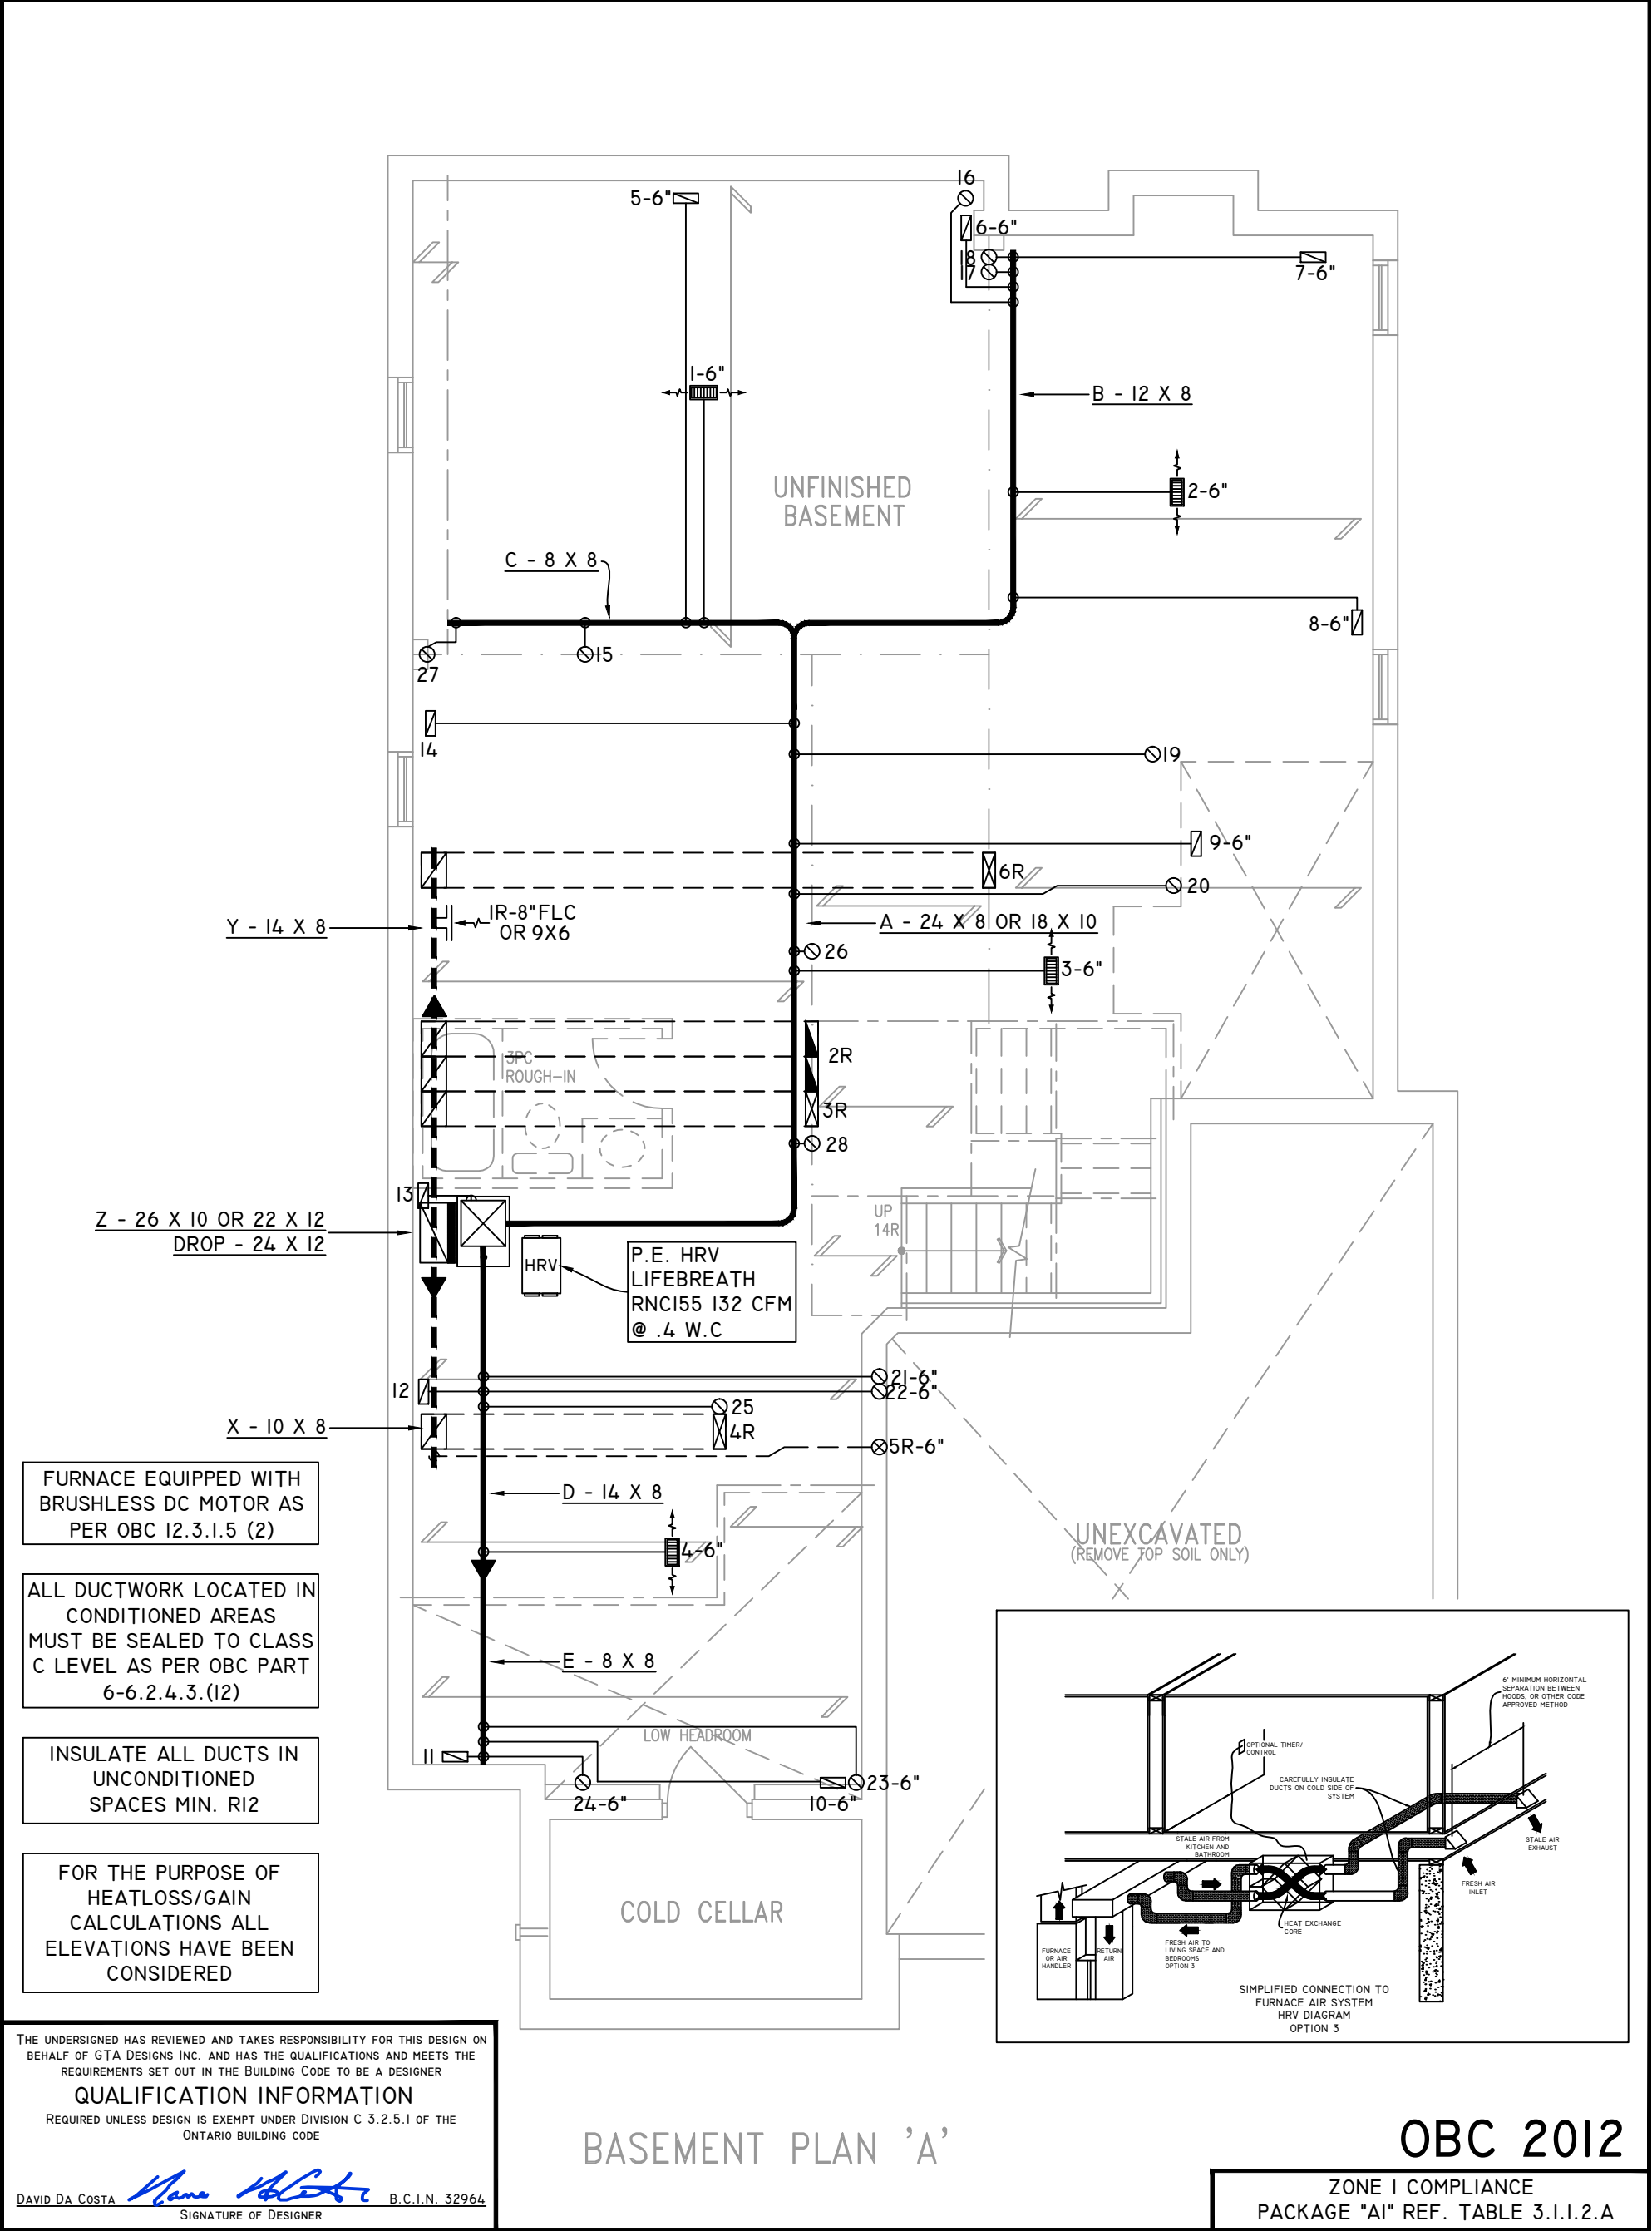

  	FLEX DUCT		LOW/HIGH WALL/KICK SUPPLY DIFFUSER		DUCT CONNECTION TO JOIST LINING		RETURN AIR GRILLE (SIZE INDICATED ON DRAWING)	S.A.	SUPPLY AIR
	RIGID ROUND DUCT		HRV EXHAUST GRILLE		RETURN AIR PIPE RISER		RETURN AIR RISER UP TO FLOOR ABOVE	R.A.	RETURN AIR
	SUPPLY DIFFUSER		SUPPLY AIR PIPE RISER		RETURN ROUND DUCT		RETURN AIR FROM BASEMENT SECOND FLOOR		THERMOSTAT
			VOLUME DAMPER						PRINCIPAL EXHAUST FAN SWITCH
									W/R & PRINCIPAL EXHAUST FAN

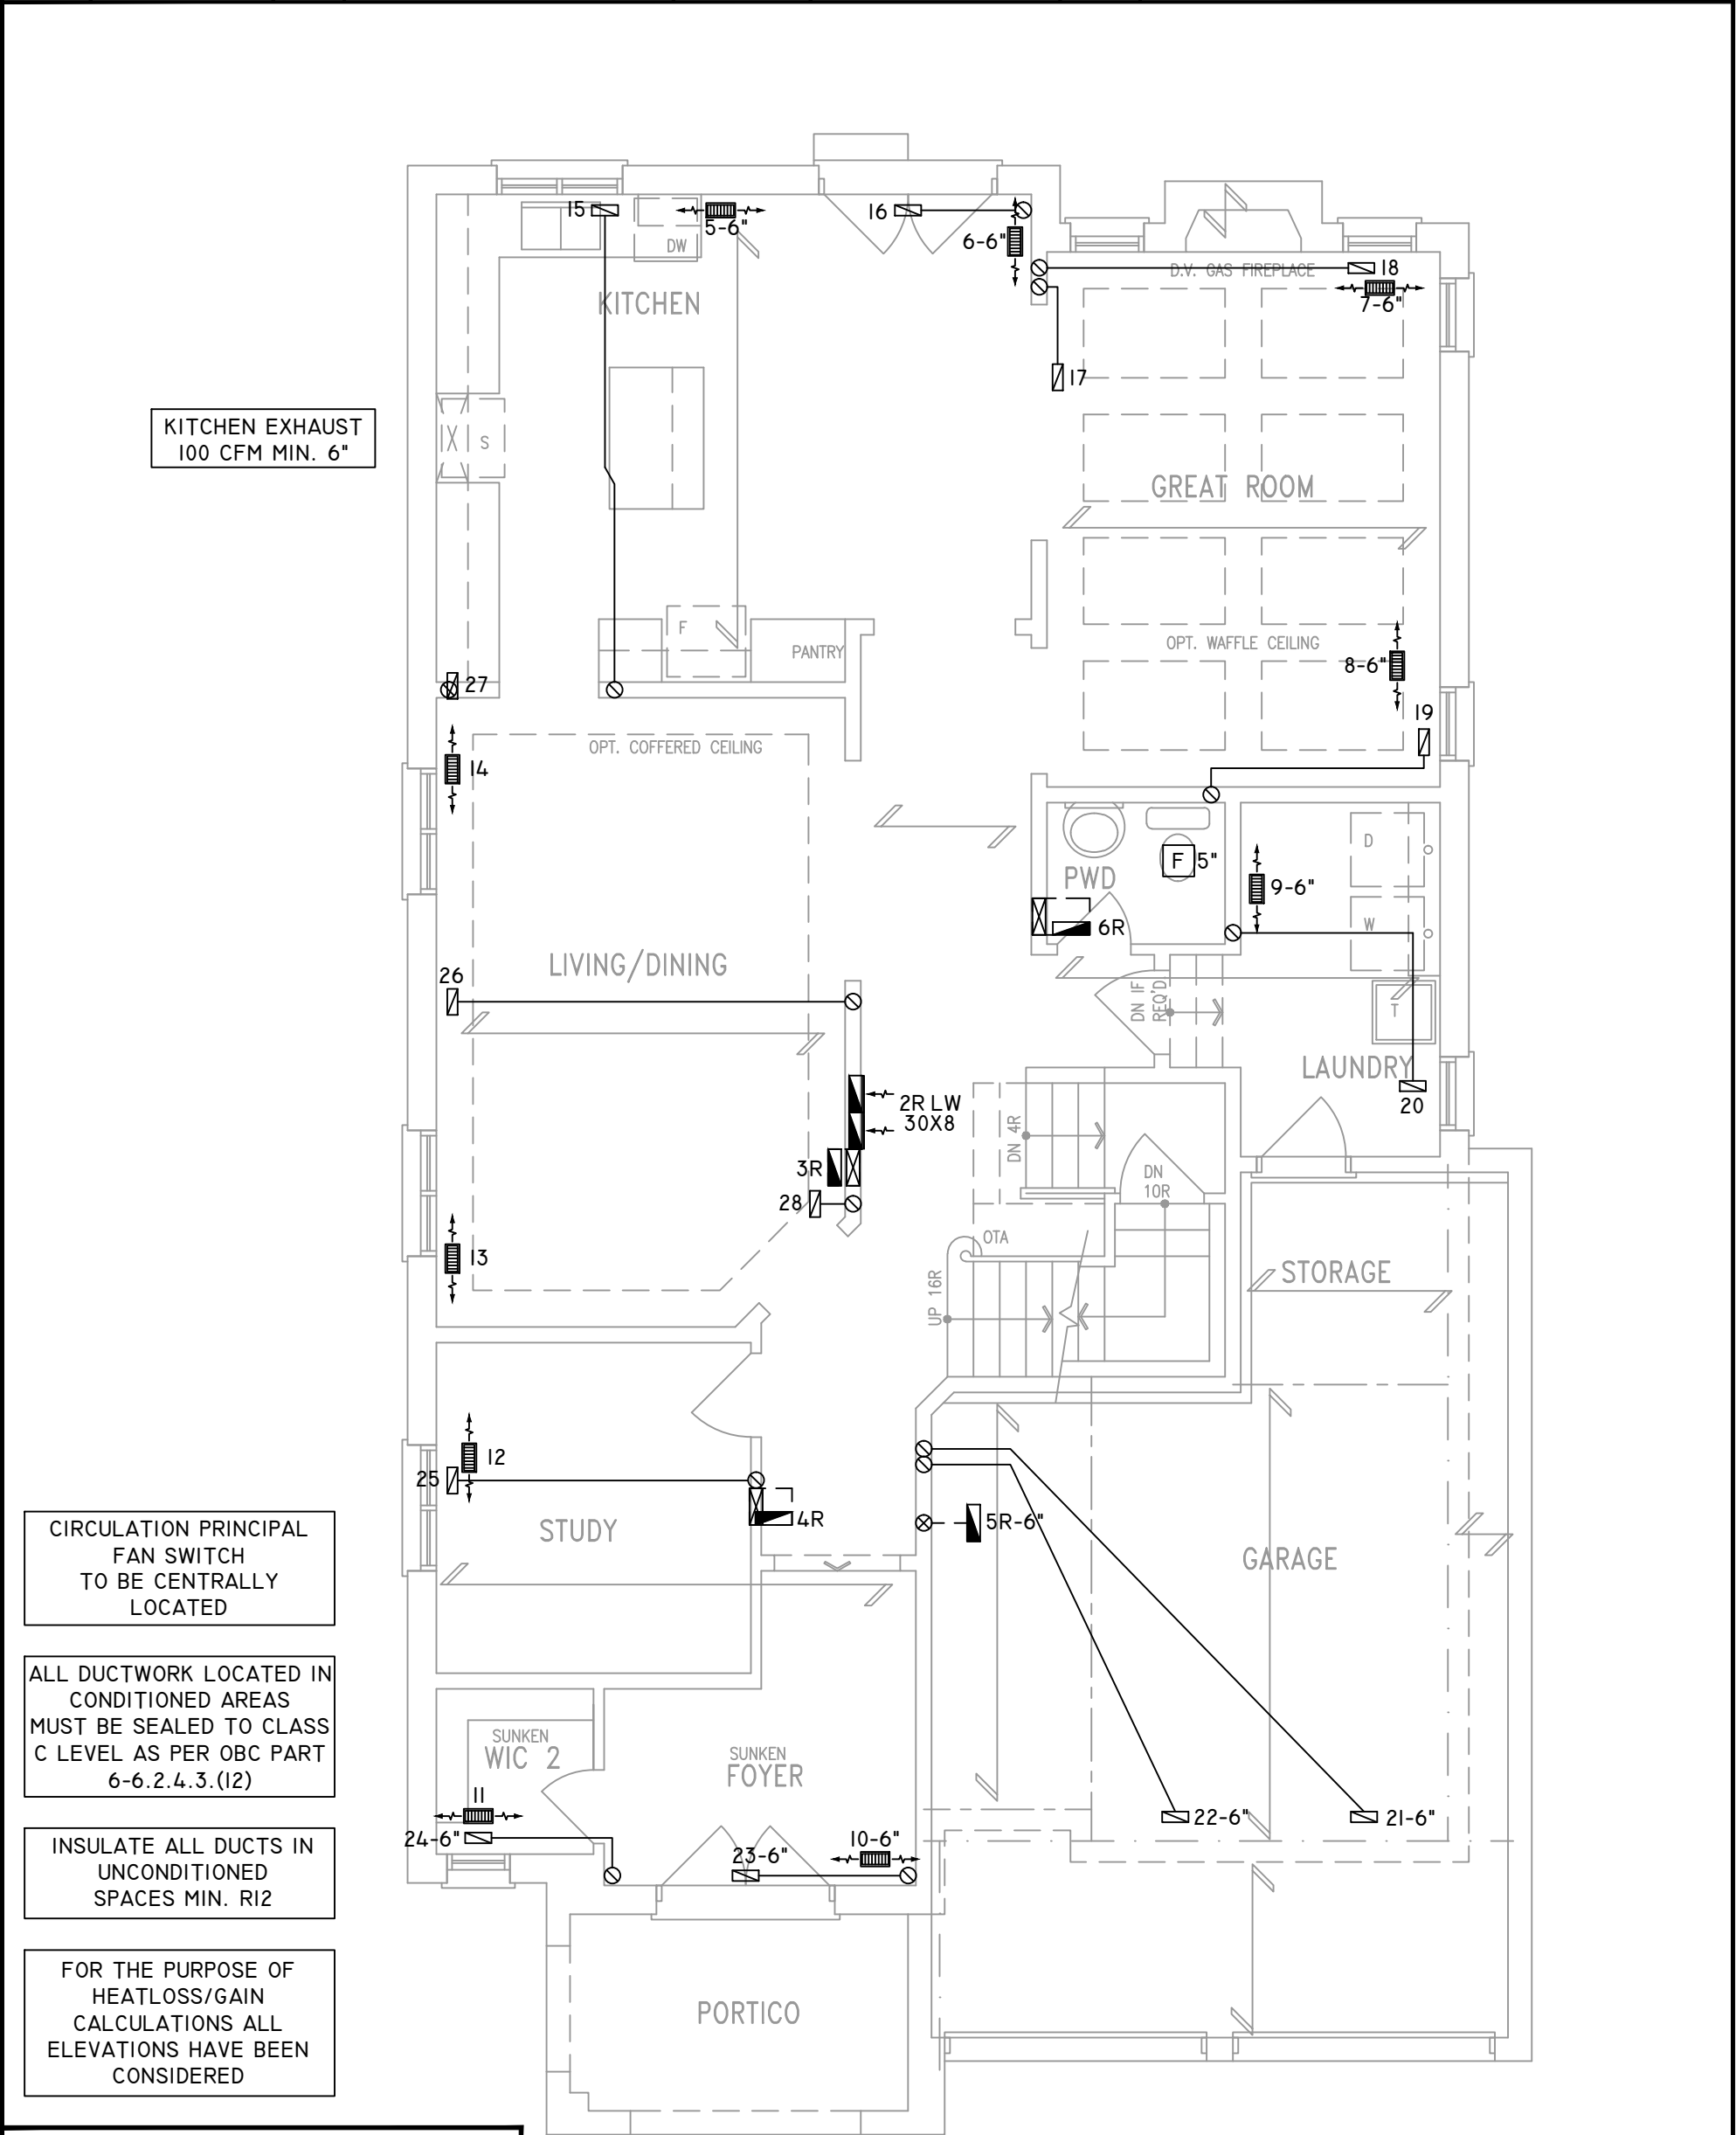

THE UNDERSIGNED HAS REVIEWED AND TAKES RESPONSIBILITY FOR THIS DESIGN ON BEHALF OF GTA DESIGNS INC. AND HAS THE QUALIFICATIONS AND MEETS THE REQUIREMENTS SET OUT IN THE BUILDING CODE TO BE A DESIGNER	
QUALIFICATION INFORMATION	
REQUIRED UNLESS DESIGN IS EXEMPT UNDER DIVISION C 3.2.5.1 OF THE ONTARIO BUILDING CODE	
DAVID DA COSTA	
SIGNATURE OF DESIGNER	
B.C.I.N. 32964	

GROUND FLOOR PLAN 'A'

OBC 2012

ZONE I COMPLIANCE
PACKAGE "A1" REF. TABLE 3.1.1.2.A

NOTES
INSTALLATION TO COMPLY WITH THE LATEST ONTARIO BUILDING CODE.
ALL SUPPLY OUTLETS TO BE 5" DIA. UNLESS OTHERWISE SPECIFIED.
PROVIDE BALANCING DAMPERS ON ALL BRANCHES.
ALL R/A PARTITIONS 6" (FIRST FLOOR ONLY)
INSULATE DUCTS IN UNCONDITIONED SPACES R12 UNDERCUT ALL DOORS 1" MIN.
CONTRACTOR MUST WORK FROM APPROVED PLANS.
ANY ALTERATIONS TO THIS ORIGINAL PLAN ARE NOT THE RESPONSIBILITY OF GTA DESIGNS.
GTA DESIGNS MUST BE CONSULTED IF KITCHEN EXHAUST FAN EXCEEDS 700 CFM DEPRESSURIZATION MAY OCCUR WITH IN THE DWELLING.




2985 DREW ROAD
SUITE 202,
MISSISSAUGA, ONT.
L4T 0A4 TEL: 905-671-9800
EMAIL: DAVE@GTADESIGNS.CA
WEB: WWW.GTADESIGNS.CA


HEAT-LOSS	57,465	BTU/HR.
UNIT MAKE	AMANA	OR EQUAL.
UNIT MODEL	AMEC960803BNA	OR EQUAL.
UNIT HEATING INPUT	80,000	BTU/HR.
UNIT HEATING OUTPUT	76,800	BTU/HR.
A/C COOLING CAPACITY	3.0	TONS.
FAN SPEED	1172	CFM

# OF RUNS	S/A	R/A	FANS
3RD FLOOR			
2ND FLOOR	14	4	4
1ST FLOOR	10	1	2
BASEMENT	4	1	

FLOOR PLAN: GROUND FLOOR	
DRAWN BY: AM	CHECKED: DD
LAYOUT NO. JB-04609	SGFT 3330
	DRAWING NO. M2

 DATE:	APRIL 3, 2018
CLIENT:	BAYVIEW WELLINGTON
MODEL:	S42-5 ALT. 2ND FLR RIDEAU 5
PROJECT:	GREEN VALLEY EAST BRADFORD,ONT.
SCALE:	3/16" = 1'-0"

	FLEX DUCT		LOW/HIGH WALL/KICK SUPPLY DIFFUSER		DUCT CONNECTION TO JOIST LINING		RETURN AIR GRILLE (SIZE INDICATED ON DRAWING)	S.A.	SUPPLY AIR
	RIGID ROUND DUCT		HRV EXHAUST GRILLE		RETURN AIR PIPE RISER		RETURN AIR RISER UP TO FLOOR ABOVE	R.A.	RETURN AIR
	SUPPLY DIFFUSER		SUPPLY AIR PIPE RISER		RETURN ROUND DUCT		RETURN AIR FROM BASEMENT SECOND FLOOR		THERMOSTAT
			VOLUME DAMPER						PRINCIPAL EXHAUST FAN SWITCH
									W/R & PRINCIPAL EXHAUST FAN

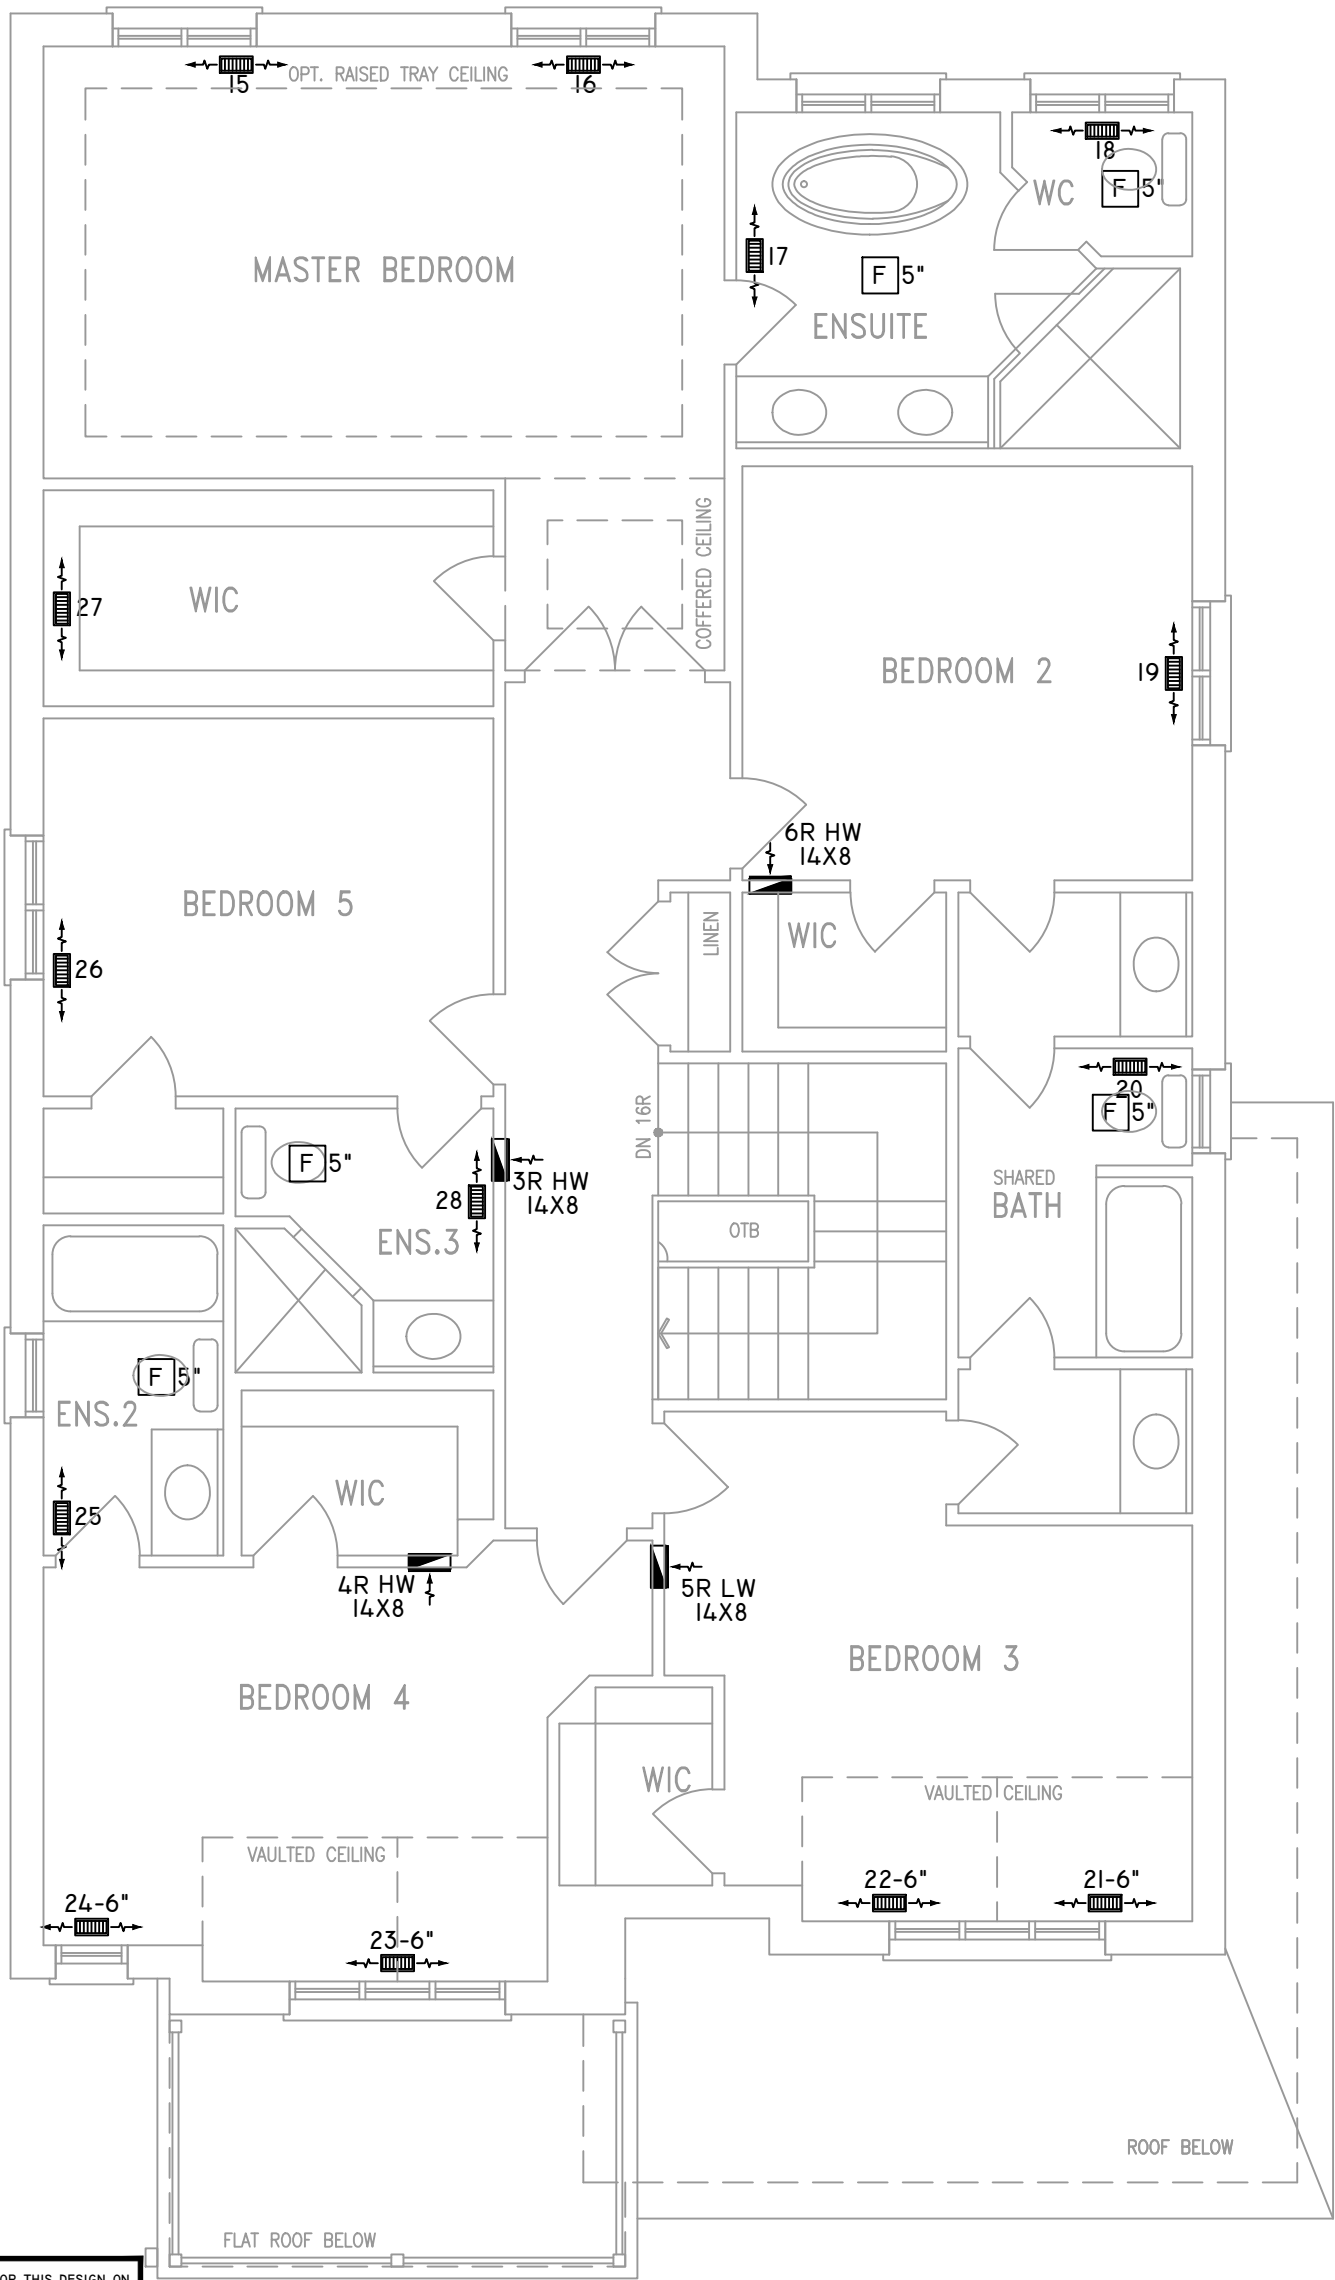

ALL DUCTWORK LOCATED IN
CONDITIONED AREAS
MUST BE SEALED TO CLASS
C LEVEL AS PER OBC PART
6-6.2.4.3.(12)

INSULATE ALL DUCTS IN
UNCONDITIONED
SPACES MIN. R12

FOR THE PURPOSE OF
HEATLOSS/GAIN
CALCULATIONS ALL
ELEVATIONS HAVE BEEN
CONSIDERED

THE UNDERSIGNED HAS REVIEWED AND TAKES RESPONSIBILITY FOR THIS DESIGN ON
BEHALF OF GTA DESIGNS INC. AND HAS THE QUALIFICATIONS AND MEETS THE
REQUIREMENTS SET OUT IN THE BUILDING CODE TO BE A DESIGNER

QUALIFICATION INFORMATION

REQUIRED UNLESS DESIGN IS EXEMPT UNDER DIVISION C 3.2.5.1 OF THE
ONTARIO BUILDING CODE

DAVID DA COSTA  B.C.I.N. 32964
SIGNATURE OF DESIGNER

OPT. SECOND FLOOR PLAN 'A'
5 BEDROOM W/ FOUR BATH

OBC 2012

ZONE I COMPLIANCE
PACKAGE "A1" REF. TABLE 3.1.1.2.A

NOTES

INSTALLATION TO COMPLY WITH THE LATEST ONTARIO
BUILDING CODE.

ALL R/A OUTLETS TO BE 5" DIA. UNLESS OTHERWISE
SPECIFIED.

PROVIDE BALANCING DAMPERS ON ALL BRANCHES.

ALL R/A PARTITIONS 6" (FIRST FLOOR ONLY)

INSULATE DUCTS IN UNCONDITIONED SPACES R12 UNDERCUT
ALL DOORS 1" MIN.

CONTRACTOR MUST WORK FROM APPROVED PLANS.

ANY ALTERATIONS TO THIS ORIGINAL PLAN ARE NOT THE
RESPONSIBILITY OF GTA DESIGNS.

GTA DESIGNS MUST BE CONSULTED IF KITCHEN EXHAUST
FAN EXCEEDS 700 CFM DEPRESSURIZATION MAY OCCUR
WITH IN THE DWELLING.



**2985 DREW ROAD
SUITE 202,
MISSISSAUGA, ONT.
L4T 0A4 TEL: 905-671-9800
EMAIL: DAVE@GTADESIGNS.CA
WEB: WWW.GTADESIGNS.CA**


HEAT-LOSS	57,465	BTU/HR.
UNIT MAKE	AMANA	OR EQUAL.
UNIT MODEL	AMEC960803BNA	OR EQUAL.
UNIT HEATING INPUT	80,000	BTU/HR.
UNIT HEATING OUTPUT	76,800	BTU/HR.
A/C COOLING CAPACITY	3.0	TONS.
FAN SPEED	1172	CFM

# OF RUNS	S/A	R/A	FANS
3RD FLOOR			
2ND FLOOR	14	4	4
1ST FLOOR	10	1	2
BASEMENT	4	1	


FLOOR PLAN: PARTIAL PLAN(S)		
DRAWN BY:	CHECKED:	SQFT
AM	DD	3330
LAYOUT NO.	DRAWING NO.	
JB-04609	M3	

 DATE:	APRIL 3, 2018
CLIENT:	BAYVIEW WELLINGTON
MODEL:	S42-5 ALT. 2ND FLR RIDEAU 5
PROJECT:	GREEN VALLEY EAST BRADFORD,ONT.
SCALE:	3/16" = 1'-0"

	FLEX DUCT		LOW/HIGH WALL/KICK SUPPLY DIFFUSER		DUCT CONNECTION TO JOIST LINING		RETURN AIR GRILLE (SIZE INDICATED ON DRAWING)	S.A.	SUPPLY AIR
	RIGID ROUND DUCT		HRV EXHAUST GRILLE		RETURN AIR PIPE RISER		RETURN AIR RISER UP TO FLOOR ABOVE	R.A.	RETURN AIR
	SUPPLY DIFFUSER		SUPPLY AIR PIPE RISER		RETURN ROUND DUCT		RETURN AIR FROM BASEMENT SECOND FLOOR		THERMOSTAT
			VOLUME DAMPER						PRINCIPAL EXHAUST FAN SWITCH
									W/R & PRINCIPAL EXHAUST FAN

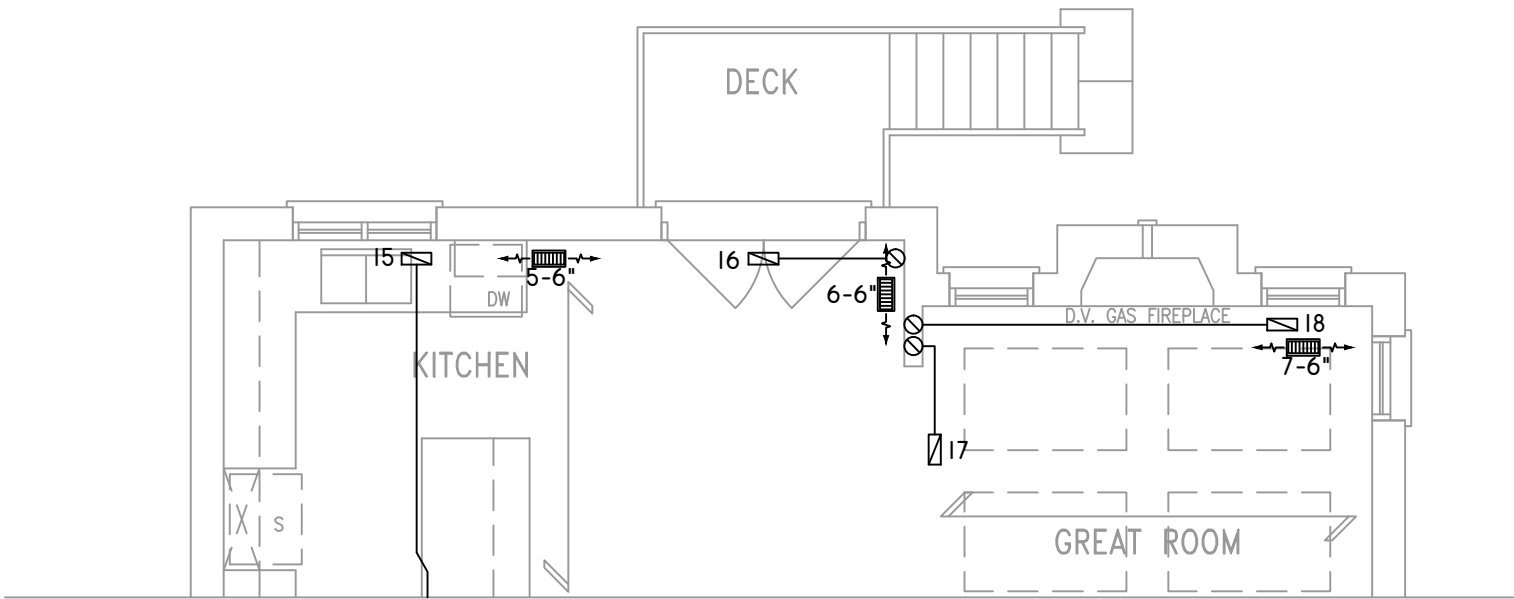

PARTIAL GROUND FLOOR PLAN W/ W.O.D.
9R & MORE CONDITION

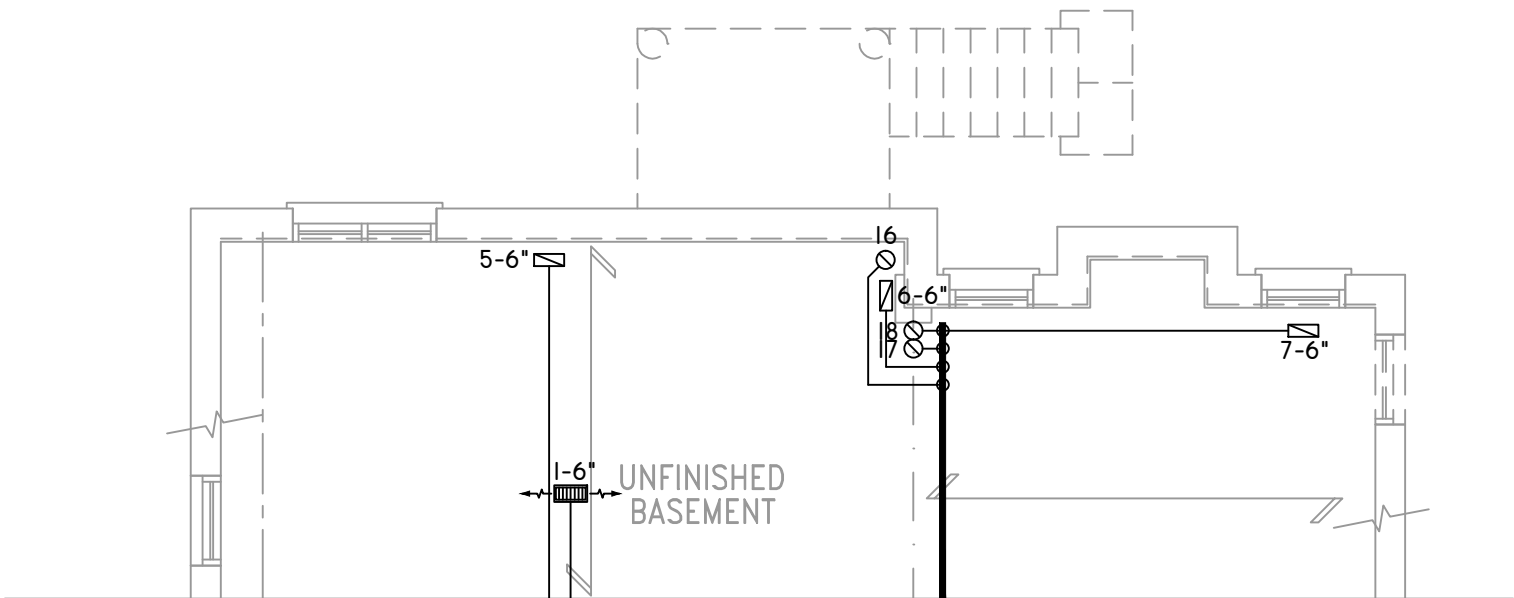

PARTIAL BASEMENT PLAN W/ W.O.D.
9R OR MORE CONDITION

THE UNDERSIGNED HAS REVIEWED AND TAKES RESPONSIBILITY FOR THIS DESIGN ON BEHALF OF GTA DESIGNS INC. AND HAS THE QUALIFICATIONS AND MEETS THE REQUIREMENTS SET OUT IN THE BUILDING CODE TO BE A DESIGNER

QUALIFICATION INFORMATION

REQUIRED UNLESS DESIGN IS EXEMPT UNDER DIVISION C 3.2.5.1 OF THE ONTARIO BUILDING CODE

DAVID DA COSTA  B.C.I.N. 32964

SIGNATURE OF DESIGNER

OBC 2012

ZONE I COMPLIANCE
PACKAGE "A1" REF. TABLE 3.1.1.2.A

NOTES

INSTALLATION TO COMPLY WITH THE LATEST ONTARIO BUILDING CODE.

ALL SUPPLY OUTLETS TO BE 5" DIA. UNLESS OTHERWISE SPECIFIED.

PROVIDE BALANCING DAMPERS ON ALL BRANCHES.

ALL R/A PARTITIONS 6" (FIRST FLOOR ONLY)

INSULATE DUCTS IN UNCONDITIONED SPACES R12 UNDERCUT ALL DOORS 1" MIN.

CONTRACTOR MUST WORK FROM APPROVED PLANS.

ANY ALTERATIONS TO THIS ORIGINAL PLAN ARE NOT THE RESPONSIBILITY OF GTA DESIGNS.

GTA DESIGNS MUST BE CONSULTED IF KITCHEN EXHAUST FAN EXCEEDS 700 CFM DEPRESSURIZATION MAY OCCUR WITH IN THE DWELLING.




2985 DREW ROAD
SUITE 202,
MISSISSAUGA, ONT.
L4T 0A4 TEL: 905-671-9800
EMAIL: DAVE@GTADESIGNS.CA
WEB: WWW.GTADESIGNS.CA




HEAT-LOSS	57,465	BTU/HR.
UNIT MAKE	AMANA	OR EQUAL.
UNIT MODEL	AMEC960803BNA	OR EQUAL.
UNIT HEATING INPUT	80,000	BTU/HR.
UNIT HEATING OUTPUT	76,800	BTU/HR.
A/C COOLING CAPACITY	3.0	TONS.
FAN SPEED	1172	CFM

# OF RUNS	S/A	R/A	FANS
3RD FLOOR			
2ND FLOOR	14	4	4
1ST FLOOR	10	1	2
BASEMENT	4	1	

FLOOR PLAN: PARTIAL PLAN(S)	
DRAWN BY: AM	CHECKED: DD
LAYOUT NO. JB-04609	SQFT 3330
DRAWING NO. M4	

 DATE:	APRIL 3, 2018
CLIENT:	BAYVIEW WELLINGTON
MODEL:	S42-5 ALT. 2ND FLR RIDEAU 5
PROJECT:	GREEN VALLEY EAST BRADFORD,ONT.
SCALE:	3/16" = 1'-0"

	FLEX DUCT		LOW/HIGH WALL/KICK SUPPLY DIFFUSER		DUCT CONNECTION TO JOIST LINING		RETURN AIR GRILLE (SIZE INDICATED ON DRAWING)	S.A.	SUPPLY AIR
	RIGID ROUND DUCT		HRV EXHAUST GRILLE		RETURN AIR PIPE RISER		RETURN AIR RISER UP TO FLOOR ABOVE	R.A.	RETURN AIR
	SUPPLY DIFFUSER		SUPPLY AIR PIPE RISER		RETURN ROUND DUCT		RETURN AIR FROM BASEMENT SECOND FLOOR		THERMOSTAT
			VOLUME DAMPER						PRINCIPAL EXHAUST FAN SWITCH
									W/R & PRINCIPAL EXHAUST FAN

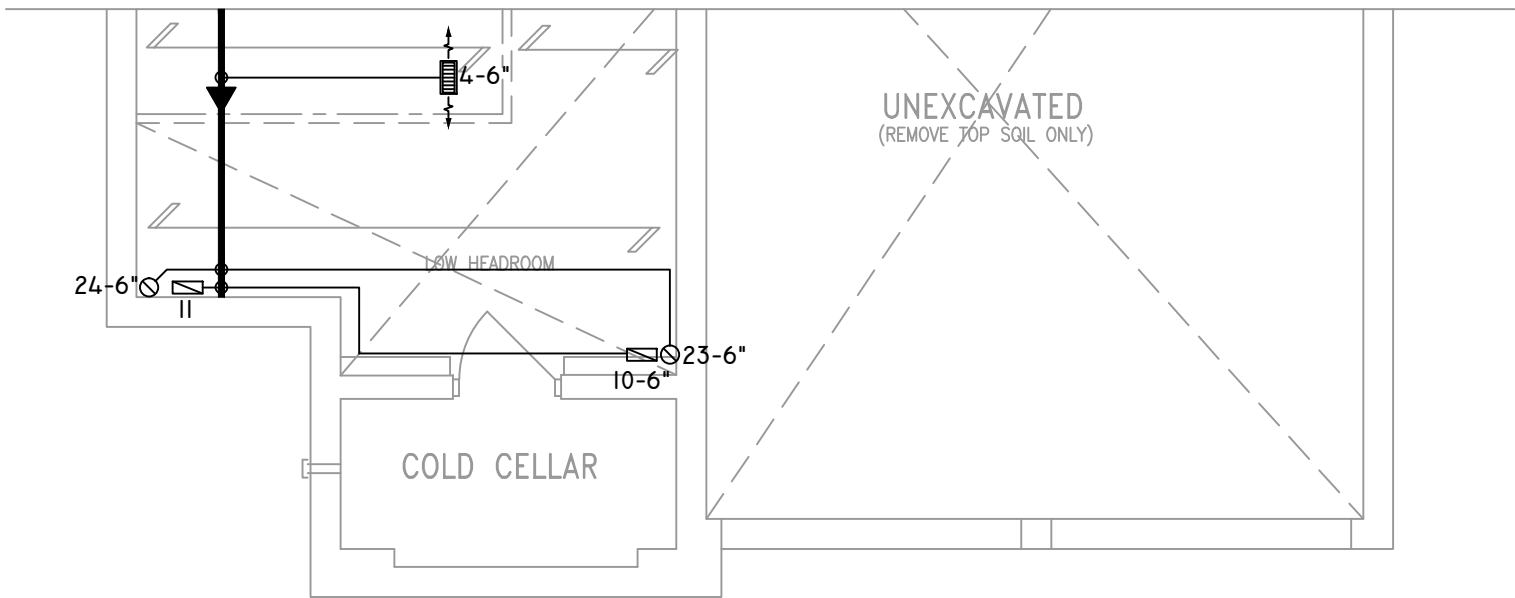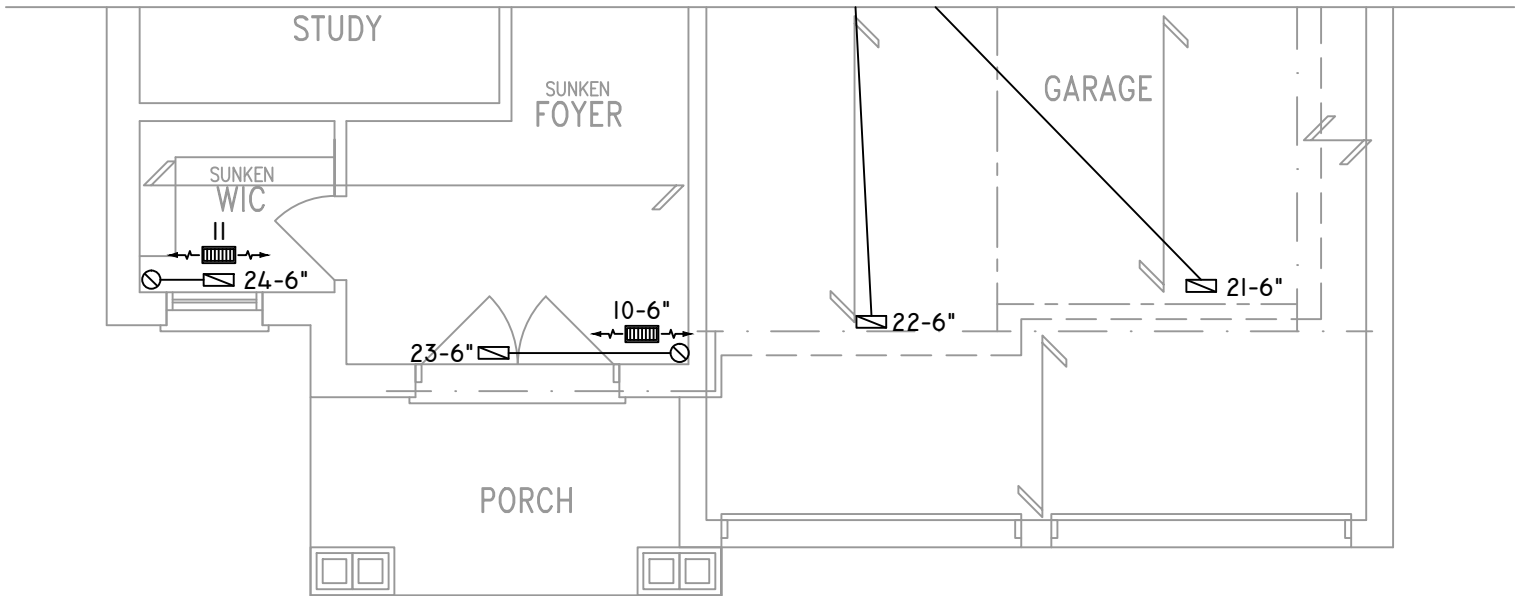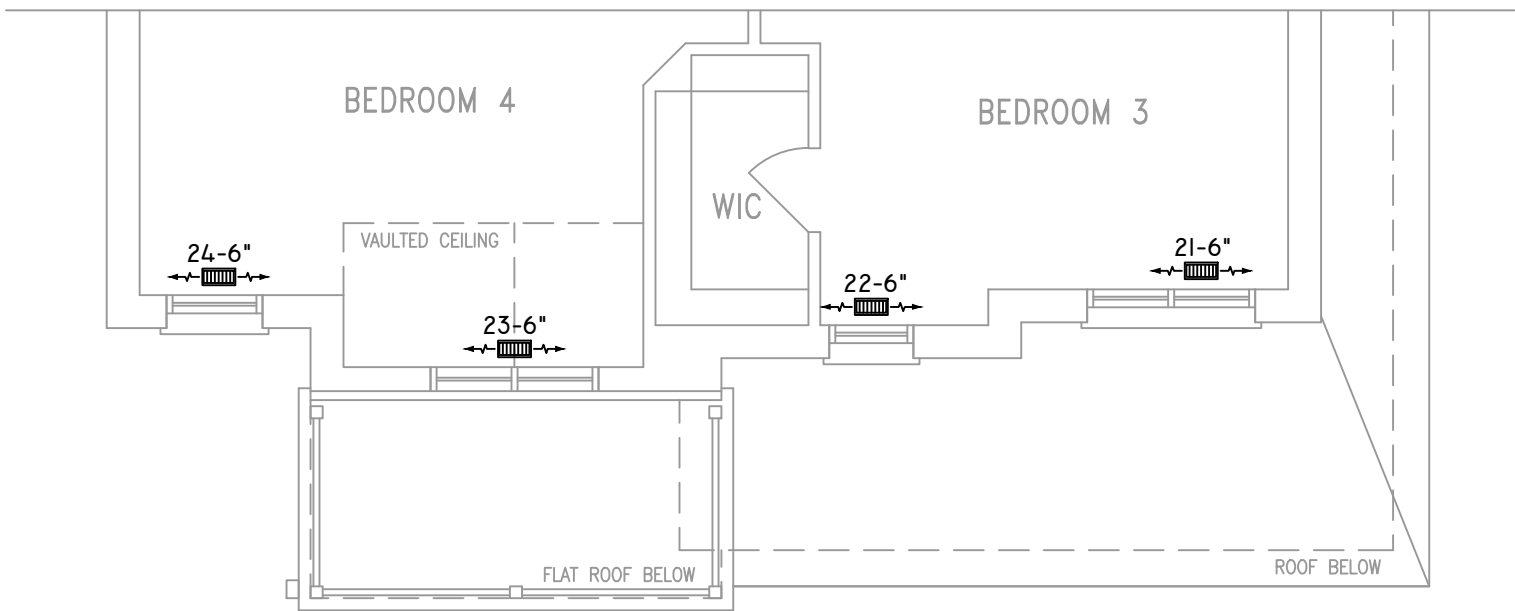

THE UNDERSIGNED HAS REVIEWED AND TAKES RESPONSIBILITY FOR THIS DESIGN ON BEHALF OF GTA DESIGNS INC. AND HAS THE QUALIFICATIONS AND MEETS THE REQUIREMENTS SET OUT IN THE BUILDING CODE TO BE A DESIGNER

QUALIFICATION INFORMATION

REQUIRED UNLESS DESIGN IS EXEMPT UNDER DIVISION C 3.2.5.1 OF THE ONTARIO BUILDING CODE

DAVID DA COSTA  B.C.I.N. 32964

SIGNATURE OF DESIGNER

PARTIAL BASEMENT PLAN 'B'

OBC 2012

ZONE I COMPLIANCE
PACKAGE "A1" REF. TABLE 3.1.1.2.A

NOTES

INSTALLATION TO COMPLY WITH THE LATEST ONTARIO BUILDING CODE.

ALL SUPPLY OUTLETS TO BE 5" DIA. UNLESS OTHERWISE SPECIFIED.

PROVIDE BALANCING DAMPERS ON ALL BRANCHES.

ALL R/A PARTITIONS 6" (FIRST FLOOR ONLY)

INSULATE DUCTS IN UNCONDITIONED SPACES R12 UNDERCUT ALL DOORS 1" MIN.

CONTRACTOR MUST WORK FROM APPROVED PLANS.

ANY ALTERATIONS TO THIS ORIGINAL PLAN ARE NOT THE RESPONSIBILITY OF GTA DESIGNS.

GTA DESIGNS MUST BE CONSULTED IF KITCHEN EXHAUST FAN EXCEEDS 700 CFM DEPRESSURIZATION MAY OCCUR WITH IN THE DWELLING.




2985 DREW ROAD
SUITE 202,
MISSISSAUGA, ONT.
L4T 0A4 TEL: 905-671-9800
EMAIL: DAVE@GTADESIGNS.CA
WEB: WWW.GTADESIGNS.CA


HEAT-LOSS	57,465	BTU/HR.
UNIT MAKE	AMANA	OR EQUAL.
UNIT MODEL	AMEC960803BNA	OR EQUAL.
UNIT HEATING INPUT	80,000	BTU/HR.
UNIT HEATING OUTPUT	76,800	BTU/HR.
A/C COOLING CAPACITY	3.0	TONS.
FAN SPEED	1172	CFM

# OF RUNS	S/A	R/A	FANS
3RD FLOOR			
2ND FLOOR	14	4	4
1ST FLOOR	10	1	2
BASEMENT	4	1	


FLOOR PLAN:	
PARTIAL PLAN(S)	
DRAWN BY: AM	CHECKED: DD
LAYOUT NO. JB-04609	DRAWING NO. M5
SQFT 3330	

 DATE:	APRIL 3, 2018
CLIENT:	BAYVIEW WELLINGTON
MODEL:	S42-5 ALT. 2ND FLR RIDEAU 5
PROJECT:	GREEN VALLEY EAST BRADFORD,ONT.
SCALE:	3/16" = 1'-0"


	FLEX DUCT		LOW/HIGH WALL/KICK SUPPLY DIFFUSER		DUCT CONNECTION TO JOIST LINING		RETURN AIR GRILLE (SIZE INDICATED ON DRAWING)	S.A.	SUPPLY AIR
	RIGID ROUND DUCT		HRV EXHAUST GRILLE		RETURN AIR PIPE RISER		RETURN AIR RISER UP TO FLOOR ABOVE	R.A.	RETURN AIR
	SUPPLY DIFFUSER		SUPPLY AIR PIPE RISER		RETURN ROUND DUCT		RETURN AIR FROM BASEMENT SECOND FLOOR		THERMOSTAT
			VOLUME DAMPER						PRINCIPAL EXHAUST FAN SWITCH W/R & PRINCIPAL EXHAUST FAN

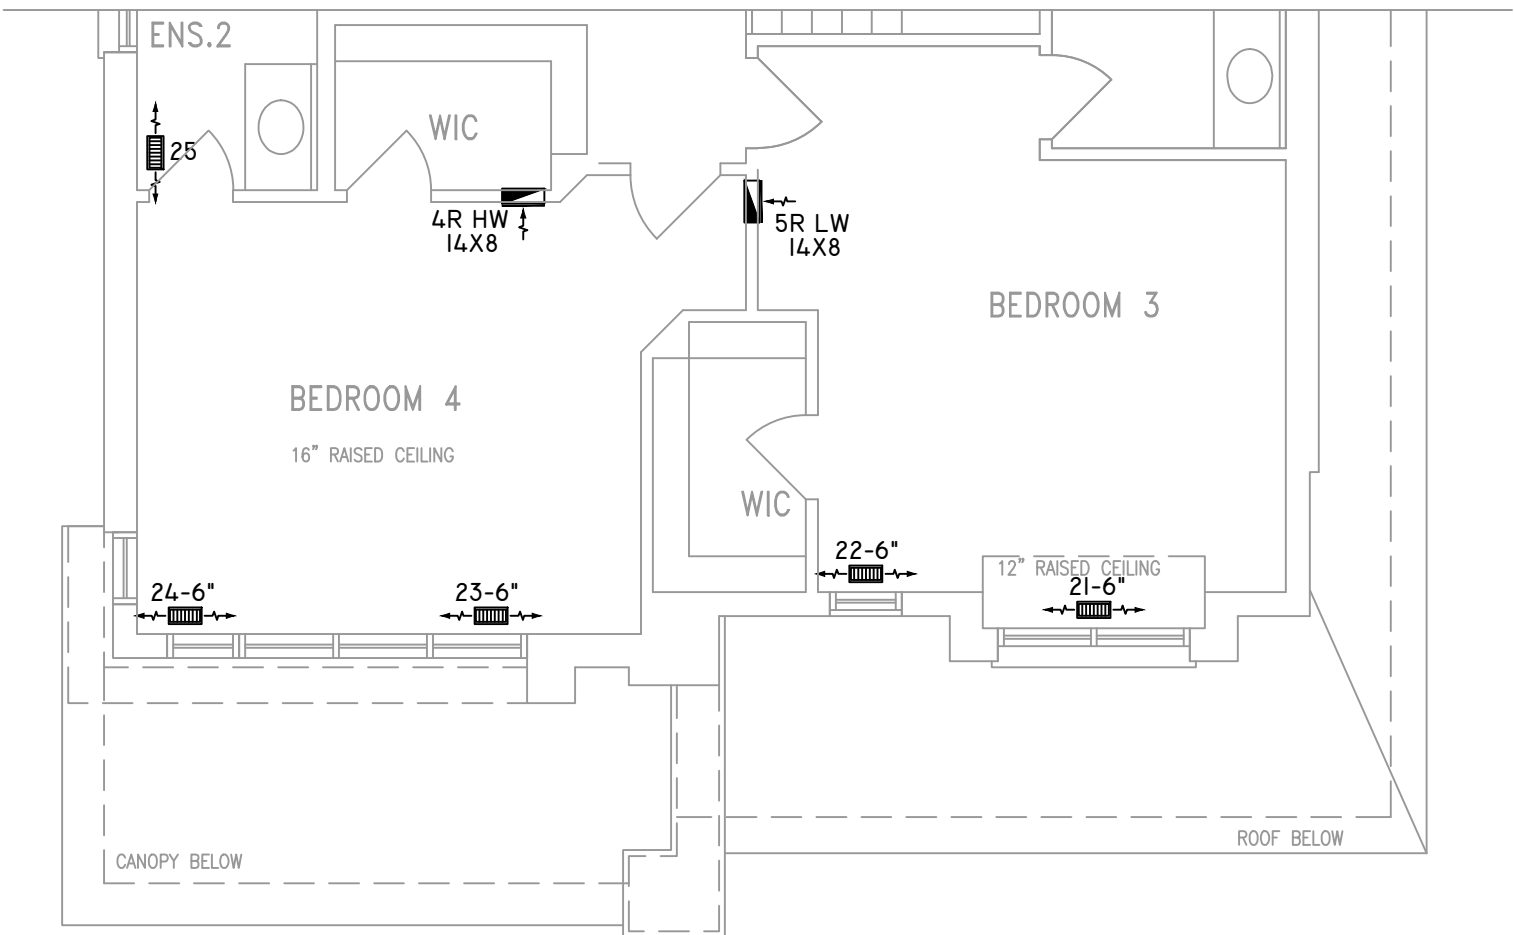

PARTIAL OPT. SECOND FLOOR PLAN 'C'

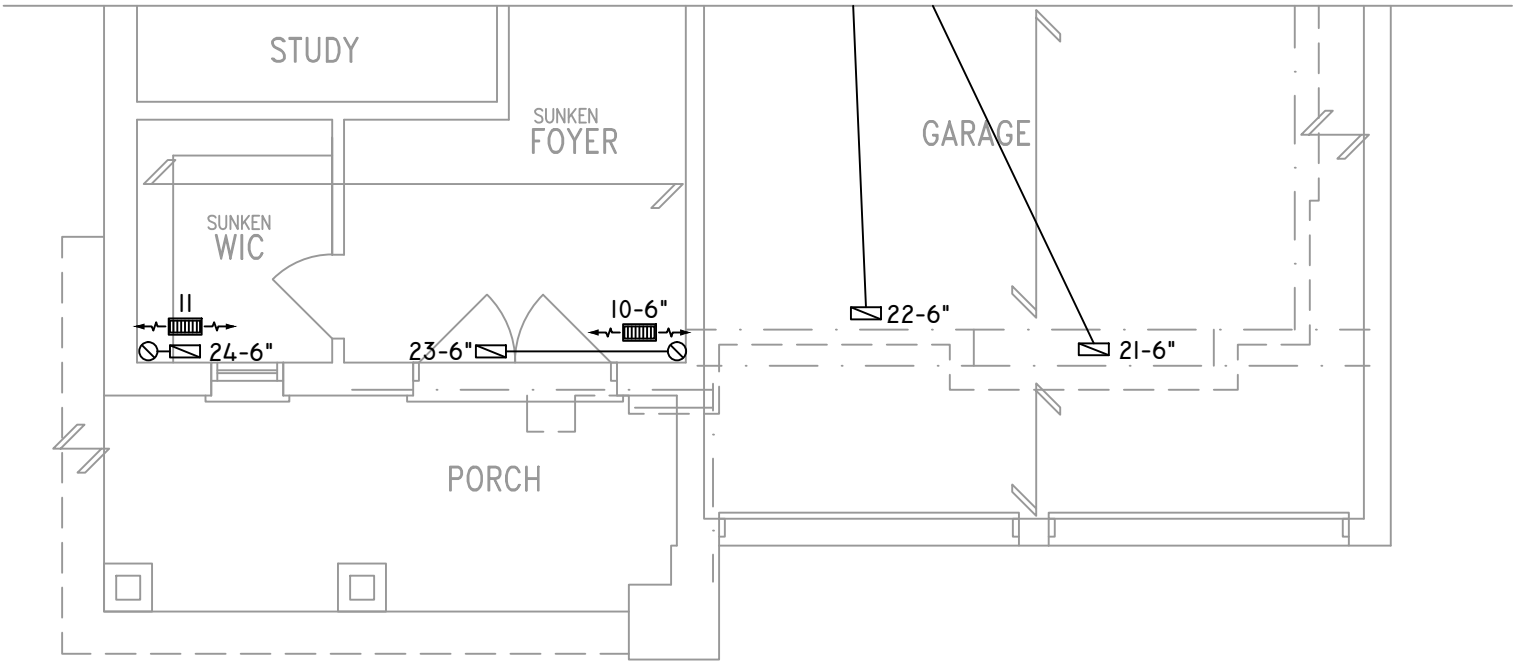

PARTIAL GROUND FLOOR PLAN 'C'

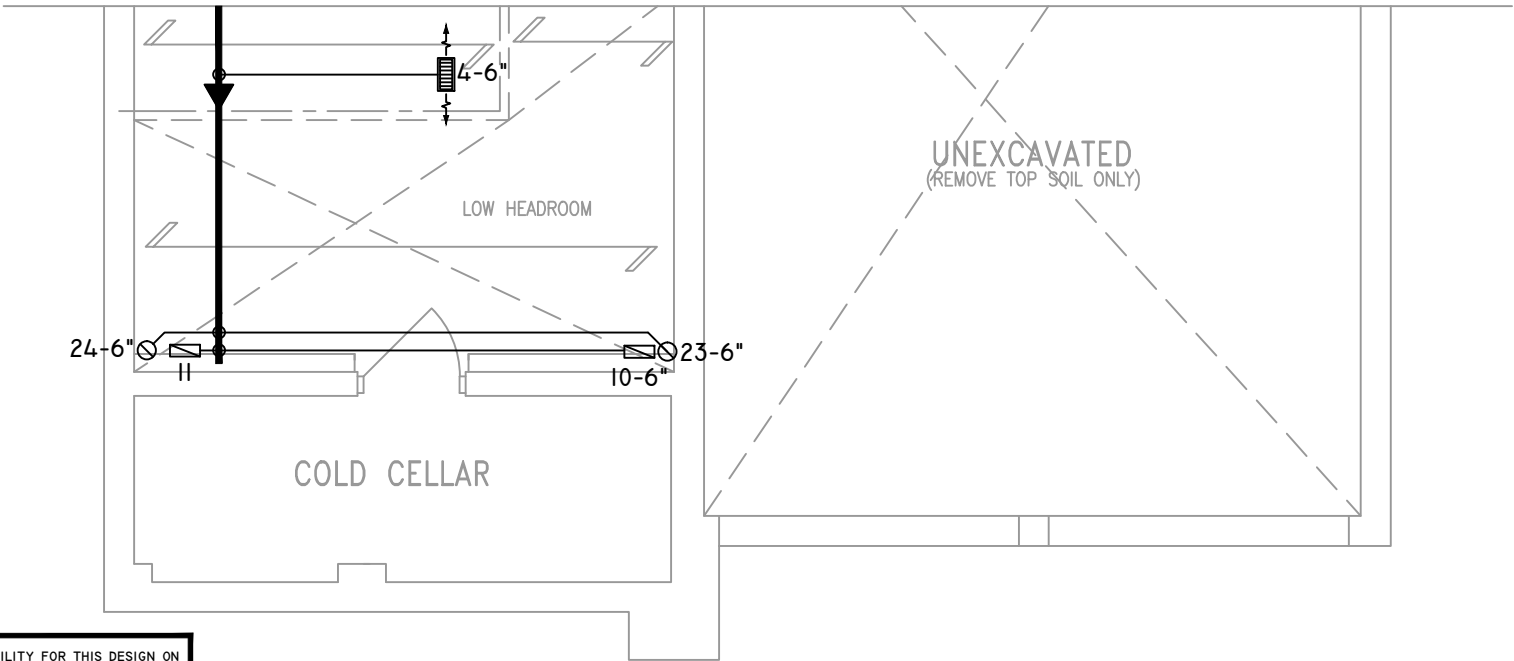

PARTIAL BASEMENT PLAN 'C'

THE UNDERSIGNED HAS REVIEWED AND TAKES RESPONSIBILITY FOR THIS DESIGN ON BEHALF OF GTA DESIGNS INC. AND HAS THE QUALIFICATIONS AND MEETS THE REQUIREMENTS SET OUT IN THE BUILDING CODE TO BE A DESIGNER

QUALIFICATION INFORMATION

REQUIRED UNLESS DESIGN IS EXEMPT UNDER DIVISION C 3.2.5.1 OF THE ONTARIO BUILDING CODE

DAVID DA COSTA  B.C.I.N. 32964

SIGNATURE OF DESIGNER

OBC 2012

ZONE I COMPLIANCE
PACKAGE "A1" REF. TABLE 3.1.1.2.A

NOTES

INSTALLATION TO COMPLY WITH THE LATEST ONTARIO BUILDING CODE.

ALL SUPPLY OUTLETS TO BE 5" DIA. UNLESS OTHERWISE SPECIFIED.

PROVIDE BALANCING DAMPERS ON ALL BRANCHES.

ALL R/A PARTITIONS 6" (FIRST FLOOR ONLY)

INSULATE DUCTS IN UNCONDITIONED SPACES R12 UNDERCUT ALL DOORS 1" MIN.

CONTRACTOR MUST WORK FROM APPROVED PLANS.

ANY ALTERATIONS TO THIS ORIGINAL PLAN ARE NOT THE RESPONSIBILITY OF GTA DESIGNS.

GTA DESIGNS MUST BE CONSULTED IF KITCHEN EXHAUST FAN EXCEEDS 700 CFM DEPRESSURIZATION MAY OCCUR WITH IN THE DWELLING.



2985 DREW ROAD
SUITE 202,
MISSISSAUGA, ONT.
L4T 0A4 TEL: 905-671-9800
EMAIL: DAVE@GTADESIGNS.CA
WEB: WWW.GTADESIGNS.CA


HEAT-LOSS	57,465	BTU/HR.
UNIT MAKE	AMANA	OR EQUAL.
UNIT MODEL	AMEC960803BNA	OR EQUAL.
UNIT HEATING INPUT	80,000	BTU/HR.
UNIT HEATING OUTPUT	76,800	BTU/HR.
A/C COOLING CAPACITY	3.0	TONS.
FAN SPEED	1172	CFM

# OF RUNS	S/A	R/A	FANS
3RD FLOOR			
2ND FLOOR	14	4	4
1ST FLOOR	10	1	2
BASEMENT	4	1	


FLOOR PLAN: PARTIAL PLAN(S)	
DRAWN BY: AM	CHECKED: DD
LAYOUT NO. JB-04609	SQFT 3330
DRAWING NO. M6	

DATE:	APRIL 3, 2018
CLIENT:	BAYVIEW WELLINGTON
MODEL:	S42-5 ALT. 2ND FLR RIDEAU 5
PROJECT:	GREEN VALLEY EAST BRADFORD,ONT.
SCALE:	3/16" = 1'-0"


	FLEX DUCT RIGID ROUND DUCT SUPPLY DIFFUSER		LOW/HIGH WALL/KICK SUPPLY DIFFUSER HRV EXHAUST GRILLE SUPPLY AIR PIPE RISER VOLUME DAMPER		DUCT CONNECTION TO JOIST LINING RETURN AIR PIPE RISER RETURN ROUND DUCT		RETURN AIR GRILLE (SIZE INDICATED ON DRAWING) RETURN AIR RISER UP TO FLOOR ABOVE RETURN AIR FROM BASEMENT SECOND FLOOR	S.A. R.A. T \$ F PE	SUPPLY AIR RETURN AIR THERMOSTAT PRINCIPAL EXHAUST FAN SWITCH W/R & PRINCIPAL EXHAUST FAN
--	--	--	--	--	---	--	---	---------------------------------	---

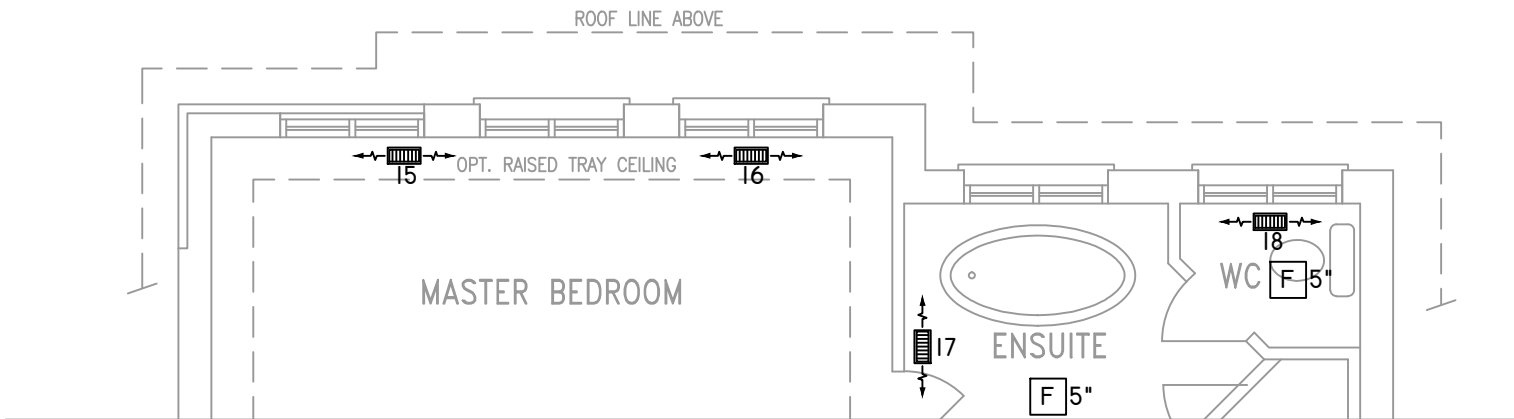


PARTIAL STD & OPT SECOND FLOOR PLAN
ELEVATION 'C' REAR UPGRADE

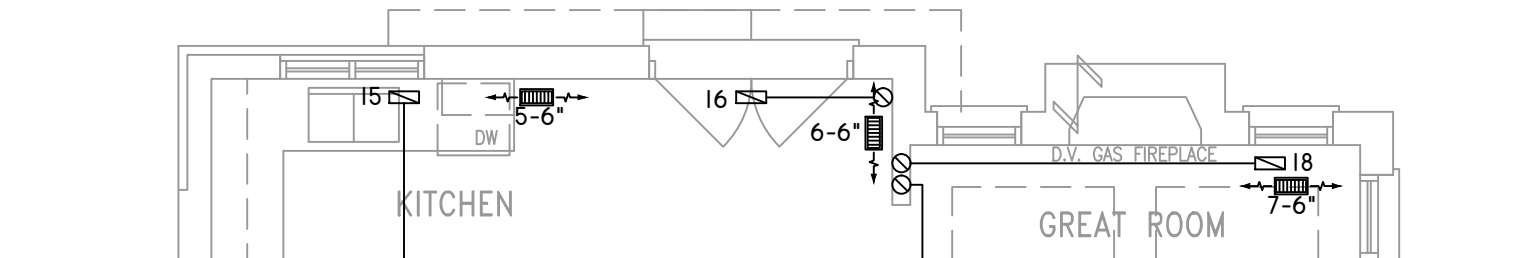

PARTIAL STD & OPT GROUND FLOOR PLAN
ELEVATION 'C' REAR UPGRADE

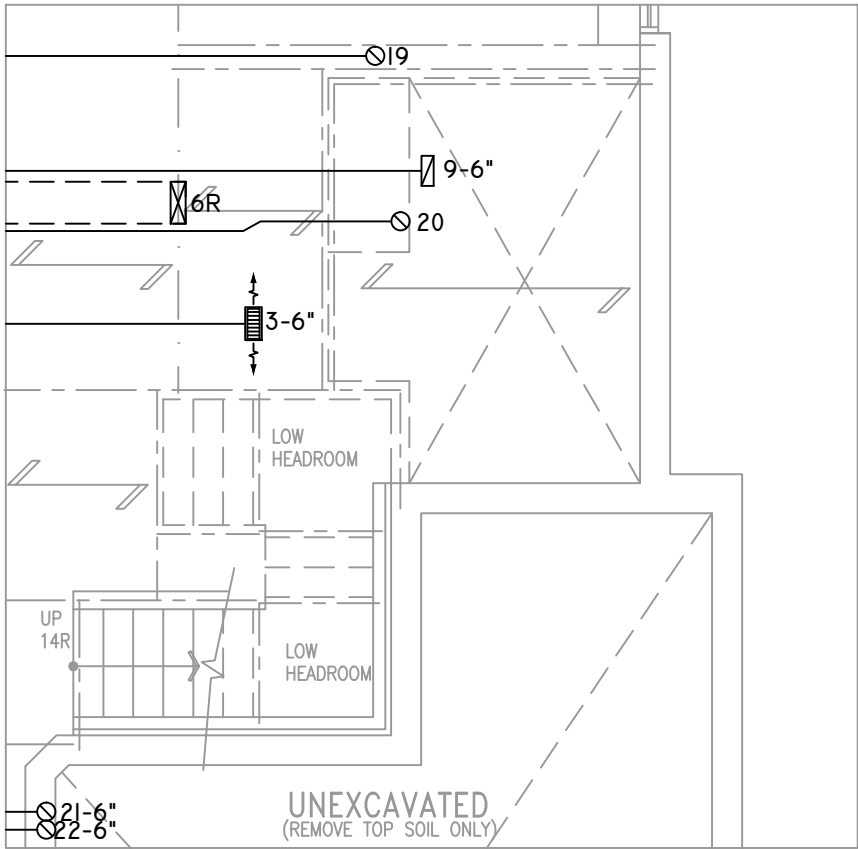

PARTIAL BASEMENT PLAN W/
SUNKEN LAUNDRY -1R

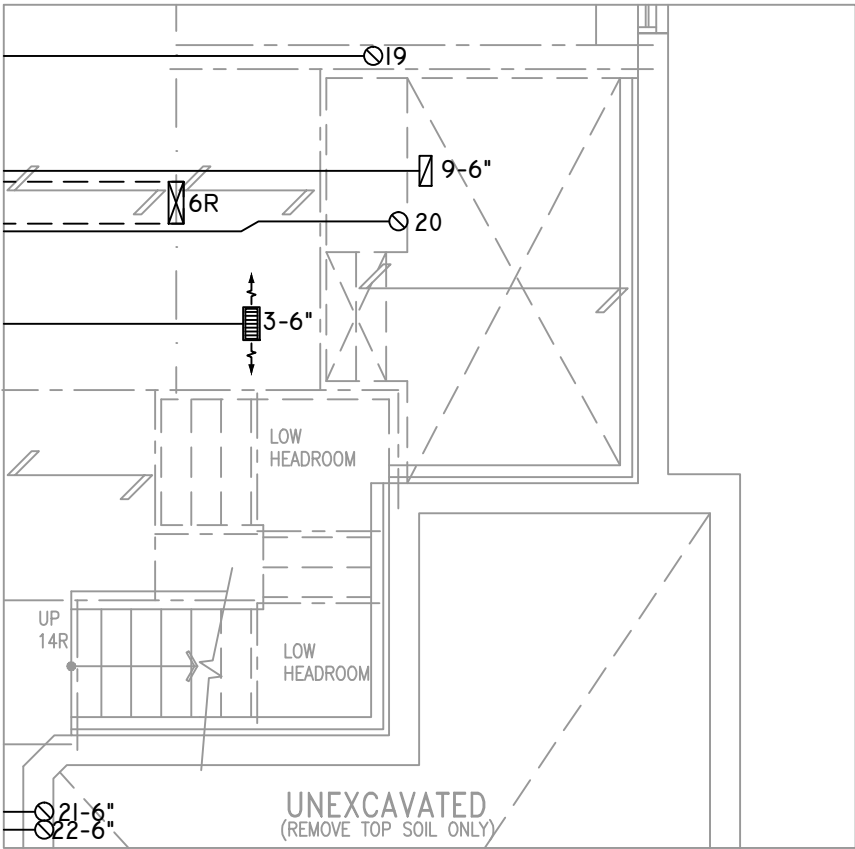

PARTIAL BASEMENT PLAN W/
SUNKEN LAUNDRY -2R TO -3R

THE UNDERSIGNED HAS REVIEWED AND TAKES RESPONSIBILITY FOR THIS DESIGN ON BEHALF OF GTA DESIGNS INC. AND HAS THE QUALIFICATIONS AND MEETS THE REQUIREMENTS SET OUT IN THE BUILDING CODE TO BE A DESIGNER

QUALIFICATION INFORMATION

REQUIRED UNLESS DESIGN IS EXEMPT UNDER DIVISION C 3.2.5.1 OF THE ONTARIO BUILDING CODE

DAVID DA COSTA

B.C.I.N. 32964

SIGNATURE OF DESIGNER

OBC 2012

ZONE I COMPLIANCE
PACKAGE "A1" REF. TABLE 3.1.1.2.A

NOTES
INSTALLATION TO COMPLY WITH THE LATEST ONTARIO BUILDING CODE.
ALL SUPPLY OUTLETS TO BE 5" DIA. UNLESS OTHERWISE SPECIFIED.
PROVIDE BALANCING DAMPERS ON ALL BRANCHES.
ALL R/A PARTITIONS 6" (FIRST FLOOR ONLY)
INSULATE DUCTS IN UNCONDITIONED SPACES R12 UNDERCUT ALL DOORS 1" MIN.
CONTRACTOR MUST WORK FROM APPROVED PLANS.
ANY ALTERATIONS TO THIS ORIGINAL PLAN ARE NOT THE RESPONSIBILITY OF GTA DESIGNS.
GTA DESIGNS MUST BE CONSULTED IF KITCHEN EXHAUST FAN EXCEEDS 700 CFM DEPRESSURIZATION MAY OCCUR WITH IN THE DWELLING.

2985 DREW ROAD
SUITE 202,
MISSISSAUGA, ONT.
L4T 0A4 TEL: 905-671-9800
EMAIL: DAVE@GTADESIGNS.CA
WEB: WWW.GTADESIGNS.CA

HEAT-LOSS	57,465	BTU/HR.
UNIT MAKE	AMANA	OR EQUAL.
UNIT MODEL	AMEC960803BNA	OR EQUAL.
UNIT HEATING INPUT	80,000	BTU/HR.
UNIT HEATING OUTPUT	76,800	BTU/HR.
A/C COOLING CAPACITY	3.0	TONS.
FAN SPEED	1172	CFM

# OF RUNS	S/A	R/A	FANS
3RD FLOOR			
2ND FLOOR	14	4	4
1ST FLOOR	10	1	2
BASEMENT	4	1	

FLOOR PLAN: PARTIAL PLAN(S)	
DRAWN BY: AM	CHECKED: DD
LAYOUT NO: JB-04609	DRAWING NO: M7
SQFT 3330	

DATE:	APRIL 3, 2018
CLIENT:	BAYVIEW WELLINGTON
MODEL:	S42-5 ALT. 2ND FLR RIDEAU 5
PROJECT:	GREEN VALLEY EAST BRADFORD,ONT.
SCALE:	3/16" = 1'-0"