

Use one form for each individual who reviews and takes responsibility for design activities with respect to the project.

A. Project Information					
Building number, street name Rideau 7 S42-7C				Lot: Lot/con.	
Municipality Bradford		Postal code	Plan number/ other description		
B. Individual who reviews and takes responsibility for design activities					
Name David DaCosta			Firm gtaDesigns Inc.		
Street address 2985 Drew Road, Suite 202				Unit no.	Lot/con.
Municipality Mississauga		Postal code L4T 0A4	Province Ontario	E-mail dave@gtadesigns.ca	
Telephone number (905) 671-9800		Fax number (647) 494-9643		Cell number (416) 268-6820	
C. Design activities undertaken by individual identified in Section B. [Building Code Table 3.5.2.1 of Division C]					
☐ House ☐ Small Buildings ☐ Large Buildings ☐ Complex Buildings		☒ HVAC – House ☐ Building Services ☐ Detection, Lighting and Power ☐ Fire Protection		☐ Building Structural ☐ Plumbing – House ☐ Plumbing – All Buildings ☐ On-site Sewage Systems	
Description of designer's work			Model Certification		Project #:
					Layout #:
Heating and Cooling Load Calculations			Main	X	Builder
Air System Design			Alternate		Project
Residential mechanical ventilation Design Summary			Area Sq ft:	3179	Model
Residential System Design per CAN/CSA-F280-12					SB-12
Residential New Construction - Forced Air					
Bayview Wellington Green Valley East Rideau 7 S42-7C Package A1					
D. Declaration of Designer					
I, <u>David DaCosta</u> declare that (choose one as appropriate): (print name)					
☐ I review and take responsibility for the design work on behalf of a firm registered under subsection 3.2.4 Division C of the Building Code. I am qualified, and the firm is registered, in the appropriate classes/categories. Individual BCIN: _____ Firm BCIN: _____					
☒ I review and take responsibility for the design and am qualified in the appropriate category as an "other designer" under subsection 3.2.5 of Division C, of the Building Code. Individual BCIN: <u>32964</u> Basis for exemption from registration: <u>Division C 3.2.4.1. (4)</u>					
☐ The design work is exempt from the registration and qualification requirements of the Building Code. Basis for exemption from registration and qualification:					
I certify that: 1. The information contained in this schedule is true to the best of my knowledge. 2. I have submitted this application with the knowledge and consent of the firm.					
<u>April 4, 2018</u> Date			 Signature of Designer		

NOTE:

- For the purposes of this form, "individual" means the "person" referred to in Clause 3.2.4.7(1) d), of Division C, Article 3.2.5.1. of Division C and all other persons who are exempt from qualifications under Subsections 3.2.4 . and 3.2.5. of Division C.
- Schedule 1 does not require to be completed a holder of a license, temporary license, or a certificate of authorization, issued by the Ontario Association of Architects. Schedule 1 is also not required to be completed by a holder of a license to practise, a limited licence to practise, or a certificate of authorization, issued by the Association of Professional Engineers of Ontario.

Heat loss and gain calculation summary sheet				CSA-F280-M12 Standard Form No. 1	
These documents issued for the use of Bayview Wellington				Layout No.	
and may not be used by any other persons without authorization. Documents for permit and/or construction are signed in red.				JB-04589	
Building Location					
Address (Model): S42-7C			Site: Green Valley East		
Model: Rideau 7			Lot:		
City and Province: Bradford			Postal code:		
Calculations based on					
Dimensional information based on:			VA3 Design Jan/2018		
Attachment: Detached			Front facing: East/West		Assumed? Yes
No. of Levels: 3		Ventilated? Included	Air tightness: 1961-Present (ACH=3.57)		Assumed? Yes
Weather location: Bradford			Wind exposure: Sheltered		
HRV? LifeBreath		RNC155	Internal shading: Light-translucent		Occupants: 5
Sensible Eff. at -25C 71%		Apparent Effect. at -0C 84%	Units: Imperial		Area Sq ft: 3179
Sensible Eff. at -0C 75%					
Heating design conditions			Cooling design conditions		
Outdoor temp -9.4 Indoor temp: 72 Mean soil temp: 48			Outdoor temp 86 Indoor temp: 75 Latitude: 44		
Above grade walls			Below grade walls		
Style A: As per OBC SB12 Package A1 R 22			Style A: As per OBC SB12 Package A1 R 20ci		
Style B: Existing Walls (When Applicable) R 12			Style B:		
Style C:			Style C:		
Style D:			Style D:		
Floors on soil			Ceilings		
Style A: As per Selected OBC SB12 Package A1			Style A: As per Selected OBC SB12 Package A1 R 60		
Style B:			Style B: As per Selected OBC SB12 Package A1 R 31		
Exposed floors			Style C:		
Style A: As per Selected OBC SB12 Package A1 R 31			Doors		
Style B:			Style A: As per Selected OBC SB12 Package A1 R 4.00		
Windows			Style B:		
Style A: As per Selected OBC SB12 Package A1 R 4.06			Style C:		
Style B: Existing Windows (When Applicable) R 1.99			Skylights		
Style C:			Style A: As per Selected OBC SB12 Package A1 R 2.03		
Style D:			Style B:		
Attached documents: As per Shedule 1		Heat Loss/Gain Caculations based on CSA-F280-12 Effective R-Values			
Notes: Residential New Construction - Forced Air					
Calculations performed by					
Name: David DaCosta			Postal code: L4T 0A4		
Company: gtaDesigns Inc.			Telephone: (905) 671-9800		
Address: 2985 Drew Road, Suite 202			Fax: (416) 268-6820		
City: Mississauga			E-mail dave@gtadesigns.ca		

Builder: **Bayview Wellington**

Date: **April 4, 2018**

Project: **Green Valley East**

Model: **Rideau 7 S42-7C**

System 1

I review and take responsibility for the design work and am qualified in the appropriate category as an "other designer" under Division C subsection 3.2.5. of the Building Code.

Individual BCIN: 32964

David DaCosta

David DaCosta

Project # **PJ-00204**
Layout # **JB-04589**

Page 3

DESIGN LOAD SPECIFICATIONS		AIR DISTRIBUTION & PRESSURE		FURNACE/AIR HANDLER DATA:		BOILER/WATER HEATER DATA:		A/C UNIT DATA:	
Level 1 Net Load	17,243 btu/h	Equipment External Static Pressure	0.5 "w.c.	Make	Amana	Make	Type	Amana	3.0 Ton
Level 2 Net Load	20,393 btu/h	Additional Equipment Pressure Drop	0.225 "w.c.	Model	AMEC960803BNA	Model		Cond.-----	3.0
Level 3 Net Load	19,647 btu/h	Available Design Pressure	0.275 "w.c.	Input Btu/h	80000	Input Btu/h		Coil -----	3.0
Level 4 Net Load	0 btu/h	Return Branch Longest Effective Length	300 ft	Output Btu/h	76800	Output Btu/h			
Total Heat Loss	57,283 btu/h	R/A Plenum Pressure	0.138 "w.c.	E.s.p.	0.50 " W.C.	Min.Output Btu/h	AWH		
Total Heat Gain	35,225 btu/h	S/A Plenum Pressure	0.14 "w.c.	Water Temp	deg. F.	Blower DATA:			
Combo System HL + 10%	63,012 Btu/h	Heating Air Flow Proportioning Factor	0.0205 cfm/btu/h	AFUE	96%	Blower Speed Selected:	W2	Blower Type	ECM
Building Volume Vb	36948 ft³	Cooling Air Flow Proportioning Factor	0.0333 cfm/btu/h	Aux. Heat				(Brushless DC OBC 12.3.1.5.(2))	
Ventilation Load	1,118 Btu/h.	R/A Temp	70 deg. F.	SB-12 Package	Package A1	Heating Check	1172 cfm	Cooling Check	1172 cfm
Ventilation PVC	79.5 cfm	S/A Temp	131 deg. F.						
Supply Branch and Grill Sizing		Diffuser loss	0.01 "w.c.	Temp. Rise>>>	61 deg. F.	Selected cfm>	1172 cfm	Cooling Air Flow Rate	1172 cfm

	Level 1														Level 2													
S/A Outlet No.	1	2	3	4											5	6	7	8	9	10	11	12	13	14				
Room Use	BASE	BASE	BASE	BASE											KIT	KIT	LAUN	LIV	LIV	FOY	DIN	DIN	GRT	GRT				
Btu/Outlet	4311	4311	4311	4311											1869	1869	2507	2992	2992	1971	1183	1183	1913	1913				
Heating Airflow Rate CFM	88	88	88	88											38	38	51	61	61	40	24	24	39	39				
Cooling Airflow Rate CFM	12	12	12	12											66	66	68	69	69	29	57	57	63	63				
Duct Design Pressure	0.13	0.13	0.13	0.13	0.13	0.13	0.13	0.13	0.13	0.13	0.13	0.13	0.13	0.13	0.13	0.13	0.13	0.13	0.13	0.13	0.13	0.13	0.13	0.13	0.13	0.13	0.13	
Actual Duct Length	33	36	40	58											33	35	29	64	57	46	35	41	47	40				
Equivalent Length	100	120	110	120	70	70	70	70	70	70	70	70	70	70	80	130	140	120	130	120	95	80	110	130	70	70	70	70
Total Effective Length	133	156	150	178	70	70	70	70	70	70	70	70	70	70	113	165	169	184	187	166	130	121	157	170	70	70	70	70
Adjusted Pressure	0.10	0.08	0.09	0.07	0.19	0.19	0.19	0.19	0.19	0.19	0.19	0.19	0.19	0.19	0.12	0.08	0.08	0.07	0.07	0.08	0.10	0.11	0.08	0.08	0.19	0.19	0.19	0.19
Duct Size Round	6	6	6	6											6	6	6	6	6	5	6	6	6	6				
Outlet Size	4x10	4x10	4x10	4x10	4x10	4x10	4x10	4x10	4x10	4x10	4x10	4x10	4x10	4x10	4x10	4x10	4x10	4x10	4x10	3x10	4x10	4x10	4x10	4x10	4x10	4x10	4x10	4x10
Trunk	D	C	E	F											D	D	E	F	F	E	B	C	C					

	Level 3														Level 4													
S/A Outlet No.	15	16	17	18	19	20	21	22	23	24	25	26	27															
Room Use	MAST	MAST	ENS	WC	WIC	BED 2	BATH	BED 3	BED 4	BED 4	BATH 2	MED	BED 3															
Btu/Outlet	1683	1683	1519	392	352	1298	983	1903	2285	2285	1173	2189	1903															
Heating Airflow Rate CFM	34	34	31	8	7	27	20	39	47	47	24	45	39															
Cooling Airflow Rate CFM	56	56	35	5	3	26	10	44	70	70	26	74	44															
Duct Design Pressure	0.13	0.13	0.13	0.13	0.13	0.13	0.13	0.13	0.13	0.13	0.13	0.13	0.13	0.13	0.13	0.13	0.13	0.13	0.13	0.13	0.13	0.13	0.13	0.13	0.13	0.13	0.13	
Actual Duct Length	67	51	45	51	49	45	44	88	80	72	59	63	78															
Equivalent Length	120	130	140	135	120	140	150	180	150	180	110	130	170	70	70	70	70	70	70	70	70	70	70	70	70	70	70	
Total Effective Length	187	181	185	186	169	185	194	268	230	252	169	193	248	70	70	70	70	70	70	70	70	70	70	70	70	70	70	
Adjusted Pressure	0.07	0.07	0.07	0.07	0.08	0.07	0.07	0.05	0.06	0.05	0.08	0.07	0.05	0.19	0.19	0.19	0.19	0.19	0.19	0.19	0.19	0.19	0.19	0.19	0.19	0.19	0.19	
Duct Size Round	6	6	4	3	3	4	4	6	6	6	4	6	6															
Outlet Size	4x10	4x10	3x10	3x10	3x10	3x10	3x10	4x10	4x10	4x10	3x10	4x10	4x10	4x10	4x10	4x10	4x10	4x10	4x10	4x10	4x10	4x10	4x10	4x10	4x10	4x10	4x10	
Trunk	C	D	D	D	B	E	E	F	F	F	E	C	F															

Return Branch And Grill Sizing		Grill Pressure Loss		0.02 "w.c.							
R/A Inlet No.	1R	2R	3R	4R	5R	6R	7R	8R	9R	10R	11R
Inlet Air Volume CFM	170	440	154	154	154	100					
Duct Design Pressure	0.12	0.12	0.12	0.12	0.12	0.12	0.12	0.12	0.12	0.12	0.12
Actual Duct Length	12	27	52	47	40	50					
Equivalent Length	110	165	160	235	165	125	50	50	50	50	50
Total Effective Length	122	192	212	282	205	175	50	50	50	50	50
Adjusted Pressure	0.10	0.06	0.06	0.04	0.06	0.07	0.24	0.24	0.24	0.24	0.24
Duct Size Round	7.0	11.5	8.0	8.5	8.0	6.0					
Inlet Size	FLC	8	8	8	8	8					
" "	x	x	x	x	x	x	x	x	x	x	x
Inlet Size		30	14	14	14	14					
Trunk	Y	Z	Y	Z	Z						

Return Trunk Duct Sizing							
Trunk	CFM	Press.	Round	Rect. Size			
Drop	1172	0.04	18.0	24x12			
Z	1072	0.04	17.5	28x10	22x12		
Y	324	0.06	10.5	12x8	10x10		
X							
W							
V							
U							
T							
S							
R							
Q							

Supply Trunk Duct Sizing							
Trunk	CFM	Press.	Round	Rect. Size			
A	1173	0.05	17.0	26x10	22x12		
B	540	0.07	12.0	16x8	12x10		
C	246	0.07	9.0	8x8	10x7		
D	238	0.07	9.0	8x8	10x7		
E	633	0.05	13.5	20x8	16x10		
F	382	0.05	11.5	14x8	12x10		
G							
H							
I							
J							
K							

2012 OBC

Builder: Bayview Wellington

Date: April 4, 2018

Project: Green Valley East

Model: Rideau 7 S42-7C

System 1

Weather Data Bradford 44 -9.4 86 22 48.2

Heat Loss ^T 81.4 deg. F Ht gain ^T 11 deg. F GTA: 3179

Project # PJ-00204
Layout # JB-04589

Level 1

Run ft. exposed wall A	182	A	A	A	A	A	A	A	A	A	A	A	A
Run ft. exposed wall B	B	B	B	B	B	B	B	B	B	B	B	B	B
Ceiling height	3.7	AG	3.7	AG	3.7	AG	3.7	AG	3.7	AG	3.7	AG	3.7
Floor area	1282	Area	Area	Area	Area	Area	Area	Area	Area	Area	Area	Area	Area
Exposed Ceilings A	A	A	A	A	A	A	A	A	A	A	A	A	A
Exposed Ceilings B	B	B	B	B	B	B	B	B	B	B	B	B	B
Exposed Floors	Flr	Flr	Flr	Flr	Flr	Flr	Flr	Flr	Flr	Flr	Flr	Flr	Flr
Gross Exp Wall A	673												
Gross Exp Wall B													

Components	R-Values	Loss	Gain	Loss	Gain	Loss	Gain	Loss	Gain	Loss	Gain	Loss	Gain	Loss	Gain	Loss	Gain
North Shaded	4.06	20.05	10.52	3	60	32											
East/West	4.06	20.05	26.96	19	381	512											
South	4.06	20.05	20.50	3	60	61											
WOB Windows	3.15	25.84	28.32														
Skylight	2.03	40.10	88.23														
Doors	4.00	20.35	2.75	21	427	58											
Net exposed walls A	21.12	3.85	0.52	627		327											
Net exposed walls B	14.49	5.62	0.76														
Exposed Ceilings A	59.22	1.37	0.64														
Exposed Ceilings B	22.86	3.56	1.66														
Exposed Floors	29.80	2.73	0.17														
Foundation Conductive Heatloss	On Grade () or Above			7446													
Total Conductive	Heat Loss			8375													
	Heat Gain				990												
Air Leakage	Heat Loss/Gain	1.0298	0.0305	8625	30												
Ventilation	Case 1	0.07	0.05														
	Case 2	14.07	11.88														
	Case 3	x	0.03	243	49												
Heat Gain People					239												
Appliances Loads	1 = .25 percent				5258												
Duct and Pipe loss					10%												
Level 1 HL Total	17,243		Total HL for per room	17243													
Level 1 HG Total	1,390		Total HG per room x 1.3		1390												

Level 2

Run ft. exposed wall A	35	A	LAUN	26	A	LIV	55	A	FOY	14	A	DIN	18	A	GRT	33	A	A	A	A	A	A	A
Run ft. exposed wall B	B	B	B	B	B	B	B	B	B	B	B	B	B	B	B	B	B	B	B	B	B	B	B
Ceiling height	10.0		12.0		10.0		11.0		10.0		10.0		10.0		10.0		10.0		10.0		10.0		10.0
Floor area	306	Area	122	Area	257	Area	134	Area	254	Area	200	Area	5	Area	Area	Area	Area	Area	Area	Area	Area	Area	Area
Exposed Ceilings A	A	A	A	A	A	A	A	A	A	A	A	A	A	A	A	A	A	A	A	A	A	A	A
Exposed Ceilings B	B	B	B	B	B	B	B	B	B	B	B	B	B	B	B	B	B	B	B	B	B	B	B
Exposed Floors	Flr	Flr	Flr	Flr	Flr	Flr	Flr	Flr	Flr	Flr	Flr	Flr	Flr	Flr	Flr	Flr	Flr	Flr	Flr	Flr	Flr	Flr	Flr
Gross Exp Wall A	350		312		550		154		180		330												
Gross Exp Wall B																							

Components	R-Values	Loss	Gain	Loss	Gain	Loss	Gain	Loss	Gain	Loss	Gain	Loss	Gain	Loss	Gain	Loss	Gain	Loss	Gain	Loss	Gain	Loss	Gain
North Shaded	4.06	20.05	10.52	24	481	253																	
East/West	4.06	20.05	26.96	44	882	1186																	
South	4.06	20.05	20.50																				
Existing Windows	1.99	40.90	22.15																				
Skylight	2.03	40.10	88.23																				
Doors	4.00	20.35	2.75																				
Net exposed walls A	17.03	4.78	0.65	282	1348	182	291	1391	188	438	2094	283	109	521	70	124	593	80	252	1205	163		
Net exposed walls B	8.50	9.58	1.29																				
Exposed Ceilings A	59.22	1.37	0.64																				
Exposed Ceilings B	22.86	3.56	1.66																				
Exposed Floors	29.80	2.73	0.17																				
Foundation Conductive Heatloss	On Grade () or Above																						
Total Conductive	Heat Loss				2711			1818		4339		1430		1715		2775							
	Heat Gain					1621		246		2941		620		1228		2101							
Air Leakage	Heat Loss/Gain	0.3499	0.0305		949	49		636	7	1518	90	500	19	600	37	971	64						
Ventilation	Case 1	0.02	0.05																				
	Case 2	14.07	11.88																				
	Case 3	x	0.03		79	81		53	12	126	147		42	31		50	61		81	105			
Heat Gain People						239																	
Appliances Loads	1 = .25 percent				1.0	1314	1.0	1314					1.0	1314	0.5	657							
Duct and Pipe loss						10%																	
Level 2 HL Total	20,393		Total HL for per room	3739		3986		2507		5983		4130		1971		2366		3433		3827		3805	
Level 2 HG Total	18,280		Total HG per room x 1.3					2054					871										

I review and take responsibility for the design work and am qualified in the appropriate category as an "other designer" under

Division C subsection 3.2.5. of the Building Code. Individual BCIN:

32964

Dave DaCosta

Dave DaCosta

SB-12 Package

Package A1

Total Heat Loss	57,283	btu/h
Total Heat Gain	35,225	btu/h

2012 OBC	Builder: Bayview Wellington	Date: April 4, 2018	System 1	Weather Data	Bradford	44	-9.4	86	22	48.2	Heat Loss ^T	81.4 deg. F	Ht gain ^T	11 deg. F	GTA: 3179	Project #	PJ-00204
	Project: Green Valley East	Model: Rideau 7 S42-7C														Layout #	JB-04589

Level 3		MAST		ENS		WC		WIC		BED 2		BATH		BED 3		BED 4		BATH 2		MED														
Run ft. exposed wall A		31 A		19 A		4 A		5 A		14 A		6 A		31 A		41 A		12 A		17 A		A												
Run ft. exposed wall B		B		B		B		B		B		B		B		B		B		B		B												
Ceiling height		9.0		8.0		8.0		8.0		8.0		8.0		8.0		9.0		8.0		10.0		8.0												
Floor area		249 Area		108 Area		27 Area		65 Area		170 Area		99 Area		221 Area		257 Area		102 Area		287 Area		Area												
Exposed Ceilings A		249 A		108 A		27 A		65 A		170 A		99 A		221 A		257 A		102 A		287 A		A												
Exposed Ceilings B		B		B		B		B		B		B		B		B		B		B		B												
Exposed Floors		Flr		Flr		Flr		Flr		8 Flr		83 Flr		221 Flr		Flr		Flr		7 Flr		Flr												
Gross Exp Wall A		279		152		32		40		112		48		248		369		96		170														
Gross Exp Wall B																																		
Components	R-Values	Loss	Gain	Loss	Gain	Loss	Gain	Loss	Gain	Loss	Gain	Loss	Gain	Loss	Gain	Loss	Gain	Loss	Gain	Loss	Gain	Loss	Gain											
North Shaded	4.06	20.05	10.52					8	160	84				16	321	168																		
East/West	4.06	20.05	26.96	44	882	1186								8	160	84																		
South	4.06	20.05	20.50	22	441	451																												
Existing Windows	1.99	40.90	22.15																															
Skylight	2.03	40.10	88.23																															
Doors	4.00	20.35	2.75																															
Net exposed walls A	17.03	4.78	0.65	213	1018	138	130	621	84	24	115	16	40	191	26	96	459	62	40	191	26	204	975	132	269	1286	174	74	354	48	136	650	88	
Net exposed walls B	8.50	9.58	1.29																															
Exposed Ceilings A	59.22	1.37	0.64	249	342	160	108	148	69	27	37	17	65	89	42	170	234	109	99	136	64	221	304	142	257	353	165	102	140	65	287	394	184	
Exposed Ceilings B	22.86	3.56	1.66																															
Exposed Floors	29.80	2.73	0.17													8	22	1	83	227	14	221	604	37							7	19	1	
Foundation Conductive Heatloss																																		
Total Conductive	Heat Loss			2684																														
	Heat Gain				1935				746		117			281			1035			714			2765				3644			935		1745		970
Air Leakage	Heat Loss/Gain	0.2251	0.0305	604	59				273	23		70	4		63	2		233	10		161	6		622	46		820	84		210	17		393	30
Ventilation	Case 1	0.01	0.05																															
	Case 2	14.07	11.88																															
	Case 3	x	0.03																															
Heat Gain People			239	2	78	97		35	37		9	6		8	3		30	17		21	9		80	75		106	138	239		27	28		51	48
Appliances Loads	1 =.25 percent		5258													1		239					1		239	1								
Duct and Pipe loss			10%																												0.5		657	
Level 3 HL Total	19,647		Total HL for per room	3366			1519		392			352		1298			983		88	19	1	339	174			4570		1173		792		2189	2217	
Level 3 HG Total	15,555		Total HG per room x 1.3		3339			1048			164		95		789			288				1	3806	2639			4183							

Level 4																	
Run ft. exposed wall A	A			A				A					A				A
Run ft. exposed wall B	B			B				B					B				B
Ceiling height																	
Floor area	Area			Area				Area					Area				Area
Exposed Ceilings A	A			A				A					A				A
Exposed Ceilings B	B			B				B					B				B
Exposed Floors	Flr			Flr				Flr					Flr				Flr
Gross Exp Wall A																	
Gross Exp Wall B																	
Components	R-Values	Loss	Gain	Loss	Gain	Loss	Gain	Loss	Gain	Loss	Gain	Loss	Gain	Loss	Gain	Loss	Gain
North Shaded	4.06	20.05	10.52														
East/West	4.06	20.05	26.96														
South	4.06	20.05	20.50														
Existing Windows	1.99	40.90	22.15														
Skylight	2.03	40.10	88.23														
Doors	4.00	20.35	2.75														
Net exposed walls A	17.03	4.78	0.65														
Net exposed walls B	8.50	9.58	1.29														
Exposed Ceilings A	59.22	1.37	0.64														
Exposed Ceilings B	22.86	3.56	1.66														
Exposed Floors	29.80	2.73	0.17														
Foundation Conductive Heatloss																	
Total Conductive	Heat Loss																
	Heat Gain																
Air Leakage	Heat Loss/Gain	0.0000	0.0305														
Ventilation	Case 1	0.00	0.05														
	Case 2	14.07	11.88														
	Case 3	x	0.03														
Heat Gain People			239														
Appliances Loads	1 =.25 percent		5258														
Duct and Pipe loss			10%														
Level 4 HL Total	0																
Level 4 HG Total	0																

Total Heat Loss	57,283	btu/h
Total Heat Gain	35,225	btu/h

I review and take responsibility for the design work and am qualified in the appropriate category as an "other designer" under

Division C subsection 3.2.5. of the Building Code. Individual BCIN:

32964

David DaCosta

David DaCosta

SB-12 Package

Package A1

I review and take responsibility for the design work and am qualified in the appropriate category as an "other designer" under Division C subsection 3.2.5. of the Building Code.

Individual BCIN: 32964



David DaCosta

Package:
Package A1
Project:
Bradford
Model:
S42-7C
RESIDENTIAL MECHANICAL VENTILATION DESIGN SUMMARY

For systems serving one dwelling unit & conforming to the Ontario Building Code, O.reg 332/12

Location of Installation

Lot #	Plan #
Township	Bradford
Roll #	Permit #
Address	

Builder

Name	Bayview Wellington
Address	
City	
Tel	Fax

Installing Contractor

Name	
Address	
City	
Tel	Fax

Combustion Appliances 9.32.3.1(1)

- | | | |
|----|-------------------------------------|--|
| a) | ☒ | Direct vent (sealed combustion) only |
| b) | ☐ | Positive venting induced draft (except fireplaces) |
| c) | ☐ | Natural draft, B-vent or induced draft fireplaces |
| d) | ☐ | Solid fuel (including fireplaces) |
| e) | ☐ | No combustion Appliances |

Heating System

- | | |
|-------------------------------------|--|
| ☒ | Forced air |
| ☐ | Non forced air |
| ☐ | Electric space heat (if over 10% of heat load) |

House Type 9.32.3.1(2)

- | | | |
|-------|-------------------------------------|---|
| I | ☒ | Type a) or b) appliances only, no solid fuel |
| II | ☐ | Type I except with solid fuel (including fireplace) |
| III | ☐ | Any type c) appliance |
| IV | ☐ | Type I or II either electric space heat |
| Other | ☐ | Type I, II or IV no forced air |

System Design Option

- | | | |
|---|-------------------------------------|---|
| 1 | ☐ | Exhaust only / forced air system |
| 2 | ☐ | HRV WITH DUCTING / forced air system |
| 3 | ☒ | HRV simplified connection to forced air system |
| 4 | ☐ | HRV full ducting/not coupled to forced air system |
| | | Part 6 design |

Total Ventilation Capacity 9.32.3.3(1)

Bsmt & Master Bdrm	2 @ 21.2 cfm	42.4 cfm
Other Bedrooms	3 @ 10.6 cfm	31.8 cfm
Bathrooms & Kitchen	5 @ 10.6 cfm	53 cfm
Other rooms	6 @ 10.6 cfm	63.6 cfm
Total		<u>190.8</u>

Principal Ventilation Capacity 9.32.3.4(1)

Master bedroom	1 @ 31.8 cfm	31.8 cfm
Other bedrooms	3 @ 15.9 cfm	47.7 cfm
Total		<u>79.5</u>

Principal Exhaust Fan Capacity

Make	Model	Location
LifeBreath	RNC155	Base
132 cfm		Sones or Equiv.

Heat Recovery Ventilator

Make	LifeBreath
Model	RNC155
132 cfm high	80 cfm low
Sensible efficiency @ -25 deg C	71%
Sensible efficiency @ 0 deg C	75%

Note: Installer to balance HRV/ERV to within 10 percent of PVC

Supplemental Ventilation Capacity

Total ventilation capacity	190.8
Less principal exhaust capacity	79.5
REQUIRED supplemental vent. Capacity	<u>111.3</u> cfm

Supplemental Fans 9.32.3.5.

Location	cfm	Model	Sones
Ens	50	XB50	0.3
Bath	50	XB50	0.3
Bath 2	50	XB50	0.3

all fans HVI listed Make Broan or Equiv.

Designer Certification

I hereby certify that this ventilation system has been designed in accordance with the Ontario Building Code.

Name David DaCosta

Signature



HRAI #

5190

BCIN #

32964

Date

April 4, 2018



2985 Drew Road, Suite 202, Mississauga, Ontario
 L4T 0A4 Tel: 905-671-9800 Fax: 647-494-9643
 e-mail dave@gtadesigns.ca

Energy Efficiency Design Summary: Prescriptive Method (Building Code Part 9, Residential)

Page 7
 Project # PJ-00204
 Layout # JB-04589

This form is used by a designer to demonstrate that the energy efficiency design of a house complies with the building code using the prescriptive method described in Subsection 3.1.1. of SB-12. This form is applicable where the ratio of gross area of windows/sidelights/skylights/glazing in doors and sliding glass doors to the gross area of peripheral walls is not more than 22%.

For use by Principal Authority

Application No:

Model/Certification Number

A. Project Information

Building number, street name	Rideau 7 S42-7C	Unit number	Lot/Con
Municipality	Bradford	Postal code	Reg. Plan number / other description

B. Prescriptive Compliance [indicate the building code compliance package being employed in the house design]

SB-12 Prescriptive (input design package):

Package A1

Table: 3.1.1.2.A

C. Project Design Conditions

Climatic Zone (SB-1):	Heat. Equip. Efficiency	Space Heating Fuel Source
☒ Zone 1 (< 5000 degree days) ☐ Zone 2 (≥ 5000 degree days)	☒ ≥ 92% AFUE ☐ ≥ 84% < 92% AFUE	☒ Gas ☐ Propane ☐ Solid Fuel ☐ Oil ☐ Electric ☐ Earth Energy
Ratio of Windows, Skylights & Glass (W, S & G) to Wall Area	Other Building Characteristics	
Area of Walls = <u>380.46</u> m ² or <u>4095.3</u> ft ² Area of W, S & G = <u>63.451</u> m ² or <u>683.0</u> ft ²	W, S & G % = <u>17%</u> Utilize Window ☐ Yes Averaging ☒ No	☐ Log/Post&Beam ☐ ICF Above Grade ☐ ICF Basement ☐ Slab-on-ground ☐ Walkout Basement ☒ Air Conditioning ☐ Combo Unit ☐ Air Sourced Heat Pump (ASHP) ☐ Ground Source Heat Pump (GSHP)

D. Building Specifications [provide values and ratings of the energy efficiency components proposed]

Energy Efficiency Substitutions			
☐ ICF (3.1.1.2.(5) & (6) / 3.1.1.3.(5)) ☐ Combined space heating and domestic water heating systems (3.1.1.2(7) / 3.1.1.3.(7))			
☐ Airtightness substitution(s) Airtightness test required (Refer to Design Guide Attached)	☐ Table 3.1.1.4.B Required:		Permitted Substitution:
	☐ Table 3.1.1.4.C Required:		Permitted Substitution:
Building Component	Minimum RSI/R-Values or Maximum U-Value ¹		Efficiency Ratings
Thermal Insulation	Nominal	Effective	Windows & Doors Provide U-Value ⁽¹⁾ or ER rating
Ceiling with Attic Space	60		Windows/Sliding Glass Doors 1.4
Ceiling without Attic Space	31		Skylights 2.8
Exposed Floor	31		Mechanicals
Walls Above Grade	22		Heating Equip. (AFUE) 96%
Basement Walls	20.0ci		HRV Efficiency (SRE% at 0°C) 75%
Slab (all >600mm below grade)	x		DHW Heater (EF) 0.80
Slab (edge only ≤600mm below grade)	10		DWHR (CSA B55.1 (min. 42% efficiency)) #Showers 2
Slab (all ≤600mm below grade, or heated)	10		Combined Heating System

(1) U value to be provided in either W/(m²·K) or Btu/(h·ft²·F) but not both.

E. Designer(s) [name(s) & BCIN(s), if applicable, of person(s) providing information herein to substantiate that design meets building code]

Name	BCIN	Signature
David DaCosta	32964	

Package: Package A1 System: System 1
Project: Bradford Model: S42-7C

Air Leakage Calculations

Building Air Leakage Heat Loss				
B	LRairh	Vb	HL ^Δ T	HL _{leak}
0.018	0.319	36948	81.4	17249

Building Air Leakage Heat Gain				
B	LRairh	Vb	HG ^Δ T	HG _{Leak}
0.018	0.079	36948	11	578

Air Leakage Heat Loss/Gain Multiplier Table (Section 11)				
Level	Level Factor (LF)	Building Air	Level Conductive Heat Loss	Air Leakage Heat Loss Multiplier
Level 1	0.5	17249	8375	1.0298
Level 2	0.3		14789	0.3499
Level 3	0.2		15326	0.2251
Level 4	0		0	0.0000

Levels			
1	2	3	4
(LF)	(LF)	(LF)	(LF)
1.0	0.6	0.5	0.4
	0.4	0.3	0.3
		0.2	0.2
			0.1

HG LEAK		Air Leakage Heat Gain	
	578		0.0305
BUILDING CONDUCTIVE HEAT GAIN			18929

Levels this Dwelling	
3	

Ventilation Calculations

Ventilation Heat Loss

Ventilation Heat Loss				
C	PVC	HL ^Δ T	(1-E) HRV	HL _{bvent}
1.08	79.5	81.4	0.16	1118

Ventilation Heat Gain

Ventilation Heat Gain			
C	PVC	HG ^Δ T	HG _{bvent}
1.1	79.5	11	944

Case 1

Ventilation Heat Loss (Exhaust only Systems)

Case 1 - Exhaust Only				
Level	LF	HL _{bvent}	LVL Cond. HL	Multiplier
Level 1	0.5	1118	8375	0.07
Level 2	0.3		14789	0.02
Level 3	0.2		15326	0.01
Level 4	0		0	0.00

Case 1

Ventilation Heat Gain (Exhaust Only Systems)

Case 1 - Exhaust Only		Multiplier
HG _{bvent}	944	0.05
Building	18929	

Case 2

Ventilation Heat Loss (Direct Ducted Systems)

C	HL ^Δ T	(1-E) HRV	Multiplier
1.08	81.4	0.16	14.07

Case 2

Ventilation Heat Gain (Direct Ducted Systems)

C	HG ^Δ T	Multiplier
1.08	11	11.88

Case 3

Ventilation Heat Loss (Forced Air Systems)

		HL _{bvent}	Multiplier
Total Ventilation Load		1118	0.03

Case 3

Ventilation Heat Gain (Forced Air Systems)

		Vent Heat Gain	Multiplier
HG _{bvent}	HG*1.3	944	0.05
944	1		

Foundation Conductive Heatloss Level 1

2182 Watts 7446 Btu/h

Foundation Conductive Heatloss Level 2

Watts Btu/h


Envelope Air Leakage Calculator


Supplemental tool for CAN/CSA-F280



Weather Station Description				
Province:	Ontario ▼			
Region:	Bradford ▼			
Weather Station Location:	Open flat terrain, grass ▼			
Anemometer height (m):	10			
Local Shielding				
Building Site:	Suburban, forest ▼			
Walls:	Heavy ▼			
Flue:	Heavy ▼			
Highest Ceiling Height (m):	6.61			
Building Configuration				
Type:	Detached			
Number of Stories:	Two			
Foundation:	Full			
House Volume (m ³):	1046.37			
Air Leakage/Ventilation				
Air Tightness Type:	Present (1961-) (ACH=3.57)			
Custom BDT Data:	ELA @ 10 Pa. ▼ 322.44 cm ²			
	3.57 ACH @ 50 Pa			
Mechanical Ventilation (L/s):	Total Supply:		Total Exhaust:	
	39.75		39.75	
Flue #:	#1	#2	#3	#4
Diameter (mm):	0	0	0	0
Heating Air Leakage Rate (ACH/H):		0.319		
Cooling Air Leakage Rate (ACH/H):		0.079		

Residential Foundation Thermal Load Calculator

Supplemental tool for CAN/CSA-F280

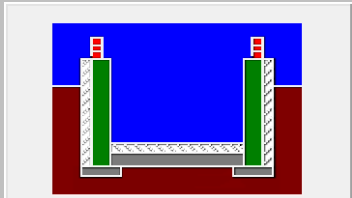Weather Station Description		
Province:	Ontario	▼
Region:	Bradford	▼
Site Description		
Soil Conductivity:	High conductivity: moist soil	▼
Water Table:	Normal (7-10 m, 23-33 Ft)	▼
Foundation Dimensions		
Floor Length (m):	22.43	 Insulation Configuration
Floor Width (m):	5.31	
Exposed Perimeter (m):	55.47	
Wall Height (m):	2.74	
Depth Below Grade (m):	1.62	
Window Area (m ²):	2.32	
Door Area (m ²):	1.95	
Radiant Slab		
Heated Fraction of the Slab:	0	
Fluid Temperature (°C):	33	
Design Months		
Heating Month	1	
Foundation Loads		
Heating Load (Watts):		2182

 	FLEX DUCT		LOW/HIGH WALL/KICK SUPPLY DIFFUSER		DUCT CONNECTION TO JOIST LINING		RETURN AIR GRILLE (SIZE INDICATED ON DRAWING)	S.A.	SUPPLY AIR
	RIGID ROUND DUCT		HRV EXHAUST GRILLE		RETURN AIR PIPE RISER		RETURN AIR RISER UP TO FLOOR ABOVE	R.A.	RETURN AIR
	SUPPLY DIFFUSER		SUPPLY AIR PIPE RISER		RETURN ROUND DUCT		RETURN AIR FROM BASEMENT SECOND FLOOR		THERMOSTAT
			VOLUME DAMPER						PRINCIPAL EXHAUST FAN SWITCH
									W/R & PRINCIPAL EXHAUST FAN

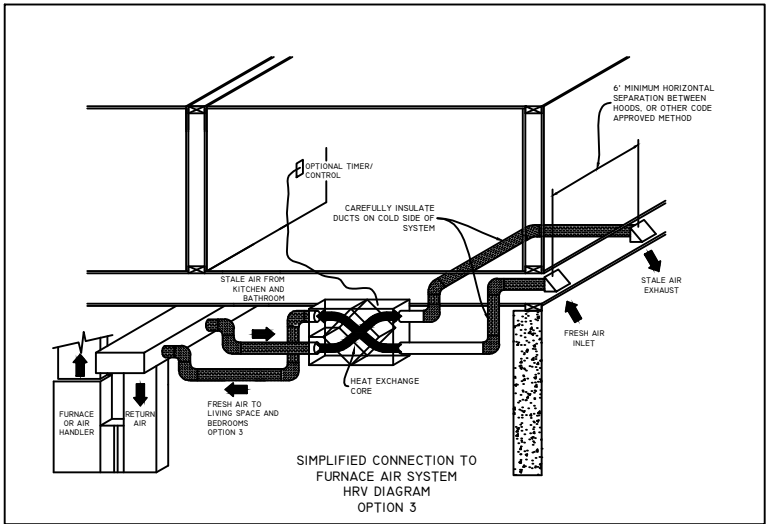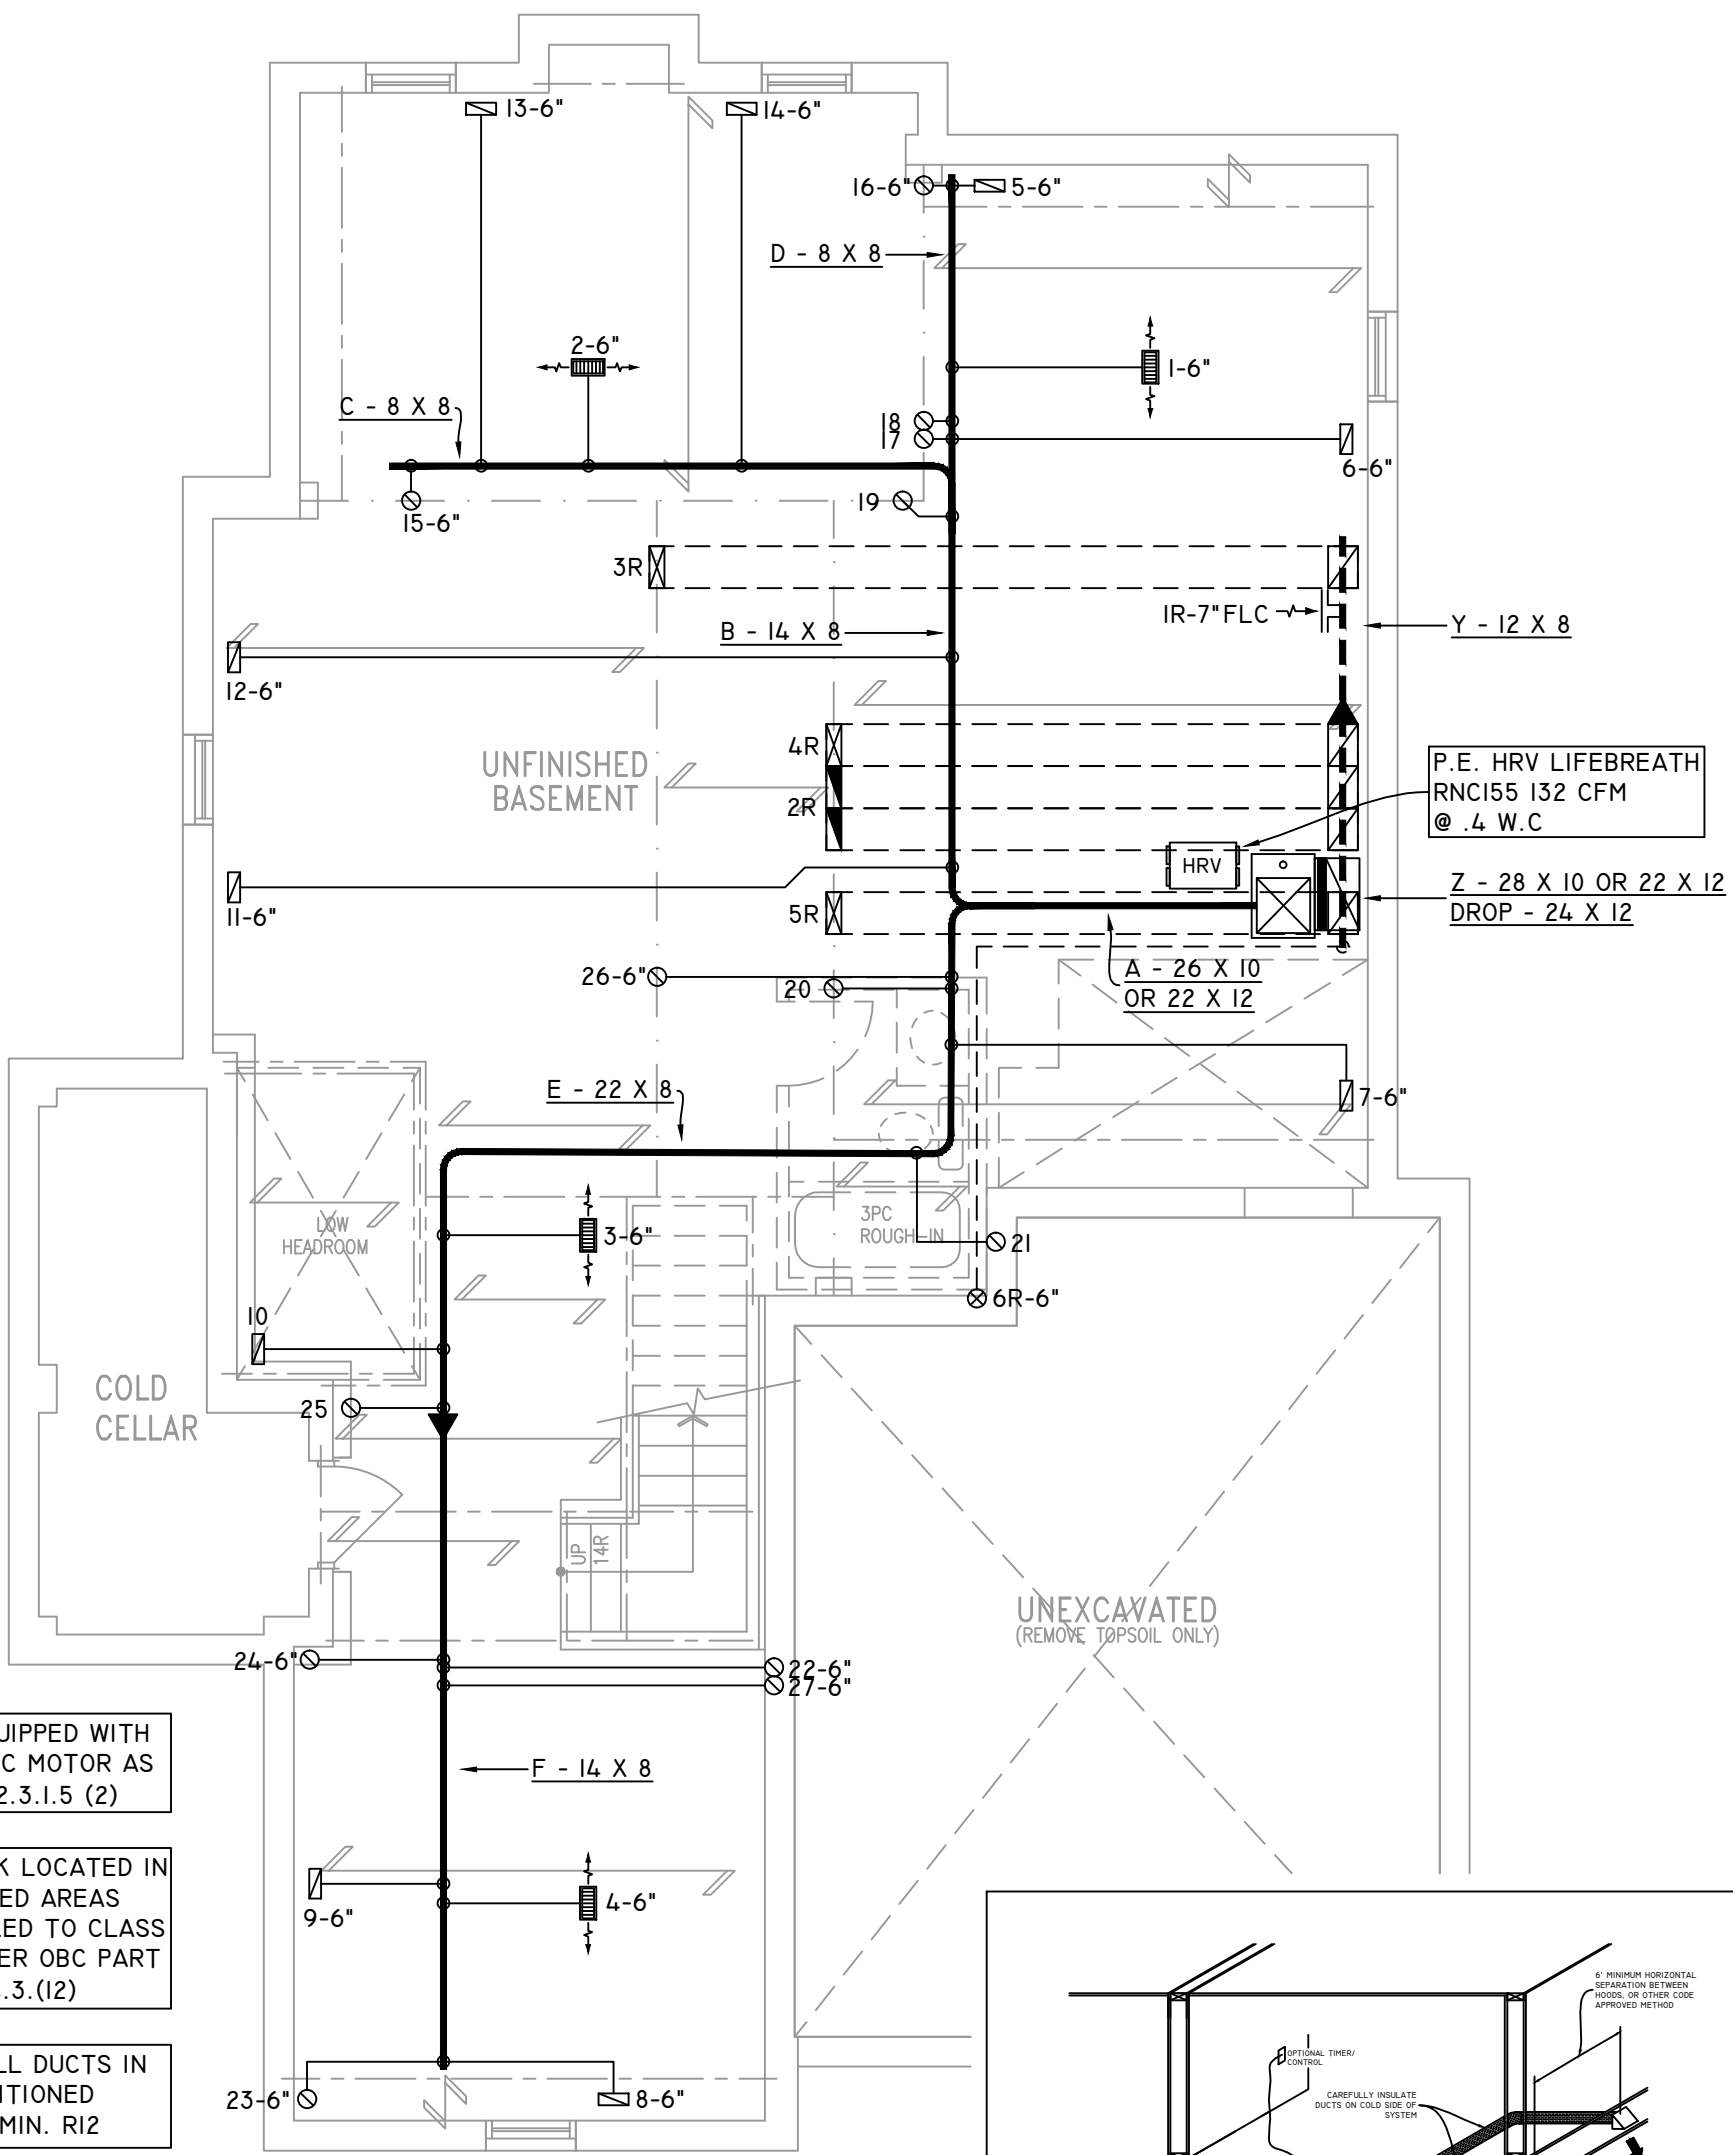

BASEMENT PLAN 'A'

OBC 2012

THE UNDERSIGNED HAS REVIEWED AND TAKES RESPONSIBILITY FOR THIS DESIGN ON BEHALF OF GTA DESIGNS INC. AND HAS THE QUALIFICATIONS AND MEETS THE REQUIREMENTS SET OUT IN THE BUILDING CODE TO BE A DESIGNER

QUALIFICATION INFORMATION

REQUIRED UNLESS DESIGN IS EXEMPT UNDER DIVISION C 3.2.5.1 OF THE ONTARIO BUILDING CODE

DAVID DA COSTA  B.C.I.N. 32964
SIGNATURE OF DESIGNER

ZONE I COMPLIANCE
PACKAGE "A1" REF. TABLE 3.1.1.2.A

NOTES

INSTALLATION TO COMPLY WITH THE LATEST ONTARIO BUILDING CODE.

ALL SUPPLY OUTLETS TO BE 5" DIA. UNLESS OTHERWISE SPECIFIED.

PROVIDE BALANCING DAMPERS ON ALL BRANCHES.

ALL R/A PARTITIONS 6" (FIRST FLOOR ONLY)

INSULATE DUCTS IN UNCONDITIONED SPACES R12 UNDERCUT ALL DOORS 1" MIN.

CONTRACTOR MUST WORK FROM APPROVED PLANS.

ANY ALTERATIONS TO THIS ORIGINAL PLAN ARE NOT THE RESPONSIBILITY OF GTA DESIGNS.

GTA DESIGNS MUST BE CONSULTED IF KITCHEN EXHAUST FAN EXCEEDS 700 CFM DEPRESSURIZATION MAY OCCUR WITH IN THE DWELLING.




2985 DREW ROAD
SUITE 202,
MISSISSAUGA, ONT.
L4T 0A4 TEL: 905-671-9800
EMAIL: DAVE@GTADESIGNS.CA
WEB: WWW.GTADESIGNS.CA


HEAT-LOSS	57,283	BTU/HR.
UNIT MAKE	AMANA	OR EQUAL.
UNIT MODEL	AMEC960803BNA	OR EQUAL.
UNIT HEATING INPUT	80,000	BTU/HR.
UNIT HEATING OUTPUT	76,800	BTU/HR.
A/C COOLING CAPACITY	3.0	TONS.
FAN SPEED	1172	CFM

# OF RUNS	S/A	R/A	FANS
3RD FLOOR			
2ND FLOOR	13	4	4
1ST FLOOR	10	1	2
BASEMENT	4	1	

FLOOR PLAN:	BASEMENT
DRAWN BY:	AM
CHECKED:	DD
LAYOUT NO.	JB-04589
SQFT	3179
DRAWING NO.	MI

 DATE:	APRIL 4, 2018
CLIENT:	BAYVIEW WELLINGTON
MODEL:	S42-7C RIDEAU 7
PROJECT:	GREEN VALLEY EAST BRADFORD,ONT.
SCALE:	3/16" = 1'-0"

	FLEX DUCT		LOW/HIGH WALL/KICK SUPPLY DIFFUSER		DUCT CONNECTION TO JOIST LINING		RETURN AIR GRILLE (SIZE INDICATED ON DRAWING)	S.A.	SUPPLY AIR
	RIGID ROUND DUCT		HRV EXHAUST GRILLE		RETURN AIR PIPE RISER		RETURN AIR RISER UP TO FLOOR ABOVE	R.A.	RETURN AIR
	SUPPLY DIFFUSER		SUPPLY AIR PIPE RISER		RETURN ROUND DUCT		RETURN AIR FROM BASEMENT SECOND FLOOR		THERMOSTAT
			VOLUME DAMPER						PRINCIPAL EXHAUST FAN SWITCH
									W/R & PRINCIPAL EXHAUST FAN

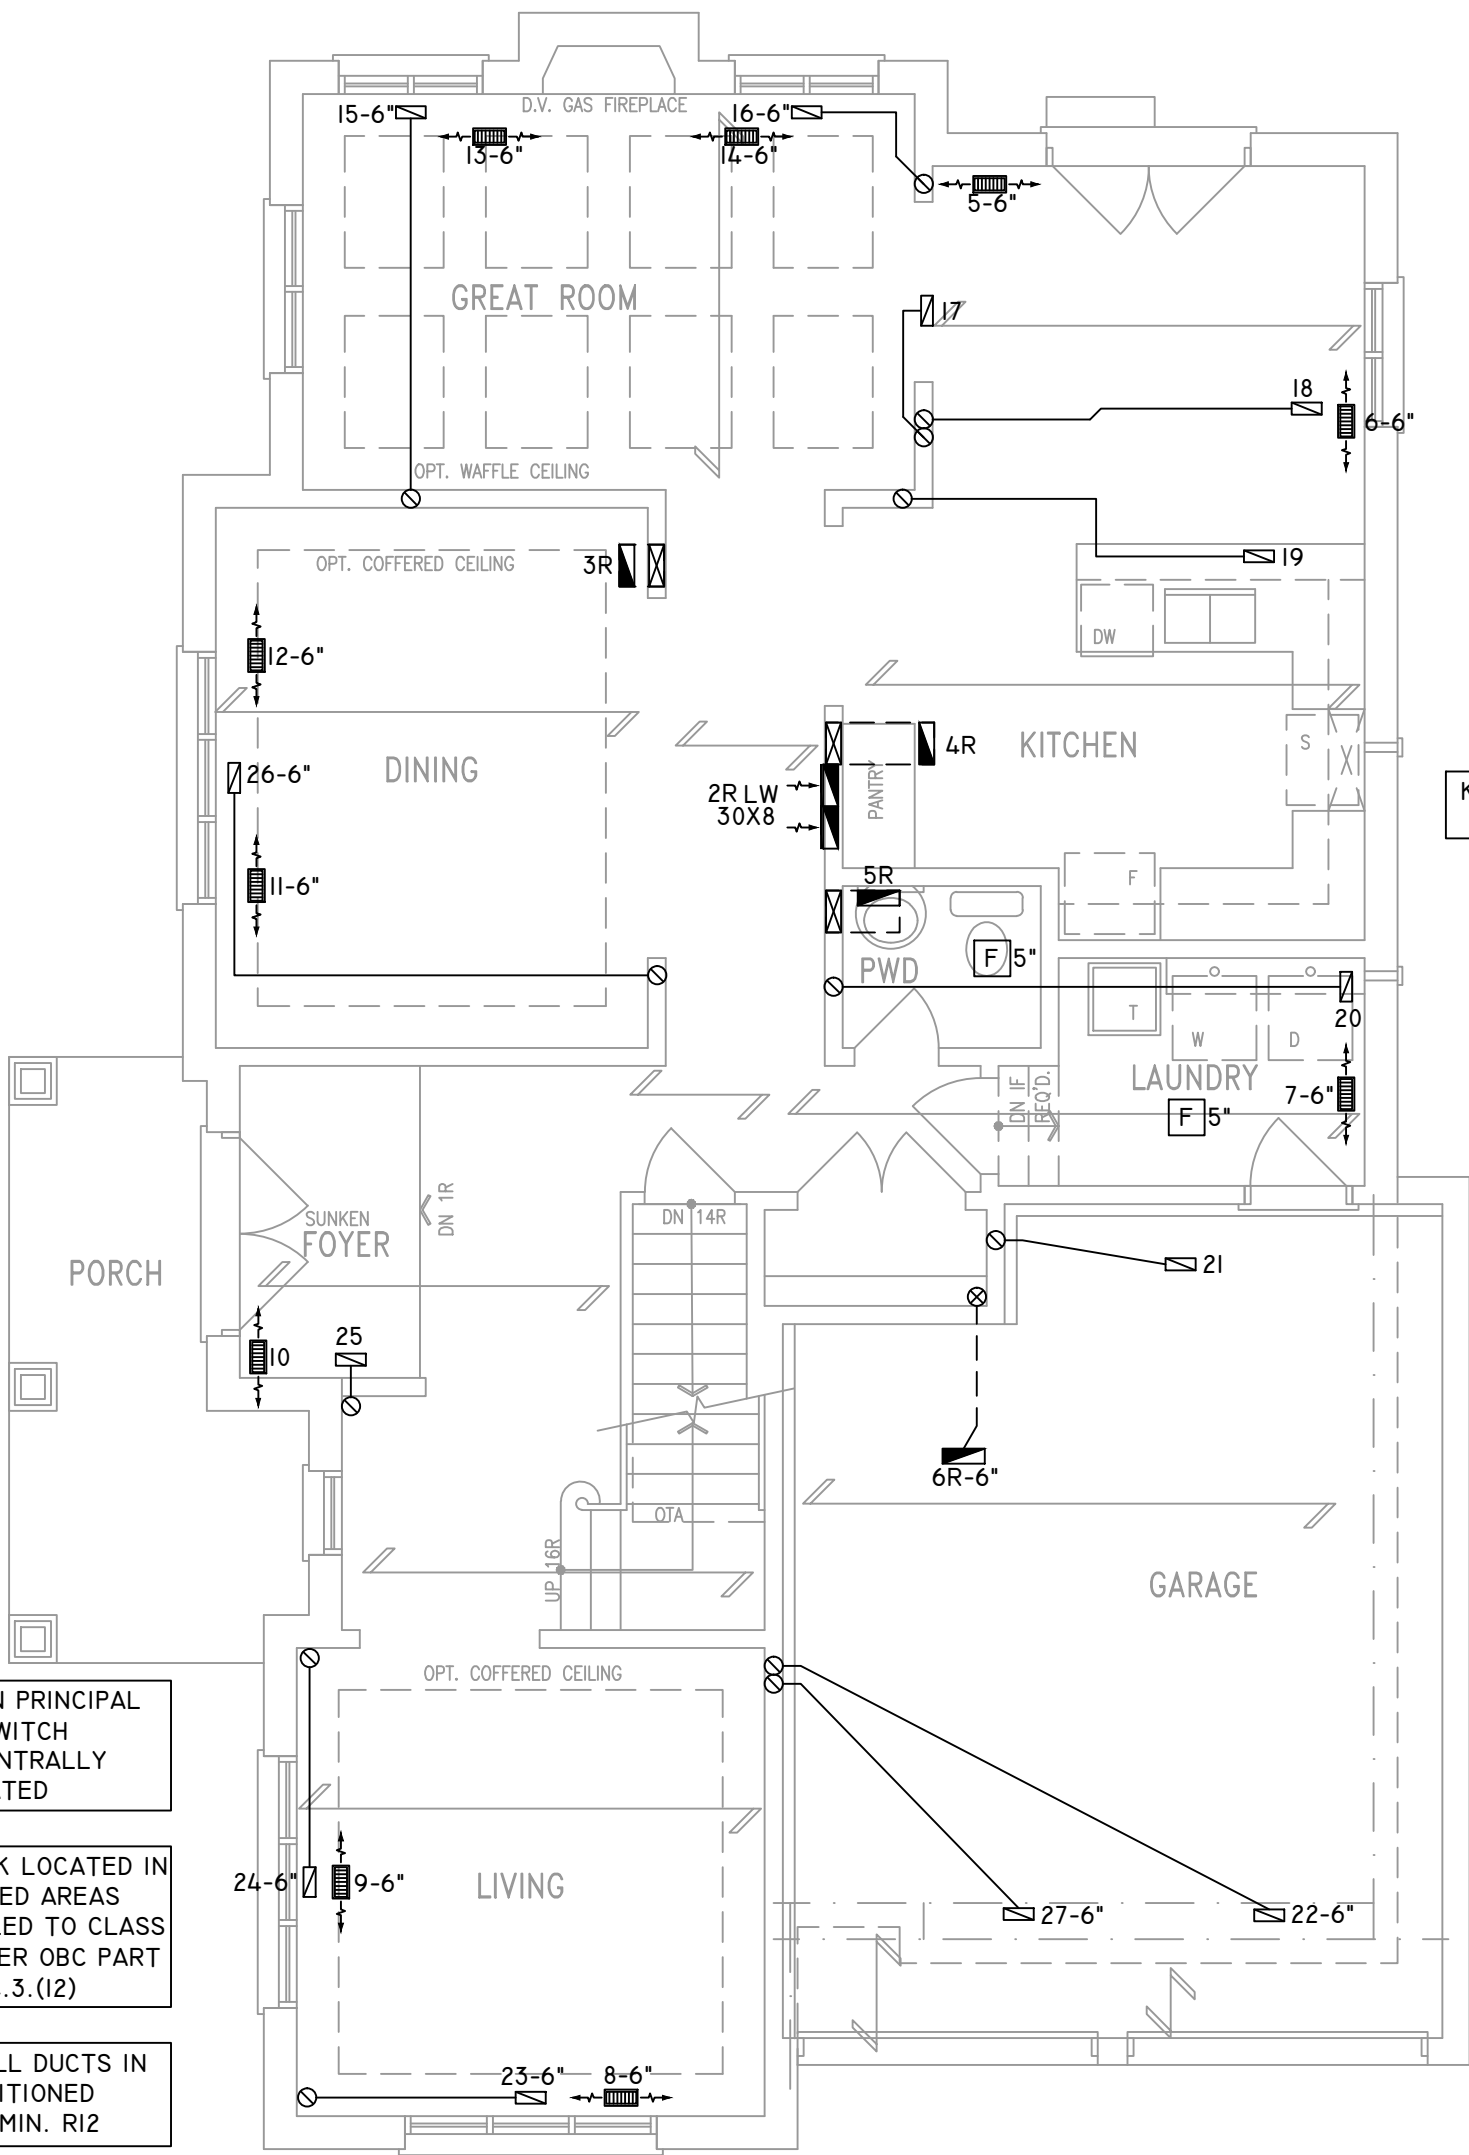

CIRCULATION PRINCIPAL FAN SWITCH TO BE CENTRALLY LOCATED

ALL DUCTWORK LOCATED IN CONDITIONED AREAS MUST BE SEALED TO CLASS C LEVEL AS PER OBC PART 6-6.2.4.3.(12)

 
INSULATE ALL DUCTS IN UNCONDITIONED SPACES MIN. R12

FOR THE PURPOSE OF HEATLOSS/GAIN CALCULATIONS ALL ELEVATIONS HAVE BEEN CONSIDERED

THE UNDERSIGNED HAS REVIEWED AND TAKES RESPONSIBILITY FOR THIS DESIGN ON BEHALF OF GTA DESIGNS INC. AND HAS THE QUALIFICATIONS AND MEETS THE REQUIREMENTS SET OUT IN THE BUILDING CODE TO BE A DESIGNER

QUALIFICATION INFORMATION

REQUIRED UNLESS DESIGN IS EXEMPT UNDER DIVISION C 3.2.5.1 OF THE ONTARIO BUILDING CODE

DAVID DA COSTA  B.C.I.N. 32964

SIGNATURE OF DESIGNER

GROUND FLOOR PLAN 'A'

OBC 2012

ZONE I COMPLIANCE
PACKAGE "A1" REF. TABLE 3.1.1.2.A

NOTES
INSTALLATION TO COMPLY WITH THE LATEST ONTARIO BUILDING CODE.
ALL SUPPLY OUTLETS TO BE 5" DIA. UNLESS OTHERWISE SPECIFIED.
PROVIDE BALANCING DAMPERS ON ALL BRANCHES.
ALL R/A PARTITIONS 6" (FIRST FLOOR ONLY)
INSULATE DUCTS IN UNCONDITIONED SPACES R12 UNDERCUT ALL DOORS 1" MIN.
CONTRACTOR MUST WORK FROM APPROVED PLANS.
ANY ALTERATIONS TO THIS ORIGINAL PLAN ARE NOT THE RESPONSIBILITY OF GTA DESIGNS.
GTA DESIGNS MUST BE CONSULTED IF KITCHEN EXHAUST FAN EXCEEDS 700 CFM DEPRESSURIZATION MAY OCCUR WITH IN THE DWELLING.





2985 DREW ROAD
SUITE 202,
MISSISSAUGA, ONT.
L4T 0A4 TEL: 905-671-9800
EMAIL: DAVE@GTADDESIGNS.CA
WEB: WWW.GTADDESIGNS.CA


HEAT-LOSS	57,283	BTU/HR.
UNIT MAKE	AMANA	OR EQUAL.
UNIT MODEL	AMEC960803BNA	OR EQUAL.
UNIT HEATING INPUT	80,000	BTU/HR.
UNIT HEATING OUTPUT	76,800	BTU/HR.
A/C COOLING CAPACITY	3.0	TONS.
FAN SPEED	1172	CFM

# OF RUNS	S/A	R/A	FANS
3RD FLOOR			
2ND FLOOR	13	4	4
1ST FLOOR	10	1	2
BASEMENT	4	1	

FLOOR PLAN: GROUND FLOOR	
DRAWN BY: AM	CHECKED: DD
LAYOUT NO. JB-04589	DRAWING NO. M2

  DATE:	APRIL 4, 2018
CLIENT:	BAYVIEW WELLINGTON
MODEL:	S42-7C RIDEAU 7
PROJECT:	GREEN VALLEY EAST BRADFORD,ONT.
SCALE:	3/16" = 1'-0"

	FLEX DUCT		LOW/HIGH WALL/KICK SUPPLY DIFFUSER		DUCT CONNECTION TO JOIST LINING		RETURN AIR GRILLE (SIZE INDICATED ON DRAWING)	S.A.	SUPPLY AIR
	RIGID ROUND DUCT		HRV EXHAUST GRILLE		RETURN AIR PIPE RISER		RETURN AIR RISER UP TO FLOOR ABOVE	R.A.	RETURN AIR
	SUPPLY DIFFUSER		SUPPLY AIR PIPE RISER		RETURN ROUND DUCT		RETURN AIR FROM BASEMENT SECOND FLOOR		THERMOSTAT
			VOLUME DAMPER						PRINCIPAL EXHAUST FAN SWITCH
									W/R & PRINCIPAL EXHAUST FAN

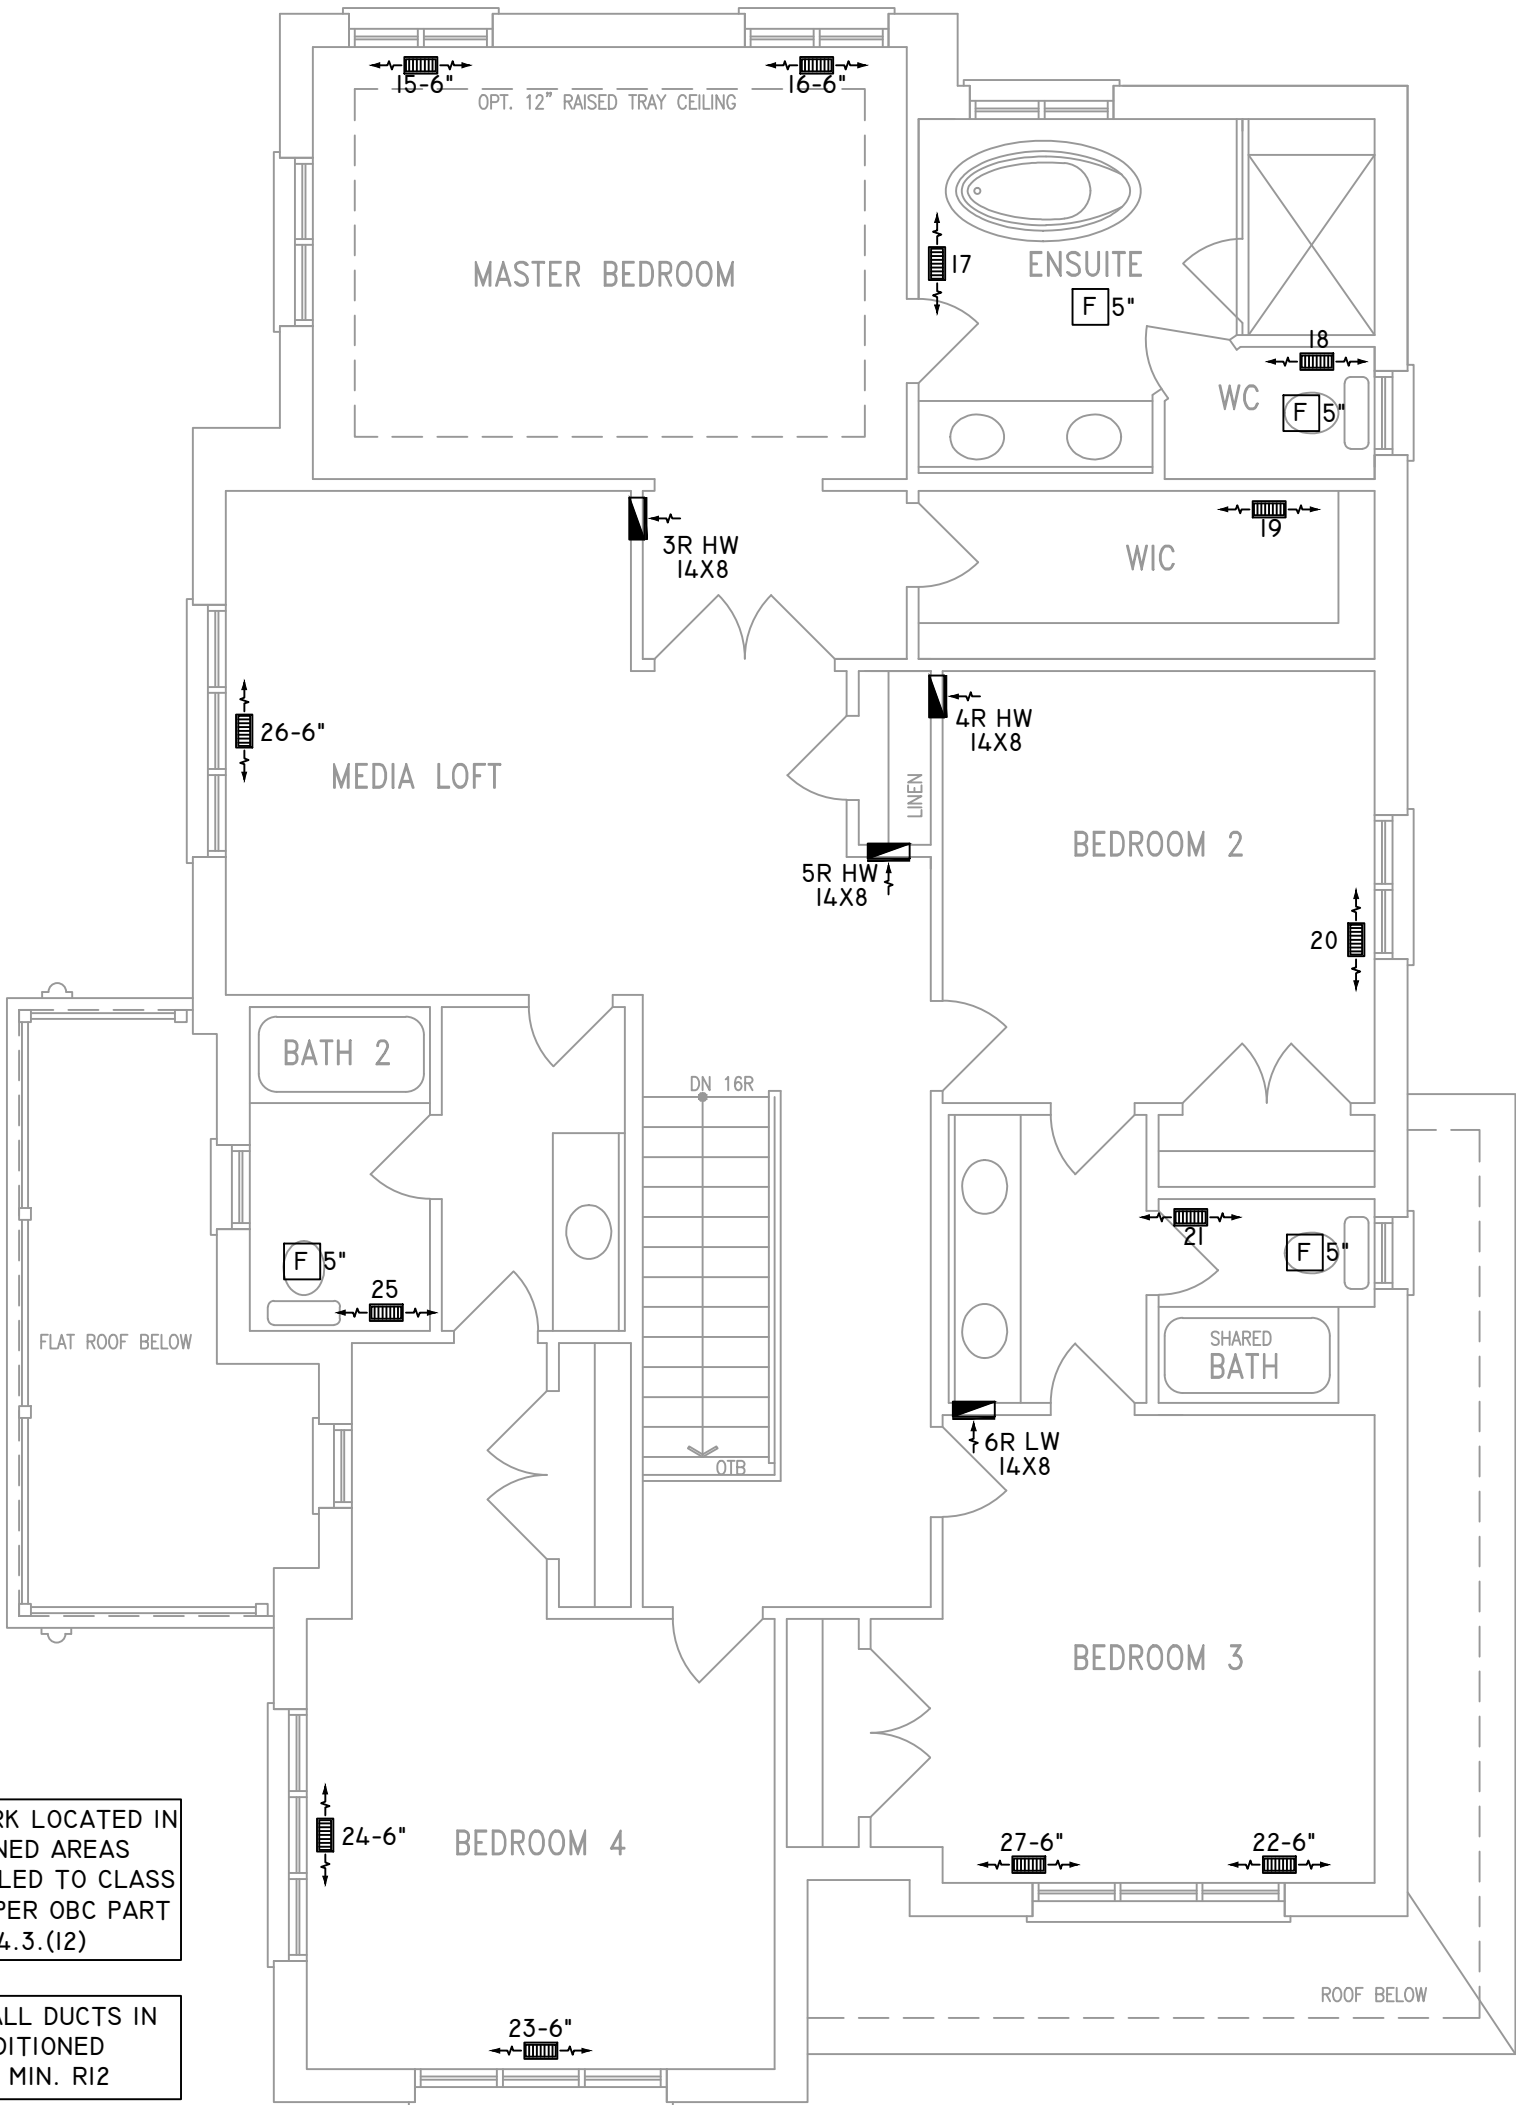

ALL DUCTWORK LOCATED IN
CONDITIONED AREAS
MUST BE SEALED TO CLASS
C LEVEL AS PER OBC PART
6-6.2.4.3.(12)

INSULATE ALL DUCTS IN
UNCONDITIONED
SPACES MIN. R12

FOR THE PURPOSE OF
HEATLOSS/GAIN
CALCULATIONS ALL
ELEVATIONS HAVE BEEN
CONSIDERED

THE UNDERSIGNED HAS REVIEWED AND TAKES RESPONSIBILITY FOR THIS DESIGN ON
BEHALF OF GTA DESIGNS INC. AND HAS THE QUALIFICATIONS AND MEETS THE
REQUIREMENTS SET OUT IN THE BUILDING CODE TO BE A DESIGNER

QUALIFICATION INFORMATION

REQUIRED UNLESS DESIGN IS EXEMPT UNDER DIVISION C 3.2.5.1 OF THE
ONTARIO BUILDING CODE

DAVID DA COSTA  B.C.I.N. 32964
SIGNATURE OF DESIGNER

SECOND FLOOR PLAN 'A' 4 BEDROOM + MEDIA LOFT

OBC 2012

ZONE I COMPLIANCE
PACKAGE "A1" REF. TABLE 3.1.1.2.A

NOTES

INSTALLATION TO COMPLY WITH THE LATEST ONTARIO
BUILDING CODE.

ALL SUPPLY OUTLETS TO BE 5" DIA. UNLESS OTHERWISE
SPECIFIED.

PROVIDE BALANCING DAMPERS ON ALL BRANCHES.

ALL R/A PARTITIONS 6" (FIRST FLOOR ONLY)

INSULATE DUCTS IN UNCONDITIONED SPACES R12 UNDERCUT
ALL DOORS 1" MIN.

CONTRACTOR MUST WORK FROM APPROVED PLANS.

ANY ALTERATIONS TO THIS ORIGINAL PLAN ARE NOT THE
RESPONSIBILITY OF GTA DESIGNS.

GTA DESIGNS MUST BE CONSULTED IF KITCHEN EXHAUST
FAN EXCEEDS 700 CFM DEPRESSURIZATION MAY OCCUR
WITH IN THE DWELLING.



**2985 DREW ROAD
SUITE 202,
MISSISSAUGA, ONT.
L4T 0A4 TEL: 905-671-9800
EMAIL: DAVE@GTADESIGNS.CA
WEB: WWW.GTADESIGNS.CA**


HEAT-LOSS	57,283	BTU/HR.
UNIT MAKE	AMANA	OR EQUAL.
UNIT MODEL	AMEC960803BNA	OR EQUAL.
UNIT HEATING INPUT	80,000	BTU/HR.
UNIT HEATING OUTPUT	76,800	BTU/HR.
A/C COOLING CAPACITY	3.0	TONS.
FAN SPEED	1172	CFM

# OF RUNS	S/A	R/A	FANS
3RD FLOOR			
2ND FLOOR	13	4	4
1ST FLOOR	10	1	2
BASEMENT	4	1	


FLOOR PLAN: SECOND FLOOR	
DRAWN BY: AM	CHECKED: DD
LAYOUT NO. JB-04589	DRAWING NO. M3

 DATE:	APRIL 4, 2018
CLIENT:	BAYVIEW WELLINGTON
MODEL:	S42-7C RIDEAU 7
PROJECT:	GREEN VALLEY EAST BRADFORD,ONT.
SCALE:	3/16" = 1'-0"


	FLEX DUCT		LOW/HIGH WALL/KICK SUPPLY DIFFUSER		DUCT CONNECTION TO JOIST LINING		RETURN AIR GRILLE (SIZE INDICATED ON DRAWING)	S.A.	SUPPLY AIR
	RIGID ROUND DUCT		HRV EXHAUST GRILLE		RETURN AIR PIPE RISER		RETURN AIR RISER UP TO FLOOR ABOVE	R.A.	RETURN AIR
	SUPPLY DIFFUSER		SUPPLY AIR PIPE RISER		RETURN ROUND DUCT		RETURN AIR FROM BASEMENT SECOND FLOOR		THERMOSTAT
			VOLUME DAMPER						PRINCIPAL EXHAUST FAN SWITCH
									W/R & PRINCIPAL EXHAUST FAN

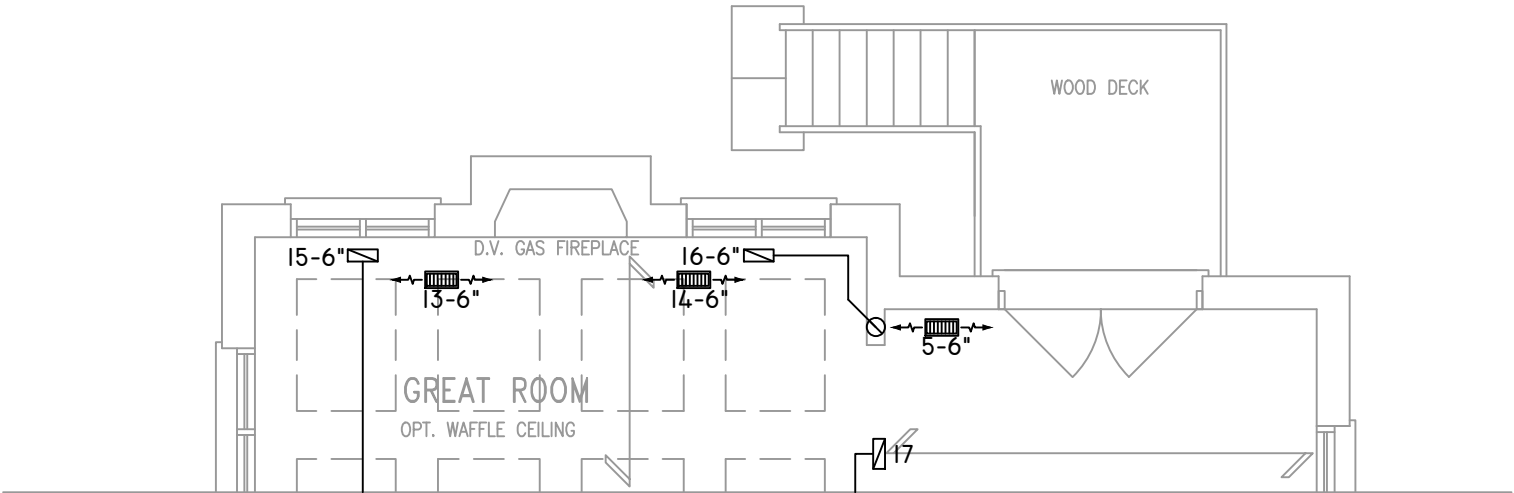


PARTIAL GROUND FLOOR PLAN W.O.D.
9R AND MORE CONDITION ELEV. 'A'

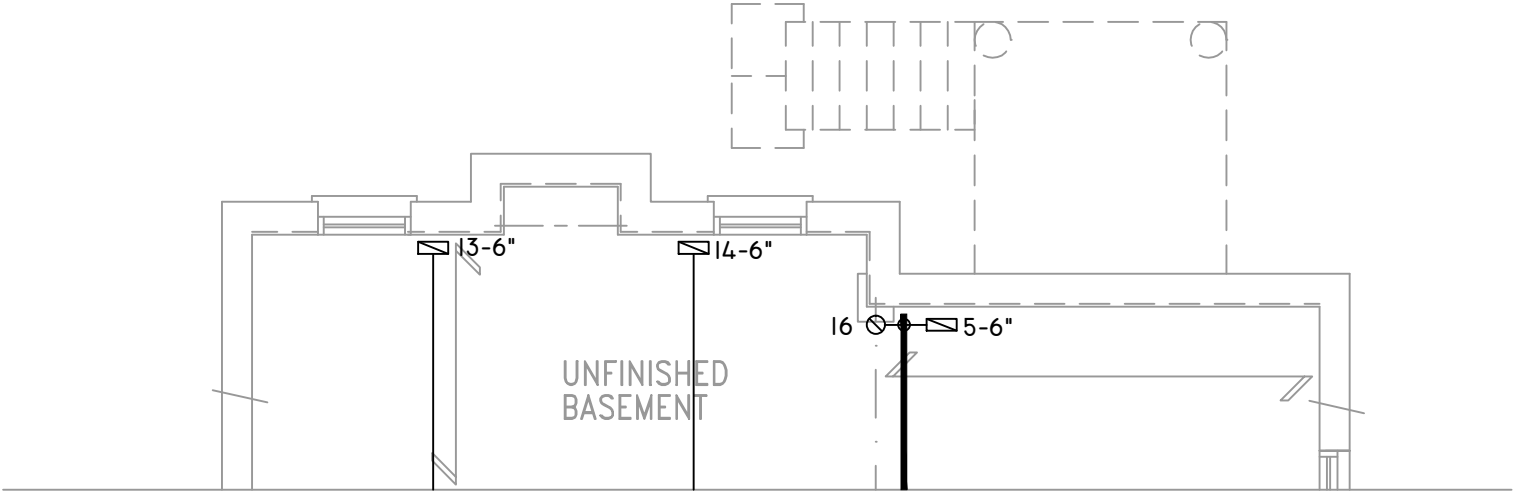

PARTIAL BASEMENT PLAN W.O.D.
9R AND MORE CONDITION ELEV. 'A'

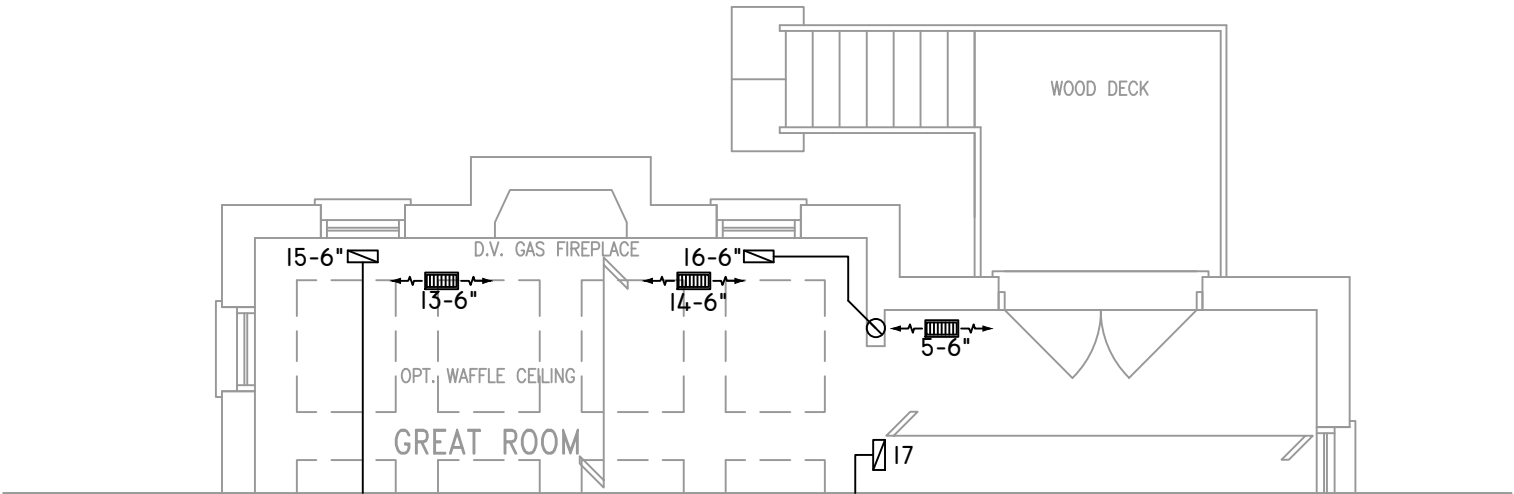

PARTIAL GROUND FLOOR PLAN W.O.D.
9R OR MORE CONDITION ELEV. 'B'

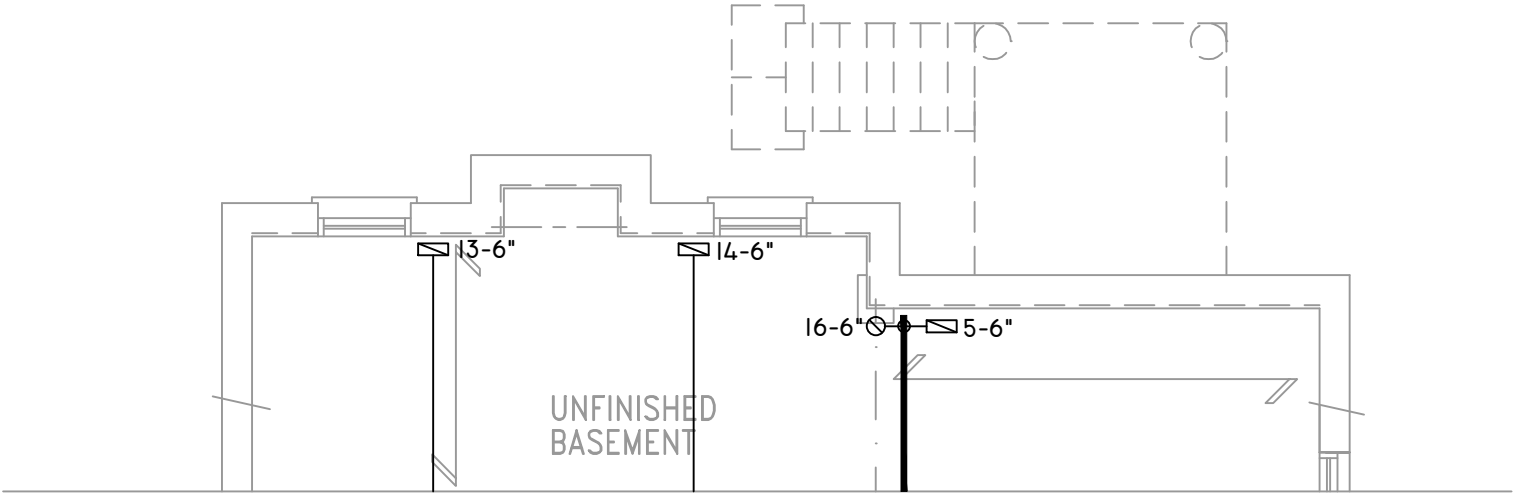

PARTIAL BASEMENT PLAN W.O.D.
9R OR MORE CONDITION ELEV. 'B'

THE UNDERSIGNED HAS REVIEWED AND TAKES RESPONSIBILITY FOR THIS DESIGN ON BEHALF OF GTA DESIGNS INC. AND HAS THE QUALIFICATIONS AND MEETS THE REQUIREMENTS SET OUT IN THE BUILDING CODE TO BE A DESIGNER

QUALIFICATION INFORMATION

REQUIRED UNLESS DESIGN IS EXEMPT UNDER DIVISION C 3.2.5.1 OF THE ONTARIO BUILDING CODE

DAVID DA COSTA



B.C.I.N. 32964

SIGNATURE OF DESIGNER

OBC 2012

ZONE I COMPLIANCE
PACKAGE "A1" REF. TABLE 3.1.1.2.A

NOTES
INSTALLATION TO COMPLY WITH THE LATEST ONTARIO BUILDING CODE.
ALL SUPPLY OUTLETS TO BE 5" DIA. UNLESS OTHERWISE SPECIFIED.
PROVIDE BALANCING DAMPERS ON ALL BRANCHES.
ALL R/A PARTITIONS 6" (FIRST FLOOR ONLY)
INSULATE DUCTS IN UNCONDITIONED SPACES R12 UNDERCUT ALL DOORS 1" MIN.
CONTRACTOR MUST WORK FROM APPROVED PLANS.
ANY ALTERATIONS TO THIS ORIGINAL PLAN ARE NOT THE RESPONSIBILITY OF GTA DESIGNS.
GTA DESIGNS MUST BE CONSULTED IF KITCHEN EXHAUST FAN EXCEEDS 700 CFM DEPRESSURIZATION MAY OCCUR WITH IN THE DWELLING.




2985 DREW ROAD
SUITE 202,
MISSISSAUGA, ONT.
L4T 0A4 TEL: 905-671-9800
EMAIL: DAVE@GTADESIGNS.CA
WEB: WWW.GTADESIGNS.CA


HEAT-LOSS	57,283	BTU/HR.
UNIT MAKE	AMANA	OR EQUAL.
UNIT MODEL	AMEC960803BNA	OR EQUAL.
UNIT HEATING INPUT	80,000	BTU/HR.
UNIT HEATING OUTPUT	76,800	BTU/HR.
A/C COOLING CAPACITY	3.0	TONS.
FAN SPEED	1172	CFM

# OF RUNS	S/A	R/A	FANS
3RD FLOOR			
2ND FLOOR	13	4	4
1ST FLOOR	10	1	2
BASEMENT	4	1	


FLOOR PLAN: PARTIAL PLAN(S)	
DRAWN BY: AM	CHECKED: DD
LAYOUT NO. JB-04589	SQFT 3179
DRAWING NO. M4	

 DATE:	APRIL 4, 2018
CLIENT:	BAYVIEW WELLINGTON
MODEL:	S42-7C RIDEAU 7
PROJECT:	GREEN VALLEY EAST BRADFORD,ONT.
SCALE:	3/16" = 1'-0"


	FLEX DUCT		LOW/HIGH WALL/KICK SUPPLY DIFFUSER		DUCT CONNECTION TO JOIST LINING		RETURN AIR GRILLE (SIZE INDICATED ON DRAWING)	S.A.	SUPPLY AIR
	RIGID ROUND DUCT		HRV EXHAUST GRILLE		RETURN AIR PIPE RISER		RETURN AIR RISER UP TO FLOOR ABOVE	R.A.	RETURN AIR
	SUPPLY DIFFUSER		SUPPLY AIR PIPE RISER		RETURN ROUND DUCT		RETURN AIR FROM BASEMENT SECOND FLOOR		THERMOSTAT
			VOLUME DAMPER						PRINCIPAL EXHAUST FAN SWITCH
									W/R & PRINCIPAL EXHAUST FAN

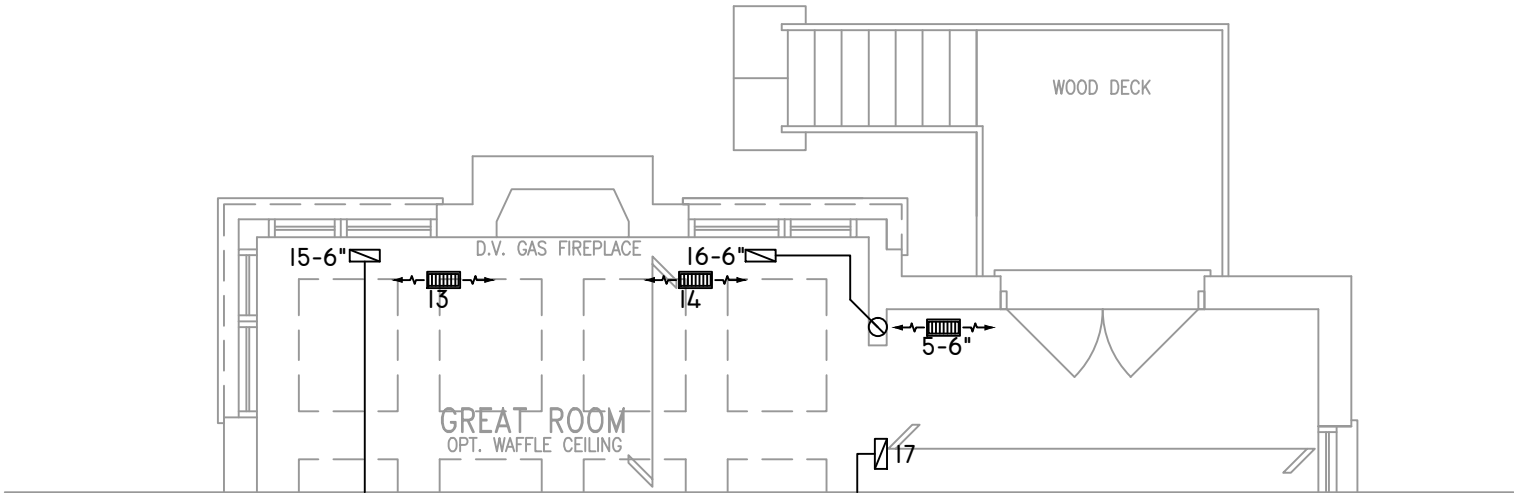


PARTIAL GROUND FLOOR PLAN W.O.D.
9R OR MORE CONDITION ELEV. 'C'

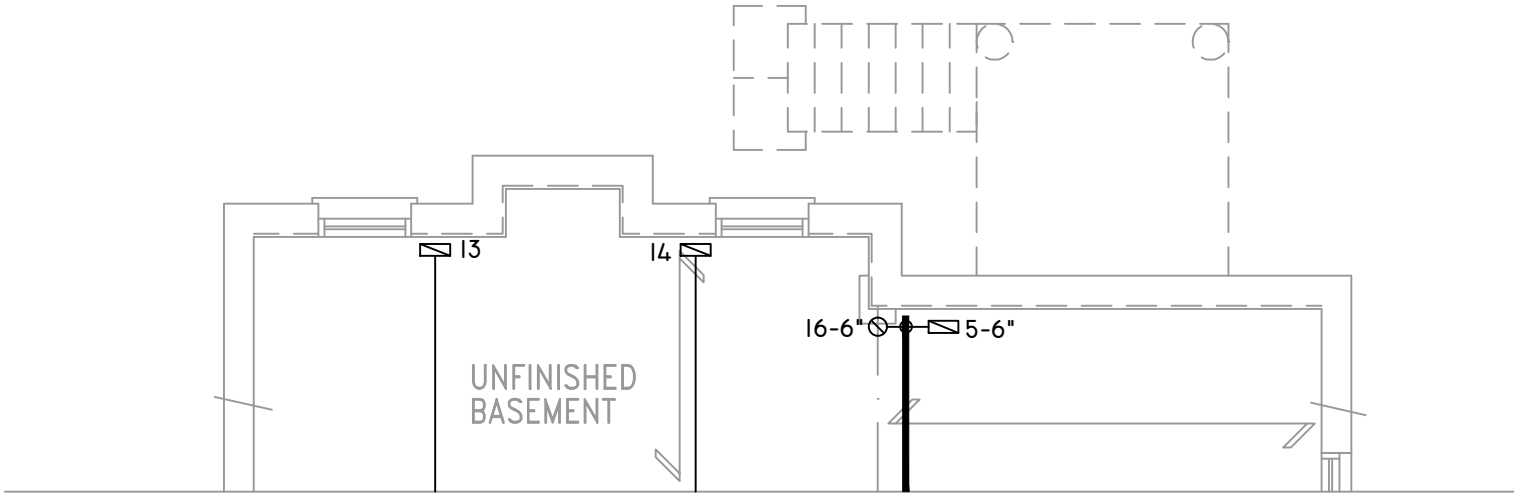

PARTIAL BASEMENT PLAN W.O.D.
9R OR MORE CONDITION ELEV. 'C'

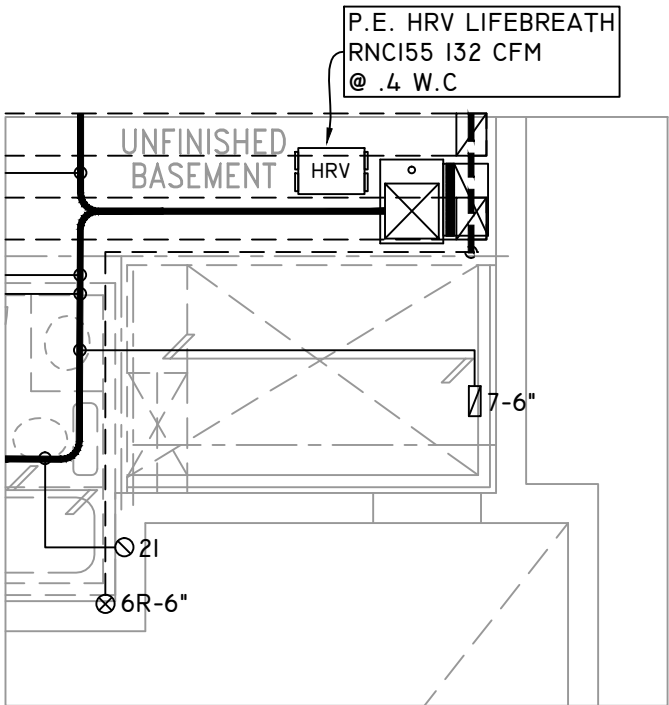

PART. BASEMENT PLAN FOR OPT.
SUNKEN LAUNDRY 2R OR MORE COND

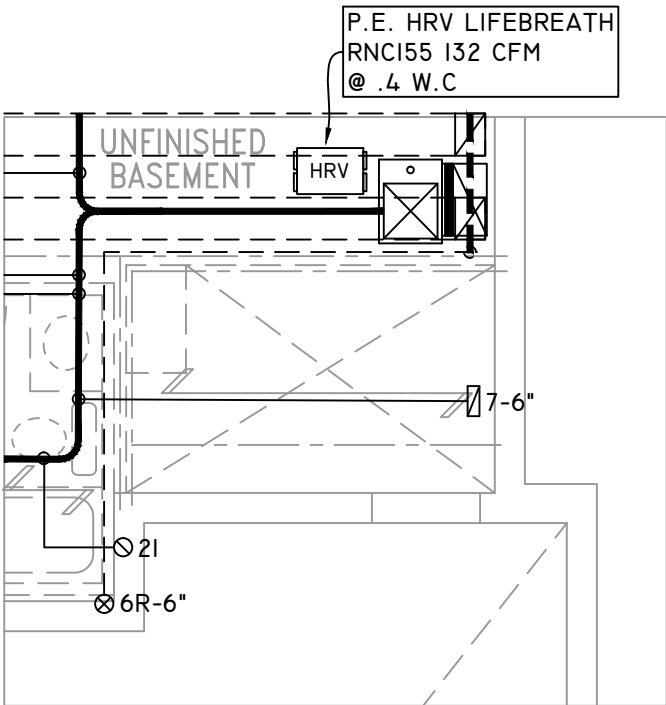

PART. BASEMENT PLAN FOR OPT.
SUNKEN LAUNDRY 1R COND

THE UNDERSIGNED HAS REVIEWED AND TAKES RESPONSIBILITY FOR THIS DESIGN ON BEHALF OF GTA DESIGNS INC. AND HAS THE QUALIFICATIONS AND MEETS THE REQUIREMENTS SET OUT IN THE BUILDING CODE TO BE A DESIGNER

QUALIFICATION INFORMATION

REQUIRED UNLESS DESIGN IS EXEMPT UNDER DIVISION C 3.2.5.1 OF THE ONTARIO BUILDING CODE

DAVID DA COSTA  B.C.I.N. 32964

SIGNATURE OF DESIGNER

OBC 2012

ZONE I COMPLIANCE
PACKAGE "AI" REF. TABLE 3.1.1.2.A

NOTES
INSTALLATION TO COMPLY WITH THE LATEST ONTARIO BUILDING CODE.
ALL SUPPLY OUTLETS TO BE 5" DIA. UNLESS OTHERWISE SPECIFIED.
PROVIDE BALANCING DAMPERS ON ALL BRANCHES.
ALL R/A PARTITIONS 6" (FIRST FLOOR ONLY)
INSULATE DUCTS IN UNCONDITIONED SPACES R12 UNDERCUT ALL DOORS 1" MIN.
CONTRACTOR MUST WORK FROM APPROVED PLANS.
ANY ALTERATIONS TO THIS ORIGINAL PLAN ARE NOT THE RESPONSIBILITY OF GTA DESIGNS.
GTA DESIGNS MUST BE CONSULTED IF KITCHEN EXHAUST FAN EXCEEDS 700 CFM DEPRESSURIZATION MAY OCCUR WITH IN THE DWELLING.




2985 DREW ROAD
SUITE 202,
MISSISSAUGA, ONT.
L4T 0A4 TEL: 905-671-9800
EMAIL: DAVE@GTADESIGNS.CA
WEB: WWW.GTADESIGNS.CA


HEAT-LOSS	57,283	BTU/HR.
UNIT MAKE	AMANA	OR EQUAL.
UNIT MODEL	AMEC960803BNA	OR EQUAL.
UNIT HEATING INPUT	80,000	BTU/HR.
UNIT HEATING OUTPUT	76,800	BTU/HR.
A/C COOLING CAPACITY	3.0	TONS.
FAN SPEED	1172	CFM

# OF RUNS	S/A	R/A	FANS
3RD FLOOR			
2ND FLOOR	13	4	4
1ST FLOOR	10	1	2
BASEMENT	4	1	


FLOOR PLAN: PARTIAL PLAN(S)	
DRAWN BY: AM	CHECKED: DD
LAYOUT NO. JB-04589	DRAWING NO. M5
SQFT 3179	

 DATE:	APRIL 4, 2018
CLIENT:	BAYVIEW WELLINGTON
MODEL:	S42-7C RIDEAU 7
PROJECT:	GREEN VALLEY EAST BRADFORD,ONT.
SCALE:	3/16" = 1'-0"


	FLEX DUCT		LOW/HIGH WALL/KICK SUPPLY DIFFUSER		DUCT CONNECTION TO JOIST LINING		RETURN AIR GRILLE (SIZE INDICATED ON DRAWING)	S.A.	SUPPLY AIR
	RIGID ROUND DUCT		HRV EXHAUST GRILLE		RETURN AIR PIPE RISER		RETURN AIR RISER UP TO FLOOR ABOVE	R.A.	RETURN AIR
	SUPPLY DIFFUSER		SUPPLY AIR PIPE RISER		RETURN ROUND DUCT		RETURN AIR FROM BASEMENT SECOND FLOOR		THERMOSTAT
			VOLUME DAMPER						PRINCIPAL EXHAUST FAN SWITCH
									W/R & PRINCIPAL EXHAUST FAN

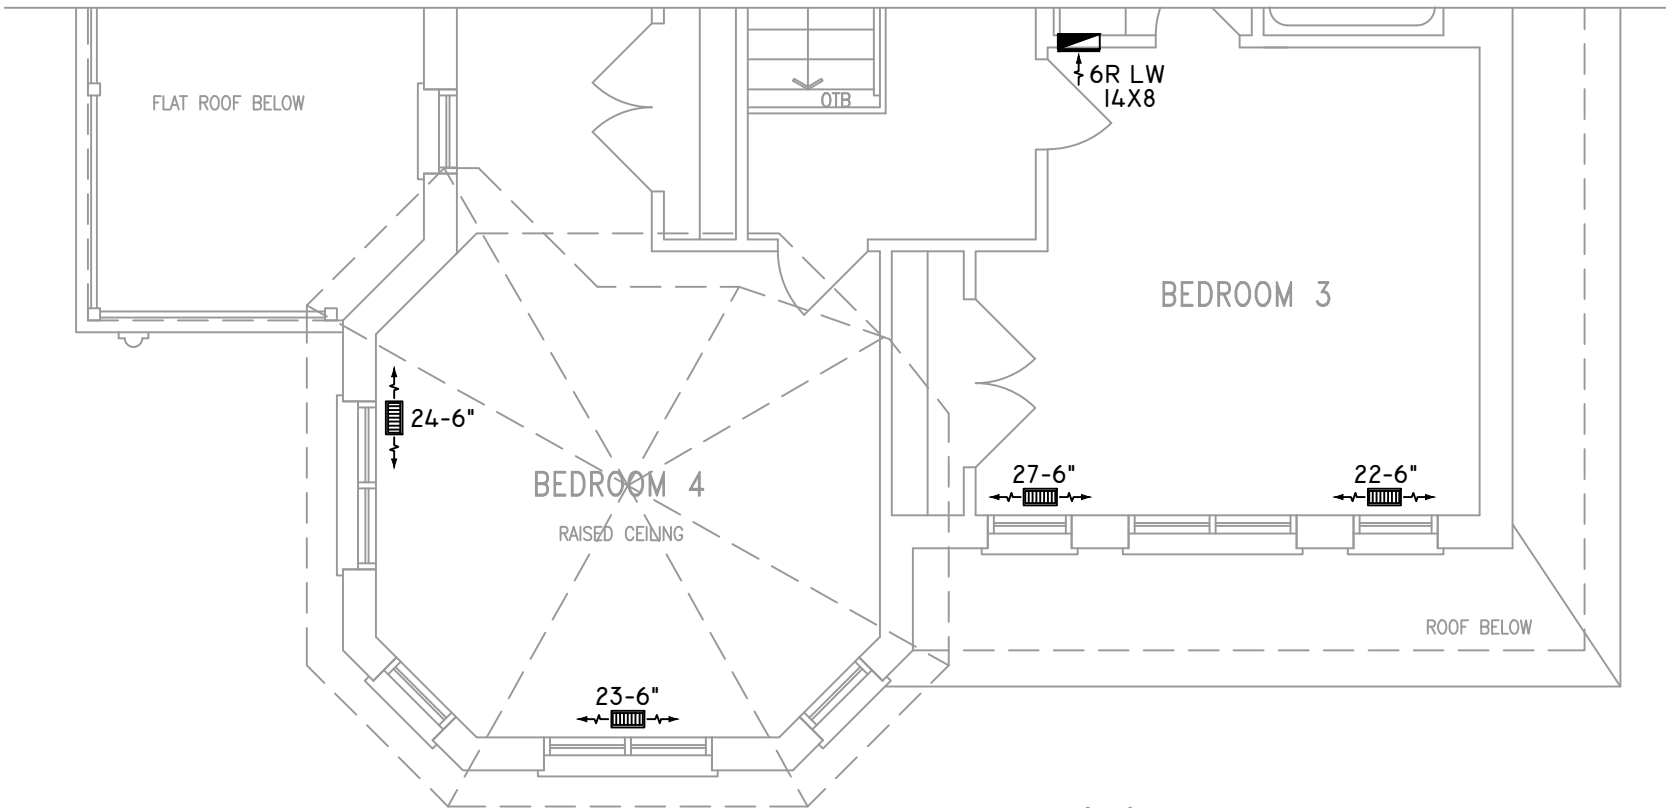

SECOND FLOOR PLAN 'B'
4 BEDROOM + MEDIA LOFT

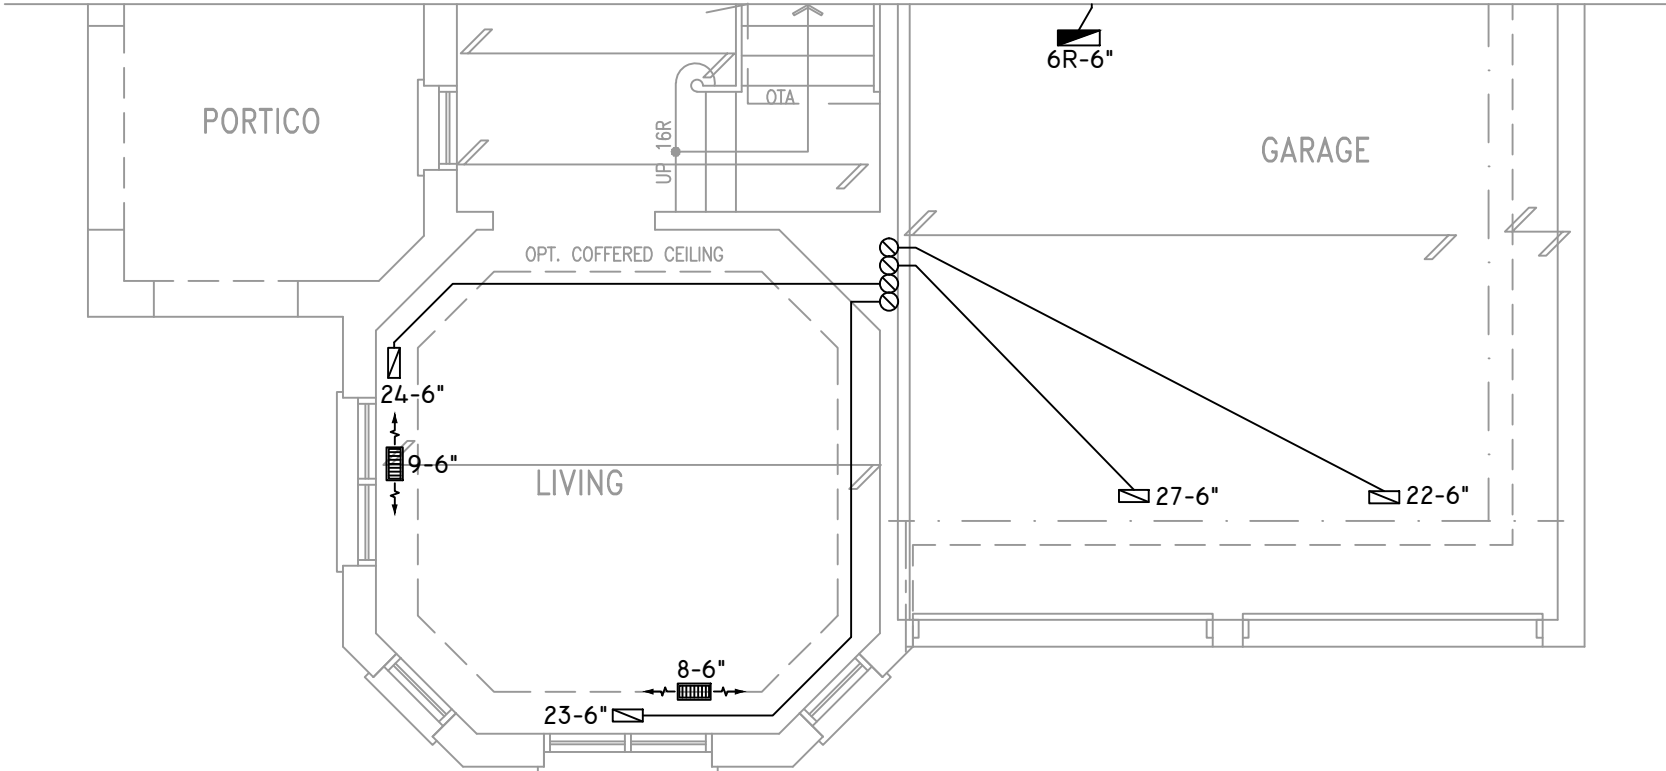

GROUND FLOOR PLAN 'B'

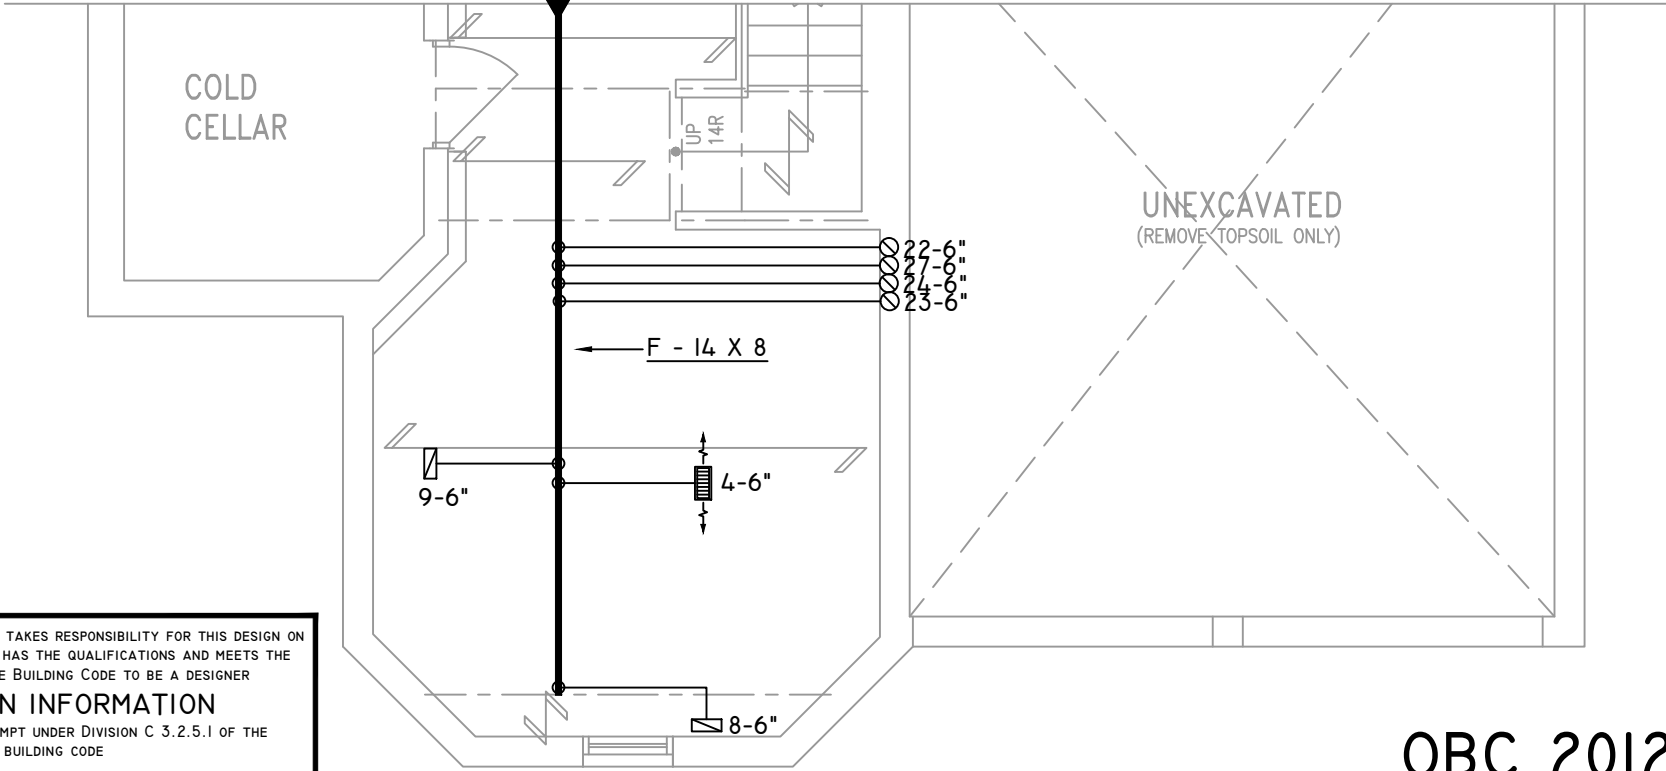

BASEMENT PLAN 'B'

THE UNDERSIGNED HAS REVIEWED AND TAKES RESPONSIBILITY FOR THIS DESIGN ON BEHALF OF GTA DESIGNS INC. AND HAS THE QUALIFICATIONS AND MEETS THE REQUIREMENTS SET OUT IN THE BUILDING CODE TO BE A DESIGNER

QUALIFICATION INFORMATION

REQUIRED UNLESS DESIGN IS EXEMPT UNDER DIVISION C 3.2.5.1 OF THE ONTARIO BUILDING CODE

DAVID DA COSTA  B.C.I.N. 32964

SIGNATURE OF DESIGNER

OBC 2012

ZONE I COMPLIANCE
PACKAGE "A1" REF. TABLE 3.1.1.2.A

NOTES
INSTALLATION TO COMPLY WITH THE LATEST ONTARIO BUILDING CODE.
ALL SUPPLY OUTLETS TO BE 5" DIA. UNLESS OTHERWISE SPECIFIED.
PROVIDE BALANCING DAMPERS ON ALL BRANCHES.
ALL R/A PARTITIONS 6" (FIRST FLOOR ONLY)
INSULATE DUCTS IN UNCONDITIONED SPACES R12 UNDERCUT ALL DOORS 1" MIN.
CONTRACTOR MUST WORK FROM APPROVED PLANS.
ANY ALTERATIONS TO THIS ORIGINAL PLAN ARE NOT THE RESPONSIBILITY OF GTA DESIGNS.
GTA DESIGNS MUST BE CONSULTED IF KITCHEN EXHAUST FAN EXCEEDS 700 CFM DEPRESSURIZATION MAY OCCUR WITH IN THE DWELLING.

 **GTADESIGNS**

 
2985 DREW ROAD
SUITE 202,
MISSISSAUGA, ONT.
L4T 0A4 TEL: 905-671-9800
EMAIL: DAVE@GTADESIGNS.CA
WEB: WWW.GTADESIGNS.CA


HEAT-LOSS	57,283	BTU/HR.
UNIT MAKE	AMANA	OR EQUAL.
UNIT MODEL	AMEC960803BNA	OR EQUAL.
UNIT HEATING INPUT	80,000	BTU/HR.
UNIT HEATING OUTPUT	76,800	BTU/HR.
A/C COOLING CAPACITY	3.0	TONS.
FAN SPEED	1172	CFM

# OF RUNS	S/A	R/A	FANS
3RD FLOOR			
2ND FLOOR	13	4	4
1ST FLOOR	10	1	2
BASEMENT	4	1	


FLOOR PLAN:	
PARTIAL PLAN(S)	
DRAWN BY: AM	CHECKED: DD
LAYOUT NO. JB-04589	DRAWING NO. M6

DATE:	APRIL 4, 2018
CLIENT:	BAYVIEW WELLINGTON
MODEL:	S42-7C RIDEAU 7
PROJECT:	GREEN VALLEY EAST BRADFORD, ONT.
SCALE:	3/16" = 1'-0"


	FLEX DUCT		LOW/HIGH WALL/KICK SUPPLY DIFFUSER		DUCT CONNECTION TO JOIST LINING		RETURN AIR GRILLE (SIZE INDICATED ON DRAWING)	S.A.	SUPPLY AIR
	RIGID ROUND DUCT		HRV EXHAUST GRILLE		RETURN AIR PIPE RISER		RETURN AIR RISER UP TO FLOOR ABOVE	R.A.	RETURN AIR
	SUPPLY DIFFUSER		SUPPLY AIR PIPE RISER		RETURN ROUND DUCT		RETURN AIR FROM BASEMENT SECOND FLOOR		THERMOSTAT
			VOLUME DAMPER						PRINCIPAL EXHAUST FAN SWITCH
									W/R & PRINCIPAL EXHAUST FAN

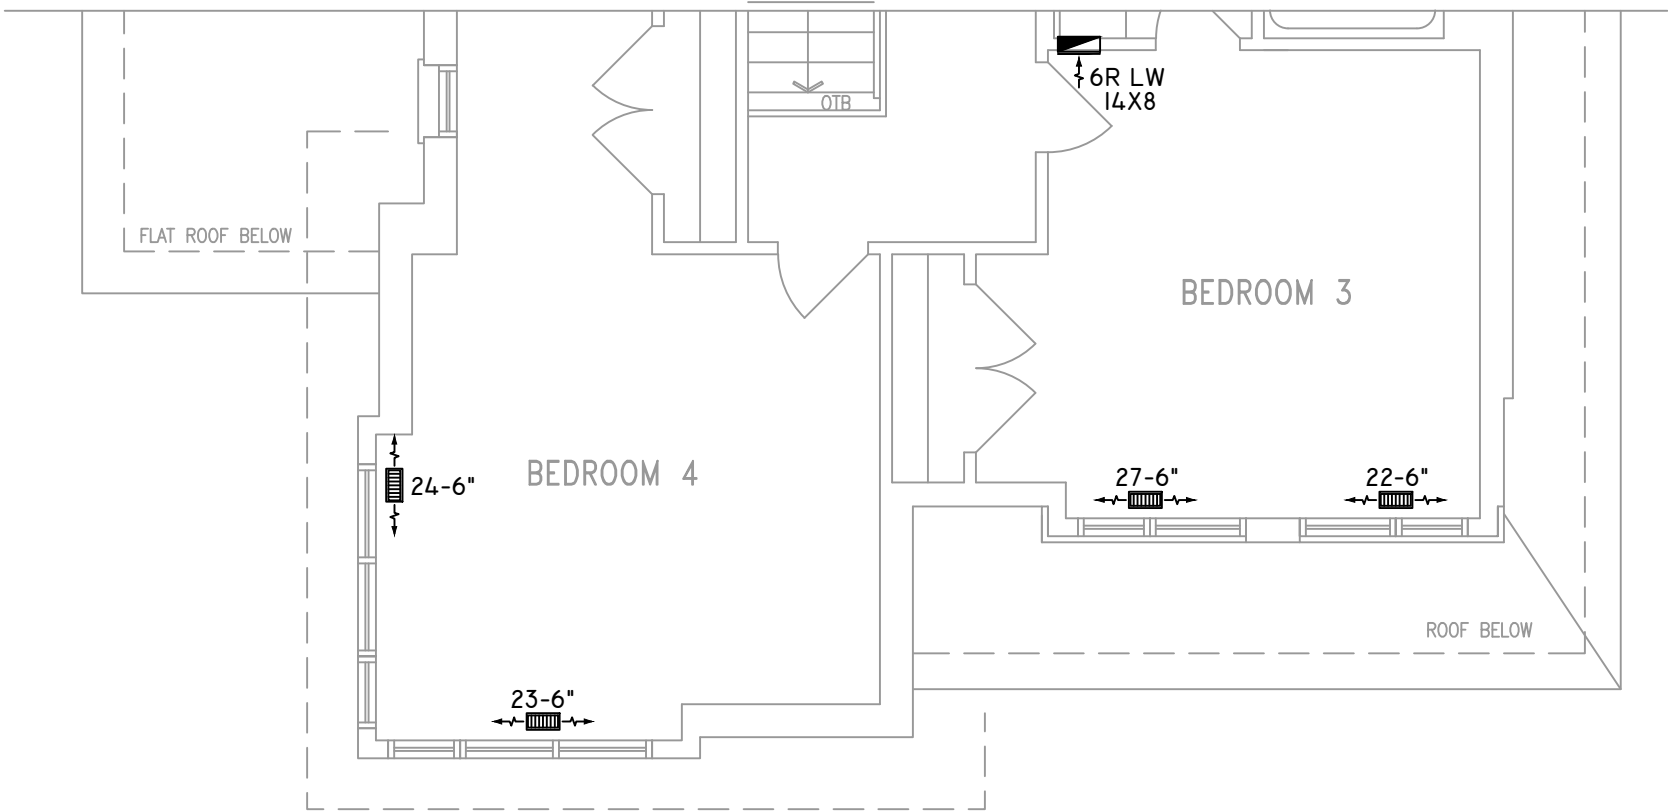

SECOND FLOOR PLAN 'C'
4 BEDROOM + MEDIA LOFT

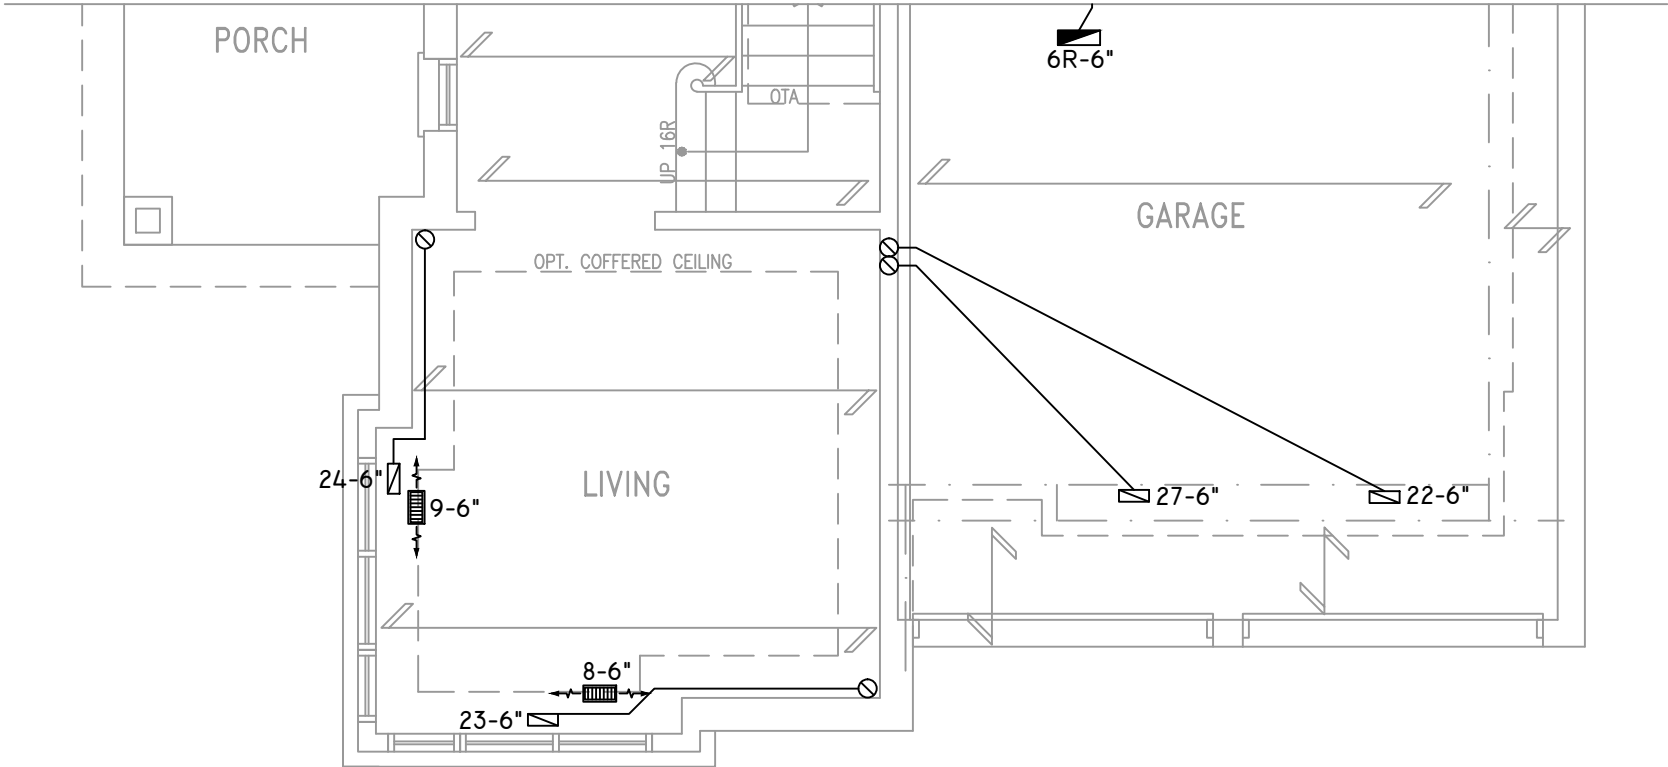

GROUND FLOOR PLAN 'C'

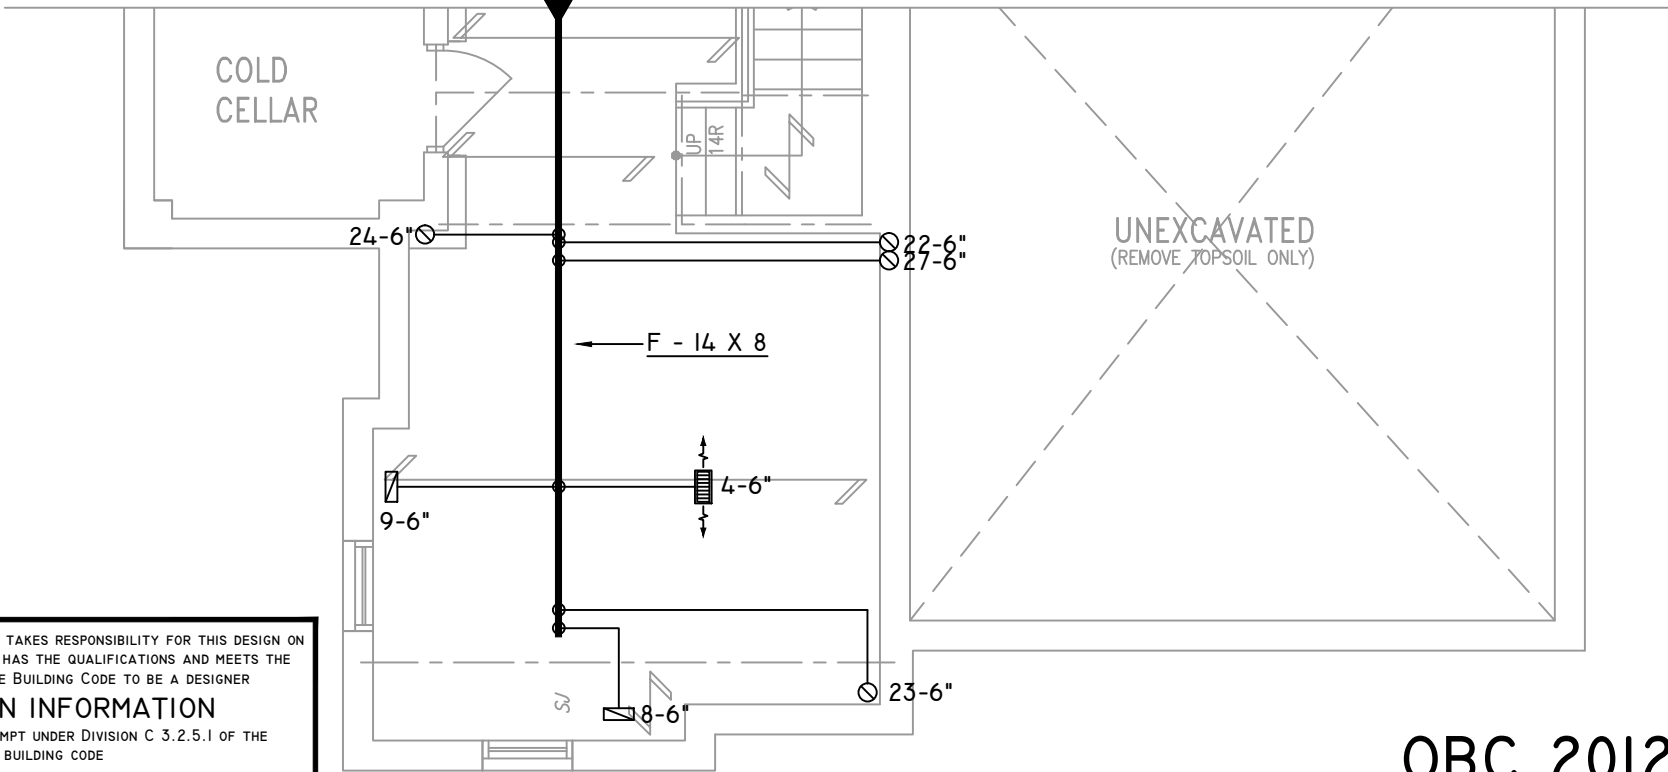

BASEMENT PLAN 'C'

THE UNDERSIGNED HAS REVIEWED AND TAKES RESPONSIBILITY FOR THIS DESIGN ON BEHALF OF GTA DESIGNS INC. AND HAS THE QUALIFICATIONS AND MEETS THE REQUIREMENTS SET OUT IN THE BUILDING CODE TO BE A DESIGNER

QUALIFICATION INFORMATION

REQUIRED UNLESS DESIGN IS EXEMPT UNDER DIVISION C 3.2.5.1 OF THE ONTARIO BUILDING CODE

DAVID DA COSTA  B.C.I.N. 32964

SIGNATURE OF DESIGNER

OBC 2012

ZONE I COMPLIANCE
PACKAGE "A1" REF. TABLE 3.1.1.2.A

NOTES
INSTALLATION TO COMPLY WITH THE LATEST ONTARIO BUILDING CODE.
ALL SUPPLY OUTLETS TO BE 5" DIA. UNLESS OTHERWISE SPECIFIED.
PROVIDE BALANCING DAMPERS ON ALL BRANCHES.
ALL R/A PARTITIONS 6" (FIRST FLOOR ONLY)
INSULATE DUCTS IN UNCONDITIONED SPACES R12 UNDERCUT ALL DOORS 1" MIN.
CONTRACTOR MUST WORK FROM APPROVED PLANS.
ANY ALTERATIONS TO THIS ORIGINAL PLAN ARE NOT THE RESPONSIBILITY OF GTA DESIGNS.
GTA DESIGNS MUST BE CONSULTED IF KITCHEN EXHAUST FAN EXCEEDS 700 CFM DEPRESSURIZATION MAY OCCUR WITH IN THE DWELLING.




2985 DREW ROAD
SUITE 202,
MISSISSAUGA, ONT.
L4T 0A4 TEL: 905-671-9800
EMAIL: DAVE@GTADISIGNS.CA
WEB: WWW.GTADISIGNS.CA


HEAT-LOSS	57,283	BTU/HR.
UNIT MAKE	AMANA	OR EQUAL.
UNIT MODEL	AMEC960803BNA	OR EQUAL.
UNIT HEATING INPUT	80,000	BTU/HR.
UNIT HEATING OUTPUT	76,800	BTU/HR.
A/C COOLING CAPACITY	3.0	TONS.
FAN SPEED	1172	CFM

# OF RUNS	S/A	R/A	FANS
3RD FLOOR			
2ND FLOOR	13	4	4
1ST FLOOR	10	1	2
BASEMENT	4	1	

FLOOR PLAN:		
PARTIAL PLAN(S)		
DRAWN BY:	CHECKED:	SQFT
AM	DD	3179
LAYOUT NO.	DRAWING NO.	
JB-04589	M7	

 DATE:	APRIL 4, 2018
CLIENT:	BAYVIEW WELLINGTON
MODEL:	S42-7C RIDEAU 7
PROJECT:	GREEN VALLEY EAST BRADFORD,ONT.
SCALE:	3/16" = 1'-0"

	FLEX DUCT		LOW/HIGH WALL/KICK SUPPLY DIFFUSER		DUCT CONNECTION TO JOIST LINING		RETURN AIR GRILLE (SIZE INDICATED ON DRAWING)	S.A.	SUPPLY AIR
	RIGID ROUND DUCT		HRV EXHAUST GRILLE		RETURN AIR PIPE RISER		RETURN AIR RISER UP TO FLOOR ABOVE	R.A.	RETURN AIR
	SUPPLY DIFFUSER		SUPPLY AIR PIPE RISER		RETURN ROUND DUCT		RETURN AIR FROM BASEMENT SECOND FLOOR		THERMOSTAT
			VOLUME DAMPER						PRINCIPAL EXHAUST FAN SWITCH
									W/R & PRINCIPAL EXHAUST FAN

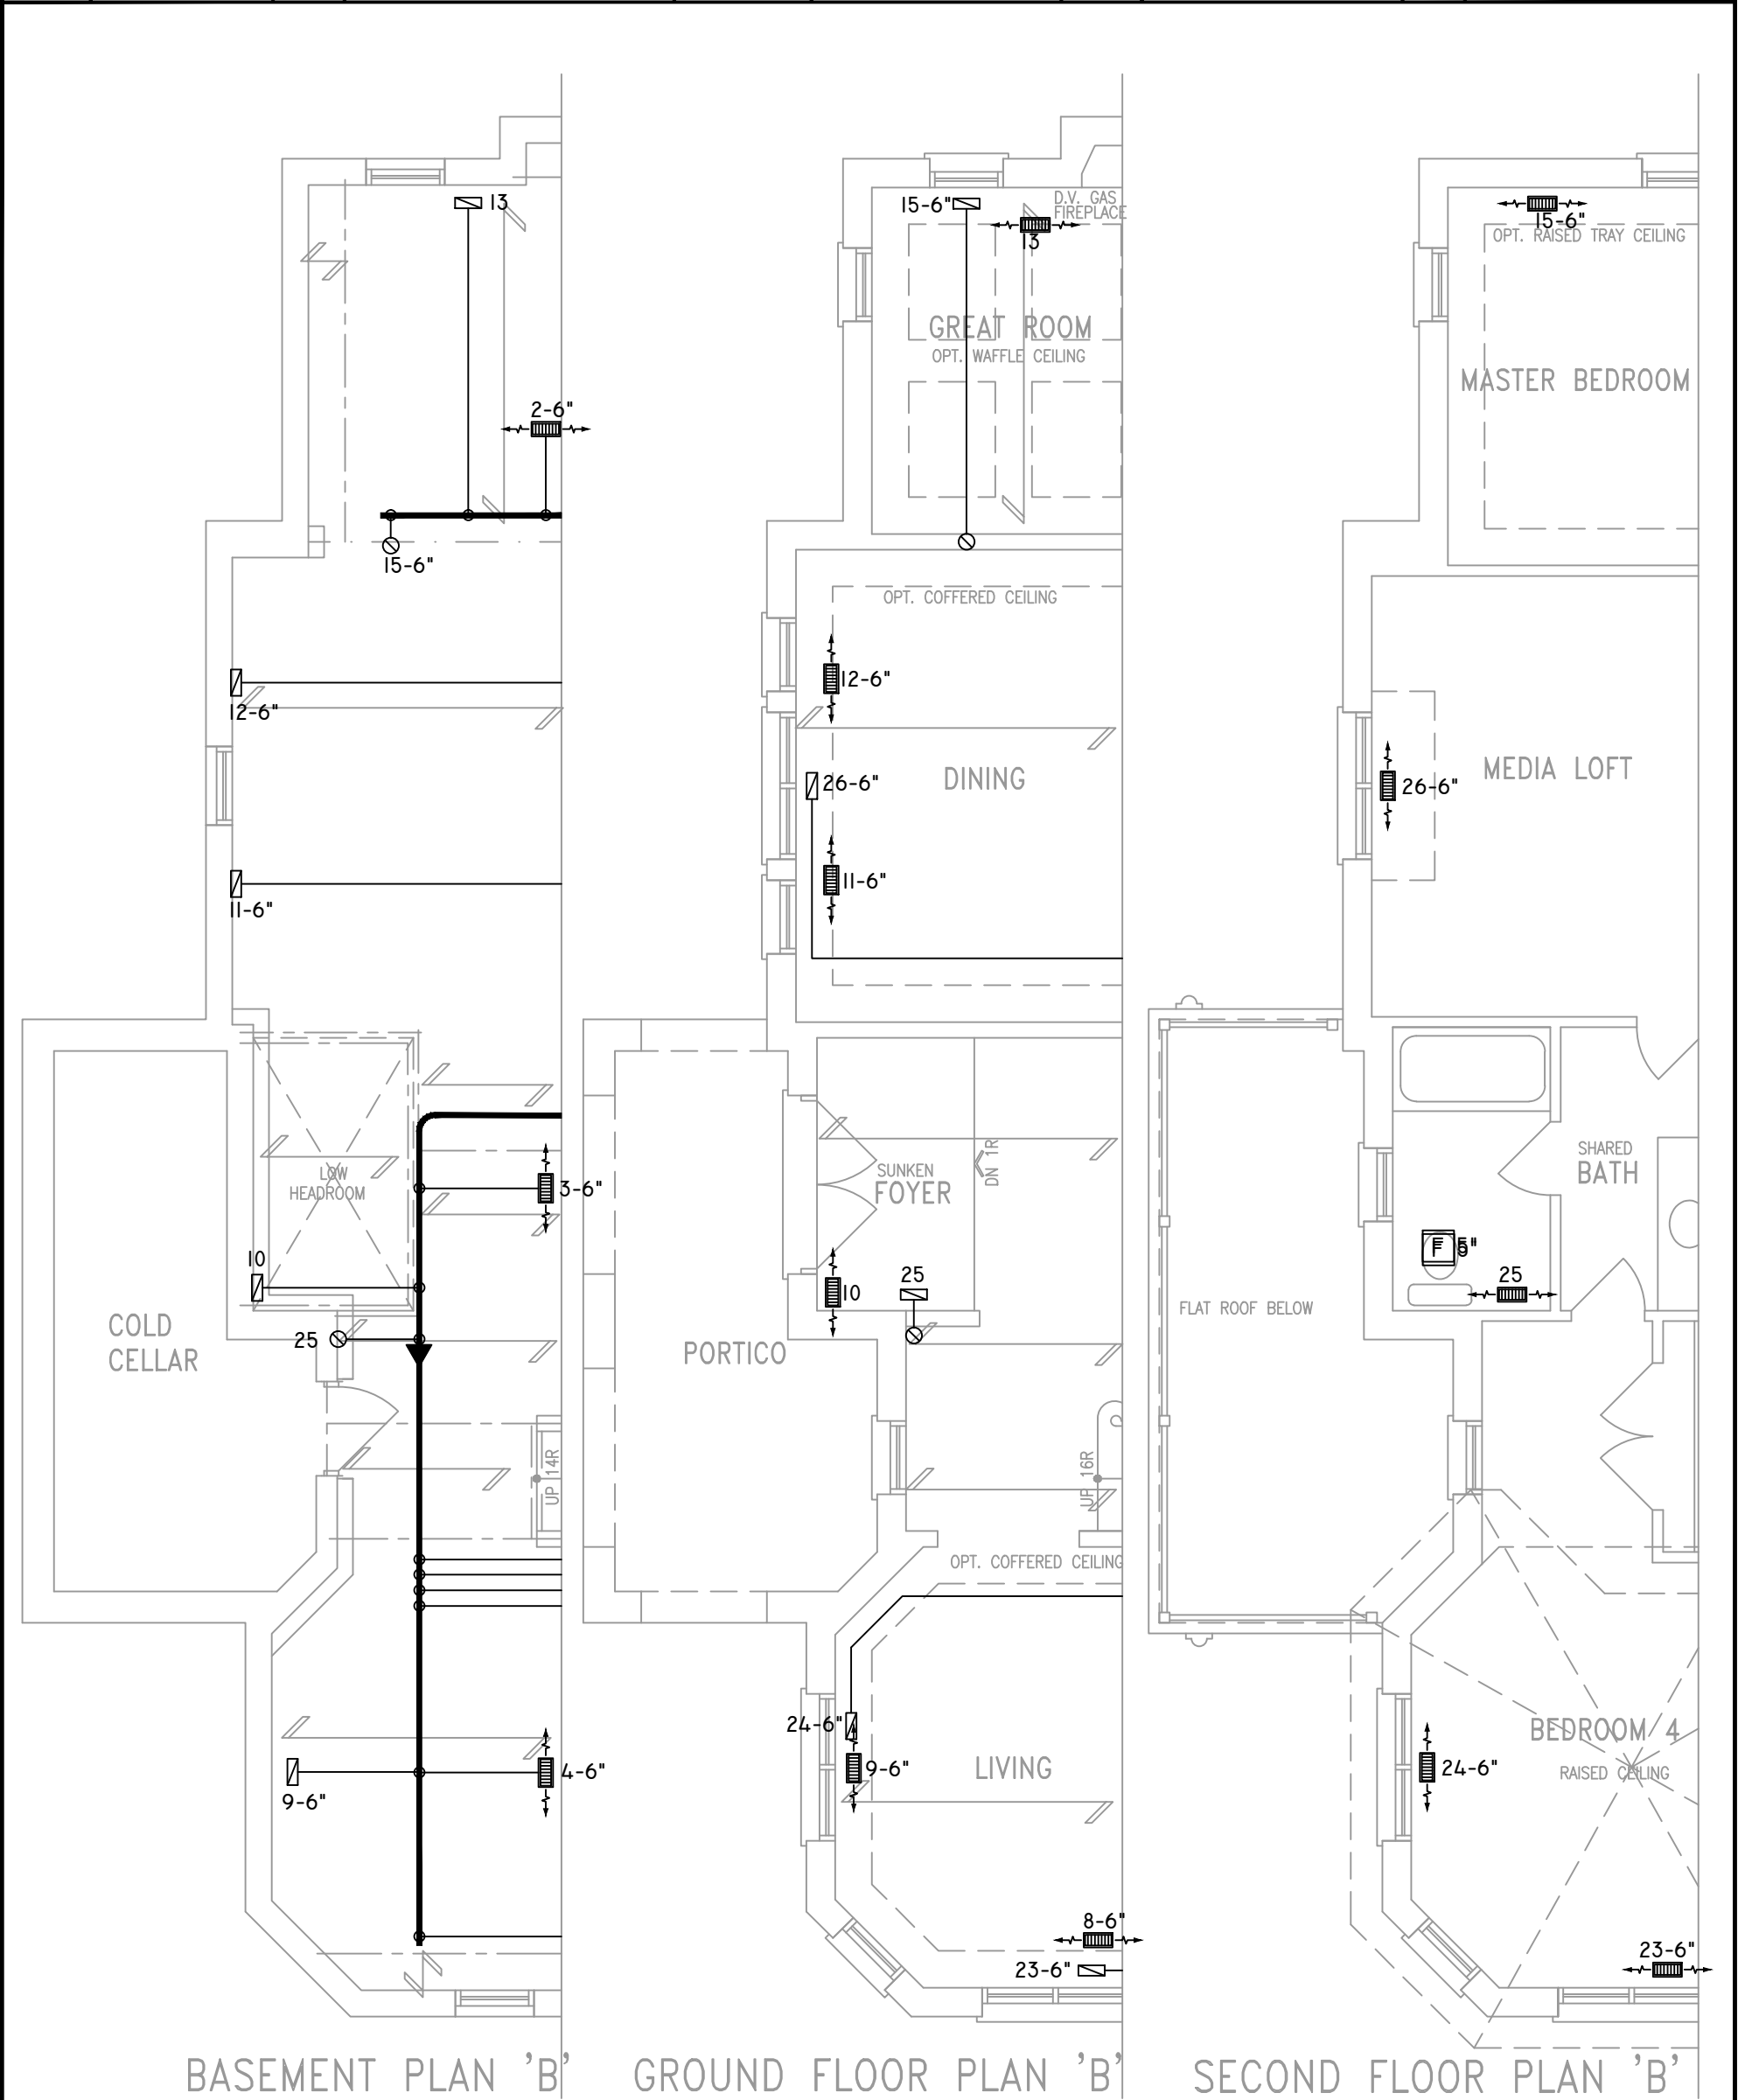

THE UNDERSIGNED HAS REVIEWED AND TAKES RESPONSIBILITY FOR THIS DESIGN ON BEHALF OF GTA DESIGNS INC. AND HAS THE QUALIFICATIONS AND MEETS THE REQUIREMENTS SET OUT IN THE BUILDING CODE TO BE A DESIGNER

QUALIFICATION INFORMATION

REQUIRED UNLESS DESIGN IS EXEMPT UNDER DIVISION C 3.2.5.1 OF THE ONTARIO BUILDING CODE

DAVID DA COSTA  B.C.I.N. 32964

SIGNATURE OF DESIGNER

ZONE I COMPLIANCE

PACKAGE "A1" REF. TABLE 3.1.1.2.A

NOTES

INSTALLATION TO COMPLY WITH THE LATEST ONTARIO BUILDING CODE.

ALL SUPPLY OUTLETS TO BE 5" DIA. UNLESS OTHERWISE SPECIFIED.

PROVIDE BALANCING DAMPERS ON ALL BRANCHES.

ALL R/A PARTITIONS 6" (FIRST FLOOR ONLY)

INSULATE DUCTS IN UNCONDITIONED SPACES R12 UNDERCUT ALL DOORS 1" MIN.

CONTRACTOR MUST WORK FROM APPROVED PLANS.

ANY ALTERATIONS TO THIS ORIGINAL PLAN ARE NOT THE RESPONSIBILITY OF GTA DESIGNS.

GTA DESIGNS MUST BE CONSULTED IF KITCHEN EXHAUST FAN EXCEEDS 700 CFM DEPRESSURIZATION MAY OCCUR WITH IN THE DWELLING.




2985 DREW ROAD
SUITE 202,
MISSISSAUGA, ONT.
L4T 0A4 TEL: 905-671-9800
EMAIL: DAVE@GTADESIGNS.CA
WEB: WWW.GTADESIGNS.CA


HEAT-LOSS	57,283	BTU/HR.
UNIT MAKE	AMANA	OR EQUAL.
UNIT MODEL	AMEC960803BNA	OR EQUAL.
UNIT HEATING INPUT	80,000	BTU/HR.
UNIT HEATING OUTPUT	76,800	BTU/HR.
A/C COOLING CAPACITY	3.0	TONS.
FAN SPEED	1172	CFM

# OF RUNS	S/A	R/A	FANS
3RD FLOOR			
2ND FLOOR	13	4	4
1ST FLOOR	10	1	2
BASEMENT	4	1	

FLOOR PLAN: PARTIAL PLAN(S)		
DRAWN BY: AM	CHECKED: DD	SQFT 3179
LAYOUT NO. JB-04589	DRAWING NO. M8	

 DATE:	APRIL 4, 2018
CLIENT:	BAYVIEW WELLINGTON
MODEL:	S42-7C RIDEAU 7
PROJECT:	GREEN VALLEY EAST BRADFORD,ONT.
SCALE:	3/16" = 1'-0"


	FLEX DUCT		LOW/HIGH WALL/KICK SUPPLY DIFFUSER		DUCT CONNECTION TO JOIST LINING		RETURN AIR GRILLE (SIZE INDICATED ON DRAWING)	S.A.	SUPPLY AIR
	RIGID ROUND DUCT		HRV EXHAUST GRILLE		RETURN AIR PIPE RISER		RETURN AIR RISER UP TO FLOOR ABOVE	R.A.	RETURN AIR
	SUPPLY DIFFUSER		SUPPLY AIR PIPE RISER		RETURN ROUND DUCT		RETURN AIR FROM BASEMENT SECOND FLOOR		THERMOSTAT
			VOLUME DAMPER						PRINCIPAL EXHAUST FAN SWITCH W/R & PRINCIPAL EXHAUST FAN

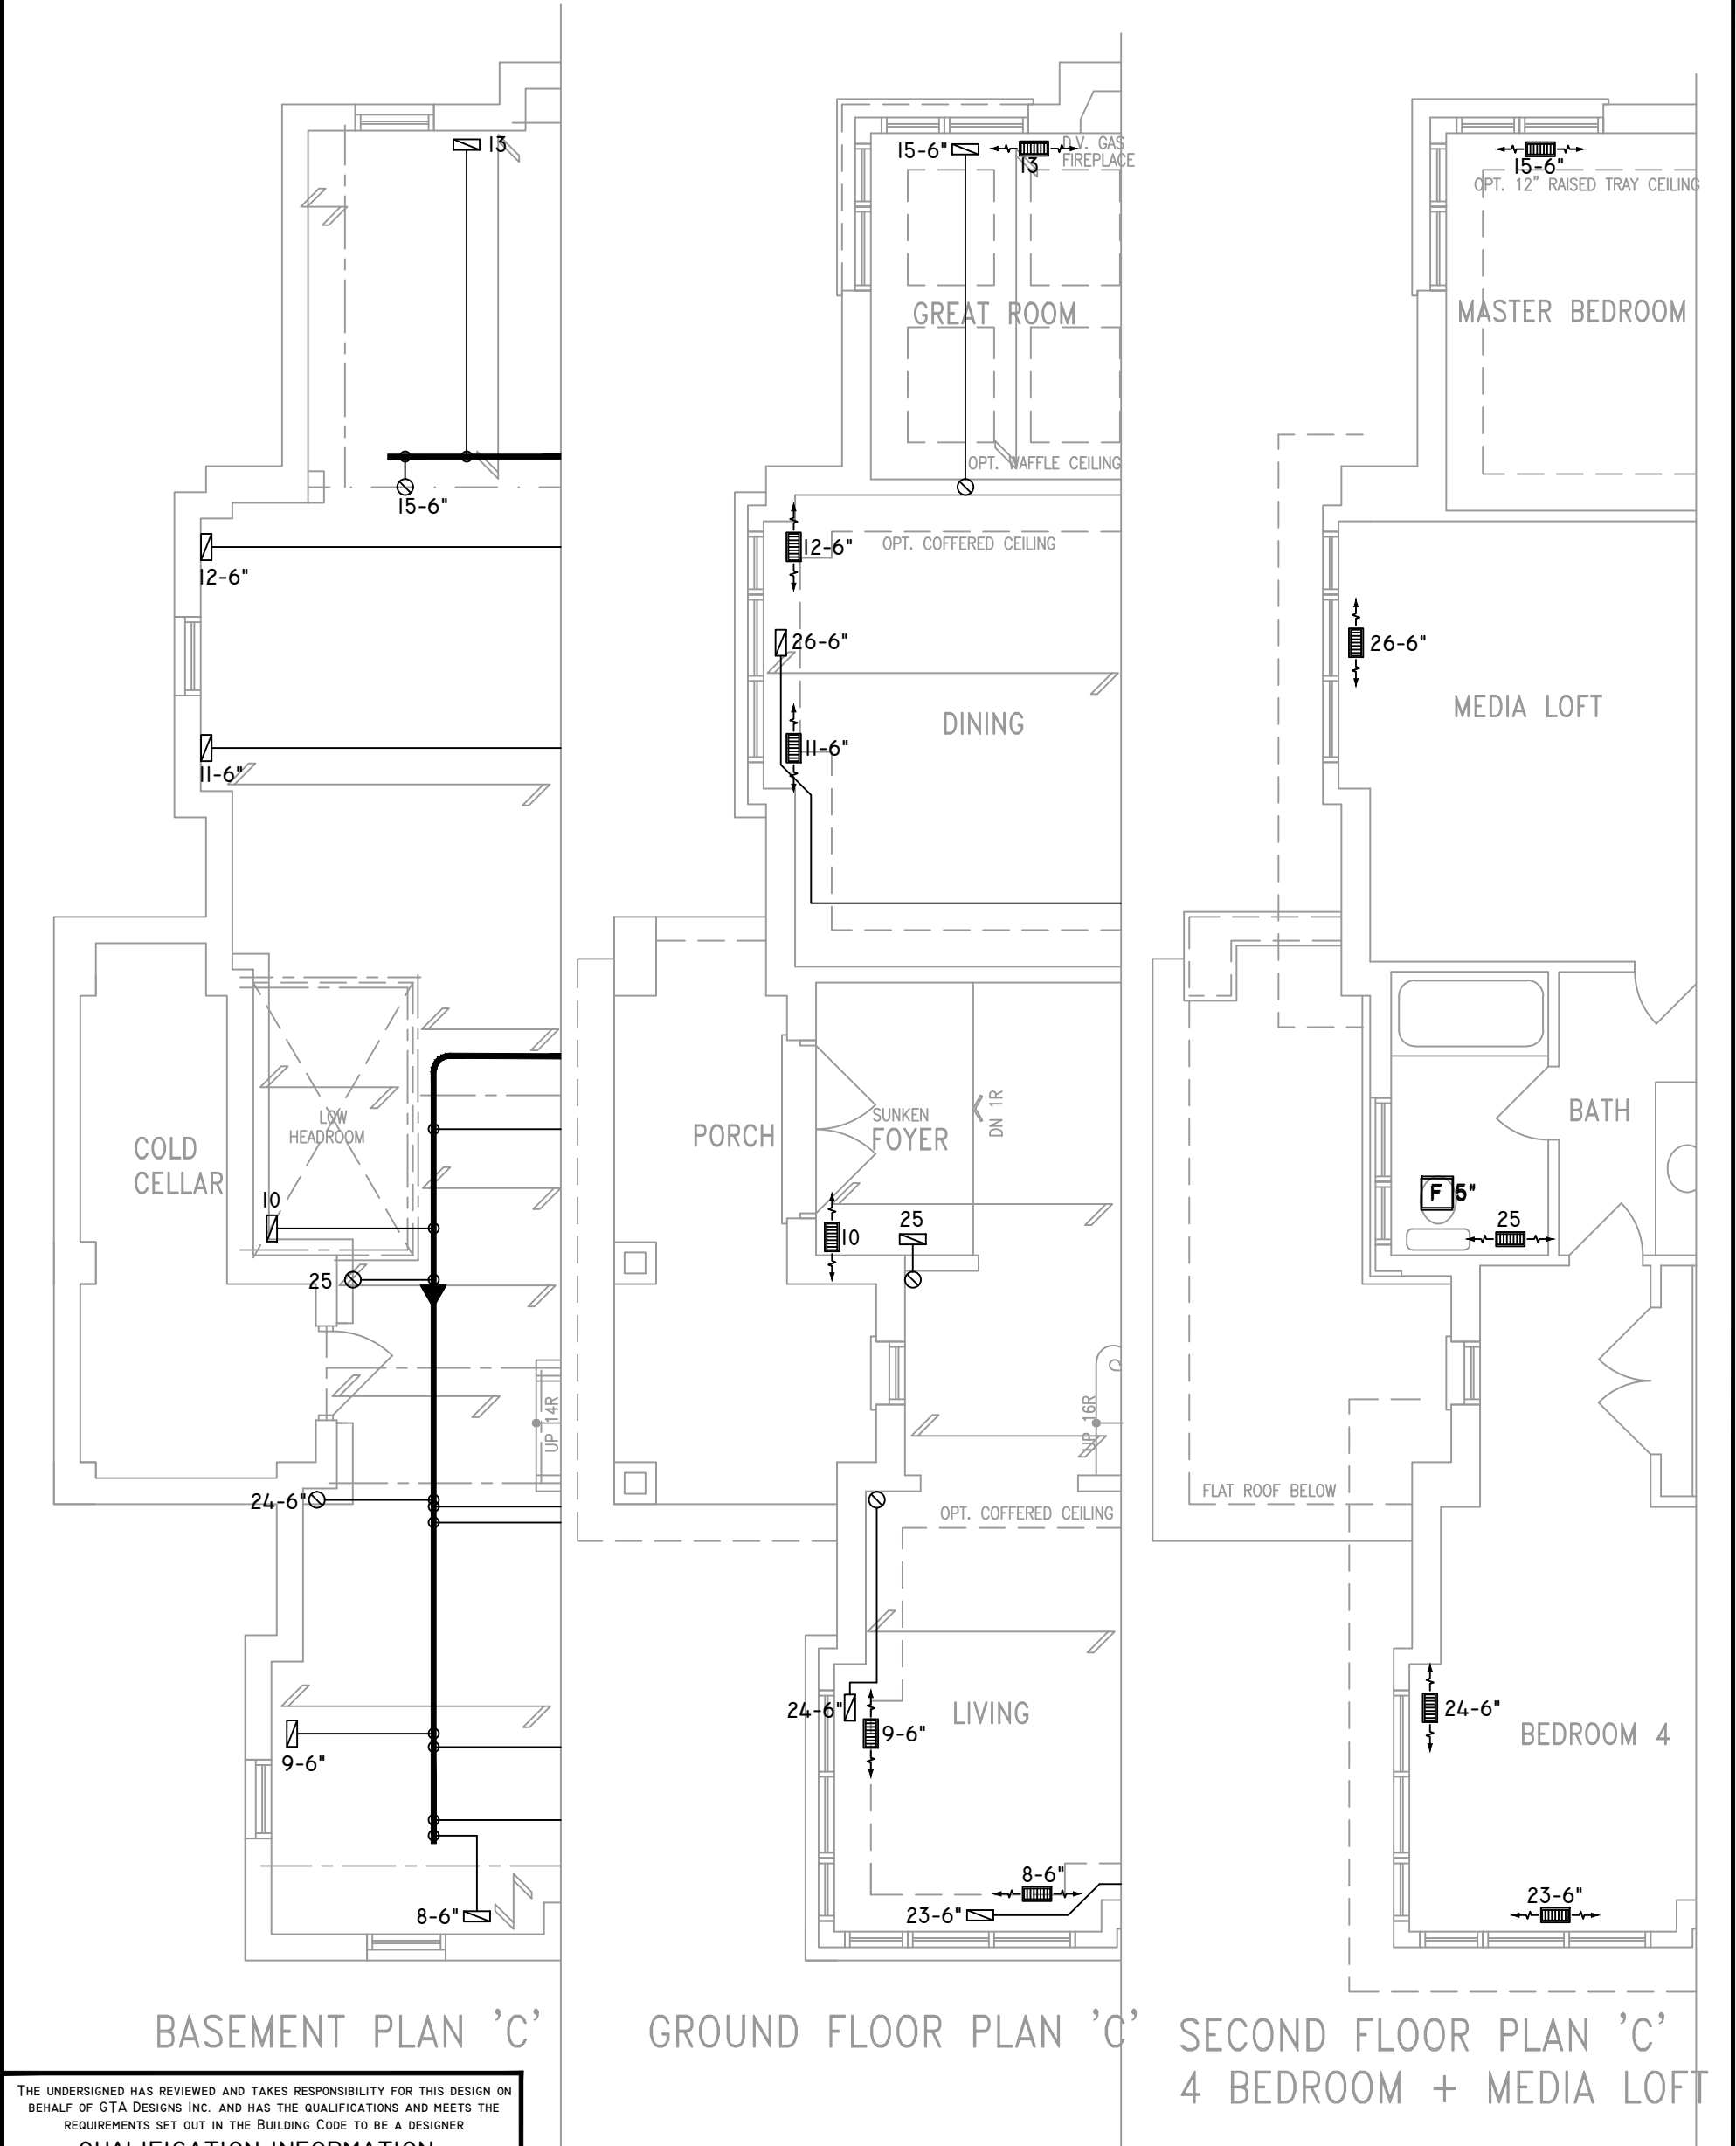

THE UNDERSIGNED HAS REVIEWED AND TAKES RESPONSIBILITY FOR THIS DESIGN ON BEHALF OF GTA DESIGNS INC. AND HAS THE QUALIFICATIONS AND MEETS THE REQUIREMENTS SET OUT IN THE BUILDING CODE TO BE A DESIGNER

QUALIFICATION INFORMATION

 REQUIRED UNLESS DESIGN IS EXEMPT UNDER DIVISION C 3.2.5.1 OF THE ONTARIO BUILDING CODE

DAVID DA COSTA  B.C.I.N. 32964

SIGNATURE OF DESIGNER

OBC 2012

ZONE I COMPLIANCE
PACKAGE "A1" REF. TABLE 3.1.1.2.A

NOTES
INSTALLATION TO COMPLY WITH THE LATEST ONTARIO BUILDING CODE.
ALL SUPPLY OUTLETS TO BE 5" DIA. UNLESS OTHERWISE SPECIFIED.
PROVIDE BALANCING DAMPERS ON ALL BRANCHES.
ALL R/A PARTITIONS 6" (FIRST FLOOR ONLY)
INSULATE DUCTS IN UNCONDITIONED SPACES R12 UNDERCUT ALL DOORS 1" MIN.
CONTRACTOR MUST WORK FROM APPROVED PLANS.
ANY ALTERATIONS TO THIS ORIGINAL PLAN ARE NOT THE RESPONSIBILITY OF GTA DESIGNS.
GTA DESIGNS MUST BE CONSULTED IF KITCHEN EXHAUST FAN EXCEEDS 700 CFM DEPRESSURIZATION MAY OCCUR WITH IN THE DWELLING.




2985 DREW ROAD
SUITE 202,
MISSISSAUGA, ONT.
L4T 0A4 TEL: 905-671-9800
EMAIL: DAVE@GTADESIGNS.CA
WEB: WWW.GTADESIGNS.CA


HEAT-LOSS	57,283	BTU/HR.
UNIT MAKE	AMANA	OR EQUAL.
UNIT MODEL	AMEC960803BNA	OR EQUAL.
UNIT HEATING INPUT	80,000	BTU/HR.
UNIT HEATING OUTPUT	76,800	BTU/HR.
A/C COOLING CAPACITY	3.0	TONS.
FAN SPEED	1172	CFM

# OF RUNS	S/A	R/A	FANS
3RD FLOOR			
2ND FLOOR	13	4	4
1ST FLOOR	10	1	2
BASEMENT	4	1	


FLOOR PLAN: PARTIAL PLAN(S)		
DRAWN BY: AM	CHECKED: DD	SQFT 3179
LAYOUT NO. JB-04589	DRAWING NO. M9	

 DATE:	APRIL 4, 2018
CLIENT:	BAYVIEW WELLINGTON
MODEL:	S42-7C RIDEAU 7
PROJECT:	GREEN VALLEY EAST BRADFORD,ONT.
SCALE:	3/16" = 1'-0"

	FLEX DUCT		LOW/HIGH WALL/KICK SUPPLY DIFFUSER		DUCT CONNECTION TO JOIST LINING		RETURN AIR GRILLE (SIZE INDICATED ON DRAWING)	S.A.	SUPPLY AIR
	RIGID ROUND DUCT		HRV EXHAUST GRILLE		RETURN AIR PIPE RISER		RETURN AIR RISER UP TO FLOOR ABOVE	R.A.	RETURN AIR
	SUPPLY DIFFUSER		SUPPLY AIR PIPE RISER		RETURN ROUND DUCT		RETURN AIR FROM BASEMENT SECOND FLOOR		THERMOSTAT
			VOLUME DAMPER						PRINCIPAL EXHAUST FAN SWITCH W/R & PRINCIPAL EXHAUST FAN

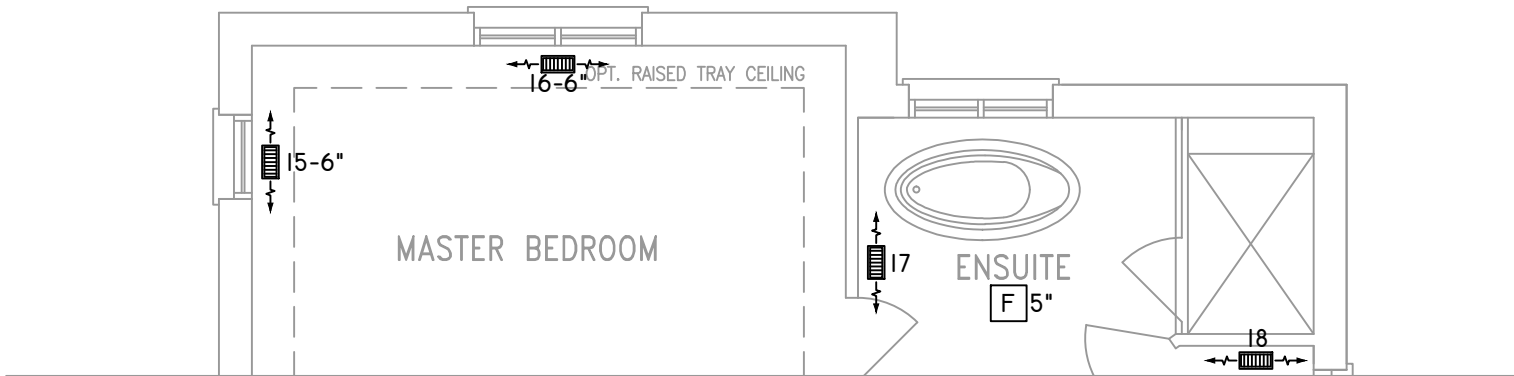

SECOND FLOOR PLAN 'B'
4 BEDROOM + MEDIA LOFT

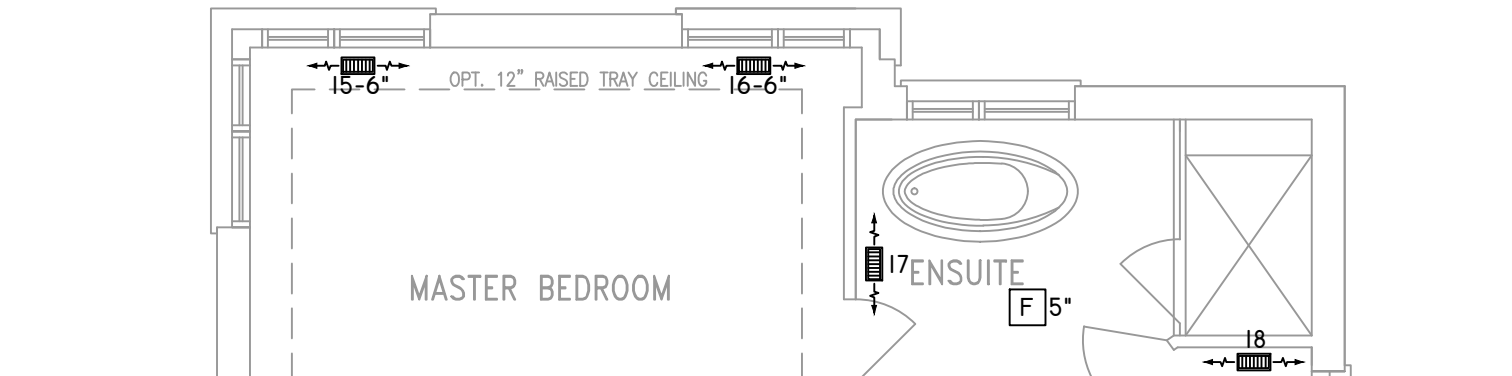


SECOND FLOOR PLAN 'C'
4 BEDROOM + MEDIA LOFT

THE UNDERSIGNED HAS REVIEWED AND TAKES RESPONSIBILITY FOR THIS DESIGN ON BEHALF OF GTA DESIGNS INC. AND HAS THE QUALIFICATIONS AND MEETS THE REQUIREMENTS SET OUT IN THE BUILDING CODE TO BE A DESIGNER

QUALIFICATION INFORMATION

REQUIRED UNLESS DESIGN IS EXEMPT UNDER DIVISION C 3.2.5.1 OF THE ONTARIO BUILDING CODE

 DAVID DA COSTA



B.C.I.N. 32964

SIGNATURE OF DESIGNER

OBC 2012

ZONE I COMPLIANCE
PACKAGE "A1" REF. TABLE 3.1.1.2.A

NOTES
INSTALLATION TO COMPLY WITH THE LATEST ONTARIO BUILDING CODE.
ALL SUPPLY OUTLETS TO BE 5" DIA. UNLESS OTHERWISE SPECIFIED.
PROVIDE BALANCING DAMPERS ON ALL BRANCHES.
ALL R/A PARTITIONS 6" (FIRST FLOOR ONLY)
INSULATE DUCTS IN UNCONDITIONED SPACES R12 UNDERCUT ALL DOORS 1" MIN.
CONTRACTOR MUST WORK FROM APPROVED PLANS.
ANY ALTERATIONS TO THIS ORIGINAL PLAN ARE NOT THE RESPONSIBILITY OF GTA DESIGNS.
GTA DESIGNS MUST BE CONSULTED IF KITCHEN EXHAUST FAN EXCEEDS 700 CFM DEPRESSURIZATION MAY OCCUR WITH IN THE DWELLING.



2985 DREW ROAD
SUITE 202,
MISSISSAUGA, ONT.
L4T 0A4 TEL: 905-671-9800
EMAIL: DAVE@GTADESIGNS.CA
WEB: WWW.GTADESIGNS.CA

HEAT-LOSS	57,283	BTU/HR.
UNIT MAKE	AMANA	OR EQUAL.
UNIT MODEL	AMEC960803BNA	OR EQUAL.
UNIT HEATING INPUT	80,000	BTU/HR.
UNIT HEATING OUTPUT	76,800	BTU/HR.
A/C COOLING CAPACITY	3.0	TONS.
FAN SPEED	1172	CFM

# OF RUNS	S/A	R/A	FANS
3RD FLOOR			
2ND FLOOR	13	4	4
1ST FLOOR	10	1	2
BASEMENT	4	1	

FLOOR PLAN: PARTIAL PLAN(S)	
DRAWN BY: AM	CHECKED: DD
LAYOUT NO. JB-04589	DRAWING NO. M10

DATE:	APRIL 4, 2018
CLIENT:	BAYVIEW WELLINGTON
MODEL:	S42-7C RIDEAU 7
PROJECT:	GREEN VALLEY EAST BRADFORD,ONT.
SCALE:	3/16" = 1'-0"