

Use one form for each individual who reviews and takes responsibility for design activities with respect to the project.

A. Project Information					
Building number, street name Rideau 1 S42-1B				Lot: Lot/con.	
Municipality Bradford		Postal code	Plan number/ other description		
B. Individual who reviews and takes responsibility for design activities					
Name David DaCosta			Firm gtaDesigns Inc.		
Street address 2985 Drew Road, Suite 202				Unit no.	Lot/con.
Municipality Mississauga		Postal code L4T 0A4	Province Ontario	E-mail dave@gtadesigns.ca	
Telephone number (905) 671-9800		Fax number (647) 494-9643		Cell number (416) 268-6820	
C. Design activities undertaken by individual identified in Section B. [Building Code Table 3.5.2.1 of Division C]					
☐ House ☒ HVAC – House ☐ Building Structural ☐ Small Buildings ☐ Building Services ☐ Plumbing – House ☐ Large Buildings ☐ Detection, Lighting and Power ☐ Plumbing – All Buildings ☐ Complex Buildings ☐ Fire Protection ☐ On-site Sewage Systems					
Description of designer's work			Model Certification		Project #:
					PJ-00204
					Layout #:
					JB-04581
Heating and Cooling Load Calculations		Main	X	Builder	Bayview Wellington
Air System Design		Alternate		Project	Green Valley East
Residential mechanical ventilation Design Summary		Area Sq ft:	1791	Model	Rideau 1
Residential System Design per CAN/CSA-F280-12					S42-1B
Residential New Construction - Forced Air				SB-12	Package A1
D. Declaration of Designer					
I, <u>David DaCosta</u> declare that (choose one as appropriate): (print name)					
☐ I review and take responsibility for the design work on behalf of a firm registered under subsection 3.2.4 Division C of the Building Code. I am qualified, and the firm is registered, in the appropriate classes/categories. Individual BCIN: _____ Firm BCIN: _____					
☒ I review and take responsibility for the design and am qualified in the appropriate category as an "other designer" under subsection 3.2.5 of Division C, of the Building Code. Individual BCIN: <u>32964</u> Basis for exemption from registration: <u>Division C 3.2.4.1. (4)</u>					
☐ The design work is exempt from the registration and qualification requirements of the Building Code. Basis for exemption from registration and qualification:					
I certify that: 1. The information contained in this schedule is true to the best of my knowledge. 2. I have submitted this application with the knowledge and consent of the firm.					
<u>March 20, 2018</u> Date			 Signature of Designer		

NOTE:

- For the purposes of this form, "individual" means the "person" referred to in Clause 3.2.4.7(1) d), of Division C, Article 3.2.5.1. of Division C and all other persons who are exempt from qualifications under Subsections 3.2.4 . and 3.2.5.of Division C.
- Schedule 1 does not require to be completed a holder of a license, temporary license, or a certificate of authorization, issued by the Ontario Association of Architects. Schedule 1 is also not required to be completed by a holder of a license to practise, a limited licence to practise, or a certificate of authorization, issued by the Association of Professional Engineers of Ontario.

Heat loss and gain calculation summary sheet				CSA-F280-M12 Standard Form No. 1	
These documents issued for the use of Bayview Wellington				Layout No.	
and may not be used by any other persons without authorization. Documents for permit and/or construction are signed in red.				JB-04581	
Building Location					
Address (Model): S42-1B			Site: Green Valley East		
Model: Rideau 1			Lot:		
City and Province: Bradford			Postal code:		
Calculations based on					
Dimensional information based on:			VA3 Design Jan/2018		
Attachment: Detached			Front facing: East/West		Assumed? Yes
No. of Levels: 2		Ventilated? Included	Air tightness: 1961-Present (ACH=3.57)		Assumed? Yes
Weather location: Bradford			Wind exposure: Sheltered		
HRV? LifeBreath		RNC155	Internal shading: Light-translucent		Occupants: 3
Sensible Eff. at -25C 71%		Apparent Effect. at -0C 84%	Units: Imperial		Area Sq ft: 1791
Sensible Eff. at -0C 75%					
Heating design conditions			Cooling design conditions		
Outdoor temp -9.4 Indoor temp: 72 Mean soil temp: 48			Outdoor temp 86 Indoor temp: 75 Latitude: 44		
Above grade walls			Below grade walls		
Style A: As per OBC SB12 Package A1 R 22			Style A: As per OBC SB12 Package A1 R 20ci		
Style B: Existing Walls (When Applicable) R 12			Style B:		
Style C:			Style C:		
Style D:			Style D:		
Floors on soil			Ceilings		
Style A: As per Selected OBC SB12 Package A1			Style A: As per Selected OBC SB12 Package A1 R 60		
Style B:			Style B: As per Selected OBC SB12 Package A1 R 31		
Exposed floors			Style C:		
Style A: As per Selected OBC SB12 Package A1 R 31			Doors		
Style B:			Style A: As per Selected OBC SB12 Package A1 R 4.00		
Windows			Style B:		
Style A: As per Selected OBC SB12 Package A1 R 3.55			Style C:		
Style B: Existing Windows (When Applicable) R 1.99			Skylights		
Style C:			Style A: As per Selected OBC SB12 Package A1 R 2.03		
Style D:			Style B:		
Attached documents: As per Shedule 1		Heat Loss/Gain Caculations based on CSA-F280-12 Effective R-Values			
Notes: Residential New Construction - Forced Air					
Calculations performed by					
Name: David DaCosta			Postal code: L4T 0A4		
Company: gtaDesigns Inc.			Telephone: (905) 671-9800		
Address: 2985 Drew Road, Suite 202			Fax: (416) 268-6820		
City: Mississauga			E-mail dave@gtadesigns.ca		

Builder: **Bayview Wellington**

Date: **March 20, 2018**

I review and take responsibility for the design work and am qualified in the appropriate category as an "other designer" under Division C subsection 3.2.5. of the Building Code.

Page 3

Project: **Green Valley East**

Model: **Rideau 1 S42-1B**

System 1

Individual BCIN: 32964

David DaCosta

Project # **PJ-00204**
Layout # **JB-04581**

DESIGN LOAD SPECIFICATIONS		AIR DISTRIBUTION & PRESSURE		FURNACE/AIR HANDLER DATA:		BOILER/WATER HEATER DATA:		A/C UNIT DATA:	
Level 1 Net Load	16,429 btu/h	Equipment External Static Pressure	0.5 "w.c.	Make	Amana	Make	Type	Amana	2.0 Ton
Level 2 Net Load	22,208 btu/h	Additional Equipment Pressure Drop	0.225 "w.c.	Model	AMEC960603BNA	Model		Cond.-----	2.0
Level 3 Net Load	0 btu/h	Available Design Pressure	0.275 "w.c.	Input Btu/h	60000	Input Btu/h		Coil -----	2.0
Level 4 Net Load	0 btu/h	Return Branch Longest Effective Length	300 ft	Output Btu/h	57600	Output Btu/h			
Total Heat Loss	38,637 btu/h	R/A Plenum Pressure	0.138 "w.c.	E.s.p.	0.50 " W.C.	Min.Output Btu/h	AWH		
Total Heat Gain	21,150 btu/h	S/A Plenum Pressure	0.14 "w.c.	Water Temp	deg. F.	Blower DATA:			
Combo System HL + 10%	42,500 Btu/h	Heating Air Flow Proportioning Factor	0.0303 cfm/btuh	AFUE	96%	Blower Speed Selected:	W2	Blower Type	ECM
Building Volume Vb	29151 ft³	Cooling Air Flow Proportioning Factor	0.0455 cfm/btuh	Aux. Heat				(Brushless DC OBC 12.3.1.5.(2))	
Ventilation Load	671 Btu/h.	R/A Temp	70 deg. F.	SB-12 Package	Package A1	Heating Check	1170 cfm	Cooling Check	963 cfm
Ventilation PVC	47.7 cfm	S/A Temp	116 deg. F.						
Supply Branch and Grill Sizing		Diffuser loss	0.01 "w.c.	Temp. Rise>>>	46 deg. F.	Selected cfm>	1170 cfm	Cooling Air Flow Rate	963 cfm

	Level 1														Level 2													
S/A Outlet No.	1	2	3	4	5	6									7	8	9	10	11	12	13	14	15	16	17	18	19	
Room Use	BASE	BASE	BASE	BASE	BASE	BASE									MAST	MAST	LIV/DIN	LIV/DIN	LIV/DIN	KIT	KIT	LAUN	FOY IB/BED2	IB/BED2	BATH	ENS		
Btu/Outlet	2738	2738	2738	2738	2738	2738									1744	1744	1654	1654	1654	1744	1744	1393	2491	2052	2052	879	1402	
Heating Airflow Rate CFM	83	83	83	83	83	83									53	53	50	50	50	53	53	42	75	62	62	27	42	
Cooling Airflow Rate CFM	18	18	18	18	18	18									62	62	84	84	84	73	73	72	71	69	69	19	34	
Duct Design Pressure	0.13	0.13	0.13	0.13	0.13	0.13	0.13	0.13	0.13	0.13	0.13	0.13	0.13	0.13	0.13	0.13	0.13	0.13	0.13	0.13	0.13	0.13	0.13	0.13	0.13			
Actual Duct Length	45	55	33	26	15	26									58	51	49	56	67	53	46	35	26	34	30	9	24	
Equivalent Length	110	100	110	90	140	90	70	70	70	70	70	70	70	70	120	80	90	110	90	70	80	140	100	80	70	120	100	70
Total Effective Length	155	155	143	116	155	116	70	70	70	70	70	70	70	70	178	131	139	166	157	123	126	175	126	114	100	129	124	70
Adjusted Pressure	0.08	0.08	0.09	0.11	0.08	0.11	0.19	0.19	0.19	0.19	0.19	0.19	0.19	0.19	0.07	0.10	0.09	0.08	0.08	0.11	0.10	0.07	0.10	0.11	0.13	0.10	0.10	0.19
Duct Size Round	6	6	6	6	6	6									5	5	6	6	6	5	5	6	6	5	5	4	4	
Outlet Size	4x10	4x10	4x10	4x10	4x10	4x10	4x10	4x10	4x10	4x10	4x10	4x10	4x10	4x10	3x10	3x10	4x10	4x10	4x10	3x10	3x10	4x10	4x10	3x10	3x10	3x10	3x10	4x10
Trunk	C	B	A	A	D	D									C	C	C	B	B	A	A	A	D	D	D	D	D	A

	Level 3														Level 4													
S/A Outlet No.																												
Room Use																												
Btu/Outlet																												
Heating Airflow Rate CFM																												
Cooling Airflow Rate CFM																												
Duct Design Pressure	0.13	0.13	0.13	0.13	0.13	0.13	0.13	0.13	0.13	0.13	0.13	0.13	0.13	0.13	0.13	0.13	0.13	0.13	0.13	0.13	0.13	0.13	0.13	0.13	0.13	0.13	0.13	0.13
Actual Duct Length																												
Equivalent Length	70	70	70	70	70	70	70	70	70	70	70	70	70	70	70	70	70	70	70	70	70	70	70	70	70	70	70	70
Total Effective Length	70	70	70	70	70	70	70	70	70	70	70	70	70	70	70	70	70	70	70	70	70	70	70	70	70	70	70	70
Adjusted Pressure	0.19	0.19	0.19	0.19	0.19	0.19	0.19	0.19	0.19	0.19	0.19	0.19	0.19	0.19	0.19	0.19	0.19	0.19	0.19	0.19	0.19	0.19	0.19	0.19	0.19	0.19	0.19	0.19
Duct Size Round																												
Outlet Size	4x10	4x10	4x10	4x10	4x10	4x10	4x10	4x10	4x10	4x10	4x10	4x10	4x10	4x10	4x10	4x10	4x10	4x10	4x10	4x10	4x10	4x10	4x10	4x10	4x10	4x10	4x10	4x10
Trunk																												

Return Branch And Grill Sizing						Grill Pressure Loss						0.02 "w.c						Return Trunk Duct Sizing						Supply Trunk Duct Sizing					
R/A Inlet No.	1R	2R	3R	4R	5R	6R	7R	8R	9R	10R	11R	Trunk	CFM	Press.	Round	Rect. Size	Trunk	CFM	Press.	Round	Rect. Size								
Inlet Air Volume CFM	250	200	200	420	100							Drop					A												
Duct Design Pressure	0.12	0.12	0.12	0.12	0.12	0.12	0.12	0.12	0.12	0.12	0.12		1170	0.06	16.5	24x10	B	778	0.07	14.0	22x8 18x10								
Actual Duct Length	18	32	39	20	21								1170	0.06	16.5	32x8 24x10	C	183	0.08	8.0	8x8 8x7								
Equivalent Length	150	180	135	135	105	50	50	50	50	50	50		650	0.06	13.5	20x8 16x10	D	239	0.07	9.0	8x8 10x7								
Total Effective Length	168	212	174	155	126	50	50	50	50	50	50						E	392	0.08	10.5	12x8 10x10								
Adjusted Pressure	0.07	0.06	0.07	0.08	0.09	0.24	0.24	0.24	0.24	0.24	0.24	W					F												
Duct Size Round	8.0	8.5	8.5	10.5	6.0							V					G												
Inlet Size	FLC	8	8	8	8							U					H												
" "	x	x	x	x	x	x	x	x	x	x	x	T					I												
Inlet Size	9x6	14	14	30	14							S					J												
												R					K												
												O																	
Trunk	Y	Y	Y	Z	Z																								

2012 OBC

Builder: Bayview Wellington

Date: March 20, 2018

Project: Green Valley East

Model: Rideau 1 S42-1B

System 1

Weather Data Bradford 44 -9.4 86 22 48.2

Heat Loss ^T 81.4 deg. F Ht gain ^T 11 deg. F GTA: 1791

Project # PJ-00204
Layout # JB-04581

Level 1

Run ft. exposed wall A	206	A	A	A	A	A	A	A	A	A	A	A	A	A
Run ft. exposed wall B	B	B	B	B	B	B	B	B	B	B	B	B	B	B
Ceiling height	3.8	AG	3.8	AG	3.8	AG	3.8	AG	3.8	AG	3.8	AG	3.8	AG
Floor area	1626	Area	Area	Area	Area	Area	Area	Area	Area	Area	Area	Area	Area	Area
Exposed Ceilings A	A	A	A	A	A	A	A	A	A	A	A	A	A	A
Exposed Ceilings B	B	B	B	B	B	B	B	B	B	B	B	B	B	B
Exposed Floors	Flr	Flr	Flr	Flr	Flr	Flr	Flr	Flr	Flr	Flr	Flr	Flr	Flr	Flr
Gross Exp Wall A	779													
Gross Exp Wall B														

Components	R-Values	Loss	Gain	Loss	Gain	Loss	Gain	Loss	Gain	Loss	Gain	Loss	Gain	Loss	Gain	Loss	Gain
North Shaded	3.55	22.93	10.91														
East/West	3.55	22.93	27.35	41	940	1121											
South	3.55	22.93	20.89	6	138	125											
WOB Windows	3.15	25.84	28.32														
Skylight	2.03	40.10	88.23														
Doors	4.00	20.35	2.75	21	427	58											
Net exposed walls A	21.12	3.85	0.52	711		370											
Net exposed walls B	14.49	5.62	0.76														
Exposed Ceilings A	59.22	1.37	0.64														
Exposed Ceilings B	22.86	3.56	1.66														
Exposed Floors	29.80	2.73	0.17														
Foundation Conductive Heatloss	On Grade () or Above																
Total Conductive	Heat Loss																
	Heat Gain																
Air Leakage	Heat Loss/Gain	0.5900	0.0299														
Ventilation	Case 1	0.04	0.05														
	Case 2	14.07	11.88														
	Case 3	x	0.02	0.05													
Heat Gain People			239														
Appliances Loads	1 = .25 percent		4114														
Duct and Pipe loss			10%														
Level 1 HL Total	16,429			16429													
Level 1 HG Total	2,359				2359												

Level 2

Run ft. exposed wall A	35	A	38	A	36	A	15	A	17	A	42	A	10	A	14	A	A	A
Run ft. exposed wall B	B	B	B	B	B	B	B	B	B	B	B	B	B	B	B	B	B	B
Ceiling height	10.0		12.0		9.0		10.0		12.0		10.0		9.0		9.0		9.0	
Floor area	286	Area	300	Area	535	Area	52	Area	68	Area	151	Area	67	Area	154	Area	Area	Area
Exposed Ceilings A	286	A	300	A	535	A	52	A	68	A	151	A	67	A	154	A	A	A
Exposed Ceilings B	B	B	B	B	B	B	B	B	B	B	B	B	B	B	B	B	B	B
Exposed Floors	Flr	Flr	Flr	Flr	Flr	Flr	Flr	Flr	Flr	Flr	Flr	Flr	Flr	Flr	Flr	Flr	Flr	Flr
Gross Exp Wall A	350		456		324		150		204		420		90		126			
Gross Exp Wall B																		

Components	R-Values	Loss	Gain	Loss	Gain	Loss	Gain	Loss	Gain	Loss	Gain	Loss	Gain	Loss	Gain	Loss	Gain	Loss	Gain
North Shaded	3.55	22.93	10.91																
East/West	3.55	22.93	27.35	40	917	1094													
South	3.55	22.93	20.89																
Existing Windows	1.99	40.90	22.15																
Skylight	2.03	40.10	88.23																
Doors	4.00	20.35	2.75																
Net exposed walls A	17.03	4.78	0.65	310	1482	200													
Net exposed walls B	8.50	9.58	1.29																
Exposed Ceilings A	59.22	1.37	0.64	286	393	184													
Exposed Ceilings B	22.86	3.56	1.66																
Exposed Floors	29.80	2.73	0.17																
Foundation Conductive Heatloss	On Grade () or Above																		
Total Conductive	Heat Loss																		
	Heat Gain																		
Air Leakage	Heat Loss/Gain	0.2252	0.0299																
Ventilation	Case 1	0.02	0.05																
	Case 2	14.07	11.88																
	Case 3	x	0.02	0.05															
Heat Gain People			239																
Appliances Loads	1 = .25 percent		4114																
Duct and Pipe loss			10%																
Level 2 HL Total	22,208			3488															
Level 2 HG Total	18,791				2703														

I review and take responsibility for the design work and am qualified in the appropriate category as an "other designer" under

Division C subsection 3.2.5. of the Building Code. Individual BCIN:

32964

Dave DaCosta

Dave DaCosta

SB-12 Package

Package A1

Site Copy

I review and take responsibility for the design work and am qualified in the appropriate category as an "other designer" under Division C subsection 3.2.5. of the Building Code.

Individual BCIN: 32964



David DaCosta

Package:
Package A1
Project:
Bradford
Model:
S42-1B
RESIDENTIAL MECHANICAL VENTILATION DESIGN SUMMARY

For systems serving one dwelling unit & conforming to the Ontario Building Code, O.reg 332/12

Location of Installation

Lot #	Plan #
Township	Bradford
Roll #	Permit #
Address	

Builder

Name	Bayview Wellington
Address	
City	
Tel	Fax

Installing Contractor

Name	
Address	
City	
Tel	Fax

Combustion Appliances 9.32.3.1(1)

- | | | |
|----|-------------------------------------|--|
| a) | ☒ | Direct vent (sealed combustion) only |
| b) | ☐ | Positive venting induced draft (except fireplaces) |
| c) | ☐ | Natural draft, B-vent or induced draft fireplaces |
| d) | ☐ | Solid fuel (including fireplaces) |
| e) | ☐ | No combustion Appliances |

Heating System

- | | |
|-------------------------------------|--|
| ☒ | Forced air |
| ☐ | Non forced air |
| ☐ | Electric space heat (if over 10% of heat load) |

House Type 9.32.3.1(2)

- | | | |
|-------|-------------------------------------|---|
| I | ☒ | Type a) or b) appliances only, no solid fuel |
| II | ☐ | Type I except with solid fuel (including fireplace) |
| III | ☐ | Any type c) appliance |
| IV | ☐ | Type I or II either electric space heat |
| Other | ☐ | Type I, II or IV no forced air |

System Design Option

- | | | |
|---|-------------------------------------|---|
| 1 | ☐ | Exhaust only / forced air system |
| 2 | ☐ | HRV WITH DUCTING / forced air system |
| 3 | ☒ | HRV simplified connection to forced air system |
| 4 | ☐ | HRV full ducting/not coupled to forced air system |
| | | Part 6 design |

Total Ventilation Capacity 9.32.3.3(1)

Bsmt & Master Bdrm	2 @ 21.2 cfm	42.4 cfm
Other Bedrooms	1 @ 10.6 cfm	10.6 cfm
Bathrooms & Kitchen	3 @ 10.6 cfm	31.8 cfm
Other rooms	5 @ 10.6 cfm	53 cfm
Total		<u>137.8</u>

Principal Ventilation Capacity 9.32.3.4(1)

Master bedroom	1 @ 31.8 cfm	31.8 cfm
Other bedrooms	1 @ 15.9 cfm	15.9 cfm
Total		<u>47.7</u>

Principal Exhaust Fan Capacity

Make	Model	Location
LifeBreath	RNC155	Base

132 cfm Sones or Equiv.

Heat Recovery Ventilator

Make	LifeBreath
Model	RNC155
	132 cfm high 80 cfm low
Sensible efficiency @ -25 deg C	71%
Sensible efficiency @ 0 deg C	75%

Note: Installer to balance HRV/ERV to within 10 percent of PVC

Supplemental Ventilation Capacity

Total ventilation capacity	137.8
Less principal exhaust capacity	47.7
REQUIRED supplemental vent. Capacity	<u>90.1</u> cfm

Supplemental Fans 9.32.3.5.

Location	cfm	Model	Sones
Ens	50	XB50	0.3
Bath	50	XB50	0.3

all fans HVI listed Make Broan or Equiv.

Designer Certification

I hereby certify that this ventilation system has been designed in accordance with the Ontario Building Code.

Name David DaCosta

Signature



HRAI #

5190

BCIN #

32964

Date

March 20, 2018



2985 Drew Road, Suite 202, Mississauga, Ontario
 L4T 0A4 Tel: 905-671-9800 Fax: 647-494-9643
 e-mail dave@gtadesigns.ca

Energy Efficiency Design Summary: Prescriptive Method (Building Code Part 9, Residential)

Page 7
 Project # PJ-00204
 Layout # JB-04581

This form is used by a designer to demonstrate that the energy efficiency design of a house complies with the building code using the prescriptive method described in Subsection 3.1.1. of SB-12. This form is applicable where the ratio of gross area of windows/sidelights/skylights/glazing in doors and sliding glass doors to the gross area of peripheral walls is not more than 22%.

For use by Principal Authority

Application No:

Model/Certification Number

A. Project Information

Building number, street name Rideau 1 S42-1B		Unit number	Lot/Con
Municipality Bradford	Postal code	Reg. Plan number / other description	

B. Prescriptive Compliance [indicate the building code compliance package being employed in the house design]

SB-12 Prescriptive (input design package):

Package A1

Table: 3.1.1.2.A

C. Project Design Conditions

Climatic Zone (SB-1):	Heat. Equip. Efficiency	Space Heating Fuel Source		
☒ Zone 1 (< 5000 degree days) ☐ Zone 2 (≥ 5000 degree days)	☒ ≥ 92% AFUE ☐ ≥ 84% < 92% AFUE	☒ Gas ☐ Oil	☐ Propane ☐ Electric	☐ Solid Fuel ☐ Earth Energy
Ratio of Windows, Skylights & Glass (W, S & G) to Wall Area		Other Building Characteristics		
Area of Walls = <u>269.29</u> m ² or <u>2898.6</u> ft ²	W, S & G % = <u>11%</u>	☐ Log/Post&Beam ☐ Slab-on-ground ☒ Air Conditioning ☐ Air Sourced Heat Pump (ASHP) ☐ Ground Source Heat Pump (GSHP)		
Area of W, S & G = <u>28.799</u> m ² or <u>310.0</u> ft ²	Utilize Window Averaging ☐ Yes ☒ No	☐ ICF Above Grade ☐ Walkout Basement ☐ Combo Unit		

D. Building Specifications [provide values and ratings of the energy efficiency components proposed]

Energy Efficiency Substitutions			
☐ ICF (3.1.1.2.(5) & (6) / 3.1.1.3.(5)) ☐ Combined space heating and domestic water heating systems (3.1.1.2(7) / 3.1.1.3.(7))			
☐ Airtightness substitution(s) Airtightness test required (Refer to Design Guide Attached)	☐ Table 3.1.1.4.B Required:		Permitted Substitution:
	☐ Table 3.1.1.4.C Required:		Permitted Substitution:
Building Component	Minimum RSI/R-Values or Maximum U-Value ¹		Efficiency Ratings
Thermal Insulation	Nominal	Effective	Windows & Doors Provide U-Value ⁽¹⁾ or ER rating
Ceiling with Attic Space	60		Windows/Sliding Glass Doors 1.6
Ceiling without Attic Space	31		Skylights 2.8
Exposed Floor	31		Mechanicals
Walls Above Grade	22		Heating Equip.(AFUE) 96%
Basement Walls	20.0ci		HRV Efficiency (SRE% at 0°C) 75%
Slab (all >600mm below grade)	x		DHW Heater (EF) 0.80
Slab (edge only ≤600mm below grade)	10		DWHR (CSA B55.1 (min. 42% efficiency)) #Showers 2
Slab (all ≤600mm below grade, or heated)	10		Combined Heating System

(1) U value to be provided in either W/(m²·K) or Btu/(h·ft²·°F) but not both.

E. Designer(s) [name(s) & BCIN(s), if applicable, of person(s) providing information herein to substantiate that design meets building code]

Name David DaCosta	BCIN 32964	Signature
------------------------------	----------------------	---------------

Package: Package A1 System: System 1
Project: Bradford Model: S42-1B

Air Leakage Calculations

Building Air Leakage Heat Loss				
B	LRairh	Vb	HL^T	HLleak
0.018	0.234	29151	81.4	10009

Building Air Leakage Heat Gain				
B	LRairh	Vb	HG^T	HG Leak
0.018	0.055	29151	11	316

Air Leakage Heat Loss/Gain Multiplier Table (Section 11)				
Level	Level Factor (LF)	Building Air	Level Conductive Heat Loss	Air Leakage Heat Loss Multiplier
Level 1	0.6	10009	10179	0.5900
Level 2	0.4		17778	0.2252
Level 3	0		0	0.0000
Level 4	0		0	0.0000

Levels			
1	2	3	4
(LF)	(LF)	(LF)	(LF)
1.0	0.6	0.5	0.4
	0.4	0.3	0.3
		0.2	0.2
			0.1

HG LEAK		Air Leakage Heat Gain	
	316		0.0299
BUILDING CONDUCTIVE HEAT GAIN			10557

Levels this Dwelling	
2	

Ventilation Calculations

Ventilation Heat Loss

Ventilation Heat Loss				
C	PVC	HL^T	(1-E) HRV	HLbvent
1.08	47.7	81.4	0.16	671

Ventilation Heat Gain

Ventilation Heat Gain			
C	PVC	HG^T	HGbvent
1.1	47.7	11	567

Case 1

Ventilation Heat Loss (Exhaust only Systems)

Case 1 - Exhaust Only				
Level	LF	HLbvent	LVL Cond. HL	Multiplier
Level 1	0.6	671	10179	0.04
Level 2	0.4		17778	0.02
Level 3	0		0	0.00
Level 4	0		0	0.00

Case 1

Ventilation Heat Gain (Exhaust Only Systems)

Case 1 - Exhaust Only		Multiplier	
HGbvent	567	0.05	
Building	10557		

Case 2

Ventilation Heat Loss (Direct Ducted Systems)

C	HL^T	(1-E) HRV	Multiplier
1.08	81.4	0.16	14.07

Case 2

Ventilation Heat Gain (Direct Ducted Systems)

C	HG^T	Multiplier
1.08	11	11.88

Case 3

Ventilation Heat Loss (Forced Air Systems)

HLbvent		Multiplier
Total Ventilation Load	671	0.02

Case 3

Ventilation Heat Gain (Forced Air Systems)

Vent Heat Gain		Multiplier
HGbvent	HG*1.3	0.05
567	1	

Foundation Conductive Heatloss Level 1

2542 Watts 8674 Btu/h

Foundation Conductive Heatloss Level 2

Watts Btu/h

I review and take responsibility for the design work and am qualified in the appropriate category as an "other designer" under Division C subsection 3.2.5. of the Building Code. Individual BCIN: 32964

David DaCosta


Envelope Air Leakage Calculator


Supplemental tool for CAN/CSA-F280


Weather Station Description				
Province:	Ontario ▼			
Region:	Bradford ▼			
Weather Station Location:	Open flat terrain, grass ▼			
Anemometer height (m):	10			
Local Shielding				
Building Site:	Suburban, forest ▼			
Walls:	Heavy ▼			
Flue:	Heavy ▼			
Highest Ceiling Height (m):	3.90			
Building Configuration				
Type:	Detached			
Number of Stories:	One			
Foundation:	Full			
House Volume (m ³):	825.56			
Air Leakage/Ventilation				
Air Tightness Type:	Present (1961-) (ACH=3.57)			
Custom BDT Data:	ELA @ 10 Pa. ▼ 322.44 cm ²			
	3.57 ACH @ 50 Pa			
Mechanical Ventilation (L/s):	Total Supply:		Total Exhaust:	
	23.85		23.85	
Flue #:	#1	#2	#3	#4
Diameter (mm):	0	0	0	0
Heating Air Leakage Rate (ACH/H):		0.234		
Cooling Air Leakage Rate (ACH/H):		0.055		

Residential Foundation Thermal Load Calculator

Supplemental tool for CAN/CSA-F280

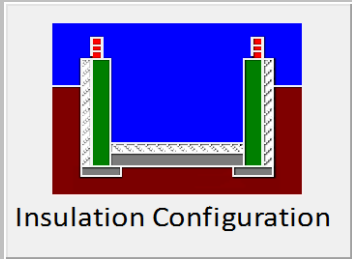Weather Station Description		
Province:	Ontario ▼	
Region:	Bradford ▼	
Site Description		
Soil Conductivity:	High conductivity: moist soil ▼	
Water Table:	Normal (7-10 m, 23-33 Ft) ▼	
Foundation Dimensions		
Floor Length (m):	25.46	 Insulation Configuration
Floor Width (m):	5.93	
Exposed Perimeter (m):	62.79	
Wall Height (m):	2.74	
Depth Below Grade (m):	1.59	
Window Area (m ²):	4.37	
Door Area (m ²):	1.95	
Radiant Slab		
Heated Fraction of the Slab:	0	
Fluid Temperature (°C):	33	
Design Months		
Heating Month	1	
Foundation Loads		
Heating Load (Watts):		2542

 	FLEX DUCT		LOW/HIGH WALL/KICK SUPPLY DIFFUSER		DUCT CONNECTION TO JOIST LINING		RETURN AIR GRILLE (SIZE INDICATED ON DRAWING)	S.A.	SUPPLY AIR
	RIGID ROUND DUCT		HRV EXHAUST GRILLE		RETURN AIR PIPE RISER		RETURN AIR RISER UP TO FLOOR ABOVE	R.A.	RETURN AIR
	SUPPLY DIFFUSER		SUPPLY AIR PIPE RISER		RETURN ROUND DUCT		RETURN AIR FROM BASEMENT SECOND FLOOR		THERMOSTAT
			VOLUME DAMPER						PRINCIPAL EXHAUST FAN SWITCH
									W/R & PRINCIPAL EXHAUST FAN

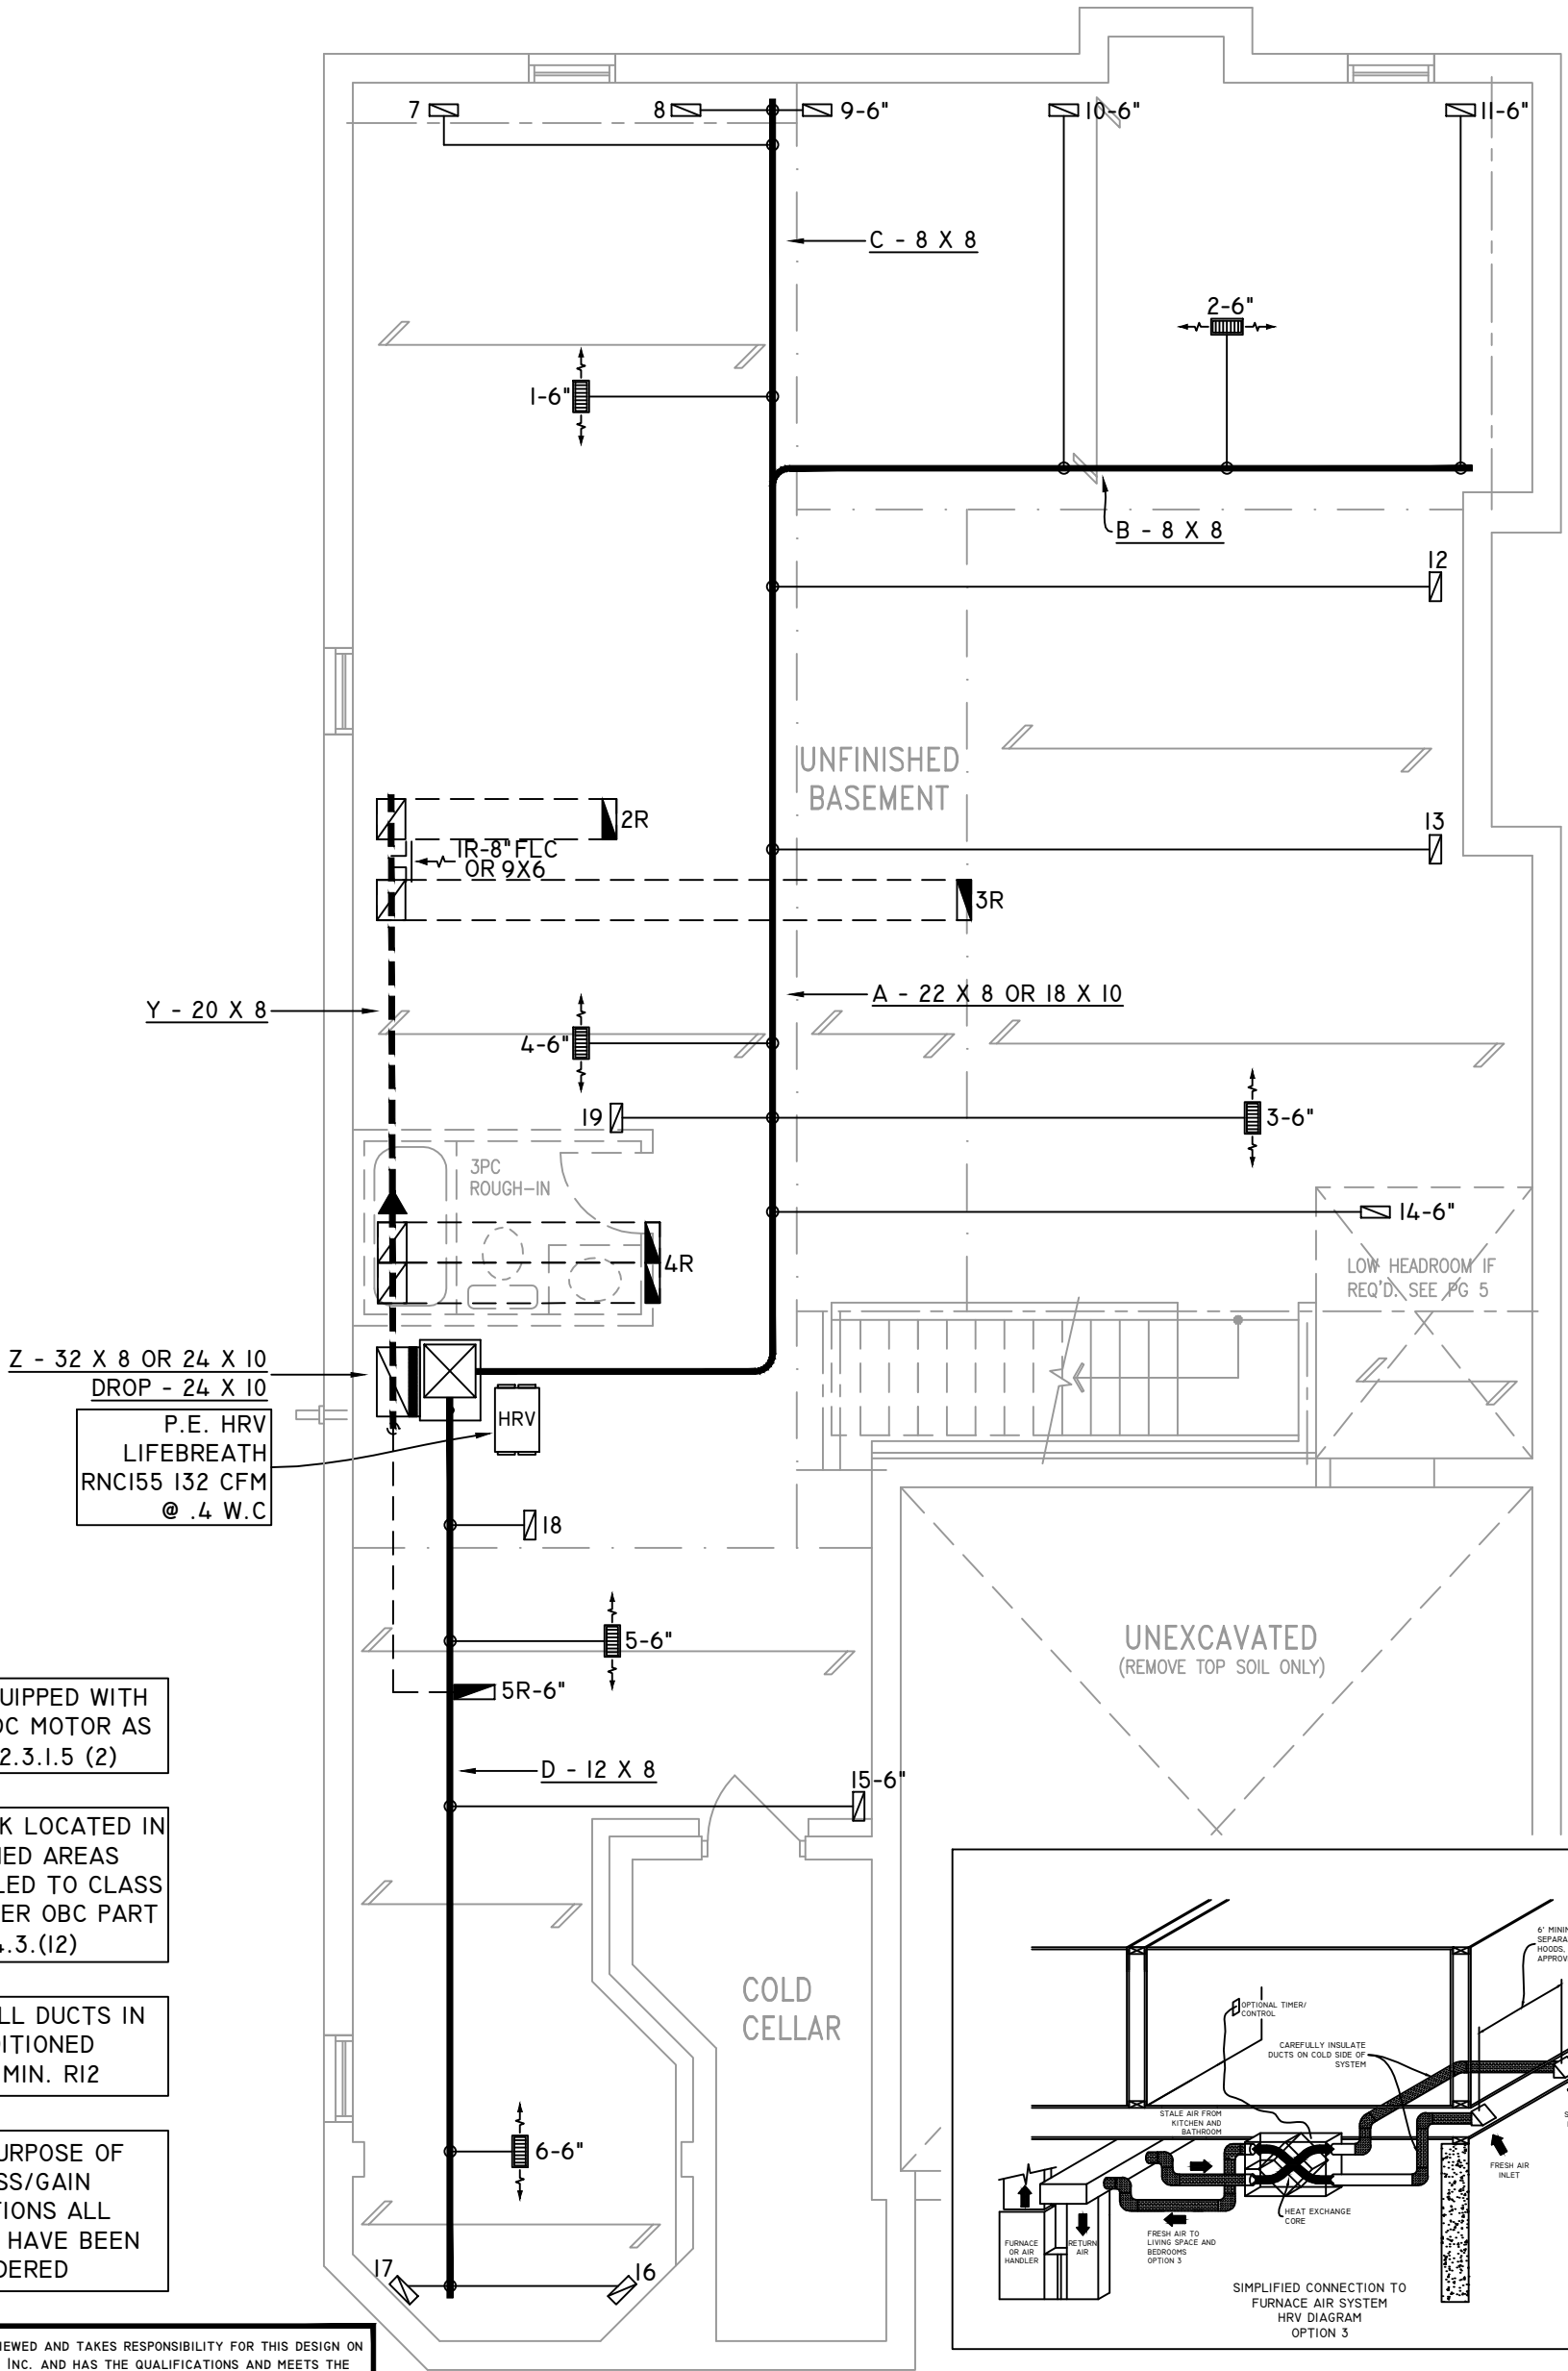

FURNACE EQUIPPED WITH
BRUSHLESS DC MOTOR AS
PER OBC 12.3.1.5 (2)

ALL DUCTWORK LOCATED IN
CONDITIONED AREAS
MUST BE SEALED TO CLASS
C LEVEL AS PER OBC PART
6-6.2.4.3.(12)

INSULATE ALL DUCTS IN
UNCONDITIONED
SPACES MIN. R12

FOR THE PURPOSE OF
HEATLOSS/GAIN
CALCULATIONS ALL
ELEVATIONS HAVE BEEN
CONSIDERED

THE UNDERSIGNED HAS REVIEWED AND TAKES RESPONSIBILITY FOR THIS DESIGN ON BEHALF OF GTA DESIGNS INC. AND HAS THE QUALIFICATIONS AND MEETS THE REQUIREMENTS SET OUT IN THE BUILDING CODE TO BE A DESIGNER

QUALIFICATION INFORMATION

REQUIRED UNLESS DESIGN IS EXEMPT UNDER DIVISION C 3.2.5.1 OF THE ONTARIO BUILDING CODE

DAVID DA COSTA  B.C.I.N. 32964

SIGNATURE OF DESIGNER

BASEMENT PLAN 'A'

OBC 2012

ZONE I COMPLIANCE
PACKAGE "A1" REF. TABLE 3.1.1.2.A

NOTES

INSTALLATION TO COMPLY WITH THE LATEST ONTARIO BUILDING CODE.

ALL SUPPLY OUTLETS TO BE 5" DIA. UNLESS OTHERWISE SPECIFIED.

PROVIDE BALANCING DAMPERS ON ALL BRANCHES.

ALL R/A PARTITIONS 6" (FIRST FLOOR ONLY)

INSULATE DUCTS IN UNCONDITIONED SPACES R12 UNDERCUT ALL DOORS 1" MIN.

CONTRACTOR MUST WORK FROM APPROVED PLANS.

ANY ALTERATIONS TO THIS ORIGINAL PLAN ARE NOT THE RESPONSIBILITY OF GTA DESIGNS.

GTA DESIGNS MUST BE CONSULTED IF KITCHEN EXHAUST FAN EXCEEDS 700 CFM DEPRESSURIZATION MAY OCCUR WITH IN THE DWELLING.




2985 DREW ROAD
SUITE 202,
MISSISSAUGA, ONT.
L4T 0A4 TEL: 905-671-9800
EMAIL: DAVE@GTADESIGNS.CA
WEB: WWW.GTADESIGNS.CA


HEAT-LOSS	38,637	BTU/HR.
UNIT MAKE	AMANA	OR EQUAL.
UNIT MODEL	AMEC960603BNA	OR EQUAL.
UNIT HEATING INPUT	60,000	BTU/HR.
UNIT HEATING OUTPUT	57,600	BTU/HR.
A/C COOLING CAPACITY	2.0	TONS.
FAN SPEED	1170	CFM

# OF RUNS	S/A	R/A	FANS
3RD FLOOR			
2ND FLOOR			
1ST FLOOR	13	4	4
BASEMENT	6	1	

FLOOR PLAN:	BASEMENT
DRAWN BY:	AM
CHECKED:	DD
LAYOUT NO.	JB-04581
SQFT	1791
DRAWING NO.	MI

 DATE:	MARCH 20, 2018
CLIENT:	BAYVIEW WELLINGTON
MODEL:	S42-IB RIDEAU I
PROJECT:	GREEN VALLEY EAST BRADFORD,ONT.
SCALE:	3/16" = 1'-0"

	FLEX DUCT		LOW/HIGH WALL/KICK SUPPLY DIFFUSER		DUCT CONNECTION TO JOIST LINING		RETURN AIR GRILLE (SIZE INDICATED ON DRAWING)	S.A.	SUPPLY AIR
	RIGID ROUND DUCT		HRV EXHAUST GRILLE		RETURN AIR PIPE RISER		RETURN AIR RISER UP TO FLOOR ABOVE	R.A.	RETURN AIR
	SUPPLY DIFFUSER		SUPPLY AIR PIPE RISER		RETURN ROUND DUCT		RETURN AIR FROM BASEMENT SECOND FLOOR		THERMOSTAT
			VOLUME DAMPER						PRINCIPAL EXHAUST FAN SWITCH
									W/R & PRINCIPAL EXHAUST FAN

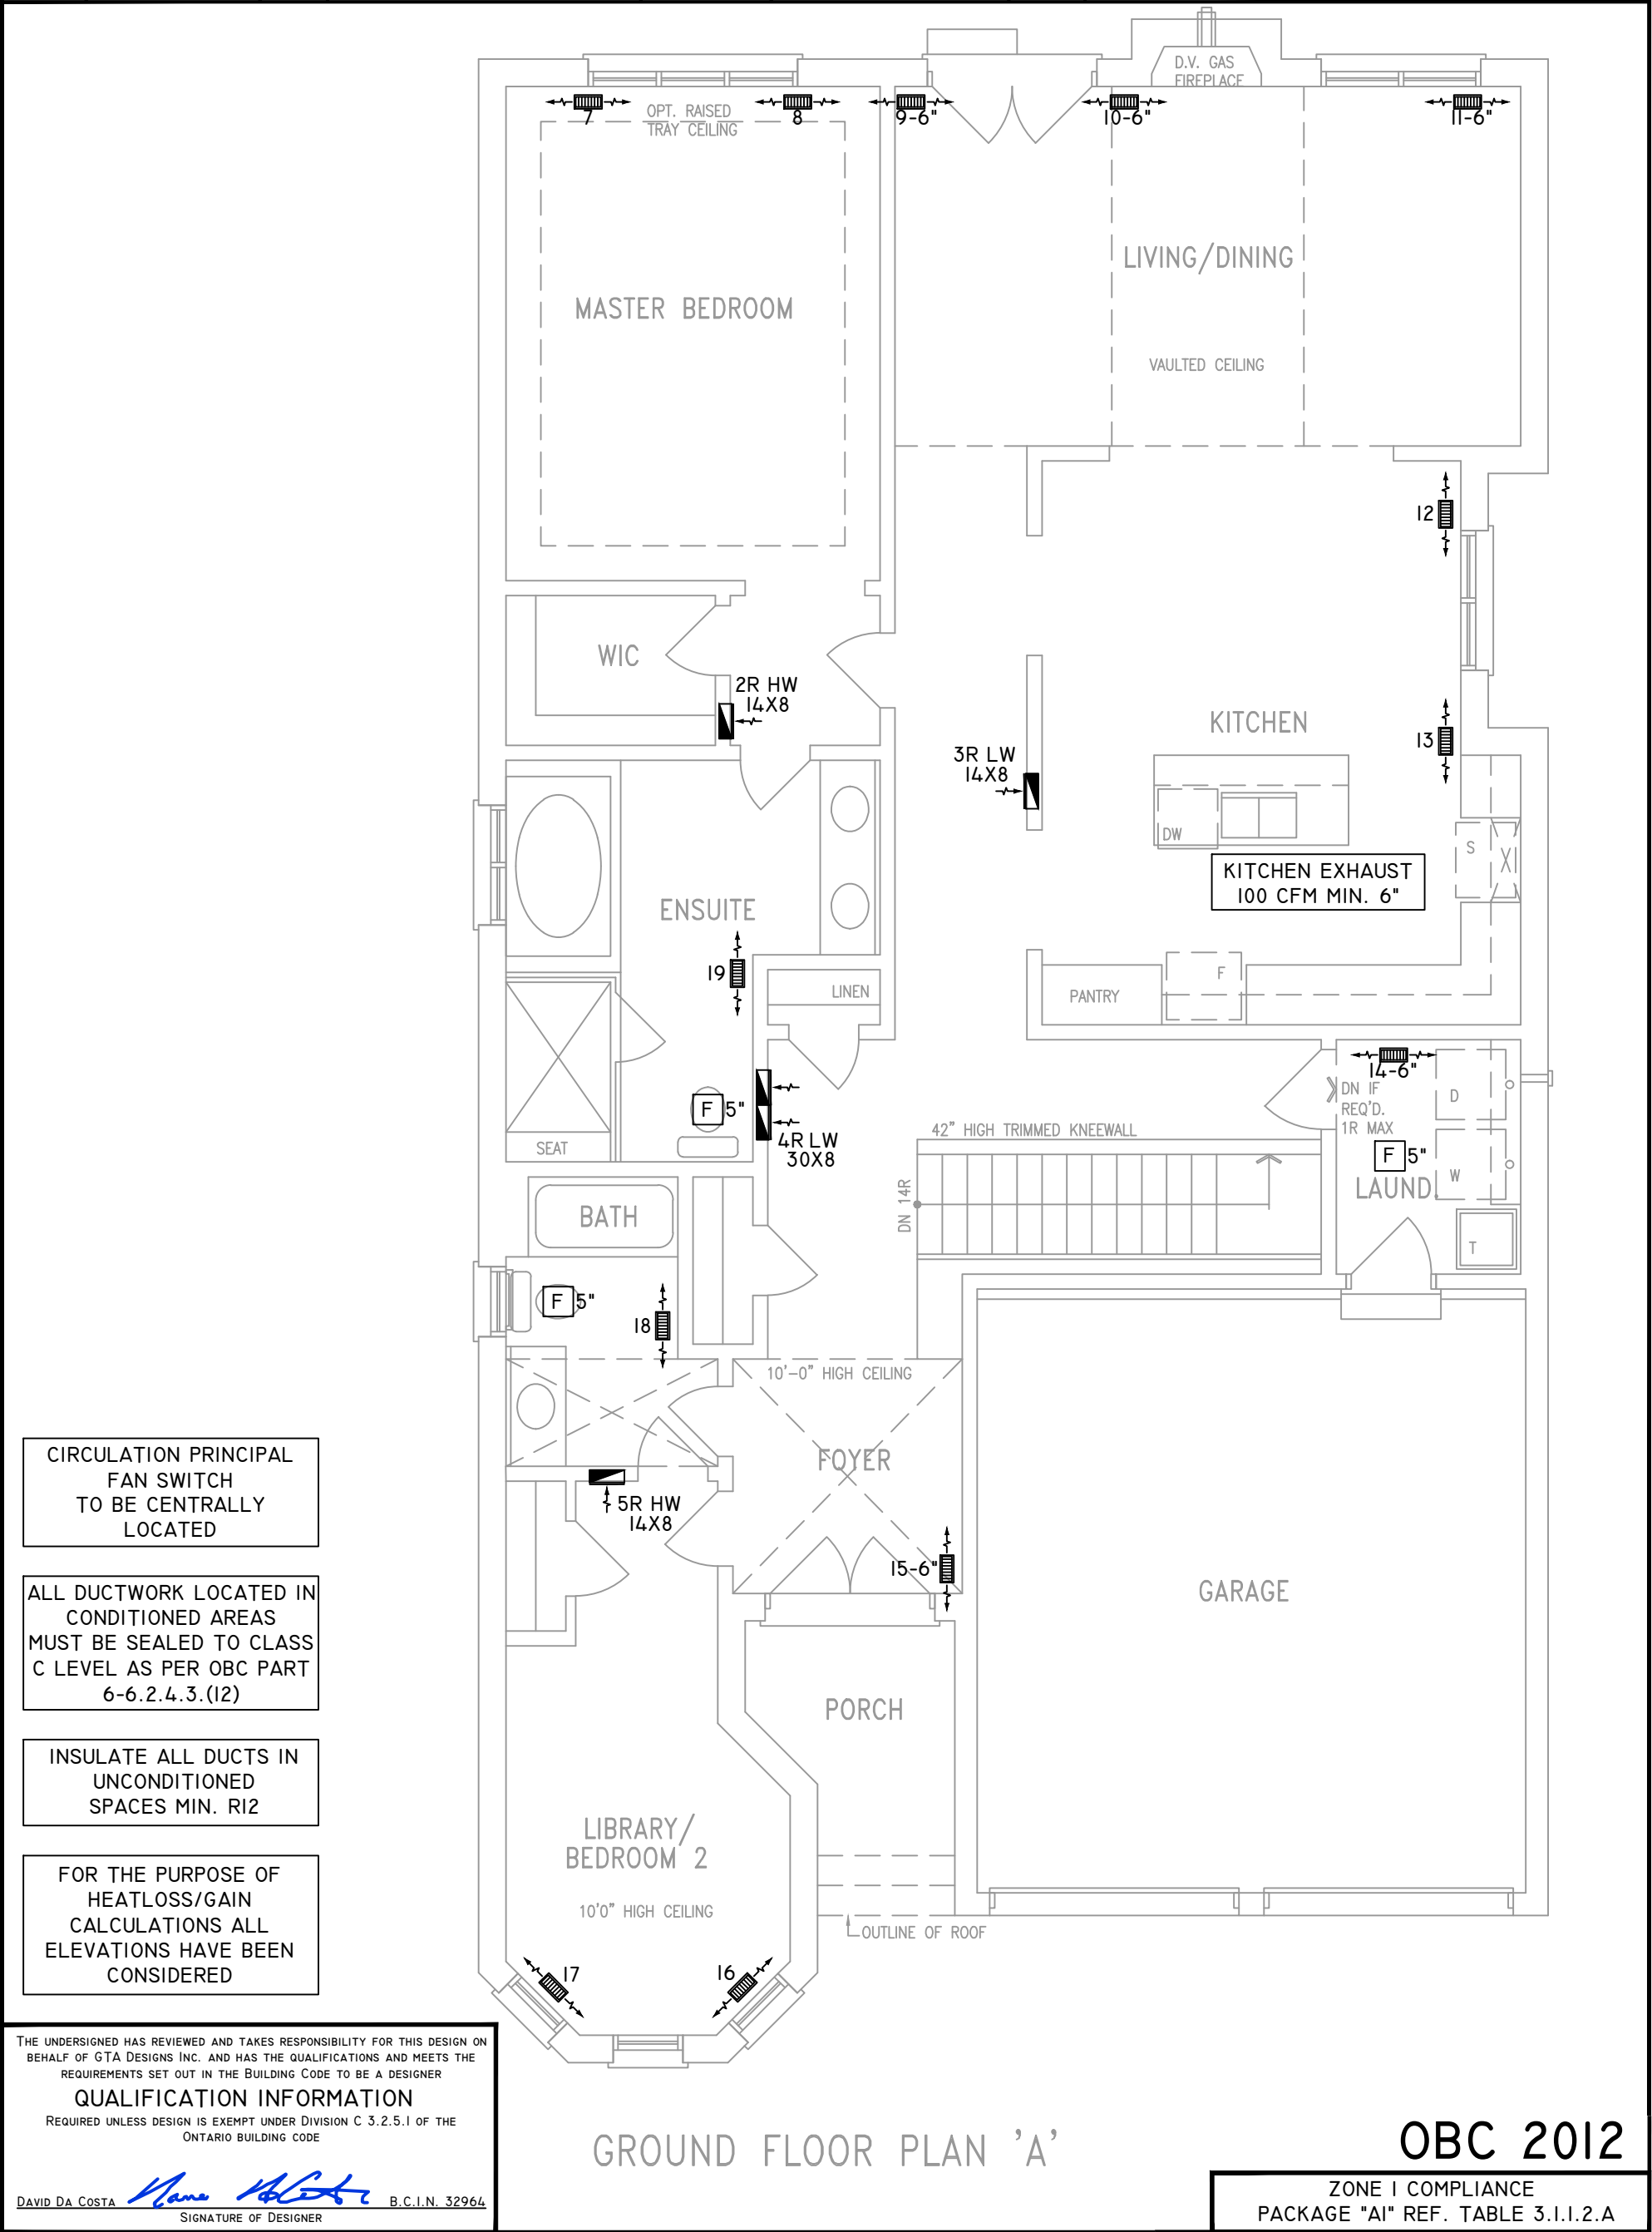

CIRCULATION PRINCIPAL FAN SWITCH TO BE CENTRALLY LOCATED

ALL DUCTWORK LOCATED IN CONDITIONED AREAS MUST BE SEALED TO CLASS C LEVEL AS PER OBC PART 6-6.2.4.3.(12)

INSULATE ALL DUCTS IN UNCONDITIONED SPACES MIN. R12

FOR THE PURPOSE OF HEATLOSS/GAIN CALCULATIONS ALL ELEVATIONS HAVE BEEN CONSIDERED

THE UNDERSIGNED HAS REVIEWED AND TAKES RESPONSIBILITY FOR THIS DESIGN ON BEHALF OF GTA DESIGNS INC. AND HAS THE QUALIFICATIONS AND MEETS THE REQUIREMENTS SET OUT IN THE BUILDING CODE TO BE A DESIGNER

QUALIFICATION INFORMATION

REQUIRED UNLESS DESIGN IS EXEMPT UNDER DIVISION C 3.2.5.1 OF THE ONTARIO BUILDING CODE

DAVID DA COSTA  B.C.I.N. 32964

SIGNATURE OF DESIGNER

NOTES
INSTALLATION TO COMPLY WITH THE LATEST ONTARIO BUILDING CODE.
ALL SUPPLY OUTLETS TO BE 5" DIA. UNLESS OTHERWISE SPECIFIED.
PROVIDE BALANCING DAMPERS ON ALL BRANCHES.
ALL R/A PARTITIONS 6" (FIRST FLOOR ONLY)
INSULATE DUCTS IN UNCONDITIONED SPACES R12 UNDERCUT ALL DOORS 1" MIN.
CONTRACTOR MUST WORK FROM APPROVED PLANS.
ANY ALTERATIONS TO THIS ORIGINAL PLAN ARE NOT THE RESPONSIBILITY OF GTA DESIGNS.
GTA DESIGNS MUST BE CONSULTED IF KITCHEN EXHAUST FAN EXCEEDS 700 CFM DEPRESSURIZATION MAY OCCUR WITH IN THE DWELLING.

**GTADESIGNS**

2985 DREW ROAD
SUITE 202,
MISSISSAUGA, ONT.
L4T 0A4 TEL: 905-671-9800
EMAIL: DAVE@GTADESIGNS.CA
WEB: WWW.GTADESIGNS.CA

HEAT-LOSS	38,637	BTU/HR.
UNIT MAKE	AMANA	OR EQUAL.
UNIT MODEL	AMEC960603BNA	OR EQUAL.
UNIT HEATING INPUT	60,000	BTU/HR.
UNIT HEATING OUTPUT	57,600	BTU/HR.
A/C COOLING CAPACITY	2.0	TONS.
FAN SPEED	1170	CFM

# OF RUNS	S/A	R/A	FANS
3RD FLOOR			
2ND FLOOR			
1ST FLOOR	13	4	4
BASEMENT	6	1	



FLOOR PLAN: GROUND FLOOR	
DRAWN BY: AM	CHECKED: DD
LAYOUT NO. JB-04581	SQFT 1791
	DRAWING NO. M2


DATE:	MARCH 20, 2018
CLIENT:	BAYVIEW WELLINGTON
MODEL:	S42-1B RIDEAU I
PROJECT:	GREEN VALLEY EAST BRADFORD,ONT.
SCALE:	3/16" = 1'-0"

OBC 2012

ZONE I COMPLIANCE
PACKAGE "A1" REF. TABLE 3.1.1.2.A

  
GROUND FLOOR PLAN 'A'

	FLEX DUCT		LOW/HIGH WALL/KICK SUPPLY DIFFUSER		DUCT CONNECTION TO JOIST LINING		RETURN AIR GRILLE (SIZE INDICATED ON DRAWING)	S.A.	SUPPLY AIR
	RIGID ROUND DUCT		HRV EXHAUST GRILLE		RETURN AIR PIPE RISER		RETURN AIR RISER UP TO FLOOR ABOVE	R.A.	RETURN AIR
	SUPPLY DIFFUSER		SUPPLY AIR PIPE RISER		RETURN ROUND DUCT		RETURN AIR FROM BASEMENT SECOND FLOOR		THERMOSTAT
			VOLUME DAMPER						PRINCIPAL EXHAUST FAN SWITCH W/R & PRINCIPAL EXHAUST FAN

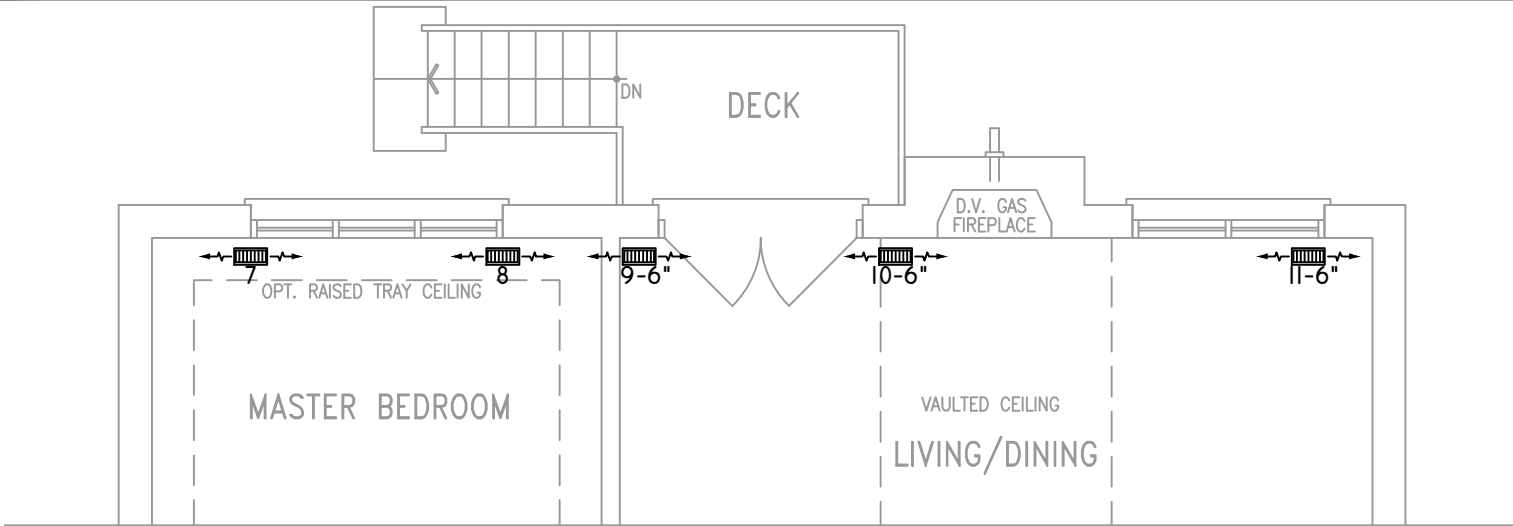


PART GROUND FLOOR PLAN 'A' - W.O.D. CONDITION

ELEVS 'B' & 'C' SIMILAR

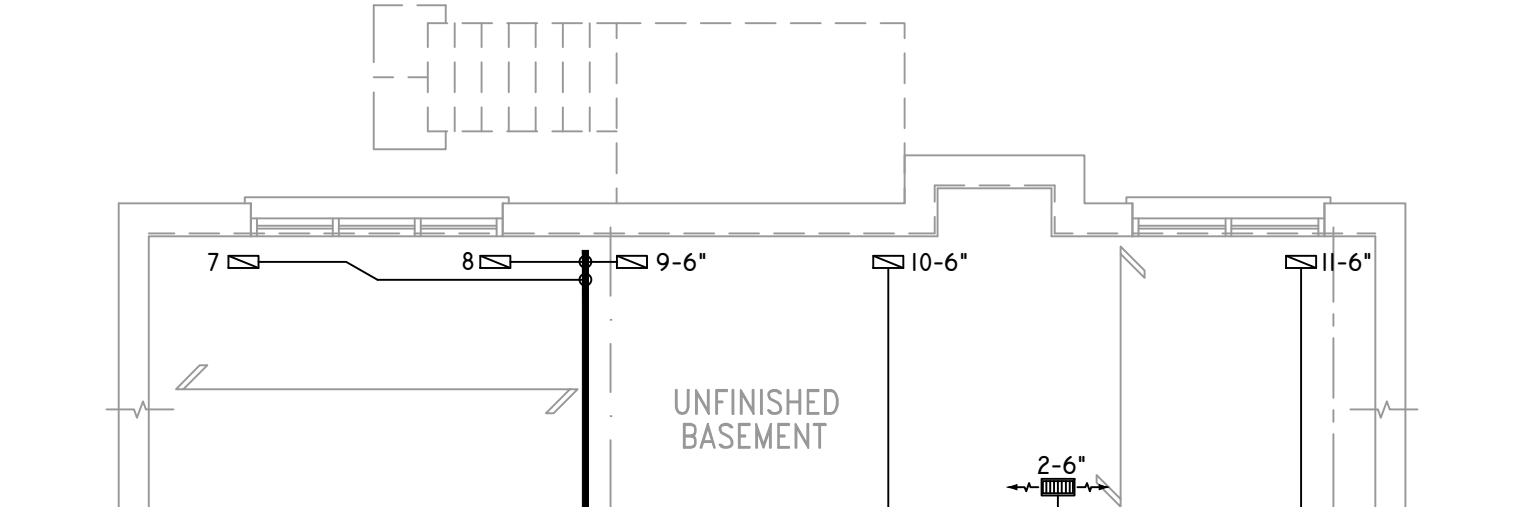


PART. BASEMENT PLAN 'A' - W.O.D. CONDITION

ELEVS 'B' & 'C' SIMILAR

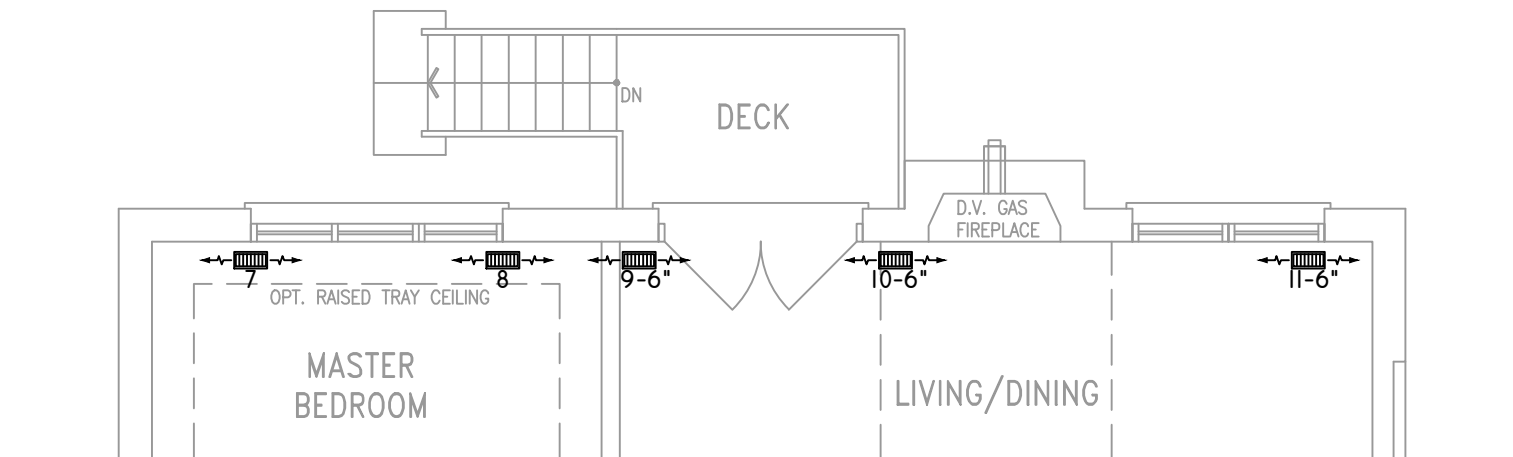

PARTIAL GROUND FLOOR PLAN ELEVATION 'C'
REAR UPGRADE WOD COND.

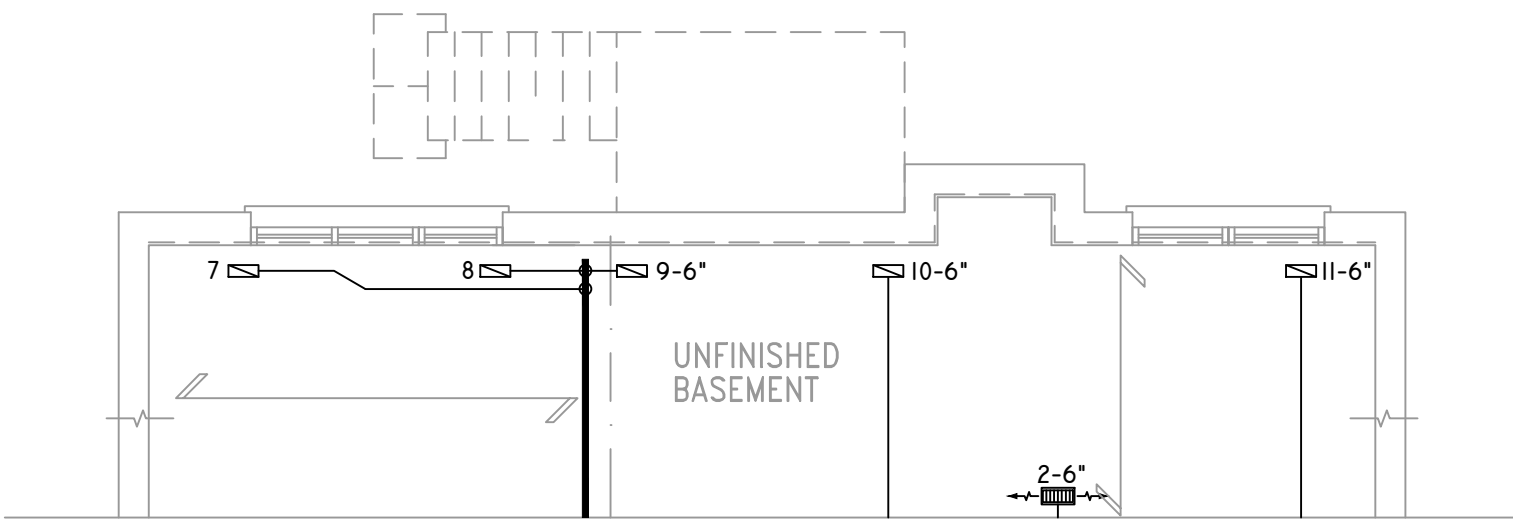

PART. BASEMENT PLAN ELEVATION 'C'
REAR UPG W.O.D. CONDITION

THE UNDERSIGNED HAS REVIEWED AND TAKES RESPONSIBILITY FOR THIS DESIGN ON BEHALF OF GTA DESIGNS INC. AND HAS THE QUALIFICATIONS AND MEETS THE REQUIREMENTS SET OUT IN THE BUILDING CODE TO BE A DESIGNER

QUALIFICATION INFORMATION

REQUIRED UNLESS DESIGN IS EXEMPT UNDER DIVISION C 3.2.5.1 OF THE ONTARIO BUILDING CODE

DAVID DA COSTA  B.C.I.N. 32964

SIGNATURE OF DESIGNER

OBC 2012

ZONE I COMPLIANCE
PACKAGE "A1" REF. TABLE 3.1.1.2.A

NOTES
INSTALLATION TO COMPLY WITH THE LATEST ONTARIO BUILDING CODE.
ALL SUPPLY OUTLETS TO BE 5" DIA. UNLESS OTHERWISE SPECIFIED.
PROVIDE BALANCING DAMPERS ON ALL BRANCHES.
ALL R/A PARTITIONS 6" (FIRST FLOOR ONLY)
INSULATE DUCTS IN UNCONDITIONED SPACES R12 UNDERCUT ALL DOORS 1" MIN.
CONTRACTOR MUST WORK FROM APPROVED PLANS.
ANY ALTERATIONS TO THIS ORIGINAL PLAN ARE NOT THE RESPONSIBILITY OF GTA DESIGNS.
GTA DESIGNS MUST BE CONSULTED IF KITCHEN EXHAUST FAN EXCEEDS 700 CFM DEPRESSURIZATION MAY OCCUR WITH IN THE DWELLING.




2985 DREW ROAD
SUITE 202,
MISSISSAUGA, ONT.
L4T 0A4 TEL: 905-671-9800
EMAIL: DAVE@GTADESIGNS.CA
WEB: WWW.GTADESIGNS.CA


HEAT-LOSS	38,637	BTU/HR.
UNIT MAKE	AMANA	OR EQUAL.
UNIT MODEL	AMEC960603BNA	OR EQUAL.
UNIT HEATING INPUT	60,000	BTU/HR.
UNIT HEATING OUTPUT	57,600	BTU/HR.
A/C COOLING CAPACITY	2.0	TONS.
FAN SPEED	1170	CFM

# OF RUNS	S/A	R/A	FANS
3RD FLOOR			
2ND FLOOR			
1ST FLOOR	13	4	4
BASEMENT	6	1	


FLOOR PLAN: PARTIAL PLAN(S)	
DRAWN BY: AM	CHECKED: DD
LAYOUT NO. JB-04581	SQFT 1791
DRAWING NO. M3	

 DATE:	MARCH 20, 2018
CLIENT:	BAYVIEW WELLINGTON
MODEL:	S42-1B RIDEAU I
PROJECT:	GREEN VALLEY EAST BRADFORD,ONT.
SCALE:	3/16" = 1'-0"

	FLEX DUCT		LOW/HIGH WALL/KICK SUPPLY DIFFUSER		DUCT CONNECTION TO JOIST LINING		RETURN AIR GRILLE (SIZE INDICATED ON DRAWING)	S.A.	SUPPLY AIR
	RIGID ROUND DUCT		HRV EXHAUST GRILLE		RETURN AIR PIPE RISER		RETURN AIR RISER UP TO FLOOR ABOVE	R.A.	RETURN AIR
	SUPPLY DIFFUSER		SUPPLY AIR PIPE RISER		RETURN ROUND DUCT		RETURN AIR FROM BASEMENT SECOND FLOOR		THERMOSTAT
			VOLUME DAMPER						PRINCIPAL EXHAUST FAN SWITCH
									W/R & PRINCIPAL EXHAUST FAN

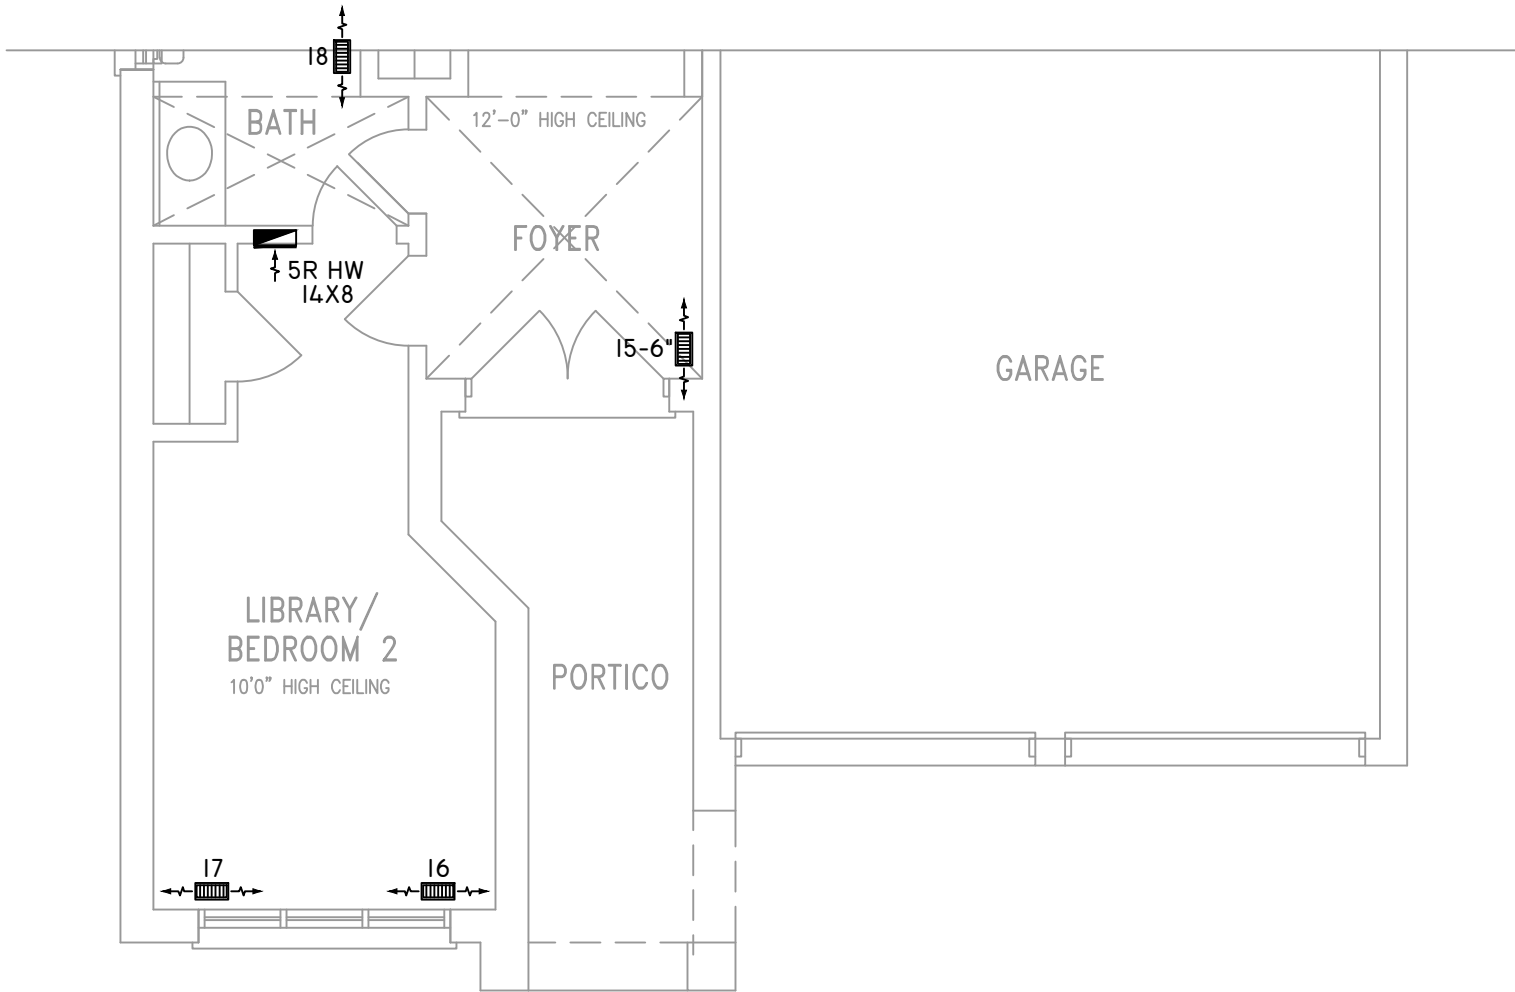

PART. GROUND FLOOR PLAN 'B'

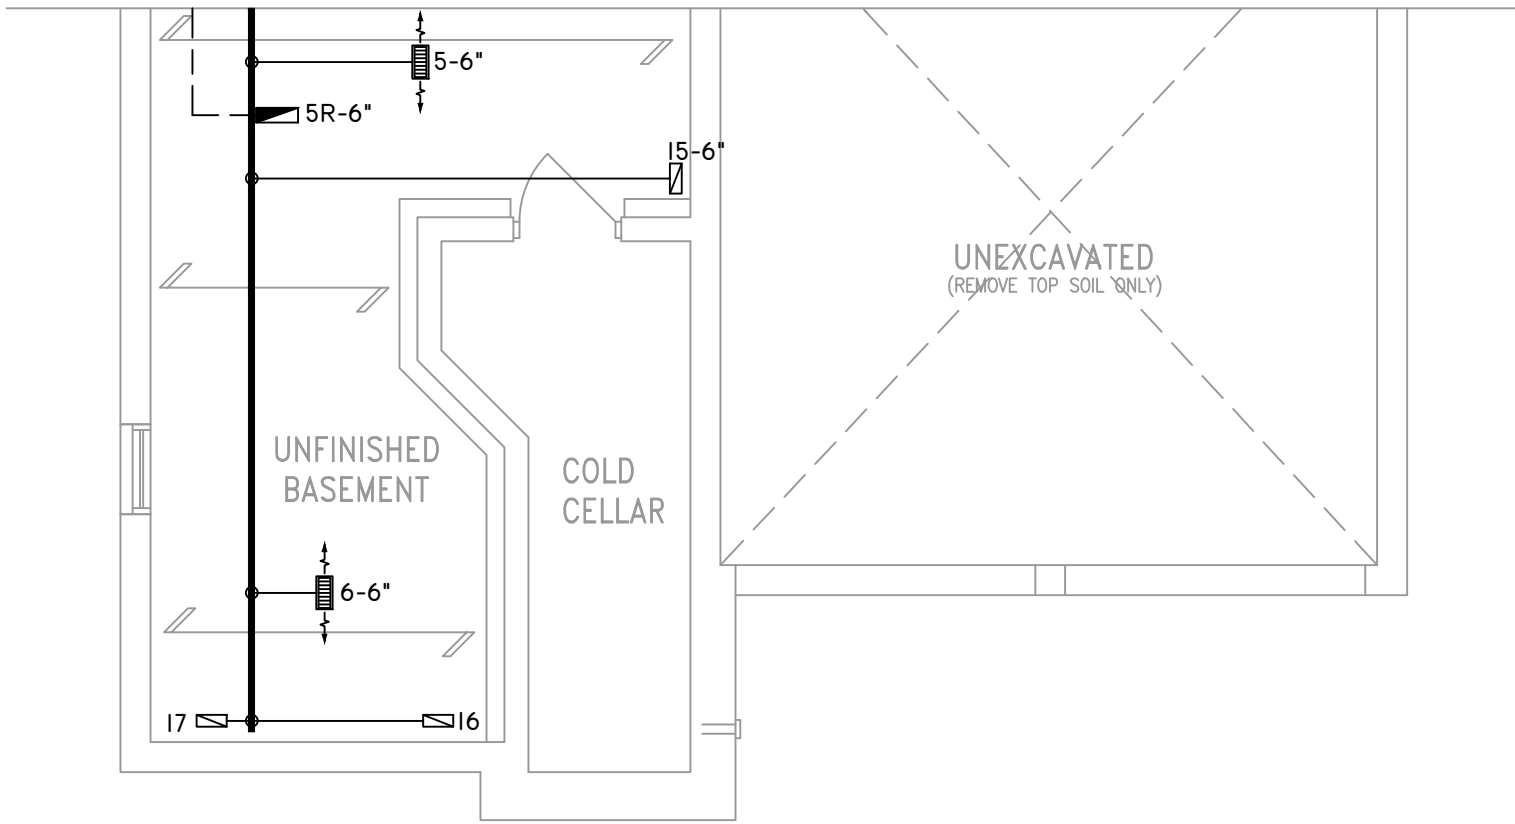

PART. BASEMENT PLAN 'B'

THE UNDERSIGNED HAS REVIEWED AND TAKES RESPONSIBILITY FOR THIS DESIGN ON BEHALF OF GTA DESIGNS INC. AND HAS THE QUALIFICATIONS AND MEETS THE REQUIREMENTS SET OUT IN THE BUILDING CODE TO BE A DESIGNER

QUALIFICATION INFORMATION

REQUIRED UNLESS DESIGN IS EXEMPT UNDER DIVISION C 3.2.5.1 OF THE ONTARIO BUILDING CODE

DAVID DA COSTA  B.C.I.N. 32964
SIGNATURE OF DESIGNER

OBC 2012

ZONE I COMPLIANCE
PACKAGE "A1" REF. TABLE 3.1.1.2.A

NOTES

INSTALLATION TO COMPLY WITH THE LATEST ONTARIO BUILDING CODE.

ALL SUPPLY OUTLETS TO BE 5" DIA. UNLESS OTHERWISE SPECIFIED.

PROVIDE BALANCING DAMPERS ON ALL BRANCHES.

ALL R/A PARTITIONS 6" (FIRST FLOOR ONLY)

INSULATE DUCTS IN UNCONDITIONED SPACES R12 UNDERCUT ALL DOORS 1" MIN.

CONTRACTOR MUST WORK FROM APPROVED PLANS.

ANY ALTERATIONS TO THIS ORIGINAL PLAN ARE NOT THE RESPONSIBILITY OF GTA DESIGNS.

GTA DESIGNS MUST BE CONSULTED IF KITCHEN EXHAUST FAN EXCEEDS 700 CFM DEPRESSURIZATION MAY OCCUR WITH IN THE DWELLING.




2985 DREW ROAD
SUITE 202,
MISSISSAUGA, ONT.
L4T 0A4 TEL: 905-671-9800
EMAIL: DAVE@GTADESIGNS.CA
WEB: WWW.GTADESIGNS.CA


HEAT-LOSS	38,637	BTU/HR.
UNIT MAKE	AMANA	OR EQUAL.
UNIT MODEL	AMEC960603BNA	OR EQUAL.
UNIT HEATING INPUT	60,000	BTU/HR.
UNIT HEATING OUTPUT	57,600	BTU/HR.
A/C COOLING CAPACITY	2.0	TONS.
FAN SPEED	1170	CFM

# OF RUNS	S/A	R/A	FANS
3RD FLOOR			
2ND FLOOR			
1ST FLOOR	13	4	4
BASEMENT	6	1	


FLOOR PLAN: PARTIAL PLAN(S)	
DRAWN BY: AM	CHECKED: DD
LAYOUT NO. JB-04581	SQFT 1791
DRAWING NO. M4	

 DATE:	MARCH 20, 2018
CLIENT:	BAYVIEW WELLINGTON
MODEL:	S42-1B RIDEAU I
PROJECT:	GREEN VALLEY EAST BRADFORD,ONT.
SCALE:	3/16" = 1'-0"

	FLEX DUCT		LOW/HIGH WALL/KICK SUPPLY DIFFUSER		DUCT CONNECTION TO JOIST LINING		RETURN AIR GRILLE (SIZE INDICATED ON DRAWING)	S.A.	SUPPLY AIR
	RIGID ROUND DUCT		HRV EXHAUST GRILLE		RETURN AIR PIPE RISER		RETURN AIR RISER UP TO FLOOR ABOVE	R.A.	RETURN AIR
	SUPPLY DIFFUSER		SUPPLY AIR PIPE RISER		RETURN ROUND DUCT		RETURN AIR FROM BASEMENT SECOND FLOOR		THERMOSTAT
			VOLUME DAMPER						PRINCIPAL EXHAUST FAN SWITCH
									W/R & PRINCIPAL EXHAUST FAN

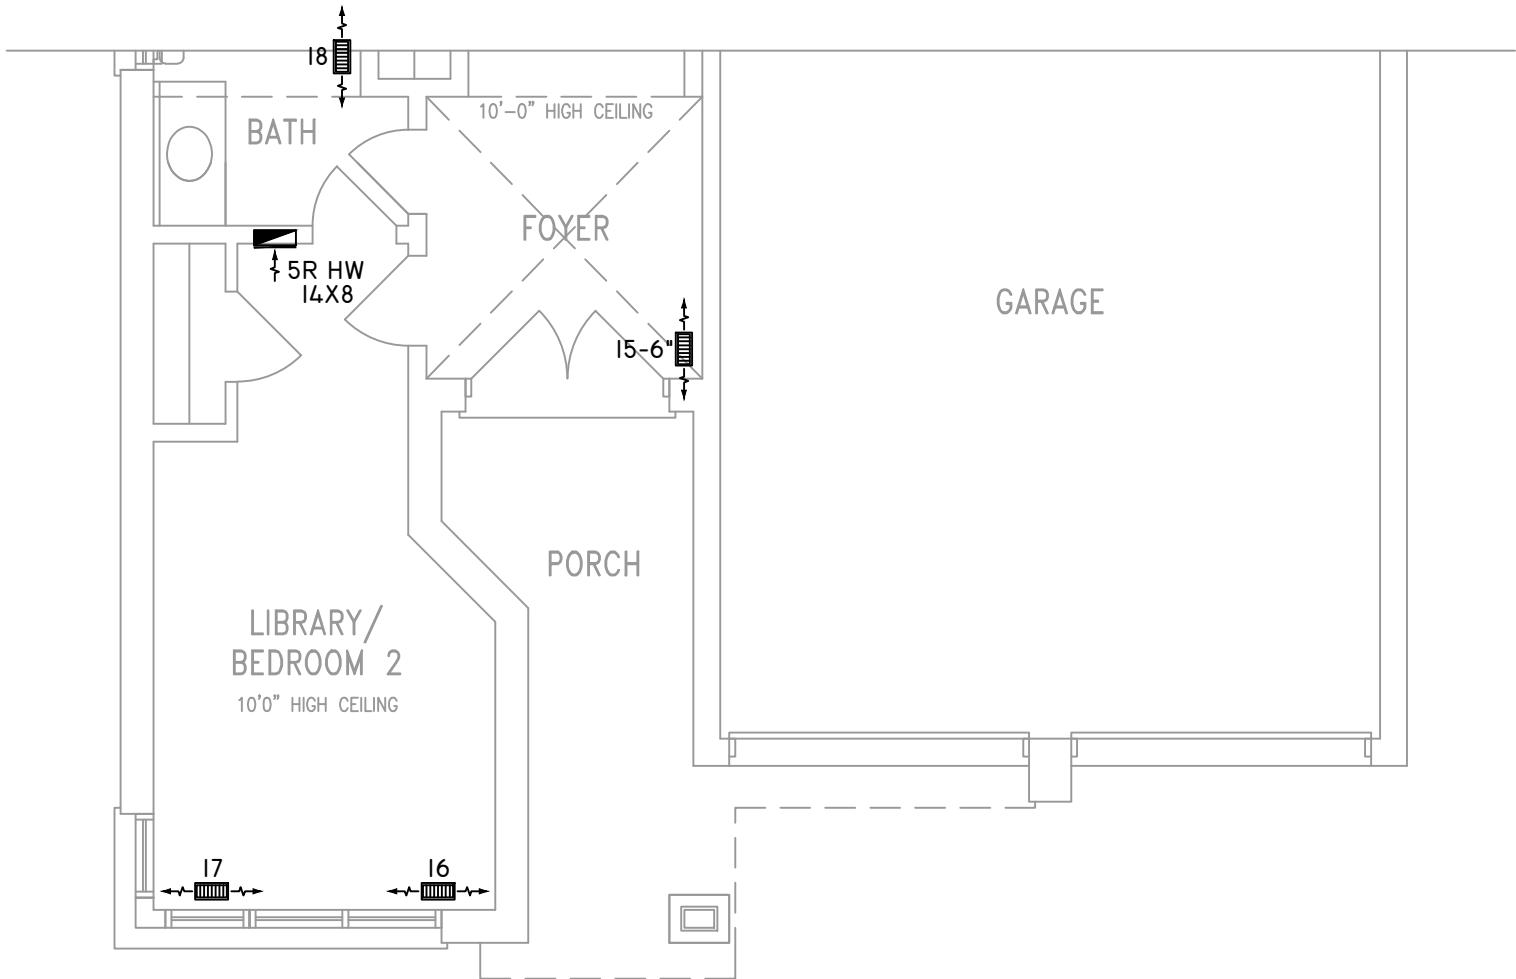

PART. GROUND FLOOR PLAN 'C'

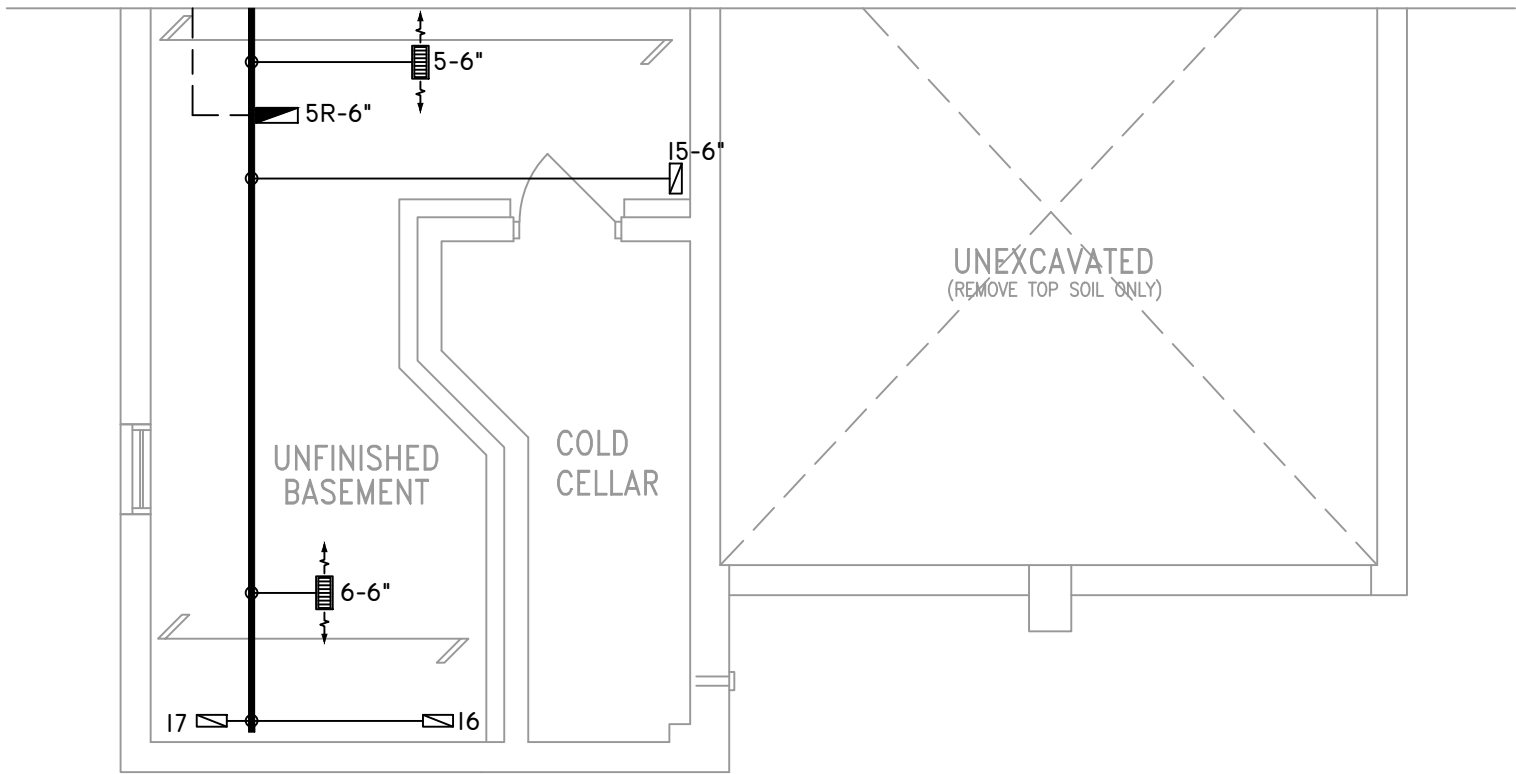

PART. BASEMENT PLAN 'C'

THE UNDERSIGNED HAS REVIEWED AND TAKES RESPONSIBILITY FOR THIS DESIGN ON BEHALF OF GTA DESIGNS INC. AND HAS THE QUALIFICATIONS AND MEETS THE REQUIREMENTS SET OUT IN THE BUILDING CODE TO BE A DESIGNER

QUALIFICATION INFORMATION

REQUIRED UNLESS DESIGN IS EXEMPT UNDER DIVISION C 3.2.5.1 OF THE ONTARIO BUILDING CODE

DAVID DA COSTA  B.C.I.N. 32964

SIGNATURE OF DESIGNER

OBC 2012

ZONE I COMPLIANCE
PACKAGE "A1" REF. TABLE 3.1.1.2.A

NOTES

INSTALLATION TO COMPLY WITH THE LATEST ONTARIO BUILDING CODE.

ALL SUPPLY OUTLETS TO BE 5" DIA. UNLESS OTHERWISE SPECIFIED.

PROVIDE BALANCING DAMPERS ON ALL BRANCHES.

ALL R/A PARTITIONS 6" (FIRST FLOOR ONLY)

INSULATE DUCTS IN UNCONDITIONED SPACES R12 UNDERCUT ALL DOORS 1" MIN.

CONTRACTOR MUST WORK FROM APPROVED PLANS.

ANY ALTERATIONS TO THIS ORIGINAL PLAN ARE NOT THE RESPONSIBILITY OF GTA DESIGNS.

GTA DESIGNS MUST BE CONSULTED IF KITCHEN EXHAUST FAN EXCEEDS 700 CFM DEPRESSURIZATION MAY OCCUR WITH IN THE DWELLING.




2985 DREW ROAD
SUITE 202,
MISSISSAUGA, ONT.
L4T 0A4 TEL: 905-671-9800
EMAIL: DAVE@GTADESIGNS.CA
WEB: WWW.GTADESIGNS.CA


HEAT-LOSS	38,637	BTU/HR.
UNIT MAKE	AMANA	OR EQUAL.
UNIT MODEL	AMEC960603BNA	OR EQUAL.
UNIT HEATING INPUT	60,000	BTU/HR.
UNIT HEATING OUTPUT	57,600	BTU/HR.
A/C COOLING CAPACITY	2.0	TONS.
FAN SPEED	1170	CFM

# OF RUNS	S/A	R/A	FANS
3RD FLOOR			
2ND FLOOR			
1ST FLOOR	13	4	4
BASEMENT	6	1	


FLOOR PLAN:	
PARTIAL PLAN(S)	
DRAWN BY:	CHECKED:
AM	DD
LAYOUT NO.	DRAWING NO.
JB-04581	M5

 DATE:	MARCH 20, 2018
CLIENT:	BAYVIEW WELLINGTON
MODEL:	S42-1B RIDEAU I
PROJECT:	GREEN VALLEY EAST BRADFORD,ONT.
SCALE:	3/16" = 1'-0"

	FLEX DUCT		LOW/HIGH WALL/KICK SUPPLY DIFFUSER		DUCT CONNECTION TO JOIST LINING		RETURN AIR GRILLE (SIZE INDICATED ON DRAWING)	S.A.	SUPPLY AIR
	RIGID ROUND DUCT		HRV EXHAUST GRILLE		RETURN AIR PIPE RISER		RETURN AIR RISER UP TO FLOOR ABOVE	R.A.	RETURN AIR
	SUPPLY DIFFUSER		SUPPLY AIR PIPE RISER		RETURN ROUND DUCT		RETURN AIR FROM BASEMENT SECOND FLOOR		THERMOSTAT
			VOLUME DAMPER						PRINCIPAL EXHAUST FAN SWITCH
									W/R & PRINCIPAL EXHAUST FAN

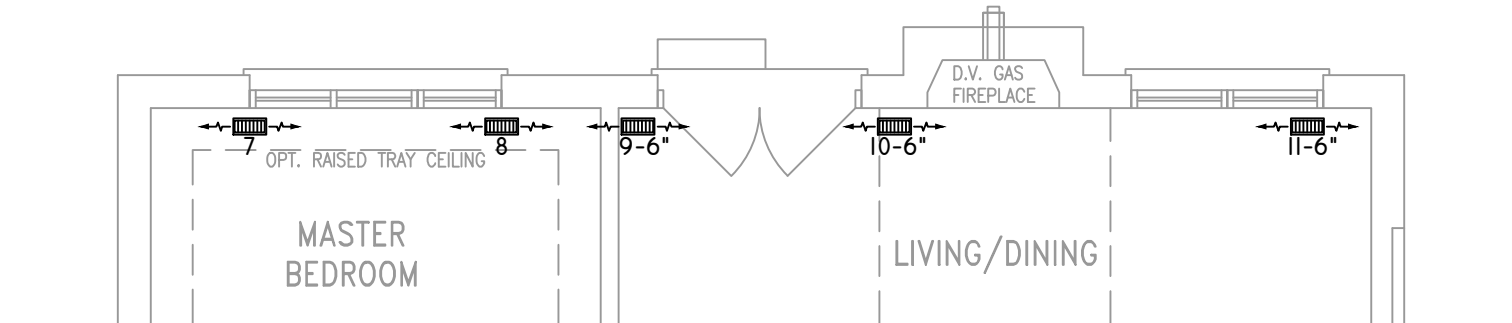

PARTIAL GROUND FLOOR PLAN ELEVATION 'C' REAR UPGRADE

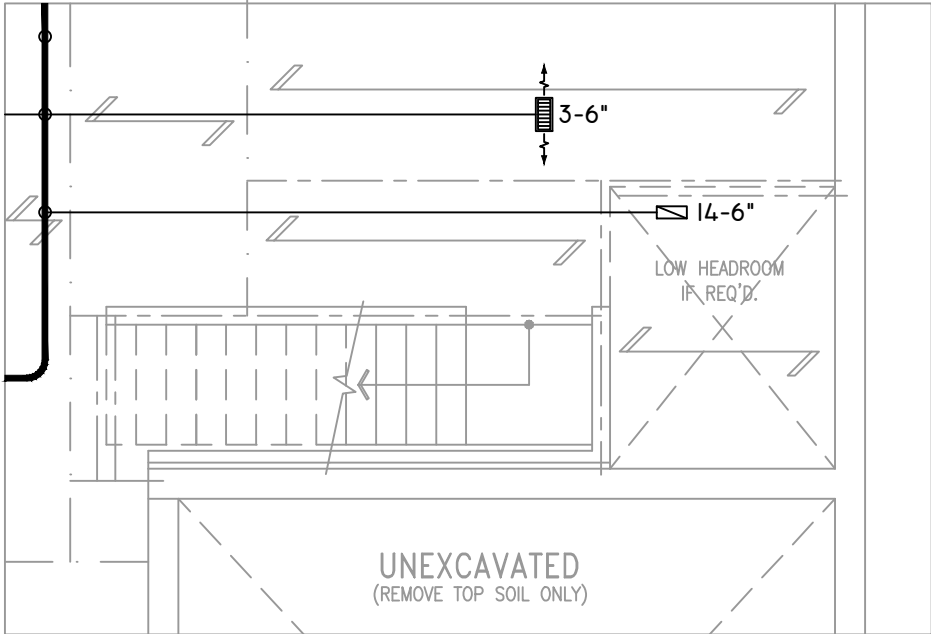

PARTIAL BASEMENT PLAN
W/ 1R SUNKEN MUD AREA ABOVE

THE UNDERSIGNED HAS REVIEWED AND TAKES RESPONSIBILITY FOR THIS DESIGN ON BEHALF OF GTA DESIGNS INC. AND HAS THE QUALIFICATIONS AND MEETS THE REQUIREMENTS SET OUT IN THE BUILDING CODE TO BE A DESIGNER

QUALIFICATION INFORMATION

REQUIRED UNLESS DESIGN IS EXEMPT UNDER DIVISION C 3.2.5.1 OF THE ONTARIO BUILDING CODE

DAVID DA COSTA



B.C.I.N. 32964

SIGNATURE OF DESIGNER

OBC 2012

ZONE I COMPLIANCE
PACKAGE "A1" REF. TABLE 3.1.1.2.A

NOTES
INSTALLATION TO COMPLY WITH THE LATEST ONTARIO BUILDING CODE.
ALL SUPPLY OUTLETS TO BE 5" DIA. UNLESS OTHERWISE SPECIFIED.
PROVIDE BALANCING DAMPERS ON ALL BRANCHES.
ALL R/A PARTITIONS 6" (FIRST FLOOR ONLY)
INSULATE DUCTS IN UNCONDITIONED SPACES R12 UNDERCUT ALL DOORS 1" MIN.
CONTRACTOR MUST WORK FROM APPROVED PLANS.
ANY ALTERATIONS TO THIS ORIGINAL PLAN ARE NOT THE RESPONSIBILITY OF GTA DESIGNS.
GTA DESIGNS MUST BE CONSULTED IF KITCHEN EXHAUST FAN EXCEEDS 700 CFM DEPRESSURIZATION MAY OCCUR WITH IN THE DWELLING.



2985 DREW ROAD
SUITE 202,
MISSISSAUGA, ONT.
L4T 0A4 TEL: 905-671-9800
EMAIL: DAVE@GTADESIGNS.CA
WEB: WWW.GTADESIGNS.CA

HEAT-LOSS	38,637	BTU/HR.
UNIT MAKE	AMANA	OR EQUAL.
UNIT MODEL	AMEC960603BNA	OR EQUAL.
UNIT HEATING INPUT	60,000	BTU/HR.
UNIT HEATING OUTPUT	57,600	BTU/HR.
A/C COOLING CAPACITY	2.0	TONS.
FAN SPEED	1170	CFM

# OF RUNS	S/A	R/A	FANS
3RD FLOOR			
2ND FLOOR			
1ST FLOOR	13	4	4
BASEMENT	6	1	

FLOOR PLAN:	
PARTIAL PLAN(S)	
DRAWN BY: AM	CHECKED: DD
LAYOUT NO. JB-04581	DRAWING NO. M6

DATE:	MARCH 20, 2018
CLIENT:	BAYVIEW WELLINGTON
MODEL:	S42-1B RIDEAU I
PROJECT:	GREEN VALLEY EAST BRADFORD,ONT.
SCALE:	3/16" = 1'-0"