

Use one form for each individual who reviews and takes responsibility for design activities with respect to the project.

A. Project Information					
Building number, street name Rideau 5 S42-5				Lot: Lot/con.	
Municipality Bradford		Postal code	Plan number/ other description		
B. Individual who reviews and takes responsibility for design activities					
Name David DaCosta			Firm gtaDesigns Inc.		
Street address 2985 Drew Road, Suite 202				Unit no.	Lot/con.
Municipality Mississauga		Postal code L4T 0A4	Province Ontario	E-mail dave@gtadesigns.ca	
Telephone number (905) 671-9800		Fax number (647) 494-9643		Cell number (416) 268-6820	
C. Design activities undertaken by individual identified in Section B. [Building Code Table 3.5.2.1 of Division C]					
☐ House ☐ Small Buildings ☐ Large Buildings ☐ Complex Buildings		☒ HVAC – House ☐ Building Services ☐ Detection, Lighting and Power ☐ Fire Protection		☐ Building Structural ☐ Plumbing – House ☐ Plumbing – All Buildings ☐ On-site Sewage Systems	
Description of designer's work				Model Certification	
				Project #:	PJ-00204
				Layout #:	JB-04587
Heating and Cooling Load Calculations		Main	X	Builder	Bayview Wellington
Air System Design		Alternate		Project	Green Valley East
Residential mechanical ventilation Design Summary		Area Sq ft:	3330	Model	Rideau 5 S42-5
Residential System Design per CAN/CSA-F280-12				SB-12	Package A1
Residential New Construction - Forced Air					
D. Declaration of Designer					
I, <u>David DaCosta</u> declare that (choose one as appropriate): (print name) ☐ I review and take responsibility for the design work on behalf of a firm registered under subsection 3.2.4 Division C of the Building Code. I am qualified, and the firm is registered, in the appropriate classes/categories. Individual BCIN: _____ Firm BCIN: _____ ☒ I review and take responsibility for the design and am qualified in the appropriate category as an "other designer" under subsection 3.2.5 of Division C, of the Building Code. Individual BCIN: <u>32964</u> Basis for exemption from registration: <u>Division C 3.2.4.1. (4)</u> ☐ The design work is exempt from the registration and qualification requirements of the Building Code. Basis for exemption from registration and qualification:					
I certify that: 1. The information contained in this schedule is true to the best of my knowledge. 2. I have submitted this application with the knowledge and consent of the firm.					
<u>April 3, 2018</u> Date			 Signature of Designer		

NOTE:

- For the purposes of this form, "individual" means the "person" referred to in Clause 3.2.4.7(1) d), of Division C, Article 3.2.5.1. of Division C and all other persons who are exempt from qualifications under Subsections 3.2.4 . and 3.2.5. of Division C.
- Schedule 1 does not require to be completed a holder of a license, temporary license, or a certificate of authorization, issued by the Ontario Association of Architects. Schedule 1 is also not required to be completed by a holder of a license to practise, a limited licence to practise, or a certificate of authorization, issued by the Association of Professional Engineers of Ontario.

Heat loss and gain calculation summary sheet				CSA-F280-M12 Standard Form No. 1	
These documents issued for the use of Bayview Wellington				Layout No.	
and may not be used by any other persons without authorization. Documents for permit and/or construction are signed in red.				JB-04587	
Building Location					
Address (Model): S42-5			Site: Green Valley East		
Model: Rideau 5			Lot:		
City and Province: Bradford			Postal code:		
Calculations based on					
Dimensional information based on:			VA3 Design Jan/2018		
Attachment: Detached			Front facing: East/West		Assumed? Yes
No. of Levels: 3		Ventilated? Included	Air tightness: 1961-Present (ACH=3.57)		Assumed? Yes
Weather location: Bradford			Wind exposure: Sheltered		
HRV? LifeBreath		RNC155	Internal shading: Light-translucent		Occupants: 5
Sensible Eff. at -25C 71%		Apparent Effect. at -0C 84%	Units: Imperial		Area Sq ft: 3330
Sensible Eff. at -0C 75%					
Heating design conditions			Cooling design conditions		
Outdoor temp -9.4 Indoor temp: 72 Mean soil temp: 48			Outdoor temp 86 Indoor temp: 75 Latitude: 44		
Above grade walls			Below grade walls		
Style A: As per OBC SB12 Package A1 R 22			Style A: As per OBC SB12 Package A1 R 20ci		
Style B: Existing Walls (When Applicable) R 12			Style B:		
Style C:			Style C:		
Style D:			Style D:		
Floors on soil			Ceilings		
Style A: As per Selected OBC SB12 Package A1			Style A: As per Selected OBC SB12 Package A1 R 60		
Style B:			Style B: As per Selected OBC SB12 Package A1 R 31		
Exposed floors			Style C:		
Style A: As per Selected OBC SB12 Package A1 R 31			Doors		
Style B:			Style A: As per Selected OBC SB12 Package A1 R 4.00		
Windows			Style B:		
Style A: As per Selected OBC SB12 Package A1 R 3.55			Style C:		
Style B: Existing Windows (When Applicable) R 1.99			Skylights		
Style C:			Style A: As per Selected OBC SB12 Package A1 R 2.03		
Style D:			Style B:		
Attached documents: As per Shedule 1		Heat Loss/Gain Caculations based on CSA-F280-12 Effective R-Values			
Notes: Residential New Construction - Forced Air					
Calculations performed by					
Name: David DaCosta			Postal code: L4T 0A4		
Company: gtaDesigns Inc.			Telephone: (905) 671-9800		
Address: 2985 Drew Road, Suite 202			Fax: (416) 268-6820		
City: Mississauga			E-mail dave@gtadesigns.ca		

Builder: **Bayview Wellington**

Date: **April 3, 2018**

Project: **Green Valley East**

Model: **Rideau 5 S42-5**

System 1

I review and take responsibility for the design work and am qualified in the appropriate category as an "other designer" under Division C subsection 3.2.5. of the Building Code.

Individual BCIN: 32964 *David DaCosta* David DaCosta

Page 3
Project # **PJ-00204**
Layout # **JB-04587**

DESIGN LOAD SPECIFICATIONS		AIR DISTRIBUTION & PRESSURE		FURNACE/AIR HANDLER DATA:		BOILER/WATER HEATER DATA:		A/C UNIT DATA:	
Level 1 Net Load	18,067 btu/h	Equipment External Static Pressure	0.5 "w.c.	Make	Amana	Make	Type	Amana	3.0 Ton
Level 2 Net Load	19,796 btu/h	Additional Equipment Pressure Drop	0.225 "w.c.	Model	AMEC960803BNA	Model		Cond.-----	3.0
Level 3 Net Load	19,302 btu/h	Available Design Pressure	0.275 "w.c.	Input Btu/h	80000	Input Btu/h		Coil -----	3.0
Level 4 Net Load	0 btu/h	Return Branch Longest Effective Length	300 ft	Output Btu/h	76800	Output Btu/h			
Total Heat Loss	57,165 btu/h	R/A Plenum Pressure	0.138 "w.c.	E.s.p.	0.50 " W.C.	Min.Output Btu/h	AWH		
Total Heat Gain	31,351 btu/h	S/A Plenum Pressure	0.14 "w.c.	Water Temp	deg. F.	Blower DATA:			
Combo System HL + 10%	62,882 Btu/h	Heating Air Flow Proportioning Factor	0.0205 cfm/btuh	AFUE	96%	Blower Speed Selected:	W2	Blower Type	ECM
Building Volume Vb	39388 ft³	Cooling Air Flow Proportioning Factor	0.0374 cfm/btuh	Aux. Heat				(Brushless DC OBC 12.3.1.5.(2))	
Ventilation Load	1,118 Btu/h.	R/A Temp	70 deg. F.	SB-12 Package	Package A1	Heating Check	1172 cfm	Cooling Check	1172 cfm
Ventilation PVC	79.5 cfm	S/A Temp	131 deg. F.						
Supply Branch and Grill Sizing		Diffuser loss	0.01 "w.c.	Temp. Rise>>>	61 deg. F.	Selected cfm>	1172 cfm	Cooling Air Flow Rate	1172 cfm

	Level 1														Level 2													
S/A Outlet No.	1	2	3	4											5	6	7	8	9	10	11	12	13	14				
Room Use	BASE	BASE	BASE	BASE											KIT	KIT	GRT	GRT	LAUN	FOY	WIC 2	STUDY	LIV/DIN	LIV/DIN				
Btu/Outlet	4517	4517	4517	4517											2051	2051	1855	1855	3396	2738	1188	2054	1303	1303				
Heating Airflow Rate CFM	93	93	93	93											42	42	38	38	70	56	24	42	27	27				
Cooling Airflow Rate CFM	18	18	18	18											84	84	67	67	56	45	24	67	46	46				
Duct Design Pressure	0.13	0.13	0.13	0.13	0.13	0.13	0.13	0.13	0.13	0.13	0.13	0.13	0.13	0.13	0.13	0.13	0.13	0.13	0.13	0.13	0.13	0.13	0.13	0.13	0.13	0.13	0.13	
Actual Duct Length	44	51	30	21											51	54	63	52	41	33	22	11	5	42				
Equivalent Length	120	160	120	70	70	70	70	70	70	70	70	70	70	70	110	150	110	180	120	120	90	100	80	70	70	70	70	
Total Effective Length	164	211	150	91	70	70	70	70	70	70	70	70	70	70	161	204	173	232	161	153	112	111	85	112	70	70	70	
Adjusted Pressure	0.08	0.06	0.09	0.14	0.19	0.19	0.19	0.19	0.19	0.19	0.19	0.19	0.19	0.19	0.08	0.06	0.08	0.06	0.08	0.08	0.12	0.12	0.15	0.12	0.19	0.19	0.19	
Duct Size Round	6	6	6	6											6	6	6	6	6	6	4	5	5	5				
Outlet Size	4x10	4x10	4x10	4x10	4x10	4x10	4x10	4x10	4x10	4x10	4x10	4x10	4x10	4x10	4x10	4x10	4x10	4x10	4x10	4x10	4x10	3x10	3x10	3x10	3x10	4x10	4x10	4x10
Trunk	C	B	A	D											C	B	B	B	A	E	E	D	A	A				

	Level 3														Level 4													
S/A Outlet No.	15	16	17	18	19	20	21	22	23	24	25	26	27															
Room Use	MAST	MAST	ENS	WC	BED 2	BATH	BED 3	BED 3	BED 4	BATH 2	MED	WIC																
Btu/Outlet	1662	1662	1246	898	1318	1680	2148	2148	1909	1909	902	1383	436															
Heating Airflow Rate CFM	34	34	26	18	27	34	44	44	39	39	18	28	9															
Cooling Airflow Rate CFM	50	50	30	26	31	15	50	50	64	64	15	63	4															
Duct Design Pressure	0.13	0.13	0.13	0.13	0.13	0.13	0.13	0.13	0.13	0.13	0.13	0.13	0.13	0.13	0.13	0.13	0.13	0.13	0.13	0.13	0.13	0.13	0.13	0.13	0.13	0.13	0.13	
Actual Duct Length	65	75	71	76	64	63	53	50	52	46	36	51	62															
Equivalent Length	125	190	160	140	120	135	140	120	140	120	100	130	140	70	70	70	70	70	70	70	70	70	70	70	70	70	70	
Total Effective Length	190	265	231	216	184	198	193	170	192	166	136	181	202	70	70	70	70	70	70	70	70	70	70	70	70	70	70	
Adjusted Pressure	0.07	0.05	0.06	0.06	0.07	0.07	0.07	0.08	0.07	0.08	0.10	0.07	0.06	0.19	0.19	0.19	0.19	0.19	0.19	0.19	0.19	0.19	0.19	0.19	0.19	0.19	0.19	
Duct Size Round	5	5	4	4	4	4	6	6	6	6	3	6	3															
Outlet Size	3x10	3x10	3x10	3x10	3x10	3x10	4x10	4x10	4x10	4x10	3x10	4x10	3x10	4x10	4x10	4x10	4x10	4x10	4x10	4x10	4x10	4x10	4x10	4x10	4x10	4x10	4x10	
Trunk	C	B	B	B	A	A	D	D	E	E	D	A	C															

Return Branch And Grill Sizing												Return Trunk Duct Sizing					Supply Trunk Duct Sizing				
R/A Inlet No.	1R	2R	3R	4R	5R	6R	7R	8R	9R	10R	11R	Trunk	CFM	Press.	Round	Rect. Size	Trunk	CFM	Press.	Round	Rect. Size
Inlet Air Volume CFM	185	440	150	150	97	150						Drop	1172	0.05	17.0	24x12	A	773	0.05	14.5	24x8 18x10
Duct Design Pressure	0.12	0.12	0.12	0.12	0.12	0.12	0.12	0.12	0.12	0.12	0.12						Z	1172	0.05	17.0	26x10 22x12
Actual Duct Length	13	28	41	41	51	55						Y	335	0.05	11.0	14x8 10x10	C	178	0.06	8.5	8x8
Equivalent Length	110	165	155	165	160	170	50	50	50	50	50	X	247	0.06	9.5	10x8	D	400	0.07	11.0	14x8 10x10
Total Effective Length	123	193	196	206	211	225	50	50	50	50	50	W					E	159	0.07	7.5	8x8
Adjusted Pressure	0.10	0.06	0.06	0.06	0.06	0.05	0.24	0.24	0.24	0.24	0.24	V					F				
Duct Size Round	8.0	11.5	8.0	8.0	6.0	8.0						U					G				
Inlet Size	FLC	8	8	8	8	8						T					H				
" "	x	x	x	x	x	x	x	x	x	x	x	S					I				
Inlet Size	9x6	30	14	14	14	14						R					J				
												O					K				
Trunk	Y	Z	Z	X	X	Y															

2012 OBC	Builder: Bayview Wellington	Date: April 3, 2018	Weather Data: Bradford	44	-9.4	86	22	48.2	Heat Loss ^T	81.4 deg. F	Ht gain ^T	11 deg. F	GTA: 3330	Project # PJ-00204	Layout # JB-04587
	Project: Green Valley East	Model: Rideau 5 S42-5	System 1												

Level 1				BASE											
Run ft. exposed wall A	175	A		A		A		A		A		A		A	
Run ft. exposed wall B		B		B		B		B		B		B		B	
Ceiling height	3.6	AG		3.6	AG	3.6	AG	3.6	AG	3.6	AG	3.6	AG	3.6	AG
Floor area	1382	Area		Area		Area		Area		Area		Area		Area	
Exposed Ceilings A	A			A		A		A		A		A		A	
Exposed Ceilings B	B			B		B		B		B		B		B	
Exposed Floors	Flr			Flr		Flr		Flr		Flr		Flr		Flr	
Gross Exp Wall A	635														
Gross Exp Wall B															
Components	R-Values	Loss	Gain	Loss	Gain	Loss	Gain	Loss	Gain	Loss	Gain	Loss	Gain	Loss	Gain
North Shaded	3.55	22.93	10.91	6	138	65									
East/West	3.55	22.93	27.35	29	665	793									
South	3.55	22.93	20.89	6	138	125									
WOB Windows	3.15	25.84	28.32												
Skylight	2.03	40.10	88.23												
Doors	4.00	20.35	2.75	21	427	58									
Net exposed walls A	21.12	3.85	0.52	573		299									
Net exposed walls B	14.49	5.62	0.76												
Exposed Ceilings A	59.22	1.37	0.64												
Exposed Ceilings B	22.86	3.56	1.66												
Exposed Floors	29.80	2.73	0.17												
Foundation Conductive Heatloss	On Grade () or Above ()			7267											
Total Conductive	Heat Loss			8634											
	Heat Gain				1340										
Air Leakage	Heat Loss/Gain	1.0624	0.0395	9173		53									
Ventilation	Case 1		0.06												
	Case 2		14.07												
	Case 3	x	0.03												
	Heat Gain People			260		81									
Appliances Loads	1 = .25 percent														
Duct and Pipe loss			10%												
Level 1 HL Total	18,067	Total HL for per room		18067											
Level 1 HG Total	1,917	Total HG per room x 1.3			1917										

Level 2				KIT GRT LAUN FOY WIC 2 STUDY LIV/DIN											
Run ft. exposed wall A	37	A		33	A		32	A		22	A		11	A	
Run ft. exposed wall B		B			B			B			B			B	
Ceiling height	10.0			10.0			12.0			11.0			11.0		
Floor area	303	Area		226	Area		196	Area		83	Area		28	Area	
Exposed Ceilings A	A			5	A		A			A			A		
Exposed Ceilings B	B			B			B			B			B		
Exposed Floors	Flr			Flr			Flr			Flr			Flr		
Gross Exp Wall A	370			330			384			242			121		
Gross Exp Wall B															
Components	R-Values	Loss	Gain	Loss	Gain	Loss	Gain	Loss	Gain	Loss	Gain	Loss	Gain	Loss	Gain
North Shaded	3.55	22.93	10.91												
East/West	3.55	22.93	27.35	61	1399	1669				14	321	383			
South	3.55	22.93	20.89										24	550	501
Existing Windows	1.99	40.90	22.15												
Skylight	2.03	40.10	88.23												
Doors	4.00	20.35	2.75												
Net exposed walls A	17.03	4.78	0.65	309	1477	200				107	511	69			
Net exposed walls B	8.50	9.58	1.29							186	889	120			
Exposed Ceilings A	59.22	1.37	0.64				5	7	3						
Exposed Ceilings B	22.86	3.56	1.66												
Exposed Floors	29.80	2.73	0.17												
Foundation Conductive Heatloss	On Grade () or Above ()														
Total Conductive	Heat Loss			2876			2601			832			1439		
	Heat Gain				1868		1252				452			621	
Air Leakage	Heat Loss/Gain	0.3967	0.0395	1141		74	1032		49	330		18	571		25
Ventilation	Case 1		0.02												
	Case 2		14.07												
	Case 3	x	0.03												
	Heat Gain People			87		113		78		25		51		43	
Appliances Loads	1 = .25 percent														
Duct and Pipe loss			10%												
Level 2 HL Total	19,796	Total HL for per room		4103			3710			1188			2054		
Level 2 HG Total	15,735	Total HG per room x 1.3			4491		3609			647			1798		

Total Heat Loss	57,165	btu/h
Total Heat Gain	31,351	btu/h

I review and take responsibility for the design work and am qualified in the appropriate category as an "other designer" under Division C subsection 3.2.5. of the Building Code. Individual BCIN: 32964

David DaCosta

SB-12 Package

Package A1

Site Copy

2012 OBC

Builder: Bayview Wellington

Date: April 3, 2018

Project: Green Valley East

Model: Rideau 5 S42-5

System 1

Weather Data Bradford 44 -9.4 86 22 48.2

Heat Loss ^T 81.4 deg. F Ht gain ^T 11 deg. F GTA: 3330

Project #
Layout #

Level 3

	MAST	ENS	WC	BED 2	BATH	BED 3	BED 4	BATH 2	MED	WIC	
Run ft. exposed wall A	34 A	14 A	10 A	12 A	18 A	30 A	28 A	11 A	12 A	6 A	A
Run ft. exposed wall B	B	B	B	B	B	B	B	B	B	B	B
Ceiling height	9.0	8.0	8.0	8.0	8.0	10.0	10.0	8.0	8.0	8.0	8.0
Floor area	310 Area	107 Area	21 Area	204 Area	120 Area	244 Area	221 Area	101 Area	241 Area	81 Area	Area
Exposed Ceilings A	310 A	107 A	21 A	204 A	120 A	244 A	221 A	101 A	241 A	81 A	A
Exposed Ceilings B	B	B	B	B	B	B	B	B	B	B	B
Exposed Floors	Flr	Flr	Flr	Flr	72 Flr	199 Flr	12 Flr	Flr	Flr	Flr	Flr
Gross Exp Wall A	306	112	80	96	144	300	280	88	96	48	
Gross Exp Wall B											

Components	R-Values	Loss	Gain	Loss	Gain	Loss	Gain	Loss	Gain	Loss	Gain	Loss	Gain	Loss	Gain	Loss	Gain	Loss	Gain	Loss	Gain
North Shaded	3.55	22.93	10.91																		
East/West	3.55	22.93	27.35	39	894	1067	16	367	438	16	367	438	16	367	438	16	367	438	16	367	438
South	3.55	22.93	20.89																		
Existing Windows	1.99	40.90	22.15																		
Skylight	2.03	40.10	88.23																		
Doors	4.00	20.35	2.75																		
Net exposed walls A	17.03	4.78	0.65	267	1276	172	96	459	62	64	306	41	80	382	52	136	650	88	259	1238	167
Net exposed walls B	8.50	9.58	1.29																		
Exposed Ceilings A	59.22	1.37	0.64	310	426	199	107	147	69	21	29	13	204	280	131	120	165	77	244	335	157
Exposed Ceilings B	22.86	3.56	1.66																		
Exposed Floors	29.80	2.73	0.17																		
Foundation Conductive Heatloss																					
Total Conductive																					
Air Leakage	Heat Loss/Gain	0.2503	0.0395																		
Ventilation	Case 1	0.02	0.06																		
	Case 2	14.07	11.88																		
	Case 3	x	0.03																		
Heat Gain People			239	2	78	87		29	34		21	30		31	22		36	16		92	90
Appliances Loads	1 =.25 percent		5597																		
Duct and Pipe loss			10%																		
Level 3 HL Total	19,302		Total HL for per room	3325				1246			898			1318			149	26		382	172
Level 3 HG Total	13,699		Total HG per room x 1.3		2678				813			704			822					4296	2649

Level 4

Run ft. exposed wall A	A	A	A	A	A	A	A	A	A	A	A
Run ft. exposed wall B	B	B	B	B	B	B	B	B	B	B	B
Ceiling height											
Floor area	Area	Area	Area	Area	Area	Area	Area	Area	Area	Area	Area
Exposed Ceilings A	A	A	A	A	A	A	A	A	A	A	A
Exposed Ceilings B	B	B	B	B	B	B	B	B	B	B	B
Exposed Floors	Flr	Flr	Flr	Flr	Flr	Flr	Flr	Flr	Flr	Flr	Flr
Gross Exp Wall A											
Gross Exp Wall B											

Components	R-Values	Loss	Gain	Loss	Gain	Loss	Gain	Loss	Gain	Loss	Gain	Loss	Gain	Loss	Gain	Loss	Gain	Loss	Gain	Loss	Gain
North Shaded	3.55	22.93	10.91																		
East/West	3.55	22.93	27.35																		
South	3.55	22.93	20.89																		
Existing Windows	1.99	40.90	22.15																		
Skylight	2.03	40.10	88.23																		
Doors	4.00	20.35	2.75																		
Net exposed walls A	17.03	4.78	0.65																		
Net exposed walls B	8.50	9.58	1.29																		
Exposed Ceilings A	59.22	1.37	0.64																		
Exposed Ceilings B	22.86	3.56	1.66																		
Exposed Floors	29.80	2.73	0.17																		
Foundation Conductive Heatloss																					
Total Conductive																					
Air Leakage	Heat Loss/Gain	0.0000	0.0395																		
Ventilation	Case 1	0.00	0.06																		
	Case 2	14.07	11.88																		
	Case 3	x	0.03																		
Heat Gain People			239																		
Appliances Loads	1 =.25 percent		5597																		
Duct and Pipe loss			10%																		
Level 4 HL Total	0		Total HL for per room																		
Level 4 HG Total	0		Total HG per room x 1.3																		

Total Heat Loss	57,165	btu/h
Total Heat Gain	31,351	btu/h

I review and take responsibility for the design work and am qualified in the appropriate category as an "other designer" under

Division C subsection 3.2.5. of the Building Code. Individual BCIN:

32964

David DaCosta

David DaCosta

SB-12 Package

Package A1

Site Copy

I review and take responsibility for the design work and am qualified in the appropriate category as an "other designer" under Division C subsection 3.2.5. of the Building Code.

Individual BCIN: 32964



David DaCosta

Package:
Package A1
Project:
Bradford
Model:
S42-5
RESIDENTIAL MECHANICAL VENTILATION DESIGN SUMMARY

For systems serving one dwelling unit & conforming to the Ontario Building Code, O.reg 332/12

Location of Installation

Lot #	Plan #
Township	Bradford
Roll #	Permit #
Address	

Builder

Name	Bayview Wellington
Address	
City	
Tel	Fax

Installing Contractor

Name	
Address	
City	
Tel	Fax

Combustion Appliances 9.32.3.1(1)

- | | | |
|----|-------------------------------------|--|
| a) | ☒ | Direct vent (sealed combustion) only |
| b) | ☐ | Positive venting induced draft (except fireplaces) |
| c) | ☐ | Natural draft, B-vent or induced draft fireplaces |
| d) | ☐ | Solid fuel (including fireplaces) |
| e) | ☐ | No combustion Appliances |

Heating System

- | | |
|-------------------------------------|--|
| ☒ | Forced air |
| ☐ | Non forced air |
| ☐ | Electric space heat (if over 10% of heat load) |

House Type 9.32.3.1(2)

- | | | |
|-------|-------------------------------------|---|
| I | ☒ | Type a) or b) appliances only, no solid fuel |
| II | ☐ | Type I except with solid fuel (including fireplace) |
| III | ☐ | Any type c) appliance |
| IV | ☐ | Type I or II either electric space heat |
| Other | ☐ | Type I, II or IV no forced air |

System Design Option

- | | | |
|---|-------------------------------------|---|
| 1 | ☐ | Exhaust only / forced air system |
| 2 | ☐ | HRV WITH DUCTING / forced air system |
| 3 | ☒ | HRV simplified connection to forced air system |
| 4 | ☐ | HRV full ducting/not coupled to forced air system |
| | | Part 6 design |

Total Ventilation Capacity 9.32.3.3(1)

Bsmt & Master Bdrm	2 @ 21.2 cfm	42.4 cfm
Other Bedrooms	3 @ 10.6 cfm	31.8 cfm
Bathrooms & Kitchen	5 @ 10.6 cfm	53 cfm
Other rooms	7 @ 10.6 cfm	74.2 cfm
Total		<u>201.4</u>

Principal Ventilation Capacity 9.32.3.4(1)

Master bedroom	1 @ 31.8 cfm	31.8 cfm
Other bedrooms	3 @ 15.9 cfm	47.7 cfm
Total		<u>79.5</u>

Principal Exhaust Fan Capacity

Make	Model	Location
LifeBreath	RNC155	Base
132 cfm		Sones or Equiv.

Heat Recovery Ventilator

Make	LifeBreath
Model	RNC155
132 cfm high	80 cfm low
Sensible efficiency @ -25 deg C	71%
Sensible efficiency @ 0 deg C	75%

Note: Installer to balance HRV/ERV to within 10 percent of PVC

Supplemental Ventilation Capacity

Total ventilation capacity	201.4
Less principal exhaust capacity	79.5
REQUIRED supplemental vent. Capacity	<u>121.9</u> cfm

Supplemental Fans 9.32.3.5.

Location	cfm	Model	Sones
Ens	50	XB50	0.3
Bath	50	XB50	0.3
Bath 2	50	XB50	0.3

all fans HVI listed Make Broan or Equiv.

Designer Certification

I hereby certify that this ventilation system has been designed in accordance with the Ontario Building Code.

Name David DaCosta

Signature



HRAI #

5190

BCIN #

32964

Date

April 3, 2018



2985 Drew Road, Suite 202, Mississauga, Ontario
 L4T 0A4 Tel: 905-671-9800 Fax: 647-494-9643
 e-mail dave@gtadesigns.ca

Energy Efficiency Design Summary: Prescriptive Method (Building Code Part 9, Residential)

Page 7
 Project # PJ-00204
 Layout # JB-04587

This form is used by a designer to demonstrate that the energy efficiency design of a house complies with the building code using the prescriptive method described in Subsection 3.1.1. of SB-12. This form is applicable where the ratio of gross area of windows/sidelights/skylights/glazing in doors and sliding glass doors to the gross area of peripheral walls is not more than 22%.

For use by Principal Authority

Application No:

Model/Certification Number

A. Project Information

Building number, street name	Rideau 5 S42-5	Unit number	Lot/Con
Municipality	Bradford	Postal code	Reg. Plan number / other description

B. Prescriptive Compliance [indicate the building code compliance package being employed in the house design]

SB-12 Prescriptive (input design package):

Package A1

Table: 3.1.1.2.A

C. Project Design Conditions

Climatic Zone (SB-1):	Heat. Equip. Efficiency	Space Heating Fuel Source
☒ Zone 1 (< 5000 degree days) ☐ Zone 2 (≥ 5000 degree days)	☒ ≥ 92% AFUE ☐ ≥ 84% < 92% AFUE	☒ Gas ☐ Propane ☐ Solid Fuel ☐ Oil ☐ Electric ☐ Earth Energy
Ratio of Windows, Skylights & Glass (W, S & G) to Wall Area	Other Building Characteristics	
Area of Walls = <u>375.53</u> m ² or <u>4042.2</u> ft ²	W, S & G % = <u>13%</u>	☐ Log/Post&Beam ☐ ICF Above Grade ☐ ICF Basement ☐ Slab-on-ground ☐ Walkout Basement ☒ Air Conditioning ☐ Combo Unit
Area of W, S & G = <u>47.565</u> m ² or <u>512.0</u> ft ²	Utilize Window ☐ Yes Averaging ☒ No	☐ Air Sourced Heat Pump (ASHP) ☐ Ground Source Heat Pump (GSHP)

D. Building Specifications [provide values and ratings of the energy efficiency components proposed]

Energy Efficiency Substitutions			
☐ ICF (3.1.1.2.(5) & (6) / 3.1.1.3.(5)) ☐ Combined space heating and domestic water heating systems (3.1.1.2(7) / 3.1.1.3.(7))			
☐ Airtightness substitution(s) Airtightness test required (Refer to Design Guide Attached)	☐ Table 3.1.1.4.B Required:		Permitted Substitution:
	☐ Table 3.1.1.4.C Required:		Permitted Substitution:
Building Component	Minimum RSI/R-Values or Maximum U-Value ¹		Efficiency Ratings
Thermal Insulation	Nominal	Effective	Windows & Doors Provide U-Value ⁽¹⁾ or ER rating
Ceiling with Attic Space	60		Windows/Sliding Glass Doors 1.6
Ceiling without Attic Space	31		Skylights 2.8
Exposed Floor	31		Mechanicals
Walls Above Grade	22		Heating Equip.(AFUE) 96%
Basement Walls	20.0ci		HRV Efficiency (SRE% at 0°C) 75%
Slab (all >600mm below grade)	x		DHW Heater (EF) 0.80
Slab (edge only ≤600mm below grade)	10		DWHR (CSA B55.1 (min. 42% efficiency)) #Showers 2
Slab (all ≤600mm below grade, or heated)	10		Combined Heating System

(1) U value to be provided in either W/(m²·K) or Btu/(h·ft²·F) but not both.

E. Designer(s) [name(s) & BCIN(s), if applicable, of person(s) providing information herein to substantiate that design meets building code]

Name	BCIN	Signature
David DaCosta	32964	

Form authorized by OHBA, OBOA, LMCBO. Revised December 1, 2016.

Site Copy


Envelope Air Leakage Calculator


Supplemental tool for CAN/CSA-F280


Weather Station Description				
Province:	Ontario ▼			
Region:	Bradford ▼			
Weather Station Location:	Open flat terrain, grass ▼			
Anemometer height (m):	10			
Local Shielding				
Building Site:	Suburban, forest ▼			
Walls:	Heavy ▼			
Flue:	Heavy ▼			
Highest Ceiling Height (m):	6.59			
Building Configuration				
Type:	Detached			
Number of Stories:	Two			
Foundation:	Full			
House Volume (m ³):	1115.47			
Air Leakage/Ventilation				
Air Tightness Type:	Present (1961-) (ACH=3.57)			
Custom BDT Data:	ELA @ 10 Pa. ▼ 322.44 cm ²			
	3.57 ACH @ 50 Pa			
Mechanical Ventilation (L/s):	Total Supply:		Total Exhaust:	
	39.75		39.75	
Flue #:	#1	#2	#3	#4
Diameter (mm):	0	0	0	0
Heating Air Leakage Rate (ACH/H):		0.318		
Cooling Air Leakage Rate (ACH/H):		0.079		

Residential Foundation Thermal Load Calculator

Supplemental tool for CAN/CSA-F280

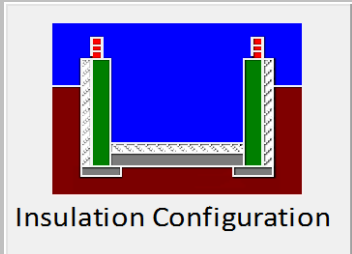Weather Station Description		
Province:	Ontario ▼	
Region:	Bradford ▼	
Site Description		
Soil Conductivity:	High conductivity: moist soil ▼	
Water Table:	Normal (7-10 m, 23-33 Ft) ▼	
Foundation Dimensions		
Floor Length (m):	20.37	 Insulation Configuration
Floor Width (m):	6.30	
Exposed Perimeter (m):	53.34	
Wall Height (m):	2.74	
Depth Below Grade (m):	1.64	
Window Area (m ²):	3.81	
Door Area (m ²):	1.95	
Radiant Slab		
Heated Fraction of the Slab:	0	
Fluid Temperature (°C):	33	
Design Months		
Heating Month	1	
Foundation Loads		
Heating Load (Watts):		2130

 	FLEX DUCT		LOW/HIGH WALL/KICK SUPPLY DIFFUSER		DUCT CONNECTION TO JOIST LINING		RETURN AIR GRILLE (SIZE INDICATED ON DRAWING)	S.A.	SUPPLY AIR
	RIGID ROUND DUCT		HRV EXHAUST GRILLE		RETURN AIR PIPE RISER		RETURN AIR RISER UP TO FLOOR ABOVE	R.A.	RETURN AIR
	SUPPLY DIFFUSER		SUPPLY AIR PIPE RISER		RETURN ROUND DUCT		RETURN AIR FROM BASEMENT SECOND FLOOR		THERMOSTAT
			VOLUME DAMPER						PRINCIPAL EXHAUST FAN SWITCH
									W/R & PRINCIPAL EXHAUST FAN

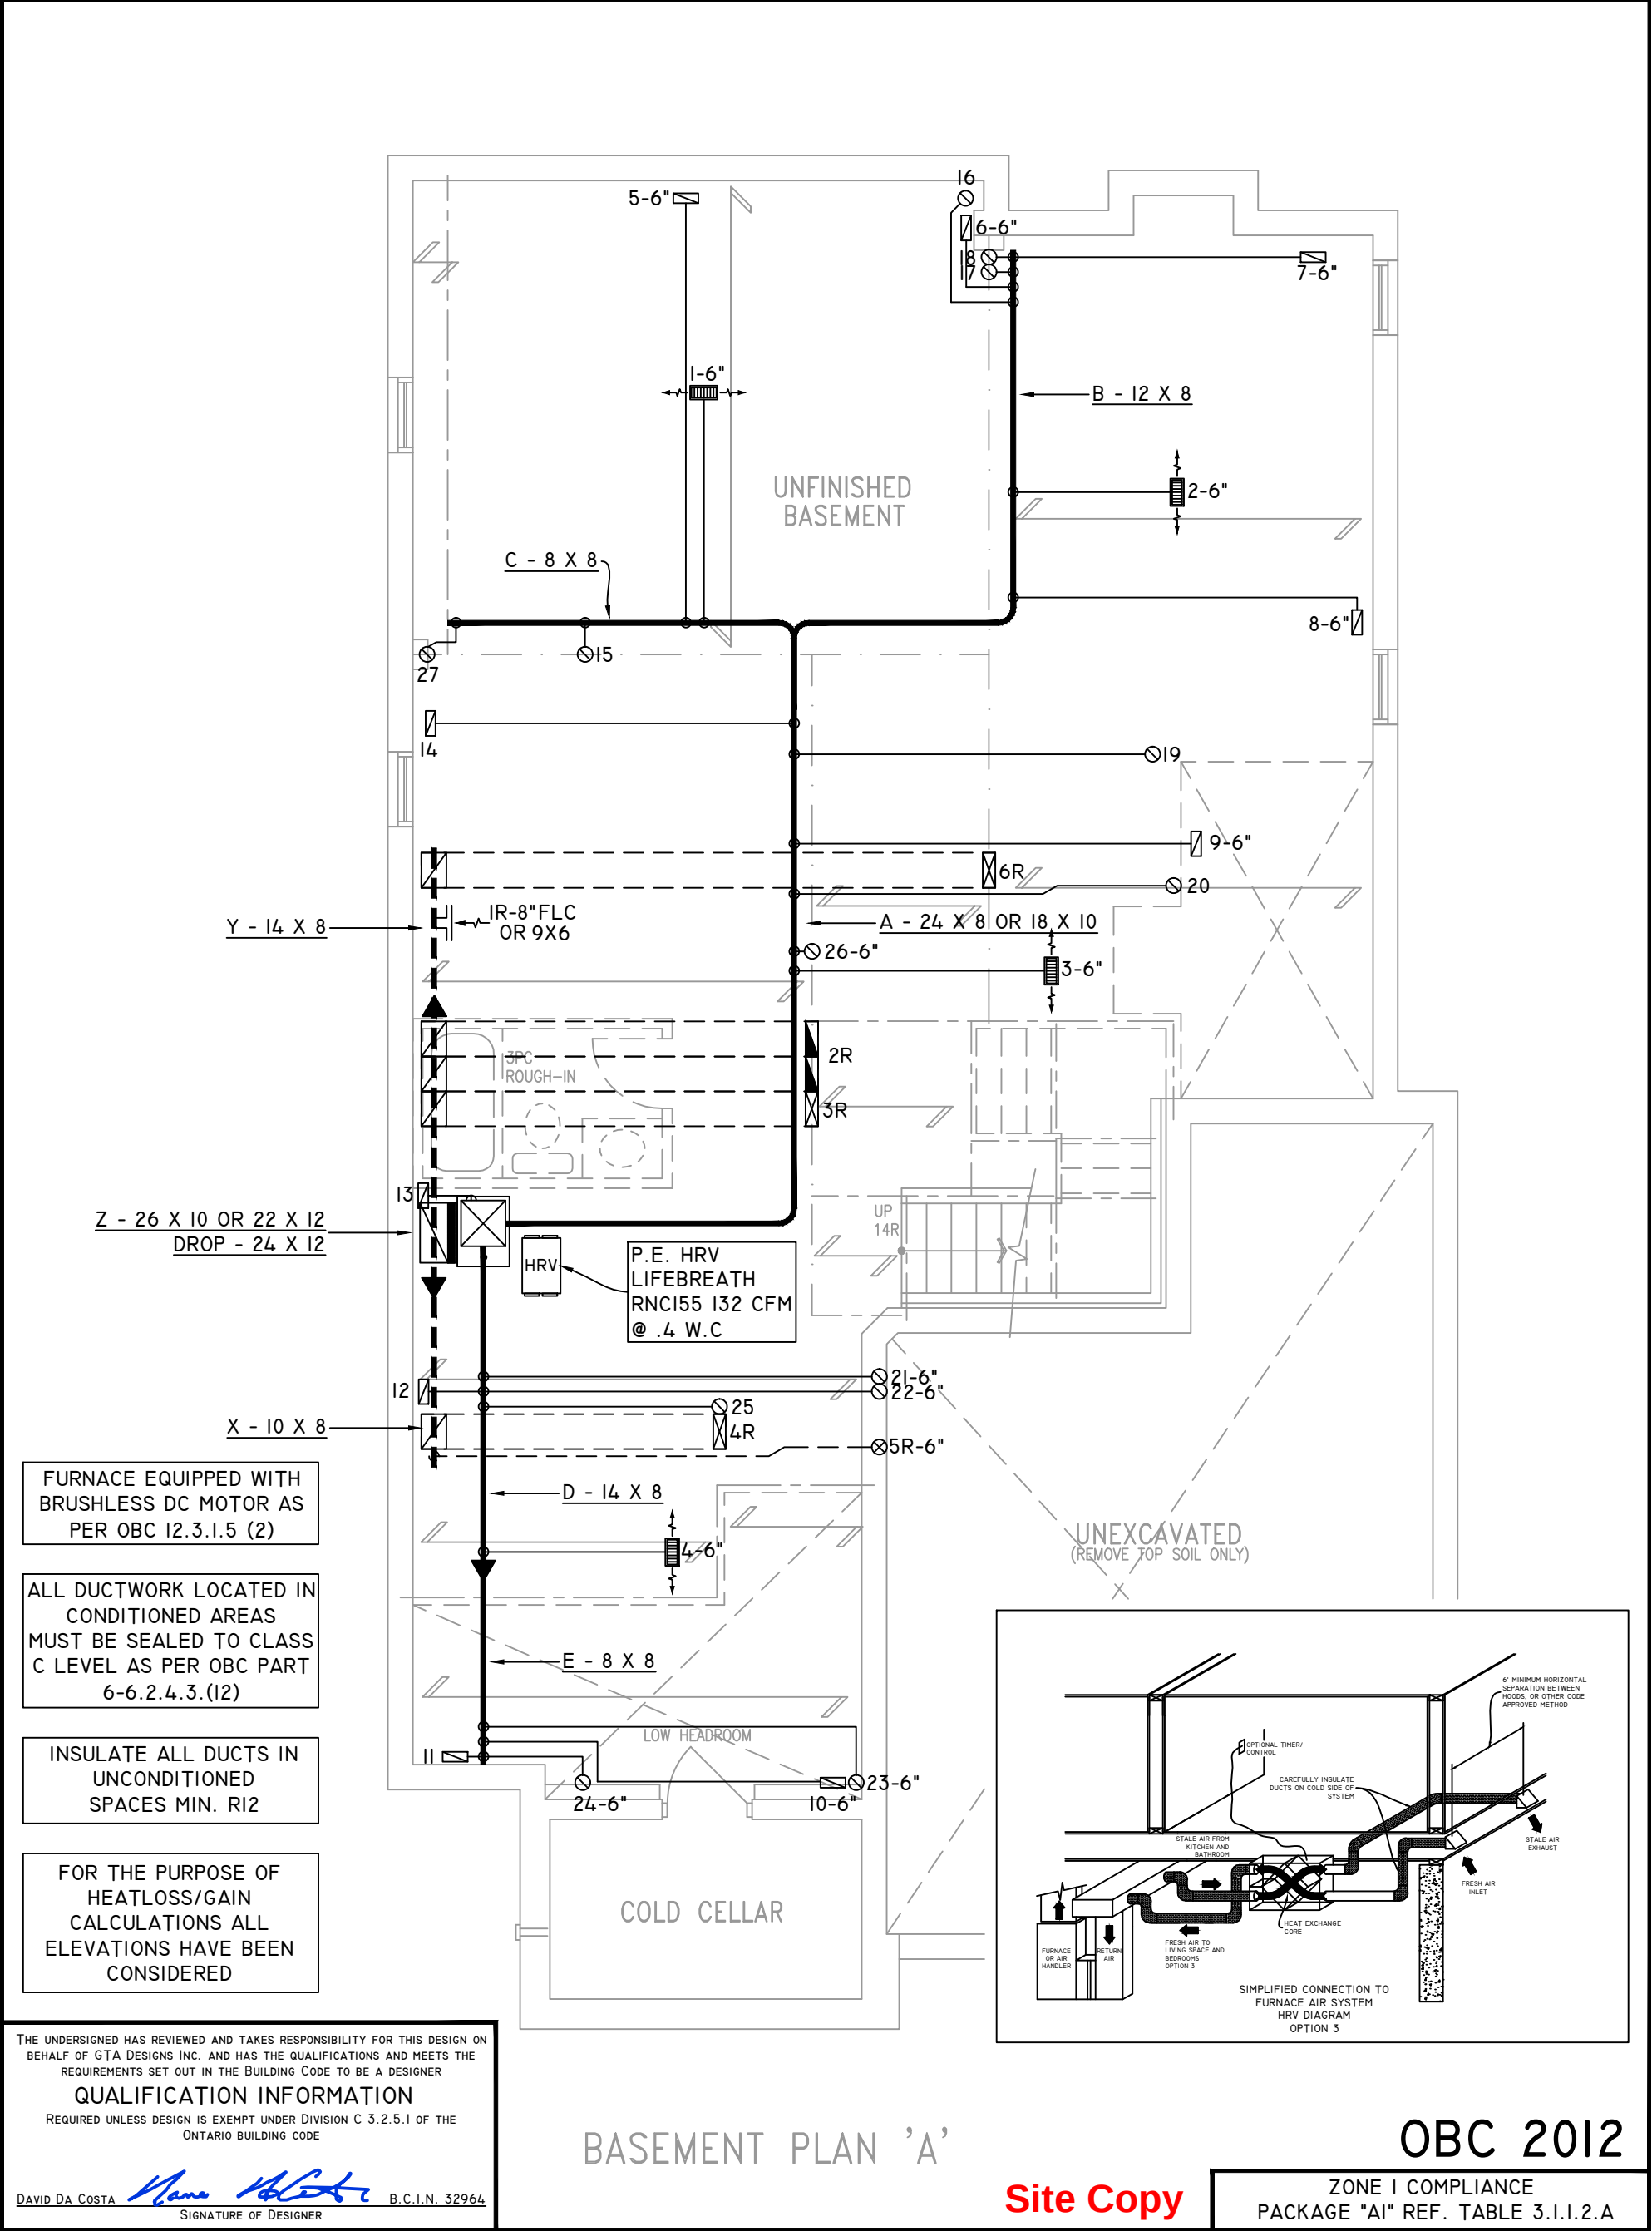

NOTES

INSTALLATION TO COMPLY WITH THE LATEST ONTARIO BUILDING CODE.

ALL SUPPLY OUTLETS TO BE 5" DIA. UNLESS OTHERWISE SPECIFIED.

PROVIDE BALANCING DAMPERS ON ALL BRANCHES.

ALL R/A PARTITIONS 6" (FIRST FLOOR ONLY)

INSULATE DUCTS IN UNCONDITIONED SPACES R12 UNDERCUT ALL DOORS 1" MIN.

CONTRACTOR MUST WORK FROM APPROVED PLANS.

ANY ALTERATIONS TO THIS ORIGINAL PLAN ARE NOT THE RESPONSIBILITY OF GTA DESIGNS.

GTA DESIGNS MUST BE CONSULTED IF KITCHEN EXHAUST FAN EXCEEDS 700 CFM DEPRESSURIZATION MAY OCCUR WITH IN THE DWELLING.

GTADESIGNS



2985 DREW ROAD
SUITE 202,
MISSISSAUGA, ONT.
L4T 0A4 TEL: 905-671-9800
EMAIL: DAVE@GTADESIGNS.CA
WEB: WWW.GTADESIGNS.CA

HEAT-LOSS	57,165	BTU/HR.
UNIT MAKE	AMANA	OR EQUAL.
UNIT MODEL	AMEC960803BNA	OR EQUAL.
UNIT HEATING INPUT	80,000	BTU/HR.
UNIT HEATING OUTPUT	76,800	BTU/HR.
A/C COOLING CAPACITY	3.0	TONS.
FAN SPEED	1172	CFM

# OF RUNS	S/A	R/A	FANS
3RD FLOOR			
2ND FLOOR	13	4	4
1ST FLOOR	10	1	2
BASEMENT	4	1	

FLOOR PLAN:	BASEMENT
DRAWN BY:	AM
CHECKED:	DD
LAYOUT NO.	JB-04587
SQFT	3330
DRAWING NO.	MI

  DATE:	APRIL 3, 2018
CLIENT:	BAYVIEW WELLINGTON
MODEL:	S42-5 RIDEAU 5
PROJECT:	GREEN VALLEY EAST BRADFORD, ONT.
SCALE:	3/16" = 1'-0"

	FLEX DUCT		LOW/HIGH WALL/KICK SUPPLY DIFFUSER		DUCT CONNECTION TO JOIST LINING		RETURN AIR GRILLE (SIZE INDICATED ON DRAWING)	S.A.	SUPPLY AIR
	RIGID ROUND DUCT		HRV EXHAUST GRILLE		RETURN AIR PIPE RISER		RETURN AIR RISER UP TO FLOOR ABOVE	R.A.	RETURN AIR
	SUPPLY DIFFUSER		SUPPLY AIR PIPE RISER		RETURN ROUND DUCT		RETURN AIR FROM BASEMENT SECOND FLOOR		THERMOSTAT
			VOLUME DAMPER						PRINCIPAL EXHAUST FAN SWITCH
									W/R & PRINCIPAL EXHAUST FAN

KITCHEN EXHAUST
100 CFM MIN. 6"

CIRCULATION PRINCIPAL
FAN SWITCH
TO BE CENTRALLY
LOCATED

ALL DUCTWORK LOCATED IN
CONDITIONED AREAS
MUST BE SEALED TO CLASS
C LEVEL AS PER OBC PART
6-6.2.4.3.(12)

INSULATE ALL DUCTS IN
UNCONDITIONED
SPACES MIN. R12

FOR THE PURPOSE OF
HEATLOSS/GAIN
CALCULATIONS ALL
ELEVATIONS HAVE BEEN
CONSIDERED

THE UNDERSIGNED HAS REVIEWED AND TAKES RESPONSIBILITY FOR THIS DESIGN ON BEHALF OF GTA DESIGNS INC. AND HAS THE QUALIFICATIONS AND MEETS THE REQUIREMENTS SET OUT IN THE BUILDING CODE TO BE A DESIGNER

QUALIFICATION INFORMATION

REQUIRED UNLESS DESIGN IS EXEMPT UNDER DIVISION C 3.2.5.1 OF THE ONTARIO BUILDING CODE

DAVID DA COSTA



B.C.I.N. 32964

SIGNATURE OF DESIGNER

GROUND FLOOR PLAN 'A'

OBC 2012

Site Copy

ZONE I COMPLIANCE
PACKAGE "A1" REF. TABLE 3.1.1.2.A

NOTES
INSTALLATION TO COMPLY WITH THE LATEST ONTARIO BUILDING CODE.
ALL SUPPLY OUTLETS TO BE 5" DIA. UNLESS OTHERWISE SPECIFIED.
PROVIDE BALANCING DAMPERS ON ALL BRANCHES.
ALL R/A PARTITIONS 6" (FIRST FLOOR ONLY)
INSULATE DUCTS IN UNCONDITIONED SPACES R12 UNDERCUT ALL DOORS 1" MIN.
CONTRACTOR MUST WORK FROM APPROVED PLANS.
ANY ALTERATIONS TO THIS ORIGINAL PLAN ARE NOT THE RESPONSIBILITY OF GTA DESIGNS.
GTA DESIGNS MUST BE CONSULTED IF KITCHEN EXHAUST FAN EXCEEDS 700 CFM DEPRESSURIZATION MAY OCCUR WITH IN THE DWELLING.




2985 DREW ROAD
SUITE 202,
MISSISSAUGA, ONT.
L4T 0A4 TEL: 905-671-9800
EMAIL: DAVE@GTADESIGNS.CA
WEB: WWW.GTADESIGNS.CA


HEAT-LOSS	57,165	BTU/HR.
UNIT MAKE	AMANA	OR EQUAL.
UNIT MODEL	AMEC960803BNA	OR EQUAL.
UNIT HEATING INPUT	80,000	BTU/HR.
UNIT HEATING OUTPUT	76,800	BTU/HR.
A/C COOLING CAPACITY	3.0	TONS.
FAN SPEED	1172	CFM

# OF RUNS	S/A	R/A	FANS
3RD FLOOR			
2ND FLOOR	13	4	4
1ST FLOOR	10	1	2
BASEMENT	4	1	

FLOOR PLAN: GROUND FLOOR	
DRAWN BY: AM	CHECKED: DD
LAYOUT NO. JB-04587	SQFT 3330
	DRAWING NO. M2

 DATE:	APRIL 3, 2018
CLIENT:	BAYVIEW WELLINGTON
MODEL:	S42-5 RIDEAU 5
PROJECT:	GREEN VALLEY EAST BRADFORD,ONT.
SCALE:	3/16" = 1'-0"

	FLEX DUCT		LOW/HIGH WALL/KICK SUPPLY DIFFUSER		DUCT CONNECTION TO JOIST LINING		RETURN AIR GRILLE (SIZE INDICATED ON DRAWING)	S.A.	SUPPLY AIR
	RIGID ROUND DUCT		HRV EXHAUST GRILLE		RETURN AIR PIPE RISER		RETURN AIR RISER UP TO FLOOR ABOVE	R.A.	RETURN AIR
	SUPPLY DIFFUSER		SUPPLY AIR PIPE RISER		RETURN ROUND DUCT		RETURN AIR FROM BASEMENT SECOND FLOOR		THERMOSTAT
			VOLUME DAMPER						PRINCIPAL EXHAUST FAN SWITCH
									W/R & PRINCIPAL EXHAUST FAN

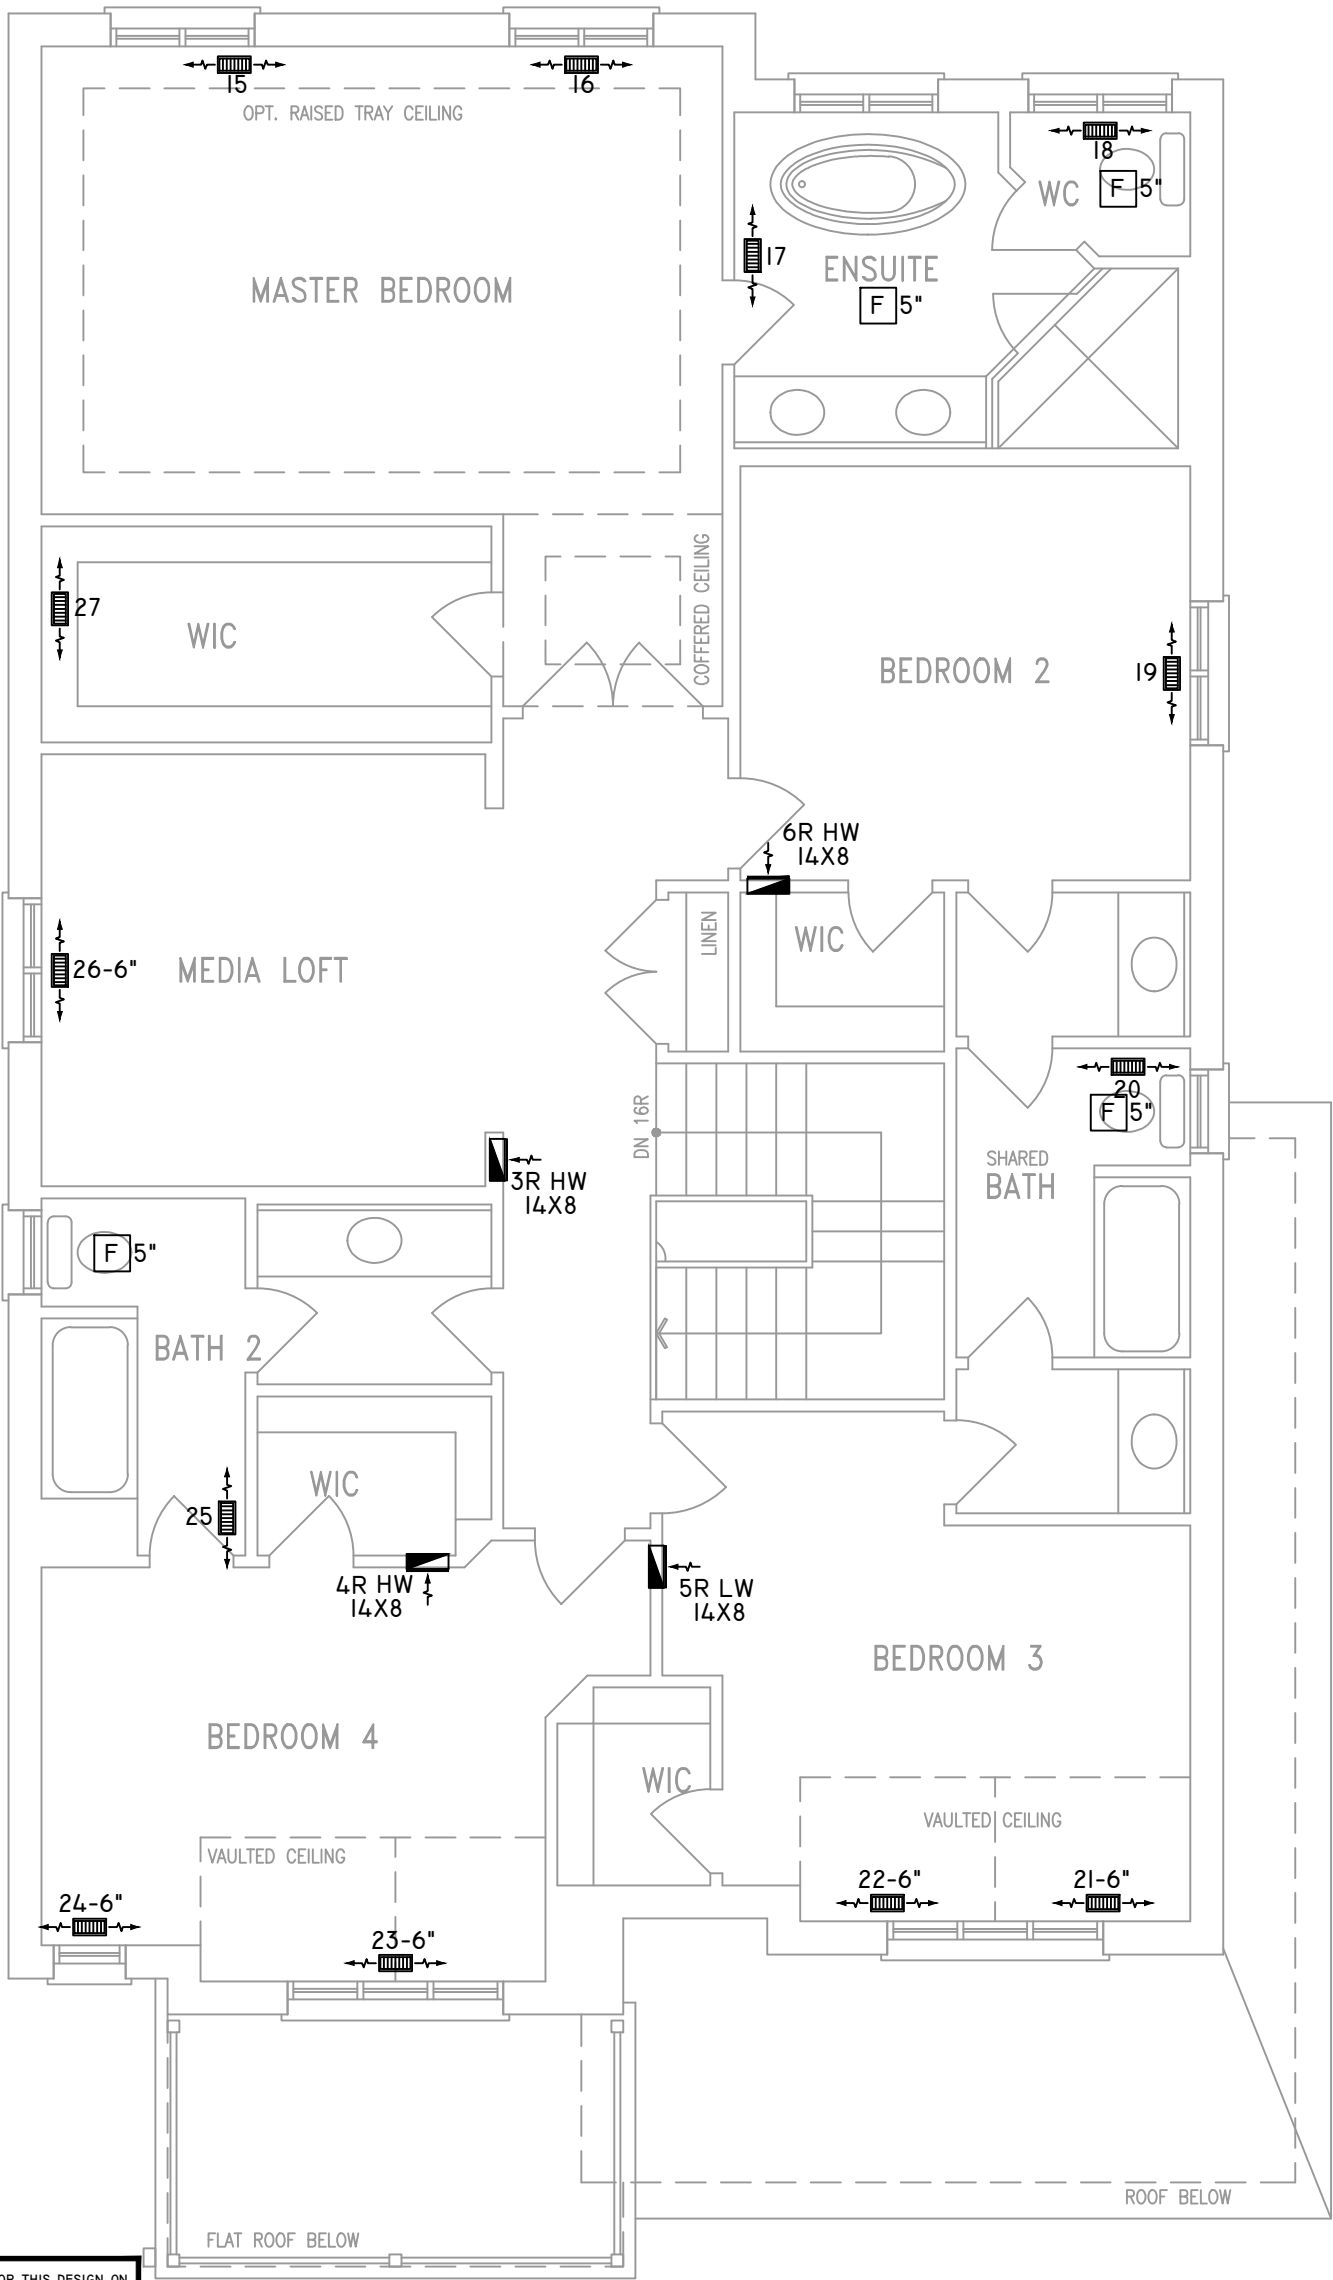

ALL DUCTWORK LOCATED IN
CONDITIONED AREAS
MUST BE SEALED TO CLASS
C LEVEL AS PER OBC PART
6-6.2.4.3.(12)

INSULATE ALL DUCTS IN
UNCONDITIONED
SPACES MIN. R12

FOR THE PURPOSE OF
HEATLOSS/GAIN
CALCULATIONS ALL
ELEVATIONS HAVE BEEN
CONSIDERED

THE UNDERSIGNED HAS REVIEWED AND TAKES RESPONSIBILITY FOR THIS DESIGN ON
BEHALF OF GTA DESIGNS INC. AND HAS THE QUALIFICATIONS AND MEETS THE
REQUIREMENTS SET OUT IN THE BUILDING CODE TO BE A DESIGNER

QUALIFICATION INFORMATION

REQUIRED UNLESS DESIGN IS EXEMPT UNDER DIVISION C 3.2.5.1 OF THE
ONTARIO BUILDING CODE

DAVID DA COSTA  B.C.I.N. 32964
SIGNATURE OF DESIGNER

SECOND FLOOR PLAN 'A'
4 BEDROOM + MEDIA LOFT

Site Copy OBC 2012

ZONE I COMPLIANCE
PACKAGE "A1" REF. TABLE 3.1.1.2.A

NOTES

INSTALLATION TO COMPLY WITH THE LATEST ONTARIO
BUILDING CODE.

ALL SUPPLY OUTLETS TO BE 5" DIA. UNLESS OTHERWISE
SPECIFIED.

PROVIDE BALANCING DAMPERS ON ALL BRANCHES.

ALL R/A PARTITIONS 6" (FIRST FLOOR ONLY)

INSULATE DUCTS IN UNCONDITIONED SPACES R12 UNDERCUT
ALL DOORS 1" MIN.

CONTRACTOR MUST WORK FROM APPROVED PLANS.

ANY ALTERATIONS TO THIS ORIGINAL PLAN ARE NOT THE
RESPONSIBILITY OF GTA DESIGNS.

GTA DESIGNS MUST BE CONSULTED IF KITCHEN EXHAUST
FAN EXCEEDS 700 CFM DEPRESSURIZATION MAY OCCUR
WITH IN THE DWELLING.



**2985 DREW ROAD
SUITE 202,
MISSISSAUGA, ONT.
L4T 0A4 TEL: 905-671-9800
EMAIL: DAVE@GTADESIGNS.CA
WEB: WWW.GTADESIGNS.CA**


HEAT-LOSS	57,165	BTU/HR.
UNIT MAKE	AMANA	OR EQUAL.
UNIT MODEL	AMEC960803BNA	OR EQUAL.
UNIT HEATING INPUT	80,000	BTU/HR.
UNIT HEATING OUTPUT	76,800	BTU/HR.
A/C COOLING CAPACITY	3.0	TONS.
FAN SPEED	1172	CFM

# OF RUNS	S/A	R/A	FANS
3RD FLOOR			
2ND FLOOR	13	4	4
1ST FLOOR	10	1	2
BASEMENT	4	1	


FLOOR PLAN: SECOND FLOOR		
DRAWN BY: AM	CHECKED: DD	SQFT 3330
LAYOUT NO. JB-04587	DRAWING NO. M3	

 DATE: APRIL 3, 2018
CLIENT: BAYVIEW WELLINGTON
MODEL: S42-5 RIDEAU 5
PROJECT: GREEN VALLEY EAST BRADFORD,ONT.
SCALE: 3/16" = 1'-0"

	FLEX DUCT		LOW/HIGH WALL/KICK SUPPLY DIFFUSER		DUCT CONNECTION TO JOIST LINING		RETURN AIR GRILLE (SIZE INDICATED ON DRAWING)	S.A.	SUPPLY AIR
	RIGID ROUND DUCT		HRV EXHAUST GRILLE		RETURN AIR PIPE RISER		RETURN AIR RISER UP TO FLOOR ABOVE	R.A.	RETURN AIR
	SUPPLY DIFFUSER		SUPPLY AIR PIPE RISER		RETURN ROUND DUCT		RETURN AIR FROM BASEMENT SECOND FLOOR		THERMOSTAT
			VOLUME DAMPER						PRINCIPAL EXHAUST FAN SWITCH
									W/R & PRINCIPAL EXHAUST FAN

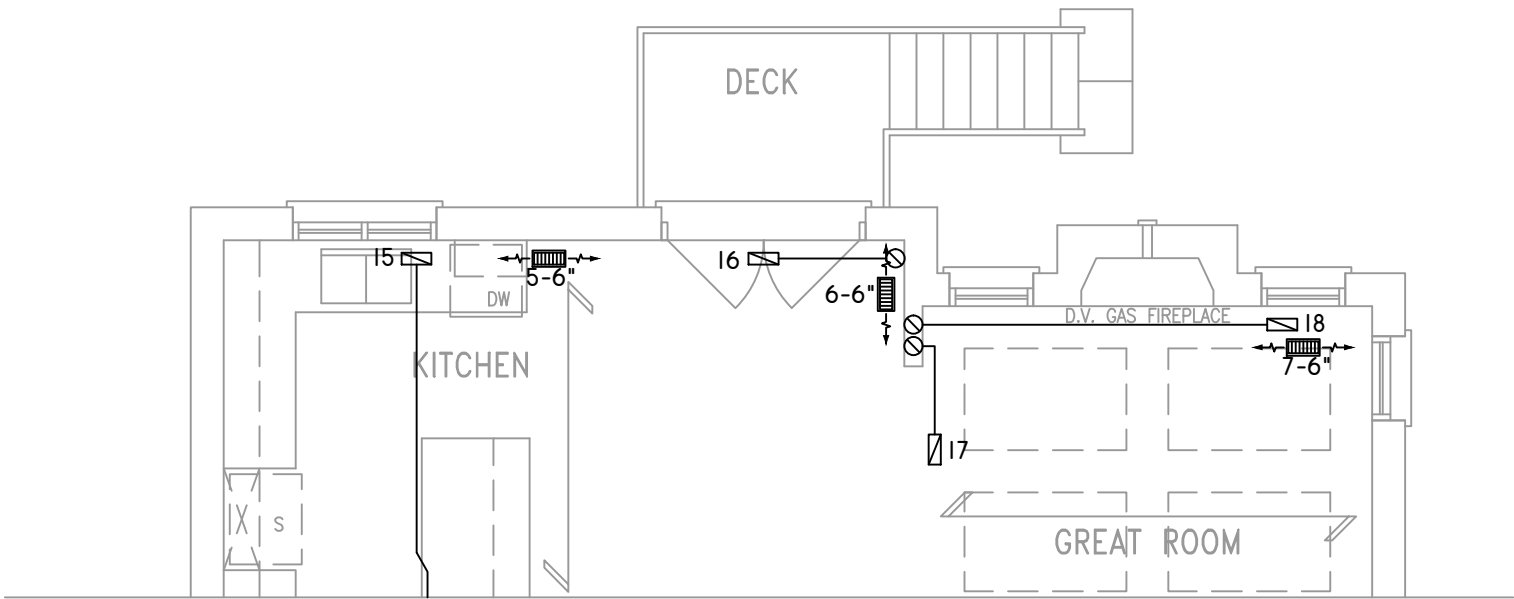

PARTIAL GROUND FLOOR PLAN W/ W.O.D.
9R & MORE CONDITION

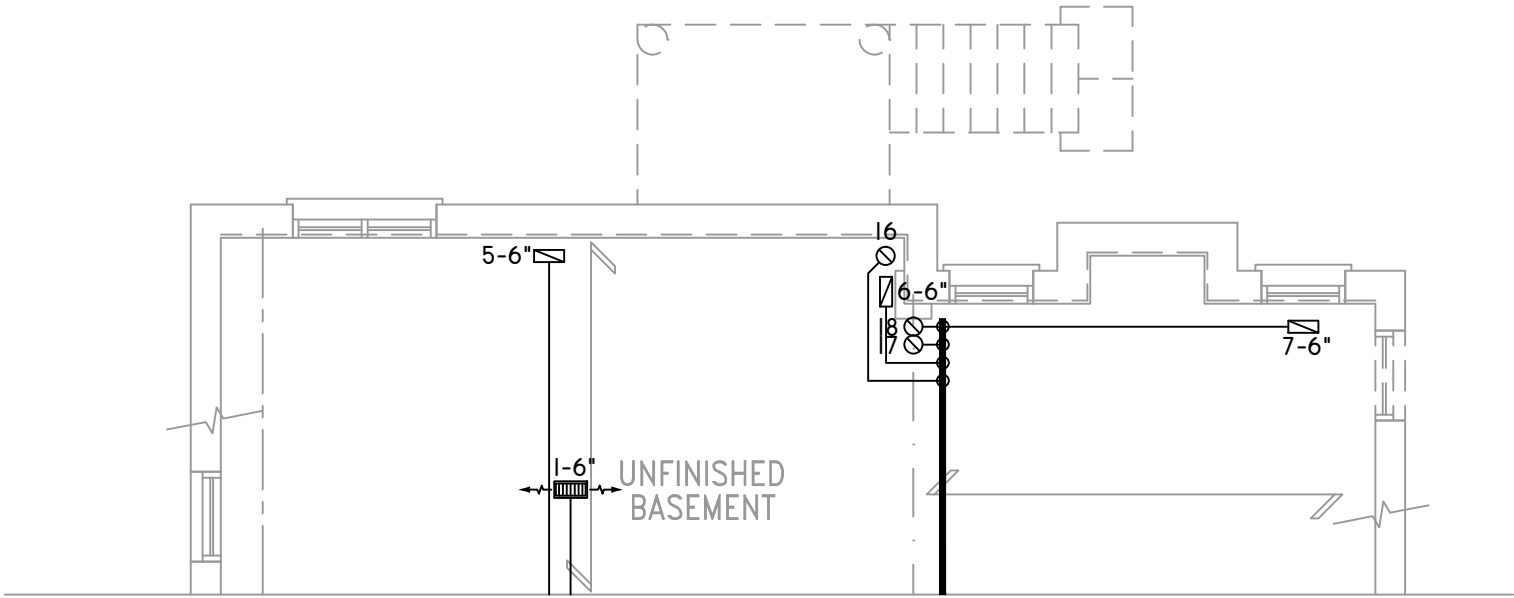

PARTIAL BASEMENT PLAN W/ W.O.D.
9R OR MORE CONDITION

THE UNDERSIGNED HAS REVIEWED AND TAKES RESPONSIBILITY FOR THIS DESIGN ON BEHALF OF GTA DESIGNS INC. AND HAS THE QUALIFICATIONS AND MEETS THE REQUIREMENTS SET OUT IN THE BUILDING CODE TO BE A DESIGNER

QUALIFICATION INFORMATION

REQUIRED UNLESS DESIGN IS EXEMPT UNDER DIVISION C 3.2.5.1 OF THE ONTARIO BUILDING CODE

DAVID DA COSTA  B.C.I.N. 32964

SIGNATURE OF DESIGNER

OBC 2012

Site Copy

ZONE I COMPLIANCE
PACKAGE "A1" REF. TABLE 3.1.1.2.A

NOTES
INSTALLATION TO COMPLY WITH THE LATEST ONTARIO BUILDING CODE.
ALL SUPPLY OUTLETS TO BE 5" DIA. UNLESS OTHERWISE SPECIFIED.
PROVIDE BALANCING DAMPERS ON ALL BRANCHES.
ALL R/A PARTITIONS 6" (FIRST FLOOR ONLY)
INSULATE DUCTS IN UNCONDITIONED SPACES R12 UNDERCUT ALL DOORS 1" MIN.
CONTRACTOR MUST WORK FROM APPROVED PLANS.
ANY ALTERATIONS TO THIS ORIGINAL PLAN ARE NOT THE RESPONSIBILITY OF GTA DESIGNS.
GTA DESIGNS MUST BE CONSULTED IF KITCHEN EXHAUST FAN EXCEEDS 700 CFM DEPRESSURIZATION MAY OCCUR WITH IN THE DWELLING.




2985 DREW ROAD
SUITE 202,
MISSISSAUGA, ONT.
L4T 0A4 TEL: 905-671-9800
EMAIL: DAVE@GTADESIGNS.CA
WEB: WWW.GTADESIGNS.CA


HEAT-LOSS	57,165	BTU/HR.
UNIT MAKE	AMANA	OR EQUAL.
UNIT MODEL	AMEC960803BNA	OR EQUAL.
UNIT HEATING INPUT	80,000	BTU/HR.
UNIT HEATING OUTPUT	76,800	BTU/HR.
A/C COOLING CAPACITY	3.0	TONS.
FAN SPEED	1172	CFM

# OF RUNS	S/A	R/A	FANS
3RD FLOOR			
2ND FLOOR	13	4	4
1ST FLOOR	10	1	2
BASEMENT	4	1	


FLOOR PLAN: PARTIAL PLAN(S)	
DRAWN BY: AM	CHECKED: DD
LAYOUT NO. JB-04587	SQFT 3330
DRAWING NO. M4	

 DATE:	APRIL 3, 2018
CLIENT:	BAYVIEW WELLINGTON
MODEL:	S42-5 RIDEAU 5
PROJECT:	GREEN VALLEY EAST BRADFORD,ONT.
SCALE:	3/16" = 1'-0"


	FLEX DUCT		LOW/HIGH WALL/KICK SUPPLY DIFFUSER		DUCT CONNECTION TO JOIST LINING		RETURN AIR GRILLE (SIZE INDICATED ON DRAWING)	S.A.	SUPPLY AIR
	RIGID ROUND DUCT		HRV EXHAUST GRILLE		RETURN AIR PIPE RISER		RETURN AIR RISER UP TO FLOOR ABOVE	R.A.	RETURN AIR
	SUPPLY DIFFUSER		SUPPLY AIR PIPE RISER		RETURN ROUND DUCT		RETURN AIR FROM BASEMENT SECOND FLOOR		THERMOSTAT
			VOLUME DAMPER						PRINCIPAL EXHAUST FAN SWITCH
									W/R & PRINCIPAL EXHAUST FAN

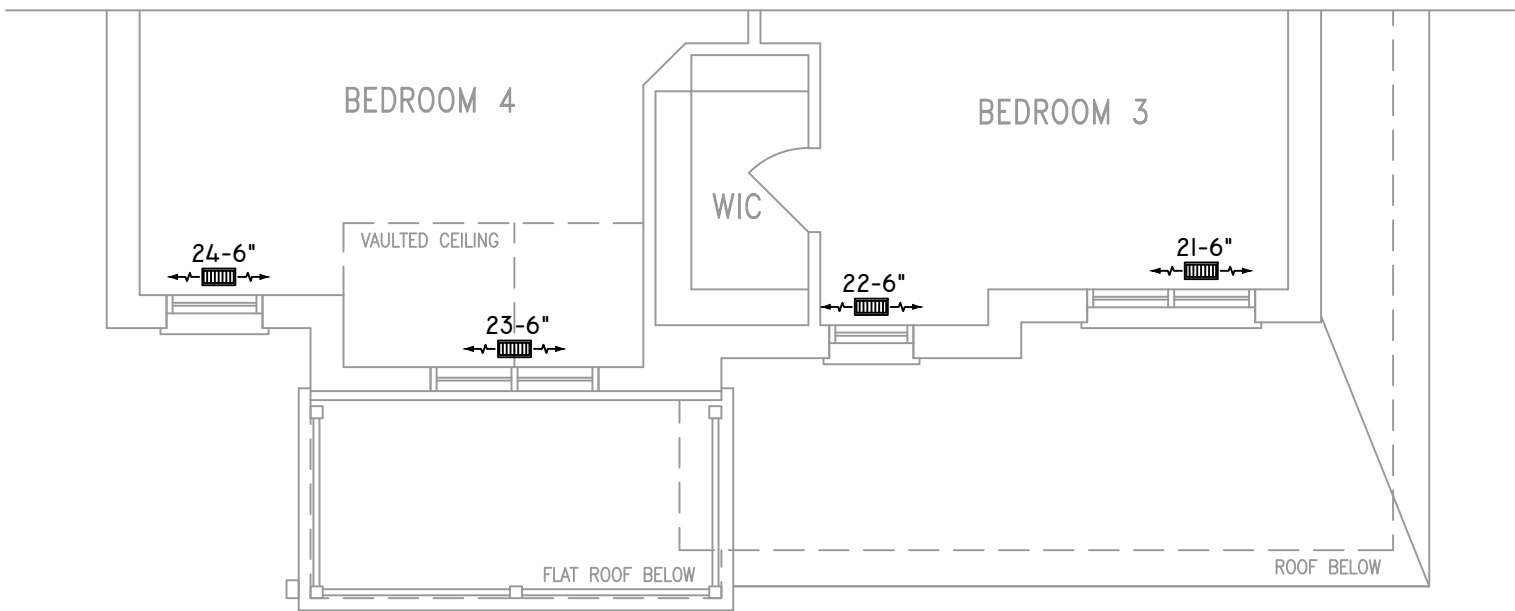

PARTIAL STD./OPT. SECOND FLOOR PLAN 'B'

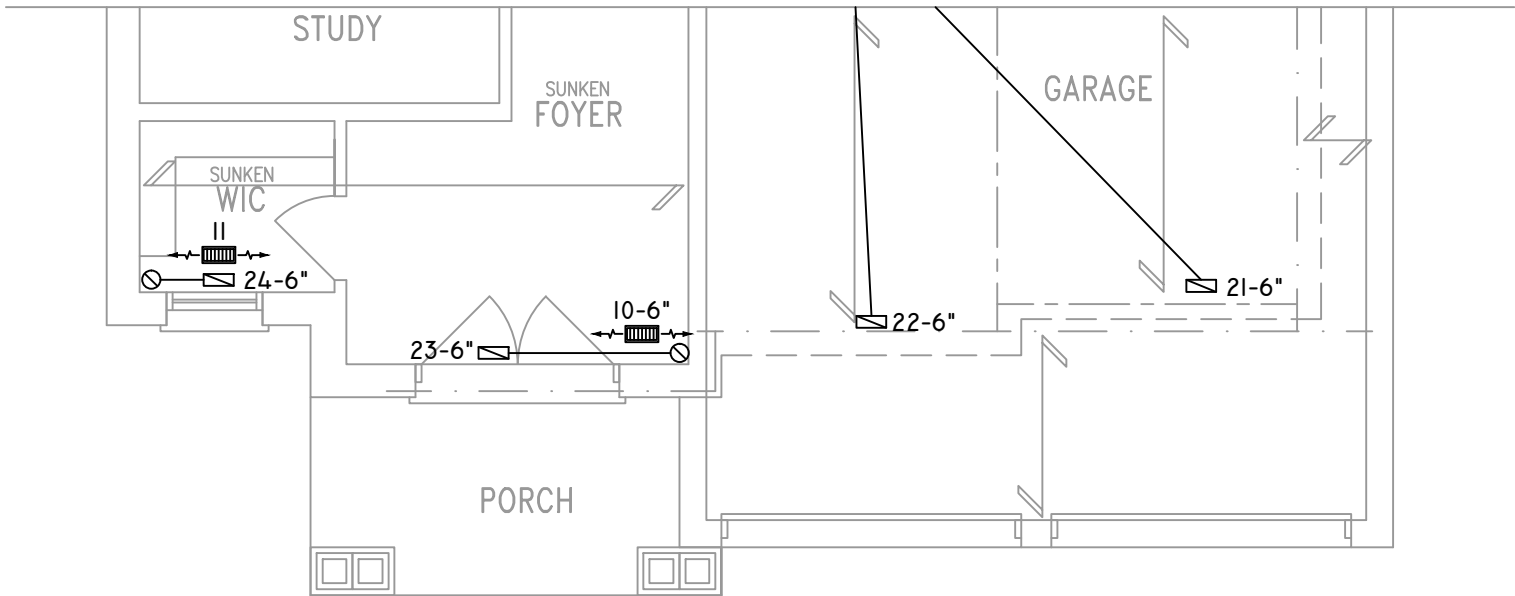

PARTIAL GROUND FLOOR PLAN 'B'

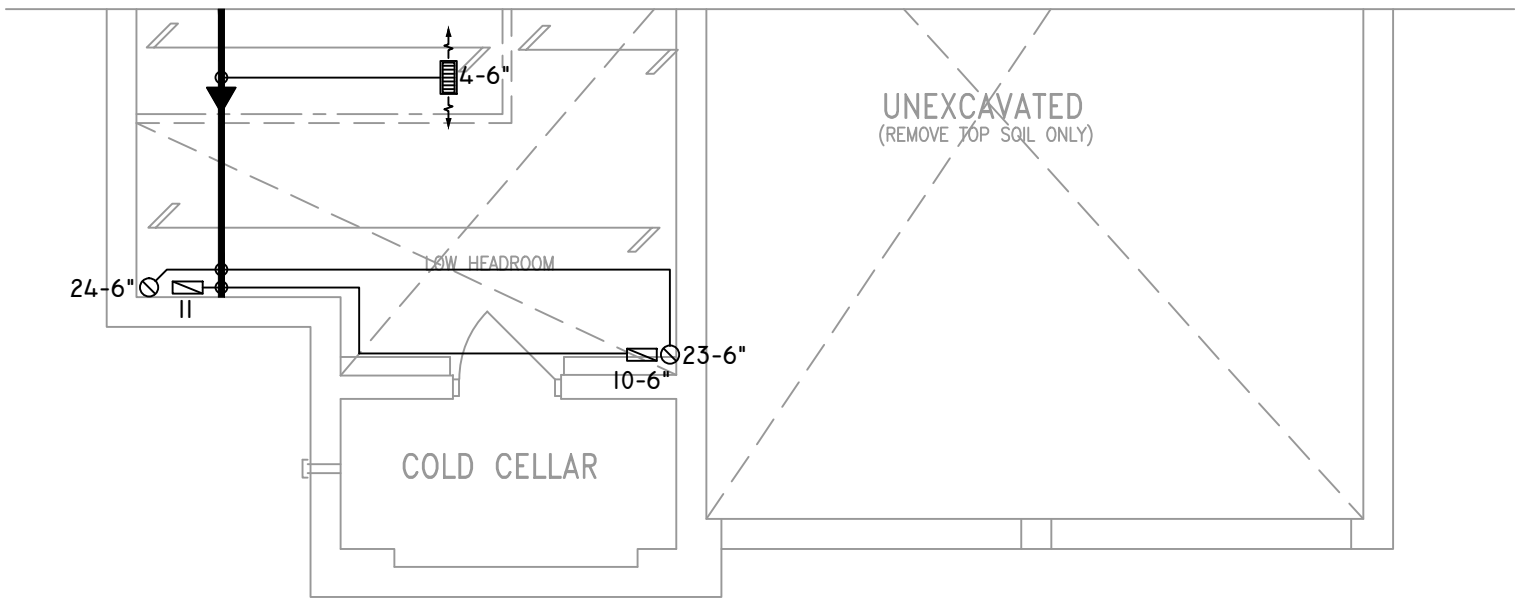

PARTIAL BASEMENT PLAN 'B'

THE UNDERSIGNED HAS REVIEWED AND TAKES RESPONSIBILITY FOR THIS DESIGN ON BEHALF OF GTA DESIGNS INC. AND HAS THE QUALIFICATIONS AND MEETS THE REQUIREMENTS SET OUT IN THE BUILDING CODE TO BE A DESIGNER

QUALIFICATION INFORMATION

REQUIRED UNLESS DESIGN IS EXEMPT UNDER DIVISION C 3.2.5.1 OF THE ONTARIO BUILDING CODE

DAVID DA COSTA  B.C.I.N. 32964

SIGNATURE OF DESIGNER

OBC 2012

Site Copy

ZONE I COMPLIANCE
PACKAGE "A1" REF. TABLE 3.1.1.2.A

NOTES
INSTALLATION TO COMPLY WITH THE LATEST ONTARIO BUILDING CODE.
ALL SUPPLY OUTLETS TO BE 5" DIA. UNLESS OTHERWISE SPECIFIED.
PROVIDE BALANCING DAMPERS ON ALL BRANCHES.
ALL R/A PARTITIONS 6" (FIRST FLOOR ONLY)
INSULATE DUCTS IN UNCONDITIONED SPACES R12 UNDERCUT ALL DOORS 1" MIN.
CONTRACTOR MUST WORK FROM APPROVED PLANS.
ANY ALTERATIONS TO THIS ORIGINAL PLAN ARE NOT THE RESPONSIBILITY OF GTA DESIGNS.
GTA DESIGNS MUST BE CONSULTED IF KITCHEN EXHAUST FAN EXCEEDS 700 CFM DEPRESSURIZATION MAY OCCUR WITH IN THE DWELLING.




2985 DREW ROAD
SUITE 202,
MISSISSAUGA, ONT.
L4T 0A4 TEL: 905-671-9800
EMAIL: DAVE@GTADESIGNS.CA
WEB: WWW.GTADESIGNS.CA


HEAT-LOSS	57,165	BTU/HR.
UNIT MAKE	AMANA	OR EQUAL.
UNIT MODEL	AMEC960803BNA	OR EQUAL.
UNIT HEATING INPUT	80,000	BTU/HR.
UNIT HEATING OUTPUT	76,800	BTU/HR.
A/C COOLING CAPACITY	3.0	TONS.
FAN SPEED	1172	CFM

# OF RUNS	S/A	R/A	FANS
3RD FLOOR			
2ND FLOOR	13	4	4
1ST FLOOR	10	1	2
BASEMENT	4	1	


FLOOR PLAN:	
PARTIAL PLAN(S)	
DRAWN BY: AM	CHECKED: DD
LAYOUT NO. JB-04587	SQFT 3330
DRAWING NO. M5	

 DATE:	APRIL 3, 2018
CLIENT:	BAYVIEW WELLINGTON
MODEL:	S42-5 RIDEAU 5
PROJECT:	GREEN VALLEY EAST BRADFORD,ONT.
SCALE:	3/16" = 1'-0"


	FLEX DUCT		LOW/HIGH WALL/KICK SUPPLY DIFFUSER		DUCT CONNECTION TO JOIST LINING		RETURN AIR GRILLE (SIZE INDICATED ON DRAWING)	S.A.	SUPPLY AIR
	RIGID ROUND DUCT		HRV EXHAUST GRILLE		RETURN AIR PIPE RISER		RETURN AIR RISER UP TO FLOOR ABOVE	R.A.	RETURN AIR
	SUPPLY DIFFUSER		SUPPLY AIR PIPE RISER		RETURN ROUND DUCT		RETURN AIR FROM BASEMENT SECOND FLOOR		THERMOSTAT
			VOLUME DAMPER						PRINCIPAL EXHAUST FAN SWITCH
									W/R & PRINCIPAL EXHAUST FAN

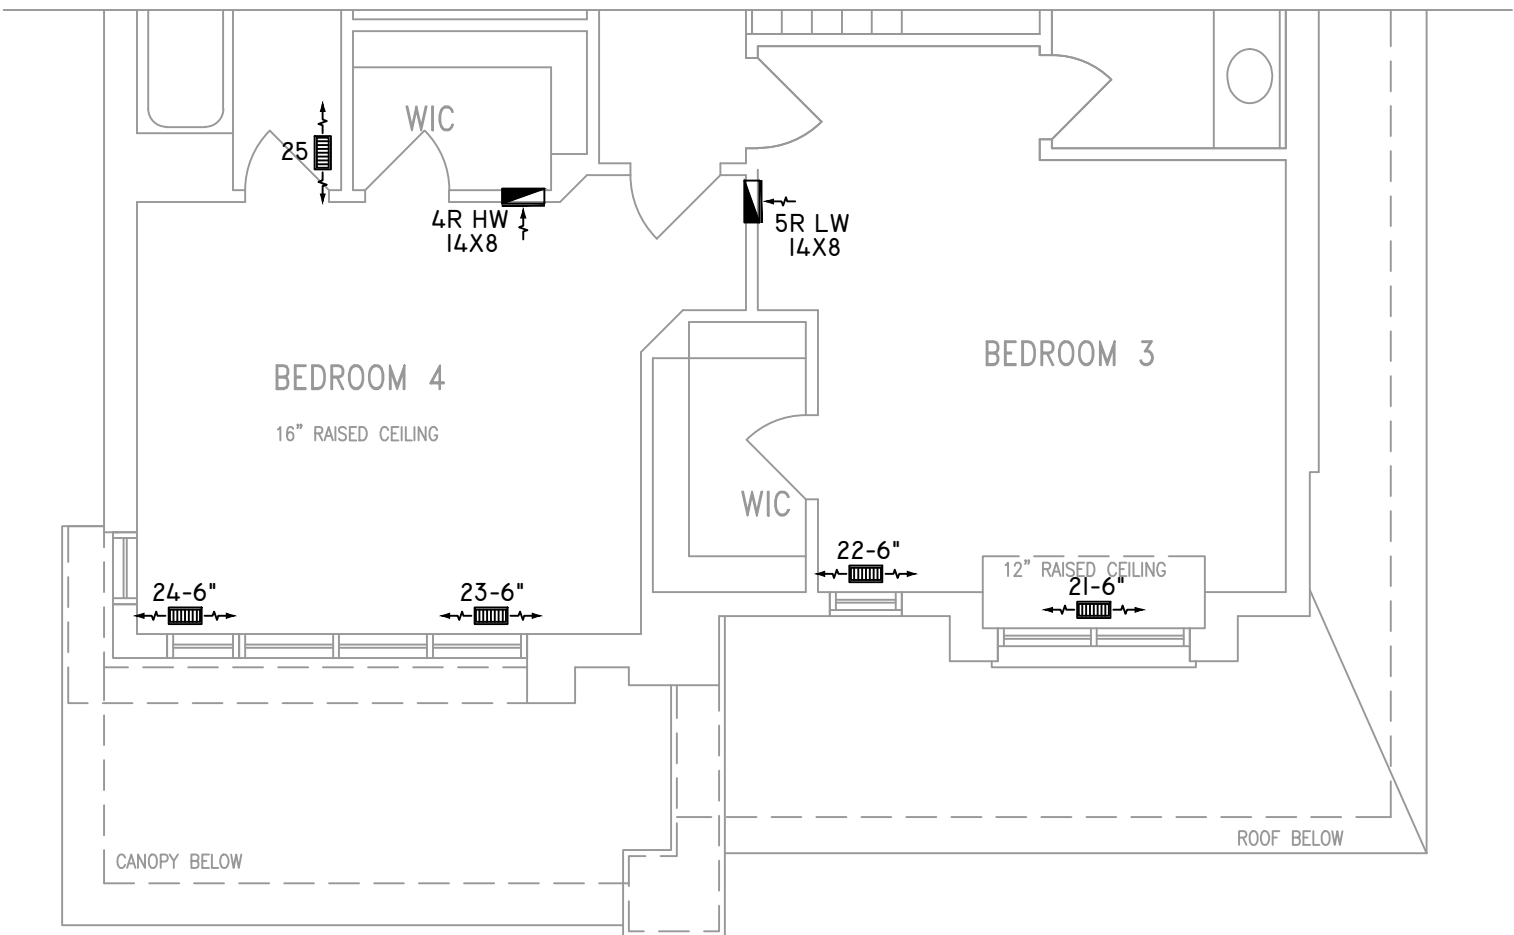

PARTIAL STD. SECOND FLOOR PLAN 'C'

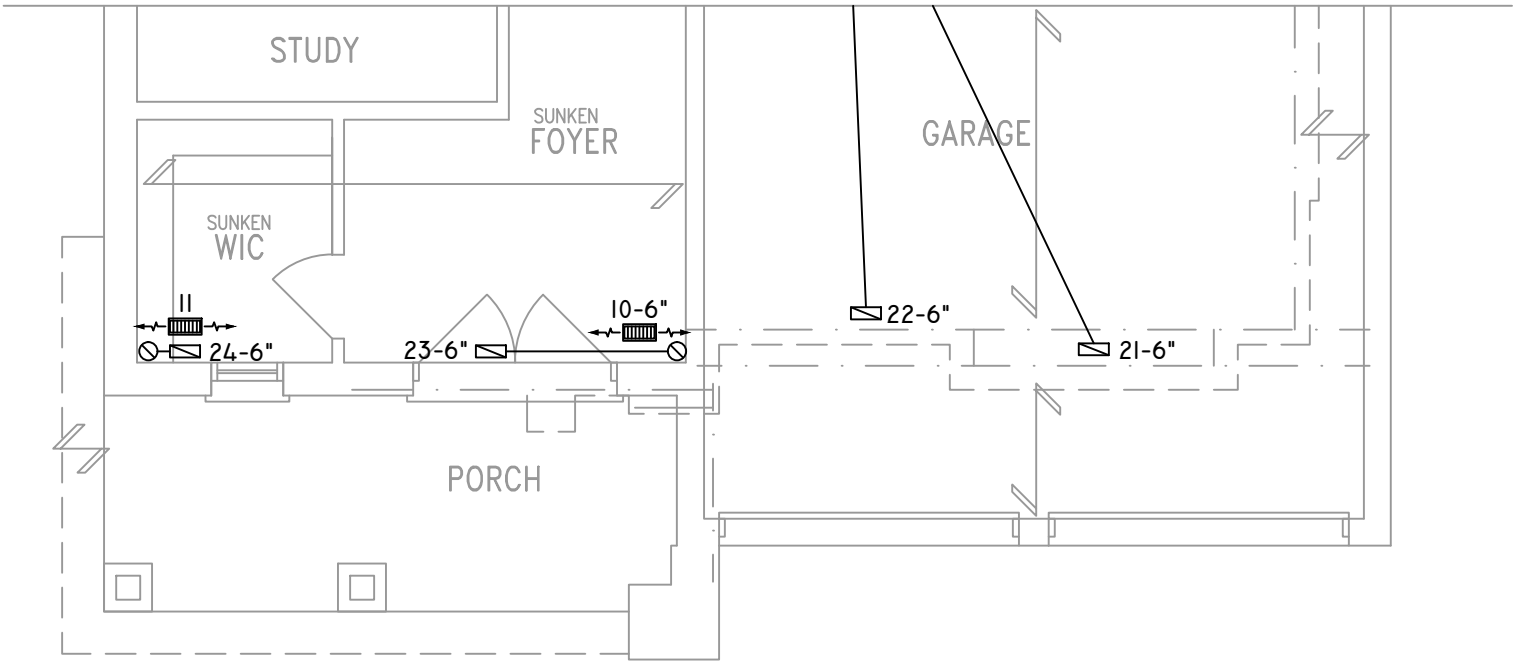

PARTIAL GROUND FLOOR PLAN 'C'

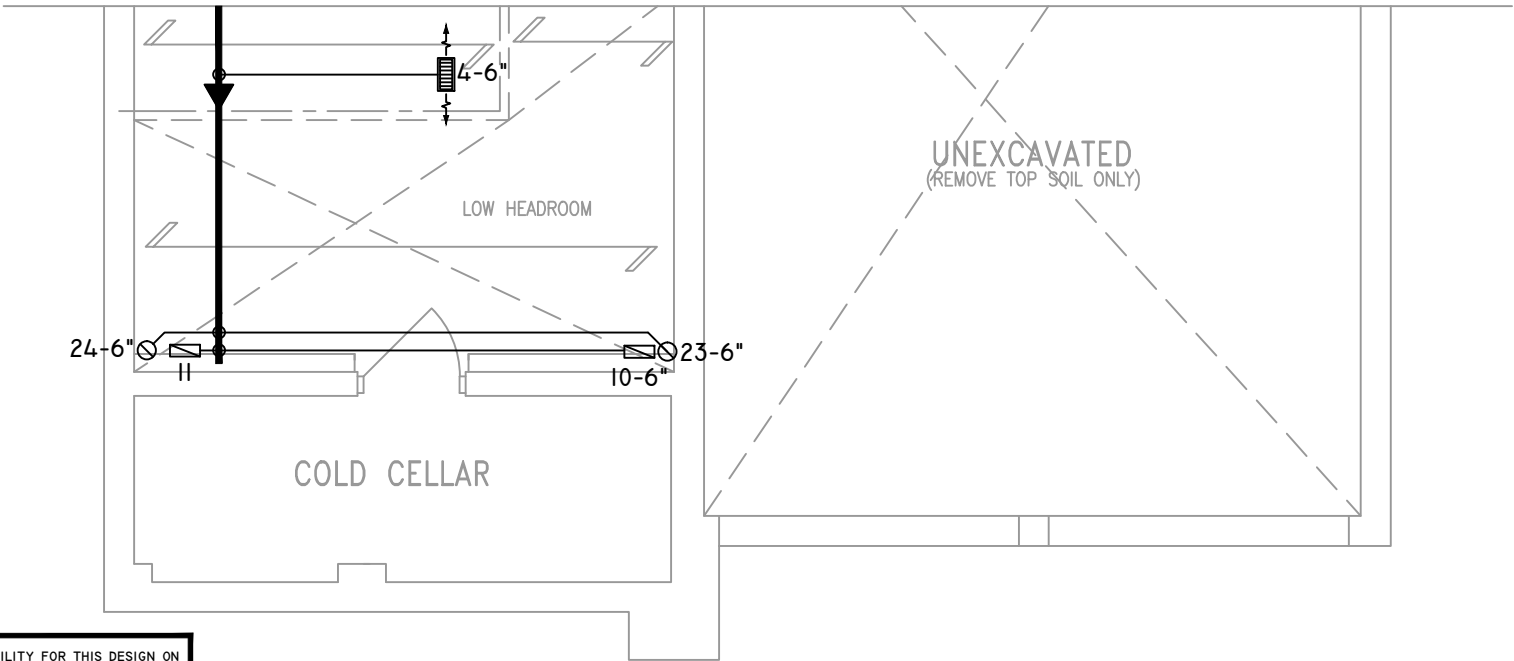

PARTIAL BASEMENT PLAN 'C'

THE UNDERSIGNED HAS REVIEWED AND TAKES RESPONSIBILITY FOR THIS DESIGN ON BEHALF OF GTA DESIGNS INC. AND HAS THE QUALIFICATIONS AND MEETS THE REQUIREMENTS SET OUT IN THE BUILDING CODE TO BE A DESIGNER

QUALIFICATION INFORMATION

REQUIRED UNLESS DESIGN IS EXEMPT UNDER DIVISION C 3.2.5.1 OF THE ONTARIO BUILDING CODE

DAVID DA COSTA  B.C.I.N. 32964

SIGNATURE OF DESIGNER

OBC 2012

Site Copy

ZONE I COMPLIANCE
PACKAGE "A1" REF. TABLE 3.1.1.2.A

NOTES

INSTALLATION TO COMPLY WITH THE LATEST ONTARIO BUILDING CODE.

ALL SUPPLY OUTLETS TO BE 5" DIA. UNLESS OTHERWISE SPECIFIED.

PROVIDE BALANCING DAMPERS ON ALL BRANCHES.

ALL R/A PARTITIONS 6" (FIRST FLOOR ONLY)

INSULATE DUCTS IN UNCONDITIONED SPACES R12 UNDERCUT ALL DOORS 1" MIN.

CONTRACTOR MUST WORK FROM APPROVED PLANS.

ANY ALTERATIONS TO THIS ORIGINAL PLAN ARE NOT THE RESPONSIBILITY OF GTA DESIGNS.

GTA DESIGNS MUST BE CONSULTED IF KITCHEN EXHAUST FAN EXCEEDS 700 CFM DEPRESSURIZATION MAY OCCUR WITH IN THE DWELLING.




2985 DREW ROAD
SUITE 202,
MISSISSAUGA, ONT.
L4T 0A4 TEL: 905-671-9800
EMAIL: DAVE@GTADESIGNS.CA
WEB: WWW.GTADESIGNS.CA


HEAT-LOSS	57,165	BTU/HR.
UNIT MAKE	AMANA	OR EQUAL.
UNIT MODEL	AMEC960803BNA	OR EQUAL.
UNIT HEATING INPUT	80,000	BTU/HR.
UNIT HEATING OUTPUT	76,800	BTU/HR.
A/C COOLING CAPACITY	3.0	TONS.
FAN SPEED	1172	CFM

# OF RUNS	S/A	R/A	FANS
3RD FLOOR			
2ND FLOOR	13	4	4
1ST FLOOR	10	1	2
BASEMENT	4	1	


FLOOR PLAN:		
PARTIAL PLAN(S)		
DRAWN BY: AM	CHECKED: DD	SQFT 3330
LAYOUT NO. JB-04587	DRAWING NO. M6	

 DATE:	APRIL 3, 2018
CLIENT:	BAYVIEW WELLINGTON
MODEL:	S42-5 RIDEAU 5
PROJECT:	GREEN VALLEY EAST BRADFORD,ONT.
SCALE:	3/16" = 1'-0"


	FLEX DUCT		LOW/HIGH WALL/KICK SUPPLY DIFFUSER		DUCT CONNECTION TO JOIST LINING		RETURN AIR GRILLE (SIZE INDICATED ON DRAWING)	S.A.	SUPPLY AIR
	RIGID ROUND DUCT		HRV EXHAUST GRILLE		RETURN AIR PIPE RISER		RETURN AIR RISER UP TO FLOOR ABOVE	R.A.	RETURN AIR
	SUPPLY DIFFUSER		SUPPLY AIR PIPE RISER		RETURN ROUND DUCT		RETURN AIR FROM BASEMENT SECOND FLOOR		THERMOSTAT
			VOLUME DAMPER						PRINCIPAL EXHAUST FAN SWITCH
									W/R & PRINCIPAL EXHAUST FAN

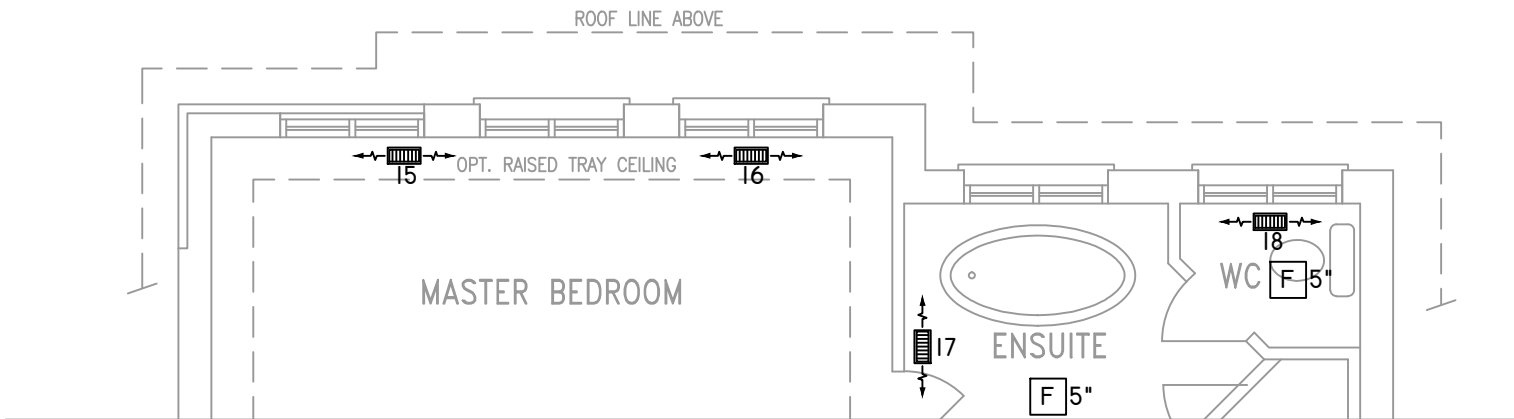


PARTIAL STD & OPT SECOND FLOOR PLAN
ELEVATION 'C' REAR UPGRADE

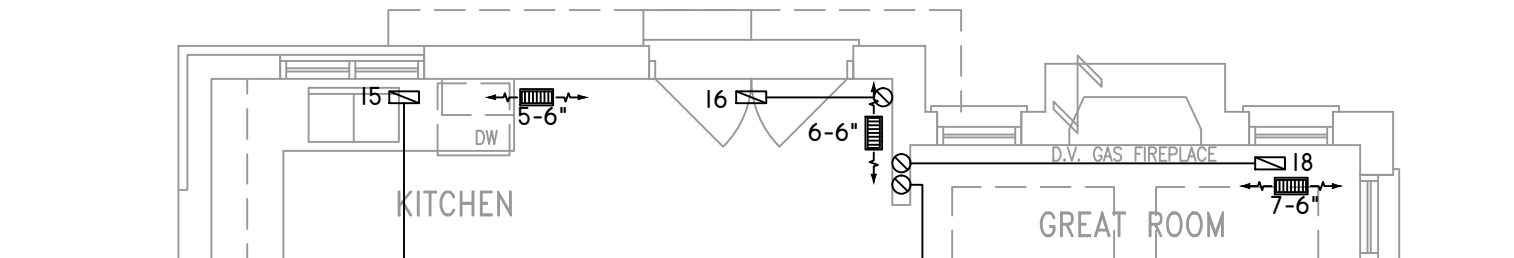

PARTIAL STD & OPT GROUND FLOOR PLAN
ELEVATION 'C' REAR UPGRADE

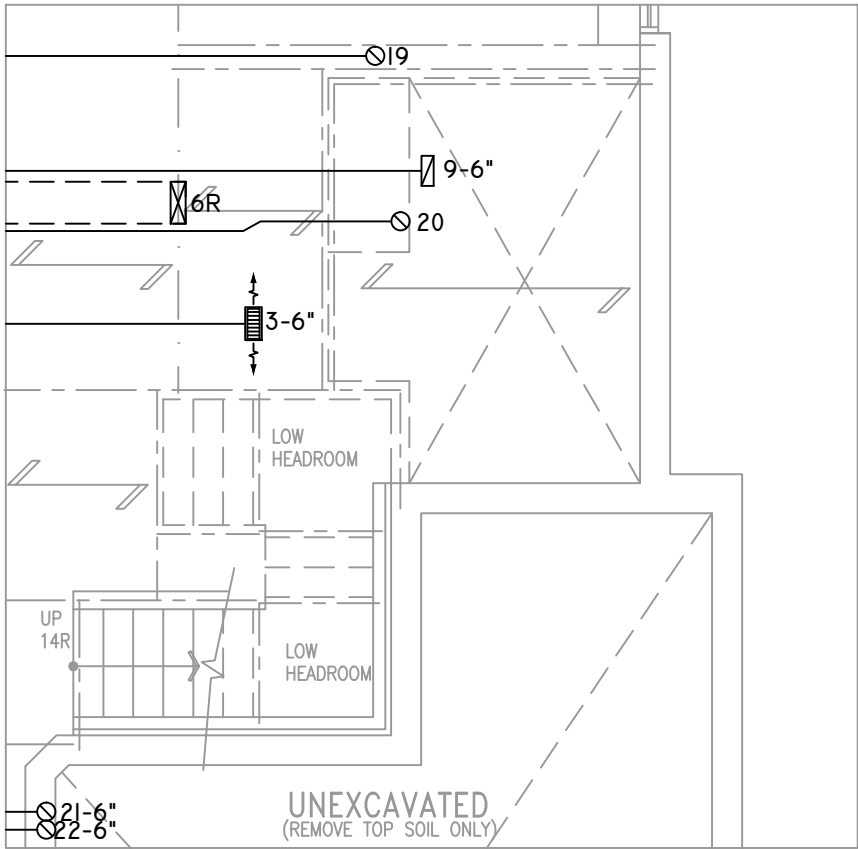

PARTIAL BASEMENT PLAN W/
SUNKEN LAUNDRY -1R

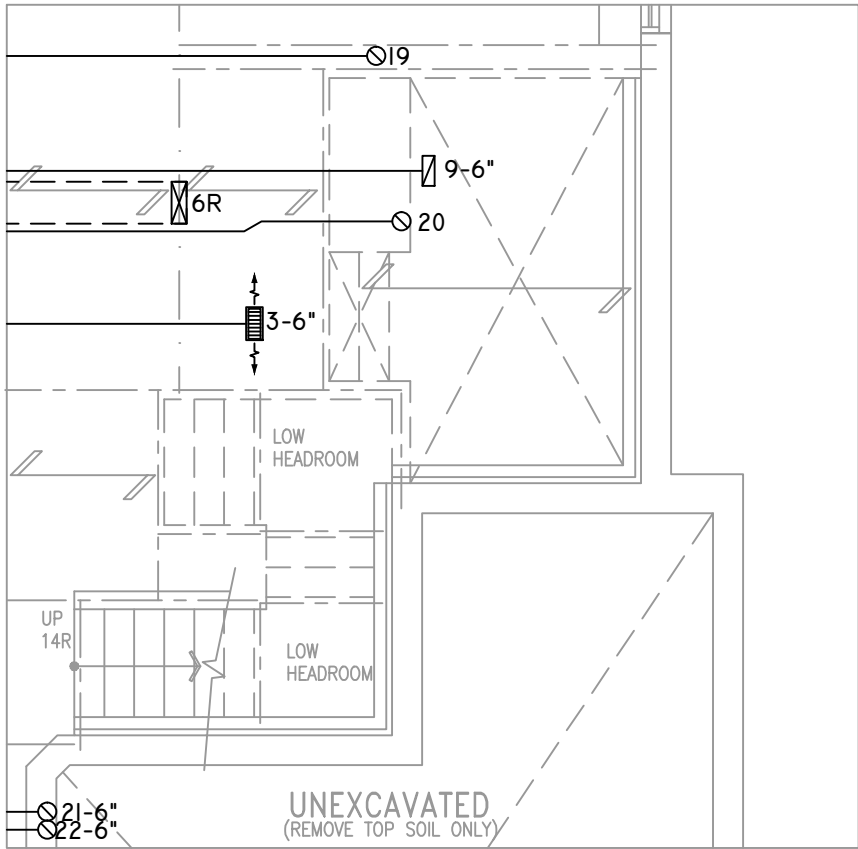

PARTIAL BASEMENT PLAN W/
SUNKEN LAUNDRY -2R TO -3R

THE UNDERSIGNED HAS REVIEWED AND TAKES RESPONSIBILITY FOR THIS DESIGN ON BEHALF OF GTA DESIGNS INC. AND HAS THE QUALIFICATIONS AND MEETS THE REQUIREMENTS SET OUT IN THE BUILDING CODE TO BE A DESIGNER

QUALIFICATION INFORMATION

REQUIRED UNLESS DESIGN IS EXEMPT UNDER DIVISION C 3.2.5.1 OF THE ONTARIO BUILDING CODE

DAVID DA COSTA



B.C.I.N. 32964

SIGNATURE OF DESIGNER

OBC 2012

Site Copy

ZONE I COMPLIANCE
PACKAGE "A1" REF. TABLE 3.1.1.2.A

NOTES
INSTALLATION TO COMPLY WITH THE LATEST ONTARIO BUILDING CODE.
ALL SUPPLY OUTLETS TO BE 5" DIA. UNLESS OTHERWISE SPECIFIED.
PROVIDE BALANCING DAMPERS ON ALL BRANCHES.
ALL R/A PARTITIONS 6" (FIRST FLOOR ONLY)
INSULATE DUCTS IN UNCONDITIONED SPACES R12 UNDERCUT ALL DOORS 1" MIN.
CONTRACTOR MUST WORK FROM APPROVED PLANS.
ANY ALTERATIONS TO THIS ORIGINAL PLAN ARE NOT THE RESPONSIBILITY OF GTA DESIGNS.
GTA DESIGNS MUST BE CONSULTED IF KITCHEN EXHAUST FAN EXCEEDS 700 CFM DEPRESSURIZATION MAY OCCUR WITH IN THE DWELLING.



2985 DREW ROAD
SUITE 202,
MISSISSAUGA, ONT.
L4T 0A4 TEL: 905-671-9800
EMAIL: DAVE@GTADESIGNS.CA
WEB: WWW.GTADESIGNS.CA

HEAT-LOSS	57,165	BTU/HR.
UNIT MAKE	AMANA	OR EQUAL.
UNIT MODEL	AMEC960803BNA	OR EQUAL.
UNIT HEATING INPUT	80,000	BTU/HR.
UNIT HEATING OUTPUT	76,800	BTU/HR.
A/C COOLING CAPACITY	3.0	TONS.
FAN SPEED	1172	CFM

# OF RUNS	S/A	R/A	FANS
3RD FLOOR			
2ND FLOOR	13	4	4
1ST FLOOR	10	1	2
BASEMENT	4	1	

FLOOR PLAN: PARTIAL PLAN(S)	
DRAWN BY: AM	CHECKED: DD
LAYOUT NO: JB-04587	DRAWING NO: M7
SQFT 3330	

DATE:	APRIL 3, 2018
CLIENT:	BAYVIEW WELLINGTON
MODEL:	S42-5 RIDEAU 5
PROJECT:	GREEN VALLEY EAST BRADFORD,ONT.
SCALE:	3/16" = 1'-0"