


Use one form for each individual who reviews and takes responsibility for design activities with respect to the project.

A. Project Information					
Building number, street name Rideau 8 S42-8C Alt. 2nd FLR				Lot: Lot/con.	
Municipality Bradford		Postal code	Plan number/ other description		
B. Individual who reviews and takes responsibility for design activities					
Name David DaCosta			Firm gtaDesigns Inc.		
Street address 2985 Drew Road, Suite 202				Unit no.	Lot/con.
Municipality Mississauga		Postal code L4T 0A4	Province Ontario	E-mail dave@gtadesigns.ca	
Telephone number (905) 671-9800		Fax number (647) 494-9643		Cell number (416) 268-6820	
C. Design activities undertaken by individual identified in Section B. [Building Code Table 3.5.2.1 of Division C]					
<input type="checkbox"/> House		<input checked="" type="checkbox"/> HVAC – House		<input type="checkbox"/> Building Structural	
<input type="checkbox"/> Small Buildings		<input type="checkbox"/> Building Services		<input type="checkbox"/> Plumbing – House	
<input type="checkbox"/> Large Buildings		<input type="checkbox"/> Detection, Lighting and Power		<input type="checkbox"/> Plumbing – All Buildings	
<input type="checkbox"/> Complex Buildings		<input type="checkbox"/> Fire Protection		<input type="checkbox"/> On-site Sewage Systems	
Description of designer's work				Model Certification	
				Project #:	PJ-00204
				Layout #:	JB-04615
Heating and Cooling Load Calculations		Main		Builder	Bayview Wellington
Air System Design		Alternate x		Project	Green Valley East
Residential mechanical ventilation Design Summary		Area Sq ft: 3454		Model	Rideau 8
Residential System Design per CAN/CSA-F280-12					S42-8C Alt. 2nd FLR
Residential New Construction - Forced Air				SB-12	Package A1
D. Declaration of Designer					
<p>I, <u>David DaCosta</u> declare that (choose one as appropriate):</p> <p>(print name)</p> <p><input type="checkbox"/> I review and take responsibility for the design work on behalf of a firm registered under subsection 3.2.4 Division C of the Building Code. I am qualified, and the firm is registered, in the appropriate classes/categories.</p> <p>Individual BCIN: _____</p> <p>Firm BCIN: _____</p> <p><input checked="" type="checkbox"/> I review and take responsibility for the design and am qualified in the appropriate category as an "other designer" under subsection 3.2.5 of Division C, of the Building Code.</p> <p>Individual BCIN: <u>32964</u></p> <p>Basis for exemption from registration: <u>Division C 3.2.4.1. (4)</u></p> <p><input type="checkbox"/> The design work is exempt from the registration and qualification requirements of the Building Code.</p> <p>Basis for exemption from registration and qualification:</p>					
<p>I certify that:</p> <p>1. The information contained in this schedule is true to the best of my knowledge.</p> <p>2. I have submitted this application with the knowledge and consent of the firm.</p>					
<p><u>April 4, 2018</u></p> <p>Date</p>			<p></p> <p>Signature of Designer</p>		

NOTE:

- For the purposes of this form, "individual" means the "person" referred to in Clause 3.2.4.7(1) d), of Division C, Article 3.2.5.1. of Division C and all other persons who are exempt from qualifications under Subsections 3.2.4 . and 3.2.5. of Division C.
- Schedule 1 does not require to be completed a holder of a license, temporary license, or a certificate of authorization, issued by the Ontario Association of Architects. Schedule 1 is also not required to be completed by a holder of a license to practise, a limited licence to practise, or a certificate of authorization, issued by the Association of Professional Engineers of Ontario.

Heat loss and gain calculation summary sheet				CSA-F280-M12 Standard Form No. 1	
These documents issued for the use of Bayview Wellington				Layout No.	
and may not be used by any other persons without authorization. Documents for permit and/or construction are signed in red.				JB-04615	
Building Location					
Address (Model): S42-8C Alt. 2nd FLR			Site: Green Valley East		
Model: Rideau 8			Lot:		
City and Province: Bradford			Postal code:		
Calculations based on					
Dimensional information based on:			VA3 Design Jan/2018		
Attachment: Detached			Front facing: East/West		Assumed? Yes
No. of Levels: 3 Ventilated? Included			Air tightness: 1961-Present (ACH=3.57)		Assumed? Yes
Weather location: Bradford			Wind exposure: Sheltered		
HRV? LifeBreath RNC155			Internal shading: Light-translucent		Occupants: 6
Sensible Eff. at -25C 71%		Apparent Effect. at -0C 84%	Units: Imperial		Area Sq ft: 3454
Sensible Eff. at -0C 75%					
Heating design conditions			Cooling design conditions		
Outdoor temp -9.4 Indoor temp: 72 Mean soil temp: 48			Outdoor temp 86 Indoor temp: 75 Latitude: 44		
Above grade walls			Below grade walls		
Style A: As per OBC SB12 Package A1 R 22			Style A: As per OBC SB12 Package A1 R 20ci		
Style B: Existing Walls (When Applicable) R 12			Style B:		
Style C:			Style C:		
Style D:			Style D:		
Floors on soil			Ceilings		
Style A: As per Selected OBC SB12 Package A1			Style A: As per Selected OBC SB12 Package A1 R 60		
Style B:			Style B: As per Selected OBC SB12 Package A1 R 31		
Exposed floors			Style C:		
Style A: As per Selected OBC SB12 Package A1 R 31			Doors		
Style B:			Style A: As per Selected OBC SB12 Package A1 R 4.00		
Windows			Style B:		
Style A: As per Selected OBC SB12 Package A1 R 3.55			Style C:		
Style B: Existing Windows (When Applicable) R 1.99			Skylights		
Style C:			Style A: As per Selected OBC SB12 Package A1 R 2.03		
Style D:			Style B:		
Attached documents: As per Shedule 1		Heat Loss/Gain Caculations based on CSA-F280-12 Effective R-Values			
Notes: Residential New Construction - Forced Air					
Calculations performed by					
Name: David DaCosta			Postal code: L4T 0A4		
Company: gtaDesigns Inc.			Telephone: (905) 671-9800		
Address: 2985 Drew Road, Suite 202			Fax: (416) 268-6820		
City: Mississauga			E-mail dave@gtadesigns.ca		

Builder: **Bayview Wellington**

Date: **April 4, 2018**

Project: **Green Valley East**

Model: **S42-8C Alt. 2nd FLR**

System 1

I review and take responsibility for the design work and am qualified in the appropriate category as an "other designer" under Division C subsection 3.2.5. of the Building Code.

Individual BCIN: 32964 *David DaCosta* David DaCosta

Page 3
Project # **PJ-00204**
Layout # **JB-04615**

DESIGN LOAD SPECIFICATIONS				AIR DISTRIBUTION & PRESSURE				FURNACE/AIR HANDLER DATA:				BOILER/WATER HEATER DATA:				A/C UNIT DATA:			
Level 1 Net Load	18,384	btu/h		Equipment External Static Pressure	0.5	"w.c.		Make	Amana			Make	Type	Amana	3.0	Ton			
Level 2 Net Load	21,267	btu/h		Additional Equipment Pressure Drop	0.225	"w.c.		Model	AMEC960803BNA			Model		Cond.-----	3.0				
Level 3 Net Load	21,455	btu/h		Available Design Pressure	0.275	"w.c.		Input Btu/h	80000			Input Btu/h		Coil -----	3.0				
Level 4 Net Load	0	btu/h		Return Branch Longest Effective Length	300	ft		Output Btu/h	76800			Output Btu/h							
Total Heat Loss	61,107	btu/h		R/A Plenum Pressure	0.138	"w.c.		E.s.p.	0.50	" W.C.		Min.Output Btu/h	AWH						
Total Heat Gain	35,110	btu/h		S/A Plenum Pressure	0.14	"w.c.		Water Temp	deg. F.			Blower DATA:							
Combo System HL + 10%	67,217	Btu/h		Heating Air Flow Proportioning Factor	0.0192	cfm/btuh		AFUE	96%			Blower Speed Selected:	W2	Blower Type	ECM				
Building Volume Vb	40445	ft³		Cooling Air Flow Proportioning Factor	0.0334	cfm/btuh		Aux. Heat						(Brushless DC OBC 12.3.1.5.(2))					
Ventilation Load	1,342	Btu/h		R/A Temp	70	deg. F.		SB-12 Package	Package A1			Heating Check	1172	cfm	Cooling Check	1172	cfm		
Ventilation PVC	95.4	cfm		S/A Temp	131	deg. F.						Selected cfm>	1172	cfm	Cooling Air Flow Rate	1172	cfm		
Supply Branch and Grill Sizing				Diffuser loss	0.01	"w.c.		Temp. Rise>>>	61	deg. F.									

	Level 1														Level 2													
S/A Outlet No.	1	2	3	4											5	6	7	8	9	10	11	12	13	14				
Room Use	BASE	BASE	BASE	BASE											KIT	KIT	LAUN	STUDY	STUDY	FOY	LIV/DIN	LIV/DIN	GRT	GRT				
Btu/Outlet	4596	4596	4596	4596											2114	2114	3304	2573	2573	2407	1468	1468	1623	1623				
Heating Airflow Rate CFM	88	88	88	88											41	41	63	49	49	46	28	28	31	31				
Cooling Airflow Rate CFM	12	12	12	12											71	71	82	60	60	31	59	59	48	48				
Duct Design Pressure	0.13	0.13	0.13	0.13	0.13	0.13	0.13	0.13	0.13	0.13	0.13	0.13	0.13	0.13	0.13	0.13	0.13	0.13	0.13	0.13	0.13	0.13	0.13	0.13	0.13	0.13		
Actual Duct Length	33	37	29	50											36	37	53	54	59	41	38	35	47	53				
Equivalent Length	110	110	140	100	70	70	70	70	70	70	70	70	70	70	80	120	150	110	130	110	130	90	100	120	70	70	70	70
Total Effective Length	143	147	169	150	70	70	70	70	70	70	70	70	70	70	116	157	203	164	189	151	168	125	147	173	70	70	70	70
Adjusted Pressure	0.09	0.09	0.08	0.09	0.19	0.19	0.19	0.19	0.19	0.19	0.19	0.19	0.19	0.19	0.11	0.08	0.06	0.08	0.07	0.09	0.08	0.10	0.09	0.08	0.19	0.19	0.19	0.19
Duct Size Round	6	6	6	6											6	6	6	5	5	5	5	5	5	5				
Outlet Size	4x10	4x10	4x10	4x10	4x10	4x10	4x10	4x10	4x10	4x10	4x10	4x10	4x10	4x10	4x10	4x10	4x10	3x10	3x10	3x10	3x10	3x10	3x10	4x10	4x10	4x10	4x10	4x10
Trunk	C	D	E	F											C	C	E	G	G	E	E	B	D	D				

	Level 3														Level 4													
S/A Outlet No.	15	16	17	18	19	20	21	22	23	24	25	26	27	28														
Room Use	MAST	MAST	ENS	WC	WIC	BED 2	BATH	BED 3	BED 3	BED 4	BED 4	ENS 3	BED 5	ENS 4														
Btu/Outlet	1580	1580	1766	513	558	2293	1131	1949	1949	1818	1818	1151	2521	827														
Heating Airflow Rate CFM	30	30	34	10	11	44	22	37	37	35	35	22	48	16														
Cooling Airflow Rate CFM	46	46	43	6	5	69	10	41	41	57	57	27	71	16														
Duct Design Pressure	0.13	0.13	0.13	0.13	0.13	0.13	0.13	0.13	0.13	0.13	0.13	0.13	0.13	0.13	0.13	0.13	0.13	0.13	0.13	0.13	0.13	0.13	0.13	0.13	0.13	0.13	0.13	0.13
Actual Duct Length	61	52	53	48	49	62	66	74	70	81	65	70	60	49														
Equivalent Length	110	125	110	165	100	120	180	170	150	145	135	155	170	100	70	70	70	70	70	70	70	70	70	70	70	70	70	70
Total Effective Length	171	177	163	213	149	182	246	244	220	226	200	225	230	149	70	70	70	70	70	70	70	70	70	70	70	70	70	70
Adjusted Pressure	0.08	0.07	0.08	0.06	0.09	0.07	0.05	0.05	0.06	0.06	0.07	0.06	0.06	0.09	0.19	0.19	0.19	0.19	0.19	0.19	0.19	0.19	0.19	0.19	0.19	0.19	0.19	0.19
Duct Size Round	5	5	5	3	3	6	4	5	5	5	5	4	6	3														
Outlet Size	3x10	3x10	3x10	3x10	3x10	4x10	3x10	3x10	3x10	3x10	3x10	3x10	4x10	3x10	4x10	4x10	4x10	4x10	4x10	4x10	4x10	4x10	4x10	4x10	4x10	4x10	4x10	4x10
Trunk	D	C	C	D	B	E	F	F	F	G	F	F	E	B														

Return Branch And Grill Sizing	Grill Pressure Loss											0.02 "w.c.
R/A Inlet No.	1R	2R	3R	4R	5R	6R	7R	8R	9R	10R	11R	
Inlet Air Volume CFM	176	434	154	154	154	100						
Duct Design Pressure	0.12	0.12	0.12	0.12	0.12	0.12	0.12	0.12	0.12	0.12	0.12	
Actual Duct Length	10	22	50	49	56	83						
Equivalent Length	150	125	200	155	155	165	50	50	50	50	50	
Total Effective Length	160	147	250	204	211	248	50	50	50	50	50	
Adjusted Pressure	0.07	0.08	0.05	0.06	0.06	0.05	0.24	0.24	0.24	0.24	0.24	
Duct Size Round	7.0	11.0	8.0	8.0	8.0	6.0						
Inlet Size	FLC	8	8	8	8	8						
" "	x	x	x	x	x	x	x	x	x	x	x	
Inlet Size		30	14	14	14	14						
Trunk	Z	Z	Z	Z	Y	Y						

Return Trunk Duct Sizing	Trunk	CFM	Press.	Round	Rect. Size
Drop		1172	0.05	17.0	24x12
Z		1172	0.05	17.0	26x10 22x12
Y		254	0.05	10.0	12x8 10x10
X					
W					
V					
U					
T					
S					
R					
Q					

Supply Trunk Duct Sizing	Trunk	CFM	Press.	Round	Rect. Size
A		1173	0.05	17.0	26x10 22x12
B		479	0.06	12.0	16x8 12x10
C		233	0.07	9.0	8x8 10x7
D		191	0.06	8.5	8x8
E		694	0.05	14.0	22x8 18x10
F		376	0.05	11.5	14x8 12x10
G		134	0.06	7.5	8x8
H					
I					
J					
K					

2012 OBC

Builder: Bayview Wellington

Date: April 4, 2018

Project: Green Valley East

Model: Rideau 8 S42-8C Alt. 2nd FLR

System 1

Weather Data Bradford 44 -9.4 86 22 48.2

Heat Loss ^T 81.4 deg. F Ht gain ^T 11 deg. F GTA: 3454

Project # PJ-00204
Layout # JB-04615

Level 1

Run ft. exposed wall A	183	A	A	A	A	A	A	A	A	A	A	A	A
Run ft. exposed wall B	B	B	B	B	B	B	B	B	B	B	B	B	B
Ceiling height	3.7	AG	3.7	AG	3.7	AG	3.7	AG	3.7	AG	3.7	AG	3.7
Floor area	1409	Area	Area	Area	Area	Area	Area	Area	Area	Area	Area	Area	Area
Exposed Ceilings A	A	A	A	A	A	A	A	A	A	A	A	A	A
Exposed Ceilings B	B	B	B	B	B	B	B	B	B	B	B	B	B
Exposed Floors	Flr	Flr	Flr	Flr	Flr	Flr	Flr	Flr	Flr	Flr	Flr	Flr	Flr
Gross Exp Wall A	677												
Gross Exp Wall B													

Components	R-Values	Loss	Gain	Loss	Gain	Loss	Gain	Loss	Gain	Loss	Gain	Loss	Gain	Loss	Gain	Loss	Gain
North Shaded	3.55	22.93	10.91	3	69	33											
East/West	3.55	22.93	27.35	18	413	492											
South	3.55	22.93	20.89	3	69	63											
WOB Windows	3.55	22.93	27.35														
Skylight	2.03	40.10	88.23														
Doors	4.00	20.35	2.75	21	427	58											
Net exposed walls A	21.12	3.85	0.52	632		329											
Net exposed walls B	14.49	5.62	0.76														
Exposed Ceilings A	59.22	1.37	0.64														
Exposed Ceilings B	22.86	3.56	1.66														
Exposed Floors	29.80	2.73	0.17														
Foundation Conductive Heatloss	On Grade () or Above ()			7679													
Total Conductive	Heat Loss			8656													
	Heat Gain				975												
Air Leakage	Heat Loss/Gain	1.0907	0.0354	9441	34												
Ventilation	Case 1	0.08	0.06														
	Case 2	14.07	11.88														
	Case 3	x	0.03	287	62												
Heat Gain People			239														
Appliances Loads	1 = .25 percent		5753														
Duct and Pipe loss			10%														
Level 1 HL Total	18,384		Total HL for per room	18384													
Level 1 HG Total	1,392		Total HG per room x 1.3		1392												

Level 2

Run ft. exposed wall A	37	A	31	A	40	A	18	A	25	A	30	A	A	A	A	A	A
Run ft. exposed wall B	B	B	B	B	B	B	B	B	B	B	B	B	B	B	B	B	B
Ceiling height	10.0		12.0		10.0		11.0		10.0		10.0		10.0		10.0		10.0
Floor area	329	Area	208	Area	171	Area	137	Area	340	Area	213	Area	Area	Area	Area	Area	Area
Exposed Ceilings A	A	A	17	A	A	A	A	A	A	A	A	A	Area	Area	Area	Area	Area
Exposed Ceilings B	B	B	B	B	B	B	B	B	B	B	B	B	B	B	B	B	B
Exposed Floors	Flr	Flr	Flr	Flr	Flr	Flr	Flr	Flr	Flr	Flr	Flr	Flr	Flr	Flr	Flr	Flr	Flr
Gross Exp Wall A	370		372		400		198		250		300						
Gross Exp Wall B																	

Components	R-Values	Loss	Gain	Loss	Gain	Loss	Gain	Loss	Gain	Loss	Gain	Loss	Gain	Loss	Gain	Loss	Gain
North Shaded	3.55	22.93	10.91	24	550	262	12	275	131								
East/West	3.55	22.93	27.35	44	1009	1204				48	1101	1313					
South	3.55	22.93	20.89							48	1101	1003	24	550	501	49	1124
Existing Windows	1.99	40.90	22.15										16	734	875	32	734
Skylight	2.03	40.10	88.23											367	334		
Doors	4.00	20.35	2.75														
Net exposed walls A	17.03	4.78	0.65	302	1443	195	339	1620	219	304	1453	196	153	731	99	201	961
Net exposed walls B	8.50	9.58	1.29														
Exposed Ceilings A	59.22	1.37	0.64					17	23	11							
Exposed Ceilings B	22.86	3.56	1.66														
Exposed Floors	29.80	2.73	0.17														
Foundation Conductive Heatloss	On Grade () or Above ()		x														
Total Conductive	Heat Loss			3003				2346			3654			1709		2084	
	Heat Gain				1661			419			2512			658		1153	
Air Leakage	Heat Loss/Gain	0.3751	0.0354	1126	59			880	15		1371	89		641	23	782	41
Ventilation	Case 1	0.03	0.06														
	Case 2	14.07	11.88														
	Case 3	x	0.03	100	105			78	27		121	159		57	42	69	73
Heat Gain People			239														
Appliances Loads	1 = .25 percent		5753	1.0		1438	1.0		1438				1.0		1438	0.5	719
Duct and Pipe loss			10%														
Level 2 HL Total	21,267		Total HL for per room	4229		4242		3304		2468		5146		2407		2935	
Level 2 HG Total	17,649		Total HG per room x 1.3									3588		940		3517	

I review and take responsibility for the design work and am qualified in the appropriate category as an "other designer" under

Division C subsection 3.2.5. of the Building Code. Individual BCIN:

32964

Dave DaCosta

David DaCosta

SB-12 Package

Package A1

Total Heat Loss	61,107	btu/h
Total Heat Gain	35,110	btu/h

Site Copy

2012 OBC	Builder: Bayview Wellington	Date: April 4, 2018	System 1	Weather Data		Bradford	44	-9.4	86	22	48.2	Page 5
	Project: Green Valley East	Model: Rideau 8 S42-8C Alt. 2nd FLR		Heat Loss ^T	81.4 deg. F	Ht gain ^T	11 deg. F	GTA:	3454	Project # Layout #	PJ-00204 JB-04615	

Level 3	MAST	ENS	WC	WIC	BED 2	BATH	BED 3	BED 4	ENS 3	BED 5	ENS 4
Run ft. exposed wall A	30 A	19 A	6 A	8 A	21 A	6 A	32 A	26 A	10 A	16 A	9 A
Run ft. exposed wall B	B	B	B	B	B	B	B	B	B	B	B
Ceiling height	9.0	8.0	8.0	8.0	8.0	8.0	9.0	9.0	8.0	10.0	8.0
Floor area	266 Area	135 Area	24 Area	100 Area	298 Area	108 Area	195 Area	206 Area	96 Area	226 Area	69 Area
Exposed Ceilings A	266 A	135 A	24 A	100 A	298 A	108 A	195 A	206 A	96 A	226 A	69 A
Exposed Ceilings B	B	B	B	B	B	B	B	B	B	B	B
Exposed Floors	Flr	Flr	Flr	Flr	43 Flr	108 Flr	178 Flr	12 Flr	Flr	Flr	Flr
Gross Exp Wall A	270	152	48	64	168	48	288	234	80	160	72
Gross Exp Wall B											
Components	R-Values	Loss	Gain	Loss	Gain	Loss	Gain	Loss	Gain	Loss	Gain
North Shaded	3.55	22.93	10.91								
East/West	3.55	22.93	27.35	33	757	903					
South	3.55	22.93	20.89	14	321	292					
Existing Windows	1.99	40.90	22.15								
Skylight	2.03	40.10	88.23								
Doors	4.00	20.35	2.75								
Net exposed walls A	17.03	4.78	0.65	223	1066	144	125	597	81	40	191
Net exposed walls B	8.50	9.58	1.29								
Exposed Ceilings A	59.22	1.37	0.64	266	366	171	135	186	87	24	33
Exposed Ceilings B	22.86	3.56	1.66								
Exposed Floors	29.80	2.73	0.17								
Foundation Conductive Heatloss											
Total Conductive											
Air Leakage	Heat Loss/Gain	0.2264	0.0354								
Ventilation	Case 1	0.02	0.06								
	Case 2	14.07	11.88								
	Case 3	x	0.03	0.06							
Heat Gain People			239	2	83	96	478	47	57	14	8
Appliances Loads	1 =.25 percent		5753								
Duct and Pipe loss			10%								
Level 3 HL Total	21,455			3161				1766		513	
Level 3 HG Total	16,069				2778				1294		184

Level 4	A	A	A	A	A	A	A	A	A	A	A
Run ft. exposed wall A	B	B	B	B	B	B	B	B	B	B	B
Run ft. exposed wall B											
Ceiling height											
Floor area	Area	Area	Area	Area	Area	Area	Area	Area	Area	Area	Area
Exposed Ceilings A	A	A	A	A	A	A	A	A	A	A	A
Exposed Ceilings B	B	B	B	B	B	B	B	B	B	B	B
Exposed Floors	Flr	Flr	Flr	Flr	Flr	Flr	Flr	Flr	Flr	Flr	Flr
Gross Exp Wall A											
Gross Exp Wall B											
Components	R-Values	Loss	Gain	Loss	Gain	Loss	Gain	Loss	Gain	Loss	Gain
North Shaded	3.55	22.93	10.91								
East/West	3.55	22.93	27.35								
South	3.55	22.93	20.89								
Existing Windows	1.99	40.90	22.15								
Skylight	2.03	40.10	88.23								
Doors	4.00	20.35	2.75								
Net exposed walls A	17.03	4.78	0.65								
Net exposed walls B	8.50	9.58	1.29								
Exposed Ceilings A	59.22	1.37	0.64								
Exposed Ceilings B	22.86	3.56	1.66								
Exposed Floors	29.80	2.73	0.17								
Foundation Conductive Heatloss											
Total Conductive											
Air Leakage	Heat Loss/Gain	0.0000	0.0354								
Ventilation	Case 1	0.00	0.06								
	Case 2	14.07	11.88								
	Case 3	x	0.03	0.06							
Heat Gain People			239								
Appliances Loads	1 =.25 percent		5753								
Duct and Pipe loss			10%								
Level 4 HL Total	0										
Level 4 HG Total	0										

Total Heat Loss	61,107	btu/h
Total Heat Gain	35,110	btu/h

I review and take responsibility for the design work and am qualified in the appropriate category as an "other designer" under Division C subsection 3.2.5. of the Building Code. Individual BCIN: 32964

David DaCosta

SB-12 Package

Package A1

Site Copy

I review and take responsibility for the design work and am qualified in the appropriate category as an "other designer" under Division C subsection 3.2.5. of the Building Code.

Individual BCIN: 32964



David DaCosta

Package: Package A1
Project: Bradford
Model: S42-8C Alt. 2nd FLR

RESIDENTIAL MECHANICAL VENTILATION DESIGN SUMMARY

For systems serving one dwelling unit & conforming to the Ontario Building Code, O.reg 332/12

Location of Installation	
Lot #	Plan #
Township	Bradford
Roll #	Permit #
Address	

Builder	
Name	Bayview Wellington
Address	
City	
Tel	Fax

Installing Contractor	
Name	
Address	
City	
Tel	Fax

Combustion Appliances 9.32.3.1(1)		
a)	x	Direct vent (sealed combustion) only
b)		Positive venting induced draft (except fireplaces)
c)		Natural draft, B-vent or induced draft fireplaces
d)		Solid fuel (including fireplaces)
e)		No combustion Appliances

Heating System		
x	Forced air	
	Non forced air	
	Electric space heat (if over 10% of heat load)	

House Type 9.32.3.1(2)		
I	x	Type a) or b) appliances only, no solid fuel
II		Type I except with solid fuel (including fireplace)
III		Any type c) appliance
IV		Type I or II either electric space heat
Other		Type I, II or IV no forced air

System Design Option		
1	Exhaust only / forced air system	
2	HRV WITH DUCTING / forced air system	
3	HRV simplified connection to forced air system	
4	HRV full ducting/not coupled to forced air system	
	Part 6 design	

Total Ventilation Capacity 9.32.3.3(1)				
Bsmt & Master Bdrm	2	@	21.2 cfm	42.4 cfm
Other Bedrooms	4	@	10.6 cfm	42.4 cfm
Bathrooms & Kitchen	6	@	10.6 cfm	63.6 cfm
Other rooms	6	@	10.6 cfm	63.6 cfm
Total				<u>212</u>

Principal Ventilation Capacity 9.32.3.4(1)				
Master bedroom	1	@	31.8 cfm	31.8 cfm
Other bedrooms	4	@	15.9 cfm	63.6 cfm
Total				<u>95.4</u>

 
Principal Exhaust Fan Capacity				
Make	Model		Location	
LifeBreath	RNC155		Base	
132 cfm			Sones	or Equiv.

Heat Recovery Ventilator			
Make	LifeBreath		
Model	RNC155		
	132 cfm high		80 cfm low
Sensible efficiency @ -25 deg C			71%
Sensible efficiency @ 0 deg C			75%

Note: Installer to balance HRV/ERV to within 10 percent of PVC

Supplemental Ventilation Capacity		
Total ventilation capacity	212.0	
Less principal exhaust capacity	95.4	
REQUIRED supplemental vent. Capacity	<u>116.6</u> cfm	

Supplemental Fans 9.32.3.5.			
Location	cfm	Model	Sones
Ens	50	XB50	0.3
Bath	50	XB50	0.3
Ens 3	50	XB50	0.3
all fans HVI listed			
Make	Broan		or Equiv.

Designer Certification			
I hereby certify that this ventilation system has been designed in accordance with the Ontario Building Code.			
Name	David DaCosta		
Signature			
HRAI #	5190	BCIN #	32964
Date	April 4, 2018		



2985 Drew Road, Suite 202, Mississauga, Ontario
L4T 0A4 Tel: 905-671-9800 Fax: 647-494-9643
e-mail dave@gtadesigns.ca

Energy Efficiency Design Summary: Prescriptive Method (Building Code Part 9, Residential)

Page 7
Project # PJ-00204
Layout # JB-04615

This form is used by a designer to demonstrate that the energy efficiency design of a house complies with the building code using the prescriptive method described in Subsection 3.1.1. of SB-12. This form is applicable where the ratio of gross area of windows/sidelights/skylights/glazing in doors and sliding glass doors to the gross area of peripheral walls is not more than 22%.

For use by Principal Authority

Application No:

Model/Certification Number

A. Project Information

Building number, street name Rideau 8 S42-8C Alt. 2nd FLR		Unit number	Lot/Con
Municipality Bradford	Postal code	Reg. Plan number / other description	

B. Prescriptive Compliance [indicate the building code compliance package being employed in the house design]

SB-12 Prescriptive (input design package):

Package A1

Table: 3.1.1.2.A

C. Project Design Conditions

Climatic Zone (SB-1):	Heat. Equip. Efficiency	Space Heating Fuel Source		
<input checked="" type="checkbox"/> Zone 1 (< 5000 degree days) <input type="checkbox"/> Zone 2 (≥ 5000 degree days)	<input checked="" type="checkbox"/> ≥ 92% AFUE <input type="checkbox"/> ≥ 84% < 92% AFUE	<input checked="" type="checkbox"/> Gas <input type="checkbox"/> Oil	<input type="checkbox"/> Propane <input type="checkbox"/> Electric	<input type="checkbox"/> Solid Fuel <input type="checkbox"/> Earth Energy
Ratio of Windows, Skylights & Glass (W, S & G) to Wall Area		Other Building Characteristics		
Area of Walls = <u>385.64</u> m ² or <u>4151.0</u> ft ²	W, S & G % = <u>15%</u>	<input type="checkbox"/> Log/Post&Beam <input type="checkbox"/> Slab-on-ground <input checked="" type="checkbox"/> Air Conditioning <input type="checkbox"/> Air Sourced Heat Pump (ASHP) <input type="checkbox"/> Ground Source Heat Pump (GSHP)		
Area of W, S & G = <u>59.549</u> m ² or <u>641.0</u> ft ²	Utilize Window Averaging <input type="checkbox"/> Yes <input checked="" type="checkbox"/> No	<input type="checkbox"/> ICF Above Grade <input type="checkbox"/> Walkout Basement <input type="checkbox"/> Combo Unit		

D. Building Specifications [provide values and ratings of the energy efficiency components proposed]

Energy Efficiency Substitutions			
<input type="checkbox"/> ICF (3.1.1.2.(5) & (6) / 3.1.1.3.(5)) <input type="checkbox"/> Combined space heating and domestic water heating systems (3.1.1.2(7) / 3.1.1.3.(7))			
<input type="checkbox"/> Airtightness substitution(s) Airtightness test required (Refer to Design Guide Attached)	<input type="checkbox"/> Table 3.1.1.4.B Required:		Permitted Substitution:
	<input type="checkbox"/> Table 3.1.1.4.C Required:		Permitted Substitution:
Building Component	Minimum RSI/R-Values or Maximum U-Value ¹		Efficiency Ratings
Thermal Insulation	Nominal	Effective	Windows & Doors Provide U-Value ⁽¹⁾ or ER rating
Ceiling with Attic Space	60		Windows/Sliding Glass Doors 1.6
Ceiling without Attic Space	31		Skylights 2.8
Exposed Floor	31		Mechanicals
Walls Above Grade	22		Heating Equip.(AFUE) 96%
Basement Walls	20.0ci		HRV Efficiency (SRE% at 0°C) 75%
Slab (all >600mm below grade)	x		DHW Heater (EF) 0.80
Slab (edge only ≤600mm below grade)	10		DWHR (CSA B55.1 (min. 42% efficiency)) #Showers 2
Slab (all ≤600mm below grade, or heated)	10		Combined Heating System

(1) U value to be provided in either W/(m²·K) or Btu/(h·ft²·F) but not both.

E. Designer(s) [name(s) & BCIN(s), if applicable, of person(s) providing information herein to substantiate that design meets building code]

Name David DaCosta	BCIN 32964	Signature
------------------------------	----------------------	---------------

Form authorized by OHBA, OBOA, LMCBO. Revised December 1, 2016.

Site Copy

Package: Project: Package A1 Bradford System: Model: System 1 S42-8C Alt. 2nd FLR

Air Leakage Calculations

Building Air Leakage Heat Loss				
B	LRairh	Vb	HL^T	HLleak
0.018	0.319	40445	81.4	18882

Building Air Leakage Heat Gain				
B	LRairh	Vb	HG^T	HG Leak
0.018	0.079	40445	11	632

Air Leakage Heat Loss/Gain Multiplier Table (Section 11)				
Level	Level Factor (LF)	Building Air	Level Conductive Heat Loss	Air Leakage Heat Loss Multiplier
Level 1	0.5	18882	8656	1.0907
Level 2	0.3		15102	0.3751
Level 3	0.2		16679	0.2264
Level 4	0		0	0.0000

Levels			
1	2	3	4
(LF)	(LF)	(LF)	(LF)
1.0	0.6	0.5	0.4
	0.4	0.3	0.3
		0.2	0.2
			0.1

HG LEAK		Air Leakage Heat Gain	
	632		0.0354
BUILDING CONDUCTIVE HEAT GAIN			17876

Levels this Dwelling	
3	

Ventilation Calculations

Ventilation Heat Loss

Ventilation Heat Loss				
C	PVC	HL^T	(1-E) HRV	HLbvent
1.08	95.4	81.4	0.16	1342

Ventilation Heat Gain

Ventilation Heat Gain			
C	PVC	HG^T	HGbvent
1.1	95.4	11	1133

Case 1

Ventilation Heat Loss (Exhaust only Systems)

Case 1 - Exhaust Only				
Level	LF	HLbvent	LVL Cond. HL	Multiplier
Level 1	0.5	1342	8656	0.08
Level 2	0.3		15102	0.03
Level 3	0.2		16679	0.02
Level 4	0		0	0.00

Case 1

Ventilation Heat Gain (Exhaust Only Systems)

Case 1 - Exhaust Only		Multiplier	
HGbvent	1133	0.06	
Building	17876		

Case 2

Ventilation Heat Loss (Direct Ducted Systems)

C	HL^T	(1-E) HRV	Multiplier
1.08	81.4	0.16	14.07

Case 2

Ventilation Heat Gain (Direct Ducted Systems)

C	HG^T	Multiplier
1.08	11	11.88

Case 3

Ventilation Heat Loss (Forced Air Systems)

HLbvent		Multiplier
Total Ventilation Load	1342	0.03

Case 3

Ventilation Heat Gain (Forced Air Systems)

Vent Heat Gain		Multiplier
HGbvent	HG*1.3	1133
1133	1	

Foundation Conductive Heatloss Level 1

2250 Watts 7679 Btu/h

Foundation Conductive Heatloss Level 2

Watts Btu/h

I review and take responsibility for the design work and am qualified in the appropriate category as an "other designer" under Division C subsection 3.2.5. of the Building Code. Individual BCIN: 32964

David DaCosta

Site Copy


Envelope Air Leakage Calculator



 






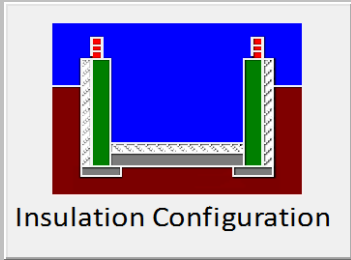






Supplemental tool for CAN/CSA-F280


Weather Station Description				
Province:	Ontario ▼			
Region:	Bradford ▼			
Weather Station Location:	Open flat terrain, grass ▼			
Anemometer height (m):	10			
Local Shielding				
Building Site:	Suburban, forest ▼			
Walls:	Heavy ▼			
Flue:	Heavy ▼			
Highest Ceiling Height (m):	6.61			
Building Configuration				
Type:	Detached			
Number of Stories:	Two			
Foundation:	Full			
House Volume (m ³):	1145.40			
Air Leakage/Ventilation				
Air Tightness Type:	Present (1961-) (ACH=3.57)			
Custom BDT Data:	ELA @ 10 Pa. ▼ 322.44 cm ²			
	3.57 ACH @ 50 Pa			
Mechanical Ventilation (L/s):	Total Supply:		Total Exhaust:	
	47.7		47.7	
Flue #:	#1	#2	#3	#4
Diameter (mm):	0	0	0	0
Heating Air Leakage Rate (ACH/H):		0.319		
Cooling Air Leakage Rate (ACH/H):		0.079		

Residential Foundation Thermal Load Calculator

Supplemental tool for CAN/CSA-F280

Weather Station Description		
Province:	Ontario ▼	
Region:	Bradford ▼	
Site Description		
Soil Conductivity:	High conductivity: moist soil ▼	
Water Table:	Normal (7-10 m, 23-33 Ft) ▼	
Foundation Dimensions		
Floor Length (m):	21.92	 <p>Insulation Configuration</p>
Floor Width (m):	5.97	
Exposed Perimeter (m):	55.78	
Wall Height (m):	2.74	
Depth Below Grade (m):	1.62	
Window Area (m ²):	2.23	
Door Area (m ²):	1.95	
Radiant Slab		
Heated Fraction of the Slab:	0	
Fluid Temperature (°C):	33	
Design Months		
Heating Month	1	
Foundation Loads		
Heating Load (Watts):		2250

   	FLEX DUCT		LOW/HIGH WALL/KICK SUPPLY DIFFUSER		DUCT CONNECTION TO JOIST LINING		RETURN AIR GRILLE (SIZE INDICATED ON DRAWING)	S.A.	SUPPLY AIR
	RIGID ROUND DUCT		HRV EXHAUST GRILLE		RETURN AIR PIPE RISER		RETURN AIR RISER UP TO FLOOR ABOVE	R.A.	RETURN AIR
	SUPPLY DIFFUSER		SUPPLY AIR PIPE RISER		RETURN ROUND DUCT		RETURN AIR FROM BASEMENT SECOND FLOOR		THERMOSTAT
			VOLUME DAMPER						PRINCIPAL EXHAUST FAN SWITCH
									W/R & PRINCIPAL EXHAUST FAN

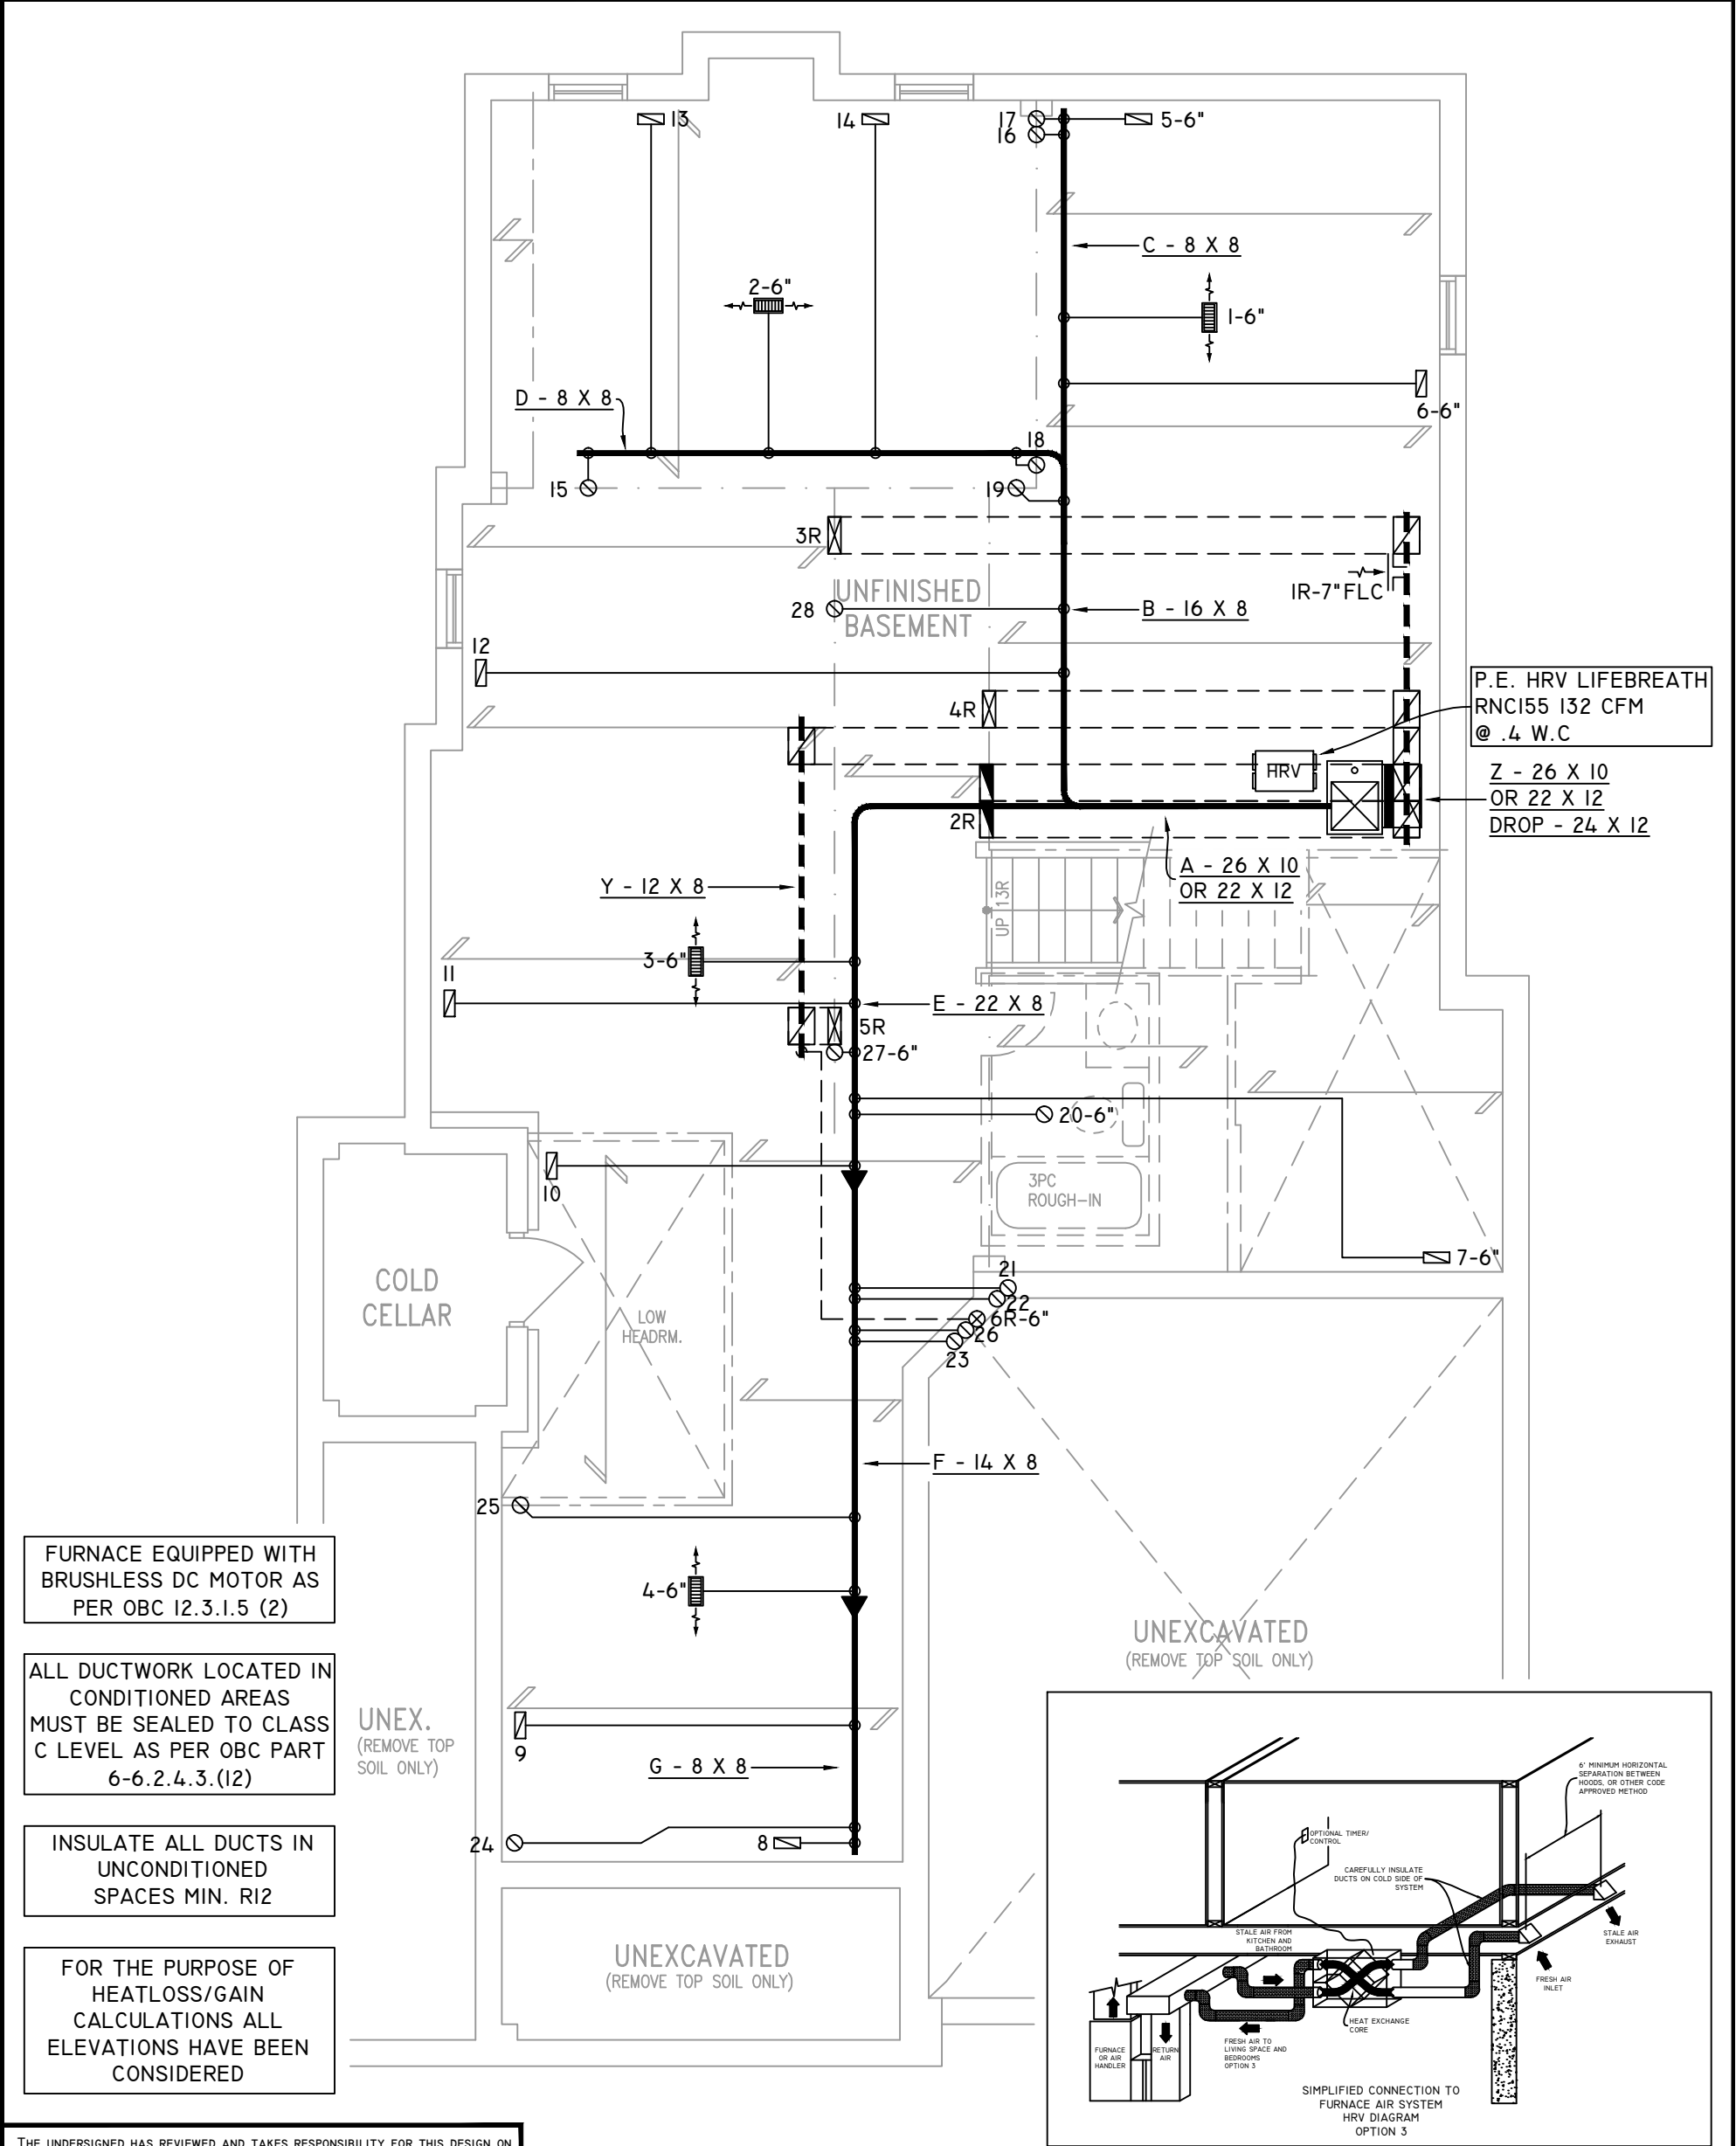

THE UNDERSIGNED HAS REVIEWED AND TAKES RESPONSIBILITY FOR THIS DESIGN ON BEHALF OF GTA DESIGNS INC. AND HAS THE QUALIFICATIONS AND MEETS THE REQUIREMENTS SET OUT IN THE BUILDING CODE TO BE A DESIGNER

QUALIFICATION INFORMATION

REQUIRED UNLESS DESIGN IS EXEMPT UNDER DIVISION C 3.2.5.1 OF THE ONTARIO BUILDING CODE

DAVID DA COSTA  B.C.I.N. 32964

SIGNATURE OF DESIGNER

BASEMENT PLAN 'A'

OBC 2012

Site Copy

ZONE I COMPLIANCE
PACKAGE "A1" REF. TABLE 3.1.1.2.A

NOTES

INSTALLATION TO COMPLY WITH THE LATEST ONTARIO BUILDING CODE.

ALL SUPPLY OUTLETS TO BE 5" DIA. UNLESS OTHERWISE SPECIFIED.

PROVIDE BALANCING DAMPERS ON ALL BRANCHES.

ALL R/A PARTITIONS 6" (FIRST FLOOR ONLY)

INSULATE DUCTS IN UNCONDITIONED SPACES R12 UNDERCUT ALL DOORS 1" MIN.

CONTRACTOR MUST WORK FROM APPROVED PLANS.

ANY ALTERATIONS TO THIS ORIGINAL PLAN ARE NOT THE RESPONSIBILITY OF GTA DESIGNS.

GTA DESIGNS MUST BE CONSULTED IF KITCHEN EXHAUST FAN EXCEEDS 700 CFM DEPRESSURIZATION MAY OCCUR WITH IN THE DWELLING.





 













2985 DREW ROAD
SUITE 202,
MISSISSAUGA, ONT.
L4T 0A4 TEL: 905-671-9800
EMAIL: DAVE@GTADESIGNS.CA
WEB: WWW.GTADESIGNS.CA


HEAT-LOSS	61,107	BTU/HR.
UNIT MAKE	AMANA	OR EQUAL.
UNIT MODEL	AMEC960803BNA	OR EQUAL.
UNIT HEATING INPUT	80,000	BTU/HR.
UNIT HEATING OUTPUT	76,800	BTU/HR.
A/C COOLING CAPACITY	3.0	TONS.
FAN SPEED	1172	CFM

# OF RUNS	S/A	R/A	FANS
3RD FLOOR			
2ND FLOOR	14	4	4
1ST FLOOR	10	1	2
BASEMENT	4	1	

FLOOR PLAN:	BASEMENT
DRAWN BY:	AM
CHECKED:	DD
LAYOUT NO.	JB-04615
SQFT	3454
DRAWING NO.	MI

DATE:	APRIL 4, 2018
CLIENT:	BAYVIEW WELLINGTON
MODEL:	S42-8C ALT. 2ND FLR RIDEAU 8
PROJECT:	GREEN VALLEY EAST BRADFORD, ONT.
SCALE:	3/16" = 1'-0"

	FLEX DUCT		LOW/HIGH WALL/KICK SUPPLY DIFFUSER		DUCT CONNECTION TO JOIST LINING		RETURN AIR GRILLE (SIZE INDICATED ON DRAWING)	S.A.	SUPPLY AIR
	RIGID ROUND DUCT		HRV EXHAUST GRILLE		RETURN AIR PIPE RISER		RETURN AIR RISER UP TO FLOOR ABOVE	R.A.	RETURN AIR
	SUPPLY DIFFUSER		SUPPLY AIR PIPE RISER		RETURN ROUND DUCT		RETURN AIR FROM BASEMENT SECOND FLOOR		THERMOSTAT
			VOLUME DAMPER						PRINCIPAL EXHAUST FAN SWITCH
									W/R & PRINCIPAL EXHAUST FAN

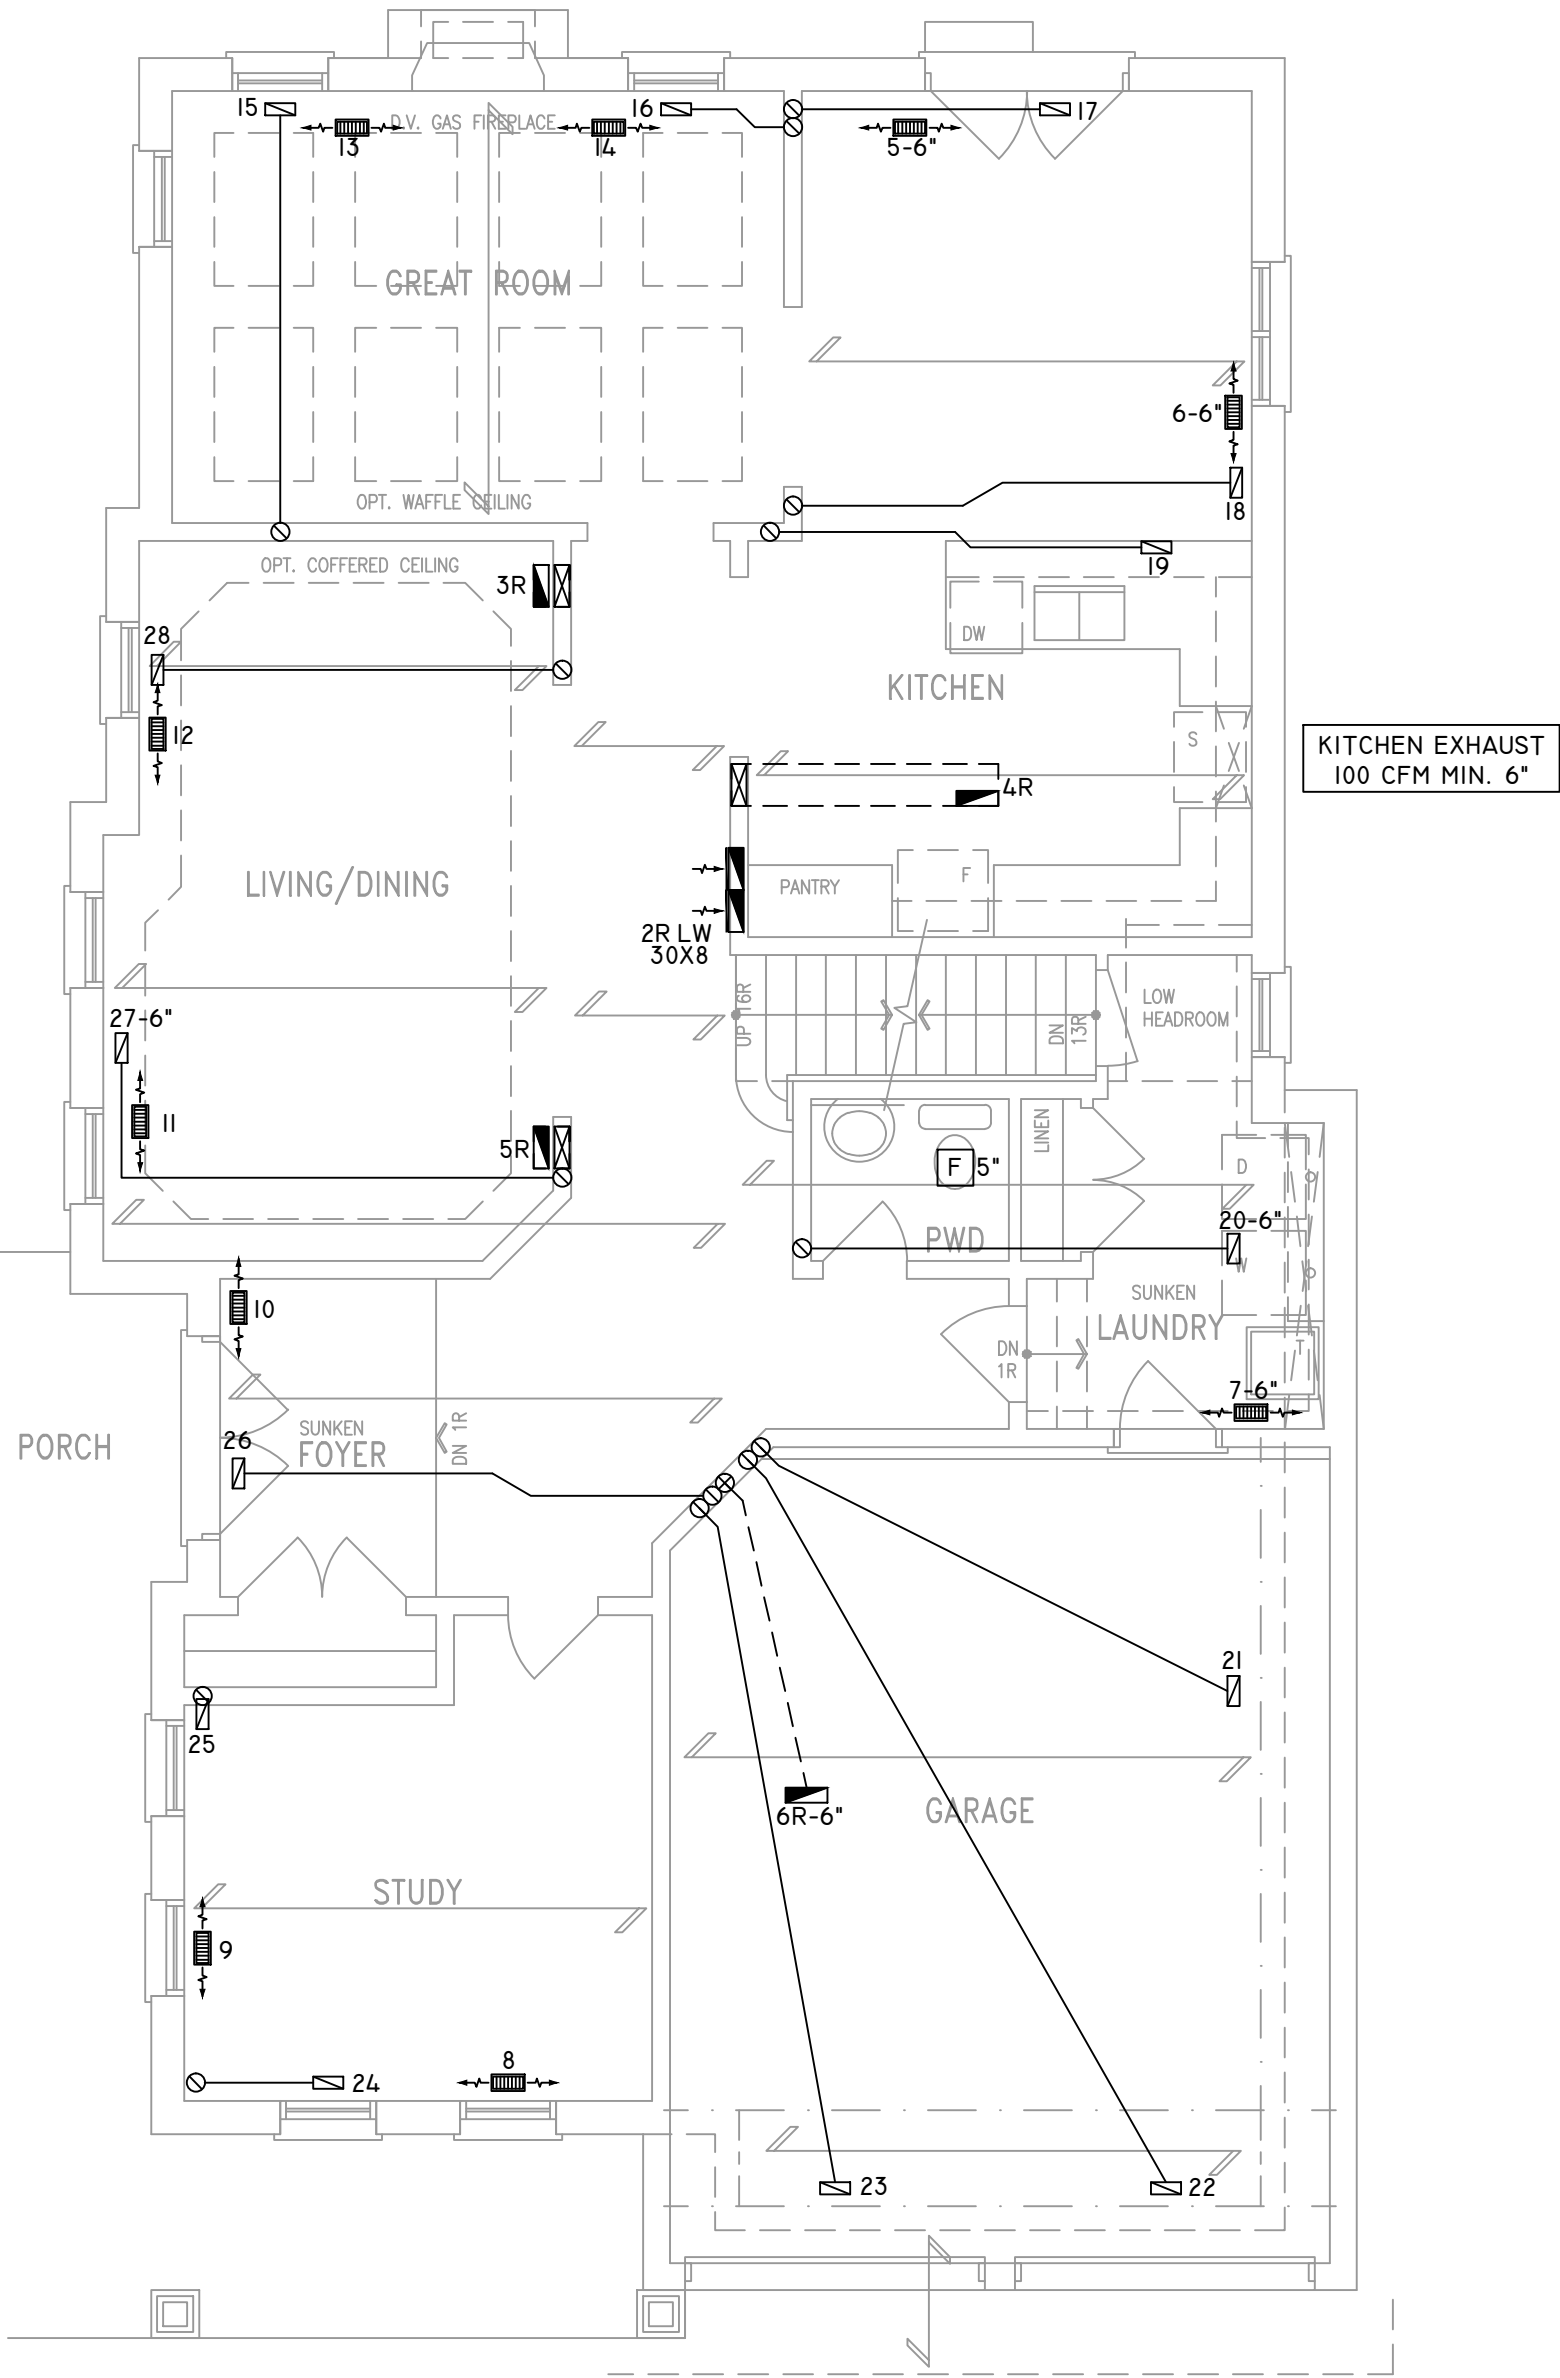

THE UNDERSIGNED HAS REVIEWED AND TAKES RESPONSIBILITY FOR THIS DESIGN ON BEHALF OF GTA DESIGNS INC. AND HAS THE QUALIFICATIONS AND MEETS THE REQUIREMENTS SET OUT IN THE BUILDING CODE TO BE A DESIGNER

QUALIFICATION INFORMATION

REQUIRED UNLESS DESIGN IS EXEMPT UNDER DIVISION C 3.2.5.1 OF THE ONTARIO BUILDING CODE

DAVID DA COSTA  B.C.I.N. 32964

SIGNATURE OF DESIGNER

GROUND FLOOR PLAN 'A'

OBC 2012

Site Copy

ZONE I COMPLIANCE
PACKAGE "A1" REF. TABLE 3.1.1.2.A

NOTES

INSTALLATION TO COMPLY WITH THE LATEST ONTARIO BUILDING CODE.

ALL SUPPLY OUTLETS TO BE 5" DIA. UNLESS OTHERWISE SPECIFIED.

PROVIDE BALANCING DAMPERS ON ALL BRANCHES.

ALL R/A PARTITIONS 6" (FIRST FLOOR ONLY)

INSULATE DUCTS IN UNCONDITIONED SPACES R12 UNDERCUT ALL DOORS 1" MIN.

CONTRACTOR MUST WORK FROM APPROVED PLANS.

ANY ALTERATIONS TO THIS ORIGINAL PLAN ARE NOT THE RESPONSIBILITY OF GTA DESIGNS.

GTA DESIGNS MUST BE CONSULTED IF KITCHEN EXHAUST FAN EXCEEDS 700 CFM DEPRESSURIZATION MAY OCCUR WITH IN THE DWELLING.





 













2985 DREW ROAD
SUITE 202,
MISSISSAUGA, ONT.
L4T 0A4 TEL: 905-671-9800
EMAIL: DAVE@GTADISIGNS.CA
WEB: WWW.GTADISIGNS.CA


HEAT-LOSS	61,107	BTU/HR.
UNIT MAKE	AMANA	OR EQUAL.
UNIT MODEL	AMEC960803BNA	OR EQUAL.
UNIT HEATING INPUT	80,000	BTU/HR.
UNIT HEATING OUTPUT	76,800	BTU/HR.
A/C COOLING CAPACITY	3.0	TONS.
FAN SPEED	1172	CFM

# OF RUNS	S/A	R/A	FANS
3RD FLOOR			
2ND FLOOR	14	4	4
1ST FLOOR	10	1	2
BASEMENT	4	1	

FLOOR PLAN: GROUND FLOOR	
DRAWN BY: AM	CHECKED: DD
LAYOUT NO. JB-04615	SGFT 3454
	DRAWING NO. M2

DATE: APRIL 4, 2018
CLIENT: BAYVIEW WELLINGTON
MODEL: S42-8C ALT. 2ND FLR RIDEAU 8
PROJECT: GREEN VALLEY EAST BRADFORD,ONT.
SCALE: 3/16" = 1'-0"

	FLEX DUCT		LOW/HIGH WALL/KICK SUPPLY DIFFUSER		DUCT CONNECTION TO JOIST LINING		RETURN AIR GRILLE (SIZE INDICATED ON DRAWING)	S.A.	SUPPLY AIR
	RIGID ROUND DUCT		HRV EXHAUST GRILLE		RETURN AIR PIPE RISER		RETURN AIR RISER UP TO FLOOR ABOVE	R.A.	RETURN AIR
	SUPPLY DIFFUSER		SUPPLY AIR PIPE RISER		RETURN ROUND DUCT		RETURN AIR FROM BASEMENT SECOND FLOOR		THERMOSTAT
			VOLUME DAMPER						PRINCIPAL EXHAUST FAN SWITCH W/R & PRINCIPAL EXHAUST FAN

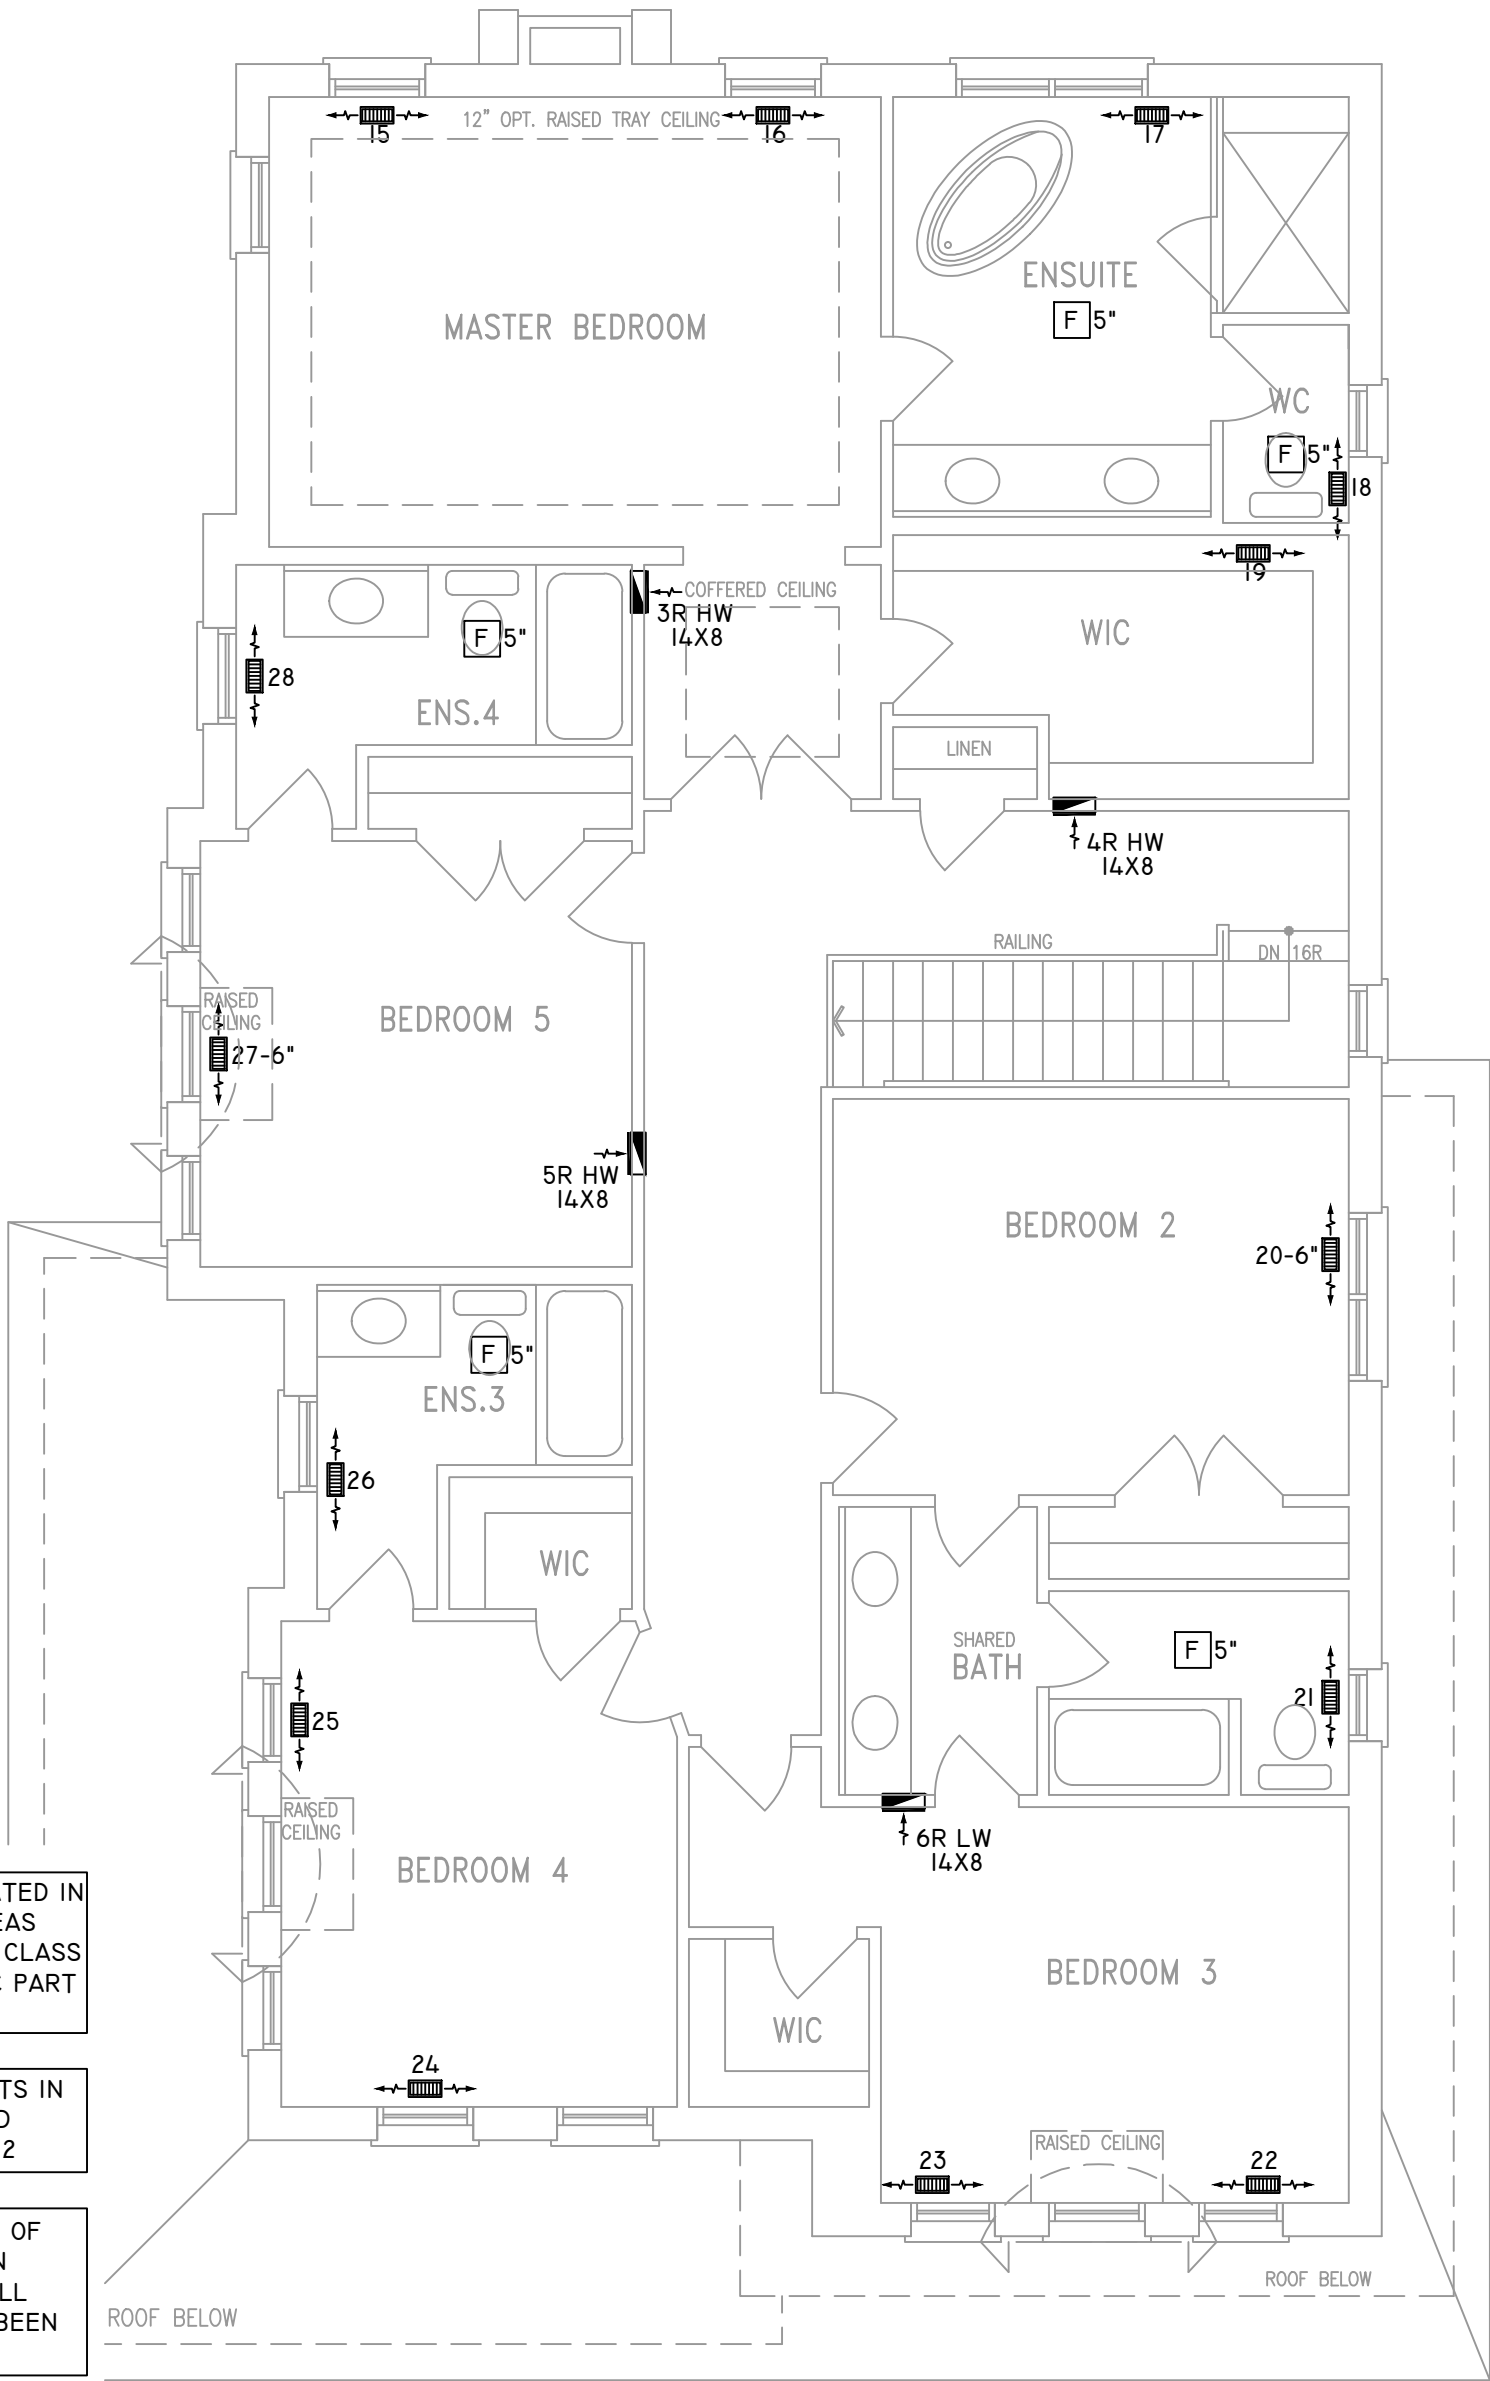

ALL DUCTWORK LOCATED IN
CONDITIONED AREAS
MUST BE SEALED TO CLASS
C LEVEL AS PER OBC PART
6-6.2.4.3.(12)


INSULATE ALL DUCTS IN
UNCONDITIONED
SPACES MIN. R12

FOR THE PURPOSE OF
HEATLOSS/GAIN
CALCULATIONS ALL
ELEVATIONS HAVE BEEN
CONSIDERED

THE UNDERSIGNED HAS REVIEWED AND TAKES RESPONSIBILITY FOR THIS DESIGN ON
BEHALF OF GTA DESIGNS INC. AND HAS THE QUALIFICATIONS AND MEETS THE
REQUIREMENTS SET OUT IN THE BUILDING CODE TO BE A DESIGNER

QUALIFICATION INFORMATION

REQUIRED UNLESS DESIGN IS EXEMPT UNDER DIVISION C 3.2.5.1 OF THE
ONTARIO BUILDING CODE

DAVID DA COSTA  B.C.I.N. 32964
SIGNATURE OF DESIGNER

SECOND FLOOR PLAN 'A' 5 BEDROOM W/ FOUR BATH

Site Copy

OBC 2012

ZONE I COMPLIANCE
PACKAGE "A1" REF. TABLE 3.1.1.2.A

NOTES

INSTALLATION TO COMPLY WITH THE LATEST ONTARIO
BUILDING CODE.

ALL SUPPLY OUTLETS TO BE 5" DIA. UNLESS OTHERWISE
SPECIFIED.

PROVIDE BALANCING DAMPERS ON ALL BRANCHES.

ALL R/A PARTITIONS 6" (FIRST FLOOR ONLY)

INSULATE DUCTS IN UNCONDITIONED SPACES R12 UNDERCUT
ALL DOORS 1" MIN.

CONTRACTOR MUST WORK FROM APPROVED PLANS.

ANY ALTERATIONS TO THIS ORIGINAL PLAN ARE NOT THE
RESPONSIBILITY OF GTA DESIGNS.

GTA DESIGNS MUST BE CONSULTED IF KITCHEN EXHAUST
FAN EXCEEDS 700 CFM DEPRESSURIZATION MAY OCCUR
WITH IN THE DWELLING.

**GTADESIGNS**



 














2985 DREW ROAD
SUITE 202,
MISSISSAUGA, ONT.
L4T 0A4 TEL: 905-671-9800
EMAIL: DAVE@GTADESIGNS.CA
WEB: WWW.GTADESIGNS.CA


HEAT-LOSS	61,107	BTU/HR.
UNIT MAKE	AMANA	OR EQUAL.
UNIT MODEL	AMEC960803BNA	OR EQUAL.
UNIT HEATING INPUT	80,000	BTU/HR.
UNIT HEATING OUTPUT	76,800	BTU/HR.
A/C COOLING CAPACITY	3.0	TONS.
FAN SPEED	1172	CFM

# OF RUNS	S/A	R/A	FANS
3RD FLOOR			
2ND FLOOR	14	4	4
1ST FLOOR	10	1	2
BASEMENT	4	1	


FLOOR PLAN: SECOND FLOOR	
DRAWN BY: AM	CHECKED: DD
LAYOUT NO. JB-04615	SQFT 3454
	DRAWING NO. M3

DATE:	APRIL 4, 2018
CLIENT:	BAYVIEW WELLINGTON
MODEL:	S42-8C ALT. 2ND FLR RIDEAU 8
PROJECT:	GREEN VALLEY EAST BRADFORD, ONT.
SCALE:	3/16" = 1'-0"


	FLEX DUCT		LOW/HIGH WALL/KICK SUPPLY DIFFUSER		DUCT CONNECTION TO JOIST LINING		RETURN AIR GRILLE (SIZE INDICATED ON DRAWING)	S.A.	SUPPLY AIR
	RIGID ROUND DUCT		HRV EXHAUST GRILLE		RETURN AIR PIPE RISER		RETURN AIR RISER UP TO FLOOR ABOVE	R.A.	RETURN AIR
	SUPPLY DIFFUSER		SUPPLY AIR PIPE RISER		RETURN ROUND DUCT		RETURN AIR FROM BASEMENT SECOND FLOOR		THERMOSTAT
			VOLUME DAMPER						PRINCIPAL EXHAUST FAN SWITCH
									W/R & PRINCIPAL EXHAUST FAN

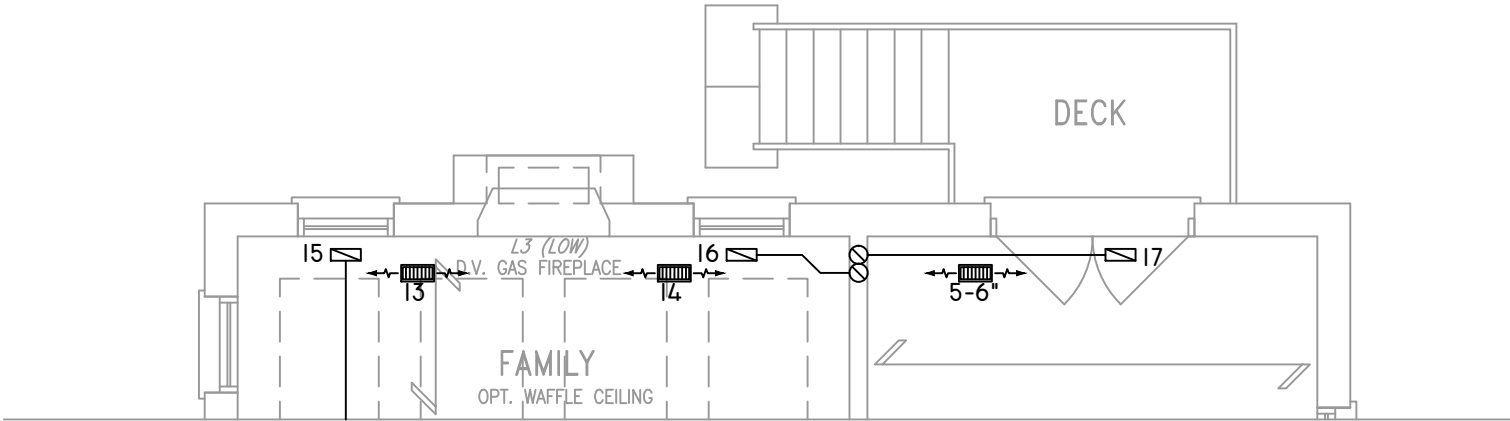


PART. GROUND FLOOR PLAN 'A' – W.O.D. 9R OR MORE COND.

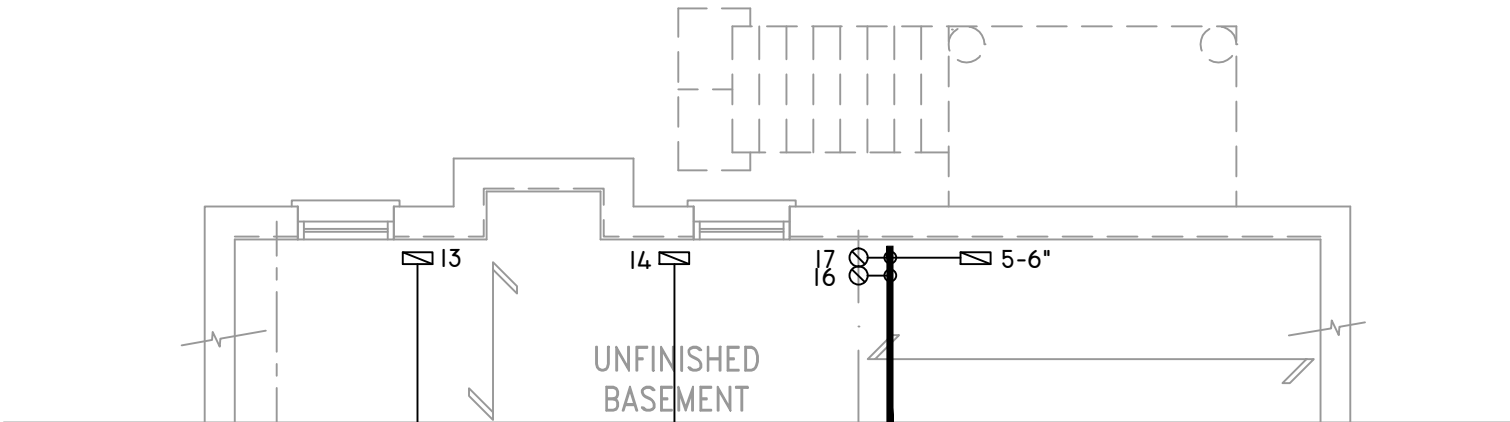

PART. BASEMENT PLAN 'A' – W.O.D. 9R OR MORE COND.

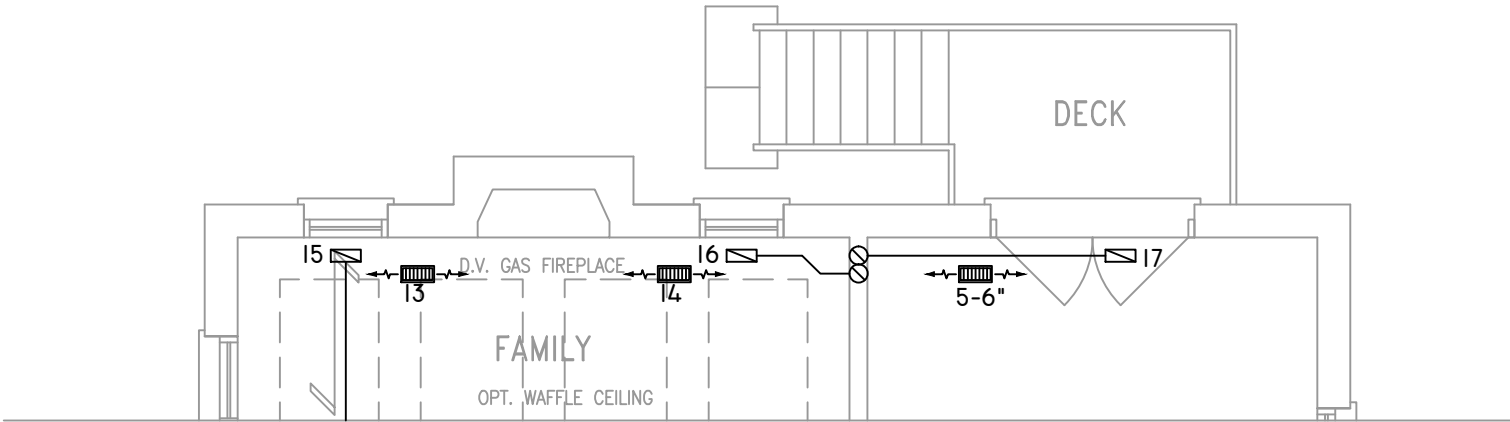

PART. GROUND FLOOR PLAN 'B' – W.O.D. 9R OR MORE COND.

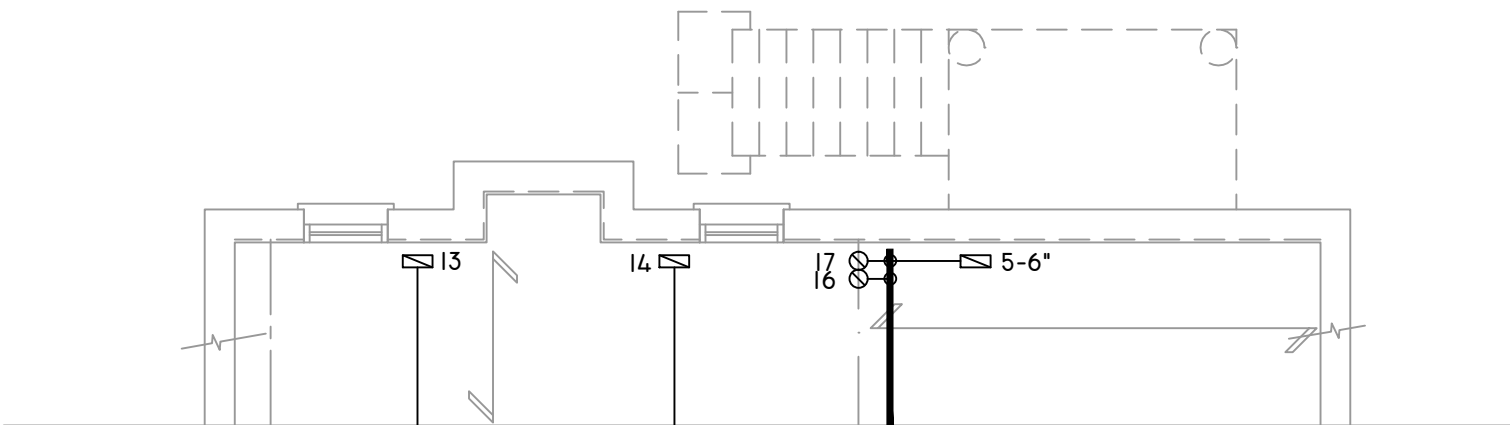


PART. BASEMENT PLAN 'B' – W.O.D. 9R OR MORE COND.

THE UNDERSIGNED HAS REVIEWED AND TAKES RESPONSIBILITY FOR THIS DESIGN ON BEHALF OF GTA DESIGNS INC. AND HAS THE QUALIFICATIONS AND MEETS THE REQUIREMENTS SET OUT IN THE BUILDING CODE TO BE A DESIGNER

QUALIFICATION INFORMATION

REQUIRED UNLESS DESIGN IS EXEMPT UNDER DIVISION C 3.2.5.1 OF THE ONTARIO BUILDING CODE

 DAVID DA COSTA



B.C.I.N. 32964

SIGNATURE OF DESIGNER

OBC 2012

Site Copy

ZONE I COMPLIANCE
PACKAGE "A1" REF. TABLE 3.1.1.2.A

NOTES
INSTALLATION TO COMPLY WITH THE LATEST ONTARIO BUILDING CODE.
ALL SUPPLY OUTLETS TO BE 5" DIA. UNLESS OTHERWISE SPECIFIED.
PROVIDE BALANCING DAMPERS ON ALL BRANCHES.
ALL R/A PARTITIONS 6" (FIRST FLOOR ONLY)
INSULATE DUCTS IN UNCONDITIONED SPACES R12 UNDERCUT ALL DOORS 1" MIN.
CONTRACTOR MUST WORK FROM APPROVED PLANS.
ANY ALTERATIONS TO THIS ORIGINAL PLAN ARE NOT THE RESPONSIBILITY OF GTA DESIGNS.
GTA DESIGNS MUST BE CONSULTED IF KITCHEN EXHAUST FAN EXCEEDS 700 CFM DEPRESSURIZATION MAY OCCUR WITH IN THE DWELLING.



















2985 DREW ROAD
SUITE 202,
MISSISSAUGA, ONT.
L4T 0A4 TEL: 905-671-9800
EMAIL: DAVE@GTADISGNS.CA
WEB: WWW.GTADISGNS.CA


HEAT-LOSS	61,107	BTU/HR.
UNIT MAKE	AMANA	OR EQUAL.
UNIT MODEL	AMEC960803BNA	OR EQUAL.
UNIT HEATING INPUT	80,000	BTU/HR.
UNIT HEATING OUTPUT	76,800	BTU/HR.
A/C COOLING CAPACITY	3.0	TONS.
FAN SPEED	1172	CFM

# OF RUNS	S/A	R/A	FANS
3RD FLOOR			
2ND FLOOR	14	4	4
1ST FLOOR	10	1	2
BASEMENT	4	1	


FLOOR PLAN: PARTIAL PLAN(S)	
DRAWN BY: AM	CHECKED: DD
LAYOUT NO: JB-04615	SQFT 3454
DRAWING NO: M4	

DATE:	APRIL 4, 2018
CLIENT:	BAYVIEW WELLINGTON
MODEL:	S42-8C ALT. 2ND FLR RIDEAU 8
PROJECT:	GREEN VALLEY EAST BRADFORD,ONT.
SCALE:	3/16" = 1'-0"


	FLEX DUCT		LOW/HIGH WALL/KICK SUPPLY DIFFUSER		DUCT CONNECTION TO JOIST LINING		RETURN AIR GRILLE (SIZE INDICATED ON DRAWING)	S.A.	SUPPLY AIR
	RIGID ROUND DUCT		HRV EXHAUST GRILLE		RETURN AIR PIPE RISER		RETURN AIR RISER UP TO FLOOR ABOVE	R.A.	RETURN AIR
	SUPPLY DIFFUSER		SUPPLY AIR PIPE RISER		RETURN ROUND DUCT		RETURN AIR FROM BASEMENT SECOND FLOOR		THERMOSTAT
			VOLUME DAMPER						PRINCIPAL EXHAUST FAN SWITCH
									W/R & PRINCIPAL EXHAUST FAN

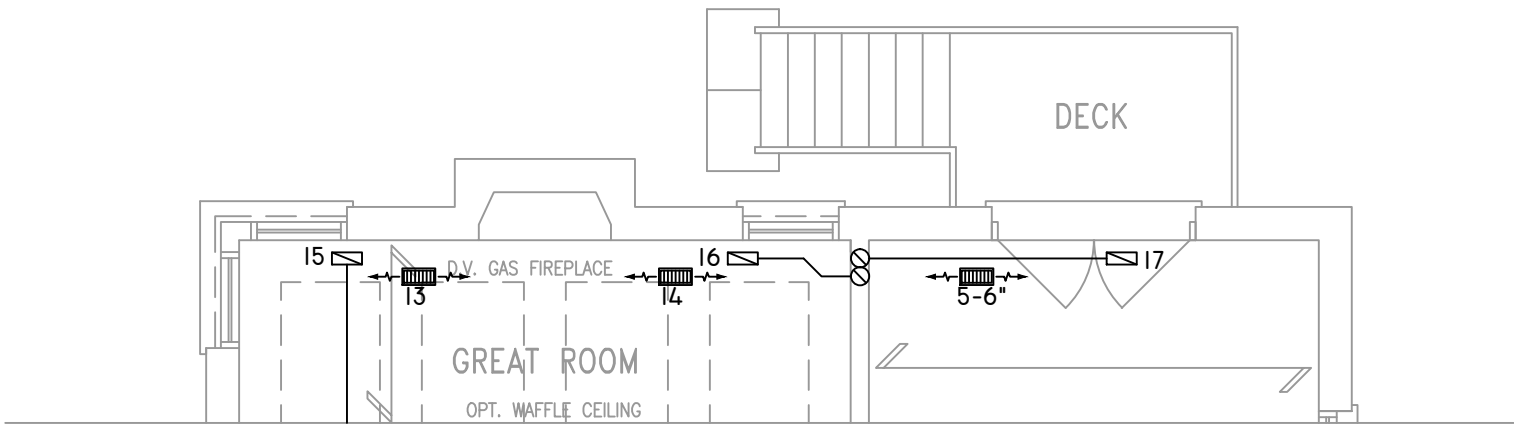

PART. GROUND FLOOR PLAN 'C' – W.O.D. 9R OR MORE COND.

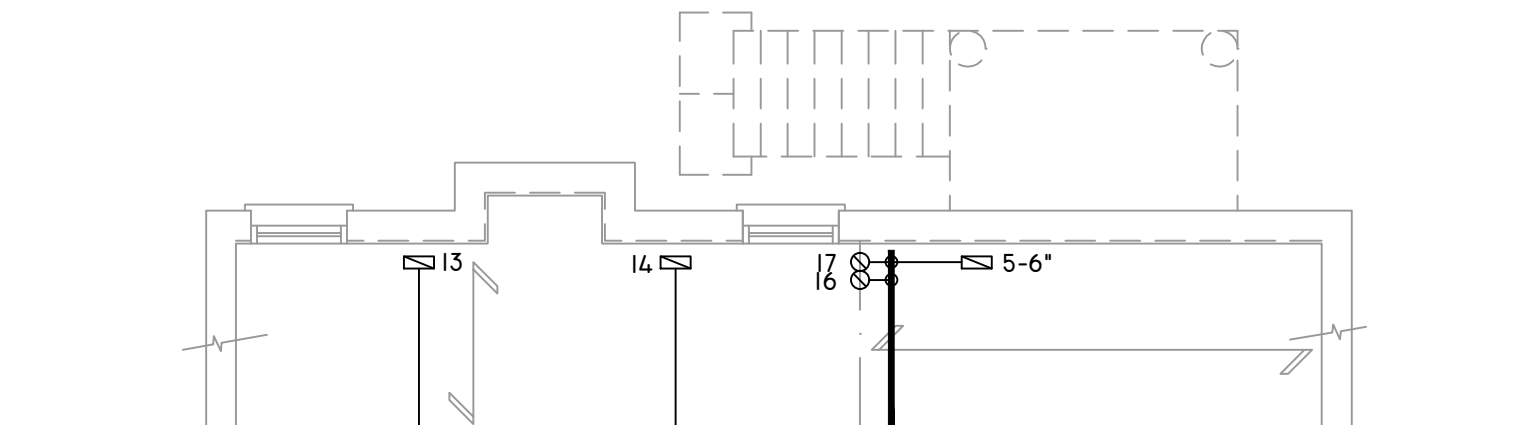

PART. BASEMENT PLAN 'C' – W.O.D. 9R OR MORE COND.

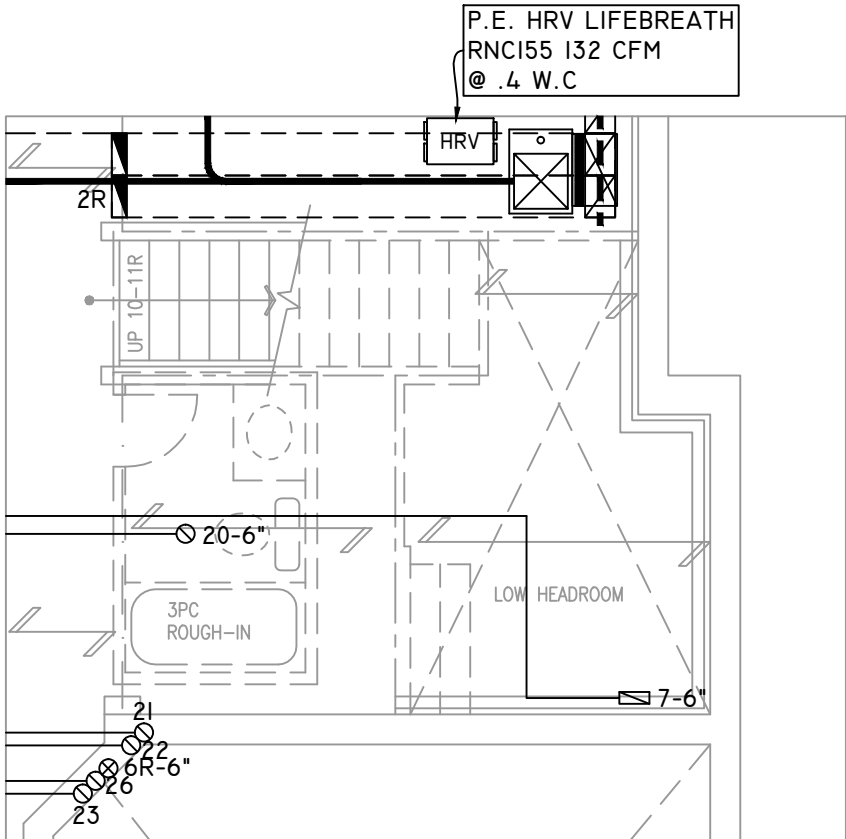


PART. BASEMENT PLAN W/ SUNKEN LAUNDRY (-2R to -3R COND.)

THE UNDERSIGNED HAS REVIEWED AND TAKES RESPONSIBILITY FOR THIS DESIGN ON BEHALF OF GTA DESIGNS INC. AND HAS THE QUALIFICATIONS AND MEETS THE REQUIREMENTS SET OUT IN THE BUILDING CODE TO BE A DESIGNER

QUALIFICATION INFORMATION

REQUIRED UNLESS DESIGN IS EXEMPT UNDER DIVISION C 3.2.5.1 OF THE ONTARIO BUILDING CODE

 DAVID DA COSTA



B.C.I.N. 32964

SIGNATURE OF DESIGNER

OBC 2012

Site Copy

ZONE I COMPLIANCE
PACKAGE "AI" REF. TABLE 3.1.1.2.A

NOTES
INSTALLATION TO COMPLY WITH THE LATEST ONTARIO BUILDING CODE.
ALL SUPPLY OUTLETS TO BE 5" DIA. UNLESS OTHERWISE SPECIFIED.
PROVIDE BALANCING DAMPERS ON ALL BRANCHES.
ALL R/A PARTITIONS 6" (FIRST FLOOR ONLY)
INSULATE DUCTS IN UNCONDITIONED SPACES R12 UNDERCUT ALL DOORS 1" MIN.
CONTRACTOR MUST WORK FROM APPROVED PLANS.
ANY ALTERATIONS TO THIS ORIGINAL PLAN ARE NOT THE RESPONSIBILITY OF GTA DESIGNS.
GTA DESIGNS MUST BE CONSULTED IF KITCHEN EXHAUST FAN EXCEEDS 700 CFM DEPRESSURIZATION MAY OCCUR WITH IN THE DWELLING.



















2985 DREW ROAD
SUITE 202,
MISSISSAUGA, ONT.
L4T 0A4 TEL: 905-671-9800
EMAIL: DAVE@GTADESIGNS.CA
WEB: WWW.GTADESIGNS.CA


HEAT-LOSS	61,107	BTU/HR.
UNIT MAKE	AMANA	OR EQUAL.
UNIT MODEL	AMEC960803BNA	OR EQUAL.
UNIT HEATING INPUT	80,000	BTU/HR.
UNIT HEATING OUTPUT	76,800	BTU/HR.
A/C COOLING CAPACITY	3.0	TONS.
FAN SPEED	1172	CFM

# OF RUNS	S/A	R/A	FANS
3RD FLOOR			
2ND FLOOR	14	4	4
1ST FLOOR	10	1	2
BASEMENT	4	1	


FLOOR PLAN:	
PARTIAL PLAN(S)	
DRAWN BY: AM	CHECKED: DD
LAYOUT NO. JB-04615	DRAWING NO. M5

DATE:	APRIL 4, 2018
CLIENT:	BAYVIEW WELLINGTON
MODEL:	S42-8C ALT. 2ND FLR RIDEAU 8
PROJECT:	GREEN VALLEY EAST BRADFORD,ONT.
SCALE:	3/16" = 1'-0"


	FLEX DUCT		LOW/HIGH WALL/KICK SUPPLY DIFFUSER		DUCT CONNECTION TO JOIST LINING		RETURN AIR GRILLE (SIZE INDICATED ON DRAWING)	S.A.	SUPPLY AIR
	RIGID ROUND DUCT		HRV EXHAUST GRILLE		RETURN AIR PIPE RISER		RETURN AIR RISER UP TO FLOOR ABOVE	R.A.	RETURN AIR
	SUPPLY DIFFUSER		SUPPLY AIR PIPE RISER		RETURN ROUND DUCT		RETURN AIR FROM BASEMENT SECOND FLOOR		THERMOSTAT
			VOLUME DAMPER						PRINCIPAL EXHAUST FAN SWITCH
									W/R & PRINCIPAL EXHAUST FAN

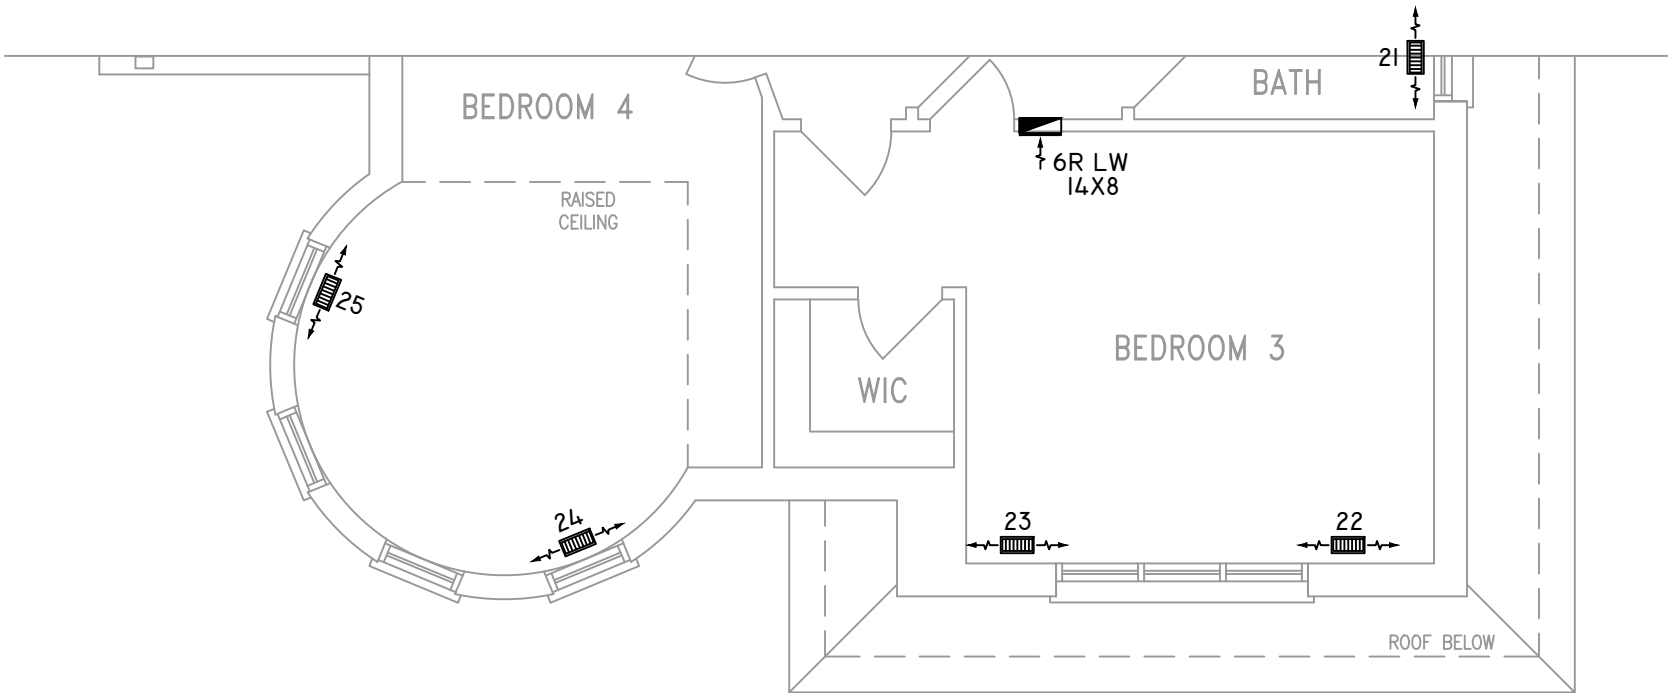

OPT. SECOND FLOOR PLAN 'B'
5 BEDROOM W/ FOUR BATH

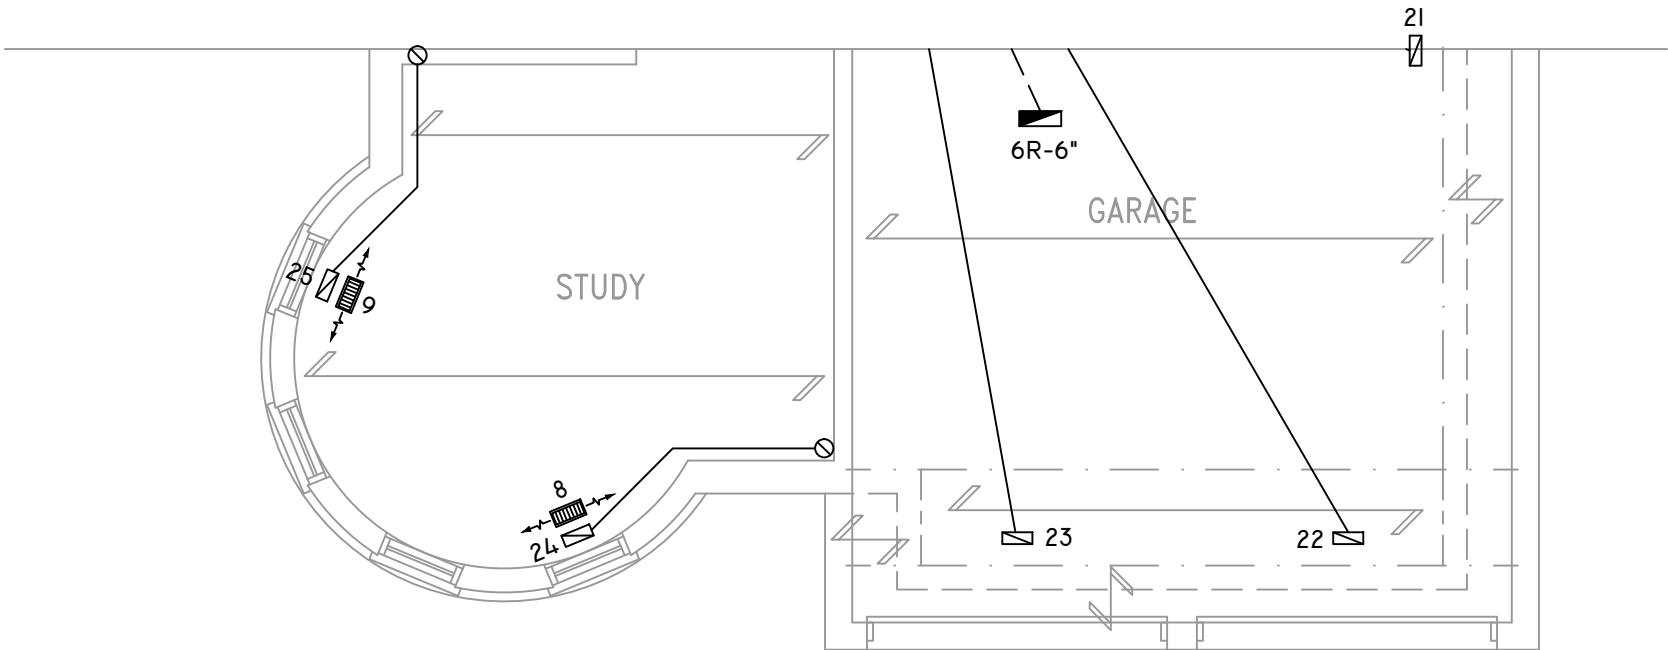

GROUND FLOOR PLAN 'B'

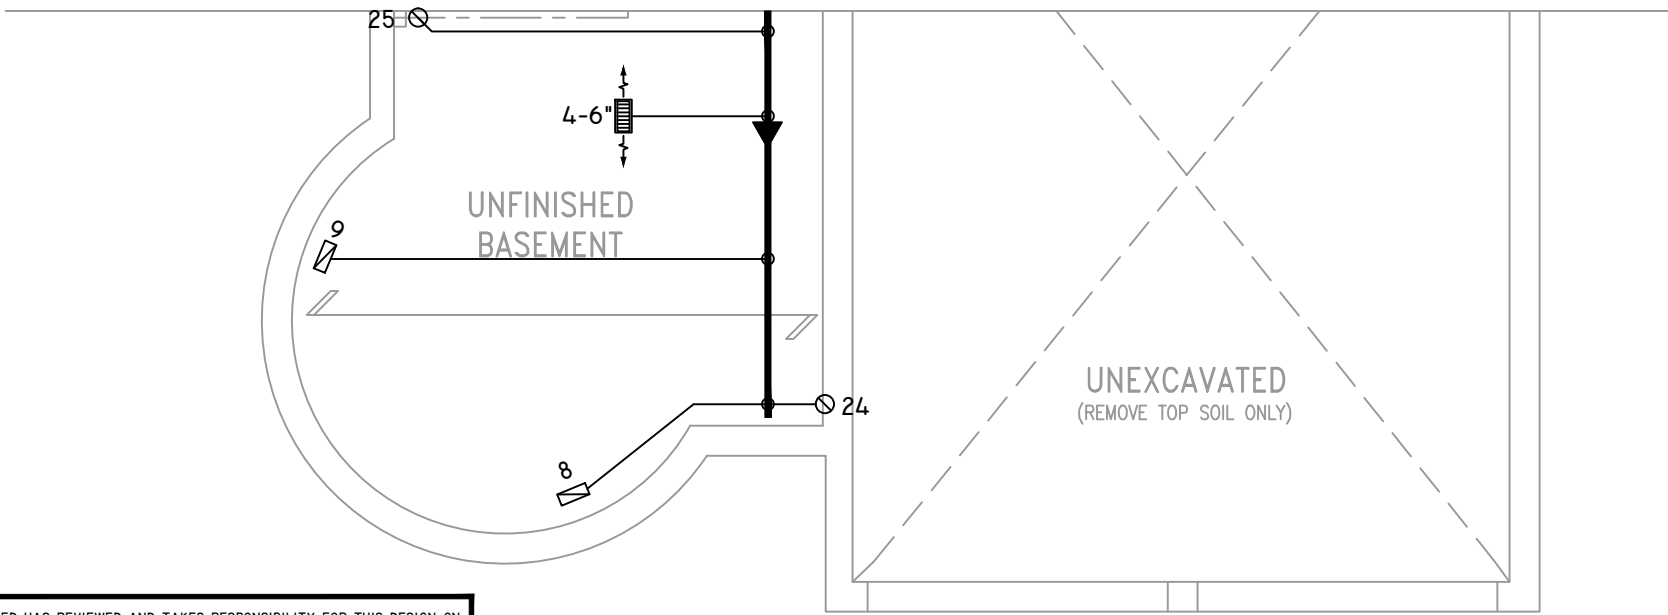


BASEMENT PLAN 'B'

THE UNDERSIGNED HAS REVIEWED AND TAKES RESPONSIBILITY FOR THIS DESIGN ON BEHALF OF GTA DESIGNS INC. AND HAS THE QUALIFICATIONS AND MEETS THE REQUIREMENTS SET OUT IN THE BUILDING CODE TO BE A DESIGNER

QUALIFICATION INFORMATION

 REQUIRED UNLESS DESIGN IS EXEMPT UNDER DIVISION C 3.2.5.1 OF THE ONTARIO BUILDING CODE

DAVID DA COSTA  B.C.I.N. 32964

SIGNATURE OF DESIGNER

OBC 2012

Site Copy

ZONE I COMPLIANCE
PACKAGE "A1" REF. TABLE 3.1.1.2.A

NOTES
INSTALLATION TO COMPLY WITH THE LATEST ONTARIO BUILDING CODE.
ALL SUPPLY OUTLETS TO BE 5" DIA. UNLESS OTHERWISE SPECIFIED.
PROVIDE BALANCING DAMPERS ON ALL BRANCHES.
ALL R/A PARTITIONS 6" (FIRST FLOOR ONLY)
INSULATE DUCTS IN UNCONDITIONED SPACES R12 UNDERCUT ALL DOORS 1" MIN.
CONTRACTOR MUST WORK FROM APPROVED PLANS.
ANY ALTERATIONS TO THIS ORIGINAL PLAN ARE NOT THE RESPONSIBILITY OF GTA DESIGNS.
GTA DESIGNS MUST BE CONSULTED IF KITCHEN EXHAUST FAN EXCEEDS 700 CFM DEPRESSURIZATION MAY OCCUR WITH IN THE DWELLING.





 













2985 DREW ROAD
SUITE 202,
MISSISSAUGA, ONT.
L4T 0A4 TEL: 905-671-9800
EMAIL: DAVE@GTADESIGNS.CA
WEB: WWW.GTADESIGNS.CA


HEAT-LOSS	61,107	BTU/HR.
UNIT MAKE	AMANA	OR EQUAL.
UNIT MODEL	AMEC960803BNA	OR EQUAL.
UNIT HEATING INPUT	80,000	BTU/HR.
UNIT HEATING OUTPUT	76,800	BTU/HR.
A/C COOLING CAPACITY	3.0	TONS.
FAN SPEED	1172	CFM

# OF RUNS	S/A	R/A	FANS
3RD FLOOR			
2ND FLOOR	14	4	4
1ST FLOOR	10	1	2
BASEMENT	4	1	


FLOOR PLAN:	
PARTIAL PLAN(S)	
DRAWN BY: AM	CHECKED: DD
LAYOUT NO. JB-04615	DRAWING NO. M6
3454	

DATE:	APRIL 4, 2018
CLIENT:	BAYVIEW WELLINGTON
MODEL:	S42-8C ALT. 2ND FLR RIDEAU 8
PROJECT:	GREEN VALLEY EAST BRADFORD,ONT.
SCALE:	3/16" = 1'-0"


	FLEX DUCT		LOW/HIGH WALL/KICK SUPPLY DIFFUSER		DUCT CONNECTION TO JOIST LINING		RETURN AIR GRILLE (SIZE INDICATED ON DRAWING)	S.A.	SUPPLY AIR
	RIGID ROUND DUCT		HRV EXHAUST GRILLE		RETURN AIR PIPE RISER		RETURN AIR RISER UP TO FLOOR ABOVE	R.A.	RETURN AIR
	SUPPLY DIFFUSER		SUPPLY AIR PIPE RISER		RETURN ROUND DUCT		RETURN AIR FROM BASEMENT SECOND FLOOR		THERMOSTAT
			VOLUME DAMPER						PRINCIPAL EXHAUST FAN SWITCH
									W/R & PRINCIPAL EXHAUST FAN

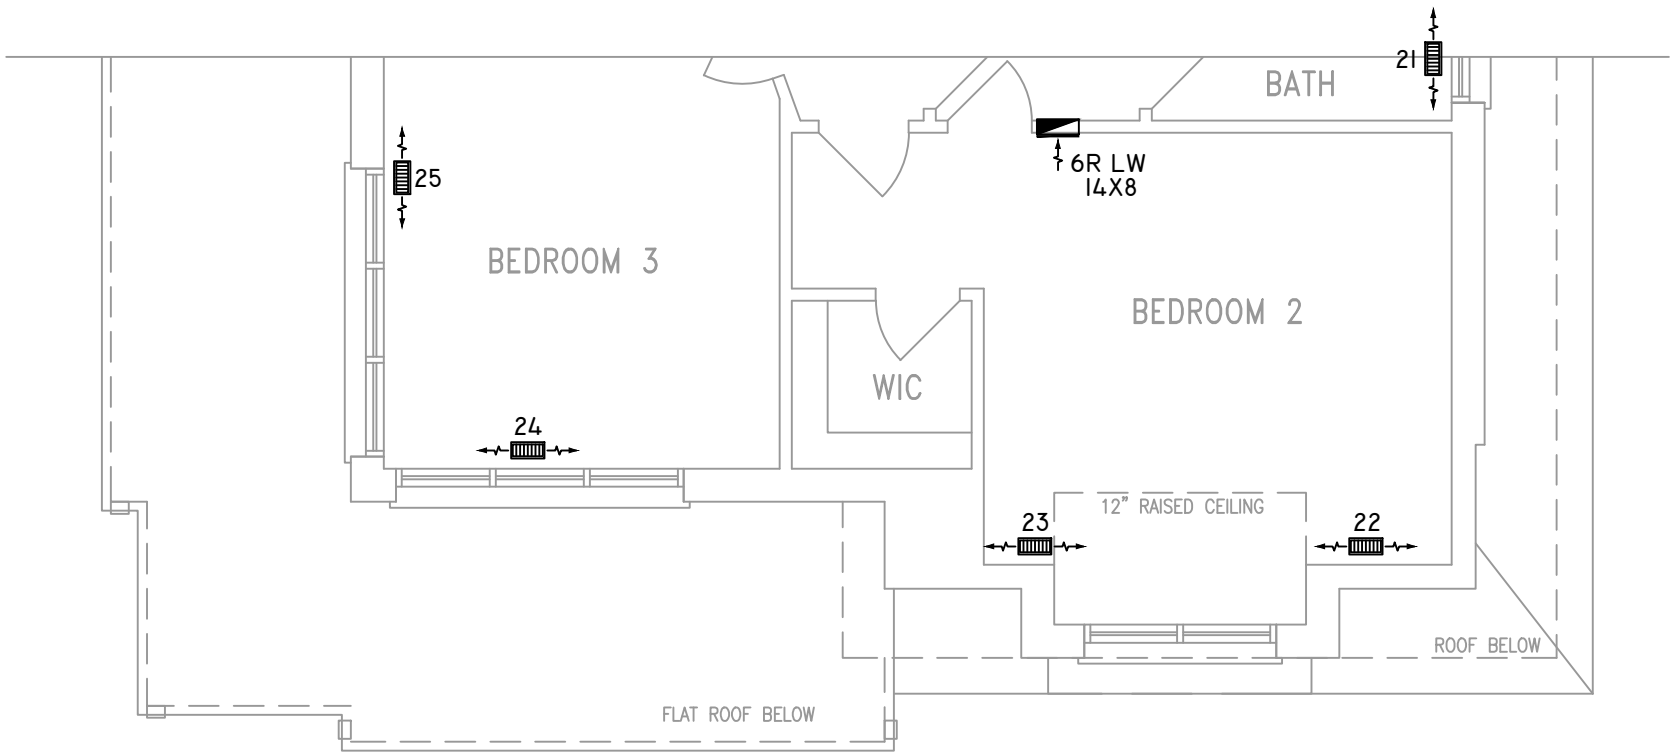

OPT. SECOND FLOOR PLAN 'C' 5 BEDROOM W/ FOUR BATH

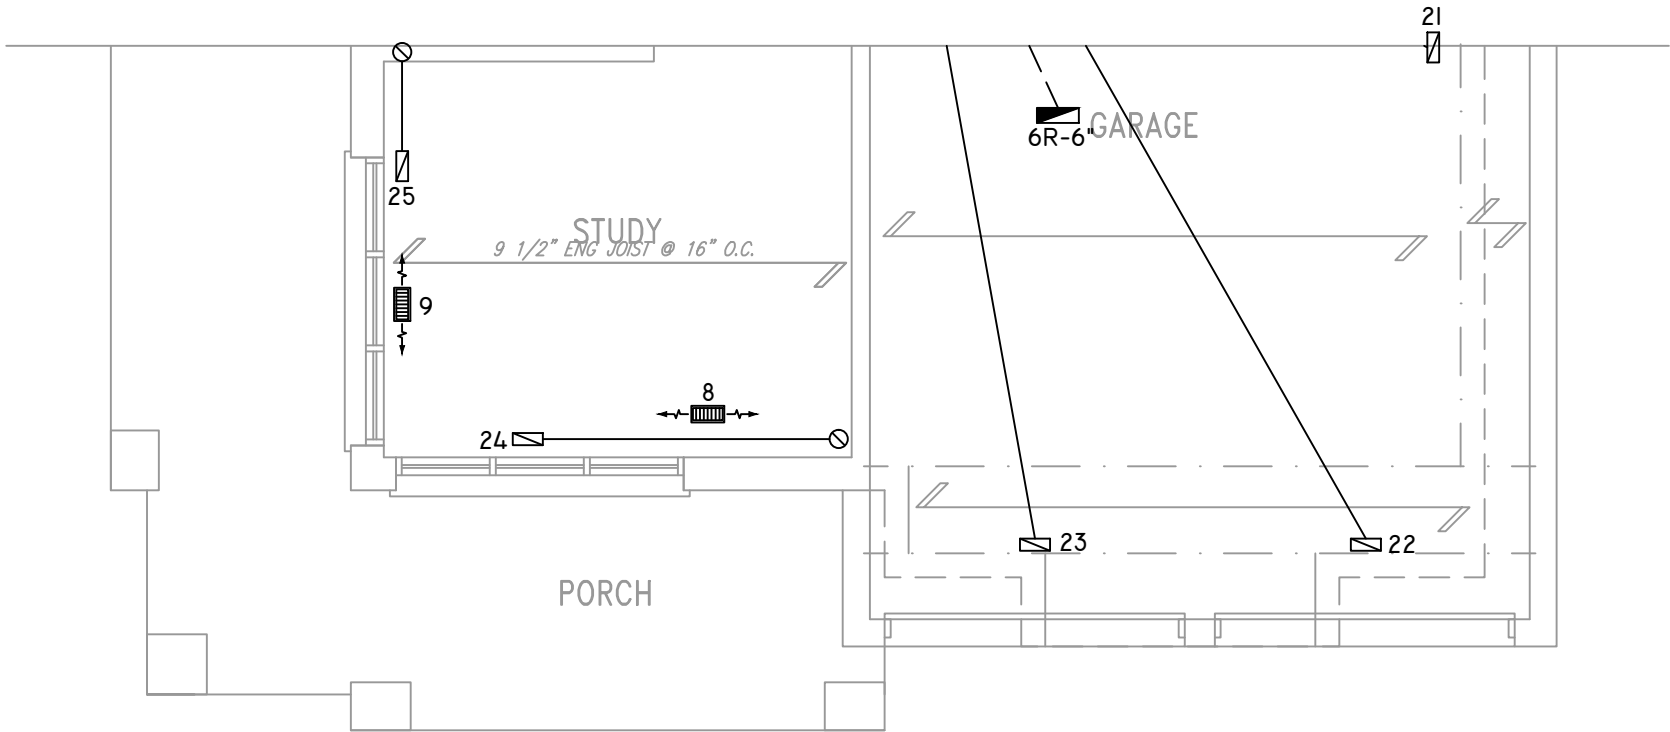

GROUND FLOOR PLAN 'C'

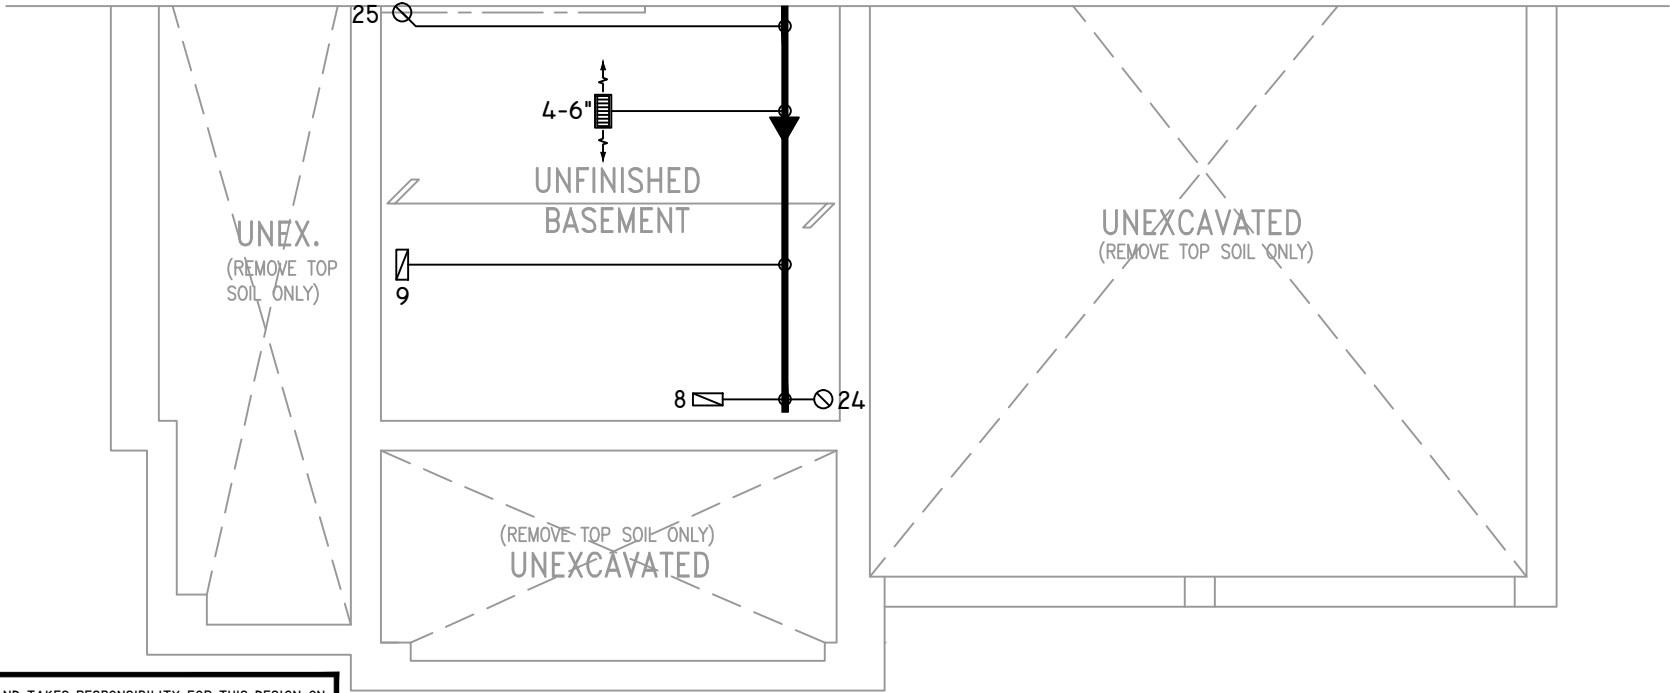


BASEMENT PLAN 'C'

OBC 2012

THE UNDERSIGNED HAS REVIEWED AND TAKES RESPONSIBILITY FOR THIS DESIGN ON BEHALF OF GTA DESIGNS INC. AND HAS THE QUALIFICATIONS AND MEETS THE REQUIREMENTS SET OUT IN THE BUILDING CODE TO BE A DESIGNER

QUALIFICATION INFORMATION

REQUIRED UNLESS DESIGN IS EXEMPT UNDER DIVISION C 3.2.5.1 OF THE ONTARIO BUILDING CODE

DAVID DA COSTA  B.C.I.N. 32964
SIGNATURE OF DESIGNER

Site Copy

ZONE I COMPLIANCE
PACKAGE "A1" REF. TABLE 3.1.1.2.A

NOTES

INSTALLATION TO COMPLY WITH THE LATEST ONTARIO BUILDING CODE.

ALL SUPPLY OUTLETS TO BE 5" DIA. UNLESS OTHERWISE SPECIFIED.

PROVIDE BALANCING DAMPERS ON ALL BRANCHES.

ALL R/A PARTITIONS 6" (FIRST FLOOR ONLY)

INSULATE DUCTS IN UNCONDITIONED SPACES R12 UNDERCUT ALL DOORS 1" MIN.

CONTRACTOR MUST WORK FROM APPROVED PLANS.

ANY ALTERATIONS TO THIS ORIGINAL PLAN ARE NOT THE RESPONSIBILITY OF GTA DESIGNS.

GTA DESIGNS MUST BE CONSULTED IF KITCHEN EXHAUST FAN EXCEEDS 700 CFM DEPRESSURIZATION MAY OCCUR WITH IN THE DWELLING.





 














2985 DREW ROAD
SUITE 202,
MISSISSAUGA, ONT.
L4T 0A4 TEL: 905-671-9800
EMAIL: DAVE@GTADDESIGNS.CA
WEB: WWW.GTADDESIGNS.CA


HEAT-LOSS	61,107	BTU/HR.
UNIT MAKE	AMANA	OR EQUAL.
UNIT MODEL	AMEC960803BNA	OR EQUAL.
UNIT HEATING INPUT	80,000	BTU/HR.
UNIT HEATING OUTPUT	76,800	BTU/HR.
A/C COOLING CAPACITY	3.0	TONS.
FAN SPEED	1172	CFM

# OF RUNS	S/A	R/A	FANS
3RD FLOOR			
2ND FLOOR	14	4	4
1ST FLOOR	10	1	2
BASEMENT	4	1	


FLOOR PLAN:	
PARTIAL PLAN(S)	
DRAWN BY: AM	CHECKED: DD
LAYOUT NO: JB-04615	DRAWING NO: M7
SQFT 3454	

DATE:	APRIL 4, 2018
CLIENT:	BAYVIEW WELLINGTON
MODEL:	S42-8C ALT. 2ND FLR RIDEAU 8
PROJECT:	GREEN VALLEY EAST BRADFORD,ONT.
SCALE:	3/16" = 1'-0"


	FLEX DUCT		LOW/HIGH WALL/KICK SUPPLY DIFFUSER		DUCT CONNECTION TO JOIST LINING		RETURN AIR GRILLE (SIZE INDICATED ON DRAWING)	S.A.	SUPPLY AIR
	RIGID ROUND DUCT		HRV EXHAUST GRILLE		RETURN AIR PIPE RISER		RETURN AIR RISER UP TO FLOOR ABOVE	R.A.	RETURN AIR
	SUPPLY DIFFUSER		SUPPLY AIR PIPE RISER		RETURN ROUND DUCT		RETURN AIR FROM BASEMENT SECOND FLOOR		THERMOSTAT
			VOLUME DAMPER						PRINCIPAL EXHAUST FAN SWITCH
									W/R & PRINCIPAL EXHAUST FAN

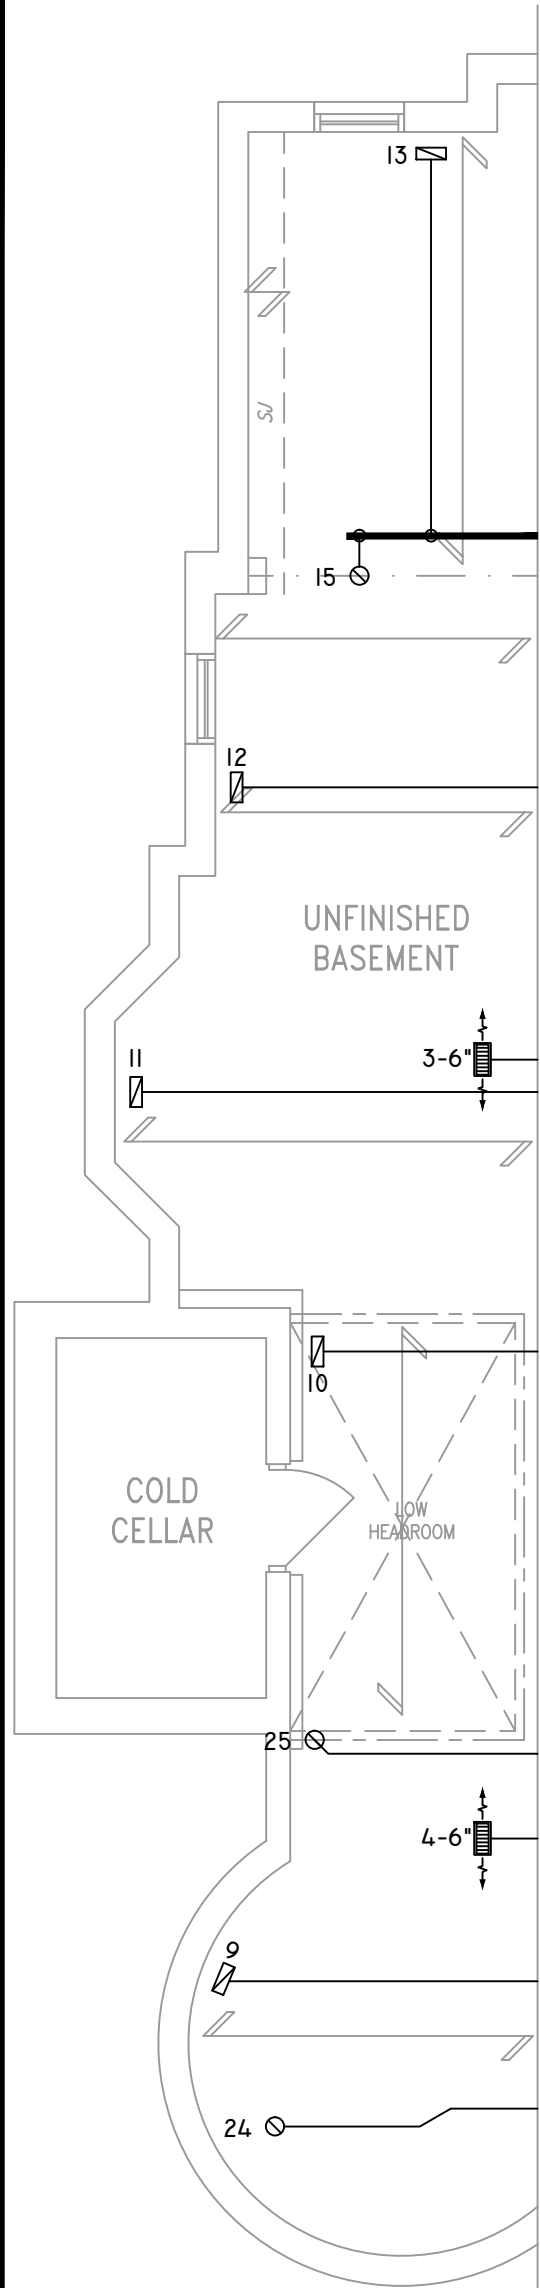

BASEMENT PLAN 'B'

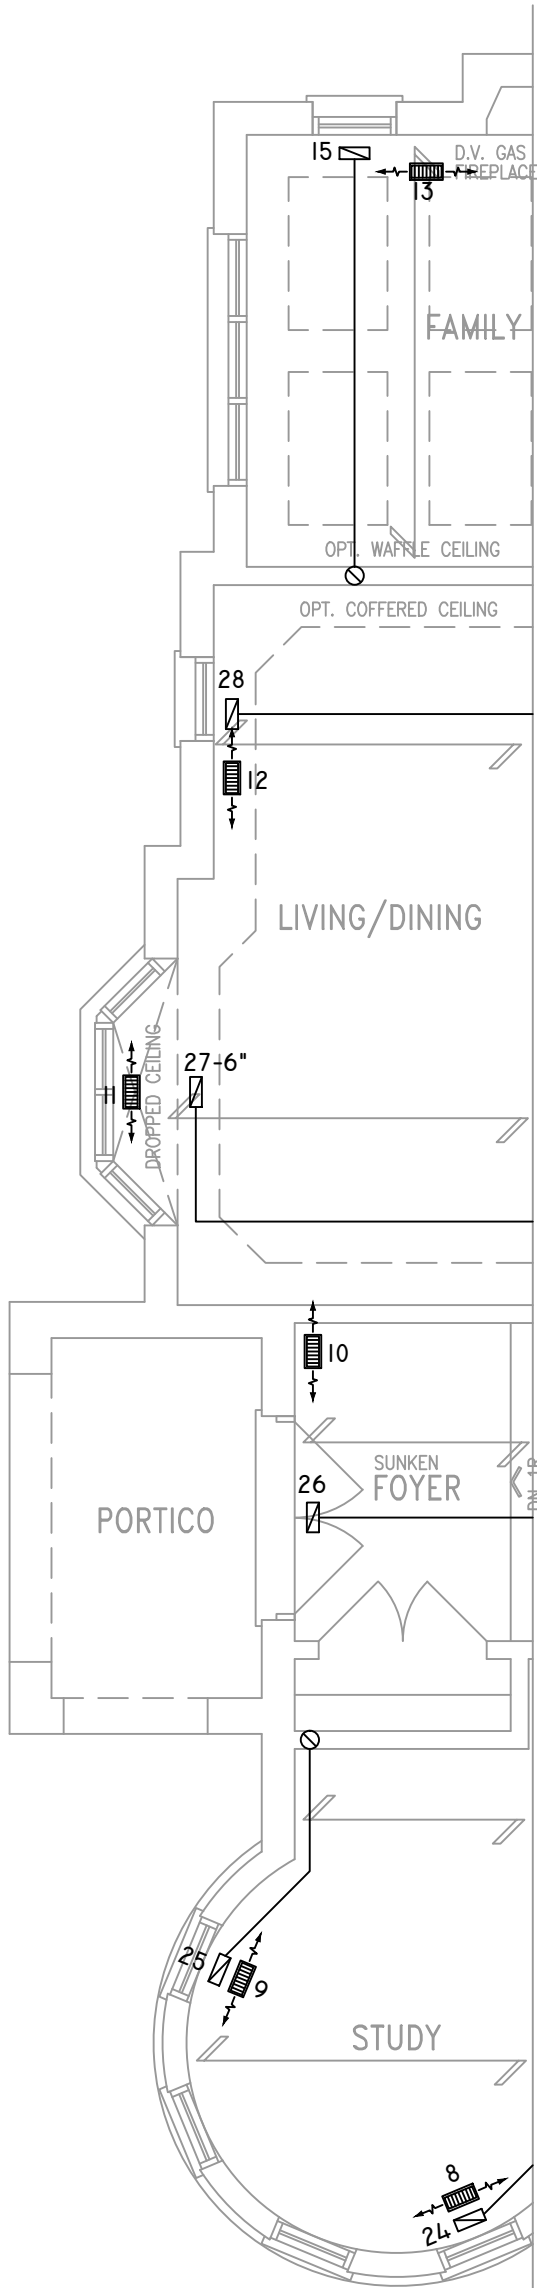

GROUND FLOOR PLAN 'B'

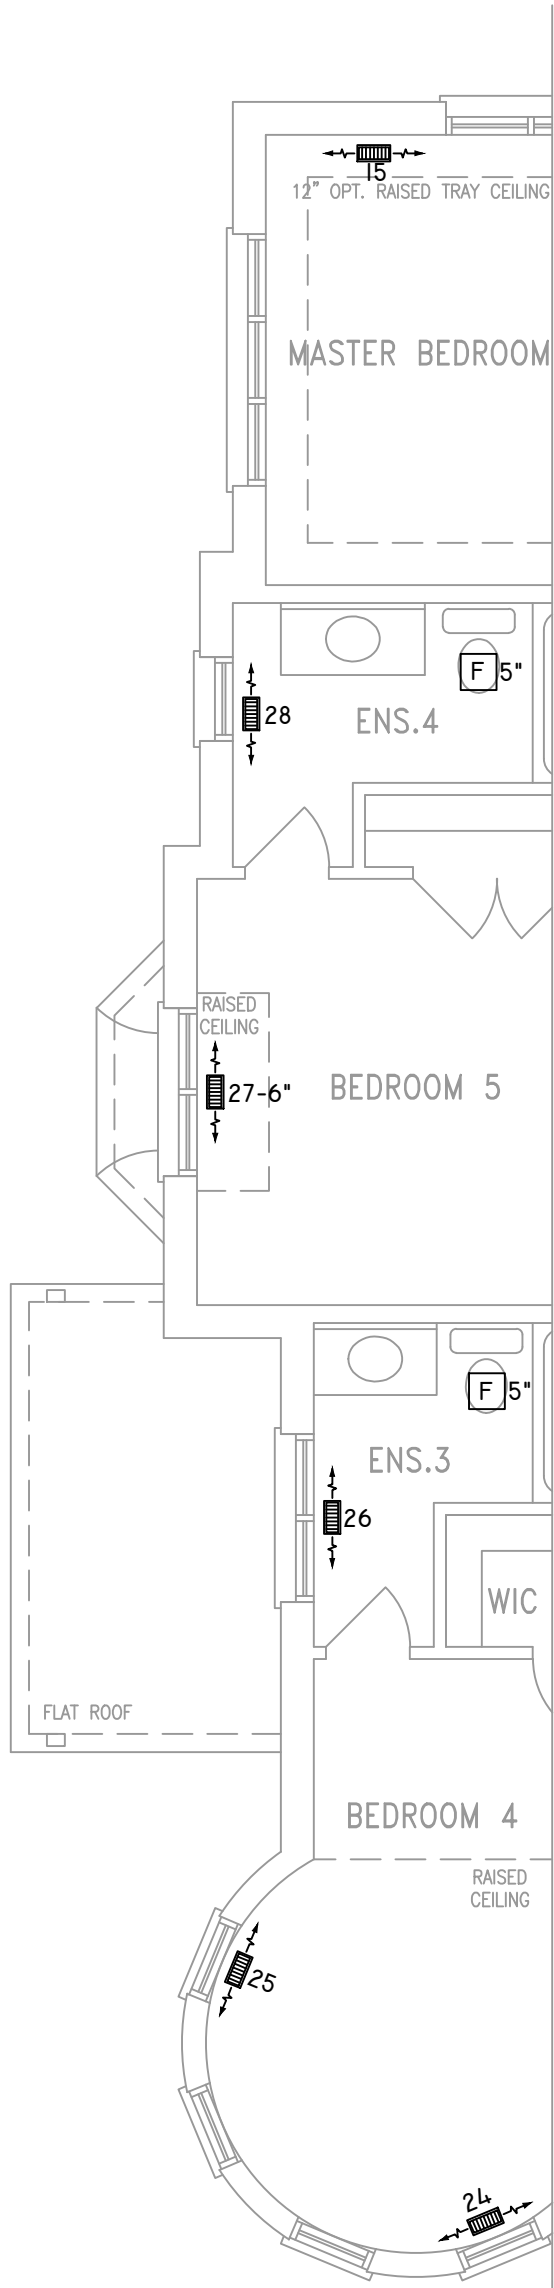


OPT. SECOND FLOOR PLAN 'B'
5 BEDROOM W/ FOUR BATH

THE UNDERSIGNED HAS REVIEWED AND TAKES RESPONSIBILITY FOR THIS DESIGN ON BEHALF OF GTA DESIGNS INC. AND HAS THE QUALIFICATIONS AND MEETS THE REQUIREMENTS SET OUT IN THE BUILDING CODE TO BE A DESIGNER

QUALIFICATION INFORMATION

 REQUIRED UNLESS DESIGN IS EXEMPT UNDER DIVISION C 3.2.5.1 OF THE ONTARIO BUILDING CODE

DAVID DA COSTA  B.C.I.N. 32964

SIGNATURE OF DESIGNER

NOTES
INSTALLATION TO COMPLY WITH THE LATEST ONTARIO BUILDING CODE.
ALL SUPPLY OUTLETS TO BE 5" DIA. UNLESS OTHERWISE SPECIFIED.
PROVIDE BALANCING DAMPERS ON ALL BRANCHES.
ALL R/A PARTITIONS 6" (FIRST FLOOR ONLY)
INSULATE DUCTS IN UNCONDITIONED SPACES R12 UNDERCUT ALL DOORS 1" MIN.
CONTRACTOR MUST WORK FROM APPROVED PLANS.
ANY ALTERATIONS TO THIS ORIGINAL PLAN ARE NOT THE RESPONSIBILITY OF GTA DESIGNS.
GTA DESIGNS MUST BE CONSULTED IF KITCHEN EXHAUST FAN EXCEEDS 700 CFM DEPRESSURIZATION MAY OCCUR WITH IN THE DWELLING.



2985 DREW ROAD
SUITE 202,
MISSISSAUGA, ONT.
L4T 0A4 TEL: 905-671-9800
EMAIL: DAVE@GTADESIGNS.CA
WEB: WWW.GTADESIGNS.CA

HEAT-LOSS	61,107	BTU/HR.
UNIT MAKE	AMANA	OR EQUAL.
UNIT MODEL	AMEC960803BNA	OR EQUAL.
UNIT HEATING INPUT	80,000	BTU/HR.
UNIT HEATING OUTPUT	76,800	BTU/HR.
A/C COOLING CAPACITY	3.0	TONS.
FAN SPEED	1172	CFM

# OF RUNS	S/A	R/A	FANS
3RD FLOOR			
2ND FLOOR	14	4	4
1ST FLOOR	10	1	2
BASEMENT	4	1	



 







 





FLOOR PLAN:		
PARTIAL PLAN(S)		
DRAWN BY:	CHECKED:	SQFT
AM	DD	3454
LAYOUT NO.	DRAWING NO.	
JB-04615	M8	


DATE:	APRIL 4, 2018
CLIENT:	BAYVIEW WELLINGTON
MODEL:	S42-8C ALT. 2ND FLR RIDEAU 8
PROJECT:	GREEN VALLEY EAST BRADFORD,ONT.
SCALE:	3/16" = 1'-0"

OBC 2012


Site Copy

ZONE I COMPLIANCE
PACKAGE "A1" REF. TABLE 3.1.1.2.A


	FLEX DUCT		LOW/HIGH WALL/KICK SUPPLY DIFFUSER		DUCT CONNECTION TO JOIST LINING		RETURN AIR GRILLE (SIZE INDICATED ON DRAWING)	S.A.	SUPPLY AIR
	RIGID ROUND DUCT		HRV EXHAUST GRILLE		RETURN AIR PIPE RISER		RETURN AIR RISER UP TO FLOOR ABOVE	R.A.	RETURN AIR
	SUPPLY DIFFUSER		SUPPLY AIR PIPE RISER		RETURN ROUND DUCT		RETURN AIR FROM BASEMENT SECOND FLOOR		THERMOSTAT
			VOLUME DAMPER						PRINCIPAL EXHAUST FAN SWITCH
									W/R & PRINCIPAL EXHAUST FAN

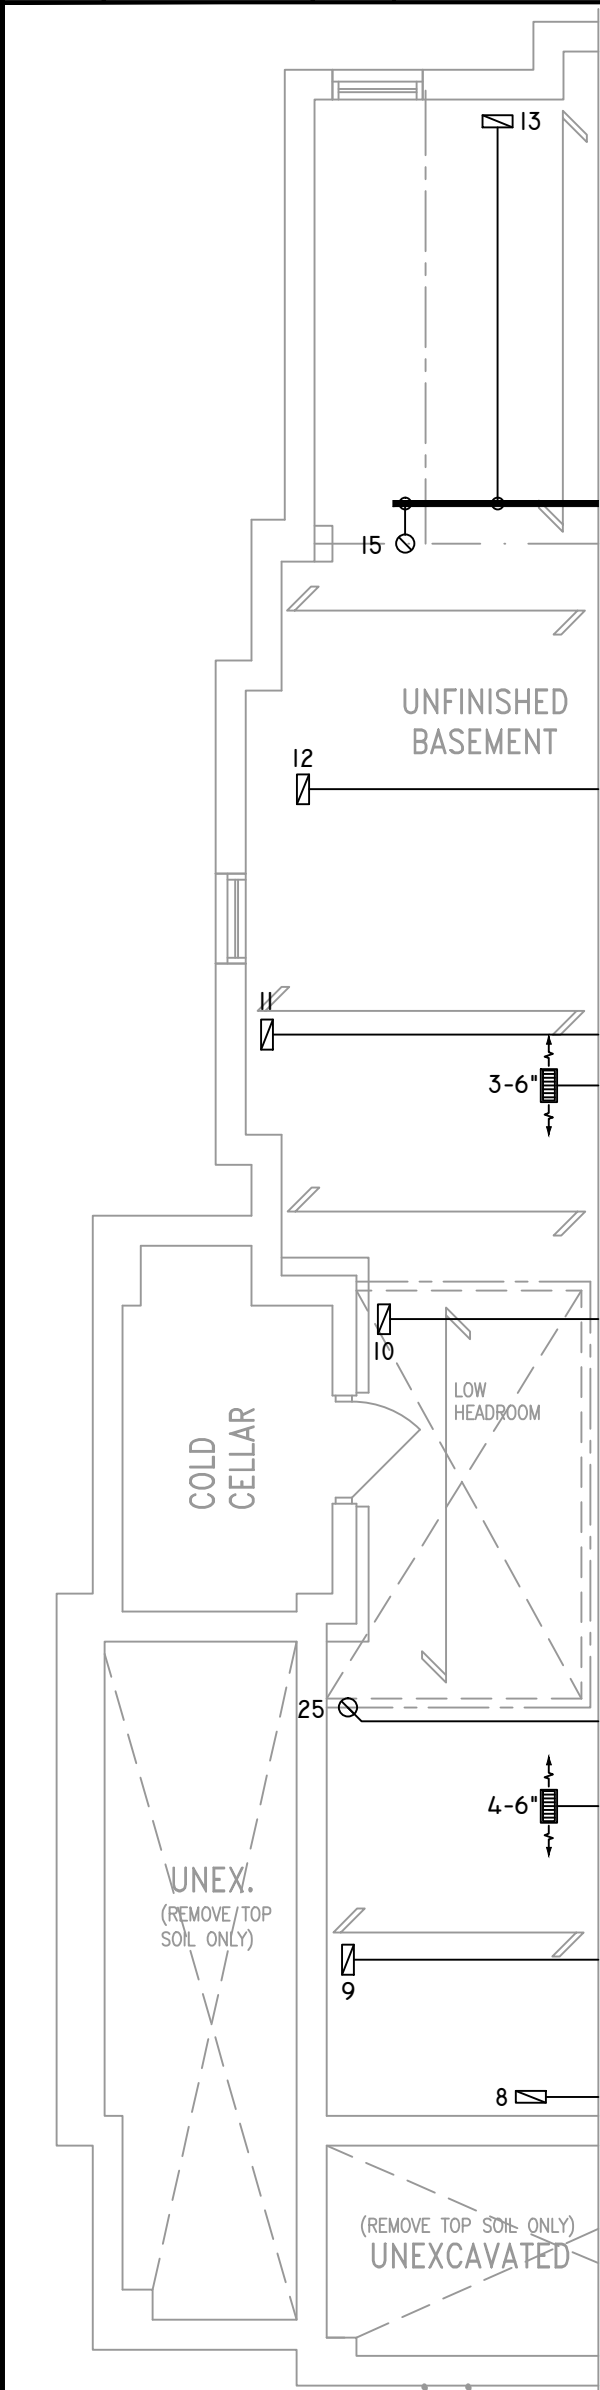

BASEMENT PLAN 'C'

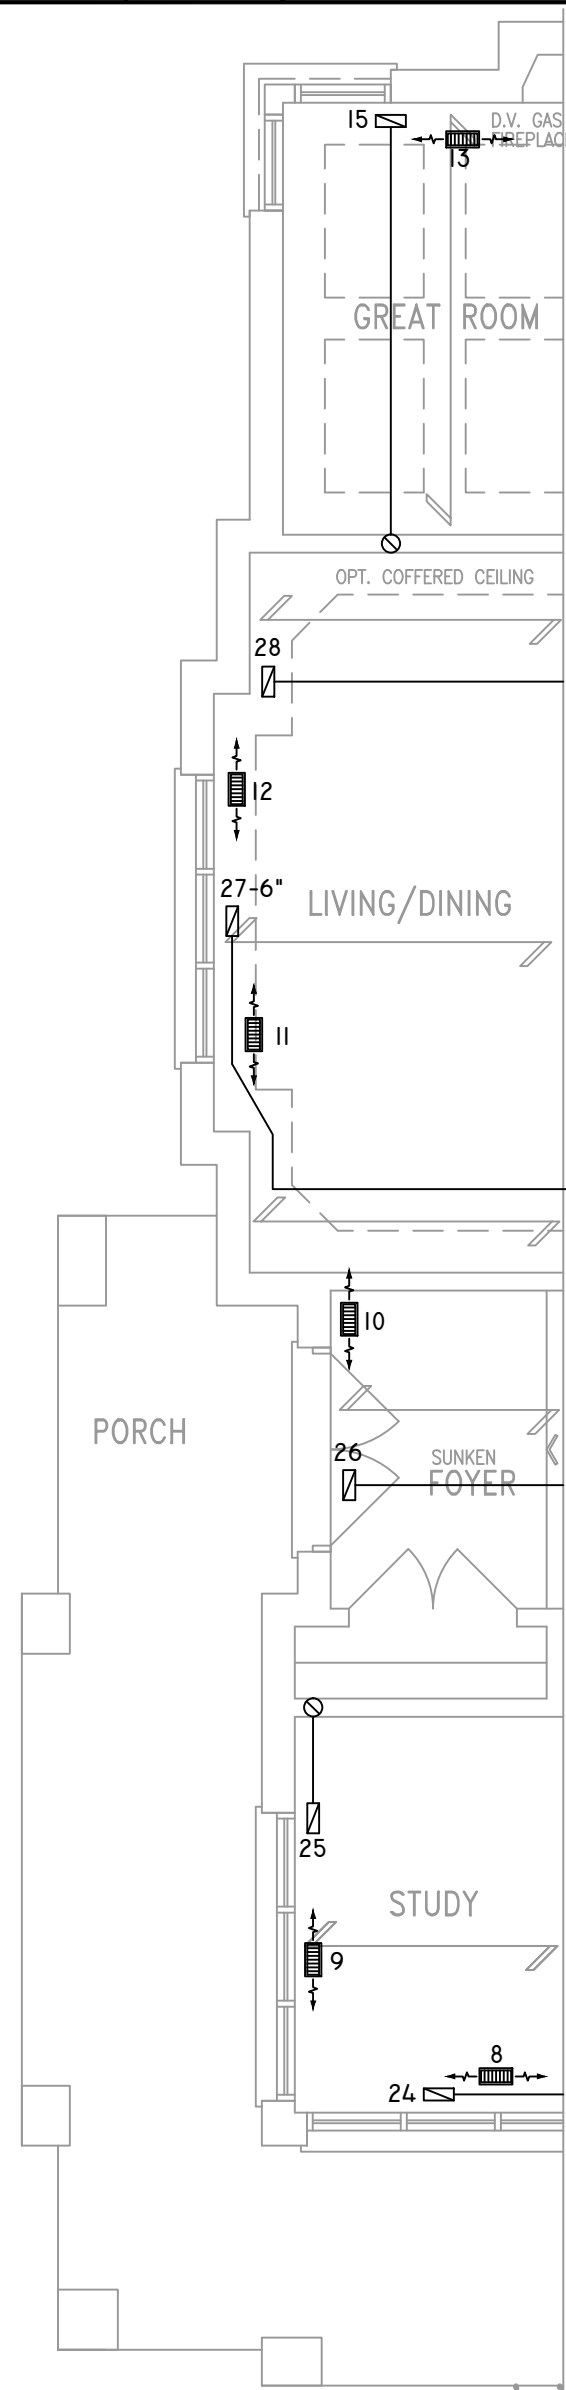

GROUND FLOOR PLAN 'C'

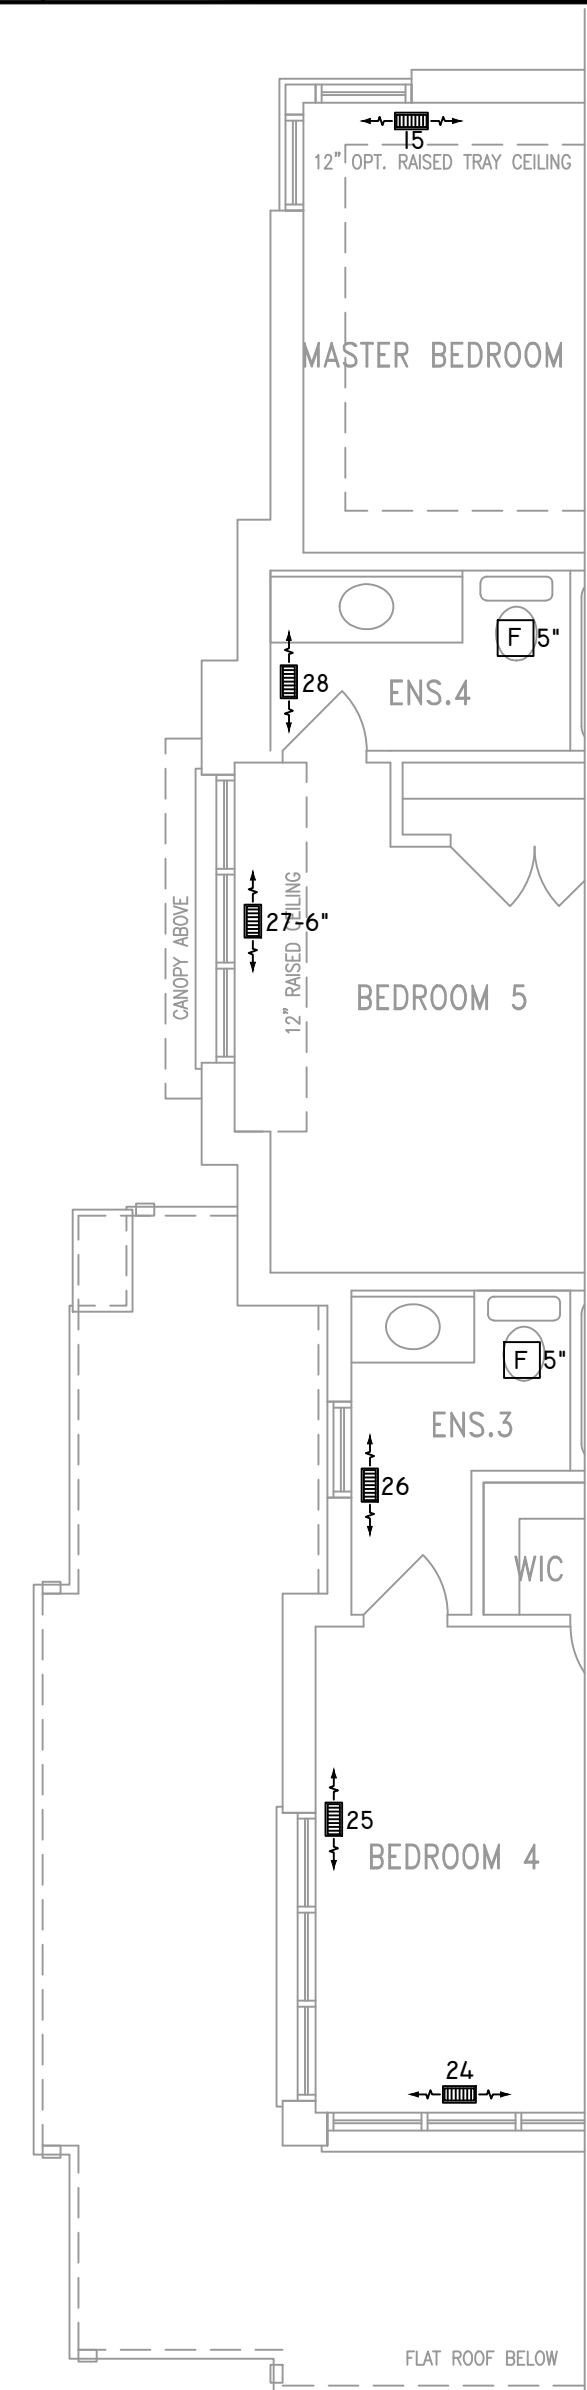


OPT. SECOND FLOOR PLAN 'C'
5 BEDROOM W/ FOUR BATH

THE UNDERSIGNED HAS REVIEWED AND TAKES RESPONSIBILITY FOR THIS DESIGN ON BEHALF OF GTA DESIGNS INC. AND HAS THE QUALIFICATIONS AND MEETS THE REQUIREMENTS SET OUT IN THE BUILDING CODE TO BE A DESIGNER

QUALIFICATION INFORMATION

REQUIRED UNLESS DESIGN IS EXEMPT UNDER DIVISION C 3.2.5.1 OF THE ONTARIO BUILDING CODE

DAVID DA COSTA  B.C.I.N. 32964
SIGNATURE OF DESIGNER

NOTES

INSTALLATION TO COMPLY WITH THE LATEST ONTARIO BUILDING CODE.

ALL SUPPLY OUTLETS TO BE 5" DIA. UNLESS OTHERWISE SPECIFIED.

PROVIDE BALANCING DAMPERS ON ALL BRANCHES.

ALL R/A PARTITIONS 6" (FIRST FLOOR ONLY)

INSULATE DUCTS IN UNCONDITIONED SPACES R12 UNDERCUT ALL DOORS 1" MIN.

CONTRACTOR MUST WORK FROM APPROVED PLANS.

ANY ALTERATIONS TO THIS ORIGINAL PLAN ARE NOT THE RESPONSIBILITY OF GTA DESIGNS.

GTA DESIGNS MUST BE CONSULTED IF KITCHEN EXHAUST FAN EXCEEDS 700 CFM DEPRESSURIZATION MAY OCCUR WITH IN THE DWELLING.



2985 DREW ROAD
SUITE 202,
MISSISSAUGA, ONT.
L4T 0A4 TEL: 905-671-9800
EMAIL: DAVE@GTADDESIGNS.CA
WEB: WWW.GTADDESIGNS.CA

HEAT-LOSS	61,107	BTU/HR.
UNIT MAKE	AMANA	OR EQUAL.
UNIT MODEL	AMEC960803BNA	OR EQUAL.
UNIT HEATING INPUT	80,000	BTU/HR.
UNIT HEATING OUTPUT	76,800	BTU/HR.
A/C COOLING CAPACITY	3.0	TONS.
FAN SPEED	1172	CFM

# OF RUNS	S/A	R/A	FANS
3RD FLOOR			
2ND FLOOR	14	4	4
1ST FLOOR	10	1	2
BASEMENT	4	1	



 














FLOOR PLAN: PARTIAL PLAN(S)		
DRAWN BY: AM	CHECKED: DD	SQFT 3454
LAYOUT NO. JB-04615	DRAWING NO. M9	


DATE: APRIL 4, 2018
CLIENT: BAYVIEW WELLINGTON
MODEL: S42-8C ALT. 2ND FLR RIDEAU 8
PROJECT: GREEN VALLEY EAST BRADFORD,ONT.
SCALE: 3/16" = 1'-0"

Site Copy


ZONE I COMPLIANCE
PACKAGE "A1" REF. TABLE 3.1.1.2.A

OBC 2012


	FLEX DUCT		LOW/HIGH WALL/KICK SUPPLY DIFFUSER		DUCT CONNECTION TO JOIST LINING		RETURN AIR GRILLE (SIZE INDICATED ON DRAWING)	S.A.	SUPPLY AIR
	RIGID ROUND DUCT		HRV EXHAUST GRILLE		RETURN AIR PIPE RISER		RETURN AIR RISER UP TO FLOOR ABOVE	R.A.	RETURN AIR
	SUPPLY DIFFUSER		SUPPLY AIR PIPE RISER		RETURN ROUND DUCT		RETURN AIR FROM BASEMENT SECOND FLOOR		THERMOSTAT
			VOLUME DAMPER						PRINCIPAL EXHAUST FAN SWITCH
									W/R & PRINCIPAL EXHAUST FAN

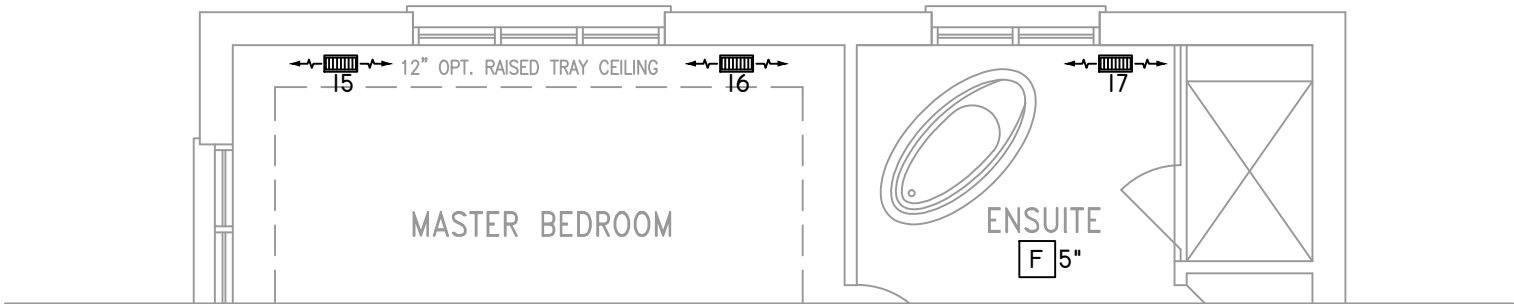

SECOND FLOOR PLAN 'B' 5
BEDROOM W/ FOUR BATH

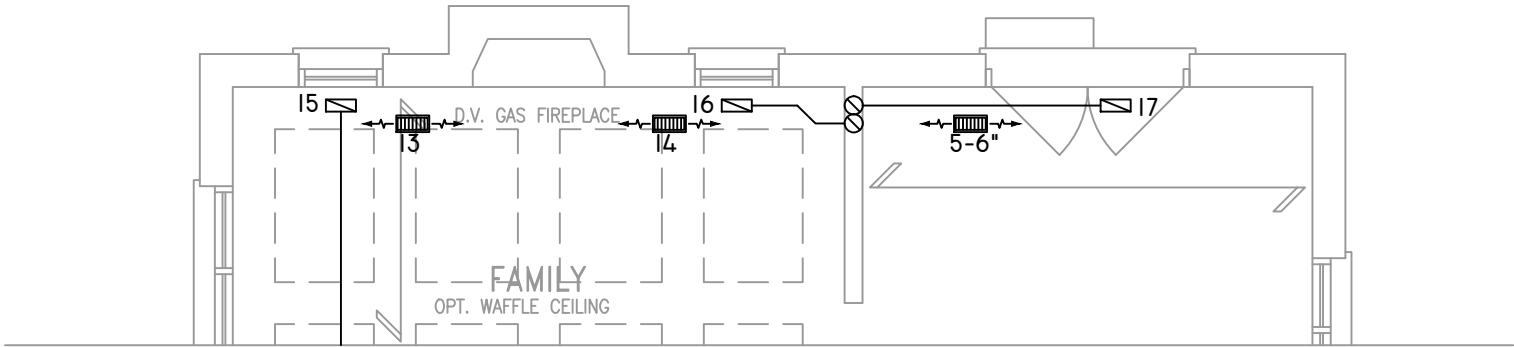

GROUND FLOOR PLAN 'B'

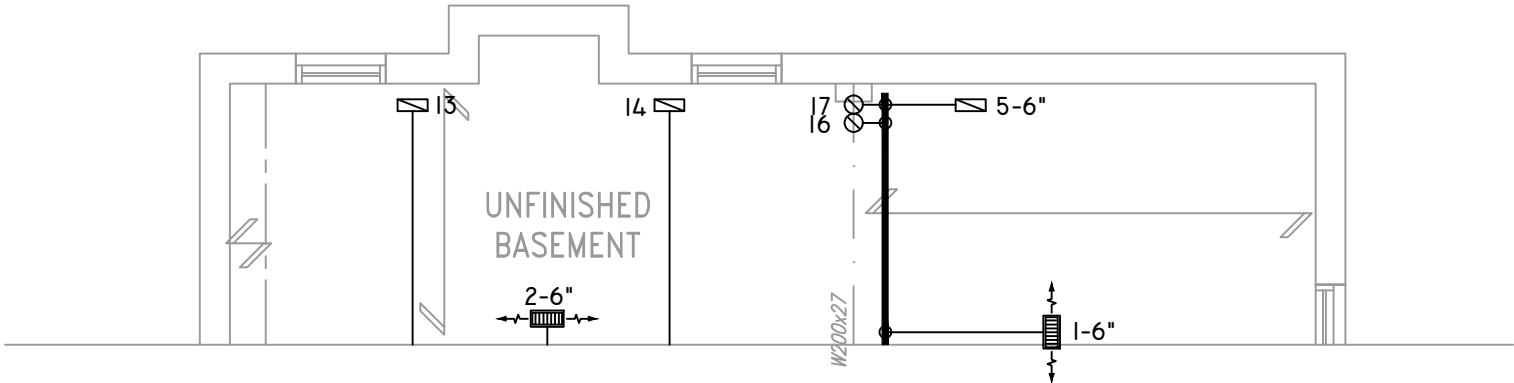

BASEMENT PLAN 'B'

THE UNDERSIGNED HAS REVIEWED AND TAKES RESPONSIBILITY FOR THIS DESIGN ON BEHALF OF GTA DESIGNS INC. AND HAS THE QUALIFICATIONS AND MEETS THE REQUIREMENTS SET OUT IN THE BUILDING CODE TO BE A DESIGNER

QUALIFICATION INFORMATION

REQUIRED UNLESS DESIGN IS EXEMPT UNDER DIVISION C 3.2.5.1 OF THE ONTARIO BUILDING CODE

DAVID DA COSTA  B.C.I.N. 32964

SIGNATURE OF DESIGNER

OBC 2012

ZONE I COMPLIANCE
PACKAGE "A1" REF. TABLE 3.1.1.2.A

NOTES

INSTALLATION TO COMPLY WITH THE LATEST ONTARIO BUILDING CODE.

ALL SUPPLY OUTLETS TO BE 5" DIA. UNLESS OTHERWISE SPECIFIED.

PROVIDE BALANCING DAMPERS ON ALL BRANCHES.

ALL R/A PARTITIONS 6" (FIRST FLOOR ONLY)

INSULATE DUCTS IN UNCONDITIONED SPACES R12 UNDERCUT ALL DOORS 1" MIN.

CONTRACTOR MUST WORK FROM APPROVED PLANS.

ANY ALTERATIONS TO THIS ORIGINAL PLAN ARE NOT THE RESPONSIBILITY OF GTA DESIGNS.

GTA DESIGNS MUST BE CONSULTED IF KITCHEN EXHAUST FAN EXCEEDS 700 CFM DEPRESSURIZATION MAY OCCUR WITH IN THE DWELLING.





 













2985 DREW ROAD
SUITE 202,
MISSISSAUGA, ONT.
L4T 0A4 TEL: 905-671-9800
EMAIL: DAVE@GTADESIGNS.CA
WEB: WWW.GTADESIGNS.CA


HEAT-LOSS	61,107	BTU/HR.
UNIT MAKE	AMANA	OR EQUAL.
UNIT MODEL	AMEC960803BNA	OR EQUAL.
UNIT HEATING INPUT	80,000	BTU/HR.
UNIT HEATING OUTPUT	76,800	BTU/HR.
A/C COOLING CAPACITY	3.0	TONS.
FAN SPEED	1172	CFM
 
# OF RUNS	S/A	R/A	FANS
3RD FLOOR			
2ND FLOOR	14	4	4
1ST FLOOR	10	1	2
BASEMENT	4	1	


FLOOR PLAN: PARTIAL PLAN(S)		
DRAWN BY: AM	CHECKED: DD	SQFT 3454
LAYOUT NO. JB-04615	DRAWING NO. M10	

DATE:	APRIL 4, 2018
CLIENT:	BAYVIEW WELLINGTON
MODEL:	S42-8C ALT. 2ND FLR RIDEAU 8
PROJECT:	GREEN VALLEY EAST BRADFORD,ONT.
SCALE:	3/16" = 1'-0"


	FLEX DUCT		LOW/HIGH WALL/KICK SUPPLY DIFFUSER		DUCT CONNECTION TO JOIST LINING		RETURN AIR GRILLE (SIZE INDICATED ON DRAWING)	S.A.	SUPPLY AIR
	RIGID ROUND DUCT		HRV EXHAUST GRILLE		RETURN AIR PIPE RISER		RETURN AIR RISER UP TO FLOOR ABOVE	R.A.	RETURN AIR
	SUPPLY DIFFUSER		SUPPLY AIR PIPE RISER		RETURN ROUND DUCT		RETURN AIR FROM BASEMENT SECOND FLOOR		THERMOSTAT
			VOLUME DAMPER						PRINCIPAL EXHAUST FAN SWITCH
									W/R & PRINCIPAL EXHAUST FAN

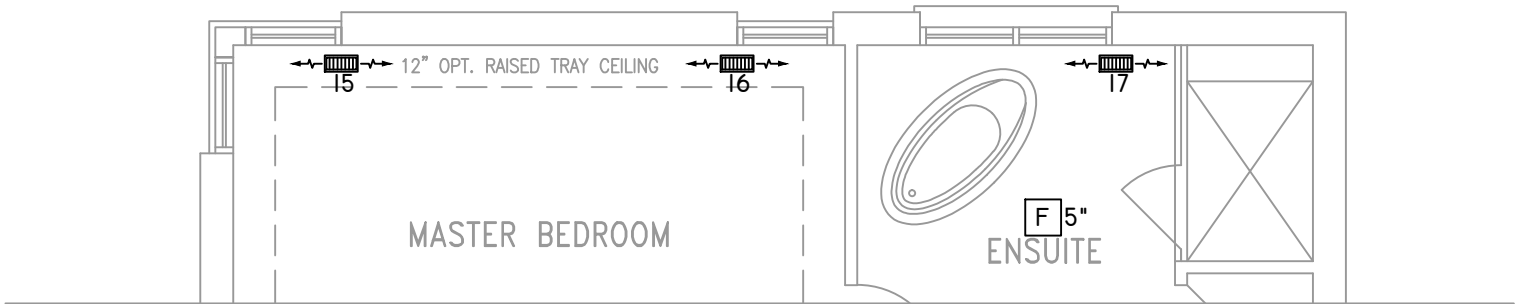

SECOND FLOOR PLAN 'C' 5 BEDROOM W/ FOUR BATH

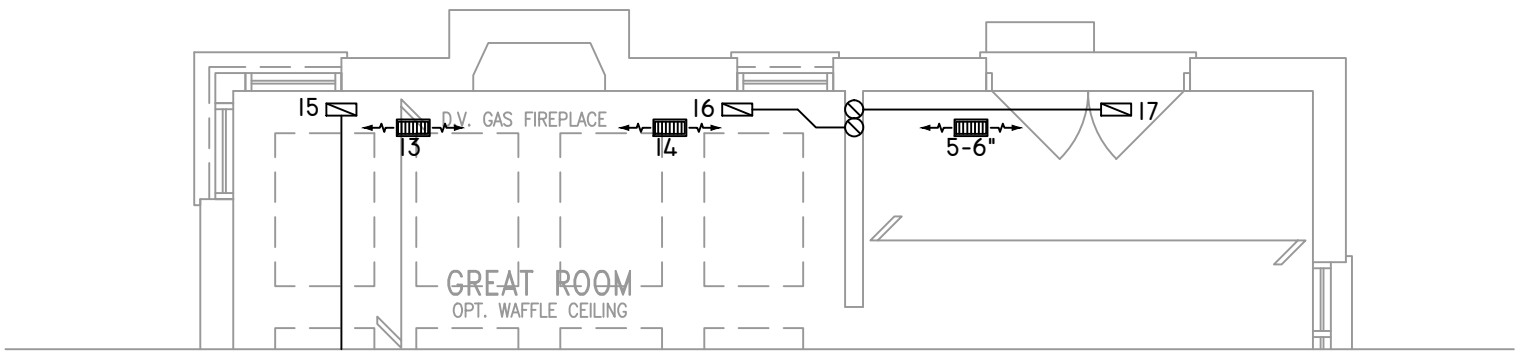

GROUND FLOOR PLAN 'C'

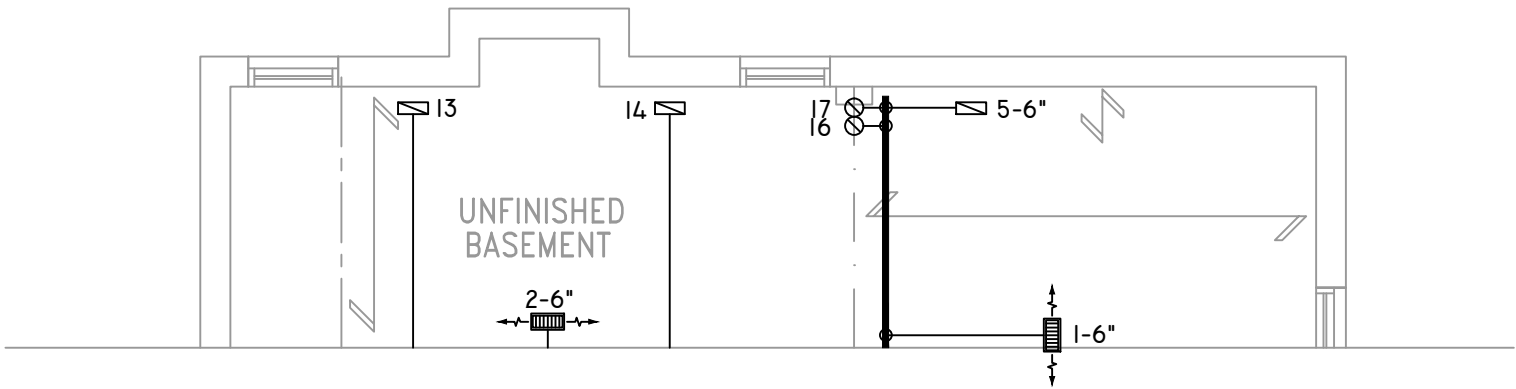


BASEMENT PLAN 'C'

THE UNDERSIGNED HAS REVIEWED AND TAKES RESPONSIBILITY FOR THIS DESIGN ON BEHALF OF GTA DESIGNS INC. AND HAS THE QUALIFICATIONS AND MEETS THE REQUIREMENTS SET OUT IN THE BUILDING CODE TO BE A DESIGNER

QUALIFICATION INFORMATION

REQUIRED UNLESS DESIGN IS EXEMPT UNDER DIVISION C 3.2.5.1 OF THE ONTARIO BUILDING CODE

 DAVID DA COSTA



B.C.I.N. 32964

SIGNATURE OF DESIGNER

OBC 2012

Site Copy

ZONE I COMPLIANCE
PACKAGE "A1" REF. TABLE 3.1.1.2.A

NOTES
INSTALLATION TO COMPLY WITH THE LATEST ONTARIO BUILDING CODE.
ALL SUPPLY OUTLETS TO BE 5" DIA. UNLESS OTHERWISE SPECIFIED.
PROVIDE BALANCING DAMPERS ON ALL BRANCHES.
ALL R/A PARTITIONS 6" (FIRST FLOOR ONLY)
INSULATE DUCTS IN UNCONDITIONED SPACES R12 UNDERCUT ALL DOORS 1" MIN.
CONTRACTOR MUST WORK FROM APPROVED PLANS.
ANY ALTERATIONS TO THIS ORIGINAL PLAN ARE NOT THE RESPONSIBILITY OF GTA DESIGNS.
GTA DESIGNS MUST BE CONSULTED IF KITCHEN EXHAUST FAN EXCEEDS 700 CFM DEPRESSURIZATION MAY OCCUR WITH IN THE DWELLING.



2985 DREW ROAD
SUITE 202,
MISSISSAUGA, ONT.
L4T 0A4 TEL: 905-671-9800
EMAIL: DAVE@GTADESIGNS.CA
WEB: WWW.GTADESIGNS.CA

HEAT-LOSS	61,107	BTU/HR.
UNIT MAKE	AMANA	OR EQUAL.
UNIT MODEL	AMEC960803BNA	OR EQUAL.
UNIT HEATING INPUT	80,000	BTU/HR.
UNIT HEATING OUTPUT	76,800	BTU/HR.
A/C COOLING CAPACITY	3.0	TONS.
FAN SPEED	1172	CFM

# OF RUNS	S/A	R/A	FANS
3RD FLOOR			
2ND FLOOR	14	4	4
1ST FLOOR	10	1	2
BASEMENT	4	1	

FLOOR PLAN:		
PARTIAL PLAN(S)		
DRAWN BY:	CHECKED:	SQFT
AM	DD	3454
LAYOUT NO.	DRAWING NO.	
JB-04615	M11	

DATE:	APRIL 4, 2018
CLIENT:	BAYVIEW WELLINGTON
MODEL:	S42-8C ALT. 2ND FLR RIDEAU 8
PROJECT:	GREEN VALLEY EAST BRADFORD,ONT.
SCALE:	3/16" = 1'-0"