

Use one form for each individual who reviews and takes responsibility for design activities with respect to the project.

A. Project Information					
Building number, street name Rideau 16 S42-16 WOB				Lot: Lot/con.	
Municipality Bradford		Postal code	Plan number/ other description		
B. Individual who reviews and takes responsibility for design activities					
Name David DaCosta			Firm gtaDesigns Inc.		
Street address 2985 Drew Road, Suite 202				Unit no.	Lot/con.
Municipality Mississauga		Postal code L4T 0A4	Province Ontario	E-mail dave@gtadesigns.ca	
Telephone number (905) 671-9800		Fax number (647) 494-9643		Cell number (416) 268-6820	
C. Design activities undertaken by individual identified in Section B. [Building Code Table 3.5.2.1 of Division C]					
☐ House ☒ HVAC – House ☐ Building Structural ☐ Small Buildings ☐ Building Services ☐ Plumbing – House ☐ Large Buildings ☐ Detection, Lighting and Power ☐ Plumbing – All Buildings ☐ Complex Buildings ☐ Fire Protection ☐ On-site Sewage Systems					
Description of designer's work				Model Certification	
Heating and Cooling Load Calculations Air System Design Residential mechanical ventilation Design Summary Residential System Design per CAN/CSA-F280-12 Residential New Construction - Forced Air				Project #: PJ-00204	
				Layout #: JB-04592	
				Builder	Bayview Wellington
				Project	Green Valley East
				Model	Rideau 16 S42-16 WOB
				SB-12	Package A1
D. Declaration of Designer					
I, <u>David DaCosta</u> declare that (choose one as appropriate): (print name)					
☐ I review and take responsibility for the design work on behalf of a firm registered under subsection 3.2.4 Division C of the Building Code. I am qualified, and the firm is registered, in the appropriate classes/categories. Individual BCIN: _____ Firm BCIN: _____					
☒ I review and take responsibility for the design and am qualified in the appropriate category as an "other designer" under subsection 3.2.5 of Division C, of the Building Code. Individual BCIN: <u>32964</u> Basis for exemption from registration: <u>Division C 3.2.4.1. (4)</u>					
☐ The design work is exempt from the registration and qualification requirements of the Building Code. Basis for exemption from registration and qualification:					
I certify that: 1. The information contained in this schedule is true to the best of my knowledge. 2. I have submitted this application with the knowledge and consent of the firm.					
<u>April 4, 2018</u> Date				 Signature of Designer	

NOTE:

- For the purposes of this form, "individual" means the "person" referred to in Clause 3.2.4.7(1) d), of Division C, Article 3.2.5.1. of Division C and all other persons who are exempt from qualifications under Subsections 3.2.4 . and 3.2.5.of Division C.
- Schedule 1 does not require to be completed a holder of a license, temporary license, or a certificate of authorization, issued by the Ontario Association of Architects. Schedule 1 is also not required to be completed by a holder of a license to practise, a limited licence to practise, or a certificate of authorization, issued by the Association of Professional Engineers of Ontario.

Heat loss and gain calculation summary sheet				CSA-F280-M12 Standard Form No. 1	
These documents issued for the use of Bayview Wellington				Layout No.	
and may not be used by any other persons without authorization. Documents for permit and/or construction are signed in red.				JB-04592	
Building Location					
Address (Model): S42-16 WOB			Site: Green Valley East		
Model: Rideau 16			Lot:		
City and Province: Bradford			Postal code:		
Calculations based on					
Dimensional information based on:			VA3 Design Jan/2018		
Attachment: Detached			Front facing: East/West		Assumed? Yes
No. of Levels: 3		Ventilated? Included	Air tightness: 1961-Present (ACH=3.57)		Assumed? Yes
Weather location: Bradford			Wind exposure: Sheltered		
HRV? LifeBreath		RNC155	Internal shading: Light-translucent		Occupants: 5
Sensible Eff. at -25C 71%		Apparent Effect. at -0C 84%	Units: Imperial		Area Sq ft: 2687
Sensible Eff. at -0C 75%					
Heating design conditions			Cooling design conditions		
Outdoor temp -9.4 Indoor temp: 72 Mean soil temp: 48			Outdoor temp 86 Indoor temp: 75 Latitude: 44		
Above grade walls			Below grade walls		
Style A: As per OBC SB12 Package A1 R 22			Style A: As per OBC SB12 Package A1 R 20ci		
Style B: Existing Walls (When Applicable) R 12			Style B:		
Style C:			Style C:		
Style D:			Style D:		
Floors on soil			Ceilings		
Style A: As per Selected OBC SB12 Package A1			Style A: As per Selected OBC SB12 Package A1 R 60		
Style B:			Style B: As per Selected OBC SB12 Package A1 R 31		
Exposed floors			Style C:		
Style A: As per Selected OBC SB12 Package A1 R 31			Doors		
Style B:			Style A: As per Selected OBC SB12 Package A1 R 4.00		
Windows			Style B:		
Style A: As per Selected OBC SB12 Package A1 R 3.55			Style C:		
Style B: Existing Windows (When Applicable) R 1.99			Skylights		
Style C:			Style A: As per Selected OBC SB12 Package A1 R 2.03		
Style D:			Style B:		
Attached documents: As per Shedule 1		Heat Loss/Gain Caculations based on CSA-F280-12 Effective R-Values			
Notes: Residential New Construction - Forced Air					
Calculations performed by					
Name: David DaCosta			Postal code: L4T 0A4		
Company: gtaDesigns Inc.			Telephone: (905) 671-9800		
Address: 2985 Drew Road, Suite 202			Fax: (416) 268-6820		
City: Mississauga			E-mail dave@gtadesigns.ca		

Builder: **Bayview Wellington**

Date: **April 4, 2018**

Project: **Green Valley East**

Model: **Rideau 16
S42-16 WOB**

System 1

I review and take responsibility for the design work and am qualified in the appropriate category as an "other designer" under Division C subsection 3.2.5. of the Building Code.

Individual BCIN: 32964

David DaCosta

David DaCosta

Project # **PJ-00204**
Layout # **JB-04592**

Page 3

DESIGN LOAD SPECIFICATIONS		AIR DISTRIBUTION & PRESSURE		FURNACE/AIR HANDLER DATA:		BOILER/WATER HEATER DATA:		A/C UNIT DATA:	
Level 1 Net Load	18,816 btu/h	Equipment External Static Pressure	0.5 "w.c.	Make	Amana	Make	Type	Amana	3.0 Ton
Level 2 Net Load	17,782 btu/h	Additional Equipment Pressure Drop	0.225 "w.c.	Model	AMEC960603BNA	Model		Cond.-----	3.0
Level 3 Net Load	16,572 btu/h	Available Design Pressure	0.275 "w.c.	Input Btu/h	60000	Input Btu/h		Coil -----	3.0
Level 4 Net Load	0 btu/h	Return Branch Longest Effective Length	300 ft	Output Btu/h	57600	Output Btu/h			
Total Heat Loss	53,169 btu/h	R/A Plenum Pressure	0.138 "w.c.	E.s.p.	0.50 " W.C.	Min.Output Btu/h	AWH		
Total Heat Gain	30,693 btu/h	S/A Plenum Pressure	0.14 "w.c.	Water Temp	deg. F.	Blower DATA:			
Combo System HL + 10%	58,486 Btu/h	Heating Air Flow Proportioning Factor	0.0220 cfm/btu/h	AFUE	96%	Blower Speed Selected:	W2	Blower Type	ECM
Building Volume Vb	32057 ft³	Cooling Air Flow Proportioning Factor	0.0381 cfm/btu/h	Aux. Heat				(Brushless DC OBC 12.3.1.5.(2))	
Ventilation Load	1,118 Btu/h.	R/A Temp	70 deg. F.	SB-12 Package	Package A1	Heating Check	1170 cfm	Cooling Check	1170 cfm
Ventilation PVC	79.5 cfm	S/A Temp	116 deg. F.						
Supply Branch and Grill Sizing		Diffuser loss	0.01 "w.c.	Temp. Rise>>>	46 deg. F.	Selected cfm>	1170 cfm	Cooling Air Flow Rate	1170 cfm

S/A Outlet No.	Level 1														Level 2									
	1	2	3	4	24										5	6	7	8	9	10	11	12	13	
Room Use	BASE	BASE	BASE	BASE	BASE										KIT	KIT	LAUN	PWD	FOY	LIV/DIN	LIV/DIN	GRT	GRT	
Btu/Outlet	3763	3763	3763	3763	3763										1966	1966	1726	596	3250	2039	2039	2100	2100	
Heating Airflow Rate CFM	83	83	83	83	83										43	43	38	13	72	45	45	46	46	
Cooling Airflow Rate CFM	32	32	32	32	32										96	96	60	3	53	68	68	60	60	
Duct Design Pressure	0.13	0.13	0.13	0.13	0.13	0.13	0.13	0.13	0.13	0.13	0.13	0.13	0.13	0.13	0.13	0.13	0.13	0.13	0.13	0.13	0.13	0.13	0.13	0.13
Actual Duct Length	31	27	14	27	36										29	37	17	9	40	33	24	42	34	
Equivalent Length	100	110	70	100	95	70	70	70	70	70	70	70	70	100	120	120	130	90	80	130	90	110	70	70
Total Effective Length	131	137	84	127	131	70	70	70	70	70	70	70	70	129	157	137	139	130	113	154	132	144	70	70
Adjusted Pressure	0.10	0.09	0.15	0.10	0.10	0.19	0.19	0.19	0.19	0.19	0.19	0.19	0.19	0.10	0.08	0.09	0.09	0.10	0.12	0.08	0.10	0.09	0.19	0.19
Duct Size Round	6	6	6	6	6									6	6	5	3	5	5	5	5	5	5	
Outlet Size	4x10	4x10	4x10	4x10	4x10	4x10	4x10	4x10	4x10	4x10	4x10	4x10	4x10	4x10	4x10	3x10	3x10	3x10	3x10	3x10	3x10	3x10	4x10	4x10
Trunk	C	B	A	E	B										B	B	A	A	E	D	D	C	C	

	Level 3											Level 4														
S/A Outlet No.	14	15	16	17	18	19	20	21	22	23																
Room Use	MAST	MAST	ENS	BED 2	BATH	BED 3	BED 3	BED 4	BED 4	ENS 2																
Btu/Outlet	2063	2063	2351	1211	1049	2021	2021	1564	1564	666																
Heating Airflow Rate CFM	45	45	52	27	23	44	44	34	34	15																
Cooling Airflow Rate CFM	63	63	48	30	19	53	53	50	50	13																
Duct Design Pressure	0.13	0.13	0.13	0.13	0.13	0.13	0.13	0.13	0.13	0.13	0.13	0.13	0.13	0.13	0.13	0.13	0.13	0.13	0.13	0.13	0.13	0.13	0.13	0.13	0.13	0.13
Actual Duct Length	56	45	38	39	42	42	40	46	48	43																
Equivalent Length	100	90	170	100	140	130	120	150	150	130	70	70	70	70	70	70	70	70	70	70	70	70	70	70	70	
Total Effective Length	156	135	208	139	182	172	160	196	198	173	70	70	70	70	70	70	70	70	70	70	70	70	70	70	70	
Adjusted Pressure	0.08	0.10	0.06	0.09	0.07	0.08	0.08	0.07	0.07	0.08	0.19	0.19	0.19	0.19	0.19	0.19	0.19	0.19	0.19	0.19	0.19	0.19	0.19	0.19	0.19	
Duct Size Round	5	5	6	4	4	5	5	5	5	3																
Outlet Size	3x10	3x10	4x10	3x10	3x10	3x10	3x10	3x10	3x10	3x10	4x10	4x10	4x10	4x10	4x10	4x10	4x10	4x10	4x10	4x10	4x10	4x10	4x10	4x10	4x10	
Trunk	C	B	B	A	D	D	D	E	E	A																

Return Branch And Grill Sizing	Grill Pressure Loss											0.02 "w.c.
R/A Inlet No.	1R	2R	3R	4R	5R	6R	7R	8R	9R	10R	11R	
Inlet Air Volume CFM	207	435	146	90	146	146						
Duct Design Pressure	0.12	0.12	0.12	0.12	0.12	0.12	0.12	0.12	0.12	0.12	0.12	
Actual Duct Length	15	12	37	12	49	50						
Equivalent Length	110	125	160	160	195	200	50	50	50	50	50	
Total Effective Length	125	137	197	172	244	250	50	50	50	50	50	
Adjusted Pressure	0.09	0.09	0.06	0.07	0.05	0.05	0.24	0.24	0.24	0.24	0.24	
Duct Size Round	8.0	10.5	7.5	6.0	8.0	8.0						
Inlet Size	FLC	8	8	8	8	8						
" "	x	x	x	x	x	x	x	x	x	x	x	
Inlet Size	9x6	30	14	14	14	14						
Trunk	Y	Z	Z	Z	Y	Y						

Return Trunk Duct Sizing	Trunk	CFM	Press.	Round	Rect. Size
Drop		1170	0.05	17.0	24x12
Z		1170	0.05	17.0	26x10 22x12
Y		499	0.05	12.5	18x8 14x10
X					
W					
V					
U					
T					
S					
R					
Q					

Supply Trunk Duct Sizing	Trunk	CFM	Press.	Round	Rect. Size
A		745	0.06	14.0	22x8 18x10
B		349	0.06	10.5	12x8 10x10
C		221	0.08	8.5	8x8
D		425	0.07	11.0	14x8 10x10
E		223	0.07	8.5	8x8
F					
G					
H					
I					
J					
K					

2012 OBC	Builder: Bayview Wellington	Date: April 4, 2018	Weather Data	Bradford	44	-9.4	86	22	48.2	Heat Loss ^T	81.4 deg. F	Ht gain ^T	11 deg. F	GTA: 2687	Project # PJ-00204	Layout # JB-04592
	Project: Green Valley East	Model: Rideau 16 S42-16 WOB	System 1													

Level 1				BASE																
Run ft. exposed wall A	109	A		A		A		A		A		A		A		A		A		
Run ft. exposed wall B	54	B		B		B		B		B		B		B		B		B		
Ceiling height	4.2	AG		4.2	AG		4.2	AG		4.2	AG		4.2	AG		4.2	AG		4.2	AG
Floor area	846	Area		Area		Area		Area		Area		Area		Area		Area		Area		
Exposed Ceilings A	A			A		A		A		A		A		A		A		A		
Exposed Ceilings B	B			B		B		B		B		B		B		B		B		
Exposed Floors	Flr			Flr		Flr		Flr		Flr		Flr		Flr		Flr		Flr		
Gross Exp Wall A	456																			
Gross Exp Wall B	486																			
Components	R-Values	Loss	Gain	Loss	Gain	Loss	Gain	Loss	Gain	Loss	Gain	Loss	Gain	Loss	Gain	Loss	Gain	Loss	Gain	
North Shaded	3.55	22.93	10.91																	
East/West	3.55	22.93	27.35																	
South	3.55	22.93	20.89																	
WOB Windows	3.55	22.93	27.35	88	2018	2407														
Skylight	2.03	40.10	88.23																	
Doors	4.00	20.35	2.75	21	427	58														
Net exposed walls A	21.12	3.85	0.52	435		227														
Net exposed walls B	14.49	5.62	0.76	398		302														
Exposed Ceilings A	59.22	1.37	0.64																	
Exposed Ceilings B	22.86	3.56	1.66																	
Exposed Floors	29.80	2.73	0.17																	
Foundation Conductive Heatloss	On Grade () or Above ()			6198																
Total Conductive	Heat Loss			10879																
	Heat Gain				2994															
Air Leakage	Heat Loss/Gain	0.6988	0.0307	7602		92														
Ventilation	Case 1		0.05																	
	Case 2		14.07																	
	Case 3	x	0.03																	
					334	170														
Heat Gain People			239																	
Appliances Loads	1 = .25 percent		4138																	
Duct and Pipe loss			10%																	
Level 1 HL Total	18,816	Total HL for per room		18816																
Level 1 HG Total	4,232	Total HG per room x 1.3			4232															

Level 2				KIT LAUN PWD FOY LIV/DIN GRT															
Run ft. exposed wall A	32	A		16	A		9	A		25	A		38	A		42	A		A
Run ft. exposed wall B		B			B			B			B			B			B		B
Ceiling height	10.0			12.0			10.0			11.0			10.0			10.0			10.0
Floor area	253	Area		90	Area		53	Area		75	Area		305	Area		380	Area		Area
Exposed Ceilings A	A			A			A			A			A			A			A
Exposed Ceilings B	B			B			B			B			B			B			B
Exposed Floors	Flr			Flr			Flr			Flr			Flr			Flr			Flr
Gross Exp Wall A	320			192			90			275			380			420			
Gross Exp Wall B																			
Components	R-Values	Loss	Gain	Loss	Gain	Loss	Gain	Loss	Gain	Loss	Gain	Loss	Gain	Loss	Gain	Loss	Gain	Loss	Gain
North Shaded	3.55	22.93	10.91																
East/West	3.55	22.93	27.35	72	1651	1969				24	550	656	14	321	383	56	1284	1532	
South	3.55	22.93	20.89																
Existing Windows	1.99	40.90	22.15																
Skylight	2.03	40.10	88.23																
Doors	4.00	20.35	2.75																
Net exposed walls A	17.03	4.78	0.65	248	1185	160	21	427	58	90	430	58	230	1099	149	318	1520	205	364
Net exposed walls B	8.50	9.58	1.29																
Exposed Ceilings A	59.22	1.37	0.64																
Exposed Ceilings B	22.86	3.56	1.66																
Exposed Floors	29.80	2.73	0.17																
Foundation Conductive Heatloss	On Grade () or Above ()																		
Total Conductive	Heat Loss			2836															
	Heat Gain				2130														
Air Leakage	Heat Loss/Gain	0.3556	0.0307	1009		65													
Ventilation	Case 1		0.03																
	Case 2		14.07																
	Case 3	x	0.03																
	Heat Gain People			87		121				38		10				13		3	
Appliances Loads	1 = .25 percent																		
Duct and Pipe loss			10%																
Level 2 HL Total	17,782	Total HL for per room		3932						1.5		1552	1.0		1034				
Level 2 HG Total	14,857	Total HG per room x 1.3			5028														

I review and take responsibility for the design work and am qualified in the appropriate category as an "other designer" under

Division C subsection 3.2.5. of the Building Code. Individual BCIN:

32964

Dave DaCosta

Dave DaCosta

SB-12 Package

Package A1

Site Copy



2985 Drew Road, Suite 202, Mississauga, Ontario L4T 0A4 Tel: 905-671-9800 Fax: 647-494-9643

e-mail dave@gtadesigns.ca

Page 5

9.1-00204

B-04592

Builder: Bayview Wellington

Date: April 4, 2018

Weather Data	Bradford	44	-9.4	86	22	48.2
--------------	----------	----	------	----	----	------

Heat Loss ΔT 81.4 deg. F Ht gain ΔT 11 deg. F GTA: 2687

Project #

Layout #

2012 OBC

Project: **Green Valley East**

Model: S42-16 WOB

System 1

[illegible]

I review and take responsibility for the design work and am qualified in the appropriate category as an "other designer" under Division C subsection 3.2.5. of the Building Code. Individual BCIN: 32964 

David DaCosta

SB-12 Package

Package A1

Site Copy

I review and take responsibility for the design work and am qualified in the appropriate category as an "other designer" under Division C subsection 3.2.5. of the Building Code.

Individual BCIN: 32964



David DaCosta

Package: Package A1
Project: Bradford
Model: S42-16 WOB

RESIDENTIAL MECHANICAL VENTILATION DESIGN SUMMARY

For systems serving one dwelling unit & conforming to the Ontario Building Code, O.reg 332/12

Location of Installation	
Lot #	Plan #
Township	Bradford
Roll #	Permit #
Address	

Builder	
Name	Bayview Wellington
Address	
City	
Tel	Fax

Installing Contractor	
Name	
Address	
City	
Tel	Fax

Combustion Appliances 9.32.3.1(1)		
a)	☒	Direct vent (sealed combustion) only
b)	☐	Positive venting induced draft (except fireplaces)
c)	☐	Natural draft, B-vent or induced draft fireplaces
d)	☐	Solid fuel (including fireplaces)
e)	☐	No combustion Appliances

Heating System	
☒	Forced air
☐	Non forced air
☐	Electric space heat (if over 10% of heat load)

House Type 9.32.3.1(2)		
I	☒	Type a) or b) appliances only, no solid fuel
II	☐	Type I except with solid fuel (including fireplace)
III	☐	Any type c) appliance
IV	☐	Type I or II either electric space heat
Other	☐	Type I, II or IV no forced air

System Design Option		
1	☐	Exhaust only / forced air system
2	☐	HRV WITH DUCTING / forced air system
3	☒	HRV simplified connection to forced air system
4	☐	HRV full ducting/not coupled to forced air system
		Part 6 design

Total Ventilation Capacity 9.32.3.3(1)			
Bsmt & Master Bdrm	2 @ 21.2 cfm	42.4 cfm	
Other Bedrooms	3 @ 10.6 cfm	31.8 cfm	
Bathrooms & Kitchen	5 @ 10.6 cfm	53 cfm	
Other rooms	5 @ 10.6 cfm	53 cfm	
Total		<u>180.2</u>	

Principal Ventilation Capacity 9.32.3.4(1)			
Master bedroom	1 @ 31.8 cfm	31.8 cfm	
Other bedrooms	3 @ 15.9 cfm	47.7 cfm	
Total		<u>79.5</u>	

 
Principal Exhaust Fan Capacity			
Make	Model	Location	
LifeBreath	RNC155	Base	
132 cfm		Sones	or Equiv.

Heat Recovery Ventilator			
Make	LifeBreath		
Model	RNC155		
	132 cfm high	80 cfm low	
Sensible efficiency @ -25 deg C		71%	
Sensible efficiency @ 0 deg C		75%	

Note: Installer to balance HRV/ERV to within 10 percent of PVC

Supplemental Ventilation Capacity	
Total ventilation capacity	180.2
Less principal exhaust capacity	79.5
REQUIRED supplemental vent. Capacity	<u>100.7</u> cfm

Supplemental Fans 9.32.3.5.			
Location	cfm	Model	Sones
Ens	50	XB50	0.3
Bath	50	XB50	0.3
Ens 2	50	XB50	0.3
all fans HVI listed			
	Make	Broan	or Equiv.

Designer Certification			
I hereby certify that this ventilation system has been designed in accordance with the Ontario Building Code.			
Name	David DaCosta		
Signature			
HRAI #	5190	BCIN #	32964
Date	April 4, 2018		



2985 Drew Road, Suite 202, Mississauga, Ontario
 L4T 0A4 Tel: 905-671-9800 Fax: 647-494-9643
 e-mail dave@gtadesigns.ca

Energy Efficiency Design Summary: Prescriptive Method (Building Code Part 9, Residential)

Page 7
 Project # PJ-00204
 Layout # JB-04592

This form is used by a designer to demonstrate that the energy efficiency design of a house complies with the building code using the prescriptive method described in Subsection 3.1.1. of SB-12. This form is applicable where the ratio of gross area of windows/sidelights/skylights/glazing in doors and sliding glass doors to the gross area of peripheral walls is not more than 22%.

For use by Principal Authority

Application No:

Model/Certification Number

A. Project Information

Building number, street name Rideau 16 S42-16 WOB		Unit number	Lot/Con
Municipality Bradford	Postal code	Reg. Plan number / other description	

B. Prescriptive Compliance [indicate the building code compliance package being employed in the house design]

SB-12 Prescriptive (input design package): Package A1 Table: 3.1.1.2.A

C. Project Design Conditions

Climatic Zone (SB-1):	Heat. Equip. Efficiency	Space Heating Fuel Source		
☒ Zone 1 (< 5000 degree days) ☐ Zone 2 (≥ 5000 degree days)	☒ ≥ 92% AFUE ☐ ≥ 84% < 92% AFUE	☒ Gas ☐ Oil	☐ Propane ☐ Electric	☐ Solid Fuel ☐ Earth Energy
Ratio of Windows, Skylights & Glass (W, S & G) to Wall Area		Other Building Characteristics		
Area of Walls = <u>364.28</u> m ² or <u>3921.1</u> ft ²	W, S & G % = <u>14%</u>	☐ Log/Post&Beam ☐ Slab-on-ground ☒ Air Conditioning ☐ Air Sourced Heat Pump (ASHP) ☐ Ground Source Heat Pump (GSHP)		
Area of W, S & G = <u>49.794</u> m ² or <u>536.0</u> ft ²	Utilize Window Averaging ☐ Yes ☒ No	☐ ICF Above Grade ☒ Walkout Basement ☐ Combo Unit		

D. Building Specifications [provide values and ratings of the energy efficiency components proposed]

Energy Efficiency Substitutions			
☐ ICF (3.1.1.2.(5) & (6) / 3.1.1.3.(5)) ☐ Combined space heating and domestic water heating systems (3.1.1.2(7) / 3.1.1.3.(7))			
☐ Airtightness substitution(s) Airtightness test required (Refer to Design Guide Attached)	☐ Table 3.1.1.4.B Required:		Permitted Substitution:
	☐ Table 3.1.1.4.C Required:		Permitted Substitution:
Building Component	Minimum RSI/R-Values or Maximum U-Value ¹		Efficiency Ratings
Thermal Insulation	Nominal	Effective	Windows & Doors Provide U-Value ⁽¹⁾ or ER rating
Ceiling with Attic Space	60		Windows/Sliding Glass Doors 1.6
Ceiling without Attic Space	31		Skylights 2.8
Exposed Floor	31		Mechanicals
Walls Above Grade	22		Heating Equip. (AFUE) 96%
Basement Walls	20.0ci		HRV Efficiency (SRE% at 0°C) 75%
Slab (all >600mm below grade)	x		DHW Heater (EF) 0.80
Slab (edge only ≤600mm below grade)	10		DWHR (CSA B55.1 (min. 42% efficiency)) #Showers 2
Slab (all ≤600mm below grade, or heated)	10		Combined Heating System

(1) U value to be provided in either W/(m²·K) or Btu/(h·ft²·F) but not both.

E. Designer(s) [name(s) & BCIN(s), if applicable, of person(s) providing information herein to substantiate that design meets building code]

Name David DaCosta	BCIN 32964	Signature
------------------------------	----------------------	---------------

Package: Package A1 System: System 1
Project: Bradford Model: S42-16 WOB

Air Leakage Calculations

Building Air Leakage Heat Loss				
B	LRairh	Vb	HL ^Δ T	HL _{leak}
0.018	0.324	32057	81.4	15204

Building Air Leakage Heat Gain				
B	LRairh	Vb	HG ^Δ T	HG _{Leak}
0.018	0.080	32057	11	509

Air Leakage Heat Loss/Gain Multiplier Table (Section 11)				
Level	Level Factor (LF)	Building Air	Level Conductive Heat Loss	Air Leakage Heat Loss Multiplier
Level 1	0.5	15204	10879	0.6988
Level 2	0.3		12826	0.3556
Level 3	0.2		12688	0.2397
Level 4	0		0	0.0000

Levels			
1	2	3	4
(LF)	(LF)	(LF)	(LF)
1.0	0.6	0.5	0.4
	0.4	0.3	0.3
		0.2	0.2
			0.1

HG LEAK		Air Leakage Heat Gain	
	509		0.0307
BUILDING CONDUCTIVE HEAT GAIN			16609

Levels this Dwelling	
3	

Ventilation Calculations

Ventilation Heat Loss

Ventilation Heat Loss				
C	PVC	HL ^Δ T	(1-E) HRV	HL _{bvent}
1.08	79.5	81.4	0.16	1118

Ventilation Heat Gain

Ventilation Heat Gain			
C	PVC	HG ^Δ T	HG _{bvent}
1.1	79.5	11	944

Case 1

Ventilation Heat Loss (Exhaust only Systems)

Case 1 - Exhaust Only				
Level	LF	HL _{bvent}	LVL Cond. HL	Multiplier
Level 1	0.5	1118	10879	0.05
Level 2	0.3		12826	0.03
Level 3	0.2		12688	0.02
Level 4	0		0	0.00

Case 1

Ventilation Heat Gain (Exhaust Only Systems)

Case 1 - Exhaust Only		Multiplier
HG _{bvent}	944	0.06
Building	16609	

Case 2

Ventilation Heat Loss (Direct Ducted Systems)

C	HL ^Δ T	(1-E) HRV	Multiplier
1.08	81.4	0.16	14.07

Case 2

Ventilation Heat Gain (Direct Ducted Systems)

C	HG ^Δ T	Multiplier
1.08	11	11.88

Case 3

Ventilation Heat Loss (Forced Air Systems)

HL _{bvent}		Multiplier
Total Ventilation Load	1118	0.03

Case 3

Ventilation Heat Gain (Forced Air Systems)

Vent Heat Gain		Multiplier
HG _{bvent}	HG*1.3	0.06
944	1	

Foundation Conductive Heatloss Level 1

1817 Watts 6198 Btu/h

Foundation Conductive Heatloss Level 2

Watts Btu/h

I review and take responsibility for the design work and am qualified in the appropriate category as an "other designer" under Division C subsection 3.2.5. of the Building Code. Individual BCIN: 32964

David DaCosta


Envelope Air Leakage Calculator

Supplemental tool for CAN/CSA-F280

Weather Station Description				
Province:	Ontario ▼			
Region:	Bradford ▼			
Weather Station Location:	Open flat terrain, grass ▼			
Anemometer height (m):	10			
Local Shielding				
Building Site:	Suburban, forest ▼			
Walls:	Heavy ▼			
Flue:	Heavy ▼			
Highest Ceiling Height (m):	6.76			
Building Configuration				
Type:	Detached			
Number of Stories:	Two			
Foundation:	Full			
House Volume (m ³):	907.85			
Air Leakage/Ventilation				
Air Tightness Type:	Present (1961-) (ACH=3.57)			
Custom BDT Data:	ELA @ 10 Pa. ▼ 322.44 cm ²			
	3.57 ACH @ 50 Pa			
Mechanical Ventilation (L/s):	Total Supply:		Total Exhaust:	
	39.75		39.75	
Flue #:	#1	#2	#3	#4
Diameter (mm):	0	0	0	0
Heating Air Leakage Rate (ACH/H):		0.324		
Cooling Air Leakage Rate (ACH/H):		0.080		


Residential Foundation Thermal Load Calculator

 
Supplemental tool for CAN/CSA-F280

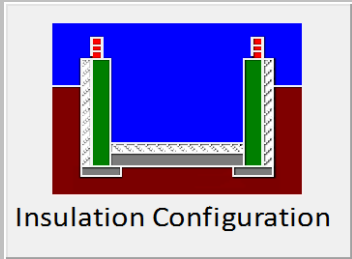
Weather Station Description		
Province:	Ontario ▼	
Region:	Bradford ▼	
Site Description		
Soil Conductivity:	High conductivity: moist soil ▼	
Water Table:	Normal (7-10 m, 23-33 Ft) ▼	
Foundation Dimensions		
Floor Length (m):	16.81	 Insulation Configuration
Floor Width (m):	4.67	
Exposed Perimeter (m):	33.22	
Wall Height (m):	2.74	
Depth Below Grade (m):	1.47	
Window Area (m ²):	0.00	
Door Area (m ²):	1.95	
Radiant Slab		
Heated Fraction of the Slab:	0	
Fluid Temperature (°C):	33	
Design Months		
Heating Month	1	
Foundation Loads		
Heating Load (Watts):		1559

Residential Slab on Grade Thermal Load Calculator

Supplemental tool for CAN/CSA-F280

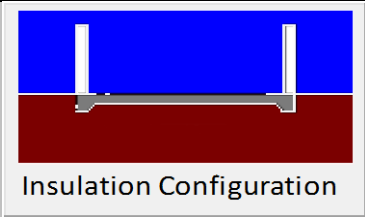Weather Station Description		
Province:	Ontario	▼
Region:	Bradford	▼
Site Description		
Soil Conductivity:	High conductivity: moist soil	▼
Water Table:	Normal (7-10 m, 23-33 Ft)	▼
Floor Dimensions		
Length (m):	10.25	 Insulation Configuration
Width (m):	2.85	
Exposed Perimeter (m):	16.46	
Radiant Slab		
Heated Fraction of the Slab:	0	
Fluid Temperature (°C):	33	
Design Months		
Heating Month	1	
Foundation Loads		
Heating Load (Watts):		258

	FLEX DUCT		LOW/HIGH WALL/KICK SUPPLY DIFFUSER		DUCT CONNECTION TO JOIST LINING		RETURN AIR GRILLE (SIZE INDICATED ON DRAWING)	S.A.	SUPPLY AIR
	RIGID ROUND DUCT		HRV EXHAUST GRILLE		RETURN AIR PIPE RISER		RETURN AIR RISER UP TO FLOOR ABOVE	R.A.	RETURN AIR
	SUPPLY DIFFUSER		SUPPLY AIR PIPE RISER VOLUME DAMPER		RETURN ROUND DUCT		RETURN AIR FROM BASEMENT SECOND FLOOR		THERMOSTAT
									PRINCIPAL EXHAUST FAN SWITCH
									W/R & PRINCIPAL EXHAUST FAN

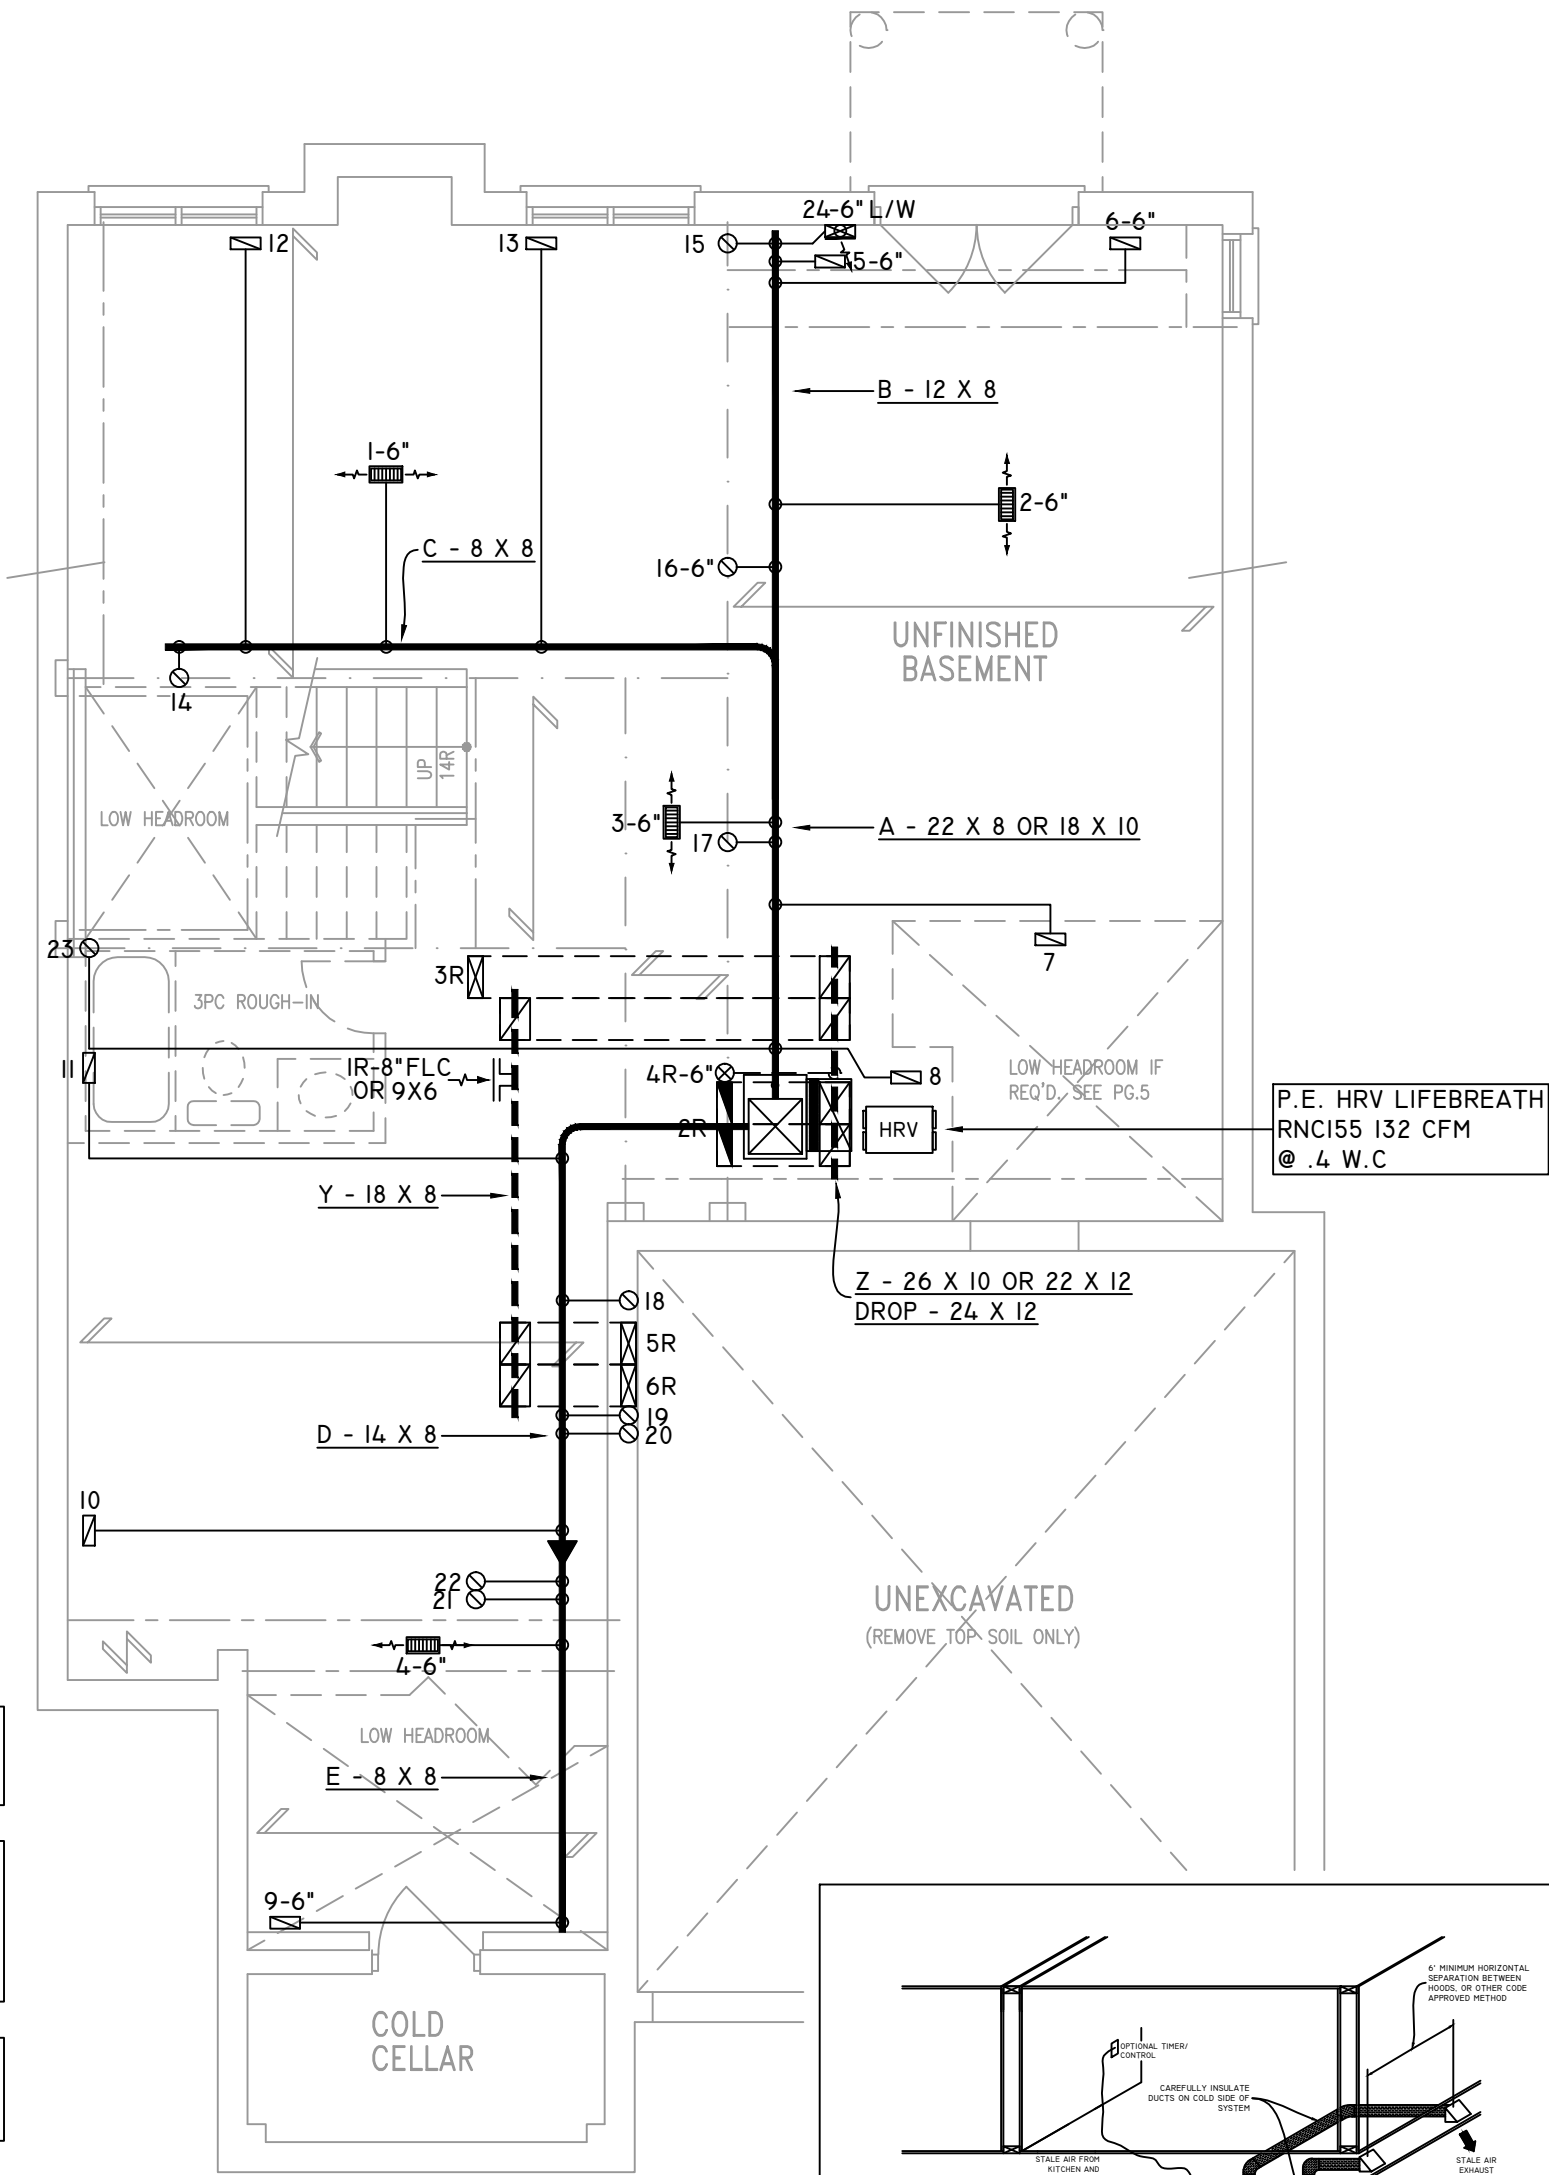

FURNACE EQUIPPED WITH
BRUSHLESS DC MOTOR AS
PER OBC 12.3.1.5 (2)

ALL DUCTWORK LOCATED IN
CONDITIONED AREAS
MUST BE SEALED TO CLASS
C LEVEL AS PER OBC PART
6-6.2.4.3.(12)

INSULATE ALL DUCTS IN
UNCONDITIONED
SPACES MIN. R12

FOR THE PURPOSE OF
HEATLOSS/GAIN
CALCULATIONS ALL
ELEVATIONS HAVE BEEN
CONSIDERED

THE UNDERSIGNED HAS REVIEWED AND TAKES RESPONSIBILITY FOR THIS DESIGN ON BEHALF OF GTA DESIGNS INC. AND HAS THE QUALIFICATIONS AND MEETS THE REQUIREMENTS SET OUT IN THE BUILDING CODE TO BE A DESIGNER

QUALIFICATION INFORMATION

REQUIRED UNLESS DESIGN IS EXEMPT UNDER DIVISION C 3.2.5.1 OF THE ONTARIO BUILDING CODE

DAVID DA COSTA  B.C.I.N. 32964
SIGNATURE OF DESIGNER

BASEMENT PLAN 'A'

OBC 2012

Site Copy

ZONE I COMPLIANCE
PACKAGE "A1" REF. TABLE 3.1.1.2.A

NOTES

INSTALLATION TO COMPLY WITH THE LATEST ONTARIO BUILDING CODE.

ALL SUPPLY OUTLETS TO BE 5" DIA. UNLESS OTHERWISE SPECIFIED.

PROVIDE BALANCING DAMPERS ON ALL BRANCHES.

ALL R/A PARTITIONS 6" (FIRST FLOOR ONLY)

INSULATE DUCTS IN UNCONDITIONED SPACES R12 UNDERCUT ALL DOORS 1" MIN.

CONTRACTOR MUST WORK FROM APPROVED PLANS.

ANY ALTERATIONS TO THIS ORIGINAL PLAN ARE NOT THE RESPONSIBILITY OF GTA DESIGNS.

GTA DESIGNS MUST BE CONSULTED IF KITCHEN EXHAUST FAN EXCEEDS 700 CFM DEPRESSURIZATION MAY OCCUR WITH IN THE DWELLING.



 
2985 DREW ROAD
SUITE 202,
MISSISSAUGA, ONT.
L4T 0A4 TEL: 905-671-9800
EMAIL: DAVE@GTADESIGNS.CA
WEB: WWW.GTADESIGNS.CA


HEAT-LOSS	53,169	BTU/HR.
UNIT MAKE	AMANA	OR EQUAL.
UNIT MODEL	AMEC960603BNA	OR EQUAL.
UNIT HEATING INPUT	60,000	BTU/HR.
UNIT HEATING OUTPUT	57,600	BTU/HR.
A/C COOLING CAPACITY	3.0	TONS.
FAN SPEED	1170	CFM

# OF RUNS	S/A	R/A	FANS
3RD FLOOR			
2ND FLOOR	10	4	3
1ST FLOOR	9	1	3
BASEMENT	5	1	

FLOOR PLAN:	BASEMENT
DRAWN BY:	AM
CHECKED:	DD
LAYOUT NO.	JB-04619
SQFT	2687
DRAWING NO.	MI

DATE:	MARCH 29, 2018
CLIENT:	BAYVIEW WELLINGTON
MODEL:	S42-16 WOB RIDEAU 16
PROJECT:	GREEN VALLEY EAST BRADFORD,ONT.
SCALE:	3/16" = 1'-0"

	FLEX DUCT		LOW/HIGH WALL/KICK SUPPLY DIFFUSER		DUCT CONNECTION TO JOIST LINING		RETURN AIR GRILLE (SIZE INDICATED ON DRAWING)	S.A.	SUPPLY AIR
	RIGID ROUND DUCT		HRV EXHAUST GRILLE		RETURN AIR PIPE RISER		RETURN AIR RISER UP TO FLOOR ABOVE	R.A.	RETURN AIR
	SUPPLY DIFFUSER		SUPPLY AIR PIPE RISER		RETURN ROUND DUCT		RETURN AIR FROM BASEMENT SECOND FLOOR		THERMOSTAT
			VOLUME DAMPER						PRINCIPAL EXHAUST FAN SWITCH
									W/R & PRINCIPAL EXHAUST FAN

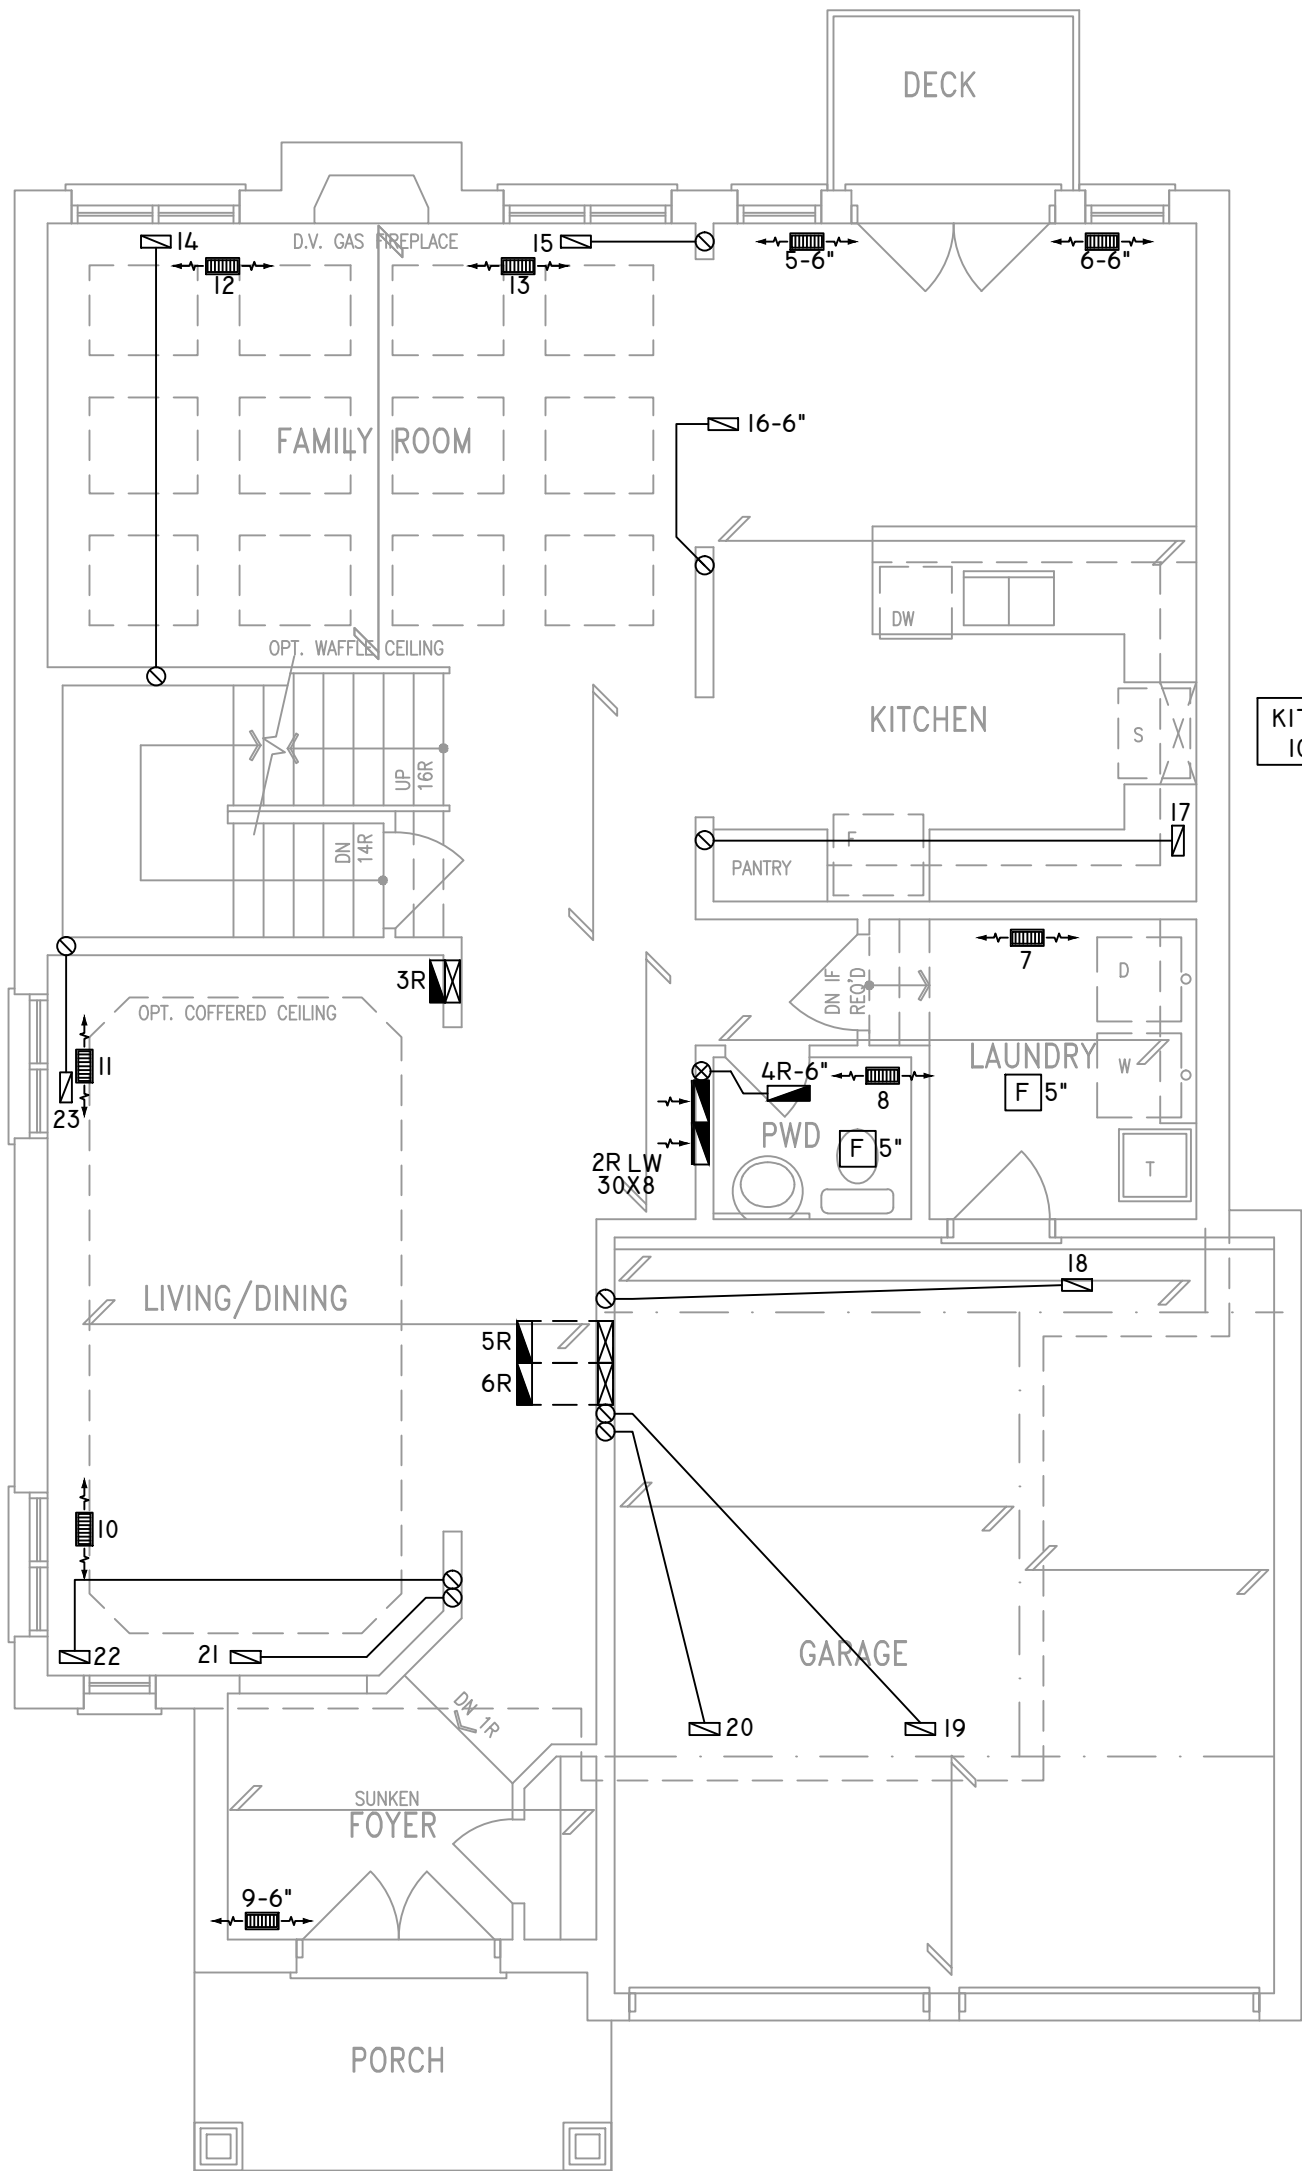

CIRCULATION PRINCIPAL FAN SWITCH TO BE CENTRALLY LOCATED

ALL DUCTWORK LOCATED IN CONDITIONED AREAS MUST BE SEALED TO CLASS C LEVEL AS PER OBC PART 6-6.2.4.3.(12)

INSULATE ALL DUCTS IN UNCONDITIONED SPACES MIN. R12

FOR THE PURPOSE OF HEATLOSS/GAIN CALCULATIONS ALL ELEVATIONS HAVE BEEN CONSIDERED

THE UNDERSIGNED HAS REVIEWED AND TAKES RESPONSIBILITY FOR THIS DESIGN ON BEHALF OF GTA DESIGNS INC. AND HAS THE QUALIFICATIONS AND MEETS THE REQUIREMENTS SET OUT IN THE BUILDING CODE TO BE A DESIGNER

QUALIFICATION INFORMATION

REQUIRED UNLESS DESIGN IS EXEMPT UNDER DIVISION C 3.2.5.1 OF THE ONTARIO BUILDING CODE

DAVID DA COSTA  B.C.I.N. 32964

SIGNATURE OF DESIGNER

GROUND FLOOR PLAN 'A'

Site Copy

OBC 2012

ZONE I COMPLIANCE
PACKAGE "A1" REF. TABLE 3.1.1.2.A

NOTES
INSTALLATION TO COMPLY WITH THE LATEST ONTARIO BUILDING CODE.
ALL SUPPLY OUTLETS TO BE 5" DIA. UNLESS OTHERWISE SPECIFIED.
PROVIDE BALANCING DAMPERS ON ALL BRANCHES.
ALL R/A PARTITIONS 6" (FIRST FLOOR ONLY)
INSULATE DUCTS IN UNCONDITIONED SPACES R12 UNDERCUT ALL DOORS 1" MIN.
CONTRACTOR MUST WORK FROM APPROVED PLANS.
ANY ALTERATIONS TO THIS ORIGINAL PLAN ARE NOT THE RESPONSIBILITY OF GTA DESIGNS.
GTA DESIGNS MUST BE CONSULTED IF KITCHEN EXHAUST FAN EXCEEDS 700 CFM DEPRESSURIZATION MAY OCCUR WITH IN THE DWELLING.



 
2985 DREW ROAD
SUITE 202,
MISSISSAUGA, ONT.
L4T 0A4 TEL: 905-671-9800
EMAIL: DAVE@GTADISIGNS.CA
WEB: WWW.GTADISIGNS.CA


HEAT-LOSS	53,169	BTU/HR.
UNIT MAKE	AMANA	OR EQUAL.
UNIT MODEL	AMEC960603BNA	OR EQUAL.
UNIT HEATING INPUT	60,000	BTU/HR.
UNIT HEATING OUTPUT	57,600	BTU/HR.
A/C COOLING CAPACITY	3.0	TONS.
FAN SPEED	1170	CFM

# OF RUNS	S/A	R/A	FANS
3RD FLOOR			
2ND FLOOR	10	4	3
1ST FLOOR	9	1	3
BASEMENT	5	1	

FLOOR PLAN: GROUND FLOOR	
DRAWN BY: AM	CHECKED: DD
LAYOUT NO. JB-04619	DRAWING NO. M2

DATE:	MARCH 29, 2018
CLIENT:	BAYVIEW WELLINGTON
MODEL:	S42-16 WOB RIDEAU 16
PROJECT:	GREEN VALLEY EAST BRADFORD,ONT.
SCALE:	3/16" = 1'-0"

	FLEX DUCT		LOW/HIGH WALL/KICK SUPPLY DIFFUSER		DUCT CONNECTION TO JOIST LINING		RETURN AIR GRILLE (SIZE INDICATED ON DRAWING)	S.A.	SUPPLY AIR
	RIGID ROUND DUCT		HRV EXHAUST GRILLE		RETURN AIR PIPE RISER		RETURN AIR RISER UP TO FLOOR ABOVE	R.A.	RETURN AIR
	SUPPLY DIFFUSER		SUPPLY AIR PIPE RISER		RETURN ROUND DUCT		RETURN AIR FROM BASEMENT SECOND FLOOR		THERMOSTAT
			VOLUME DAMPER						PRINCIPAL EXHAUST FAN SWITCH
									W/R & PRINCIPAL EXHAUST FAN

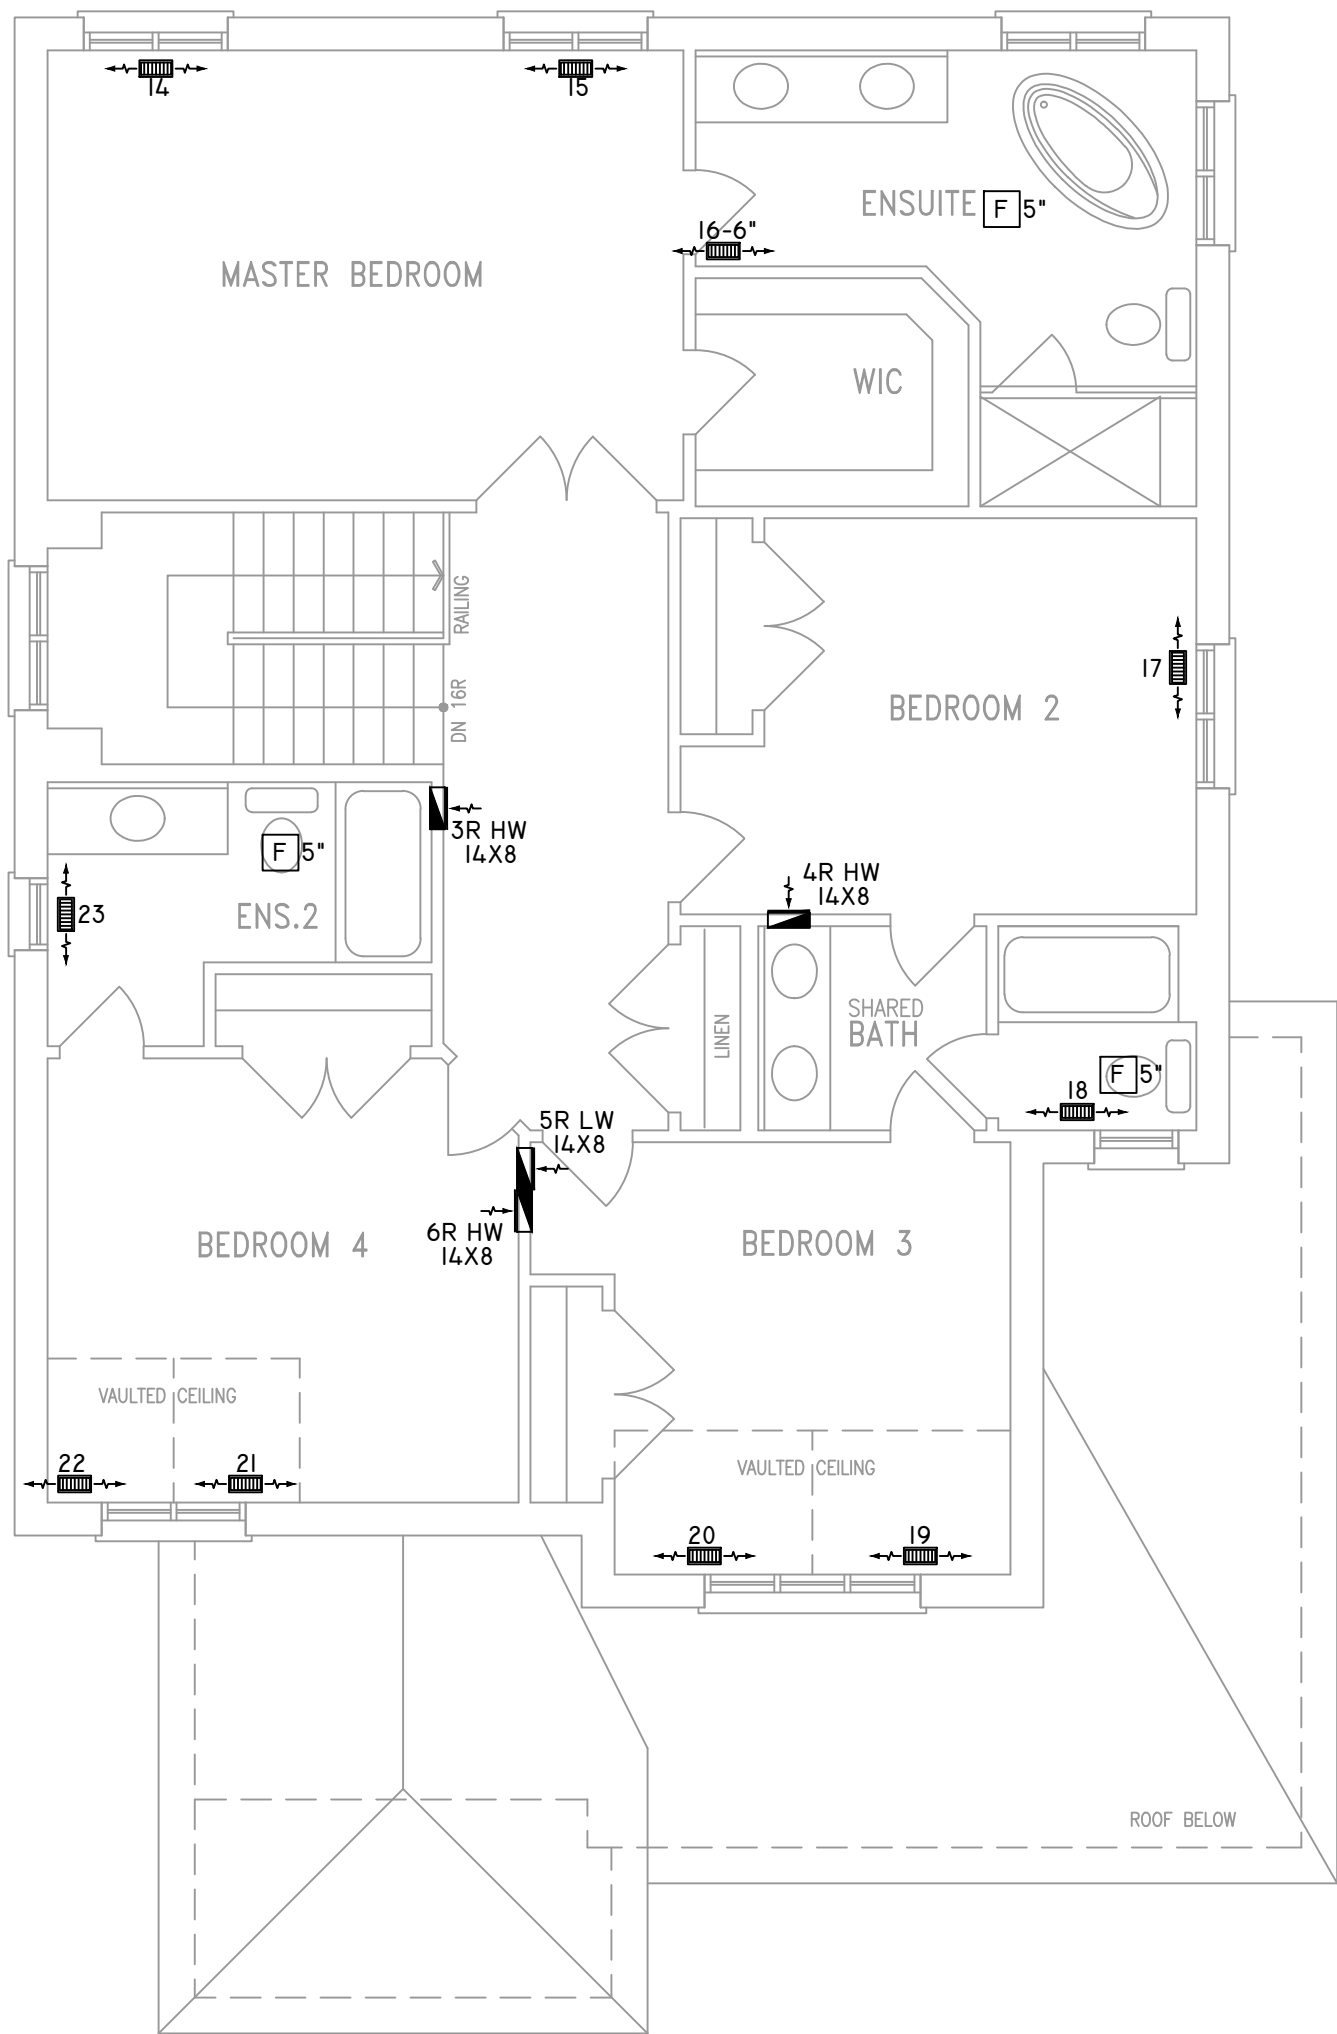

ALL DUCTWORK LOCATED IN
CONDITIONED AREAS
MUST BE SEALED TO CLASS
C LEVEL AS PER OBC PART
6-6.2.4.3.(12)

INSULATE ALL DUCTS IN
UNCONDITIONED
SPACES MIN. R12

FOR THE PURPOSE OF
HEATLOSS/GAIN
CALCULATIONS ALL
ELEVATIONS HAVE BEEN
CONSIDERED

THE UNDERSIGNED HAS REVIEWED AND TAKES RESPONSIBILITY FOR THIS DESIGN ON
BEHALF OF GTA DESIGNS INC. AND HAS THE QUALIFICATIONS AND MEETS THE
REQUIREMENTS SET OUT IN THE BUILDING CODE TO BE A DESIGNER

QUALIFICATION INFORMATION

REQUIRED UNLESS DESIGN IS EXEMPT UNDER DIVISION C 3.2.5.1 OF THE
ONTARIO BUILDING CODE

DAVID DA COSTA  B.C.I.N. 32964
SIGNATURE OF DESIGNER

SECOND FLOOR PLAN 'A'

Site Copy

OBC 2012

ZONE I COMPLIANCE
PACKAGE "A1" REF. TABLE 3.1.1.2.A

NOTES

INSTALLATION TO COMPLY WITH THE LATEST ONTARIO
BUILDING CODE.

ALL SUPPLY OUTLETS TO BE 5" DIA. UNLESS OTHERWISE
SPECIFIED.

PROVIDE BALANCING DAMPERS ON ALL BRANCHES.

ALL R/A PARTITIONS 6" (FIRST FLOOR ONLY)

INSULATE DUCTS IN UNCONDITIONED SPACES R12 UNDERCUT
ALL DOORS 1" MIN.

CONTRACTOR MUST WORK FROM APPROVED PLANS.

ANY ALTERATIONS TO THIS ORIGINAL PLAN ARE NOT THE
RESPONSIBILITY OF GTA DESIGNS.

GTA DESIGNS MUST BE CONSULTED IF KITCHEN EXHAUST
FAN EXCEEDS 700 CFM DEPRESSURIZATION MAY OCCUR
WITH IN THE DWELLING.

**GTADESIGNS**

 
2985 DREW ROAD
SUITE 202,
MISSISSAUGA, ONT.
L4T 0A4 TEL: 905-671-9800
EMAIL: DAVE@GTADESIGNS.CA
WEB: WWW.GTADESIGNS.CA




HEAT-LOSS	53,169	BTU/HR.
UNIT MAKE	AMANA	OR EQUAL.
UNIT MODEL	AMEC960603BNA	OR EQUAL.
UNIT HEATING INPUT	60,000	BTU/HR.
UNIT HEATING OUTPUT	57,600	BTU/HR.
A/C COOLING CAPACITY	3.0	TONS.
FAN SPEED	1170	CFM

# OF RUNS	S/A	R/A	FANS
3RD FLOOR			
2ND FLOOR	10	4	3
1ST FLOOR	9	1	3
BASEMENT	5	1	

FLOOR PLAN: PARTIAL PLAN(S)		
DRAWN BY: AM	CHECKED: DD	SQFT 2687
LAYOUT NO. JB-04619	DRAWING NO. M3	

DATE:	MARCH 29, 2018
CLIENT:	BAYVIEW WELLINGTON
MODEL:	S42-16 WOB RIDEAU 16
PROJECT:	GREEN VALLEY EAST BRADFORD,ONT.
SCALE:	3/16" = 1'-0"

	FLEX DUCT		LOW/HIGH WALL/KICK SUPPLY DIFFUSER		DUCT CONNECTION TO JOIST LINING		RETURN AIR GRILLE (SIZE INDICATED ON DRAWING)	S.A.	SUPPLY AIR
	RIGID ROUND DUCT		HRV EXHAUST GRILLE		RETURN AIR PIPE RISER		RETURN AIR RISER UP TO FLOOR ABOVE	R.A.	RETURN AIR
	SUPPLY DIFFUSER		SUPPLY AIR PIPE RISER		RETURN ROUND DUCT		RETURN AIR FROM BASEMENT SECOND FLOOR		THERMOSTAT
			VOLUME DAMPER						PRINCIPAL EXHAUST FAN SWITCH
									W/R & PRINCIPAL EXHAUST FAN

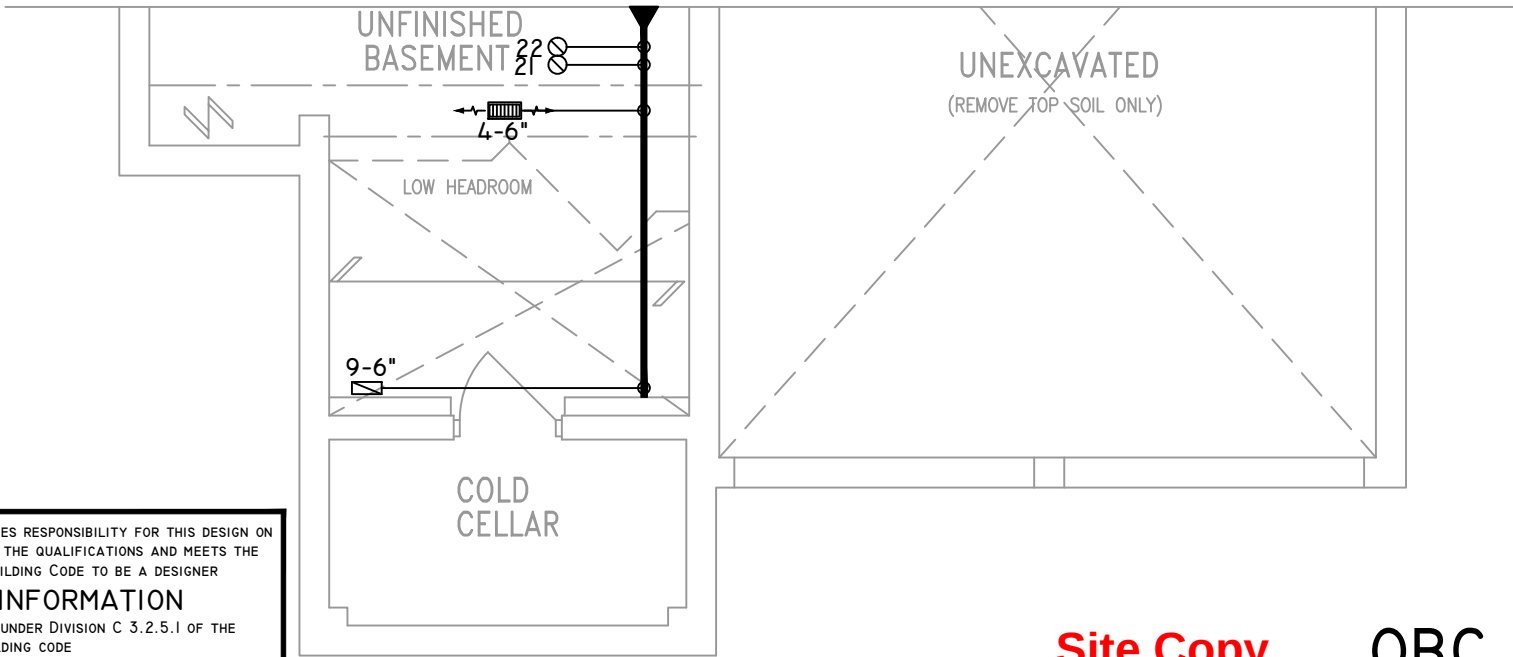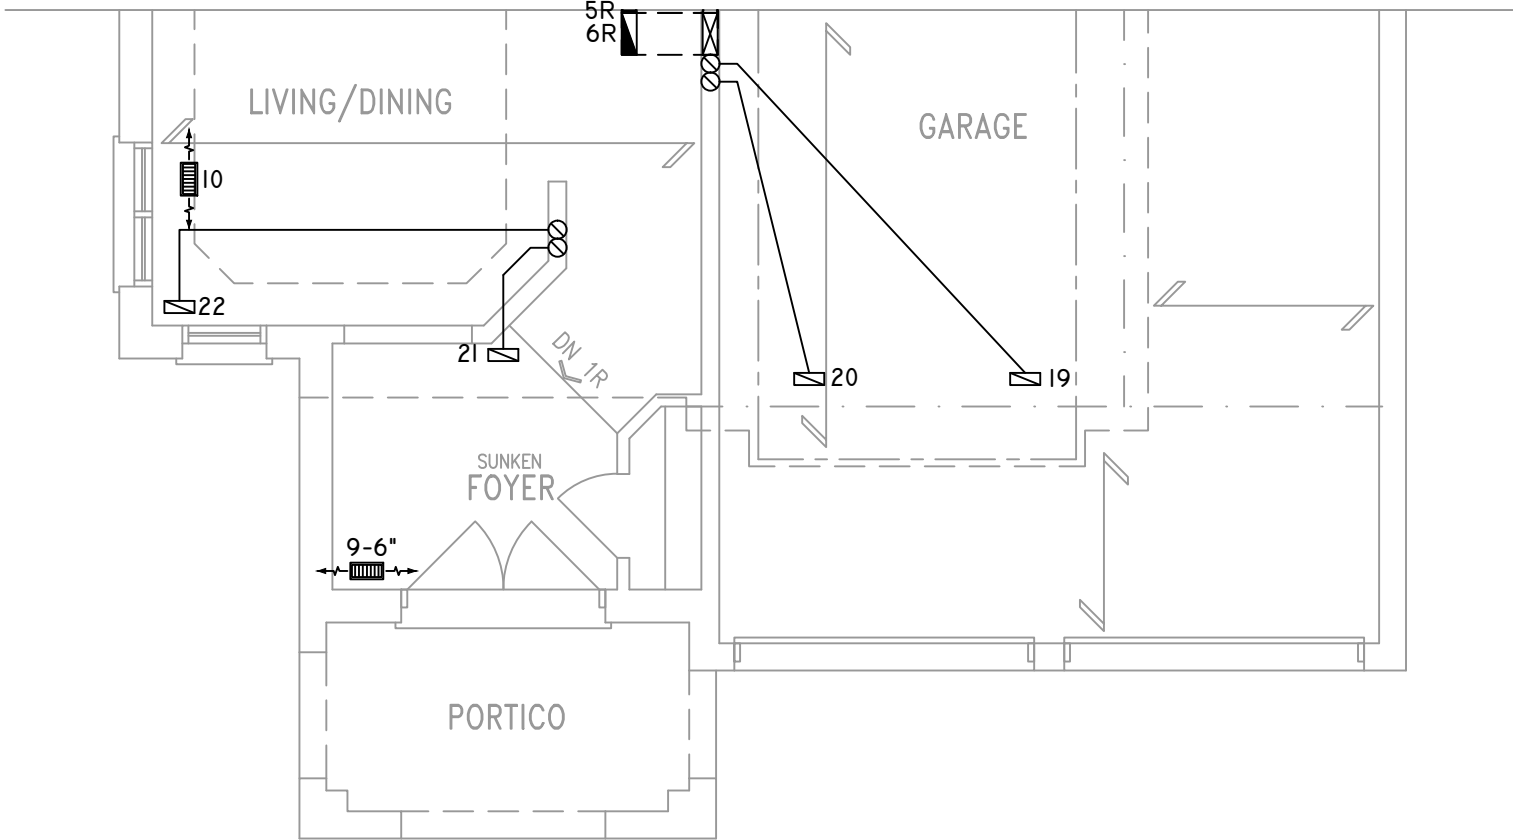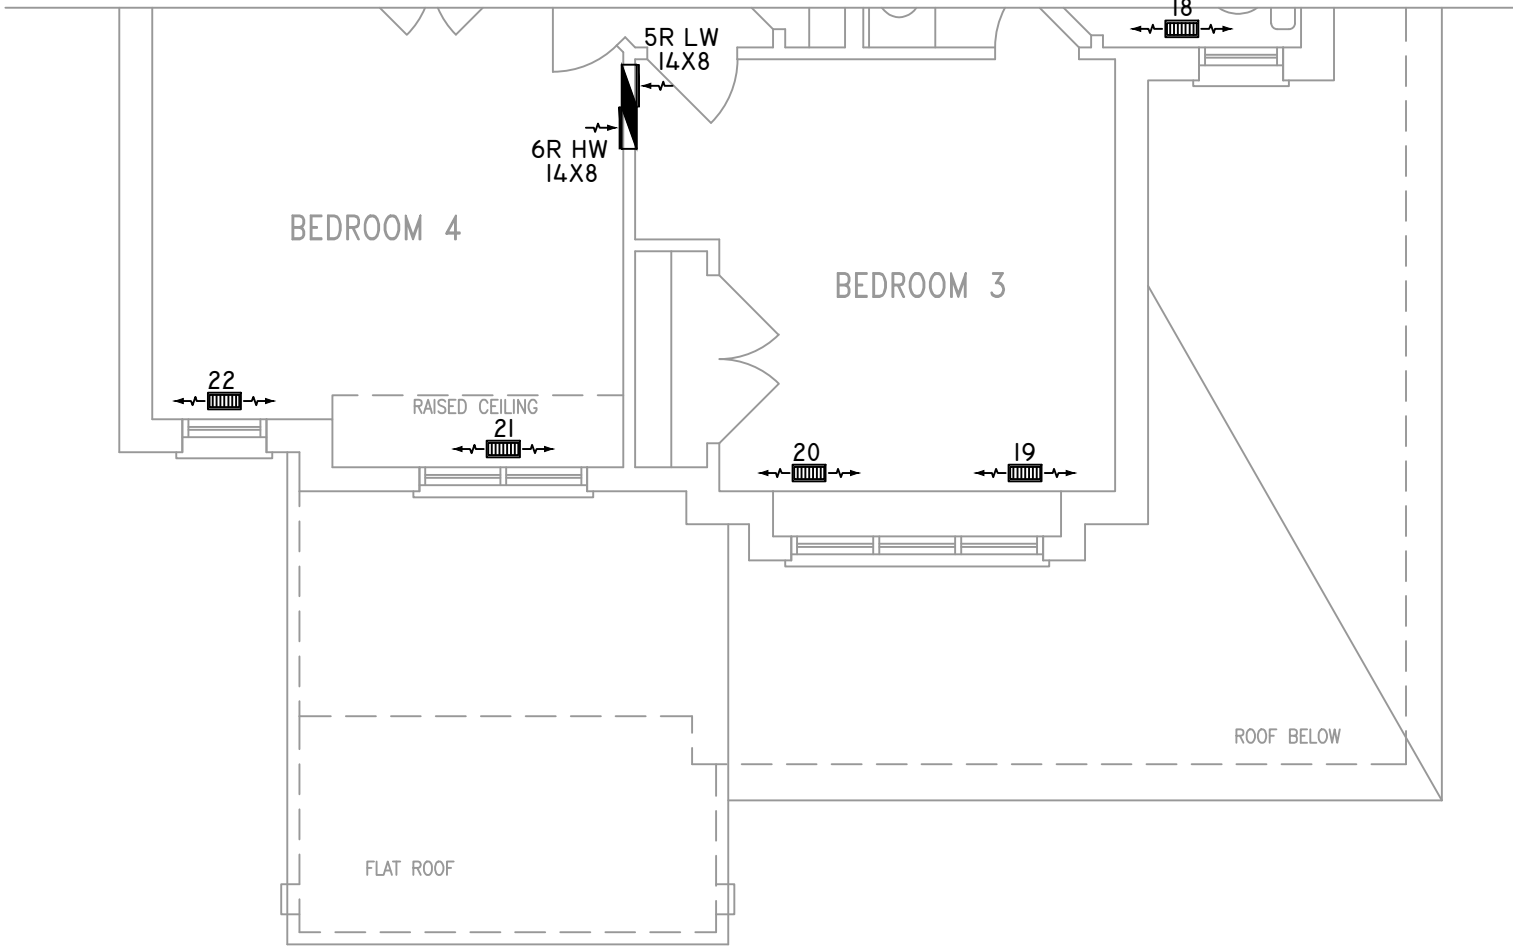

THE UNDERSIGNED HAS REVIEWED AND TAKES RESPONSIBILITY FOR THIS DESIGN ON BEHALF OF GTA DESIGNS INC. AND HAS THE QUALIFICATIONS AND MEETS THE REQUIREMENTS SET OUT IN THE BUILDING CODE TO BE A DESIGNER

QUALIFICATION INFORMATION

REQUIRED UNLESS DESIGN IS EXEMPT UNDER DIVISION C 3.2.5.1 OF THE ONTARIO BUILDING CODE

DAVID DA COSTA  B.C.I.N. 32964

SIGNATURE OF DESIGNER

NOTES

INSTALLATION TO COMPLY WITH THE LATEST ONTARIO BUILDING CODE.

ALL SUPPLY OUTLETS TO BE 5" DIA. UNLESS OTHERWISE SPECIFIED.

PROVIDE BALANCING DAMPERS ON ALL BRANCHES.

ALL R/A PARTITIONS 6" (FIRST FLOOR ONLY)

INSULATE DUCTS IN UNCONDITIONED SPACES R12 UNDERCUT ALL DOORS 1" MIN.

CONTRACTOR MUST WORK FROM APPROVED PLANS.

ANY ALTERATIONS TO THIS ORIGINAL PLAN ARE NOT THE RESPONSIBILITY OF GTA DESIGNS.

GTA DESIGNS MUST BE CONSULTED IF KITCHEN EXHAUST FAN EXCEEDS 700 CFM DEPRESSURIZATION MAY OCCUR WITH IN THE DWELLING.



2985 DREW ROAD
SUITE 202,
MISSISSAUGA, ONT.
L4T 0A4 TEL: 905-671-9800
EMAIL: DAVE@GTADESIGNS.CA
WEB: WWW.GTADESIGNS.CA

HEAT-LOSS	53,169	BTU/HR.
UNIT MAKE	AMANA	OR EQUAL.
UNIT MODEL	AMEC960603BNA	OR EQUAL.
UNIT HEATING INPUT	60,000	BTU/HR.
UNIT HEATING OUTPUT	57,600	BTU/HR.
A/C COOLING CAPACITY	3.0	TONS.
FAN SPEED	1170	CFM

 
# OF RUNS	S/A	R/A	FANS
3RD FLOOR			
2ND FLOOR	10	4	3
1ST FLOOR	9	1	3
BASEMENT	5	1	




FLOOR PLAN: PARTIAL PLAN(S)	
DRAWN BY: AM	CHECKED: DD
LAYOUT NO: JB-04619	DRAWING NO: M4
SQFT 2687	

DATE:	MARCH 29, 2018
CLIENT:	BAYVIEW WELLINGTON
MODEL:	S42-I6 WOB RIDEAU I6
PROJECT:	GREEN VALLEY EAST BRADFORD,ONT.
SCALE:	3/16" = 1'-0"

Site Copy OBC 2012

ZONE I COMPLIANCE
PACKAGE "A1" REF. TABLE 3.1.1.2.A

	FLEX DUCT		LOW/HIGH WALL/KICK SUPPLY DIFFUSER		DUCT CONNECTION TO JOIST LINING		RETURN AIR GRILLE (SIZE INDICATED ON DRAWING)	S.A.	SUPPLY AIR
	RIGID ROUND DUCT		HRV EXHAUST GRILLE		RETURN AIR PIPE RISER		RETURN AIR RISER UP TO FLOOR ABOVE	R.A.	RETURN AIR
	SUPPLY DIFFUSER		SUPPLY AIR PIPE RISER		RETURN ROUND DUCT		RETURN AIR FROM BASEMENT SECOND FLOOR		THERMOSTAT
			VOLUME DAMPER						W/R & PRINCIPAL EXHAUST FAN

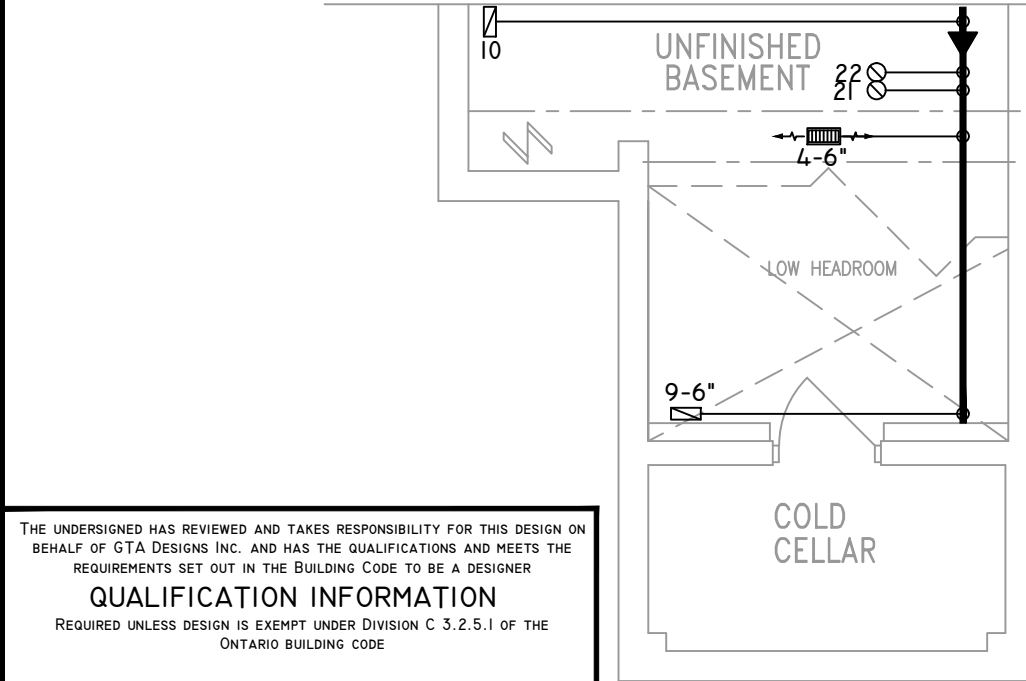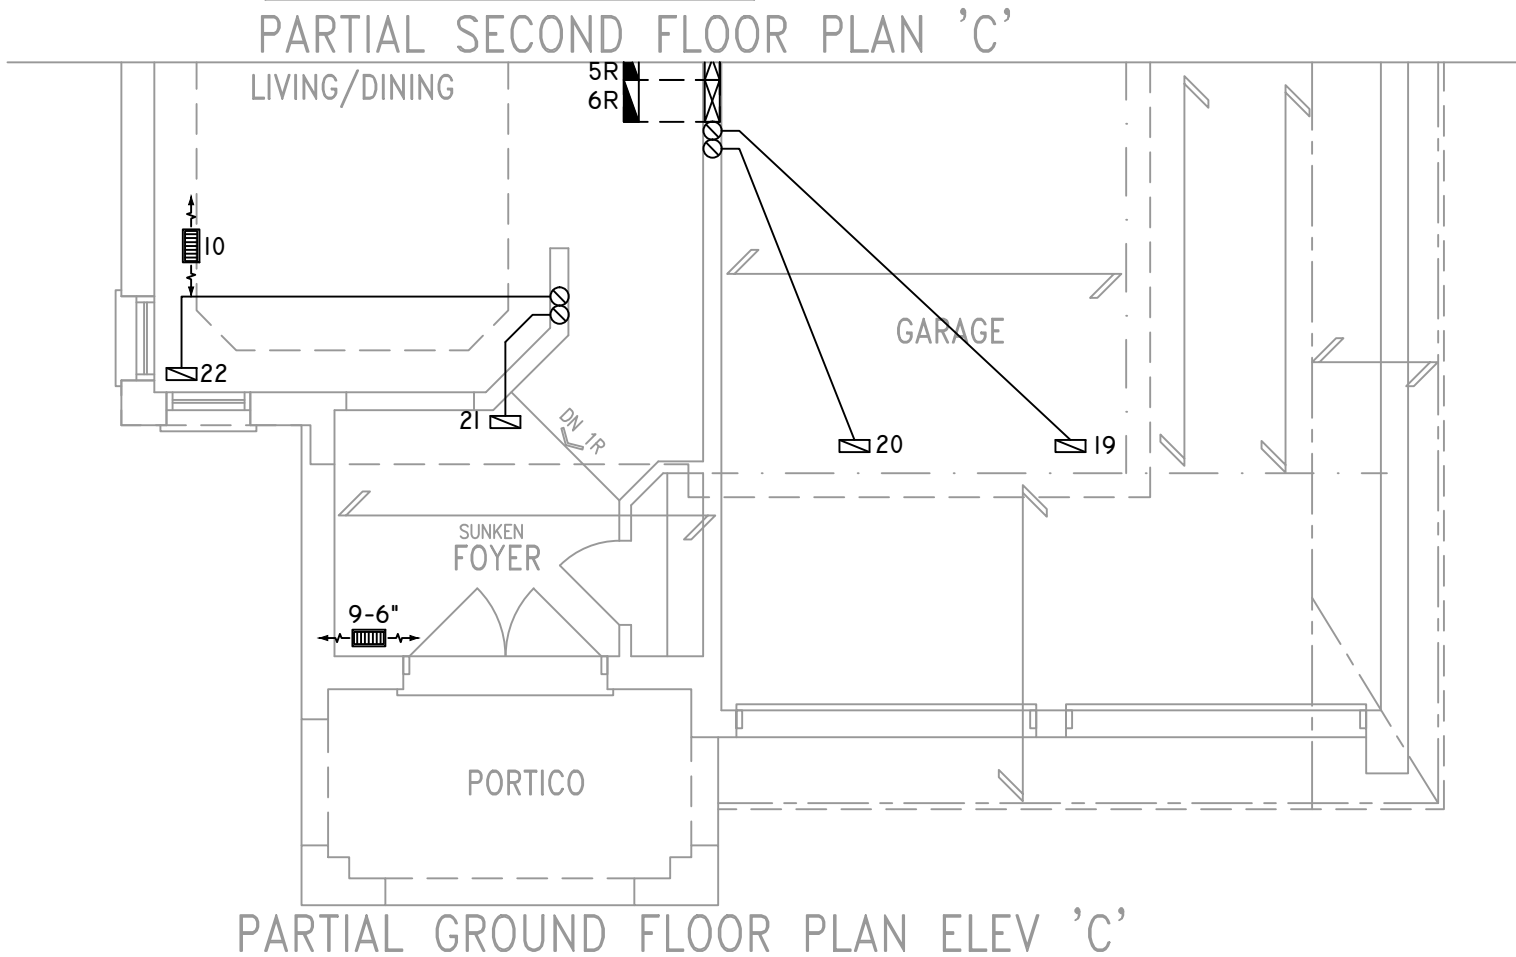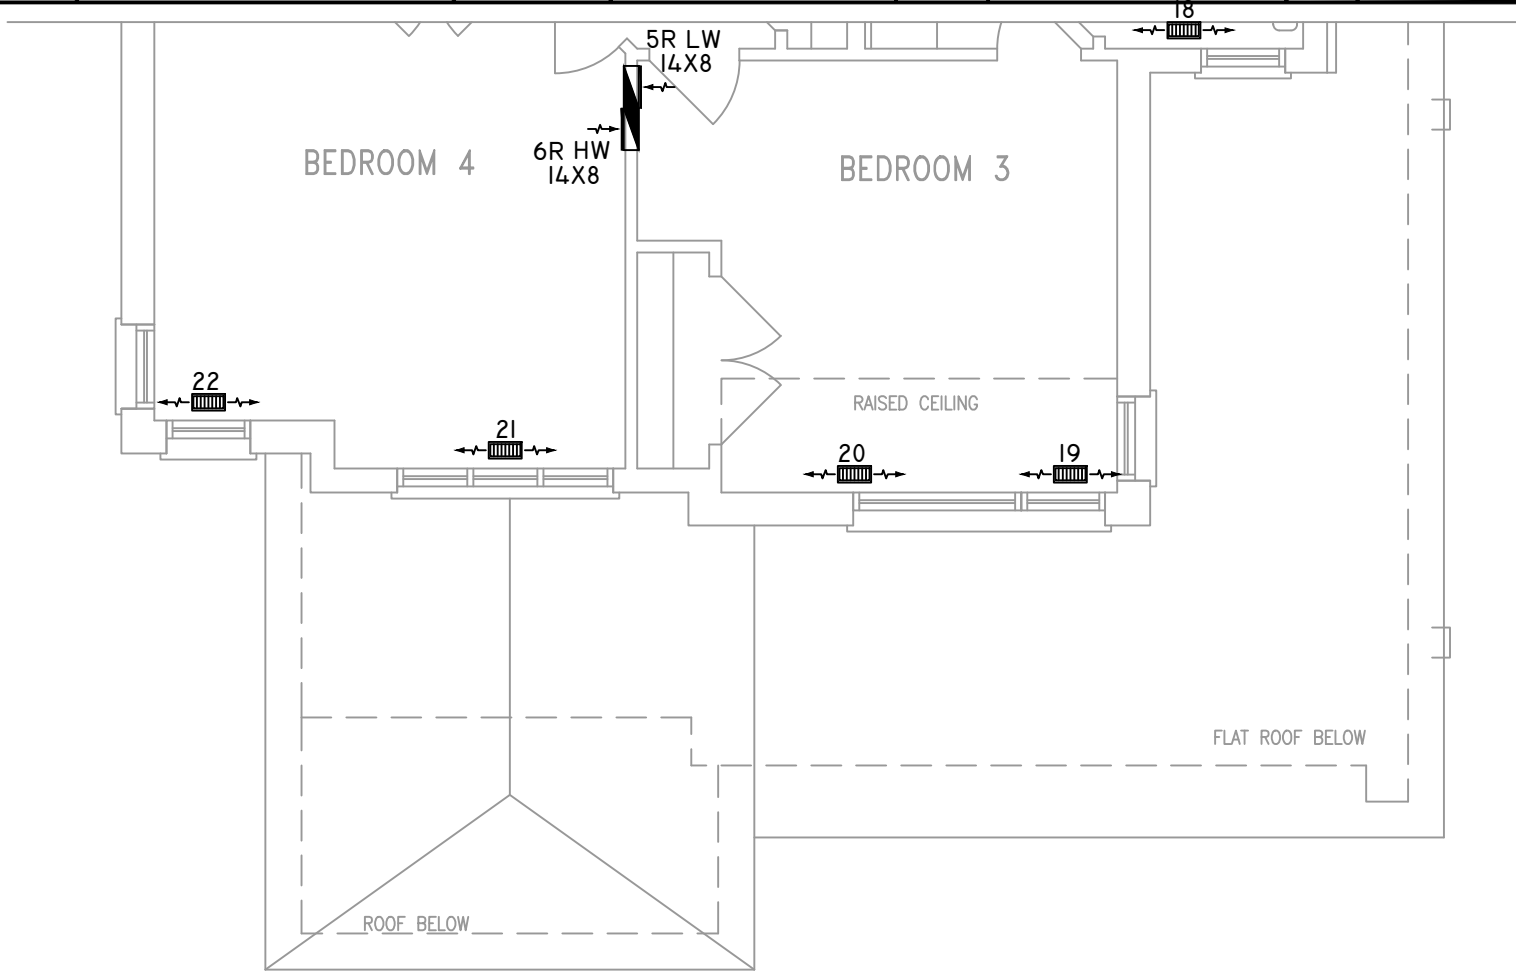

THE UNDERSIGNED HAS REVIEWED AND TAKES RESPONSIBILITY FOR THIS DESIGN ON BEHALF OF GTA DESIGNS INC. AND HAS THE QUALIFICATIONS AND MEETS THE REQUIREMENTS SET OUT IN THE BUILDING CODE TO BE A DESIGNER

QUALIFICATION INFORMATION

REQUIRED UNLESS DESIGN IS EXEMPT UNDER DIVISION C 3.2.5.1 OF THE ONTARIO BUILDING CODE

DAVID DA COSTA  B.C.I.N. 32964

SIGNATURE OF DESIGNER

Site Copy OBC 2012

ZONE I COMPLIANCE PACKAGE "AI" REF. TABLE 3.1.1.2.A

NOTES

INSTALLATION TO COMPLY WITH THE LATEST ONTARIO BUILDING CODE.

ALL SUPPLY OUTLETS TO BE 5" DIA. UNLESS OTHERWISE SPECIFIED.

PROVIDE BALANCING DAMPERS ON ALL BRANCHES.

ALL R/A PARTITIONS 6" (FIRST FLOOR ONLY)

INSULATE DUCTS IN UNCONDITIONED SPACES R12 UNDERCUT ALL DOORS 1" MIN.

CONTRACTOR MUST WORK FROM APPROVED PLANS.

ANY ALTERATIONS TO THIS ORIGINAL PLAN ARE NOT THE RESPONSIBILITY OF GTA DESIGNS.

GTA DESIGNS MUST BE CONSULTED IF KITCHEN EXHAUST FAN EXCEEDS 700 CFM DEPRESSURIZATION MAY OCCUR WITH IN THE DWELLING.



GTADESIGNS

 
2985 DREW ROAD
SUITE 202,
MISSISSAUGA, ONT.
L4T 0A4 TEL: 905-671-9800
EMAIL: DAVE@GTADESIGNS.CA
WEB: WWW.GTADESIGNS.CA


HEAT-LOSS	53,169	BTU/HR.
UNIT MAKE	AMANA	OR EQUAL.
UNIT MODEL	AMEC960603BNA	OR EQUAL.
UNIT HEATING INPUT	60,000	BTU/HR.
UNIT HEATING OUTPUT	57,600	BTU/HR.
A/C COOLING CAPACITY	3.0	TONS.
FAN SPEED	1170	CFM

# OF RUNS	S/A	R/A	FANS
3RD FLOOR			
2ND FLOOR	10	4	3
1ST FLOOR	9	1	3
BASEMENT	5	1	


FLOOR PLAN: PARTIAL PLAN(S)	
DRAWN BY: AM	CHECKED: DD
LAYOUT NO. JB-04619	DRAWING NO. M5
SQFT 2687	

DATE:	MARCH 29, 2018
CLIENT:	BAYVIEW WELLINGTON
MODEL:	S42-16 WOB RIDEAU 16
PROJECT:	GREEN VALLEY EAST BRADFORD, ONT.
SCALE:	3/16" = 1'-0"


	FLEX DUCT		LOW/HIGH WALL/KICK SUPPLY DIFFUSER		DUCT CONNECTION TO JOIST LINING		RETURN AIR GRILLE (SIZE INDICATED ON DRAWING)	S.A.	SUPPLY AIR
	RIGID ROUND DUCT		HRV EXHAUST GRILLE		RETURN AIR PIPE RISER		RETURN AIR RISER UP TO FLOOR ABOVE	R.A.	RETURN AIR
	SUPPLY DIFFUSER		SUPPLY AIR PIPE RISER		RETURN ROUND DUCT		RETURN AIR FROM BASEMENT SECOND FLOOR		THERMOSTAT
			VOLUME DAMPER						PRINCIPAL EXHAUST FAN SWITCH
									W/R & PRINCIPAL EXHAUST FAN

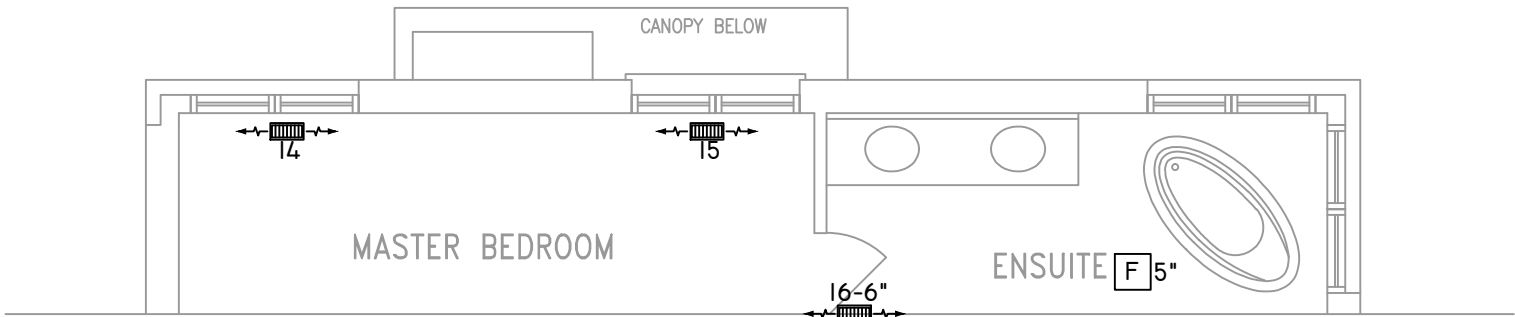


PARTIAL SECOND FLOOR PLAN ELEVATION 'C' REAR UPGRADE

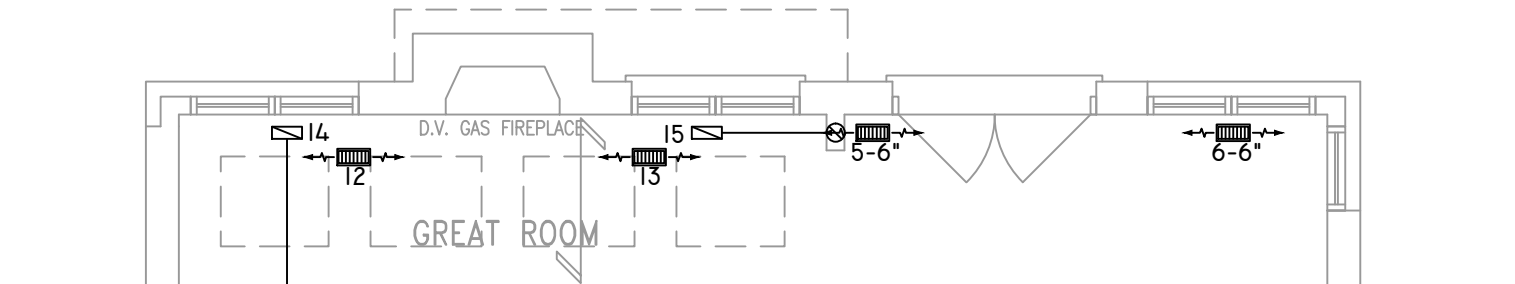

PARTIAL GROUND FLOOR PLAN ELEVATION 'C' REAR UPGRADE

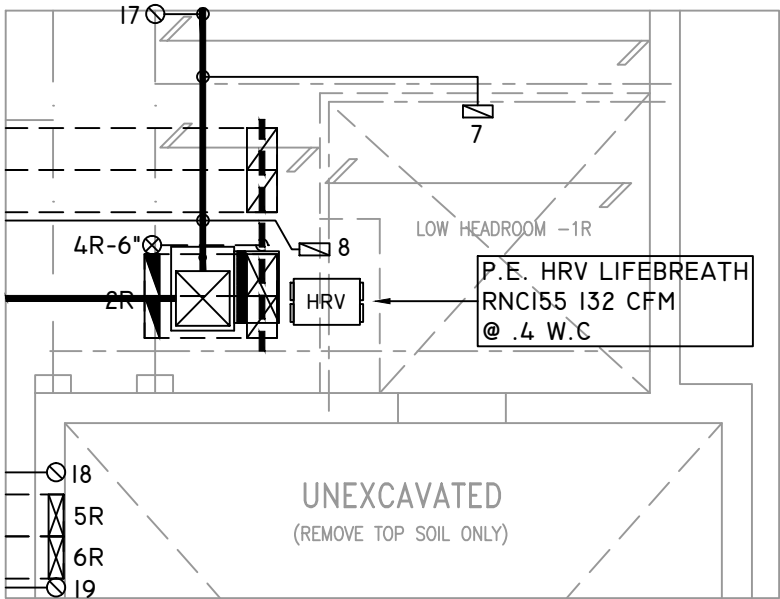

PARTIAL SUNKEN LAUNDRY
1R CONDITION

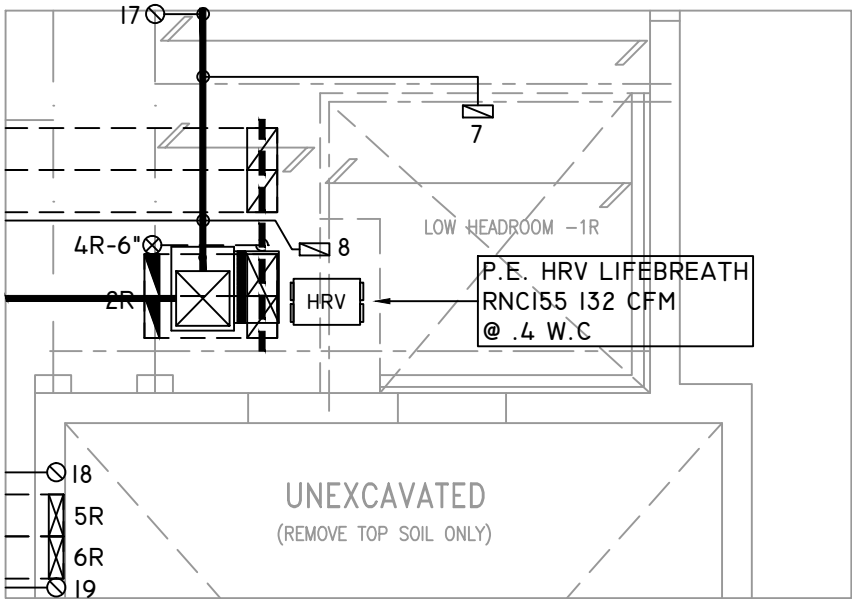

PARTIAL SUNKEN LAUNDRY
2-3R CONDITION

THE UNDERSIGNED HAS REVIEWED AND TAKES RESPONSIBILITY FOR THIS DESIGN ON BEHALF OF GTA DESIGNS INC. AND HAS THE QUALIFICATIONS AND MEETS THE REQUIREMENTS SET OUT IN THE BUILDING CODE TO BE A DESIGNER

QUALIFICATION INFORMATION

REQUIRED UNLESS DESIGN IS EXEMPT UNDER DIVISION C 3.2.5.1 OF THE ONTARIO BUILDING CODE

DAVID DA COSTA  B.C.I.N. 32964
SIGNATURE OF DESIGNER

OBC 2012

Site Copy

ZONE I COMPLIANCE
PACKAGE "AI" REF. TABLE 3.1.1.2.A

NOTES

INSTALLATION TO COMPLY WITH THE LATEST ONTARIO BUILDING CODE.

ALL SUPPLY OUTLETS TO BE 5" DIA. UNLESS OTHERWISE SPECIFIED.

PROVIDE BALANCING DAMPERS ON ALL BRANCHES.

ALL R/A PARTITIONS 6" (FIRST FLOOR ONLY)

INSULATE DUCTS IN UNCONDITIONED SPACES R12 UNDERCUT ALL DOORS 1" MIN.

CONTRACTOR MUST WORK FROM APPROVED PLANS.

ANY ALTERATIONS TO THIS ORIGINAL PLAN ARE NOT THE RESPONSIBILITY OF GTA DESIGNS.

GTA DESIGNS MUST BE CONSULTED IF KITCHEN EXHAUST FAN EXCEEDS 700 CFM DEPRESSURIZATION MAY OCCUR WITH IN THE DWELLING.

 

**2985 DREW ROAD
SUITE 202,
MISSISSAUGA, ONT.
L4T 0A4 TEL: 905-671-9800
EMAIL: DAVE@GTADESIGNS.CA
WEB: WWW.GTADESIGNS.CA**


HEAT-LOSS	53,169	BTU/HR.
UNIT MAKE	AMANA	OR EQUAL.
UNIT MODEL	AMEC960603BNA	OR EQUAL.
UNIT HEATING INPUT	60,000	BTU/HR.
UNIT HEATING OUTPUT	57,600	BTU/HR.
A/C COOLING CAPACITY	3.0	TONS.
FAN SPEED	1170	CFM

# OF RUNS	S/A	R/A	FANS
3RD FLOOR			
2ND FLOOR	10	4	3
1ST FLOOR	9	1	3
BASEMENT	5	1	


FLOOR PLAN: PARTIAL PLAN(S)		
DRAWN BY: AM	CHECKED: DD	SQFT 2687
LAYOUT NO. JB-04619	DRAWING NO. M6	

DATE:	MARCH 29, 2018
CLIENT:	BAYVIEW WELLINGTON
MODEL:	S42-16 WOB RIDEAU 16
PROJECT:	GREEN VALLEY EAST BRADFORD,ONT.
SCALE:	3/16" = 1'-0"

	FLEX DUCT		LOW/HIGH WALL/KICK SUPPLY DIFFUSER		DUCT CONNECTION TO JOIST LINING		RETURN AIR GRILLE (SIZE INDICATED ON DRAWING)	S.A.	SUPPLY AIR
	RIGID ROUND DUCT		HRV EXHAUST GRILLE		RETURN AIR PIPE RISER		RETURN AIR RISER UP TO FLOOR ABOVE	R.A.	RETURN AIR
	SUPPLY DIFFUSER		SUPPLY AIR PIPE RISER		RETURN ROUND DUCT		RETURN AIR FROM BASEMENT SECOND FLOOR		THERMOSTAT
			VOLUME DAMPER						PRINCIPAL EXHAUST FAN SWITCH W/R & PRINCIPAL EXHAUST FAN

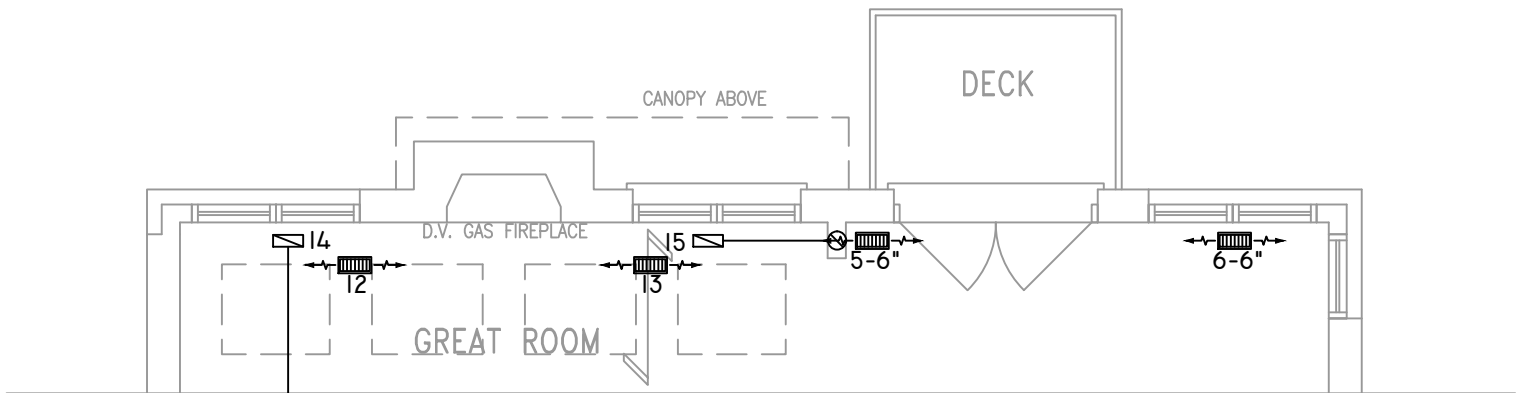

PARTIAL GROUND FLOOR PLAN WOB ELEVATION 'C' REAR UPGRADE

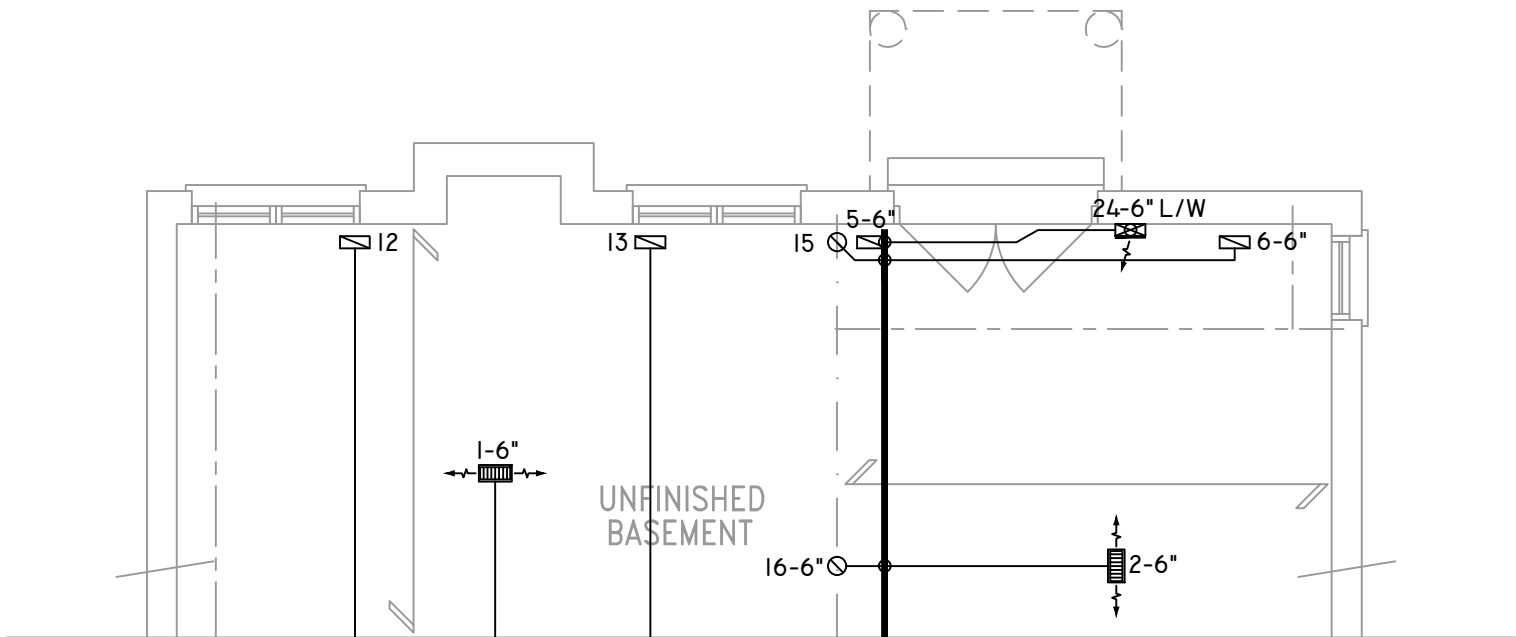

PARTIAL BASEMENT PLAN WOB ELEVATION 'C' REAR UPGRADE

THE UNDERSIGNED HAS REVIEWED AND TAKES RESPONSIBILITY FOR THIS DESIGN ON BEHALF OF GTA DESIGNS INC. AND HAS THE QUALIFICATIONS AND MEETS THE REQUIREMENTS SET OUT IN THE BUILDING CODE TO BE A DESIGNER

QUALIFICATION INFORMATION

REQUIRED UNLESS DESIGN IS EXEMPT UNDER DIVISION C 3.2.5.1 OF THE ONTARIO BUILDING CODE

DAVID DA COSTA  B.C.I.N. 32964

SIGNATURE OF DESIGNER

OBC 2012

Site Copy

ZONE I COMPLIANCE
PACKAGE "A1" REF. TABLE 3.1.1.2.A

NOTES
INSTALLATION TO COMPLY WITH THE LATEST ONTARIO BUILDING CODE.
ALL SUPPLY OUTLETS TO BE 5" DIA. UNLESS OTHERWISE SPECIFIED.
PROVIDE BALANCING DAMPERS ON ALL BRANCHES.
ALL R/A PARTITIONS 6" (FIRST FLOOR ONLY)
INSULATE DUCTS IN UNCONDITIONED SPACES R12 UNDERCUT ALL DOORS 1" MIN.
CONTRACTOR MUST WORK FROM APPROVED PLANS.
ANY ALTERATIONS TO THIS ORIGINAL PLAN ARE NOT THE RESPONSIBILITY OF GTA DESIGNS.
GTA DESIGNS MUST BE CONSULTED IF KITCHEN EXHAUST FAN EXCEEDS 700 CFM DEPRESSURIZATION MAY OCCUR WITH IN THE DWELLING.



2985 DREW ROAD
SUITE 202,
MISSISSAUGA, ONT.
L4T 0A4 TEL: 905-671-9800
EMAIL: DAVE@GTADESIGNS.CA
WEB: WWW.GTADESIGNS.CA

HEAT-LOSS	53,169	BTU/HR.
UNIT MAKE	AMANA	OR EQUAL.
UNIT MODEL	AMEC960603BNA	OR EQUAL.
UNIT HEATING INPUT	60,000	BTU/HR.
UNIT HEATING OUTPUT	57,600	BTU/HR.
A/C COOLING CAPACITY	3.0	TONS.
FAN SPEED	1170	CFM

# OF RUNS	S/A	R/A	FANS
3RD FLOOR			
2ND FLOOR	10	4	3
1ST FLOOR	9	1	3
BASEMENT	5	1	

FLOOR PLAN: PARTIAL PLAN(S)	
DRAWN BY: AM	CHECKED: DD
LAYOUT NO: JB-04619	DRAWING NO: M7
SQFT 2687	

DATE:	MARCH 29, 2018
CLIENT:	BAYVIEW WELLINGTON
MODEL:	S42-16 WOB RIDEAU 16
PROJECT:	GREEN VALLEY EAST BRADFORD,ONT.
SCALE:	3/16" = 1'-0"