



PARTIAL PLAN
FOR OPTIONAL
GAS FIREPLACE

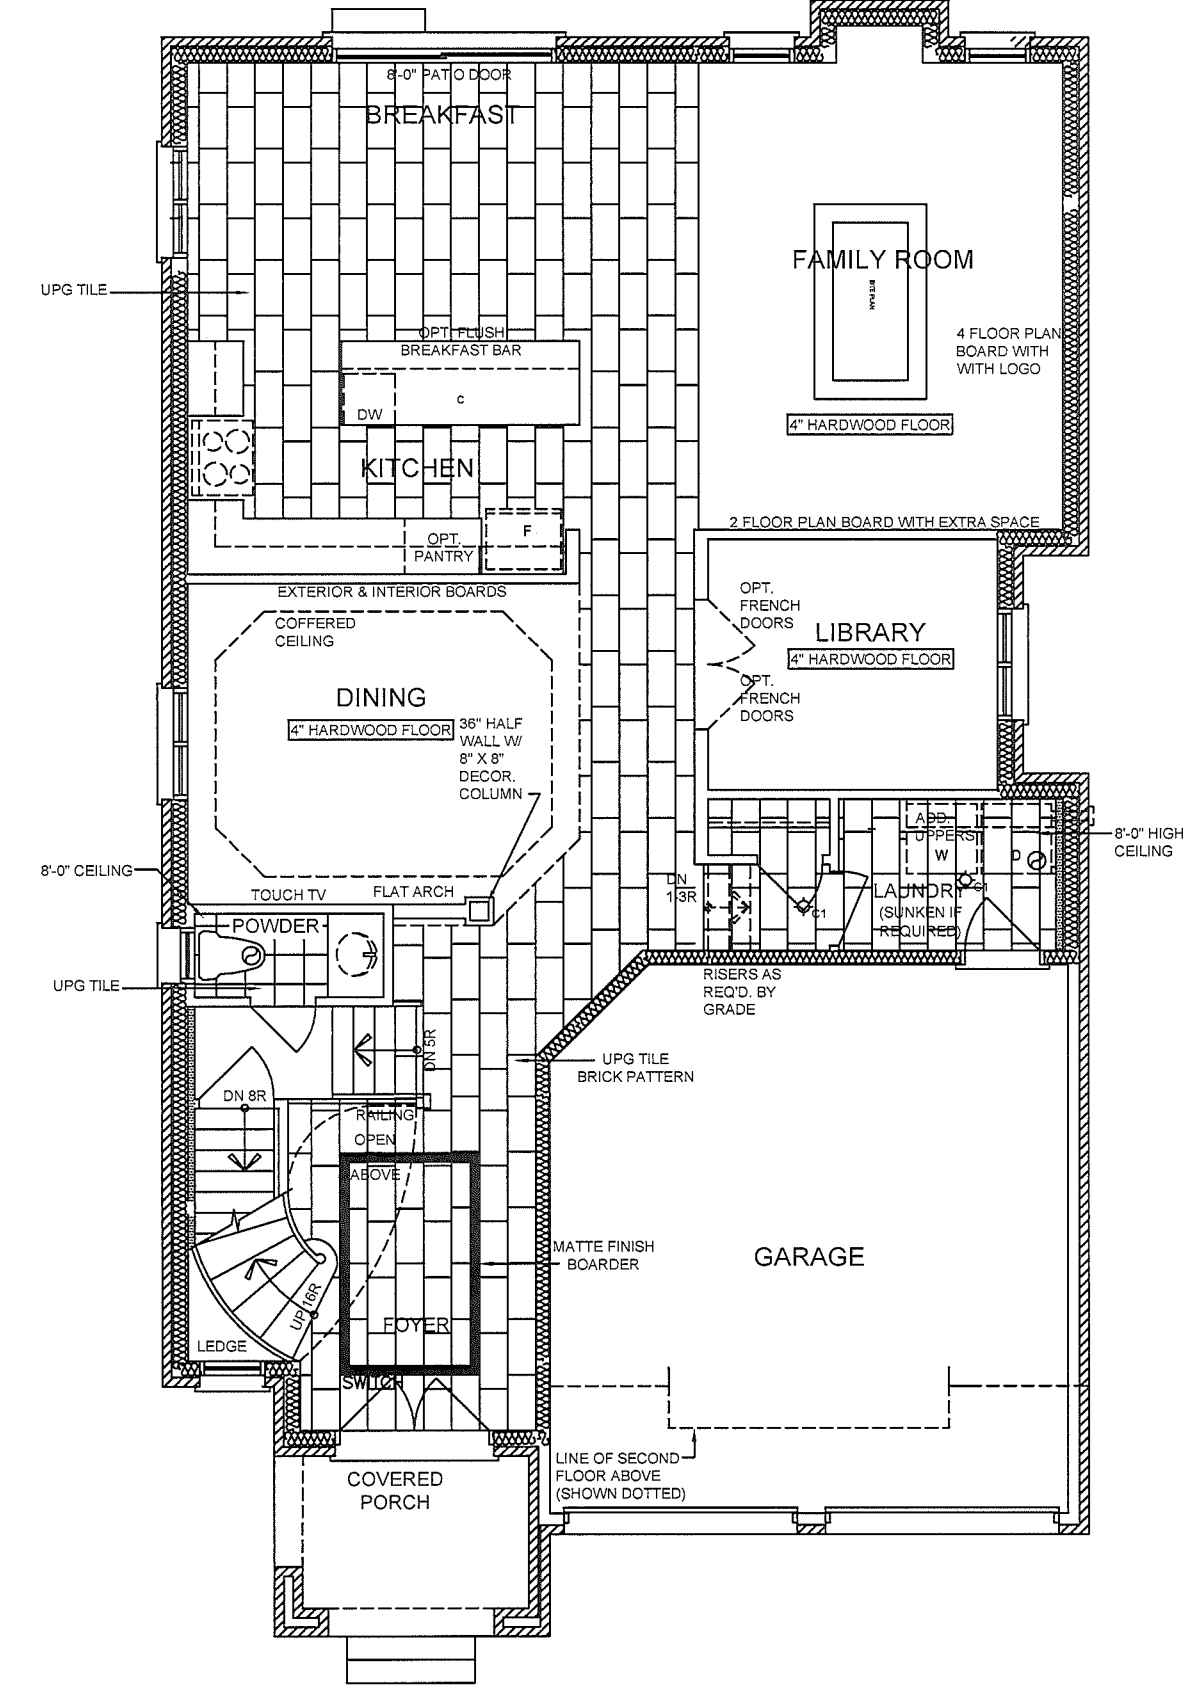


TILE LAYOUT

Client DELPARK HOMES	Sheet Title GROUND FLOOR PLAN ELEVATION C		LOT#16 MODEL HOME	Project No.
Project THE BROOK CITY OF OSHAWA				2015-17
Model / Unit 40-6 Elevation B & C (Two Storey)	Scale SCALE	Drawn by EO		Drawing Number
	Date FEB. 2016	Checked by PF		
ASPEN 6		Updated: AD April 9 2018		

LIGHTING & MECHANICAL SYMBOLS	
	CHANDELIER
	UNDER LIGHT VALANCE
	RECESSED POT FIXTURE
	WALL SCONCE
	WALL SCONCE
	PENDANT FIXTURE
	CEILING FIXTURE

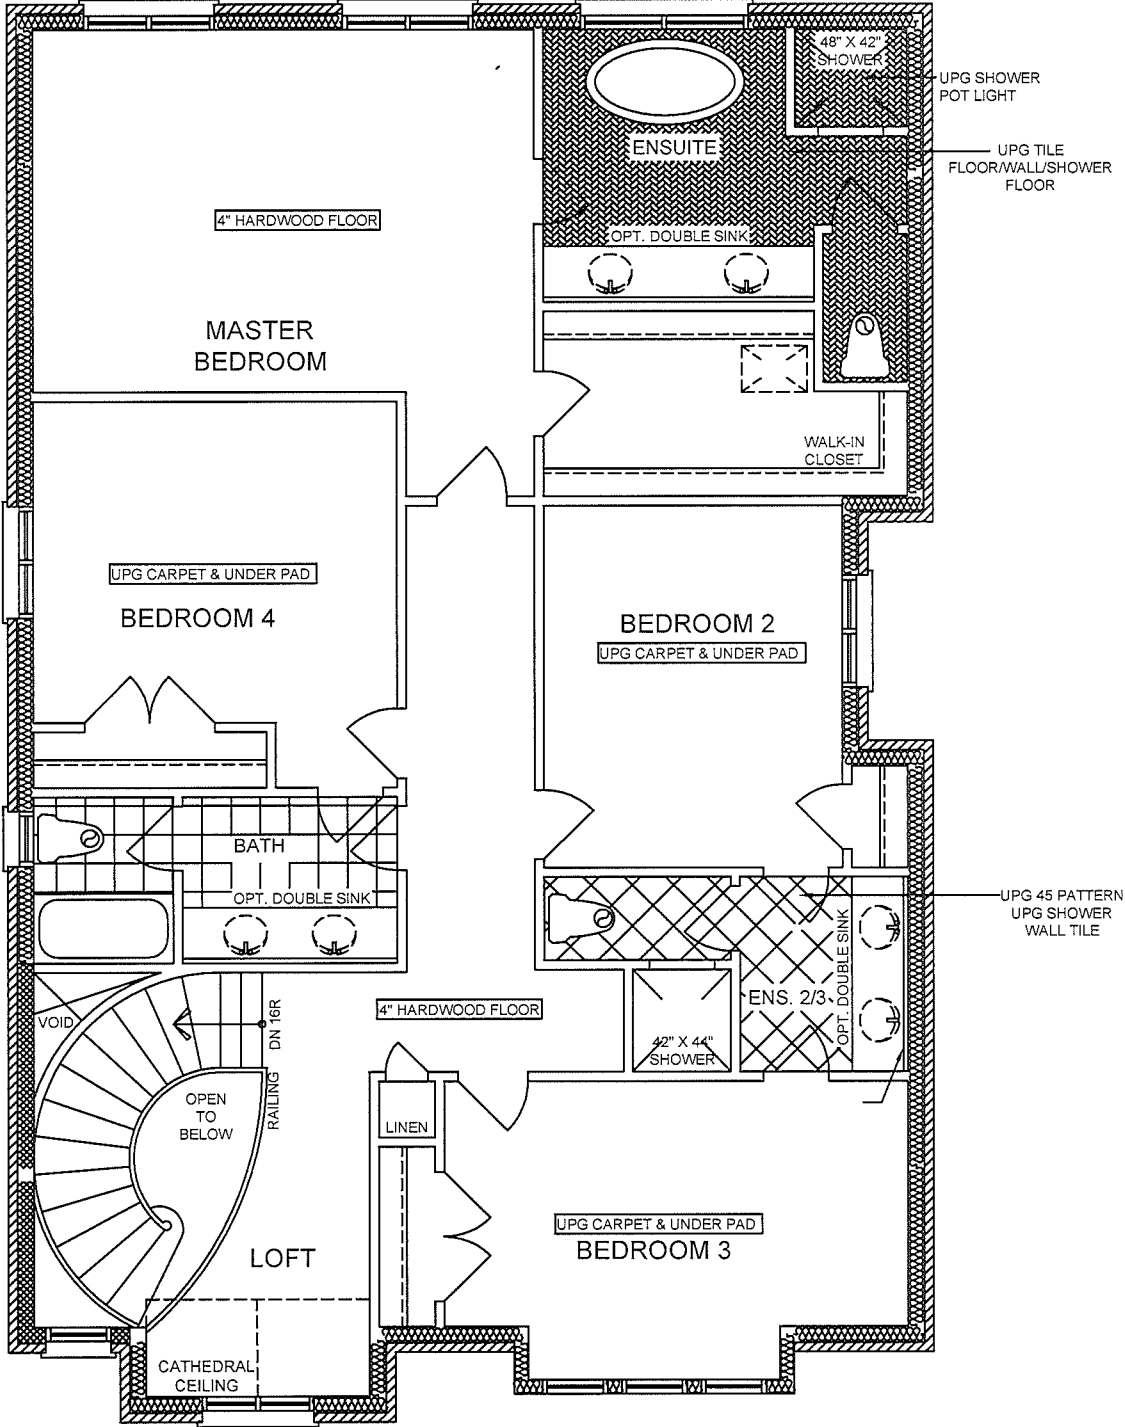


Client DELPARK HOMES	Sheet Title SECOND FLOOR PLAN ELEVATION C		LOT#16 MODEL HOME LIGHTING PLAN	Project No. 2015-17
Project THE BROOK CITY OF OSHAWA	Scale SCALE	Drawn by EO		Drawing Number
Model / Unit 40-6 Elevation B & C (Two Storey)	Date FEB. 2016	Checked by PF		A8
ASPEN 6		Updated: AD April 23 2018		

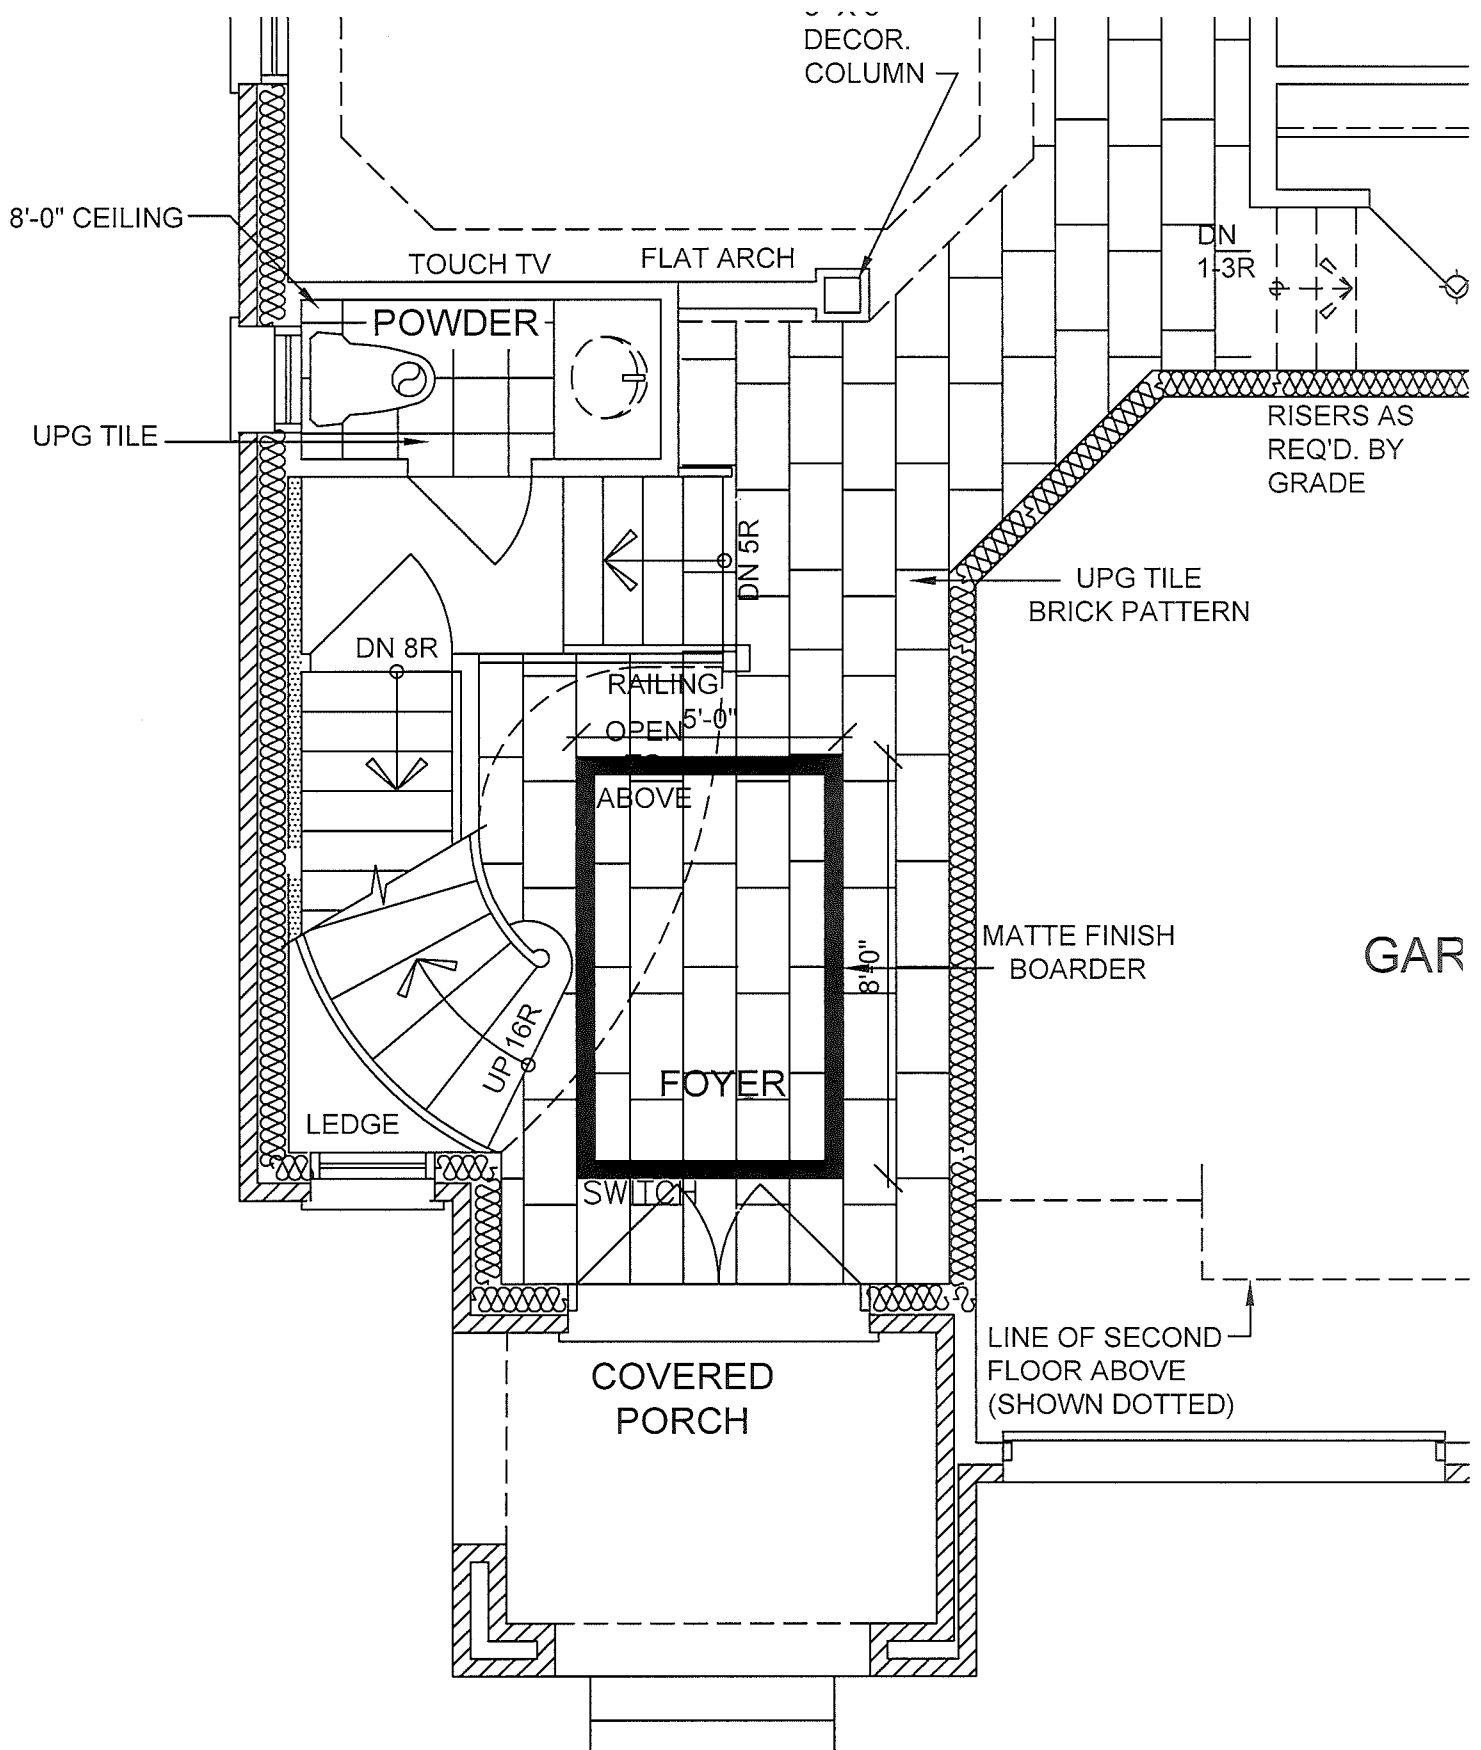

Foyer Boarder

4x24 - Regal Matte Grey


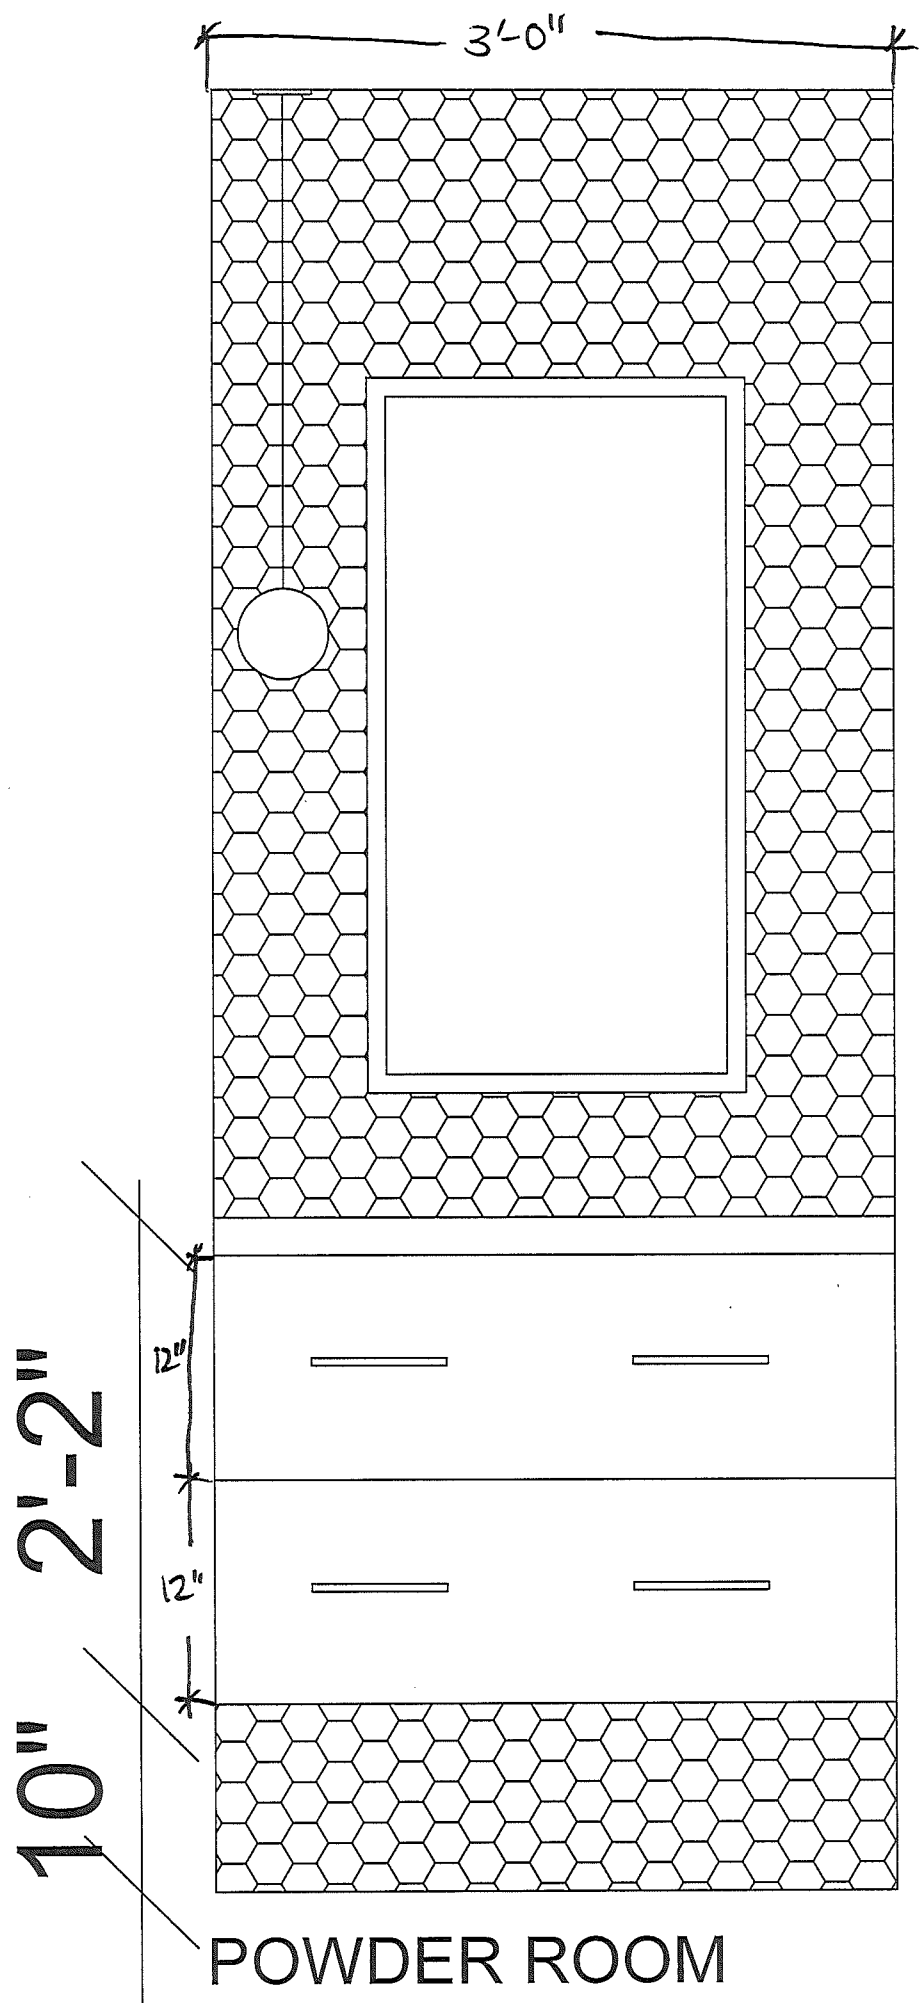


Tile:
Ontario Hexagon
Matte Snow White
upg grout.

Cabinet
3ftw x 24"d
w undermount
sink

2 drawers

POWDER ROOM
FRONT WALL- ELEVATION

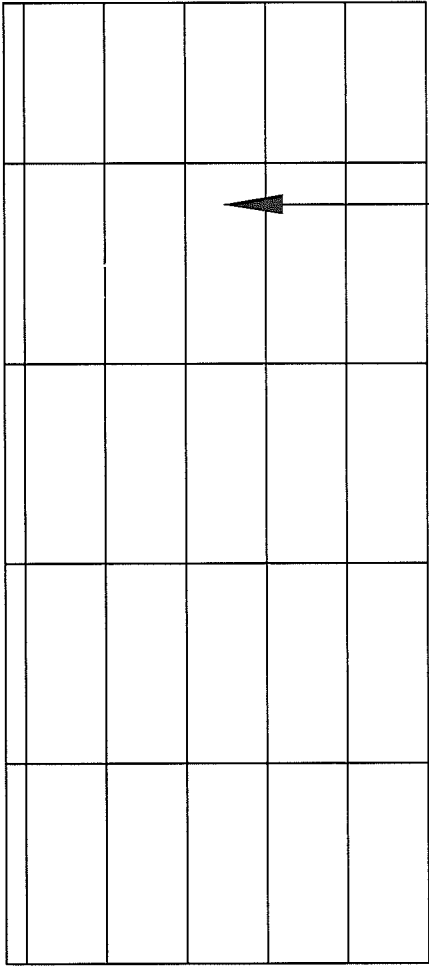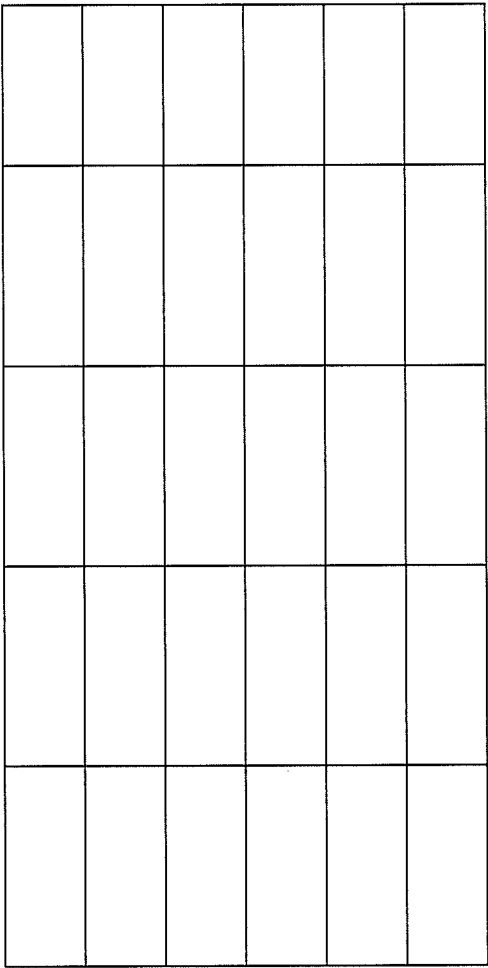

FRONT & SIDE ELEVATION
MASTER BEDROOM SHOWER WALL LAYOUT