



update file deqwall stage.


Finished 3pc bathroom Walk-out
Recreation Room A/C

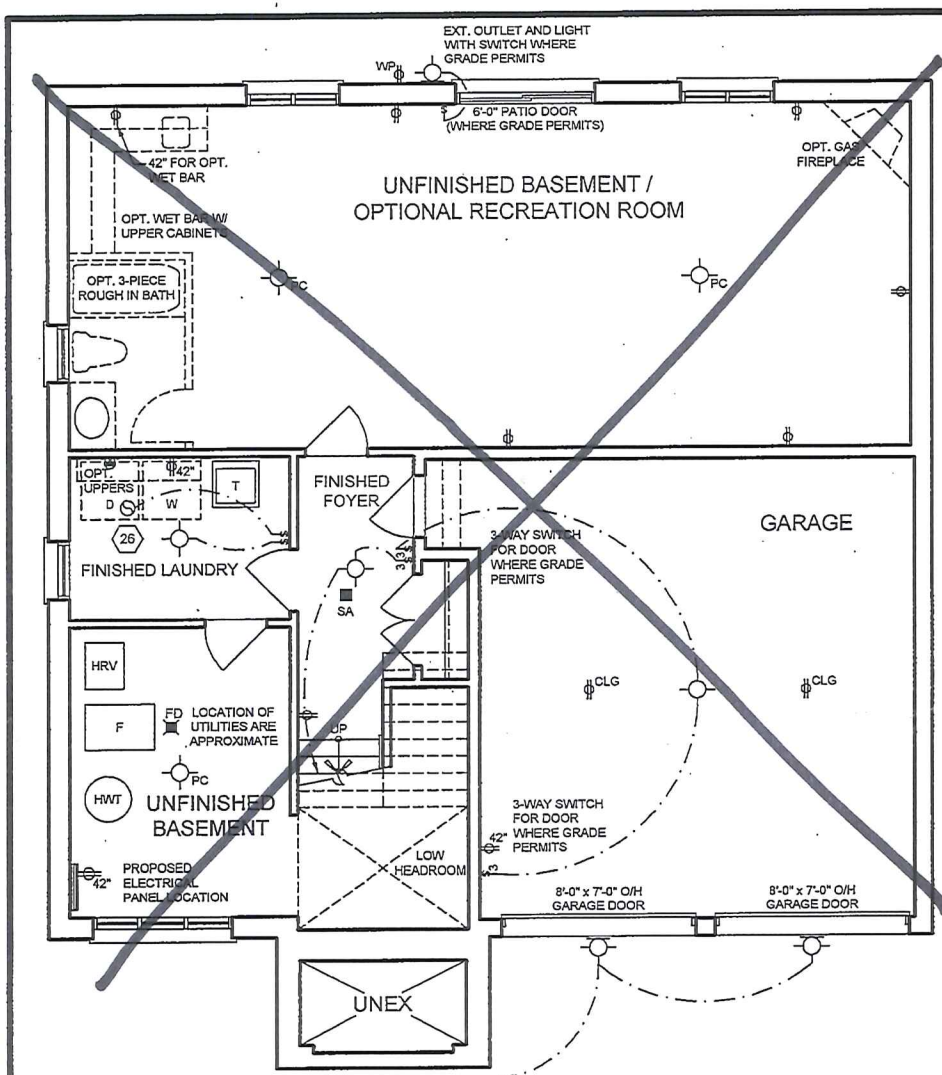


BASEMENT PLAN
ELEVATION 'B' & 'C'

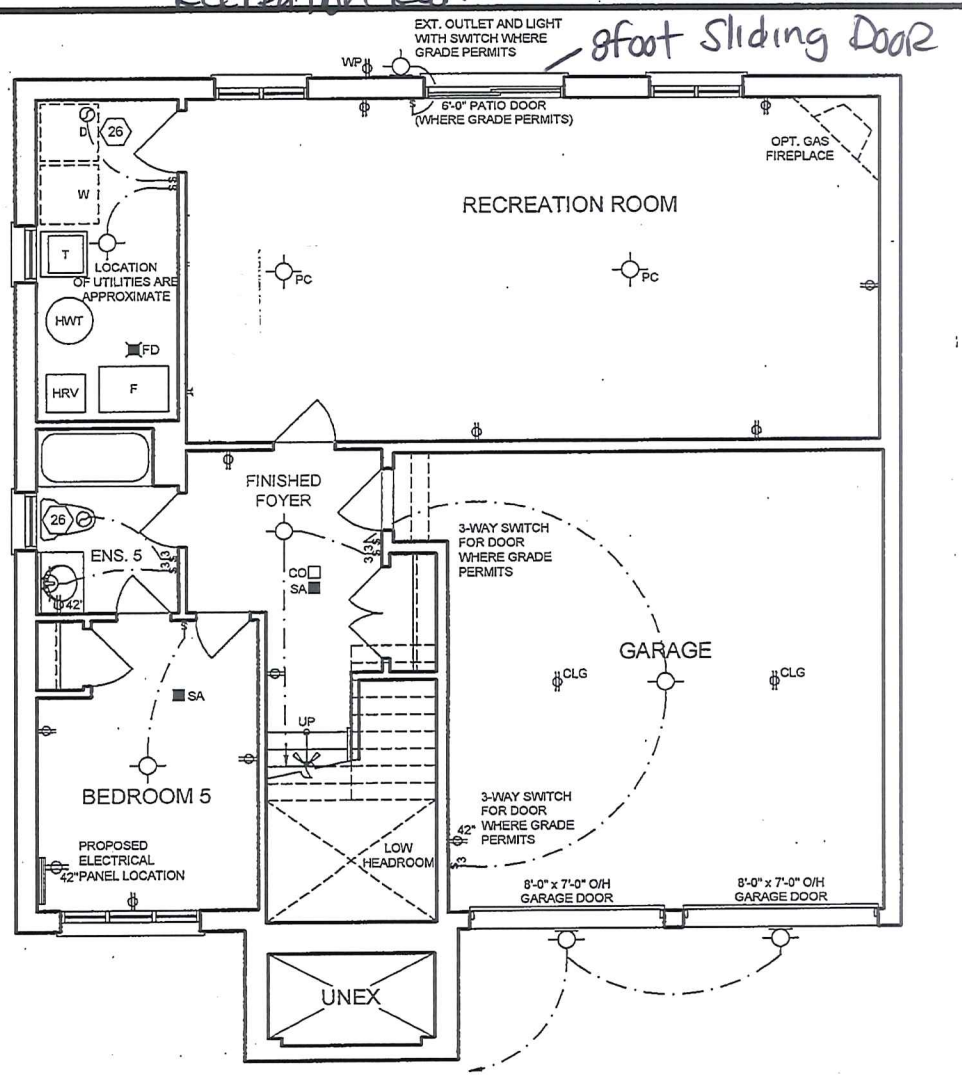

OPTIONAL BASEMENT PLAN
ELEVATION 'B' & 'C'

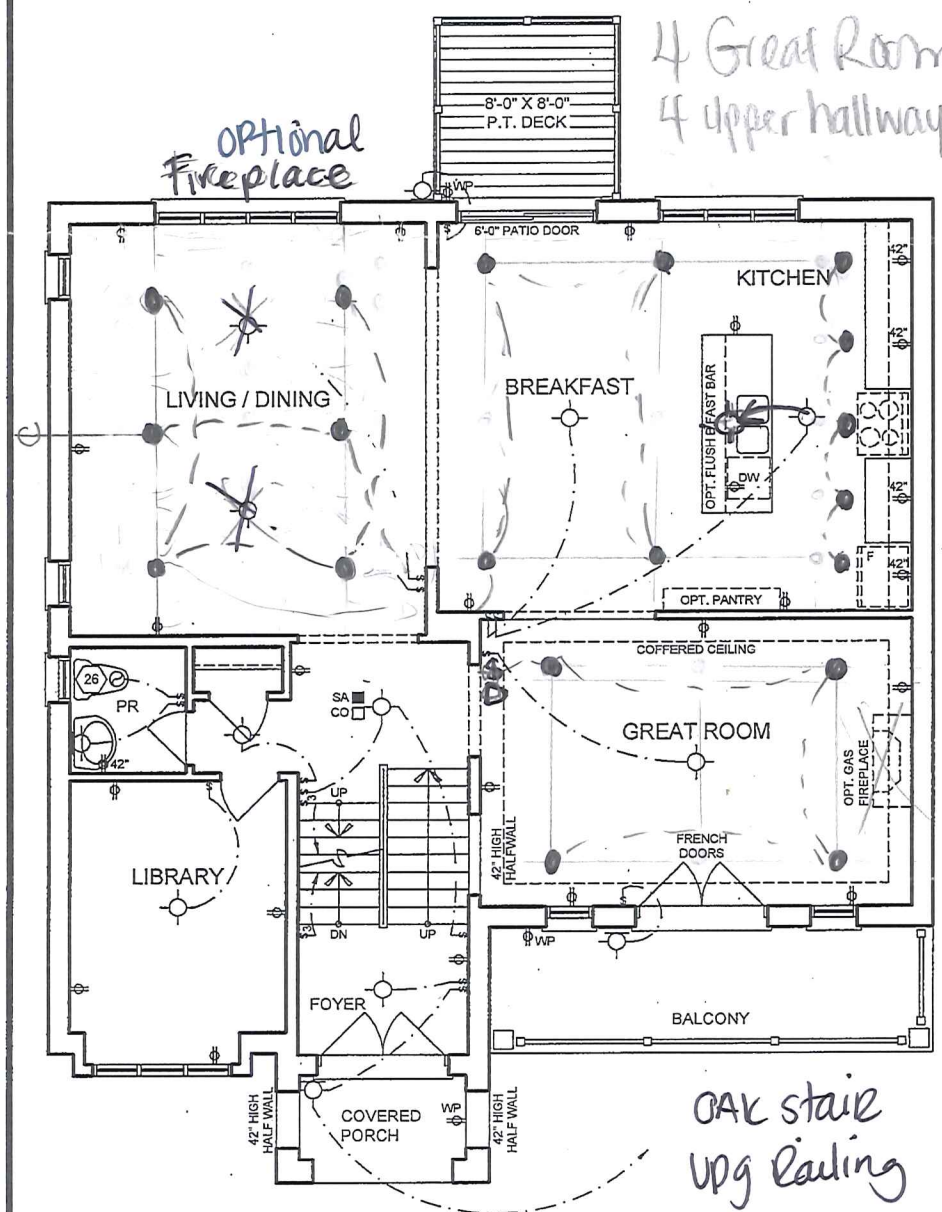

MAIN FLOOR PLAN
ELEVATION 'B'

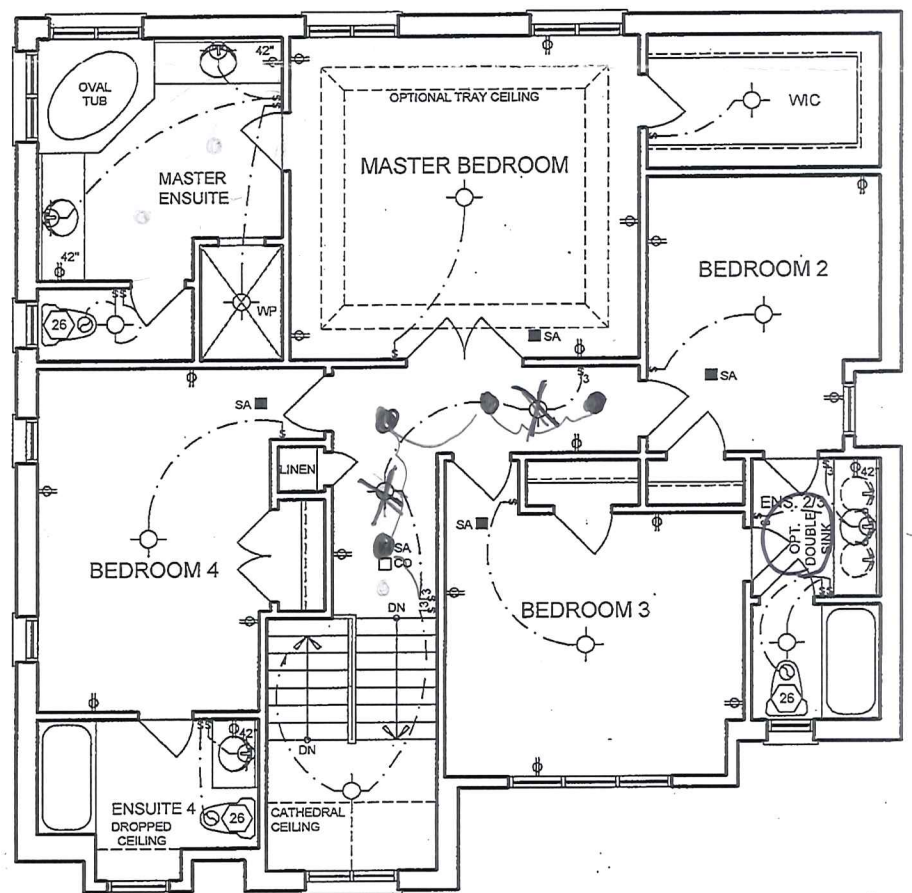

UPPER FLOOR PLAN
ELEVATION 'B'

NOTE: ELECTRICAL PLANS ARE
SIMILAR FOR ELEVATION 'C'

Client DELPARK HOMES Project THE CROSSWINDS MUNICIPALITY OF CLARINGTON Model / Unit 45-6 Elevations B & C (Three Storey)	Sheet Title ELECTRICAL PLANS ELEVATION 'B' Scale 3/16" = 1'-0" Date MAR. 2017 Drawn by KH Checked by PF STAFFORD 6	REGISTERED PERSON: D.W. CASSIDY & CO. ARCHITECTURAL TECHNOLOGISTS FIRM BCIN 28461 I, <u>STEPHEN P. KENNEDY</u> have reviewed and take responsibility for this design. Signature <u>[Signature]</u> BCIN <u>23411</u> Date: <u>NOV. 7, 2017</u>	CASSIDY & CO. ARCHITECTURAL TECHNOLOGISTS 60 RANDALL DRIVE SUITE 11 AJAX, ONTARIO L1S 6L3 PH (905) 619-1270 FAX (905) 619-1269	Project No. 2014-43 Drawing Number A20
---	--	---	--	--