


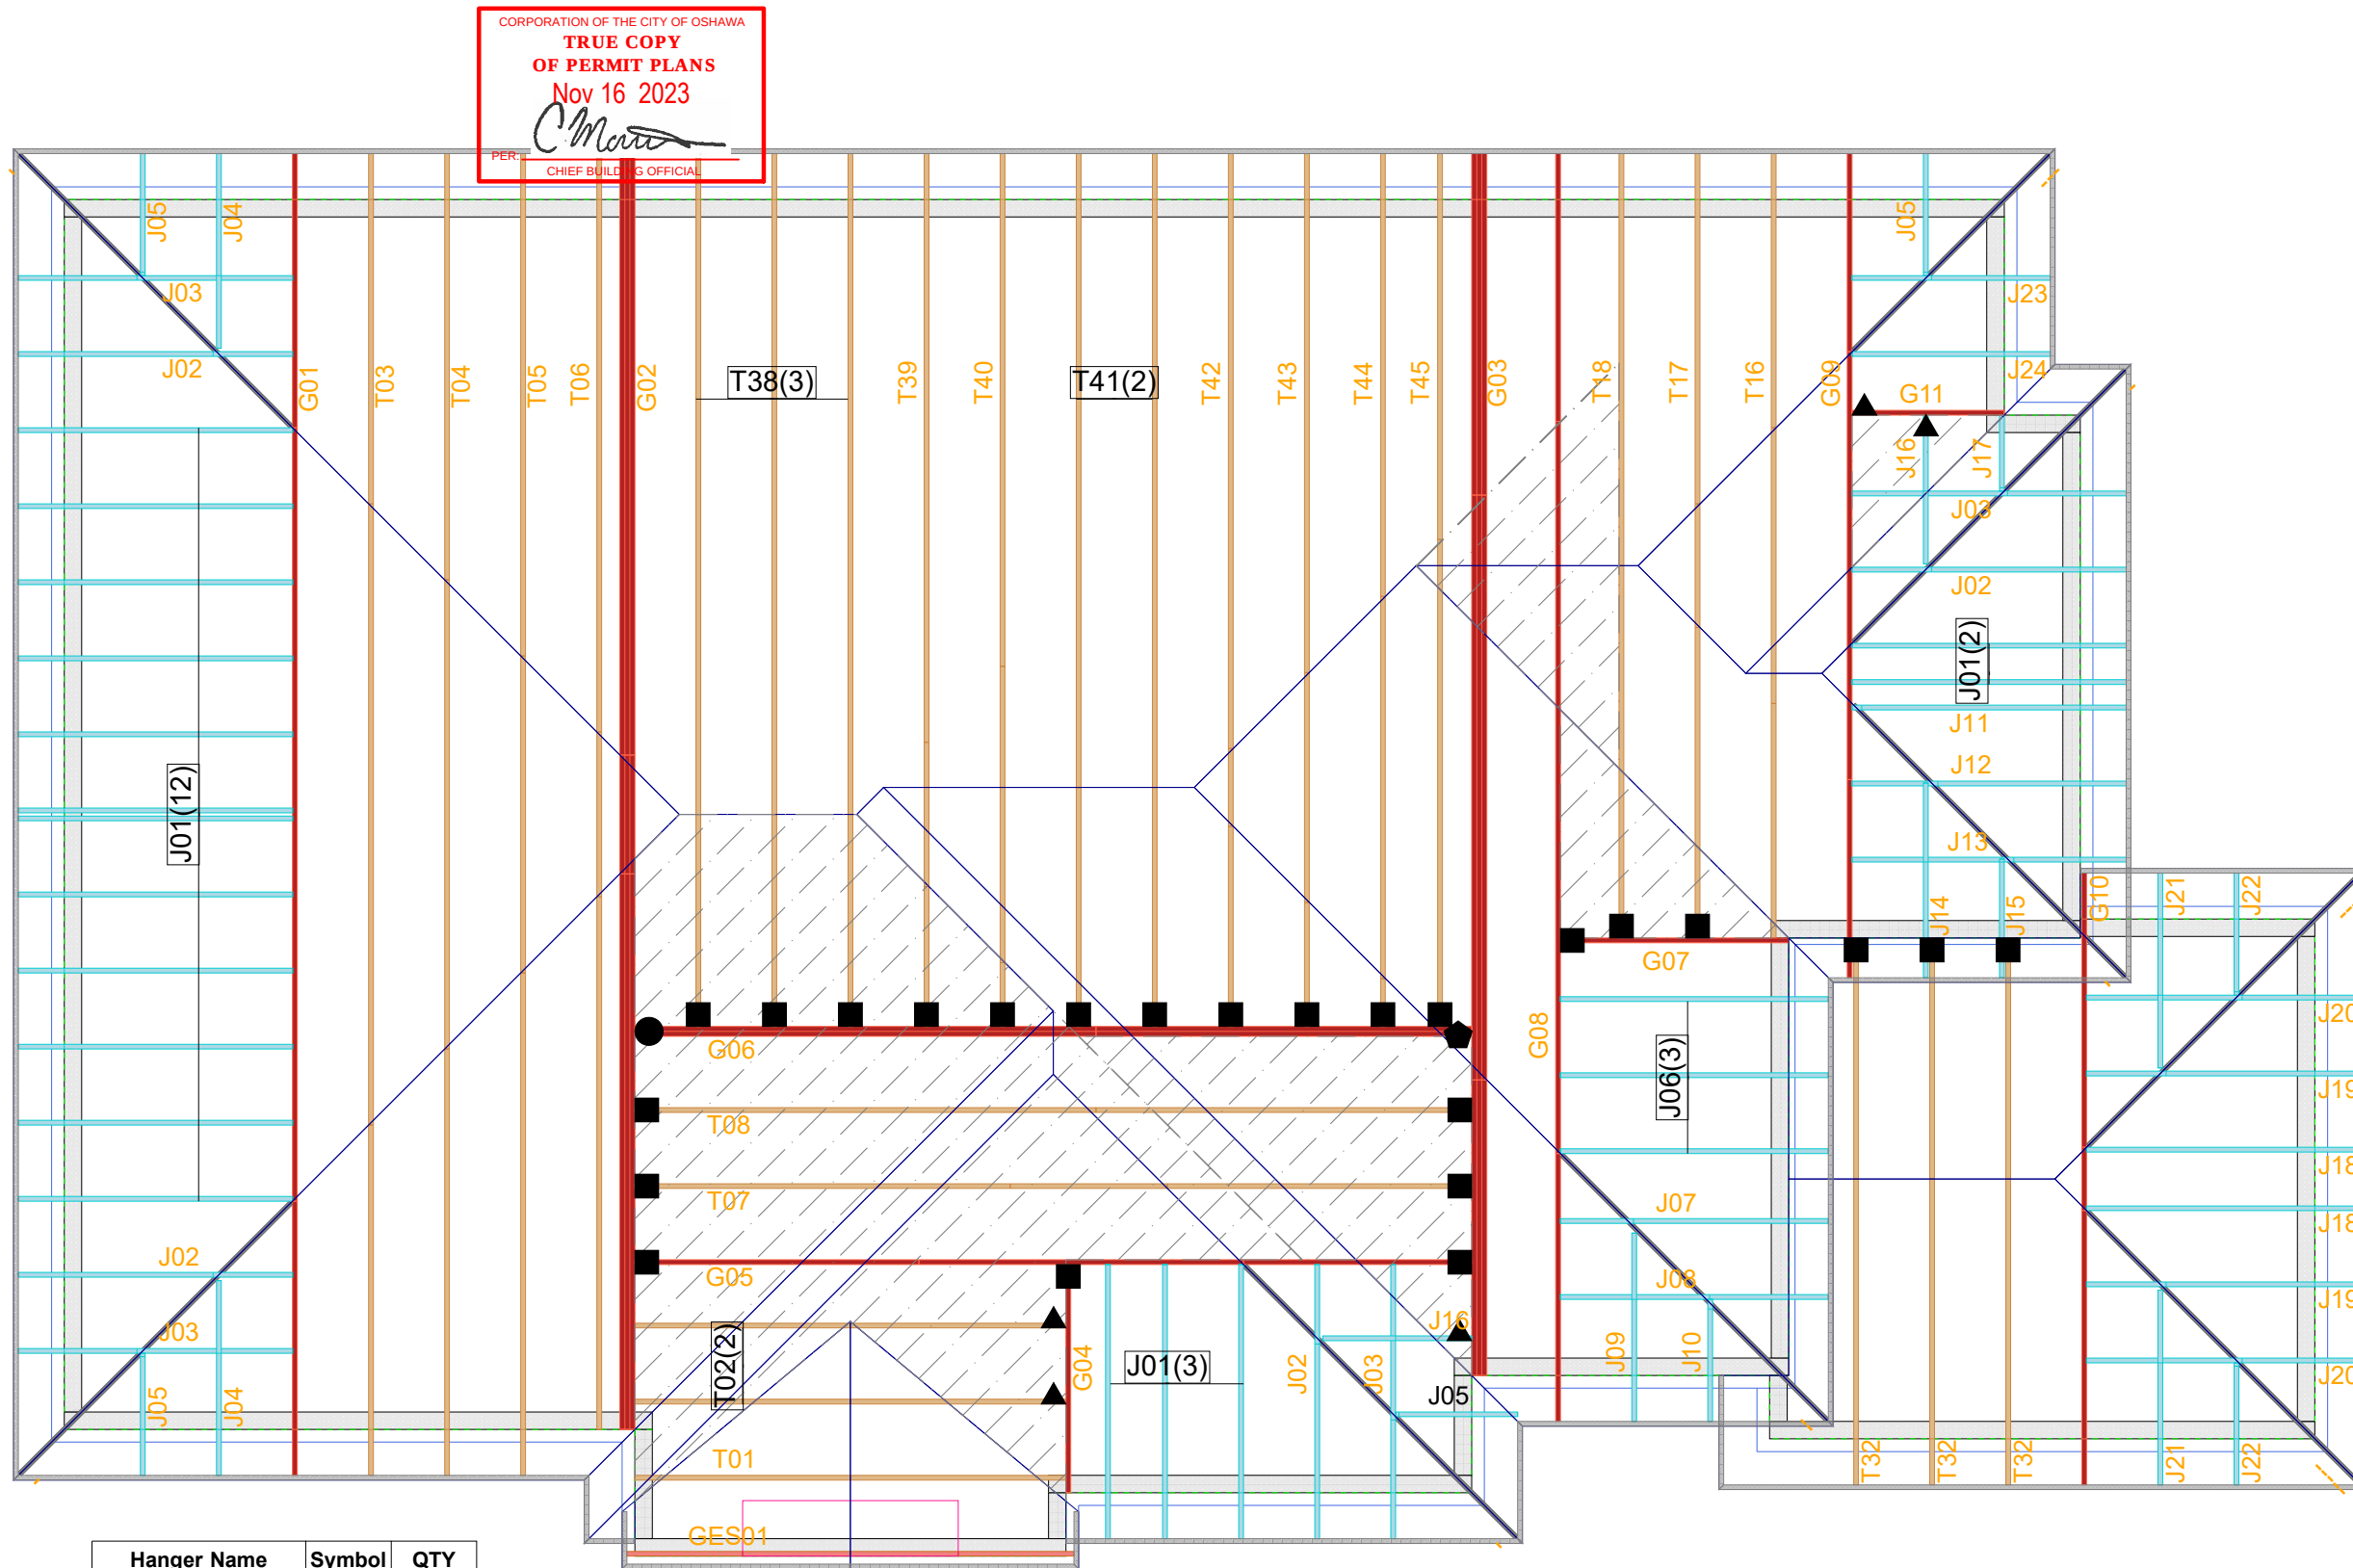

Hanger Name	Symbol	QTY
LUS24	▲	5
LJS26DS	■	24
HGUS48	●	1
HGUS410	◆	1



CONVENTIONAL FRAMING BY OTHERS

ALL CONVENTIONAL FRAMING TO CONFORM WITH PART 9 OF THE OBC. ROOF RAFTERS THAT CROSS OVER TRUSSES TO BE MIN. 2x4 SPF @ 24" C/C WITH A 2x4 VERTICAL POST TO THE TRUSS BELOW. VERTICAL POSTS TO BE Laterally BRACED SO THAT UNBRACED LENGTH DOES NOT EXCEED 6'. DESIGN OF CONVENTIONAL FRAMING IS THE RESPONSIBILITY OF THE PROJECT ENGINEER.

JOB INFORMATION

Customer	GREENPARK HOMES
Job #	23-00097R0
Address	ZADORRA ESTATES OSHAWA, ON
Model	CAROL 12-ELEV 3
Sales Rep	RALPH MIRIGELLO
Designer	RB
Date	5/29/23
Path	C:\MITEK\CA\JOBS\GREENPARK\ZADORRA ESTATES\CAROL 12-ELEV 3\CAROL 12-ELEV 3\

DESIGN INFORMATION

Code	NBCC 2015
Bldg	Residential - HSB (NBCC Part 9)
TC LL	34.8 lb/ft ²
TC DL	6.0 lb/ft ²
BC LL	0.0 lb/ft ²
BC DL	7.3 lb/ft ²
Deflection	LL=L/360 TL=L/360
Spacing	24" O/C unless otherwise noted
Complies With	OBC 2012 (2019 Amendment) CSA O86-14 and TPIC 2014

IMPORTANT INFORMATION

- Hangers and Fasteners to be installed as per manufacturer
- Refer to truss drawings in the Truss Engineering Package for ply-to-ply attachment notes
- For site-framed valleys: top chords of all roof trusses must be laterally supported using 2x4 continuous bracing @24 O/C - all bracing must be anchored at ends as per TPIC Installation Guidelines
- Read all notes on this page in addition to those shown on the KOTT Truss Engineering package
- Field erection, handling and bracing are not the responsibility of KOTT, or KOTT Engineering
- Unless noted otherwise, hurricane ties are to be installed at the bearings of all trusses > 40 ft clear span, and any girder or beam supporting trusses with a clear span >40 ft. See hanger legend for type.
- Unless noted otherwise, for Part 9 bldgs, all trusses are to be anchored to the top of supporting walls as follows: trusses with a clear span <40 ft use 3-1/4" nails @ each bearing; trusses with a clear span >40 ft use 3-1/4" nails @ each bearing in addition to the appropriate hurricane tie.

KOTT Inc.
14 Anderson Blvd.
Uxbridge, ON
905.642.4400



Engineering Notes: Trusses

NE0723-062

**GREENPARK - ZADORRA
ESTATES - CAROL 12-3**

CORPORATION OF THE CITY OF OSHAWA

**TRUE COPY
OF PERMIT PLANS**

Nov 16 2023



CHRIS BULAND-WONG

PLEASE READ ALL INFORMATION BEFORE INSTALLATION OF THE COMPONENT

RESPONSIBILITIES

THE UNDERSIGNED ENGINEER IS ONLY RESPONSIBLE FOR THE STRUCTURAL INTEGRITY OF THIS BUILDING COMPONENT FOR THE CONDITIONS AND LOADS SHOWN ON CALCULATION PAGE. THE STRUCTURAL INTEGRITY OF THE BUILDING AND THE VERIFICATION OF THE DIMENSIONS AND THE DESIGN LOADS USED ARE THE RESPONSIBILITY OF THE BUILDING DESIGNER.

THE UNDERSIGNED ENGINEER DISCLAIMS ANY RESPONSIBILITY FOR DAMAGES AS A RESULT OF FAULTY OR INCORRECT INFORMATION, SPECIFICATION AND/OR DESIGNS FURNISHED TO THE ENGINEER.

IT IS THE RESPONSIBILITY OF KOTT Inc. TO ENSURE THAT TRUSSES ARE MANUFACTURED IN CONFORMANCE WITH THESE DESIGNS AND WITH THE SPECIFICATIONS OUTLINED BELOW. THE UNDERSIGNED ENGINEER IS NOT RESPONSIBLE FOR QUALITY CONTROL IN THE TRUSS MANUFACTURING PLANT.

DESIGN INFORMATION

THIS DESIGN IS FOR AN INDIVIDUAL BUILDING COMPONENT AND HAS BEEN BASED ON INFORMATION PROVIDED BY KOTT DESIGN.

1. THE BUILDING USE AND OCCUPANCY TYPE IS AS INDICATED ON THE DRAWING.
2. GEOMETRY OF THE TRUSS AND DIMENSIONS INDICATED ON THE DRAWING ARE IDENTICAL TO THOSE OF THE INSTALLED TRUSS.
3. THE TRUSS LOADING INTENSITY AND DISTRIBUTION AS WELL AS LOAD TRANSFER MECHANISM IS THAT INDICATED ON THE DRAWING. NO BUILDINGS, TREES, PARAPETS OR OTHER PROJECTIONS HIGHER THAN THE ROOF FOR WHICH THE TRUSSES ARE USED ARE LOCATED WITHIN A DISTANCE LESS THAN TEN (10) TIMES THE DIFFERENCE IN HEIGHT, OR FIVE METERS (16 FT) WHICHEVER IS GREATER, UNLESS THE DRAWING INDICATES THAT THE SNOW DRIFTING HAS BEEN TAKEN INTO ACCOUNT.
4. THE TRUSSES ARE TO BE SUPPORTED AT THE BEARING POINTS INDICATED AND ANCHORED TO THE SUPPORTS WHERE CONSIDERED NECESSARY BY THE DESIGNER OF THE OVERALL STRUCTURE. BEARING SIZES SHOWN ARE THE MINIMUM REQUIRED TO PREVENT CRUSHING OF THE TRUSS MEMBERS AND DO NOT NECESSARILY TAKE INTO ACCOUNT STABILITY OF THE OVERALL BUILDING STRUCTURE. ELEVATION OF BEARINGS MUST BE CAREFULLY CHECKED AND SHIMMED TO ALIGNMENT FOR SOLID BEARINGS. ADEQUATE WOOD TRUSS BEARING IS THE RESPONSIBILITY OF THE BUILDING DESIGNER.

CODE

TRUSSES ARE DESIGNED IN CONFORMANCE WITH THE RELEVANT SECTIONS OF THE NATIONAL BUILDING CODE OF CANADA OR THE CANADIAN CODE FOR FARM BUILDINGS, WHICHEVER APPLIES TO THE BUILDING TYPE INDICATED ON THE DRAWING, THE ONTARIO BUILDING CODE, TPIC AND CANADIAN STANDARDS ASSOCIATION GUIDELINES.

HANDLING, INSTALLATION AND BRACING

1. THE TRUSSES MUST BE HANDLED AND INSTALLED BY A QUALIFIED PROFESSIONAL AS PER THE SUPPLIED DOCUMENT TITLED INFORMATION FOR TRUSS INSTALLERS AND THE BCSI-B1 AND BCSI-B3 SUMMARY SHEETS.
2. THE COMPRESSION CHORDS ARE Laterally Braced by Continuous Rigid Diaphragm Sheathing or as Specified on the Drawing.
3. TEMPORARY AND PERMANENT BRACING MUST BE INSTALLED AS INDICATED ON THE TRUSS DRAWING AND ACCORDING TO THE BCSI-B1 AND BCSI-B3 SUMMARY SHEETS. BRACING FOR THE LATERAL STABILITY OF THE TRUSS IS TO BE PROVIDED BY THE BUILDING DESIGNER.
4. IT IS RECOMMENDED THAT A PROFESSIONAL ENGINEER'S ADVICE BE OBTAINED FOR THE BRACING OF TRUSSES SPANNING MORE THAN 12.37M (40'-7").

JOB NAME	TRUSS NAME	QUANTITY	PLY	JOB DESC.	DRWG NO.
NE0723-063	G01	1	1	GREENPARK - ZADORRA ESTATES - CAROL 12-3	

Version 8.630 S Mar 22 2023 MiTek Industries, Inc. Wed Jul 12 14:08:58 2023 Page 2

CORPORATION OF THE CITY OF ID3KJz3MpdK9HiOi2_Zqr9QzCaP9-I?4d5OD02VuESHn0pxm4pSRyRk02oCRd5?EKJzyyoZ3

**TRUE COPY
OF PERMIT PLANS**

Nov 16 2023

SPECIFIED CONCENTRATED LOADS (LBS)									
JT	LOC.	LC	MAX.	TYPE	HEEL	CONN.			
R	16-0-12	-21	-21	TOTAL	—	C1			
S	14-0-12	-21	-21	TOTAL	—	C1			
U	6-0-12	-21	-21	TOTAL	—	C1			
X	8-0-12	-102	-102	FRONT VERT	—	C1			
Y	10-0-12	-102	-102	FRONT VERT	—	C1			
Z	12-0-12	-102	-102	FRONT VERT	—	C1			
AA	14-0-12	-102	-102	FRONT VERT	—	C1			
AB	18-3-4	-102	-102	FRONT VERT	—	C1			
AC	20-3-4	-102	-102	FRONT VERT	—	C1			
AD	24-3-4	-102	-102	FRONT VERT	—	C1			
AE	2-0-12	-21	-21	FRONT VERT	—	C1			
AF	4-0-12	-21	-21	FRONT VERT	—	C1			
AG	8-0-12	-21	-21	FRONT VERT	—	C1			
AH	10-0-12	-21	-21	FRONT VERT	—	C1			
AI	12-0-12	-21	-21	FRONT VERT	—	C1			
AJ	20-3-4	-21	-21	FRONT VERT	—	C1			
AK	22-3-4	-21	-21	FRONT VERT	—	C1			
AL	24-3-4	-21	-21	FRONT VERT	—	C1			
AM	28-3-4	-21	-21	FRONT VERT	—	C1			
AN	30-3-4	-21	-21	FRONT VERT	—	C1			


CONNECTION REQUIREMENTS

- 1) C1: A SUITABLE HANGER/MECHANICAL CONNECTION IS REQUIRED.



READ ALL NOTES ON THIS PAGE AND ON THE
ENGINEERING NOTES: TRUSSES. THE NOTE PAGE
IS AN INTEGRAL PART OF THIS DRAWING AS IT
CONTAINS SPECIFICATIONS AND CRITERIA USED
IN THE DESIGN OF THIS COMPONENT.

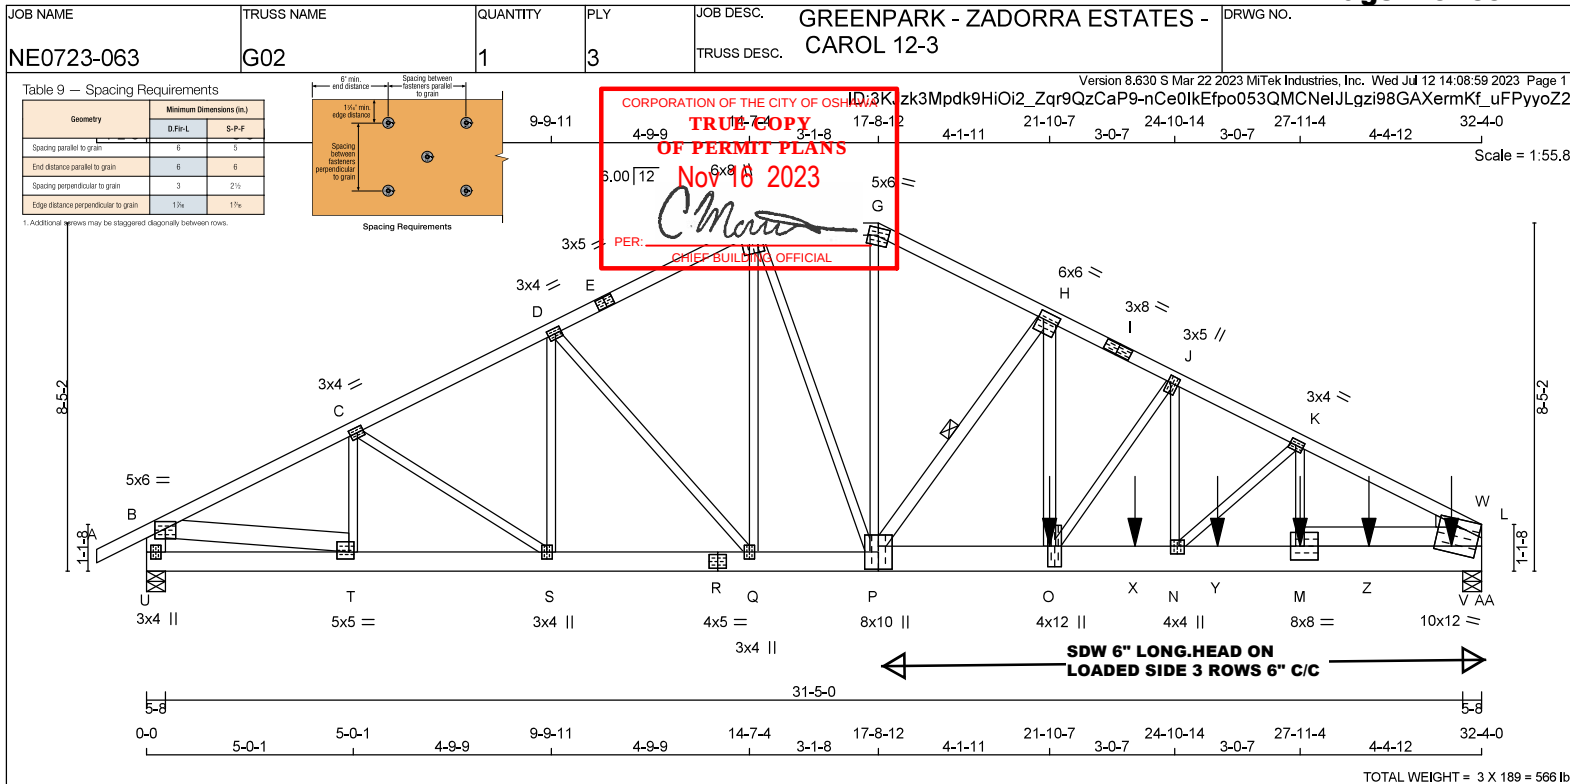

**LUMBER**

N. L. G. A. RULES	SIZE	LUMBER
CHORDS	2x4	No.2
A - E	2x4	DRY
F - G	2x4	DRY
G - I	2x4	DRY
I - L	2x4	DRY
U - B	2x6	DRY
U - R	2x6	DRY
R - P	2x6	DRY
P - L	2x8	DRY

REINFORCING MEMBERS	SIZE	LUMBER
HW2	2x6	DRY
ALL WEBS EXCEPT	2x3	DRY
P - H	2x4	DRY
O - H	2x4	DRY
B - T	2x6	DRY

DRY: SEASONED LUMBER.

DESIGN CONSISTS OF 3 TRUSSES BUILT SEPARATELY THEN FASTENED TOGETHER AS FOLLOWS:

CHORDS #ROWS	SURFACE SPACING (IN)	LOAD (PLF)
TOP CHORDS : (0.122"x3") SPIRAL NAILS		
A-E	12	TOP
E-F	12	TOP
F-G	12	TOP
G-I	12	TOP
I-L	12	TOP
U-B	12	TOP
BOTTOM CHORDS : (0.122"x3") SPIRAL NAILS		
U-R	12	TOP
R-P	12	TOP
P-L	12	TOP

WEBS : (0.122"x3") SPIRAL NAILS

2x3	1	6
2x4	1	6
2x6	2	6

STAGGER NAILS BY HALF THE SURFACE SPACING IN ADJACENT PLIES.

DIMENSIONS, SUPPORTS AND LOADINGS SPECIFIED BY FABRICATOR TO BE VERIFIED BY BUILDING DESIGNER**BEARINGS**

	FACTORED GROSS REACTION	MAXIMUM FACTORED GROSS REACTION	INPUT BRG	REQ'D BRG	HEEL WEDGE
JT	VERT	HORZ	DOWN	HORZ	UPLIFT
U	6436	0	6436	0	0
L	14265	0	14265	0	0

UNFACTORED REACTIONS

	1ST LCASE	MAX./MIN. COMPONENT REACTIONS
JT	COMBINED	SNOW
U	4491	3293 / 0
L	9952	7301 / 0

BEARING MATERIAL TO BE SPF NO.2 OR BETTER AT JOINT(S) U, L

BRACING

TOP CHORD TO BE SHEATHED OR MAX. PURLIN SPACING = 1.92 FT.
MAX. UNBRACED BOTTOM CHORD LENGTH = 10.00 FT OR RIGID CEILING DIRECTLY APPLIED.

ALL PITCH BREAKS AND PERIMETER CORNER JOINTS MUST BE Laterally RESTRAINED.

1 - 2x6 DRY SPF No.2 LATERAL BRACE(S) AT 1/2 LENGTH OF H-P. DBS = 4-0-0 . CBF = 282 LBS.

DBS = DIAGONAL BRACE SPACING (MAX). CBF = CUMULATIVE BRACING FORCE (PER BRACE). FASTEN LATERAL BRACE(S) TO EACH PLY USING (0.122"x3") SPIRAL NAILS : 1 NAIL FOR 2x3 BRACE(S), 2 FOR 1x4, 2x4, 2x5, 3 FOR 2x6, 4 FOR 2x8, 5 FOR 2x10, AND 6 FOR 2x12.

END VERTICAL(S) MUST BE SHEATHED OR HAVE BRACES AS INDICATED IN THE MAX. UNBRACED LENGTH COLUMN OF THE TABLE BELOW

LOADING

TOTAL LOAD CASES: (4)

CHORDS	MAX. FACTORED MEMB. FORCE (LBS)	FACTORED VERT. LOAD (PLF)	MAX. UNBRACED LENGTH (LC)	MAX. FACTORED MEMB. FORCE (LBS)	WEBS	MAX. FACTORED MEMB. FORCE (LBS)
FR-TO					FR-TO	
A-B	0 / 34	-119.4	-119.4 0.05 (1)	10.00	T-C	-1321 / 0
B-C	-10260 / 0	-119.4	-119.4 0.34 (1)	3.56	C-S	0 / 715
C-D	-10941 / 0	-119.4	-119.4 0.35 (1)	3.45	S-D	-338 / 0
D-E	-10763 / 0	-119.4	-119.4 0.35 (1)	3.49	D-Q	-289 / 0
E-F	-10763 / 0	-119.4	-119.4 0.35 (1)	3.49	Q-F	0 / 388
F-G	-11109 / 0	-119.4	-119.4 0.22 (1)	3.49	F-P	0 / 4282
G-H	-12371 / 0	-119.4	-119.4 0.34 (1)	3.25	P-G	0 / 5144
H-I	-19628 / 0	-119.4	-119.4 0.57 (1)	2.31	I-H	-11274 / 0
I-J	-19628 / 0	-119.4	-119.4 0.57 (1)	2.31	O-H	0 / 11909
J-K	-21621 / 0	-119.4	-119.4 0.71 (1)	2.03	O-J	-3087 / 0
K-W	-22063 / 0	-119.4	-119.4 0.87 (1)	1.92	N-J	0 / 3114
W-L	-15783 / 0	-119.4	-119.4 0.40 (1)	2.74	N-K	-503 / 0
U-B	-6349 / 0	0.0	0.0 0.14 (1)	6.90	M-K	0 / 180
U-T	0 / 0	-18.2	-18.2 0.05 (1)	10.00	B-T	0 / 9293
T-S	0 / 9195	-18.2	-18.2 0.41 (1)	10.00	M-W	0 / 13159
S-R	0 / 9788	-18.2	-18.2 0.42 (1)	10.00	V-W	0 / 1283
R-Q	0 / 9788	-18.2	-18.2 0.42 (1)	10.00		
Q-P	0 / 9604	-18.2	-18.2 0.41 (1)	10.00		
P-O	0 / 17578	-18.2	-18.2 0.73 (1)	10.00		
O-X	0 / 19339	-18.2	-18.2 0.82 (1)	10.00		
X-N	0 / 19339	-18.2	-18.2 0.82 (1)	10.00		
N-Y	0 / 19705	-18.2	-18.2 0.84 (1)	10.00		
Y-M	0 / 19705	-18.2	-18.2 0.84 (1)	10.00		
M-Z	0 / 6838	-18.2	-18.2 0.44 (1)	10.00		
Z-AA	0 / 6838	-18.2	-18.2 0.44 (1)	10.00		
AA-V	0 / 6838	-18.2	-18.2 0.44 (1)	10.00		
V-L	0 / 6838	-18.2	-18.2 0.22 (1)	10.00		

SPECIFIED CONCENTRATED LOADS (LBS)

JT	LOC.	LC1	MAX-	MAX+	FACE	DIR.	TYPE	HEEL	CONN.
M	27-11-4	-1689	-1689	—	BACK	VERT	TOTAL	—	C1
O	21-10-7	-6388	-6388	—	BACK	VERT	TOTAL	—	C1
X	23-11-4	-1044	-1044	—	BACK	VERT	TOTAL	—	C1
Y	25-11-4	-1044	-1044	—	BACK	VERT	TOTAL	—	C1
Z	29-7-4	-531	-531	—	BACK	VERT	TOTAL	—	C1
AA	31-7-4	-533	-533	—	BACK	VERT	TOTAL	—	C1

CONNECTION REQUIREMENTS

1) C1: A SUITABLE HANGER/MECHANICAL CONNECTION IS REQUIRED.

DESIGN CRITERIA

*** SPECIAL LOADS ANALYSIS ***
GEOMETRY AND/OR BASIC LOADS CHANGED BY USER.
LOADS WERE DERIVED FROM USER INPUT
NO FURTHER MODIFICATIONS WERE MADE

SPECIFIED LOADS:

TOP CH.	LL =	34.8	PSF
	DL =	6.0	PSF
BOT CH.	LL =	0.0	PSF
	DL =	7.3	PSF
TOTAL LOAD	=	48.1	PSF

SPACING = 24.0 IN. C/C

LOADING IN FLAT SECTION BASED ON A SLOPE OF 2.00/12 MINIMUM

*** NON STANDARD GIRDER ***
ADDTL USER-DEFINED LOADS APPLIED TO ALL LOAD CASES.

THIS TRUSS IS DESIGNED FOR RESIDENTIAL OR SMALL BUILDING REQUIREMENTS OF PART 9, NBCC 2015

THIS DESIGN COMPLIES WITH:
- PART 9 OF BCBC 2018, NBC-2019AE
- PART 9 OF OBC 2012 (2019 AMENDMENT)
- CSA 086-14
- TPIC 2014

(55 % OF 48.1 P.S.F. G.S.L. PLUS 8.4 P.S.F. RAIN LOAD)
EQUALS 34.8 P.S.F. SPECIFIED ROOF LIVE LOAD

ALLOWABLE DEFL.(LL) = L/360 (1.08")
CALCULATED VERT. DEFL.(LL) = L/999 (0.24")
ALLOWABLE DEFL.(TL) = L/360 (1.08")
CALCULATED VERT. DEFL.(TL) = L/949 (0.41")

CSI: TC=0.87/0.97 (K-W:1) , BC=0.84/0.97 (M-N:1) ,
WB=0.92/0.97 (H-P:1) , SS=0.25/1.00 (N-O:1)

DOL LUMBER=1.00 NAIL=1.00 LS BEND=1.10 COMP=1.10
SHEAR=1.10 TENS=1.10

COMPANION LIVE LOAD FACTOR = 1.00

AUTOSOLVE HEELS OFF

TRUSS PLATE MANUFACTURER IS NOT RESPONSIBLE FOR QUALITY CONTROL IN THE TRUSS MANUFACTURING PLANT.

NAIL VALUES
PLATE GRIP(DRY) SHEAR SECTION (PSI) (PLI) (PLI)
MAX MIN MAX MIN MAX MIN
MT20 650 371 1747 788 1987 1873

PLATE PLACEMENT TOL. = 0.250 inches

PLATE ROTATION TOL. = 5.0 Deg.

JSI GRIP= 0.90 (G) (INPUT = 0.90)
JSI METAL = 0.84 (P) (INPUT = 1.00)

CONTINUED ON PAGE 2

READ ALL NOTES ON THIS PAGE AND ON THE ENGINEERING NOTES: TRUSSES. THE NOTE PAGE IS AN INTEGRAL PART OF THIS DRAWING AS IT CONTAINS SPECIFICATIONS AND CRITERIA USED IN THE DESIGN OF THIS COMPONENT.



JOB NAME	TRUSS NAME	QUANTITY	PLY	JOB DESC.	DRWG NO.
NE0723-063	G02	1	3	GREENPARK - ZADORRA ESTATES - CAROL 12-3	

Version 8.630 S Mar 22 2023 MiTek Industries, Inc. Wed Jul 12 14:08:59 2023 Page 2

GIRDER NAILING ASSUMES NAILED HANGERS ARE FASTENED WITH MIN. 3-0 INCH NAILS.

PLATES (table is in inches)

JT	TYPE	PLATES	W	LEN	Y	X
B	TMVW-p	MT20	5.0	6.0	2.00	3.00
C, D, K						
C	TMVW-t	MT20	3.0	4.0	1.50	1.75
E	TS-t	MT20	3.0	5.0		
F	TTWW+m	MT20	6.0	8.0	2.50	2.75
G	TTW-n	MT20	5.0	6.0	2.00	3.00
H	TMVW-l	MT20	6.0	6.0	2.25	1.50
I	TS-t	MT20	3.0	8.0		
J	TMVW-t	MT20	3.0	5.0	2.00	0.75
L	TMBWV1-m	MT20	10.0	12.0	Edge	1.00
M	BMVW-l	MT20	8.0	8.0		
N	BMVW-t	MT20	4.0	4.0	2.25	1.50
O	BMVW-t	MT20	4.0	12.0	6.00	1.75
P	BSWWW-H	MT20	8.0	10.0		
Q	BMVW-t	MT20	3.0	4.0		
R	BS-t	MT20	4.0	5.0		
S	BMVW-t	MT20	3.0	4.0		
T	BMVW-l	MT20	5.0	5.0	2.00	1.50
U	BMV1+p	MT20	3.0	4.0		

Edge - INDICATES REFERENCE CORNER OF PLATE TOUCHES
EDGE OF CHORD.

CONNECTION REQUIREMENTS

1) C1: A SUITABLE HANGER/M

QUIRED.

CORPORATION OF THE CITY OF OSHKOSH

**TRUE COPY
OF PERMIT PLANS**

Nov 16 2023

PER: 
CHIEF BUILDING OFFICIAL



READ ALL NOTES ON THIS PAGE AND ON THE
ENGINEERING NOTES: TRUSSES. THE NOTE PAGE
IS AN INTEGRAL PART OF THIS DRAWING AS IT
CONTAINS SPECIFICATIONS AND CRITERIA USED
IN THE DESIGN OF THIS COMPONENT.




JOB NAME	TRUSS NAME	QUANTITY	PLY	JOB DESC.	GREENPARK - ZADORRA ESTATES -	DRWG NO.
NE0723-063	G03	1	3	TRUSS DESC.	CAROL 12-3	


Table 9 — Spacing Requirements

Geometry	Minimum Dimensions (in.)	
	D-F-L	S-P-F
Spacing parallel to grain	6	5
End distance parallel to grain	6	6
Spacing perpendicular to grain	3	2 1/2
Edge distance perpendicular to grain	1 1/4	1 1/4

1. Additional screws may be staggered diagonally between rows.

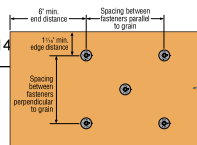

CORPORATION OF THE CITY OF KILKIN
TRUE COPY
OF PERMIT PLANS
Nov 16 2023
 PER: *[Signature]*
CHIEF BUILDING OFFICIAL

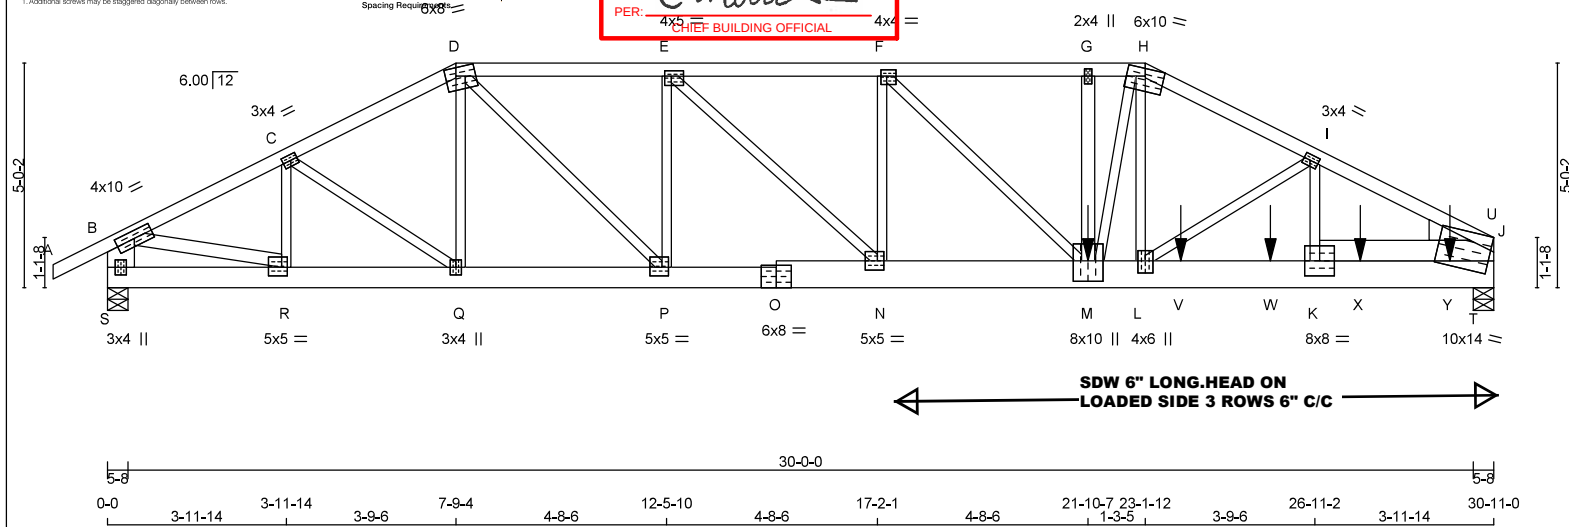

TOTAL WEIGHT = 3 X 165 = 495 lb

LUMBER

N. L. G. A. RULES	SIZE	LUMBER	DESCR.
CHORDS	2x4	No.2	SPF
A - D	2x4	DRY	No.2
D - H	2x4	DRY	No.2
H - J	2x4	DRY	No.2
S - B	2x8	DRY	No.2
S - O	2x6	DRY	No.2
O - J	2x8	DRY	No.2

REINFORCING MEMBERS	SIZE	LUMBER	DESCR.
HW2	2x6	DRY	No.2

ALL WEBS EXCEPT	SIZE	LUMBER	DESCR.
M - G	2x4	DRY	No.2
B - R	2x4	DRY	No.2

DRY: SEASONED LUMBER.

DESIGN CONSISTS OF 3 TRUSSES BUILT SEPARATELY THEN FASTENED TOGETHER AS FOLLOWS:

CHORDS #ROWS	SURFACE SPACING (IN)	LOAD (PLF)
TOP CHORDS : (0.122"x3") SPIRAL NAILS		
A-D 1	12	TOP
D-H 1	12	TOP
H-J 1	12	TOP
S-B 2	12	TOP
BOTTOM CHORDS : (0.122"x3") SPIRAL NAILS		
S-O 2	12	TOP
N-T SDW 6" LONG. 3 ROWS 6" C/C		SIDE(2634.4)
WEBS : (0.122"x3") SPIRAL NAILS		
2x3 1	6	
2x4 1	6	
2x6 2	6	

STAGGER NAILS BY HALF THE SURFACE SPACING IN ADJACENT PLIES.

GIRDER NAILING ASSUMES NAILED HANGERS ARE FASTENED WITH MIN. 3-0 INCH NAILS.

TOP - COMPONENTS ARE LOADED FROM THE TOP AND MUST BE PLACED ON TOP EDGE OF ALL PLIES FOR THE LOAD TO BE TRANSFERRED TO EACH PLY.

DIMENSIONS, SUPPORTS AND LOADINGS SPECIFIED BY FABRICATOR TO BE VERIFIED BY BUILDING DESIGNER

DESIGNER	FACTORED		MAXIMUM FACTORED		INPUT		REQ'D	
	VERT	HORZ	DOWN	HORZ	UP/LIFT	IN-SX	BRG	HEEL
JT	14473	0	14473	0	0	5-8	5-4	2x6 R
S	6096	0	6096	0	0	5-8	2-3	

UNFACTORED REACTIONS

1ST LCASE		MAX./MIN. COMPONENT REACTIONS					
JT	COMBINED	SNOW	LIVE	PERM.LIVE	WIND	DEAD	SOIL
J	10097	7406 / 0	0 / 0	0 / 0	0 / 0	2691 / 0	0 / 0
S	4254	3118 / 0	0 / 0	0 / 0	0 / 0	1135 / 0	0 / 0

BEARING MATERIAL TO BE SPF NO.2 OR BETTER AT JOINT(S) J, S

BRACINGTOP CHORD TO BE SHEATHED OR MAX. PURLIN SPACING = 1.93 FT.
MAX. UNBRACED BOTTOM CHORD LENGTH = 10.00 FT OR RIGID CEILING DIRECTLY APPLIED.

ALL PITCH BREAKS AND PERIMETER CORNER JOINTS MUST BE Laterally RESTRAINED.

LOADING

TOTAL LOAD CASES: (4)

CHORDS		WEBS	
MEMB.	MAX. FACTORED FORCE (LBS)	MEMB.	MAX. FACTORED FORCE (LBS)
FR-TO	FROM TO	FR-TO	FROM TO
A-B	0 / 34	R-C	-1643 / 0
B-C	-9180 / 0	C-Q	0 / 1102
C-D	-10231 / 0	Q-D	-376 / 0
D-E	-13705 / 0	D-P	0 / 6437
E-F	-18010 / 0	P-E	-4685 / 0
F-G	-20907 / 0	E-N	0 / 5937
G-H	-20907 / 0	N-F	-3491 / 0
H-I	-21714 / 0	F-M	0 / 4081
I-U	-22339 / 0	M-G	-96 / 30
U-J	-16081 / 0	M-H	0 / 5200
S-B	-5978 / 0	H-L	0 / 4238
S-R	0 / 0	L-I	-666 / 0
R-Q	0 / 8225	K-I	0 / 232
Q-P	0 / 9119	B-R	0 / 8363
P-O	0 / 13707	T-U	0 / 1134
O-N	0 / 13707	U-K	0 / 13415
N-M	0 / 18010		
M-L	0 / 19504		
L-V	0 / 19957		
V-W	0 / 19957		
W-K	0 / 19957		
K-X	0 / 6909		
X-Y	0 / 6909		
Y-T	0 / 6909		
T-J	0 / 6909		

SPECIFIED CONCENTRATED LOADS (LBS)

JT	LOC.	LC1	MAX-	MAX+	FACE	DIR.	TYPE	HEEL	CONN.
M	21-10-7	-7045	-7045	—	FRONT	VERT	TOTAL	—	C1
V	23-11-4	-1044	-1044	—	FRONT	VERT	TOTAL	—	C1
W	25-11-4	-1044	-1044	—	FRONT	VERT	TOTAL	—	C1
X	27-11-4	-1998	-1998	—	FRONT	VERT	TOTAL	—	C1
Y	29-11-4	-141	-141	—	FRONT	VERT	TOTAL	—	C1

CONNECTION REQUIREMENTS

1) C1: A SUITABLE HANGER/MECHANICAL CONNECTION IS REQUIRED.

DESIGN CRITERIA*** SPECIAL LOADS ANALYSIS ***
GEOMETRY AND/OR BASIC LOADS CHANGED BY USER.
LOADS WERE DERIVED FROM USER INPUT
NO FURTHER MODIFICATIONS WERE MADE**SPECIFIED LOADS:**

TOP CH.	LL =	34.8	PSF
	DL =	6.0	PSF
BOT CH.	LL =	0.0	PSF
	DL =	7.3	PSF
TOTAL LOAD	=	48.1	PSF

SPACING = 24.0 IN. C/C

LOADING IN FLAT SECTION BASED ON A SLOPE OF 2.00/12 MINIMUM

*** NON STANDARD GIRDER ***
ADDTL USER-DEFINED LOADS APPLIED TO ALL LOAD CASES.

THIS TRUSS IS DESIGNED FOR RESIDENTIAL OR SMALL BUILDING REQUIREMENTS OF PART 9, NBCC 2015

THIS DESIGN COMPLIES WITH:
- PART 9 OF BCBC 2018, NBC-2019AE
- PART 9 OF OBC 2012 (2019 AMENDMENT)
- CSA 086-14
- TPIC 2014(55 % OF 48.1 P.S.F. G.S.L. PLUS 8.4 P.S.F. RAIN LOAD)
EQUALS 34.8 P.S.F. SPECIFIED ROOF LIVE LOADALLOWABLE DEFL.(LL) = L/360 (1.03")
CALCULATED VERT. DEFL.(LL) = L/999 (0.27")
ALLOWABLE DEFL.(TL) = L/360 (1.03")
CALCULATED VERT. DEFL.(TL) = L/819 (0.45")CSI: TC=0.81/0.97 (F-G-1), BC=0.87/0.97 (L-M-1),
VB=0.54/0.97 (E-P-1), SI=0.37/1.00 (K-T-1)DOL LUMBER=1.00 NAIL=1.00 LS BEND=1.10 COMP=1.10
SHEAR=1.10 TENS=1.10

COMPANION LIVE LOAD FACTOR = 1.00

AUTOSOLVE RIGHT HEEL ONLY

TRUSS PLATE MANUFACTURER IS NOT RESPONSIBLE FOR QUALITY CONTROL IN THE TRUSS MANUFACTURING PLANT.

NAIL VALUES
PLATE GRIP(DRY) SHEAR SECTION (PSI) (PLI) (PLI)
MAX MIN MAX MIN MAX MIN
MT20 650 371 1747 788 1987 1873

PLATE PLACEMENT TOL. = 0.250 inches

PLATE ROTATION TOL. = 5.0 Deg.

JSI GRIP= 0.90 (R) (INPUT = 0.90)
JSI METAL = 0.99 (h) (INPUT = 1.00)

CONTINUED ON PAGE 2

READ ALL NOTES ON THIS PAGE AND ON THE ENGINEERING NOTES: TRUSSES. THE NOTE PAGE IS AN INTEGRAL PART OF THIS DRAWING AS IT CONTAINS SPECIFICATIONS AND CRITERIA USED IN THE DESIGN OF THIS COMPONENT.



JOB NAME	TRUSS NAME	QUANTITY	PLY	JOB DESC.	DRWG NO.
NE0723-063	G03	1	3	GREENPARK - ZADORRA ESTATES - CAROL 12-3	

Version 8.630 S Mar 22 2023 MiTek Industries, Inc. Wed Jul 12 14:09:00 2023 Page 2

CORPORATION OF THE CITY OF D-3KJzk3mpdk9HiOi2_Zqr9QzCaP9-FOCOW4FHa68xhawOwMpYutVvupXcpGB3wZJjRoryoZ1

PLATES (table is in inches)

JT	TYPE	PLATES	W	LEN	Y	X
B	TMVW-t	MT20	4.0	10.0		
C	TMVW-t	MT20	3.0	4.0	1.50	1.75
D	TTWW-m	MT20	6.0	8.0	2.25	2.75
E	TMVW-t	MT20	4.0	5.0	1.50	1.75
F	TMVW-t	MT20	4.0	4.0	1.75	1.50
G	TMVW-w	MT20	2.0	4.0		
H	TTWW-m	MT20	6.0	10.0	Edge	
I	TMVW-t	MT20	3.0	4.0	1.50	1.75
J	TMBMW1-m	MT20	10.0	14.0	Edge	1.00
K	BMVW-t	MT20	8.0	8.0		
L	BMVW-t	MT20	4.0	6.0	3.25	2.00
M	BMVW-t	MT20	8.0	10.0	5.50	4.00
N	BMVW-t	MT20	5.0	5.0	2.50	1.75
O	BS-t	MT20	6.0	8.0		
P	BMVW-t	MT20	5.0	5.0	2.25	1.75
Q	BMVW-t	MT20	3.0	4.0		
R	BMVW-t	MT20	5.0	5.0	2.25	1.50
S	BMV1+p	MT20	3.0	4.0		

Edge - INDICATES REFERENCE CORNER OF PLATE TOUCHES
EDGE OF CHORD.

**TRUE COPY
OF PERMIT PLANS**
Nov 16 2023
C. Martin
PER: _____
CHIEF BUILDING OFFICIAL




READ ALL NOTES ON THIS PAGE AND ON THE
ENGINEERING NOTES: TRUSSES. THE NOTE PAGE
IS AN INTEGRAL PART OF THIS DRAWING AS IT
CONTAINS SPECIFICATIONS AND CRITERIA USED
IN THE DESIGN OF THIS COMPONENT.



JOB NAME	TRUSS NAME	QUANTITY	PLY	JOB DESC.	GREENPARK - ZADORRA ESTATES -	DRWG NO.
NE0723-063	G04	1	1	TRUSS DESC.	CAROL 12-3	

Version 8.630 S Mar 22 2023 MiTek Industries, Inc. Wed Jul 12 14:09:01 2023 Page 1

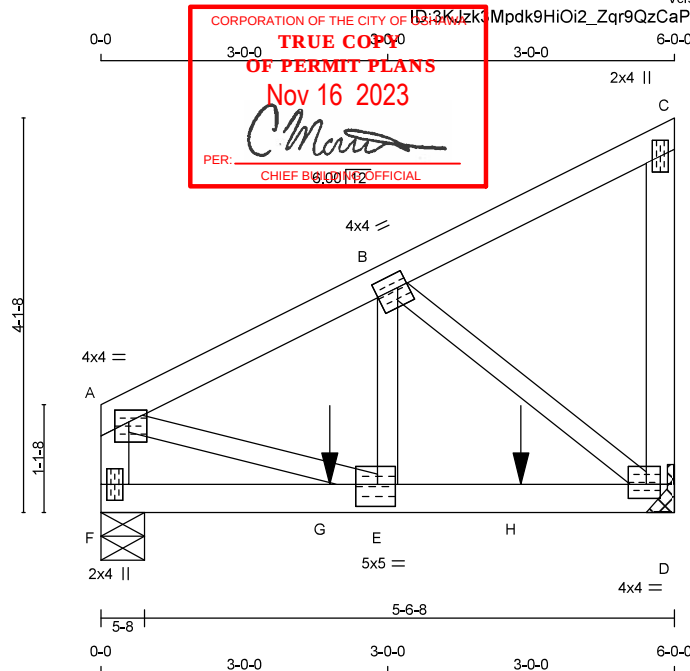

Scale: 1/2"=1'

TOTAL WEIGHT = 26 lb

LUMBER

N. L. G. A. RULES	CHORDS	SIZE	LUMBER	DESCR.
A - C	2x4	DRY	No.2	SPF
D - C	2x4	DRY	No.2	SPF
F - A	2x4	DRY	No.2	SPF
F - D	2x4	DRY	No.2	SPF
ALL WEBS EXCEPT	2x3	DRY	No.2	SPF

DRY: SEASONED LUMBER.

PLATES (table is in inches)

JT	TYPE	PLATES	W	LEN	Y	X
A	TMVW-p	MT20	4.0	4.0	1.50	1.75
B	TMVW-H	MT20	4.0	4.0	1.75	1.25
C	TMV+p	MT20	2.0	4.0		
D	BMVW+4	MT20	4.0	4.0	1.75	1.75
E	BMVW+4	MT20	5.0	5.0	2.75	2.25
F	BMV1+p	MT20	2.0	4.0		

DIMENSIONS, SUPPORTS AND LOADINGS SPECIFIED BY FABRICATOR TO BE VERIFIED BY BUILDING**DESIGNER**

FACTORED	MAXIMUM FACTORED	INPUT	REQD
GROSS REACTION	GROSS REACTION	BRG	BRG
JT VERT	DOWN	UPLIFT	IN-SX
D 1276	0	0	0
F 1074	0	0	0

A SUITABLE HANGER/MECHANICAL CONNECTION IS REQUIRED AT JOINT D. MINIMUM BEARING LENGTH AT JOINT D = 1-8.

UNFACTORED REACTIONS

1ST LCASE		MAX./MIN. COMPONENT REACTIONS					
JT	COMBINED	SNOW	LIVE	PERM.LIVE	WIND	DEAD	SOIL
D	889	655 / 0	0 / 0	0 / 0	0 / 0	234 / 0	0 / 0
F	749	551 / 0	0 / 0	0 / 0	0 / 0	198 / 0	0 / 0

BEARING MATERIAL TO BE SPF NO.2 OR BETTER AT JOINT(S) F

BRACINGTOP CHORD TO BE SHEATHED OR MAX. PURLIN SPACING = 5.48 FT.
MAX. UNBRACED BOTTOM CHORD LENGTH = 10.00 FT. OR RIGID CEILING DIRECTLY APPLIED.

ALL PITCH BREAKS AND PERIMETER CORNER JOINTS MUST BE LATERALLY RESTRAINED.

LOADING

TOTAL LOAD CASES: (4)

CHORDS				WEBS			
MEMB.	MAX. FACTORED FORCE (LBS)	FACTORED VERT. LOAD (PLF)	MAX. UNBRACED LENGTH (LC)	MEMB.	MAX. FACTORED FORCE (LBS)	MAX. UNBRACED LENGTH (LC)	
FR-TO		FROM	TO	FR-TO		FROM	TO
A-B	-1245 / 0	-119.4	-119.4	0.18 (1)	5.48	E-B	0 / 1005
B-C	-16 / 0	-119.4	-119.4	0.16 (1)	6.25	B-D	-1425 / 0
D-C	-144 / 0	0.0	0.0	0.04 (1)	7.81	A-E	0 / 1169
F-A	-1014 / 0	0.0	0.0	0.11 (1)	7.66		
F-G	0 / 0	-18.2	-18.2	0.54 (1)	10.00		
G-E	0 / 0	-18.2	-18.2	0.54 (1)	10.00		
E-H	0 / 1128	-18.2	-18.2	0.79 (1)	10.00		
H-D	0 / 1128	-18.2	-18.2	0.79 (1)	10.00		

SPECIFIED CONCENTRATED LOADS (LBS)

JT	LOC.	LC1	MAX-	MAX+	FACE	DIR.	TYPE	HEEL	CONN.
G	2-4-12	-531	-531		BACK	VERT	TOTAL		C1
H	4-4-12	-531	-531		BACK	VERT	TOTAL		C1

CONNECTION REQUIREMENTS

1) C1: A SUITABLE HANGER/MECHANICAL CONNECTION IS REQUIRED.

DESIGN CRITERIA*** SPECIAL LOADS ANALYSIS ***
GEOMETRY AND/OR BASIC LOADS CHANGED BY USER.
LOADS WERE DERIVED FROM USER INPUT
NO FURTHER MODIFICATIONS WERE MADE**SPECIFIED LOADS:**

TOP CH.	LL = 34.8	PSF
	DL = 6.0	PSF
BOT CH.	LL = 0.0	PSF
	DL = 7.3	PSF
TOTAL LOAD	= 48.1	PSF

SPACING = 24.0 IN. C/C*** NON STANDARD GIRDER ***
ADDTL USER-DEFINED LOADS APPLIED TO ALL LOAD CASES.

THIS TRUSS IS DESIGNED FOR RESIDENTIAL OR SMALL BUILDING REQUIREMENTS OF PART 9, NBC 2015

THIS DESIGN COMPLIES WITH:

- PART 9 OF BCBC 2018, NBC-2019AE
- PART 9 OF OBC 2012 (2019 AMENDMENT)
- CSA 086-14
- TPIC 2014

(55 % OF 48.1 P.S.F. G.S.L. PLUS 8.4 P.S.F. RAIN LOAD)
EQUALS 34.8 P.S.F. SPECIFIED ROOF LIVE LOADALLOWABLE DEFL.(LL)= L/360 (0.20")
CALCULATED VERT. DEFL.(LL) = L/999 (0.04")
ALLOWABLE DEFL.(TL)= L/360 (0.20")
CALCULATED VERT. DEFL.(TL) = L/999 (0.06")CSI: TC=0.18/0.97 (A-B:1) , BC=0.79/0.97 (D-E:1) ,
WB=0.36/0.97 (B-D:1) , SS=0.65/1.00 (E-F:1)DOL LUMBER=1.00 NAIL=1.00 LS BEND=1.00 COMP=1.00
SHEAR=1.00 TENS= 1.00

COMPANION LIVE LOAD FACTOR = 1.00

TRUSS PLATE MANUFACTURER IS NOT RESPONSIBLE FOR QUALITY CONTROL IN THE TRUSS MANUFACTURING PLANT.

NAIL VALUES

PLATE	GRIP(DRY)	SHEAR	SECTION
(PSI)	(PLI)	(PLI)	
MAX MIN	MAX MIN	MAX MIN	MAX MIN
MT20	650 371	1747 788	1987 1873


PLATE PLACEMENT TOL. = 0.250 inches

PLATE ROTATION TOL. = 5.0 Deg.

JSI GRIP= 0.89 (E) (INPUT = 0.90)
JSI METAL= 0.38 (D) (INPUT = 1.00)

READ ALL NOTES ON THIS PAGE AND ON THE ENGINEERING NOTES: TRUSSES. THE NOTE PAGE IS AN INTEGRAL PART OF THIS DRAWING AS IT CONTAINS SPECIFICATIONS AND CRITERIA USED IN THE DESIGN OF THIS COMPONENT.



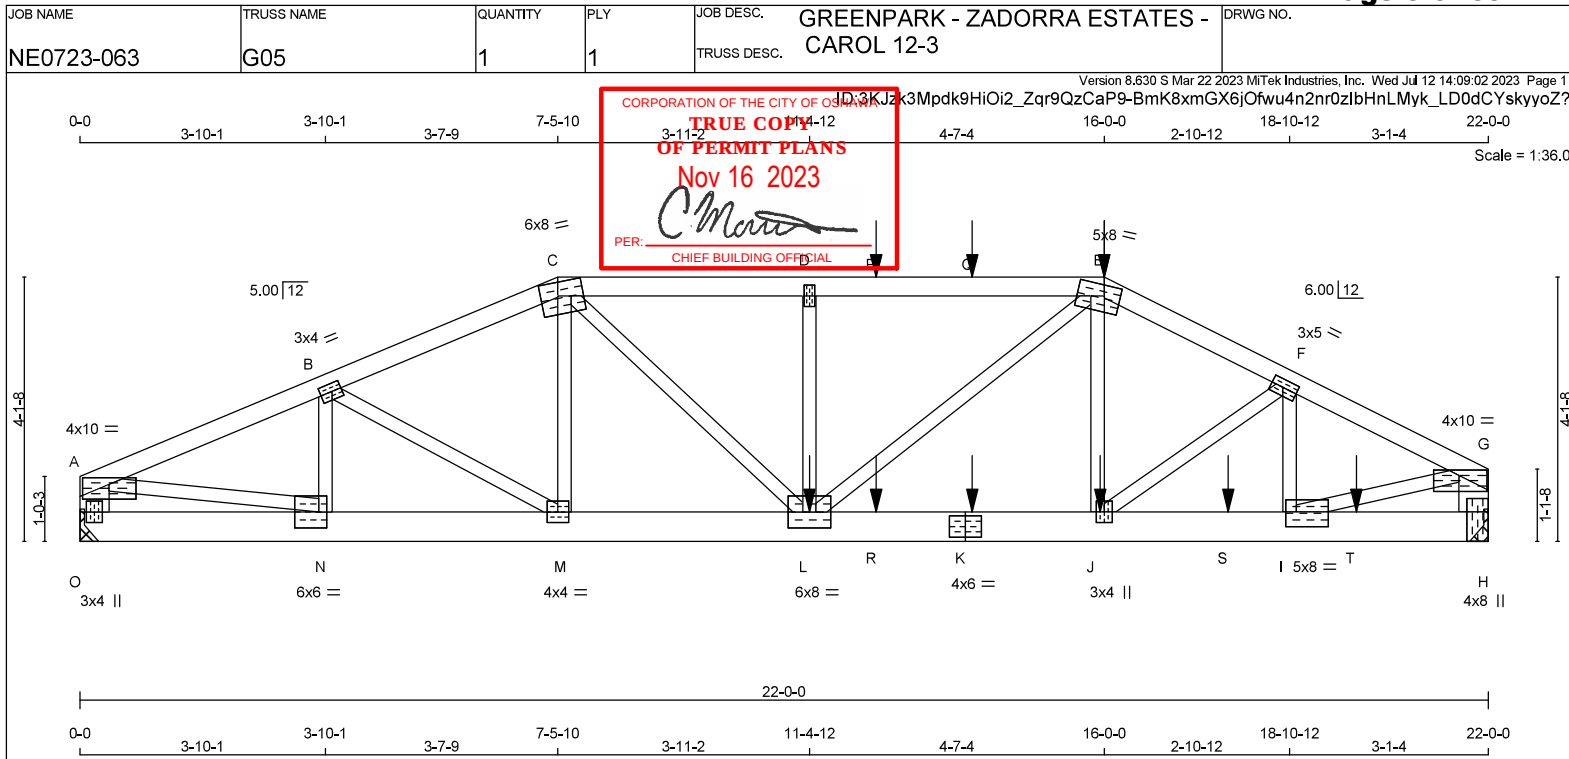

LUMBER

N. L. G. A. RULES

CHORDS	SIZE	LUMBER
A - C	2x4	DRY No.2
C - E	2x4	DRY 2100F 1.8E
E - G	2x4	DRY No.2
H - G	2x6	DRY No.2
O - A	2x6	DRY No.2
O - K	2x6	DRY No.2
K - H	2x6	DRY No.2

ALL WEBS EXCEPT

DRY: SEASONED LUMBER.

PLATES (table is in inches)

JT	TYPE	PLATES	W	LEN	Y	X
A	TMVW-p	MT20	4.0	10.0	1.25	5.00
B	TMVW-l	MT20	3.0	4.0	1.50	1.75
C	TTVW-m	MT20	6.0	8.0	2.50	3.25
D	TMVW-w	MT20	2.0	4.0		
E	TTVW-m	MT20	5.0	8.0	2.00	3.00
F	TMVW-l	MT20	3.0	5.0	1.50	2.25
G	TMVW-p	MT20	4.0	10.0	1.00	5.25
H	BMV1-t	MT20	4.0	8.0	Edge	1.50
I	BMVW-l	MT20	5.0	8.0	2.75	2.00
J	BMVW-t	MT20	3.0	4.0		
K	BS-t	MT20	4.0	6.0		
L	BMVW-w	MT20	6.0	8.0		
M	BMVW-l	MT20	4.0	4.0		
N	BMVW-l	MT20	6.0	6.0	3.00	1.50
O	BMV1-p	MT20	3.0	4.0		

Edge - INDICATES REFERENCE CORNER OF PLATE TOUCHES EDGE OF CHORD.

DIMENSIONS, SUPPORTS AND LOADINGS SPECIFIED BY FABRICATOR TO BE VERIFIED BY BUILDING

DESIGNER

BEARINGS

	FACTORED GROSS REACTION	MAXIMUM FACTORED GROSS REACTION	INPUT BRG	REQD BRG
JT	VERT	HORZ	DOWN	HORZ
O	2441	0	2441	0
H	2881	0	2881	0

A SUITABLE HANGER/MECHANICAL CONNECTION IS REQUIRED AT JOINT O, H. MINIMUM BEARING LENGTH AT JOINT O = 2-10, JOINT H = 3-8.

UNFACTORED REACTIONS

	1ST LOASE	MAX./MIN. COMPONENT REACTIONS
JT	COMBINED	SNOW LIVE PERM. LIVE WIND DEAD SOIL
O	1704	1246 / 0 0 / 0 0 / 0 457 / 0 0 / 0
H	2013	1463 / 0 0 / 0 0 / 0 550 / 0 0 / 0

BRACING

TOP CHORD TO BE SHEATHED OR MAX. PURLIN SPACING = 2.92 FT.
 MAX. UNBRACED BOTTOM CHORD LENGTH = 10.00 FT OR RIGID CEILING DIRECTLY APPLIED.

ALL PITCH BREAKS AND PERIMETER CORNER JOINTS MUST BE Laterally RESTRAINED.

LOADING

TOTAL LOAD CASES: (4)

CHORDS				WEBS			
MEMB.	MAX. FACTORED FORCE (LBS)	FACTORED VERT. LOAD (PLF)	MAX. CSI (LC)	MEMB.	MAX. FACTORED FORCE (LBS)	MAX. CSI (LC)	
FR-TO		FROM	TO	FR-TO			
A-B	-4024 / 0	-119.4	-119.4 0.50 (1)	3.02	N-B	-673 / 0	0.12 (1)
B-C	-4206 / 0	-119.4	-119.4 0.51 (1)	2.92	B-M	0 / 160	0.04 (1)
C-D	-5082 / 0	-119.4	-119.4 0.49 (1)	3.36	M-C	0 / 129	0.03 (1)
D-P	-5082 / 0	-119.4	-119.4 0.59 (1)	3.25	C-L	0 / 1676	0.41 (1)
P-Q	-5082 / 0	-119.4	-119.4 0.59 (1)	3.25	L-D	-833 / 0	0.21 (1)
Q-E	-5082 / 0	-119.4	-119.4 0.59 (1)	3.25	E-D	0 / 1465	0.36 (1)
E-F	-4430 / 0	-119.4	-119.4 0.40 (1)	2.96	J-E	-15 / 119	0.05 (4)
F-G	-3978 / 0	-119.4	-119.4 0.39 (1)	3.14	J-F	0 / 474	0.12 (1)
H-G	-2785 / 0	0.0	0.0 0.20 (1)	6.15	I-F	-902 / 0	0.16 (1)
O-A	-2352 / 0	0.0	0.0 0.16 (1)	6.58	I-G	0 / 3667	0.91 (1)
					A-N	0 / 3778	0.94 (1)
O-N	0 / 0	-18.2	-18.2 0.15 (1)	10.00			
N-M	0 / 3728	-18.2	-18.2 0.64 (1)	10.00			
M-L	0 / 3869	-18.2	-18.2 0.62 (1)	10.00			
L-R	0 / 3945	-18.2	-18.2 0.63 (1)	10.00			
R-K	0 / 3945	-18.2	-18.2 0.63 (1)	10.00			
K-J	0 / 3945	-18.2	-18.2 0.63 (1)	10.00			
J-S	0 / 3568	-18.2	-18.2 0.60 (1)	10.00			
S-I	0 / 3568	-18.2	-18.2 0.60 (1)	10.00			
I-T	0 / 0	-18.2	-18.2 0.13 (1)	10.00			
T-H	0 / 0	-18.2	-18.2 0.13 (1)	10.00			

SPECIFIED CONCENTRATED LOADS (LBS)

JT	LOC.	LC1	MAX-	MAX+	FACE	DIR.	TYPE	HEEL	CONN.
E	16-0-0	-413	-413		FRONT	VERT	TOTAL		C1
J	15-11-4	-21	-21		FRONT	VERT	TOTAL		C1
K	13-11-4	-21	-21		FRONT	VERT	TOTAL		C1
L	11-4-12	-875	-875		FRONT	VERT	TOTAL		C1
P	12-5-4	-102	-102		FRONT	VERT	TOTAL		C1
Q	13-11-4	-102	-102		FRONT	VERT	TOTAL		C1
R	12-5-4	-21	-21		FRONT	VERT	TOTAL		C1
S	17-11-4	-21	-21		FRONT	VERT	TOTAL		C1
T	19-11-4	-21	-21		FRONT	VERT	TOTAL		C1

CONNECTION REQUIREMENTS

1) C1: A SUITABLE HANGER/MECHANICAL CONNECTION IS REQUIRED.

DESIGN CRITERIA

*** SPECIAL LOADS ANALYSIS ***
 GEOMETRY AND/OR BASIC LOADS CHANGED BY USER.
 LOADS WERE DERIVED FROM USER INPUT
 NO FURTHER MODIFICATIONS WERE MADE

SPECIFIED LOADS:

TOT CH.	LL	=	34.8	PSF
	DL	=	6.0	PSF
BOT CH.	LL	=	0.0	PSF
	DL	=	7.3	PSF
TOTAL LOAD	=	48.1	PSF	

SPACING = 24.0 IN. C/C

LOADING IN FLAT SECTION BASED ON A SLOPE OF 2.00/12 MINIMUM

*** NON STANDARD GIRDER ***

ADDTL USER-DEFINED LOADS APPLIED TO ALL LOAD CASES.

THIS TRUSS IS DESIGNED FOR RESIDENTIAL OR SMALL BUILDING REQUIREMENTS OF PART 9, NBCC 2015

THIS DESIGN COMPLIES WITH:

- PART 9 OF BCBC 2018, NBC-2019AE
- PART 9 OF OBC 2012 (2019 AMENDMENT)
- CSA 086-14
- TPIC 2014

(55 % OF 48.1 P.S.F. G.S.L. PLUS 8.4 P.S.F. RAIN LOAD) EQUALS 34.8 P.S.F. SPECIFIED ROOF LIVE LOAD

ALLOWABLE DEFL.(LL) = $L/360$ (0.73")
 CALCULATED VERT. DEFL.(LL) = $L/999$ (0.16")
 ALLOWABLE DEFL.(TL) = $L/360$ (0.73")
 CALCULATED VERT. DEFL.(TL) = $L/984$ (0.27")

CSI: TC=0.59/0.97 (D-E:1), BC=0.64/0.97 (M-N:1), WB=0.94/0.97 (A-N:1), SSI=0.46/1.00 (D-E:1)

DOL LUMBER=1.00 NAIL=1.00 LS BEND=1.00 COMP=1.00 SHEAR=1.00 TENS=1.00

COMPANION LIVE LOAD FACTOR = 1.00

TRUSS PLATE MANUFACTURER IS NOT RESPONSIBLE FOR QUALITY CONTROL IN THE TRUSS MANUFACTURING PLANT.

NAIL VALUES

PLATE	GRIP(DRY)	SHEAR (PSI)	SECTION (PLI)
		MAX MIN	MAX MIN
MT20	650	371 1747	788 1987 1873


PLATE PLACEMENT TOL. = 0.250 inches

PLATE ROTATION TOL. = 5.0 Deg.

JSI GRIP= 0.87 (E) (INPUT = 0.90)
JSI METAL = 0.99 (K) (INPUT = 1.00)

READ ALL NOTES ON THIS PAGE AND ON THE
 ENGINEERING NOTES: TRUSSES. THE NOTE PAGE
 IS AN INTEGRAL PART OF THIS DRAWING AS IT
 CONTAINS SPECIFICATIONS AND CRITERIA USED
 IN THE DESIGN OF THIS COMPONENT.



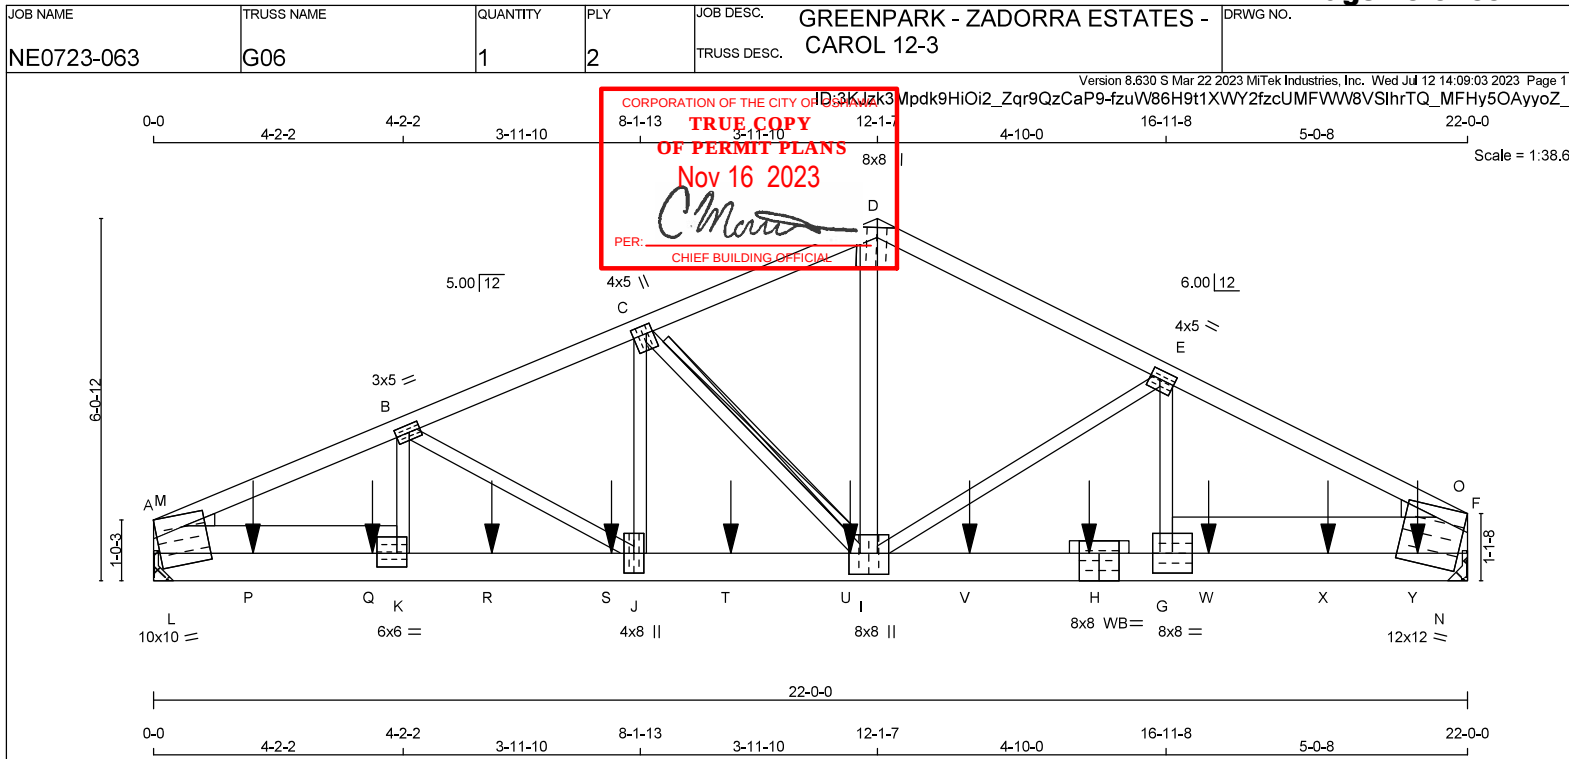

TOTAL WEIGHT = 2 X 113 = 227 lb

LUMBER

N. L. G. A. RULES	CHORDS	SIZE	LUMBER	DESCR.
A - D	2x4	DRY	2100F 1.8E	SPF
D - F	2x4	DRY	2100F 1.8E	SPF
A - H	2x6	DRY	2100F 1.8E	SPF
H - F	2x6	DRY	2100F 1.8E	SPF

REINFORCING MEMBERS	SIZE	DRY	No.2	SPF
HW1	2x8	DRY	No.2	SPF
HW2	2x8	DRY	No.2	SPF

ALL WEBS EXCEPT I - D	2x4	DRY	No.2	SPF
-----------------------	-----	-----	------	-----

DRY: SEASONED LUMBER.

DESIGN CONSISTS OF 2 TRUSSES BUILT SEPARATELY THEN FASTENED TOGETHER AS FOLLOWS:

CHORDS #ROWS	SURFACE SPACING (IN)	LOAD (PLF)
TOP CHORDS : (0.122"x3") SPIRAL NAILS		
A-D 1 12	TOP	
D-F 1 12	TOP	
BOTTOM CHORDS : (0.122"x3") SPIRAL NAILS		
A-H 2 12	SIDE(0.0)	
H-F 2 12	SIDE(0.0)	
WEBS : (0.122"x3") SPIRAL NAILS		
2x3 1 6		
2x4 1 6		
2x6 2 6		
2x8 2 6		

NAILS TO BE DRIVEN FROM ONE SIDE ONLY.

GIRDER NAILING ASSUMES NAILED HANGERS ARE FASTENED WITH MIN. 3-0 INCH NAILS.

TOP - COMPONENTS ARE LOADED FROM THE TOP AND MUST BE PLACED ON TOP EDGE OF ALL PLIES FOR THE LOAD TO BE TRANSFERRED TO EACH PLY.

SIDE - PLF SHOWN IS THE EQUIVALENT UDL APPLIED TO ONE SIDE THAT THE CORRESPONDING NAILING PATTERN SHALL BE CAPABLE OF TRANSFERRING. REMAINING PLF MUST BE APPLIED ON THE OPPOSITE SIDE OR ON THE TOP.

DIMENSIONS, SUPPORTS AND LOADINGS SPECIFIED BY FABRICATOR TO BE VERIFIED BY BUILDING**DESIGNER****BEARINGS**

	FACTORED GROSS REACTION	MAXIMUM FACTORED GROSS REACTION	INPUT BRG	REQD BRG	HEEL WEDGE
JT	VERT	HORZ	DOWN	HORZ	UPLIFT
A	9174	0	9174	0	0
F	10117	0	10117	0	0

A SUITABLE HANGER/MECHANICAL CONNECTION IS REQUIRED AT JOINT A, F. MINIMUM BEARING LENGTH AT JOINT A = 4-0, JOINT F = 4-0.

UNFACTORED REACTIONS

	1ST LOASE	SNOW	LIVE	PERM.LIVE	WIND	DEAD	SOIL
JT	COMBINED						
A	6402	4687 / 0	0 / 0	0 / 0	0 / 0	1715 / 0	0 / 0
F	7060	5169 / 0	0 / 0	0 / 0	0 / 0	1891 / 0	0 / 0

BRACING

TOP CHORD TO BE SHEATHED OR MAX. PURLIN SPACING = 2.92 FT. MAX. UNBRACED BOTTOM CHORD LENGTH = 10.00 FT OR RIGID CEILING DIRECTLY APPLIED.

ALL FITCH BREAKS AND PERIMETER CORNER JOINTS MUST BE Laterally RESTRAINED.

2x4 DRY SPF No.2 T-BRACE AT C-I

FASTEN T AND I-BRACES TO NARROW EDGE OF WEB WITH ONE ROW PER PLY OF 3" COMMON WIRE NAILS @ 6" O.C. WITH 3" MINIMUM END DISTANCE. BRACE MUST COVER 90% OF WEB LENGTH.

LOADING

TOTAL LOAD CASES: (4)

MEMB.	MAX. FACTORED FORCE (LBS)	FACTORED VERT. LOAD (PLF)	MAX. UNBRACED LENGTH (L)	MAX. FACTORED FORCE (LBS)	MAX. UNBRACED LENGTH (L)
FR-TO					
A-M	-11841 / 0	-119.4	-119.4 0.24 (1)	3.41	K-B 0 / 1176 0.15 (1)
M-B	-15204 / 0	-119.4	-119.4 0.40 (1)	2.92	B-J -1762 / 0 0.32 (1)
B-C	-13524 / 0	-119.4	-119.4 0.34 (1)	3.16	J-C 0 / 3625 0.45 (1)
C-D	-10475 / 0	-119.4	-119.4 0.23 (1)	3.66	C-I -4121 / 0 0.62 (1)
D-E	-10579 / 0	-119.4	-119.4 0.34 (1)	3.58	I-D 0 / 8291 0.73 (1)
E-O	-13560 / 0	-119.4	-119.4 0.38 (1)	3.17	I-E -3203 / 0 0.97 (1)
O-F	-12937 / 0	-119.4	-119.4 0.26 (1)	3.26	G-E 0 / 2488 0.31 (1)
					L-M 0 / 2562 0.00 (1)
A-L	0 / 5488	-18.2	-18.2 0.25 (1)	10.00	M-K 0 / 8708 0.57 (1)
L-P	0 / 5488	-18.2	-18.2 0.34 (1)	10.00	N-O 0 / 4082 0.00 (1)
P-Q	0 / 5488	-18.2	-18.2 0.34 (1)	10.00	C-G 0 / 7055 0.38 (1)
Q-K	0 / 5488	-18.2	-18.2 0.34 (1)	10.00	
K-R	0 / 14012	-18.2	-18.2 0.59 (1)	10.00	
R-S	0 / 14012	-18.2	-18.2 0.59 (1)	10.00	
S-J	0 / 14012	-18.2	-18.2 0.59 (1)	10.00	
J-T	0 / 12499	-18.2	-18.2 0.60 (1)	10.00	
T-U	0 / 12499	-18.2	-18.2 0.60 (1)	10.00	
U-I	0 / 12499	-18.2	-18.2 0.60 (1)	10.00	
I-V	0 / 12128	-18.2	-18.2 0.59 (1)	10.00	
V-H	0 / 12128	-18.2	-18.2 0.59 (1)	10.00	
H-G	0 / 12128	-18.2	-18.2 0.59 (1)	10.00	
G-W	0 / 5211	-18.2	-18.2 0.45 (1)	10.00	
W-X	0 / 5211	-18.2	-18.2 0.45 (1)	10.00	
X-Y	0 / 5211	-18.2	-18.2 0.45 (1)	10.00	
Y-N	0 / 5211	-18.2	-18.2 0.45 (1)	10.00	
N-F	0 / 5211	-18.2	-18.2 0.28 (1)	10.00	

SPECIFIED CONCENTRATED LOADS (LBS)

JT	LOC.	LC1	MAX-	MAX+	FACE	DIR.	TYPE	HEEL	CONN.
H	15-8-0	-1031	-1031	—	BACK	VERT	TOTAL	—	C1
P	1-8-0	-1031	-1031	—	BACK	VERT	TOTAL	—	C1
Q	3-8-0	-1031	-1031	—	BACK	VERT	TOTAL	—	C1
R	5-8-0	-1031	-1031	—	BACK	VERT	TOTAL	—	C1
S	7-8-0	-1031	-1031	—	BACK	VERT	TOTAL	—	C1
T	9-8-0	-1031	-1031	—	BACK	VERT	TOTAL	—	C1
U	11-8-0	-1031	-1031	—	BACK	VERT	TOTAL	—	C1
V	13-8-0	-1031	-1031	—	BACK	VERT	TOTAL	—	C1
W	17-8-0	-1031	-1031	—	BACK	VERT	TOTAL	—	C1
X	19-8-0	-1031	-1031	—	BACK	VERT	TOTAL	—	C1
Y	21-2-0	-1032	-1032	—	BACK	VERT	TOTAL	—	C1

CONNECTION REQUIREMENTS

1) C1: A SUITABLE HANGER/MECHANICAL CONNECTION IS REQUIRED.

DESIGN CRITERIA*** SPECIAL LOADS ANALYSIS ***
GEOMETRY AND/OR BASIC LOADS CHANGED BY USER.
LOADS WERE DERIVED FROM USER INPUT
NO FURTHER MODIFICATIONS WERE MADE**SPECIFIED LOADS:**

TOP CH.	LL =	34.8	PSF
	DL =	6.0	PSF
BOT CH.	LL =	0.0	PSF
	DL =	7.3	PSF
TOTAL LOAD	=	48.1	PSF

SPACING = 24.0 IN. C/C

*** NON STANDARD GIRDER ***

ADDTL USER-DEFINED LOADS APPLIED TO ALL LOAD CASES.

THIS TRUSS IS DESIGNED FOR RESIDENTIAL OR SMALL BUILDING REQUIREMENTS OF PART 9, NBC 2015

THIS DESIGN COMPLIES WITH:

- PART 9 OF BCBC 2018, NBC-2019AE
- PART 9 OF OBC 2012 (2019 AMENDMENT)
- CSA 086-14
- TPIC 2014

(55 % OF 48.1 P.S.F. G.S.L. PLUS 8.4 P.S.F. RAIN LOAD) EQUALS 34.8 P.S.F. SPECIFIED ROOF LIVE LOAD

ALLOWABLE DEFL.(LL) = L/360 (0.73")
CALCULATED VERT. DEFL.(LL) = L/999 (0.17")
ALLOWABLE DEFL.(TL) = L/360 (0.73")
CALCULATED VERT. DEFL.(TL) = L/916 (0.29")CSI: TC=0.40/0.97 (B-M-1), BC=0.60/0.97 (I-J-1),
WB=0.97/0.97 (E-I-1), SSI=0.77/1.00 (G-N-1)DOL LUMBER=1.00 NAIL=1.00 LS BEND=1.00 COMP=1.00
SHEAR=1.00 TENS=1.00

COMPANION LIVE LOAD FACTOR = 1.00

TRUSS PLATE MANUFACTURER IS NOT RESPONSIBLE FOR QUALITY CONTROL IN THE TRUSS MANUFACTURING PLANT.

NAIL VALUES

PLATE	GRIP(DRY)	SHEAR	SECTION
	(PSI)	(PLI)	(PLI)
	MAX MIN	MAX MIN	MAX MIN
MT20	650 371	1747 788	1987 1873

PLATE PLACEMENT TOL. = 0.250 inches

PLATE ROTATION TOL. = 5.0 Deg.

JSI GRIP= 0.87 (J) (INPUT = 0.90)
JSI METAL= 0.97 (K) (INPUT = 1.00)

CONTINUED ON PAGE 2



READ ALL NOTES ON THIS PAGE AND ON THE ENGINEERING NOTES: TRUSSES. THE NOTE PAGE IS AN INTEGRAL PART OF THIS DRAWING AS IT CONTAINS SPECIFICATIONS AND CRITERIA USED IN THE DESIGN OF THIS COMPONENT.



JOB NAME	TRUSS NAME	QUANTITY	PLY	JOB DESC.	DRWG NO.
NE0723-063	G06	1	2	GREENPARK - ZADORRA ESTATES - CAROL 12-3	

Version 8.630 S Mar 22 2023 MiTek Industries, Inc. Wed Jul 12 14:09:03 2023 Page 2

PLATES (table is in inches)

JT	TYPE	PLATES	W	LEN	Y	X
A	TMBMW1-m	MT20	10.0	10.0	3.75	Edge
B	TMBWW1	MT20	3.0	5.0	1.50	2.25
C	TMBWW1	MT20	4.0	5.0	1.75	1.25
D	TTW+m	MT20	8.0	8.0	Edge	3.75
E	TMBWW1	MT20	4.0	5.0	1.75	2.00
F	TMBMW1-m	MT20	12.0	12.0	Edge	1.00
G	BMBWW1	MT20	8.0	8.0		
H	BS-t	MT20	8.0	8.0		
I	BMBWW1	MT20	8.0	8.0	4.25	4.00
J	BMBWW1	MT20	4.0	8.0		
K	BMBWW1	MT20	6.0	6.0	2.75	2.00

Edge - INDICATES REFERENCE CORNER OF PLATE TOUCHES
EDGE OF CHORD.

WB - INDICATES BLOCKING REQUIRED


CONNECTION REQUIREMENTS

1) C1: A SUITABLE HANGER/M

REQUIRED.



READ ALL NOTES ON THIS PAGE AND ON THE
ENGINEERING NOTES: TRUSSES. THE NOTE PAGE
IS AN INTEGRAL PART OF THIS DRAWING AS IT
CONTAINS SPECIFICATIONS AND CRITERIA USED
IN THE DESIGN OF THIS COMPONENT.

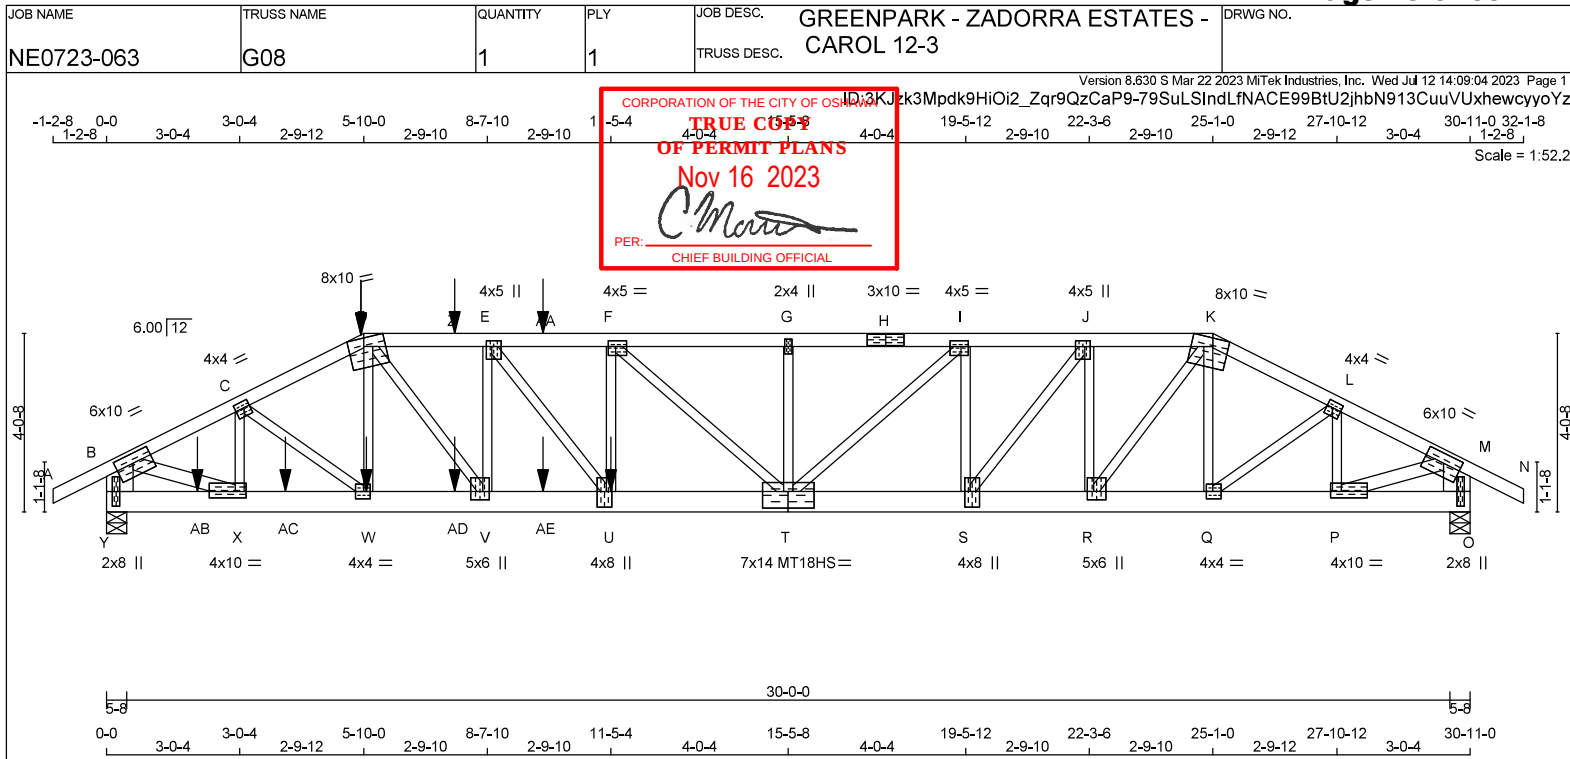

LUMBER

N. L. G. A. RULES	CHORDS	SIZE	LUMBER	DESCR.
A - D	2x4	DRY	No.2	SPF
D - H	2x4	DRY	2100F 1.8E	SPF
H - K	2x4	DRY	2100F 1.8E	SPF
K - N	2x4	DRY	No.2	SPF
Y - B	2x8	DRY	No.2	SPF
O - M	2x8	DRY	No.2	SPF
Y - T	2x8	DRY	2100F 1.8E	SPF
T - O	2x6	DRY	2100F 1.8E	SPF
ALL WEBS	2x3	DRY	No.2	SPF
EXCEPT				
B - X	2x4	DRY	No.2	SPF
P - M	2x4	DRY	No.2	SPF

DRY: SEASONED LUMBER.

PLATES (table is in inches)

JT	TYPE	PLATES	W	LEN	Y	X
B	TMVW-4	MT20	6.0	10.0	2.50	4.75
C	TMVW-4	MT20	4.0	4.0	1.75	1.50
D	TTVW-m	MT20	8.0	10.0	Edge	4.25
E	TMVW-t	MT20	4.0	5.0	1.50	1.50
F	TMVW-4	MT20	4.0	5.0	1.50	2.00
G	TMVW-w	MT20	2.0	4.0		
H	TS-4	MT20	3.0	10.0		
I	TMVW-4	MT20	4.0	5.0	1.50	2.00
J	TMVW-t	MT20	4.0	5.0	1.50	1.50
K	TTVW-m	MT20	8.0	10.0	Edge	4.25
L	TMVW-4	MT20	4.0	4.0	1.75	1.50
O	BMV1-p	MT20	2.0	8.0	4.00	3.75
P	BMVW-4	MT20	4.0	10.0	1.75	3.00
Q	BMVW-4	MT20	4.0	4.0	2.00	1.75
R	BMVW-t	MT20	5.0	6.0	2.25	1.75
S	BMVW-t	MT20	4.0	8.0	4.25	1.50
T	BSVWV-4	MT18HS	7.0	14.0	4.50	7.00
U	BMVW-t	MT20	4.0	8.0	4.25	1.50
V	BMVW-t	MT20	5.0	6.0	2.25	1.75
W	BMVW-4	MT20	4.0	4.0	2.00	1.75
X	BMVW-4	MT20	4.0	10.0	1.75	3.00
Y	BMV1-p	MT20	2.0	8.0	4.00	1.50

DIMENSIONS, SUPPORTS AND LOADINGS SPECIFIED BY FABRICATOR TO BE VERIFIED BY BUILDING

DESIGNER

BEARINGS

	FACTORED GROSS REACTION	MAXIMUM FACTORED GROSS REACTION	INPUT BRG	REQD BRG
JT	VERT	DOWN	UP/LIFT	IN-SX
Y	4239	0	0	5-8
O	3195	0	0	5-8

UNFACTORED REACTIONS

	1ST CASE	MAX./MIN. COMPONENT REACTIONS					
JT	COMBINED	SNOW	LIVE	PERM. LIVE	WIND	DEAD	SOIL
Y	2959	2161 / 0	0 / 0	0 / 0	0 / 0	798 / 0	0 / 0
O	2229	1636 / 0	0 / 0	0 / 0	0 / 0	593 / 0	0 / 0

BEARING MATERIAL TO BE SPF NO.2 OR BETTER AT JOINT(S) Y, O
BEARING SIZE FACTOR = 1.15 AT JNT(S) Y, O (BASED ON SUPPORT DEPTH = 1-8)

BRACING

TOP CHORD TO BE SHEATHED OR MAX. PURLIN SPACING = 1.99 FT.
MAX. UNBRACED BOTTOM CHORD LENGTH = 10.00 FT OR RIGID CEILING DIRECTLY APPLIED.

ALL PITCH BREAKS AND PERIMETER CORNER JOINTS MUST BE Laterally RESTRAINED.

LOADING

TOTAL LOAD CASES: (4)

CHORDS	MAX. FACTORED	FACTORED	VERT. LOAD	LC1	MAX	UNBRACED	WEBS	MAX. FACTORED	MAX
MEMB.	FORCE	FORCE	FORCE	FORCE	FORCE	FORCE	FORCE	FORCE	FORCE
(LBS)	(LBS)	(LBS)	(LBS)	(LBS)	(LBS)	(LBS)	(LBS)	(LBS)	(LBS)
FR-TO		FROM	TO	CS1 (LC)		FR-TO			
A-B	0 / 34	-119.4	-119.4	0.15 (1)	10.00	X-C	-1362 / 0	0.23 (1)	
B-C	-5718 / 0	-119.4	-119.4	0.81 (1)	2.34	C-W	0 / 942	0.23 (1)	
C-D	-6583 / 0	-119.4	-119.4	0.71 (1)	1.99	W-D	-321 / 9	0.08 (1)	
D-Z	-7684 / 0	-119.4	-119.4	0.41 (1)	2.87	D-V	0 / 2998	0.74 (1)	
Z-E	-7684 / 0	-119.4	-119.4	0.41 (1)	2.87	V-E	-2237 / 0	0.56 (1)	
E-AA	-8979 / 0	-119.4	-119.4	0.51 (1)	2.54	E-U	0 / 2132	0.53 (1)	
AA-F	-8979 / 0	-119.4	-119.4	0.51 (1)	2.54	U-F	0 / 88	0.03 (4)	
F-G	-8378 / 0	-119.4	-119.4	0.52 (1)	2.67	F-T	-814 / 0	0.40 (1)	
G-H	-8378 / 0	-119.4	-119.4	0.43 (1)	2.67	T-G	-500 / 0	0.12 (1)	
H-I	-8378 / 0	-119.4	-119.4	0.52 (1)	2.67	T-I	0 / 1828	0.45 (1)	
I-J	-7028 / 0	-119.4	-119.4	0.33 (1)	3.08	S-I	-1643 / 0	0.41 (1)	
J-K	-5770 / 0	-119.4	-119.4	0.25 (1)	3.47	S-J	0 / 2072	0.51 (1)	
K-L	-4760 / 0	-119.4	-119.4	0.43 (1)	2.81	R-J	-1970 / 0	0.49 (1)	
L-M	-4192 / 0	-119.4	-119.4	0.39 (1)	3.05	R-K	0 / 2523	0.62 (1)	
M-N	0 / 34	-119.4	-119.4	0.15 (1)	10.00	Q-K	-172 / 0	0.04 (1)	
Y-B	-4114 / 0	0.0	0.0	0.22 (1)	5.86	Q-L	0 / 606	0.15 (1)	
O-M	-3097 / 0	0.0	0.0	0.17 (1)	6.59	P-L	-1028 / 0	0.18 (1)	
Y-AB	0 / 0	-18.2	-18.2	0.11 (1)	10.00	B-X	0 / 5273	0.93 (1)	
AB-X	0 / 0	-18.2	-18.2	0.11 (1)	10.00	P-M	0 / 3869	0.68 (1)	
X-AC	0 / 5124	-18.2	-18.2	0.38 (1)	10.00				
AC-W	0 / 5124	-18.2	-18.2	0.38 (1)	10.00				
W-AD	0 / 5862	-18.2	-18.2	0.34 (1)	10.00				
AD-V	0 / 5862	-18.2	-18.2	0.34 (1)	10.00				
V-AE	0 / 7685	-18.2	-18.2	0.53 (1)	10.00				
AE-U	0 / 7685	-18.2	-18.2	0.53 (1)	10.00				
U-T	0 / 8979	-18.2	-18.2	0.80 (1)	10.00				
T-S	0 / 7028	-18.2	-18.2	0.42 (1)	10.00				
S-R	0 / 5770	-18.2	-18.2	0.35 (1)	10.00				
R-Q	0 / 4236	-18.2	-18.2	0.25 (1)	10.00				
Q-P	0 / 3760	-18.2	-18.2	0.28 (1)	10.00				
P-O	0 / 0	-18.2	-18.2	0.08 (1)	10.00				

LOC.	LC1	MAX.	MAX+	FACE	DIR.	TYPE	HEEL	CONN.
JT	5-10-0	-381	-381	—	FRONT	VERT	TOTAL	C1
D	11-5-4	-1315	-1315	—	FRONT	VERT	TOTAL	C1
W	5-10-12	-21	-21	—	FRONT	VERT	TOTAL	C1
Z	7-10-12	-102	-102	—	FRONT	VERT	TOTAL	C1
AA	9-10-12	-102	-102	—	FRONT	VERT	TOTAL	C1
AB	2-0-12	-20	-20	—	FRONT	VERT	TOTAL	C1
AC	4-0-12	-21	-21	—	FRONT	VERT	TOTAL	C1
AD	7-10-12	-21	-21	—	FRONT	VERT	TOTAL	C1
AE	9-10-12	-21	-21	—	FRONT	VERT	TOTAL	C1

SPECIFIED CONCENTRATED LOADS (LBS)

JT	LOC.	LC1	MAX.	MAX+	FACE	DIR.	TYPE	HEEL	CONN.
D	5-10-0	-381	-381	—	FRONT	VERT	TOTAL	—	C1
U	11-5-4	-1315	-1315	—	FRONT	VERT	TOTAL	—	C1
W	5-10-12	-21	-21	—	FRONT	VERT	TOTAL	—	C1
Z	7-10-12	-102	-102	—	FRONT	VERT	TOTAL	—	C1
AA	9-10-12	-102	-102	—	FRONT	VERT	TOTAL	—	C1
AB	2-0-12	-20	-20	—	FRONT	VERT	TOTAL	—	C1
AC	4-0-12	-21	-21	—	FRONT	VERT	TOTAL	—	C1
AD	7-10-12	-21	-21	—	FRONT	VERT	TOTAL	—	C1
AE	9-10-12	-21	-21	—	FRONT	VERT	TOTAL	—	C1

CONNECTION REQUIREMENTS

1) C1: A SUITABLE HANGER/MECHANICAL CONNECTION IS REQUIRED.

DESIGN CRITERIA

*** SPECIAL LOADS ANALYSIS ***
GEOMETRY AND/OR BASIC LOADS CHANGED BY USER.
LOADS WERE DERIVED FROM USER INPUT
NO FURTHER MODIFICATIONS WERE MADE

SPECIFIED LOADS:

TOP CH.	LL	=	34.8	PSF
	DL	=	6.0	PSF
BOT CH.	LL	=	0.0	PSF
	DL	=	7.3	PSF
TOTAL	Load	=	48.1	PSF

SPACING = 24.0 IN. C/C

LOADING IN FLAT SECTION BASED ON A SLOPE OF 2.00/12 MINIMUM

*** NON STANDARD GIRDER ***

ADDTL USER-DEFINED LOADS APPLIED TO ALL LOAD CASES.

THIS TRUSS IS DESIGNED FOR RESIDENTIAL OR SMALL BUILDING REQUIREMENTS OF PART 9, NBCC 2015

THIS DESIGN COMPLIES WITH:

- PART 9 OF BCBC 2018, NBC-2019AE
- PART 9 OF OBC 2012 (2019 AMENDMENT)
- CSA 086-14
- TPIC 2014

(55 % OF 48.1 P.S.F. G.S.L. PLUS 8.4 P.S.F. RAIN LOAD)
EQUALS 34.8 P.S.F. SPECIFIED ROOF LIVE LOAD

ALLOWABLE DEFL.(LL) = L/360 (1.03")
CALCULATED VERT. DEFL.(LL) = L/999 (0.36")
ALLOWABLE DEFL.(TL) = L/360 (1.03")
CALCULATED VERT. DEFL.(TL) = L/598 (0.62")

CSI: TC=0.71/0.97 (C-D-1), BC=0.60/0.97 (T-U-1),
WB=0.93/0.97 (B-X-1), SSI=0.27/1.00 (D-E-1)

DOL LUMBER=1.00 NAIL=1.00 LS BEND=1.00 COMP=1.00
SHEAR=1.00 TENS=1.00

COMPANION LIVE LOAD FACTOR = 1.00

AUTOSOLVE HEELS OFF

TRUSS PLATE MANUFACTURER IS NOT RESPONSIBLE FOR QUALITY CONTROL IN THE TRUSS MANUFACTURING PLANT.

NAIL VALUES

PLATE	GRIP(DRY)	SHEAR	SECTION
(PSI)	(PLI)		
MAX	MIN	MAX	MIN
MT20	650	371	1747
MT18HS	586	403	2455
		1382	3163
		3004	

PLATE PLACEMENT TOL. = 0.250 inches

PLATE ROTATION TOL. = 5.0 Deg.

JSI GRIP= 0.90 (V) (INPUT = 0.90)

JSI METAL = 0.96 (D) (INPUT = 1.00)

CONTINUED ON PAGE 2



READ ALL NOTES ON THIS PAGE AND ON THE ENGINEERING NOTES: TRUSSES. THE NOTE PAGE IS AN INTEGRAL PART OF THIS DRAWING AS IT CONTAINS SPECIFICATIONS AND CRITERIA USED IN THE DESIGN OF THIS COMPONENT.




JOB NAME	TRUSS NAME	QUANTITY	PLY	JOB DESC.	DRWG NO.
NE0723-063	G08	1	1	GREENPARK - ZADORRA ESTATES - CAROL 12-3	
Version 8.630 S Mar 22 2023 MiTek Industries, Inc. Wed Jul 12 14:09:05 2023 Page 2					

Edge - INDICATES REFERENCE CORNER OF PLATE TOUCHES
EDGE OF CHORD.



READ ALL NOTES ON THIS PAGE AND ON THE
ENGINEERING NOTES: TRUSSES. THE NOTE PAGE
IS AN INTEGRAL PART OF THIS DRAWING AS IT
CONTAINS SPECIFICATIONS AND CRITERIA USED
IN THE DESIGN OF THIS COMPONENT.



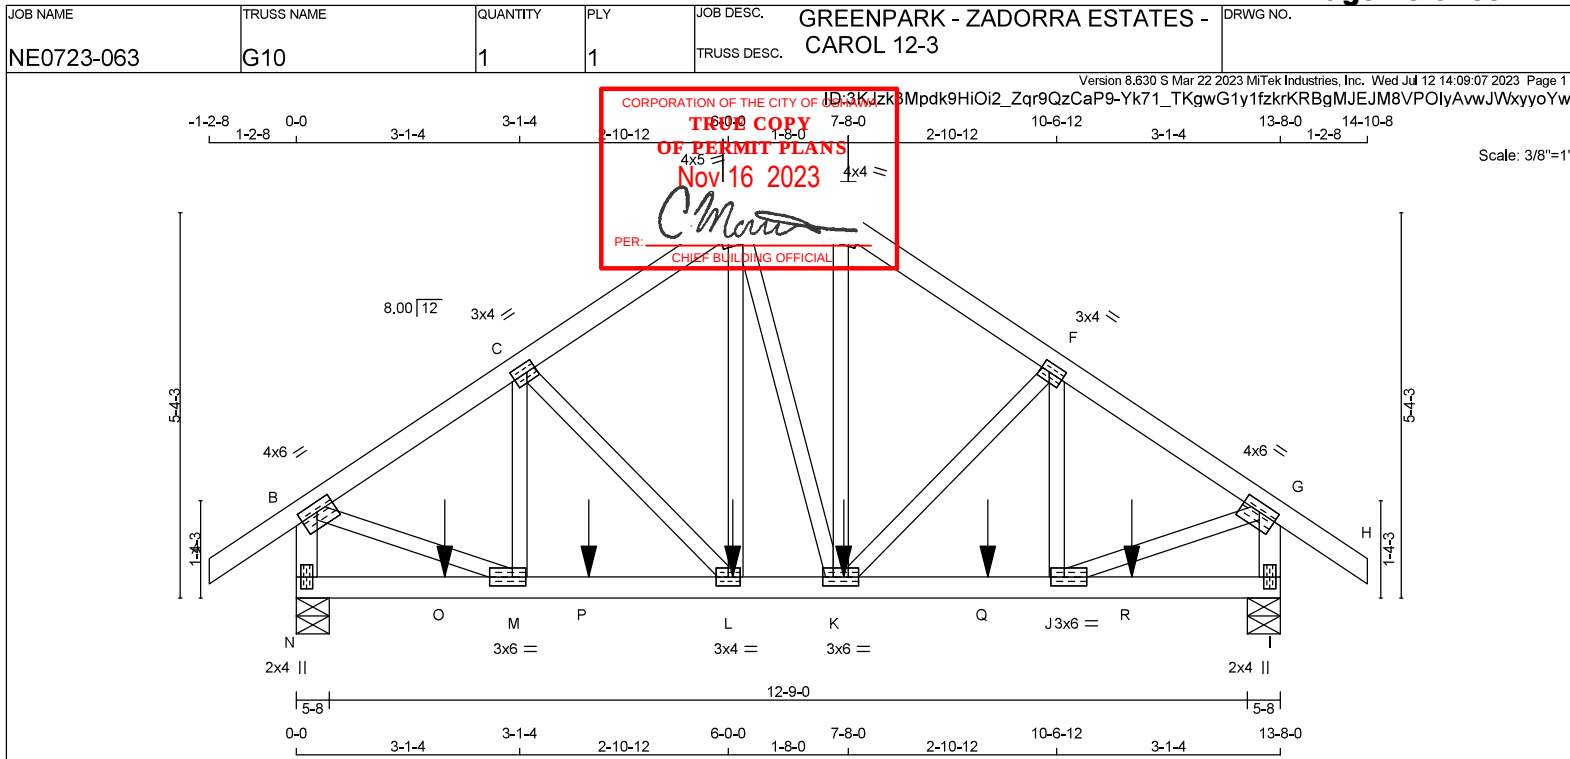

TOTAL WEIGHT = 67 lb

LUMBER

N. L. G. A. RULES	CHORDS	SIZE	LUMBER
A - D	2x4	DRY	No.2
D - E	2x4	DRY	No.2
E - H	2x4	DRY	No.2
N - B	2x4	DRY	No.2
I - G	2x4	DRY	No.2
N - I	2x4	DRY	No.2

ALL WEBS 2x3 DRY No.2 EXCEPT

DRY: SEASONED LUMBER.

PLATES (table is in inches)

JT	TYPE	PLATES	W	LEN	Y	X
B	TMWW4	MT20	4.0	6.0	1.50	3.00
C	TMWW4	MT20	3.0	4.0	1.50	1.50
D	TMWW-m	MT20	4.0	5.0	1.75	1.50
E	TMWW-m	MT20	4.0	4.0	2.00	1.75
F	TMWW4	MT20	3.0	4.0	1.50	1.50
G	TMWW4	MT20	4.0	6.0	1.50	3.00
I	BMV1+p	MT20	2.0	4.0		
J	BMWW4	MT20	3.0	6.0	1.50	2.25
K	BMWW4	MT20	3.0	6.0		
L	BMWW4	MT20	3.0	4.0		
M	BMWW4	MT20	3.0	6.0	1.50	2.25
N	BMV1+p	MT20	2.0	4.0		

DIMENSIONS, SUPPORTS AND LOADINGS SPECIFIED BY FABRICATOR TO BE VERIFIED BY BUILDING**DESIGNER****BEARINGS**

JT	VERT	HORZ	DOWN	HORZ	UPLIFT	IN-SX	IN-SX
N	1783	0	1783	0	0	5-8	2-5
I	1783	0	1783	0	0	5-8	2-5

UNFACTORED REACTIONS

JT	COMBINED	SNOW	LIVE	PERM. LIVE	WIND	DEAD	SOIL
N	1243	914 / 0	0 / 0	0 / 0	0 / 0	329 / 0	0 / 0
I	1243	914 / 0	0 / 0	0 / 0	0 / 0	329 / 0	0 / 0

BEARING MATERIAL TO BE SPF NO.2 OR BETTER AT JOINT(S) N, I

BRACING

TOP CHORD TO BE SHEATHED OR MAX. PURLIN SPACING = 4.78 FT. MAX. UNBRACED BOTTOM CHORD LENGTH = 10.00 FT OR RIGID CEILING DIRECTLY APPLIED.

ALL PITCH BREAKS AND PERIMETER CORNER JOINTS MUST BE Laterally RESTRAINED.

LOADING

TOTAL LOAD CASES: (4)

MEMB.	CHORDS	MAX. FACTORED FORCE (LBS)	FACTORED VERT. LOAD (PLF)	MAX. FACTORED CSI (LC)	MAX. UNBRACED LENGTH	MEMB.	WEBS	MAX. FACTORED FORCE (LBS)	MAX. FACTORED CSI (LC)
FR-TO						FR-TO			
A-B	0 / 43	-119.4	-119.4	0.16 (1)	10.00	M-C	-379 / 0	0.08 (1)	
B-C	-1723 / 0	-119.4	-119.4	0.22 (1)	4.78	C-L	-53 / 0	0.02 (4)	
C-D	-1725 / 0	-119.4	-119.4	0.22 (1)	4.78	L-D	0 / 107	0.04 (4)	
D-E	-1417 / 0	-119.4	-119.4	0.09 (1)	5.34	D-K	0 / 4	0.00 (4)	
E-F	-1726 / 0	-119.4	-119.4	0.22 (1)	4.78	K-E	0 / 112	0.04 (4)	
F-G	-1722 / 0	-119.4	-119.4	0.22 (1)	4.78	K-F	-51 / 0	0.02 (4)	
G-H	0 / 43	-119.4	-119.4	0.16 (1)	10.00	J-F	-382 / 0	0.08 (1)	
H-B	-1750 / 0	0.0	0.0	0.20 (1)	6.18	B-M	0 / 1528	0.38 (1)	
I-G	-1749 / 0	0.0	0.0	0.20 (1)	6.18	J-G	0 / 1528	0.38 (1)	
N-O	0 / 0	-18.2	-18.2	0.07 (4)	10.00				
O-M	0 / 0	-18.2	-18.2	0.07 (4)	10.00				
M-P	0 / 1451	-18.2	-18.2	0.29 (1)	10.00				
P-L	0 / 1451	-18.2	-18.2	0.29 (1)	10.00				
L-K	0 / 1416	-18.2	-18.2	0.26 (1)	10.00				
K-Q	0 / 1450	-18.2	-18.2	0.29 (1)	10.00				
Q-J	0 / 1450	-18.2	-18.2	0.29 (1)	10.00				
J-R	0 / 0	-18.2	-18.2	0.07 (4)	10.00				
R-I	0 / 0	-18.2	-18.2	0.07 (4)	10.00				

SPECIFIED CONCENTRATED LOADS (LBS)

JT	LOC.	LC1	MAX-	MAX+	FACE	DIR.	TYPE	HEEL	CONN.
D	6-0-0	-415	-415		BACK	VERT	TOTAL		C1
E	7-8-0	-415	-415		BACK	VERT	TOTAL		C1
K	7-7-4	-22	-22		BACK	VERT	TOTAL		C1
L	6-0-12	-22	-22		BACK	VERT	TOTAL		C1
O	2-0-12	-22	-22		BACK	VERT	TOTAL		C1
P	4-0-12	-22	-22		BACK	VERT	TOTAL		C1
Q	9-7-4	-22	-22		BACK	VERT	TOTAL		C1
R	11-7-4	-22	-22		BACK	VERT	TOTAL		C1

CONNECTION REQUIREMENTS

1) C1: A SUITABLE HANGER/MECHANICAL CONNECTION IS REQUIRED.

DESIGN CRITERIA

*** SPECIAL LOADS ANALYSIS ***
 GEOMETRY AND/OR BASIC LOADS CHANGED BY USER.
 LOADS WERE DERIVED FROM USER INPUT
 NO FURTHER MODIFICATIONS WERE MADE

SPECIFIED LOADS:

TOP CH.	LL	=	34.8	PSF
	DL	=	6.0	PSF
BOT CH.	LL	=	0.0	PSF
	DL	=	7.3	PSF
TOTAL LOAD	=	48.1	PSF	

SPACING = 24.0 IN. C/C

LOADING IN FLAT SECTION BASED ON A SLOPE OF 2.00/12 MINIMUM

*** NON STANDARD GIRDER ***

ADDTL USER-DEFINED LOADS APPLIED TO ALL LOAD CASES.

THIS TRUSS IS DESIGNED FOR RESIDENTIAL OR SMALL BUILDING REQUIREMENTS OF PART 9, NBCC 2015

THIS DESIGN COMPLIES WITH:

- PART 9 OF BCBC 2018, NBC-2019AE
- PART 9 OF OBC 2012 (2019 AMENDMENT)
- CSA 086-14
- TPIC 2014

(55 % OF 48.1 P.S.F. G.S.L. PLUS 8.4 P.S.F. RAIN LOAD) EQUALS 34.8 P.S.F. SPECIFIED ROOF LIVE LOAD

ALLOWABLE DEFL.(LL) = L/360 (0.46")
 CALCULATED VERT. DEFL.(LL) = L/999 (0.03")
 ALLOWABLE DEFL.(TL) = L/360 (0.46")
 CALCULATED VERT. DEFL.(TL) = L/999 (0.05")

CSI: TC=0.22/0.97 (B-C-1), BC=0.29/0.97 (L-M-1),
 WB=0.38/0.97 (B-M-1), SSI=0.16/1.00 (B-C-1)

DOL LUMBER=1.00 NAIL=1.00 LS BEND=1.00 COMP=1.00 SHEAR=1.00 TENS=1.00

COMPANION LIVE LOAD FACTOR = 1.00

TRUSS PLATE MANUFACTURER IS NOT RESPONSIBLE FOR QUALITY CONTROL IN THE TRUSS MANUFACTURING PLANT.

NAIL VALUES

PLATE	GRIP(DRY)	SHEAR	SECTION
(PSI)	(PLI)	(PLI)	(PLI)
MAX MIN	MAX MIN	MAX MIN	MAX MIN
MT20	650 371	1747 788	1987 1873

PLATE PLACEMENT TOL. = 0.250 inches

PLATE ROTATION TOL. = 5.0 Deg.

JSI GRIP= 0.90 (M) (INPUT = 0.90)
 JSI METAL = 0.45 (B) (INPUT = 1.00)




READ ALL NOTES ON THIS PAGE AND ON THE
 ENGINEERING NOTES: TRUSSES. THE NOTE PAGE
 IS AN INTEGRAL PART OF THIS DRAWING AS IT
 CONTAINS SPECIFICATIONS AND CRITERIA USED
 IN THE DESIGN OF THIS COMPONENT.



JOB NAME	TRUSS NAME	QUANTITY	PLY	JOB DESC.	GREENPARK - ZADORRA ESTATES -	DRWG NO.
NE0723-063	G11	1	1	TRUSS DESC.	CAROL 12-3	

Version 8.630 S Mar 22 2023 MiTek Industries, Inc. Wed Jul 12 14:09:08 2023 Page 1

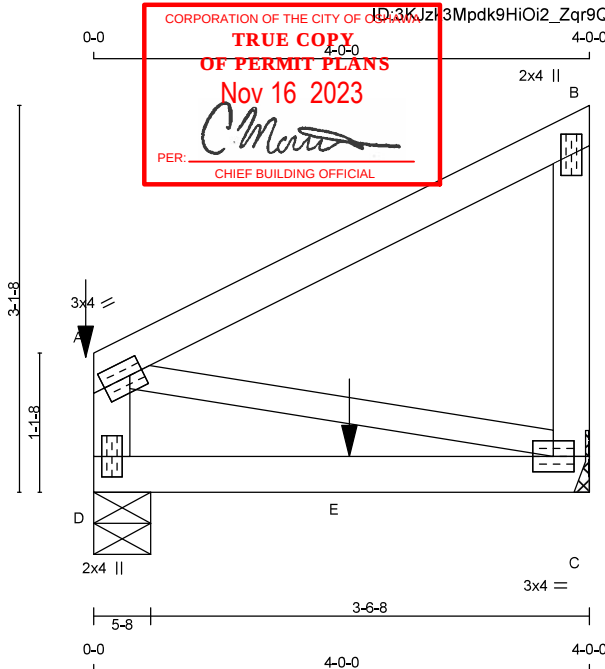

Scale = 1:18.6

TOTAL WEIGHT = 16 lb

LUMBER

N. L. G. A. RULES	CHORDS	SIZE	LUMBER
A - B	2x4	DRY	No.2
C - B	2x4	DRY	No.2
D - A	2x4	DRY	No.2
D - C	2x4	DRY	No.2
ALL WEBS	2x3	DRY	No.2
DRY: SEASONED LUMBER.			

DESIGNER

SPF
SPF
SPF
SPF

PLATES (table is in inches)

JT	TYPE	PLATES	W	LEN	Y	X
A	TMVW4	MT20	3.0	4.0	1.50	1.25
B	TMV+p	MT20	2.0	4.0		
C	BMVW1-t	MT20	3.0	4.0		
D	BMV1+p	MT20	2.0	4.0		

DIMENSIONS, SUPPORTS AND LOADINGS SPECIFIED BY FABRICATOR TO BE VERIFIED BY BUILDING**DESIGNER**

JT	VERT	HORZ	DOWN	HORZ	UPLIFT	IN-SX	IN-SX
C	382	0	382	0	0	MECHANICAL	
D	454	0	454	0	0	5-8	1-8

A SUITABLE HANGER/MECHANICAL CONNECTION IS REQUIRED AT JOINT C. MINIMUM BEARING LENGTH AT JOINT C = 1-8.

UNFACTORED REACTIONS

JT	1ST CASE	MAX. MIN. COMPONENT REACTIONS
C	265	201 / 0
D	317	233 / 0

BEARING MATERIAL TO BE SPF NO.2 OR BETTER AT JOINT(S) D

BRACINGTOP CHORD TO BE SHEATHED OR MAX. PURLIN SPACING = 10.00 FT.
MAX. UNBRACED BOTTOM CHORD LENGTH = 10.00 FT. OR RIGID CEILING DIRECTLY APPLIED.

ALL PITCH BREAKS AND PERIMETER CORNER JOINTS MUST BE LATERALLY RESTRAINED.

LOADING

TOTAL LOAD CASES: (4)

CHORDS				WEBS			
MEMB.	MAX. FACTORED FORCE (LBS)	FACTORED VERT. LOAD (PLF)	MAX. UNBRACED LENGTH (LC)	MEMB.	MAX. FACTORED FORCE (LBS)	MAX. UNBRACED LENGTH (LC)	
FR-TO		FROM TO		FR-TO			
A-B	0 / 0	-119.4	-119.4 0.36 (1)	A-C	0 / 0	0.00 (1)	
C-B	-239 / 0	0.0	0.0 0.04 (1)				
D-A	-317 / 0	0.0	0.0 0.04 (1)				
D-E	0 / 0	-18.2	-18.2 0.36 (1)			10.00	
E-C	0 / 0	-18.2	-18.2 0.36 (1)			10.00	

SPECIFIED CONCENTRATED LOADS (LBS)

JT	LOC.	LC1	MAX-	MAX+	FACE	DIR.	TYPE	HEEL	CONN.
A	0-0	-56	-56	—	TOP	VERT	TOTAL	—	C1
E	2-0-12	-141	-141	—	BACK	VERT	TOTAL	—	C1

CONNECTION REQUIREMENTS

1) C1: A SUITABLE HANGER/MECHANICAL CONNECTION IS REQUIRED.

DESIGN CRITERIA*** SPECIAL LOADS ANALYSIS ***
GEOMETRY AND/OR BASIC LOADS CHANGED BY USER.
LOADS WERE DERIVED FROM USER INPUT
NO FURTHER MODIFICATIONS WERE MADE**SPECIFIED LOADS:**

TOP CH.	LL	=	34.8	PSF
	DL	=	6.0	PSF
BOT CH.	LL	=	0.0	PSF
	DL	=	7.3	PSF
TOTAL LOAD	=	48.1	PSF	

SPACING = 24.0 IN. C/C*** NON STANDARD GIRDER ***
ADDTL USER-DEFINED LOADS APPLIED TO ALL LOAD CASES.

THIS TRUSS IS DESIGNED FOR RESIDENTIAL OR SMALL BUILDING REQUIREMENTS OF PART 9, NBC 2015

THIS DESIGN COMPLIES WITH:

- PART 9 OF BCBC 2018, NBC-2019AE
- PART 9 OF OBC 2012 (2019 AMENDMENT)
- CSA 086-14
- TPIC 2014

(55 % OF 48.1 P.S.F. G.S.L. PLUS 8.4 P.S.F. RAIN LOAD)
EQUALS 34.8 P.S.F. SPECIFIED ROOF LIVE LOADALLOWABLE DEFL.(LL)= L/360 (0.19")
CALCULATED VERT. DEFL.(LL) = L/999 (0.04")
ALLOWABLE DEFL.(TL)= L/360 (0.19")
CALCULATED VERT. DEFL.(TL) = L/708 (0.07")CSI: TC=0.36/0.97 (A-B:1) , BC=0.36/0.97 (C-D:1) ,
WB=0.00/0.97 (A-C:1) , SSI=0.18/1.00 (A-B:1)DOL LUMBER=1.00 NAIL=1.00 LS BEND=1.00 COMP=1.00
SHEAR=1.00 TENS= 1.00

COMPANION LIVE LOAD FACTOR = 1.00

TRUSS PLATE MANUFACTURER IS NOT RESPONSIBLE FOR QUALITY CONTROL IN THE TRUSS MANUFACTURING PLANT.

NAIL VALUES

PLATE	GRIP(DRY)	SHEAR	SECTION
	(PSI)	(PLI)	(PLI)
MT20	650	371	1747
	788	1987	1873


PLATE PLACEMENT TOL. = 0.250 inches

PLATE ROTATION TOL. = 5.0 Deg.

JSI GRIP= 0.28 (A) (INPUT = 0.90)
JSI METAL= 0.10 (B) (INPUT = 1.00)

READ ALL NOTES ON THIS PAGE AND ON THE ENGINEERING NOTES: TRUSSES. THE NOTE PAGE IS AN INTEGRAL PART OF THIS DRAWING AS IT CONTAINS SPECIFICATIONS AND CRITERIA USED IN THE DESIGN OF THIS COMPONENT.



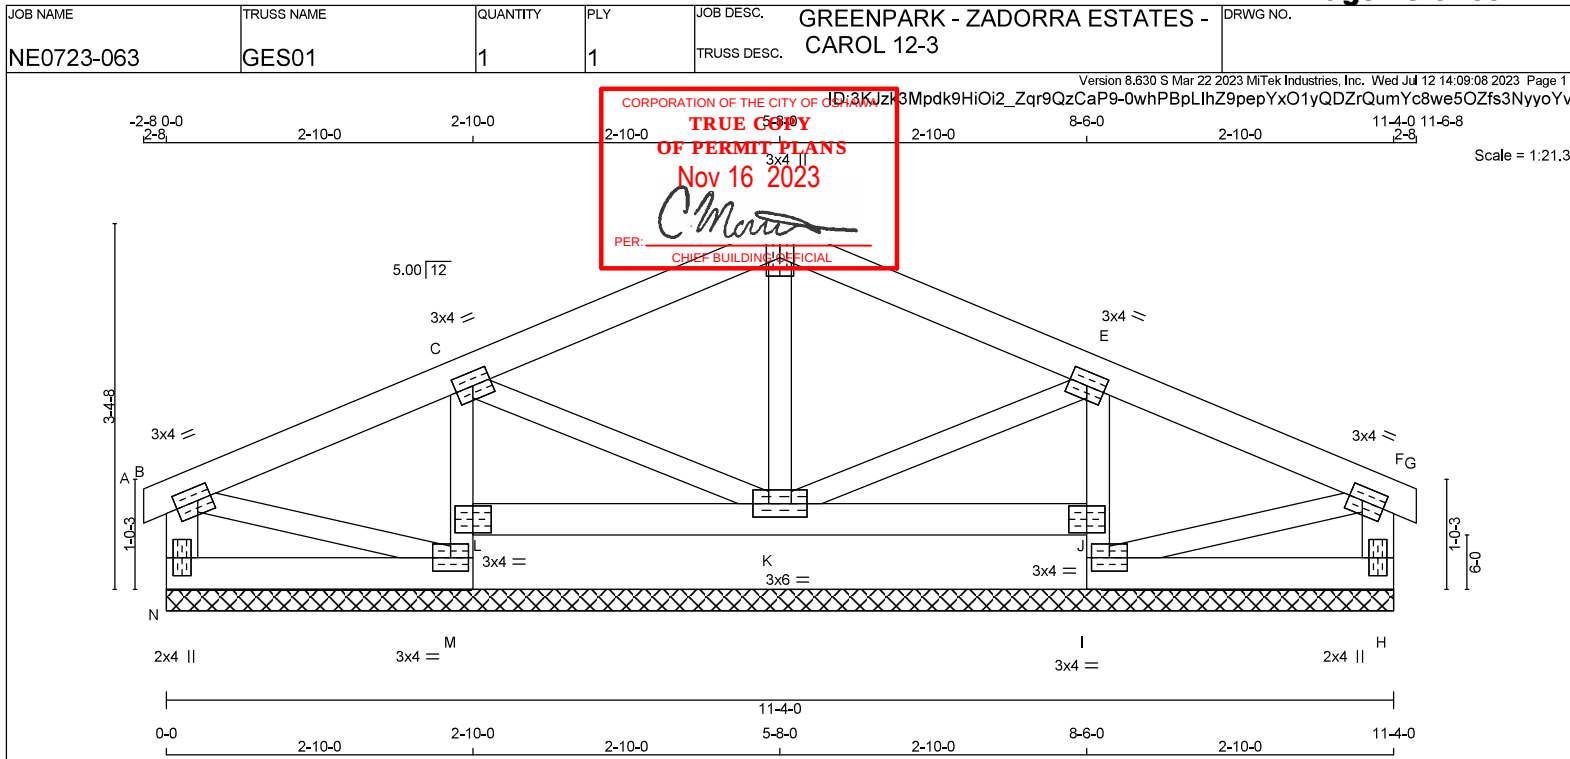

LUMBER

N. L. G. A. RULES	CHORDS	SIZE	LUMBER
A - D	2x4	DRY	No.2
D - G	2x4	DRY	No.2
N - B	2x4	DRY	No.2
H - F	2x4	DRY	No.2
N - M	2x4	DRY	No.2
M - C	2x3	DRY	No.2
L - J	2x4	DRY	No.2
I - E	2x3	DRY	No.2
I - H	2x4	DRY	No.2

ALL WEBS 2x3 DRY No.2
EXCEPT

DRY: SEASONED LUMBER.

GABLE STUDS SPACED AT 2'-0" OC.

PLATES (table is in inches)

JT	TYPE	PLATES	W	LEN	Y	X
B	TMVW4	MT20	3.0	4.0	1.50	1.50
C	TMVW4	MT20	3.0	4.0		
D	TTW+p	MT20	3.0	4.0		
E	TMVW4	MT20	3.0	4.0		
F	TMVW4	MT20	3.0	4.0	1.50	1.50
H	BMV1+p	MT20	2.0	4.0		
I	BMVW14	MT20	3.0	4.0		
J	BVM4	MT20	3.0	4.0		
K	BMVWW14	MT20	3.0	6.0		
L	BVM4	MT20	3.0	4.0		
M	BMVW14	MT20	3.0	4.0		
N	BMV1+p	MT20	2.0	4.0		

DIMENSIONS, SUPPORTS AND LOADINGS SPECIFIED BY FABRICATOR TO BE VERIFIED BY BUILDING

DESIGNER

JT	VERT	HORZ	DOWN	HORZ	UPLIFT	IN-SX	IN-SX
N	154	0	154	0	0	11'-4" (2'-10"-0")	8
I	419	0	419	0	0	11'-4" (2'-10"-0")	8
H	154	0	154	0	0	11'-4" (2'-10"-0")	8
K	423	0	423	0	0	11'-4" (2'-10"-0")	8
M	419	0	419	0	0	11'-4" (2'-10"-0")	8

VALUE IN PARENTHESIS INDICATES EFFECTIVE BEARING LENGTH

BEVELED PLATE OR SHIM REQUIRED TO PROVIDE FULL BEARING SURFACE WITH TRUSS CHORD AT JT(S): K

UNFACTORED REACTIONS

JT	COMBINED	SNOW	LIVE	PERM. LIVE	WIND	DEAD	SOIL
N	108	73 / 0	0 / 0	0 / 0	0 / 0	36 / 0	0 / 0
I	291	218 / 0	0 / 0	0 / 0	0 / 0	73 / 0	0 / 0
H	108	73 / 0	0 / 0	0 / 0	0 / 0	36 / 0	0 / 0
K	297	206 / 0	0 / 0	0 / 0	0 / 0	91 / 0	0 / 0
M	291	218 / 0	0 / 0	0 / 0	0 / 0	73 / 0	0 / 0

BEARING MATERIAL TO BE SPF NO.2 OR BETTER AT JOINT(S) N, I, H, K, M

BRACING

TOP CHORD TO BE SHEATHED OR MAX. PURLIN SPACING = 10.00 FT.
MAX. UNBRACED BOTTOM CHORD LENGTH = 7.81 FT. OR RIGID CEILING DIRECTLY APPLIED.

ALL PITCH BREAKS AND PERIMETER CORNER JOINTS MUST BE Laterally RESTRAINED.

LOADING

TOTAL LOAD CASES: (4)

MEMB.	CHORDS	MAX. FACTORED FORCE (LBS)	VERT. LOAD (PLF)	MAX. FACTORED (LC1)	MAX. FACTORED (LC)	MAX. UNBRACED LENGTH	MEMB.	WEBS	MAX. FACTORED FORCE (LBS)	MAX. FACTORED (LC)
FR-TO							FR-TO			
A-B	0 / 0	-15.0	-15.0	0.00 (4)	10.00		K-D	-305 / 0	0.05 (1)	
B-C	0 / 8	-119.4	-119.4	0.16 (1)	10.00		K-E	-60 / 0	0.01 (1)	
C-D	0 / 31	-119.4	-119.4	0.17 (1)	10.00		C-K	-60 / 0	0.01 (1)	
D-E	0 / 31	-119.4	-119.4	0.17 (1)	10.00		B-M	0 / 9	0.00 (1)	
E-F	0 / 8	-119.4	-119.4	0.16 (1)	10.00		F-F	0 / 9	0.00 (1)	
F-G	0 / 0	-15.0	-15.0	0.00 (4)	10.00					
N-B	-129 / 0	0.0	0.0	0.01 (1)	7.81					
H-F	-129 / 0	0.0	0.0	0.01 (1)	7.81					
N-M	0 / 0	-18.2	-18.2	0.04 (4)	10.00					
M-L	-396 / 0	0.0	0.0	0.01 (1)	7.81					
L-C	-376 / 0	0.0	0.0	0.01 (1)	7.81					
L-K	0 / 12	-18.2	-18.2	0.05 (4)	10.00					
K-J	0 / 12	-18.2	-18.2	0.05 (4)	10.00					
I-J	-396 / 0	0.0	0.0	0.01 (1)	7.81					
J-E	-376 / 0	0.0	0.0	0.01 (1)	7.81					
I-H	0 / 0	-18.2	-18.2	0.04 (4)	10.00					

DESIGN CRITERIA

SPECIFIED LOADS:
TOP CH. LL = 34.8 PSF
DL = 6.0 PSF
BOT CH. LL = 0.0 PSF
DL = 7.3 PSF
TOTAL LOAD = 48.1 PSF

SPACING = 24.0 IN. C/C

THIS TRUSS IS DESIGNED FOR RESIDENTIAL OR SMALL BUILDING REQUIREMENTS OF PART 9, NBCC 2015

THIS DESIGN COMPLIES WITH:
- PART 9 OF BCBC 2018, NBC-2019AE
- PART 9 OF OBC 2012 (2019 AMENDMENT)
- CSA 086-14
- TPIC 2014

(55 % OF 48.1 P.S.F. G.S.L. PLUS 8.4 P.S.F. RAIN LOAD)
EQUALS 34.8 P.S.F. SPECIFIED ROOF LIVE LOAD

CSI: TC=0.17/0.97 (D-E:1), BC=0.05/0.97 (K-L:4),
WB=0.05/0.97 (D-K:1), SSI=0.16/1.00 (D-E:1)

DOL LUMBER=1.00 NAIL=1.00 LS BEND=1.10 COMP=1.10
SHEAR=1.10 TENS= 1.10

COMPANION LIVE LOAD FACTOR = 1.00

TRUSS PLATE MANUFACTURER IS NOT RESPONSIBLE FOR QUALITY CONTROL IN THE TRUSS MANUFACTURING PLANT.

NAIL VALUES
PLATE GRIP(DRY) SHEAR SECTION
(PSI) (PLI) (PLI)
MAX MIN MAX MIN MAX MIN
MT20 650 371 1747 788 1987 1873

PLATE PLACEMENT TOL. = 0.250 inches


PLATE ROTATION TOL. = 5.0 Deg.

JSI GRIP= 0.52 (E) (INPUT = 0.90)
JSI METAL= 0.07 (E) (INPUT = 1.00)



READ ALL NOTES ON THIS PAGE AND ON THE ENGINEERING NOTES: TRUSSES. THE NOTE PAGE IS AN INTEGRAL PART OF THIS DRAWING AS IT CONTAINS SPECIFICATIONS AND CRITERIA USED IN THE DESIGN OF THIS COMPONENT.



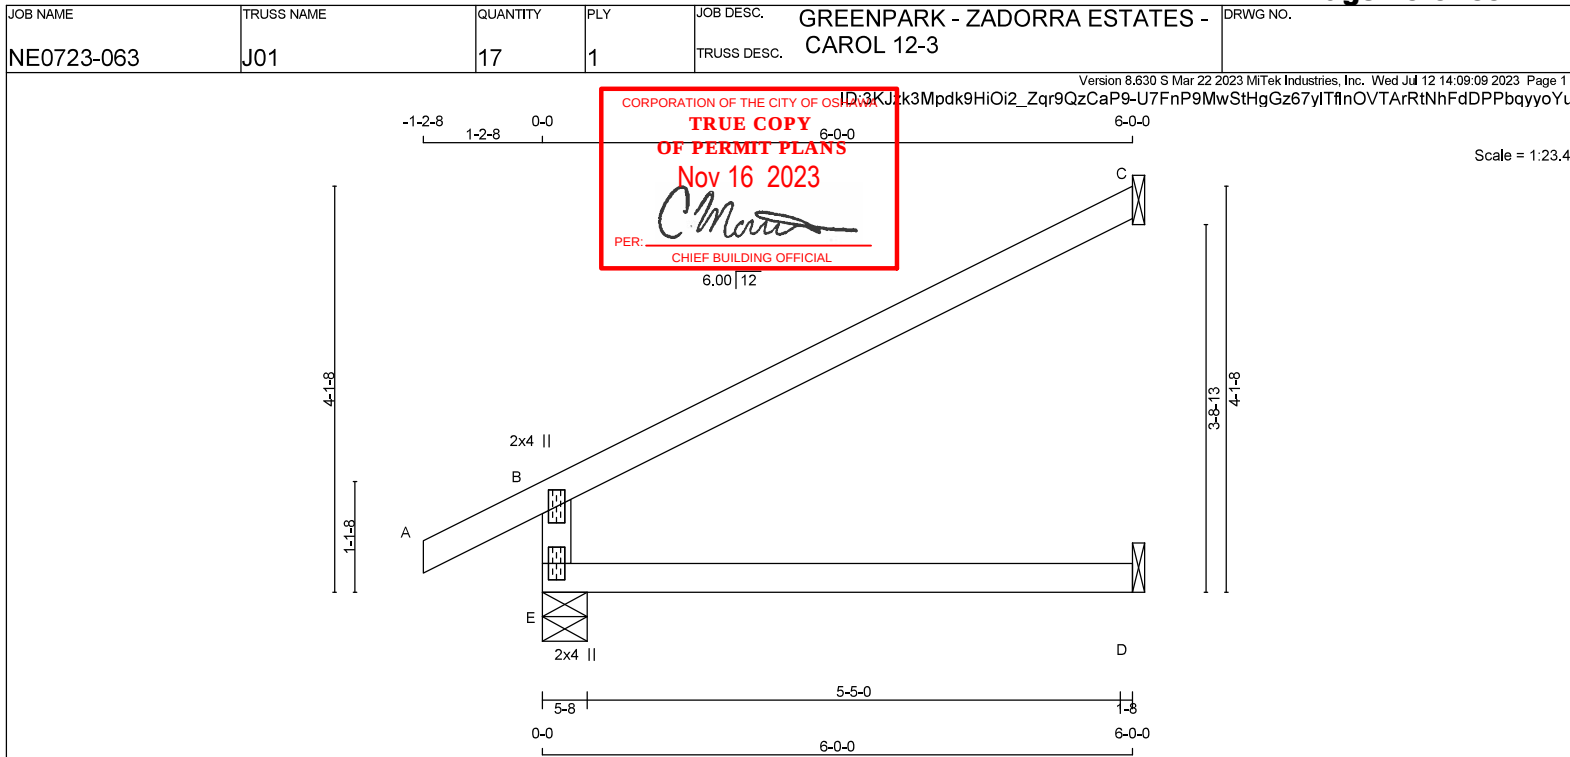

TOTAL WEIGHT = 17 X 17 = 288 lb

LUMBER

N. L. G. A. RULES	CHORDS	SIZE	LUMBER
E - B	2x4	DRY	No.2
A - C	2x4	DRY	No.2
E - D	2x4	DRY	No.2

DRY: SEASONED LUMBER.

PLATES (table is in inches)

JT	TYPE	PLATES	W	LEN	Y	X
B	TMV+p	MT20	2.0	4.0		
E	BMV1+p	MT20	2.0	4.0		

DIMENSIONS, SUPPORTS AND LOADINGS SPECIFIED BY FABRICATOR TO BE VERIFIED BY BUILDING**DESIGNER****BEARINGS**

JT	VERT	HORZ	FACTORED GROSS REACTION	MAXIMUM FACTORED GROSS REACTION	INPUT BRG	REQRD BRG
E	664	0	664	0	5-8	1-8
C	269	0	269	0	1-8	1-8
D	45	0	50	0	1-8	1-8

SEE MITEK STANDARD DETAIL MSD2015-H FOR CONNECTION TO JOINT(S) C, D

UNFACTORED REACTIONS

JT	1ST CASE	MAX./MIN. COMPONENT REACTIONS	SNOW	LIVE	PERM. LIVE	WIND	DEAD	SOIL
E	462	350 / 0	0 / 0	0 / 0	0 / 0	112 / 0	0 / 0	0 / 0
C	184	157 / 0	0 / 0	0 / 0	0 / 0	27 / 0	0 / 0	0 / 0
D	36	0 / 0	0 / 0	0 / 0	0 / 0	36 / 0	0 / 0	0 / 0

BEARING MATERIAL TO BE SPF NO.2 OR BETTER AT JOINT(S) E

BRACING

TOP CHORD TO BE SHEATHED OR MAX. PURLIN SPACING = 6.25 FT.

MAX. UNBRACED BOTTOM CHORD LENGTH = 10.00 FT OR RIGID CEILING DIRECTLY APPLIED.

ALL PITCH BREAKS AND PERIMETER CORNER JOINTS MUST BE LATERALLY RESTRAINED.

LOADING

TOTAL LOAD CASES: (4)

MEMB.	MAX. FACTORED FORCE (LBS)	FACTORED VERT. LOAD (PLF)	MAX. VERT. LOAD (PLF)	MAX. HORIZ. LOAD (PLF)	MEMB.	MAX. FACTORED FORCE (LBS)	MAX. HORIZ. LOAD (PLF)
FR-TO					FR-TO		
E-B	-600 / 0	0.0	0.0	0.11 (4)	7.81		
A-B	0 / 34	-119.4	-119.4	0.14 (1)	10.00		
B-C	-40 / 0	-119.4	-119.4	0.56 (1)	6.25		
E-D	0 / 0	-18.2	-18.2	0.14 (4)	10.00		

DESIGN CRITERIA**SPECIFIED LOADS:**

TOP CH. LL	=	34.8	PSF
DL	=	6.0	PSF
BOT CH. LL	=	0.0	PSF
DL	=	7.3	PSF
TOTAL LOAD	=	48.1	PSF

SPACING = 24.0 IN. C/C

THIS TRUSS IS DESIGNED FOR RESIDENTIAL OR SMALL BUILDING REQUIREMENTS OF PART 9, NBCC 2015

THIS DESIGN COMPLIES WITH:

- PART 9 OF BCBC 2018, NBC-2019AE
- PART 9 OF OBC 2012 (2019 AMENDMENT)
- CSA 086-14
- TPIC 2014

DESIGN ASSUMPTIONS

-OVERHANG NOT TO BE ALTERED OR CUT OFF.

(55 % OF 48.1 P.S.F., G.S.L. PLUS 8.4 P.S.F. RAIN LOAD) EQUALS 34.8 P.S.F. SPECIFIED ROOF LIVE LOAD

ALLOWABLE DEFL.(LL)= L/360 (0.20")
 CALCULATED VERT. DEFL.(LL) = L/ 999 (0.00")
 ALLOWABLE DEFL.(TL)= L/360 (0.20")
 CALCULATED VERT. DEFL.(TL) = L/ 999 (0.03")

CSI: TC=0.56/0.97 (B-C:1) , BC=0.14/0.97 (D-E:4) ,
 WB=0.00/0.97 (n/a:0) , SSI=0.31/1.00 (B-C:1)

DOL LUMBER=1.00 NAIL=1.00 LS BEND=1.10 COMP=1.10
 SHEAR=1.10 TENS=1.10

COMPANION LIVE LOAD FACTOR = 1.00

TRUSS PLATE MANUFACTURER IS NOT RESPONSIBLE FOR QUALITY CONTROL IN THE TRUSS MANUFACTURING PLANT.

NAIL VALUES

PLATE	GRIP(DRY)	SHEAR	SECTION
(PL)	(PSI)	(PL)	(PL)
MT20	650	371	1747
		788	1987
			1873

PLATE PLACEMENT TOL. = 0.250 inches


PLATE ROTATION TOL. = 5.0 Deg.

JSI GRIP= 0.34 (B) (INPUT = 0.90)
 JSI METAL= 0.25 (B) (INPUT = 1.00)



READ ALL NOTES ON THIS PAGE AND ON THE ENGINEERING NOTES: TRUSSES. THE NOTE PAGE IS AN INTEGRAL PART OF THIS DRAWING AS IT CONTAINS SPECIFICATIONS AND CRITERIA USED IN THE DESIGN OF THIS COMPONENT.

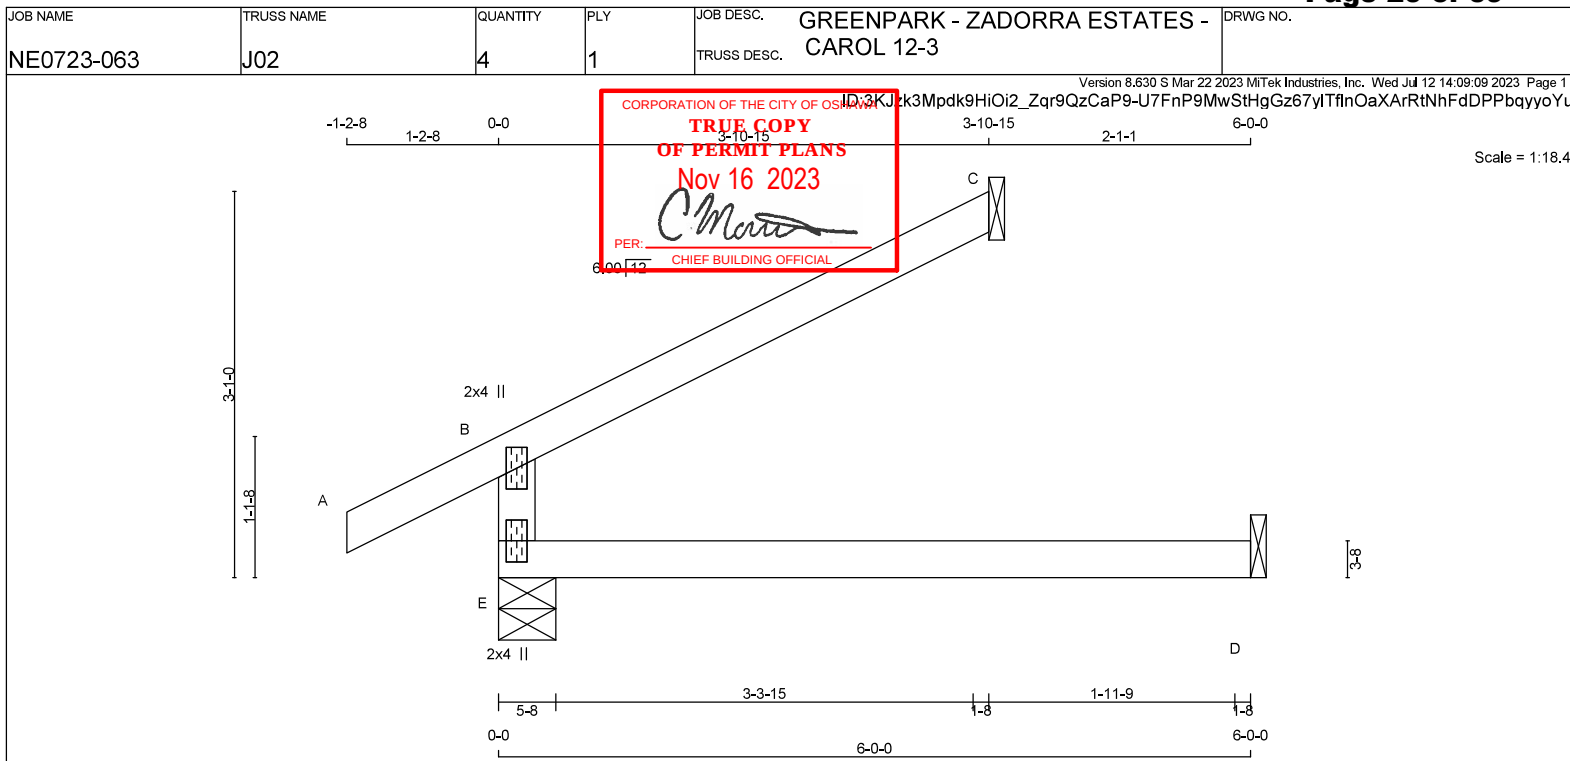

**LUMBER**

N. L. G. A. RULES	CHORDS	SIZE	LUMBER
E - B	2x4	DRY	No.2
A - C	2x4	DRY	No.2
E - D	2x4	DRY	No.2

DRY: SEASONED LUMBER.

PLATES (table is in inches)

JT	TYPE	PLATES	W	LEN	Y	X
B	TMV+p	MT20	2.0	4.0		
E	BMV1+p	MT20	2.0	4.0		

DIMENSIONS, SUPPORTS AND LOADINGS SPECIFIED BY FABRICATOR TO BE VERIFIED BY BUILDING**DESIGNER****BEARINGS**

JT	VERT	HORZ	DOWN	HORZ	UPLIFT	IN-SX	IN-SX
E	508	0	508	0	0	5-8	1-8
C	175	0	175	0	0	1-8	1-8
D	45	0	50	0	0	1-8	1-8

SEE MITEK STANDARD DETAIL MSD2015-H FOR CONNECTION TO JOINT(S) C, D

UNFACTORED REACTIONS

JT	1ST LCASE	MAX. MIN. COMPONENT REACTIONS	SNOW	LIVE	PERM. LIVE	WIND	DEAD	SOIL
E	355	259 / 0	0 / 0	0 / 0	0 / 0	96 / 0	0 / 0	0 / 0
C	120	102 / 0	0 / 0	0 / 0	0 / 0	18 / 0	0 / 0	0 / 0
D	36	0 / 0	0 / 0	0 / 0	0 / 0	36 / 0	0 / 0	0 / 0

BEARING MATERIAL TO BE SPF NO.2 OR BETTER AT JOINT(S) E, C

BRACING

TOP CHORD TO BE SHEATHED OR MAX. PURLIN SPACING = 6.25 FT.
MAX. UNBRACED BOTTOM CHORD LENGTH = 10.00 FT OR RIGID CEILING DIRECTLY APPLIED.

ALL PITCH BREAKS AND PERIMETER CORNER JOINTS MUST BE LATERALLY RESTRAINED.

LOADING

TOTAL LOAD CASES: (4)

MEMB.	MAX. FACTORED FORCE (LBS)	FACTORED VERT. LOAD (PLF)	MAX. VERT. LOAD (LBS)	MAX. HORIZ. LOAD (LBS)	MEMB.	MAX. FACTORED FORCE (LBS)	MAX. HORIZ. LOAD (LBS)
FR-TO					FR-TO		
E-B	-444 / 0	0.0	0.0	0.11 (4)	7.81		
A-B	0 / 34	-119.4	-119.4	0.14 (1)	10.00		
B-C	-26 / 0	-119.4	-119.4	0.24 (1)	6.25		
E-D	0 / 0	-18.2	-18.2	0.14 (4)	10.00		

DESIGN CRITERIA**SPECIFIED LOADS:**

TOP CH.	LL	=	34.8	PSF
	DL	=	6.0	PSF
BOT CH.	LL	=	0.0	PSF
	DL	=	7.3	PSF
TOTAL LOAD	=	48.1	PSF	

SPACING = 24.0 IN. C/C

THIS TRUSS IS DESIGNED FOR RESIDENTIAL OR SMALL BUILDING REQUIREMENTS OF PART 9, NBCC 2015

THIS DESIGN COMPLIES WITH:

- PART 9 OF BCBC 2018, NBC-2019AE
- PART 9 OF OBC 2012 (2019 AMENDMENT)
- CSA 086-14
- TPIC 2014

DESIGN ASSUMPTIONS

-OVERHANG NOT TO BE ALTERED OR CUT OFF.

(55 % OF 48.1 P.S.F. G.S.L. PLUS 8.4 P.S.F. RAIN LOAD)
EQUALS 34.8 P.S.F. SPECIFIED ROOF LIVE LOAD

ALLOWABLE DEFL.(TL)= L/360 (0.20")

CALCULATED VERT. DEFL.(TL) = L/ 999 (0.03")

CSI: TC=0.24/0.97 (B-C:1) , BC=0.14/0.97 (D-E:4) ,
WB=0.00/0.97 (n/a:0) , SSI=0.20/1.00 (B-C:1)

DOL LUMBER=1.00 NAIL=1.00 LS BEND=1.10 COMP=1.10
SHEAR=1.10 TENS= 1.10

COMPANION LIVE LOAD FACTOR = 1.00

TRUSS PLATE MANUFACTURER IS NOT RESPONSIBLE FOR QUALITY CONTROL IN THE TRUSS MANUFACTURING PLANT .

NAIL VALUES

PLATE	GRIP(DRY)	SHEAR	SECTION
	(PSI)	(PLI)	(PLI)
	MAX	MIN	MAX
MT20	650	371	788

PLATE PLACEMENT TOL. = 0.250 inches


PLATE ROTATION TOL. = 5.0 Deg.

JSI GRIP= 0.25 (B) (INPUT = 0.90)
JSI METAL= 0.18 (B) (INPUT = 1.00)



READ ALL NOTES ON THIS PAGE AND ON THE ENGINEERING NOTES: TRUSSES. THE NOTE PAGE IS AN INTEGRAL PART OF THIS DRAWING AS IT CONTAINS SPECIFICATIONS AND CRITERIA USED IN THE DESIGN OF THIS COMPONENT.

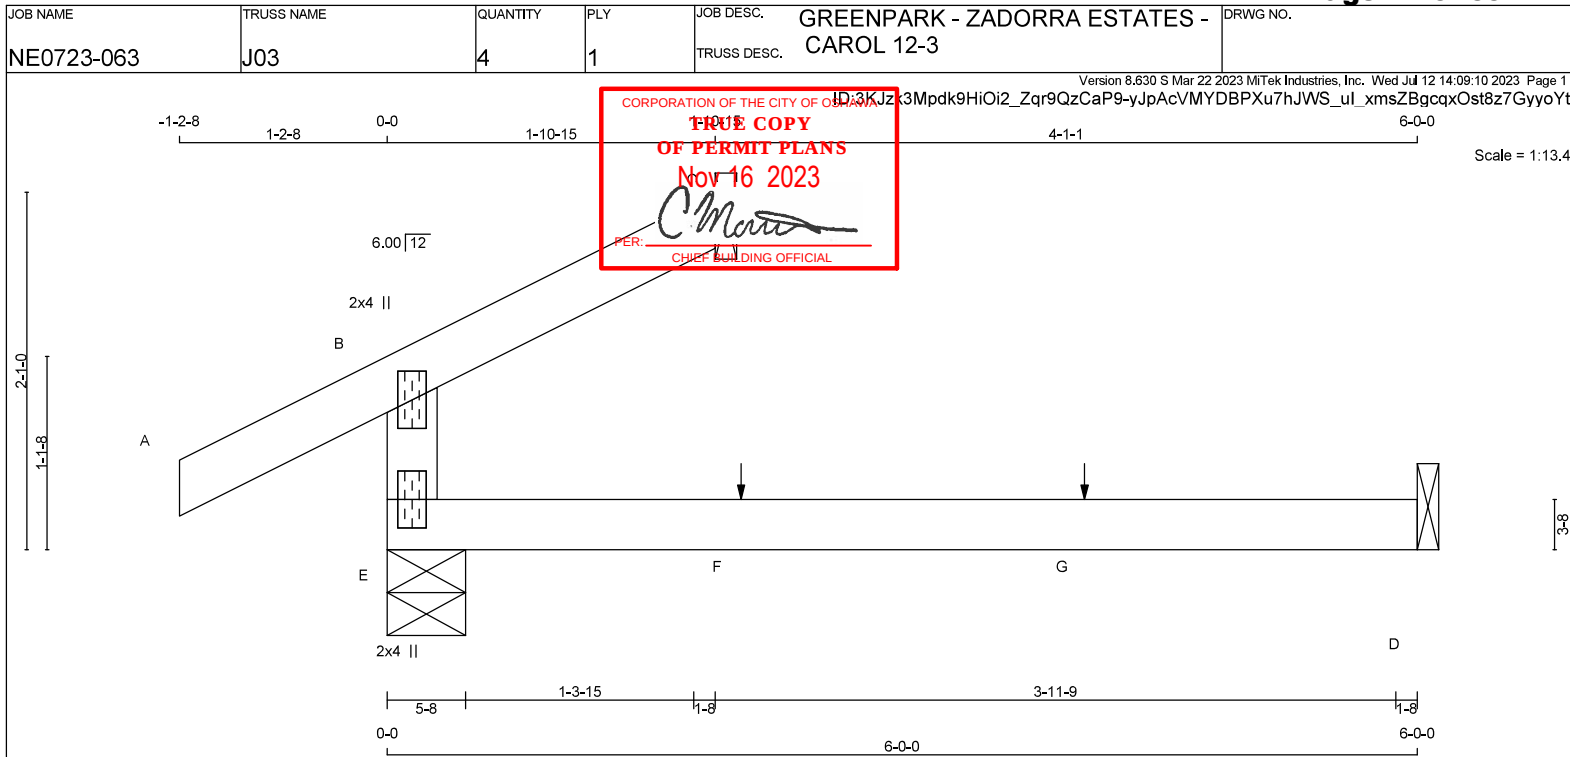

**LUMBER**

N. L. G. A. RULES	CHORDS	SIZE	LUMBER
E - B	2x4	DRY	No.2
A - C	2x4	DRY	No.2
E - D	2x4	DRY	No.2

DRY: SEASONED LUMBER.

PLATES (table is in inches)

JT	TYPE	PLATES	W	LEN	Y	X
B	TMV+p	MT20	2.0	4.0		
E	BMV1+p	MT20	2.0	4.0		

DIMENSIONS, SUPPORTS AND LOADINGS SPECIFIED BY FABRICATOR TO BE VERIFIED BY BUILDING**DESIGNER****BEARINGS**

JT	VERT	HORZ	DOWN	HORZ	UPLIFT	IN-SX	IN-SX
E	359	0	359	0	0	5-8	1-8
C	86	0	86	0	0	1-8	1-8
D	45	0	50	0	0	1-8	1-8

SEE MITEK STANDARD DETAIL MSD2015-H FOR CONNECTION TO JOINT(S) C, D

UNFACTORED REACTIONS

JT	COMBINED	SNOW	LIVE	PERM.LIVE	WIND	DEAD	SOIL
E	253	171 / 0	0 / 0	0 / 0	0 / 0	81 / 0	0 / 0
C	59	50 / 0	0 / 0	0 / 0	0 / 0	9 / 0	0 / 0
D	36	0 / 0	0 / 0	0 / 0	0 / 0	36 / 0	0 / 0

BEARING MATERIAL TO BE SPF NO.2 OR BETTER AT JOINT(S) E, C

BRACING

TOP CHORD TO BE SHEATHED OR MAX. PURLIN SPACING = 6.25 FT.
MAX. UNBRACED BOTTOM CHORD LENGTH = 10.00 FT OR RIGID CEILING DIRECTLY APPLIED.

ALL PITCH BREAKS AND PERIMETER CORNER JOINTS MUST BE LATERALLY RESTRAINED.

LOADING

TOTAL LOAD CASES: (4)

MEMB.	MAX. FACTORED FORCE (LBS)	FACTORED VERT. LOAD (PLF)	MAX. VERT. LOAD (LC1)	MAX. UNBRACED LENGTH FR-TO	MEMB.	MAX. FACTORED FORCE (LBS)	MAX. VERT. LOAD (LC1)
FR-TO							
E-B	-294 / 0	0.0	0.0	0.11 (4)	7.81		
A-B	0 / 34	-119.4	-119.4	0.14 (1)	10.00		
B-C	-12 / 0	-119.4	-119.4	0.06 (1)	6.25		
E-F	0 / 0	-18.2	-18.2	0.14 (4)	10.00		
F-G	0 / 0	-18.2	-18.2	0.14 (4)	10.00		
G-D	0 / 0	-18.2	-18.2	0.14 (4)	10.00		

SPECIFIED CONCENTRATED LOADS (LBS)

JT	LOC.	LC1	MAX-	MAX+	FACE	DIR.	TYPE	HEEL	CONN.
F	2-0-12	1	1	—	FRONT	VERT	TOTAL	—	C1
G	4-0-12	1	1	—	FRONT	VERT	TOTAL	—	C1

CONNECTION REQUIREMENTS

- 1) C1: A SUITABLE HANGER/MECHANICAL CONNECTION IS REQUIRED.

DESIGN CRITERIA

*** SPECIAL LOADS ANALYSIS ***
GEOMETRY AND/OR BASIC LOADS CHANGED BY USER.
LOADS WERE DERIVED FROM USER INPUT
NO FURTHER MODIFICATIONS WERE MADE

SPECIFIED LOADS:

TOP CH.	LL	=	34.8	PSF
	DL	=	6.0	PSF
BOT CH.	LL	=	0.0	PSF
	DL	=	7.3	PSF
TOTAL LOAD	=	48.1	PSF	

SPACING = 24.0 IN. C/C

*** NON STANDARD GIRDER ***

ADDTL USER-DEFINED LOADS APPLIED TO ALL LOAD CASES.

THIS TRUSS IS DESIGNED FOR RESIDENTIAL OR SMALL BUILDING REQUIREMENTS OF PART 9, NBCC 2015

THIS DESIGN COMPLIES WITH:

- PART 9 OF BCBC 2018, NBC-2019AE
- PART 9 OF OBC 2012 (2019 AMENDMENT)
- CSA 086-14
- TPIC 2014

DESIGN ASSUMPTIONS

-OVERHANG NOT TO BE ALTERED OR CUT OFF.

(55' OF 48.1 P.S.F. G.S.L. PLUS 8.4 P.S.F. RAIN LOAD)
EQUALS 34.8 P.S.F. SPECIFIED ROOF LIVE LOAD

ALLOWABLE DEFL.(LL) = L/360 (0.20")
CALCULATED VERT. DEFL.(LL) = L/999 (0.00")
ALLOWABLE DEFL.(TL) = L/360 (0.20")
CALCULATED VERT. DEFL.(TL) = L/999 (0.03")

CSI: TC=0.14/0.97 (A-B:1) , BC=0.14/0.97 (D-E:4) ,
WB=0.00/0.97 (n/a:0) , SSI=0.11/1.00 (A-B:1)

DOL LUMBER=1.00 NAIL=1.00 LS BEND=1.10 COMP=1.10
SHEAR=1.10 TENS=1.10

COMPANION LIVE LOAD FACTOR = 1.00

TRUSS PLATE MANUFACTURER IS NOT RESPONSIBLE FOR QUALITY CONTROL IN THE TRUSS MANUFACTURING PLANT .

NAIL VALUES

PLATE	GRIP (DRY)	SHEAR	SECTION
(PSI)	(PLI)	(PLI)	(PLI)
MAX	MIN	MAX	MIN
MT20	650	371	1747
	788	1987	1873

PLATE PLACEMENT TOL. = 0.250 inches


PLATE ROTATION TOL. = 5.0 Deg.

JSI GRIP= 0.16 (B) (INPUT = 0.90)
JSI METAL= 0.12 (B) (INPUT = 1.00)



READ ALL NOTES ON THIS PAGE AND ON THE ENGINEERING NOTES: TRUSSES. THE NOTE PAGE IS AN INTEGRAL PART OF THIS DRAWING AS IT CONTAINS SPECIFICATIONS AND CRITERIA USED IN THE DESIGN OF THIS COMPONENT.



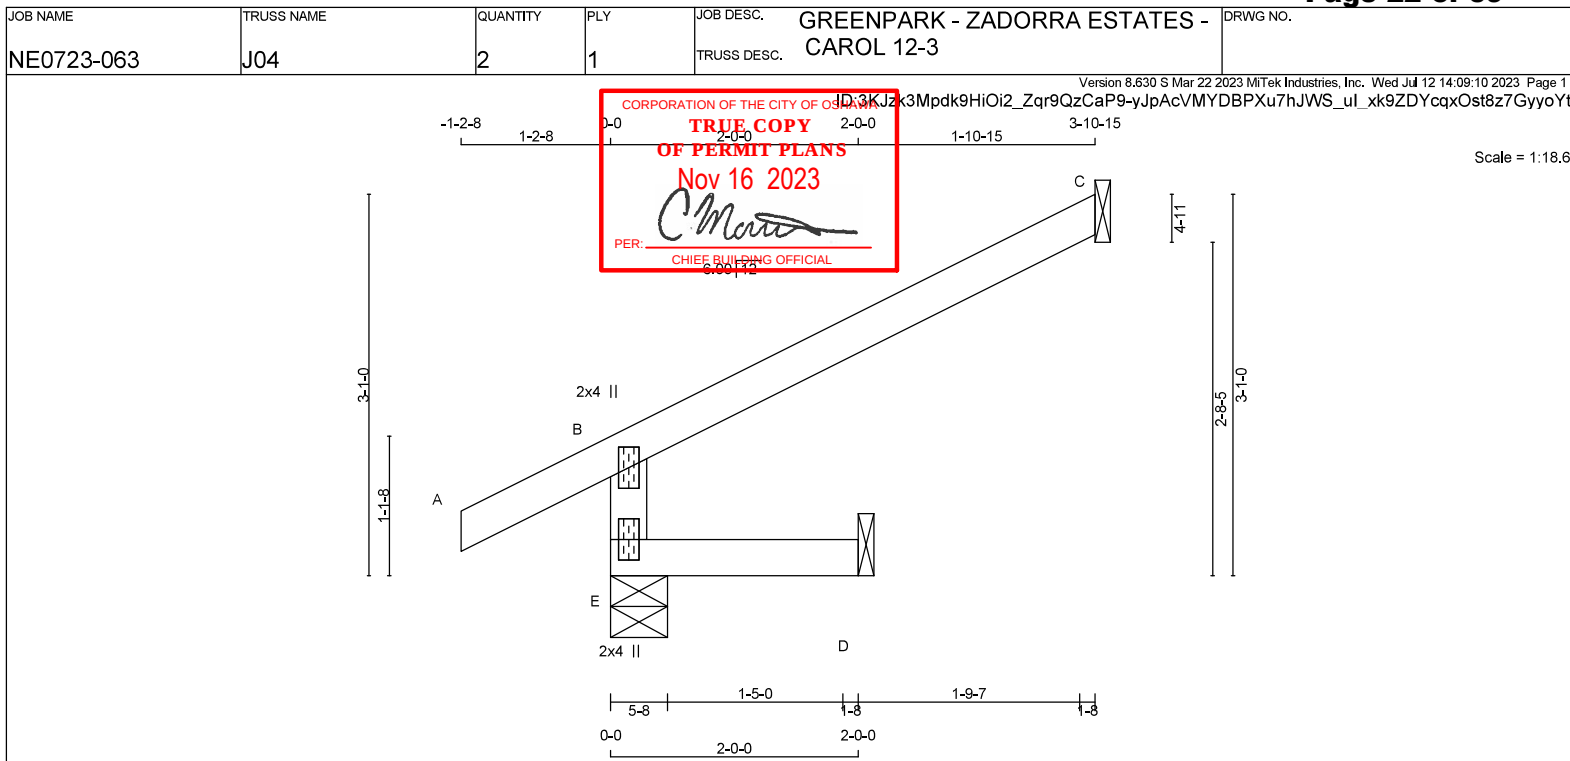

TOTAL WEIGHT = 2 X 10 = 19 lb

LUMBER

N. L. G. A. RULES	CHORDS	SIZE	LUMBER
E - B	2x4	DRY	No.2
A - C	2x4	DRY	No.2
E - D	2x4	DRY	No.2

DRY: SEASONED LUMBER.

PLATES (table is in inches)

JT	TYPE	PLATES	W	LEN	Y	X
B	TMV+p	MT20	2.0	4.0		
E	BMV1+p	MT20	2.0	4.0		

DIMENSIONS, SUPPORTS AND LOADINGS SPECIFIED BY FABRICATOR TO BE VERIFIED BY BUILDING**DESIGNER****BEARINGS**

	FACTORED GROSS REACTION	MAXIMUM FACTORED GROSS REACTION	INPUT BRG	REQD BRG
JT	VERT	HORZ	DOWN	HORZ
E	464	0	464	0
C	175	0	175	0
D	16	0	16	0

SEE MITEK STANDARD DETAIL MSD2015-H FOR CONNECTION TO JOINT(S) C, D

UNFACTORED REACTIONS

JT	1ST LCASE	MAX./MIN. COMPONENT REACTIONS	SNOW	LIVE	PERM. LIVE	WIND	DEAD	SOIL
E	320	259 / 0	0 / 0	0 / 0	0 / 0	61 / 0	0 / 0	0 / 0
C	120	102 / 0	0 / 0	0 / 0	0 / 0	18 / 0	0 / 0	0 / 0
D	13	0 / 0	0 / 0	0 / 0	0 / 0	13 / 0	0 / 0	0 / 0

BEARING MATERIAL TO BE SPF NO.2 OR BETTER AT JOINT(S) E

BRACING

TOP CHORD TO BE SHEATHED OR MAX. PURLIN SPACING = 6.25 FT.

MAX. UNBRACED BOTTOM CHORD LENGTH = 10.00 FT OR RIGID CEILING DIRECTLY APPLIED.

ALL PITCH BREAKS AND PERIMETER CORNER JOINTS MUST BE LATERALLY RESTRAINED.

LOADING

TOTAL LOAD CASES: (4)

MEMB.	MAX. FACTORED FORCE (LBS)	FACTORED VERT. LOAD (PLF)	MAX. UNBRACED LENGTH (LC)	MAX. FACTORED FORCE (LBS)	MAX. FACTORED VERT. LOAD (PLF)
FR-TO					
E-B	-444 / 0	0.0	0.0	0.01 (4)	7.81
A-B	0 / 34	-119.4	-119.4	0.14 (1)	10.00
B-C	-26 / 0	-119.4	-119.4	0.31 (1)	6.25
E-D	0 / 0	-18.2	-18.2	0.02 (4)	10.00

DESIGN CRITERIA**SPECIFIED LOADS:**

TOP CH.	LL	=	34.8	PSF
	DL	=	6.0	PSF
BOT CH.	LL	=	0.0	PSF
	DL	=	7.3	PSF
TOTAL LOAD	=	48.1	PSF	

SPACING = 24.0 IN. C/C

THIS TRUSS IS DESIGNED FOR RESIDENTIAL OR SMALL BUILDING REQUIREMENTS OF PART 9, NBCC 2015

THIS DESIGN COMPLIES WITH:

- PART 9 OF BCBC 2018, NBC-2019AE
- PART 9 OF OBC 2012 (2019 AMENDMENT)
- CSA 086-14
- TPIC 2014

DESIGN ASSUMPTIONS

-OVERHANG NOT TO BE ALTERED OR CUT OFF.

(55 % OF 48.1 P.S.F., G.S.L. PLUS 8.4 P.S.F. RAIN LOAD) EQUALS 34.8 P.S.F. SPECIFIED ROOF LIVE LOAD

ALLOWABLE DEFL.(LL)= L/360 (0.19")
 CALCULATED VERT. DEFL.(LL) = L/ 999 (0.00")
 ALLOWABLE DEFL.(TL)= L/360 (0.19")
 CALCULATED VERT. DEFL.(TL) = L/ 999 (0.00")

CSI: TC=0.31/0.97 (B-C:1), BC=0.02/0.97 (D-E:4),
 WB=0.00/0.97 (n/a:0), SSH=0.20/1.00 (B-C:1)

DOL LUMBER=1.00 NAIL=1.00 LS BEND=1.10 COMP=1.10
 SHEAR=1.10 TENS=1.10

COMPANION LIVE LOAD FACTOR = 1.00

TRUSS PLATE MANUFACTURER IS NOT RESPONSIBLE FOR QUALITY CONTROL IN THE TRUSS MANUFACTURING PLANT.

NAIL VALUES

PLATE	GRIP(DRY)	SHEAR	SECTION
	(PL)	(PL)	(PL)
MT20	650	371	1747
		788	1987
			1873

PLATE PLACEMENT TOL. = 0.250 inches

PLATE ROTATION TOL. = 5.0 Deg.

JSI GRIP= 0.25 (B) (INPUT = 0.90)
 JSI METAL= 0.18 (B) (INPUT = 1.00)




READ ALL NOTES ON THIS PAGE AND ON THE ENGINEERING NOTES: TRUSSES. THE NOTE PAGE IS AN INTEGRAL PART OF THIS DRAWING AS IT CONTAINS SPECIFICATIONS AND CRITERIA USED IN THE DESIGN OF THIS COMPONENT.



JOB NAME	TRUSS NAME	QUANTITY	PLY	JOB DESC.	GREENPARK - ZADORRA ESTATES -	DRWG NO.
NE0723-063	J05	4	1	TRUSS DESC.	CAROL 12-3	

Version 8.630 S Mar 22 2023 MiTek Industries, Inc. Wed Jul 12 14:09:11 2023 Page 1

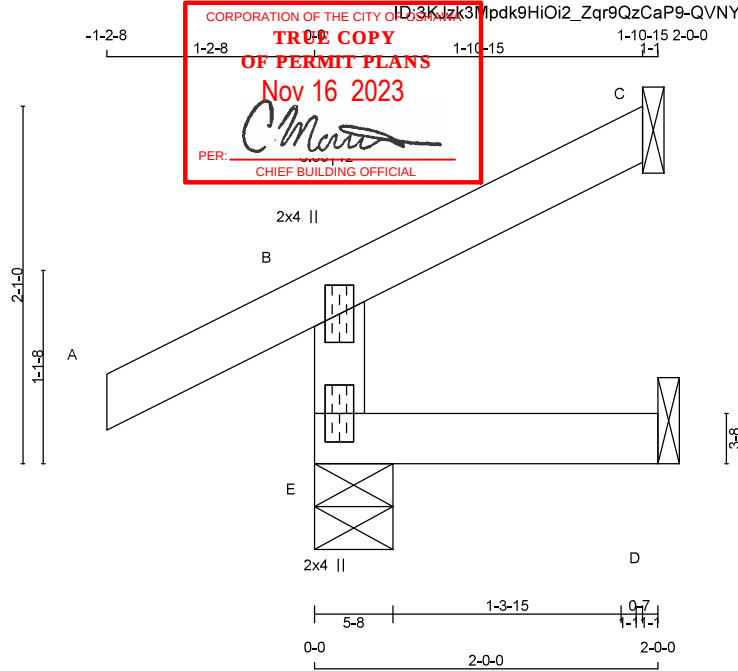

Scale = 1:13.4

TOTAL WEIGHT = 4 X 7 = 29 lb

LUMBER

N. L. G. A. RULES			
CHORDS	SIZE	LUMBER	
E - B	2x4	DRY	No.2
A - C	2x4	DRY	No.2
E - D	2x4	DRY	No.2

DRY: SEASONED LUMBER.

DESCR.
SPF
SPF
SPF**PLATES (table is in inches)**

JT	TYPE	PLATES	W	LEN	Y	X
B	TMV+p	MT20	2.0	4.0		
E	BMV1+p	MT20	2.0	4.0		

DIMENSIONS, SUPPORTS AND LOADINGS SPECIFIED BY FABRICATOR TO BE VERIFIED BY BUILDING**DESIGNER**

	FACTORED GROSS REACTION	MAXIMUM FACTORED GROSS REACTION	INPUT BRG	REQRD BRG
JT	VERT	HORZ	DOWN	HORZ
E	314	0	314	0
C	86	0	86	0
D	16	0	16	0

SEE MITEK STANDARD DETAIL MSD2015-H FOR CONNECTION TO JOINT(S) C, D

UNFACTORED REACTIONS

JT	COMBINED	SNOW	LIVE	PERM. LIVE	WIND	DEAD	SOIL
E	217	171 / 0	0 / 0	0 / 0	0 / 0	46 / 0	0 / 0
C	59	50 / 0	0 / 0	0 / 0	0 / 0	9 / 0	0 / 0
D	13	0 / 0	0 / 0	0 / 0	0 / 0	13 / 0	0 / 0

BEARING MATERIAL TO BE SPF NO.2 OR BETTER AT JOINT(S) E, C

BRACINGTOP CHORD TO BE SHEATHED OR MAX. PURLIN SPACING = 6.25 FT.
MAX. UNBRACED BOTTOM CHORD LENGTH = 10.00 FT OR RIGID CEILING DIRECTLY APPLIED.

ALL PITCH BREAKS AND PERIMETER CORNER JOINTS MUST BE LATERALLY RESTRAINED.

LOADING

TOTAL LOAD CASES: (5)

MEMB.	MAX. FORCE (LBS)	FACTORED VERT. LOAD (PLF)	MAX. VERT. LOAD (LBS)	MAX. HORIZ. LOAD (LBS)	MEMB.	MAX. FORCE (LBS)	MAX. HORIZ. LOAD (LBS)
FR-TO					FR-TO		
E-B	-294 / 0	0.0	0.0	0.01 (4)	7.81		
A-B	0 / 34	-119.4	-119.4	0.14 (1)	10.00		
B-C	-12 / 0	-119.4	-119.4	0.07 (1)	6.25		
E-D	0 / 0	-18.2	-18.2	0.02 (4)	10.00		

CANTILEVER ANALYSIS HAS BEEN CONSIDERED IN THIS DESIGN

PATTERN-LOADING CHECK APPLIED TO THIS TRUSS.

DESIGN CRITERIA

SPECIFIED LOADS:
 TOP CH. LL = 34.8 PSF
 DL = 6.0 PSF
 BOT CH. LL = 0.0 PSF
 DL = 7.3 PSF
 TOTAL LOAD = 48.1 PSF

SPACING = 24.0 IN. C/C

THIS TRUSS IS DESIGNED FOR RESIDENTIAL OR SMALL BUILDING REQUIREMENTS OF PART 9, NBCC 2015

THIS DESIGN COMPLIES WITH:

- PART 9 OF BCBC 2018, NBC-2019AE
- PART 9 OF OBC 2012 (2019 AMENDMENT)
- CSA 086-14
- TPIC 2014

DESIGN ASSUMPTIONS

-OVERHANG NOT TO BE ALTERED OR CUT OFF.

(55 % OF 48.1 P.S.F., G.S.L. PLUS 8.4 P.S.F. RAIN LOAD)
EQUALS 34.8 P.S.F. SPECIFIED ROOF LIVE LOAD

ALLOWABLE DEFL.(LL)= L/360 (0.19")
 CALCULATED VERT. DEFL.(LL) = L/ 999 (0.00")
 ALLOWABLE DEFL.(TL)= L/360 (0.19")
 CALCULATED VERT. DEFL.(TL) = L/ 999 (0.00")

CSI: TC=0.14/0.97 (A-B:1) , BC=0.02/0.97 (D-E:4) ,
WB=0.00/0.97 (n/a:0) , SSI=0.11/1.00 (A-B:1)DOL LUMBER=1.00 NAIL=1.00 LS BEND=1.10 COMP=1.10
SHEAR=1.10 TENS=1.10

COMPANION LIVE LOAD FACTOR = 1.00

TRUSS PLATE MANUFACTURER IS NOT RESPONSIBLE FOR QUALITY CONTROL IN THE TRUSS MANUFACTURING PLANT.

NAIL VALUES

PLATE	GRIP (DRY)	SHEAR	SECTION
(PL)	(PSI)	(PL)	(PL)
MT20	650	371	1747
		788	1987
		1873	


PLATE PLACEMENT TOL. = 0.250 inches

PLATE ROTATION TOL. = 5.0 Deg.

JSI GRIP= 0.16 (B) (INPUT = 0.90)
JSI METAL= 0.12 (B) (INPUT = 1.00)

READ ALL NOTES ON THIS PAGE AND ON THE
 ENGINEERING NOTES: TRUSSES. THE NOTE PAGE
 IS AN INTEGRAL PART OF THIS DRAWING AS IT
 CONTAINS SPECIFICATIONS AND CRITERIA USED
 IN THE DESIGN OF THIS COMPONENT.



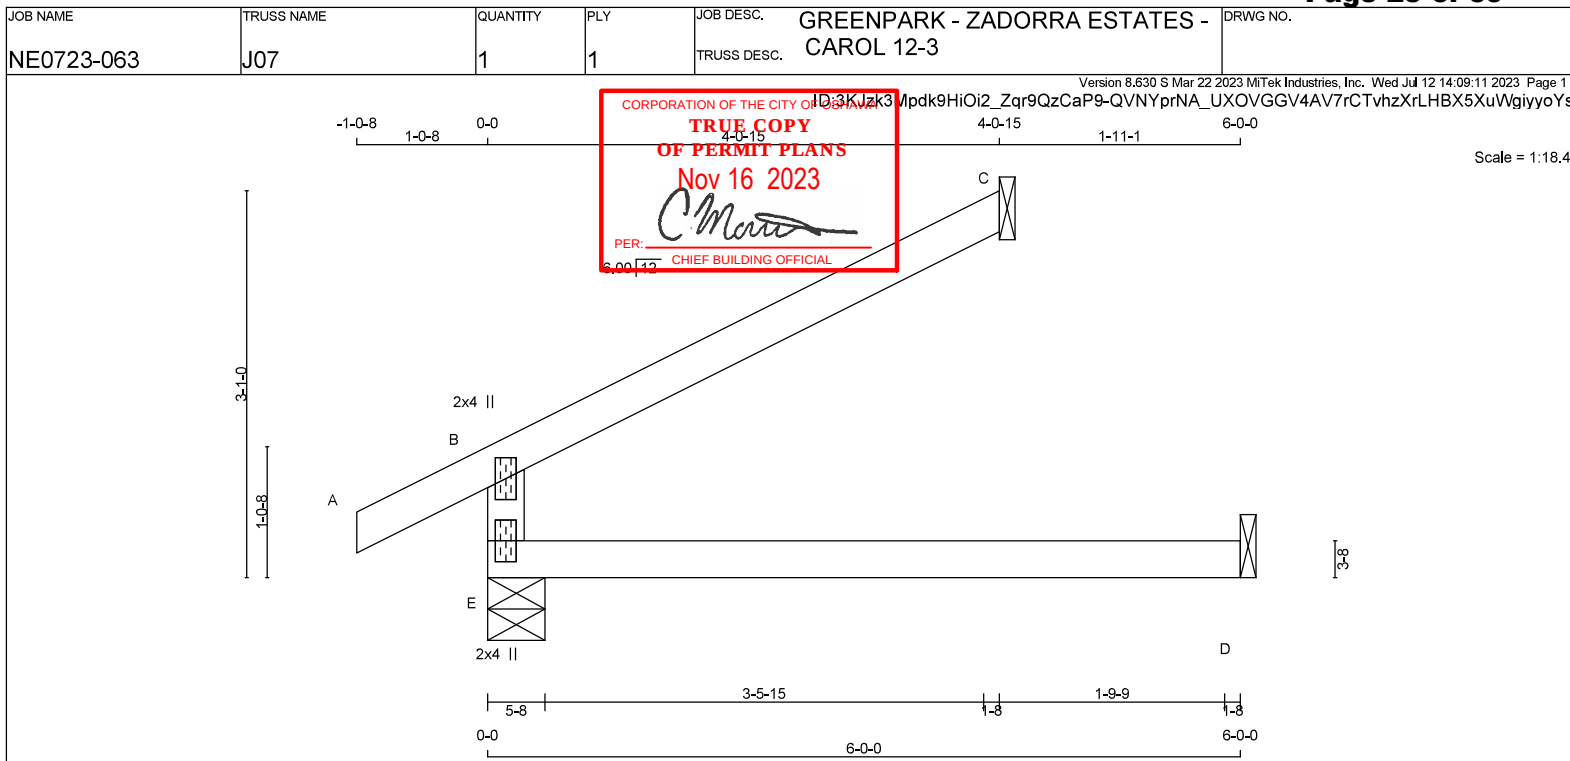

TOTAL WEIGHT = 14 lb

LUMBER

N. L. G. A. RULES	CHORDS	SIZE	LUMBER
E - B	2x4	DRY	No.2
A - C	2x4	DRY	No.2
E - D	2x4	DRY	No.2

DRY: SEASONED LUMBER.

PLATES (table is in inches)

JT	TYPE	PLATES	W	LEN	Y	X
B	TMV+p	MT20	2.0	4.0		
E	BMV1+p	MT20	2.0	4.0		

DIMENSIONS, SUPPORTS AND LOADINGS SPECIFIED BY FABRICATOR TO BE VERIFIED BY BUILDING**DESIGNER**

JT	VERT	HORZ	FACTORED GROSS REACTION	MAXIMUM FACTORED GROSS REACTION	INPUT BRG	REQRD BRG
E	501	0	501	0	5-8	1-8
C	183	0	183	0	1-8	1-8
D	45	0	50	0	1-8	1-8

SEE MITEK STANDARD DETAIL MSD2015-H FOR CONNECTION TO JOINT(S) C, D

UNFACTORED REACTIONS

JT	1ST CASE	MAX./MIN. COMPONENT REACTIONS	SNOW	LIVE	PERM. LIVE	WIND	DEAD	SOIL
E	350	254 / 0	0 / 0	0 / 0	0 / 0	96 / 0	0 / 0	0 / 0
C	125	107 / 0	0 / 0	0 / 0	0 / 0	18 / 0	0 / 0	0 / 0
D	36	0 / 0	0 / 0	0 / 0	0 / 0	36 / 0	0 / 0	0 / 0

BEARING MATERIAL TO BE SPF NO.2 OR BETTER AT JOINT(S) E, C

BRACINGTOP CHORD TO BE SHEATHED OR MAX. PURLIN SPACING = 6.25 FT.
MAX. UNBRACED BOTTOM CHORD LENGTH = 10.00 FT OR RIGID CEILING DIRECTLY APPLIED.

ALL PITCH BREAKS AND PERIMETER CORNER JOINTS MUST BE LATERALLY RESTRAINED.

LOADING

TOTAL LOAD CASES: (4)

MEMB.	MAX. FACTORED FORCE (LBS)	FACTORED VERT. LOAD (PLF)	MAX. VERT. LOAD (LC1)	MAX. HORIZ. LOAD (LC2)	MAX. UNBRACED LENGTH (FR-TO)	MEMB.	MAX. FACTORED FORCE (LBS)	MAX. HORIZ. LOAD (LC2)
FR-TO						FR-TO		
E-B	-436 / 0	0.0	0.0	0.11 (4)	7.81	E-B	-436 / 0	0.0
A-B	0 / 30	-119.4	-119.4	0.10 (1)	10.00	A-B	0 / 30	-119.4
B-C	-27 / 0	-119.4	-119.4	0.26 (1)	6.25	B-C	-27 / 0	-119.4
E-D	0 / 0	-18.2	-18.2	0.14 (4)	10.00	E-D	0 / 0	-18.2

DESIGN CRITERIA

SPECIFIED LOADS:

TOP CH. LL = 34.8 PSF

DL = 6.0 PSF

BOT CH. LL = 0.0 PSF

DL = 7.3 PSF

TOTAL LOAD = 48.1 PSF

SPACING = 24.0 IN. C/C

THIS TRUSS IS DESIGNED FOR RESIDENTIAL OR SMALL BUILDING REQUIREMENTS OF PART 9, NBCC 2015

THIS DESIGN COMPLIES WITH:

- PART 9 OF BCBC 2018, NBC-2019AE
- PART 9 OF OBC 2012 (2019 AMENDMENT)
- CSA 086-14
- TPIC 2014

DESIGN ASSUMPTIONS

-OVERHANG NOT TO BE ALTERED OR CUT OFF.

(55 % OF 48.1 P.S.F. G.S.L. PLUS 8.4 P.S.F. RAIN LOAD)
EQUALS 34.8 P.S.F. SPECIFIED ROOF LIVE LOAD

ALLOWABLE DEFL.(LL)= L/360 (0.20")

CALCULATED VERT. DEFL.(LL) = L/ 999 (0.00")

ALLOWABLE DEFL.(TL)= L/360 (0.20")

CALCULATED VERT. DEFL.(TL) = L/ 999 (0.03")

CSI: TC=0.26/0.97 (B-C:1) , BC=0.14/0.97 (D-E:4) ,
WB=0.00/0.97 (n/a:0) , SSI=0.21/1.00 (B-C:1)DOL LUMBER=1.00 NAIL=1.00 LS BEND=1.10 COMP=1.10
SHEAR=1.10 TENS=1.10

COMPANION LIVE LOAD FACTOR = 1.00

TRUSS PLATE MANUFACTURER IS NOT RESPONSIBLE FOR QUALITY CONTROL IN THE TRUSS MANUFACTURING PLANT.

NAIL VALUES

PLATE	GRIP (DRY) (PSI)	SHEAR (PLD) (PSI)	SECTION (PLD) (PSI)
MT20	650	371	1747
		788	1987
		1873	

PLATE PLACEMENT TOL. = 0.250 inches

PLATE ROTATION TOL. = 5.0 Deg.


JSI GRIP= 0.24 (B) (INPUT = 0.90)

JSI METAL= 0.18 (B) (INPUT = 1.00)



READ ALL NOTES ON THIS PAGE AND ON THE ENGINEERING NOTES: TRUSSES. THE NOTE PAGE IS AN INTEGRAL PART OF THIS DRAWING AS IT CONTAINS SPECIFICATIONS AND CRITERIA USED IN THE DESIGN OF THIS COMPONENT.



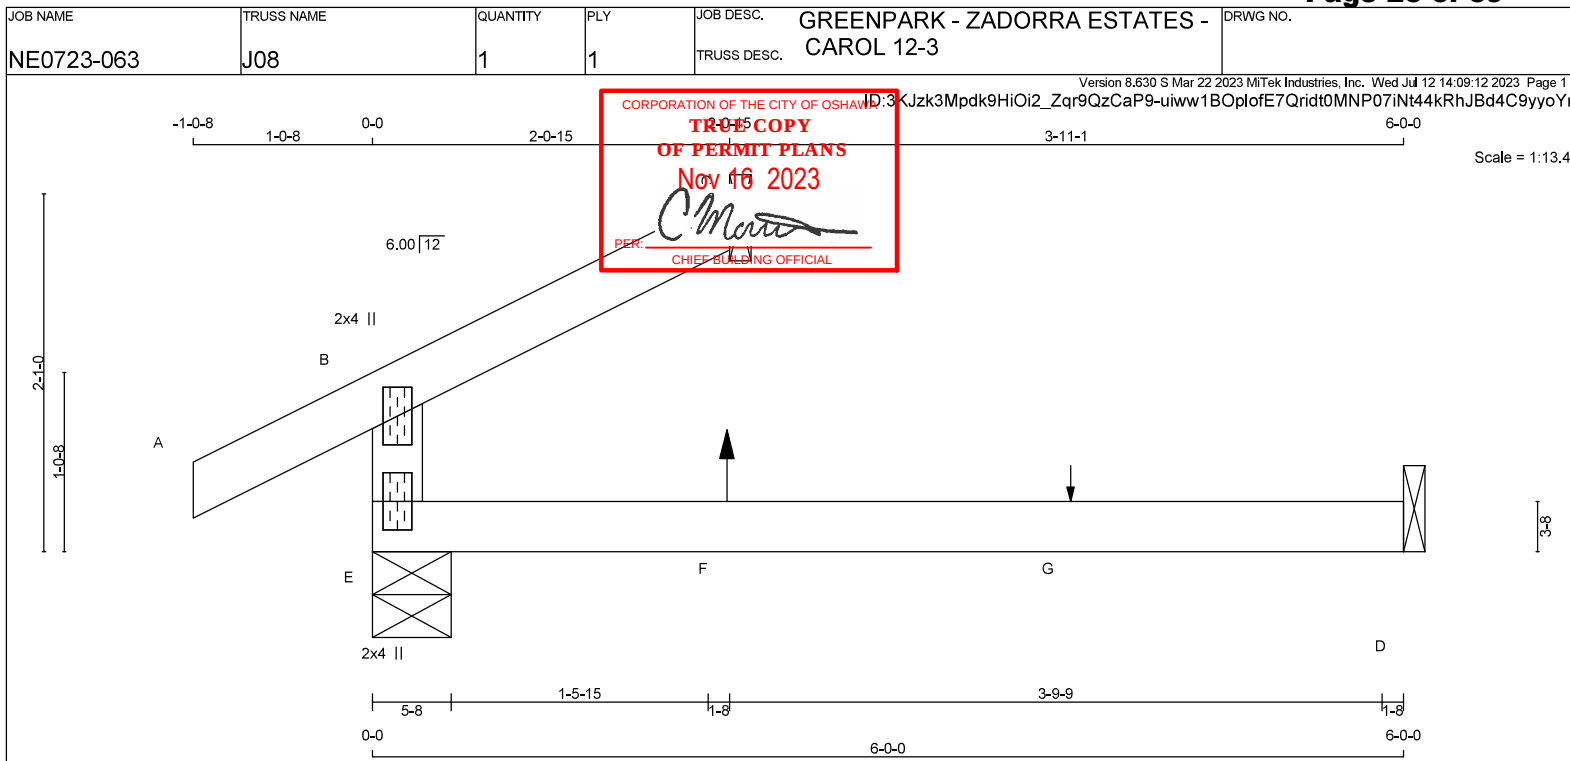

LUMBER
N. L. G. A. RULES
CHORDS SIZE LUMBER
E - B 2x4 DRY No.2
A - C 2x4 DRY No.2
E - D 2x4 DRY No.2
DRY: SEASONED LUMBER.

PLATES (table is in inches)
JT TYPE PLATES W LEN Y X
B TMV+p MT20 2.0 4.0
E BMV1+p MT20 2.0 4.0

DIMENSIONS, SUPPORTS AND LOADINGS SPECIFIED BY FABRICATOR TO BE VERIFIED BY BUILDING

DESIGNER BEARINGS

JT	VERT	HORZ	DOWN	HORZ	UPLIFT	IN-SX	IN-SX
E	346	0	346	0	0	5-8	1-8
C	94	0	94	0	0	1-8	1-8
D	43	0	50	0	0	1-8	1-8

SEE MITEK STANDARD DETAIL MSD2015-H FOR CONNECTION TO JOINT(S) C, D

UNFACTORED REACTIONS

JT	COMBINED	SNOW	LIVE	PERM.LIVE	WIND	DEAD	SOIL
E	244	163 / 0	0 / 0	0 / 0	0 / 0	81 / 0	0 / 0
C	64	55 / 0	0 / 0	0 / 0	0 / 0	9 / 0	0 / 0
D	35	0 / -1	0 / 0	0 / 0	0 / 0	36 / 0	0 / 0

BEARING MATERIAL TO BE SPF NO.2 OR BETTER AT JOINT(S) E, C

BRACING

TOP CHORD TO BE SHEATHED OR MAX. PURLIN SPACING = 6.25 FT.
MAX. UNBRACED BOTTOM CHORD LENGTH = 10.00 FT OR RIGID CEILING DIRECTLY APPLIED.

ALL PITCH BREAKS AND PERIMETER CORNER JOINTS MUST BE LATERALLY RESTRAINED.

LOADING

TOTAL LOAD CASES: (4)

MEMB.	MAX. FACTORED FORCE (LBS)	FACTORED VERT. LOAD (PLF)	MAX. LC1 (LC)	MAX. UNBRACED LENGTH FR-TO	MEMB.	MAX. FACTORED FORCE (LBS)	MAX. LC1 (LC)
FR-TO		FROM TO					
E-B	-287 / 0	0.0	0.0	0.11 (4)			
A-B	0 / 30	-119.4	-119.4	0.10 (1)			
B-C	-14 / 0	-119.4	-119.4	0.07 (1)			
E-F	0 / 0	-18.2	-18.2	0.14 (4)			
F-G	0 / 0	-18.2	-18.2	0.14 (4)			
G-D	0 / 0	-18.2	-18.2	0.14 (4)			

SPECIFIED CONCENTRATED LOADS (LBS)

JT	LOC.	LC1	MAX-	MAX+	FACE	DIR.	TYPE	HEEL	CONN.
F	2-0-12	5	1	5	BACK	VERT	TOTAL	—	C1
G	4-0-12	1	1	—	BACK	VERT	TOTAL	—	C1

CONNECTION REQUIREMENTS

- 1) C1: A SUITABLE HANGER/MECHANICAL CONNECTION IS REQUIRED.

DESIGN CRITERIA

*** SPECIAL LOADS ANALYSIS ***
GEOMETRY AND/OR BASIC LOADS CHANGED BY USER.
LOADS WERE DERIVED FROM USER INPUT
NO FURTHER MODIFICATIONS WERE MADE

SPECIFIED LOADS:

TOP CH. LL = 34.8 PSF
DL = 6.0 PSF
BOT CH. LL = 0.0 PSF
DL = 7.3 PSF
TOTAL LOAD = 48.1 PSF

SPACING = 24.0 IN. C/C

*** NON STANDARD GIRDER ***
ADDTL USER-DEFINED LOADS APPLIED TO ALL LOAD CASES.

THIS TRUSS IS DESIGNED FOR RESIDENTIAL OR SMALL BUILDING REQUIREMENTS OF PART 9, NBCC 2015

THIS DESIGN COMPLIES WITH:

- PART 9 OF BCBC 2018, NBC-2019AE
- PART 9 OF OBC 2012 (2019 AMENDMENT)
- CSA 086-14
- TPIC 2014

DESIGN ASSUMPTIONS

-OVERHANG NOT TO BE ALTERED OR CUT OFF.

(55' OF 48.1 P.S.F. G.S.L. PLUS 8.4 P.S.F. RAIN LOAD) EQUALS 34.8 P.S.F. SPECIFIED ROOF LIVE LOAD

ALLOWABLE DEFL.(LL) = L/360 (0.20")
CALCULATED VERT. DEFL.(LL) = L/999 (0.00")
ALLOWABLE DEFL.(TL) = L/360 (0.20")
CALCULATED VERT. DEFL.(TL) = L/999 (0.03")

CSI: TC=0.11/0.97 (B-E-4) , BC=0.14/0.97 (D-E-4) , WB=0.00/0.97 (n/a:0) , SSI=0.11/1.00 (B-C:1)

DOL LUMBER=1.00 NAIL=1.00 LS BEND=1.10 COMP=1.10 SHEAR=1.10 TENS=1.10

COMPANION LIVE LOAD FACTOR = 1.00

TRUSS PLATE MANUFACTURER IS NOT RESPONSIBLE FOR QUALITY CONTROL IN THE TRUSS MANUFACTURING PLANT .

NAIL VALUES

PLATE	GRIP (DRY)	SHEAR	SECTION
(PSI)	(PLI)	(PLI)	(PLI)
MAX	MIN	MAX	MIN
MT20	650	371	1747
	788	1987	1873

PLATE PLACEMENT TOL. = 0.250 inches


PLATE ROTATION TOL. = 5.0 Deg.

JSI GRIP= 0.16 (B) (INPUT = 0.90)
JSI METAL= 0.12 (B) (INPUT = 1.00)



READ ALL NOTES ON THIS PAGE AND ON THE ENGINEERING NOTES: TRUSSES. THE NOTE PAGE IS AN INTEGRAL PART OF THIS DRAWING AS IT CONTAINS SPECIFICATIONS AND CRITERIA USED IN THE DESIGN OF THIS COMPONENT.



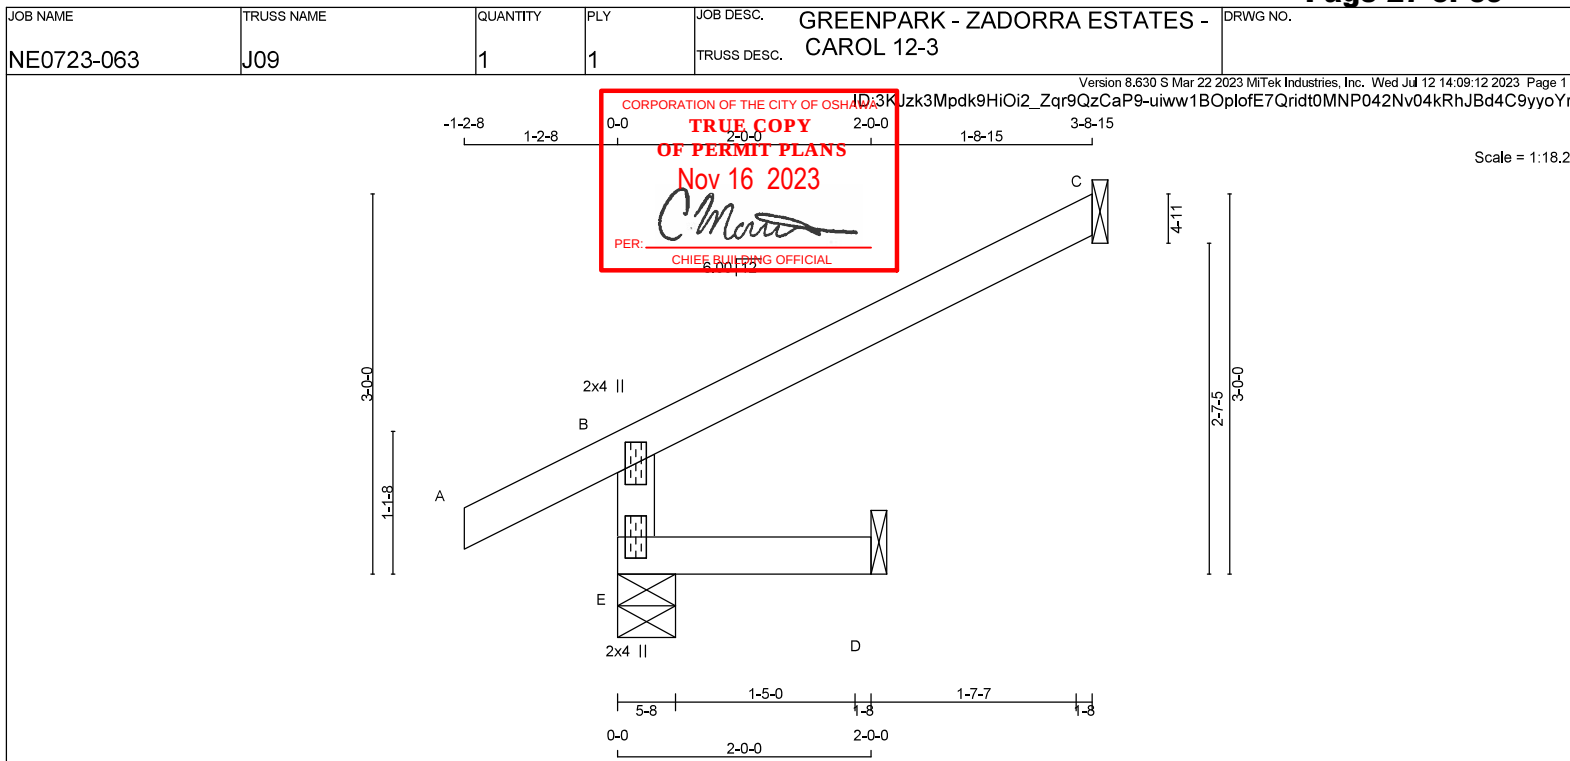

TOTAL WEIGHT = 10 lb

LUMBER

N. L. G. A. RULES	CHORDS	SIZE	LUMBER
E - B	2x4	DRY	No.2
A - C	2x4	DRY	No.2
E - D	2x4	DRY	No.2

DRY: SEASONED LUMBER.

PLATES (table is in inches)

JT	TYPE	PLATES	W	LEN	Y	X
B	TMV+p	MT20	2.0	4.0		
E	BMV1+p	MT20	2.0	4.0		

DIMENSIONS, SUPPORTS AND LOADINGS SPECIFIED BY FABRICATOR TO BE VERIFIED BY BUILDING**DESIGNER****BEARINGS**

JT	VERT	HORZ	FACTORED GROSS REACTION	MAXIMUM FACTORED GROSS REACTION	INPUT BRG	REQRD BRG
E	452	0	452	0	5-8	1-8
C	168	0	168	0	1-8	1-8
D	16	0	16	0	1-8	1-8

SEE MITEK STANDARD DETAIL MSD2015-H FOR CONNECTION TO JOINT(S) C, D

UNFACTORED REACTIONS

JT	1ST LCASE	MAX./MIN. COMPONENT REACTIONS	SNOW	LIVE	PERM.LIVE	WIND	DEAD	SOIL
E	311	252 / 0	0 / 0	0 / 0	0 / 0	60 / 0	0 / 0	0 / 0
C	115	98 / 0	0 / 0	0 / 0	0 / 0	17 / 0	0 / 0	0 / 0
D	13	0 / 0	0 / 0	0 / 0	0 / 0	13 / 0	0 / 0	0 / 0

BEARING MATERIAL TO BE SPF NO.2 OR BETTER AT JOINT(S) E

BRACING

TOP CHORD TO BE SHEATHED OR MAX. PURLIN SPACING = 6.25 FT.

MAX. UNBRACED BOTTOM CHORD LENGTH = 10.00 FT OR RIGID CEILING DIRECTLY APPLIED.

ALL PITCH BREAKS AND PERIMETER CORNER JOINTS MUST BE LATERALLY RESTRAINED.

LOADING

TOTAL LOAD CASES: (4)

MEMB.	CHORDS	MAX. FACTORED FORCE (LBS)	FACTORED VERT. LOAD (PLF)	MAX. UNBRACED LENGTH (LC)	MEMB.	WEBS	MAX. FACTORED FORCE (LBS)	MAX. UNBRACED LENGTH (LC)
FR-TO								
E-B	-431 / 0	0.0	0.0	0.01 (4)	7.81			
A-B	0 / 34	-119.4	-119.4	0.14 (1)	10.00			
B-C	-25 / 0	-119.4	-119.4	0.28 (1)	6.25			
E-D	0 / 0	-18.2	-18.2	0.02 (4)	10.00			

DESIGN CRITERIA**SPECIFIED LOADS:**

TOP CH. LL	=	34.8	PSF
DL	=	6.0	PSF
BOT CH. LL	=	0.0	PSF
DL	=	7.3	PSF
TOTAL LOAD	=	48.1	PSF

SPACING = 24.0 IN. C/C

THIS TRUSS IS DESIGNED FOR RESIDENTIAL OR SMALL BUILDING REQUIREMENTS OF PART 9, NBCC 2015

THIS DESIGN COMPLIES WITH:

- PART 9 OF BCBC 2018, NBC-2019AE
- PART 9 OF OBC 2012 (2019 AMENDMENT)
- CSA 086-14
- TPIC 2014

DESIGN ASSUMPTIONS

-OVERHANG NOT TO BE ALTERED OR CUT OFF.

(55 % OF 48.1 P.S.F., G.S.L. PLUS 8.4 P.S.F. RAIN LOAD) EQUALS 34.8 P.S.F. SPECIFIED ROOF LIVE LOAD

ALLOWABLE DEFL.(LL)= L/360 (0.19")
 CALCULATED VERT. DEFL.(LL) = L/ 999 (0.00")
 ALLOWABLE DEFL.(TL)= L/360 (0.19")
 CALCULATED VERT. DEFL.(TL) = L/ 999 (0.00")

CSI: TC=0.28/0.97 (B-C:1) , BC=0.02/0.97 (D-E:4) ,
 WB=0.00/0.97 (n/a:0) , SSI=0.19/1.00 (B-C:1)

DOL LUMBER=1.00 NAIL=1.00 LS BEND=1.10 COMP=1.10
 SHEAR=1.10 TENS=1.10

COMPANION LIVE LOAD FACTOR = 1.00

TRUSS PLATE MANUFACTURER IS NOT RESPONSIBLE FOR QUALITY CONTROL IN THE TRUSS MANUFACTURING PLANT.

NAIL VALUES

PLATE	GRIP(DRY)	SHEAR	SECTION
(PL)	(PSI)	(PL)	(PL)
MT20	650	371	1747
		788	1987
			1873

PLATE PLACEMENT TOL. = 0.250 inches

PLATE ROTATION TOL. = 5.0 Deg.


JSI GRIP= 0.24 (B) (INPUT = 0.90)

JSI METAL= 0.18 (B) (INPUT = 1.00)



READ ALL NOTES ON THIS PAGE AND ON THE ENGINEERING NOTES: TRUSSES. THE NOTE PAGE IS AN INTEGRAL PART OF THIS DRAWING AS IT CONTAINS SPECIFICATIONS AND CRITERIA USED IN THE DESIGN OF THIS COMPONENT.



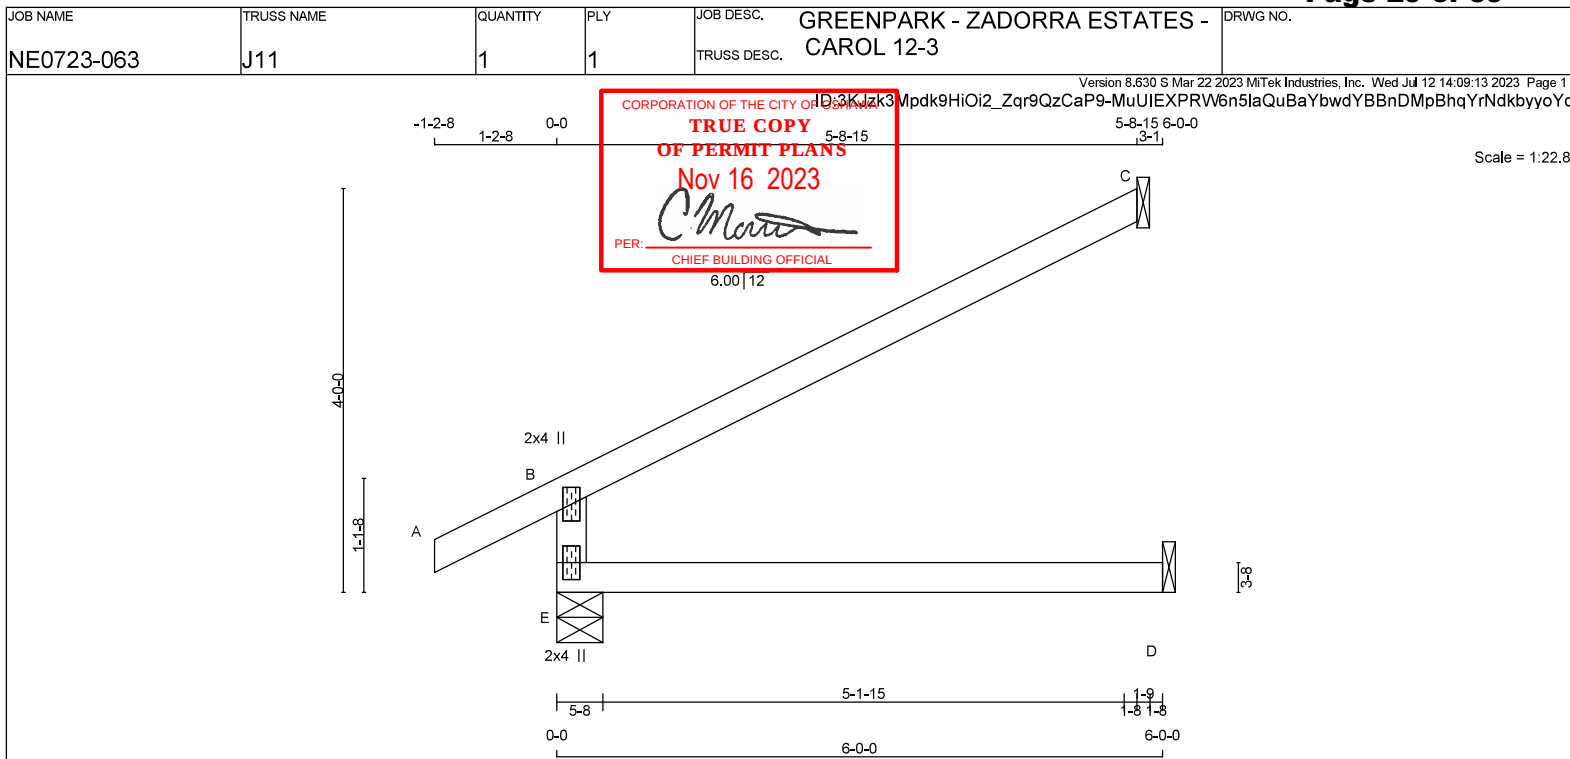

TOTAL WEIGHT = 17 lb

LUMBER

N. L. G. A. RULES	CHORDS	SIZE	LUMBER
E - B	2x4	DRY	No.2
A - C	2x4	DRY	No.2
E - D	2x4	DRY	No.2

DRY: SEASONED LUMBER.

PLATES (table is in inches)

JT	TYPE	PLATES	W	LEN	Y	X
B	TMV+p	MT20	2.0	4.0		
E	BMV1+p	MT20	2.0	4.0		

DIMENSIONS, SUPPORTS AND LOADINGS SPECIFIED BY FABRICATOR TO BE VERIFIED BY BUILDING**DESIGNER****BEARINGS**

JT	VERT	HORZ	FACTORED GROSS REACTION	MAXIMUM FACTORED GROSS REACTION	INPUT BRG	REQRD BRG
E	645	0	645	0	5-8	1-8
C	257	0	257	0	1-8	1-8
D	45	0	50	0	1-8	1-8

SEE MITEK STANDARD DETAIL MSD2015-H FOR CONNECTION TO JOINT(S) C, D

UNFACTORED REACTIONS

JT	1ST CASE	COMBINED	SNOW	LIVE	PERM. LIVE	WIND	DEAD	SOIL
E	449	339 / 0	0 / 0	0 / 0	0 / 0	110 / 0	0 / 0	0 / 0
C	176	150 / 0	0 / 0	0 / 0	0 / 0	26 / 0	0 / 0	0 / 0
D	36	0 / 0	0 / 0	0 / 0	0 / 0	36 / 0	0 / 0	0 / 0

BEARING MATERIAL TO BE SPF NO.2 OR BETTER AT JOINT(S) E, C

BRACINGTOP CHORD TO BE SHEATHED OR MAX. PURLIN SPACING = 6.25 FT.
MAX. UNBRACED BOTTOM CHORD LENGTH = 10.00 FT OR RIGID CEILING DIRECTLY APPLIED.

ALL PITCH BREAKS AND PERIMETER CORNER JOINTS MUST BE LATERALLY RESTRAINED.

LOADING

TOTAL LOAD CASES: (4)

MEMB.	MAX. FORCE (LBS)	FACTORED VERT. LOAD (PLF)	MAX. UNBRACED LENGTH (FT)	MEMB.	MAX. FORCE (LBS)	FACTORED VERT. LOAD (PLF)	MAX. UNBRACED LENGTH (FT)
FR-TO				FR-TO			
E-B	-581 / 0	0.0	0.0	0.11 (4)	7.81		
A-B	0 / 34	-119.4	-119.4	0.14 (1)	10.00		
B-C	-38 / 0	-119.4	-119.4	0.52 (1)	6.25		
E-D	0 / 0	-18.2	-18.2	0.14 (4)	10.00		

DESIGN CRITERIA**SPECIFIED LOADS:**

TOP CH.	LL	=	34.8	PSF
	DL	=	6.0	PSF
BOT CH.	LL	=	0.0	PSF
	DL	=	7.3	PSF
TOTAL LOAD		=	48.1	PSF

SPACING = 24.0 IN. C/C

THIS TRUSS IS DESIGNED FOR RESIDENTIAL OR SMALL BUILDING REQUIREMENTS OF PART 9, NBCC 2015

THIS DESIGN COMPLIES WITH:

- PART 9 OF BCBC 2018, NBC-2019AE
- PART 9 OF OBC 2012 (2019 AMENDMENT)
- CSA 086-14
- TPIC 2014

DESIGN ASSUMPTIONS

-OVERHANG NOT TO BE ALTERED OR CUT OFF.

(55 % OF 48.1 P.S.F., G.S.L. PLUS 8.4 P.S.F. RAIN LOAD)
EQUALS 34.8 P.S.F. SPECIFIED ROOF LIVE LOADALLOWABLE DEFL.(LL)= L/360 (0.20")
CALCULATED VERT. DEFL.(LL) = L/ 999 (0.00")
ALLOWABLE DEFL.(TL)= L/360 (0.20")
CALCULATED VERT. DEFL.(TL) = L/ 999 (0.03")CSI: TC=0.52/0.97 (B-C:1) , BC=0.14/0.97 (D-E:4) ,
WB=0.00/0.97 (n/a:0) , SSI=0.30/1.00 (B-C:1)DOL LUMBER=1.00 NAIL=1.00 LS BEND=1.10 COMP=1.10
SHEAR=1.10 TENS=1.10

COMPANION LIVE LOAD FACTOR = 1.00

TRUSS PLATE MANUFACTURER IS NOT RESPONSIBLE FOR QUALITY CONTROL IN THE TRUSS MANUFACTURING PLANT.

NAIL VALUES

PLATE	GRIP (DRY) (PSI)	SHEAR (PLD)	SECTION (PLD)
MT20	650	371	1747
		788	1987
			1873


PLATE PLACEMENT TOL. = 0.250 inches

PLATE ROTATION TOL. = 5.0 Deg.

JSI GRIP= 0.32 (B) (INPUT = 0.90)
JSI METAL= 0.24 (B) (INPUT = 1.00)

READ ALL NOTES ON THIS PAGE AND ON THE ENGINEERING NOTES: TRUSSES. THE NOTE PAGE IS AN INTEGRAL PART OF THIS DRAWING AS IT CONTAINS SPECIFICATIONS AND CRITERIA USED IN THE DESIGN OF THIS COMPONENT.



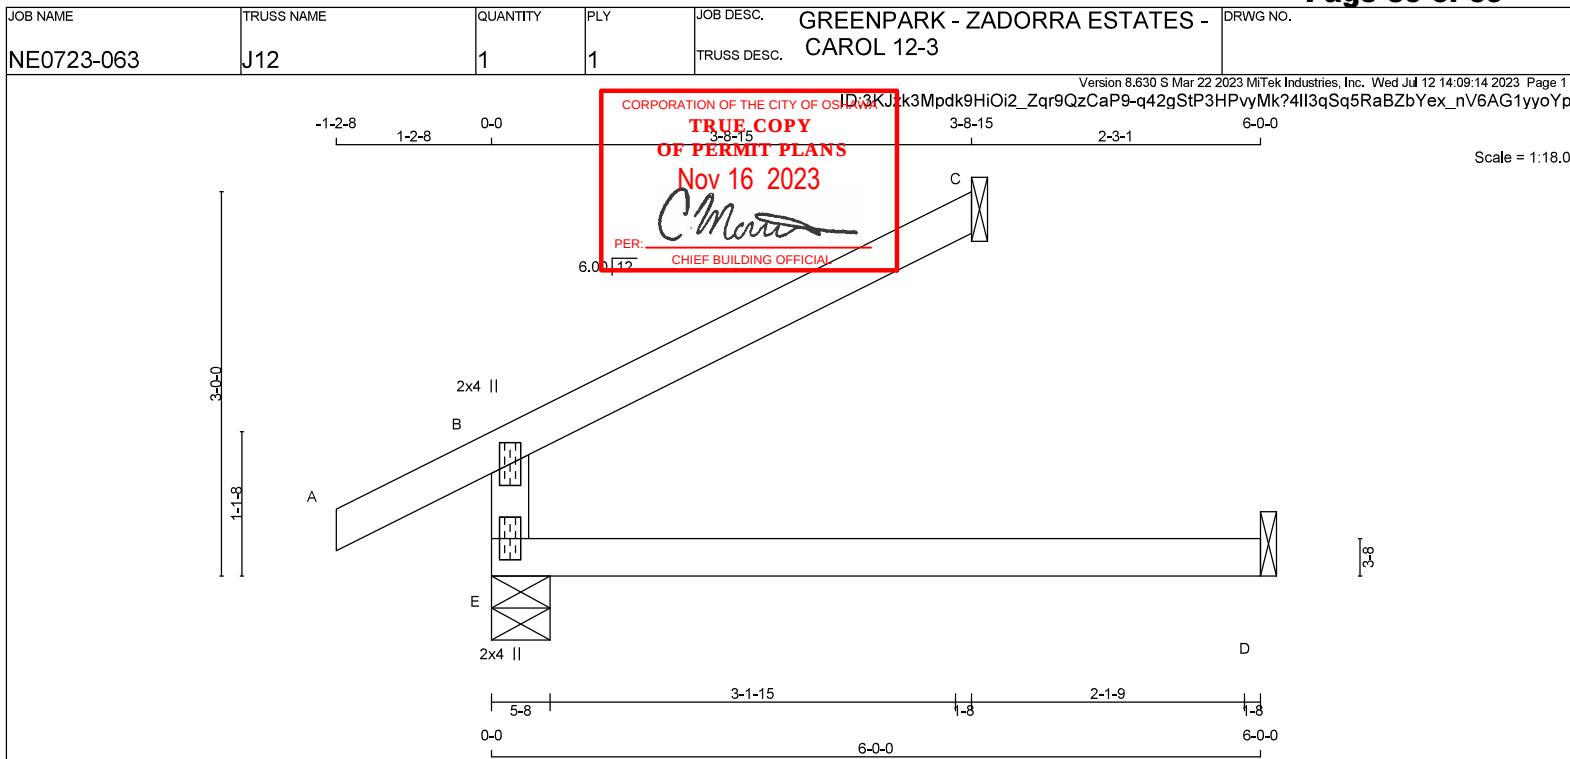

TOTAL WEIGHT = 14 lb

LUMBER

N. L. G. A. RULES	CHORDS	SIZE	LUMBER
E - B	2x4	DRY	No.2
A - C	2x4	DRY	No.2
E - D	2x4	DRY	No.2

DRY: SEASONED LUMBER.

PLATES (table is in inches)

JT	TYPE	PLATES	W	LEN	Y	X
B	TMV+p	MT20	2.0	4.0		
E	BMV1+p	MT20	2.0	4.0		

DIMENSIONS, SUPPORTS AND LOADINGS SPECIFIED BY FABRICATOR TO BE VERIFIED BY BUILDING**DESIGNER****BEARINGS**

JT	FACTORED GROSS REACTION	MAXIMUM FACTORED GROSS REACTION	INPUT BRG	REQRD BRG
E	496	496	5-8	1-8
C	168	168	1-8	1-8
D	45	50	1-8	1-8

SEE MITEK STANDARD DETAIL MSD2015-H FOR CONNECTION TO JOINT(S) C, D

UNFACTORED REACTIONS

JT	1ST CASE	MAX./MIN. COMPONENT REACTIONS	SNOW	LIVE	PERM. LIVE	WIND	DEAD	SOIL
E	346	252 / 0	0 / 0	0 / 0	0 / 0	95 / 0	0 / 0	0 / 0
C	115	98 / 0	0 / 0	0 / 0	0 / 0	17 / 0	0 / 0	0 / 0
D	36	0 / 0	0 / 0	0 / 0	0 / 0	36 / 0	0 / 0	0 / 0

BEARING MATERIAL TO BE SPF NO.2 OR BETTER AT JOINT(S) E, C

BRACING

TOP CHORD TO BE SHEATHED OR MAX. PURLIN SPACING = 6.25 FT.

MAX. UNBRACED BOTTOM CHORD LENGTH = 10.00 FT OR RIGID CEILING DIRECTLY APPLIED.

ALL PITCH BREAKS AND PERIMETER CORNER JOINTS MUST BE LATERALLY RESTRAINED.

LOADING

TOTAL LOAD CASES: (4)

MEMB.	CHORDS	MAX. FACTORED FORCE (LBS)	FACTORED VERT. LOAD (PLF)	MAX. UNBRACED LENGTH (LC)	MEMB.	WEBS	MAX. FACTORED FORCE (LBS)	MAX. UNBRACED LENGTH (LC)
FR-TO					FR-TO			
E-B	-431 / 0	0.0	0.0	0.11 (4)	7.81			
A-B	0 / 34	-119.4	-119.4	0.14 (1)	10.00			
B-C	-25 / 0	-119.4	-119.4	0.22 (1)	6.25			
E-D	0 / 0	-18.2	-18.2	0.14 (4)	10.00			

DESIGN CRITERIA**SPECIFIED LOADS:**

TOP CH.	LL	=	34.8	PSF
	DL	=	6.0	PSF
BOT CH.	LL	=	0.0	PSF
	DL	=	7.3	PSF
TOTAL LOAD	=	48.1	PSF	

SPACING = 24.0 IN./C/C

THIS TRUSS IS DESIGNED FOR RESIDENTIAL OR SMALL BUILDING REQUIREMENTS OF PART 9, NBCC 2015

THIS DESIGN COMPLIES WITH:

- PART 9 OF BCBC 2018, NBC-2019AE
- PART 9 OF OBC 2012 (2019 AMENDMENT)
- CSA 086-14
- TPIC 2014

DESIGN ASSUMPTIONS

-OVERHANG NOT TO BE ALTERED OR CUT OFF.

(55 % OF 48.1 P.S.F., G.S.L. PLUS 8.4 P.S.F. RAIN LOAD) EQUALS 34.8 P.S.F. SPECIFIED ROOF LIVE LOAD

ALLOWABLE DEFL.(LL)= L/360 (0.20")

CALCULATED VERT. DEFL.(LL) = L/ 999 (0.00")

ALLOWABLE DEFL.(TL)= L/360 (0.20")

CALCULATED VERT. DEFL.(TL) = L/ 999 (0.03")

CSI: TC=0.22/0.97 (B-C:1) , BC=0.14/0.97 (D-E:4) , WB=0.00/0.97 (n/a:0) , SSH=0.19/1.00 (B-C:1)

DOL LUMBER=1.00 NAIL=1.00 LS BEND=1.10 COMP=1.10

SHEAR=1.10 TENS=1.10

COMPANION LIVE LOAD FACTOR = 1.00

TRUSS PLATE MANUFACTURER IS NOT RESPONSIBLE FOR QUALITY CONTROL IN THE TRUSS MANUFACTURING PLANT.

NAIL VALUES

PLATE	GRIP(DRY)	SHEAR	SECTION
	(PL)	(PL)	(PL)
MT20	650	371	1747
		788	1987
			1873

PLATE PLACEMENT TOL. = 0.250 inches

PLATE ROTATION TOL. = 5.0 Deg.


JSI GRIP= 0.24 (B) (INPUT = 0.90)

JSI METAL= 0.18 (B) (INPUT = 1.00)



READ ALL NOTES ON THIS PAGE AND ON THE ENGINEERING NOTES: TRUSSES. THE NOTE PAGE IS AN INTEGRAL PART OF THIS DRAWING AS IT CONTAINS SPECIFICATIONS AND CRITERIA USED IN THE DESIGN OF THIS COMPONENT.



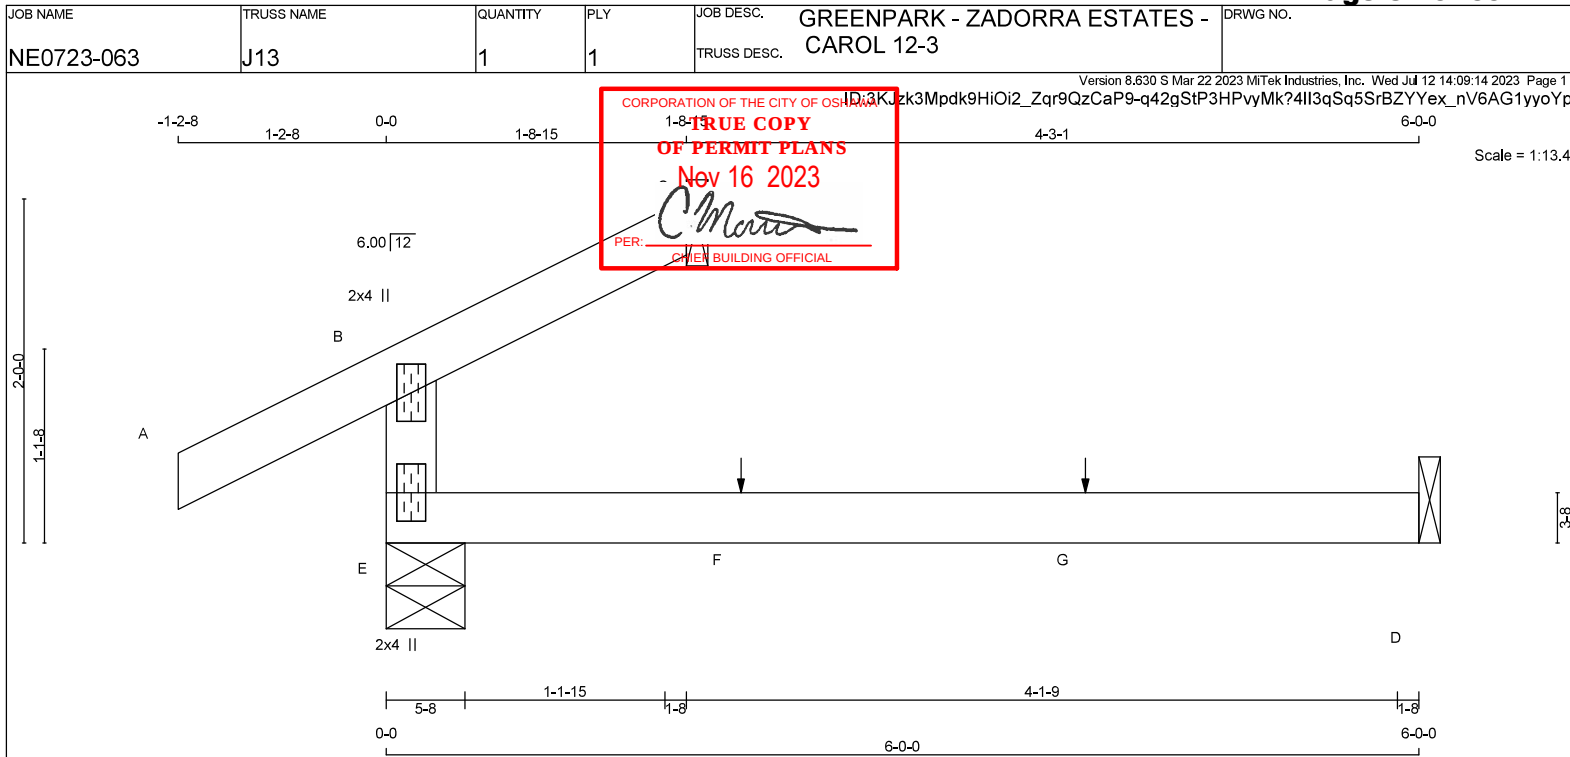

TOTAL WEIGHT = 12 lb

LUMBER

N. L. G. A. RULES	CHORDS	SIZE	LUMBER
E - B	2x4	DRY	No.2
A - C	2x4	DRY	No.2
E - D	2x4	DRY	No.2

DRY: SEASONED LUMBER.

PLATES (table is in inches)

JT	TYPE	PLATES	W	LEN	Y	X
B	TMV+p	MT20	2.0	4.0		
E	BMV1+p	MT20	2.0	4.0		

DIMENSIONS, SUPPORTS AND LOADINGS SPECIFIED BY FABRICATOR TO BE VERIFIED BY BUILDING**DESIGNER**

JT	VERT	HORZ	DOWN	HORZ	UPLIFT	IN-SX	IN-SX
E	343	0	343	0	0	5-8	1-8
C	82	0	82	0	0	1-8	1-8
D	45	0	52	0	0	1-8	1-8

SEE MITEK STANDARD DETAIL MSD2015-H FOR CONNECTION TO JOINT(S) C, D

UNFACTORED REACTIONS

JT	COMBINED	SNOW	LIVE	PERM.LIVE	WIND	DEAD	SOIL
E	239	179 / 0	0 / 0	0 / 0	0 / 0	59 / 0	0 / 0
C	59	32 / 0	0 / 0	0 / 0	0 / 0	27 / 0	0 / 0
D	36	0 / -1	0 / 0	0 / 0	0 / 0	37 / 0	0 / 0

BEARING MATERIAL TO BE SPF NO.2 OR BETTER AT JOINT(S) E, C

BRACINGTOP CHORD TO BE SHEATHED OR MAX. PURLIN SPACING = 6.25 FT.
MAX. UNBRACED BOTTOM CHORD LENGTH = 10.00 FT OR RIGID CEILING DIRECTLY APPLIED.

ALL PITCH BREAKS AND PERIMETER CORNER JOINTS MUST BE LATERALLY RESTRAINED.

LOADING

TOTAL LOAD CASES: (4)

MEMB.	MAX. FACTORED FORCE (LBS)	FACTORED VERT. LOAD (PLF)	MAX. LC1 (LC)	MAX. UNBRACED LENGTH FR-TO	MEMB.	MAX. FACTORED FORCE (LBS)	MAX. LC1 (LC)
FR-TO							
E-B	-279 / 0	0.0	0.0	0.09 (4)	7.81		
A-B	0 / 34	-119.4	-119.4	0.14 (1)	10.00		
B-C	-10 / 10	-119.4	-119.4	0.09 (4)	6.25		
E-F	0 / 0	-18.2	-18.2	0.14 (4)	10.00		
F-G	0 / 0	-18.2	-18.2	0.14 (4)	10.00		
G-D	0 / 0	-18.2	-18.2	0.14 (4)	10.00		

SPECIFIED CONCENTRATED LOADS (LBS)

JT	LOC.	LC1	MAX.	FACE	DIR.	TYPE	HEEL	CONN.
F	2-0-12	1	1	—	BACK	VERT	TOTAL	—
G	4-0-12	1	1	—	BACK	VERT	TOTAL	C1

CONNECTION REQUIREMENTS

- 1) C1: A SUITABLE HANGER/MECHANICAL CONNECTION IS REQUIRED.

DESIGN CRITERIA

*** SPECIAL LOADS ANALYSIS ***
GEOMETRY AND/OR BASIC LOADS CHANGED BY USER.
LOADS WERE DERIVED FROM USER INPUT
NO FURTHER MODIFICATIONS WERE MADE

SPECIFIED LOADS:

TOP CH.	LL =	34.8	PSF
	DL =	6.0	PSF
BOT CH.	LL =	0.0	PSF
	DL =	7.3	PSF
TOTAL LOAD	=	48.1	PSF

SPACING = 24.0 IN. C/C

*** NON STANDARD GIRDER ***

ADDTL USER-DEFINED LOADS APPLIED TO ALL LOAD CASES.

THIS TRUSS IS DESIGNED FOR RESIDENTIAL OR SMALL BUILDING REQUIREMENTS OF PART 9, NBC 2015

THIS DESIGN COMPLIES WITH:

- PART 9 OF BCBC 2018, NBC-2019AE
- PART 9 OF OBC 2012 (2019 AMENDMENT)
- CSA 086-14
- TPIC 2014

DESIGN ASSUMPTIONS

-OVERHANG NOT TO BE ALTERED OR CUT OFF.

(55% OF 48.1 P.S.F. G.S.L. PLUS 8.4 P.S.F. RAIN LOAD)
EQUALS 34.8 P.S.F. SPECIFIED ROOF LIVE LOAD

ALLOWABLE DEFL.(LL) = $L/360$ (0.20")
CALCULATED VERT. DEFL.(LL) = $L/999$ (0.00")
ALLOWABLE DEFL.(TL) = $L/360$ (0.20")
CALCULATED VERT. DEFL.(TL) = $L/999$ (0.04")

CSI: TC=0.14/0.97 (A-B:1) , BC=0.14/0.97 (D-E:4) ,
WB=0.00/0.97 (n/a:0) , SSI=0.11/1.00 (A-B:1)DOL LUMBER=1.00 NAIL=1.00 LS BEND=1.10 COMP=1.10
SHEAR=1.10 TENS=1.10

COMPANION LIVE LOAD FACTOR = 1.00

TRUSS PLATE MANUFACTURER IS NOT RESPONSIBLE FOR QUALITY CONTROL IN THE TRUSS MANUFACTURING PLANT .

NAIL VALUES

PLATE	GRIP (DRY)	SHEAR	SECTION
	(PSI)	(PLI)	(PLI)
	MAX	MIN	MAX
MT20	650	371	1747
	788	1987	1873


PLATE PLACEMENT TOL. = 0.250 inches

PLATE ROTATION TOL. = 5.0 Deg.

JSI GRIP= 0.16 (B) (INPUT = 0.90)
JSI METAL= 0.12 (B) (INPUT = 1.00)

READ ALL NOTES ON THIS PAGE AND ON THE ENGINEERING NOTES: TRUSSES. THE NOTE PAGE IS AN INTEGRAL PART OF THIS DRAWING AS IT CONTAINS SPECIFICATIONS AND CRITERIA USED IN THE DESIGN OF THIS COMPONENT.



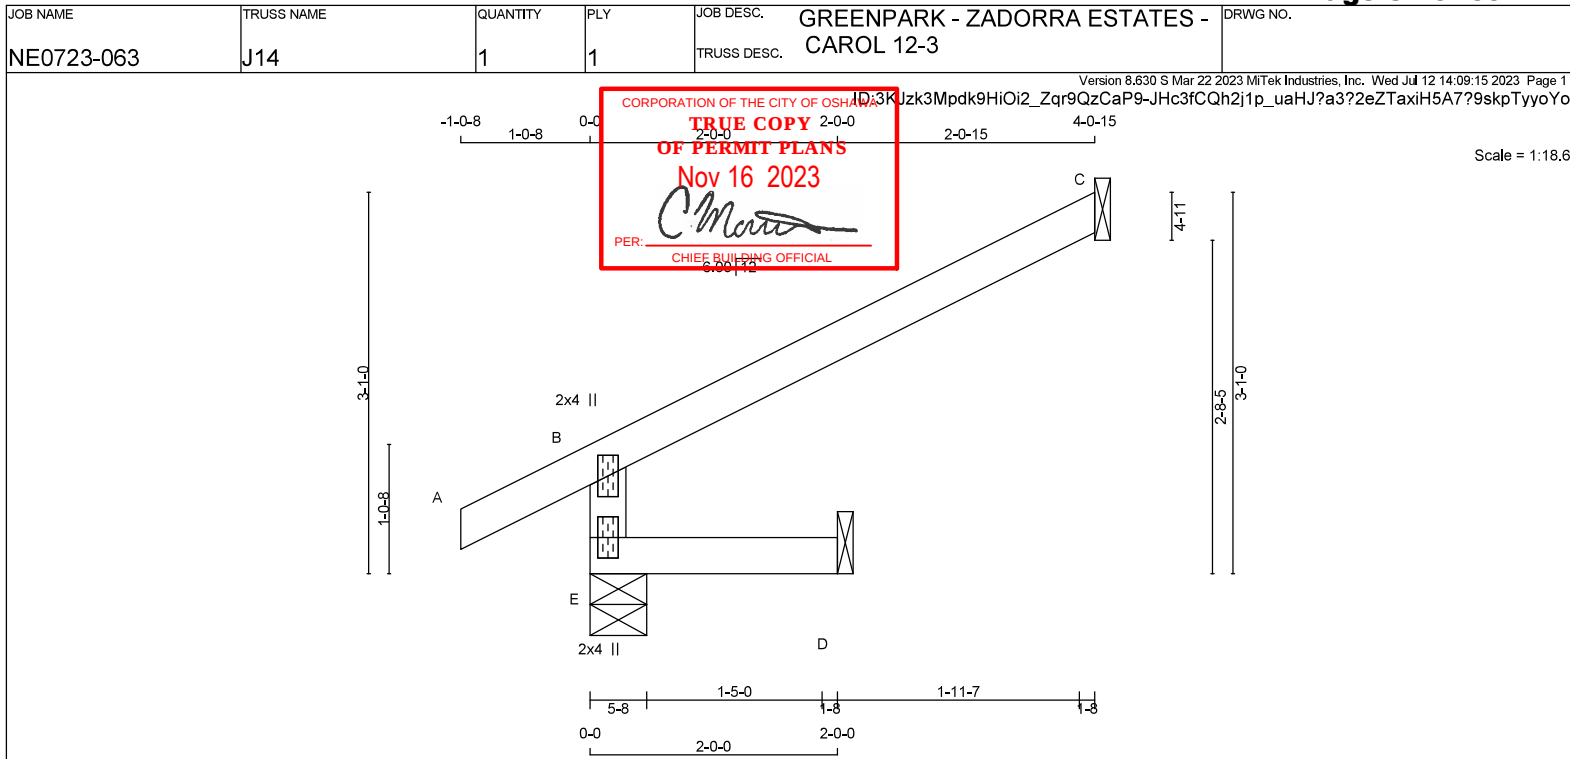

TOTAL WEIGHT = 10 lb

LUMBER

N. L. G. A. RULES	CHORDS	SIZE	LUMBER
E - B	2x4	DRY	No.2
A - C	2x4	DRY	No.2
E - D	2x4	DRY	No.2

DRY: SEASONED LUMBER.

PLATES (table is in inches)

JT	TYPE	PLATES	W	LEN	Y	X
B	TMV+p	MT20	2.0	4.0		
E	BMV1+p	MT20	2.0	4.0		

DIMENSIONS, SUPPORTS AND LOADINGS SPECIFIED BY FABRICATOR TO BE VERIFIED BY BUILDING**DESIGNER****BEARINGS**

JT	VERT	HORZ	FACTORED GROSS REACTION	MAXIMUM FACTORED GROSS REACTION	INPUT BRG	REQRD BRG
E	457	0	457	0	5-8	1-8
C	183	0	183	0	1-8	1-8
D	16	0	16	0	1-8	1-8

SEE MITEK STANDARD DETAIL MSD2015-H FOR CONNECTION TO JOINT(S) C, D

UNFACTORED REACTIONS

JT	1ST CASE	MAX./MIN. COMPONENT REACTIONS	SNOW	LIVE	PERM. LIVE	WIND	DEAD	SOIL
E	315	254 / 0	0 / 0	0 / 0	0 / 0	60 / 0	0 / 0	0 / 0
C	125	107 / 0	0 / 0	0 / 0	0 / 0	18 / 0	0 / 0	0 / 0
D	13	0 / 0	0 / 0	0 / 0	0 / 0	13 / 0	0 / 0	0 / 0

BEARING MATERIAL TO BE SPF NO.2 OR BETTER AT JOINT(S) E

BRACINGTOP CHORD TO BE SHEATHED OR MAX. PURLIN SPACING = 6.25 FT.
MAX. UNBRACED BOTTOM CHORD LENGTH = 10.00 FT. OR RIGID CEILING DIRECTLY APPLIED.

ALL PITCH BREAKS AND PERIMETER CORNER JOINTS MUST BE LATERALLY RESTRAINED.

LOADING

TOTAL LOAD CASES: (4)

MEMB.	CHORDS	MAX. FACTORED FORCE (LBS)	FACTORED VERT. LOAD (PLF)	MAX. LC1 (PLF)	MAX. UNBRACED LENGTH FR-TO	MEMB.	WEBS	MAX. FACTORED FORCE (LBS)	MAX. LC1 (LBS)
FR-TO									
E-B	-436 / 0	0.0	0.0	0.01 (4)	7.81				
A-B	0 / 30	-119.4	-119.4	0.10 (1)	10.00				
B-C	-27 / 0	-119.4	-119.4	0.34 (1)	6.25				
E-D	0 / 0	-18.2	-18.2	0.02 (4)	10.00				

DESIGN CRITERIA**SPECIFIED LOADS:**

TOP CH. LL	=	34.8	PSF
DL	=	6.0	PSF
BOT CH. LL	=	0.0	PSF
DL	=	7.3	PSF
TOTAL LOAD	=	48.1	PSF

SPACING = 24.0 IN./C

THIS TRUSS IS DESIGNED FOR RESIDENTIAL OR SMALL BUILDING REQUIREMENTS OF PART 9, NBCC 2015

THIS DESIGN COMPLIES WITH:

- PART 9 OF BCBC 2018, NBC-2019AE
- PART 9 OF OBC 2012 (2019 AMENDMENT)
- CSA 086-14
- TPIC 2014

DESIGN ASSUMPTIONS

-OVERHANG NOT TO BE ALTERED OR CUT OFF.

(55 % OF 48.1 P.S.F., G.S.L. PLUS 8.4 P.S.F. RAIN LOAD)
EQUALS 34.8 P.S.F. SPECIFIED ROOF LIVE LOADALLOWABLE DEFL.(TL) = $L/360$ (0.19")
CALCULATED VERT. DEFL.(TL) = $L/999$ (0.00")CSI: TC=0.34/0.97 (B-C:1), BC=0.02/0.97 (D-E:4),
WB=0.00/0.97 (n/a:0), SSI=0.21/1.00 (B-C:1)DOL LUMBER=1.00 NAIL=1.00 LS BEND=1.10 COMP=1.10
SHEAR=1.10 TENS= 1.10

COMPANION LIVE LOAD FACTOR = 1.00

TRUSS PLATE MANUFACTURER IS NOT RESPONSIBLE FOR QUALITY CONTROL IN THE TRUSS MANUFACTURING PLANT.

NAIL VALUES

PLATE	GRIP(DRY)	SHEAR (PSI)	SECTION (PLI)
MT20	650	371	1747
	788	1987	1873

PLATE PLACEMENT TOL. = 0.250 inches

PLATE ROTATION TOL. = 5.0 Deg.


JSI GRIP= 0.24 (B) (INPUT = 0.90)
JSI METAL= 0.18 (B) (INPUT = 1.00)

READ ALL NOTES ON THIS PAGE AND ON THE ENGINEERING NOTES: TRUSSES. THE NOTE PAGE IS AN INTEGRAL PART OF THIS DRAWING AS IT CONTAINS SPECIFICATIONS AND CRITERIA USED IN THE DESIGN OF THIS COMPONENT.



JOB NAME	TRUSS NAME	QUANTITY	PLY	JOB DESC.	GREENPARK - ZADORRA ESTATES -	DRWG NO.
NE0723-063	J16	2	1	TRUSS DESC.	CAROL 12-3	

Version 8.630 S Mar 22 2023 MiTek Industries, Inc. Wed Jul 12 14:09:16 2023 Page 1

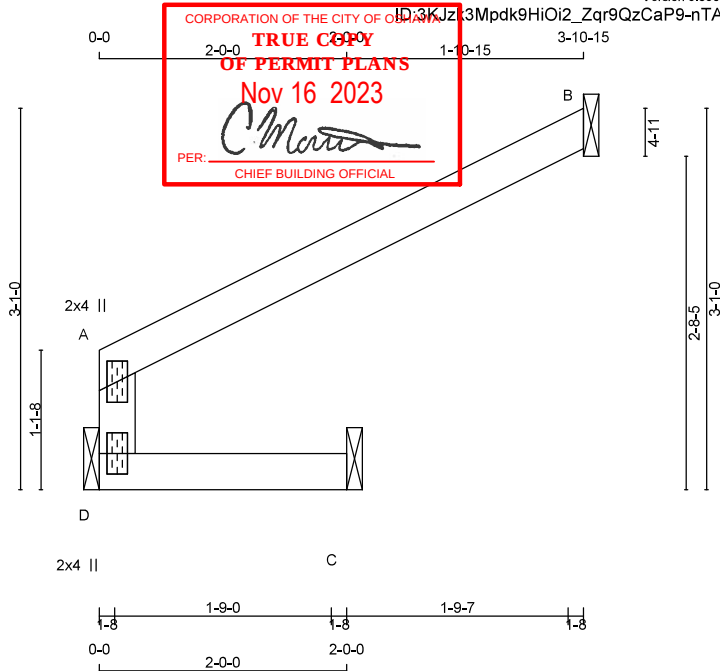

Scale = 1:18.6

TOTAL WEIGHT = 2 X 8 = 16 lb

LUMBER

N. L. G. A. RULES			
CHORDS	SIZE	LUMBER	
D - A	2x4	DRY	No.2
A - B	2x4	DRY	No.2
D - C	2x4	DRY	No.2

DRY: SEASONED LUMBER.

DESCR.
SPF
SPF
SPF**PLATES (table is in inches)**

JT	TYPE	PLATES	W	LEN	Y	X
A	TMV+p	MT20	2.0	4.0		
D	BMV1+p	MT20	2.0	4.0		

DIMENSIONS, SUPPORTS AND LOADINGS SPECIFIED BY FABRICATOR TO BE VERIFIED BY BUILDING**DESIGNER**

JT	VERT	HORZ	DOWN	HORZ	UPLIFT	IN-SX	REQD
D	225	0	225	0	0	1-8	1-8
B	205	0	205	0	0	1-8	1-8
C	74	0	74	0	0	1-8	1-8

SEE MITEK STANDARD DETAIL MSD2015-H FOR CONNECTION TO JOINT(S) D, B, C

UNFACTORED REACTIONS

JT	COMBINED	SNOW	LIVE	PERM.LIVE	WIND	DEAD	SOIL
D	156	120 / 0	0 / 0	0 / 0	0 / 0	36 / 0	0 / 0
B	140	119 / 0	0 / 0	0 / 0	0 / 0	21 / 0	0 / 0
C	52	33 / 0	0 / 0	0 / 0	0 / 0	19 / 0	0 / 0

BRACINGTOP CHORD TO BE SHEATHED OR MAX. PURLIN SPACING = 6.25 FT.
MAX. UNBRACED BOTTOM CHORD LENGTH = 10.00 FT OR RIGID CEILING DIRECTLY APPLIED.

ALL PITCH BREAKS AND PERIMETER CORNER JOINTS MUST BE Laterally RESTRAINED.

LOADING

TOTAL LOAD CASES: (4)

CHORDS				WEBS			
MEMB.	MAX. FACTORED FORCE (LBS)	FACTORED VERT. LOAD (PLF)	MAX. LC1 (LC)	MAX. UNBRACED LENGTH	MEMB.	MAX. FACTORED FORCE (LBS)	MAX. LC1 (LC)
FR-TO					FR-TO		
D-A	-262 / 0	0.0	0.0	0.13 (1)	7.81		
A-B	-13 / 0	-119.4	-119.4	0.23 (1)	6.25		
D-C	0 / 0	-18.2	-18.2	0.15 (1)	10.00		

DESIGN CRITERIA**SPECIFIED LOADS:**

TOP CH. LL	=	34.8	PSF
DL	=	6.0	PSF
BOT CH. LL	=	0.0	PSF
DL	=	7.3	PSF
TOTAL LOAD	=	48.1	PSF

SPACING = 24.0 IN./C/C

THIS TRUSS IS DESIGNED FOR RESIDENTIAL OR SMALL BUILDING REQUIREMENTS OF PART 9, NBCC 2015

THIS DESIGN COMPLIES WITH:

- PART 9 OF BCBC 2018, NBC-2019AE
- PART 9 OF OBC 2012 (2019 AMENDMENT)
- CSA 086-14
- TPIC 2014

(55 % OF 48.1 P.S.F. G.S.L. PLUS 8.4 P.S.F. RAIN LOAD)
EQUALS 34.8 P.S.F. SPECIFIED ROOF LIVE LOADALLOWABLE DEFL.(LL)= L/360 (0.19")
CALCULATED VERT. DEFL.(LL) = L/999 (0.00")
ALLOWABLE DEFL.(TL)= L/360 (0.19")
CALCULATED VERT. DEFL.(TL) = L/999 (0.01")CSI: TC=0.23/0.97 (A-B:1), BC=0.15/0.97 (C-D:1),
WB=0.00/0.97 (n/a:0), SSI=0.18/1.00 (A-B:1)DOL LUMBER=1.00 NAIL=1.00 LS BEND=1.10 COMP=1.10
SHEAR=1.10 TENS= 1.10

COMPANION LIVE LOAD FACTOR = 1.00

TRUSS PLATE MANUFACTURER IS NOT RESPONSIBLE FOR QUALITY CONTROL IN THE TRUSS MANUFACTURING PLANT.

NAIL VALUES

PLATE	GRIP(DRY)	SHEAR (PSI)	SECTION (PLI)
MT20	650	371	1747
		788	1987
			1873

PLATE PLACEMENT TOL. = 0.250 inches

PLATE ROTATION TOL. = 5.0 Deg.


JSI GRIP= 0.15 (A) (INPUT = 0.90)
JSI METAL= 0.11 (A) (INPUT = 1.00)

READ ALL NOTES ON THIS PAGE AND ON THE ENGINEERING NOTES: TRUSSES. THE NOTE PAGE IS AN INTEGRAL PART OF THIS DRAWING AS IT CONTAINS SPECIFICATIONS AND CRITERIA USED IN THE DESIGN OF THIS COMPONENT.



JOB NAME	TRUSS NAME	QUANTITY	PLY	JOB DESC.	GREENPARK - ZADORRA ESTATES -	DRWG NO.
NE0723-063	J18	2	1	TRUSS DESC.	CAROL 12-3	

Version 8.630 S Mar 22 2023 MiTek Industries, Inc. Wed Jul 12 14:09:16 2023 Page 1

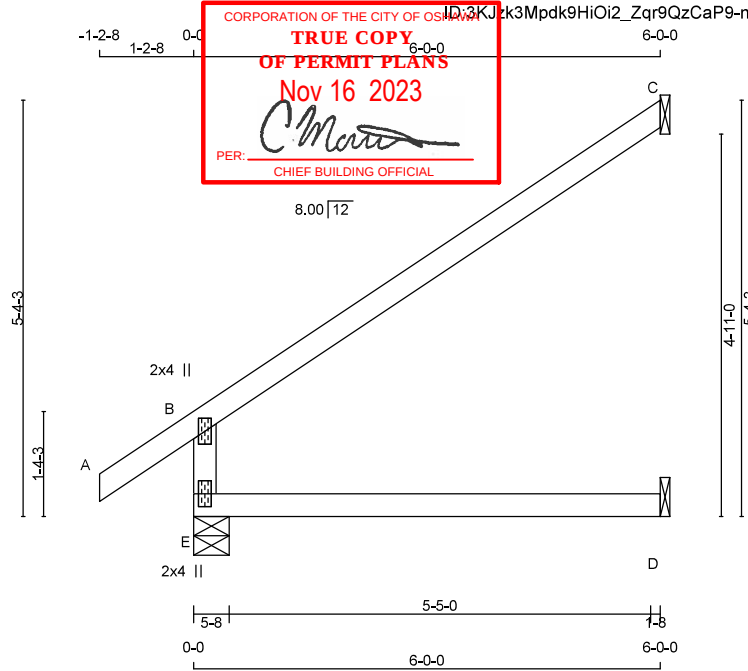

Scale = 1:29.6

TOTAL WEIGHT = 2 X 18 = 36 lb

LUMBER

N. L. G. A. RULES			
CHORDS	SIZE	LUMBER	
E - B	2x4	DRY	No.2
A - C	2x4	DRY	No.2
E - D	2x4	DRY	No.2

DRY: SEASONED LUMBER.

DESCR.
SPF
SPF
SPF**PLATES (table is in inches)**

JT	TYPE	PLATES	W	LEN	Y	X
B	TMV+p	MT20	2.0	4.0		
E	BMV1+p	MT20	2.0	4.0		

DIMENSIONS, SUPPORTS AND LOADINGS SPECIFIED BY FABRICATOR TO BE VERIFIED BY BUILDING**DESIGNER****BEARINGS**

JT	VERT	HORZ	FACTORED GROSS REACTION	MAXIMUM FACTORED GROSS REACTION	INPUT BRG	REQRD BRG
E	666	0	666	0	5-8	1-8
C	269	0	269	0	1-8	1-8
D	46	0	51	0	1-8	1-8

SEE MITEK STANDARD DETAIL MSD2015-H FOR CONNECTION TO JOINT(S) C, D

UNFACTORED REACTIONS

JT	1ST LCASE	COMBINED	SNOW	LIVE	PERM.LIVE	WIND	DEAD	SOIL
E	462	351 / 0	0 / 0	0 / 0	0 / 0	111 / 0	0 / 0	0 / 0
C	184	157 / 0	0 / 0	0 / 0	0 / 0	27 / 0	0 / 0	0 / 0
D	37	0 / 0	0 / 0	0 / 0	0 / 0	37 / 0	0 / 0	0 / 0

BEARING MATERIAL TO BE SPF NO.2 OR BETTER AT JOINT(S) E

BRACING

TOP CHORD TO BE SHEATHED OR MAX. PURLIN SPACING = 6.25 FT.

MAX. UNBRACED BOTTOM CHORD LENGTH = 10.00 FT OR RIGID CEILING DIRECTLY APPLIED.

ALL PITCH BREAKS AND PERIMETER CORNER JOINTS MUST BE LATERALLY RESTRAINED.

LOADING

TOTAL LOAD CASES: (4)

MEMB.	MAX. FACTORED FORCE (LBS)	FACTORED VERT. LOAD (PLF)	MAX. UNBRACED LENGTH (LC)	MAX. FACTORED FORCE (LBS)	MAX. FACTORED VERT. LOAD (PLF)
FR-TO					
E-B	-602 / 0	0.0	0.0	7.81	0.11 (4)
A-B	0 / 43	-119.4	-119.4	10.00	0.14 (1)
B-C	-50 / 0	-119.4	-119.4	6.25	0.56 (1)
E-D	0 / 0	-18.2	-18.2	10.00	0.13 (4)

DESIGN CRITERIA**SPECIFIED LOADS:**

TOP CH.	LL	=	34.8	PSF
	DL	=	6.0	PSF
BOT CH.	LL	=	0.0	PSF
	DL	=	7.3	PSF
TOTAL LOAD		=	48.1	PSF

SPACING = 24.0 IN./C

THIS TRUSS IS DESIGNED FOR RESIDENTIAL OR SMALL BUILDING REQUIREMENTS OF PART 9, NBCC 2015

THIS DESIGN COMPLIES WITH:

- PART 9 OF BCBC 2018, NBC-2019AE
- PART 9 OF OBC 2012 (2019 AMENDMENT)
- CSA 086-14
- TPIC 2014

DESIGN ASSUMPTIONS

-OVERHANG NOT TO BE ALTERED OR CUT OFF.

(55 % OF 48.1 P.S.F., G.S.L. PLUS 8.4 P.S.F. RAIN LOAD) EQUALS 34.8 P.S.F. SPECIFIED ROOF LIVE LOAD

ALLOWABLE DEFL.(LL)= L/360 (0.20")
 CALCULATED VERT. DEFL.(LL) = L/ 999 (0.00")
 ALLOWABLE DEFL.(TL)= L/360 (0.20")
 CALCULATED VERT. DEFL.(TL) = L/ 999 (0.04")

CSI: TC=0.56/0.97 (B-C:1) , BC=0.13/0.97 (D-E:4) ,
 WB=0.00/0.97 (n/a:0) , SSH=0.29/1.00 (B-C:1)

DOL LUMBER=1.00 NAIL=1.00 LS BEND=1.10 COMP=1.10
 SHEAR=1.10 TENS=1.10

COMPANION LIVE LOAD FACTOR = 1.00

TRUSS PLATE MANUFACTURER IS NOT RESPONSIBLE FOR QUALITY CONTROL IN THE TRUSS MANUFACTURING PLANT.

NAIL VALUES

PLATE	GRIP(DRY)	SHEAR	SECTION
	(PL)	(PL)	(PL)
MT20	650	371	1747
		788	1987
			1873

PLATE PLACEMENT TOL. = 0.250 inches

PLATE ROTATION TOL. = 5.0 Deg.


JSI GRIP= 0.37 (B) (INPUT = 0.90)

JSI METAL = 0.31 (B) (INPUT = 1.00)




READ ALL NOTES ON THIS PAGE AND ON THE
 ENGINEERING NOTES: TRUSSES. THE NOTE PAGE
 IS AN INTEGRAL PART OF THIS DRAWING AS IT
 CONTAINS SPECIFICATIONS AND CRITERIA USED
 IN THE DESIGN OF THIS COMPONENT.



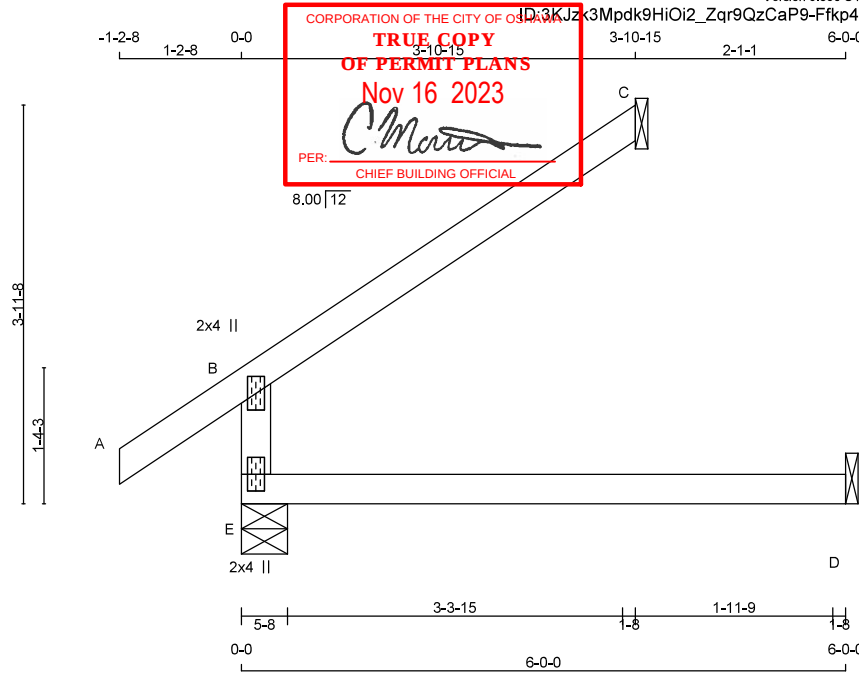

JOB NAME	TRUSS NAME	QUANTITY	PLY	JOB DESC.	GREENPARK - ZADORRA ESTATES -	DRWG NO.
NE0723-063	J20	2	1	TRUSS DESC.	CAROL 12-3	

Version 8.630 S Mar 22 2023 MiTek Industries, Inc. Wed Jul 12 14:09:17 2023 Page 1

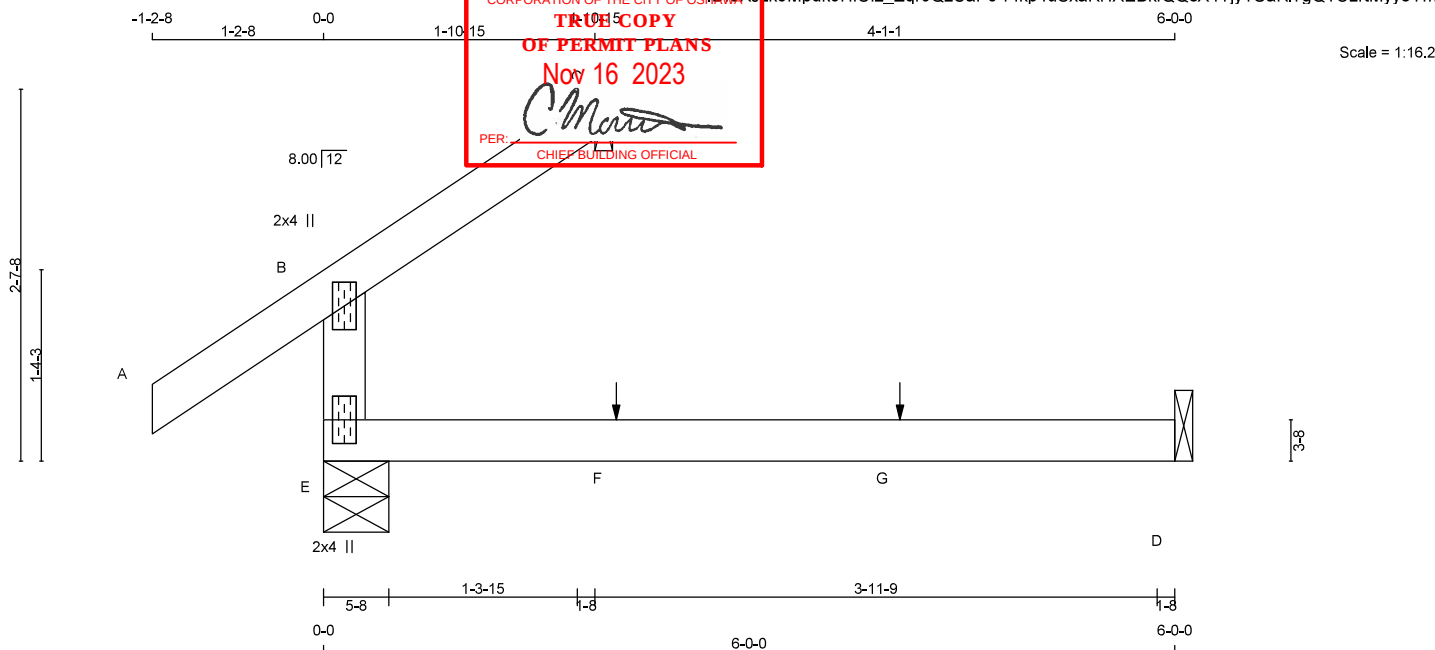

TOTAL WEIGHT = 2 X 12 = 25 lb

LUMBER

N. L. G. A. RULES				
CHORDS	SIZE	LUMBER		
E - B	2x4	DRY	No.2	
A - C	2x4	DRY	No.2	
E - D	2x4	DRY	No.2	

DRY: SEASONED LUMBER.

PLATES (table is in inches)

JT	TYPE	PLATES	W	LEN	Y	X
B	TMV+p	MT20	2.0	4.0		
E	BMV1+p	MT20	2.0	4.0		

DIMENSIONS, SUPPORTS AND LOADINGS SPECIFIED BY FABRICATOR TO BE VERIFIED BY BUILDING**DESIGNER**

	FACTORED	MAXIMUM	FACTORED	INPUT	REQD
	GROSS REACTION	GROSS REACTION		BRG	BRG
JT	VERT	HORZ	DOWN	HORZ	UPLIFT
E	360	0	360	0	0
C	86	0	86	0	0
D	46	0	51	0	0

SEE MITEK STANDARD DETAIL MSD2015-H FOR CONNECTION TO JOINT(S) C, D

UNFACTORED REACTIONS

JT	COMBINED	SNOW	LIVE	PERM.LIVE	WIND	DEAD	SOIL
E	253	172 / 0	0 / 0	0 / 0	0 / 0	81 / 0	0 / 0
C	59	50 / 0	0 / 0	0 / 0	0 / 0	9 / 0	0 / 0
D	37	0 / 0	0 / 0	0 / 0	0 / 0	37 / 0	0 / 0

BEARING MATERIAL TO BE SPF NO.2 OR BETTER AT JOINT(S) E, C

BRACINGTOP CHORD TO BE SHEATHED OR MAX. PURLIN SPACING = 6.25 FT.
MAX. UNBRACED BOTTOM CHORD LENGTH = 10.00 FT OR RIGID CEILING DIRECTLY APPLIED.

ALL PITCH BREAKS AND PERIMETER CORNER JOINTS MUST BE LATERALLY RESTRAINED.

LOADING

TOTAL LOAD CASES: (4)

MEMB.	MAX. FACTORED FORCE (LBS)	FACTORED VERT. LOAD (PLF)	MAX. LC1 (LC)	MAX. UNBRACED LENGTH (FT)	MEMB.	MAX. FACTORED FORCE (LBS)	MAX. UNBRACED LENGTH (FT)
FR-TO		FROM	TO		FR-TO		
E-B	-296 / 0	0.0	0.0	0.11 (4)	7.81		
A-B	0 / 43	-119.4	-119.4	0.14 (1)	10.00		
B-C	-15 / 0	-119.4	-119.4	0.06 (1)	6.25		
E-F	0 / 0	-18.2	-18.2	0.13 (4)	10.00		
F-G	0 / 0	-18.2	-18.2	0.13 (4)	10.00		
G-D	0 / 0	-18.2	-18.2	0.13 (4)	10.00		

SPECIFIED CONCENTRATED LOADS (LBS)

JT	LOC.	LC1	MAX.	MAX+	FACE	DIR.	TYPE	HEEL	CONN.
F	2-0-12	1	1	—	FRONT	VERT	TOTAL	—	C1
G	4-0-12	1	1	—	FRONT	VERT	TOTAL	—	C1

CONNECTION REQUIREMENTS

- 1) C1: A SUITABLE HANGER/MECHANICAL CONNECTION IS REQUIRED.

DESIGN CRITERIA

*** SPECIAL LOADS ANALYSIS ***
GEOMETRY AND/OR BASIC LOADS CHANGED BY USER.
LOADS WERE DERIVED FROM USER INPUT
NO FURTHER MODIFICATIONS WERE MADE

SPECIFIED LOADS:

TOP CH.	LL	=	34.8	PSF
	DL	=	6.0	PSF
BOT CH.	LL	=	0.0	PSF
	DL	=	7.3	PSF
TOTAL LOAD	=	48.1	PSF	

SPACING = 24.0 IN. C/C

*** NON STANDARD GIRDER ***
ADDTL USER-DEFINED LOADS APPLIED TO ALL LOAD CASES.

THIS TRUSS IS DESIGNED FOR RESIDENTIAL OR SMALL BUILDING REQUIREMENTS OF PART 9, NBCC 2015

THIS DESIGN COMPLIES WITH:

- PART 9 OF BCBC 2018, NBC-2019AE
- PART 9 OF OBC 2012 (2019 AMENDMENT)
- CSA 086-14
- TPIC 2014

DESIGN ASSUMPTIONS

-OVERHANG NOT TO BE ALTERED OR CUT OFF.

(55' OF 48.1 P.S.F. G.S.L. PLUS 8.4 P.S.F. RAIN LOAD)
EQUALS 34.8 P.S.F. SPECIFIED ROOF LIVE LOAD

ALLOWABLE DEFL.(LL) = L/360 (0.20")
CALCULATED VERT. DEFL.(LL) = L/999 (0.00")
ALLOWABLE DEFL.(TL) = L/360 (0.20")
CALCULATED VERT. DEFL.(TL) = L/999 (0.04")

CSI: TC=0.14/0.97 (A-B:1), BC=0.13/0.97 (D-E:4),
WB=0.00/0.97 (n/a:0), SSI=0.10/1.00 (A-B:1)DOL LUMBER=1.00 NAIL=1.00 LS BEND=1.10 COMP=1.10
SHEAR=1.10 TENS=1.10

COMPANION LIVE LOAD FACTOR = 1.00

TRUSS PLATE MANUFACTURER IS NOT RESPONSIBLE FOR QUALITY CONTROL IN THE TRUSS MANUFACTURING PLANT.

NAIL VALUES

PLATE	GRIP (DRY)	SHEAR	SECTION
(PSI)	(PLI)	(PLI)	(PLI)
MAX	MIN	MAX	MIN
MT20	650	371	1747
		788	1987
			1873

PLATE PLACEMENT TOL. = 0.250 inches

PLATE ROTATION TOL. = 5.0 Deg.


JSI GRIP= 0.18 (B) (INPUT = 0.90)
JSI METAL= 0.15 (B) (INPUT = 1.00)

READ ALL NOTES ON THIS PAGE AND ON THE
ENGINEERING NOTES: TRUSSES. THE NOTE PAGE
IS AN INTEGRAL PART OF THIS DRAWING AS IT
CONTAINS SPECIFICATIONS AND CRITERIA USED
IN THE DESIGN OF THIS COMPONENT.



JOB NAME	TRUSS NAME	QUANTITY	PLY	JOB DESC.	GREENPARK - ZADORRA ESTATES -	DRWG NO.
NE0723-063	J21	2	1	TRUSS DESC.	CAROL 12-3	

Version 8.630 S Mar 22 2023 MiTek Industries, Inc. Wed Jul 12 14:09:18 2023 Page 1

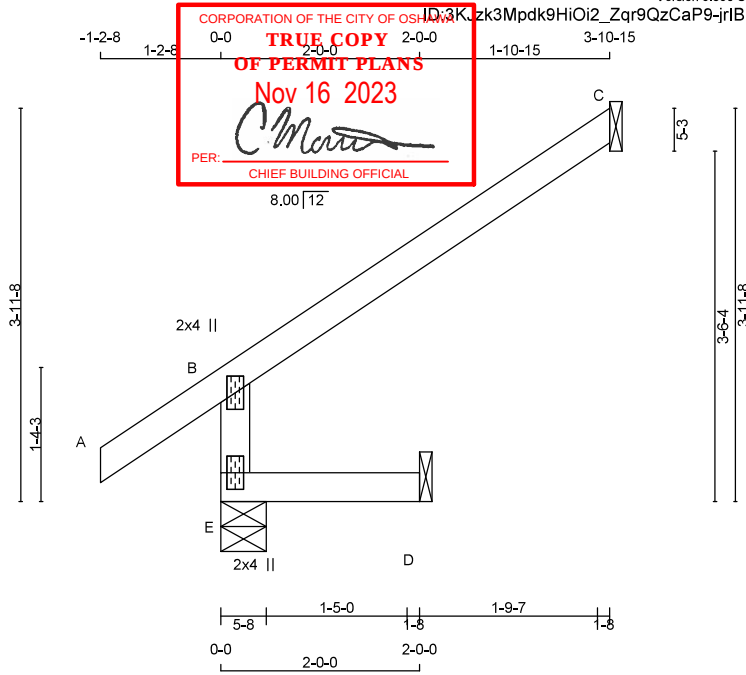

Scale = 1:23.2

TOTAL WEIGHT = 2 X 11 = 21 lb

LUMBER

N. L. G. A. RULES			
CHORDS	SIZE	LUMBER	
E - B	2x4	DRY	No.2
A - C	2x4	DRY	No.2
E - D	2x4	DRY	No.2

DRY: SEASONED LUMBER.

DESCR.
SPF
SPF
SPF**PLATES (table is in inches)**

JT	TYPE	PLATES	W	LEN	Y	X
B	TMV+p	MT20	2.0	4.0		
E	BMV1+p	MT20	2.0	4.0		

DIMENSIONS, SUPPORTS AND LOADINGS SPECIFIED BY FABRICATOR TO BE VERIFIED BY BUILDING**DESIGNER**

	FACTORED	MAXIMUM FACTORED	INPUT	REQRD
	GROSS REACTION	GROSS REACTION	BRG	BRG
JT	VERT	HORZ	DOWN	HORZ
E	466	0	466	0
C	175	0	175	0
D	16	0	16	0

SEE MITEK STANDARD DETAIL MSD2015-H FOR CONNECTION TO JOINT(S) C, D

UNFACTORED REACTIONS

JT	1ST CASE	MAX./MIN. COMPONENT REACTIONS	SNOW	LIVE	PERM. LIVE	WIND	DEAD	SOIL
E	321	260 / 0	0 / 0	0 / 0	0 / 0	61 / 0	0 / 0	0 / 0
C	120	102 / 0	0 / 0	0 / 0	0 / 0	18 / 0	0 / 0	0 / 0
D	13	0 / 0	0 / 0	0 / 0	0 / 0	13 / 0	0 / 0	0 / 0

BEARING MATERIAL TO BE SPF NO.2 OR BETTER AT JOINT(S) E

BRACINGTOP CHORD TO BE SHEATHED OR MAX. PURLIN SPACING = 6.25 FT.
MAX. UNBRACED BOTTOM CHORD LENGTH = 10.00 FT OR RIGID CEILING DIRECTLY APPLIED.

ALL PITCH BREAKS AND PERIMETER CORNER JOINTS MUST BE LATERALLY RESTRAINED.

LOADING

TOTAL LOAD CASES: (4)

MEMB.	MAX. FACTORED FORCE (LBS)	FACTORED VERT. LOAD (PLF)	MAX. VERT. LOAD (LBS)	MAX. HORIZ. LOAD (LBS)	MAX. UNBRACED LENGTH (FT)	MEMB.	MAX. FACTORED FORCE (LBS)	MAX. HORIZ. LOAD (LBS)
FR-TO						FR-TO		
E-B	-446 / 0	0.0	0.0	0.01 (4)	7.81	E-B	-446 / 0	0.0
A-B	0 / 43	-119.4	-119.4	0.14 (1)	10.00	A-B	0 / 43	-119.4
B-C	-32 / 0	-119.4	-119.4	0.31 (1)	6.25	B-C	-32 / 0	-119.4
E-D	0 / 0	-18.2	-18.2	0.02 (4)	10.00	E-D	0 / 0	-18.2

DESIGN CRITERIASPECIFIED LOADS:
TOP CH. LL = 34.8 PSF
DL = 6.0 PSF
BOT CH. LL = 0.0 PSF
DL = 7.3 PSF
TOTAL LOAD = 48.1 PSF**SPACING = 24.0 IN. C/C**

THIS TRUSS IS DESIGNED FOR RESIDENTIAL OR SMALL BUILDING REQUIREMENTS OF PART 9, NBCC 2015

THIS DESIGN COMPLIES WITH:

- PART 9 OF BCBC 2018, NBC-2019AE
- PART 9 OF OBC 2012 (2019 AMENDMENT)
- CSA 086-14
- TPIC 2014

DESIGN ASSUMPTIONS

-OVERHANG NOT TO BE ALTERED OR CUT OFF.

(55 % OF 48.1 P.S.F. G.S.L. PLUS 8.4 P.S.F. RAIN LOAD)
EQUALS 34.8 P.S.F. SPECIFIED ROOF LIVE LOADALLOWABLE DEFL.(LL)= L/360 (0.19")
CALCULATED VERT. DEFL.(LL) = L/ 999 (0.00")
ALLOWABLE DEFL.(TL)= L/360 (0.19")
CALCULATED VERT. DEFL.(TL) = L/ 999 (0.00")CSI: TC=0.31/0.97 (B-C:1) , BC=0.02/0.97 (D-E:4) ,
WB=0.00/0.97 (n/a:0) , SSH=0.19/1.00 (B-C:1)DOL LUMBER=1.00 NAIL=1.00 LS BEND=1.10 COMP=1.10
SHEAR=1.10 TENS=1.10

COMPANION LIVE LOAD FACTOR = 1.00

TRUSS PLATE MANUFACTURER IS NOT RESPONSIBLE FOR QUALITY CONTROL IN THE TRUSS MANUFACTURING PLANT.

NAIL VALUES
PLATE GRIP(DRY) SHEAR SECTION
(PL) (PL)
MAX MIN MAX MIN MAX MIN
MT20 650 371 1747 788 1987 1873

PLATE PLACEMENT TOL. = 0.250 inches

PLATE ROTATION TOL. = 5.0 Deg.

JSI GRIP= 0.27 (B) (INPUT = 0.90)
JSI METAL = 0.23 (B) (INPUT = 1.00)

READ ALL NOTES ON THIS PAGE AND ON THE ENGINEERING NOTES: TRUSSES. THE NOTE PAGE IS AN INTEGRAL PART OF THIS DRAWING AS IT CONTAINS SPECIFICATIONS AND CRITERIA USED IN THE DESIGN OF THIS COMPONENT.

