


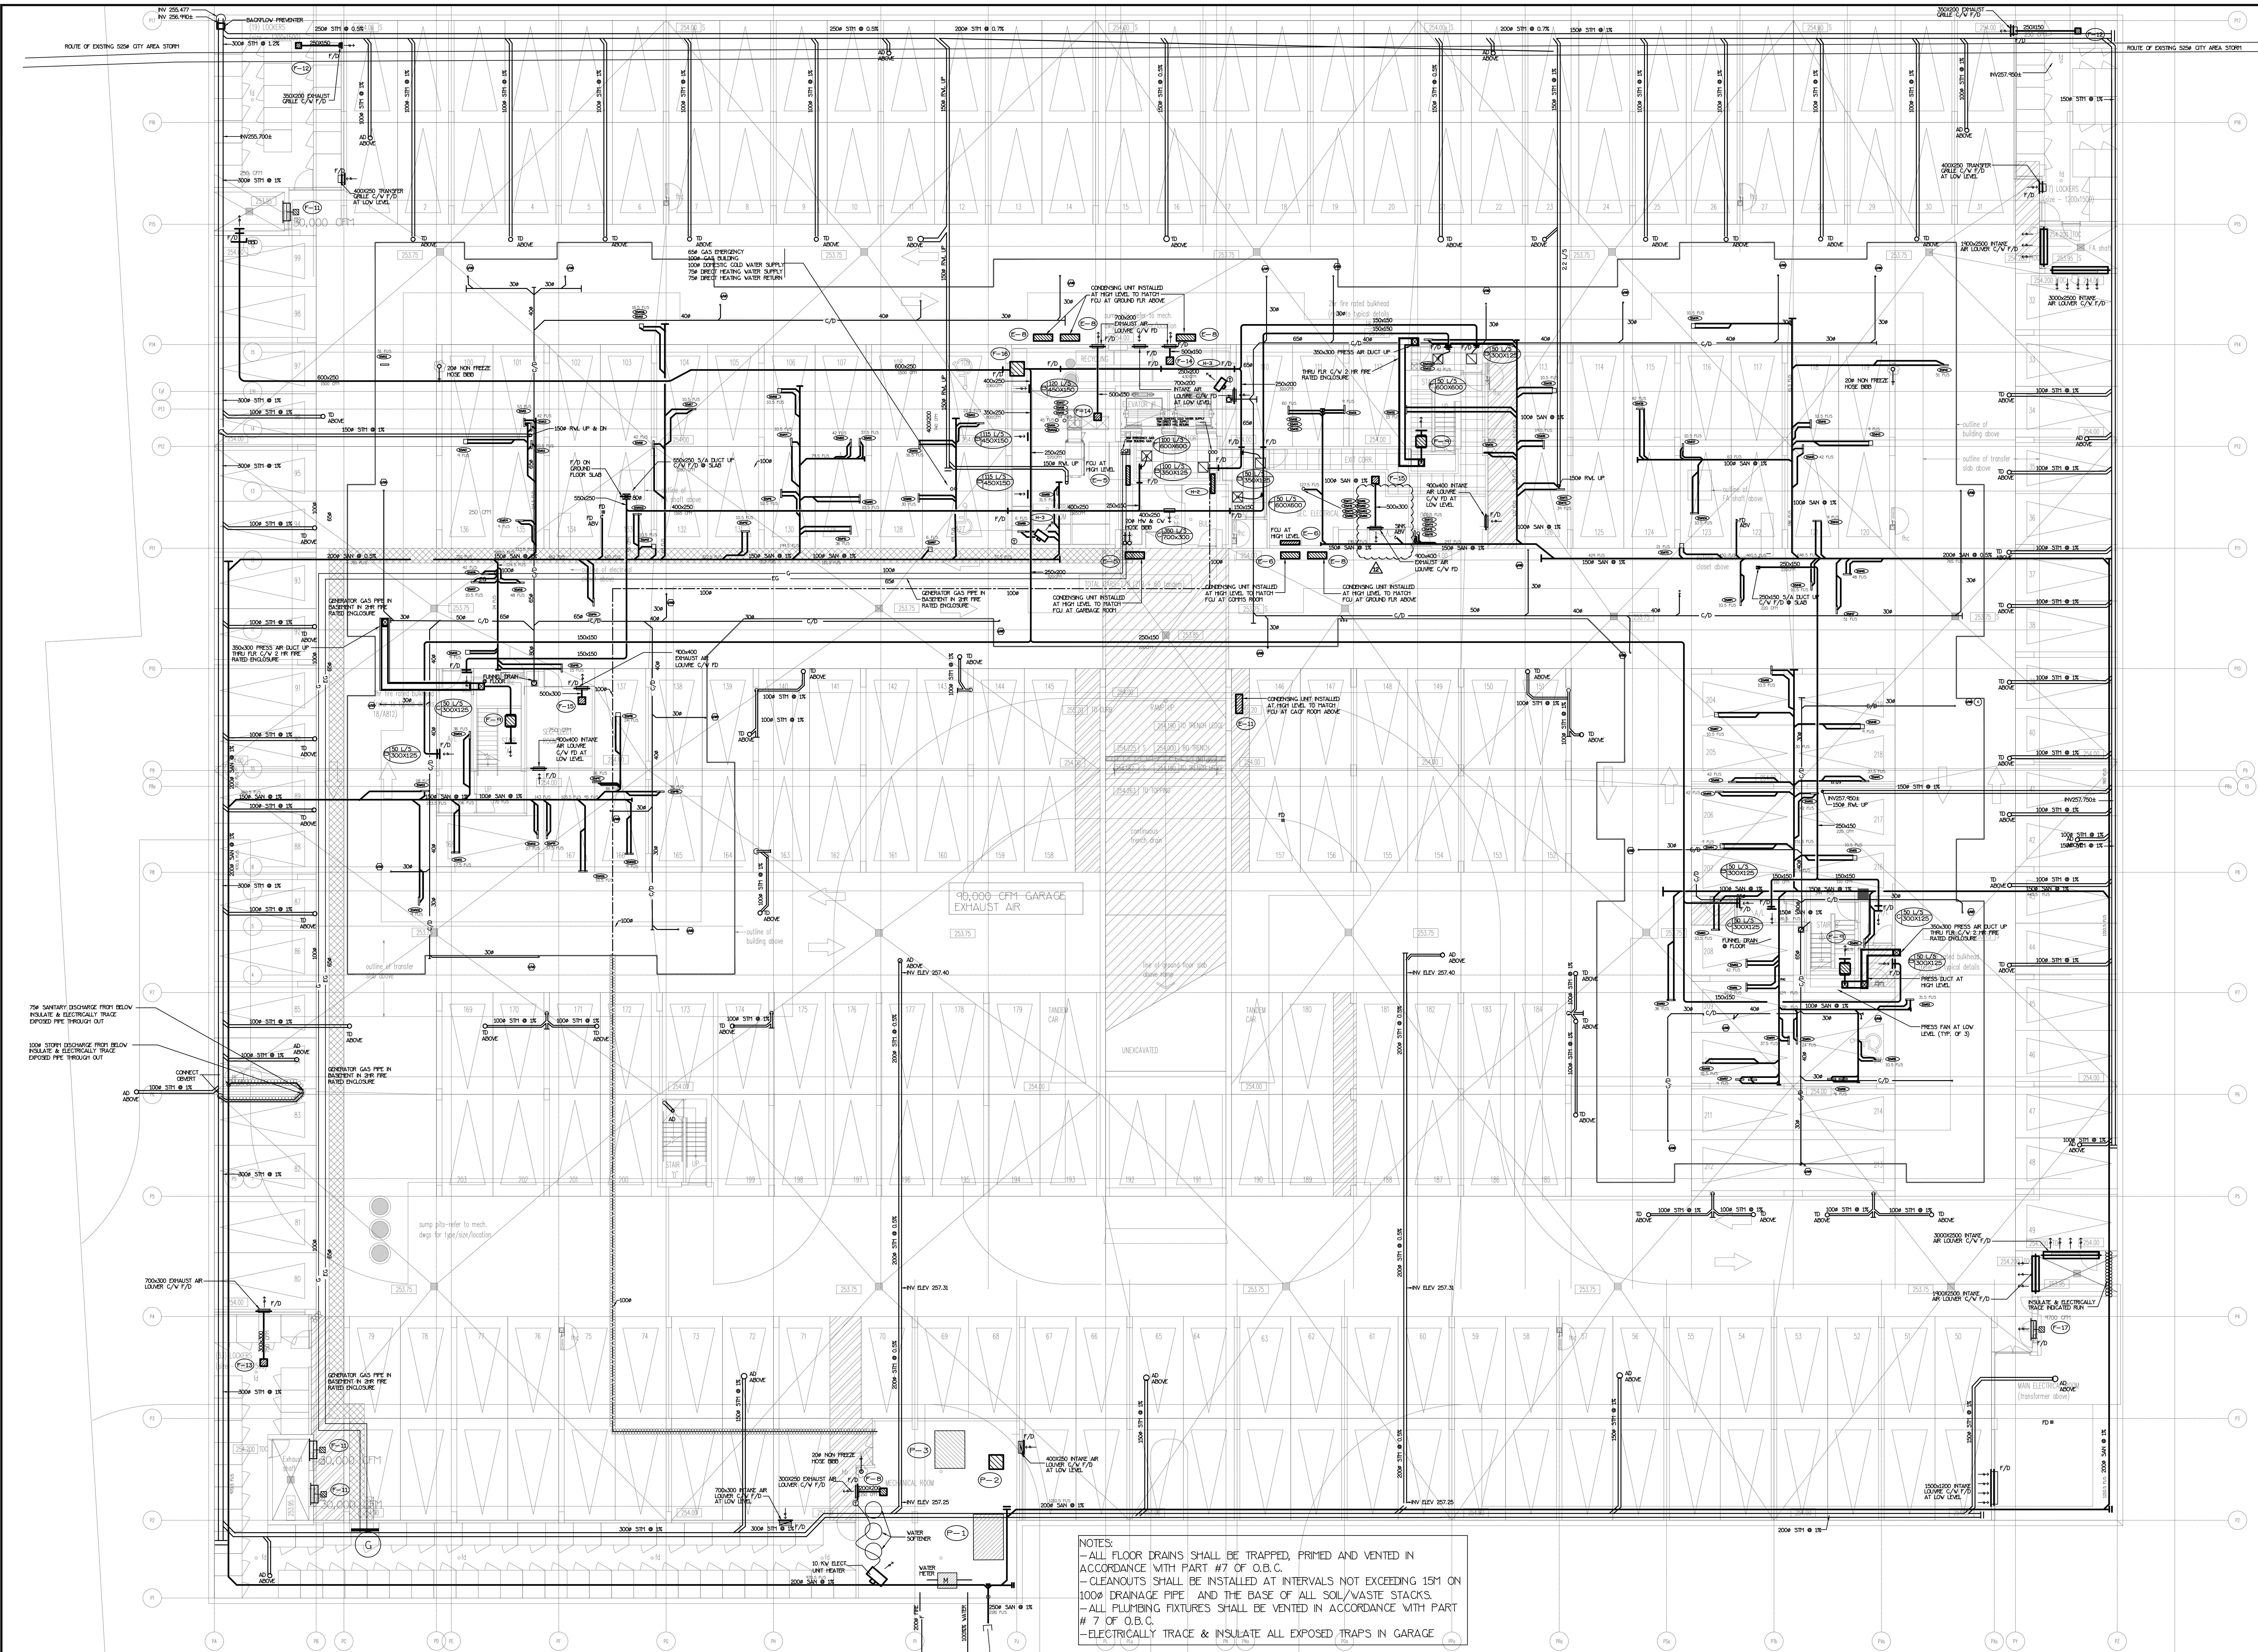

NOTES:
- ALL FLOOR DRAINS SHALL BE TRAPPED, PRIMED AND VENTED IN ACCORDANCE WITH PART #7 OF O.B.C.
- CLEANOUTS SHALL BE INSTALLED AT INTERVALS NOT EXCEEDING 15M ON 100MM DRAINAGE PIPE AND THE BASE OF ALL SOL/WASTE STACKS.
- ALL PLUMBING FIXTURES SHALL BE VENTED IN ACCORDANCE WITH PART #7 OF O.B.C.
- ELECTRICALLY TRACE & INSULATE ALL EXPOSED TRAPS IN GARAGE


NO.	BY	DESCRIPTION	DATE
12	LD	REVISED AS PER SITE INSTRUCTION H-25	JAN/15/2014
11	LD	REVISED AS PER SITE INSTRUCTION H-22	AUG/03/2018
10	LD	REVISED AS PER SITE INSTRUCTION H-17	JUN/04/2018
9	LD	REVISED AS PER SITE INSTRUCTION H-13	FEB/03/2018
8	LD	REVISED AS PER SITE INSTRUCTION H-12	DEC/13/2017
7	LD	REVISED AS PER SITE INSTRUCTION H-11	DEC/11/2017
6	LD	REVISED AS PER SITE INSTRUCTION H-9	OCT/14/2017
5	LD	REVISED AS PER SITE INSTRUCTION H-7	SEP/11/2017
4	LD	ISSUED FOR SITE INSTRUCTION H-5	AUG/04/2017
3	LD	PROGRESS FOR CONSTRUCTION	JUL/18/2017
2	LH	ISSUED FOR PERMIT	DEC/28/2016
1	LH	ISSUED FOR TENDER	MAR/21/2016

This drawing is an instrument of service, is provided by and is the property of United Engineering Inc. The contractor must verify and accept responsibility for all dimensions and conditions on site and must notify United Engineering Inc. of any discrepancy before proceeding.

United Engineering Inc. is not responsible for the accuracy of Architectural, structural, interior design, etc. on this drawing.


Refer to the appropriate trade drawings before proceeding with any work. Installation must conform to all applicable codes and requirements of the authorities having jurisdiction.

This drawing is not to be scaled, all symbols are graphic representations only.

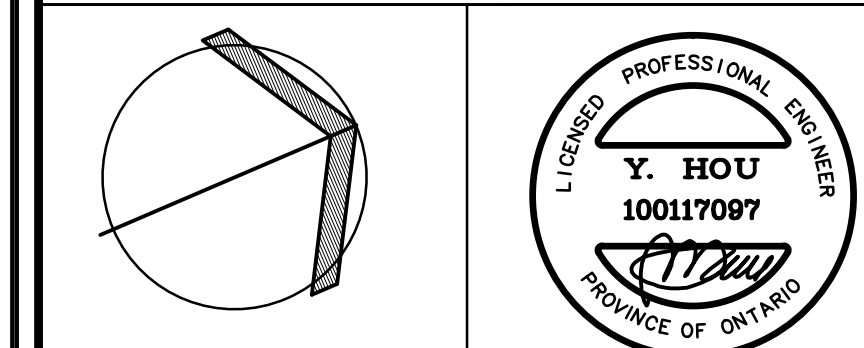

United Engineering Inc.
Mechanical Electrical Consulting Engineers
3045 Keele Street, Suite 105,
Toronto, Ontario, M3J 1W6
Tel: (416) 398 1999, Fax: (416) 398 1933

TITLE PARKING LEVEL PLAN MECHANICAL		
PROJECT 25 BAKER HILL BLVD. ROYAL PINE HOMES		
STOUFFVILLE, ONTARIO PROPOSED RESIDENTIAL DEVELOPMENT		
DRAWN GC	CHECKED BT	SCALE 1:100
DATE JUNE 2015	PROJECT 14-016	DRAWING M-4 OF 42

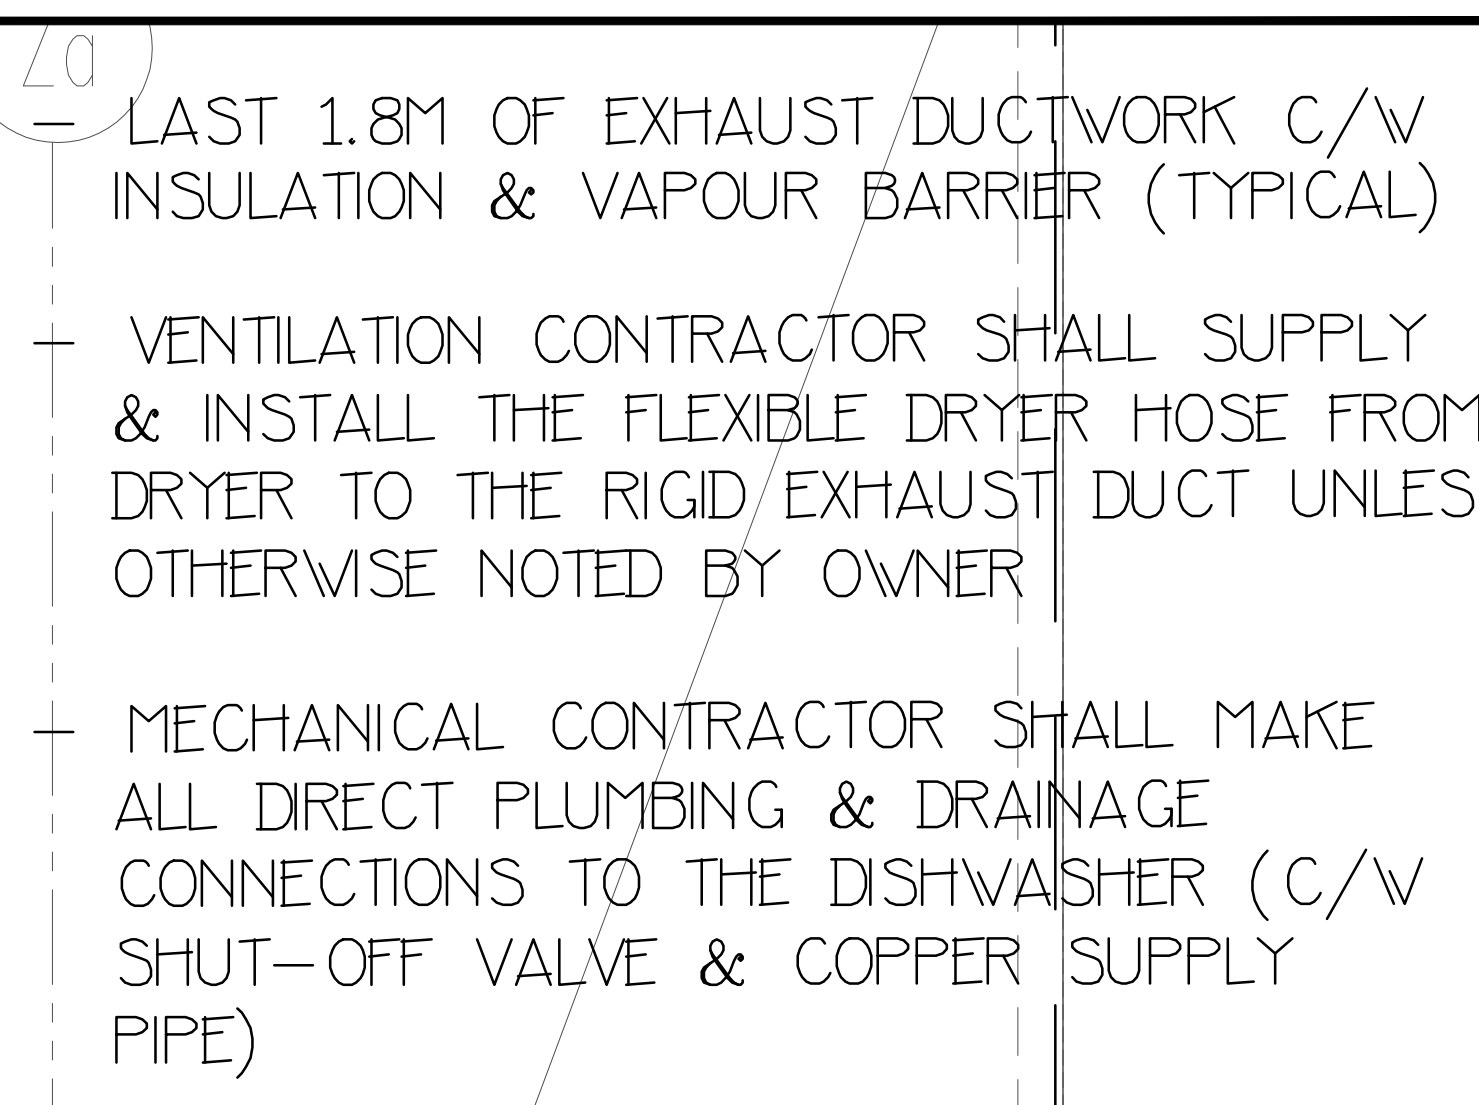

TITLE 1ST FLOOR LEVEL MECHANICAL			
PROJECT 25 BAKER HILL BLVD. ROYAL PINE HOMES			
STOUFFVILLE,		ONTARIO	
PROPOSED RESIDENTIAL DEVELOPMENT			
DRAWN	GC	CHECKED BT	SCALE 1=50
DATE	JUNE 2015	PROJECT 14-016	DRAWING M-8 OF 42



UNITED ENGINEERING INC
Mechanical and Electrical Consulting Engineers

3645 Keele St. #105
Toronto, ON, M3J 1M6
Email: info@u-eng.ca
T: (416) 398-1999
F: (416) 398-1933

SITE INSTRUCTION

PROJECT: HAMPTON MANOR
25 BAKER HILL BLVD
STOUFFVILLE, ONTARIO

PROJECT NO: 14-016

CONTRACT: Mechanical

DATE Jan. 15, 2019

SITE INSTRUCTION: M-25

THIS SITE INSTRUCTION IS NOT TO BE CONSTRUED AS A CHANGE IN THE CONTRACT PRICE, BUT IS ISSUED FOR CLARIFICATION ONLY. IF A CHANGE IN CONTRACT PRICE IS PERCEIVED, PROVIDE AN ITEMIZED BREAKDOWN OF ANY EXTRAS OR CREDITS WITHIN SEVEN (7) WORKING DAYS.

Purpose: Revised mechanical layout to suit Architectural change (resized storage room and mail room, added a janitor room).

1.0 Reference Drawing M-4 (P1 Level - Mechanical) Issued

1.1 Connected: New janitor room sink drain above to nearest existing sanitary pipe.

2.0 Reference Drawing M-5, M-8 (1st Floor Level - Mechanical) Issued

2.1 Relocated: Management room fan (F-21) and storage room fan (F-2).

2.2 Relocated: Fresh Air diffuser for mail room.

2.3 Added: Fan (F-2) for new janitor room.

2.4 Added: 20ø cw, hw, and sink for new janitor room.

PREPARED BY:

Leon Bai
Mechanical Department

ISSUED TO ROYAL PINE HOMES,
Cinzia Caruso, Cinzia@royalpinehomes.com;
Vince Staffieri, vince@royalpinehomes.com
FOR DISTRIBUTION TO ALL AFFECTED PARTIES.