



UNITED ENGINEERING INC
Mechanical and Electrical Consulting Engineers

3645 Keele St. #105
Toronto, ON, M3J 1M6
Email: info@u-eng.ca
T: (416) 398-1999
F: (416) 398-1933

ADDENDUM

PROJECT: Forestside Estates
Attmar & Palleschi Drive
Brampton, Ontario

PROJECT NO.: 18-017

CONTRACT: Mechanical

DATE: August 13, 2019

ADDENDUM NO. M-1

CONTRACTORS ARE TO REVIEW ALL CHANGES, DELETIONS AND ADDITIONS TO THE WORK LISTED IN THIS DOCUMENT AND THE REVISED DRAWINGS AND INCORPORATE THESE ITEMS IN THE TENDER PRICE.

PURPOSE: To match site services changes.

1.0 Mechanical drawing M-3 (Ground Floor Plan Overall- Mechanical) Issued

1.1 Revised: Area drain location & corresponding storm piping connection.

2.0 Mechanical drawing M-3A (Ground Floor Plan A - Mechanical) Issued

2.1 Revised: Area drain location & corresponding storm piping connection.


3.0 Mechanical drawing M-3B (Ground Floor Plan B - Mechanical) Issued

3.1 Revised: Area drain location & corresponding storm piping connection.

PREPARED BY:


Daria Lemke
Mechanical Department

ISSUED TO ROYAL PINE HOMES,
Cinzia Caruso, Cinzia@royalpinehomes.com;
Vince Staffieri, vince@royalpinehomes.com
FOR DISTRIBUTION TO ALL AFFECTED PARTIES.

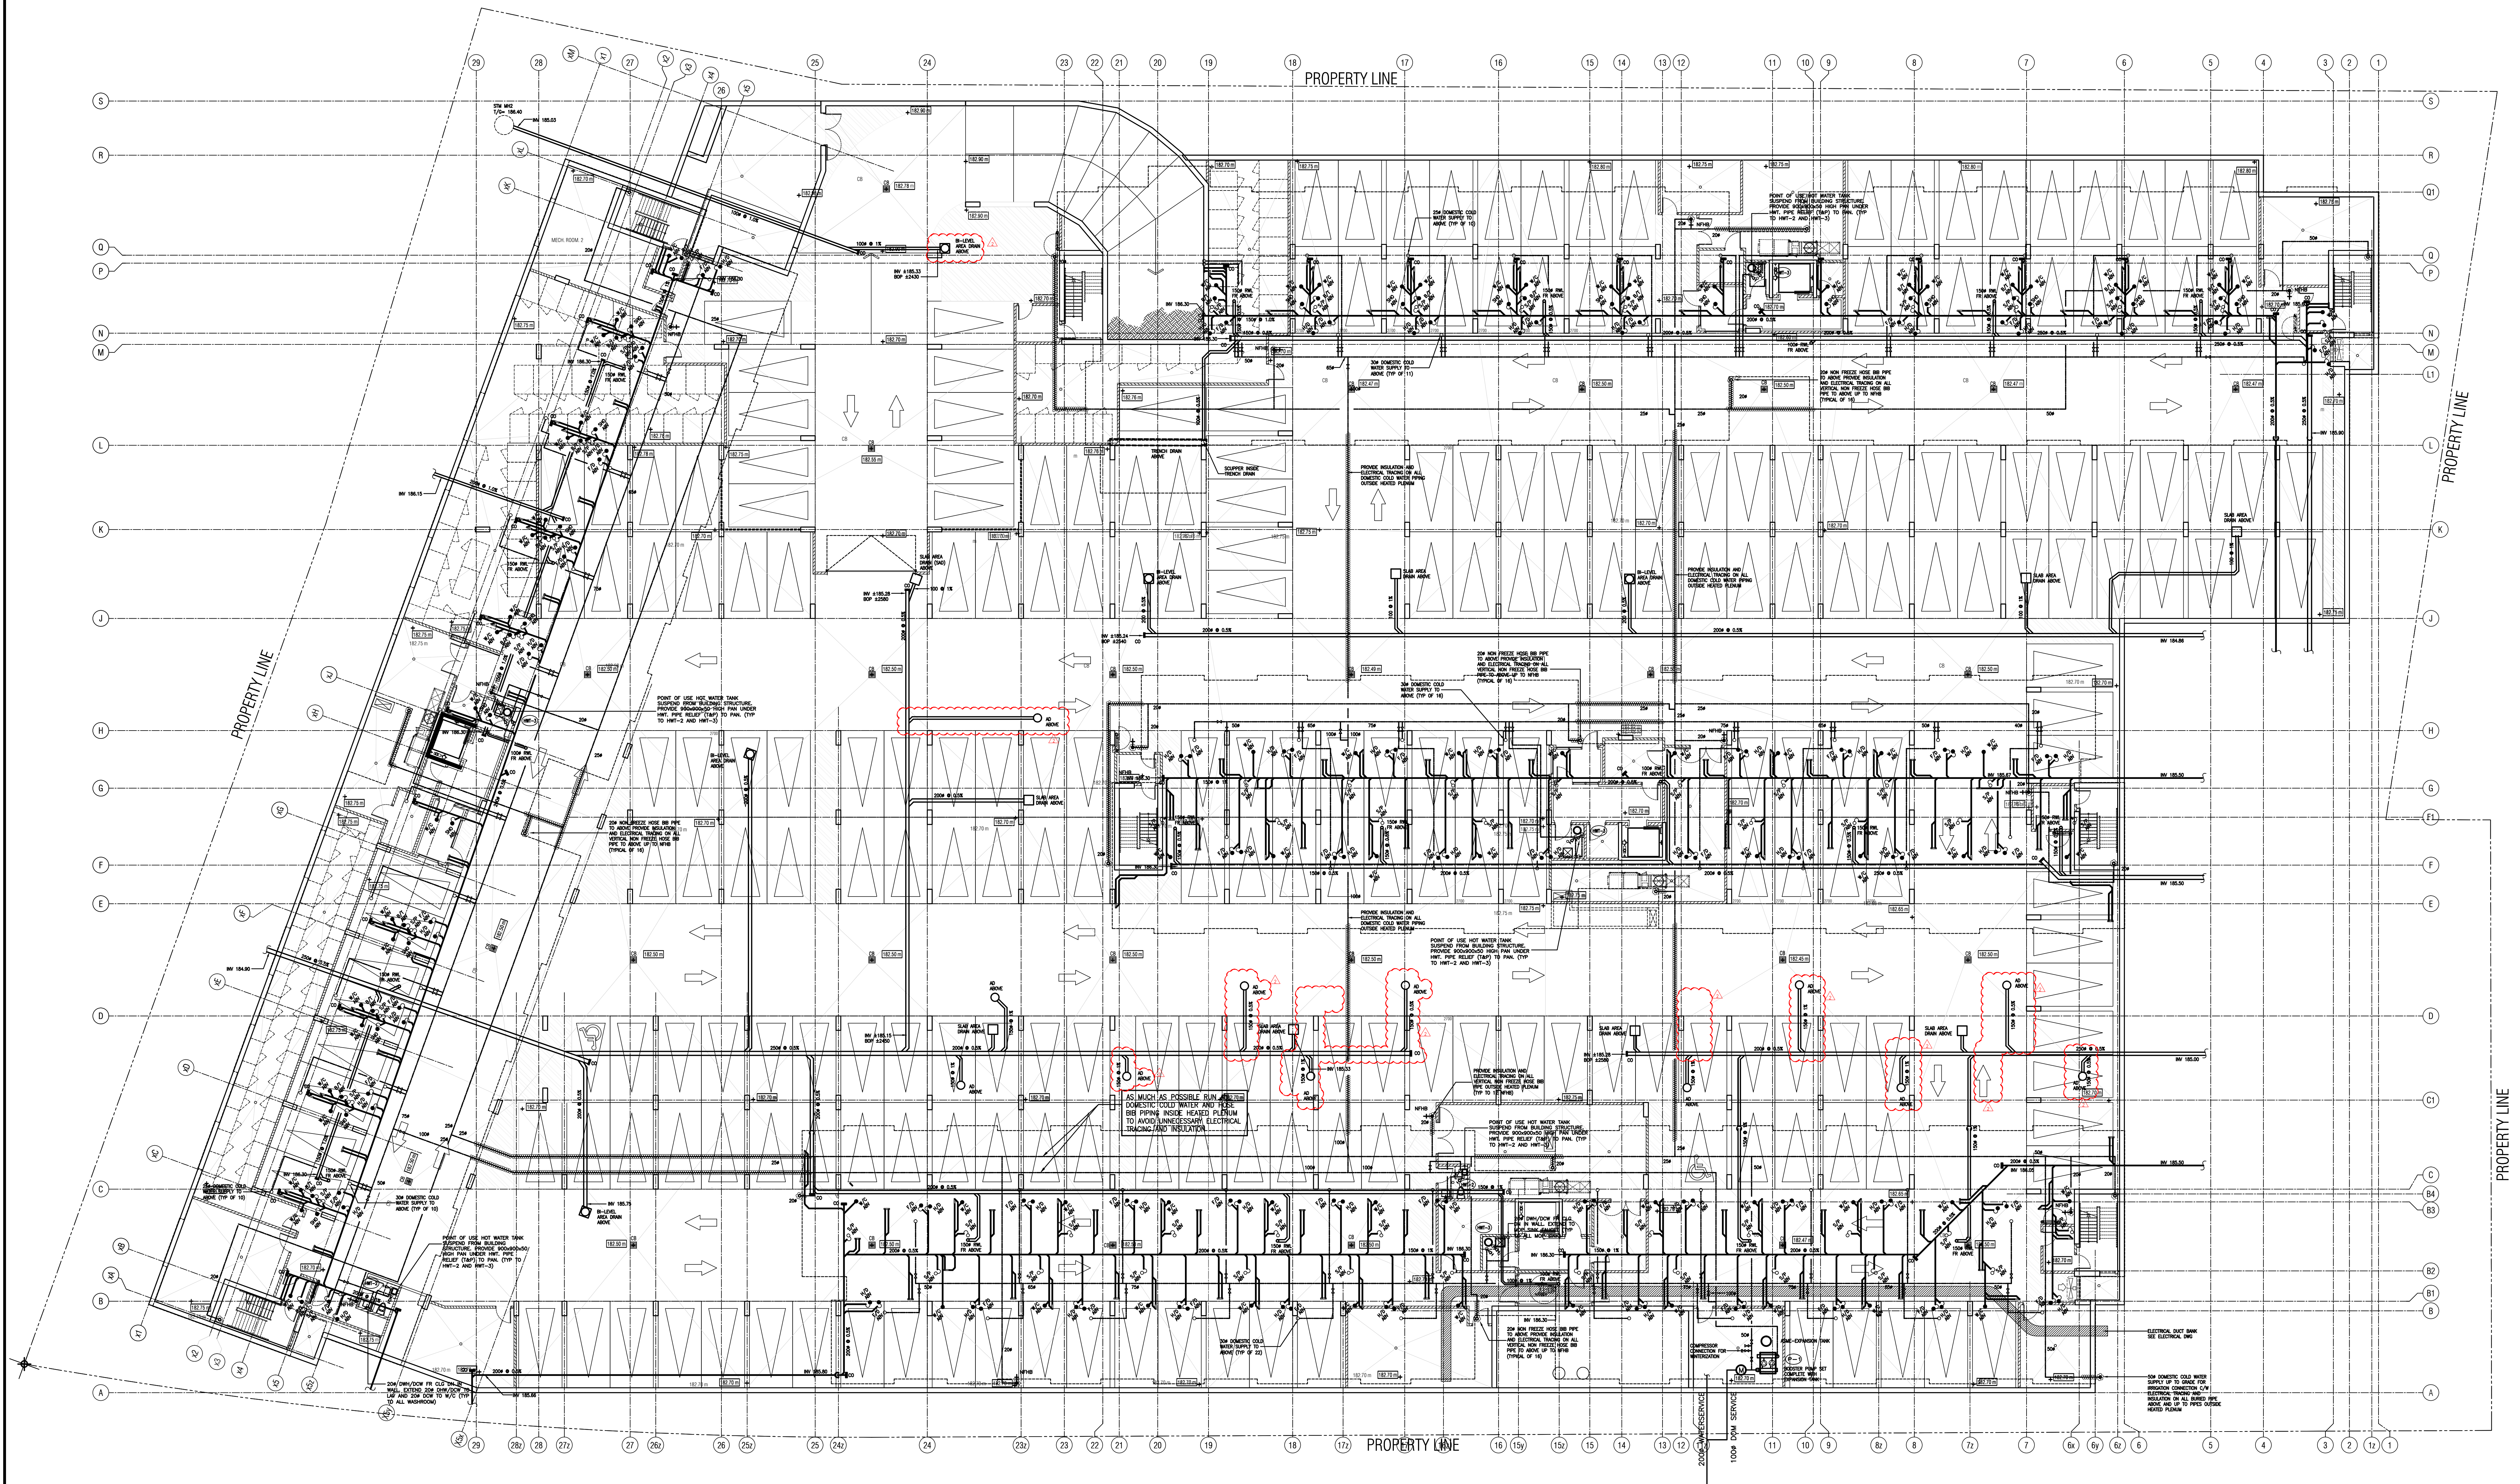


02	RC	ADDENDUM #01	AUG. 13, 2019
01	RC	ISSUED FOR TENDER	AUG. 02, 2019
NO.	BY	DESCRIPTION	DATE
REVISIONS			

This drawing is an instrument of service, is provided by and is the property of United Engineering Inc. The contractor must verify and accept responsibility for all dimensions and conditions on site and must notify United Engineering Inc. of any discrepancy before proceeding.

United Engineering Inc. is not responsible for the accuracy of Architectural, structural, interior design, etc. on this drawing.


Refer to the appropriate trade drawings before proceeding with any work. Installation must conform to all applicable codes and requirements of the authorities having jurisdiction.

This drawing is not to be scaled, all symbols are graphic representations only.

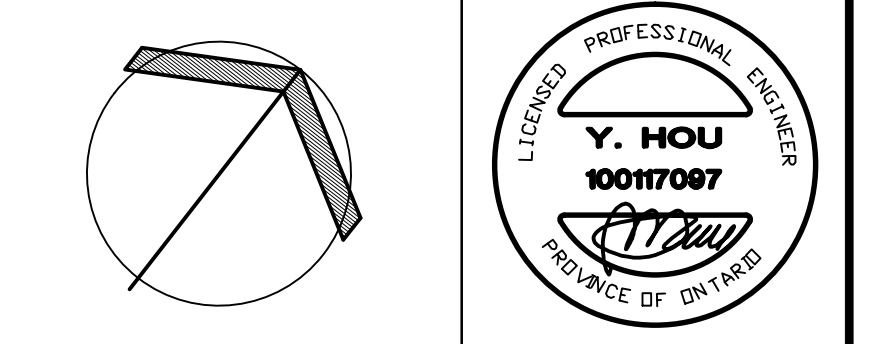

UNITED ENGINEERING INC.
Mechanical Electrical Consulting Engineers
3645 Keele Street, Suite 105,
Toronto, Ontario, M3J 1M6
Tel: (416) 396 1999, Fax: (416) 396 1933

TITLE PARKING LEVEL - PLUMBING MECHANICAL	
PROJECT BRAMPTON STACKED FORESTSIDE ESTATES	
ATTMAR + PALLESCI DRIVE BRAMPTON, ONTARIO	
DRAWN MC	CHECKED LM
DATE MAY, 2019	SCALE 1:150
PROJECT 18-017	
DRAWING M-3	
OF	

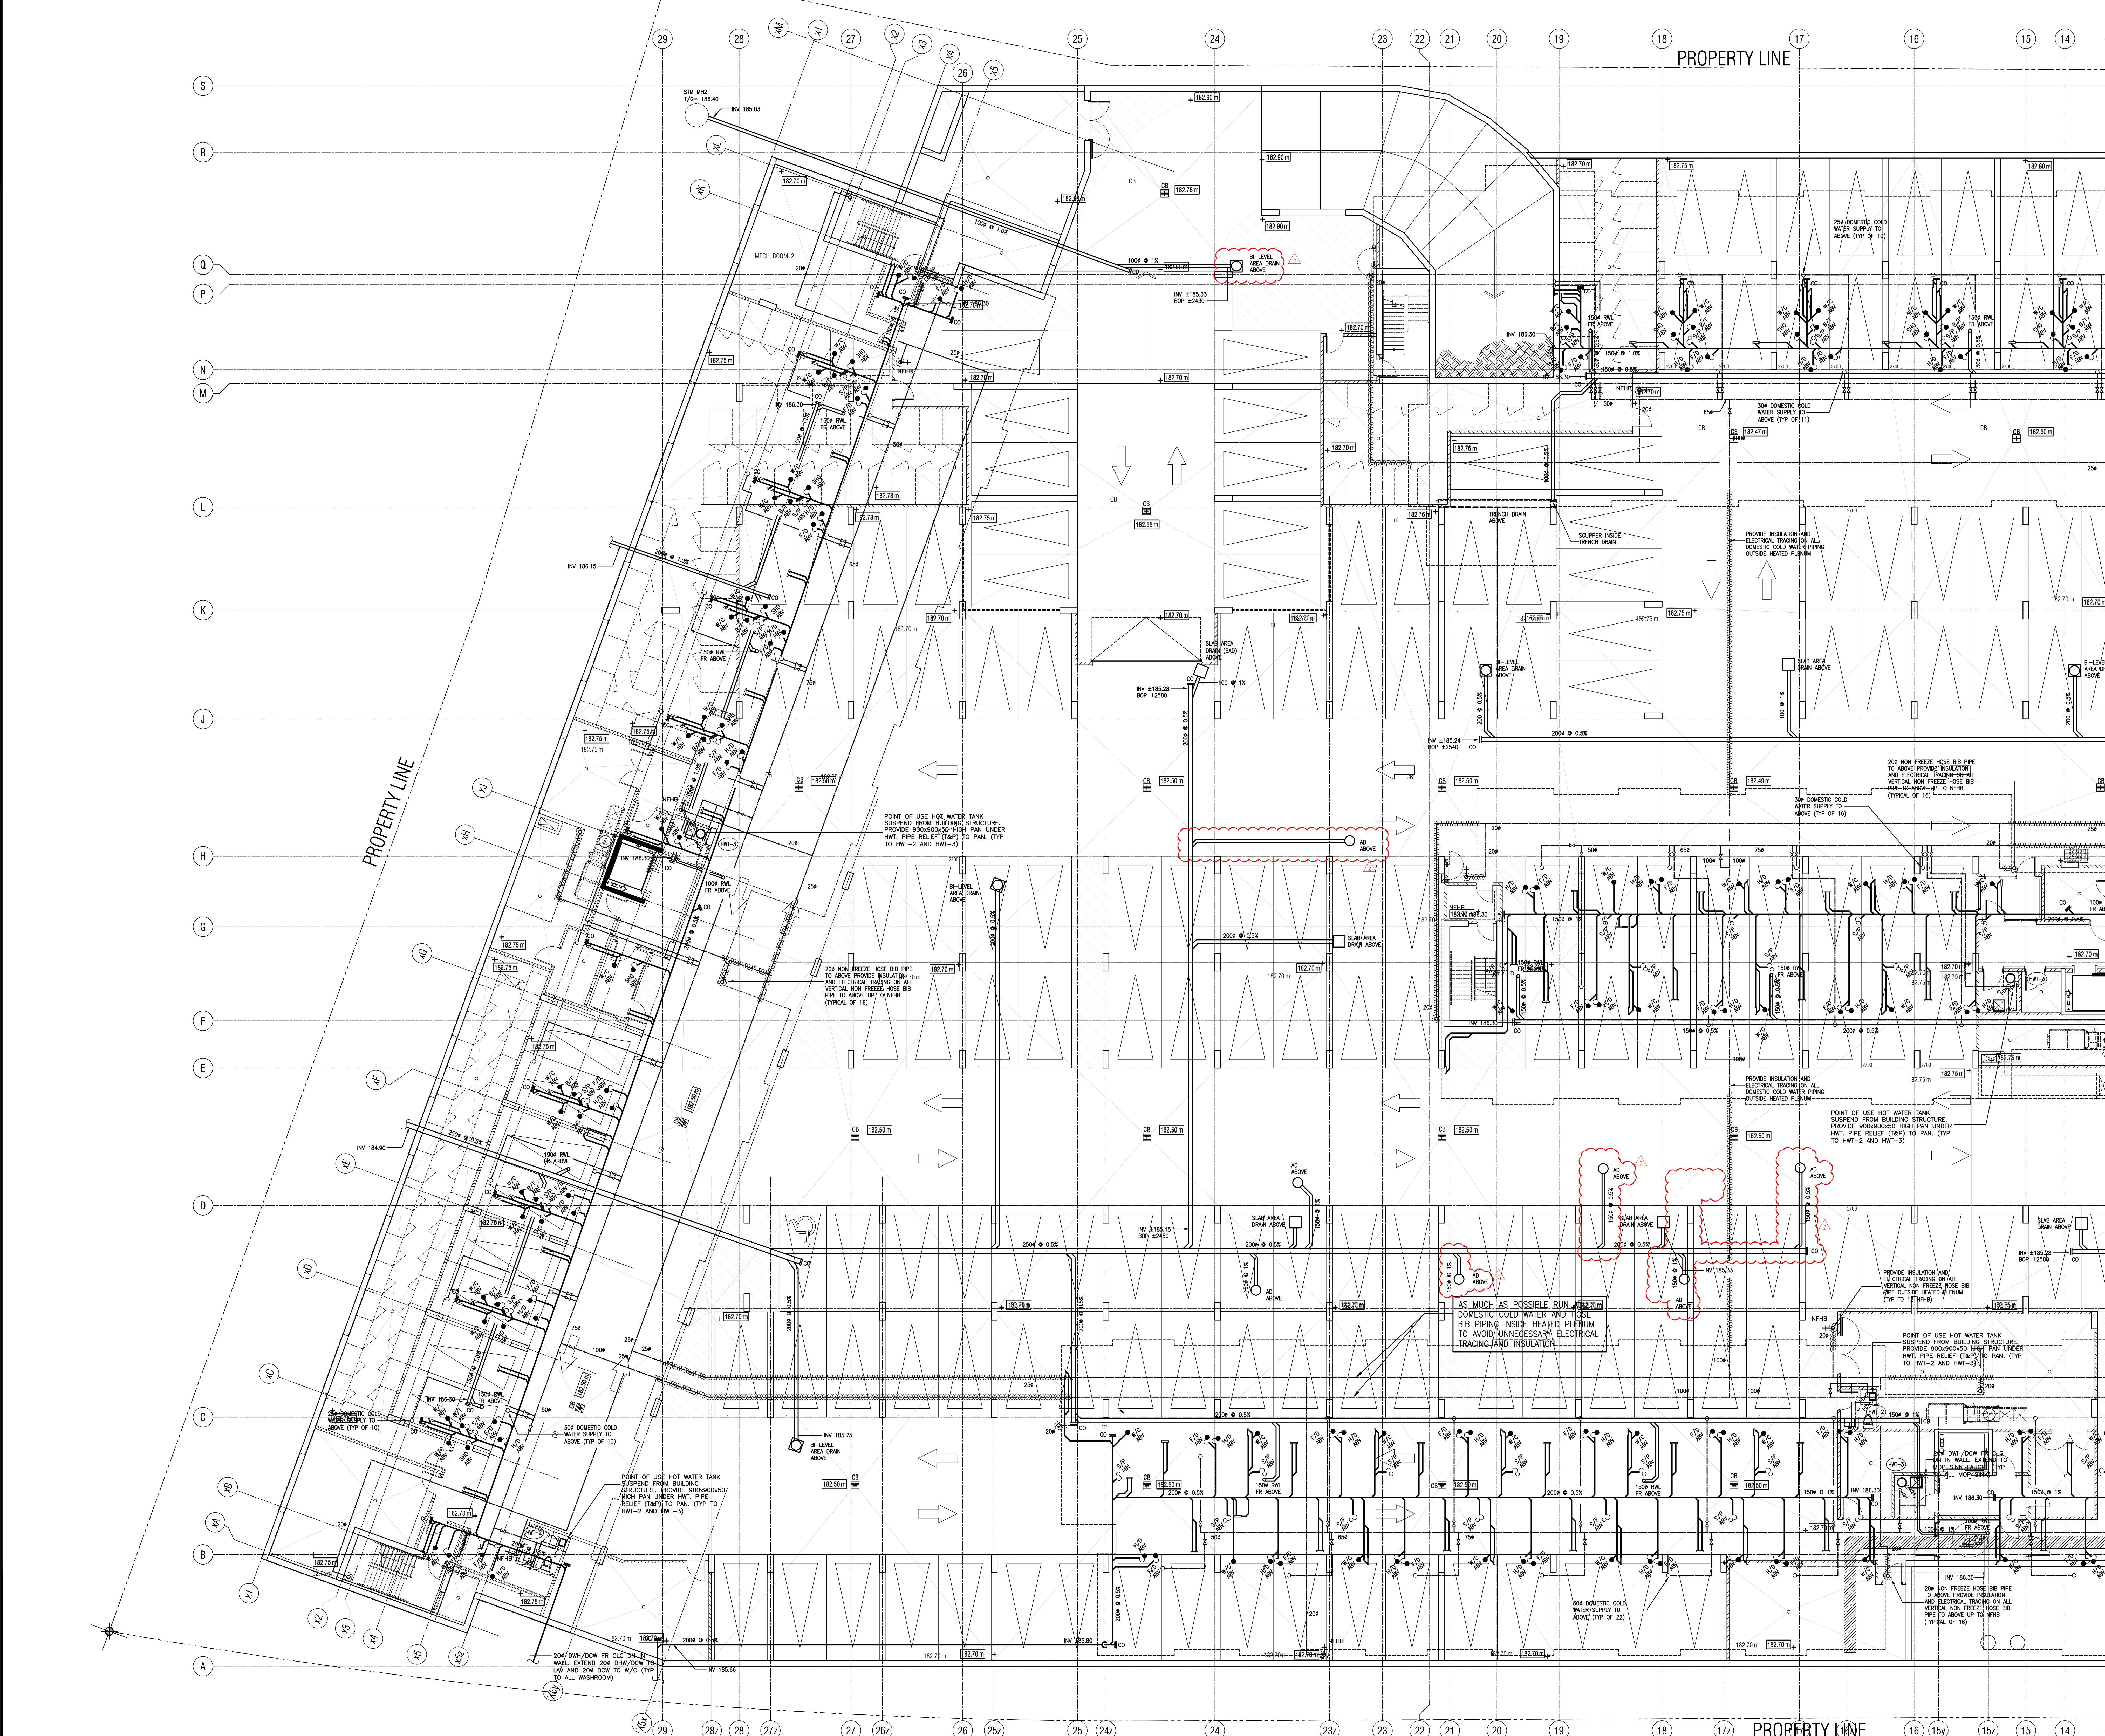

NO.	BY	DESCRIPTION	DATE
02	RC	ADDENDUM #01	AUG. 13, 2019
01	RC	ISSUED FOR TENDER	AUG. 02, 2019


REVISIONS	
NO.	DESCRIPTION
01	ISSUED FOR TENDER
02	ADDENDUM #01

This drawing is an instrument of service, is provided by and is the property of United Engineering Inc. The contractor must verify and accept responsibility for all dimensions and conditions on site and must notify United Engineering Inc. of any discrepancy before proceeding.

United Engineering Inc. is not responsible for the accuracy of Architectural, structural, interior design, etc. on this drawing.

Refer to the appropriate trade drawings before proceeding with any work. Installation must conform to all applicable codes and requirements of the authorities having jurisdiction.

This drawing is not to be scaled, all symbols are graphic representations only.

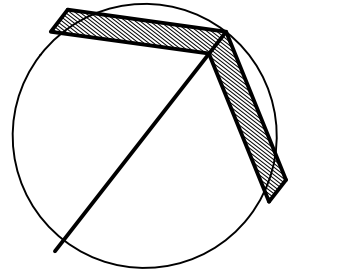

UNITED ENGINEERING INC.
Mechanical Electrical Consulting Engineers
3645 Keele Street, Suite 105,
Toronto, Ontario, M3J 1M6
Tel: (416) 396 1999, Fax: (416) 396 1933

TITLE
PARKING LEVEL - PLUMBING
MECHANICAL - PART 1


PROJECT
BRAMPTON STACKED
FORESTSIDE ESTATES

**ATTMAY + PALLESCI DRIVE
BRAMPTON, ONTARIO**

DRAWN	CHECKED	SCALE
MC	LM	1:100

DATE	PROJECT	DRAWING
MAY, 2019	18-017	M-3A

OF -

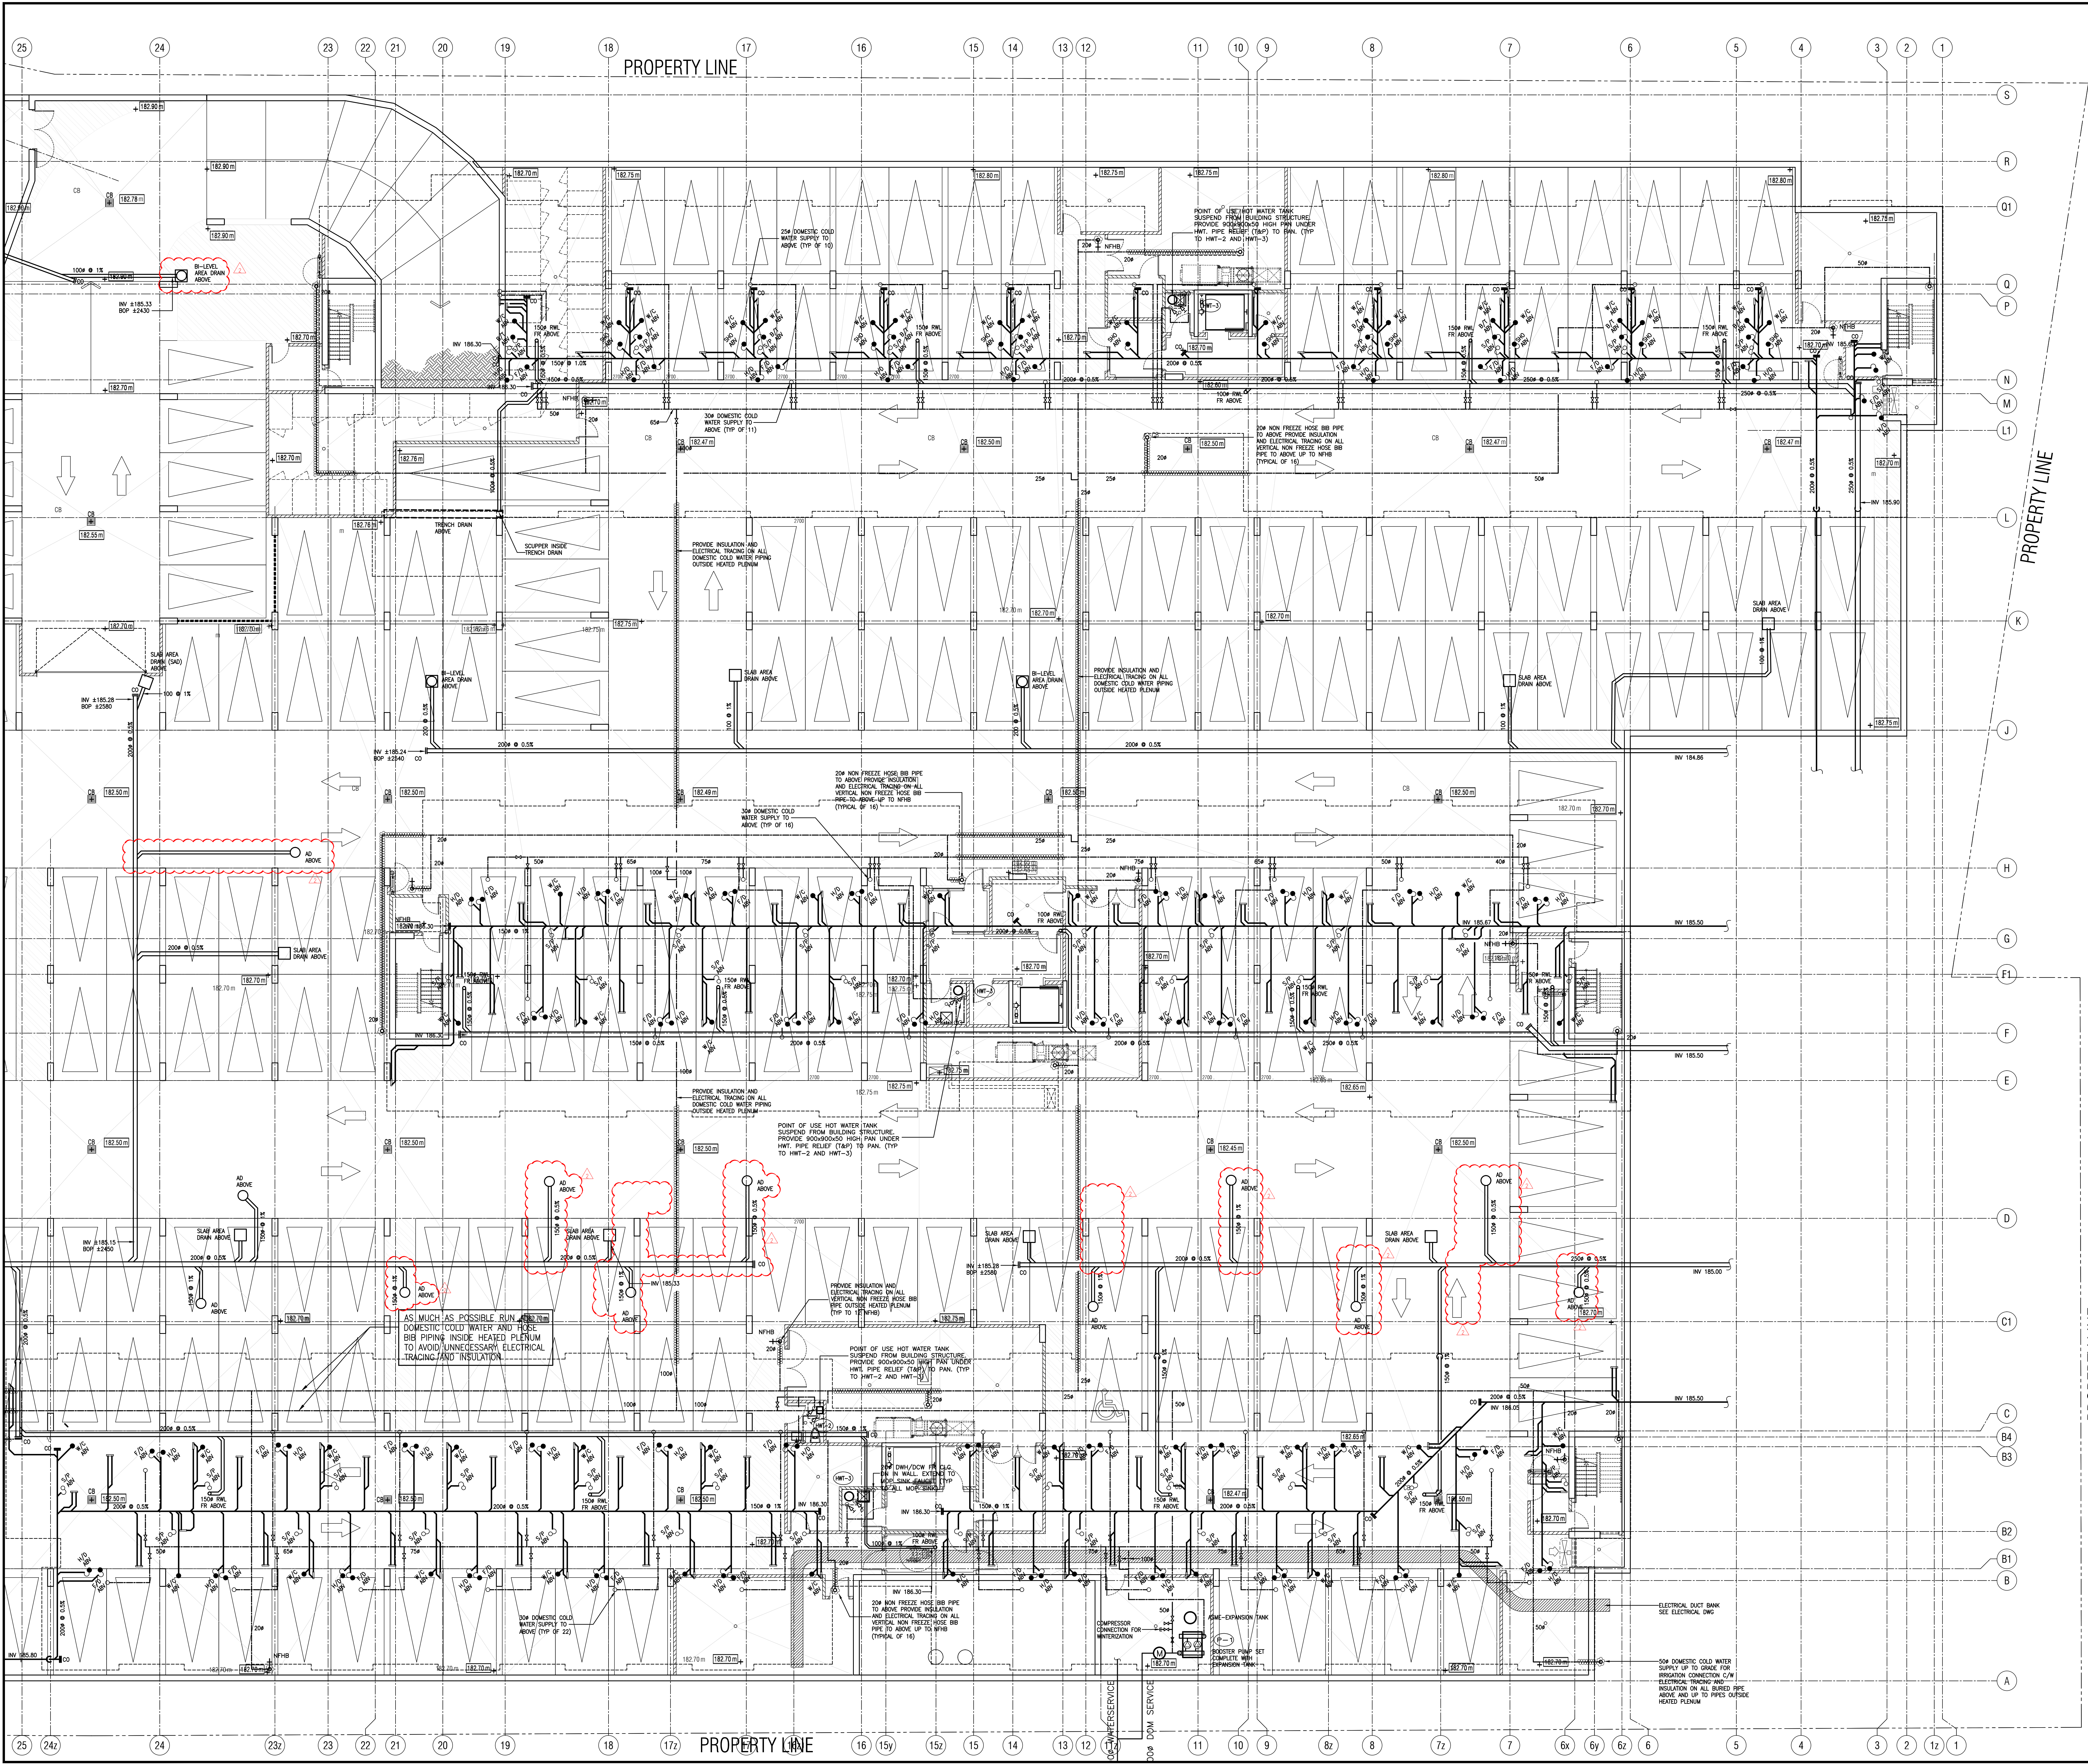


NO.	BY	DESCRIPTION	DATE
02	RC	ADDENDUM #01	AUG. 13, 2019
01	RC	ISSUED FOR TENDER	AUG. 02, 2019

REVISIONS	
NO.	DESCRIPTION
02	RC
01	RC

This drawing is an instrument of service, is provided by and is the property of United Engineering Inc. The contractor must verify and accept responsibility for all dimensions and conditions on site and must notify United Engineering Inc. of any discrepancy before proceeding.

United Engineering Inc. is not responsible for the accuracy of Architectural, structural, interior design, etc. on this drawing. Refer to the appropriate trade drawings before proceeding with any work. Installation must conform to all applicable codes and requirements of the authorities having jurisdiction. This drawing is not to be scaled, all symbols are graphic representations only.

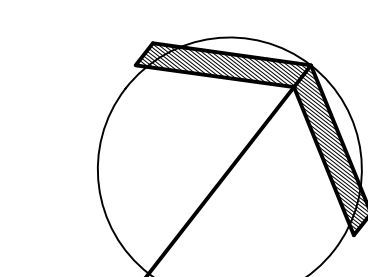

UNITED ENGINEERING INC.
Mechanical Electrical Consulting Engineers
3645 Keele Street, Suite 105,
Toronto, Ontario, M3J 1M6
Tel: (416) 396 1999, Fax: (416) 396 1933

TITLE
PARKING LEVEL - PLUMBING
MECHANICAL - PART 2

PROJECT
BRAMPTON STACKED FORESTSIDE ESTATES

ATTNAR + PALLESCI DRIVE
BRAMPTON, ONTARIO

DRAWN	CHECKED	SCALE
MC	LM	1:100

DATE	PROJECT	DRAWING
MAY, 2019	18-017	M-3B