



CONSTRUCTION SUMMARY
EARLGLEN INVESTMENTS INC.

PURCHASER: CHANG YOU HE

TEL: RES.: 647-866-0188

LOT NUMBER	PHASE	HOUSE TYPE	CLOSING DATE	
020 BLOCK 003	1	THE KATHERINE(END)-ELEV A-3 BDRM-3 BATHS	16-Jun-26	

Offer Worksheet	BONUS PACKAGE: PURCHASER TO RECEIVE \$10,000 (INCLUSIVE OF TAXES) WORTH OF UPGRADES AT DECOR CENTER AT TIME OF COLOUR CHART. Note:
Offer Worksheet	APPLIANCE PACKAGE: PURCHASER TO RECEIVE 5 APPLIANCES TO INCLUDE FRIDGE, STOVE, DISHWASHER WITH STAINLESS STEEL FINISH AND WHITE WASHER & DRYER AS PER VENDORS SAMPLES. Note:
Offer Worksheet	COMPLETE CENTRAL AIR CONDITIONING SYSTEM, AS PER VENDORS STANDARD SAMPLES. Note:
Offer Worksheet	VENDOR AGREES TO SUPPLY AND INSTALL 7 1/2inch LAMINATE FLOORING ON UPPER HALLWAY, AS PER PLAN AND AS PER VENDORS STANDARD SAMPLES. Note:



CONSTRUCTION SUMMARY
EARLGLEN INVESTMENTS INC.

PURCHASER: CHANG YOU HE

TEL: RES.: 647-866-0188

LOT NUMBER	PHASE	HOUSE TYPE	CLOSING DATE	
020 BLOCK 003	1	THE KATHERINE(END)-ELEV A-3 BDRM-3 BATHS	16-Jun-26	

Date Added: 14-Aug-25 Invoice Number: 8872

1 - Install Standard Cable Rough-Ins (x2) and Install Standard Telephone Rough-Ins (x2) (See Sketch) Note:
1 - ENSUITE #2 - Install UPGRADE 2x2 Mosaic Floor Tile and 6" Curb with White Quartz in lieu of builders standard acrylic shower base at ensuite #2 shower stall. (See Sketch) Note: Delete Builders Standard Chrome Framed Shower Glass Panel and Chrome Framed Shower Door. Front of shower stall to be LEFT OPEN. Purchaser to Supply and Install Own Glass at shower stall AFTER CLOSING. Purchaser Accpets and Acknowledges NO Credit will be provided for deleting standard glass at shower stall.
1 - KITCHEN - In addition to builders standard ceiling light, Install ONE (x1) ADDITIONAL CEILING LIGHT with Seperate Switch - To be installed centred above kitchen island (See Sketch) Note:
1 - MAIN FLOOR & 2ND FLOOR - INTERIOR DOORS - Install UPGRADE Interior Doors - LOGAN SMOOTH - To be installed throughout main floor and 2nd floor where applicable (See Sketch) Note: Main Floor - Extended Height (x1) Foyer Closet - Standard Height (x3) MudRoomCloset, PowderRoom & Door Leading to Basement 2nd Floor - Extended Height (x13) Throughout 2nd Floor Priced as per Fonzie C.
1 - MAIN FLOOR & 2ND FLOOR - DOOR HARDWARE - Install UPGRADE Hardware - WEISER MONTREAL SQUARE BLACK with Matching RADIUS MATTE BLACK HINGES - To be installed throughout main floor and 2nd floor interior doors, where applicable (See Sketch) Note:
1 - STAIRCASE VS FLOORING WOOD SPECIES DIFFERENCE: STAIRCASE - The purchaser was advised and therefore accepts and acknowledges that the wood species of the staircase and flooring chosen do not match. This difference may result in a stain colour variance. Note: The purchaser agrees that the vendor is to be exempt from any and all claims by the purchaser regarding this colour variance.
1 - KITCHEN & BATHROOMS - Purchaser has DECLINED All Upgrades offered during decor appointment at the decor centre for kitchen & bathroom cabinetry. Standard Kitchen Layout & Standard Bathroom Vanities to be installed as per standard plan. (See Sketch) Note:
1 - POWDER ROOM - VANITY CABINETRY - Install UPGRADE Cabinetry - CATEGORY 4 - LP LAMINATE - FLAVIE (VG)(TX) QTM 1922 - To be installed at powder room vanity, where applicable (See Sketch) Note:
1 - PRIMARY ENSUITE - VANITY CABINETRY - Install UPGRADE Cabinetry - CATEGORY 4 - LP LAMINATE - MARIA (VG)(TX) QTM 1922 - To be installed at primary ensuite vanity, where applicable (See Sketch) Note:
1 - MAIN BATH - VANITY CABINETRY - Install UPGRADE Cabinetry - CATEGORY 4 - LP LAMINATE - MARIA (VG)(TX) QTM 1922 - To be installed at main bath vanity, where applicable (See Sketch) Note:
1 - ENSUITE #2 - VANITY CABINETRY - Install UPGRADE Cabinetry - CATEGORY 4 - LP LAMINATE - MARIA (VG)(TX) QTM 1922 - To be installed at ensuite #2 vanity, where applicable (See Sketch) Note:
1 - APPLIANCES – INSTALL STANDARD APPLIANCE PACKAGE (See Attached) Note:
1 - KITCHEN - COUNTERTOP - Install Builders Standard Stone Countertop – EVEREST VANILLA WHITE with STANDARD " A " EDGE PROFILE - To be installed throughout kitchen, where applicable (does not include stone backsplash) (See Sketch) Note:



CONSTRUCTION SUMMARY
EARLGLEN INVESTMENTS INC.

PURCHASER: CHANG YOU HE

TEL: RES.: 647-866-0188

LOT NUMBER	PHASE	HOUSE TYPE	CLOSING DATE
020 BLOCK 003	1	THE KATHERINE(END)-ELEV A-3 BDRM-3 BATHS	16-Jun-26

Date Added: 14-Aug-25 Invoice Number: 8872

1 - DISCLAIMER - STONE COUNTERTOP; KITCHEN - Due to the many variables that can affect the pattern, colour and/or design and “pitting” of stone products, stone installed will not be identical to the samples displayed. Note: Every effort is made to provide stone countertops as close as possible but the vendor is not responsible for results which differ from the sample displayed. All countertop surfaces may have seams, and product pattern and shade can change in areas containing seams.
1 - DISCLAIMER - STONE COUNTERTOP; KITCHEN - Stone slabs vary in size & all seams are visible & the fabricator reserves the right to position the seams as necessary. Note:
1 - KITCHEN - KITCHEN SINK - Install Builders Standard Undermount Sink – Kindred Undermount Sink – Model #RDU 1831/7 Note:
1 - KITCHEN - KITCHEN FAUCET - Install Builders Standard Faucet - MOEN Method Single Handle Pull-Out (Single Hole) Kitchen Faucet - Model # 7585 – Chrome Note:
1 - POWDER ROOM - COUNTERTOP - Install Builders Standard Stone Countertop – EVEREST VANILLA WHITE with STANDARD " A " EDGE PROFILE - To be installed throughout powder room vanity, where applicable (Includes Applicable Splash) (See Sketch) Note:
1 - PRIMARY ENSUITE - COUNTERTOP - Install Builders Standard Stone Countertop – EVEREST VANILLA WHITE with STANDARD " A " EDGE PROFILE - To be installed throughout primart ensuite vanity, where applicable (Includes Applicable Splash) (See Sketch) Note:
1 - MAIN BATH - COUNTERTOP - Install Builders Standard Stone Countertop – EVEREST VANILLA WHITE with STANDARD " A " EDGE PROFILE - To be installed throughout main bath vanity, where applicable (Includes Applicable Splash) (See Sketch) Note:
1 - ENSUITE #2 - COUNTERTOP - Install Builders Standard Stone Countertop – EVEREST VANILLA WHITE with STANDARD " A " EDGE PROFILE - To be installed throughout ensuite #2 vanity, where applicable (Includes Applicable Splash) (See Sketch) Note:
1 - DISCLAIMER - STONE COUNTERTOP; ALL BAHTROOMS - Due to the many variables that can affect the pattern, colour and/or design and “pitting” of stone products, stone installed will not be identical to the samples displayed. Note: Every effort is made to provide stone countertops as close as possible but the vendor is not responsible for results which differ from the sample displayed. All countertop surfaces may have seams, and product pattern and shade can change in areas containing seams.
1 - CLARIFICATION - PLUMBING FIXTURES AND PLUMBING FAUCETS; ALL BATHROOMS - Install Builders Standard Plumbing Fixtures and Install Builders Standard Plumbing Faucets throughout all bathrooms, where applicable. Note: To Include; Powder Room, Primary Ensuite, Main Bath and Ensuite #2 (See Sketch)
1 - PRIMARY ENSUITE - FLOORING - Install UPGRADE #2 TILES - 12x24 ST.MARTIN SAND - To be installed throughout primary ensuite floor, where applicable. To be Installed STRAIGHT/STACKED (See Sketch) Note:
1 - PRIMARY ENSUITE - SHOWER WALLS - Install UPGRADE #3 TILES - 12x24 ST.MARTIN SAND - To be installed throughout primary ensuite shower walls, where applicable. To be Installed HORIZONTALLY/STACKED(See Sketch) Note:
1 - PRIMARY ENSUITE - SHOWER CEILING - Install UPGRADE TILES (12x24 St.Martin Sand) at Primary Ensuite Shower Stall Ceiling, where applicable (See Sketch) Note:
1 - ENSUITE #2 - FLOORING - Install UPGRADE #1 TILES - 18x18 VERNAZZO BIANCO - To be installed throughout ensuite #2 floor, where applicable.(See Sketch) Note:



CONSTRUCTION SUMMARY
EARLGLEN INVESTMENTS INC.

PURCHASER: CHANG YOU HE TEL: RES.: 647-866-0188

LOT NUMBER	PHASE	HOUSE TYPE	CLOSING DATE
020 BLOCK 003	1	THE KATHERINE(END)-ELEV A-3 BDRM-3 BATHS	16-Jun-26

Date Added: 14-Aug-25 Invoice Number: 8872

1 - ENSUITE #2 - SHOWER WALLS - Install UPGRADE #2 TILES - 18x18 VERNAZZO BIANCO - To be installed throughout ensuite #2 shower walls, where applicable.(See Sketch) Note:
1 - ENSUITE #2 - SHOWER CEILING - Install UPGRADE TILES (18x18 Vernazzo Bianco) at Ensuite #2 Shower Stall Ceiling, where applicable (See Sketch) Note:
1 - MAIN BATH - FLOORING - Install UPGRADE #2 TILES - 12x24 ST.MARTIN SAND - To be installed throughout main bath floor, where applicable. To be Installed STRAIGHT/STACKED (See Sketch) Note:
1 - MAIN BATH - TUB/SHOWER CEILING - Install STANDARD WALL TILES (8x10 Uniwall Tender Grey Glossy) at Main Bath Tub/Shower Ceiling, where applicable (See Sketch) Note:
1 - PURCHASER HAS ATTENDED A DECOR APPOINTMENT AT THE DESIGN STUDIO AND HAS DECLINED ANY ADDITIONAL UPGRADES. Purchaser accepts and acknowledges that there will be no further changes/additions/deletions to be made upon signing on AUGUST 13,2025 Note:
1 - PURCHASER AWARE AND ACCEPTS THAT ANY CHANGES MADE TO UPGRADES AFTER SIGNING THIS PURCHASERS EXTRA FORM ARE SUBJECT TO A MINIMUM ADMINISTRATION FEE OF \$1,000 Note:

Date Added: 28-Jul-25 Invoice Number: 8871

1 - BASEMENT - Install UPGRADE 200 AMP SERVICE in lieu of builders standard 100 Amp (See Sketch) Note:
1 - FRONT EXTERIOR - In addition to builders standard exterior coach light, Install ONE (x1) ADDITIONAL EXTERIOR COACH LIGHT. - To be installed beside exterior front door. Both Exterior Coach Lights to be Controlled by ONE (x1) Switch (See Sketch) Note:
1 - BASEMENT - WINDOW - Delete Two (2) Standard 30 IN (W) x 16 IN (H) Basement Windows and Install ONE (x1) LARGER 48 IN (W) x 24 IN (H) Basement Window (with possible window well) (See Sketch) Note: No Charge as per Fonzie C.
1 - FRONT EXTERIOR - DOOR - Install EXTENDED HEIGHT DOUBLE DOORS (delete applicable sidelites and transom window above) in lieu of builders standard height single door (See Sketch) Note:
1 - MAIN FLOOR - INTERIOR DOORS - Install EXTENDED HEIGHT Interior Door (Includes Standard Interior Door Style Only) (x1 Door) To be installed at Foyer Closet Door ONLY (See Sketch) Note: Remaining Interior Doors (x3) at Main Floor to Remain Standard Height. To Include; Mud Room Closet, Powder Room and Door Leading to Basement.
13 - 2ND FLOOR - INTERIOR DOORS - Install EXTENDED HEIGHT Interior Door (Includes Standard Interior Door Style Only) (x13 Doors) To be installed throughout 2nd floor interior doors, where applicable (See Sketch) Note: To Include; Primary Bedroom Doors, Primary Bedroom W.I.C, Primary Ensuite, Laundry Room, Linen Closet, Main Bath, Bedroom #2, Bedroom #2 Closet, Ensuite #2, Bedroom #3 and Bedroom #3 Closet
1 - PRIMARY ENSUITE - Install UPGRADE 2x2 Mosaic Floor Tile and 6" Curb with White Quartz in lieu of builders standard acrylic shower base. Enlarge shower stall to approx. 42" x 71" (as per Fonzie C.) (See Sketch) Note: Delete Builders Standard Chrome Framed Shower Glass Panel & Chrome Framed Shower Door. Front of Shower Stall to be LEFT OPEN. Purchaser to Supply and Install Own Glass at shower stall AFTER CLOSING No Additional Cost for Standard Wall Tiles - As per Fonzie C.
1 - 2ND FLOOR - CEILINGS - Install UPGRADE SMOOTH CEILINGS - To be installed throughout 2nd floor, where applicable. To Include; Upper Hall, Primary Bedroom, Bedroom #2 and Bedroom #3 (See Sketch) Note:



PURCHASER: CHANG YOU HE

TEL: RES.: 647-866-0188

LOT NUMBER	PHASE	HOUSE TYPE	CLOSING DATE	
020 BLOCK 003	1	THE KATHERINE(END)-ELEV A-3 BDRM-3 BATHS	16-Jun-26	

Date Added: 28-Jul-25

Invoice Number: 8871

1 - GREAT ROOM - WINDOW - Enlarge existing rear window at great room. To be Approx. New Rough-Opening of 85" x 69" (Approved as per Fonzie C.) (See Sketch)
Note: Priced as per Fonzie C.

1 - PRIMARY BEDROOM - WINDOW - Enlarge existing window at primary bedroom. To be Approx. New Rough-Opening of 85" x 69" (Approved as per Fonzie C.) (See Sketch)
Note: Priced as per Fonzie C.

1 - BONUS PACKAGE - PURCHASER HAS APPLIED \$10,000.00 (Includes Taxes) WORTH OF UPGRADE PROMOTIONAL PACKAGE TOWARDS THE PURCHASE OF STRUCTURAL UPGRADES COMPLETED AT THE DECOR CENTRE
Note:

1 - PURCHASER HAS ATTENDED A STRUCTURAL APPOINTMENT AT THE DESIGN STUDIO AND HAS DECLINED ANY ADDITIONAL UPGRADES. Purchaser accepts and acknowledges that there will be no further structural changes/additions/deletions to be made upon signing on JULY 28,2025

Note:

1 - PURCHASER AWARE AND ACCEPTS THAT ANY CHANGES MADE TO UPGRADES AFTER SIGNING THIS PURCHASERS EXTRA FORM ARE SUBJECT TO A MINIMUM ADMINISTRATION FEE OF \$1,000
Note:

This Document is Extremely Time Sensitive - Printed 14 Aug 25 at 13:30



Room	Interior Paint	Cabinet	Style	Countertop	Counter Edge	Handle / Knob		
Primary Ensuite	STANDARD - SILVER BIRCH	✓	CATEGORY 4 - LP LAMINATE - MARIA (VG) (TX) - QTM 1922 (UPG)	✓	EVEREST VANILLA WHITE (STD)	✓	A " EDGE (STD)	DH00015
Main Bath	STANDARD - SILVER BIRCH	✓	CATEGORY 4 - LP LAMINATE - MARIA (VG) (TX) - QTM 1922 (UPG)	✓	EVEREST VANILLA WHITE (STD)	✓	A " EDGE (STD)	DH00015
Ensuite #2	STANDARD - SILVER BIRCH	✓	CATEGORY 4 - LP LAMINATE - MARIA (VG) (TX) - QTM 1922 (UPG)	✓	EVEREST VANILLA WHITE (STD)	✓	A " EDGE (STD)	DH00015
Laundry (2nd Floor)	STANDARD - SILVER BIRCH		NONE		NONE		NONE	
Powder Room	STANDARD - SILVER BIRCH	✓	CATEGORY 4 - LP LAMINATE - FLAVIE (VG) (TX) - QTM 1922 (UPG)	✓	EVEREST VANILLA WHITE (STD)	✓	A " EDGE (STD)	DH00015
Mud Room	STANDARD - SILVER BIRCH		N/A		N/A		N/A	
Kitchen/Dinette	STANDARD - SILVER BIRCH		CATEGORY 1 - LP LAMINATE - WILLOW GREY (SM) - QTS 1022 (STD)	✓	EVEREST VANILLA WHITE (STD)	✓	A " EDGE (STD)	DH00015
Foyer	STANDARD - SILVER BIRCH							

Cabinet	Style	Countertop	Counter Edge	Handle / Knob
	CATEGORY 4 - LP LAMINATE - MARIA (VG) (TX) - QTM 1922 (UPG)	✓ EVEREST VANILLA WHITE (STD)	✓ A " EDGE (STD)	DH00015
	CATEGORY 4 - LP LAMINATE - MARIA (VG) (TX) - QTM 1922 (UPG)	✓ EVEREST VANILLA WHITE (STD)	✓ A " EDGE (STD)	DH00015
	CATEGORY 4 - LP LAMINATE - MARIA (VG) (TX) - QTM 1922 (UPG)	✓ EVEREST VANILLA WHITE (STD)	✓ A " EDGE (STD)	DH00015
	NONE	NONE	NONE	NONE
	CATEGORY 4 - LP LAMINATE - FLAVIE (VG) (TX) - QTM 1922 (UPG)	✓ EVEREST VANILLA WHITE (STD)	✓ A " EDGE (STD)	DH00015
	N/A	N/A	N/A	N/A
	CATEGORY 1 - LP LAMINATE - WILLOW GREY (SM) - QTS 1022 (STD)	✓ EVEREST VANILLA WHITE (STD)	✓ A " EDGE (STD)	DH00015

**Kitchen Sink - Install Standard Undermount Sink - Kindred Undermount Sink - Model #RPU183177. **Kitchen Faucet - Install Standard Faucet - MOEN Method Single Handle Pull-Out (Single Hole) Kitchen Faucet - Model # 7585 - Chrome **APPLIANCES - STANDARD APPLIANCE PACKAGE (See Attached)

	N/A	Fireplace
	N/A	Fireplace
	N/A	Location Flooring
	N/A	Style
	N/A	Finish
	N/A	Marble
	N/A	Hearth
	N/A	

Vendor: EARLEEN INVESTMENTS INC.

Lot: 020 BLOCK 003 Project: EARLGLEN INVESTMENTS INC. Model: THE KATHERINE(END)-ELEV A-3 BDRM-3 BATHS

Lot 20 / BIK3




80 Sante Drive, Vaughan, ON L4K 3C4
T 416.746.1811 F 905.761.5901
www.QTK.ca info@qtk.ca

CLIENT: ROYAL PINE HOMES	JOB NAME: 2018	ROOM: KITCHEN	DRAWN BY: PS
SITE: EARLGLEN	DOOR STYLE: _	DOOR HANDLE: _	SCALE: 1/2" = 1'-0"
PHONE: _	FINISH: _	DRW HANDLE: _	DATE: 07 APRIL 2025
EMAIL: _	SPECIES: _	TOP: _	PAGE: 1 OF 1
COMMENTS:	CUSTOMER INITIALS: _____		

Customer Agrees and Accepts the following conditions: 1. The Drawing is a representation only and the installed cabinetry may vary slightly in product size, measurements, handle appearance and location and other details. Although Quality Tops & Kitchens Ltd. (QTK) does it's best to manufacture exactly what is shown here outside factors may prevent that and some variance is to be expected and accepted by the customer. 2. These drawings represent the intellectual property of QTK and as such the customer understands and accepts that all deposits given by the customer to QTK are non-refundable after QTK has supplied drawings (either physically or electronically) to the customer. If the customer decides to cancel the order after QTK has submitted drawings to the customer, the deposit will then be considered a design fee and no money will be returned to the customer. Door/drawer fronts with inner profiles may receive slab fronts due to rail size restrictions based on width/height of the panels or site conditions.

KITCHEN PLAN

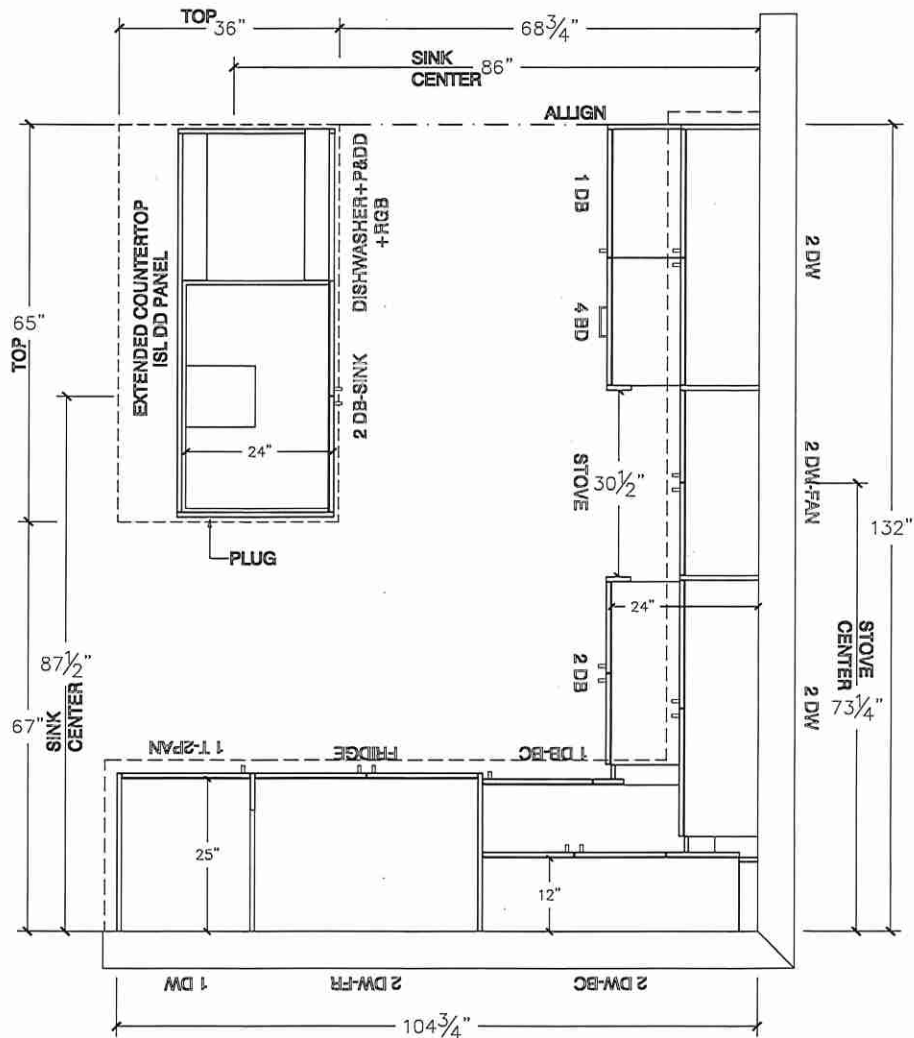


Lot 20/BIK3




80 Sante Drive, Vaughan, ON L4K 3C4
T 416.746.1811 F 905.761.5901
www.QTK.ca info@qtk.ca

CLIENT: ROYAL PINE HOMES	JOB NAME: 2018	ROOM: KITCHEN	DRAWN BY: PS
SITE: EARLGLEN	DOOR STYLE: __	DOOR HANDLE: __	SCALE: 3/8" = 1'-0"
PHONE: __	FINISH: __	DRW HANDLE: __	DATE: 07 APRIL 2025
EMAIL: __	SPECIES: __	TOP: __	PAGE: 1 OF 1
COMMENTS:	CUSTOMER INITIALS: _____		
Customer Agrees and Accepts the following conditions: 1. The Drawing is a representation only and the installed cabinetry may vary slightly in product size, measurements, handle appearance and location and other details. Although Quality Tops & Kitchens Ltd. (QTK) does it's best to manufacture exactly what is shown here outside factors may prevent that and some variance is to be expected and accepted by the customer. 2. These drawings represent the intellectual property of QTK and as such the customer understands and accepts that all deposits given by the customer to QTK are non-refundable after QTK has supplied drawings (either physically or electronically) to the customer. If the customer decides to cancel the order after QTK has submitted drawings to the customer, the deposit will then be considered a design fee and no money will be returned to the customer. Door/drawer fronts with inner profiles may receive slab fronts due to rail size restrictions based on width/height of the panels or site conditions.			

STOVE WALL ELEVATION

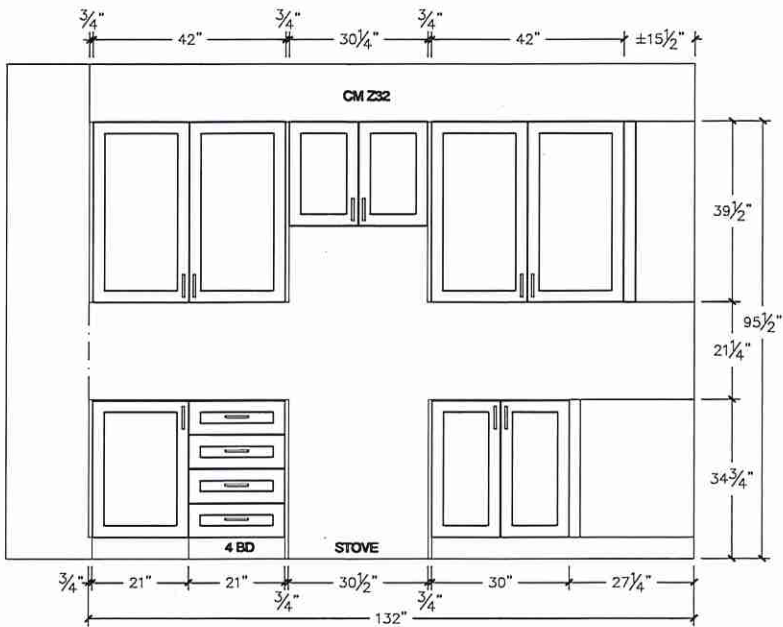

FRIDGE WALL ELEVATION

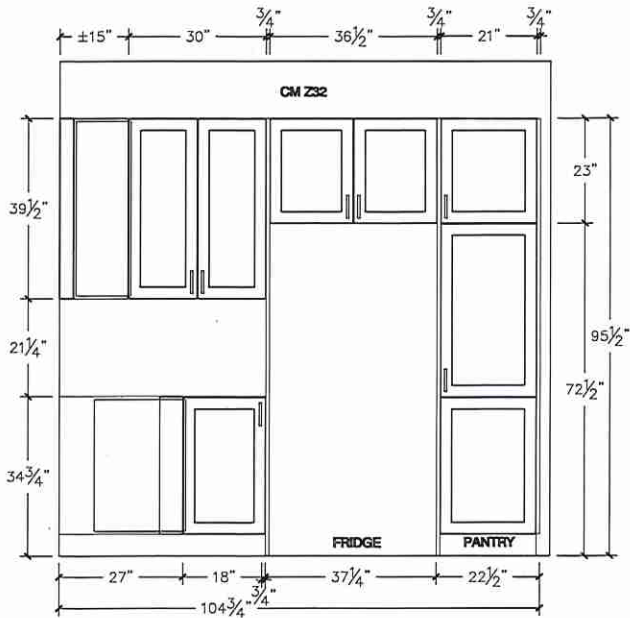

Lot 20/BLK 3




80 Sante Drive, Vaughan, ON L4K 3C4
T 416.746.1811 F 905.761.5901
www.QTK.ca info@qtk.ca


CLIENT: ROYAL PINE HOMES	JOB NAME: 2018	ROOM:	DRAWN BY: PS
SITE: EARLGLEN	DOOR STYLE: —	DOOR HANDLE: —	SCALE: 1/2" = 1'-0"
PHONE: —	FINISH: —	DRW HANDLE: —	DATE: 02 APRIL 2025
EMAIL: —	SPECIES: —	TOP: —	PAGE: 1 OF 1
COMMENTS:	CUSTOMER INITIALS:		

Customer Agrees and Accepts the following conditions: 1. The Drawing is a representation only and the installed cabinetry may vary slightly in product size, measurements, handle appearance and location and other details. Although Quality Tops & Kitchens Ltd. (QTK) does its best to manufacture exactly what is shown here outside factors may prevent that and some variance is to be expected and accepted by the customer. 2. These drawings represent the intellectual property of QTK and as such the customer understands and accepts that all deposits given by the customer to QTK are non-refundable after QTK has supplied drawings (either physically or electronically) to the customer. If the customer decides to cancel the order after QTK has submitted drawings to the customer, the deposit will then be considered a design fee and no money will be returned to the customer. Door/drawer fronts with inner profiles may receive slab fronts due to nail size restrictions based on width/height of the panels or site conditions.


ISLAND REAR ELEVATION

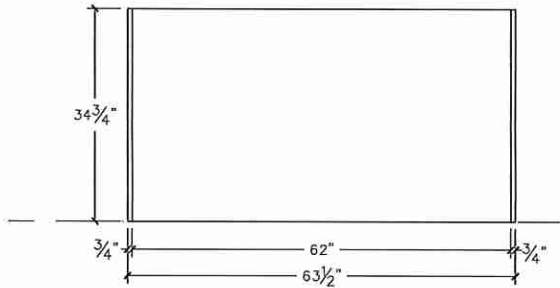

ISLAND FRONT ELEVATION

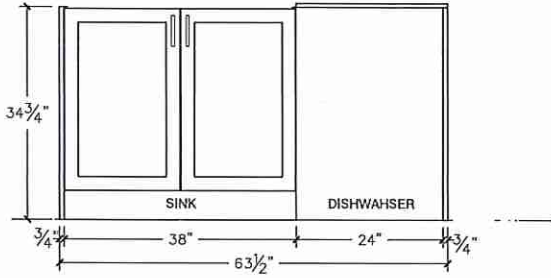

ISLAND SIDE ELEVATION

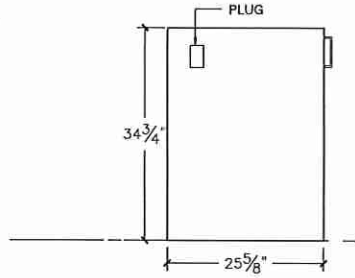

Lot 20/BLK3




80 Sante Drive, Vaughan, ON L4K 3C4
T 416.746.1811 F 905.761.5901
www.QTK.ca info@qtk.ca

CLIENT: ROYAL PINE HOMES	JOB NAME: 2018	ROOM:	DRAWN BY: PS
SITE: EARLGLEN	DOOR STYLE: —	DOOR HANDLE: —	SCALE: 1/2" = 1'-0"
PHONE: —	FINISH: —	DRW HANDLE: —	DATE: 07 APRIL 2025
EMAIL: —	SPECIES: —	TOP: —	PAGE: 1 OF 1

COMMENTS:	CUSTOMER INITIALS:
-----------	--------------------

Customer Agrees and Accepts the following conditions: 1. The Drawing is a representation only and the installed cabinetry may vary slightly in product size, measurements, handle appearance and location and other details. Although Quality Tops & Kitchens Ltd. (QTK) does its best to manufacture exactly what is shown here outside factors may prevent that and some variance is to be expected and accepted by the customer. 2. These drawings represent the intellectual property of QTK and as such the customer understands and accepts that all deposits given by the customer to QTK are non-refundable after QTK has supplied drawings (either physically or electronically) to the customer. If the customer decides to cancel the order after QTK has submitted drawings to the customer, the deposit will then be considered a design fee and no money will be returned to the customer. Door/drawer fronts with inner profiles may receive slab fronts due to rail size restrictions based on width/height of the panels or site conditions.

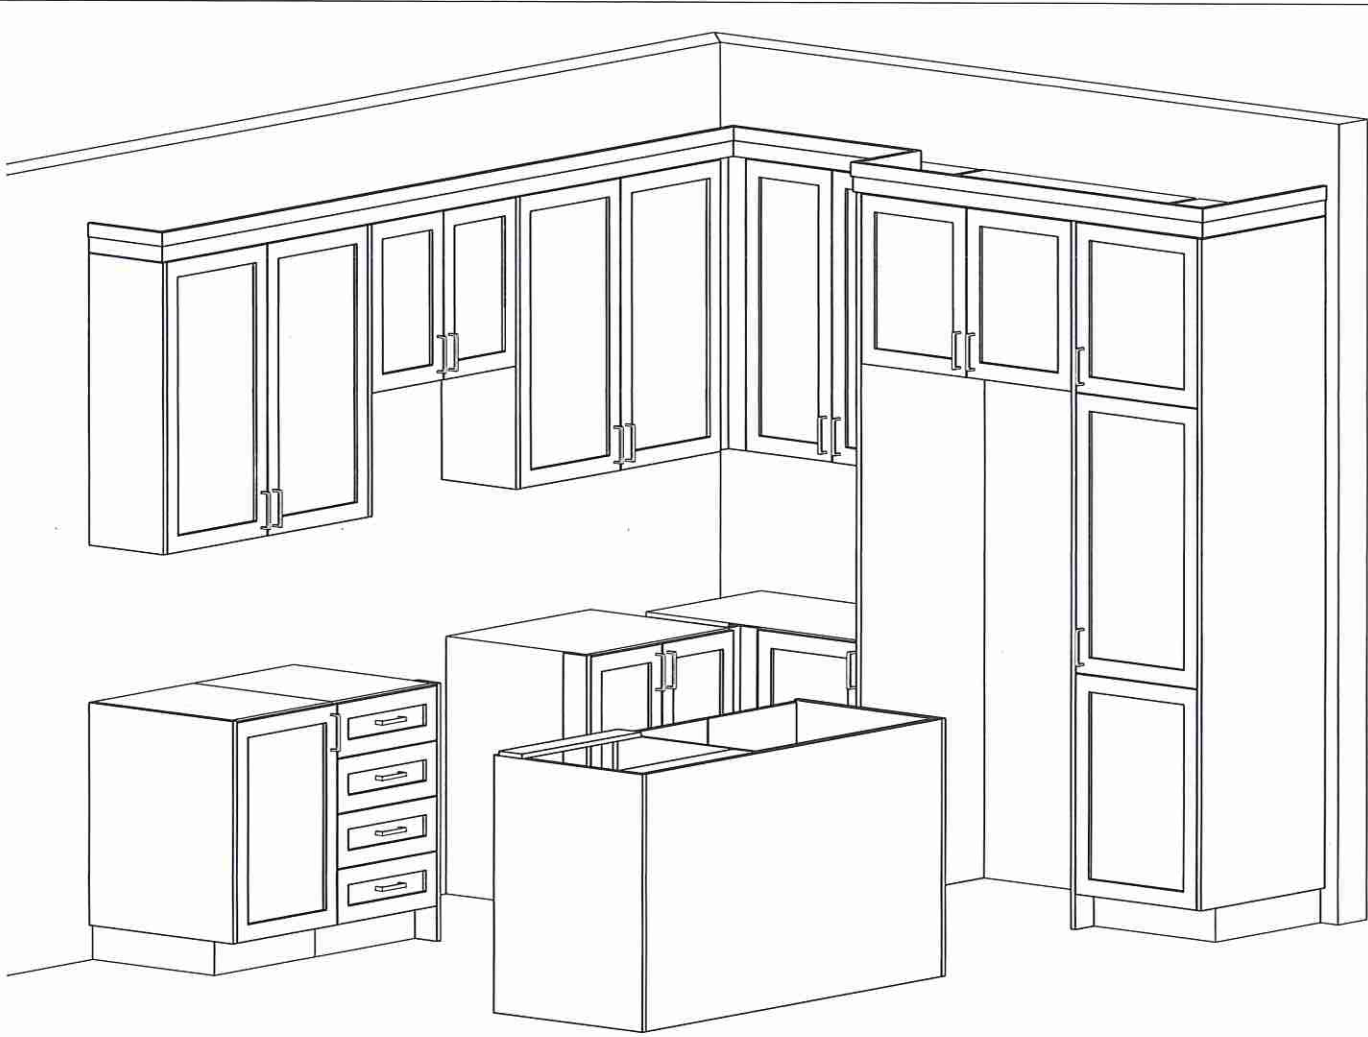

Lot 20/BLK3




80 Sante Drive, Vaughan, ON L4K 3C4
T 416.746.1811 F 905.761.5901
www.QTK.ca info@qtk.ca


CLIENT: ROYAL PINE HOMES	JOB NAME: BLK 3-20 EG (2018)	ROOM: VANITIES	DRAWN BY: PS
SITE: EARL GLEN	DOOR STYLE: —	DOOR HANDLE: —	SCALE: 1/2" = 1'-0"
PHONE: —	FINISH: —	DRW HANDLE: —	DATE: 14 AUG 2025
EMAIL: —	SPECIES: —	TOP: —	PAGE: 1 OF 1
COMMENTS:	CUSTOMER INITIALS:		

Customer Agrees and Accepts the following conditions: 1. The Drawing is a representation only and the installed cabinetry may vary slightly in product size, measurements, handle appearance and location and other details. Although Quality Tops & Kitchens Ltd. (QTK) does it's best to manufacture exactly what is shown here outside factors may prevent that and some variance is to be expected and accepted by the customer. 2. These drawings represent the intellectual property of QTK and as such the customer understands and accepts that all deposits given by the customer to QTK are non-refundable after QTK has supplied drawings (either physically or electronically) to the customer. If the customer decides to cancel the order after QTK has submitted drawings to the customer, the deposit will then be considered a design fee and no money will be returned to the customer. Door/drawer fronts with inner profiles may receive slab fronts due to rail size restrictions based on width/height of the panels or site conditions.

MASTER ENSUITE PLAN

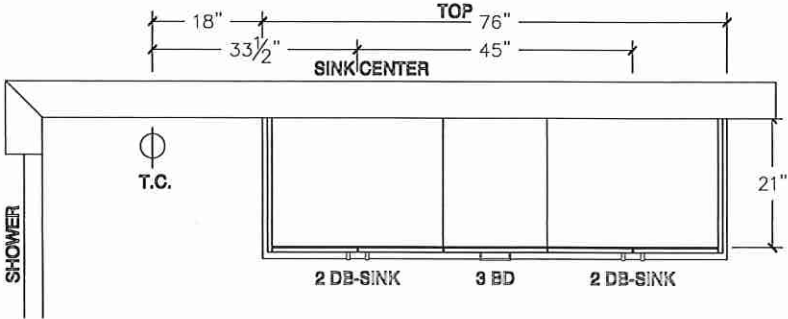

MASTER ENSUITE ELEVATION

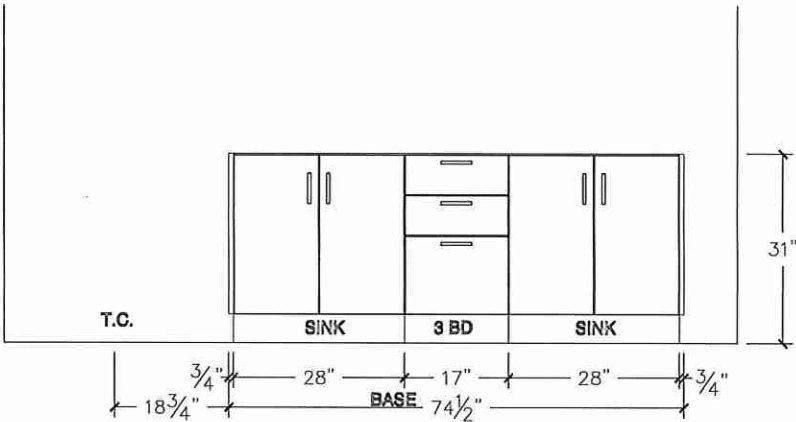

Lot 20/BIK3




80 Sante Drive, Vaughan, ON L4K 3C4
T 416.746.1811 F 905.761.5901
www.QTK.ca info@qtk.ca


CLIENT: ROYAL PINE HOMES	JOB NAME: 2018	ROOM: VANITIES	DRAWN BY: PS
SITE: EARL GLEN	DOOR STYLE: —	DOOR HANDLE: —	SCALE: 1/2" = 1'-0"
PHONE: —	FINISH: —	DRW HANDLE: —	DATE: 02 APRIL 2025
EMAIL: —	SPECIES: —	TOP: —	PAGE: 1 OF 1
COMMENTS:	CUSTOMER INITIALS:		

Customer Agrees and Accepts the following conditions: 1. The Drawing is a representation only and the installed cabinetry may vary slightly in product size, measurements, handle appearance and location and other details. Although Quality Tops & Kitchens Ltd. (QTK) does its best to manufacture exactly what is shown here outside factors may prevent that and some variance is to be expected and accepted by the customer. 2. These drawings represent the intellectual property of QTK and as such the customer understands and accepts that all deposits given by the customer to QTK are non-refundable after QTK has supplied drawings (either physically or electronically) to the customer. If the customer decides to cancel the order after QTK has submitted drawings to the customer, the deposit will then be considered a design fee and no money will be returned to the customer. Door/drawer fronts with inner profiles may receive slab fronts due to rail size restrictions based on width/height of the panels or site conditions.


MAIN BATH PLAN

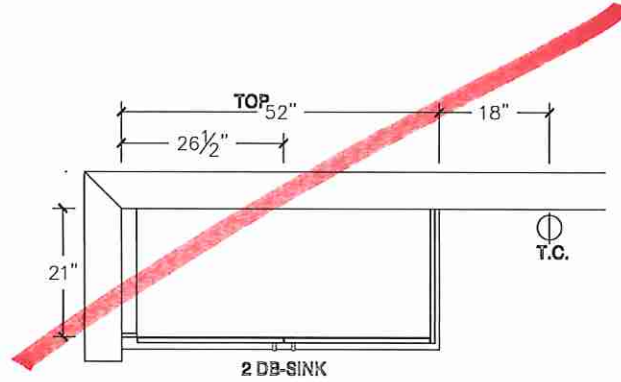


MAIN BATH PLAN (OPT W/ 3 BATH)

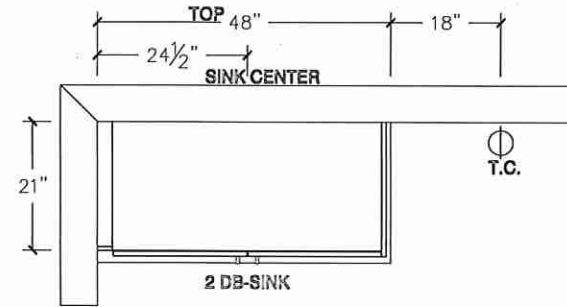

MAIN BATH ELEVATION

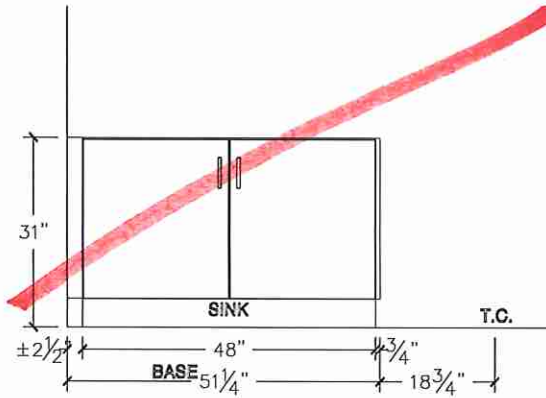

MAIN BATH ELEVATION (OPT W/ 3 BATH)

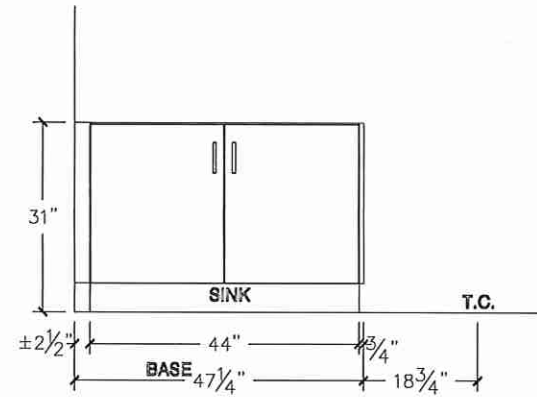

Lot 20/BLK3




80 Sante Drive, Vaughan, ON L4K 3C4
T 416.746.1811 F 905.761.5901
www.QTK.ca info@qtk.ca


CLIENT: ROYAL PINE HOMES	JOB NAME: 2018	ROOM: VANITIES	DRAWN BY: PS
SITE: EARLGLEN	DOOR STYLE: —	DOOR HANDLE: —	SCALE: 1/2" = 1'-0"
PHONE: —	FINISH: —	DRW HANDLE: —	DATE: 02 APRIL 2025
EMAIL: —	SPECIES: —	TOP: —	PAGE: 1 OF 1
COMMENTS:	CUSTOMER INITIALS:		

Customer Agrees and Accepts the following conditions: 1. The Drawing is a representation only and the installed cabinetry may vary slightly in product size, measurements, handle appearance and location and other details. Although Quality Tops & Kitchens Ltd. (QTK) does its best to manufacture exactly what is shown here outside factors may prevent that and some variance is to be expected and accepted by the customer. 2. These drawings represent the intellectual property of QTK and as such the customer understands and accepts that all deposits given by the customer to QTK are non-refundable after QTK has supplied drawings (either physically or electronically) to the customer. If the customer decides to cancel the order after QTK has submitted drawings to the customer, the deposit will then be considered a design fee and no money will be returned to the customer. Door/drawer fronts with inner profiles may receive slab fronts due to rail size restrictions based on width/height of the panels or site conditions.


MAIN BATH PLAN (OPT W/ FLEX SPACE)

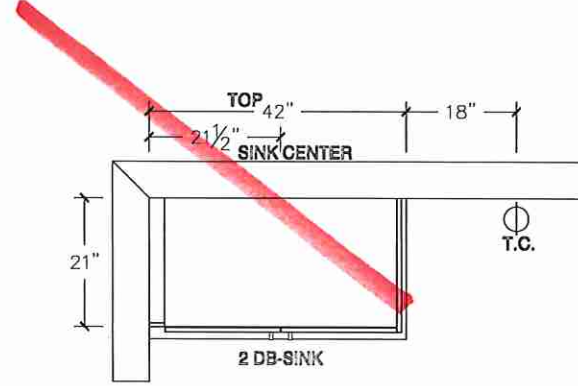


BATH 2 PLAN (OPT W/ 3 BATH)

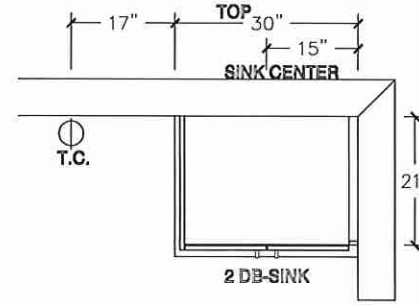

MAIN BATH ELEVATION (OPT FLEX ROOM)

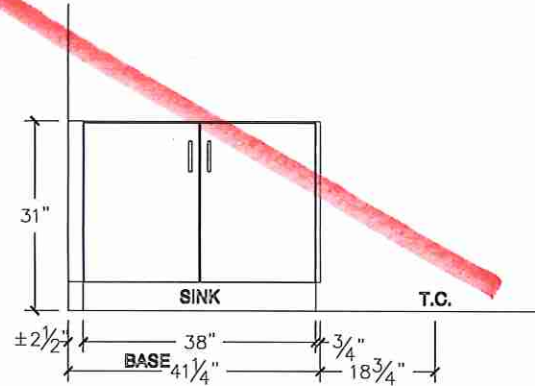

BATH 2 ELEVATION (OPT W/ 3 BATH)

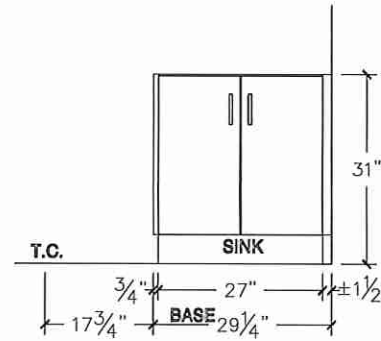

Lot 20/BIK3




80 Sante Drive, Vaughan, ON L4K 3C4
T 416.746.1811 F 905.761.5901
www.QTK.ca info@qtk.ca


CLIENT: ROYAL PINE HOMES	JOB NAME: 2018	ROOM: VANITIES	DRAWN BY: PS
SITE: EARLGLEN	DOOR STYLE: —	DOOR HANDLE: —	SCALE: 1/2" = 1'-0"
PHONE: —	FINISH: —	DRW HANDLE: —	DATE: 07 APRIL 2025
EMAIL: —	SPECIES: —	TOP: —	PAGE: 1 OF 1
COMMENTS:	CUSTOMER INITIALS:		

Customer Agrees and Accepts the following conditions: 1. The Drawing is a representation only and the installed cabinetry may vary slightly in product size, measurements, handle appearance and location and other details. Although Quality Tops & Kitchens Ltd. (QTK) does its best to manufacture exactly what is shown here outside factors may prevent that and some variance is to be expected and accepted by the customer. 2. These drawings represent the intellectual property of QTK and as such the customer understands and accepts that all deposits given by the customer to QTK are non-refundable after QTK has supplied drawings (either physically or electronically) to the customer. If the customer decides to cancel the order after QTK has submitted drawings to the customer, the deposit will then be considered a design fee and no money will be returned to the customer. Door/drawer fronts with inner profiles may receive slab fronts due to rail size restrictions based on width/height of the panels or site conditions.


OPT BSMT BATH PLAN

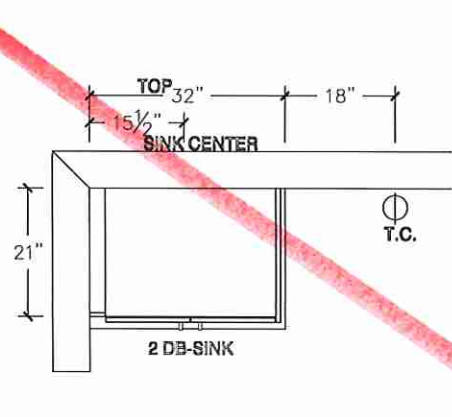

POWDER ROOM PLAN

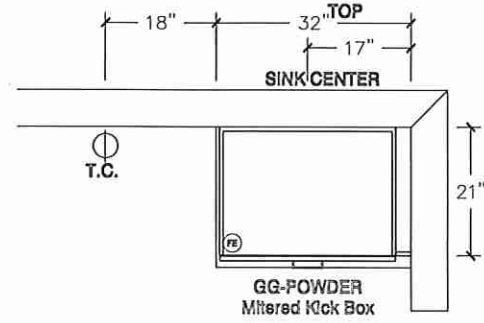

OPT BSMT BATH ELEVATION

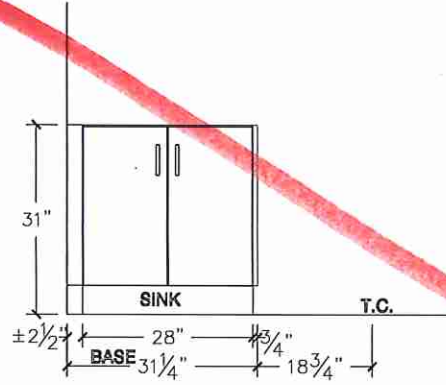

POWDER ROOM ELEVATION

