



LOT

XXxx

DATE

XX/XX/XX

THIS DRAWINGS IS TO BE USED IN CONJUNCTION WITH SCHEDULE B-1A AND MAY SHOW ONLY SOME OF THE CHANGES DETAILED ON THAT DOCUMENT. SHOULD THE DRAWINGS NOT SHOW ALL ITEMS CONTAINED ON A SCHEDULE OR MISS OTHER ITEMS ALTOGETHER, THE SCHEDULE IS CONSIDERED THE GOVERNING DOCUMENT.

TENDER 2017

I SCOTT IRWIN BCIN 2076520765 HAVE REVIEWED AND TAKE RESPONSIBILITY FOR DESIGN ACTIVITIES RELATING TO.

HOUSE & SMALL BUILDINGS

EXTERIOR FINISH LEGEND

B

-

BRICK (MAIN)

B1

-

BRICK SOLDIER COURSE (ACCENT)

B2

-

BRICK SOLDIER COURSE (ACCENT)

20mm

PROUD

B3

-

BRICK SLEEPER COURSE

B4

-

STACK BOND (ACCENT)

B5

-

BRICK SILL (ACCENT)

B6

-

BRICK ROW LOCK (ACCENT)

B7

-

BRICK CORBELLING

B8

-

BRICK COINING 20mm PROUD

+20

-

BRICK 20mm PROUD

-20

-

BRICK RECESSED 20mm

S

-

SIDING (HORIZONTAL)

ST

-

STONE VENEER

T

-

TRIM 200mm COVE SIDING

AF

-

ALUMINUM FASCIA

AC

-

ALUMINUM CLADDING

AS

-

ASPHALT SHINGLES

F

-

FLASHING

V

-

ROOF VENT MAX

P

-

PARGING

PC

-

PRECAST

PCH10

-

PRECAST HEADER 10"

PCH8

-

PRECAST HEADER 8"

PCS

-

PRECAST SILL

PCB

-

PRECAST BAND

VS

-

VINYL SHAKES

2012 OBC DRAWINGS

4.	ISSUED FOR 2016 TENDER	01/01/16	
3.	DORMER HT. ADDED	02/07/15	SI
2.	AS PER STRUCTURAL	30/01/15	
1.	STANDARD DRAWINGS	27/05/14	SI
NO.	DESCRIPTION	DATE	BY

Valecraft

Home Ld.

TITLE:

FRONT ELEVATION

ACAD FILE:


160-The Stanley 2012 Footprint (STANDARD DRAWINGS)

SCALE:


3/16" = 1'-0"

DWG.


A-1

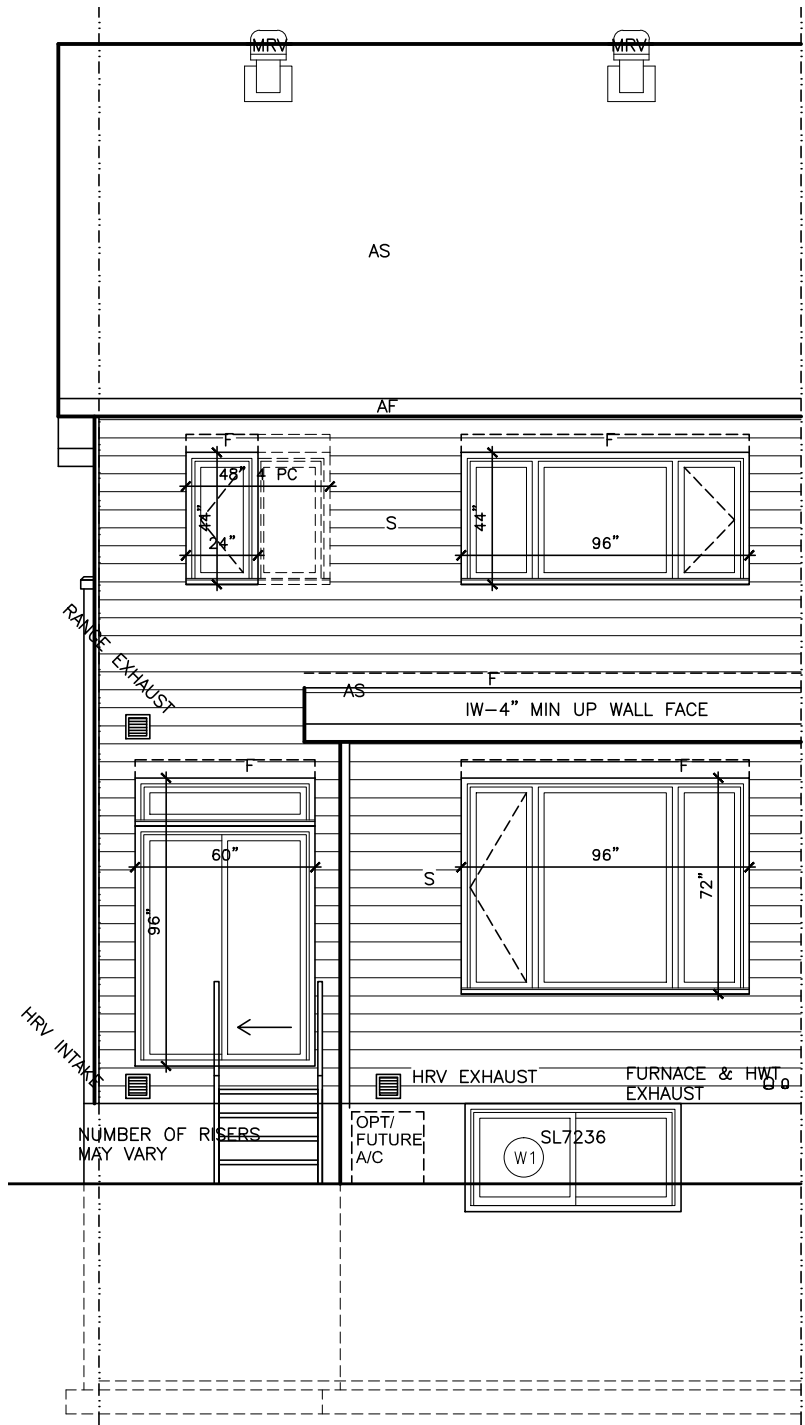

Standard Right Side Unit

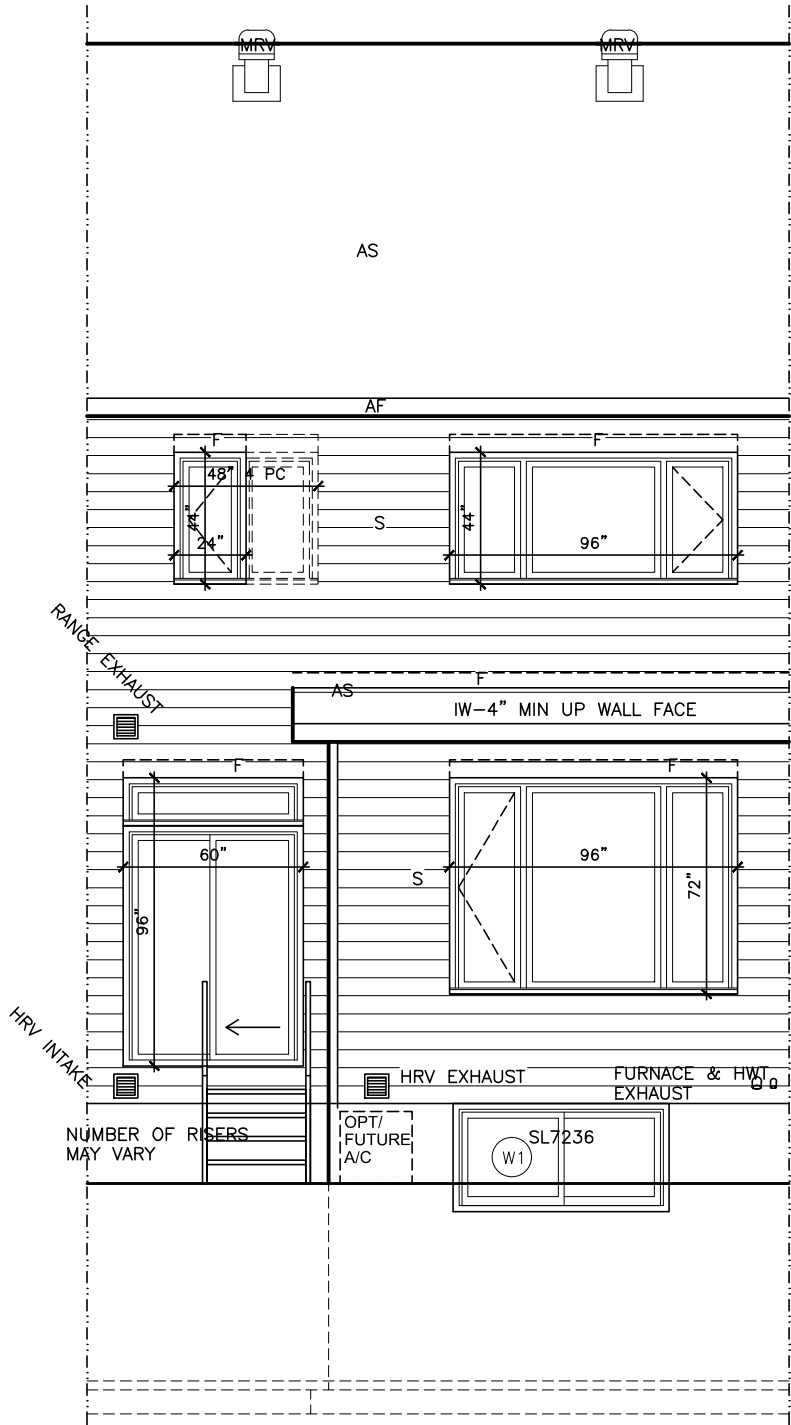

Standard Mid Unit

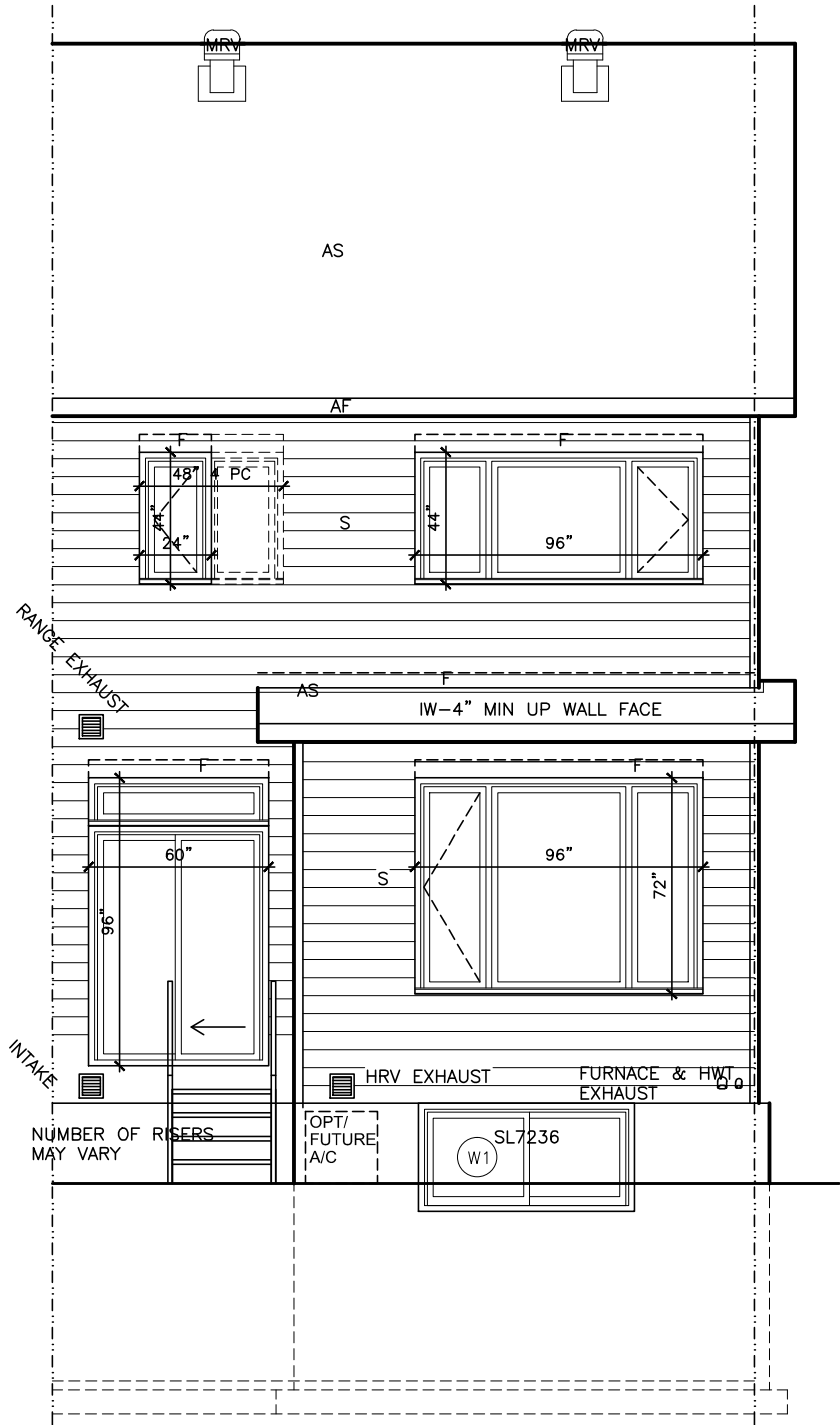

Standard Left Side Unit

LOT XXxx

DATE XX/XX/XX

THIS DRAWING IS TO BE USED IN CONJUNCTION WITH SCHEDULE B-1A AND MAY SHOW ONLY SOME OF THE CHANGES DETAILED ON THAT DOCUMENT. SHOULD THE DRAWINGS NOT SHOW ALL ITEMS CONTAINED ON A SCHEDULE OR MISS OTHER ITEMS ALTOGETHER, THE SCHEDULE IS CONSIDERED THE GOVERNING DOCUMENT. FLOORS CONT. TENDER 2017

I SCOTT IRWIN BCIN 20765 HAVE REVIEWED AND TAKE RESPONSIBILITY FOR DESIGN ACTIVITIES RELATING TO, HOUSE & SMALL BUILDINGS.

EXTERIOR FINISH LEGEND	
B	- BRICK (MAIN)
B1	- BRICK SOLDIER COURSE (ACCENT)
B2	- BRICK SOLDIER COURSE (ACCENT) 20mm PROUD
B3	- BRICK SLEEPER COURSE
B4	- STACK BOND (ACCENT)
B5	- BRICK SILL (ACCENT)
B6	- BRICK ROW LOCK (ACCENT)
B7	- BRICK CORBELLING
B8	- BRICK COINING 20mm PROUD
+20	- BRICK 20mm PROUD
-20	- BRICK RECESSED 20mm
S	- SIDING (HORIZONTAL)
ST	- STONE VENEER
T	- TRIM 200mm COVE SIDING
AF	- ALUMINUM FACIA
AC	- ALUMINUM CLADDING
AS	- ASPHALT SHINGLES
F	- FLASHING
V	- ROOF VENT MAX
P	- PARING
PC	- PRECAST
PCH10	- PRECAST HEADER 10"
PCH8	- PRECAST HEADER 8"
PCS	- PRECAST SILL
PCB	- PRECAST BAND
VS	- VINYL SHAKES

2012 OBC DRAWINGS

NO.	DESCRIPTION	DATE	BY
3.	ISSUED FOR 2016 TENDER	01/01/16	
2.	AS PER STRUCTURAL	30/01/15	
1.	STANDARD DRAWINGS	27/05/14	SI



TITLE: REAR-Stanley 1

ACAD FILE: SCALE: 3/16" = 1'-0"

160-The Stanley 2012 Footprint (STANDARD DRAWINGS) DWG. A-2

LOT **XXxx**

DATE **XX/XX/XX**

THIS DRAWINGS IS TO BE USED IN CONJUNCTION WITH SCHEDULE B-1A AND MAY SHOW ONLY SOME OF THE CHANGES DETAILED ON THAT DOCUMENT. SHOULD THE DRAWINGS NOT SHOW ALL ITEMS CONTAINED ON A SCHEDULE OR MISS OTHER ITEMS ALTOGETHER, THE SCHEDULE IS CONSIDERED THE GOVERNING DOCUMENT.
FLOORS CONT

TENDER 2017

I **SCOTT IRWIN BCIN 20765** HAVE REVIEWED AND TAKE RESPONSIBILITY FOR DESIGN ACTIVITIES RELATING TO, HOUSE & SMALL BUILDINGS _____.

EXTERIOR FINISH LEGEND	
B	- BRICK (MAIN)
B1	- BRICK SOLDIER COURSE (ACCENT)
B2	- BRICK SOLDIER COURSE (ACCENT) 20mm PROUD
B3	- BRICK SLEEPER COURSE
B4	- STACK BOND (ACCENT)
B5	- BRICK SILL (ACCENT)
B6	- BRICK ROW LOCK (ACCENT)
B7	- BRICK CORBELLING
B8	- BRICK COINING 20mm PROUD
+20	- BRICK 20mm PROUD
-20	- BRICK RECESSED 20mm
S	- SIDING (HORIZONTAL)
ST	- STONE VENEER
T	- TRIM 200mm COVE SIDING
AF	- ALUMINUM FACIA
AC	- ALUMINUM CLADDING
AS	- ASPHALT SHINGLES
F	- FLASHING
V	- ROOF VENT MAX
PC	- PARCAST
PCH10	- PRECAST HEADER 10"
PCH8	- PRECAST HEADER 8"
PCS	- PRECAST SILL
PCB	- PRECAST BAND
VS	- VINYL SHAKES

2012 OBC DRAWINGS

3.	ISSUED FOR 2016 TENDER	01/01/16	
2.	AS PER STRUCTURAL	30/01/15	
1.	STANDARD DRAWINGS	27/05/14	SI
NO	DESCRIPTION	DATE	BY






TITLE: **REAR-Stanley 2**

ACAD FILE: SCALE: 3/16" = 1'-0"

160-The Stanley
2012 Footprint
(STANDARD DRAWINGS)

A-2b

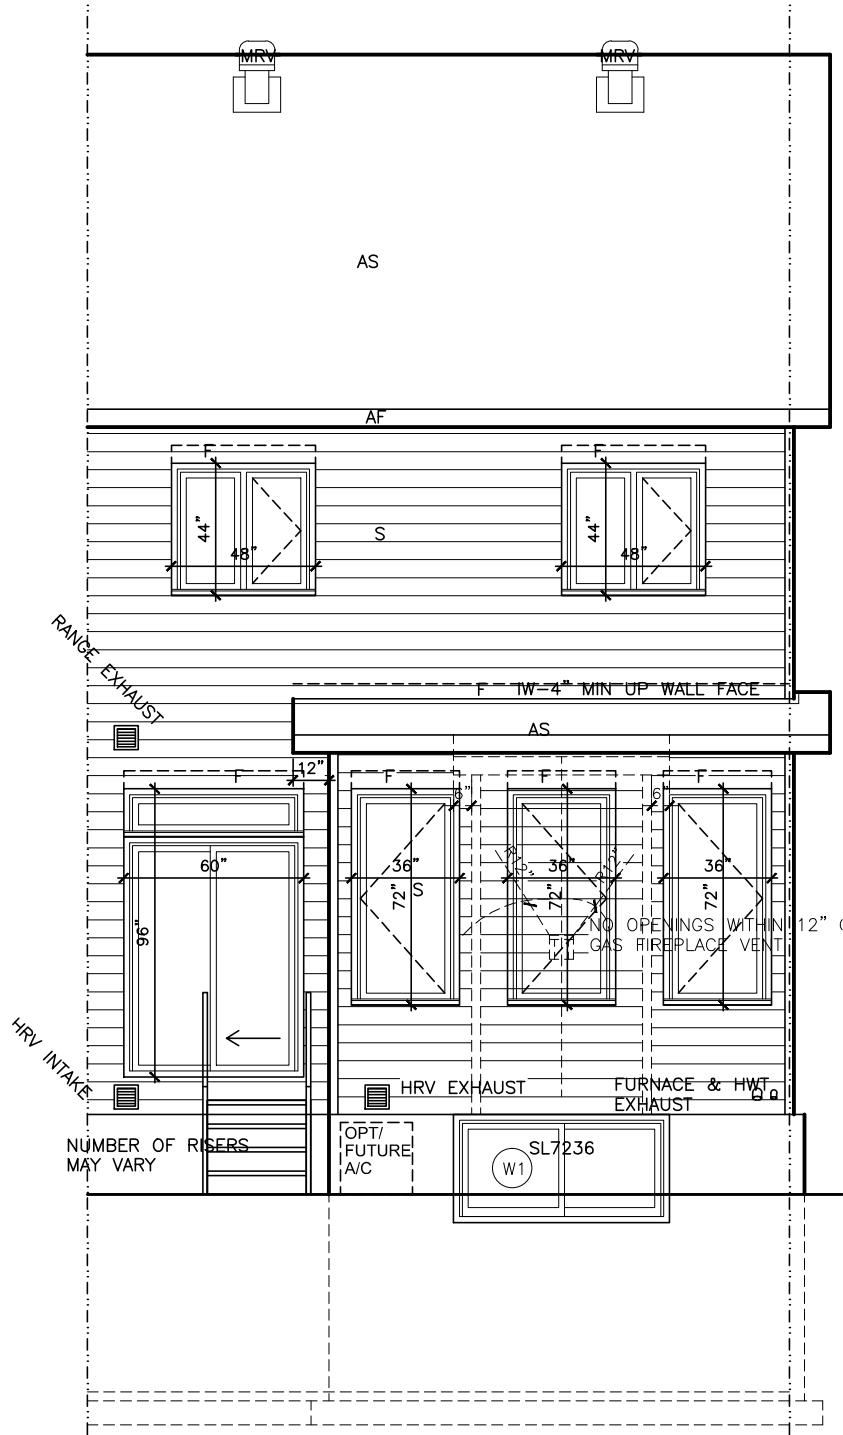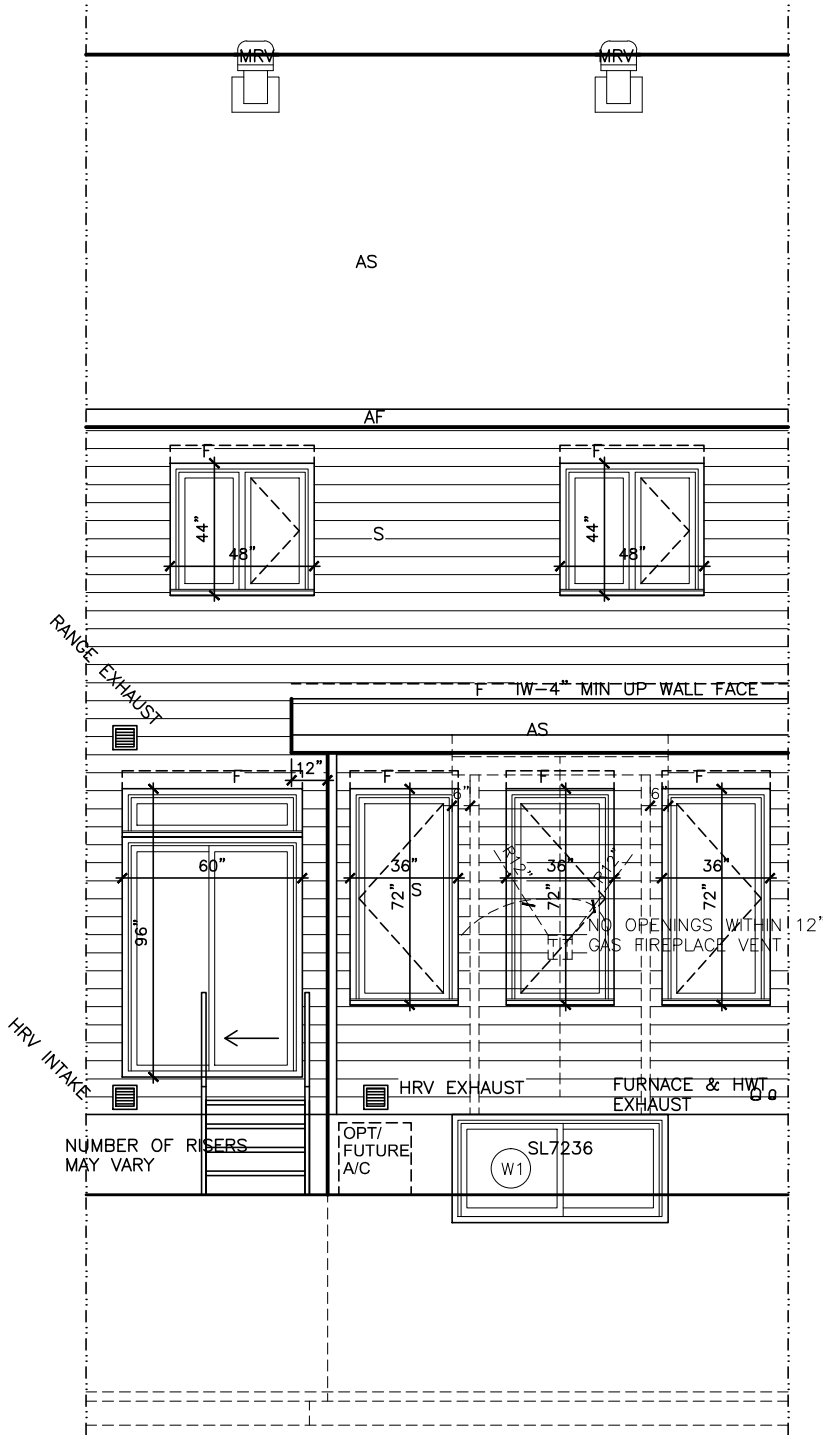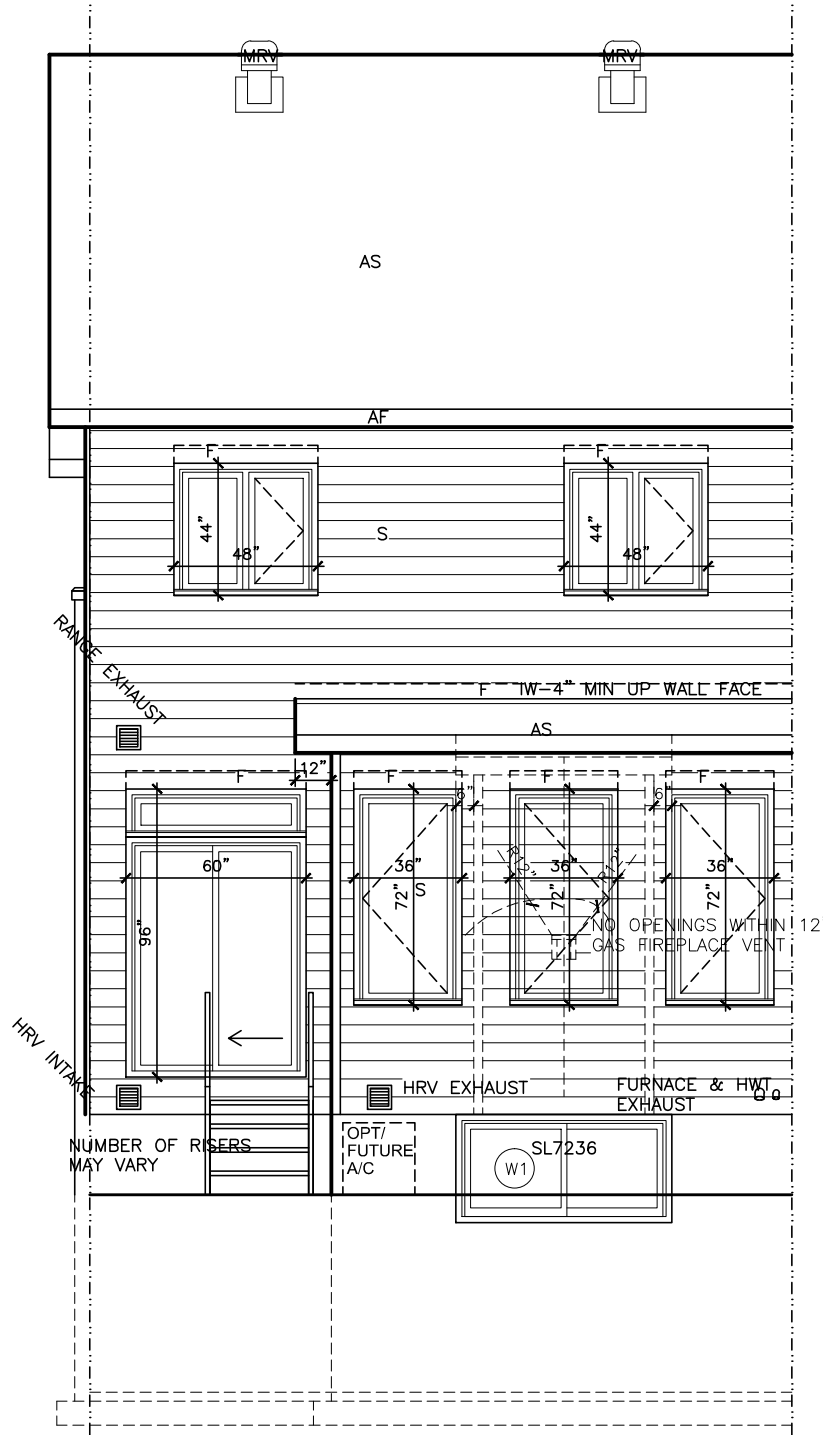

THIS DRAWINGS IS TO BE USED IN CONJUNCTION WITH SCHEDULE B-1A AND MAY SHOW ONLY SOME OF THE CHANGES DETAILED ON THAT DOCUMENT. SHOULD THE DRAWINGS NOT SHOW ALL ITEMS CONTAINED ON A SCHEDULE OR MISS OTHER ITEMS ALTOGETHER, THE SCHEDULE IS CONSIDERED THE GOVERNING DOCUMENT.
FLOORS CONT **TENDER 2017**

I SCOTT IRWIN BCIN 20765 HAVE REVIEWED AND TAKE RESPONSIBILITY FOR DESIGN ACTIVITIES RELATING TO, HOUSE & SMALL BUILDINGS .

EXTERIOR FINISH LEGEND	
B	- BRICK (MAIN)
B1	- BRICK SOLDIER COURSE (ACCENT)
B2	- BRICK SOLDIER COURSE (ACCENT)
	20mm PROUD
B3	- BRICK SLEEPER COURSE
B4	- STACK BOND (ACCENT)
B5	- BRICK SILL (ACCENT)
B6	- BRICK ROW LOCK (ACCENT)
B7	- BRICK CORBELLING
B8	- BRICK COINING 20mm PROUD
+20	- BRICK 20mm PROUD
-20	- BRICK RECESSED 20mm
S	- SIDING (HORIZONTAL)
ST	- STONE VENEER
T	- TRIM 200mm COVE SIDING
AF	- ALUMINUM FACIA
AC	- ALUMINUM CLADDING
AS	- ASPHALT SHINGLES
F	- FLASHING
V	- ROOF VENT MAX
P	- PARCAST
PC	- PRECAST
PCH10	- PRECAST HEADER 10"
PCH8	- PRECAST HEADER 8"
PCS	- PRECAST SILL
PCB	- PRECAST BAND
VS	- VINYL SHAKES



2012 OBC DRAWINGS


3.	ISSUED FOR 2016 TENDER	01/01/16	
2.	AS PER STRUCTURAL	30/01/15	
1.	STANDARD DRAWINGS	27/05/14	SI
NO	DESCRIPTION	DATE	BY



TITLE: **SIDE HOUSE ELEVATION**

ACAD FILE: SCALE: 3/16" = 1'-0"

160-The Stanley
2012 Footprint
(STANDARD DRAWINGS)
A-3

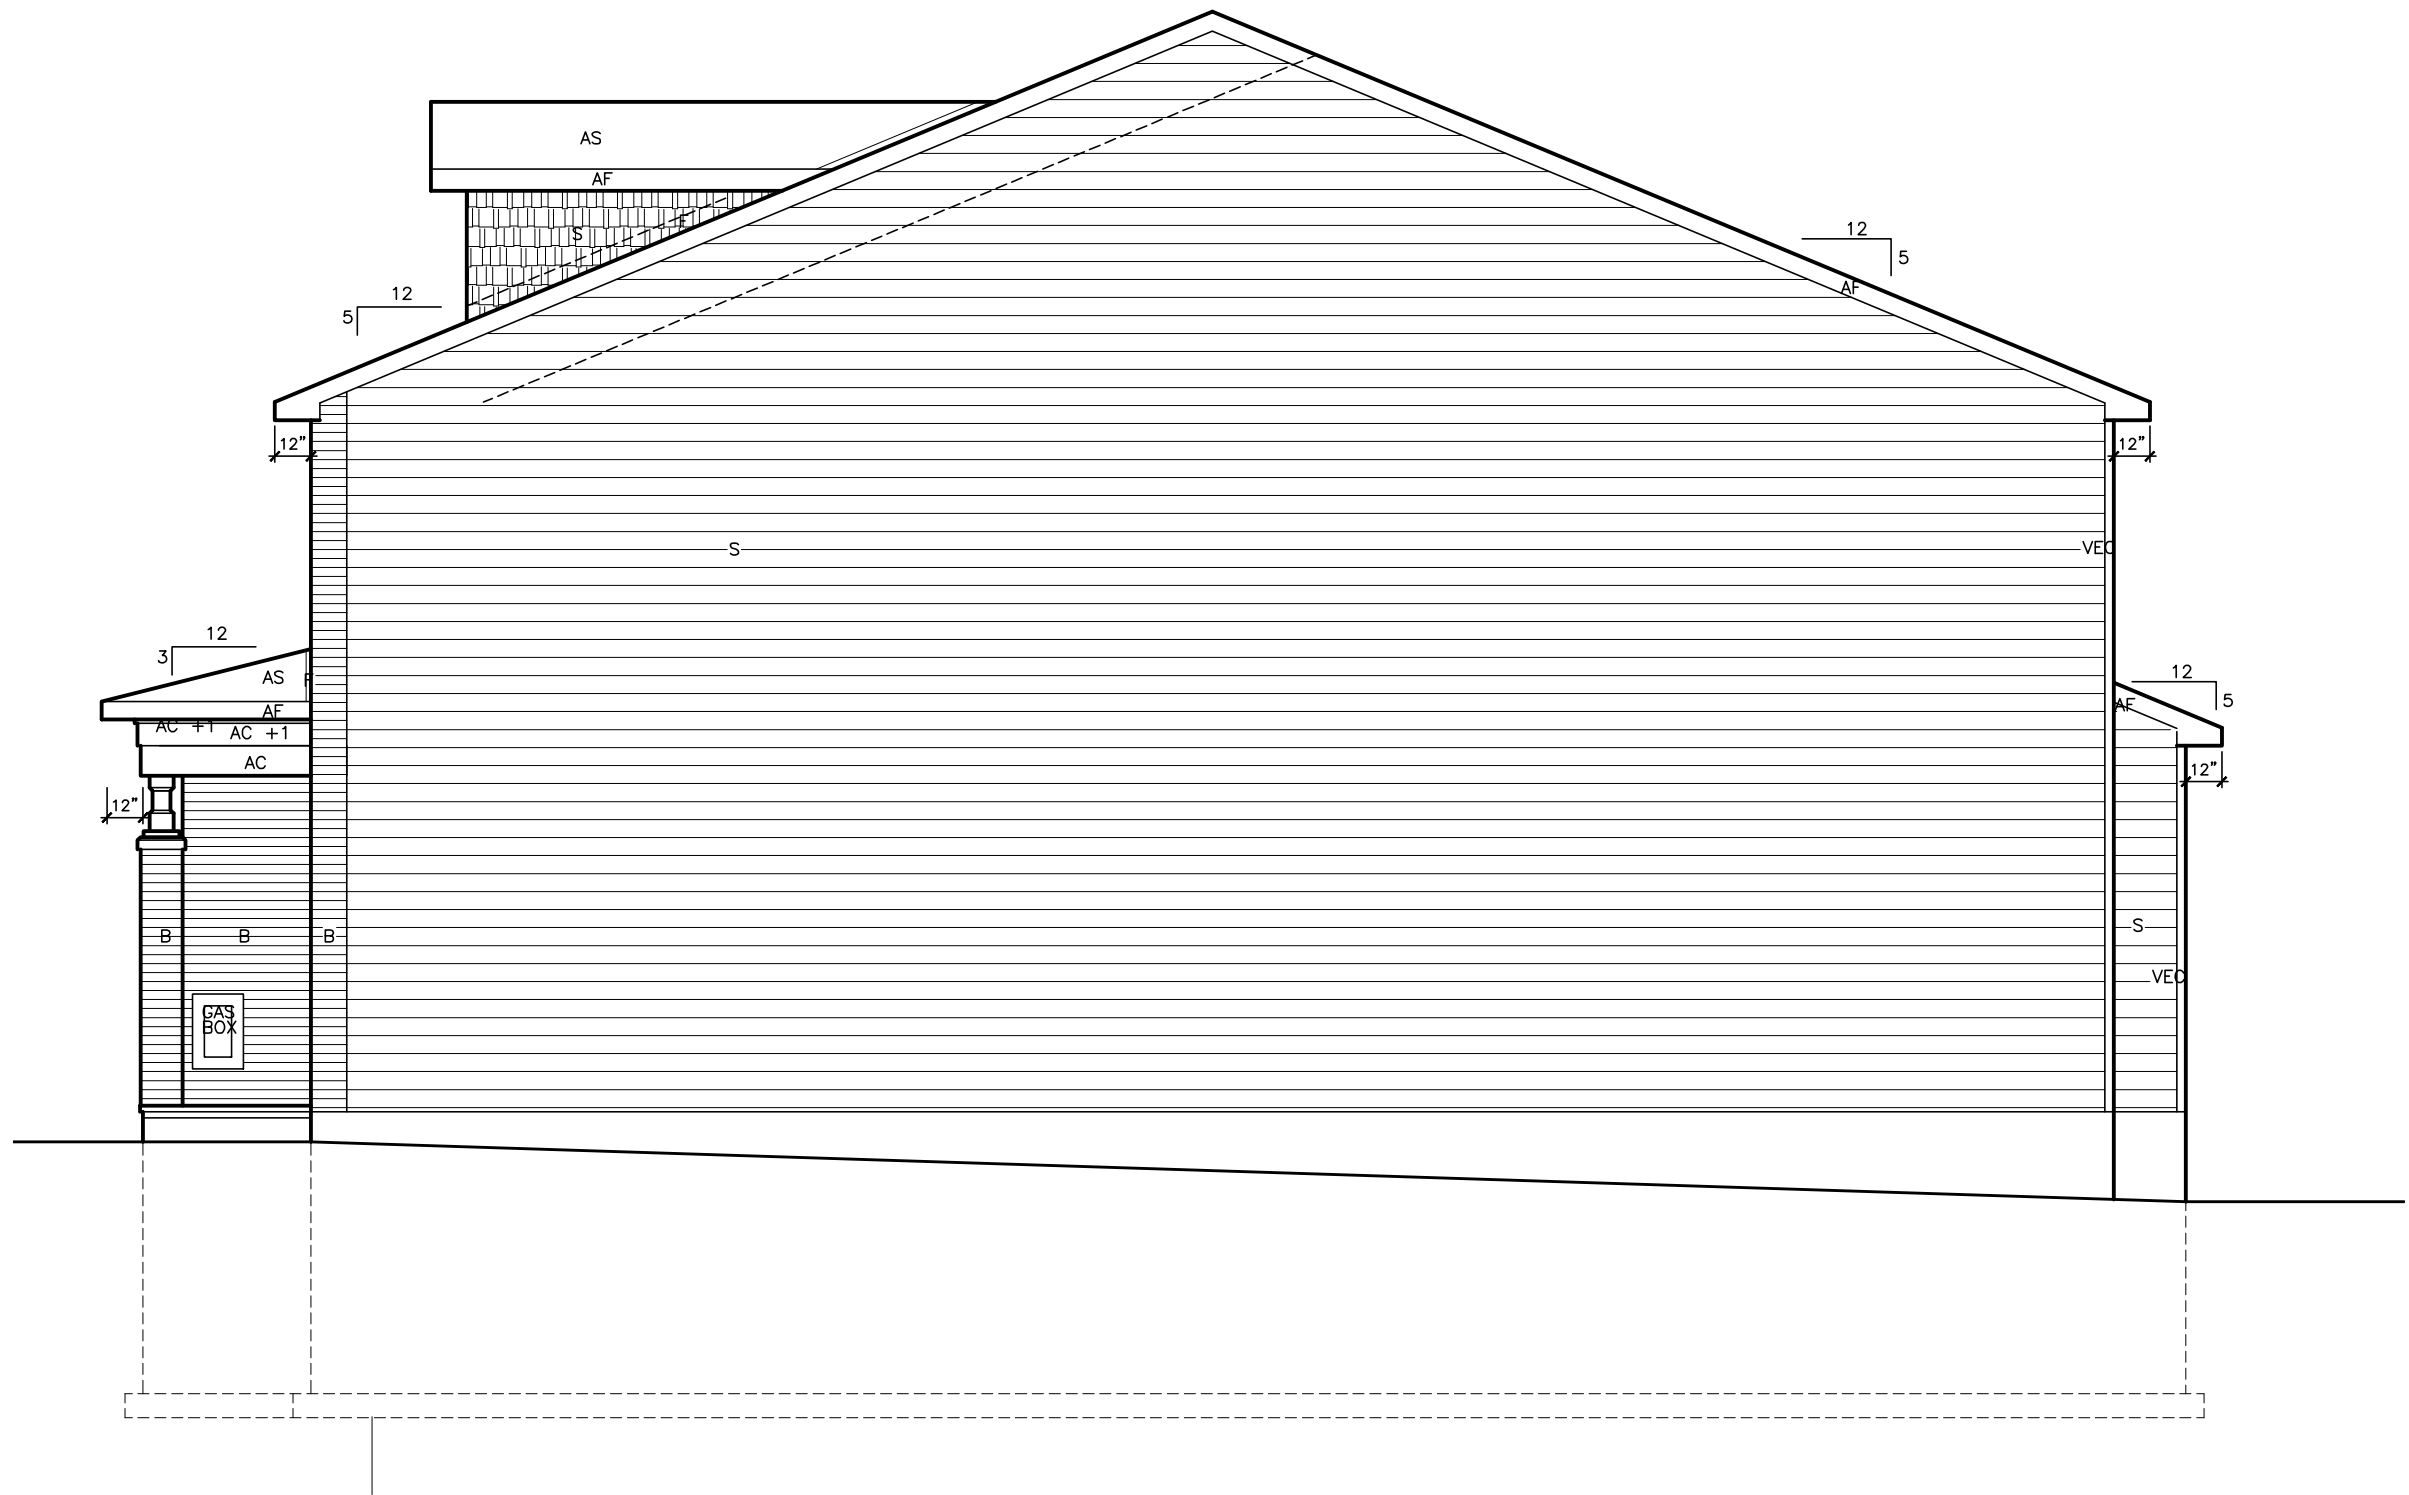

LOT _____ XXxx

DATE _____ XX/XX/XX

THIS DRAWING IS TO BE USED IN CONJUNCTION WITH SCHEDULE B-1A AND MAY SHOW ONLY SOME OF THE CHANGES DETAILED ON THAT DOCUMENT. SHOULD THE DRAWINGS NOT SHOW ALL ITEMS CONTAINED ON A SCHEDULE OR MISS OTHER ITEMS ALTOGETHER, THE SCHEDULE IS CONSIDERED THE GOVERNING DOCUMENT. FLOORS CONT. **TENDER 2017**

I SCOTT IRWIN BCIN 20765 HAVE REVIEWED AND TAKE RESPONSIBILITY FOR DESIGN ACTIVITIES RELATING TO, HOUSE & SMALL BUILDINGS _____.


EXTERIOR FINISH LEGEND	
B	- BRICK (MAIN)
B1	- BRICK SOLDIER COURSE (ACCENT)
B2	- BRICK SOLDIER COURSE (ACCENT) 20mm PROUD
B3	- BRICK SLEEPER COURSE
B4	- STACK BOND (ACCENT)
B5	- BRICK SILL (ACCENT)
B6	- BRICK ROW LOCK (ACCENT)
B7	- BRICK CORBELLING
B8	- BRICK COINING 20mm PROUD
+20	- BRICK 20mm PROUD
-20	- BRICK RECESSED 20mm
S	- SIDING (HORIZONTAL)
ST	- STONE VENEER
T	- TRIM 200mm COVE SIDING
AF	- ALUMINUM FASCIA
AC	- ALUMINUM CLADDING
AS	- ASPHALT SHINGLES
F	- FLASHING
V	- ROOF VENT MAX
P	- PARING
PC	- PRECAST
PCH10	- PRECAST HEADER 10"
PCH8	- PRECAST HEADER 8"
PCS	- PRECAST SILL
PCB	- PRECAST BAND
VS	- VINYL SHAKES

2012 OBC DRAWINGS

3.	ISSUED FOR 2016 TENDER	01/01/16	
2.	AS PER STRUCTURAL	30/01/15	
1.	STANDARD DRAWINGS	27/05/14	SI
NO.	DESCRIPTION	DATE	BY



TITLE: SIDE GARAGE ELEVATION	
ACAD FILE:	SCALE: 3/16" = 1'-0"
160-The Stanley 2012 Footprint (STANDARD DRAWINGS)	DWG. A-4

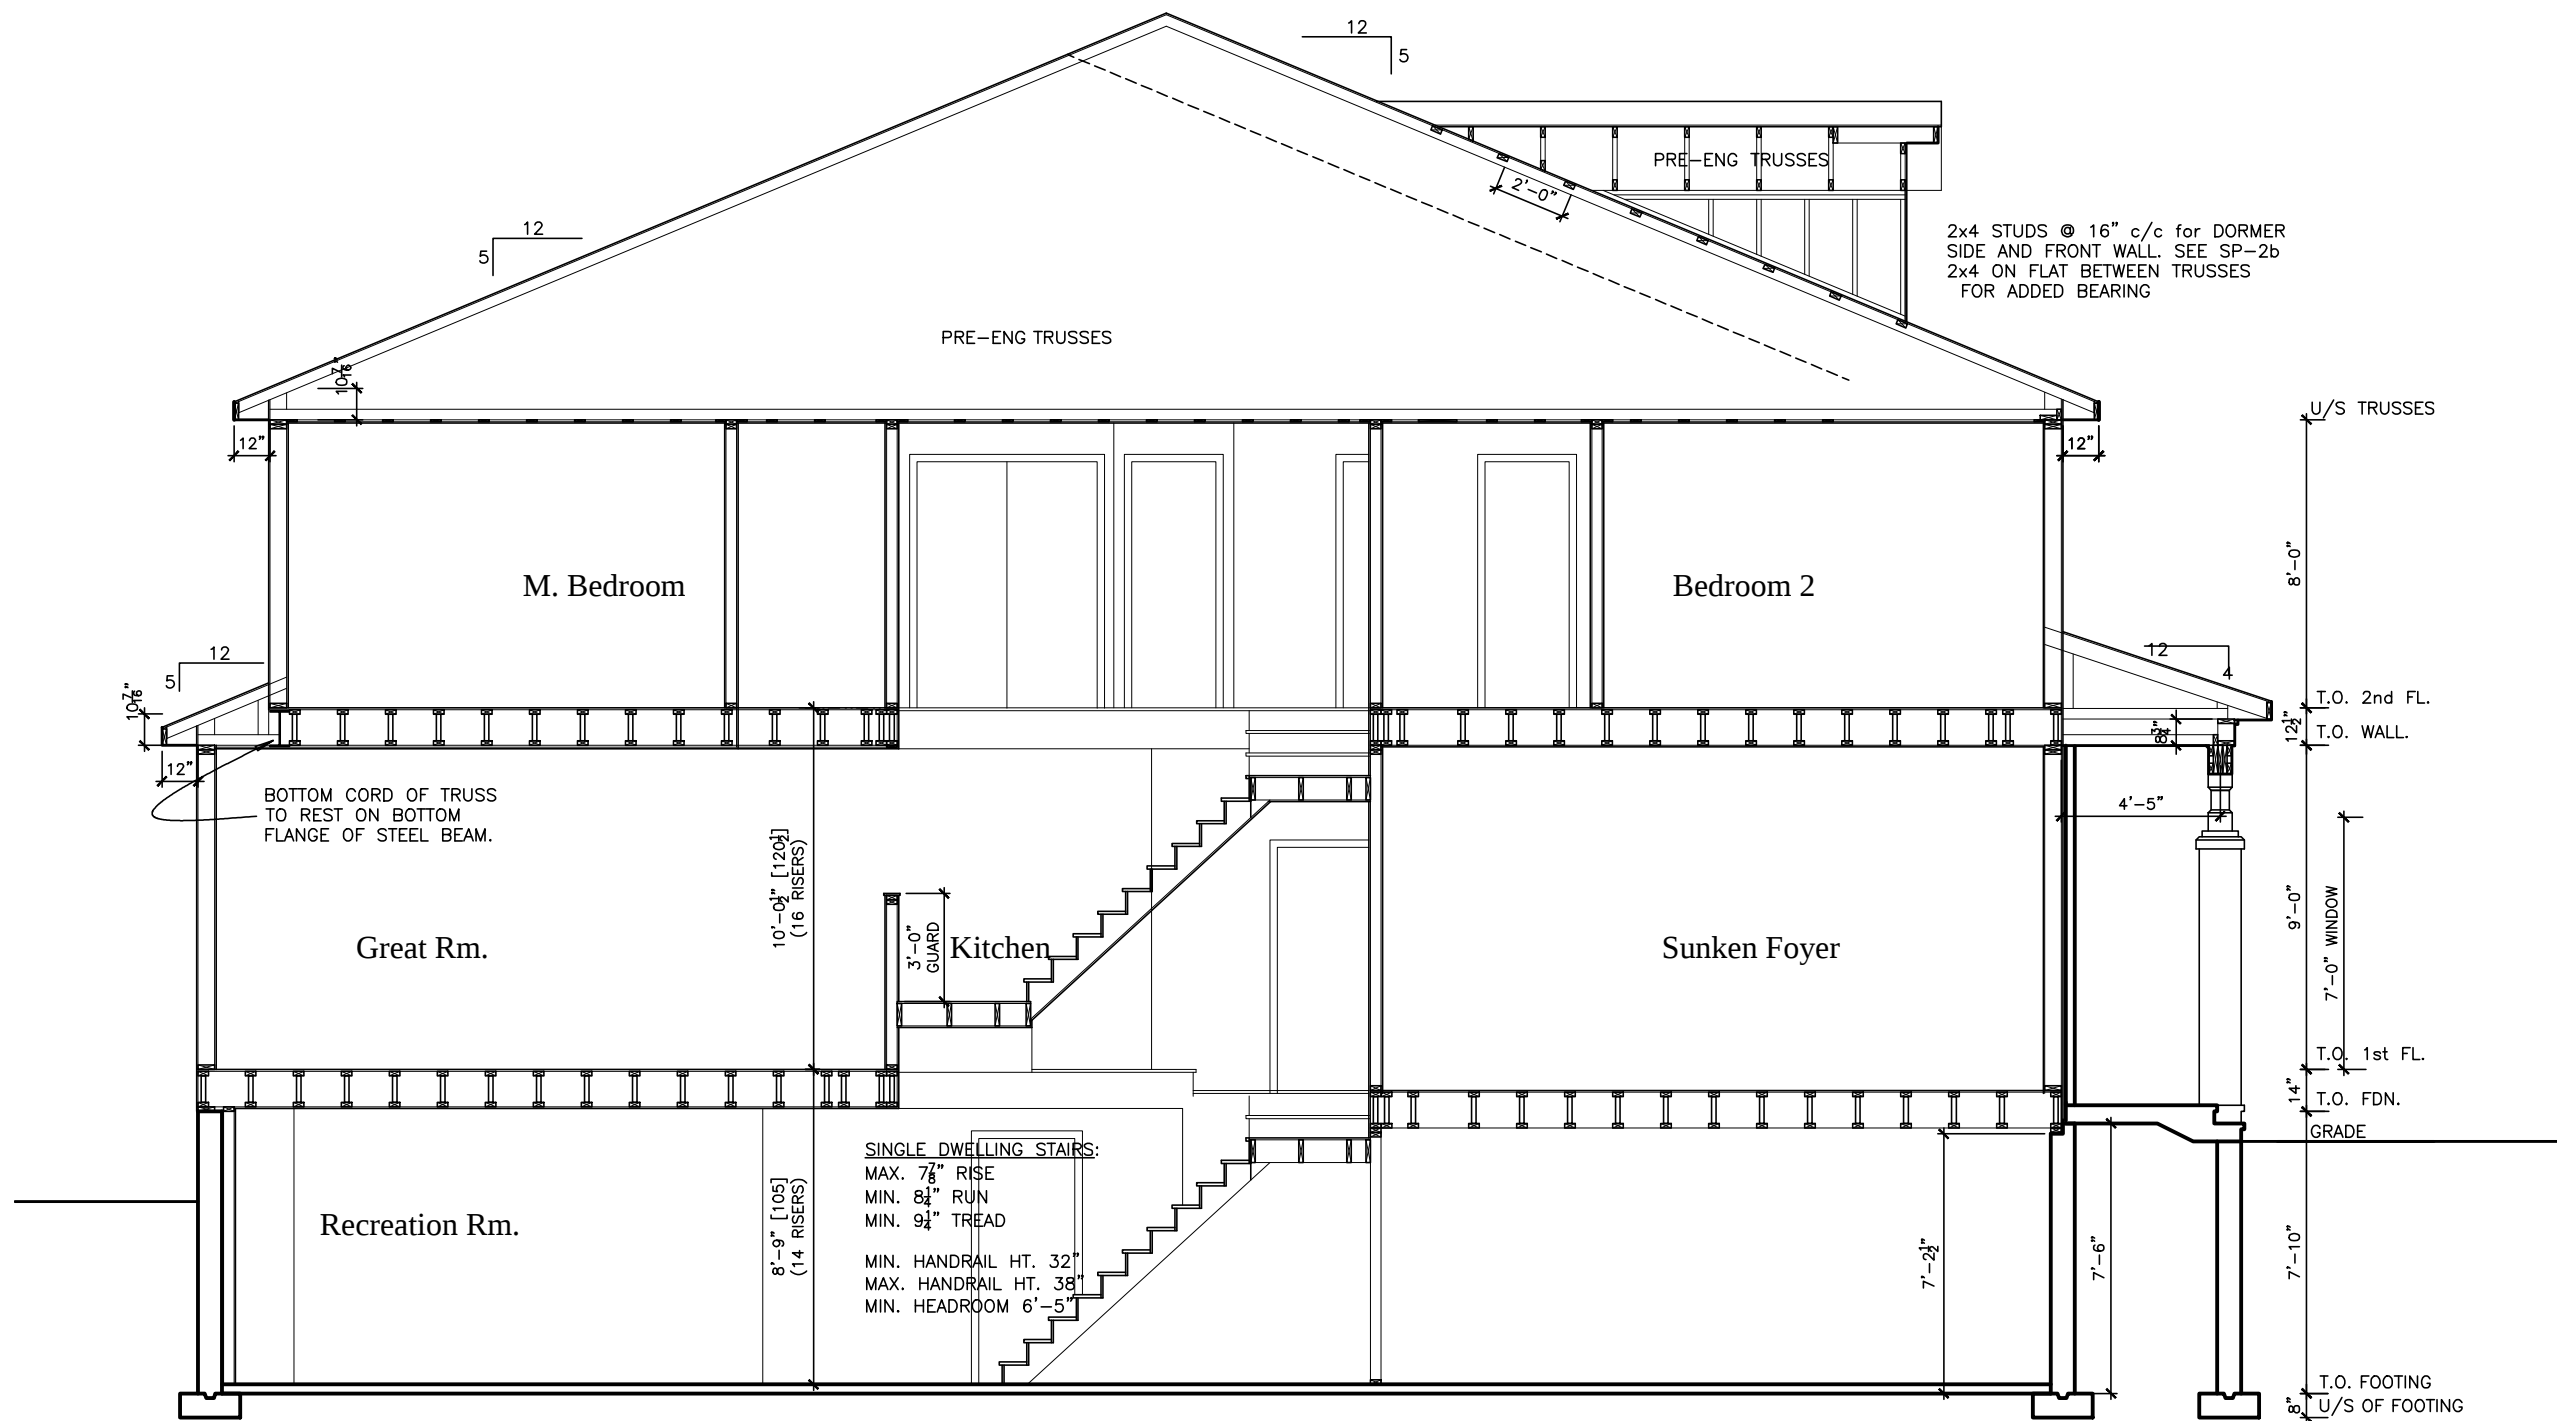

BUILDING SECTION

LOT **XXxx**

DATE **XX/XX/XX**

THIS DRAWINGS IS TO BE USED IN CONJUNCTION WITH SCHEDULE B-1A AND MAY SHOW ONLY SOME OF THE CHANGES DETAILED ON THAT DOCUMENT. SHOULD THE DRAWINGS NOT SHOW ALL ITEMS CONTAINED ON A SCHEDULE OR MISS OTHER ITEMS ALTOGETHER, THE SCHEDULE IS CONSIDERED THE GOVERNING DOCUMENT.
FLOORS CONT

TENDER 2017

I SCOTT IRWIN BCIN 20765 HAVE REVIEWED AND TAKE RESPONSIBILITY FOR DESIGN ACTIVITIES RELATING TO, HOUSE & SMALL BUILDINGS _____.


EXTERIOR FINISH LEGEND	
B	- BRICK (MAIN)
B1	- BRICK SOLDIER COURSE (ACCENT)
B2	- BRICK SOLDIER COURSE (ACCENT)
B3	- BRICK SLEEPER COURSE
B4	- STACK BOND (ACCENT)
B5	- BRICK SILL (ACCENT)
B6	- BRICK ROW LOCK (ACCENT)
B7	- BRICK CORBELLING
B8	- BRICK COINING 20mm PROUD
+20	- BRICK 20mm PROUD
-20	- BRICK RECESSED 20mm
S	- SIDING (HORIZONTAL)
ST	- STONE VENEER
T	- TRIM 200mm COVE SIDING
AF	- ALUMINUM FACIA
AC	- ALUMINUM CLADDING
AS	- ASPHALT SHINGLES
F	- FLASHING
V	- ROOF VENT MAX
PC	- PRECAST
PCH10	- PRECAST HEADER 10"
PCH8	- PRECAST HEADER 8"
PCS	- PRECAST SILL
PCB	- PRECAST BAND
VS	- VINYL SHAKES

2012 OBC DRAWINGS

3.	ISSUED FOR 2016 TENDER	01/01/16	
2.	AS PER STRUCTURAL	30/01/15	
1.	STANDARD DRAWINGS	27/05/14	SI
NO	DESCRIPTION	DATE	BY



TITLE: SECTION	
ACAD FILE:	SCALE: 3/16" = 1'-0"
160-The Stanley 2012 Footprint (STANDARD DRAWINGS)	DWG. A-5

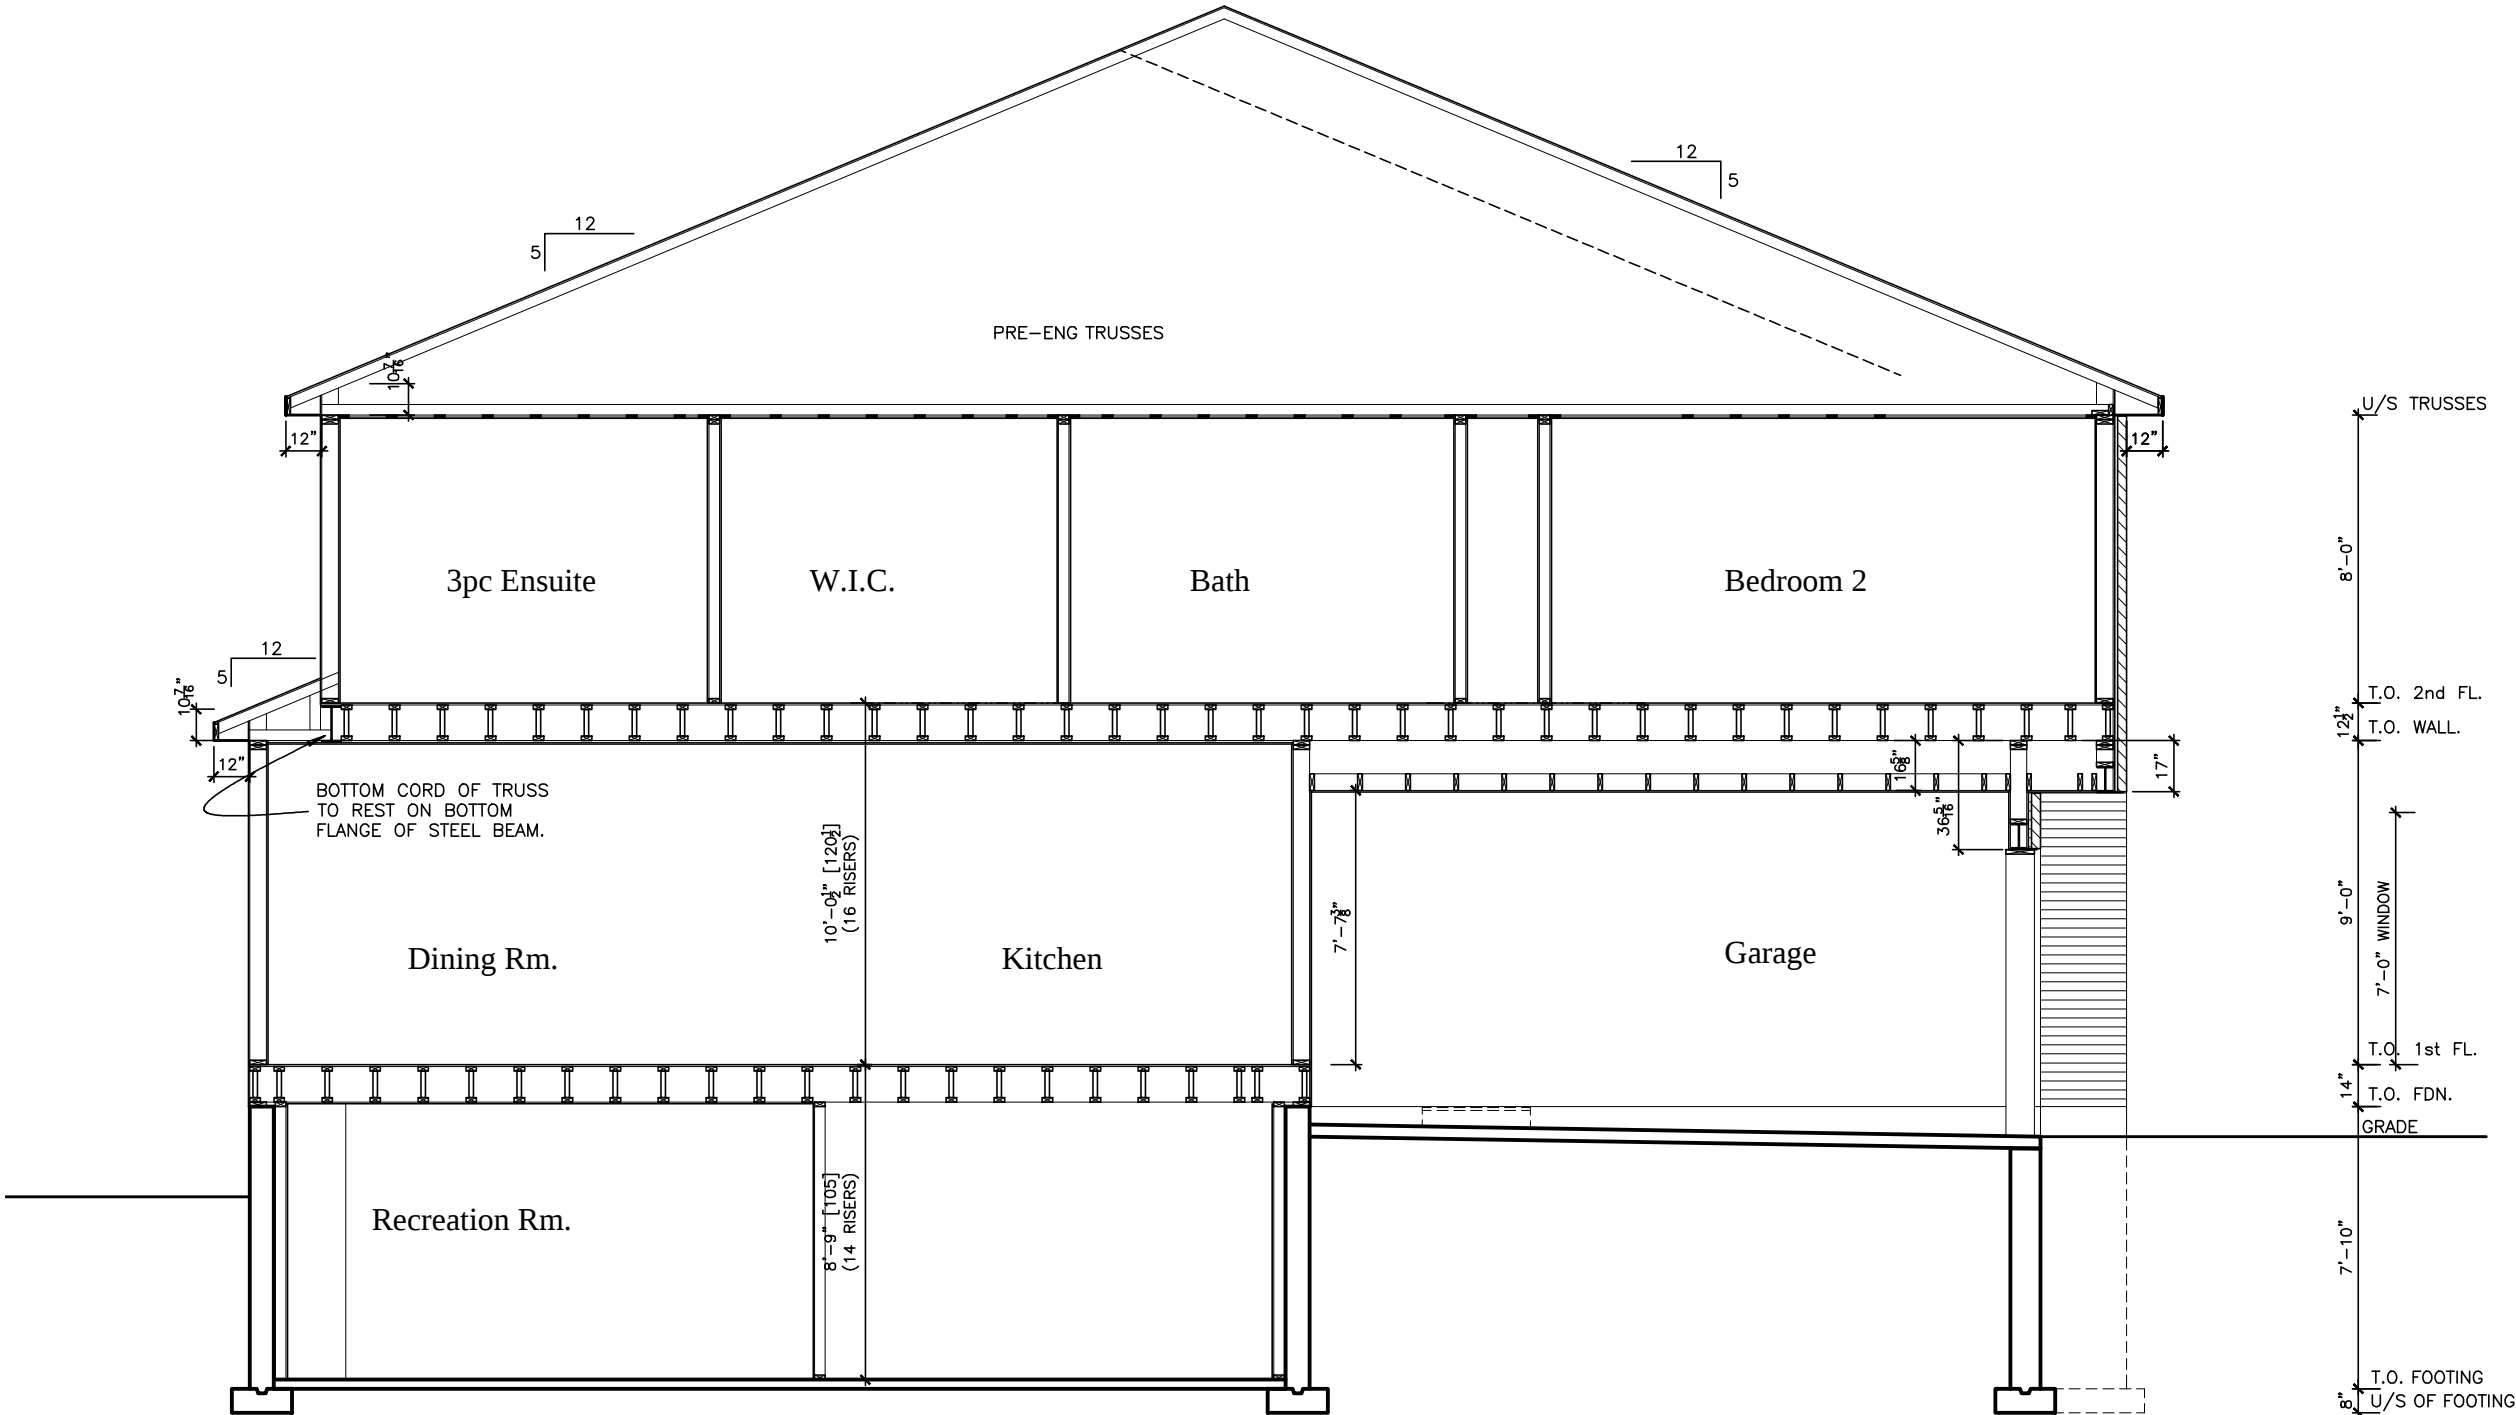

BUILDING SECTION

LOT _____ XXxx

DATE _____ XX/XX/XX

THIS DRAWINGS IS TO BE USED IN CONJUNCTION WITH SCHEDULE B-1A AND MAY SHOW ONLY SOME OF THE CHANGES DETAILED ON THAT DOCUMENT. SHOULD THE DRAWINGS NOT SHOW ALL ITEMS CONTAINED ON A SCHEDULE OR MISS OTHER ITEMS ALTOGETHER, THE SCHEDULE IS CONSIDERED THE GOVERNING DOCUMENT.
FLOORS CONT

TENDER 2017

I SCOTT IRWIN BCIN 20765 HAVE REVIEWED AND TAKE RESPONSIBILITY FOR DESIGN ACTIVITIES RELATING TO, HOUSE & SMALL BUILDINGS _____.




EXTERIOR FINISH LEGEND	
B	- BRICK (MAIN)
B1	- BRICK SOLDIER COURSE (ACCENT)
B2	- BRICK SOLDIER COURSE (ACCENT) 20mm PROUD
B3	- BRICK SLEEPER COURSE
B4	- STACK BOND (ACCENT)
B5	- BRICK SILL (ACCENT)
B6	- BRICK ROW LOCK (ACCENT)
B7	- BRICK CORBELLING
B8	- BRICK COINING 20mm PROUD
+20	- BRICK 20mm PROUD
-20	- BRICK RECESSED 20mm
S	- SIDING (HORIZONTAL)
ST	- STONE VENEER
T	- TRIM 200mm COVE SIDING
AF	- ALUMINUM FACIA
AC	- ALUMINUM CLADDING
AS	- ASPHALT SHINGLES
F	- FLASHING
V	- ROOF VENT MAX
P	- PARING
PC	- PRECAST
PCH10	- PRECAST HEADER 10"
PCH8	- PRECAST HEADER 8"
PCS	- PRECAST SILL
PCB	- PRECAST BAND
VS	- VINYL SHAKES

2012 OBC DRAWINGS

3.	ISSUED FOR 2016 TENDER	01/01/16	
2.	AS PER STRUCTURAL	30/01/15	
1.	STANDARD DRAWINGS	27/05/14	SI
NO	DESCRIPTION	DATE	BY



TITLE: SECTION	
ACAD FILE:	SCALE: 3/16" = 1'-0"
160-The Stanley 2012 Footprint (STANDARD DRAWINGS)	DWG. A-5b

   

TITLE:		BASEMENT FLOOR PLAN	
ACAD FILE:		SCALE:	3/16" = 1'-0"
160-The Stanley 2012 Footprint (STANDARD DRAWINGS)		DWG.	A-6

CONCRETE DENSITY = 24 KN/M^3

160 – MID UNIT

FOUNDATION WALL 1		STRIP WEIGHT (KN/M)
DEAD LOAD	STRUCTURAL	10.14
	FOUNDATION WALL	11.70
	*FOOTING	–
LIVE LOAD	STRUCTURAL	6.84
	SNOW	23.92

52.61

FOUNDATION WALL 4		STRIP WEIGHT (KN/M)
DEAD LOAD	STRUCTURAL	13.90
	FOUNDATION WALL	11.70
	*FOOTING	–
LIVE LOAD	STRUCTURAL	0.00
	SNOW	0.00

25.60

FOUNDATION WALL 7		STRIP WEIGHT (KN/M)
DEAD LOAD	STRUCTURAL	10.11
	FOUNDATION WALL	11.70
	*FOOTING	–
LIVE LOAD	STRUCTURAL	14.01
	SNOW	8.66

44.47

FOUNDATION WALL 10		STRIP WEIGHT (KN/M)
DEAD LOAD	STRUCTURAL	3.72
	FOUNDATION WALL	11.70
	*FOOTING	–
LIVE LOAD	STRUCTURAL	7.32
	SNOW	5.46

28.21

FOUNDATION WALL 13		STRIP WEIGHT (KN/M)
DEAD LOAD	STRUCTURAL	7.11
	FOUNDATION WALL	11.70
	*FOOTING	–
LIVE LOAD	STRUCTURAL	3.81
	SNOW	13.10

35.72

FOUNDATION WALL 2		STRIP WEIGHT (KN/M)
DEAD LOAD	STRUCTURAL	9.02
	FOUNDATION WALL	11.70
	*FOOTING	–
LIVE LOAD	STRUCTURAL	11.58
	SNOW	0.00

32.30

FOUNDATION WALL 5		STRIP WEIGHT (KN/M)
DEAD LOAD	STRUCTURAL	18.71
	FOUNDATION WALL	11.70
	*FOOTING	–
LIVE LOAD	STRUCTURAL	10.22
	SNOW	5.46

46.10

FOUNDATION WALL 8		STRIP WEIGHT (KN/M)
DEAD LOAD	STRUCTURAL	3.30
	FOUNDATION WALL	11.70
	*FOOTING	–
LIVE LOAD	STRUCTURAL	0.00
	SNOW	0.00

15.01

FOUNDATION WALL 11		STRIP WEIGHT (KN/M)
DEAD LOAD	STRUCTURAL	0.38
	FOUNDATION WALL	11.70
	*FOOTING	–
LIVE LOAD	STRUCTURAL	0.38
	SNOW	1.31

13.78

FOUNDATION WALL 14		STRIP WEIGHT (KN/M)
DEAD LOAD	STRUCTURAL	9.62
	FOUNDATION WALL	11.70
	*FOOTING	–
LIVE LOAD	STRUCTURAL	11.72
	SNOW	10.82

43.86

FOUNDATION WALL 3		STRIP WEIGHT (KN/M)
DEAD LOAD	STRUCTURAL	7.79
	FOUNDATION WALL	11.70
	*FOOTING	–
LIVE LOAD	STRUCTURAL	8.09
	SNOW	8.20

35.77

FOUNDATION WALL 6		STRIP WEIGHT (KN/M)
DEAD LOAD	STRUCTURAL	18.09
	FOUNDATION WALL	11.70
	*FOOTING	–
LIVE LOAD	STRUCTURAL	4.19
	SNOW	14.41

48.39

FOUNDATION WALL 9		STRIP WEIGHT (KN/M)
DEAD LOAD	STRUCTURAL	5.93
	FOUNDATION WALL	11.70
	*FOOTING	–
LIVE LOAD	STRUCTURAL	4.43
	SNOW	5.46


27.52

FOUNDATION WALL 12		STRIP WEIGHT (KN/M)
DEAD LOAD	STRUCTURAL	2.95
	FOUNDATION WALL	11.70
	*FOOTING	–
LIVE LOAD	STRUCTURAL	6.55
	SNOW	2.62

23.83

FOUNDATION WALL 15		STRIP WEIGHT (KN/M)
DEAD LOAD	STRUCTURAL	18.38
	FOUNDATION WALL	11.70
	*FOOTING	–
LIVE LOAD	STRUCTURAL	8.09
	SNOW	8.20

46.37

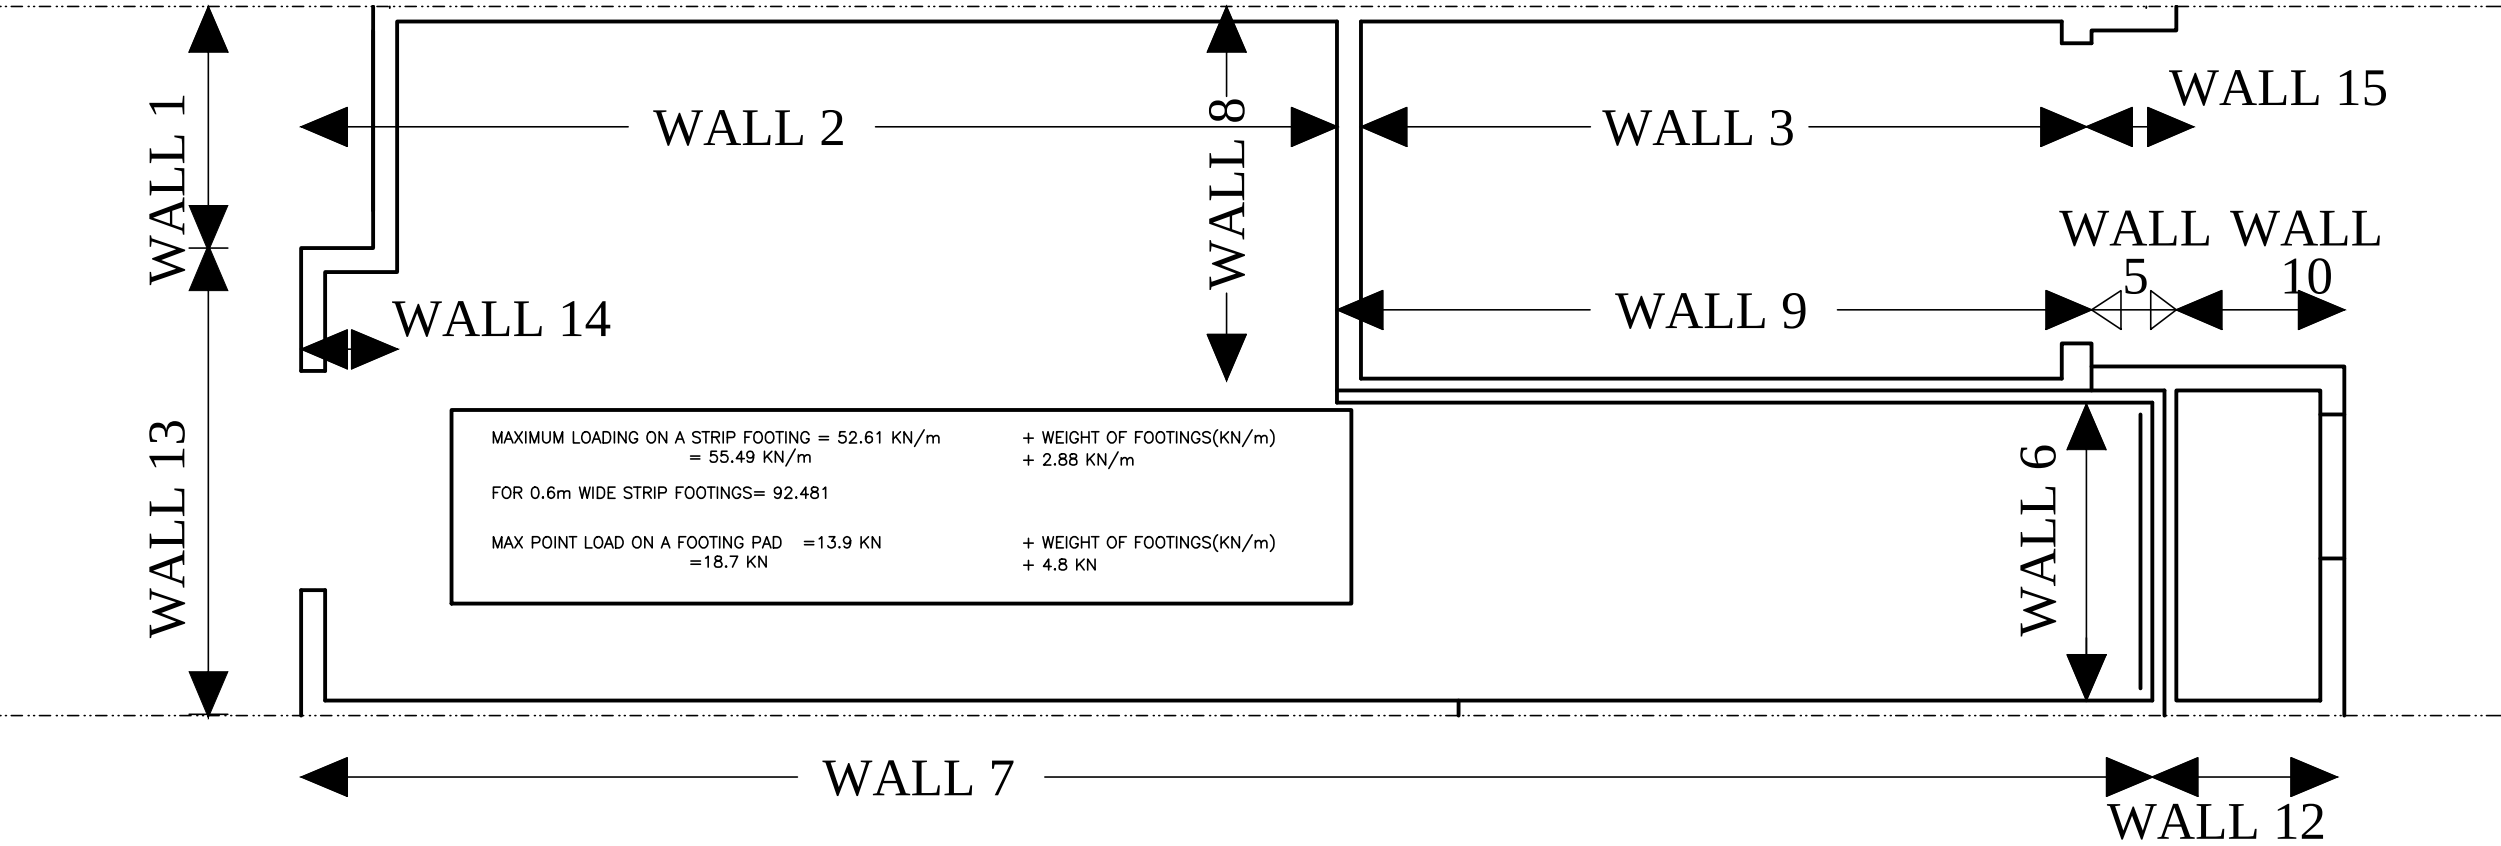

LOT XXXX

DATE XX/XX/XX

THIS DRAWINGS IS TO BE USED IN CONJUNCTION WITH SCHEDULE B-1A AND MAY SHOW ONLY SOME OF THE CHANGES DETAILED ON THAT DOCUMENT. SHOULD THE DRAWINGS NOT SHOW ALL ITEMS CONTAINED ON A SCHEDULE OR MISS OTHER ITEMS ALTOGETHER, THE SCHEDULE IS CONSIDERED THE GOVERNING DOCUMENT. FLOORS CONT.

I SCOTT IRWIN BCIN 20765 HAVE REVIEWED AND TAKE RESPONSIBILITY FOR DESIGN ACTIVITIES RELATING TO, HOUSE & SMALL BUILDINGS.

*FOOTING (8" THICK)

STRIP WIDTH (mm)	STRIP WEIGHT (kn/m)
500	2.4
600	2.88
900	4.32
1000	4.80
1100	5.28
1200	5.76
1300	6.24
1400	6.72
1500	7.20
1600	7.68
1700	8.16
1800	8.64
1900	9.12
2000	9.6
2100	10.08
2200	10.56
2300	11.04
2400	11.52
2500	12
2600	12.48
2700	12.96
2800	13.44
2900	13.92
3000	14.4

2012 OBC DRAWINGS

2.	AS PER STRUCTURAL	30/01/15	
1.	STANDARD DRAWINGS	27/05/14	SI
NO	DESCRIPTION	DATE	BY




TITLE: FOOTING/FOUNDATION LOADING MODEL 160 - The Stanley STANDARD UNIT

ACAD FILE: SCALE: 3/16" = 1'-0"

160-The Stanley 2012 Footprint (STANDARD DRAWINGS) DWG. SF2

Partial plan for End unit "Standard Right Side"

Partial plan for End unit "Standard Left Side"

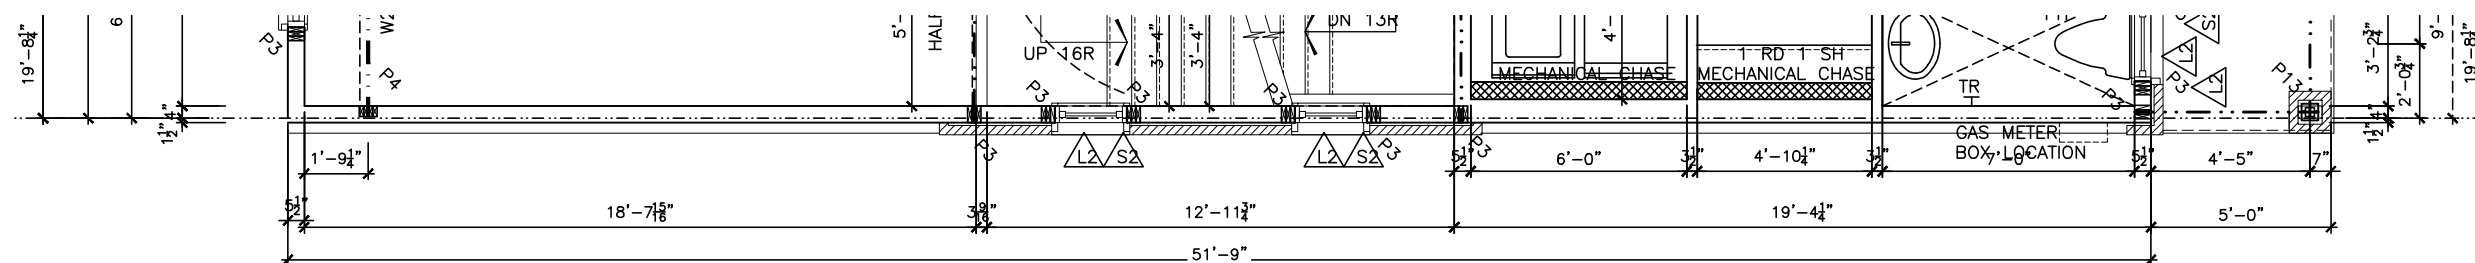

LOT XXxx

DATE XX/XX/XX

THIS DRAWINGS IS TO BE USED IN CONJUNCTION WITH SCHEDULE B-1A AND MAY SHOW ONLY SOME OF THE CHANGES DETAILED ON THAT DOCUMENT. SHOULD THE DRAWINGS NOT SHOW ALL ITEMS CONTAINED ON A SCHEDULE OR MISS OTHER ITEMS ALTOGETHER, THE SCHEDULE IS CONSIDERED THE GOVERNING DOCUMENT.

FLOORS CONT

TENDER 2017

TENDER 2017

STRUCTURAL FRAMING SCHEDULE

STEEL LINTEL

- S1 - L 90x90x6
S2 - L 90x90x8
S3 - L 100x90x8
S4 - L 125x90x8
S5 - L 125x90x10
S6 - L 200x100x12
S7 - L 150x100x10 (200mm BEARING)
- WOOD LINTEL
- L1 - (2) 38x235 w/ 12.7 PLYWOOD SPACER
L2 - (2) 38x235
L3 - (2) 38x235
L4 - (3) 38x235 w/ 2-12.7 PLYWOOD SPACER
& 2 ROW OF 90mm SPIRAL @ 200 o/c
L5 - (2) 38x286 w/ 2-12.7 PLYWOOD SPACER
& 2 ROW OF 90mm SPIRAL @ 200 o/c
L6 - (2) 45x240 LVL
L7 - (3) 45x240 LVL

POST

- P1 - 75# STEEL TELEPOST
P2 - (2)38x89 or (2)38x140
P3 - (3)38x89 or (3)38x140
P4 - (4)38x89 or (4)38x140
P5 - (5)38x89 or (5)38x140
P6 - (6)38x89 or (6)38x140
P13 - HSS 88.9x88.9x3.18 + 100x200x12 T&B PL.
(*)
P14 - HSS 89x89x4.8 + 100x200x12 T&B PL.
(*)
P15 - HSS 76.2x76.2x4.78 + 100x180x12 T&B PL.
(*)
P16 - HSS 76.2x76.2x4.78 + 130x130x12 T&B PL.
P17 - HSS 73 O.D. x4.8 + 100x180x12PL B PL.

(*) - 2-12# ANCH (WHERE ANCH PL. NOT USED)
ALL FOOTINGS 600x200 DP. UNLESS NOTED
SOIL: 100 KPA

TRIM NOTES

- PH - TOILET PAPER HOLDER 26" AFF
TB - 24" TOWEL BAR 50" AFF
TR - TOWEL RING 44" AFF

2012 OBC DRAWINGS




6.	ISSUED FOR 2016 TENDER	01/01/16	
5.	LINTEL OVER PATIO DOOR IN FLOOR SPACE	30/07/15	SI
4.	DROP CEILING ADDED	13/07/15	SI
3.	PANTRY DIM ADDED	14/05/15	SI
2.	AS PER STRUCTURAL	30/01/15	SI
1.	STANDARD DRAWINGS	27/05/14	SI
NO DESCRIPTION		DATE	BY



TITLE:
1st FLOOR PLAN-(Stanley 1)

ACAD FILE:	SCALE: 3/16" = 1'-0"
------------	-------------------------

160-The Stanley 2012 Footprint (STANDARD DRAWINGS)	DWG. A-7
--	------------------------

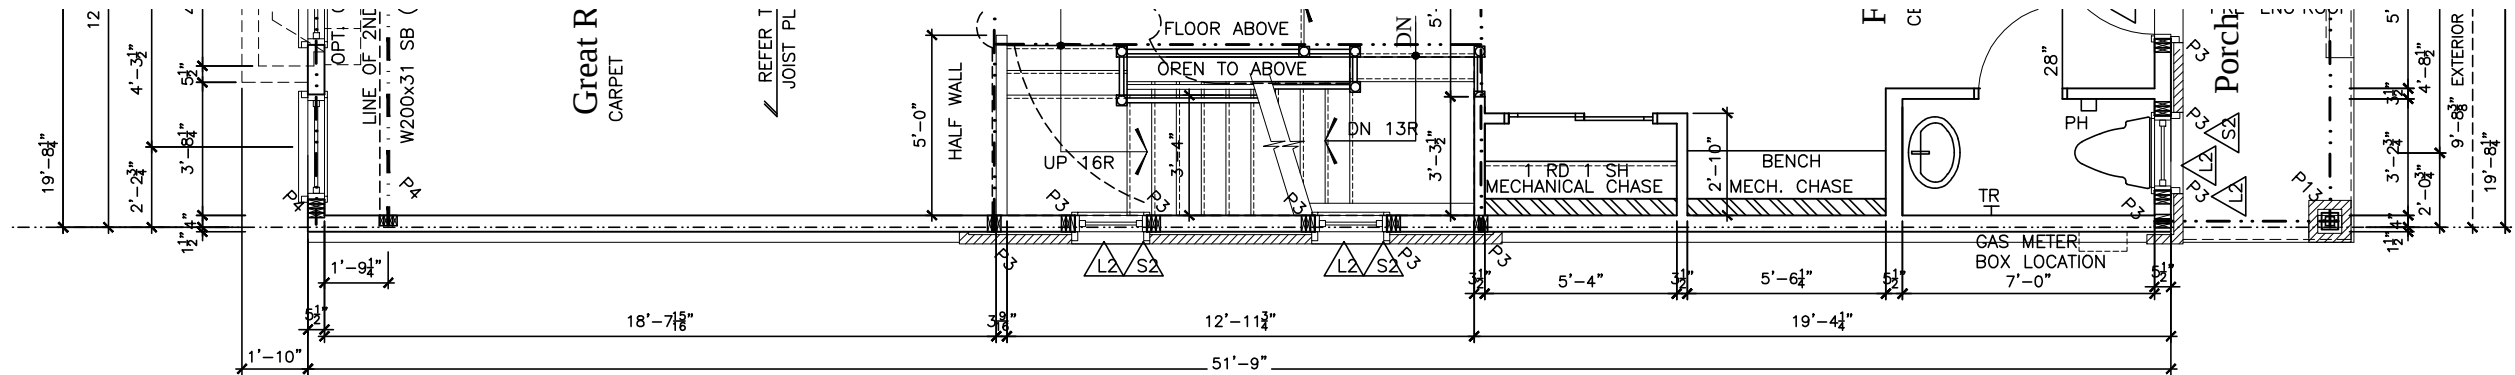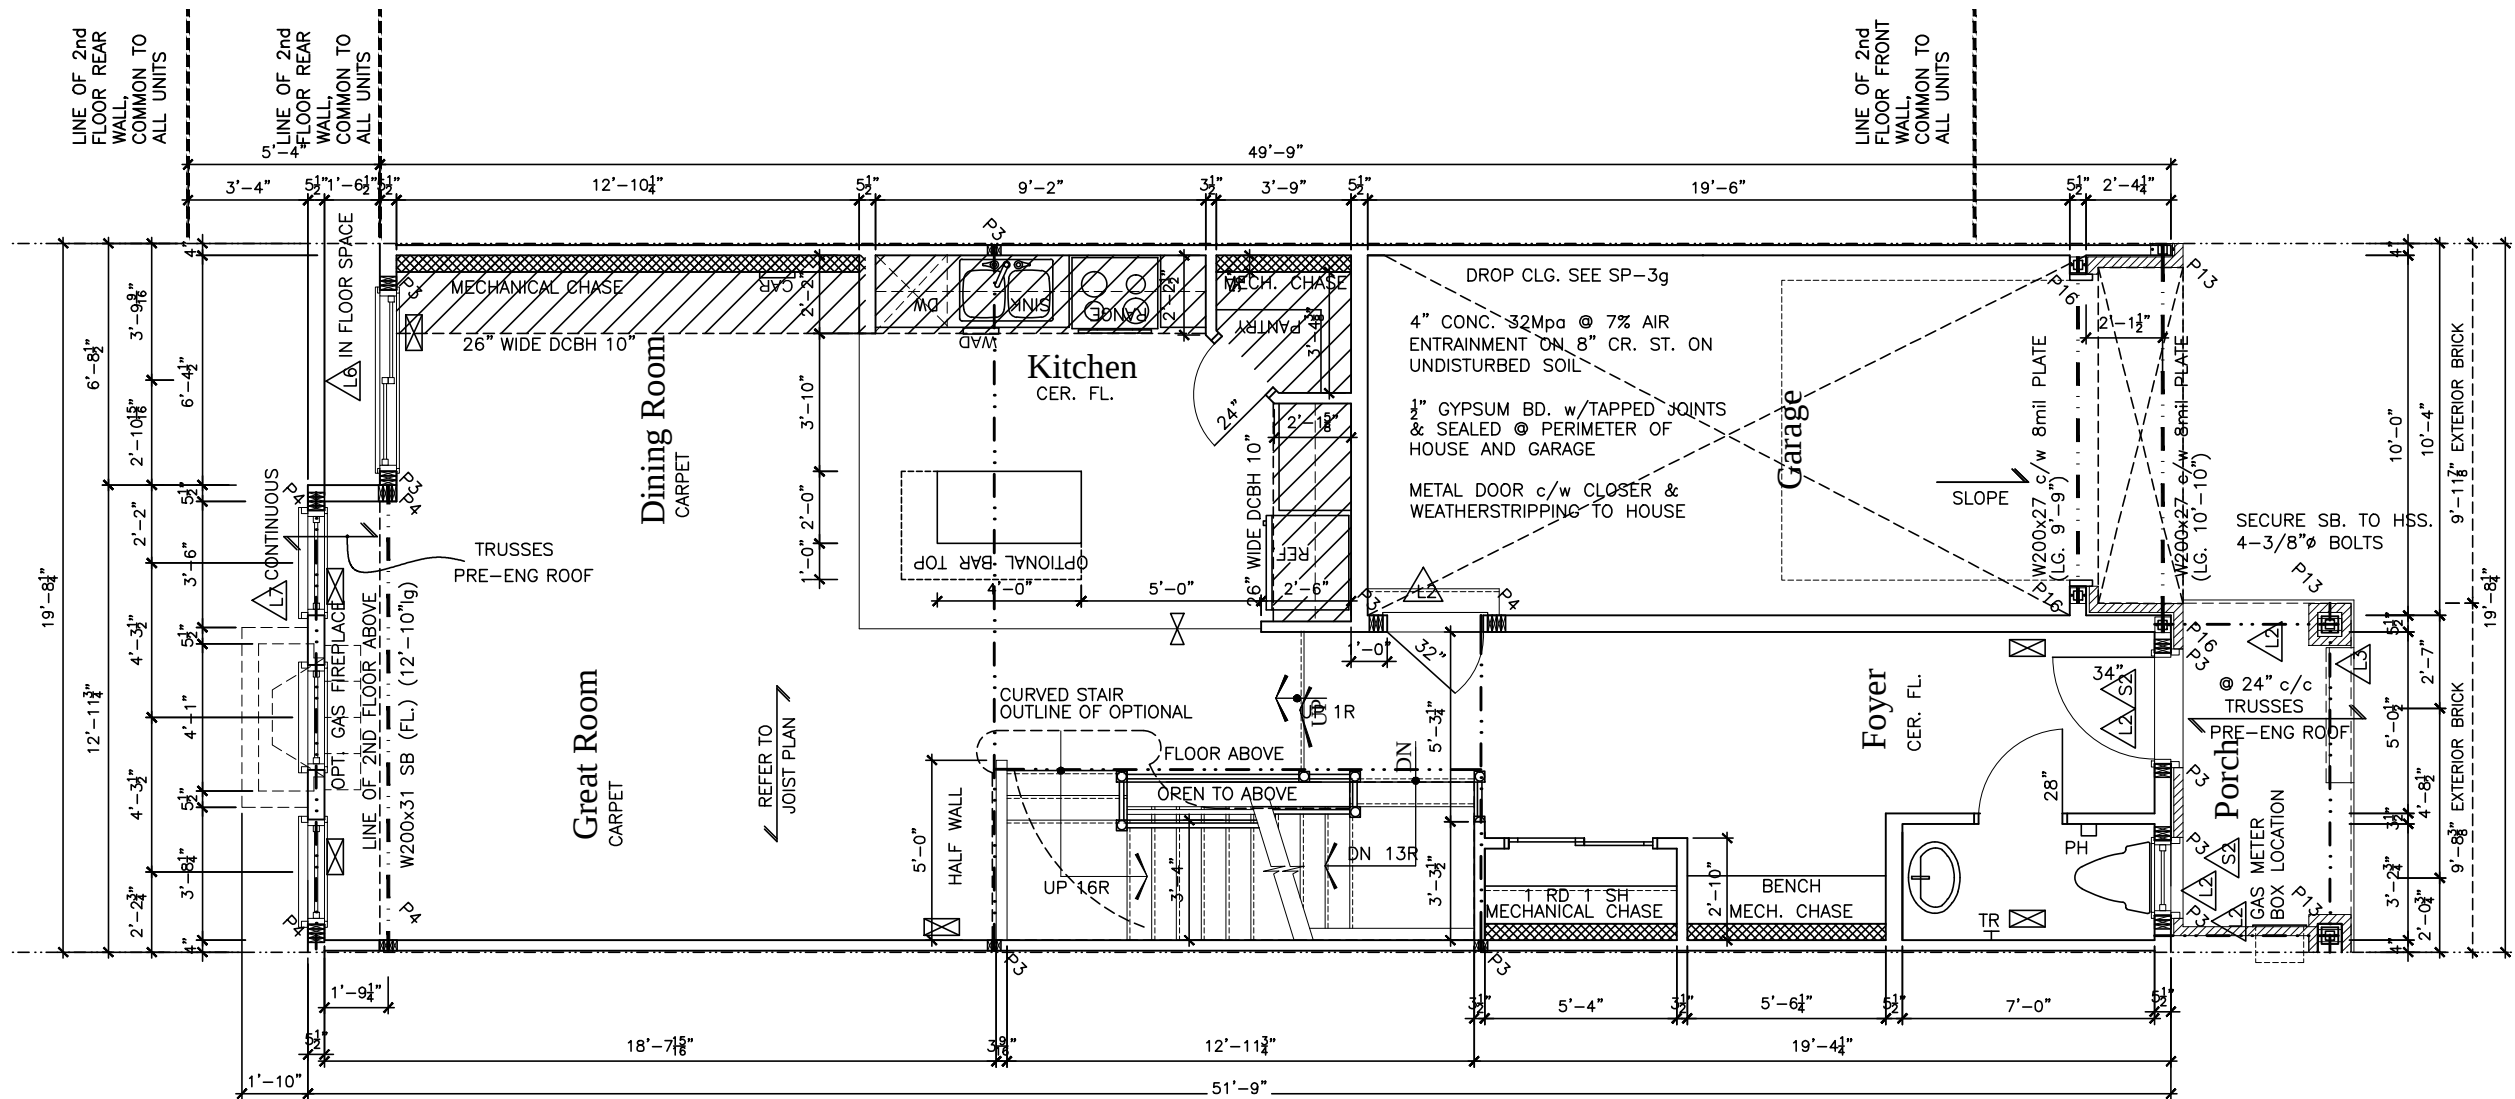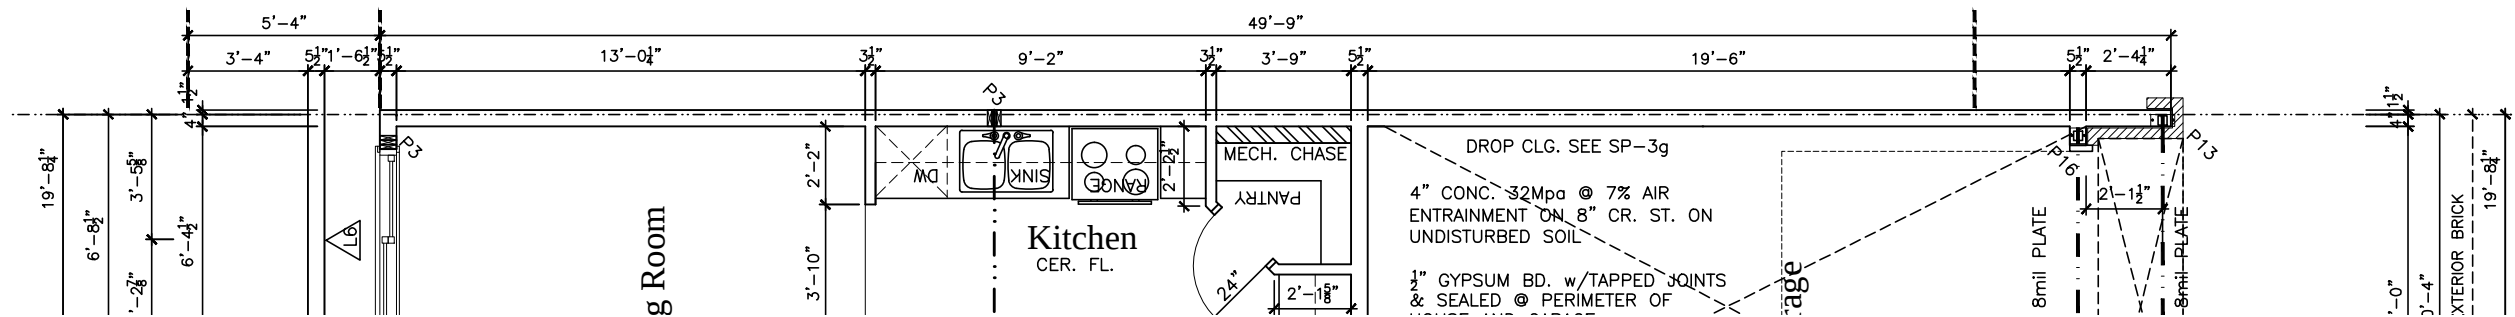

LOT **XXxx**
DATE **XX/XX/XX**
THIS DRAWINGS IS TO BE USED IN CONJUNCTION WITH SCHEDULE B-1 AND MAY SHOW ONLY SOME OF THE CHANGES DETAILED ON THAT DOCUMENT. SHOULD THE DRAWINGS NOT SHOW ALL ITEMS CONTAINED ON A SCHEDULE OR MISS OTHER ITEMS ALTOGETHER, THE SCHEDULE IS CONSIDERED THE GOVERNING DOCUMENT.
FLOORS CONT
TENDER 2017

STRUCTURAL FRAMING SCHEDULE		
STEEL LINTEL		
S1	-	L 90x90x6
S2	-	L 90x90x8
S3	-	L 100x90x8
S4	-	L 125x90x8
S5	-	L 125x90x10
S6	-	L 200x100x12
S7	-	L 150x100x10 (200mm BEARING)
WOOD LINTEL		
L1	-	(2)38x235 w/ 12.7 PLYWOOD SPACER
L2	-	(2)38x235
L3	-	(3)38x235
L4	-	(3)38x235 w/ 2-12.7 PLYWOOD SPACER
L5	-	(2) ROW OF 90mm SPIRAL @ 200 c/c
L6	-	(3)38x286 w/ 2-12.7 PLYWOOD SPACER
L7	-	(2) ROW OF 90mm SPIRAL @ 200 c/c
L8	-	(2)45x240 LVL
L9	-	(3)45x240 LVL
POSTS		
P1	-	75# STEEL TELEPOST
P2	-	(2)38x89 or (2)38x140
P3	-	(3)38x89 or (3)38x140
P4	-	(4)38x89 or (4)38x140
P5	-	(5)38x89 or (5)38x140
P6	-	(6)38x89 or (6)38x140
P13	-	HSS 88.9x88.9x3.18 + 100x200x12 T&B PL.
P14	-	HSS 89x89x4.8 + 100x200x12 T&B PL.
P15	-	HSS 76.2x76.2x4.78 + 100x180x12 T&B PL.
P16	-	HSS 76.2x76.2x4.78 + 130x130x12 T&B PL.
P17	-	HSS 73 O.D. x4.8 + 100x180x12PL B PL.
ALL FOOTINGS 600x200 DP. UNLESS NOTED		
SOIL: 100 KPA		

TRIM NOTES
PH - TOILET PAPER HOLDER 26" AFF
TB - 24" TOWEL BAR 50" AFF
TR - TOWEL RING 44" AFF

2012 OBC DRAWINGS

NO	DESCRIPTION	DATE	BY
5.	ISSUED FOR 2016 TENDER	01/01/16	
4.	DCBH ADDED	13/07/15	SI
3.	PANTRY DIM	14/05/15	SI
2.	AS PER STRUCTURAL	30/01/15	
1.	STANDARD DRAWINGS	30/01/15	SI



TITLE:
1st FLOOR PLAN-(Stanley 2)

ACAD FILE:
160-The Stanley 2012 Footprint
(STANDARD DRAWINGS)

SCALE:
3/16" = 1'-0"

DWG.
A-7b

LOT XXxx

DATE XX/XX/XX

THIS DRAWINGS IS TO BE USED IN CONJUNCTION WITH SCHEDULE B-1A AND MAY SHOW ONLY SOME OF THE CHANGES DETAILED ON THAT DOCUMENT. SHOULD THE DRAWINGS NOT SHOW ALL ITEMS CONTAINED ON A SCHEDULE OR MISS OTHER ITEMS ALTOGETHER, THE SCHEDULE IS CONSIDERED THE GOVERNING DOCUMENT.
FLOORS CONT

TENDER 2017

STRUCTURAL FRAMING SCHEDULE

- STEEL LINTEL
- S1 - L 90x90x6
 - S2 - L 90x90x8
 - S3 - L 100x90x8
 - S4 - L 125x90x8
 - S5 - L 125x90x10
 - S6 - L 200x100x12
 - S7 - L 150x100x10 (200mm BEARING)
- WOOD LINTEL
- L1 - (2)38x235 w/ 12.7 PLYWOOD SPACER
 - L2 - (2)38x235
 - L3 - (3)38x235
 - L4 - (3)38x235 w/ 2-12.7 PLYWOOD SPACER & 2 ROW OF 90mm SPIRAL @ 200 c/c
 - L5 - (3)38x286 w/ 2-12.7 PLYWOOD SPACER & 2 ROW OF 90mm SPIRAL @ 200 c/c
 - L6 - (2)45x240 LVL
 - L7 - (3)45x240 LVL
- POSTS
- P1 - 75# STEEL TELEPOST
 - P2 - (2)38x89 or (2)38x140
 - P3 - (3)38x89 or (3)38x140
 - P4 - (4)38x89 or (4)38x140
 - P5 - (5)38x89 or (5)38x140
 - P6 - (6)38x89 or (6)38x140
 - P13 - HSS 88.9x88.9x3.18 + 100x200x12 T&B PL. (*)
 - P14 - HSS 89x89x4.8 + 100x200x12 T&B PL. (*)
 - P15 - HSS 76.2x76.2x4.78 + 100x180x12 T&B PL. (*)
 - P16 - HSS 76.2x76.2x4.78 + 130x130x12 T&B PL. (*)
 - P17 - HSS 73 O.D. x4.8 + 100x180x12PL B PL. + 130x160x10 T PL. (*)
 - (*) - 2-12# ANCH (WHERE ANCH PL. NOT USED)
- ALL FOOTINGS 600x200 DP. UNLESS NOTED
SOIL: 100 KPA


- TRIM NOTES
- PH - TOILET PAPER HOLDER 26" AFF
 - TB - 24" TOWEL BAR 50" AFF
 - TR - TOWEL RING 44" AFF

2012 OBC DRAWINGS


2.	ISSUED FOR 2016 TENDER	01/01/16	
1.	PAGE ADDED DUE TO END UNIT REVISION	30/01/15	SI
NO	DESCRIPTION	DATE	BY



TITLE: 1st FLOOR PLAN-(MISC)	
ACAD FILE:	SCALE: 3/16" = 1'-0"
160-The Stanley 2012 Footprint (STANDARD DRAWINGS)	DWG. A-7c

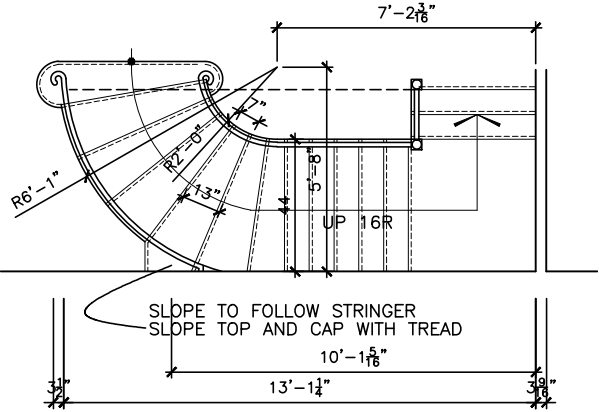

Optional Curved Stair To 2nd Floor

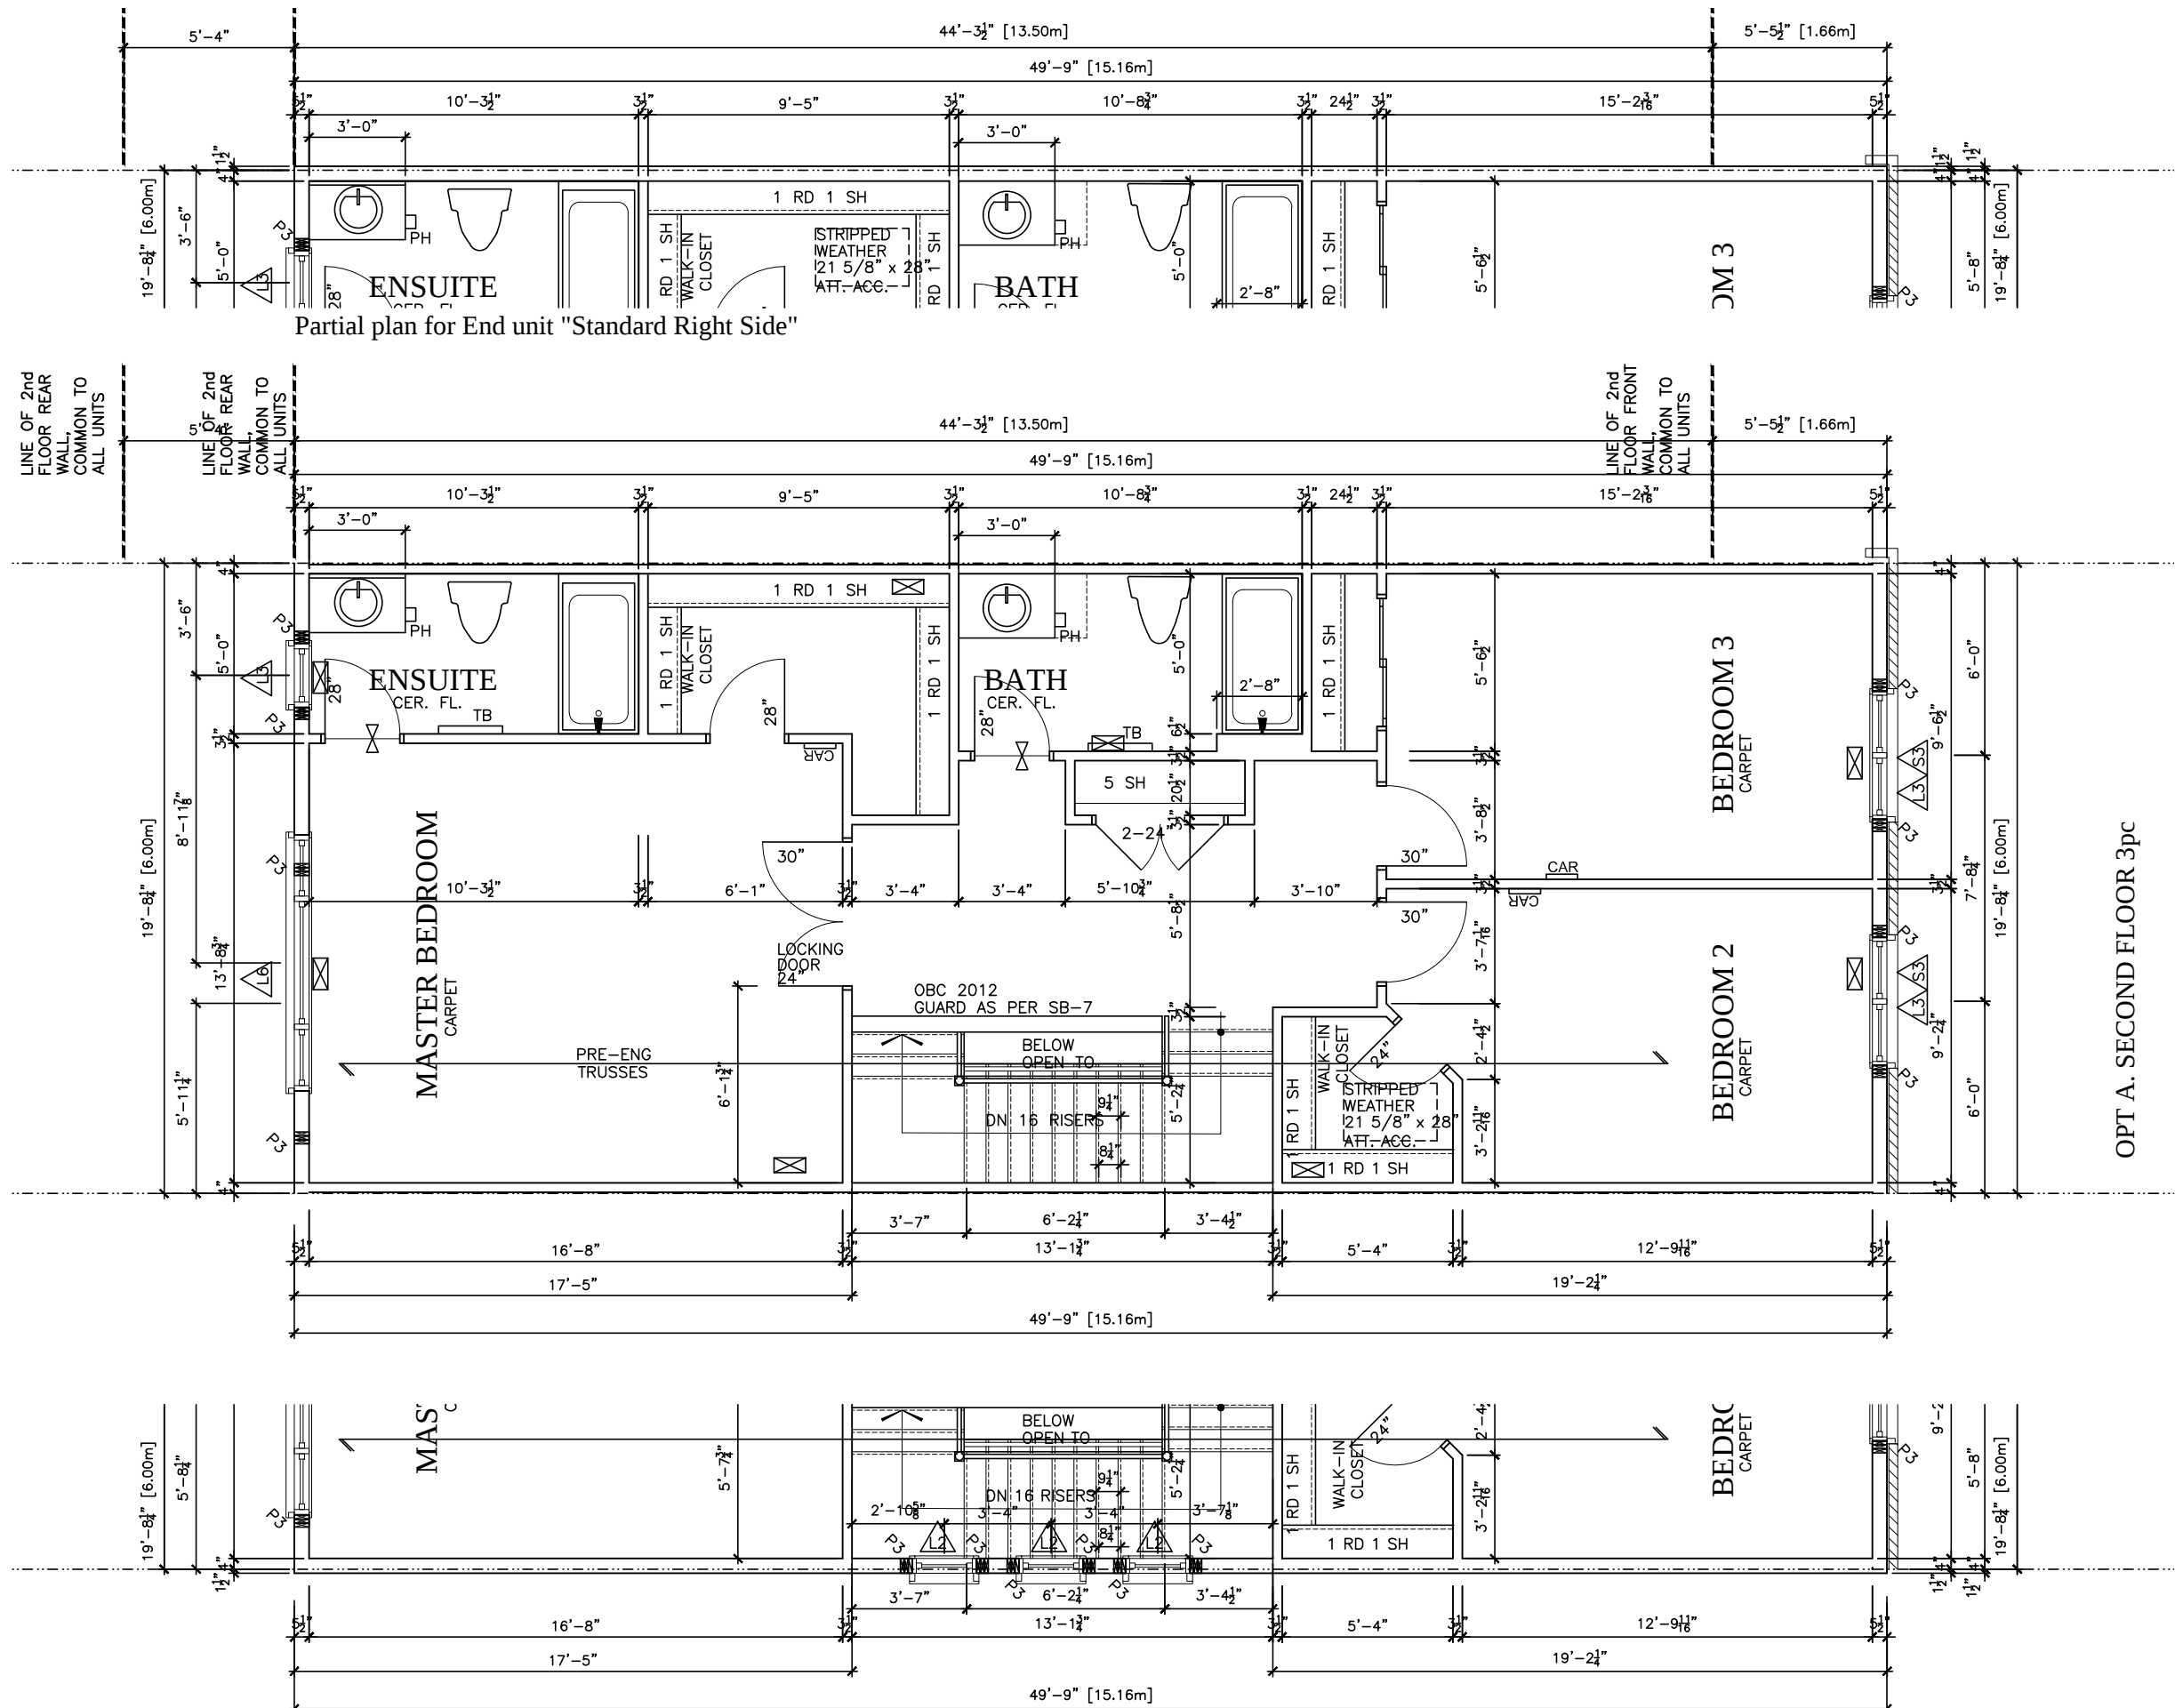

LOT **XXxx**

DATE **XX/XX/XX**

THIS DRAWING IS TO BE USED IN CONJUNCTION WITH SCHEDULE B-1 AND MAY SHOW ONLY SOME OF THE CHANGES DETAILED ON THAT DOCUMENT. SHOULD THE DRAWINGS NOT SHOW ALL ITEMS CONTAINED ON A SCHEDULE OR MISS OTHER ITEMS ALTOGETHER, THE SCHEDULE IS CONSIDERED THE GOVERNING DOCUMENT.
FLOORS CONT.

TENDER 2017

STRUCTURAL FRAMING SCHEDULE

- STEEL LINTEL**
S1 - L 90x90x6
S2 - L 90x90x8
S3 - L 100x90x8
S4 - L 125x90x8
S5 - L 125x90x10
S6 - L 200x100x12
S7 - L 150x100x10 (200mm BEARING)
- WOOD LINTEL**
L1 - (2)38x235 w/ 12.7 PLYWOOD SPACER
L2 - (2)38x235
L3 - (3)38x235 w/ 2-12.7 PLYWOOD SPACER
L4 - & 2 ROW OF 90mm SPIRAL @ 200 o/c
L5 - (3)38x286 w/ 2-12.7 PLYWOOD SPACER
L6 - & 2 ROW OF 90mm SPIRAL @ 200 o/c
L7 - (2)45x240 LVL
L8 - (3)45x240 LVL
- POSTS**
P1 - 75# STEEL TELEPOST
P2 - (2)38x89 or (2)38x140
P3 - (3)38x89 or (3)38x140
P4 - (4)38x89 or (4)38x140
P5 - (5)38x89 or (5)38x140
P6 - (6)38x89 or (6)38x140
P13 - HSS 88.9x88.9x3.18 + 100x200x12 T&B PL.
P14 - HSS 89x89x4.8 + 100x200x12 T&B PL.
P15 - HSS 76.2x76.2x4.78 + 100x180x12 T&B PL.
P16 - HSS 76.2x76.2x4.78 + 130x130x12 T&B PL.
P17 - HSS 73 O.D. x4.8 + 100x180x12PL B PL.
+ 130x160x10 T PL. (*)
(*) - 2-12# ANCH (WHERE ANCH PL. NOT USED)
ALL FOOTINGS 600x200 DP. UNLESS NOTED
SOIL: 100 KPA

- TRIM NOTES**
PH - TOILET PAPER HOLDER 26" AFF
TB - 24" TOWEL BAR 50" AFF
TR - TOWEL RING 44" AFF

2012 OBC DRAWINGS

4.	SITE MEASURE CONFIRMATION	12/01/16	SI
3.	ISSUED FOR 2016 TENDER	01/01/16	
2.	AS PER STRUCTURAL	30/01/15	
1.	STANDARD DRAWINGS	27/05/14	SI
NO.	DESCRIPTION	DATE	BY




TITLE:
2nd FLOOR PLAN - (Stanley 1)

ACAD FILE: SCALE:
3/16" = 1'-0"

**160-The Stanley
2012 Footprint**
(STANDARD DRAWINGS)

A-8

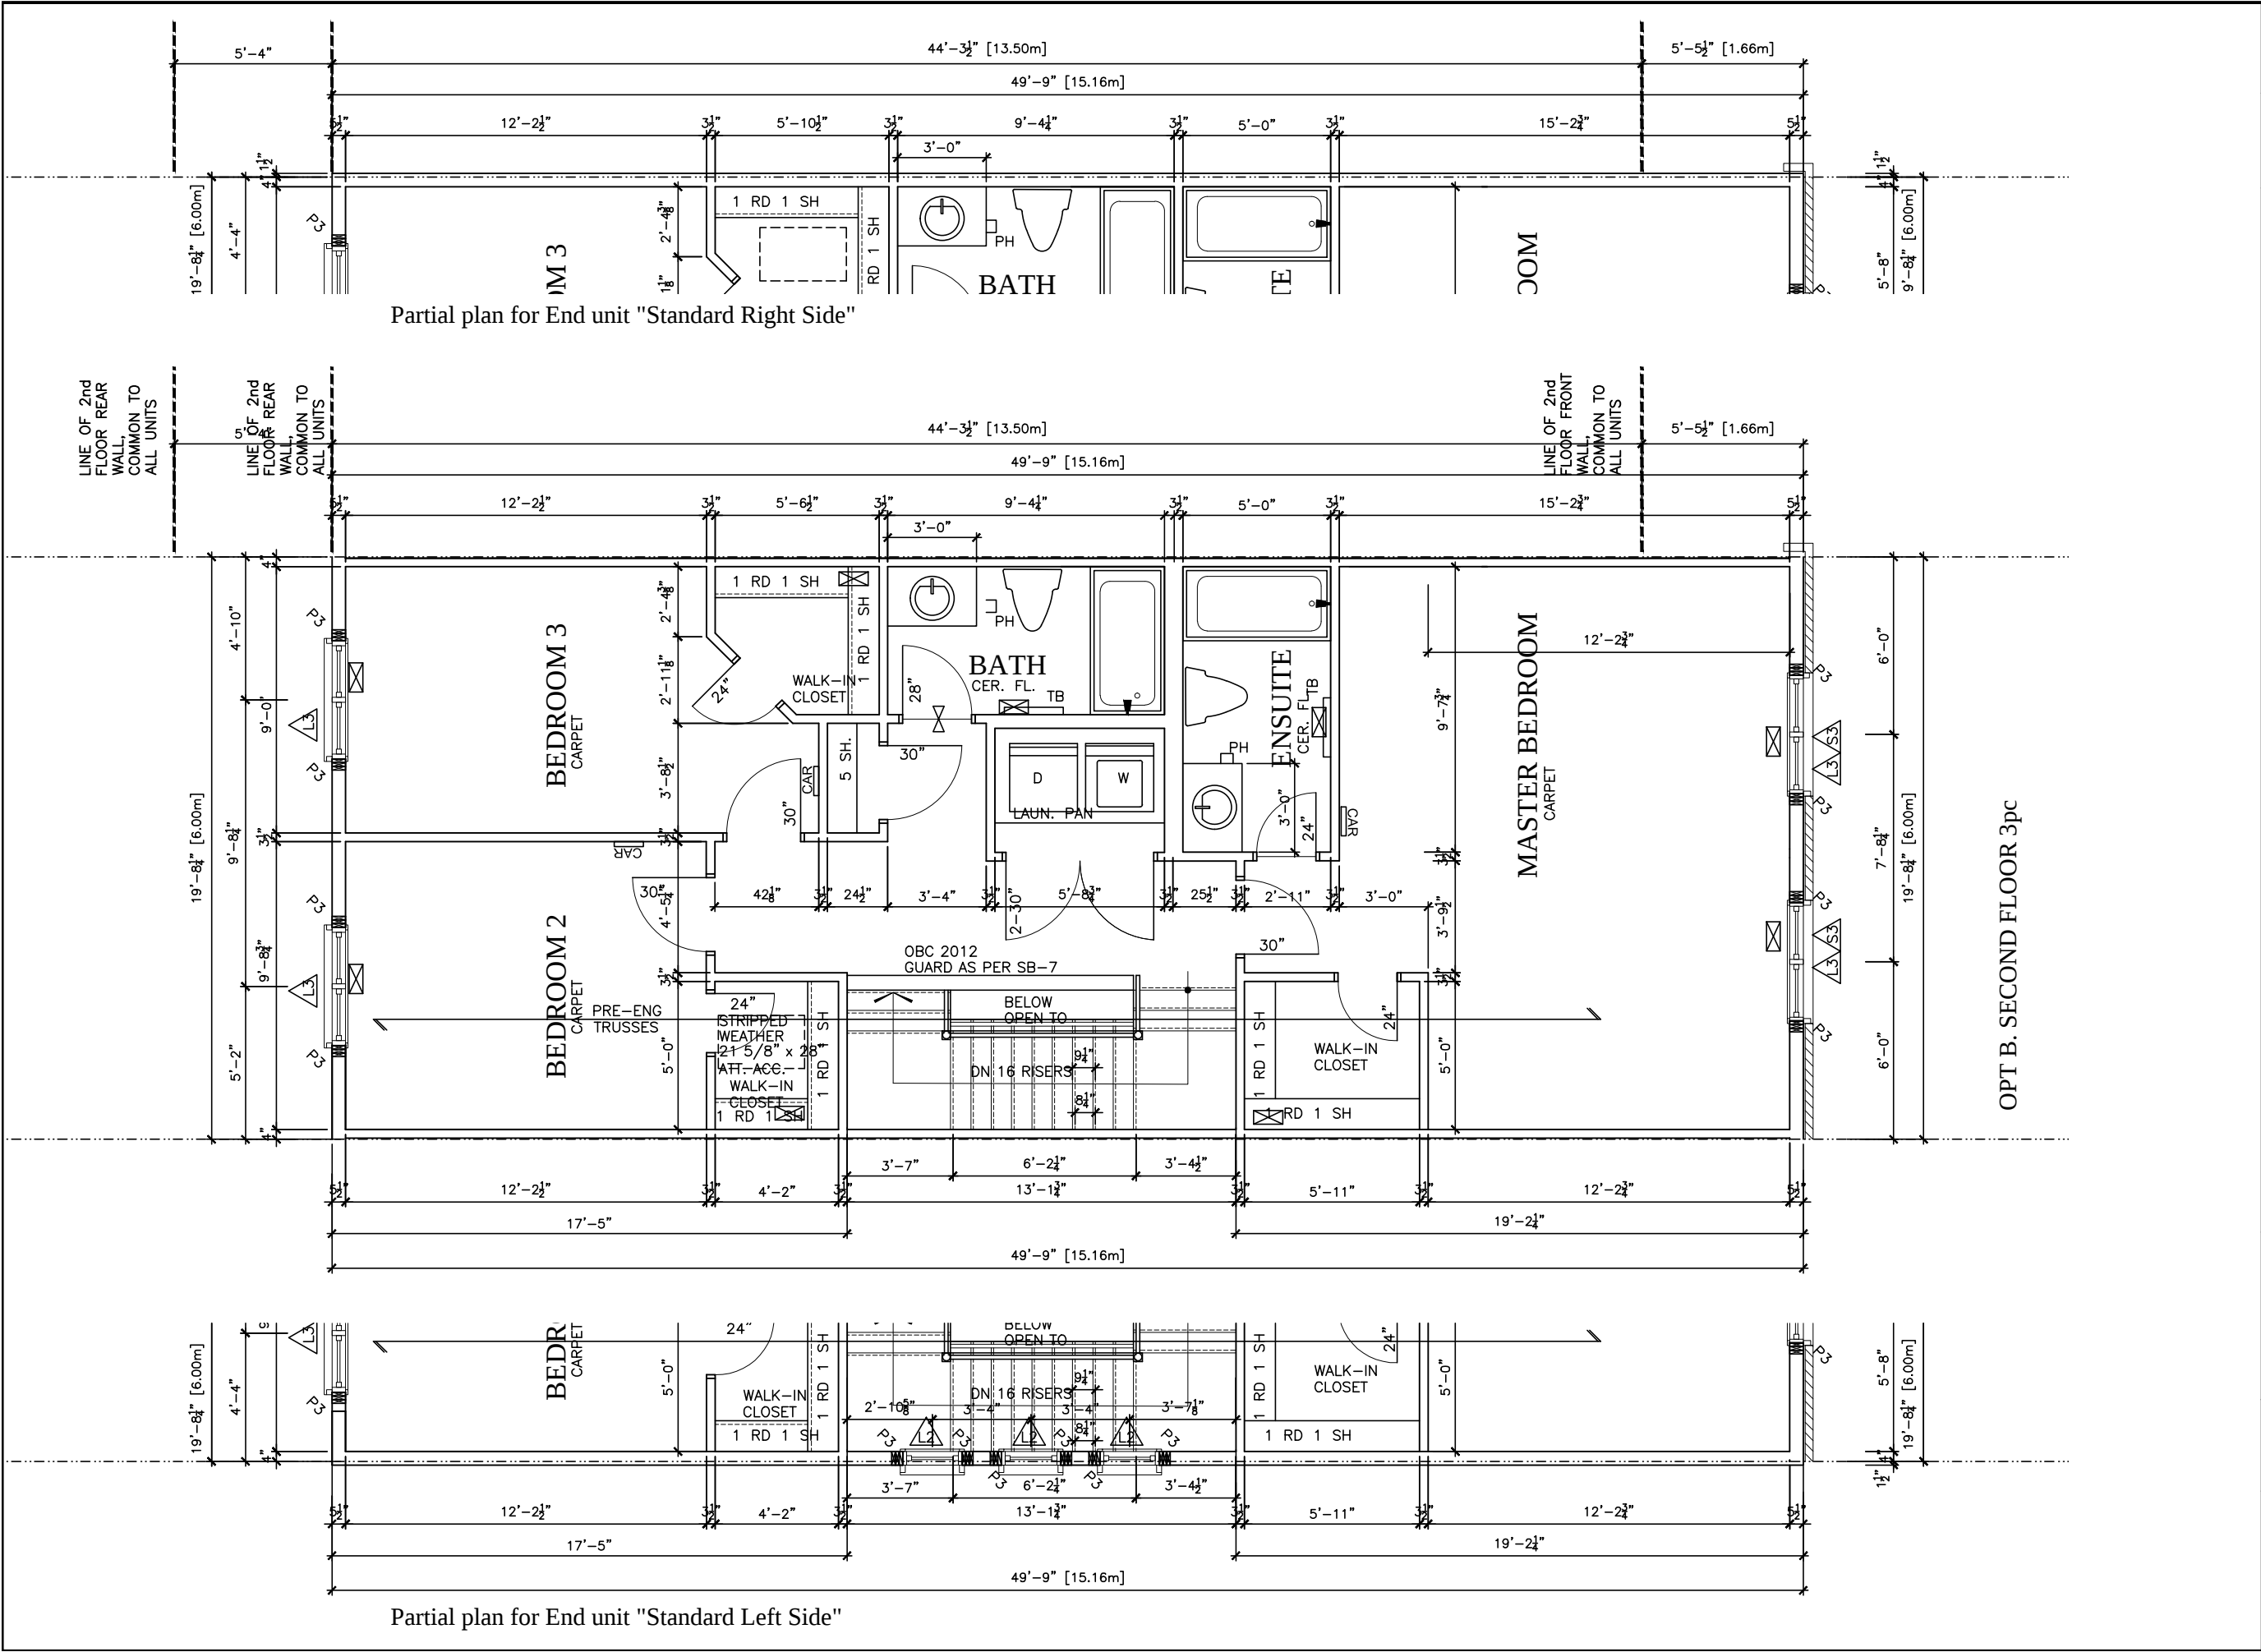

LOT **XXxx**
DATE **XX/XX/XX**

THIS DRAWINGS IS TO BE USED IN CONJUNCTION WITH SCHEDULE B-1A AND MAY SHOW ONLY SOME OF THE CHANGES DETAILED ON THAT DOCUMENT. SHOULD THE DRAWINGS NOT SHOW ALL ITEMS CONTAINED ON A SCHEDULE OR MISS OTHER ITEMS ALTOGETHER, THE SCHEDULE IS CONSIDERED THE GOVERNING DOCUMENT.
FLOORS CONT

TENDER 2017

- STRUCTURAL FRAMING SCHEDULE**
- STEEL LINTEL**
S1 - L 90x90x6
S2 - L 90x90x8
S3 - L 100x90x8
S4 - L 125x90x8
S5 - L 125x90x10
S6 - L 200x100x12
S7 - L 150x100x10 (200mm BEARING)
- WOOD LINTEL**
L1 - (2)38x235 w/ 12.7 PLYWOOD SPACER
L2 - (2)38x235
L3 - (3)38x235
L4 - (3)38x235 w/ 2-12.7 PLYWOOD SPACER
L5 - (3)38x286 w/ 2-12.7 PLYWOOD SPACER
L6 - (2)45x240 LVL
L7 - (3)45x240 LVL
- POSTS**
P1 - 75# STEEL TELEPOST
P2 - (2)38x89 or (2)38x140
P3 - (3)38x89 or (3)38x140
P4 - (4)38x89 or (4)38x140
P5 - (5)38x89 or (5)38x140
P6 - (6)38x89 or (6)38x140
P13 - HSS 88.9x88.9x3.18 + 100x200x12 T&B PL.
P14 - HSS 89x89x4.8 + 100x200x12 T&B PL.
P15 - HSS 76.2x76.2x4.78 + 100x180x12 T&B PL.
P16 - HSS 76.2x76.2x4.78 + 130x130x12 T&B PL.
P17 - HSS 73 O.D. x4.8 + 100x180x12PL B PL.
+ 130x160x10 T PL. (*)
(*) - 2-12# ANCH (WHERE ANCH PL. NOT USED)
ALL FOOTINGS 600x200 DP. UNLESS NOTED
SOIL: 100 KPA

2012 OBC DRAWINGS

4.	SITE MEASURE CONFIRMATION	12/01/16	SI
3.	ISSUED FOR 2016 TENDER	01/01/16	
2.	AS PER STRUCTURAL	30/01/15	
1.	STANDARD DRAWINGS	27/05/14	SI
NO.	DESCRIPTION	DATE	BY




TITLE:
2nd FLOOR PLAN - (Stanley 2)

ACAD FILE:
160-The Stanley 2012 Footprint
(STANDARD DRAWINGS)

SCALE:
3/16" = 1'-0"

DWG.
A-8c

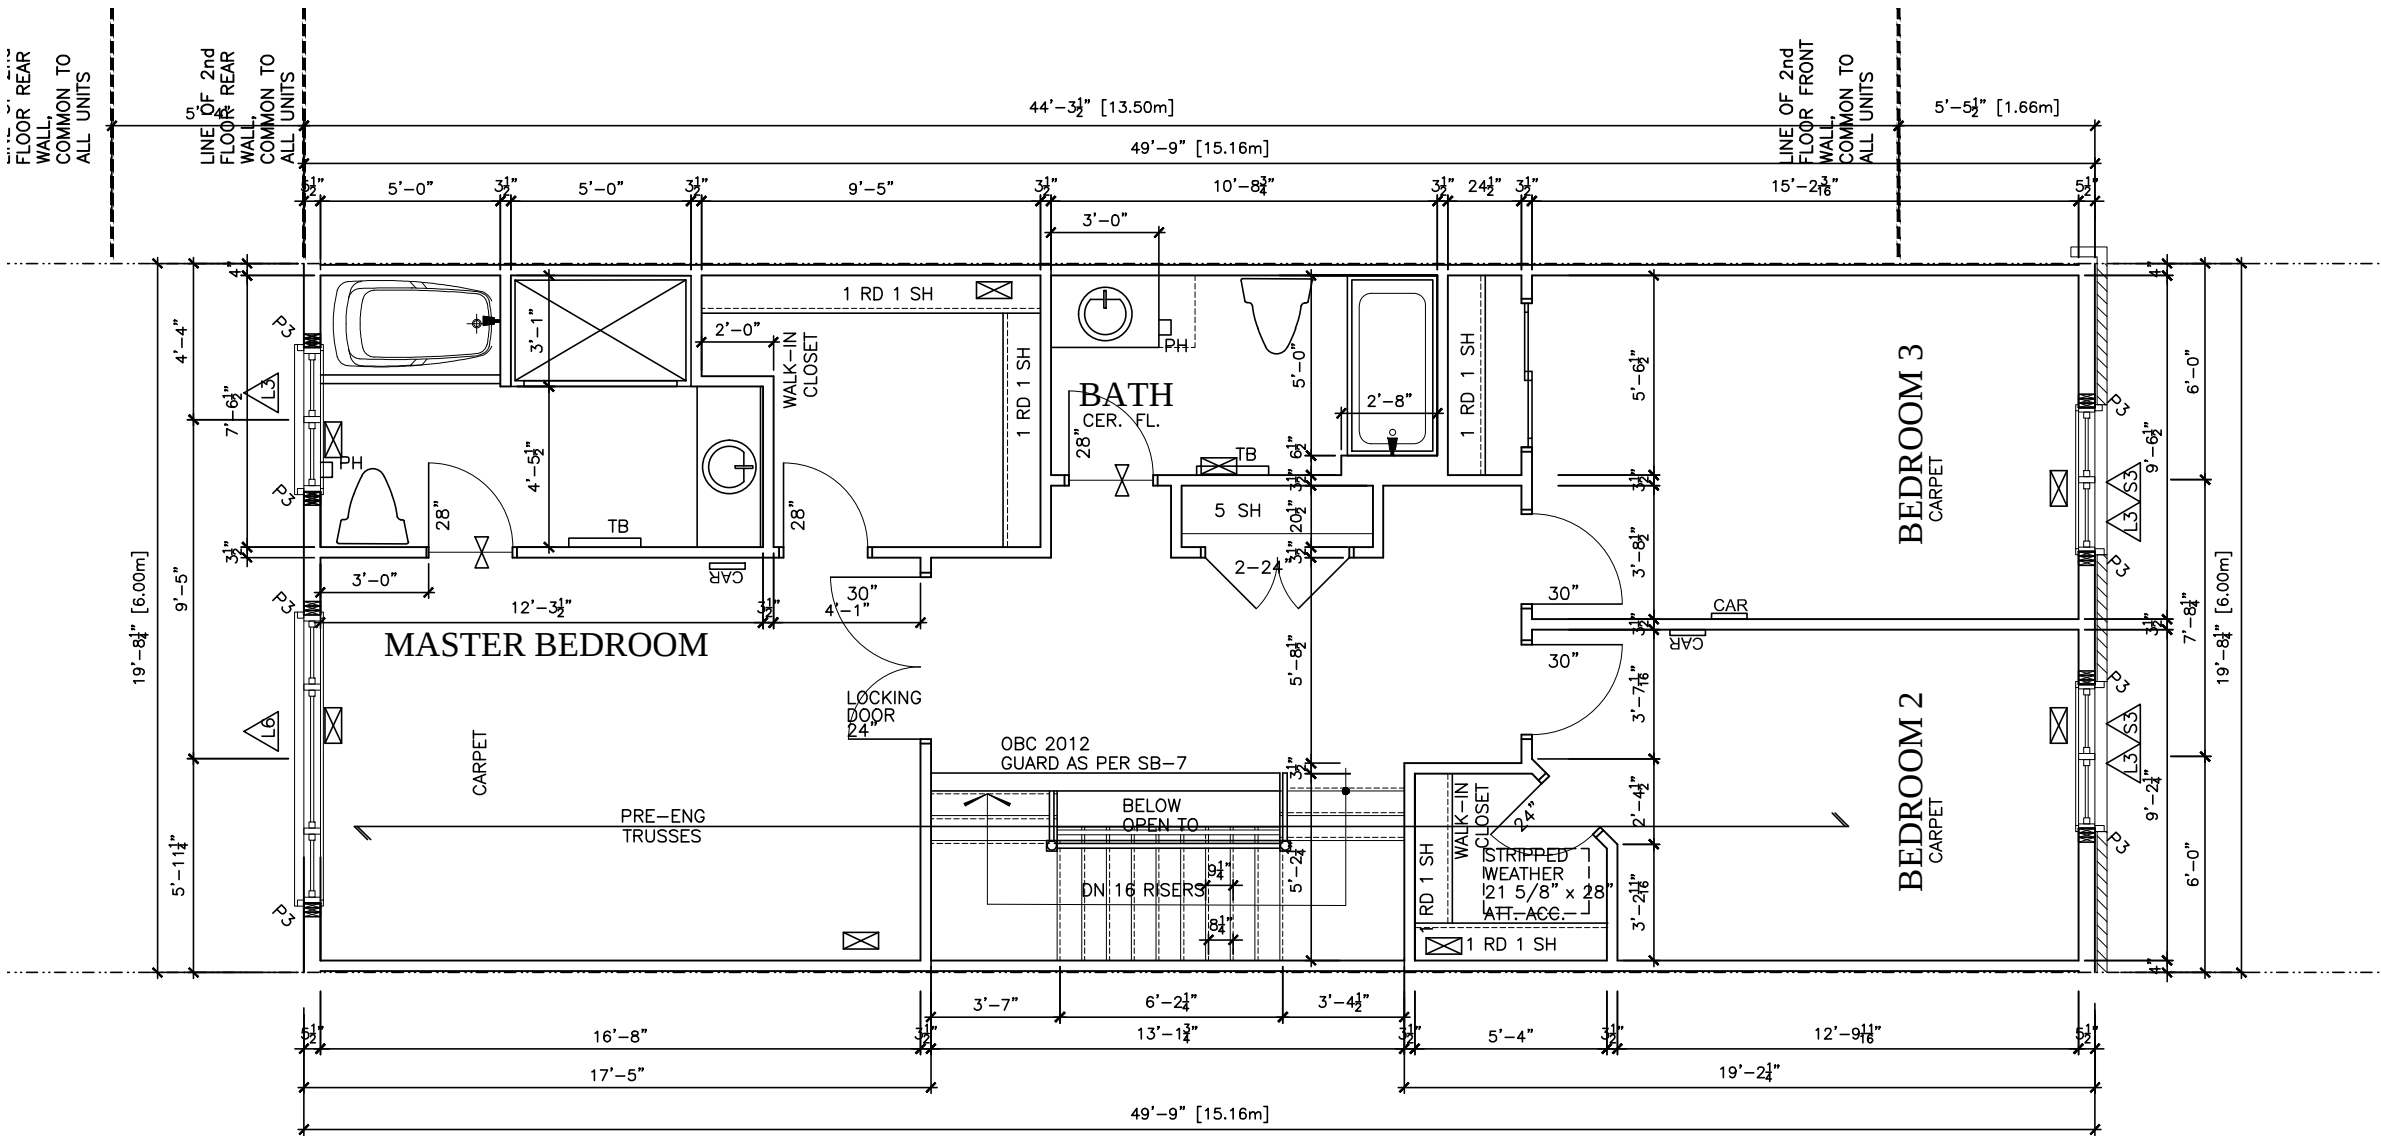

OPT A. 4pc ENSUITE

LOT **XXxx**

DATE **XX/XX/XX**

THIS DRAWINGS IS TO BE USED IN CONJUNCTION WITH SCHEDULE S-1A AND MAY SHOW ONLY SOME OF THE CHANGES DETAILED ON THAT DOCUMENT. SHOULD THE DRAWINGS NOT SHOW ALL ITEMS CONTAINED ON A SCHEDULE OR MISS OTHER ITEMS ALTOGETHER, THE SCHEDULE IS CONSIDERED THE GOVERNING DOCUMENT.
FLOORS CONT

TENDER 2017

STRUCTURAL FRAMING SCHEDULE		
STEEL LINTEL		
S1	-	L 90x90x6
S2	-	L 90x90x8
S3	-	L 100x90x8
S4	-	L 125x90x8
S5	-	L 125x90x10
S6	-	L 200x100x12
S7	-	L 150x100x10 (200mm BEARING)
WOOD LINTEL		
L1	-	(2)38x235 w/ 12.7 PLYWOOD SPACER
L2	-	(2)38x235
L3	-	(3)38x235
L4	-	(3)38x235 w/ 2-12.7 PLYWOOD SPACER & 2 ROW OF 90mm SPIRAL @ 200 o/c
L5	-	(3)38x286 w/ 2-12.7 PLYWOOD SPACER & 2 ROW OF 90mm SPIRAL @ 200 o/c
L6	-	(2)45x240 LVL
L7	-	(3)45x240 LVL
POSTS		
P1	-	75# STEEL TELEPOST
P2	-	(2)38x89 or (2)38x140
P3	-	(3)38x89 or (3)38x140
P4	-	(4)38x89 or (4)38x140
P5	-	(5)38x89 or (5)38x140
P6	-	(6)38x89 or (6)38x140
P13	-	HSS 88.9x88.9x3.18 + 100x200x12 T&B PL.
P14	-	HSS 89x89x4.8 + 100x200x12 T&B PL.
P15	-	HSS 76.2x76.2x4.78 + 100x180x12 T&B PL.
P16	-	HSS 76.2x76.2x4.78 + 130x130x12 T&B PL.
P17	-	HSS 73 O.D. x4.8 + 100x180x12PL B PL.
ALL FOOTINGS 600x200 DP. UNLESS NOTED		
SOIL: 100 KPA		

TRIM NOTES	
PH	- TOILET PAPER HOLDER 26" AFF
TB	- 24" TOWEL BAR 50" AFF
TR	- TOWEL RING 44" AFF

2012 OBC DRAWINGS

NO	DESCRIPTION	DATE	BY
5.	SITE MEASURE CONFIRMATION	12/01/16	SI
4.	ISSUED FOR 2016 TENDER	01/01/16	
3.	SHOWER DIM	09/02/15	SI
2.	FRAME CHECK NOTE ADDED	02/07/15	SI
1.	PAGE ADDED DUE TO END UNIT REVISION	30/01/15	SI



TITLE:
2nd FLOOR PLAN - (Stanley 1) misc

ACAD FILE:	SCALE: 3/16" = 1'-0"
------------	-------------------------

160-The Stanley 2012 Footprint (STANDARD DRAWINGS)	DWG. A-8b
--	---------------------

LOT **XXxx**

DATE **XX/XX/XX**

THIS DRAWINGS IS TO BE USED IN CONJUNCTION WITH SCHEDULE S-1A AND MAY SHOW ONLY SOME OF THE CHANGES DETAILED ON THAT DOCUMENT. SHOULD THE DRAWINGS NOT SHOW ALL ITEMS CONTAINED ON A SCHEDULE OR MISS OTHER ITEMS ALTOGETHER, THE SCHEDULE IS CONSIDERED THE GOVERNING DOCUMENT.
FLOORS CONT

TENDER 2017

STRUCTURAL FRAMING SCHEDULE

- STEEL LINTEL
- S1 - L 90x90x6
 - S2 - L 90x90x8
 - S3 - L 100x90x8
 - S4 - L 125x90x8
 - S5 - L 125x90x10
 - S6 - L 200x100x12
 - S7 - L 150x100x10 (200mm BEARING)
- WOOD LINTEL
- L1 - (2)38x235 w/ 12.7 PLYWOOD SPACER
 - L2 - (2)38x235
 - L3 - (3)38x235
 - L4 - (3)38x235 w/ 2-12.7 PLYWOOD SPACER & 2 ROW OF 90mm SPIRAL @ 200 o/c
 - L5 - (3)38x286 w/ 2-12.7 PLYWOOD SPACER & 2 ROW OF 90mm SPIRAL @ 200 o/c
 - L6 - (2)45x240 LVL
 - L7 - (3)45x240 LVL
- POSTS
- P1 - 75# STEEL TELEPOST
 - P2 - (2)38x89 or (2)38x140
 - P3 - (3)38x89 or (3)38x140
 - P4 - (4)38x89 or (4)38x140
 - P5 - (5)38x89 or (5)38x140
 - P6 - (6)38x89 or (6)38x140
 - P13 - HSS 88.9x88.9x3.18 + 100x200x12 T&B PL.
 - P14 - HSS 89x89x4.8 + 100x200x12 T&B PL.
 - P15 - HSS 76.2x76.2x4.78 + 100x180x12 T&B PL.
 - P16 - HSS 76.2x76.2x4.78 + 130x130x12 T&B PL.
 - P17 - HSS 73 O.D. x4.8 + 100x180x12PL B PL. + 130x160x10 T PL.
- (*) - 2-12# ANCH (WHERE ANCH PL. NOT USED)
- ALL FOOTINGS 600x200 DP. UNLESS NOTED
- SOIL: 100 KPA

2012 OBC DRAWINGS


4.	SITE MEASURE CONFIRMATION	12/01/16 SI
3.	ISSUED FOR 2016 TENDER	01/01/16
2.	SHOWER WALL DIM	02/09/15 SI
1.	PAGE ADDED DUE TO END UNIT REVISION	30/01/15 SI
NO.	DESCRIPTION	DATE BY





TITLE:
2nd FLOOR PLAN - (Stanley 2)

ACAD FILE: SCALE:
3/16" = 1'-0"

160-The Stanley
2012 Footprint
(STANDARD DRAWINGS)
DWG. A-8d

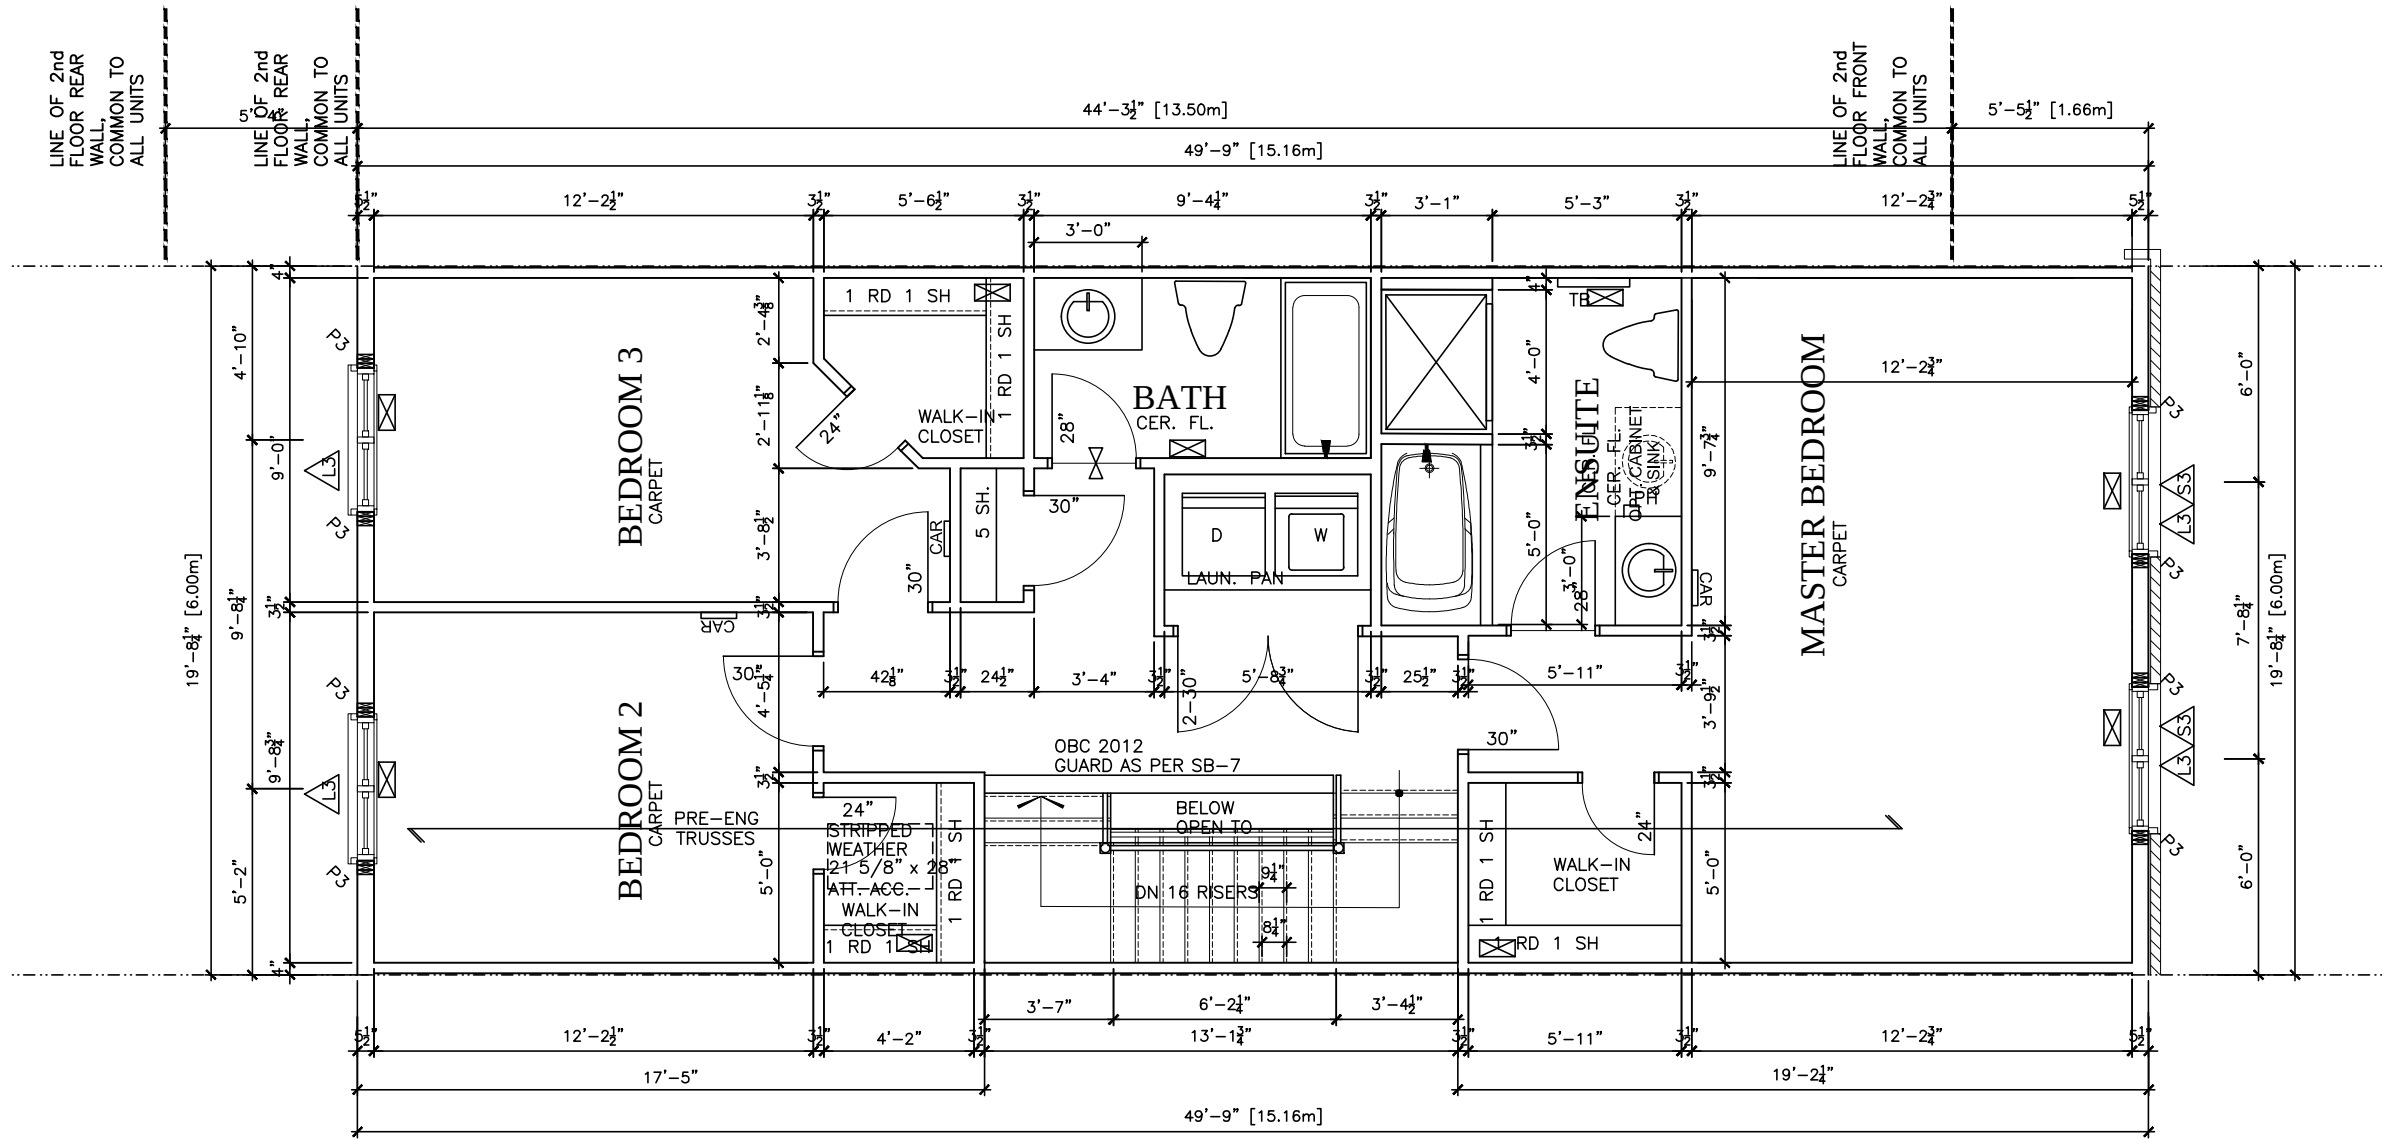


OPT B. 4pc ENSUITE

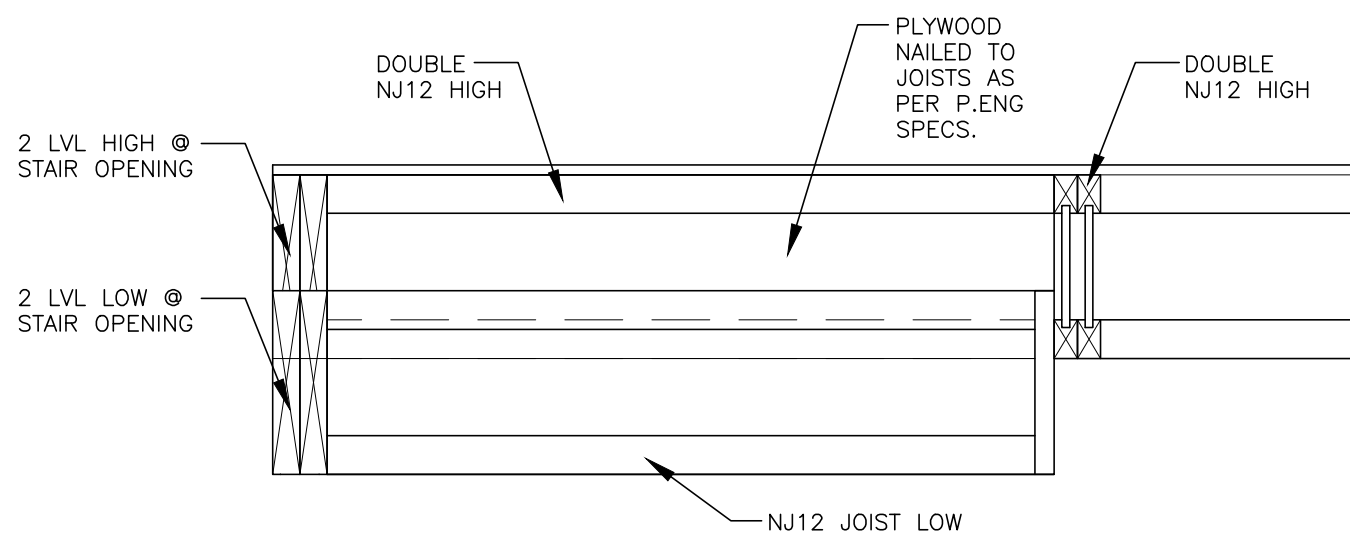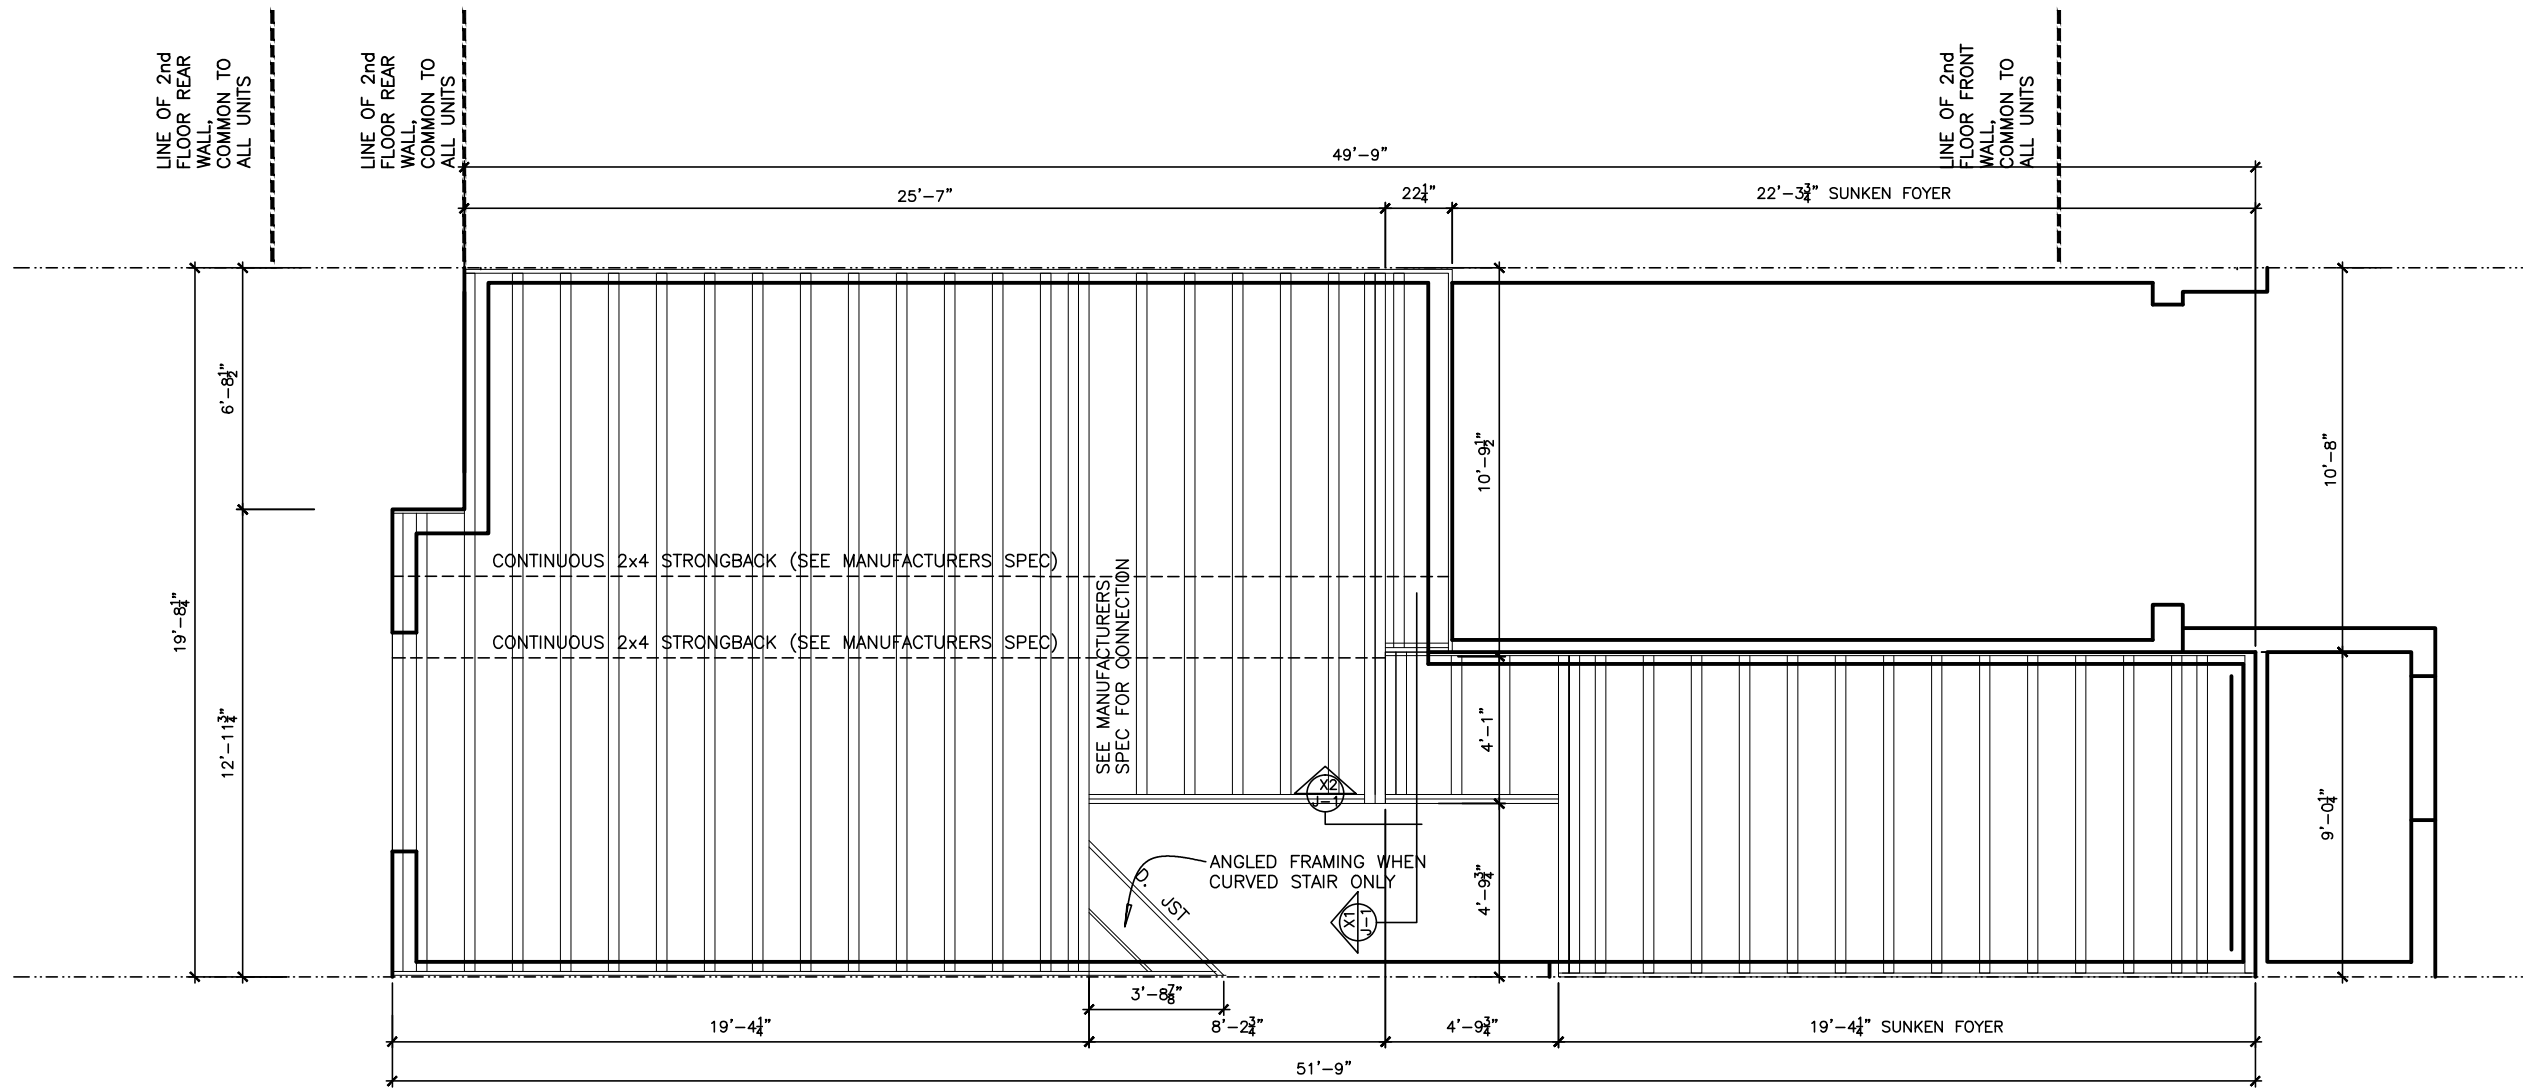

X1

J-1

SECTION THROUGH JOISTS 1

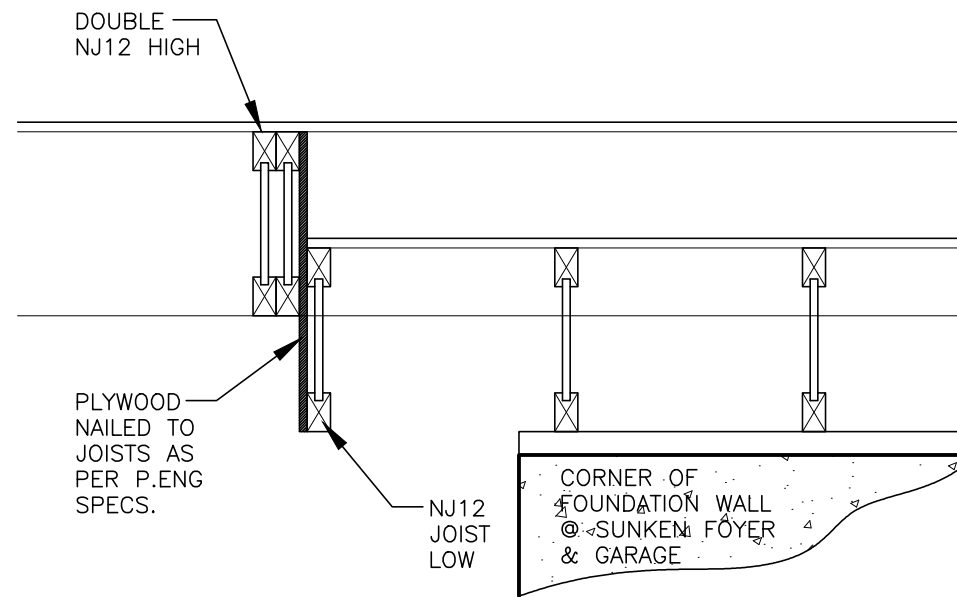

X2

J-1

SECTION THROUGH JOISTS 2

LOT XXXX

DATE XX/XX/XX

THIS DRAWING IS TO BE USED IN CONJUNCTION WITH SCHEDULE B-1A AND MAY SHOW ONLY SOME OF THE CHANGES DETAILED ON THAT DOCUMENT. SHOULD THE DRAWINGS NOT SHOW ALL ITEMS CONTAINED ON A SCHEDULE OR MISS OTHER ITEMS ALTOGETHER, THE SCHEDULE IS CONSIDERED THE GOVERNING DOCUMENT. FLOORS CONT.

TENDER 2017

STRUCTURAL FRAMING SCHEDULE

STEEL LINTEL
S1 - L 90x90x6
S2 - L 90x90x8
S3 - L 100x90x8
S4 - L 125x90x8
S5 - L 125x90x10
S6 - L 200x100x12
S7 - L 150x100x10 (200mm BEARING)

WOOD LINTEL
L1 - (2)38x235 w/ 12.7 PLYWOOD SPACER
L2 - (2)38x235
L3 - (3)38x235
L4 - (3)38x235 w/ 2-12.7 PLYWOOD SPACER & 2 ROW OF 90mm SPIRAL @ 200 o/c
L5 - (3)38x286 w/ 2-12.7 PLYWOOD SPACER & 2 ROW OF 90mm SPIRAL @ 200 o/c
L6 - (2)45x240 LVL
L7 - (3)45x240 LVL

POSTS
P1 - 75# STEEL TELEPOST
P2 - (2)38x89 or (2)38x140
P3 - (3)38x89 or (3)38x140
P4 - (4)38x89 or (4)38x140
P5 - (5)38x89 or (5)38x140
P6 - (6)38x89 or (6)38x140
P13 - HSS 88.9x88.9x3.18 + 100x200x12 T&B PL.
P14 - HSS 89x89x4.8 + 100x200x12 T&B PL.
P15 - HSS 76.2x76.2x4.78 + 100x180x12 T&B PL.
P16 - HSS 76.2x76.2x4.78 + 130x130x12 T&B PL.
P17 - HSS 73 O.D. x4.8 + 100x180x12PL B PL.
+ 130x180x10 T PL. (*)
(*) - 2-12# ANCH (WHERE ANCH PL. NOT USED)
ALL FOOTINGS 600x200 DP. UNLESS NOTED
SOIL: 100 KPA

TRIM NOTES
PH - TOILET PAPER HOLDER 26" AFF
TB - 24" TOWEL BAR 50" AFF
TR - TOWEL RING 44" AFF

2012 OBC DRAWINGS

NO	DESCRIPTION	DATE	BY
4.	ISSUED FOR 2016 TENDER	01/01/16	
3.	OPTIONAL CURVED STAIR FRAMING	30/01/15	SI
2.	AS PER STRUCTURAL	30/01/15	
1.	STANDARD DRAWINGS	27/05/14	SI




TITLE:
1st FLOOR JOIST PLAN

ACAD FILE: SCALE: 3/16" = 1'-0"

160-The Stanley
2012 Footprint
(STANDARD DRAWINGS)

J-1

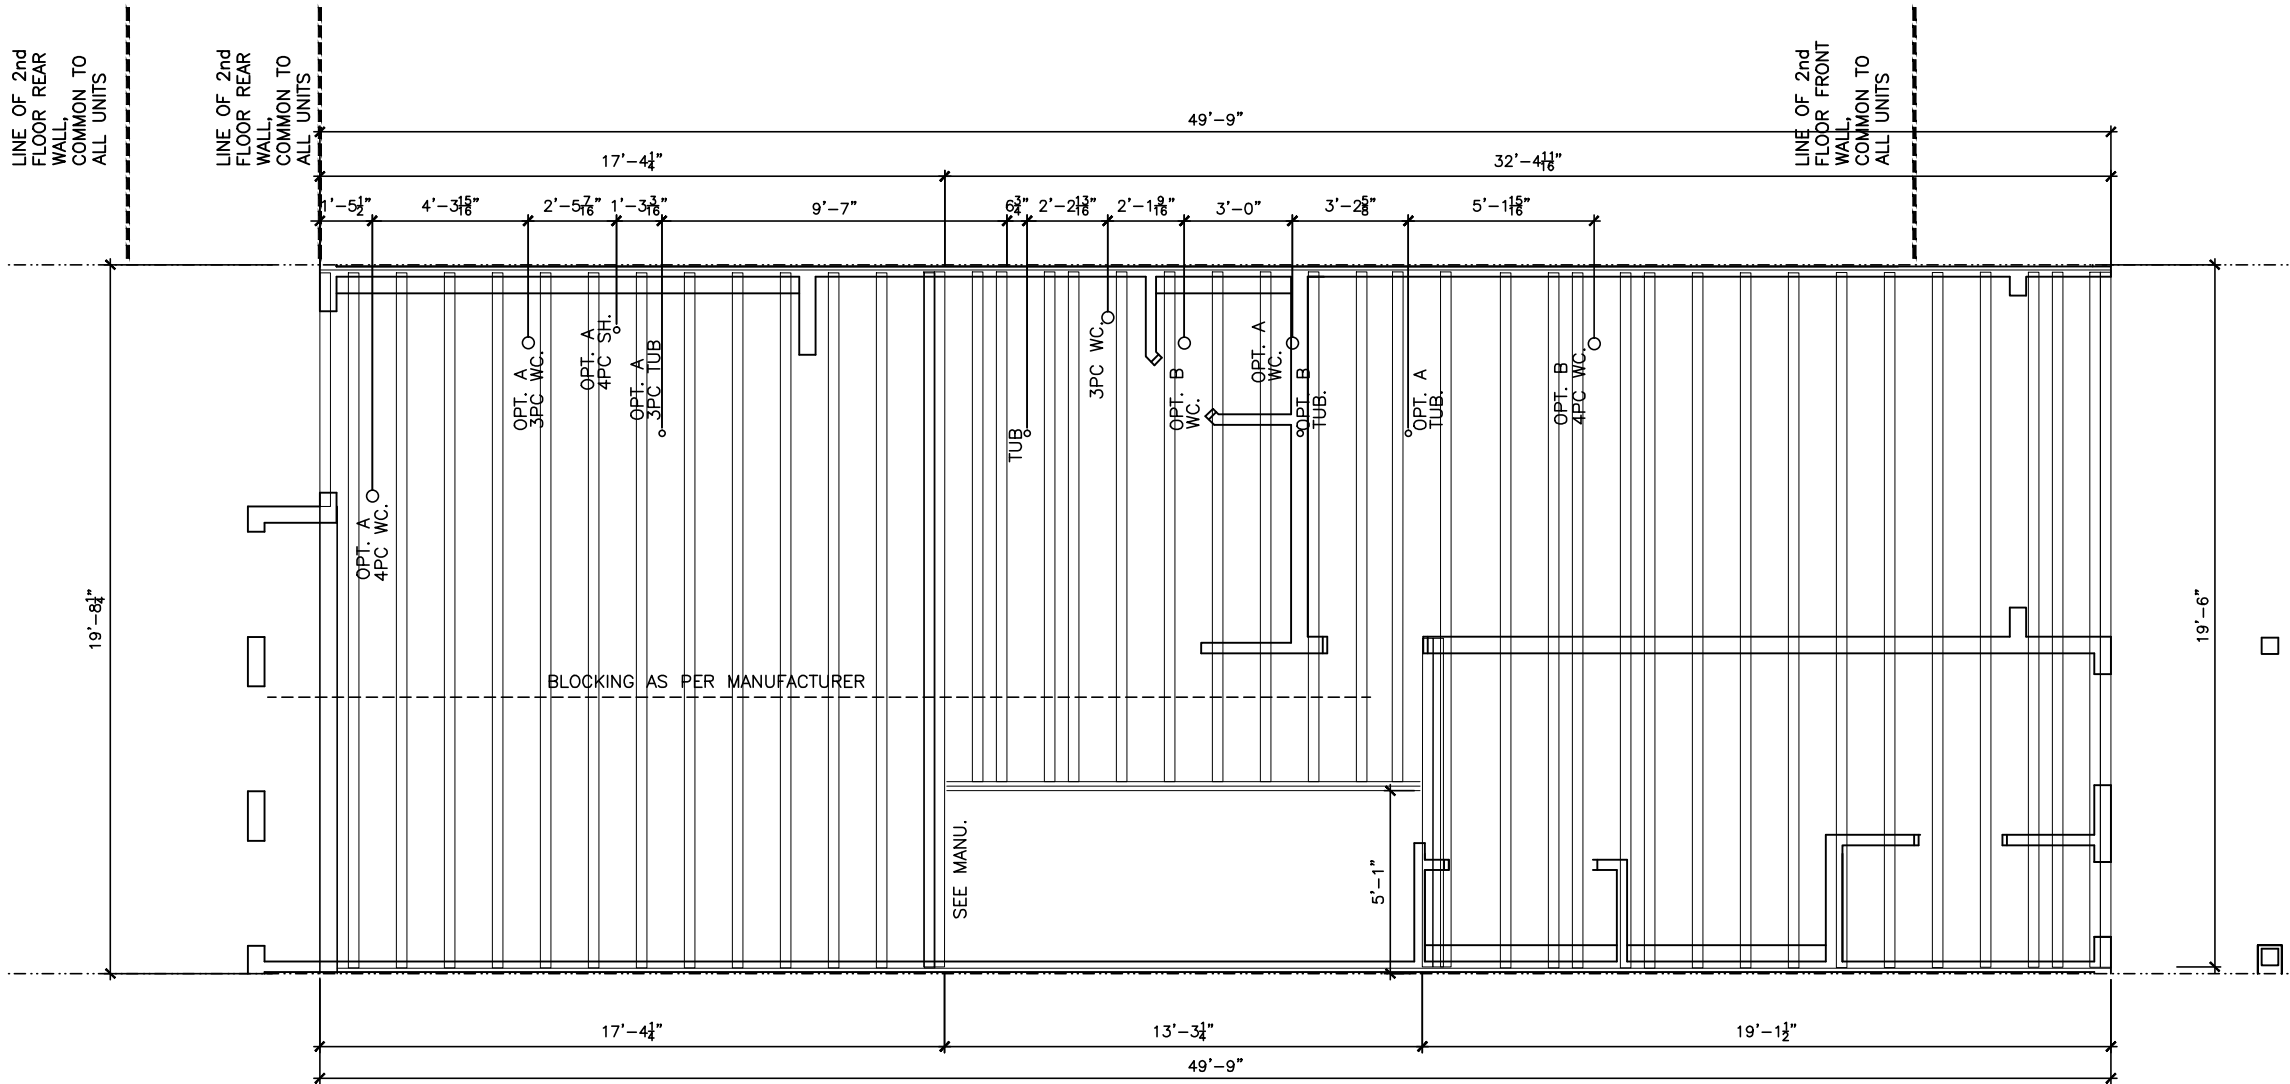

SECOND FLOOR JOIST PLAN

THIS DRAWINGS IS TO BE USED IN CONJUNCTION WITH SCHEDULE S-1A AND MAY SHOW ONLY SOME OF THE CHANGES DETAILED ON THAT DOCUMENT. SHOULD THE DRAWINGS NOT SHOW ALL ITEMS CONTAINED ON A SCHEDULE OR MISS OTHER ITEMS ALTOGETHER, THE SCHEDULE IS CONSIDERED THE GOVERNING DOCUMENT.

TENDER 2017

STRUCTURAL FRAMING SCHEDULE	
STEEL LINTEL	
S1	- L 90x90x6
S2	- L 90x90x8
S3	- L 100x90x8
S4	- L 125x90x8
S5	- L 125x90x10
S6	- L 200x100x12
S7	- L 150x100x10 (200mm BEARING)
WOOD LINTEL	
L1	- (2)38x235 w/ 12.7 PLYWOOD SPACER
L2	- (2)38x235
L3	- (3)38x235
L4	- (3)38x235 w/ 2-12.7 PLYWOOD SPACER & 2 ROW OF 90mm SPIRAL @ 200 c/c
L5	- (3)38x286 w/ 2-12.7 PLYWOOD SPACER & 2 ROW OF 90mm SPIRAL @ 200 c/c
L6	- (2)45x240 LVL
L7	- (3)45x240 LVL
POSTS	
P1	- 75# STEEL TELEPOST
P2	- (2)38x89 or (2)38x140
P3	- (3)38x89 or (3)38x140
P4	- (4)38x89 or (4)38x140
P5	- (5)38x89 or (5)38x140
P6	- (6)38x89 or (6)38x140
P13	- HSS 88.9x88.9x3.18 + 100x200x12 T&B PL. (*)
P14	- HSS 89x89x4.8 + 100x200x12 T&B PL. (*)
P15	- HSS 76.2x76.2x4.78 + 100x180x12 T&B PL. (*)
P16	- HSS 76.2x76.2x4.78 + 130x130x12 T&B PL. (*)
P17	- HSS 73 O.D. x4.8 + 100x180x12PL B PL. + 130x160x10 T PL. (*)
(*) - 2-12# ANCH (WHERE ANCH PL. NOT USED)	
ALL FOOTINGS 600x200 DP. UNLESS NOTED	
SOIL: 100 KPA	


TRIM NOTES	
PH	- TOILET PAPER HOLDER 26" AFF
TB	- 24" TOWEL BAR 50" AFF
TR	- TOWEL RING 44" AFF

2012 OBC DRAWINGS


3.	ISSUED FOR 2016 TENDER	01/01/16	
2.	AS PER STRUCTURAL	30/01/15	
1.	STANDARD DRAWINGS	27/05/14	SI
NO. DESCRIPTION		DATE	BY



TITLE:	
2nd FLOOR JOIST PLAN	
ACAD FILE:	SCALE: 3/16" = 1'-0"
160-The Stanley 2012 Footprint (STANDARD DRAWINGS)	DWG. J-2

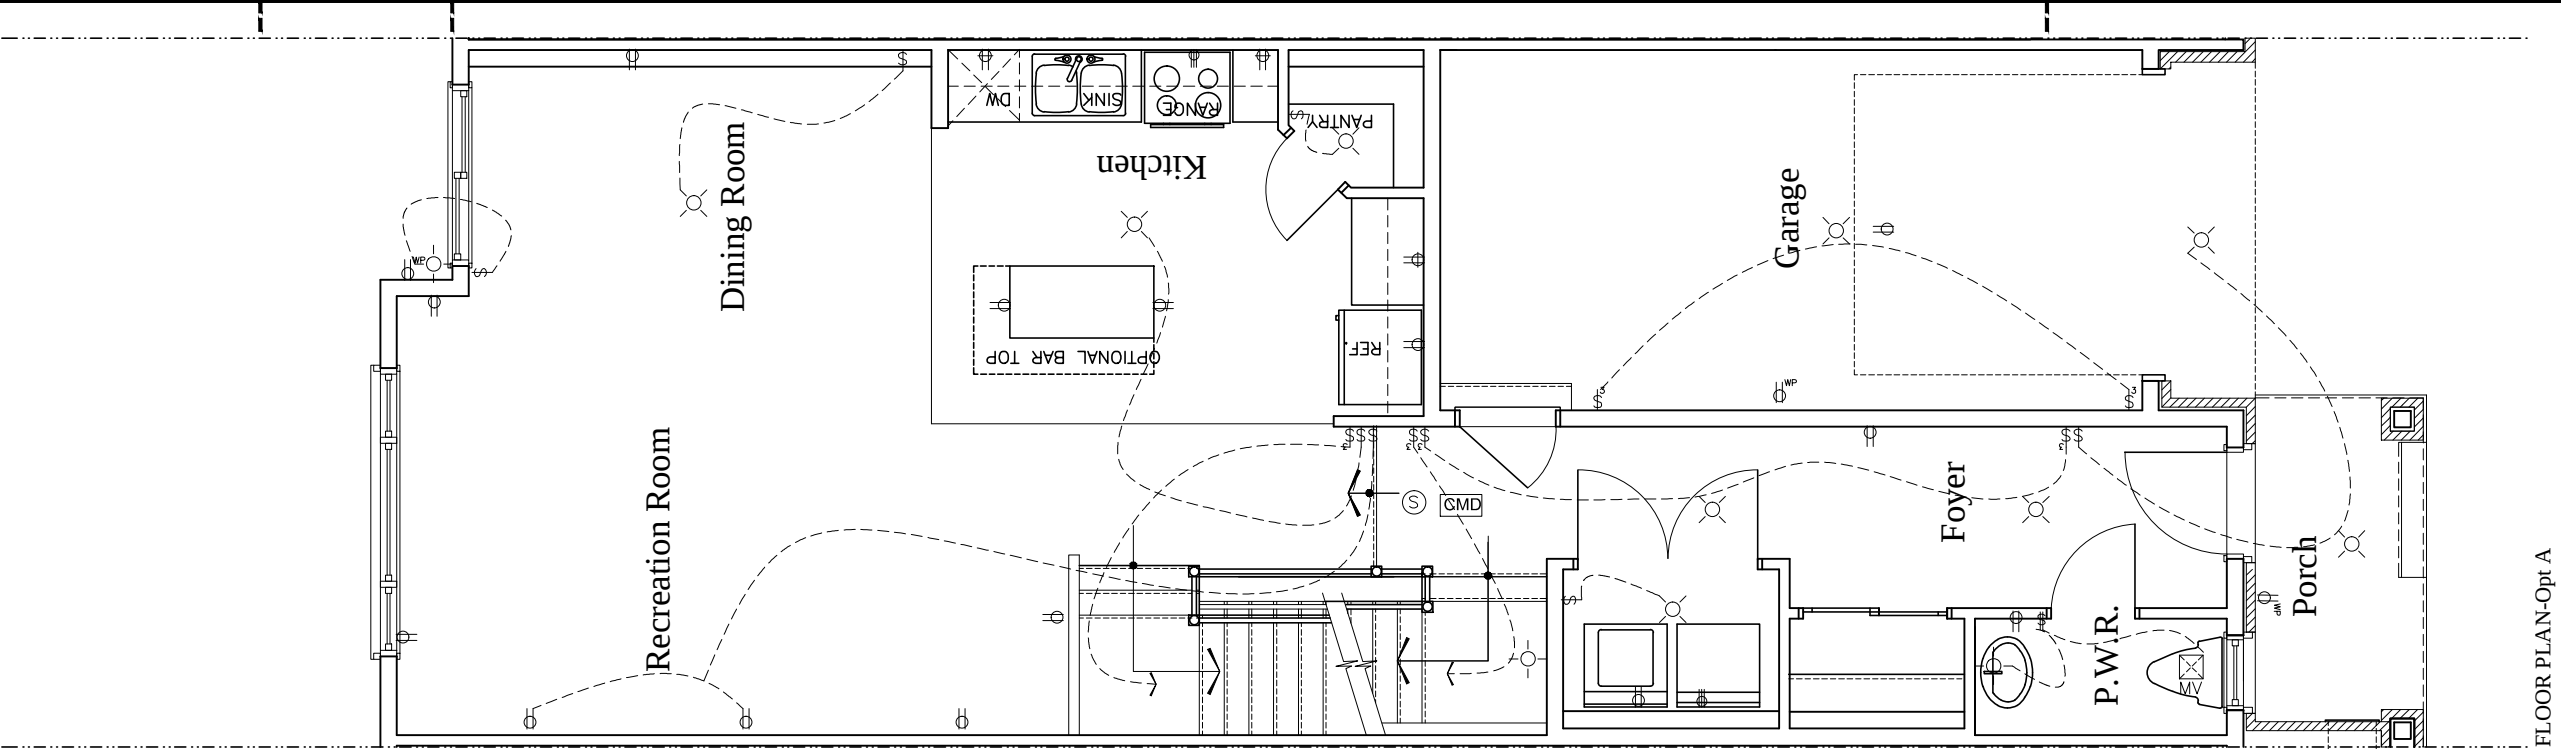

1st FLOOR PLAN-Opt A

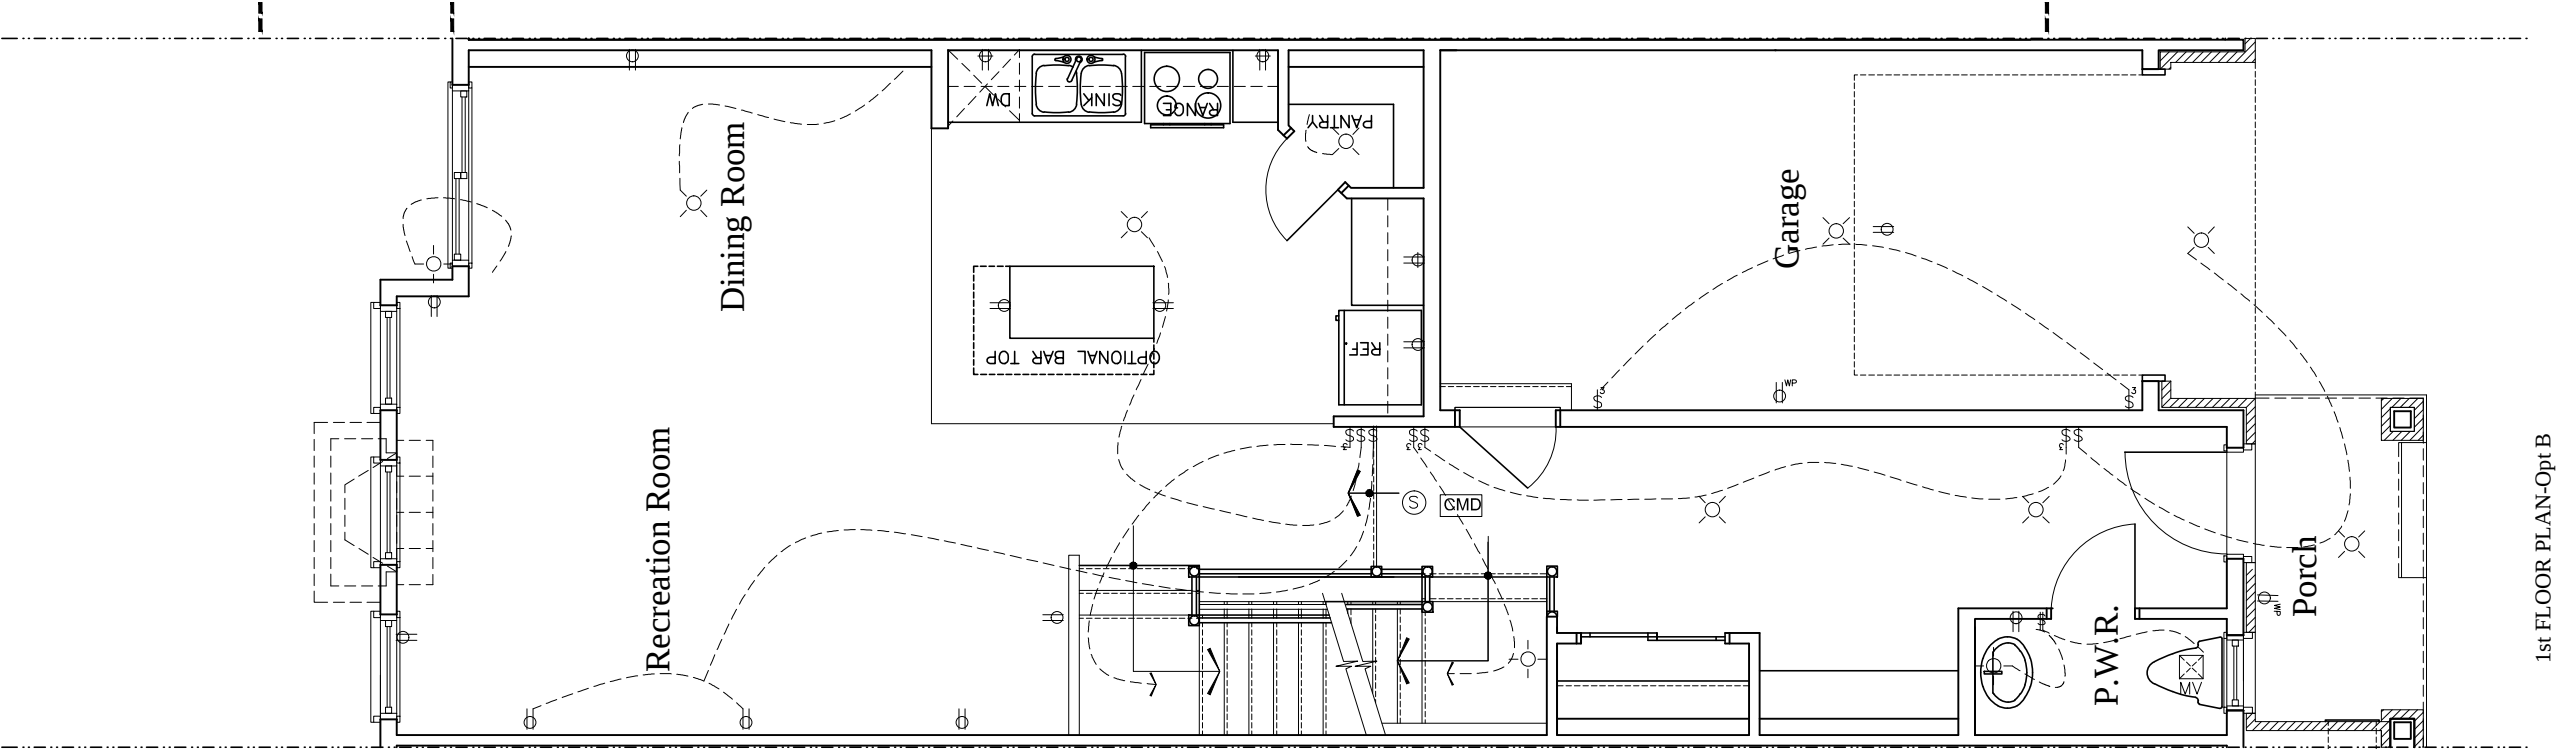

1st FLOOR PLAN-Opt B

Duplex Outlet (G.F.I. in all bathrooms)

220 V Outlet

Duplex Outlet (Upper half switched)

Split Duplex Outlet

Weather proof Duplex Outlet

Single pole switch

3 way switch

Double gang switch

Triple gang switch

Double gang 3 way switch

4 way switch

Furnace switch

Ceiling light fixture

Standard pot light

Wall mounted light fixture

Carbon Monoxide detector interconnected with smoke alarms

Carbon Monoxide detector interconnected with smoke alarms

Electrical panel

Mechanical vent

Dryer

Washer

Thermostat

Standard telephone jack

Cable television outlet.

Central vacuum location (Optional)

Ceiling light fixture

Pull Chain

2012 OBC DRAWINGS

3.	ISSUED FOR 2016 TENDER	01/01/16	
2.	AS PER STRUCTURAL	30/01/15	
1.	STANDARD DRAWINGS	27/05/14	SI
NO	DESCRIPTION	DATE	BY

Valecraft
Homes Ltd.


TITLE:
1st FLOOR ELECTRICAL PLAN

ACAD FILE:


SCALE:
3/16" = 1'-0"

160-The Stanley
2012 Footprint
(STANDARD DRAWINGS)

DWG.
E-1

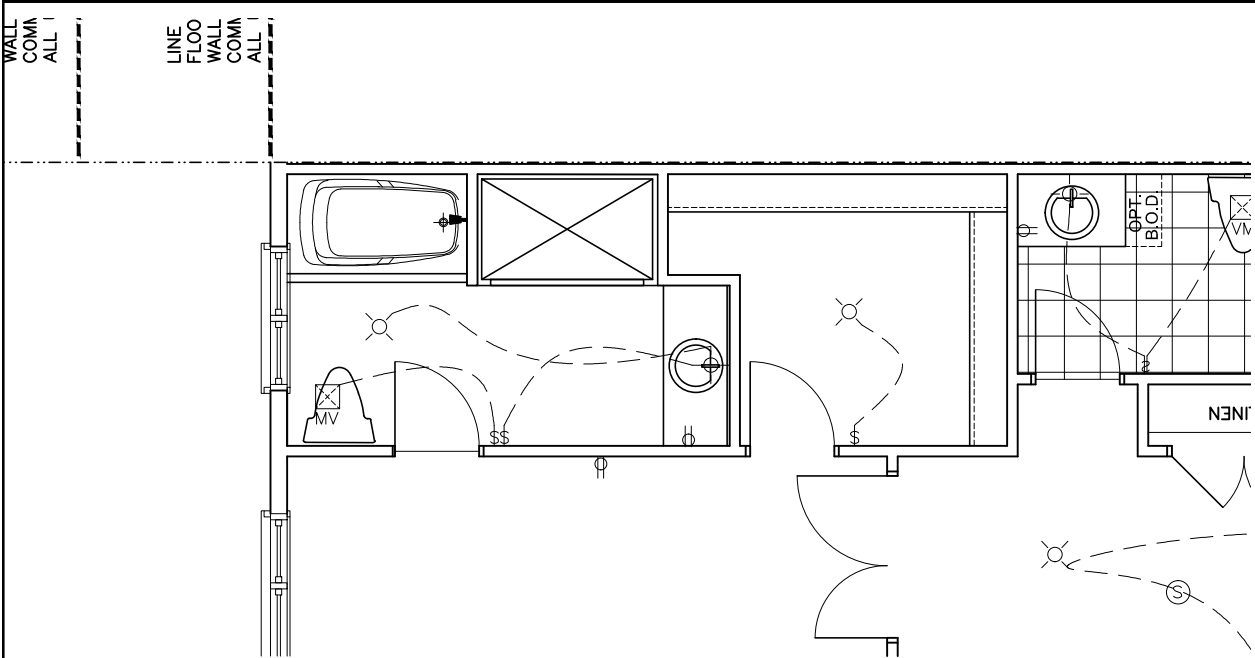

OPTIONAL. ENSUITE SHOWER

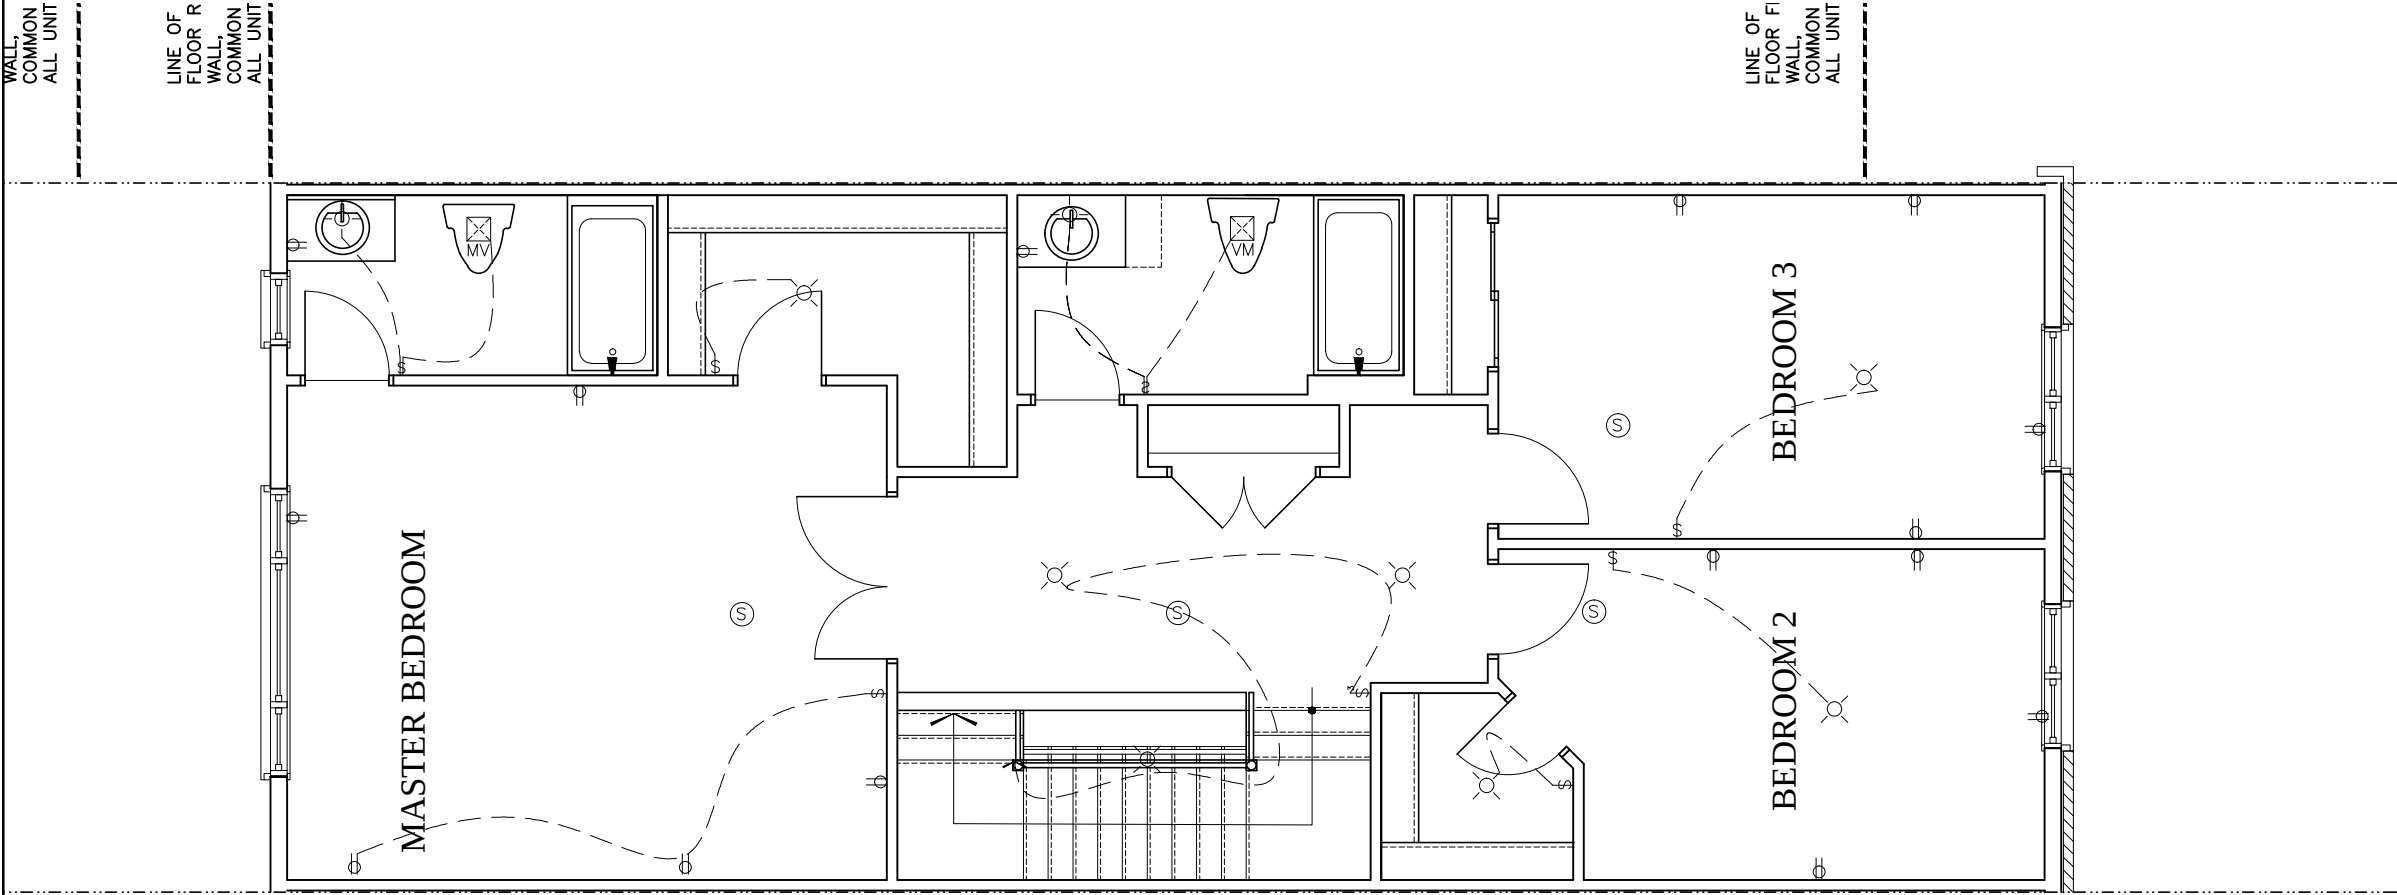

SECOND FLOOR 3pc

Duplex Outlet (G.F.I. in all bathrooms)

220 V Outlet

Duplex Outlet (Upper half switched)

Split Duplex Outlet

Weather proof Duplex Outlet

Single pole switch

3 way switch

Double gang switch

Triple gang switch

Double gang 3 way switch

4 way switch

Furnace switch

Ceiling light fixture

Standard pot light

Wall mounted light fixture

Carbon Monoxide detector

interconnected with smoke alarms

Carbon Monoxide detector

interconnected with smoke alarms

Electrical panel

Mechanical vent

Dryer

Washer

Thermostat

Standard telephone jack

Cable television outlet.

Central vacuum location (Optional)

Ceiling light fixture

Pull Chain

LOT **XXxx**

DATE **XX/XX/XX**

THIS DRAWINGS IS TO BE USED IN CONJUNCTION WITH SCHEDULE B-1A AND MAY SHOW ONLY SOME OF THE CHANGES DETAILED ON THAT DOCUMENT. SHOULD THE DRAWINGS NOT SHOW ALL ITEMS CONTAINED ON A SCHEDULE OR MISS OTHER ITEMS ALTOGETHER, THE SCHEDULE IS CONSIDERED THE GOVERNING DOCUMENT.
TENDER 2017

2012 OBC DRAWINGS

3.	ISSUED FOR 2016 TENDER	01/01/16	
2.	AS PER STRUCTURAL	30/01/15	
1.	STANDARD DRAWINGS	27/05/14	SI
NO	DESCRIPTION	DATE	BY



TITLE:
2nd FLOOR PLAN - (Stanley 1)

ACAD FILE: SCALE:
3/16" = 1'-0"

160-The Stanley
2012 Footprint
(STANDARD DRAWINGS)
DWG.
E2-a

THIS DRAWINGS IS TO BE USED IN CONJUNCTION WITH SCHEDULE B-1A AND MAY SHOW ONLY SOME OF THE CHANGES DETAILED ON THAT DOCUMENT. SHOULD THE DRAWINGS NOT SHOW ALL ITEMS CONTAINED ON A SCHEDULE OR MISS OTHER ITEMS ALTOGETHER, THE SCHEDULE IS CONSIDERED THE GOVERNING DOCUMENT. FLOORS CONT

TENDER 2017

2012 OBC DRAWINGS

3.	ISSUED FOR 2016 TENDER	01/01/16	
2.	AS PER STRUCTURAL	30/01/15	
1.	STANDARD DRAWINGS	27/05/14	SI
NO	DESCRIPTION	DATE	BY




TITLE:
2nd FLOOR PLAN - (Stanley 2)

ACAD FILE: SCALE:
3/16" = 1'-0"


160-The Stanley
2012 Footprint
(STANDARD DRAWINGS)

DWG.
E2-b

- Duplex Outlet (G.F.I. in all bathrooms)
- 220 V Outlet
- Duplex Outlet (Upper half switched)
- Split Duplex Outlet
- Weather proof Duplex Outlet
- Single pole switch
- 3 way switch
- Double gang switch
- Triple gang switch
- Double gang 3 way switch
- 4 way switch
- Furnace switch
- Ceiling light fixture
- Standard pot light
- Wall mounted light fixture
- Carbon Monoxide detector interconnected with smoke alarms
- Carbon Monoxide detector interconnected with smoke alarms
- Electrical panel
- Mechanical vent
- Dryer
- Washer
- Thermostat
- Standard telephone jack
- Cable television outlet.
- Central vacuum location (Optional)
- Ceiling light fixture
- Pull Chain

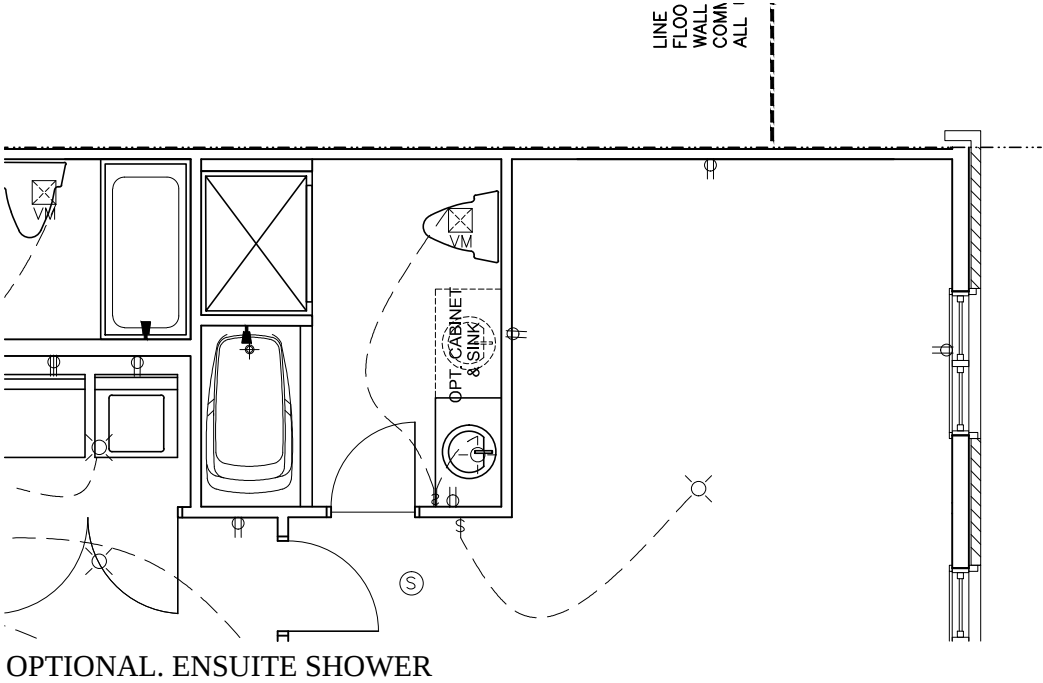

OPTIONAL. ENSUITE SHOWER

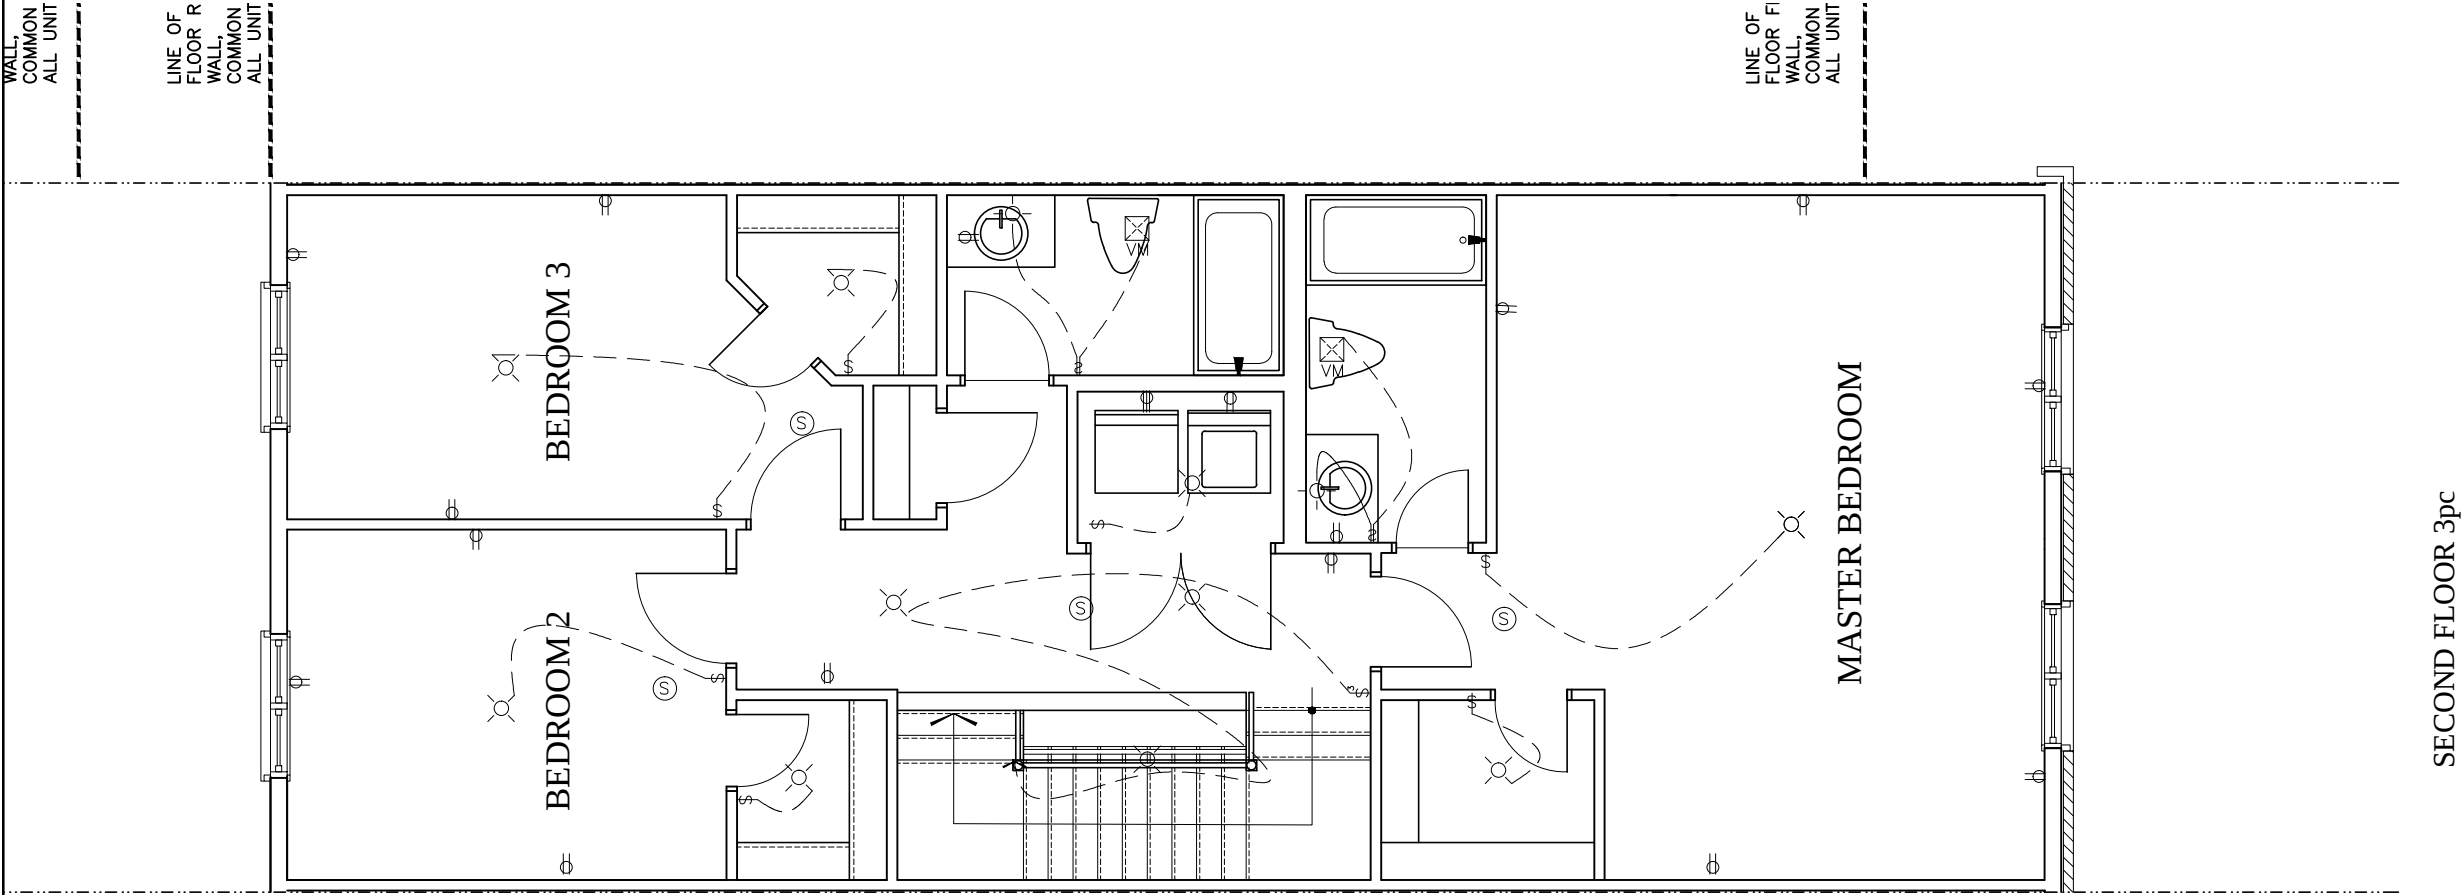

SECOND FLOOR 3pc