

LOT **XXxx**

DATE **XX/XX/XX**

THIS DRAWINGS IS TO BE USED IN CONJUNCTION WITH SCHEDULE B-1A AND MAY SHOW ONLY SOME OF THE CHANGES DETAILED ON THAT DOCUMENT. SHOULD THE DRAWINGS NOT SHOW ALL ITEMS CONTAINED ON A SCHEDULE OR MISS OTHER ITEMS ALTOGETHER, THE SCHEDULE IS CONSIDERED THE GOVERNING DOCUMENT.
FLOORS CONT

TENDER 2017

I SCOTT IRWIN BCIN 20765 HAVE REVIEWED AND TAKE RESPONSIBILITY FOR DESIGN ACTIVITIES RELATING TO, HOUSE & SMALL BUILDINGS.

EXTERIOR FINISH LEGEND

- B - BRICK (MAIN)
- B1 - BRICK SOLDIER COURSE (ACCENT)
- B2 - BRICK SOLDIER COURSE (ACCENT)
- B3 - BRICK SLEEPER COURSE
- B4 - STACK BOND (ACCENT)
- B5 - BRICK SILL (ACCENT)
- B6 - BRICK ROW LOCK (ACCENT)
- B7 - BRICK CORBELLING
- B8 - BRICK COINING 20mm PROUD
- +20 - BRICK 20mm PROUD
- 20 - BRICK RECESSED 20mm
- S - SIDING (HORIZONTAL)
- ST - STONE VENEER
- T - TRIM 200mm COVE SIDING
- AF - ALUMINUM FACSIA
- AC - ALUMINUM CLADDING
- AS - ASPHALT SHINGLES
- F - FLASHING
- V - ROOF VENT MAX
- P - PARGING
- PC - PRECAST
- PCH10 - PRECAST HEADER 10"
- PCH8 - PRECAST HEADER 8"
- PCS - PRECAST SILL
- PCB - PRECAST BAND
- VS - VINYL SHAKES

2012 OBC DRAWINGS


2.	AS PER STRUCTURAL	09/09/16	
1.	STANDARD DRAWINGS	02/11/15	SI
NO.	DESCRIPTION	DATE	BY



TITLE: **Front Elevation B**

ACAD FILE: SCALE: **3/16" = 1'-0"**

1050-The McCaslin
2012 Footprint
(STANDARD DRAWINGS)
DWG. **A-1b**

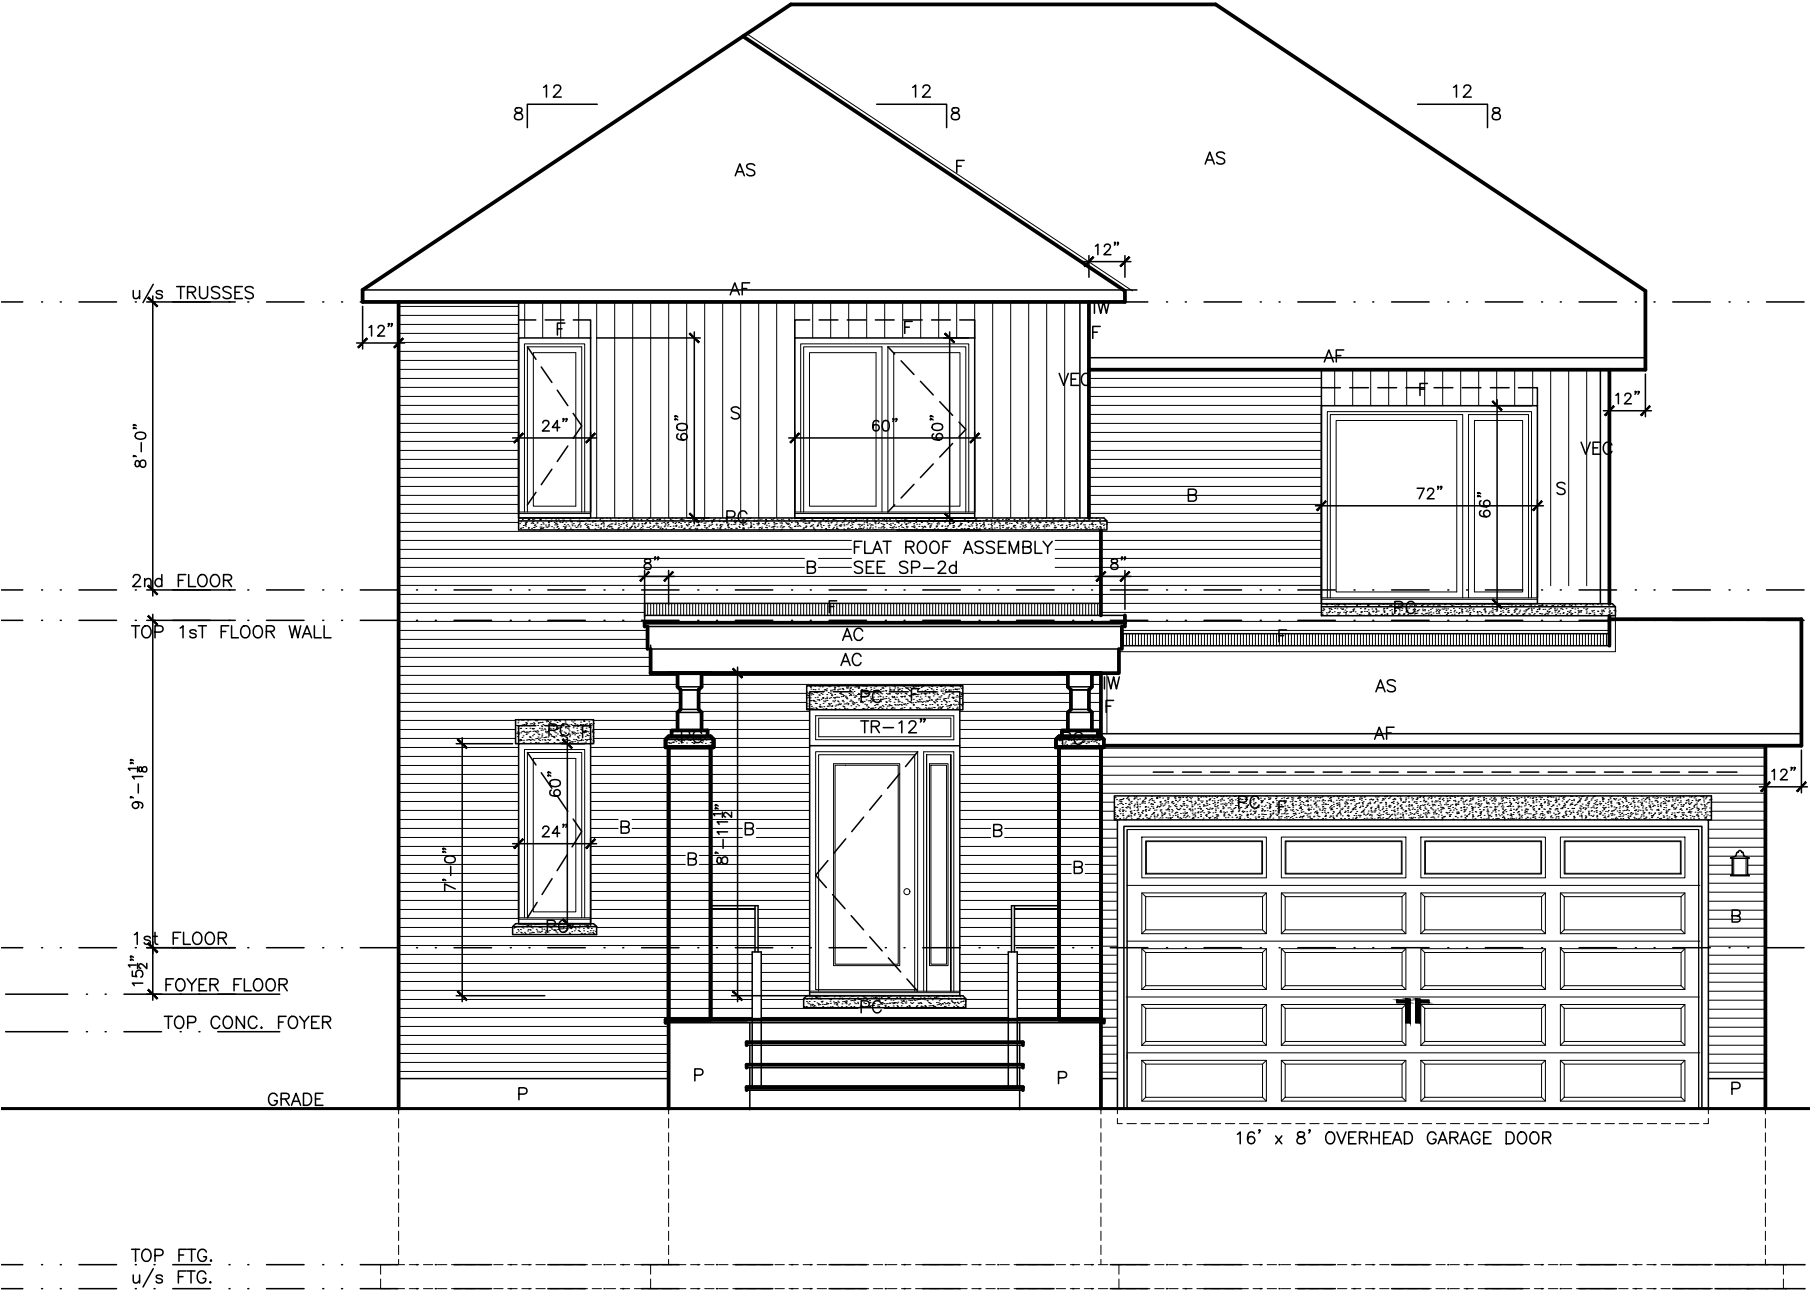

1
A1b Front Elevation B

LOT **XXxx**

DATE **XX/XX/XX**

THIS DRAWING IS TO BE USED IN CONJUNCTION WITH SCHEDULE B-1A AND MAY SHOW ONLY SOME OF THE CHANGES DETAILED ON THAT DOCUMENT. SHOULD THE DRAWINGS NOT SHOW ALL ITEMS CONTAINED ON A SCHEDULE OR MISS OTHER ITEMS ALTOGETHER, THE SCHEDULE IS CONSIDERED THE GOVERNING DOCUMENT.
FLOORS CONT

TENDER 2017

I SCOTT IRWIN BCIN 20765 HAVE REVIEWED AND TAKE RESPONSIBILITY FOR DESIGN ACTIVITIES RELATING TO, HOUSE & SMALL BUILDINGS.

EXTERIOR FINISH LEGEND

- B - BRICK (MAIN)
- B1 - BRICK SOLDIER COURSE (ACCENT)
- B2 - BRICK SOLDIER COURSE (ACCENT)
- B3 - BRICK SLEEPER COURSE
- B4 - STACK BOND (ACCENT)
- B5 - BRICK SILL (ACCENT)
- B6 - BRICK ROW LOCK (ACCENT)
- B7 - BRICK CORBELLING
- B8 - BRICK COINING 20mm PROUD
- +20 - BRICK 20mm PROUD
- 20 - BRICK RECESSED 20mm
- S - SIDING (HORIZONTAL)
- ST - STONE VENEER
- T - TRIM 200mm COVE SIDING
- AF - ALUMINUM FACSIA
- AC - ALUMINUM CLADDING
- AS - ASPHALT SHINGLES
- F - FLASHING
- V - ROOF VENT MAX
- P - PARGING
- PC - PRECAST
- PCH10 - PRECAST HEADER 10"
- PCH8 - PRECAST HEADER 8"
- PCS - PRECAST SILL
- PCB - PRECAST BAND
- VS - VINYL SHAKES

2012 OBC DRAWINGS

2.	AS PER STRUCTURAL	09/09/16	
1.	STANDARD DRAWINGS	02/11/15	SI
NO.	DESCRIPTION	DATE	BY



TITLE: **Front Elevation C**

ACAD FILE: SCALE: **3/16" = 1'-0"**


1050-The McCaslin
2012 Footprint
(STANDARD DRAWINGS)
A-1c



1 Front Elevation C
A1c

I SCOTT IRWIN BCIN 20765 HAVE REVIEWED AND TAKE
RESPONSIBILITY FOR DESIGN ACTIVITIES RELATING TO,
HOUSE & SMALL BUILDINGS _____.



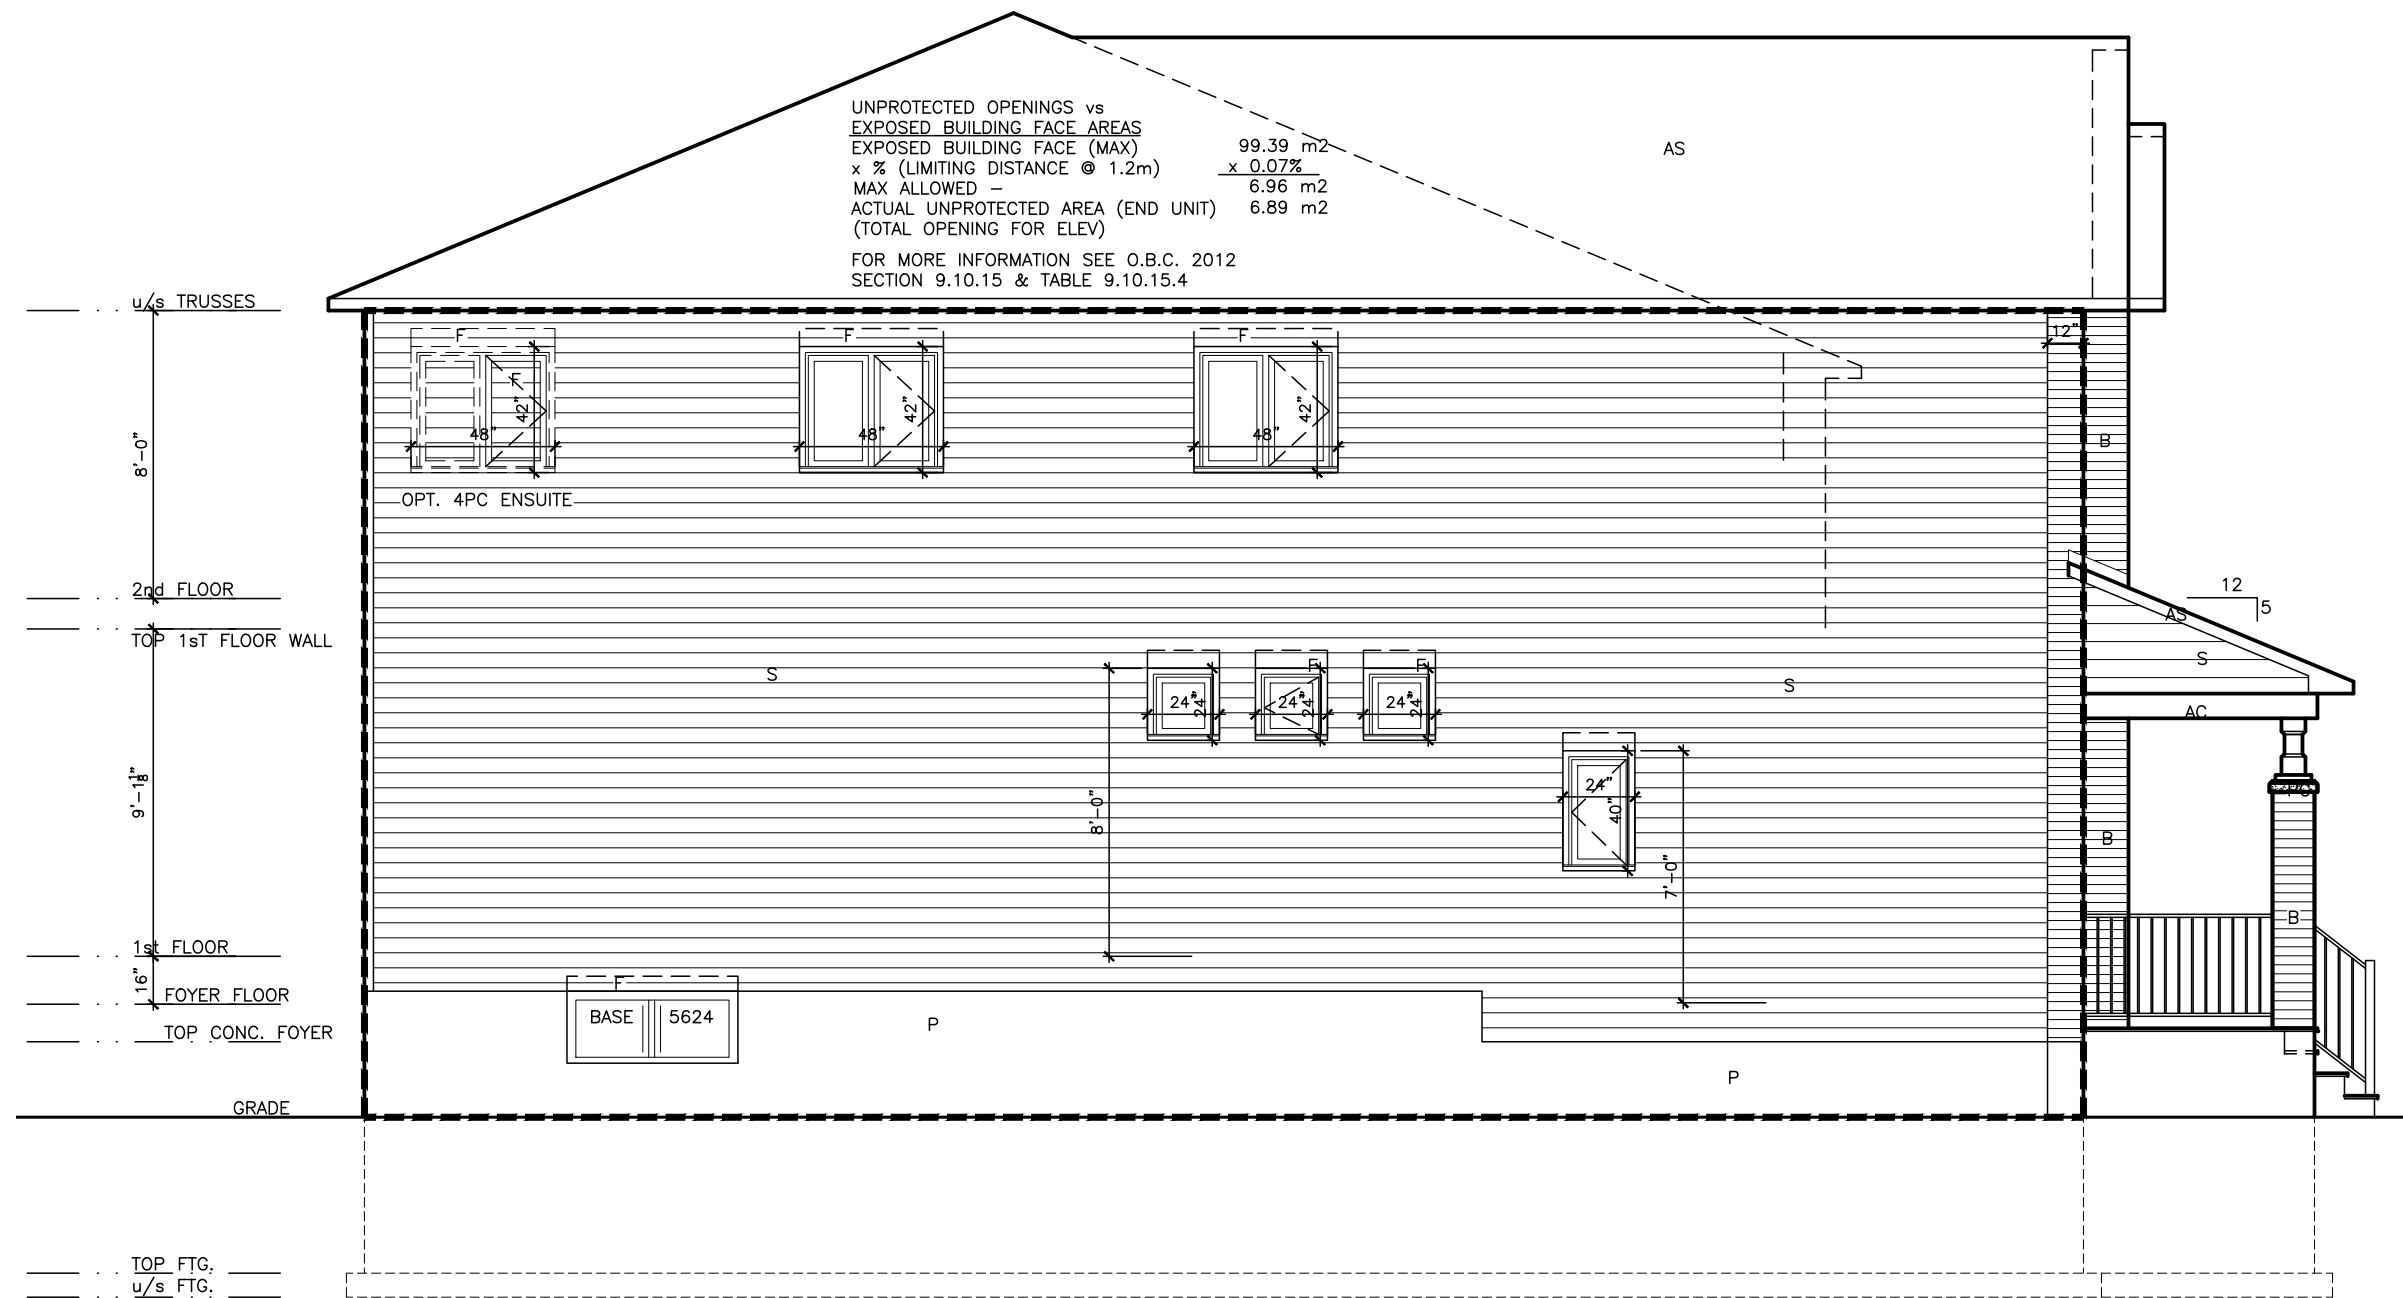

1 Left Side Elevation A
A2

LOT XXxx

DATE XX/XX/XX

THIS DRAWINGS IS TO BE USED IN CONJUNCTION WITH
SCHEDULE B-1A AND MAY SHOW ONLY SOME OF THE CHANGES
DETAILED ON THAT DOCUMENT. SHOULD THE DRAWINGS NOT
SHOW ALL ITEMS CONTAINED ON A SCHEDULE OR MISS OTHER
ITEMS ALTOGETHER, THE SCHEDULE IS CONSIDERED THE
GOVERNING DOCUMENT.
FLOORS CONT

TENDER 2017

I SCOTT IRWIN BCIN 20765 HAVE REVIEWED AND TAKE
RESPONSIBILITY FOR DESIGN ACTIVITIES RELATING TO,
HOUSE & SMALL BUILDINGS.

2012 OBC DRAWINGS

2.	AS PER STRUCTURAL	09/09/16	
1.	STANDARD DRAWINGS	02/11/15	SI
NO.	DESCRIPTION	DATE	BY




TITLE: Left Side Elevation A

ACAD FILE: SCALE: 3/16" = 1'-0"

1050-The McCaslin
2012 Footprint
(STANDARD DRAWINGS)
A-2

THIS DRAWING IS TO BE USED IN CONJUNCTION WITH SCHEDULE B-1A AND MAY SHOW ONLY SOME OF THE CHANGES DETAILED ON THAT DOCUMENT. SHOULD THE DRAWINGS NOT SHOW ALL ITEMS CONTAINED ON A SCHEDULE OR MISS OTHER ITEMS ALTOGETHER, THE SCHEDULE IS CONSIDERED THE GOVERNING DOCUMENT.
TENDER 2017

I SCOTT IRWIN BCIN 20765 HAVE REVIEWED AND TAKE RESPONSIBILITY FOR DESIGN ACTIVITIES RELATING TO, HOUSE & SMALL BUILDINGS.

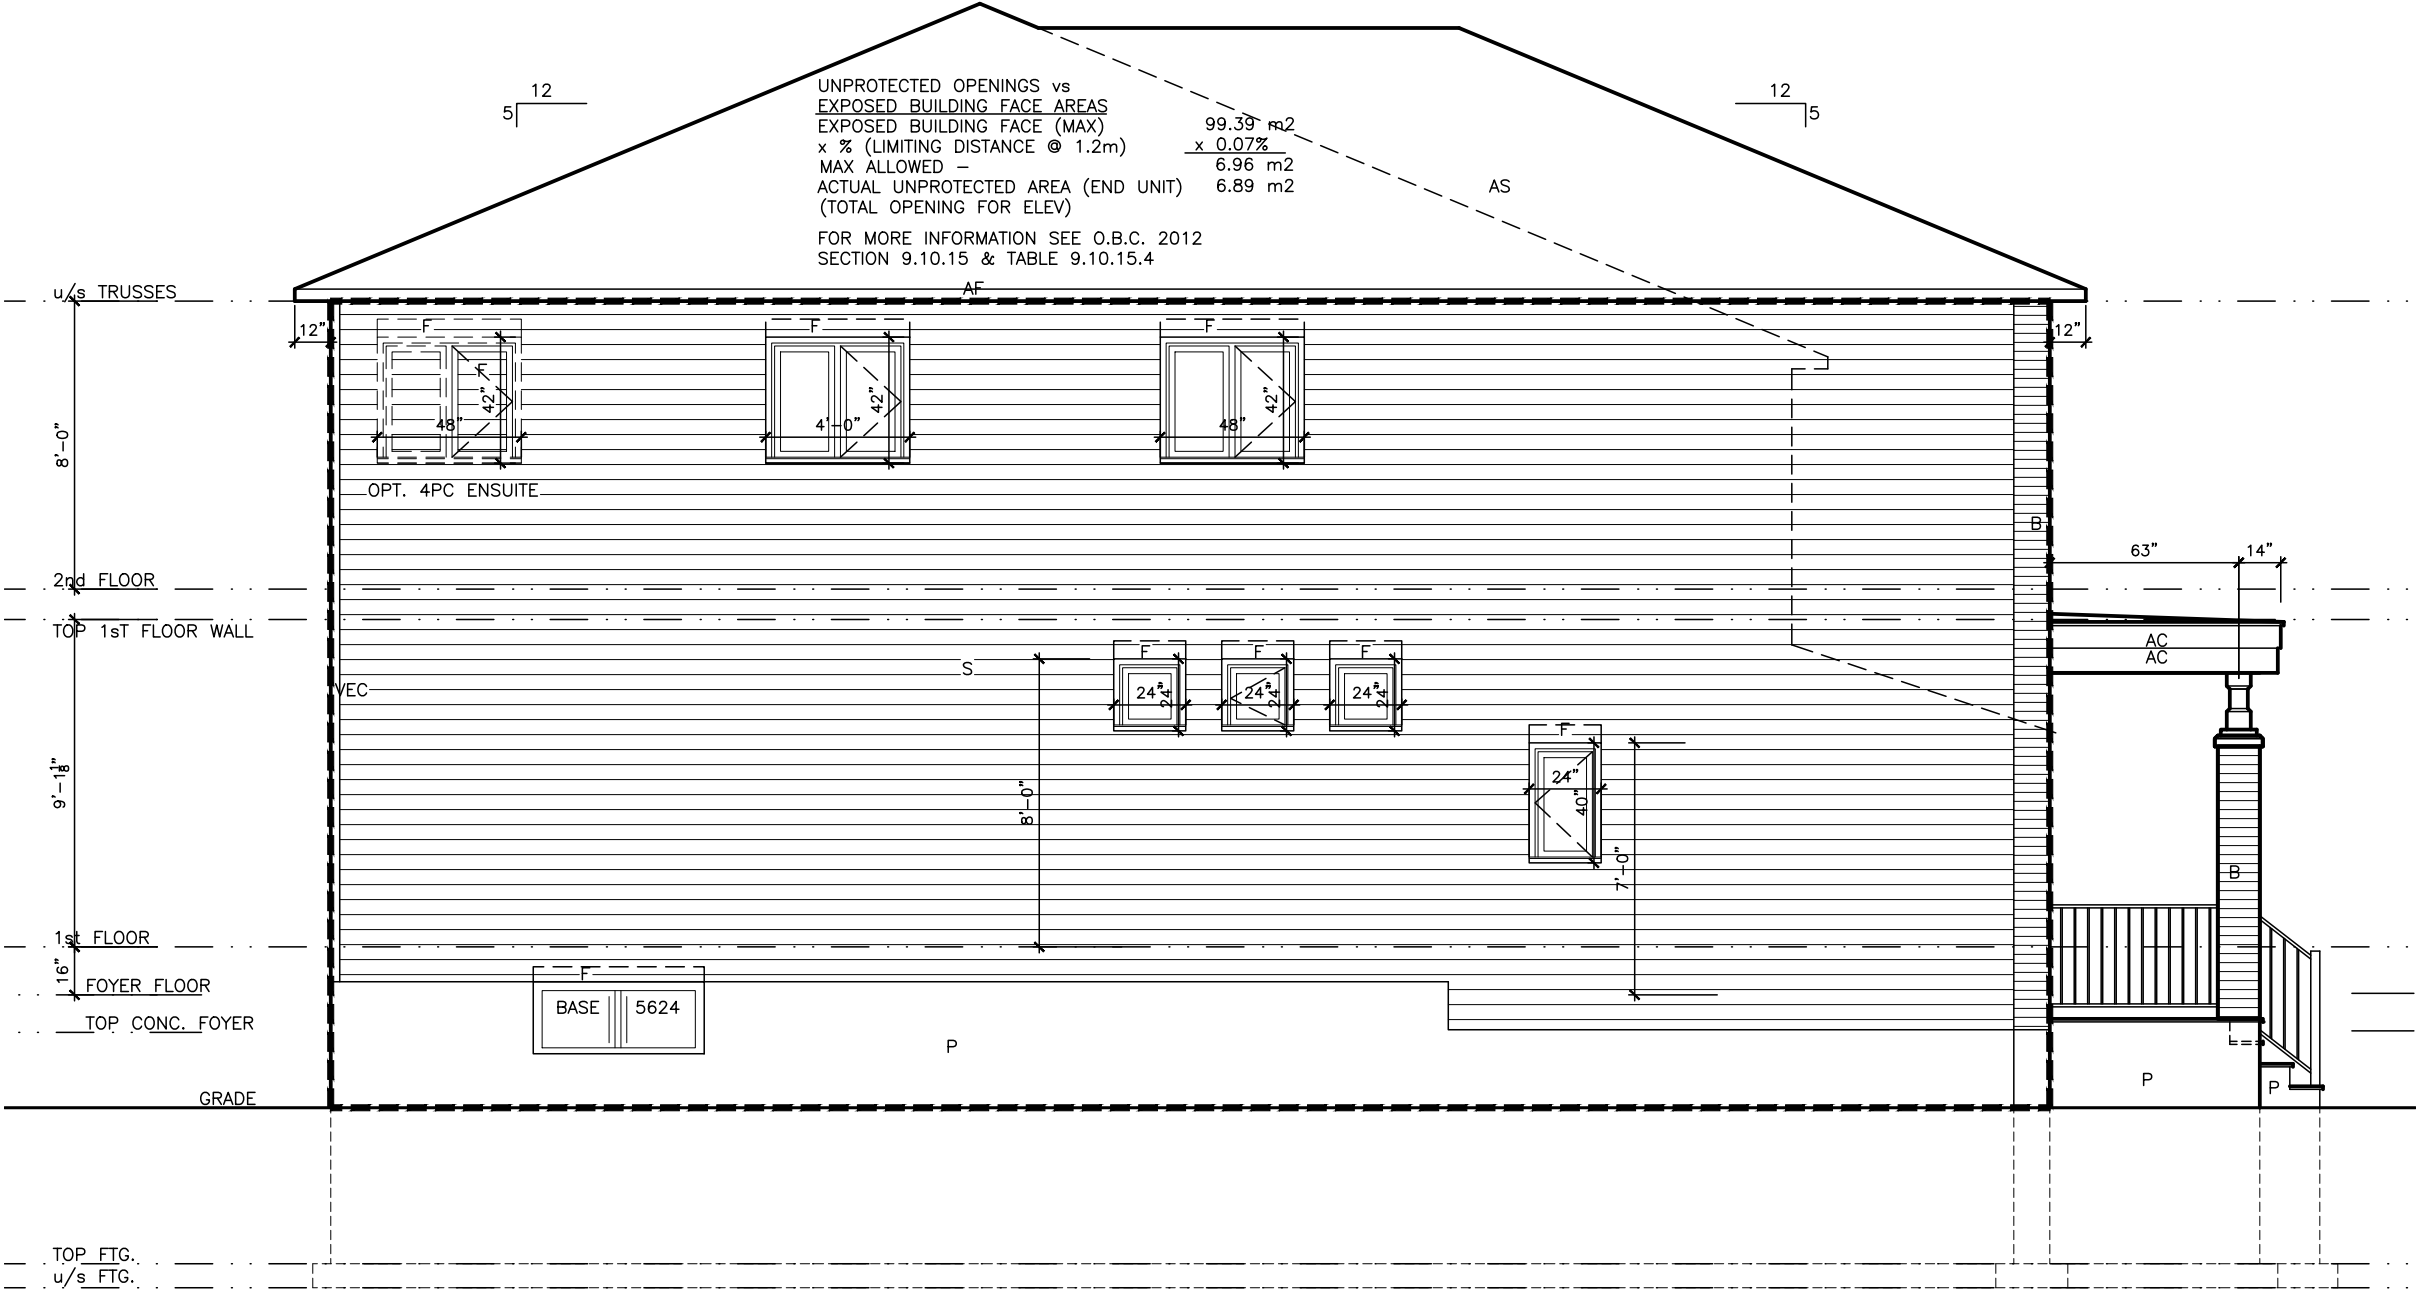

1 Left Side Elevation B
A2b

2012 OBC DRAWINGS

2.	AS PER STRUCTURAL	09/09/16	
1.	STANDARD DRAWINGS	02/11/15	SI
NO.	DESCRIPTION	DATE	BY




TITLE: Left Side Elevation B

ACAD FILE: SCALE: 3/16" = 1'-0"

1050-The McCaslin
2012 Footprint
(STANDARD DRAWINGS)
A-2b

TYPICAL PORCH ROOF:
. MODIFIED BITUMEN ROOF MEMBRANE TO
EXTEND NOT LESS THAN 4" UP WALL, 4" DOWN
FRONT FACE.
.5/8" PT PLYWOOD SHIMMED TO INSURE A 2%
SLOPE TO FRONT EDGE on.
.PT FLOOR JOIST (SEE PLAN)
.1x3 STRAPPING @ 16" c/c
.SOFFIT
.ALL CUTS ON PT TO BE TREATED
.ALL PT CLAD WITH ALUMINUM TO BE WRAPPED
IN TYVEC.

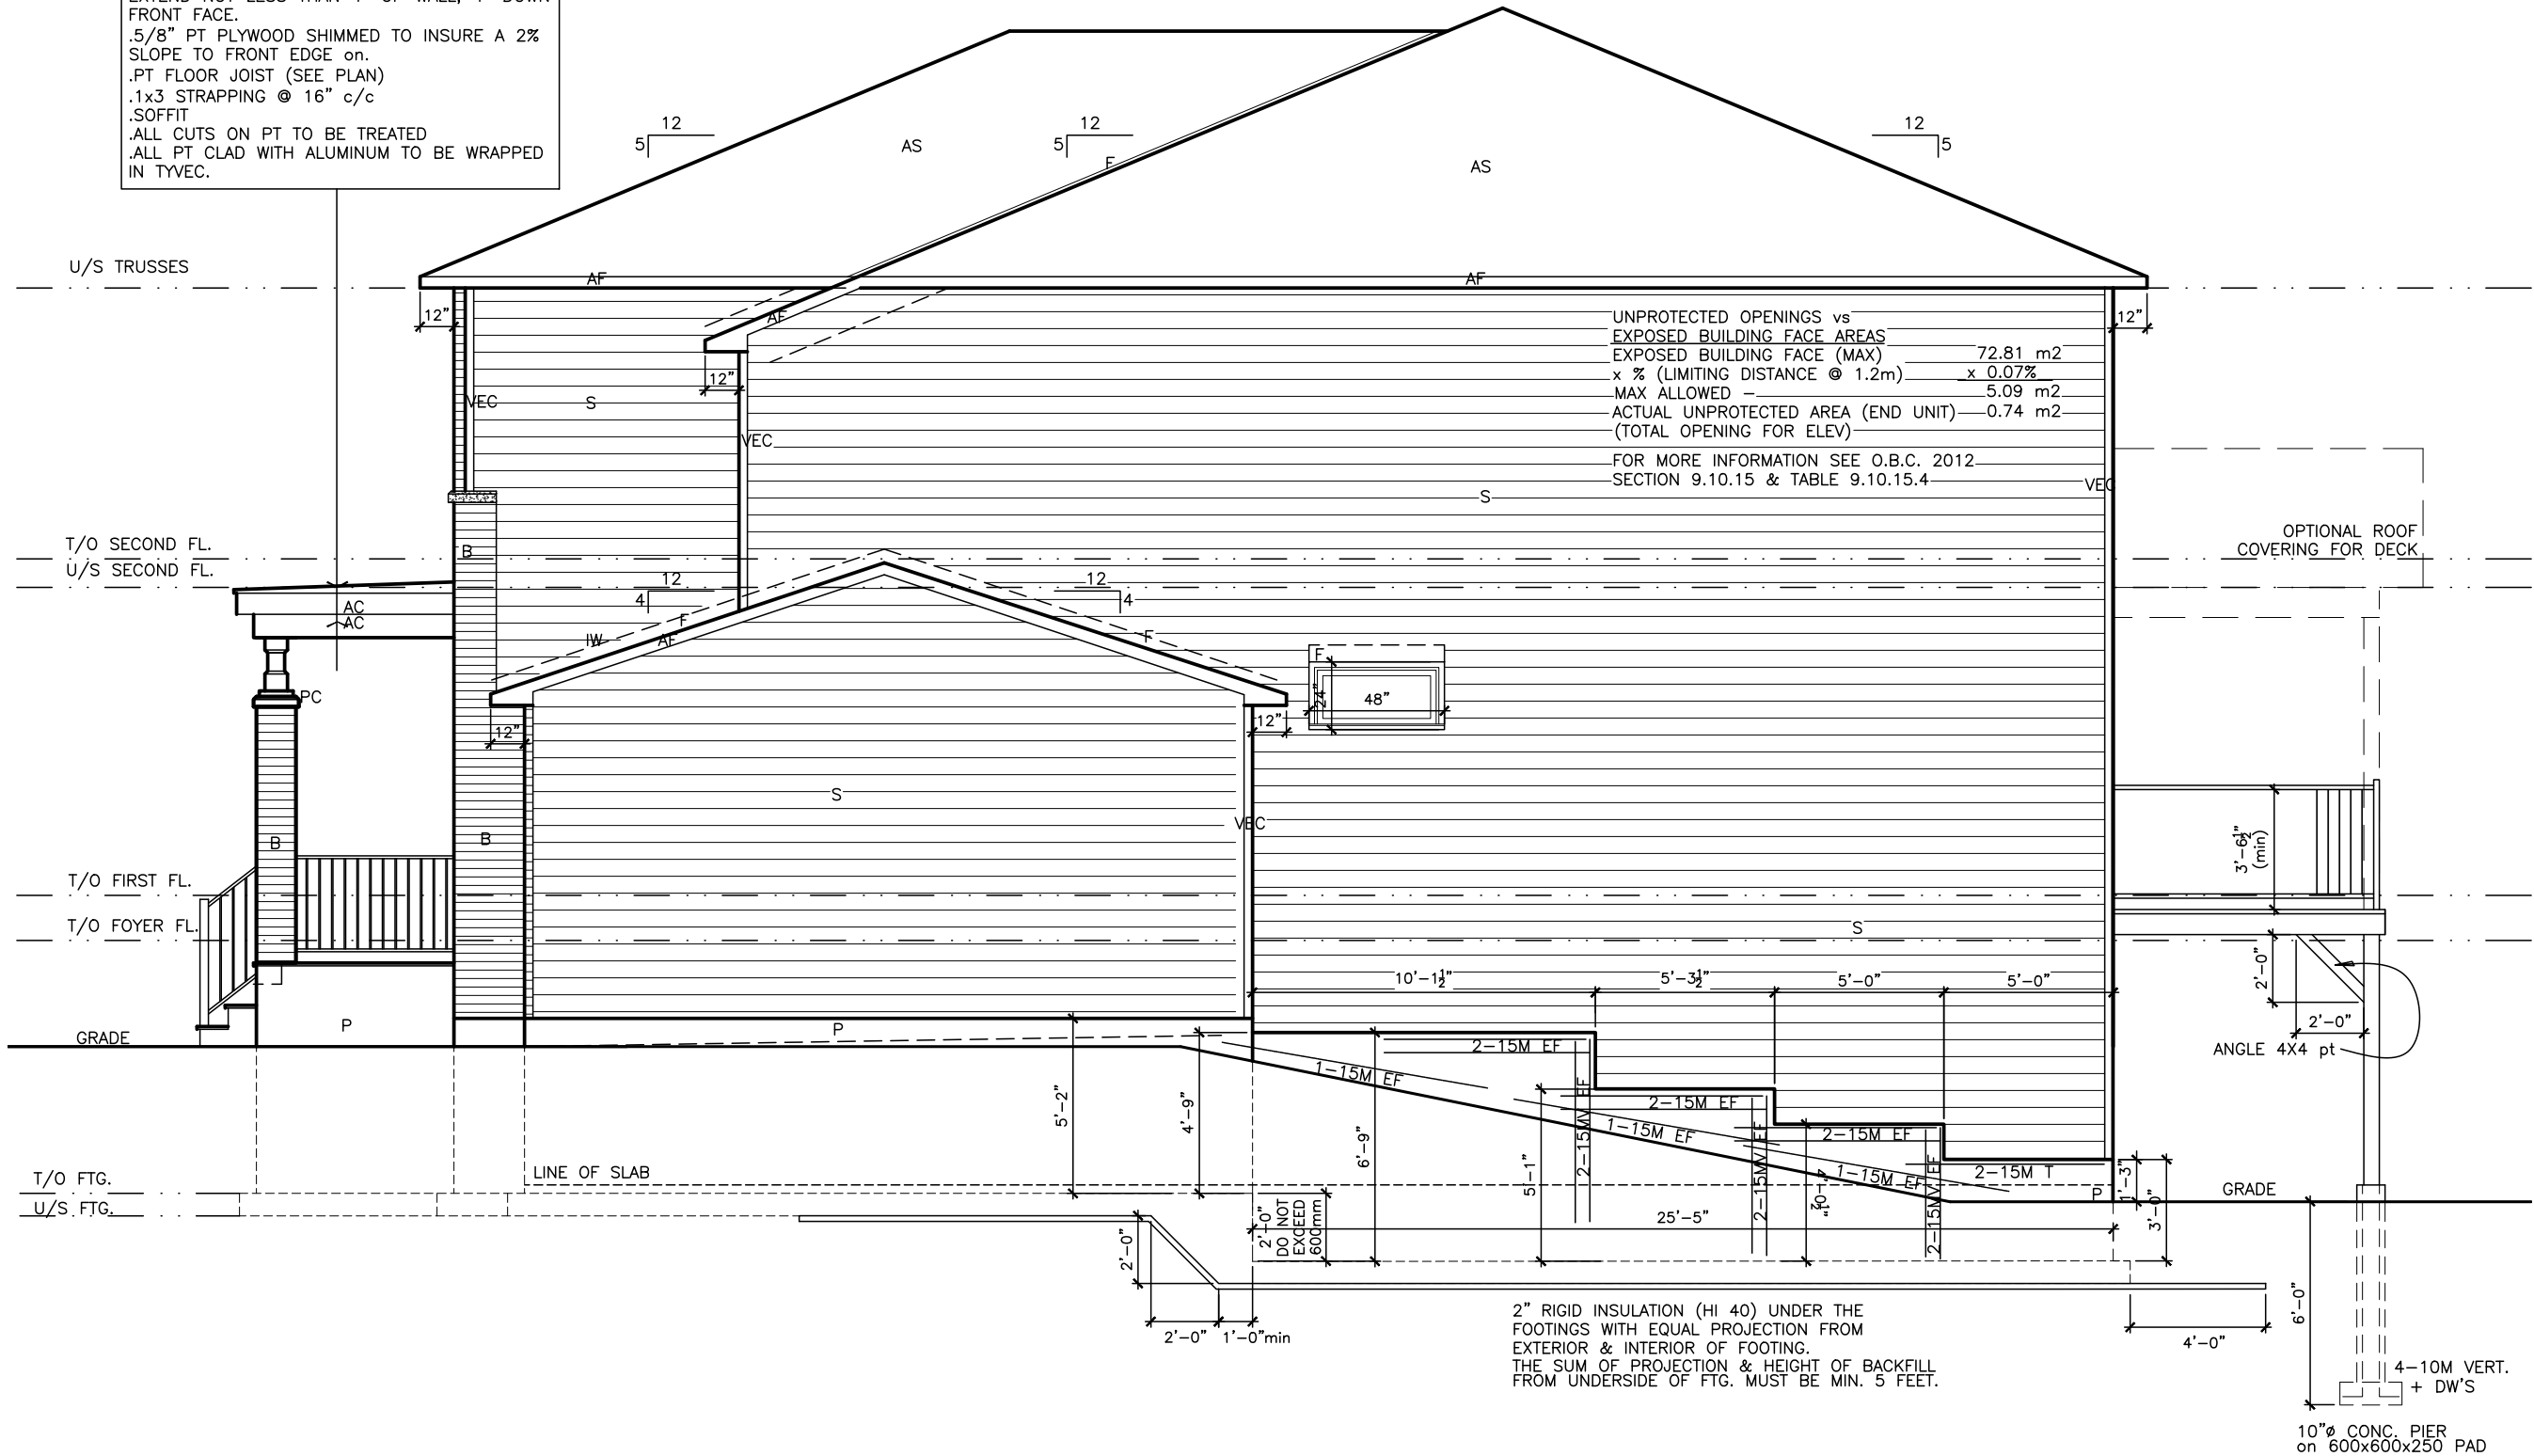

LOT _____ XXxx

DATE _____ XX/XX/XX

THIS DRAWINGS IS TO BE USED IN CONJUNCTION WITH
SCHEDULE B-1A AND MAY SHOW ONLY SOME OF THE CHANGES
DETAILED ON THAT DOCUMENT. SHOULD THE DRAWINGS NOT
SHOW ALL ITEMS CONTAINED ON A SCHEDULE OR MISS OTHER
ITEMS ALTOGETHER, THE SCHEDULE IS CONSIDERED THE
GOVERNING DOCUMENT.
FLOORS CONT. **TENDER 2017**

I **SCOTT IRWIN BCIN 20765** HAVE REVIEWED AND TAKE
RESPONSIBILITY FOR DESIGN ACTIVITIES RELATING TO,
HOUSE & SMALL BUILDINGS.

2012 OBC DRAWINGS

2.	AS PER STRUCTURAL	09/09/16	
1.	STANDARD DRAWINGS	02/11/15	SI
NO.	DESCRIPTION	DATE	BY




TITLE: Right Side Elevation B
Walk Out Basement

ACAD FILE: SCALE:
3/16" = 1'-0"

1050-The McCaslin
2012 Footprint
(STANDARD DRAWINGS) A-3e

TYPICAL PORCH ROOF:
. MODIFIED BITUMEN ROOF MEMBRANE TO
EXTEND NOT LESS THAN 4" UP WALL, 4" DOWN
FRONT FACE.
.5/8" PT PLYWOOD SHIMMED TO INSURE A 2%
SLOPE TO FRONT EDGE on.
.PT FLOOR JOIST (SEE PLAN)
.1x3 STRAPPING @ 16" c/c
.SOFFIT
.ALL CUTS ON PT TO BE TREATED
.ALL PT CLAD WITH ALUMINUM TO BE WRAPPED
IN TYVEC.

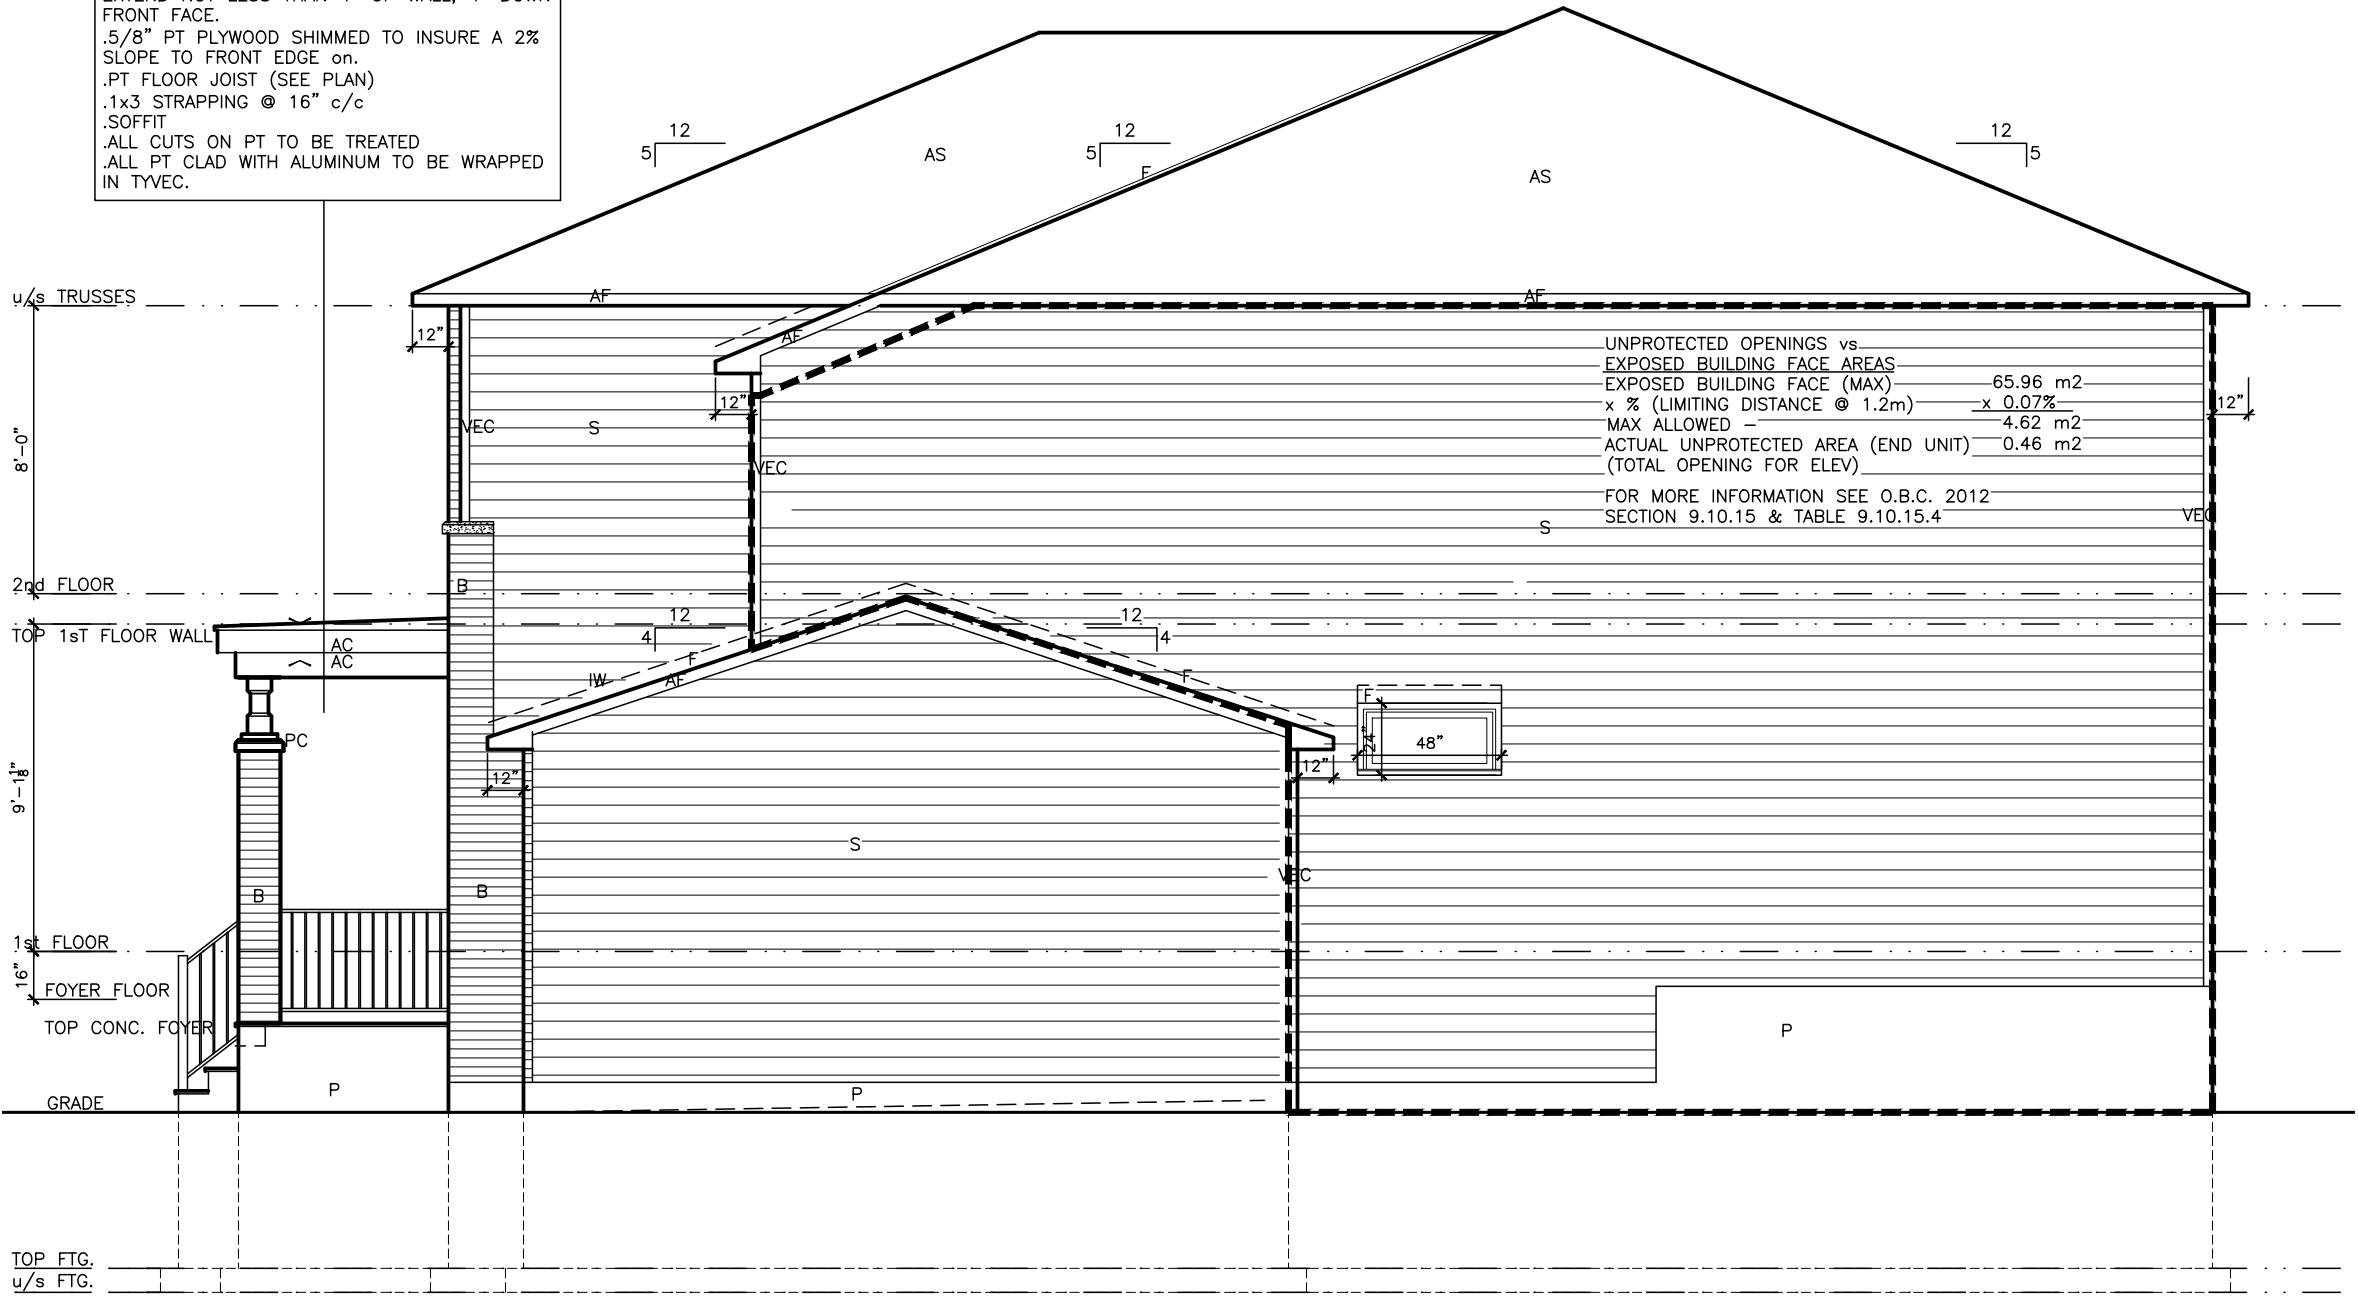

UNPROTECTED OPENINGS vs
EXPOSED BUILDING FACE AREAS
EXPOSED BUILDING FACE (MAX) 65.96 m2
x % (LIMITING DISTANCE @ 1.2m) x 0.07%
MAX ALLOWED - 4.62 m2
ACTUAL UNPROTECTED AREA (END UNIT) 0.46 m2
(TOTAL OPENING FOR ELEV)
FOR MORE INFORMATION SEE O.B.C. 2012
SECTION 9.10.15 & TABLE 9.10.15.4

LOT _____ XXxx

DATE _____ XX/XX/XX

THIS DRAWING IS TO BE USED IN CONJUNCTION WITH
SCHEDULE B-1A AND MAY SHOW ONLY SOME OF THE CHANGES
DETAILED ON THAT DOCUMENT. SHOULD THE DRAWINGS NOT
SHOW ALL ITEMS CONTAINED ON A SCHEDULE OR MISS OTHER
ITEMS ALTOGETHER, THE SCHEDULE IS CONSIDERED THE
GOVERNING DOCUMENT.
FLOORS CONT TENDER 2017

I SCOTT IRWIN BCIN 20765 HAVE REVIEWED AND TAKE
RESPONSIBILITY FOR DESIGN ACTIVITIES RELATING TO,
HOUSE & SMALL BUILDINGS.

2012 OBC DRAWINGS

2.	AS PER STRUCTURAL	09/09/16	
1.	STANDARD DRAWINGS	02/11/15	SI
NO.	DESCRIPTION	DATE	BY




TITLE: Right Side Elevation B

ACAD FILE: SCALE: 3/16" = 1'-0"

1050-The McCaslin
2012 Footprint
(STANDARD DRAWINGS) DWG. A-3b

1 Right Side Elevation B
A3b

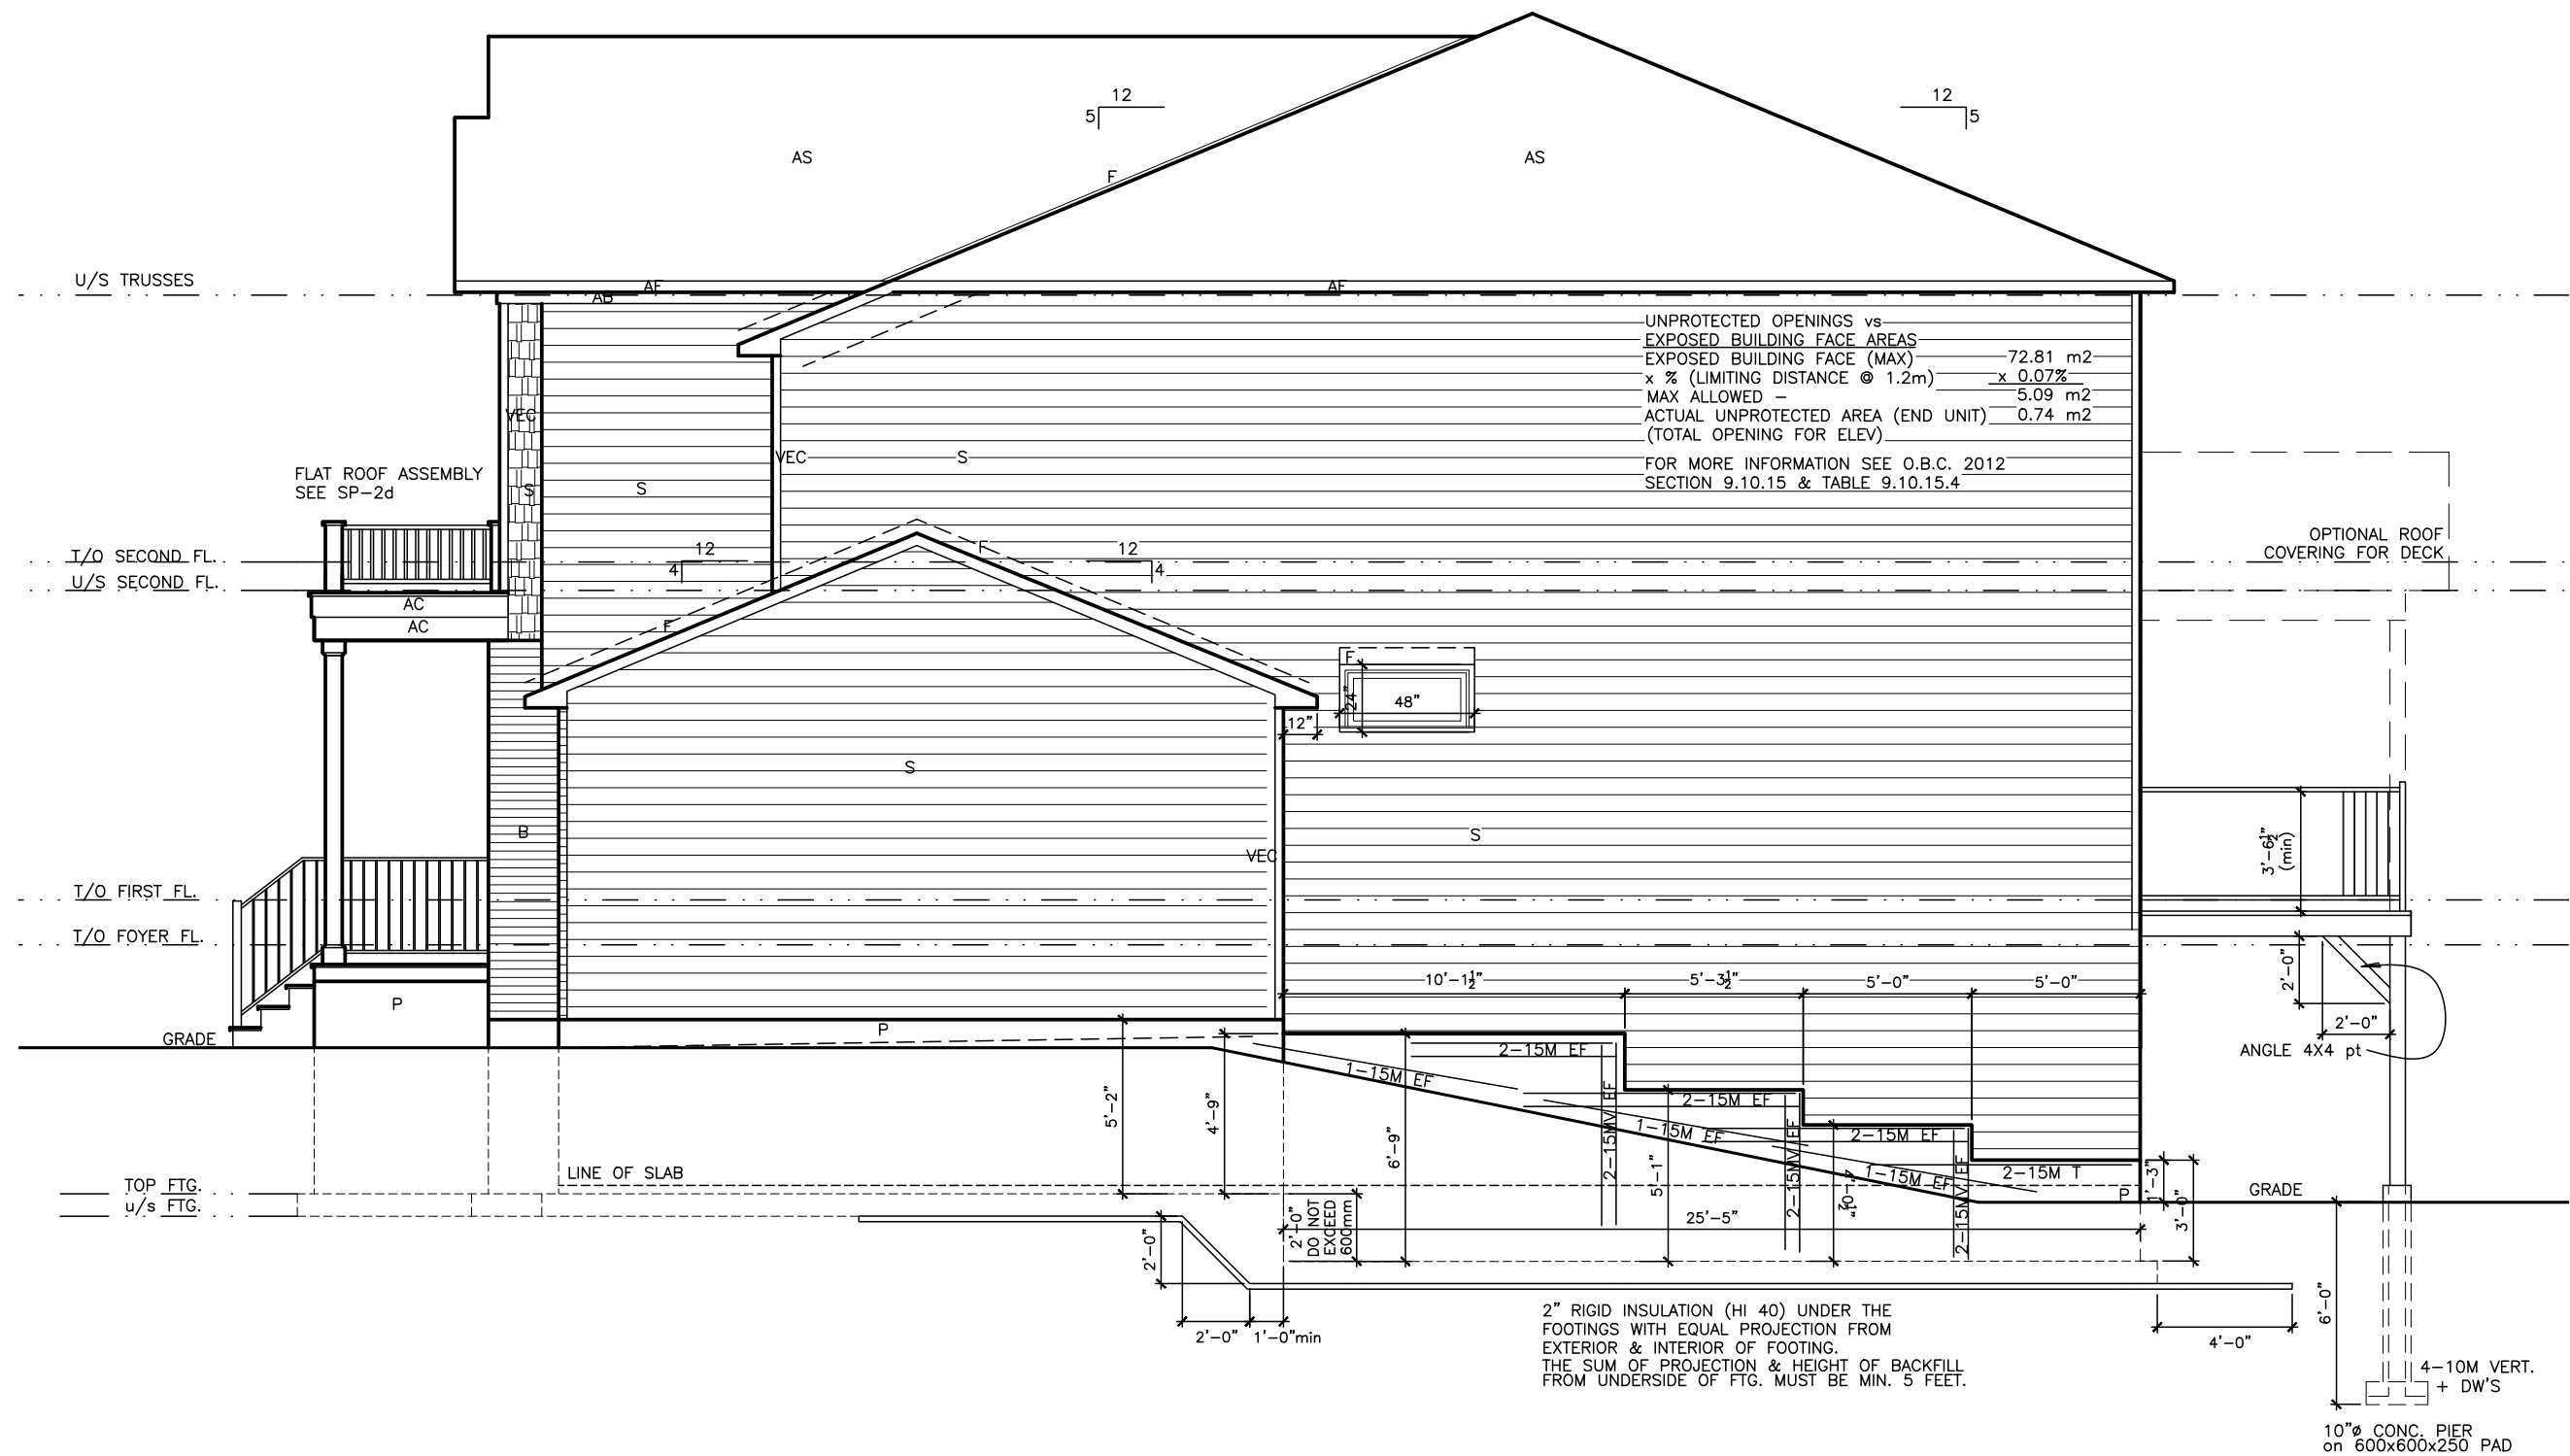

1 Right Side Elevation C - WOB
A3f

LOT XXxx
DATE XX/XX/XX
THIS DRAWING IS TO BE USED IN CONJUNCTION WITH SCHEDULE B-1A AND MAY SHOW ONLY SOME OF THE CHANGES DETAILED ON THAT DOCUMENT. SHOULD THE DRAWINGS NOT SHOW ALL ITEMS CONTAINED ON A SCHEDULE OR MISS OTHER ITEMS ALTOGETHER, THE SCHEDULE IS CONSIDERED THE GOVERNING DOCUMENT.
FLOORS CONT
TENDER 2017
I SCOTT IRWIN BCIN 20765 HAVE REVIEWED AND TAKE RESPONSIBILITY FOR DESIGN ACTIVITIES RELATING TO, HOUSE & SMALL BUILDINGS.

2012 OBC DRAWINGS		
2.	AS PER STRUCTURAL	09/09/16
1.	STANDARD DRAWINGS	02/11/15 SI
NO.	DESCRIPTION	DATE BY
		
TITLE: Right Side Elevation C Walk Out Basement		
ACAD FILE:		SCALE: 3/16" = 1'-0"
1050-The McCaslin 2012 Footprint (STANDARD DRAWINGS)		DWG. A-3f



1
A4b

Rear Elevation - WOB

LOT _____ XXxx

DATE _____ XX/XX/XX

THIS DRAWING IS TO BE USED IN CONJUNCTION WITH SCHEDULE B-1A AND MAY SHOW ONLY SOME OF THE CHANGES DETAILED ON THAT DOCUMENT. SHOULD THE DRAWINGS NOT SHOW ALL ITEMS CONTAINED ON A SCHEDULE OR MISS OTHER ITEMS ALTOGETHER, THE SCHEDULE IS CONSIDERED THE GOVERNING DOCUMENT.
FLOORS CONT

TENDER 2017

I SCOTT IRWIN BCIN 20765 HAVE REVIEWED AND TAKE RESPONSIBILITY FOR DESIGN ACTIVITIES RELATING TO, HOUSE & SMALL BUILDINGS.

2012 OBC DRAWINGS

NO	DESCRIPTION	DATE	BY
2.	AS PER STRUCTURAL	09/09/16	
1.	STANDARD DRAWINGS	02/11/15	SI



TITLE: Rear Elevation
Walk Out Basement

ACAD FILE: SCALE: 3/16" = 1'-0"


1050-The McCaslin
2012 Footprint
(STANDARD DRAWINGS)

DWG. A-4b

DATE XX/XX/XX

THIS DRAWING IS TO BE USED IN CONJUNCTION WITH SCHEDULE B-1A AND MAY SHOW ONLY SOME OF THE CHANGES DETAILED ON THAT DOCUMENT. SHOULD THE DRAWINGS NOT SHOW ALL ITEMS CONTAINED ON A SCHEDULE OR MISS OTHER ITEMS ALTOGETHER, THE SCHEDULE IS CONSIDERED THE GOVERNING DOCUMENT.

I SCOTT IRWIN BCIN 20765 HAVE REVIEWED AND TAKE
RESPONSIBILITY FOR DESIGN ACTIVITIES RELATING TO,
HOUSE & SMALL BUILDINGS _____.

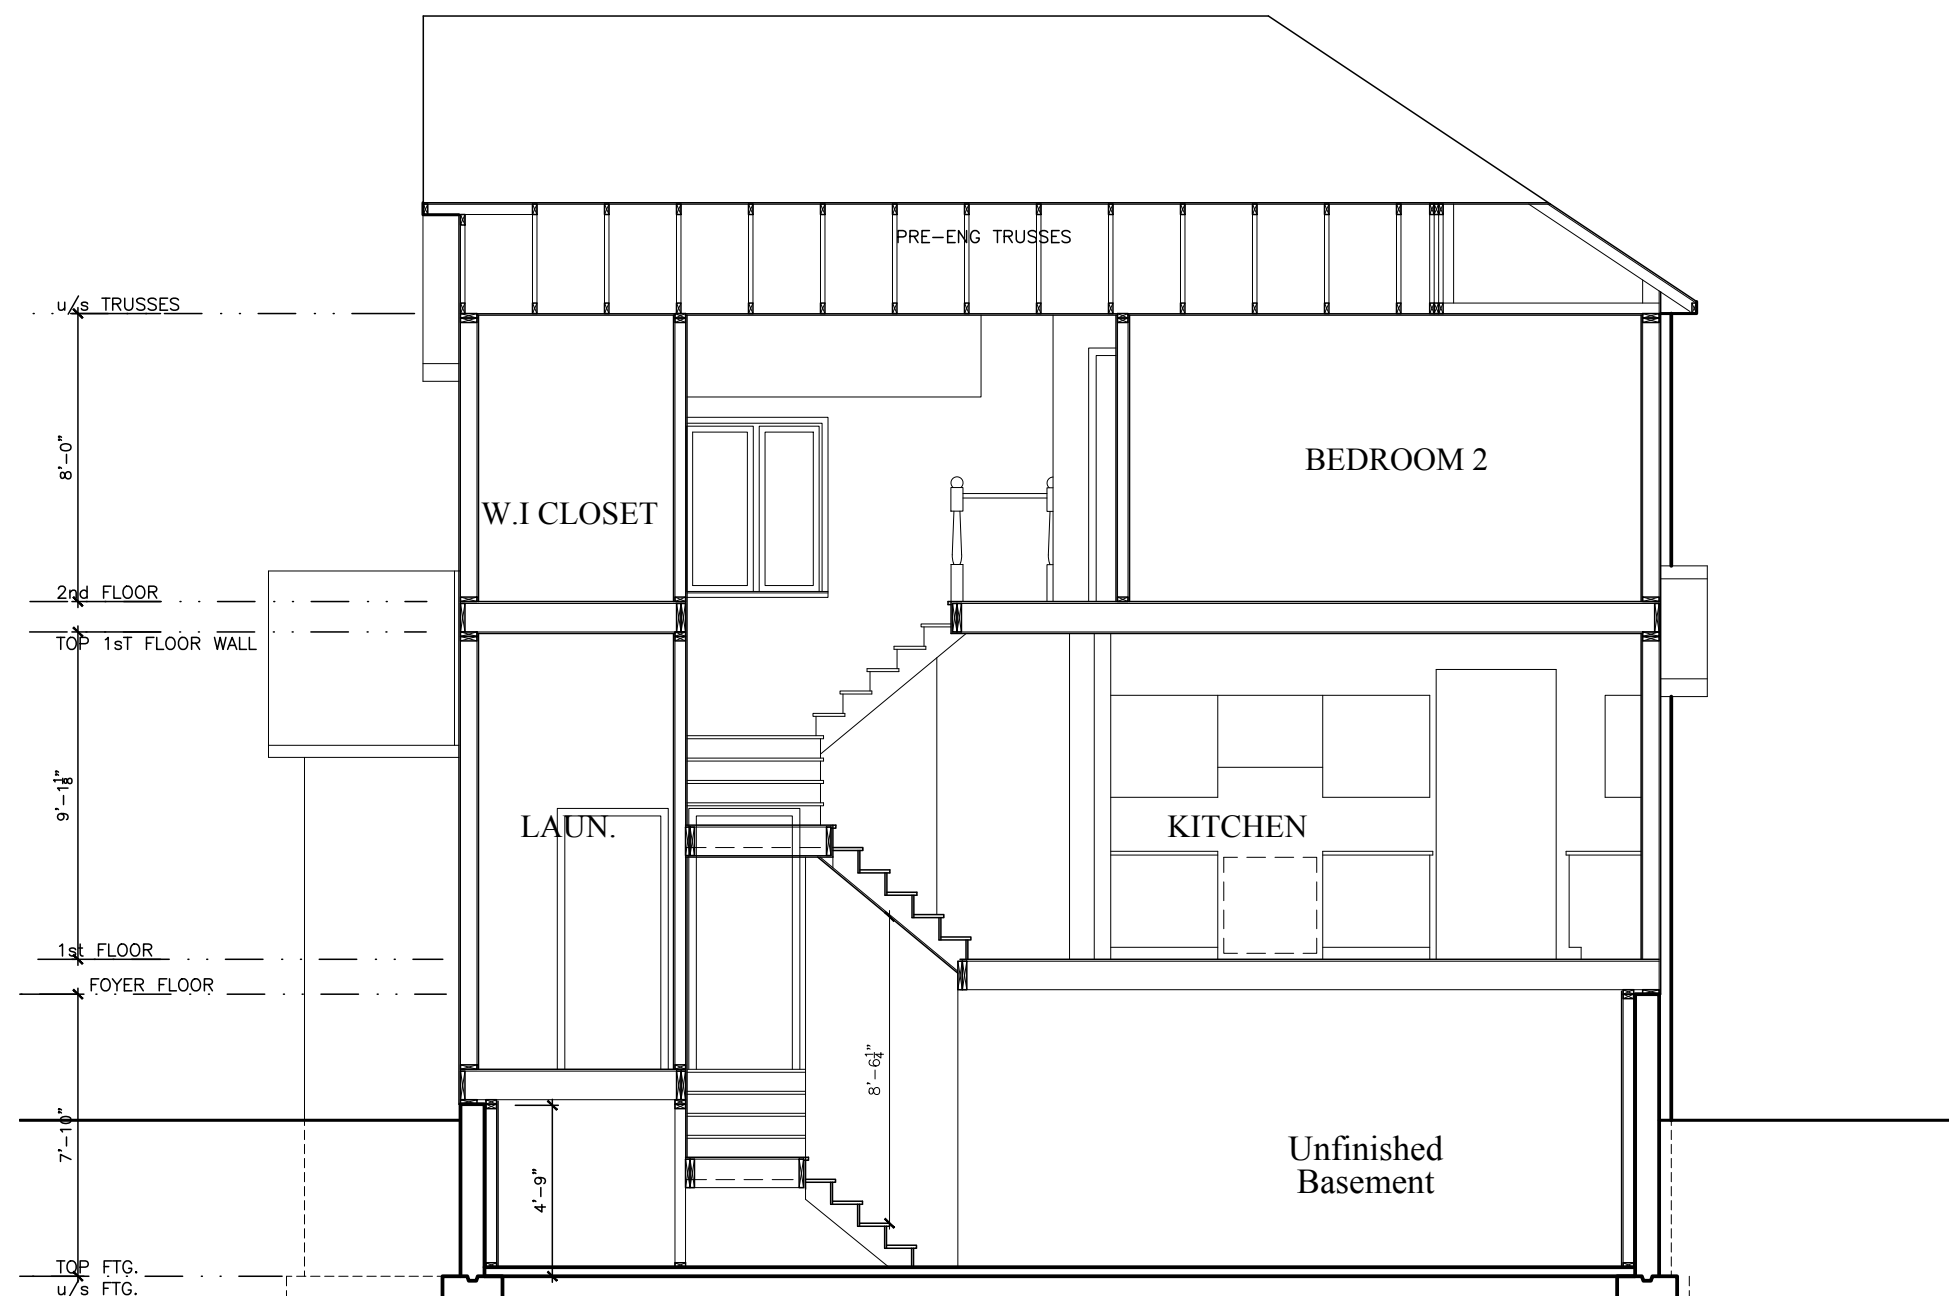

2012 OBC DRAWINGS


2.	AS PER STRUCTURAL	09/09/16	
1.	STANDARD DRAWINGS	02/11/15	SI
NO	DESCRIPTION	DATE	BY



TITLE: Section B-B

ACAD FILE:	SCALE: 3/16" = 1'-0"
------------	-------------------------

1050-The McCaslin 2012 Footprint (STANDARD DRAWINGS)	DWG. A-5b
--	------------------

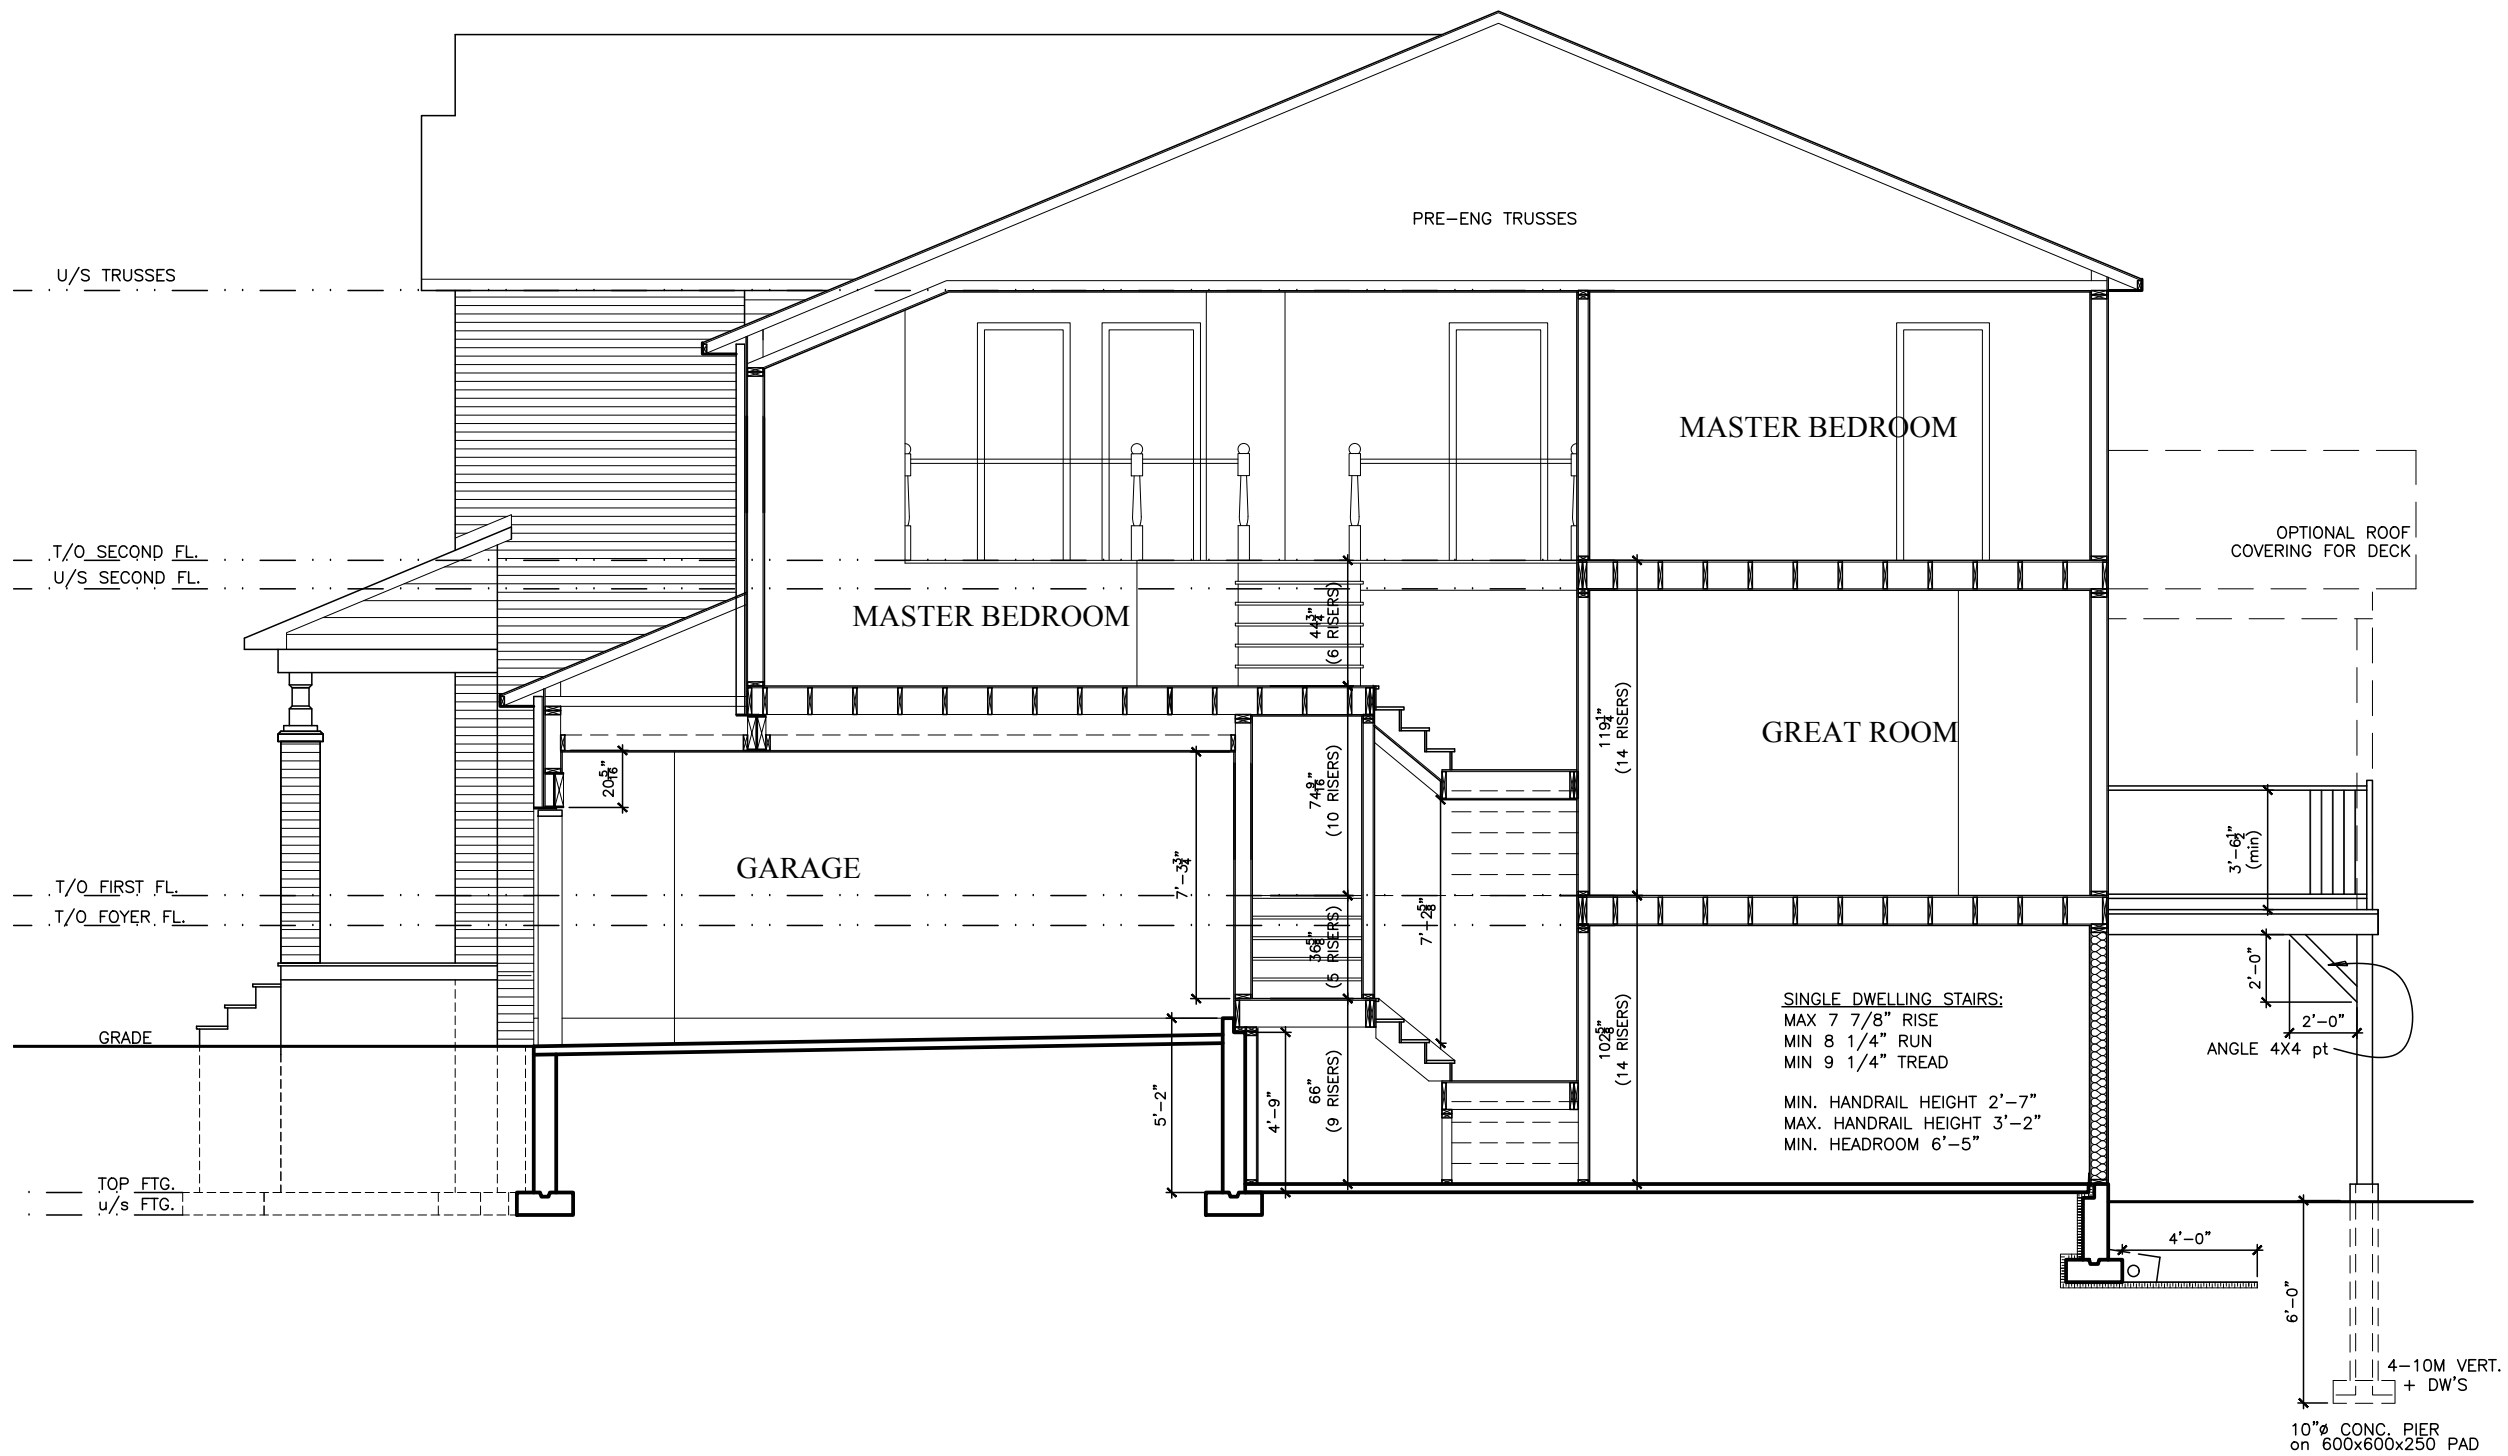

Section WOB

LOT XXxx

DATE XX/XX/XX

THIS DRAWINGS IS TO BE USED IN CONJUNCTION WITH SCHEDULE B-1A AND MAY SHOW ONLY SOME OF THE CHANGES DETAILED ON THAT DOCUMENT. SHOULD THE DRAWINGS NOT SHOW ALL ITEMS CONTAINED ON A SCHEDULE OR MISS OTHER ITEMS ALTOGETHER, THE SCHEDULE IS CONSIDERED THE GOVERNING DOCUMENT.

FLOORS CONT

TENDER 2017

I SCOTT IRWIN BCIN 20765 HAVE REVIEWED AND TAKE RESPONSIBILITY FOR DESIGN ACTIVITIES RELATING TO, HOUSE & SMALL BUILDINGS.

2012 OBC DRAWINGS

2.	AS PER STRUCTURAL	09/09/16	
1.	STANDARD DRAWINGS	02/11/15	SI
NO	DESCRIPTION	DATE	BY

Valecraft
Homes Ltd.

TITLE:
Section WOB

ACAD FILE:

SCALE:
3/16" = 1'-0"

1050-The McCaslin
2012 Footprint
(STANDARD DRAWINGS)

DWG.
A-5f

LOT _____ XXxx

DATE _____ XX/XX/XX

THIS DRAWING IS TO BE USED IN CONJUNCTION WITH SCHEDULE B-1A AND MAY SHOW ONLY SOME OF THE CHANGES DETAILED ON THAT DOCUMENT. SHOULD THE DRAWINGS NOT SHOW ALL ITEMS CONTAINED ON A SCHEDULE OR MISS OTHER ITEMS ALTOGETHER, THE SCHEDULE IS CONSIDERED THE GOVERNING DOCUMENT.
FLOORS CONT

TENDER 2017

I SCOTT IRWIN BCIN 20765 HAVE REVIEWED AND TAKE RESPONSIBILITY FOR DESIGN ACTIVITIES RELATING TO, HOUSE & SMALL BUILDINGS.



2012 OBC DRAWINGS


1. STANDARD DRAWINGS	09/15/17	SI
NO. DESCRIPTION	DATE	BY




TITLE: Section Through Garage

ACAD FILE:	SCALE: 3/16" = 1'-0"
------------	----------------------

1050-The McCaslin 2012 Footprint (STANDARD DRAWINGS)	DWG. A-5d
--	-----------

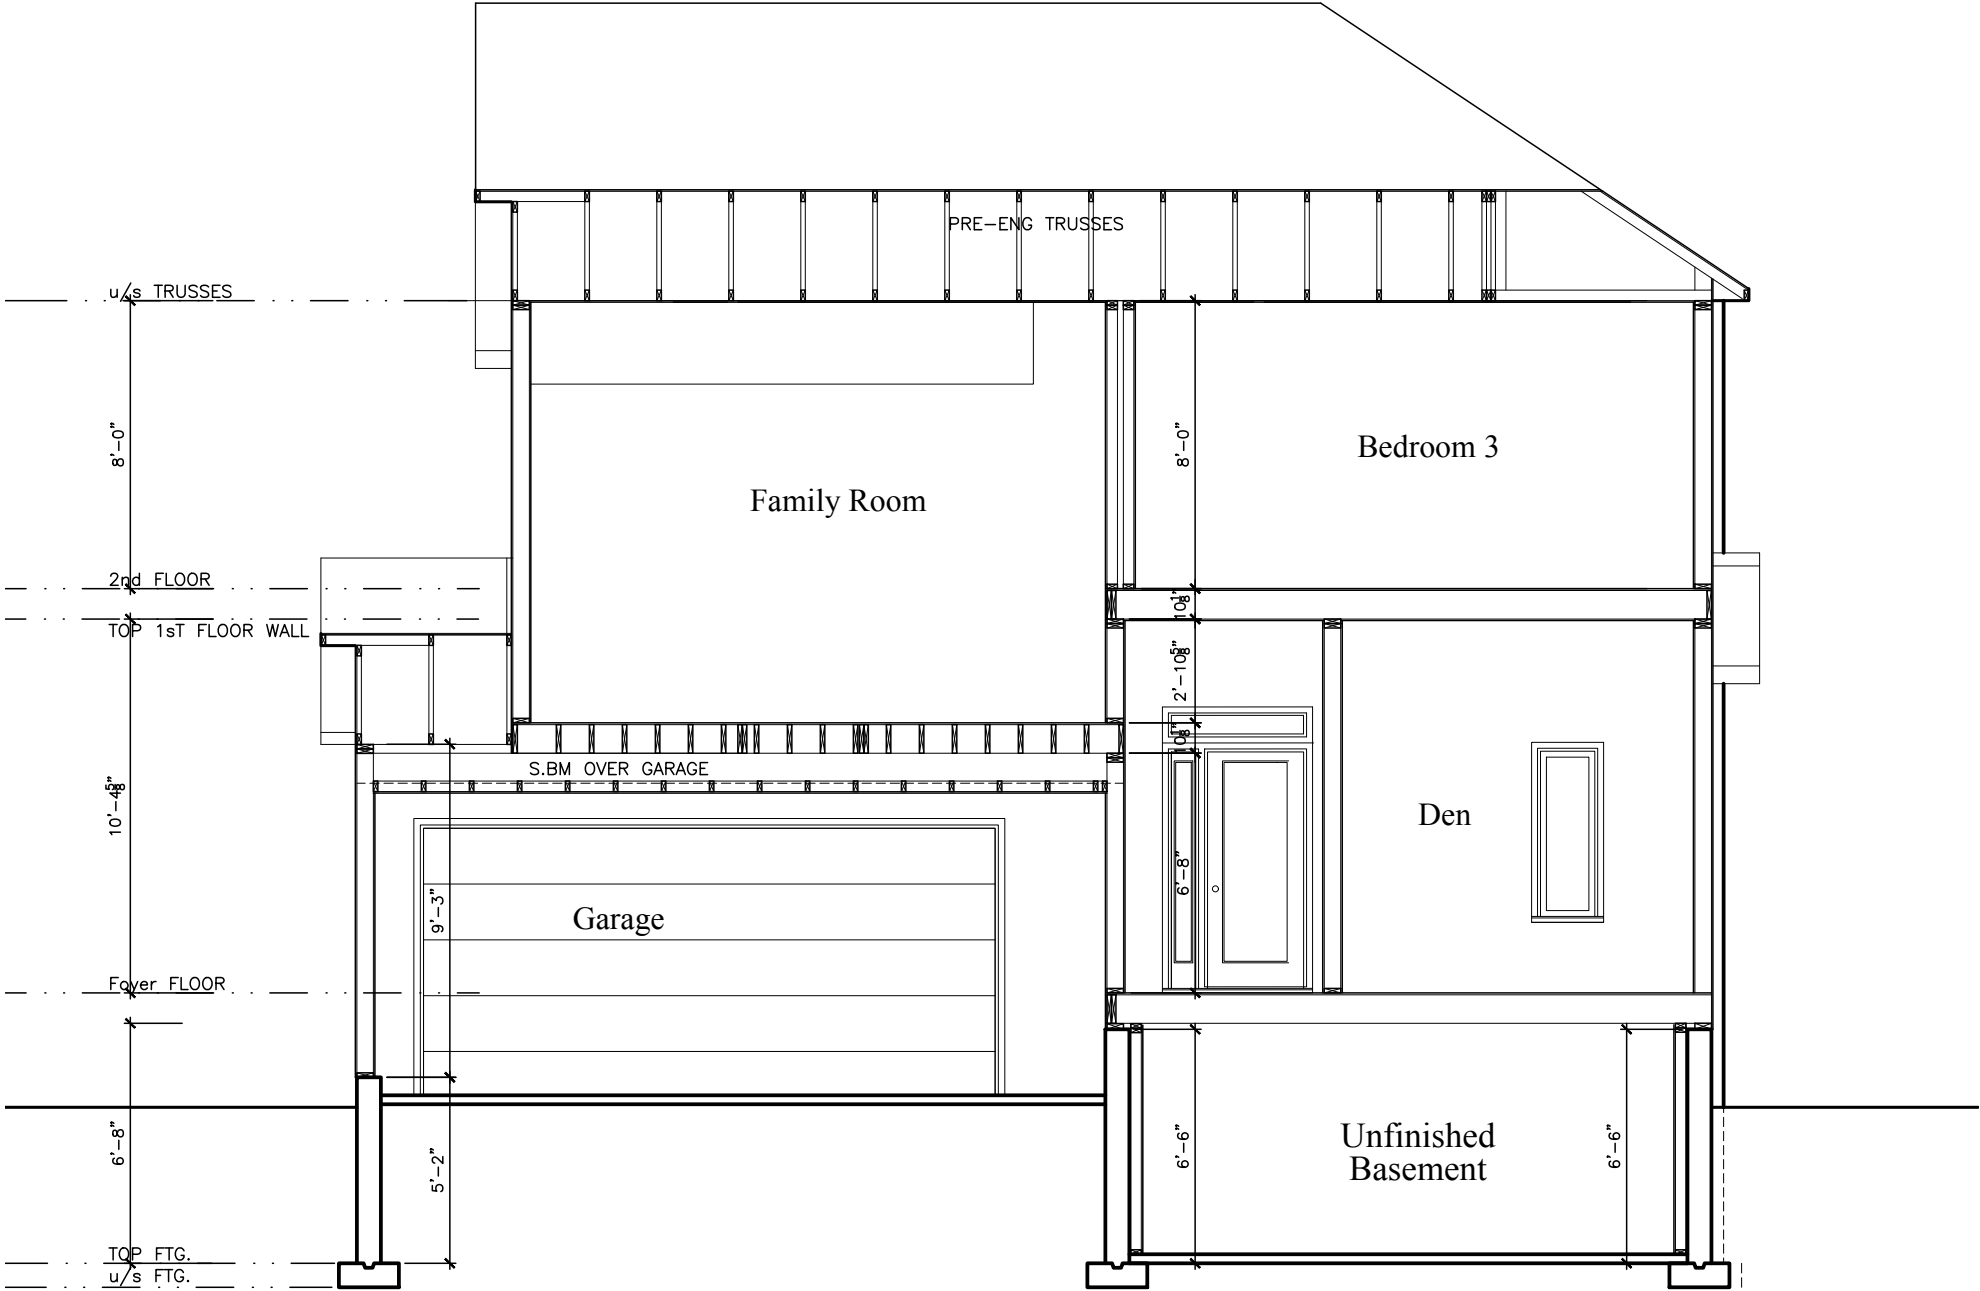

Section C-C

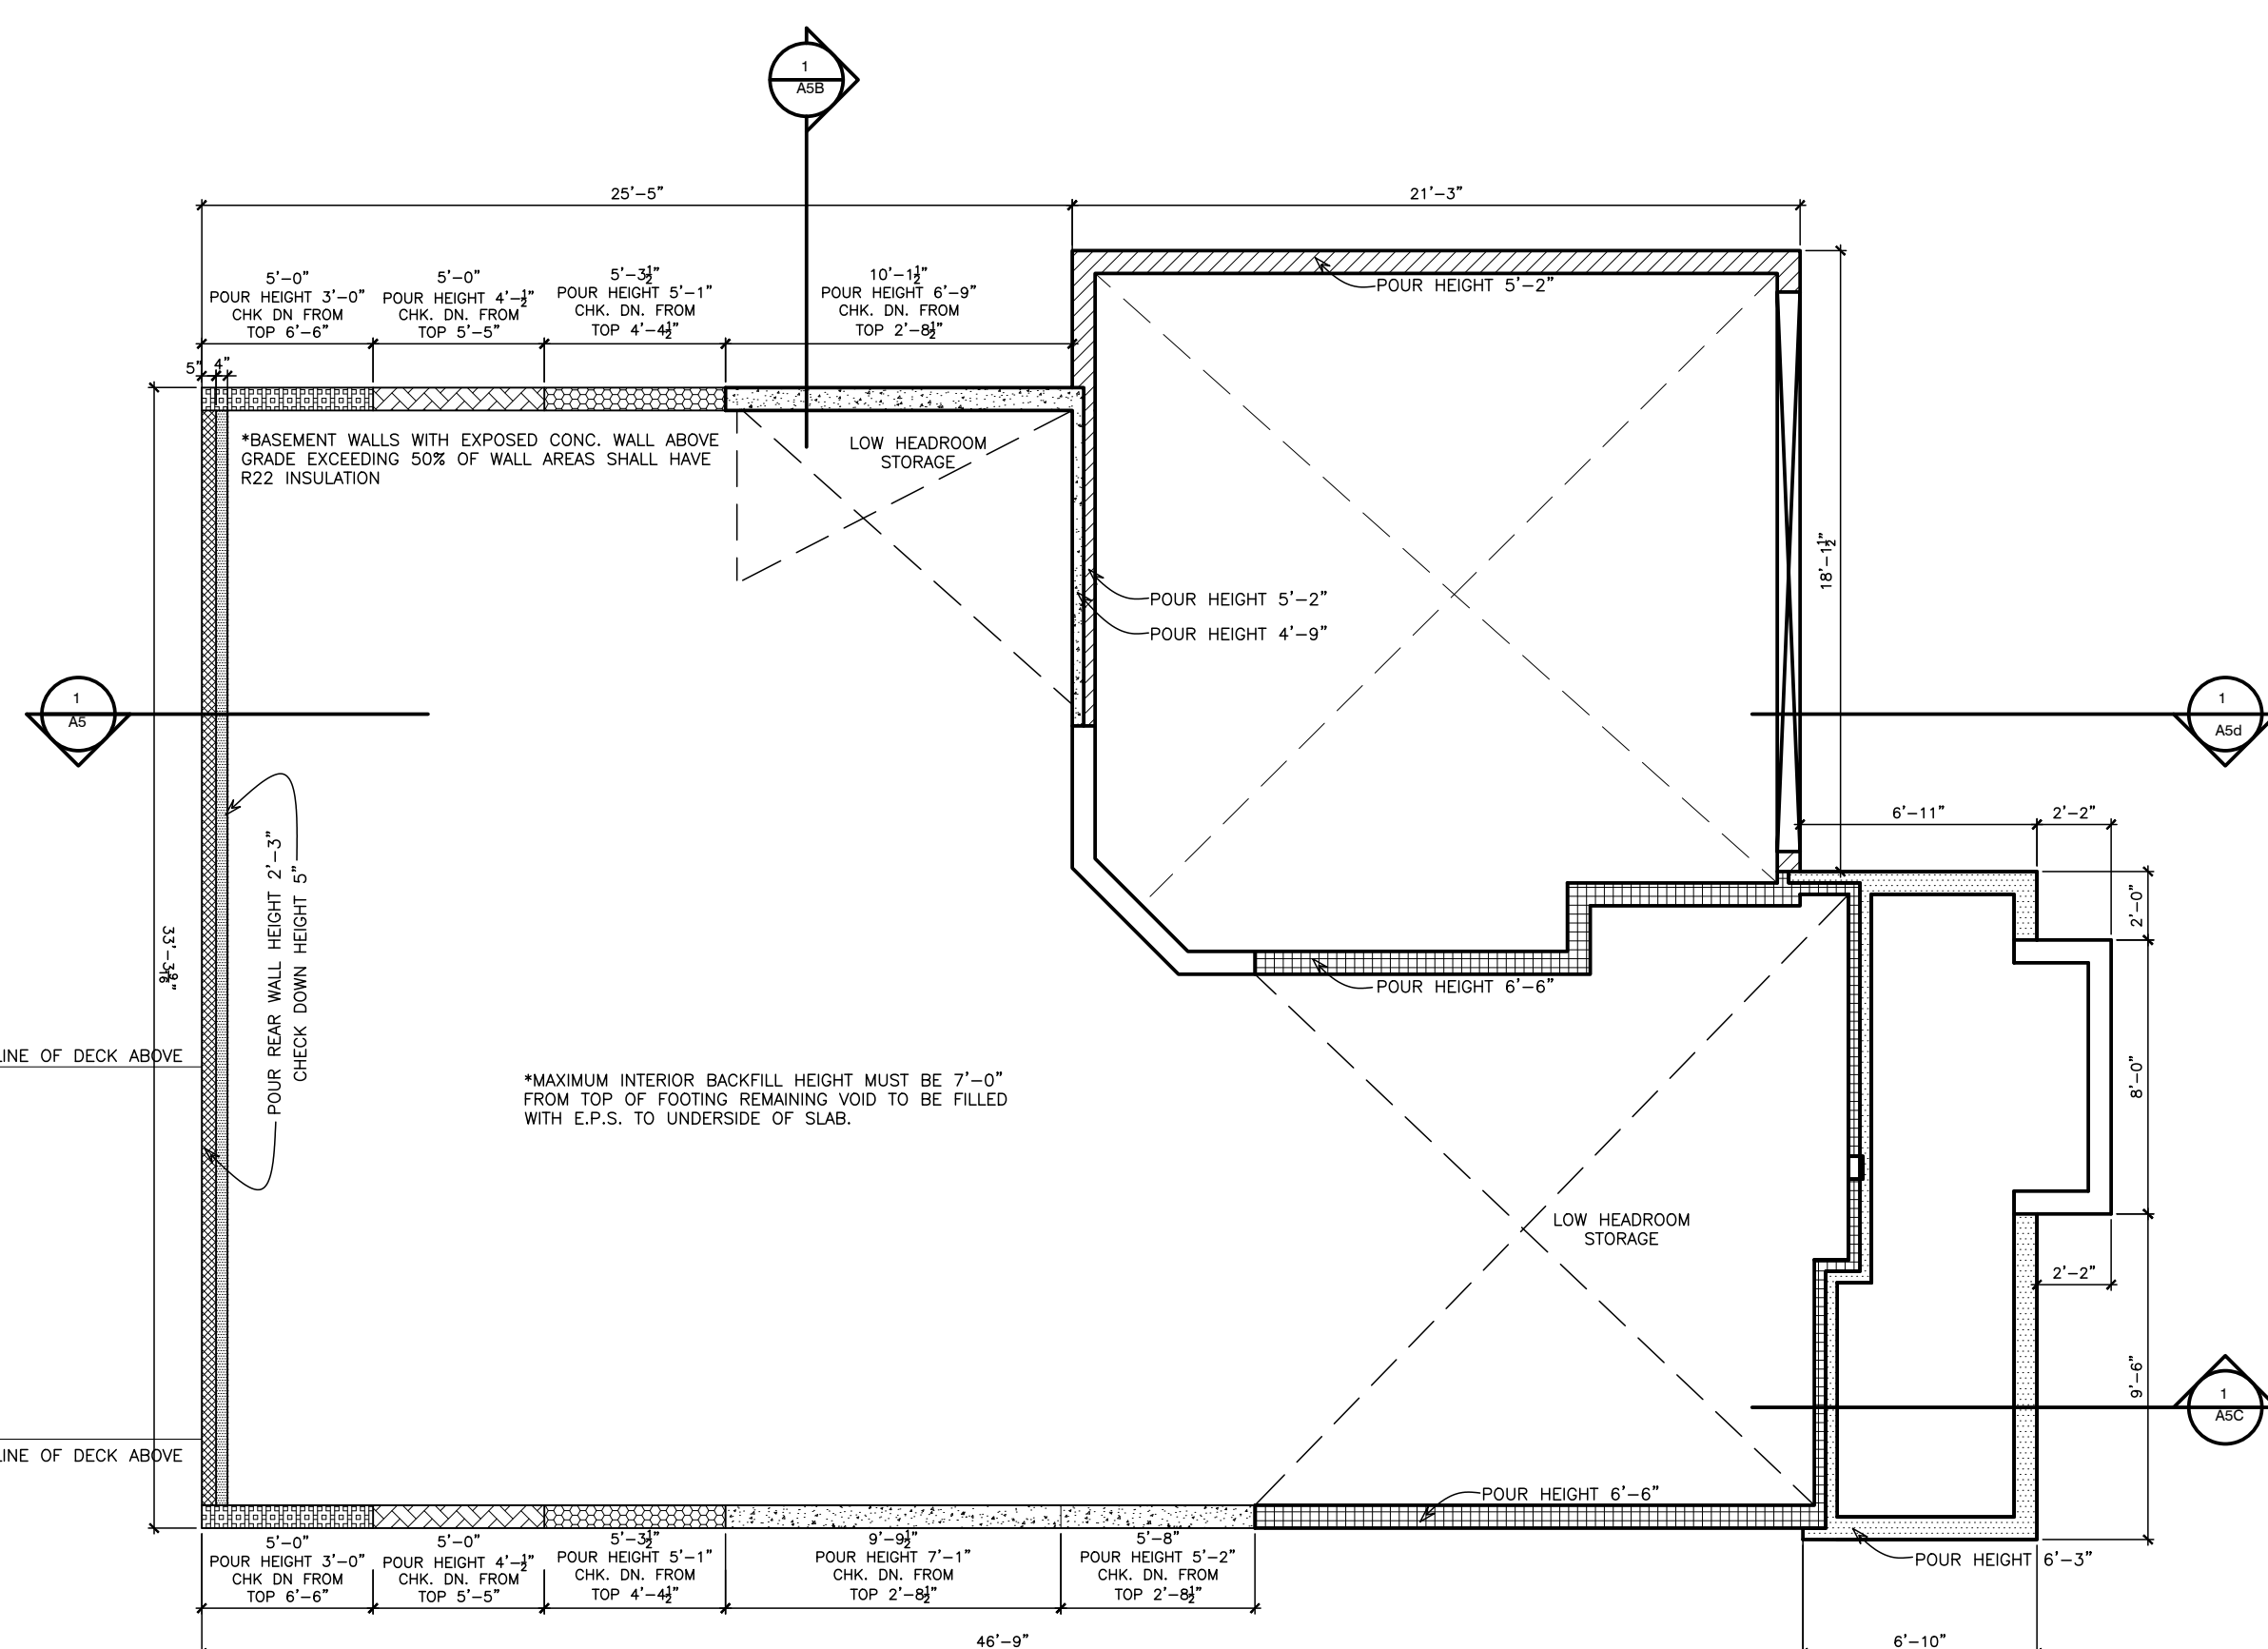

1 Foundation and Footing Plan

LOT **XXxx**

DATE **XX/XX/XX**

THIS DRAWINGS IS TO BE USED IN CONJUNCTION WITH SCHEDULE B-1A AND MAY SHOW ONLY SOME OF THE CHANGES DETAILED ON THAT DOCUMENT. SHOULD THE DRAWINGS NOT SHOW ALL ITEMS CONTAINED ON A SCHEDULE OR MISS OTHER ITEMS ALTOGETHER, THE SCHEDULE IS CONSIDERED THE GOVERNING DOCUMENT.

TENDER 2017

I **SCOTT IRWIN BCIN 20765** HAVE REVIEWED AND TAKE RESPONSIBILITY FOR DESIGN ACTIVITIES RELATING TO, HOUSE & SMALL BUILDINGS.

STRUCTURAL FRAMING SCHEDULE

STEEL LINTEL

S1 - L 90x90x6
S2 - L 90x90x8
S3 - L 100x90x8
S4 - L 125x90x8
S5 - L 125x90x10
S6 - L 200x100x12
S7 - L 150x100x10 (200mm BEARING)

WOOD LINTEL

L1 - (2)38x235 w/ 12.7 PLYWOOD SPACER
L2 - (2)38x235
L3 - (3)38x235
L4 - (3)38x235 w/ 2-12.7 PLYWOOD SPACER & 2 ROW OF 90mm SPIRAL @ 200 o/c
L5 - (3)38x286 w/ 2-12.7 PLYWOOD SPACER & 2 ROW OF 90mm SPIRAL @ 200 o/c
L6 - (2)45x240 L.L. 2.0e
L7 - (3)45x240 L.L. 2.0e

POSTS

P1 - 75# STEEL TELEPOST
P2 - (2)38x89 or (2)38x140
P3 - (3)38x89 or (3)38x140
P4 - (4)38x89 or (4)38x140
P5 - (5)38x89 or (5)38x140
P6 - (6)38x89 or (6)38x140
P13 - HSS 88.9x88.9x3.18 + 100x200x12 T&B PL.
P14 - HSS 89x89x4.8 + 100x200x12 T&B PL.
P15 - HSS 76.2x76.2x4.78 + 100x180x12 T&B PL.
P16 - HSS 76.2x76.2x4.78 + 130x130x12 T&B PL.
P17 - HSS 73 O.D. x4.8 + 100x180x12PL B PL.
(*) - 2-12# ANCH (WHERE ANCH PL. NOT USED)
ALL FOOTINGS 600x200 DP. UNLESS NOTED
SOIL: 100 KPA

F1-34"x34"x8" CONC. PAD
c/w 3-15M BARS EW
30"L

F2-24"x24"x8" CONC. PAD
c/w 2-15M BARS EW
20"L

R-5 ISS PANEL

OSB SHEATHING

3" CONC. SLAB
0.006" POLY VDR
6" CR. ST.

2"x6" PLATE PT c/w
1/2" # A.B.

T/O SLAB
T/O W/O FDN

PARGING

2" RIGID INSUL. MIN

2" HI LOAD INSULATION

SEE SP-2 FOR STANDARD FDN CONST.

4'-0"

2012 OBC DRAWINGS

2. AS PER STRUCTURAL	09/09/16	
1. STANDARD DRAWINGS	11/02/15	SI
NO DESCRIPTION	DATE	BY


Valecraft

Home Ltd.

TITLE: Foundation & Footing Plan
Walk Out Basement

ACAD FILE: 1050-The McCaslin
2012 Footprint
(STANDARD DRAWINGS)

SCALE: 3/16" = 1'-0"
DWG. A-6d

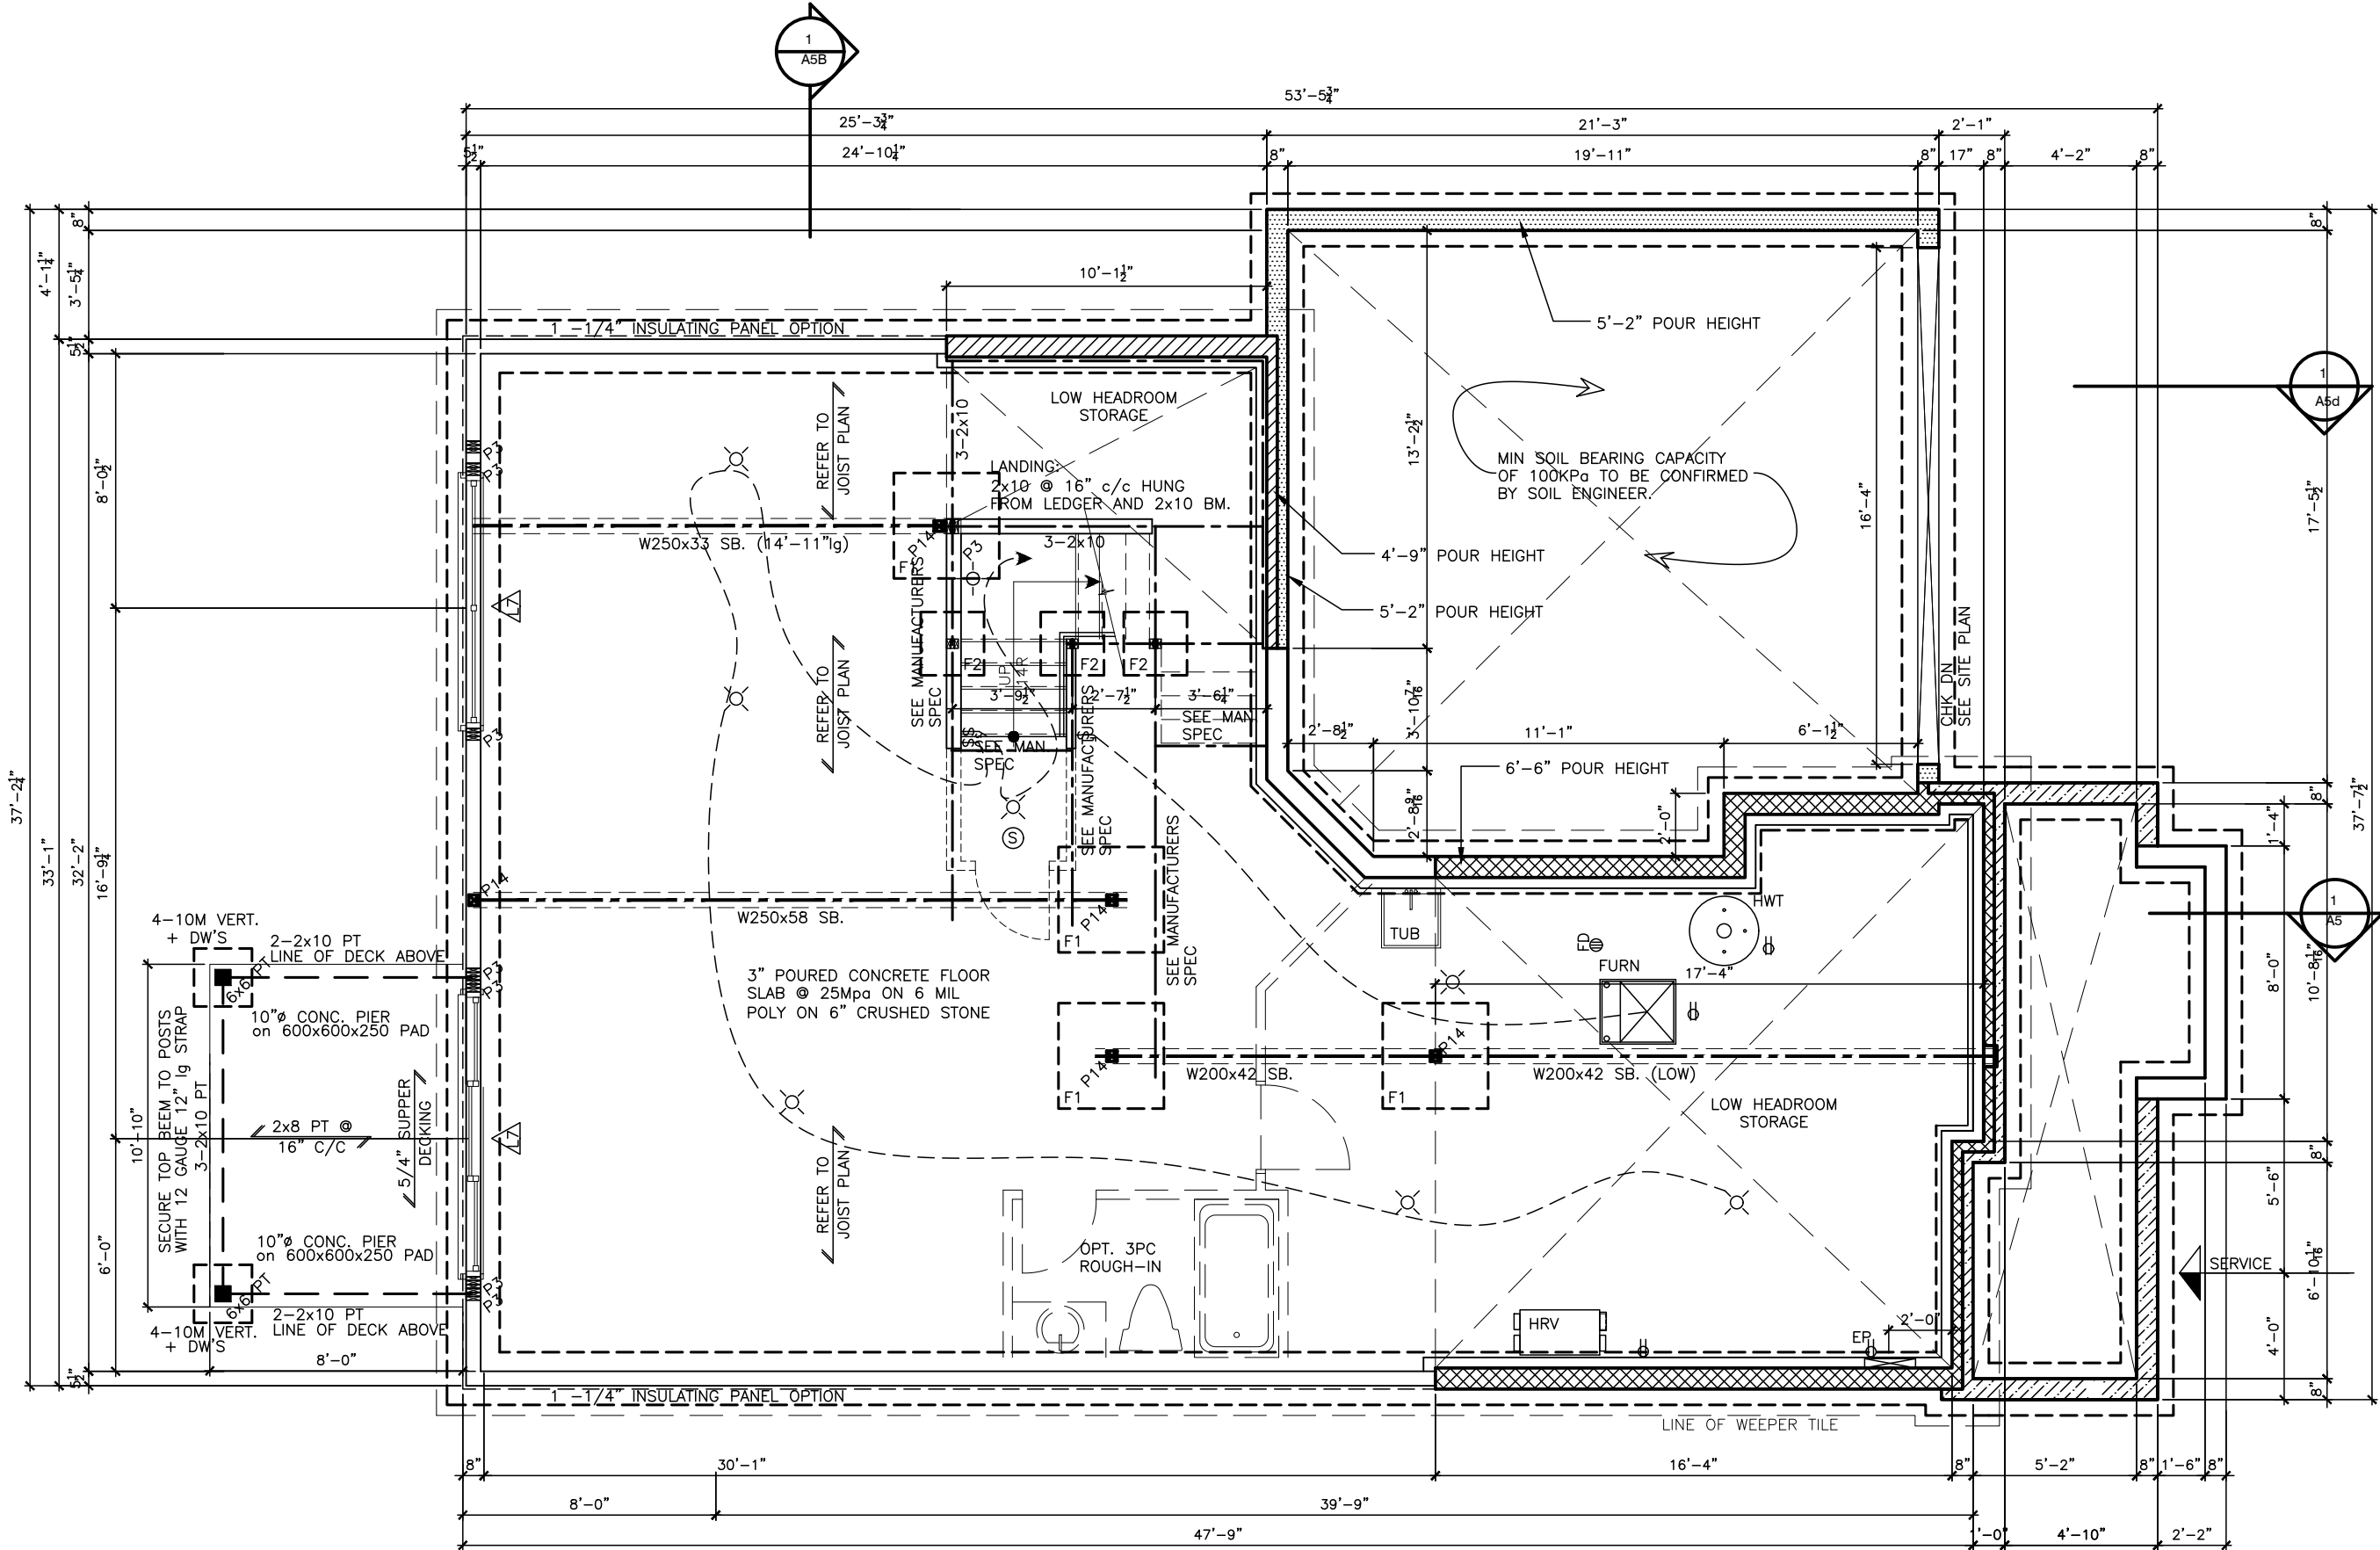

THIS DRAWING IS TO BE USED IN CONJUNCTION WITH SCHEDULE 5-1A AND MAY SHOW ONLY SOME OF THE CHANGES DETAILED ON THAT DOCUMENT. SHOULD THE DRAWINGS NOT SHOW ALL ITEMS CONTAINED ON A SCHEDULE OR MISS OTHER ITEMS ALTOGETHER, THE SCHEDULE IS CONSIDERED THE GOVERNING DOCUMENT.
FLOORS CONT

TENDER 2017

I SCOTT IRWIN BCIN 20765 HAVE REVIEWED AND TAKE RESPONSIBILITY FOR DESIGN ACTIVITIES RELATING TO, HOUSE & SMALL BUILDINGS.

STRUCTURAL FRAMING SCHEDULE

- STEEL LINTEL
S1 - L 90x90x6
S2 - L 90x90x8
S3 - L 100x90x8
S4 - L 125x90x8
S5 - L 125x90x10
S6 - L 200x100x12
S7 - L 150x100x10 (200mm BEARING)
- WOOD LINTEL
L1 - (2)38x235 w/ 12.7 PLYWOOD SPACER
L2 - (2)38x235
L3 - (3)38x235
L4 - (3)38x235 w/ 2-12.7 PLYWOOD SPACER & 2 ROW OF 90mm SPIRAL @ 200 o/c
L5 - (3)38x286 w/ 2-12.7 PLYWOOD SPACER & 2 ROW OF 90mm SPIRAL @ 200 o/c
L6 - (2)45x240 L.L. 2.0e
L7 - (3)45x240 L.L. 2.0e
- POSTS
P1 - 75# STEEL TELEPOST
P2 - (2)38x89 or (2)38x140
P3 - (3)38x89 or (3)38x140
P4 - (4)38x89 or (4)38x140
P5 - (5)38x89 or (5)38x140
P6 - (6)38x89 or (6)38x140
P13 - HSS 88.9x88.9x3.18 + 100x200x12 T&B PL.
P14 - HSS 89x89x4.8 + 100x200x12 T&B PL.
P15 - HSS 76.2x76.2x4.78 + 100x180x12 T&B PL.
P16 - HSS 76.2x76.2x4.78 + 130x130x12 T&B PL.
P17 - HSS 73 O.D. x4.8 + 100x180x12PL B PL.
(*) - 2-12# ANCH (WHERE ANCH PL. NOT USED)
- ALL FOOTINGS 600x200 DP. UNLESS NOTED
SOIL: 100 KPA

- F1 - 34"x34"x8" CONC. PAD
c/w 3-15M BARS EW
30"LG
- F2 - 24"x24"x8" CONC. PAD
c/w 2-15M BARS EW
20"LG

2012 OBC DRAWINGS

NO	DESCRIPTION	DATE	BY
2.	AS PER STRUCTURAL	09/09/16	
1.	STANDARD DRAWINGS	11/02/15	SI




TITLE: Foundation Floor Plan
Walk Out Basement

ACAD FILE: SCALE: 3/16" = 1'-0"

1050-The McCaslin
2012 Footprint
(STANDARD DRAWINGS)

DWG. A-6c

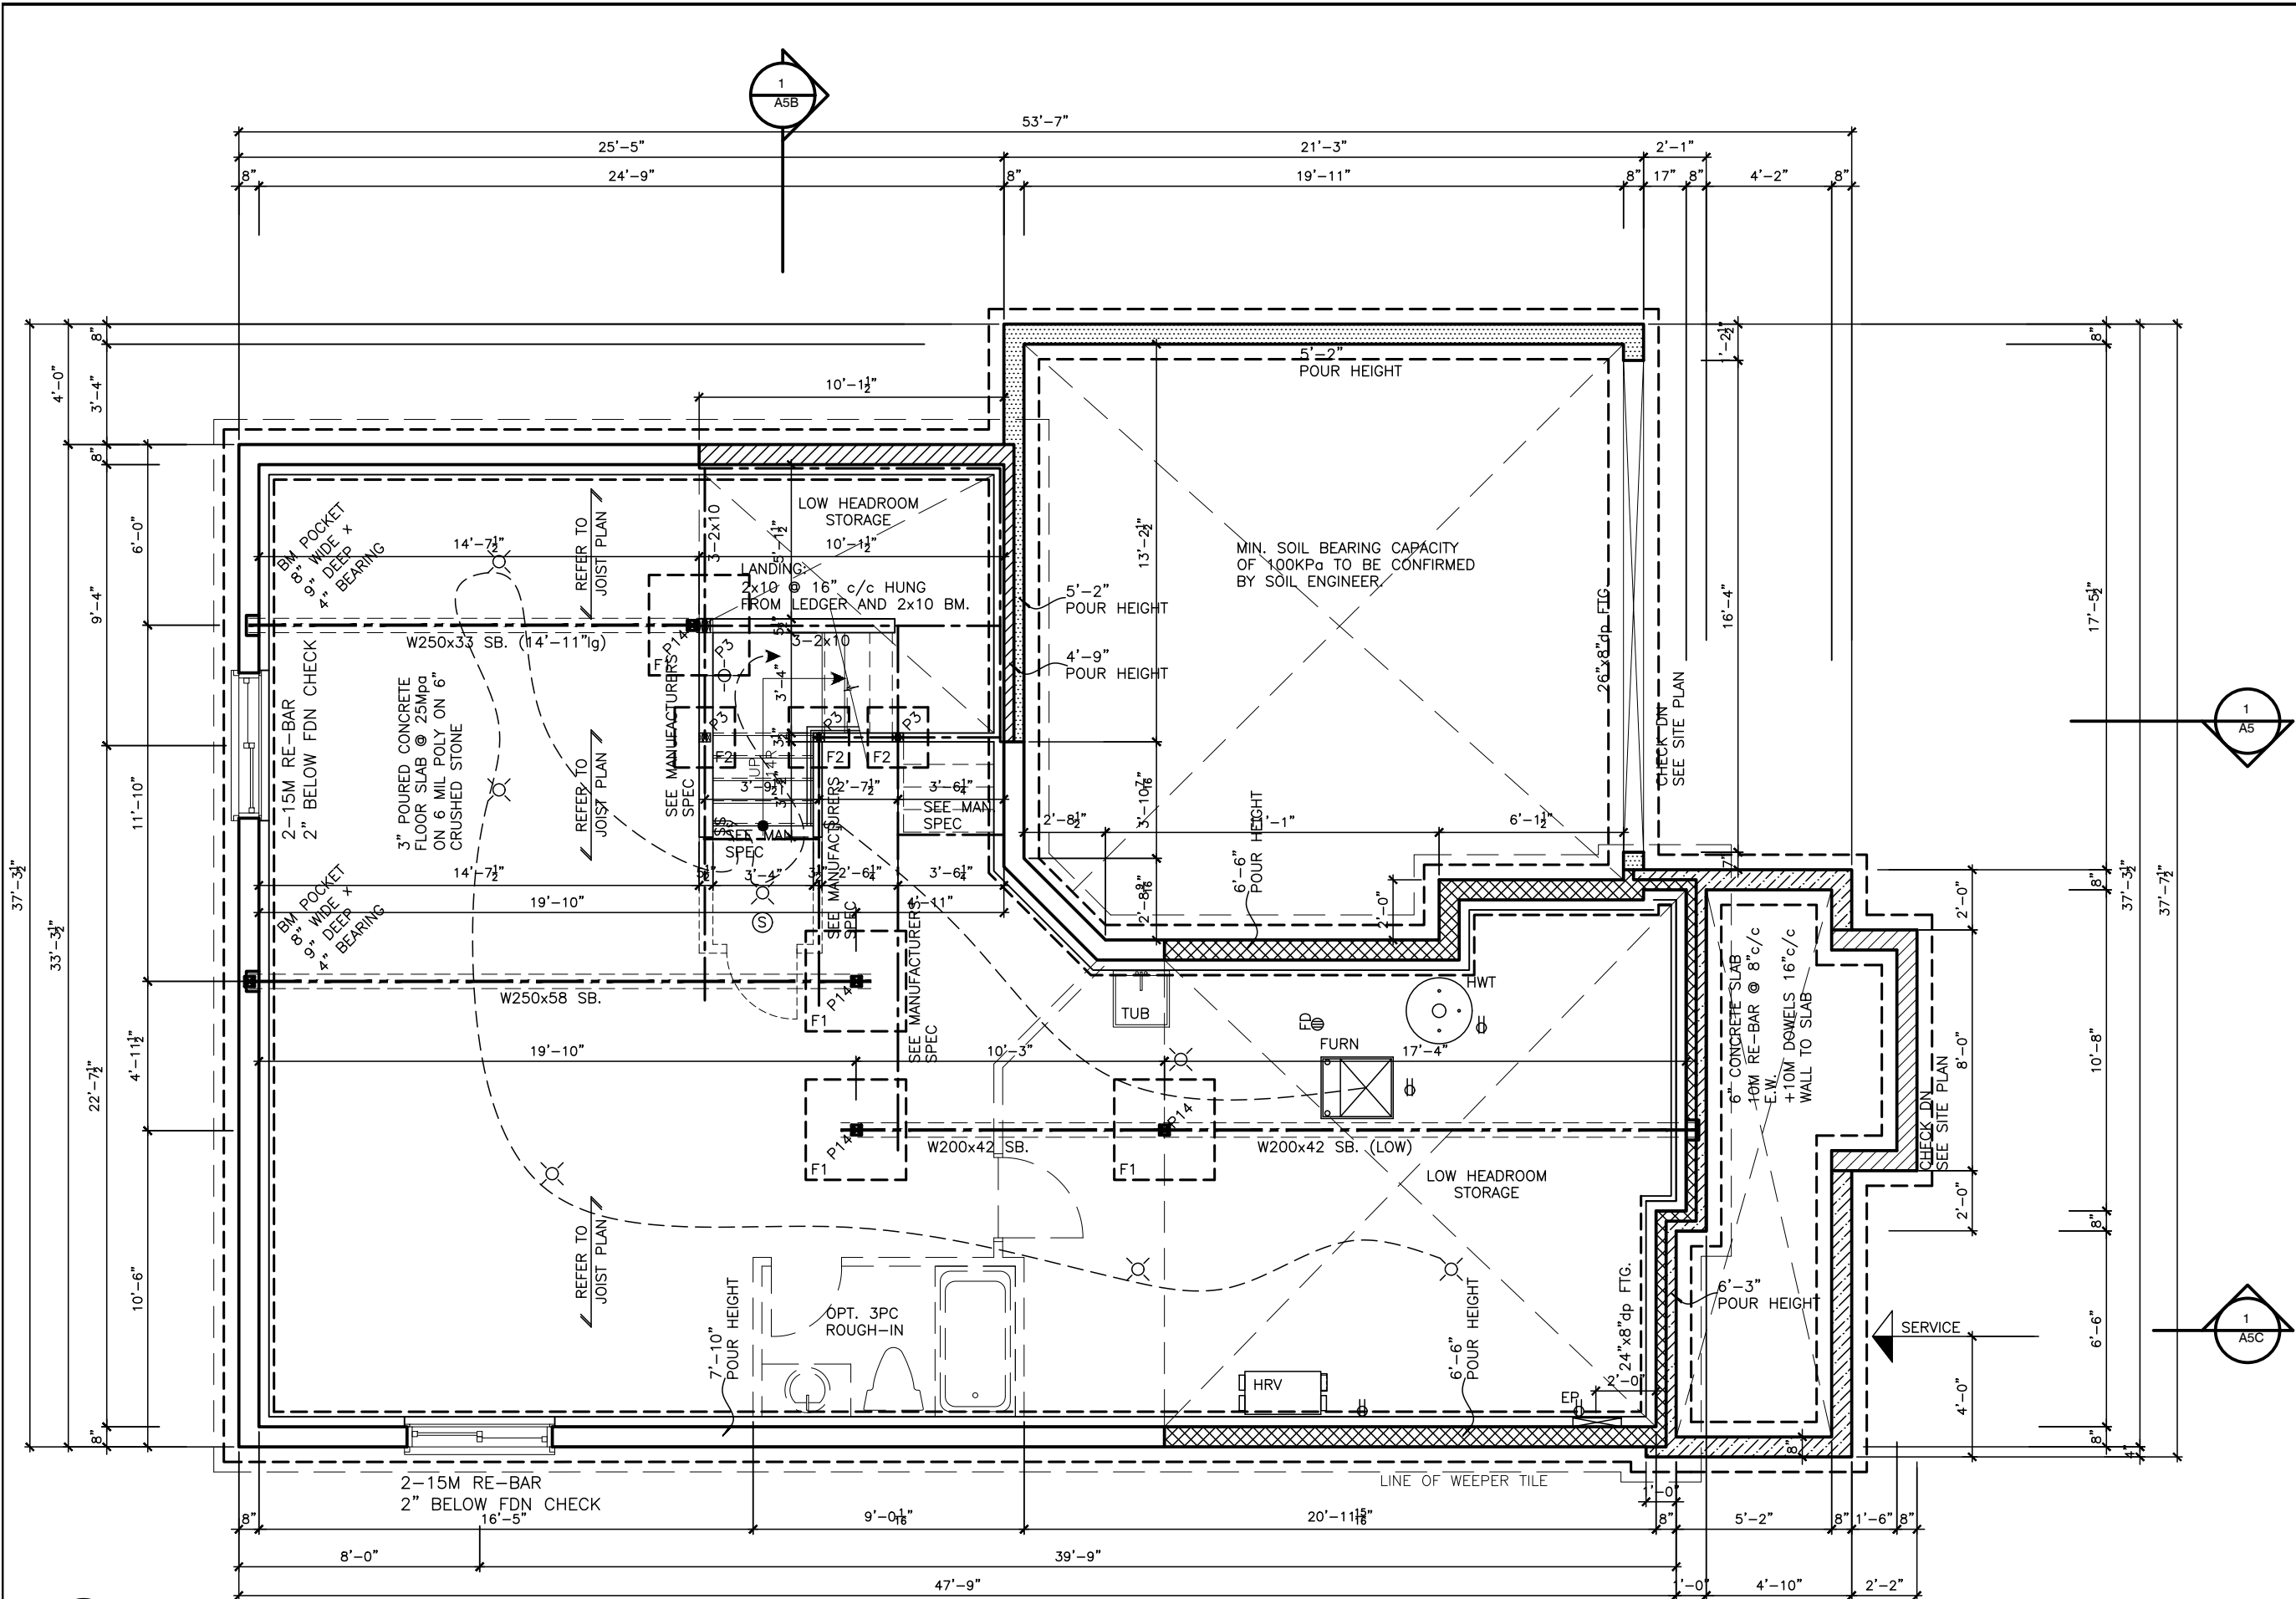

1
A6

Basement Floor Plan - Elevation A

LOT

XXxx

DATE

XX/XX/XX

THIS DRAWING IS TO BE USED IN CONJUNCTION WITH SCHEDULE B-1A AND MAY SHOW ONLY SOME OF THE CHANGES DETAILED ON THAT DOCUMENT. SHOULD THE DRAWINGS NOT SHOW ALL ITEMS CONTAINED ON A SCHEDULE OR MISS OTHER ITEMS ALTOGETHER, THE SCHEDULE IS CONSIDERED THE GOVERNING DOCUMENT.

FLOORS CONT

TENDER 2017

I SCOTT IRWIN BCIN 20765 HAVE REVIEWED AND TAKE RESPONSIBILITY FOR DESIGN ACTIVITIES RELATING TO, HOUSE & SMALL BUILDINGS.

STRUCTURAL FRAMING SCHEDULE

STEEL LINTEL
S1 - L 90x90x6
S2 - L 90x90x8
S3 - L 100x90x8
S4 - L 125x90x8
S5 - L 125x90x10
S6 - L 200x100x12
S7 - L 150x100x10 (200mm BEARING)
WOOD LINTEL
L1 - (2)38x235 w/ 12.7 PLYWOOD SPACER
L2 - (2)38x235
L3 - (3)38x235
L4 - (3)38x235 w/ 2-12.7 PLYWOOD SPACER & 2 ROW OF 90mm SPIRAL @ 200 o/c
L5 - (3)38x286 w/ 2-12.7 PLYWOOD SPACER & 2 ROW OF 90mm SPIRAL @ 200 o/c
L6 - (2)45x240 L.L. 2.0e
L7 - (3)45x240 L.L. 2.0e
POSTS
P1 - 75# STEEL TELEPOST
P2 - (2)38x89 or (2)38x140
P3 - (3)38x89 or (3)38x140
P4 - (4)38x89 or (4)38x140
P5 - (5)38x89 or (5)38x140
P6 - (6)38x89 or (6)38x140
P13 - HSS 88.9x88.9x3.18 + 100x200x12 T&B PL.
P14 - HSS 89x89x4.8 + 100x200x12 T&B PL.
P15 - HSS 76.2x76.2x4.78 + 100x180x12 T&B PL.
P16 - HSS 76.2x76.2x4.78 + 130x130x12 T&B PL.
P17 - HSS 73 O.D. x4.8 + 100x180x12 PL B PL. + 130x160x10 T PL. (*)
(*) - 2-12# ANCH (WHERE ANCH PL. NOT USED)
ALL FOOTINGS 600x200 DP. UNLESS NOTED
SOIL: 100 KPA

F1-34"x34"x8" CONC. PAD
c/w 3-15M BARS EW
30"LG

F2-24"x24"x8" CONC. PAD
c/w 2-15M BARS EW
20"LG

2012 OBC DRAWINGS

NO	DESCRIPTION	DATE	BY
2.	AS PER STRUCTURAL	09/09/16	
1.	STANDARD DRAWINGS	11/02/15	SI

Valecraft
Homes Ltd.

TITLE: Basement Floor Plan
Elevation A

ACAD FILE:


SCALE:
3/16" = 1'-0"

1050-The McCaslin
2012 Footprint
(STANDARD DRAWINGS)

DWG.
A-6



 Valecraft Homes Ltd.	
TITLE: Basement Floor Plan Elevation B & C	
ACAD FILE:	SCALE: $3/16" = 1' - 0"$
1050-The McCaslin 2012 Footprint (STANDARD DRAWINGS)	DWG. A-6b

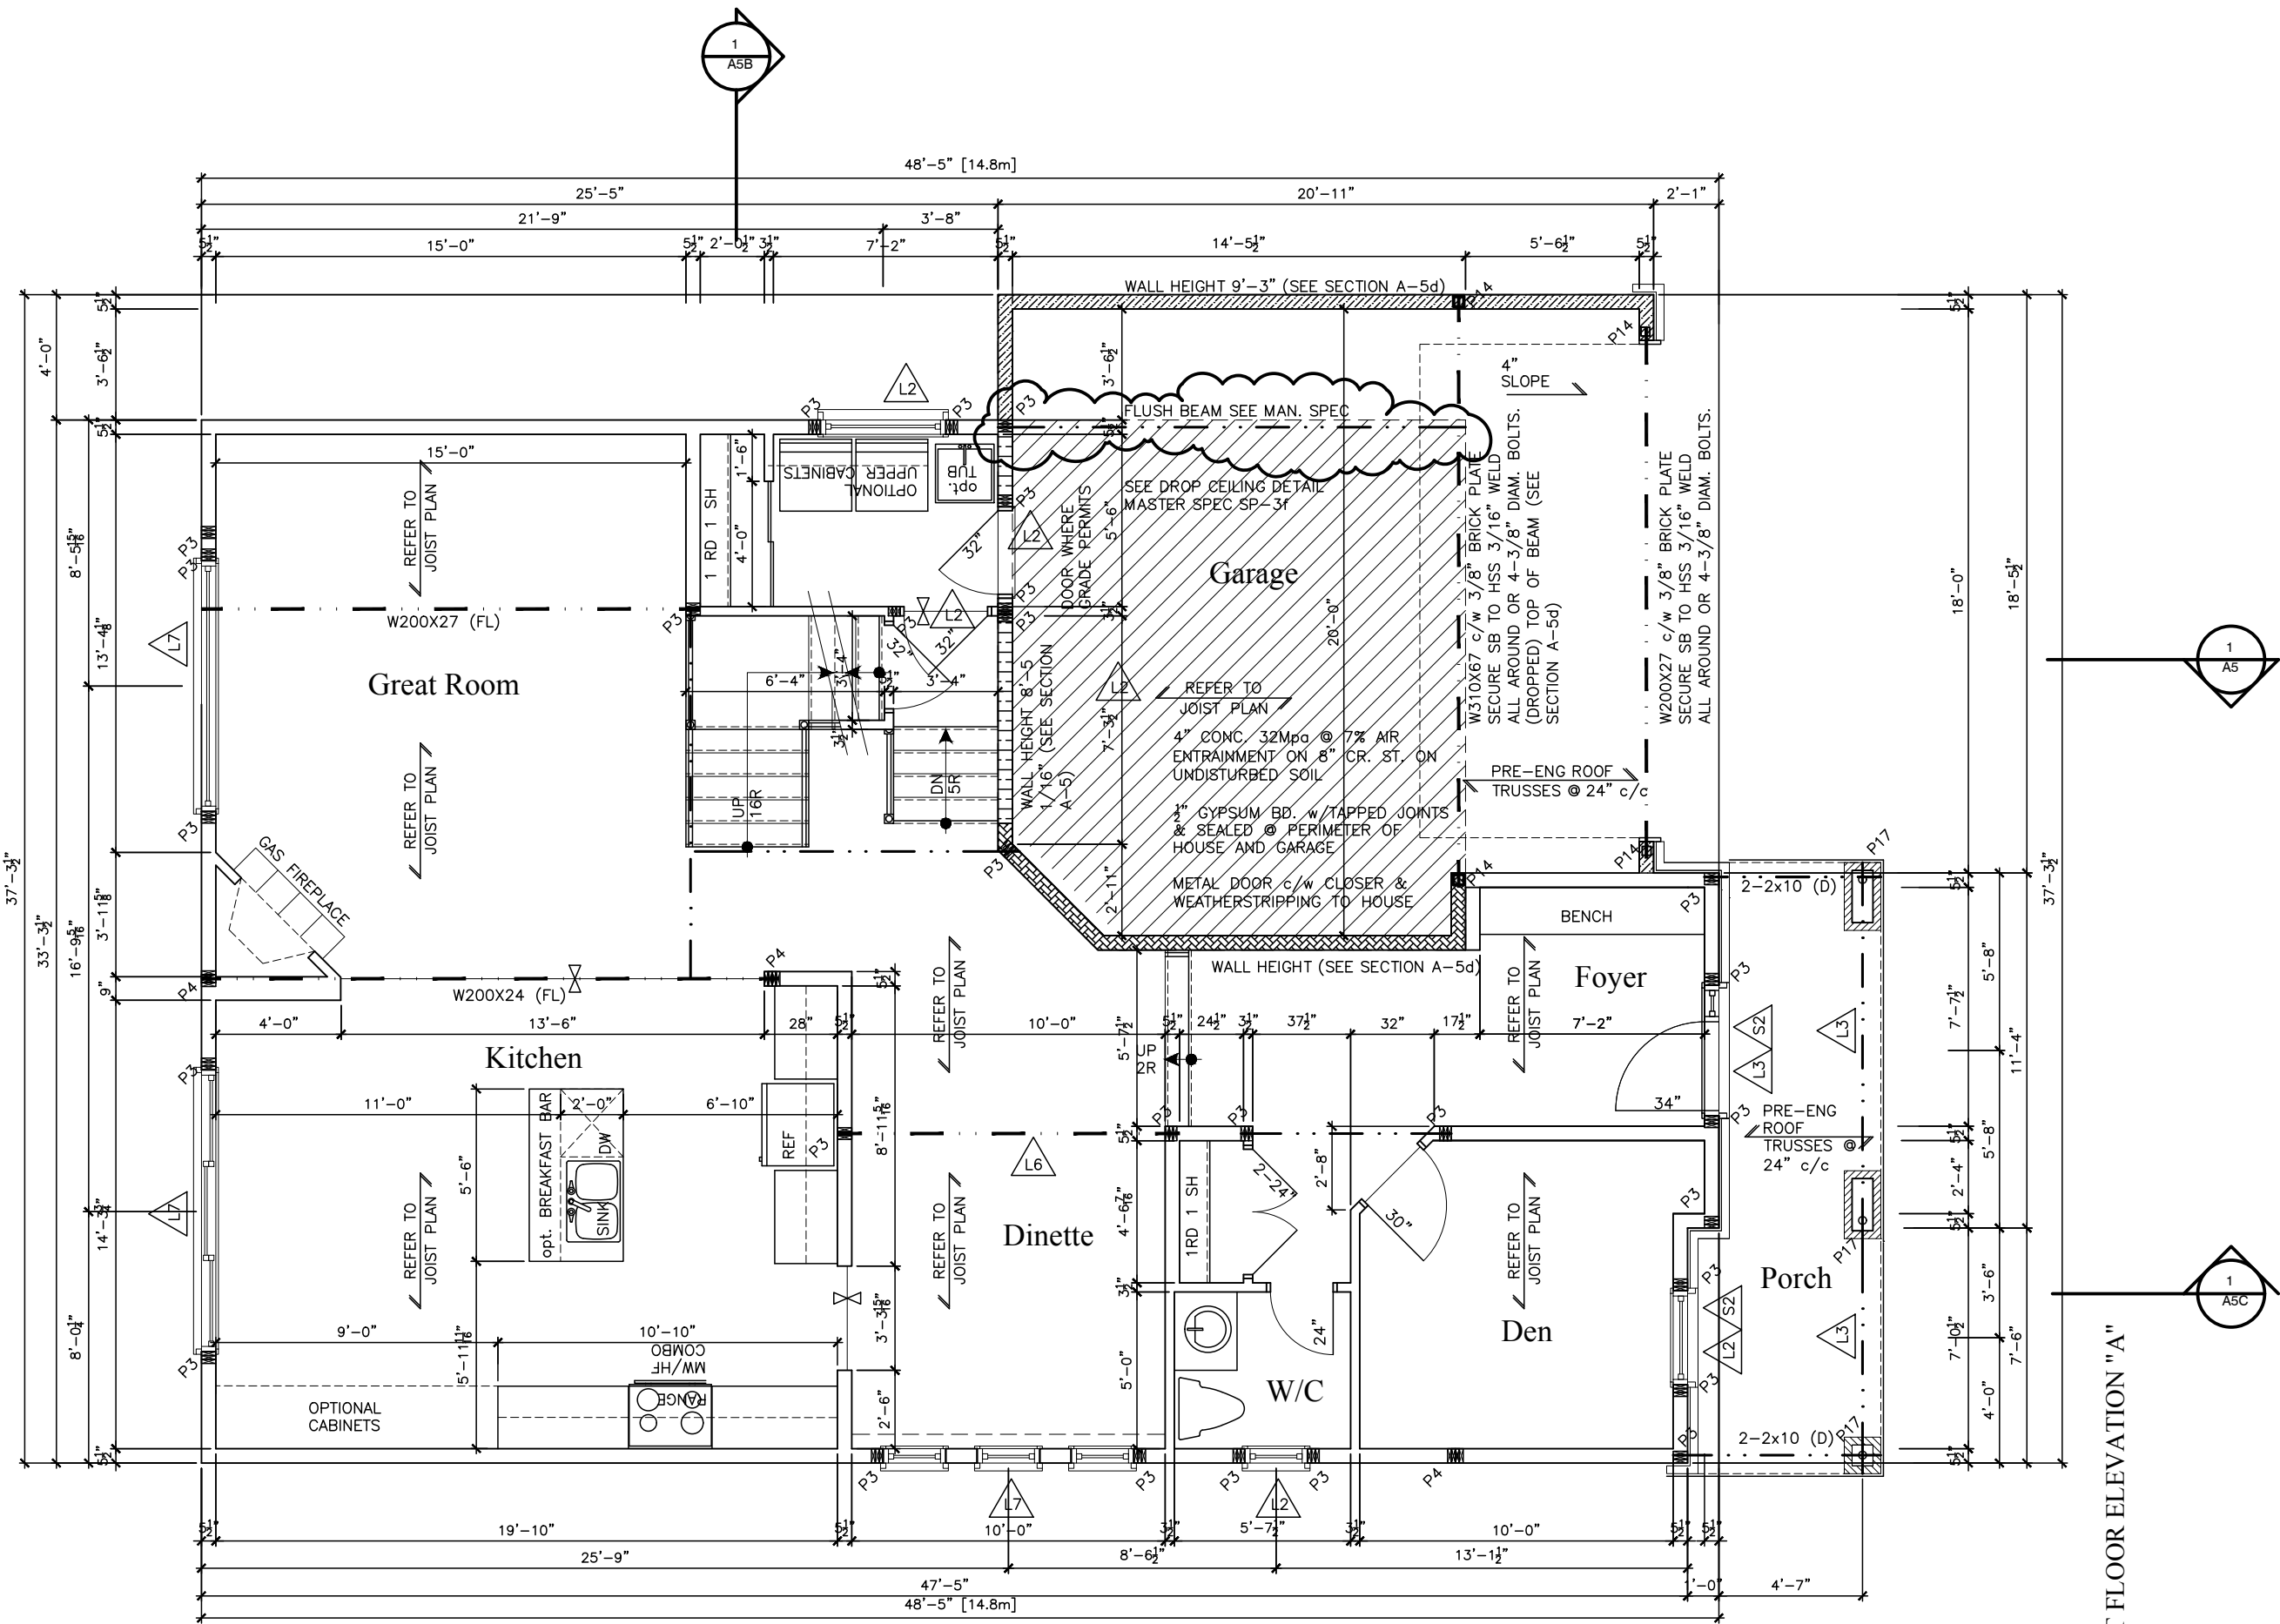

1 First Floor Plan Elevation A
A7

LOT

XXxx

DATE

XX/XX/XX

THIS DRAWINGS IS TO BE USED IN CONJUNCTION WITH SCHEDULE 8-1A AND MAY SHOW ONLY SOME OF THE CHANGES DETAILED ON THAT DOCUMENT. SHOULD THE DRAWINGS NOT SHOW ALL ITEMS CONTAINED ON A SCHEDULE OR MISS OTHER ITEMS ALTOGETHER, THE SCHEDULE IS CONSIDERED THE GOVERNING DOCUMENT.

FLOORS CONT

TENDER 2017

I SCOTT IRWIN BCIN 20765 HAVE REVIEWED AND TAKE RESPONSIBILITY FOR DESIGN ACTIVITIES RELATING TO, HOUSE & SMALL BUILDINGS.

STRUCTURAL FRAMING SCHEDULE

STEEL LINTEL
S1 - L 90x90x6
S2 - L 90x90x8
S3 - L 100x90x8
S4 - L 125x90x8
S5 - L 125x90x10
S6 - L 200x100x12
S7 - L 150x100x10 (200mm BEARING)
WOOD LINTEL
L1 - (2)38x235 w/ 12.7 PLYWOOD SPACER
L2 - (2)38x235
L3 - (3)38x235
L4 - (3)38x235 w/ 2-12.7 PLYWOOD SPACER & 2 ROW OF 90mm SPIRAL @ 200 c/c
L5 - (3)38x286 w/ 2-12.7 PLYWOOD SPACER & 2 ROW OF 90mm SPIRAL @ 200 c/c
L6 - (2)45x240 L.L. 2.0e
L7 - (3)45x240 L.L. 2.0e
POSTS
P1 - 75# STEEL TELEPOST
P2 - (2)38x89 or (2)38x140
P3 - (3)38x89 or (3)38x140
P4 - (4)38x89 or (4)38x140
P5 - (5)38x89 or (5)38x140
P6 - (6)38x89 or (6)38x140
P13 - HSS 88.9x88.9x3.18 + 100x200x12 T&B PL.
P14 - HSS 89x89x4.8 + 100x200x12 T&B PL.
P15 - HSS 76.2x76.2x4.78 + 100x180x12 T&B PL.
P16 - HSS 76.2x76.2x4.78 + 130x130x12 T&B PL.
P17 - HSS 73 O.D. x4.8 + 100x180x12PL B PL + 130x160x10 T PL.
(*) - 2-12# ANCH (WHERE ANCH PL. NOT USED)
ALL FOOTINGS 600x200 DP. UNLESS NOTED
SOIL: 100 KPA
F1-34"x34"x8" CONC. PAD c/w 3-15M BARS EW 30"LG
F2-24"x24"x8" CONC. PAD c/w 2-15M BARS EW 20"LG

2012 OBC DRAWINGS

NO	DESCRIPTION	DATE	BY
3.	WALL HEIGHTS ADDED	09/15/17	SI
2.	AS PER STRUCTURAL	09/09/16	
1.	STANDARD DRAWINGS	02/11/15	SI

Valecraft

Home Ltd.

TITLE:

1st Floor Plan - Elevation A

ACAD FILE:


SCALE:

3/16" = 1'-0"


1050-The McCaslin
2012 Footprint
(STANDARD DRAWINGS)

DWG.

A-7

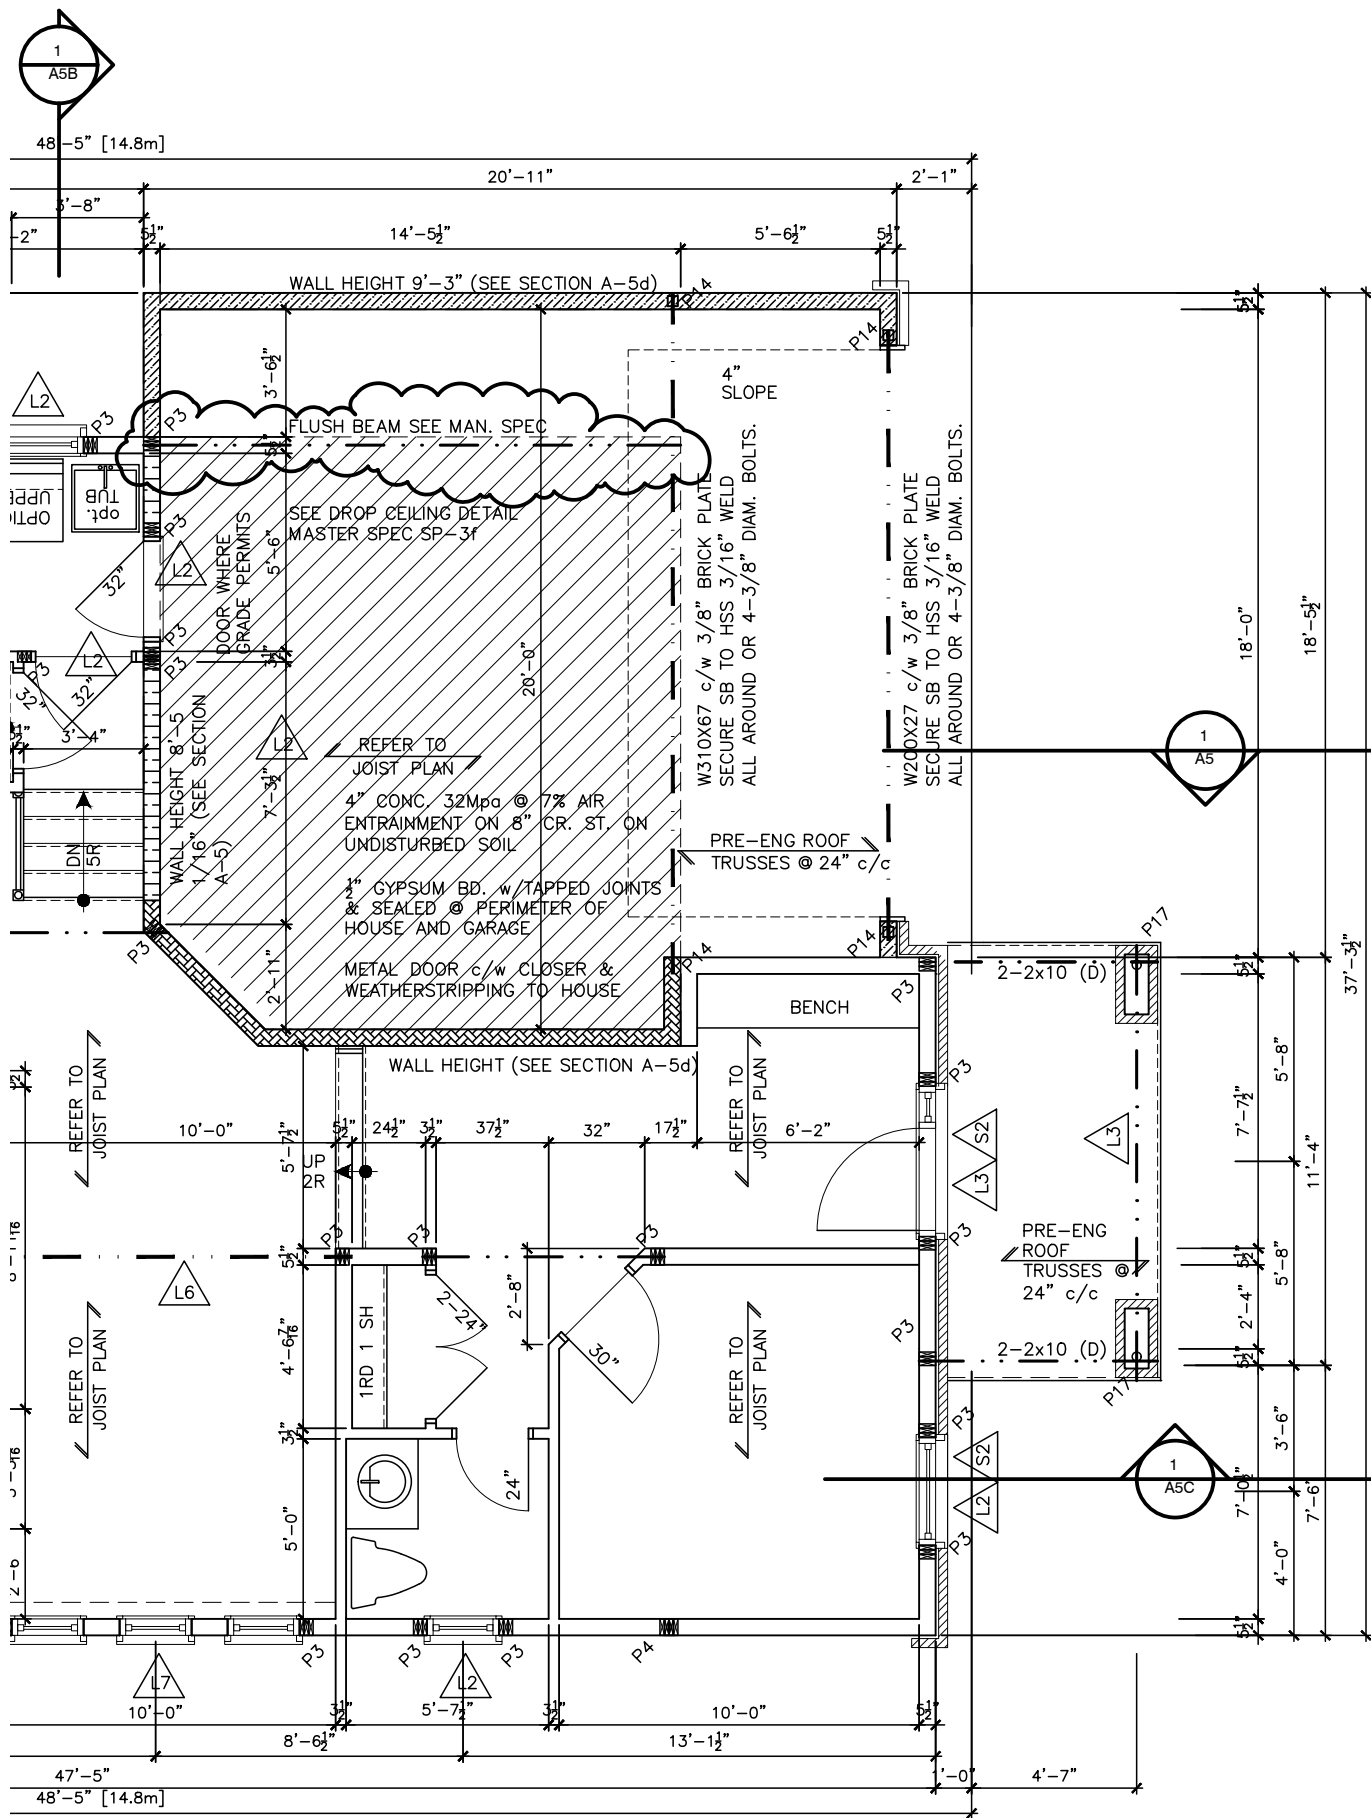

1 First Floor Plan Elevation B
A7b

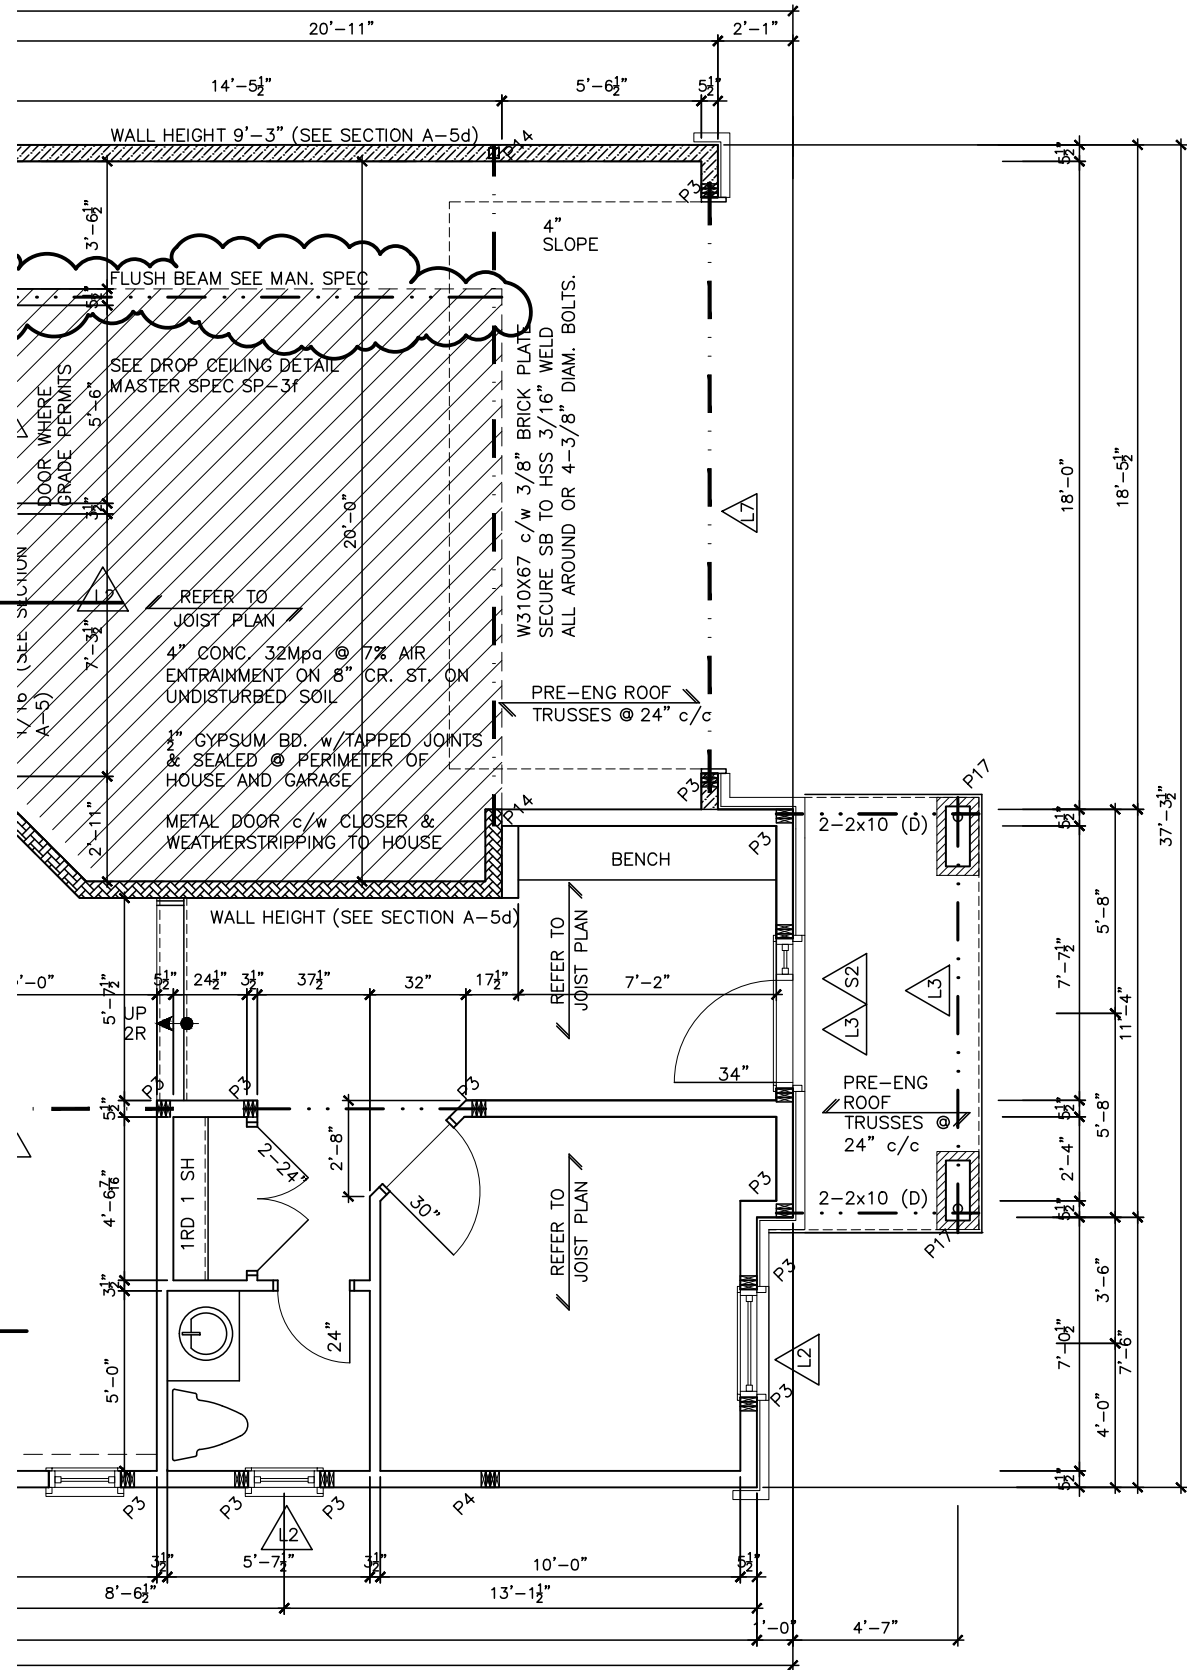

2 First Floor Plan Elevation C
A7b

LOT XXxx

DATE XX/XX/XX

THIS DRAWING IS TO BE USED IN CONJUNCTION WITH SCHEDULE 5-1A AND MAY SHOW ONLY SOME OF THE CHANGES DETAILED ON THAT DOCUMENT. SHOULD THE DRAWINGS NOT SHOW ALL ITEMS CONTAINED ON A SCHEDULE OR MISS OTHER ITEMS ALTOGETHER, THE SCHEDULE IS CONSIDERED THE GOVERNING DOCUMENT.
FLOORS CONT
TENDER 2017

I SCOTT IRWIN BCIN 20765 HAVE REVIEWED AND TAKE RESPONSIBILITY FOR DESIGN ACTIVITIES RELATING TO, HOUSE & SMALL BUILDINGS.

STRUCTURAL FRAMING SCHEDULE

- STEEL LINTEL
S1 - L 90x90x6
S2 - L 90x90x8
S3 - L 100x90x8
S4 - L 125x90x8
S5 - L 125x90x10
S6 - L 200x100x12
S7 - L 150x100x10 (200mm BEARING)
- WOOD LINTEL
L1 - (2) 38x235 w/ 12.7 PLYWOOD SPACER
L2 - (2) 38x235
L3 - (3) 38x235
L4 - (3) 38x235 w/ 2-12.7 PLYWOOD SPACER & 2 ROW OF 90mm SPIRAL @ 200 c/c
L5 - (3) 38x286 w/ 2-12.7 PLYWOOD SPACER & 2 ROW OF 90mm SPIRAL @ 200 c/c
L6 - (2) 45x240 L.L. 2.0e
L7 - (3) 45x240 L.L. 2.0e
- POSTS
P1 - 75# STEEL TELEPOST
P2 - (2) 38x89 or (2) 38x140
P3 - (3) 38x89 or (3) 38x140
P4 - (4) 38x89 or (4) 38x140
P5 - (5) 38x89 or (5) 38x140
P6 - (6) 38x89 or (6) 38x140
P13 - HSS 88.9x88.9x3.18 + 100x200x12 T&B PL.
P14 - HSS 89x89x4.8 + 100x200x12 T&B PL.
P15 - HSS 76.2x76.2x4.78 + 100x180x12 T&B PL.
P16 - HSS 76.2x76.2x4.78 + 130x130x12 T&B PL.
P17 - HSS 73 O.D. x4.8 + 100x180x12 PL B PL + 130x160x10 T PL. (*)
(*) - 2-12# ANCH (WHERE ANCH PL. NOT USED)
ALL FOOTINGS 600x200 DP. UNLESS NOTED
SOIL: 100 KPA

- F1 - 34"x34"x8" CONC. PAD c/w 3-15M BARS EW 30"LG
F2 - 24"x24"x8" CONC. PAD c/w 2-15M BARS EW 20"LG

2012 OBC DRAWINGS


NO.	DESCRIPTION	DATE	BY
3.	WALL HEIGHTS	09/15/17	SI
2.	AS PER STRUCTURAL	09/09/16	
1.	STANDARD DRAWINGS	02/11/15	SI



TITLE:
1st Floor Plan - Elevation B&C

ACAD FILE:
SCALE:
3/16" = 1'-0"

1050-The McCaslin
2012 Footprint
(STANDARD DRAWINGS)
A-7b

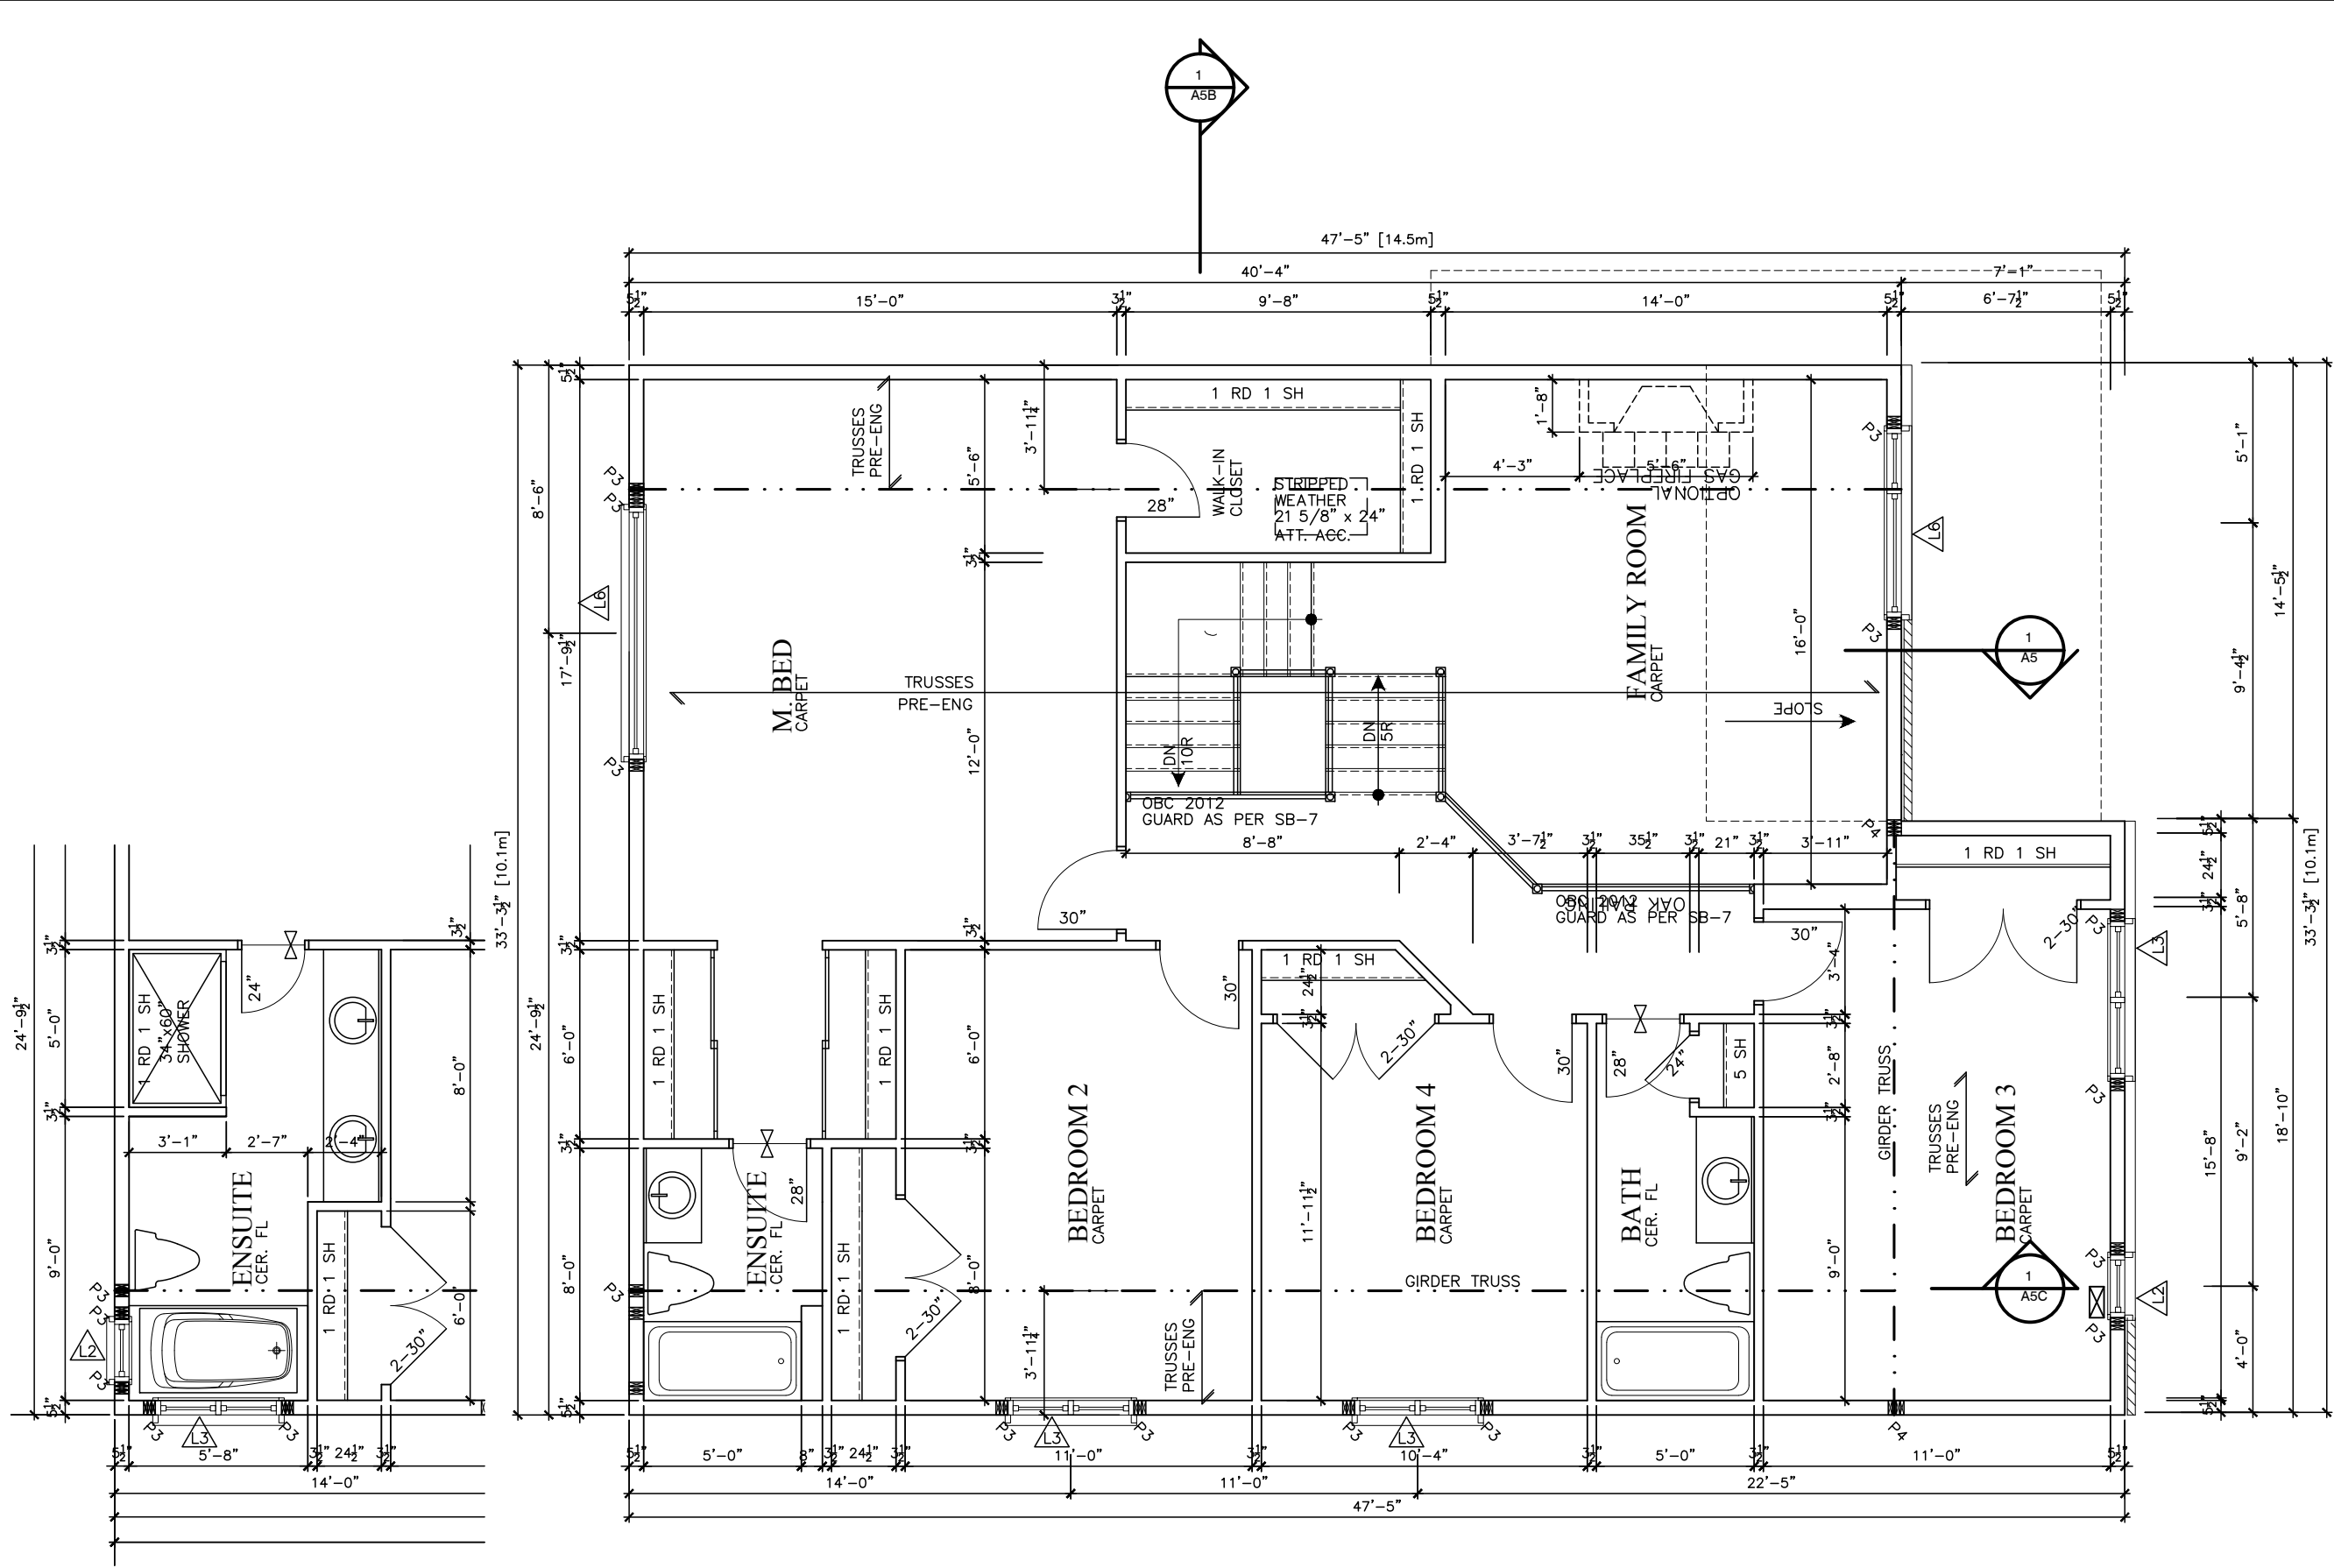

LOT

XXxx

DATE

XX/XX/XX

THIS DRAWINGS IS TO BE USED IN CONJUNCTION WITH SCHEDULE 5-1A AND MAY SHOW ONLY SOME OF THE CHANGES DETAILED ON THAT DOCUMENT. SHOULD THE DRAWINGS NOT SHOW ALL ITEMS CONTAINED ON A SCHEDULE OR MISS OTHER ITEMS ALTOGETHER, THE SCHEDULE IS CONSIDERED THE GOVERNING DOCUMENT.

TENDER 2017

I SCOTT IRWIN BCIN 20765 HAVE REVIEWED AND TAKE RESPONSIBILITY FOR DESIGN ACTIVITIES RELATING TO, HOUSE & SMALL BUILDINGS.

STRUCTURAL FRAMING SCHEDULE		
STEEL LINTEL		
S1	-	L 90x90x6
S2	-	L 90x90x8
S3	-	L 100x90x8
S4	-	L 125x90x8
S5	-	L 125x90x10
S6	-	L 200x100x12
S7	-	L 150x100x10 (200mm BEARING)
WOOD LINTEL		
L1	-	(2)38x235 w/ 12.7 PLYWOOD SPACER
L2	-	(2)38x235
L3	-	(3)38x235
L4	-	(3)38x235 w/ 2-12.7 PLYWOOD SPACER & 2 ROW OF 90mm SPIRAL @ 200 o/c
L5	-	(3)38x286 w/ 2-12.7 PLYWOOD SPACER & 2 ROW OF 90mm SPIRAL @ 200 o/c
L6	-	(2)45x240 L.L 2.0e
L7	-	(3)45x240 L.L 2.0e
POSTS		
P1	-	75# STEEL TELEPOST
P2	-	(2)38x89 or (2)38x140
P3	-	(3)38x89 or (3)38x140
P4	-	(4)38x89 or (4)38x140
P5	-	(5)38x89 or (5)38x140
P6	-	(6)38x89 or (6)38x140
P13	-	HSS 88.9x88.9x3.18 + 100x200x12 T&B PL.
P14	-	HSS 89x89x4.8 + 100x200x12 T&B PL.
P15	-	HSS 76.2x76.2x4.78 + 100x180x12 T&B PL.
P16	-	HSS 76.2x76.2x4.78 + 130x130x12 T&B PL.
P17	-	HSS 73 O.D. x4.8 + 100x180x12PL B PL. + 130x160x10 T PL. (*)
(*) - 2-12# ANCH (WHERE ANCH PL. NOT USED)		
ALL FOOTINGS 600x200 DP. UNLESS NOTED		
SOIL: 100 KPA		

SECOND FLOOR ELEVATION "B"

2012 OBC DRAWINGS

NO	DESCRIPTION	DATE	BY
	AS PER STRUCTURAL	09/09/16	
	STANDARD DRAWINGS	02/11/15	SI



TITLE:

2nd Floor Plan - Elevation B


ACAD FILE:

SCALE:

3/16" = 1'-0"

1050-The McCaslin
2012 Footprint
(STANDARD DRAWINGS)

DWG.
A-8b

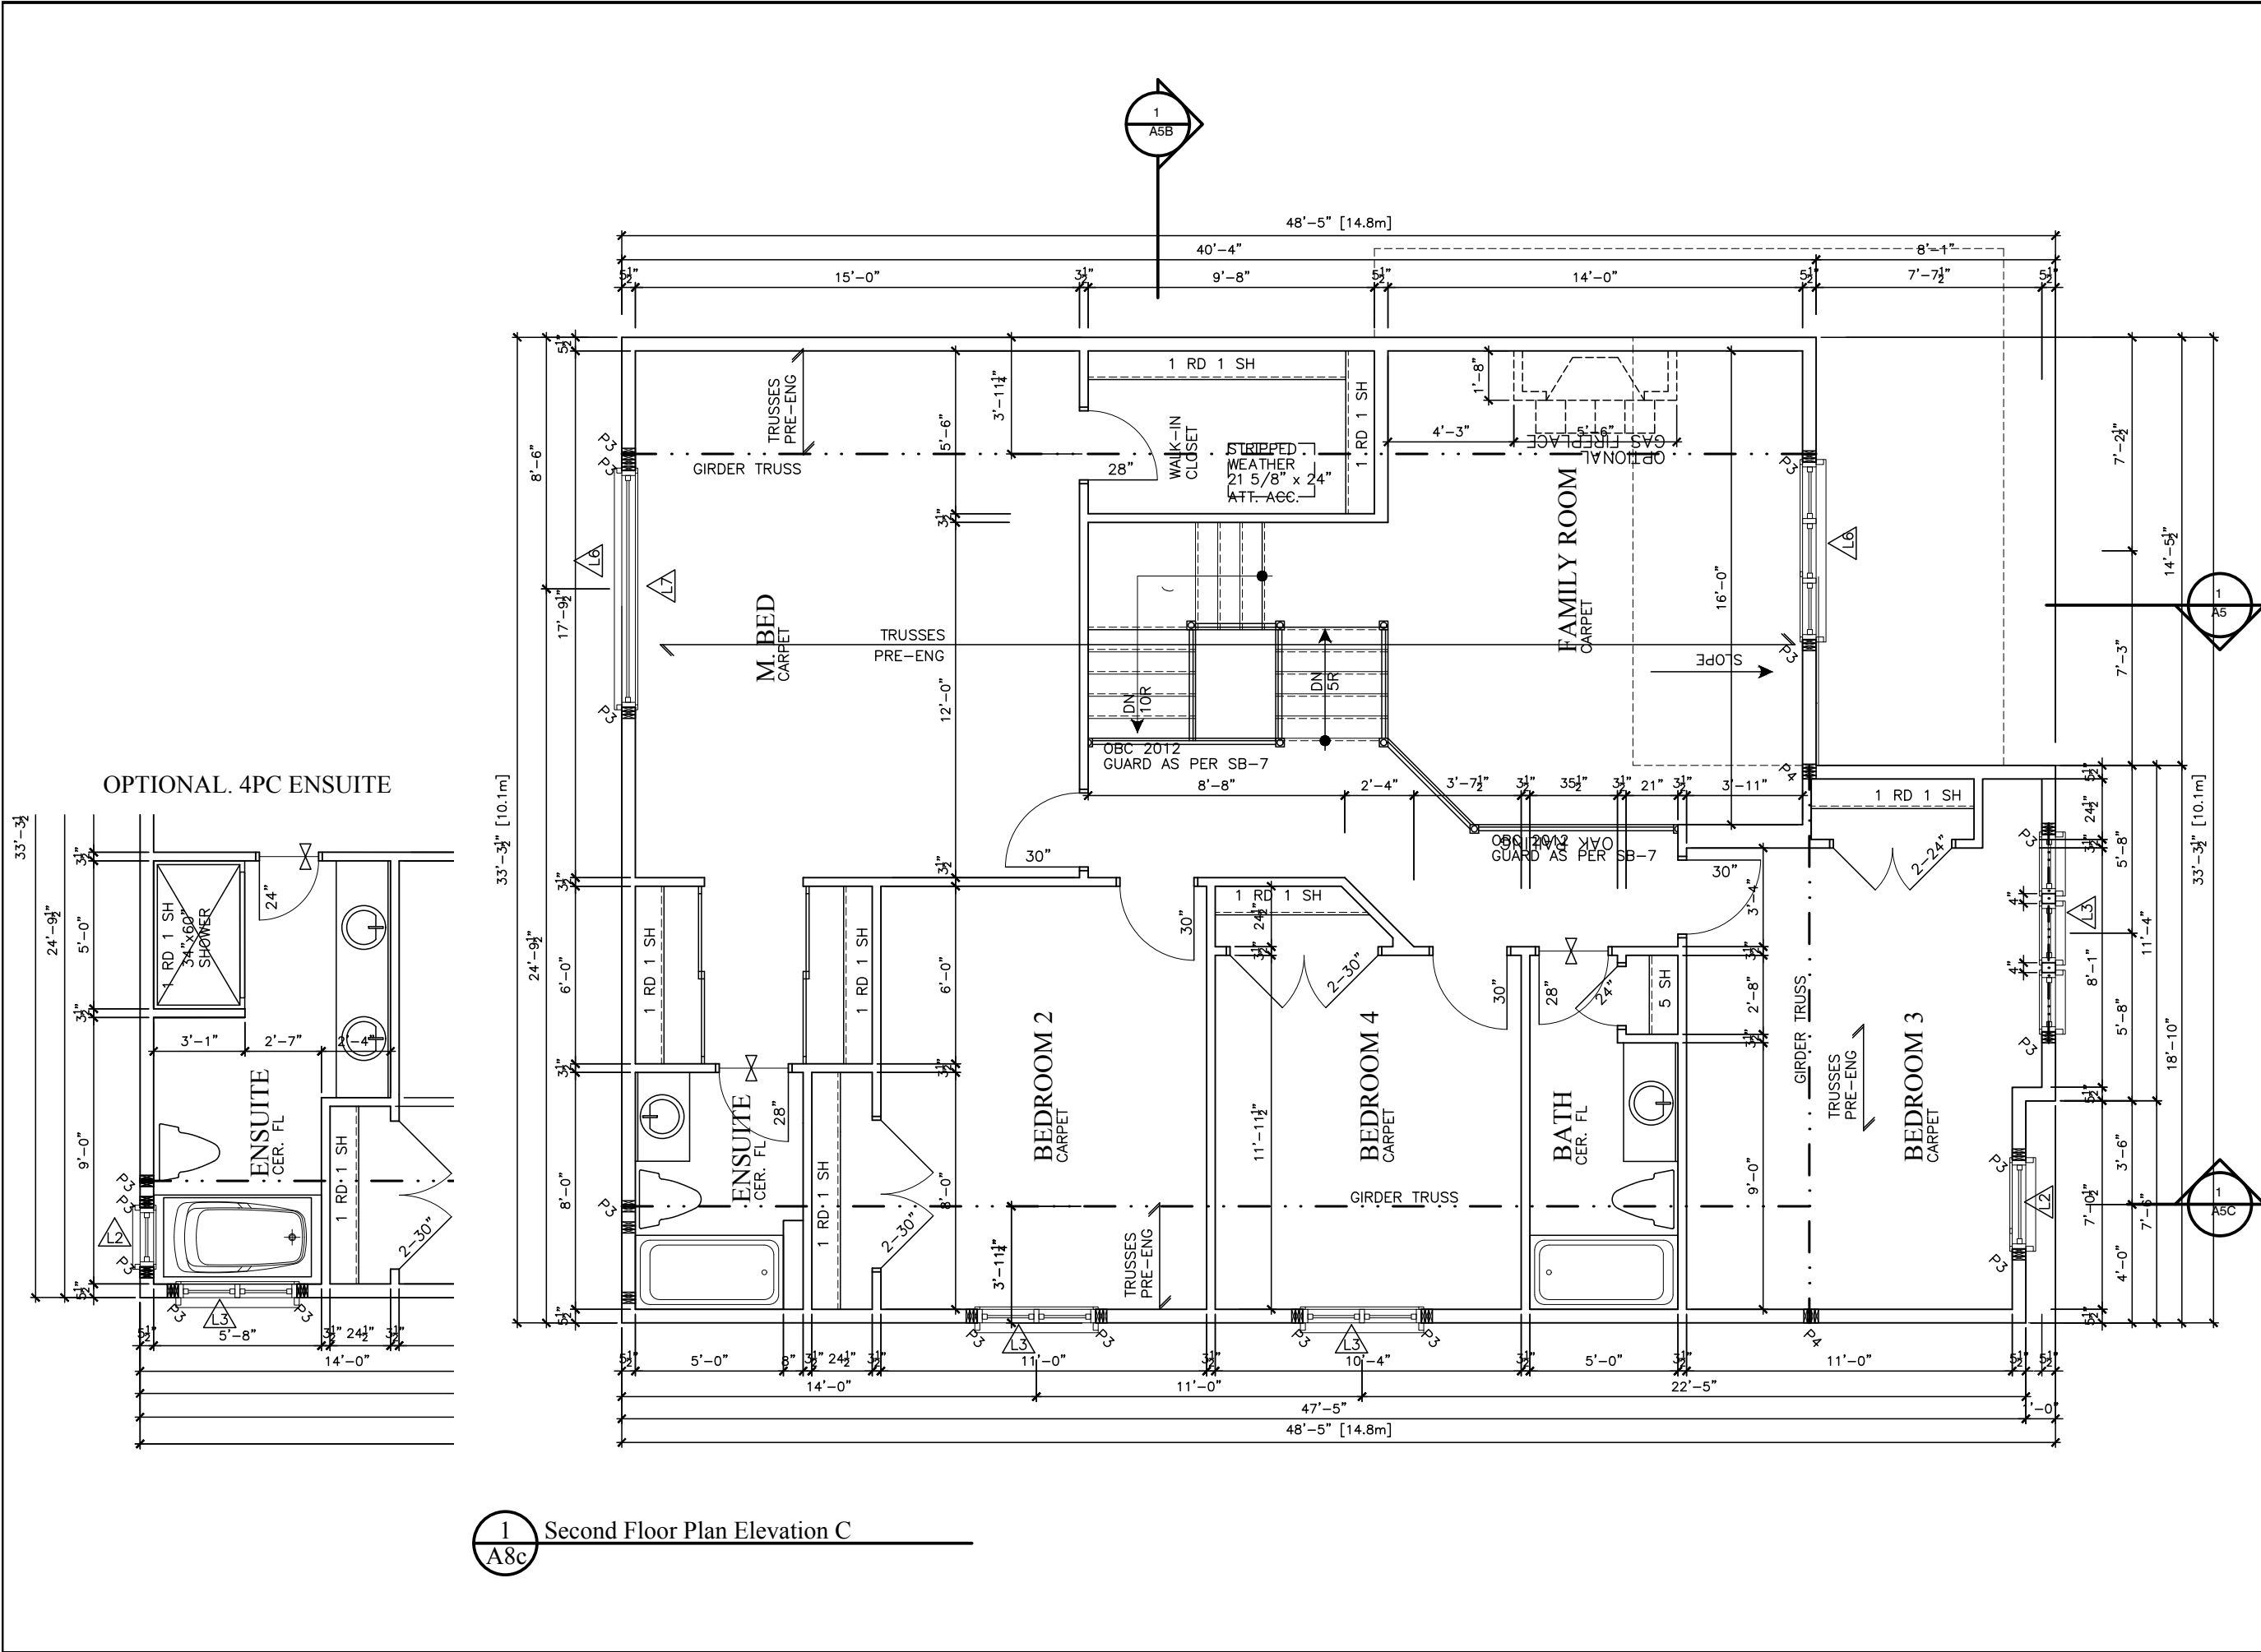

LOT

XXxx

DATE

XX/XX/XX

THIS DRAWINGS IS TO BE USED IN CONJUNCTION WITH SCHEDULE 8-1A AND MAY SHOW ONLY SOME OF THE CHANGES DETAILED ON THAT DOCUMENT. SHOULD THE DRAWINGS NOT SHOW ALL ITEMS CONTAINED ON A SCHEDULE OR MISS OTHER ITEMS ALTOGETHER, THE SCHEDULE IS CONSIDERED THE GOVERNING DOCUMENT.

TENDER 2017

I SCOTT IRWIN BCIN 20765 HAVE REVIEWED AND TAKE RESPONSIBILITY FOR DESIGN ACTIVITIES RELATING TO, HOUSE & SMALL BUILDINGS.

STRUCTURAL FRAMING SCHEDULE

STEEL LINTEL

S1 - L 90x90x6
S2 - L 90x90x8
S3 - L 100x90x8
S4 - L 125x90x8
S5 - L 125x90x10
S6 - L 200x100x12
S7 - L 150x100x10 (200mm BEARING)

WOOD LINTEL

L1 - (2)38x235 w/ 12.7 PLYWOOD SPACER
L2 - (2)38x235
L3 - (3)38x235
L4 - (3)38x235 w/ 2-12.7 PLYWOOD SPACER & 2 ROW OF 90mm SPIRAL @ 200 o/c
L5 - (3)38x286 w/ 2-12.7 PLYWOOD SPACER & 2 ROW OF 90mm SPIRAL @ 200 o/c
L6 - (2)45x240 L.L. 2.0e
L7 - (3)45x240 L.L. 2.0e

POSTS

P1 - 75# STEEL TELEPOST
P2 - (2)38x89 or (2)38x140
P3 - (3)38x89 or (3)38x140
P4 - (4)38x89 or (4)38x140
P5 - (5)38x89 or (5)38x140
P6 - (6)38x89 or (6)38x140
P13 - HSS 88.9x88.9x3.18 + 100x200x12 T&B PL.
P14 - HSS 89x89x4.8 + 100x200x12 T&B PL.
P15 - HSS 76.2x76.2x4.78 + 100x180x12 T&B PL.
P16 - HSS 76.2x76.2x4.78 + 130x130x12 T&B PL.
P17 - HSS 73 O.D. x4.8 + 100x180x12PL B PL. + 130x160x10 T PL. (*)
(*) - 2-12# ANCH (WHERE ANCH PL. NOT USED)
ALL FOOTINGS 600x200 DP. UNLESS NOTED
SOIL: 100 KPA

2012 OBC DRAWINGS

NO	DESCRIPTION	DATE	BY
AS PER STRUCTURAL	09/09/16		
STANDARD DRAWINGS	02/11/15	SI	

Valecraft

Home Ltd.

TITLE:

2nd Floor Plan - Elevation C

ACAD FILE:


1050-The McCaslin 2012 Footprint (STANDARD DRAWINGS)

SCALE:


3/16" = 1'-0"

DWG.

A-8c

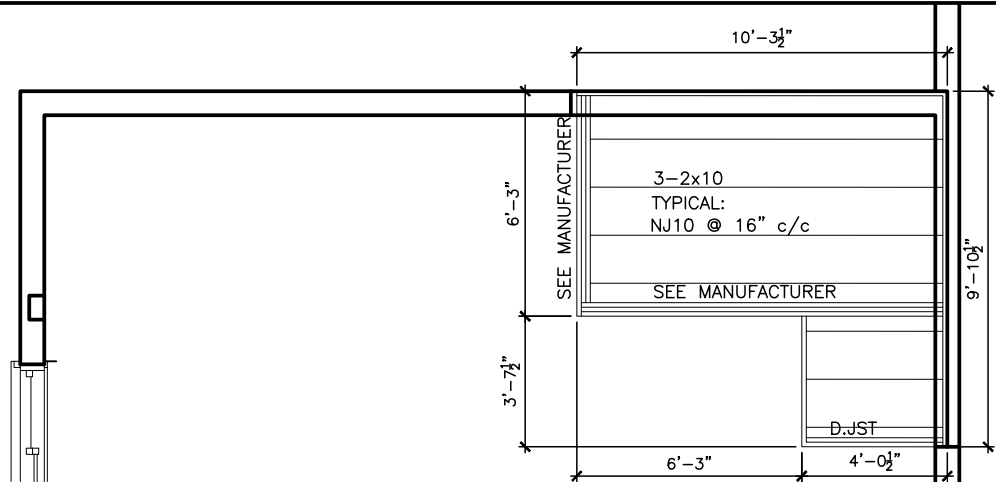

1 First Floor Joist Plan
J1b

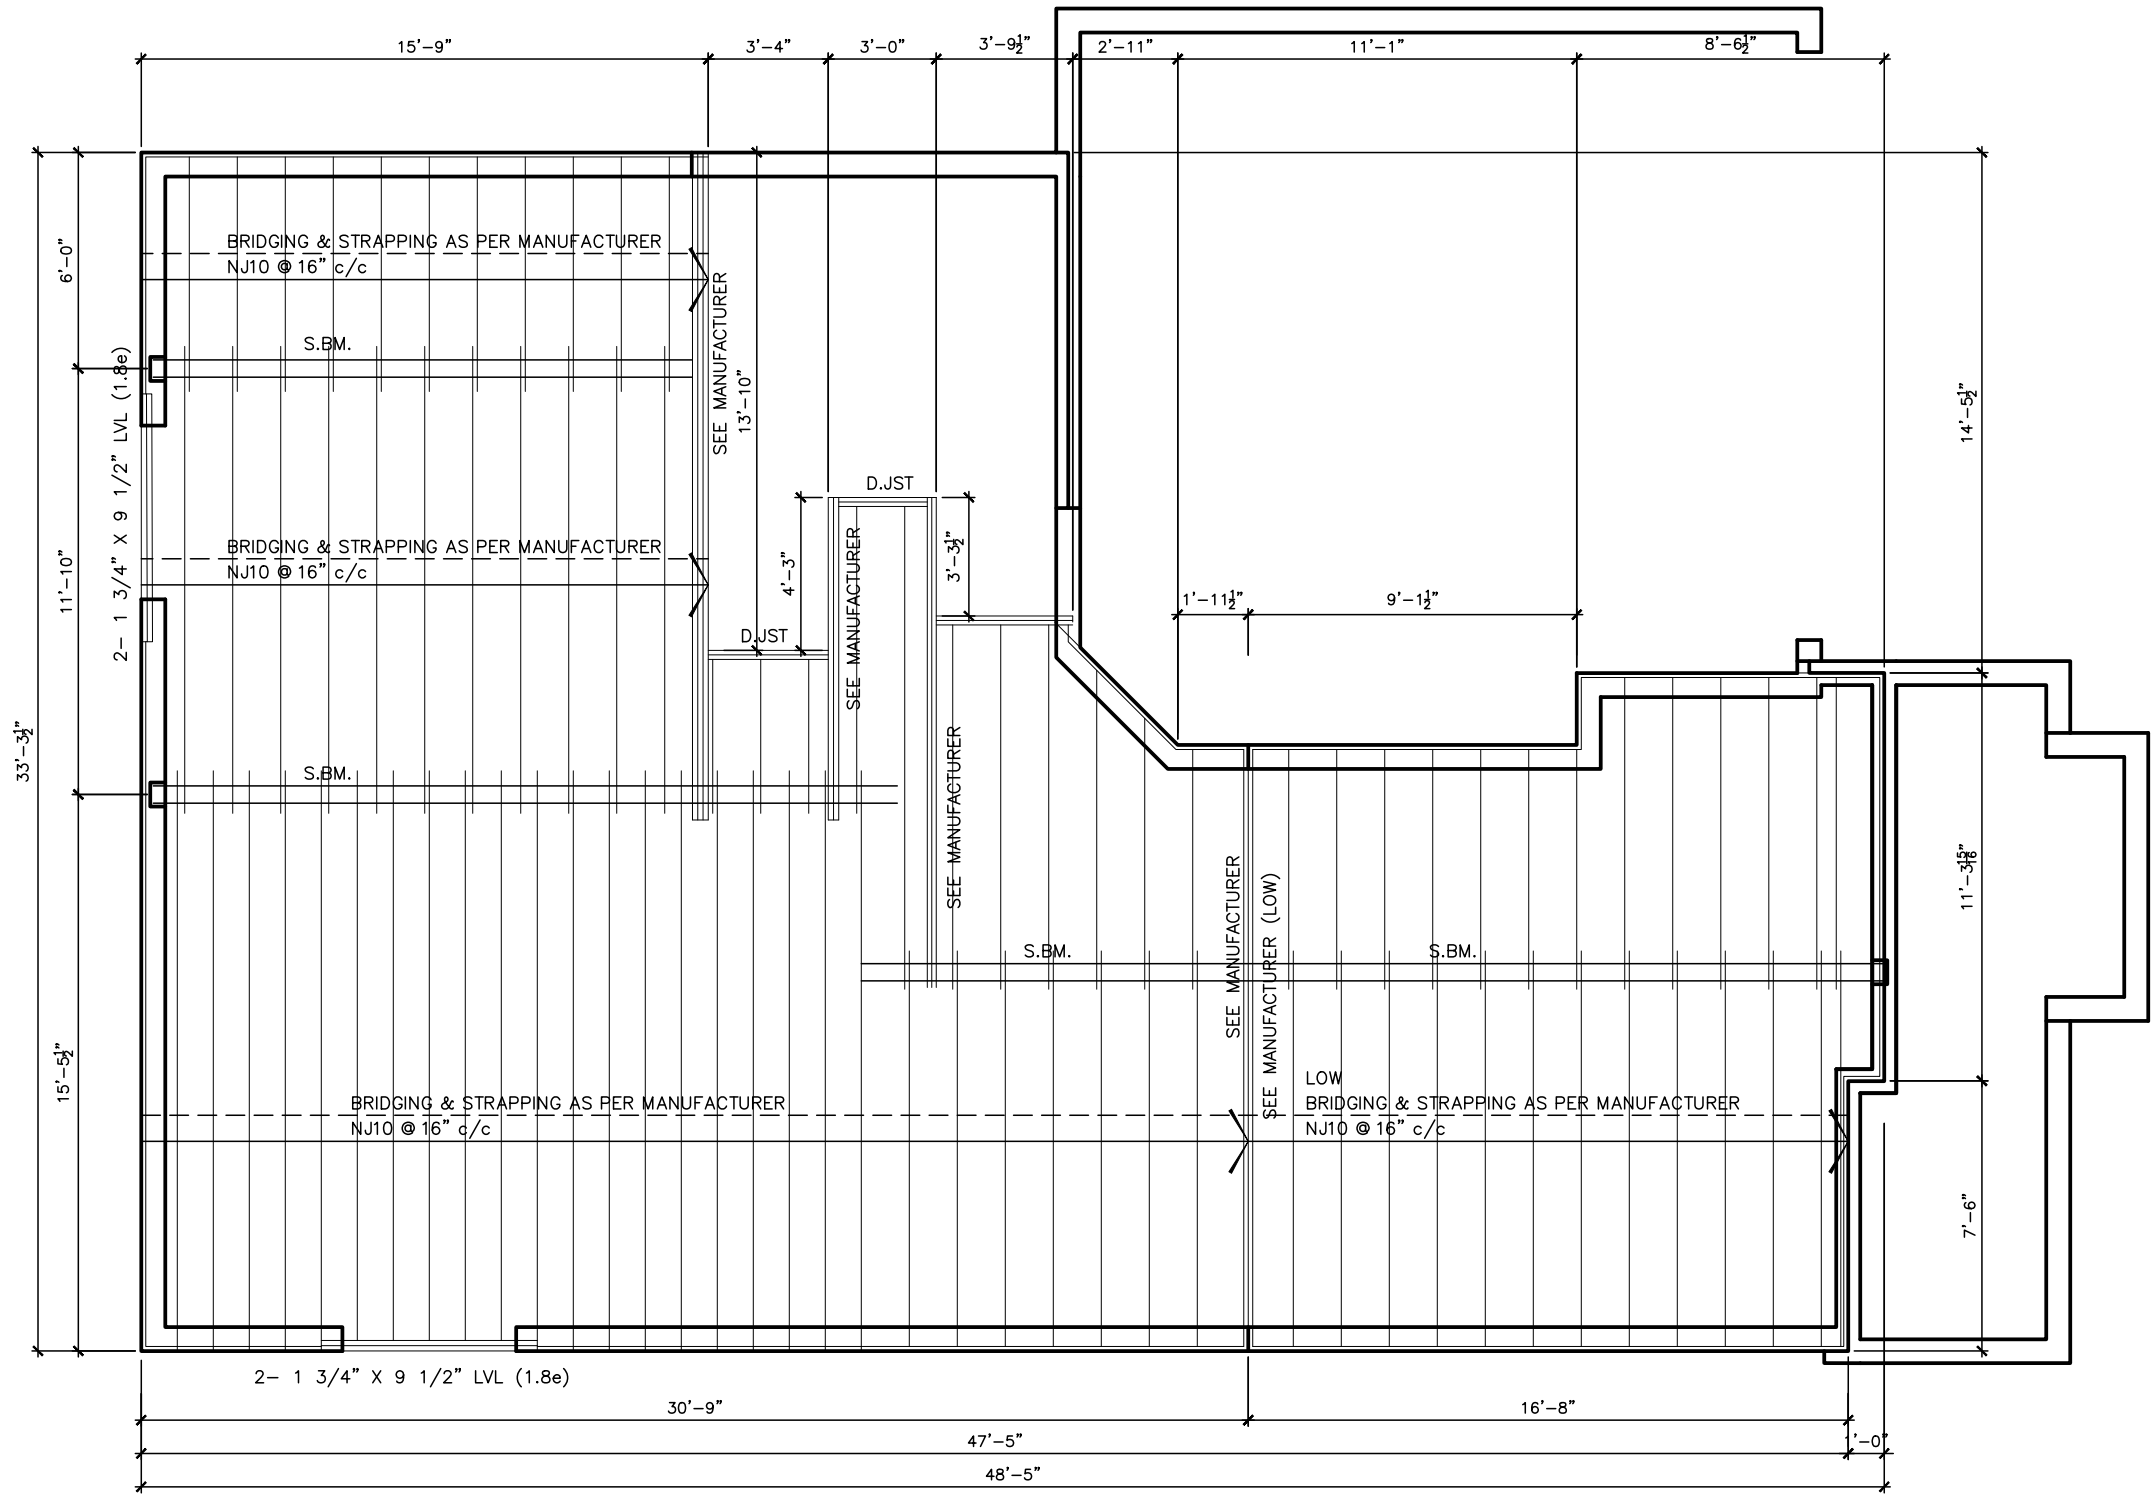

LOT **XXxx**

DATE **XX/XX/XX**

THIS DRAWING IS TO BE USED IN CONJUNCTION WITH SCHEDULE B-1A AND MAY SHOW ONLY SOME OF THE CHANGES DETAILED ON THAT DOCUMENT. SHOULD THE DRAWINGS NOT SHOW ALL ITEMS CONTAINED ON A SCHEDULE OR MISS OTHER ITEMS ALTOGETHER, THE SCHEDULE IS CONSIDERED THE GOVERNING DOCUMENT.

TENDER 2017

I SCOTT IRWIN BCIN 20765 HAVE REVIEWED AND TAKE RESPONSIBILITY FOR DESIGN ACTIVITIES RELATING TO, HOUSE & SMALL BUILDINGS.

2012 OBC DRAWINGS

2.	AS PER STRUCTURAL	09/09/16	
1.	STANDARD DRAWINGS	02/11/15	SI
NO.	DESCRIPTION	DATE	BY


**Valecraft**
Homes Ltd.

TITLE:
1st Floor Joist Plan

ACAD FILE:
1050-The McCaslin
2012 Footprint
(STANDARD DRAWINGS)

SCALE:
3/16" = 1'-0"

DWG.
J-1

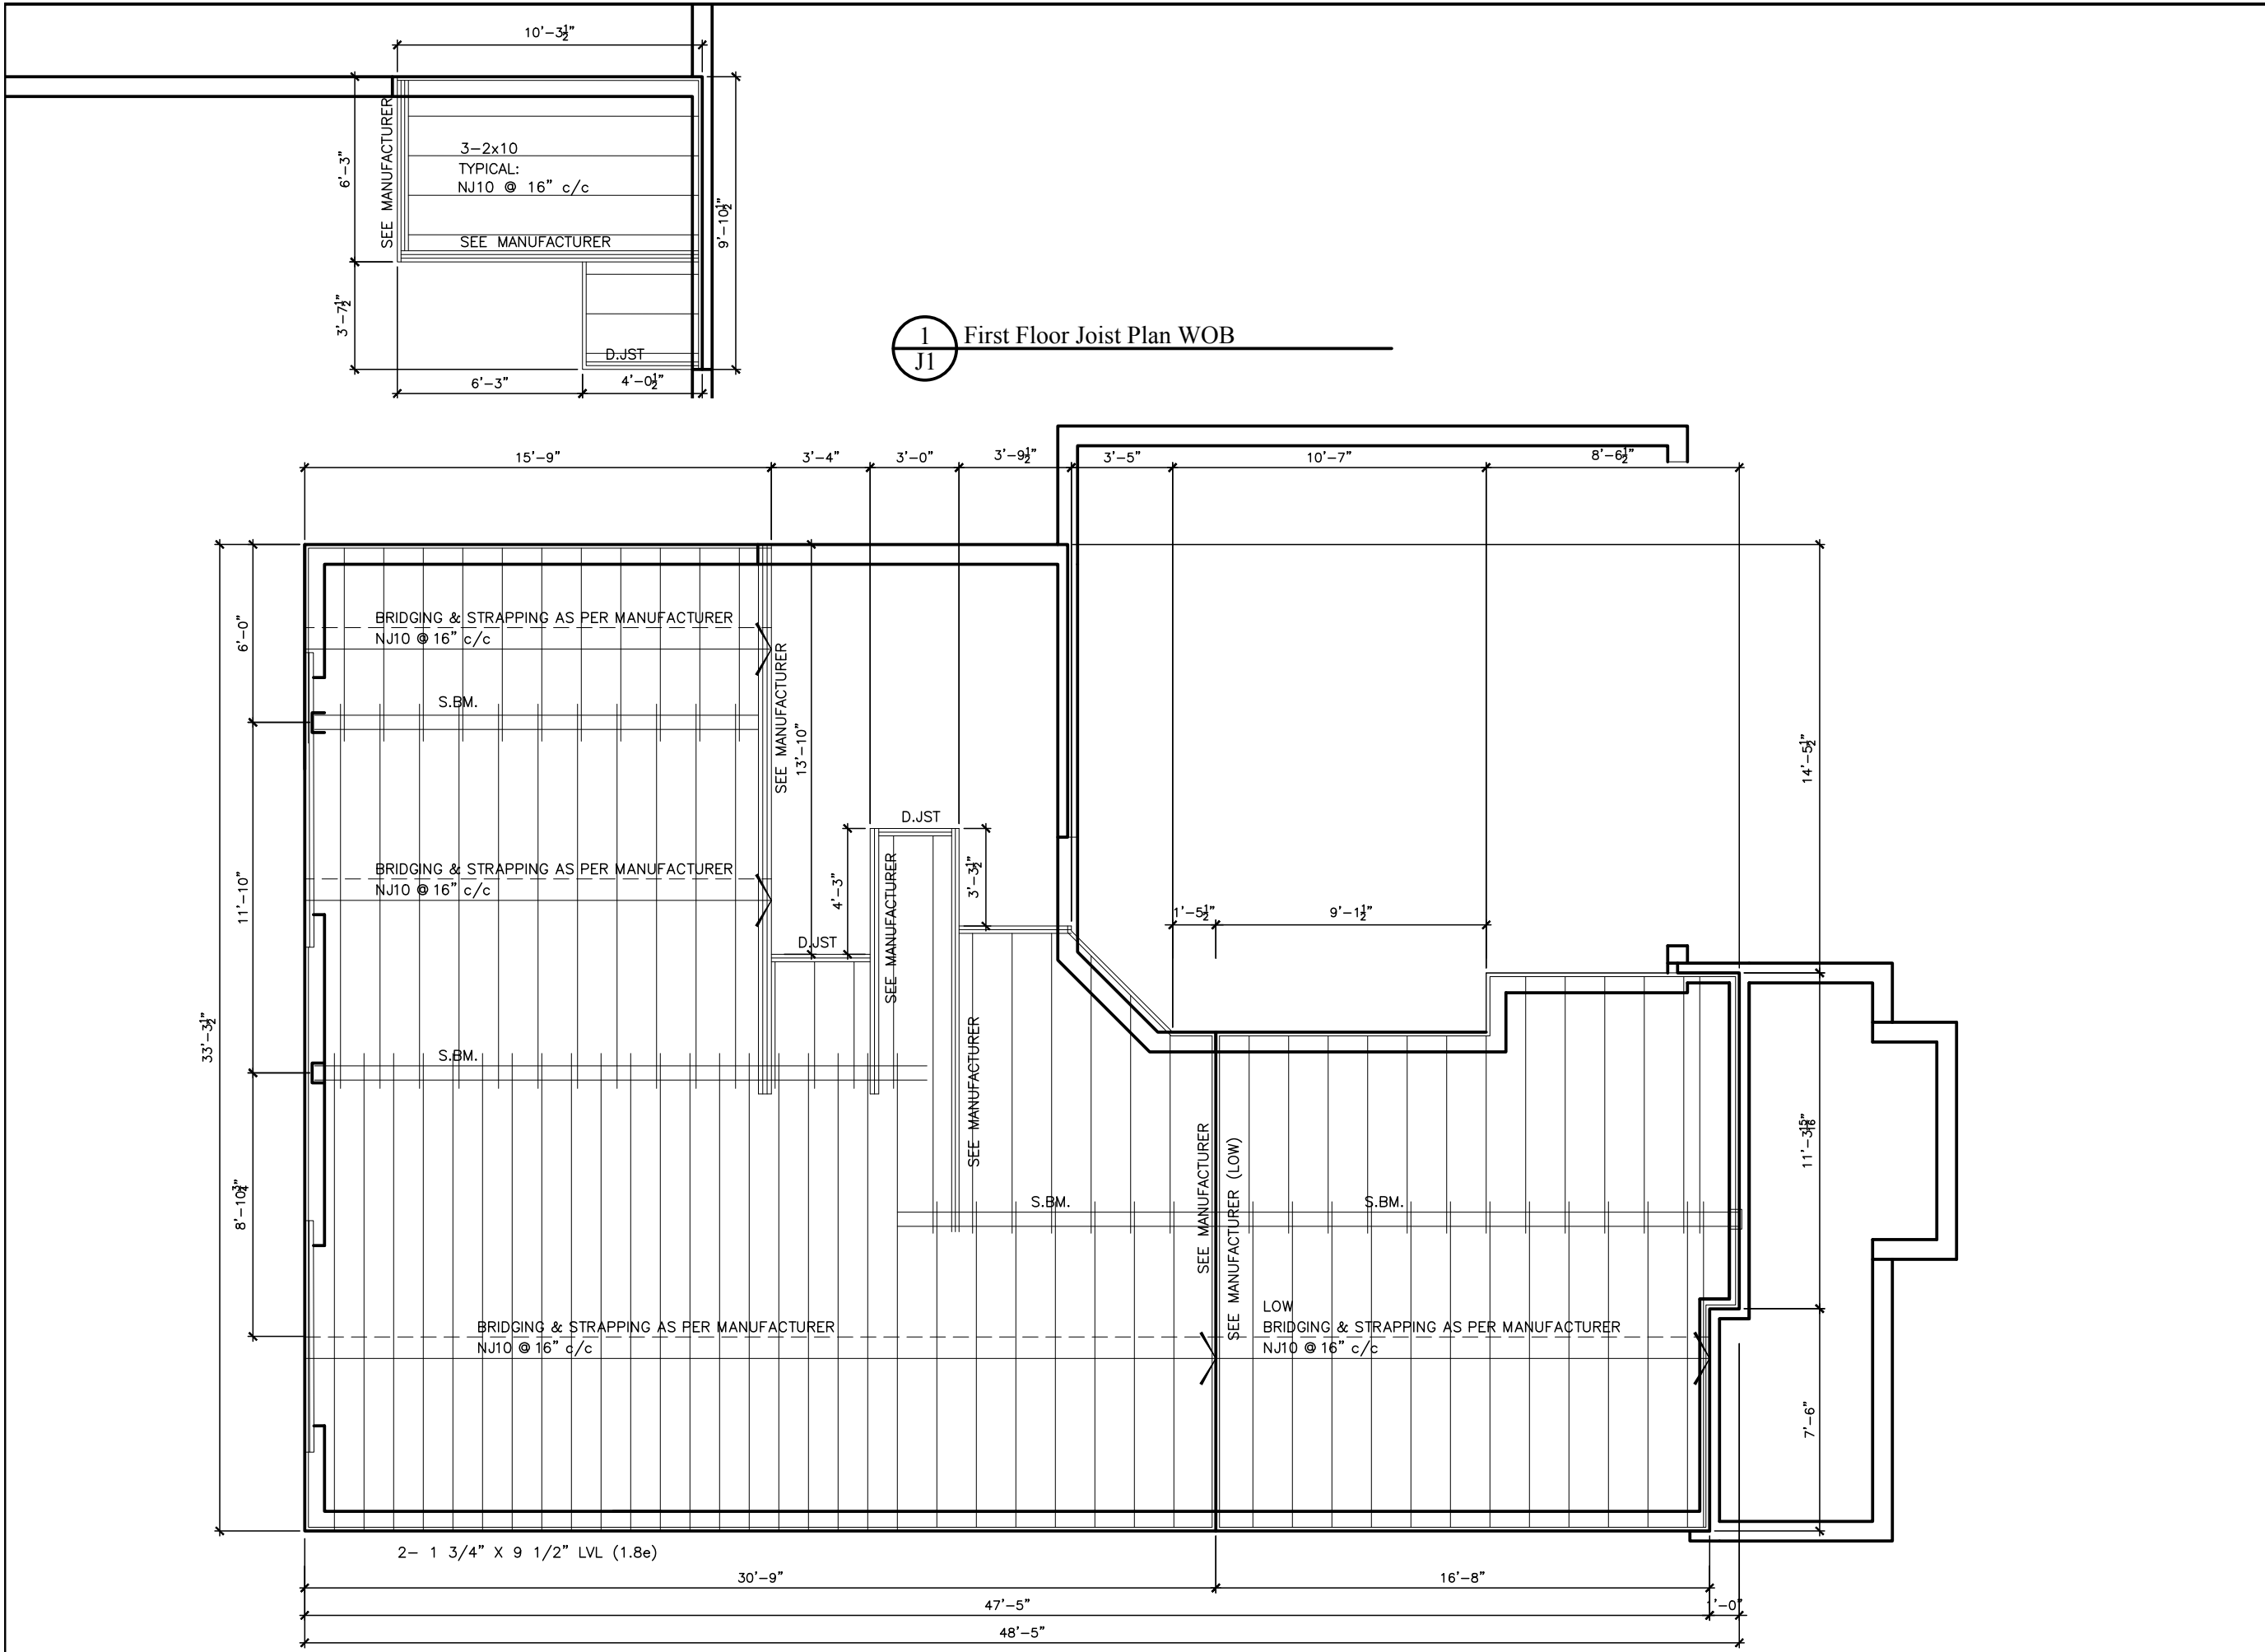

1 First Floor Joist Plan WOB

LOT

XXxx

DATE

XX/XX/XX

THIS DRAWINGS IS TO BE USED IN CONJUNCTION WITH SCHEDULE B-1A AND MAY SHOW ONLY SOME OF THE CHANGES DETAILED ON THAT DOCUMENT. SHOULD THE DRAWINGS NOT SHOW ALL ITEMS CONTAINED ON A SCHEDULE OR MISS OTHER ITEMS ALTOGETHER, THE SCHEDULE IS CONSIDERED THE GOVERNING DOCUMENT.

TENDER 2017

I SCOTT IRWIN BCIN 20765 HAVE REVIEWED AND TAKE RESPONSIBILITY FOR DESIGN ACTIVITIES RELATING TO, HOUSE & SMALL BUILDINGS.

2012 OBC DRAWINGS

2.	AS PER STRUCTURAL	09/09/16	
1.	STANDARD DRAWINGS	02/11/15	SI
NO.	DESCRIPTION	DATE	BY

Valecraft
Homes Ltd.

TITLE:

 
 
1st Floor Joist Plan

ACAD FILE:


SCALE:
3/16" = 1'-0"

1050-The McCaslin
2012 Footprint
(STANDARD DRAWINGS)

DWG.
J-1b

$$\frac{1}{J_2}$$


LOT _____	XXxx
DATE _____	XX/XX/XX
THIS DRAWINGS IS TO BE USED IN CONJUNCTION WITH SCHEDULE B-1A AND MAY SHOW ONLY SOME OF THE CHANGES DETAILED ON THAT DOCUMENT. SHOULD THE DRAWINGS NOT SHOW ALL ITEMS CONTAINED ON A SCHEDULE OR MISS OTHER ITEMS ALTOGETHER, THE SCHEDULE IS CONSIDERED THE GOVERNING DOCUMENT. FLOORS CONT	
TENDER 2017	
I SCOTT IRWIN BCIN 20765 HAVE REVIEWED AND TAKE RESPONSIBILITY FOR DESIGN ACTIVITIES RELATING TO, HOUSE & SMALL BUILDINGS_____.	
2012 OBC DRAWINGS	
AS PER STRUCTURAL	09/09/16
STANDARD DRAWINGS	02/11/15 SI
NO DESCRIPTION	DATE BY
Valecraft Homes Ltd.	
TITLE: 2nd Floor Joist Plan	
ACAD FILE:	SCALE: 3/16" = 1'-0"
1050-The McCaslin 2012 Footprint (STANDARD DRAWINGS) DWG. J-2	

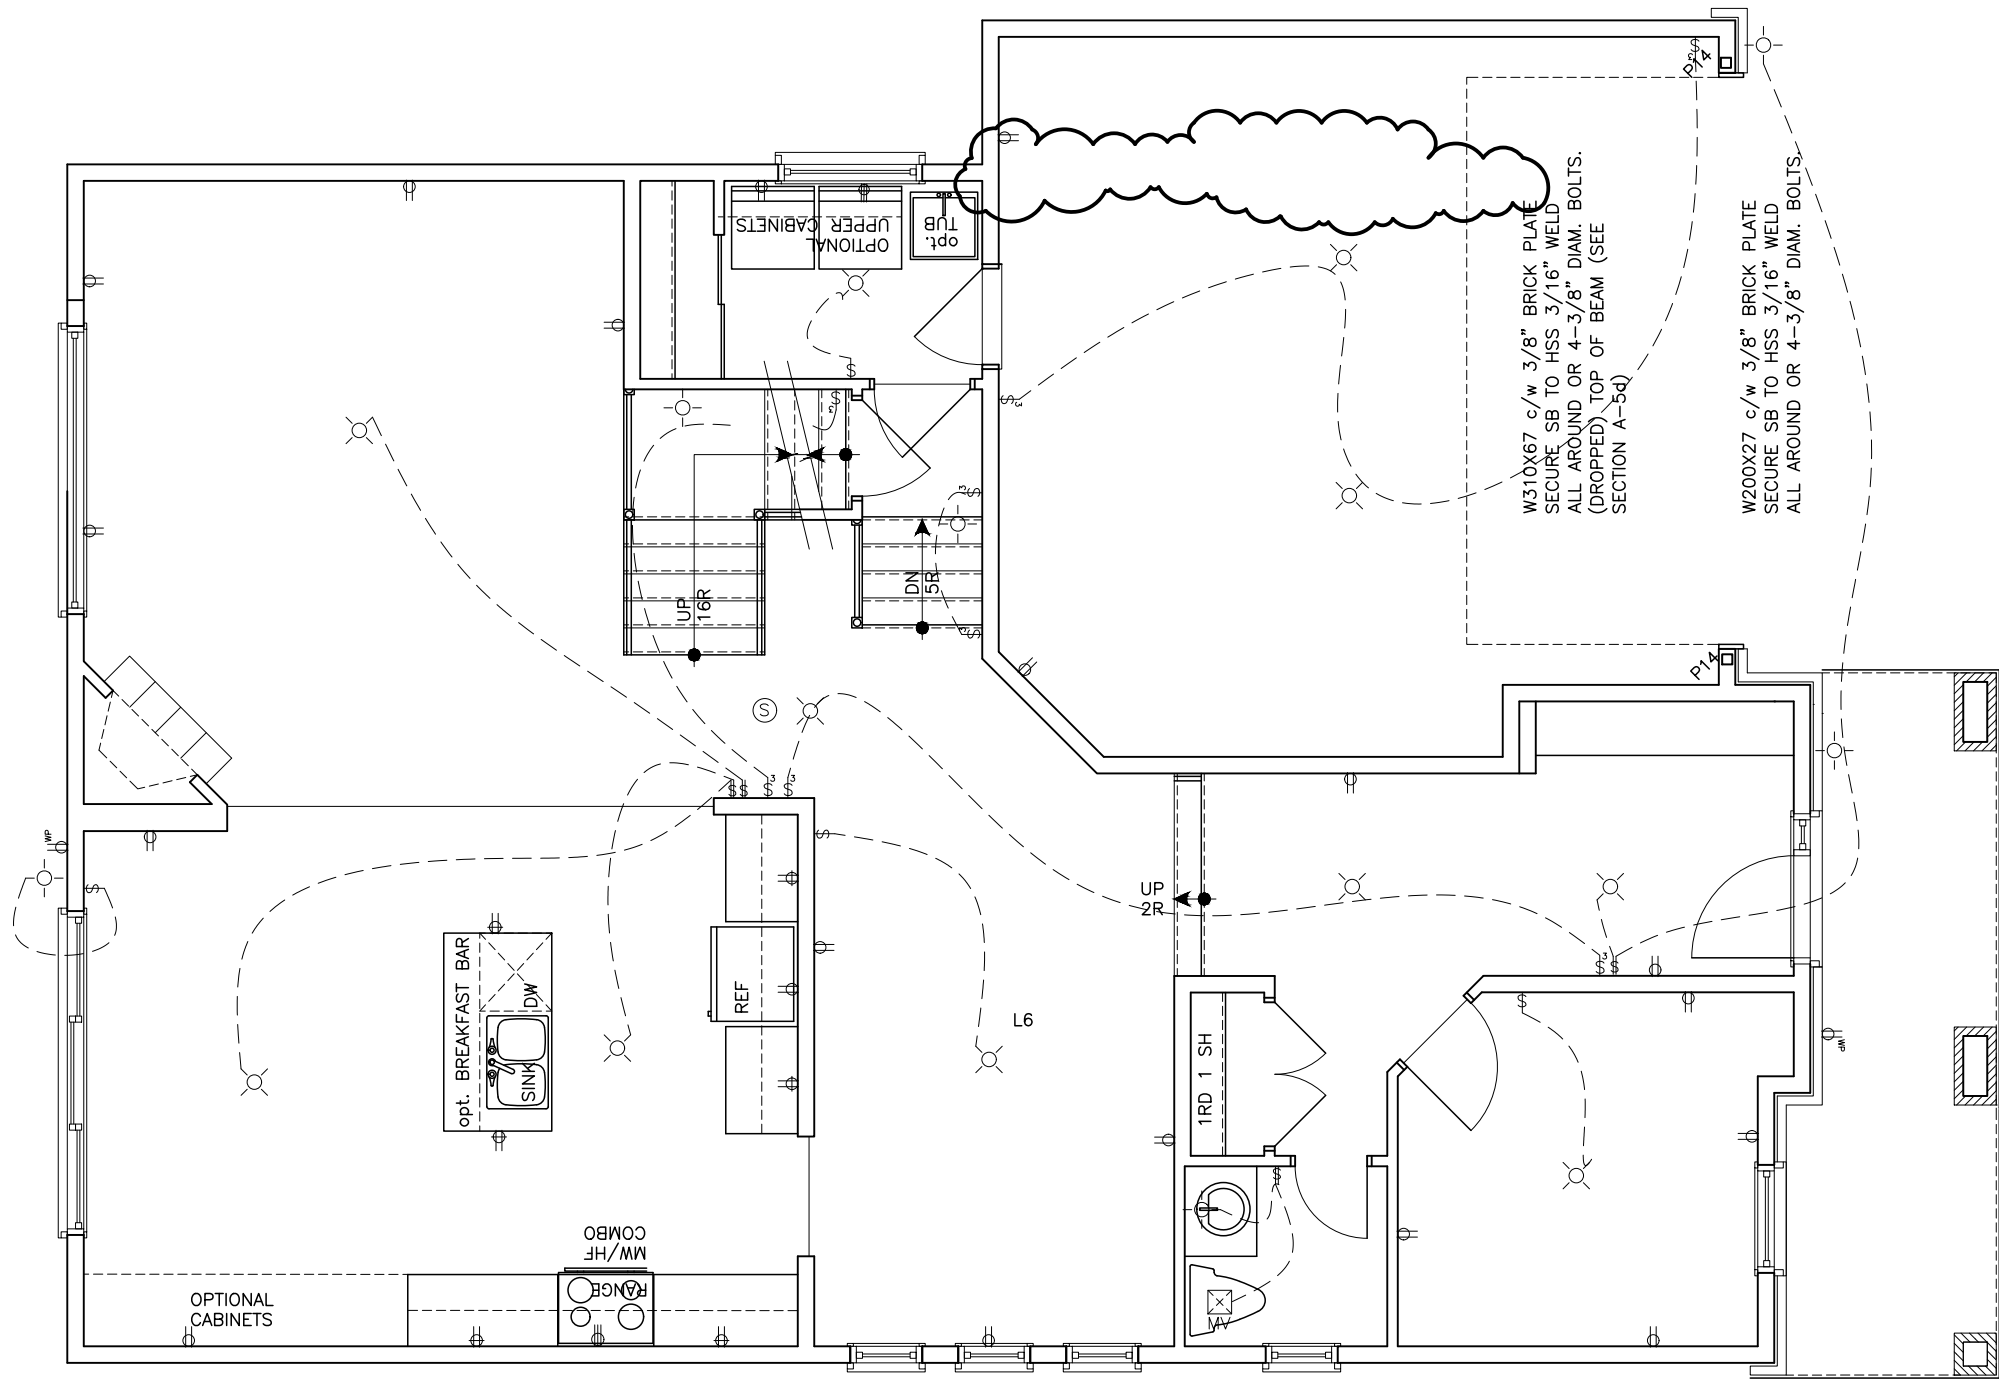

- Duplex Outlet (G.F.I. in all bathrooms)
- 220 V Outlet
- Duplex Outlet (Upper half switched)
- Split Duplex Outlet
- Weather proof Duplex Outlet
- Single pole switch
- 3 way switch
- Double gang switch
- Triple gang switch
- Double gang 3 way switch
- 4 way switch
- Furnace switch
- Ceiling light fixture
- Standard pot light
- Wall mounted light fixture
- Carbon Monoxide detector interconnected with smoke alarms
- Carbon Monoxide detector interconnected with smoke alarms
- Electrical panel
- Mechanical vent
- Dryer
- Washer
- Thermostat
- Standard telephone jack
- Cable television outlet.
- Central vacuum location (Optional)
- Ceiling light fixture
- Pull Chain

1 First Floor Electrical Plan
E1

LOT XXXX

DATE XX/XX/XX

THIS DRAWING IS TO BE USED IN CONJUNCTION WITH SCHEDULE B-1A AND MAY SHOW ONLY SOME OF THE CHANGES DETAILED ON THAT DOCUMENT. SHOULD THE DRAWINGS NOT SHOW ALL ITEMS CONTAINED ON A SCHEDULE OR MISS OTHER ITEMS ALTOGETHER, THE SCHEDULE IS CONSIDERED THE GOVERNING DOCUMENT.

I SCOTT IRWIN BCIN 20765 HAVE REVIEWED AND TAKE RESPONSIBILITY FOR DESIGN ACTIVITIES RELATING TO, HOUSE & SMALL BUILDINGS.

2012 OBC DRAWINGS

NO	DESCRIPTION	DATE	BY
2.	AS PER STRUCTURAL	09/09/16	
1.	STANDARD DRAWINGS	02/11/15	SI



TITLE:
1st Floor Electrical Plan

ACAD FILE: SCALE: 3/16" = 1'-0"

1050-The McCaslin
2012 Footprint
(STANDARD DRAWINGS)
E-1

THIS DRAWING IS TO BE USED IN CONJUNCTION WITH SCHEDULE B-1A AND MAY SHOW ONLY SOME OF THE CHANGES DETAILED ON THAT DOCUMENT. SHOULD THE DRAWINGS NOT SHOW ALL ITEMS CONTAINED ON A SCHEDULE OR MISS OTHER ITEMS ALTOGETHER, THE SCHEDULE IS CONSIDERED THE GOVERNING DOCUMENT.
FLOORS CONT

I SCOTT IRWIN BCIN 20765 HAVE REVIEWED AND TAKE RESPONSIBILITY FOR DESIGN ACTIVITIES RELATING TO, HOUSE & SMALL BUILDINGS _____.

2012 OBC DRAWINGS

AS PER STRUCTURAL	09/09/16	
STANDARD DRAWINGS	02/11/15	SI
NO DESCRIPTION	DATE	BY



TITLE:
2nd Floor Electrical Plan

ACAD FILE:	SCALE: 3/16" = 1'-0"
------------	-------------------------

1050-The McCaslin 2012 Footprint (STANDARD DRAWINGS)	DWG. E-2
--	-------------

- 














Duplex Outlet (G.F.I. in all bathrooms)

220 V Outlet

Duplex Outlet (Upper half switched)

Split Duplex Outlet

Weather proof Duplex Outlet

Single pole switch

3 way switch

Double gang switch

Triple gang switch

Double gang 3 way switch

4 way switch

Furnace switch

Ceiling light fixture

Standard pot light















Wall mounted light fixture

Carbon Monoxide detector interconnected with smoke alarms

Carbon Monoxide detector interconnected with smoke alarms

Electrical panel

Mechanical vent

Dryer

Washer

Thermostat

Standard telephone jack

Cable television outlet.

Central vacuum location (Optional)

Ceiling light fixture

Pull Chain
-
- OPTIONAL. 4PC ENSUITE
-
- 1
E2 Second Floor Electrical Plan