

THIS DRAWING IS TO BE USED IN CONJUNCTION WITH SCHEDULE B-1A AND MAY SHOW ONLY SOME OF THE CHANGES DETAILED ON THAT DOCUMENT. SHOULD THE DRAWINGS NOT SHOW ALL ITEMS CONTAINED ON A SCHEDULE OR MISS OTHER ITEMS ALTOGETHER, THE SCHEDULE IS CONSIDERED THE GOVERNING DOCUMENT.

TENDER 2017

I SCOTT IRWIN BCIN 20765 HAVE REVIEWED AND TAKE
RESPONSIBILITY FOR DESIGN ACTIVITIES RELATING TO,
HOUSE & SMALL BUILDINGS_____.

EXTERIOR FINISH LEGEND

- B - BRICK (MAIN)
- B1 - BRICK SOLDIER COURSE (ACCENT)
- B2 - BRICK SOLDIER COURSE (ACCENT)
20mm PROUD
- B3 - BRICK SLEEPER COURSE
- B4 - STACK BOND (ACCENT)
- B5 - BRICK SILL (ACCENT)
- B6 - BRICK ROW LOCK (ACCENT)
- B7 - BRICK CORBELLING
- B8 - BRICK COINING 20mm PROUD
- +20 - BRICK 20mm PROUD
- 20 - BRICK RECESSED 20mm
- S - SIDING (HORIZONTAL)
- ST - STONE VENEER
- T - TRIM 200mm COVE SIDING
- AF - ALUMINUM FACSIA
- AC - ALUMINUM CLADDING
- AS - ASPHALT SHINGLES
- F - FLASHING
- V - ROOF VENT MAX
- P - PARGING
- PC - PRECAST
- PCH10 - PRECAST HEADER 10"
- PCH8 - PRECAST HEADER 8"
- PCS - PRECAST SILL
- PCB - PRECAST BAND
- VS - VINYL SHAKES

2012 OBC DRAWINGS



2.	AS PER STRUCTURAL		
1.	STANDARD DRAWINGS	02/11/15	S
NO	DESCRIPTION	DATE	BY



TITLE: Front Elevation A

ACAD FILE:	SCALE: 3/16" = 1'-0"
------------	-------------------------

1086-The Steel 2012 Footprint (STANDARD DRAWINGS)	DWG. A-1
---	-----------------

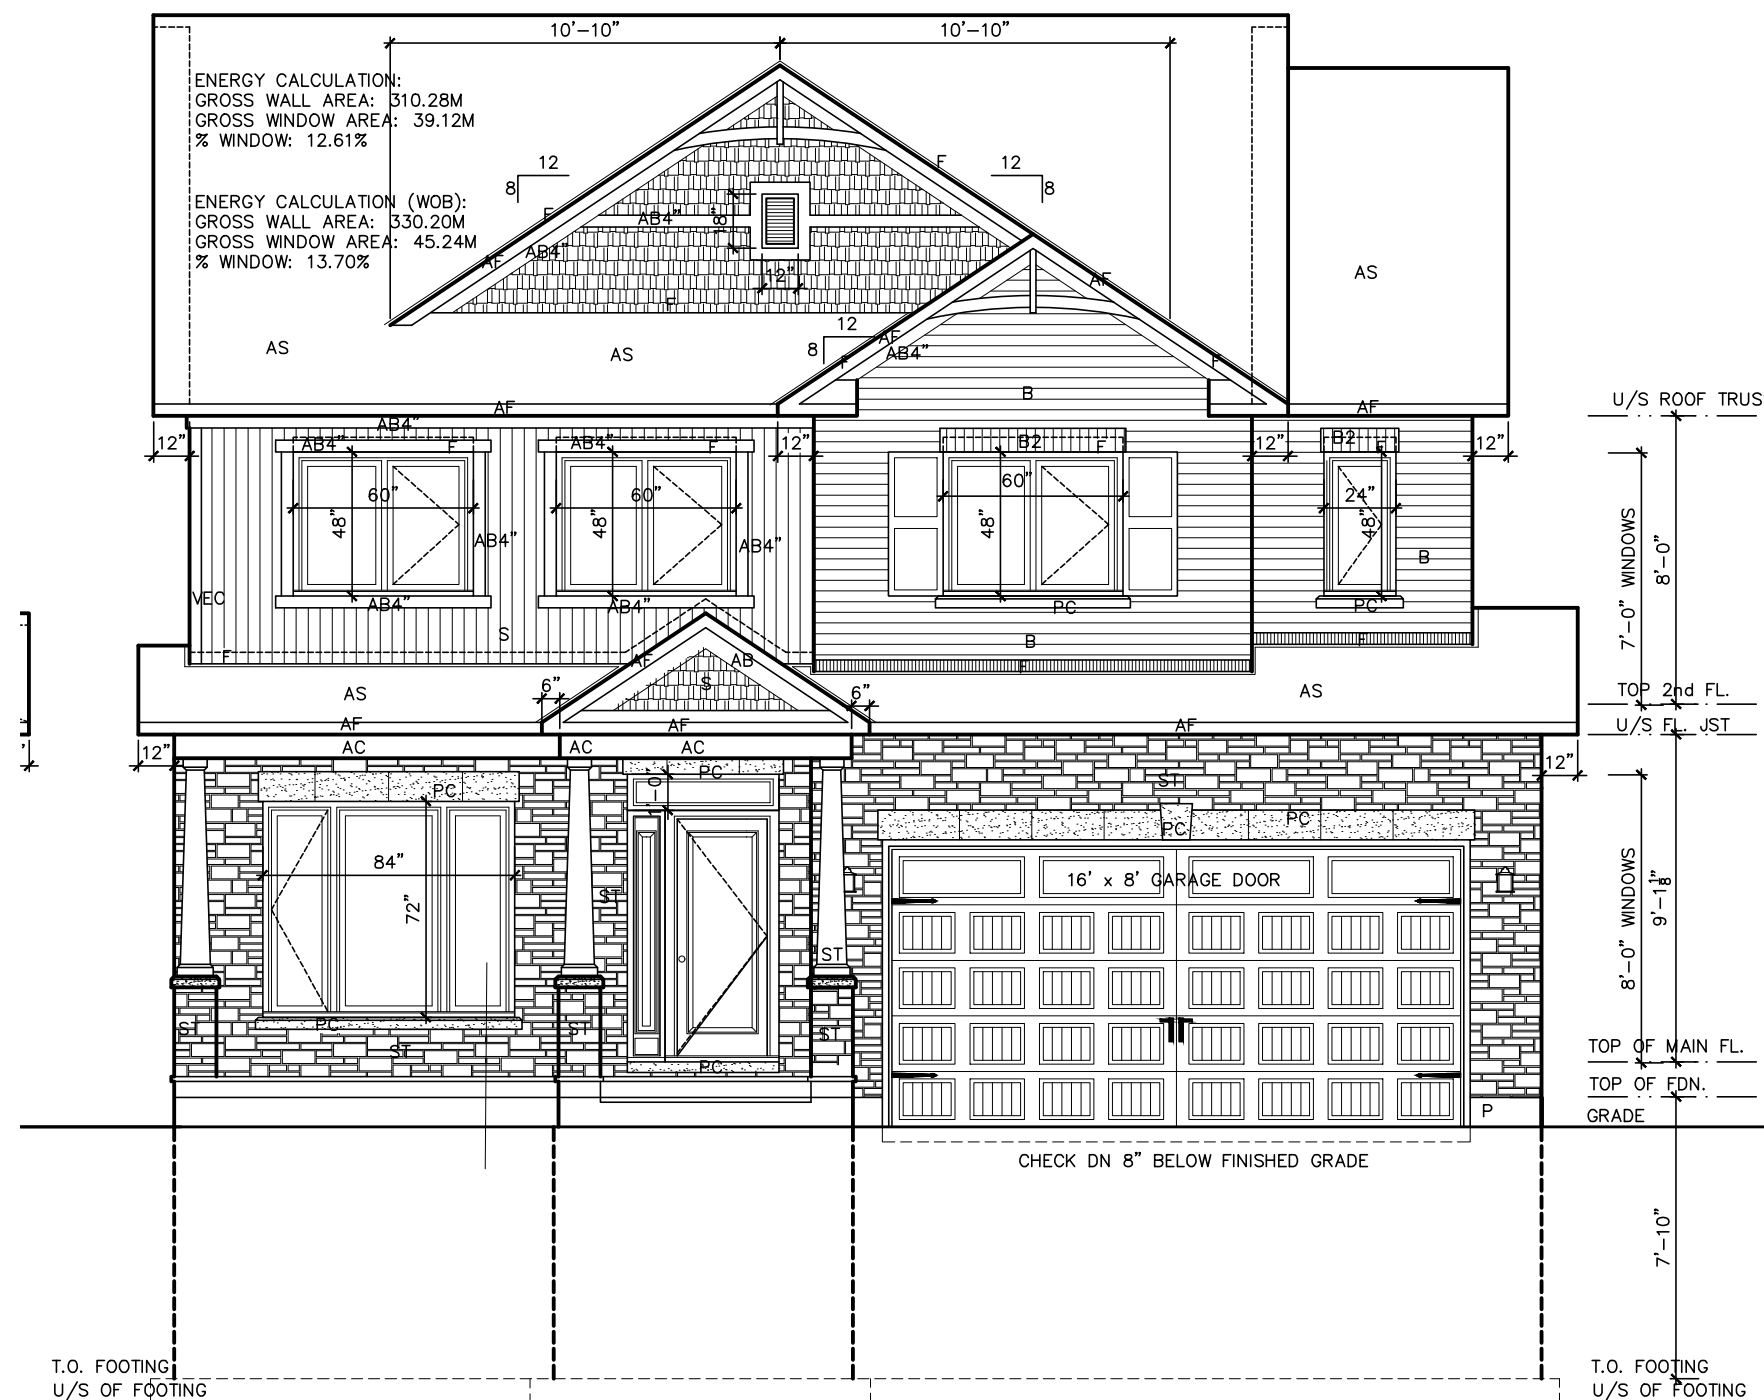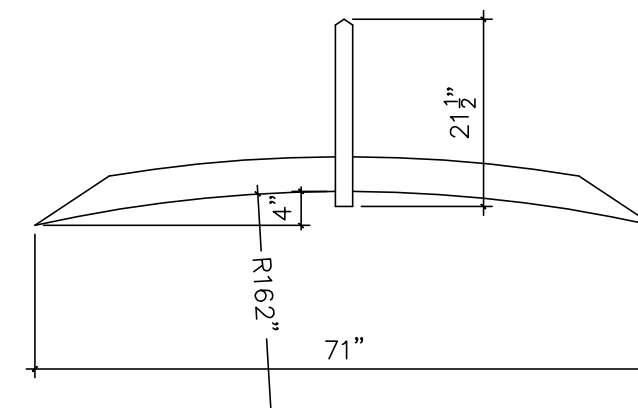

Front Elevation A



Front Elevation B

LOT XXxx

DATE XX/XX/XX

THIS DRAWING IS TO BE USED IN CONJUNCTION WITH SCHEDULE B-1A AND MAY SHOW ONLY SOME OF THE CHANGES DETAILED ON THAT DOCUMENT. SHOULD THE DRAWINGS NOT SHOW ALL ITEMS CONTAINED ON A SCHEDULE OR MISS OTHER ITEMS ALTOGETHER, THE SCHEDULE IS CONSIDERED THE GOVERNING DOCUMENT.

TENDER 2017

I SCOTT IRWIN BCIN 20765 HAVE REVIEWED AND TAKE RESPONSIBILITY FOR DESIGN ACTIVITIES RELATING TO, HOUSE & SMALL BUILDINGS.

EXTERIOR FINISH LEGEND

- B - BRICK (MAIN)
- B1 - BRICK SOLDIER COURSE (ACCENT)
- B2 - BRICK SOLDIER COURSE (ACCENT)
- B3 - BRICK SLEEPER COURSE
- B4 - STACK BOND (ACCENT)
- B5 - BRICK SILL (ACCENT)
- B6 - BRICK ROW LOCK (ACCENT)
- B7 - BRICK CORBELLING
- B8 - BRICK COINING 20mm PROUD
- +20 - BRICK 20mm PROUD
- 20 - BRICK RECESSED 20mm
- S - SIDING (HORIZONTAL)
- ST - STONE VENEER
- T - TRIM 200mm COVE SIDING
- AF - ALUMINUM FACSLA
- AC - ALUMINUM CLADDING
- AS - ASPHALT SHINGLES
- F - FLASHING
- V - ROOF VENT MAX
- P - PARGING
- PC - PRECAST
- PCH10 - PRECAST HEADER 10"
- PCH8 - PRECAST HEADER 8"
- PCS - PRECAST SILL
- PCB - PRECAST BAND
- VS - VINYL SHAKES

2012 OBC DRAWINGS


NO.	DESCRIPTION	DATE	BY
3.	AS PER STRUCTURAL		
2.	2nd FLOOR SIDING HORIZONTAL	29/02/16	SI
1.	STANDARD DRAWINGS	02/11/15	SI



TITLE: Front Elevation B

ACAD FILE: SCALE: 3/16" = 1'-0"

1086-The Steel 2012 Footprint (STANDARD DRAWINGS) A-1b

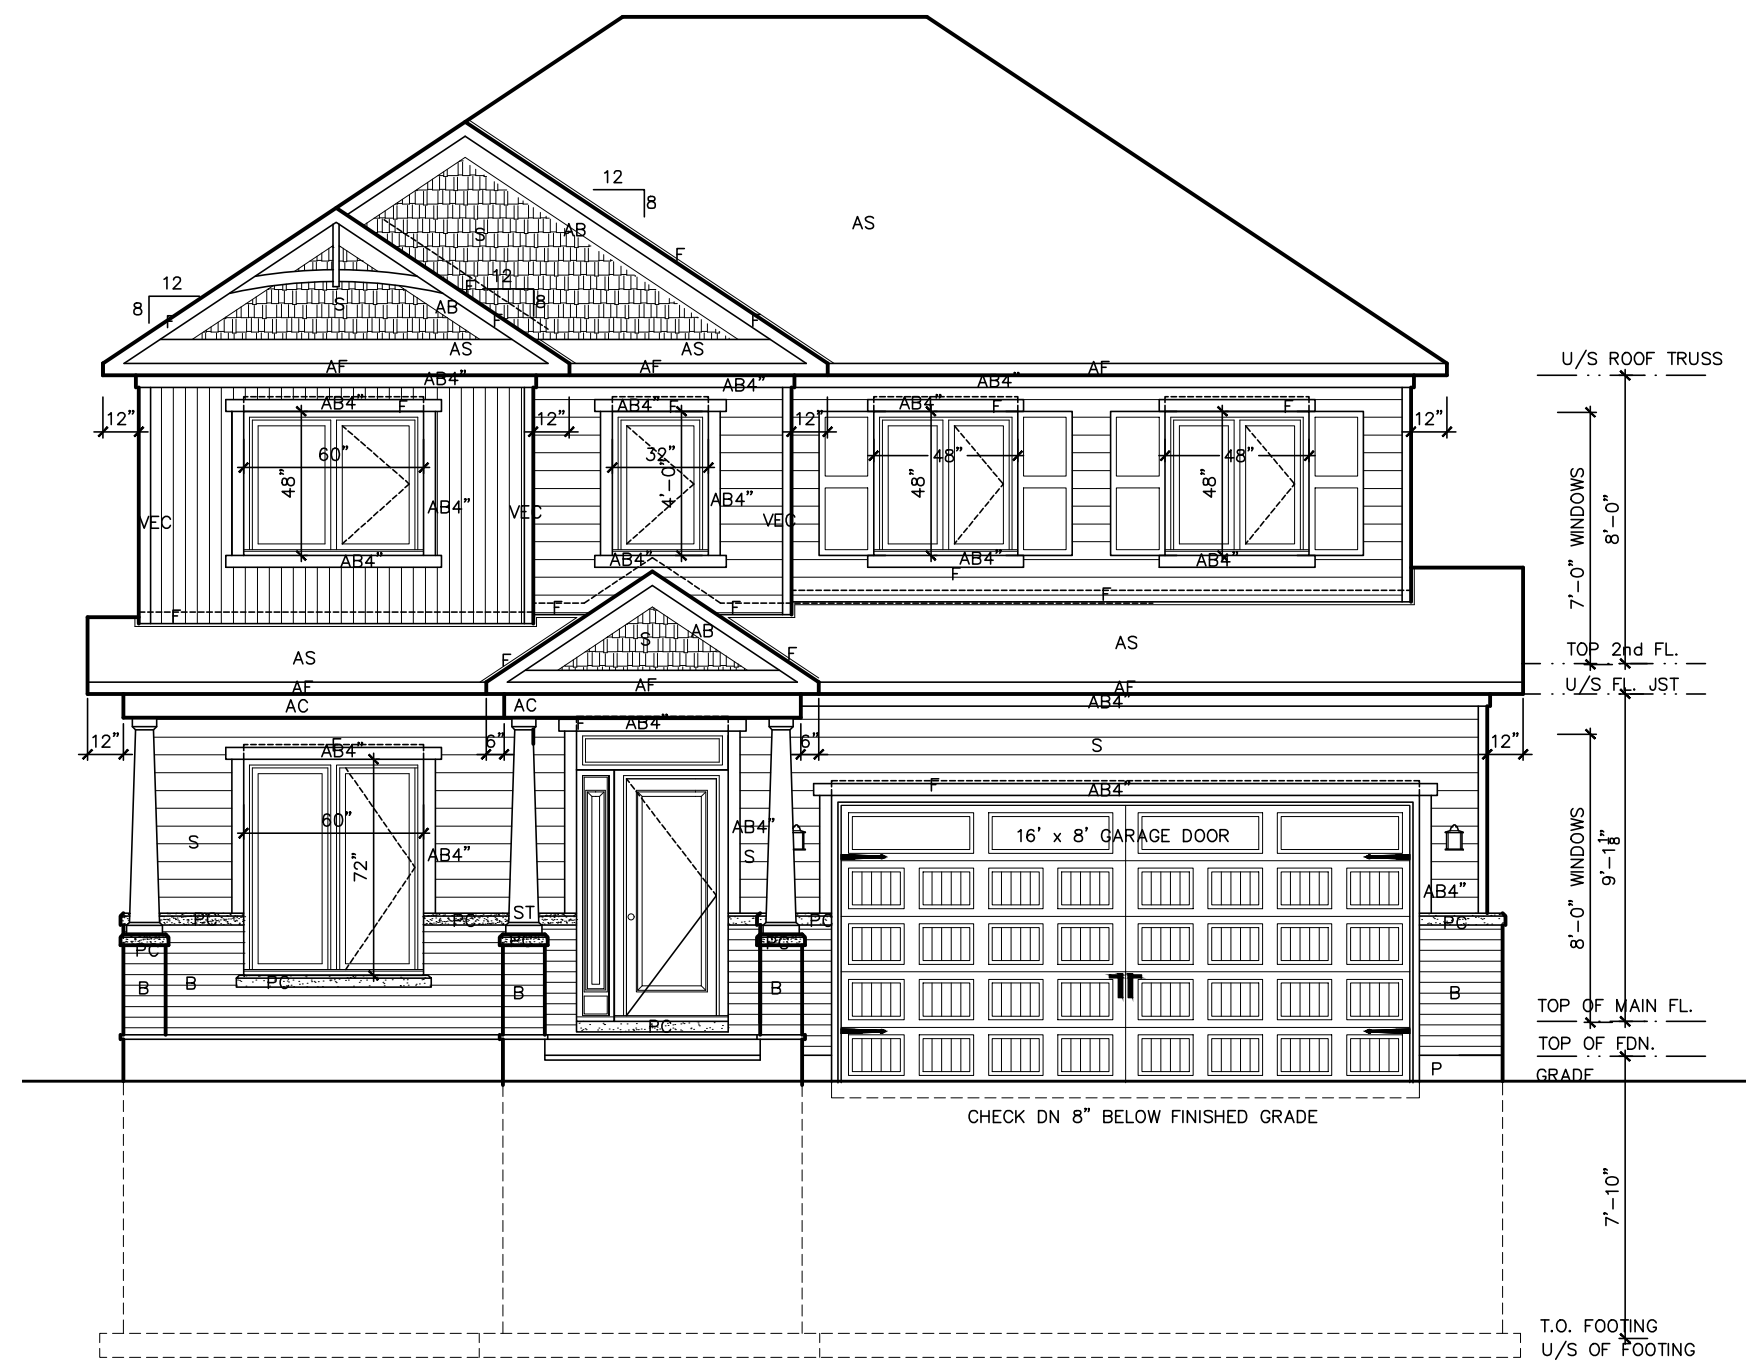

1086-The Steel 2012 Footprint (STANDARD DRAWINGS)	DWG. A-1c
---	------------------

THIS DRAWING IS TO BE USED IN CONJUNCTION WITH SCHEDULE B-1A AND MAY SHOW ONLY SOME OF THE CHANGES DETAILED ON THAT DOCUMENT. SHOULD THE DRAWINGS NOT SHOW ALL ITEMS CONTAINED ON A SCHEDULE OR MISS OTHER ITEMS ALTOGETHER, THE SCHEDULE IS CONSIDERED THE GOVERNING DOCUMENT.
FLOORS CONT

TENDER 2017

I **SCOTT IRWIN BCIN 20765** HAVE REVIEWED AND TAKE RESPONSIBILITY FOR DESIGN ACTIVITIES RELATING TO, HOUSE & SMALL BUILDINGS.

EXTERIOR FINISH LEGEND

- B - BRICK (MAIN)
- B1 - BRICK SOLDIER COURSE (ACCENT)
- B2 - BRICK SOLDIER COURSE (ACCENT) 20mm PROUD
- B3 - BRICK SLEEPER COURSE
- B4 - STACK BOND (ACCENT)
- B5 - BRICK SILL (ACCENT)
- B6 - BRICK ROW LOCK (ACCENT)
- B7 - BRICK CORBELLING
- B8 - BRICK COINING 20mm PROUD
- +20 - BRICK 20mm PROUD
- 20 - BRICK RECESSED 20mm
- S - SIDING (HORIZONTAL)
- ST - STONE VENEER
- T - TRIM 200mm COVE SIDING
- AF - ALUMINUM FACIA
- AC - ALUMINUM CLADDING
- AS - ASPHALT SHINGLES
- F - FLASHING
- V - ROOF VENT MAX
- P - PARGING
- PC - PRECAST
- PCH10 - PRECAST HEADER 10"
- PCH8 - PRECAST HEADER 8"
- PCS - PRECAST SILL
- PCB - PRECAST BAND
- VS - VINYL SHAKES

2012 OBC DRAWINGS


2.	AS PER STRUCTURAL		
1.	STANDARD DRAWINGS	02/11/15	SI
NO.	DESCRIPTION	DATE	BY




TITLE: Left Side Elevation A

ACAD FILE: SCALE: 3/16" = 1'-0"

1086-The Steel 2012 Footprint (STANDARD DRAWINGS) DWG. A-2

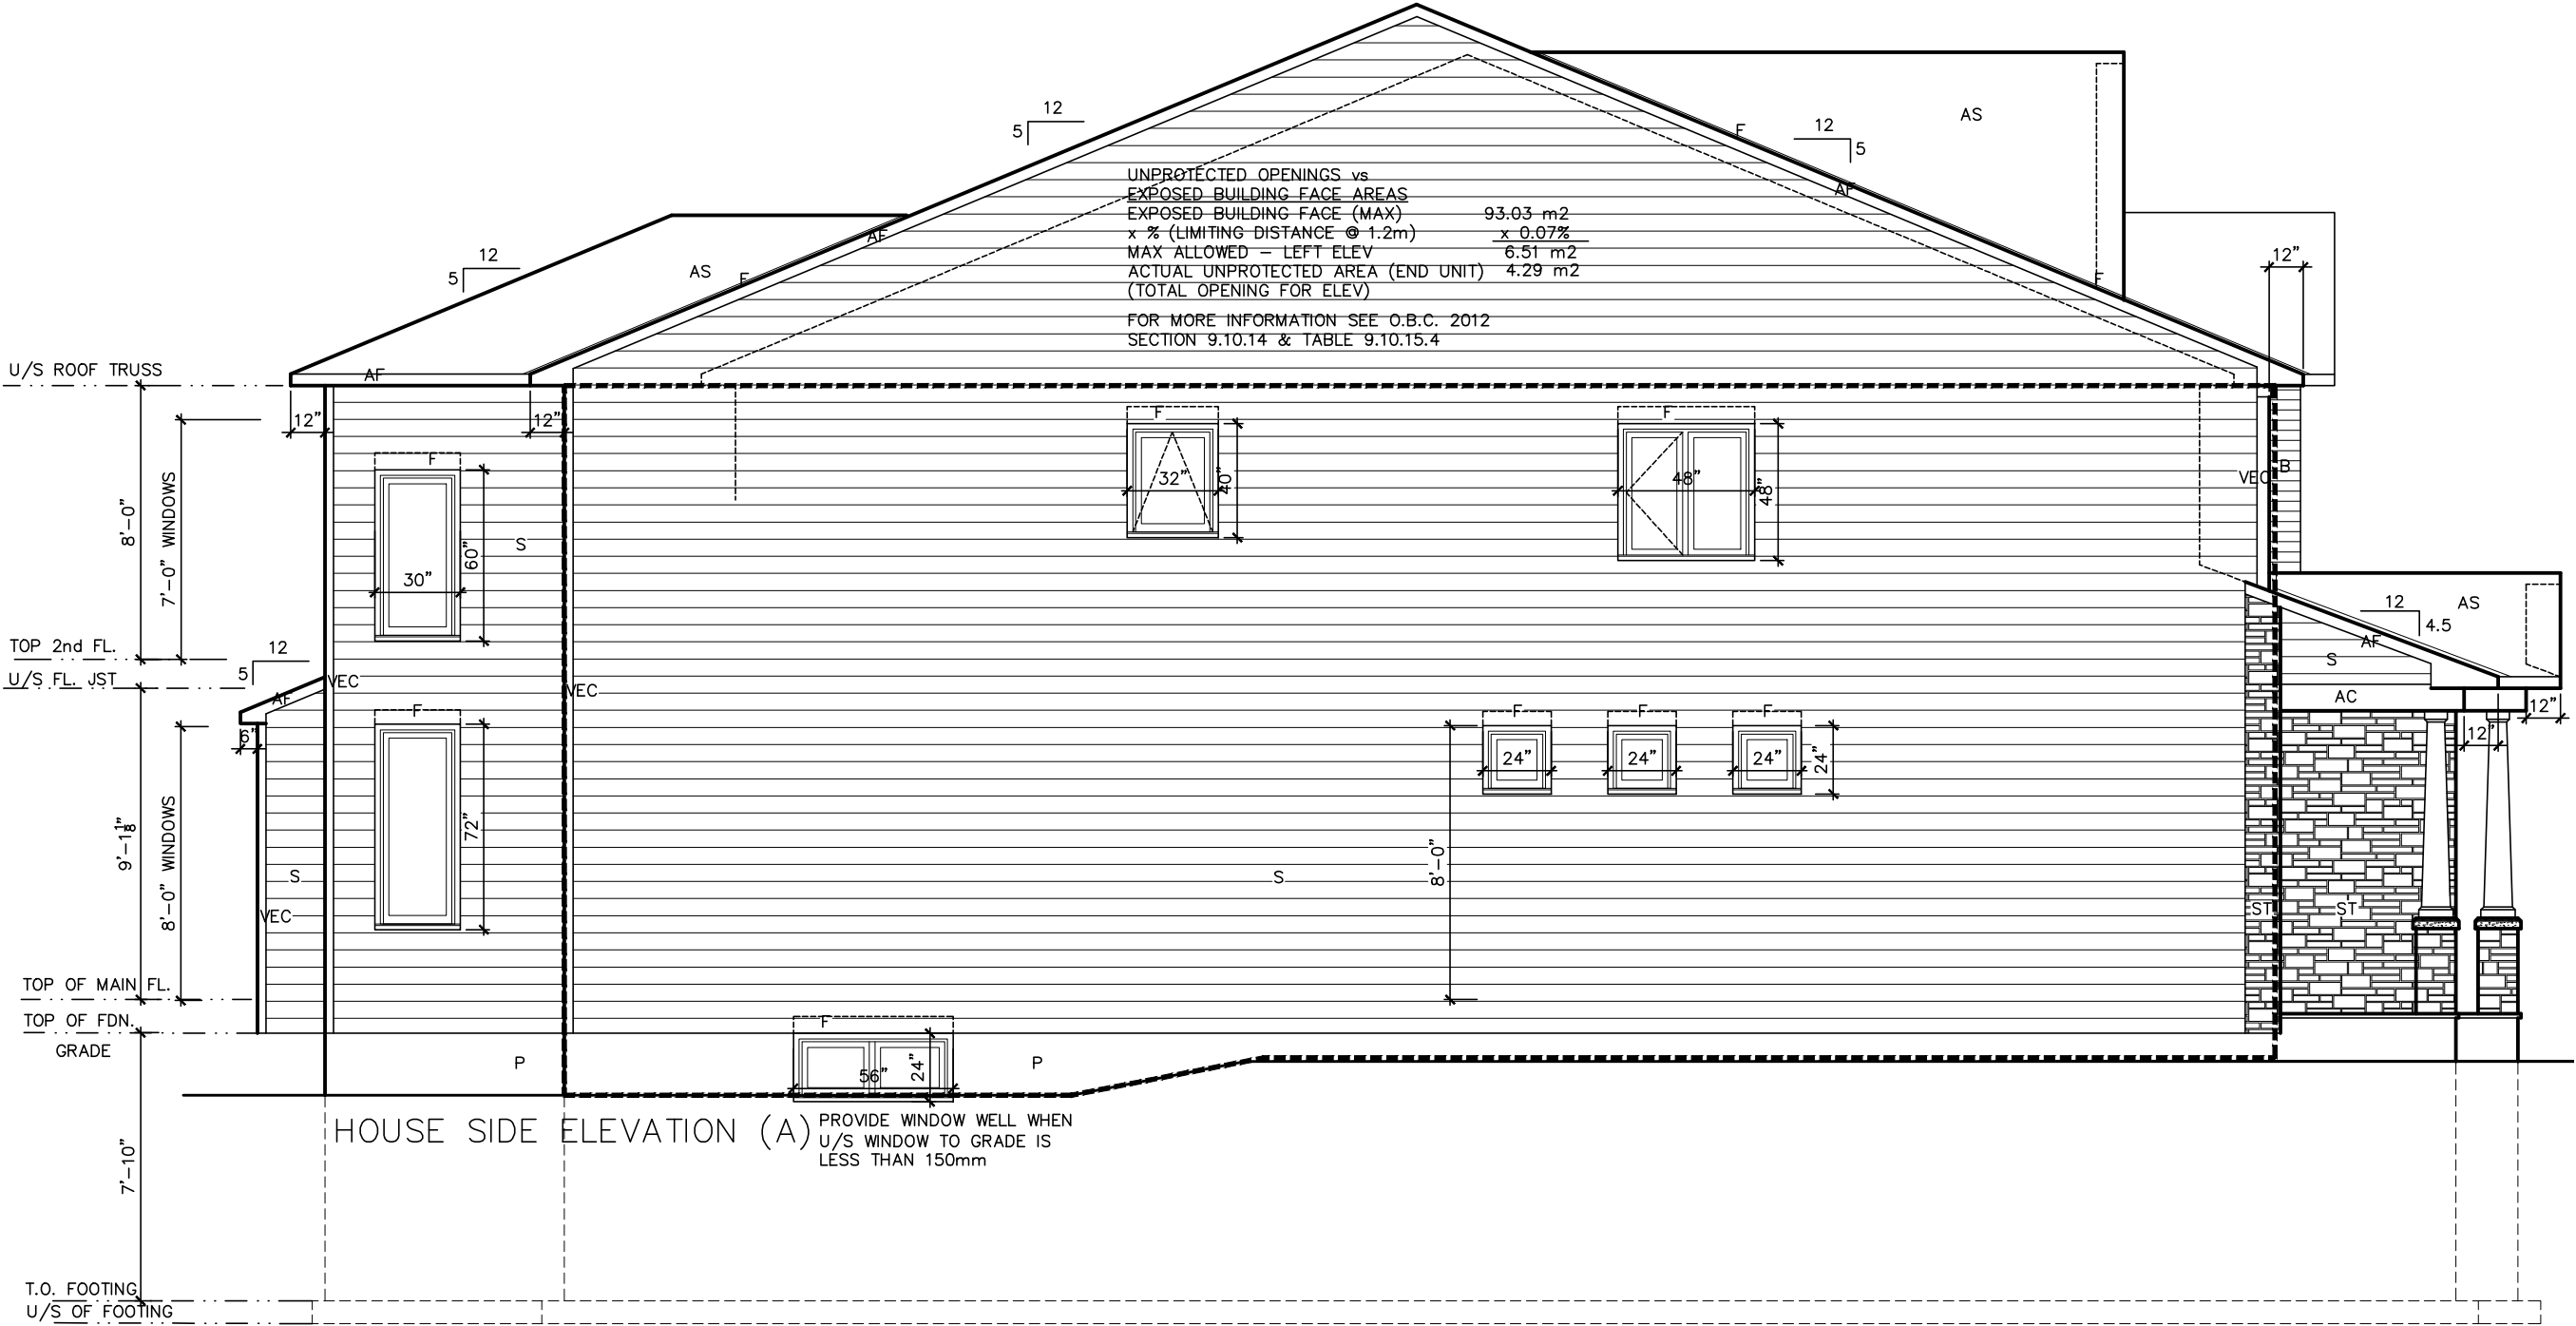

Left Side Elevation A

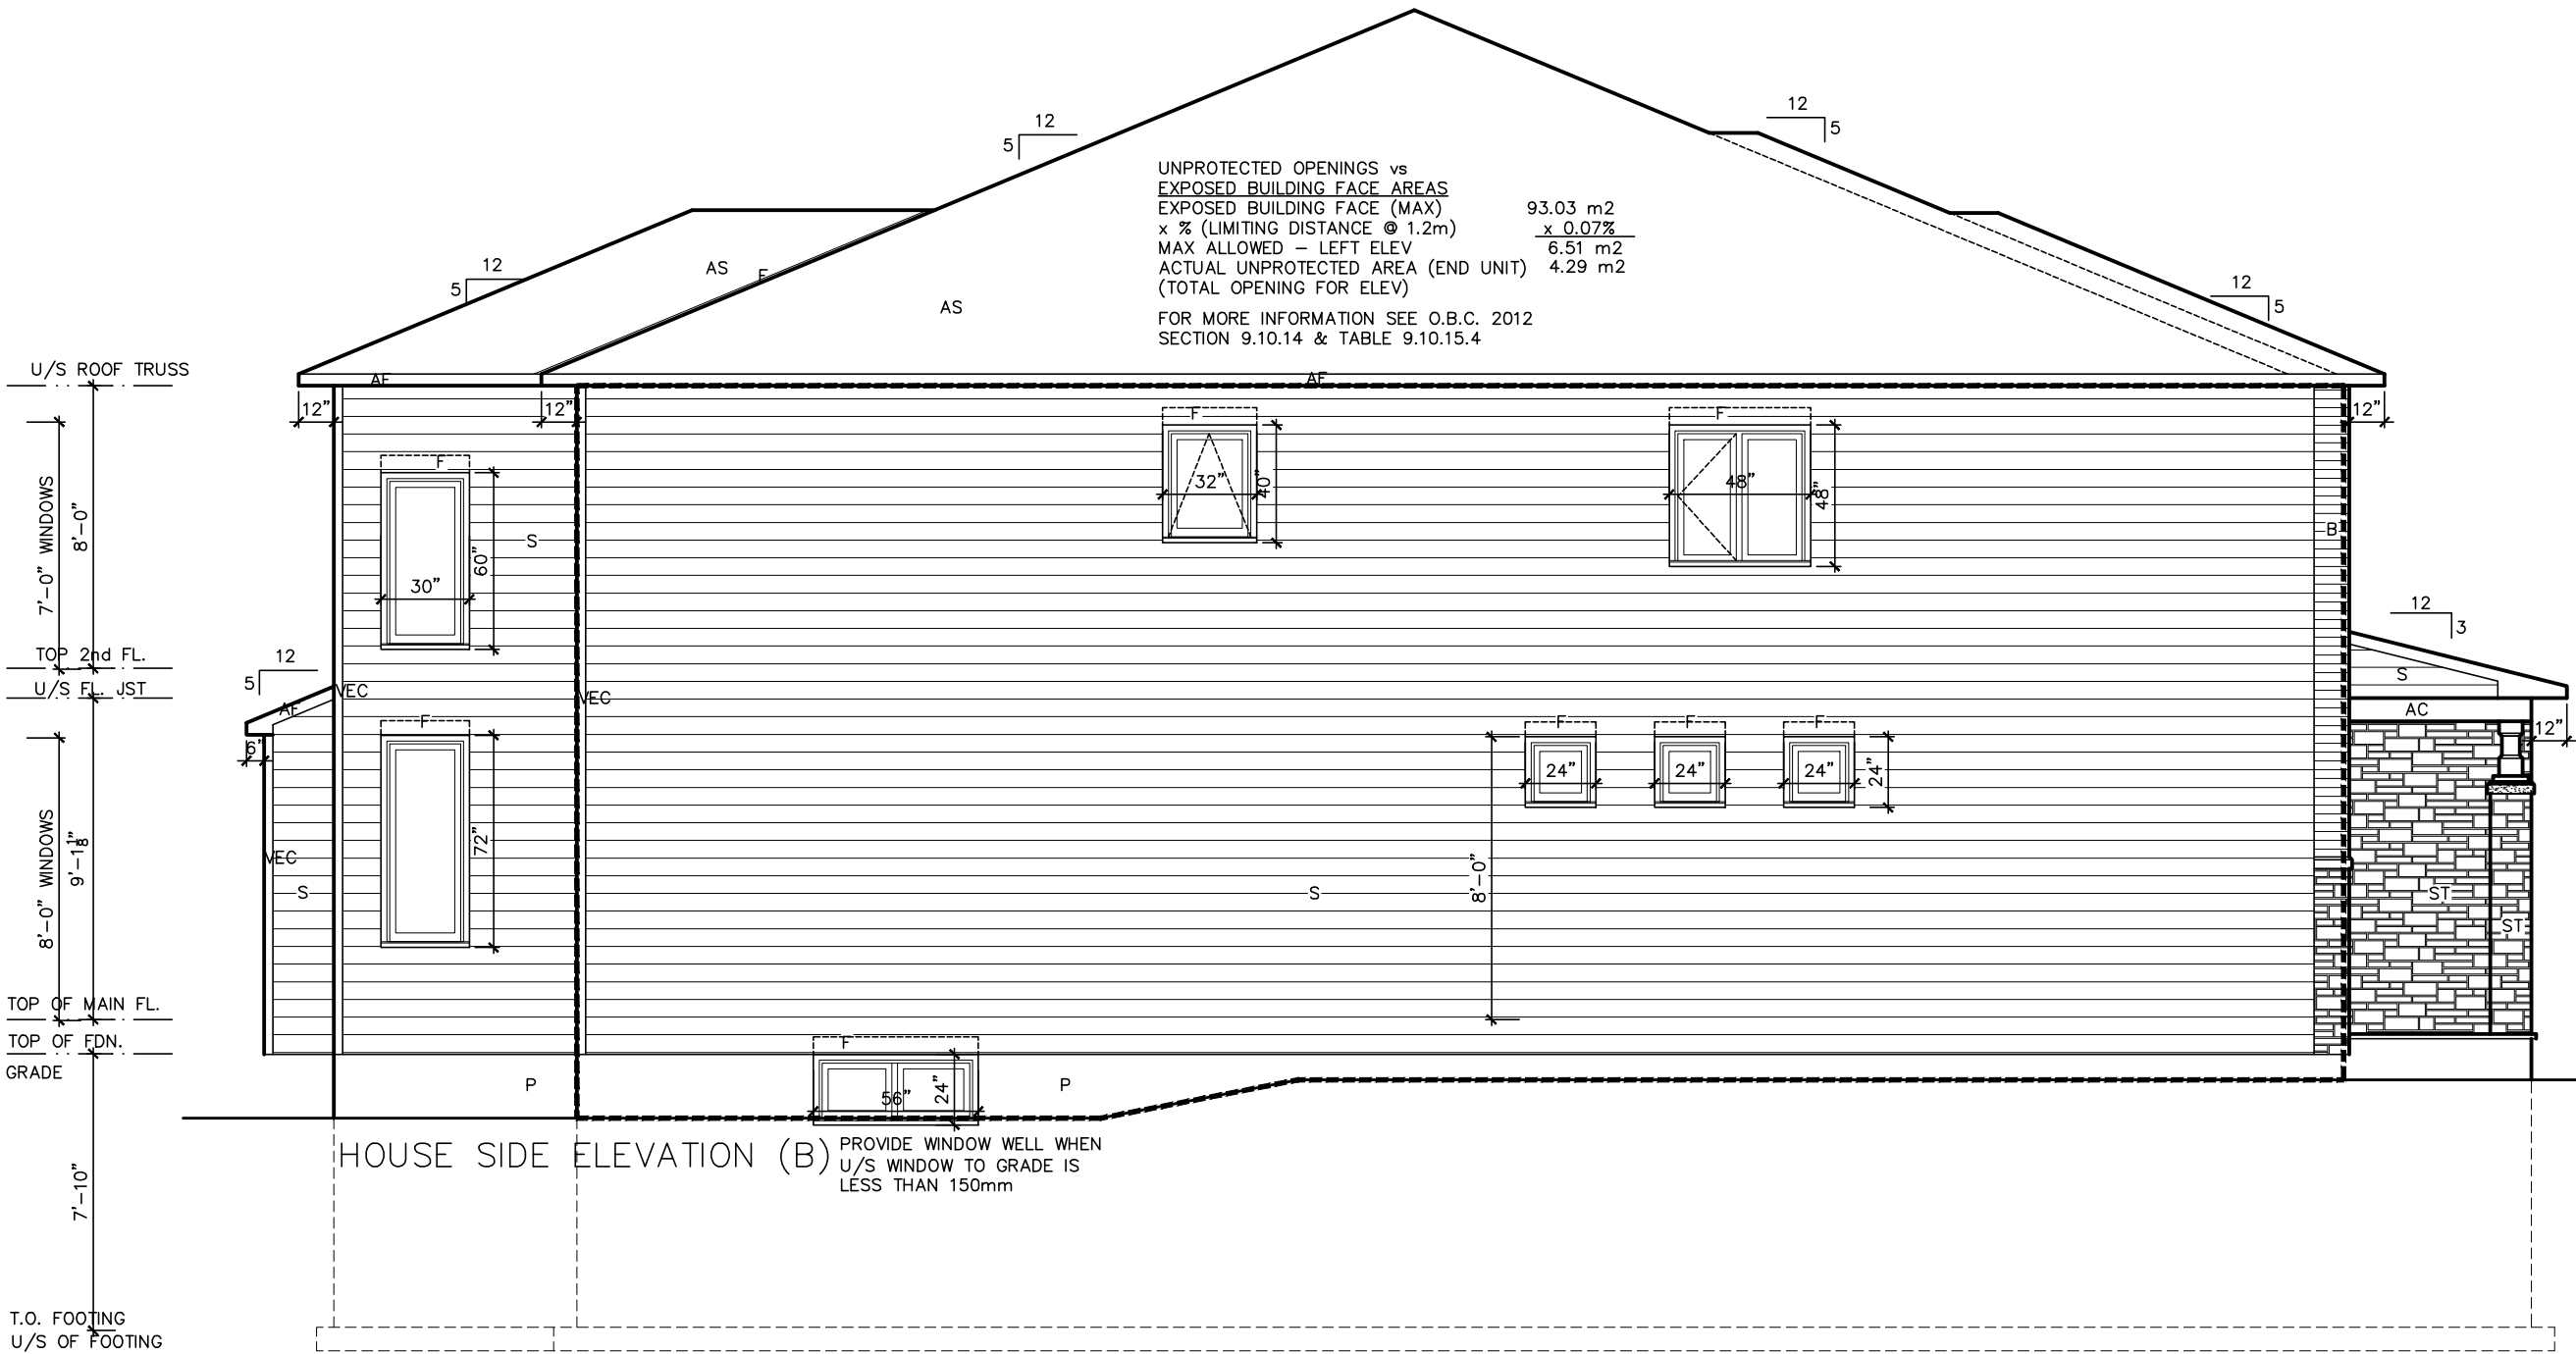

Left Side Elevation B

UNPROTECTED OPENINGS vs
EXPOSED BUILDING FACE AREAS
EXPOSED BUILDING FACE (MAX) 93.03 m2
x % (LIMITING DISTANCE @ 1.2m) x 0.07%
MAX ALLOWED - LEFT ELEV 6.51 m2
ACTUAL UNPROTECTED AREA (END UNIT) 4.29 m2
(TOTAL OPENING FOR ELEV)
FOR MORE INFORMATION SEE O.B.C. 2012
SECTION 9.10.14 & TABLE 9.10.15.4

LOT XXxx

DATE XX/XX/XX

THIS DRAWING IS TO BE USED IN CONJUNCTION WITH SCHEDULE B-1A AND MAY SHOW ONLY SOME OF THE CHANGES DETAILED ON THAT DOCUMENT. SHOULD THE DRAWINGS NOT SHOW ALL ITEMS CONTAINED ON A SCHEDULE OR MISS OTHER ITEMS ALTOGETHER, THE SCHEDULE IS CONSIDERED THE GOVERNING DOCUMENT.
FLOORS CONT

TENDER 2017

I SCOTT IRWIN BCIN 20765 HAVE REVIEWED AND TAKE RESPONSIBILITY FOR DESIGN ACTIVITIES RELATING TO, HOUSE & SMALL BUILDINGS.

EXTERIOR FINISH LEGEND

- B - BRICK (MAIN)
- B1 - BRICK SOLDIER COURSE (ACCENT)
- B2 - BRICK SOLDIER COURSE (ACCENT) 20mm PROUD
- B3 - BRICK SLEEPER COURSE
- B4 - STACK BOND (ACCENT)
- B5 - BRICK SILL (ACCENT)
- B6 - BRICK ROW LOCK (ACCENT)
- B7 - BRICK CORBELLING
- B8 - BRICK COINING 20mm PROUD
- +20 - BRICK 20mm PROUD
- 20 - BRICK RECESSED 20mm
- S - SIDING (HORIZONTAL)
- ST - STONE VENEER
- T - TRIM 200mm COVE SIDING
- AF - ALUMINUM FACSIA
- AC - ALUMINUM CLADDING
- AS - ASPHALT SHINGLES
- F - FLASHING
- V - ROOF VENT MAX
- P - PARGING
- PC - PRECAST
- PCH10 - PRECAST HEADER 10"
- PCH8 - PRECAST HEADER 8"
- PCS - PRECAST SILL
- PCB - PRECAST BAND
- VS - VINYL SHAKES

2012 OBC DRAWINGS

2. AS PER STRUCTURAL		
1. STANDARD DRAWINGS	02/11/15	SI
NO DESCRIPTION	DATE	BY



TITLE: Left Side Elevation B

ACAD FILE: SCALE: 3/16" = 1'-0"

1086-The Steel
2012 Footprint
(STANDARD DRAWINGS)

DWG. A-2b

DATE XX/XX/XX

THIS DRAWING IS TO BE USED IN CONJUNCTION WITH SCHEDULE B-1A AND MAY SHOW ONLY SOME OF THE CHANGES DETAILED ON THAT DOCUMENT. SHOULD THE DRAWINGS NOT SHOW ALL ITEMS CONTAINED ON A SCHEDULE OR MISS OTHER ITEMS ALTOGETHER, THE SCHEDULE IS CONSIDERED THE GOVERNING DOCUMENT.

I SCOTT IRWIN BCIN 20765 HAVE REVIEWED AND TAKE
RESPONSIBILITY FOR DESIGN ACTIVITIES RELATING TO,
HOUSE & SMALL BUILDINGS_____.

EXTERIOR FINISH LEGEND

- B - BRICK (MAIN)
- B1 - BRICK SOLDIER COURSE (ACCENT)
- B2 - BRICK SOLDIER COURSE (ACCENT)
20mm PROUD
- B3 - BRICK SLEEPER COURSE
- B4 - STACK BOND (ACCENT)
- B5 - BRICK SILL (ACCENT)
- B6 - BRICK ROW LOCK (ACCENT)
- B7 - BRICK CORBELLING
- B8 - BRICK COINING 20mm PROUD
- +20 - BRICK 20mm PROUD
- 20 - BRICK RECESSED 20mm
- S - SIDING (HORIZONTAL)
- ST - STONE VENEER
- T - TRIM 200mm COVE SIDING
- AF - ALUMINUM FACSSIA
- AC - ALUMINUM CLADDING
- AS - ASPHALT SHINGLES
- F - FLASHING
- V - ROOF VENT MAX
- P - PARGING
- PC - PRECAST
- PCH10 - PRECAST HEADER 10"
- PCH8 - PRECAST HEADER 8"
- PCS - PRECAST SILL
- PCB - PRECAST BAND
- VS - VINYL SHAKES

2012 OBC DRAWINGS


2.	AS PER STRUCTURAL		
1.	STANDARD DRAWINGS	02/11/15	S
NO	DESCRIPTION	DATE	BY




TITLE: Left Side Elevation C

ACAD FILE:	SCALE: 3/16" = 1'-0"
------------	-------------------------

1086-The Steel 2012 Footprint (STANDARD DRAWINGS)	DWG. A-2c
---	------------------

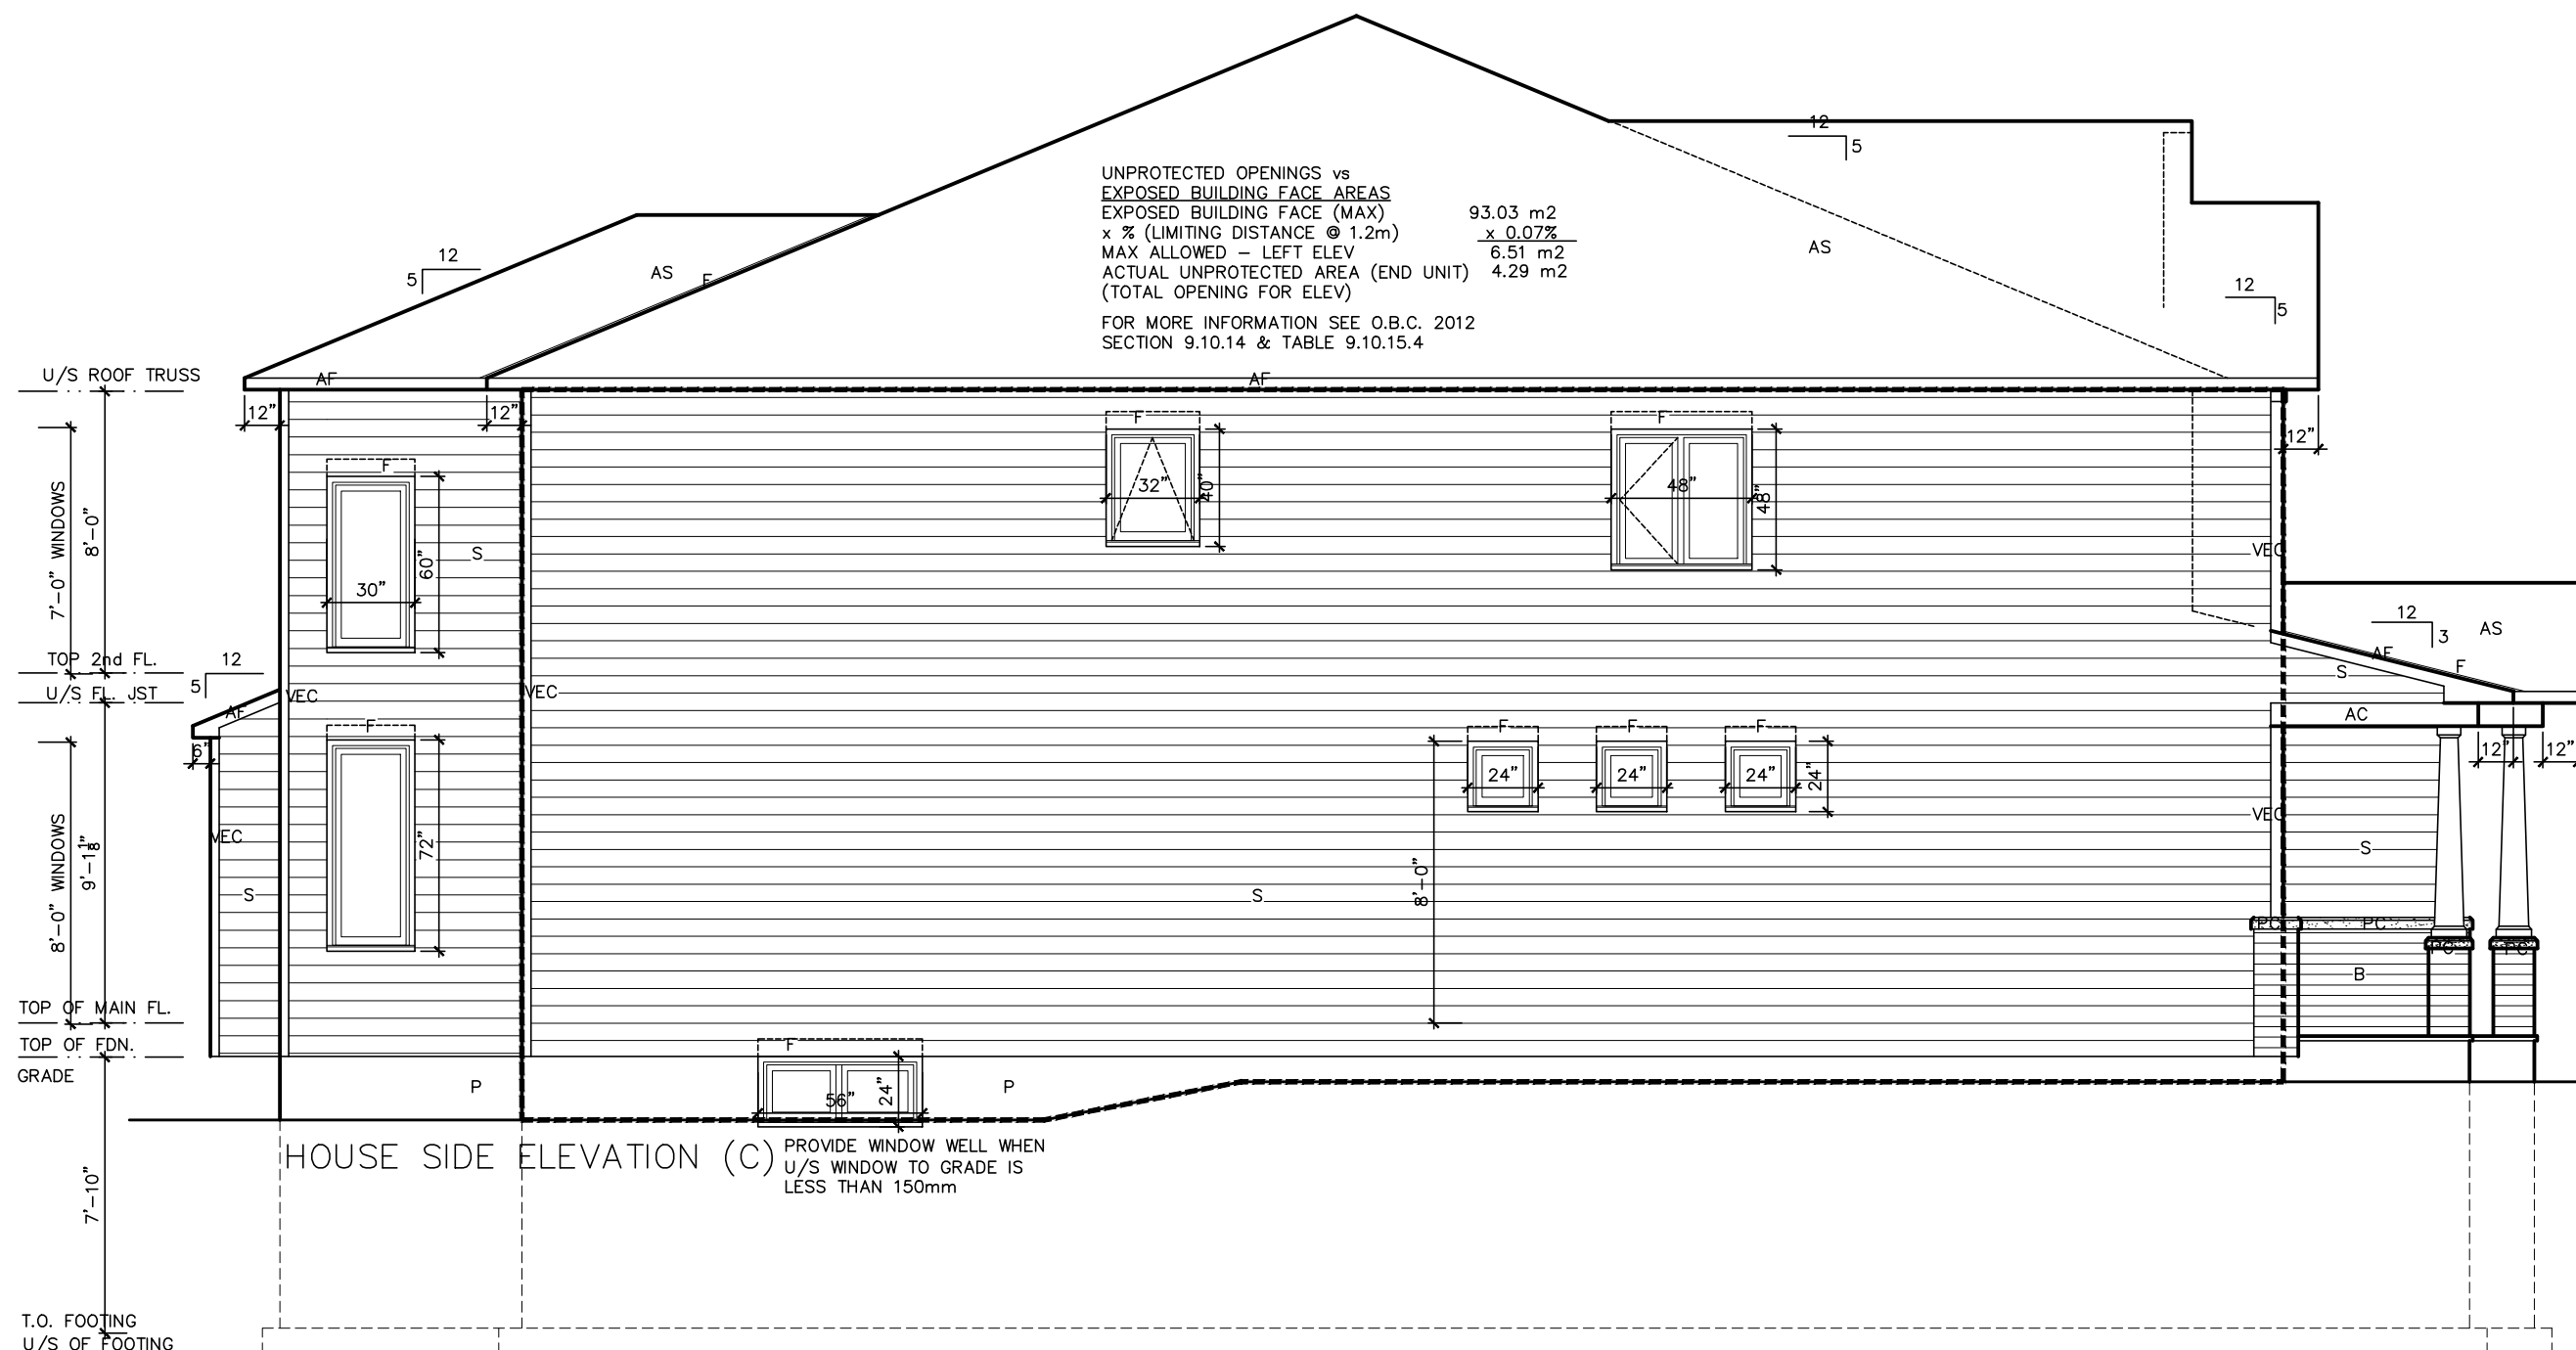

Left Side Elevation C

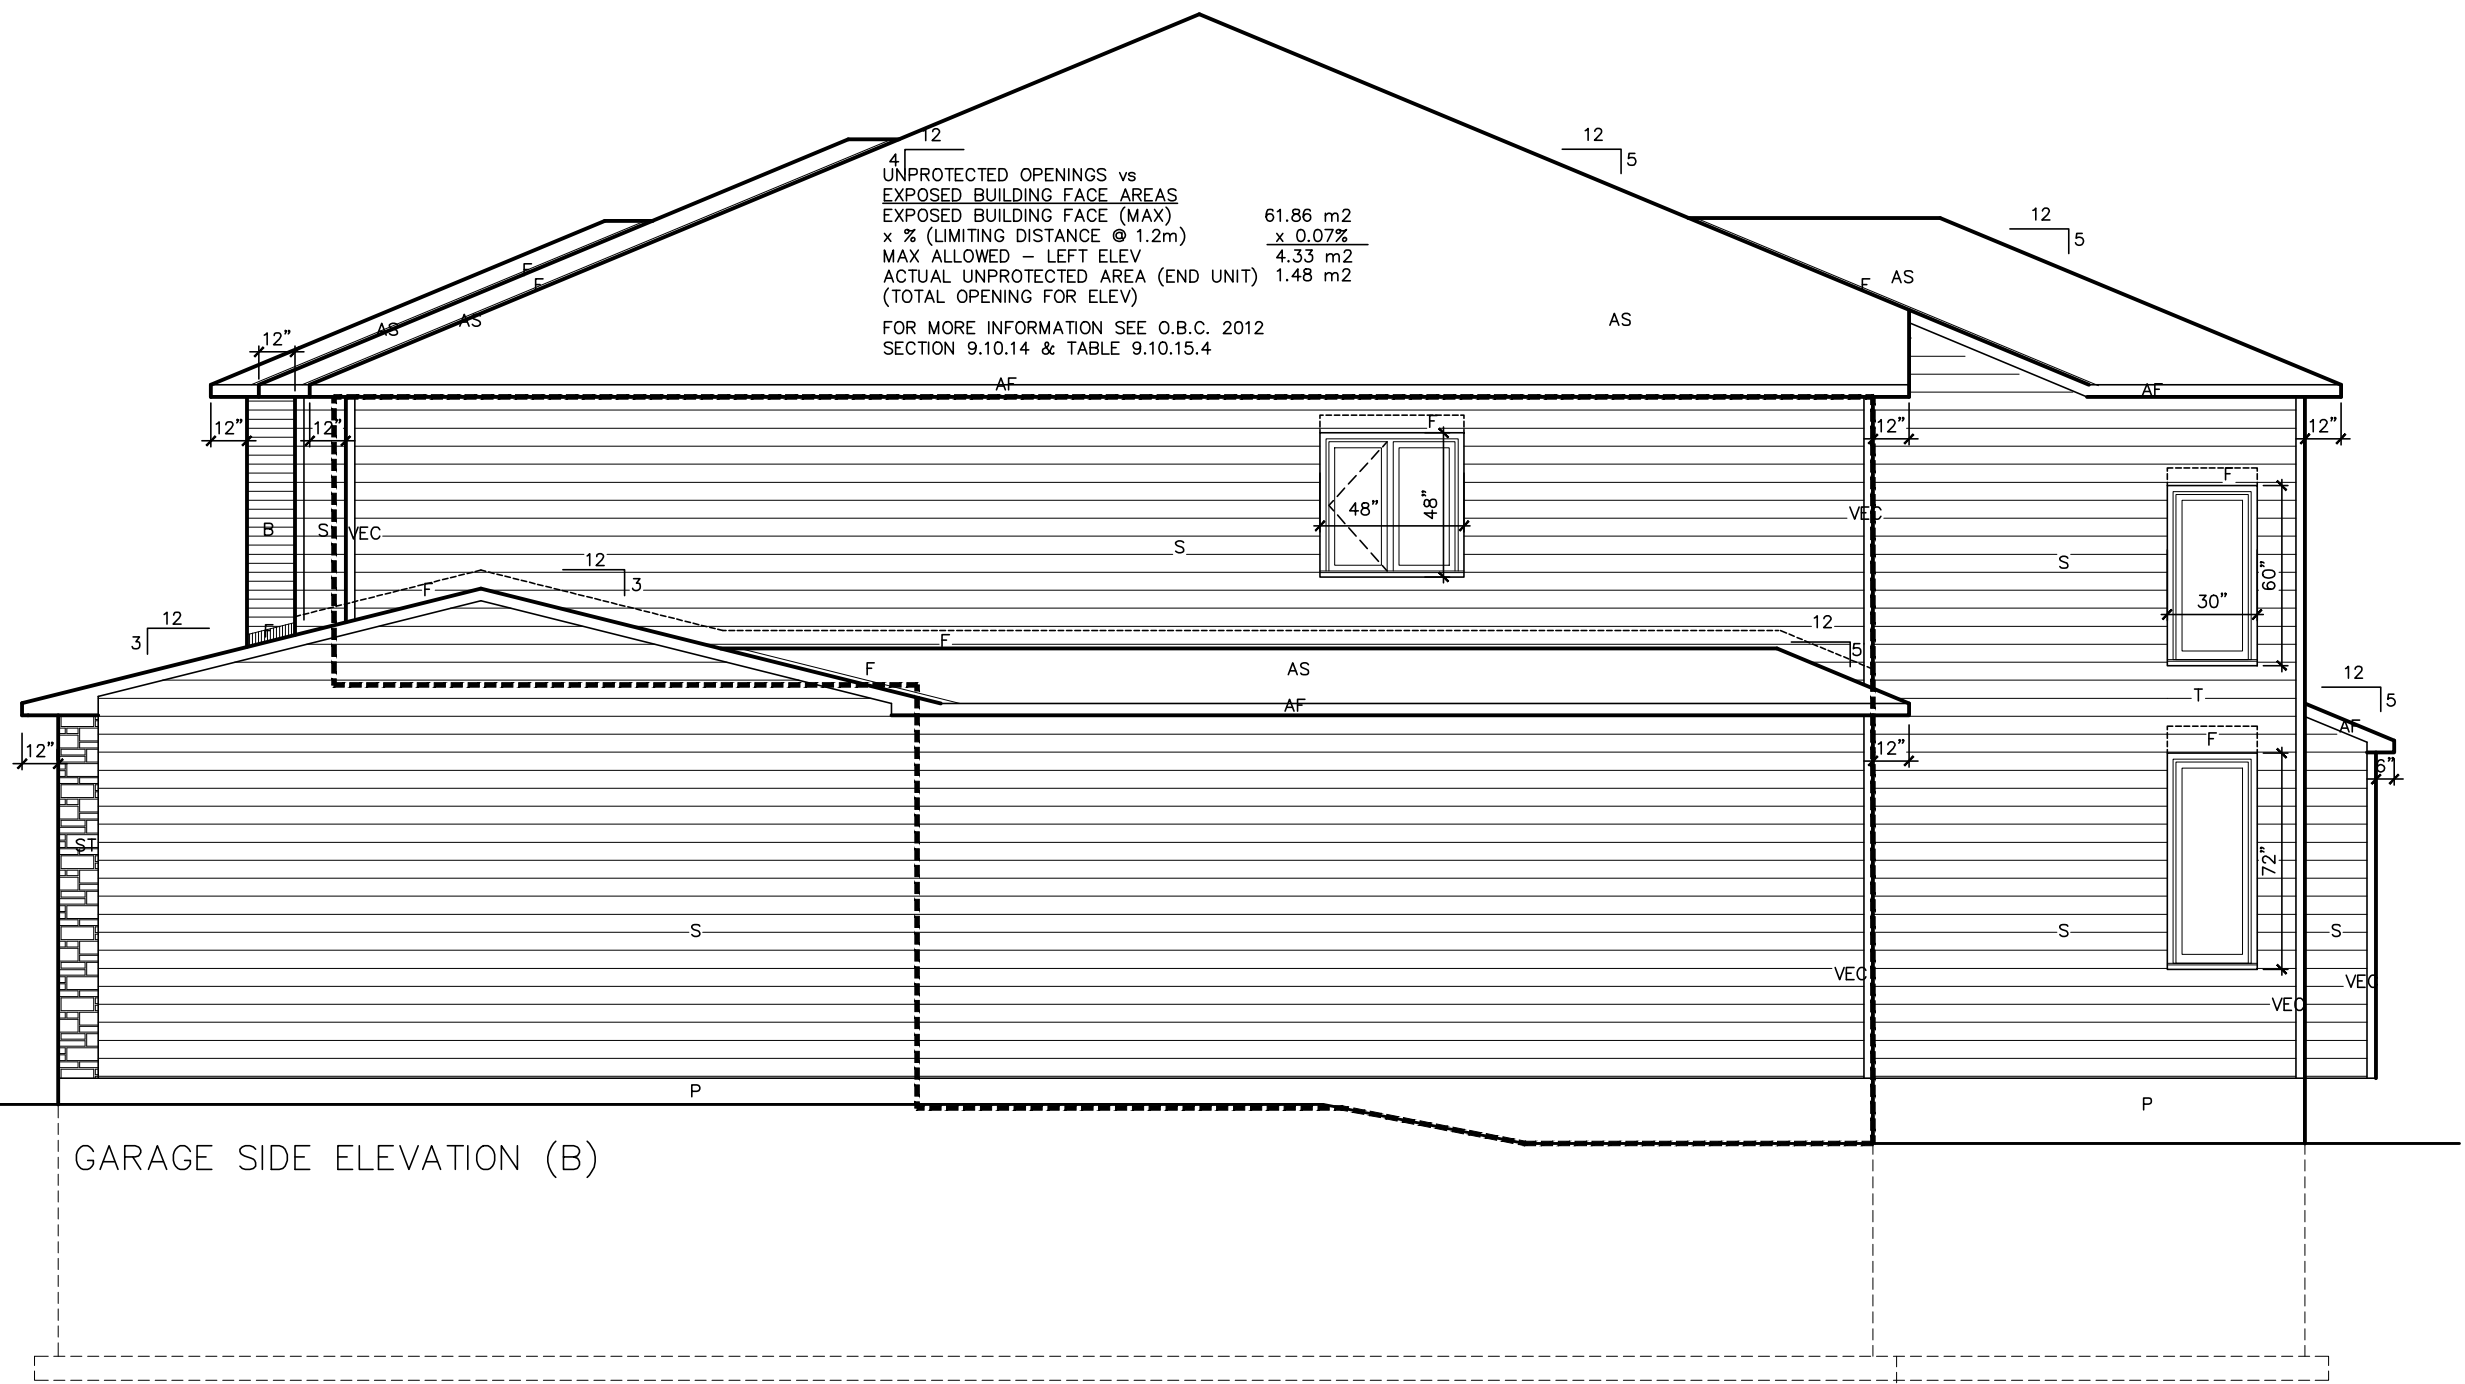

GARAGE SIDE ELEVATION (B)

Right Side Elevation B

LOT XXxx

DATE XX/XX/XX

THIS DRAWINGS IS TO BE USED IN CONJUNCTION WITH SCHEDULE B-1A AND MAY SHOW ONLY SOME OF THE CHANGES DETAILED ON THAT DOCUMENT. SHOULD THE DRAWINGS NOT SHOW ALL ITEMS CONTAINED ON A SCHEDULE OR MISS OTHER ITEMS ALTOGETHER, THE SCHEDULE IS CONSIDERED THE GOVERNING DOCUMENT.
FLOORS CONT

TENDER 2017

I SCOTT IRWIN BCIN 20765 HAVE REVIEWED AND TAKE RESPONSIBILITY FOR DESIGN ACTIVITIES RELATING TO, HOUSE & SMALL BUILDINGS.

EXTERIOR FINISH LEGEND

- B - BRICK (MAIN)
- B1 - BRICK SOLDIER COURSE (ACCENT)
- B2 - BRICK SOLDIER COURSE (ACCENT) 20mm PROUD
- B3 - BRICK SLEEPER COURSE
- B4 - STACK BOND (ACCENT)
- B5 - BRICK SILL (ACCENT)
- B6 - BRICK ROW LOCK (ACCENT)
- B7 - BRICK CORBELLING
- B8 - BRICK COINING 20mm PROUD
- +20 - BRICK 20mm PROUD
- 20 - BRICK RECESSED 20mm
- S - SIDING (HORIZONTAL)
- ST - STONE VENEER
- T - TRIM 200mm COVE SIDING
- AF - ALUMINUM FACSIA
- AC - ALUMINUM CLADDING
- AS - ASPHALT SHINGLES
- F - FLASHING
- V - ROOF VENT MAX
- P - PARGING
- PC - PRECAST
- PCH10 - PRECAST HEADER 10"
- PCH8 - PRECAST HEADER 8"
- PCS - PRECAST SILL
- PCB - PRECAST BAND
- VS - VINYL SHAKES

2012 OBC DRAWINGS


2.	AS PER STRUCTURAL		
1.	STANDARD DRAWINGS	02/11/15	SI
NO	DESCRIPTION	DATE	BY



TITLE: Right Side Elevation B

ACAD FILE: SCALE: 3/16" = 1'-0"

1086-The Steel 2012 Footprint (STANDARD DRAWINGS) DWG. A-3b

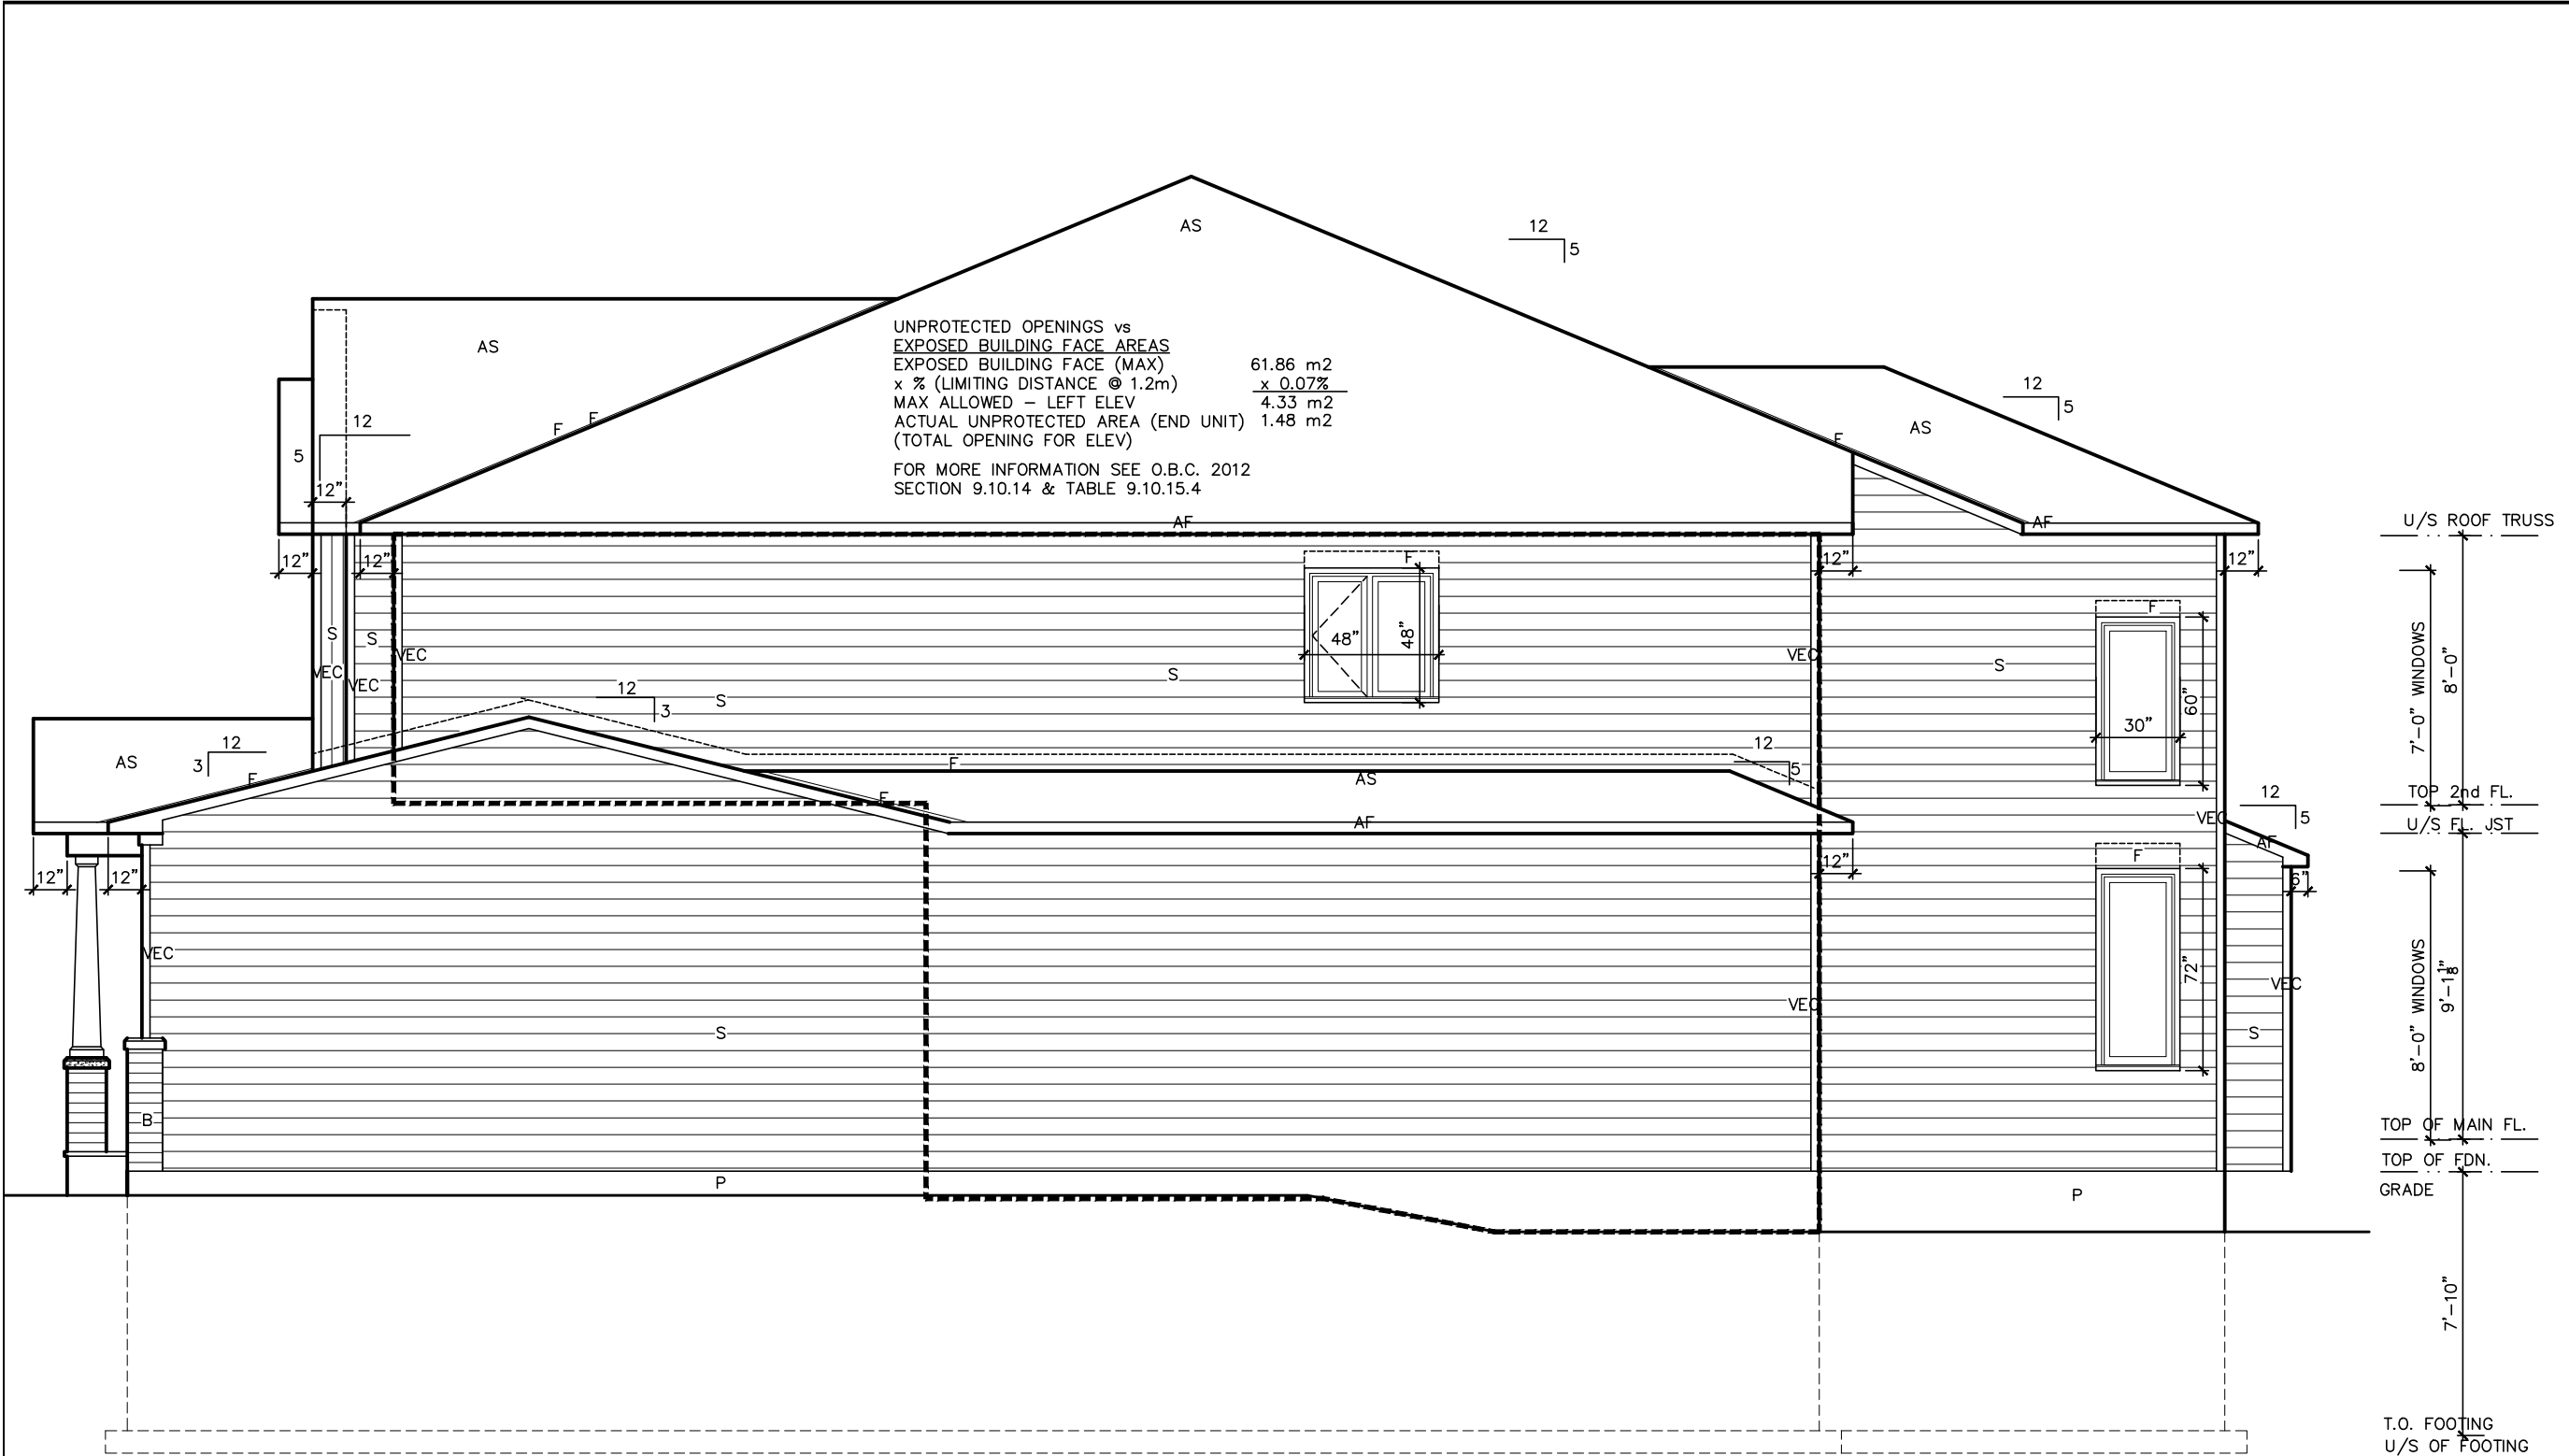

UNPROTECTED OPENINGS vs
EXPOSED BUILDING FACE AREAS
EXPOSED BUILDING FACE (MAX) 61.86 m2
x % (LIMITING DISTANCE @ 1.2m) x 0.07%
MAX ALLOWED - LEFT ELEV 4.33 m2
ACTUAL UNPROTECTED AREA (END UNIT) 1.48 m2
(TOTAL OPENING FOR ELEV)
FOR MORE INFORMATION SEE O.B.C. 2012
SECTION 9.10.14 & TABLE 9.10.15.4

GARAGE SIDE ELEVATION (C)

Right Side Elevation C

LOT XXxx

DATE XX/XX/XX

THIS DRAWING IS TO BE USED IN CONJUNCTION WITH SCHEDULE B-1A AND MAY SHOW ONLY SOME OF THE CHANGES DETAILED ON THAT DOCUMENT. SHOULD THE DRAWINGS NOT SHOW ALL ITEMS CONTAINED ON A SCHEDULE OR MISS OTHER ITEMS ALTOGETHER, THE SCHEDULE IS CONSIDERED THE GOVERNING DOCUMENT.
FLOORS CONT

TENDER 2017

I SCOTT IRWIN BCIN 20765 HAVE REVIEWED AND TAKE RESPONSIBILITY FOR DESIGN ACTIVITIES RELATING TO, HOUSE & SMALL BUILDINGS.

EXTERIOR FINISH LEGEND

- B - BRICK (MAIN)
- B1 - BRICK SOLDIER COURSE (ACCENT)
- B2 - BRICK SOLDIER COURSE (ACCENT) 20mm PROUD
- B3 - BRICK SLEEPER COURSE
- B4 - STACK BOND (ACCENT)
- B5 - BRICK SILL (ACCENT)
- B6 - BRICK ROW LOCK (ACCENT)
- B7 - BRICK CORBELLING
- B8 - BRICK COINING 20mm PROUD
- +20 - BRICK 20mm PROUD
- 20 - BRICK RECESSED 20mm
- S - SIDING (HORIZONTAL)
- ST - STONE VENEER
- T - TRIM 200mm COVE SIDING
- AF - ALUMINUM FACIA
- AC - ALUMINUM CLADDING
- AS - ASPHALT SHINGLES
- F - FLASHING
- V - ROOF VENT MAX
- P - PARGING
- PC - PRECAST
- PCH10 - PRECAST HEADER 10"
- PCH8 - PRECAST HEADER 8"
- PCS - PRECAST SILL
- PCB - PRECAST BAND
- VS - VINYL SHAKES

U/S ROOF TRUSS
7'-0" WINDOWS 8'-0"
TOP 2nd FL.
U/S FL. JST
8'-0" WINDOWS 9'-1 1/8"
TOP OF MAIN FL.
TOP OF FDN.
GRADE
7'-10"
T.O. FOOTING
U/S OF FOOTING

2012 OBC DRAWINGS


2. AS PER STRUCTURAL			
1. STANDARD DRAWINGS	02/11/15	SI	
NO DESCRIPTION	DATE	BY	



TITLE: Right Side Elevation C

ACAD FILE: SCALE: 3/16" = 1'-0"

1086-The Steel 2012 Footprint (STANDARD DRAWINGS) DWG. A-3c

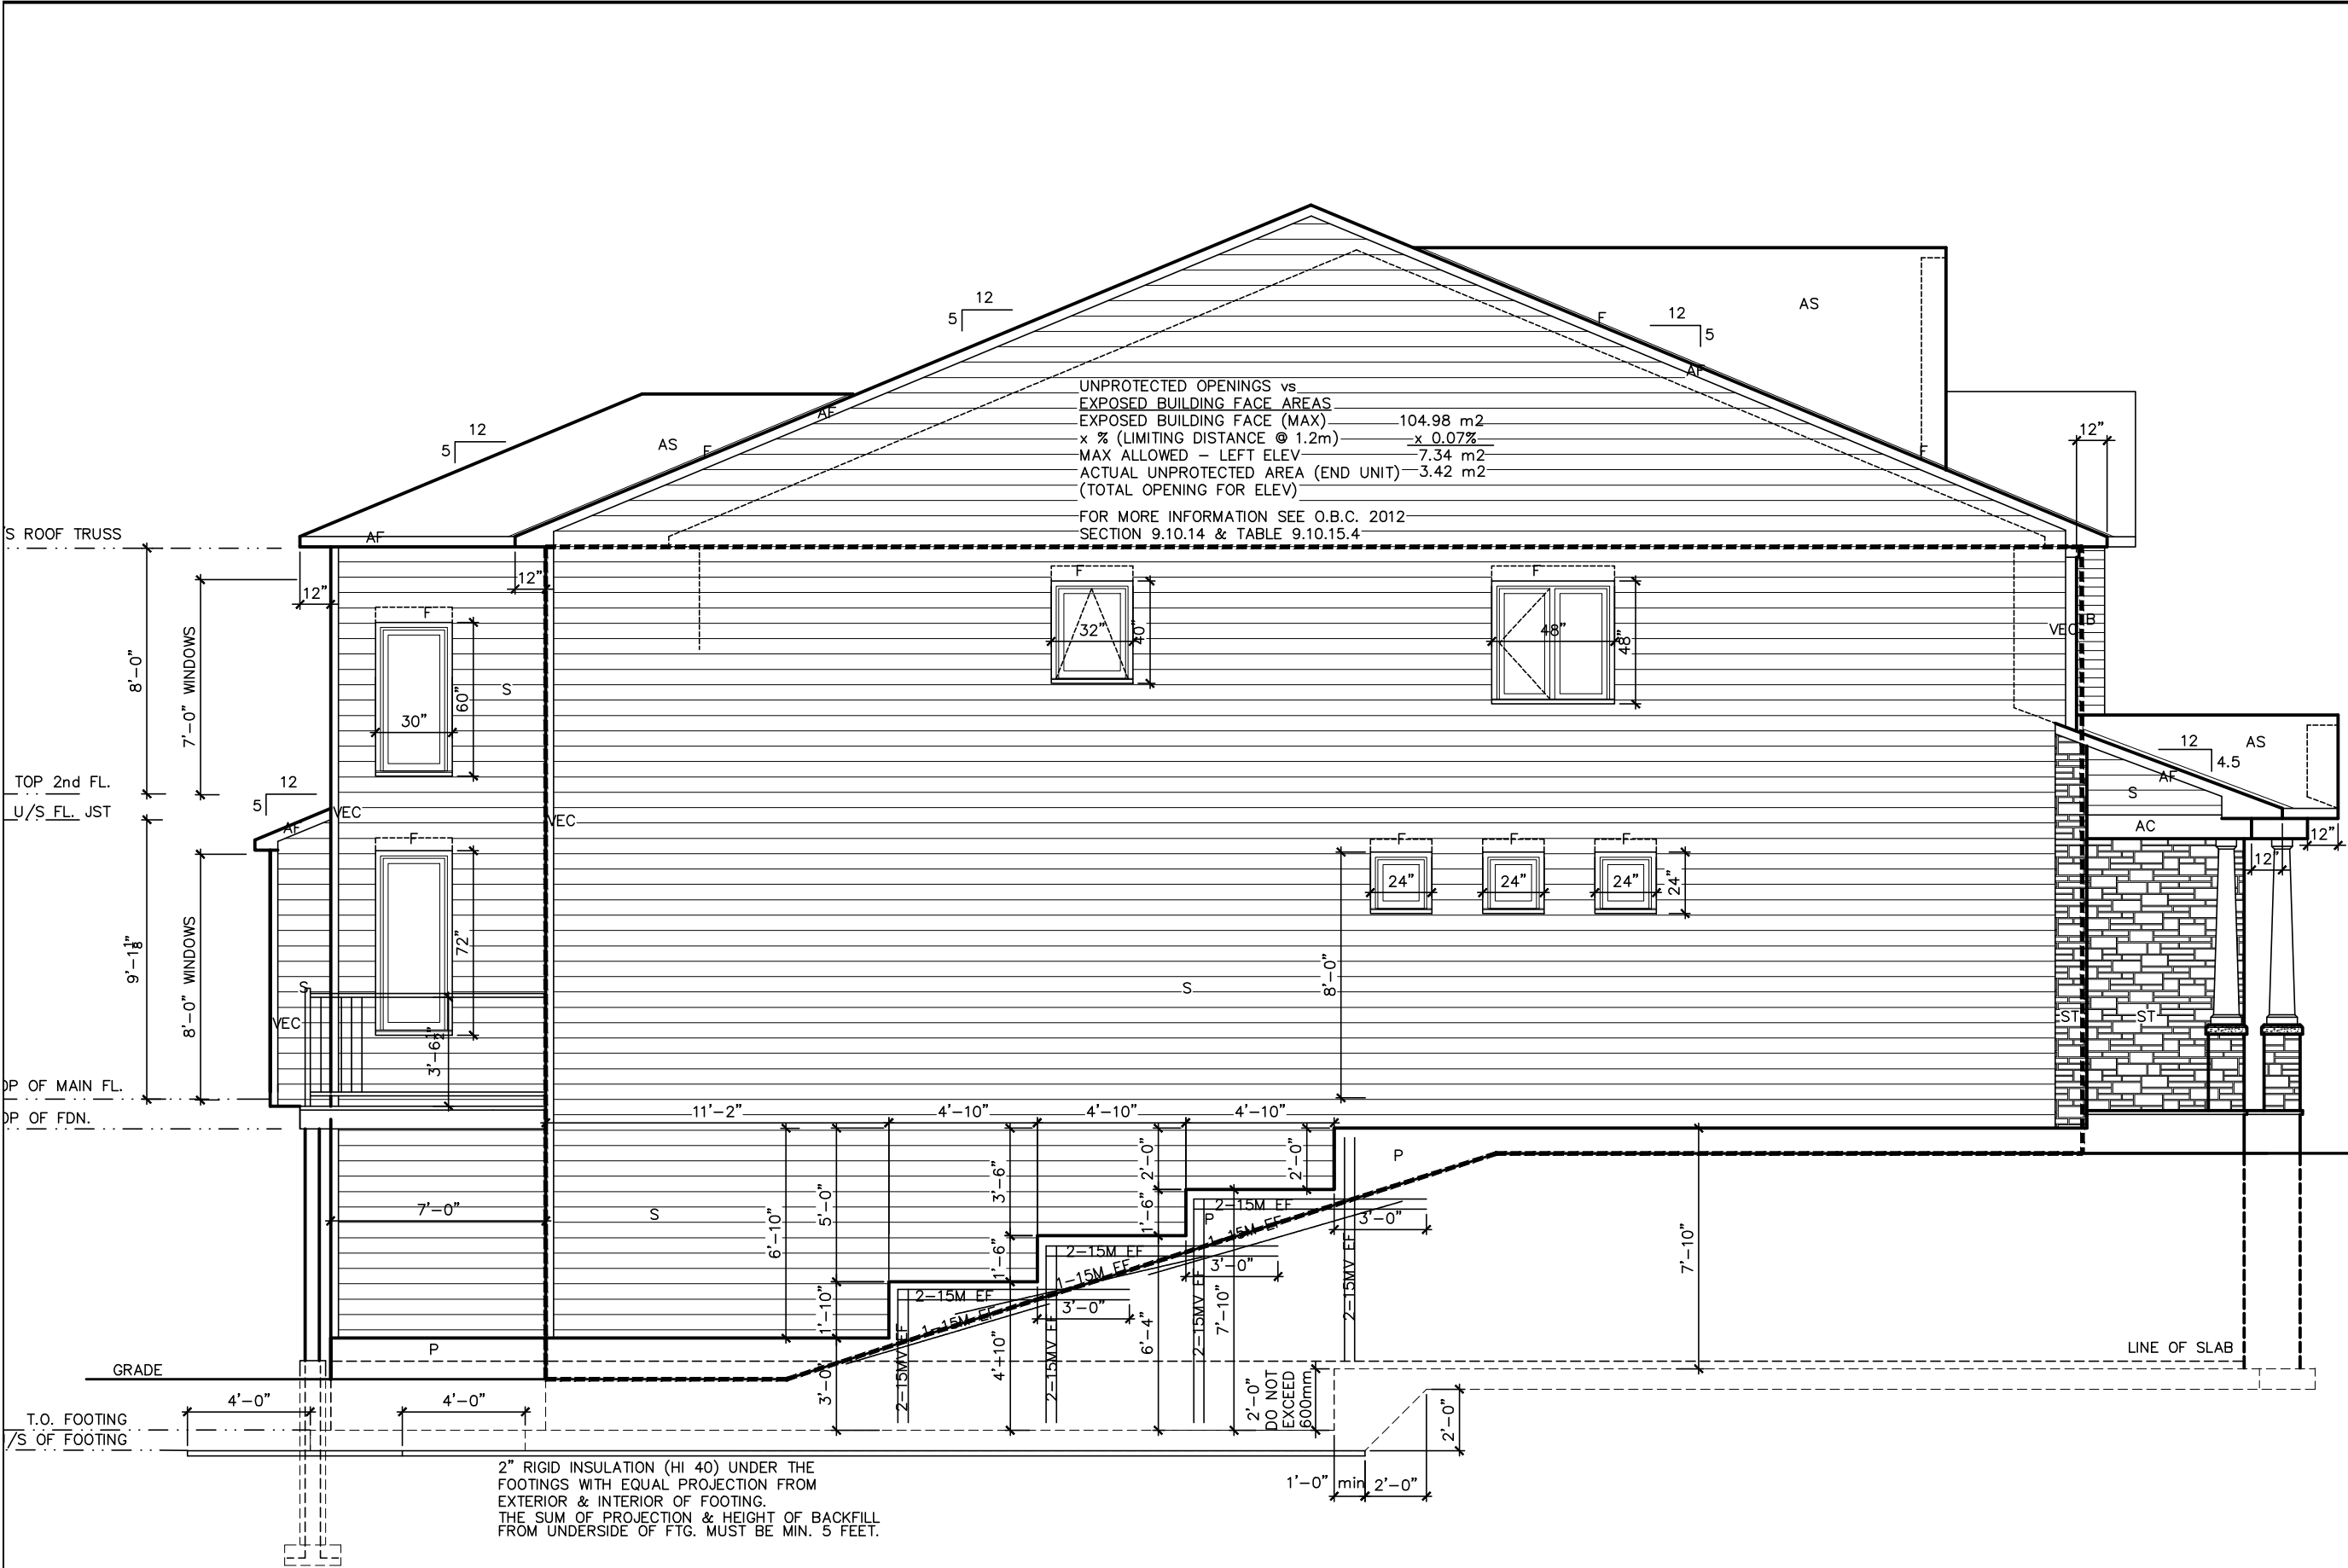

LOT **XXxx**

DATE **XX/XX/XX**

THIS DRAWING IS TO BE USED IN CONJUNCTION WITH SCHEDULE B-1A AND MAY SHOW ONLY SOME OF THE CHANGES DETAILED ON THAT DOCUMENT. SHOULD THE DRAWINGS NOT SHOW ALL ITEMS CONTAINED ON A SCHEDULE OR MISS OTHER ITEMS ALTOGETHER, THE SCHEDULE IS CONSIDERED THE GOVERNING DOCUMENT.

FLOORS CONT

TENDER 2017

I **SCOTT IRWIN BCIN 20765** HAVE REVIEWED AND TAKE RESPONSIBILITY FOR DESIGN ACTIVITIES RELATING TO, HOUSE & SMALL BUILDINGS.

- EXTERIOR FINISH LEGEND
- B

-

BRICK (MAIN)
- B1

-

BRICK SOLDIER COURSE (ACCENT)
- B2

-

BRICK SOLDIER COURSE (ACCENT)

20mm PROUD
- B3

-

BRICK SLEEPER COURSE
- B4

-

STACK BOND (ACCENT)
- B5

-

BRICK SILL (ACCENT)
- B6

-

BRICK ROW LOCK (ACCENT)
- B7

-

BRICK CORBELLING
- B8

-

BRICK COINING 20mm PROUD
- +20

-

BRICK 20mm PROUD
- 20

-

BRICK RECESSED 20mm
- S

-

SIDING (HORIZONTAL)
- ST

-

STONE VENEER
- T

-

TRIM 200mm COVE SIDING
- AF

-

ALUMINUM FACIA
- AC

-

ALUMINUM CLADDING
- AS

-

ASPHALT SHINGLES
- F

-

FLASHING
- V

-

ROOF VENT MAX
- P

-

PARGING
- PC

-

PRECAST
- PCH10

-

PRECAST HEADER 10"
- PCH8

-

PRECAST HEADER 8"
- PCS

-

PRECAST SILL
- PCB

-

PRECAST BAND
- VS

-

VINYL SHAKES

2012 OBC DRAWINGS

2.	AS PER STRUCTURAL		
1.	STANDARD DRAWINGS	02/11/15	SI
NO	DESCRIPTION	DATE	BY

Valecraft
Home Ld.

TITLE:
Left Side Elevation A - WOB

ACAD FILE:

SCALE:
3/16" = 1'-0"

1086-The Steel
2012 Footprint
(STANDARD DRAWINGS)

DWG.
A-2d

LOT **XXxx**

DATE **XX/XX/XX**

THIS DRAWING IS TO BE USED IN CONJUNCTION WITH SCHEDULE B-1A AND MAY SHOW ONLY SOME OF THE CHANGES DETAILED ON THAT DOCUMENT. SHOULD THE DRAWINGS NOT SHOW ALL ITEMS CONTAINED ON A SCHEDULE OR MISS OTHER ITEMS ALTOGETHER, THE SCHEDULE IS CONSIDERED THE GOVERNING DOCUMENT.
FLOORS CONT

TENDER 2017

I SCOTT IRWIN BCIN 20765 HAVE REVIEWED AND TAKE RESPONSIBILITY FOR DESIGN ACTIVITIES RELATING TO, HOUSE & SMALL BUILDINGS.

EXTERIOR FINISH LEGEND

- B - BRICK (MAIN)
- B1 - BRICK SOLDIER COURSE (ACCENT)
- B2 - BRICK SOLDIER COURSE (ACCENT) 20mm PROUD
- B3 - BRICK SLEEPER COURSE
- B4 - STACK BOND (ACCENT)
- B5 - BRICK SILL (ACCENT)
- B6 - BRICK ROW LOCK (ACCENT)
- B7 - BRICK CORBELLING
- B8 - BRICK COINING 20mm PROUD
- +20 - BRICK 20mm PROUD
- 20 - BRICK RECESSED 20mm
- S - SIDING (HORIZONTAL)
- ST - STONE VENEER
- T - TRIM 200mm COVE SIDING
- AF - ALUMINUM FACSIA
- AC - ALUMINUM CLADDING
- AS - ASPHALT SHINGLES
- F - FLASHING
- V - ROOF VENT MAX
- P - PARGING
- PC - PRECAST
- PCH10 - PRECAST HEADER 10"
- PCH8 - PRECAST HEADER 8"
- PCS - PRECAST SILL
- PCB - PRECAST BAND
- VS - VINYL SHAKES

2012 OBC DRAWINGS


2. AS PER STRUCTURAL		
1. STANDARD DRAWINGS	02/11/15	SI
NO. DESCRIPTION	DATE	BY



TITLE: **Left Side Elevation B - WOB**

ACAD FILE: SCALE: **3/16" = 1'-0"**

1086-The Steel
2012 Footprint
(STANDARD DRAWINGS) DWG. **A-2e**

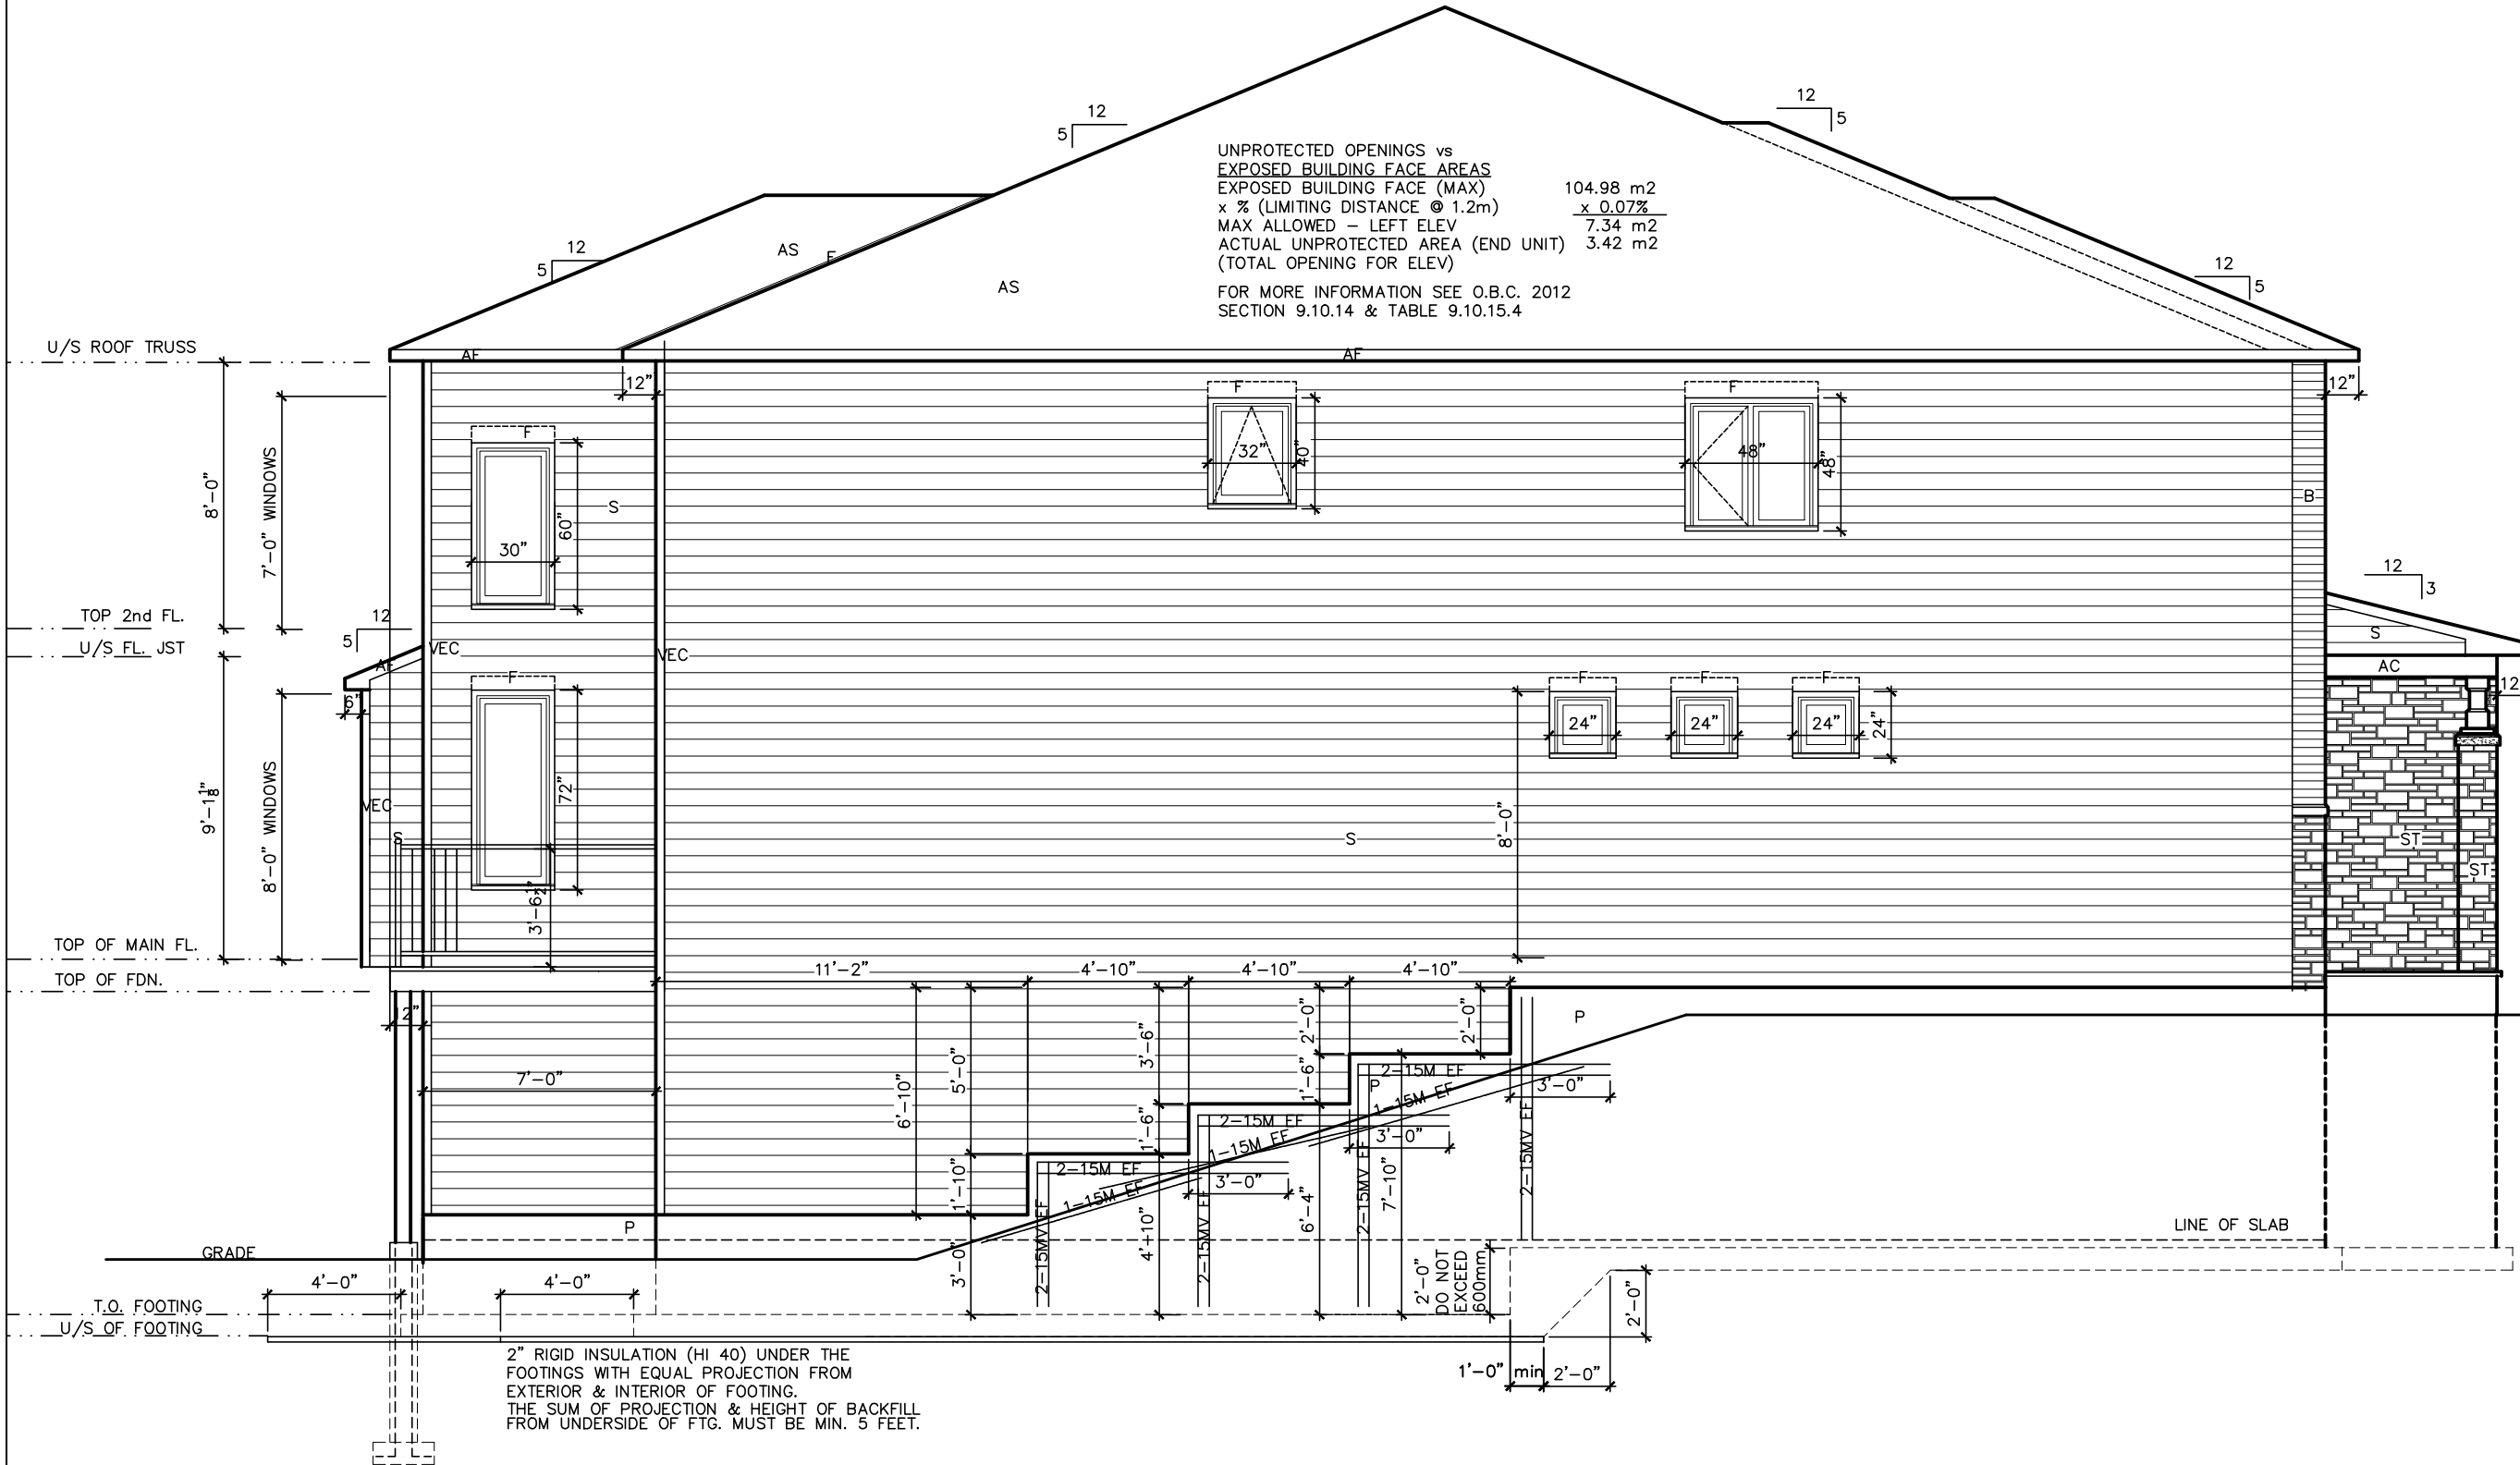

UNPROTECTED OPENINGS vs
EXPOSED BUILDING FACE AREAS
EXPOSED BUILDING FACE (MAX) 104.98 m2
x % (LIMITING DISTANCE @ 1.2m) x 0.07%
MAX ALLOWED - LEFT ELEV 7.34 m2
ACTUAL UNPROTECTED AREA (END UNIT) 3.42 m2
(TOTAL OPENING FOR ELEV)

FOR MORE INFORMATION SEE O.B.C. 2012
SECTION 9.10.14 & TABLE 9.10.15.4

Left Side Elevation B- WOB

LOT XXxx

DATE XX/XX/XX

THIS DRAWING IS TO BE USED IN CONJUNCTION WITH SCHEDULE B-1A AND MAY SHOW ONLY SOME OF THE CHANGES DETAILED ON THAT DOCUMENT. SHOULD THE DRAWINGS NOT SHOW ALL ITEMS CONTAINED ON A SCHEDULE OR MISS OTHER ITEMS ALTOGETHER, THE SCHEDULE IS CONSIDERED THE GOVERNING DOCUMENT.
FLOORS CONT

TENDER 2017

I SCOTT IRWIN BCIN 20765 HAVE REVIEWED AND TAKE RESPONSIBILITY FOR DESIGN ACTIVITIES RELATING TO, HOUSE & SMALL BUILDINGS.

EXTERIOR FINISH LEGEND

- B - BRICK (MAIN)
B1 - BRICK SOLDIER COURSE (ACCENT)
B2 - BRICK SOLDIER COURSE (ACCENT)
B3 - BRICK SLEEPER COURSE
B4 - STACK BOND (ACCENT)
B5 - BRICK SILL (ACCENT)
B6 - BRICK ROW LOCK (ACCENT)
B7 - BRICK CORBELLING
B8 - BRICK COINING 20mm PROUD
+20 - BRICK 20mm PROUD
-20 - BRICK RECESSED 20mm
S - SIDING (HORIZONTAL)
ST - STONE VENEER
T - TRIM 200mm COVE SIDING
AF - ALUMINUM FACIA
AC - ALUMINUM CLADDING
AS - ASPHALT SHINGLES
F - FLASHING
V - ROOF VENT MAX
P - PARGING
PC - PRECAST
PCH10 - PRECAST HEADER 10"
PCH8 - PRECAST HEADER 8"
PCS - PRECAST SILL
PCB - PRECAST BAND
VS - VINYL SHAKES

2012 OBC DRAWINGS


2. AS PER STRUCTURAL			
1. STANDARD DRAWINGS	02/11/15	SI	
NO. DESCRIPTION	DATE	BY	




TITLE: Left Side Elevation C - WOB

ACAD FILE: SCALE: 3/16" = 1'-0"

DWG. 1086-The Steel 2012 Footprint (STANDARD DRAWINGS) A-2f

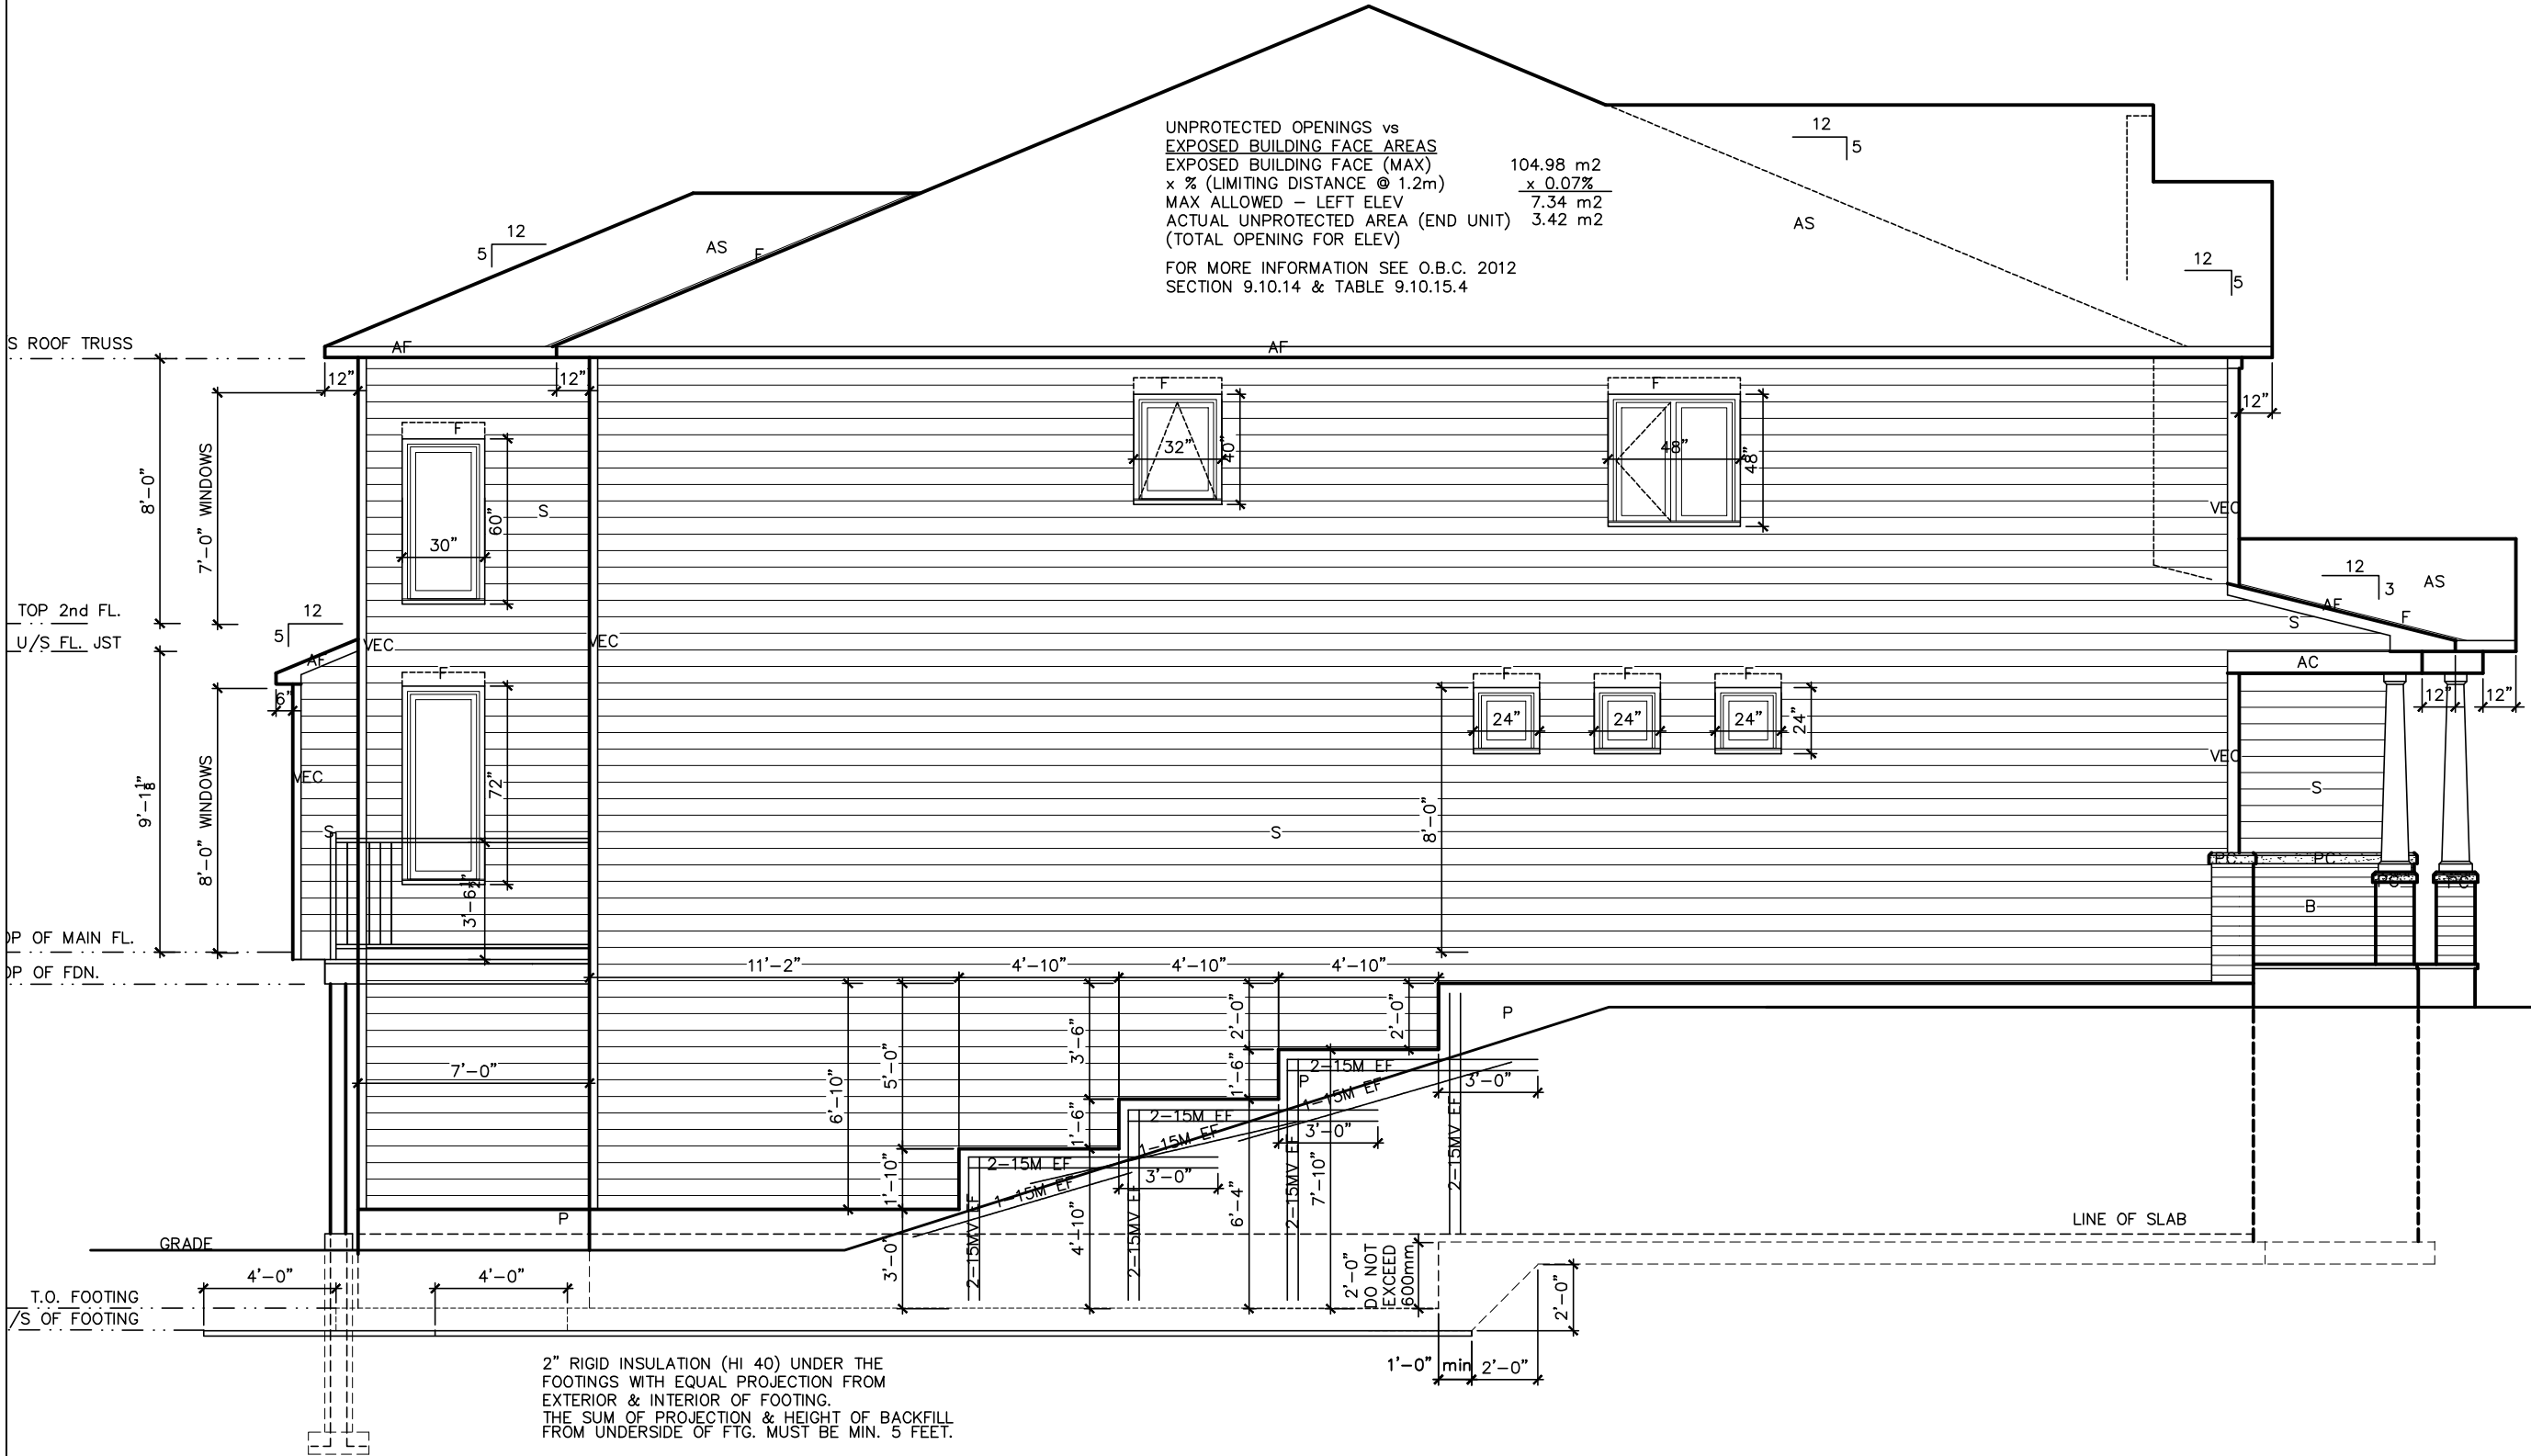

Left Side Elevation C - WOB

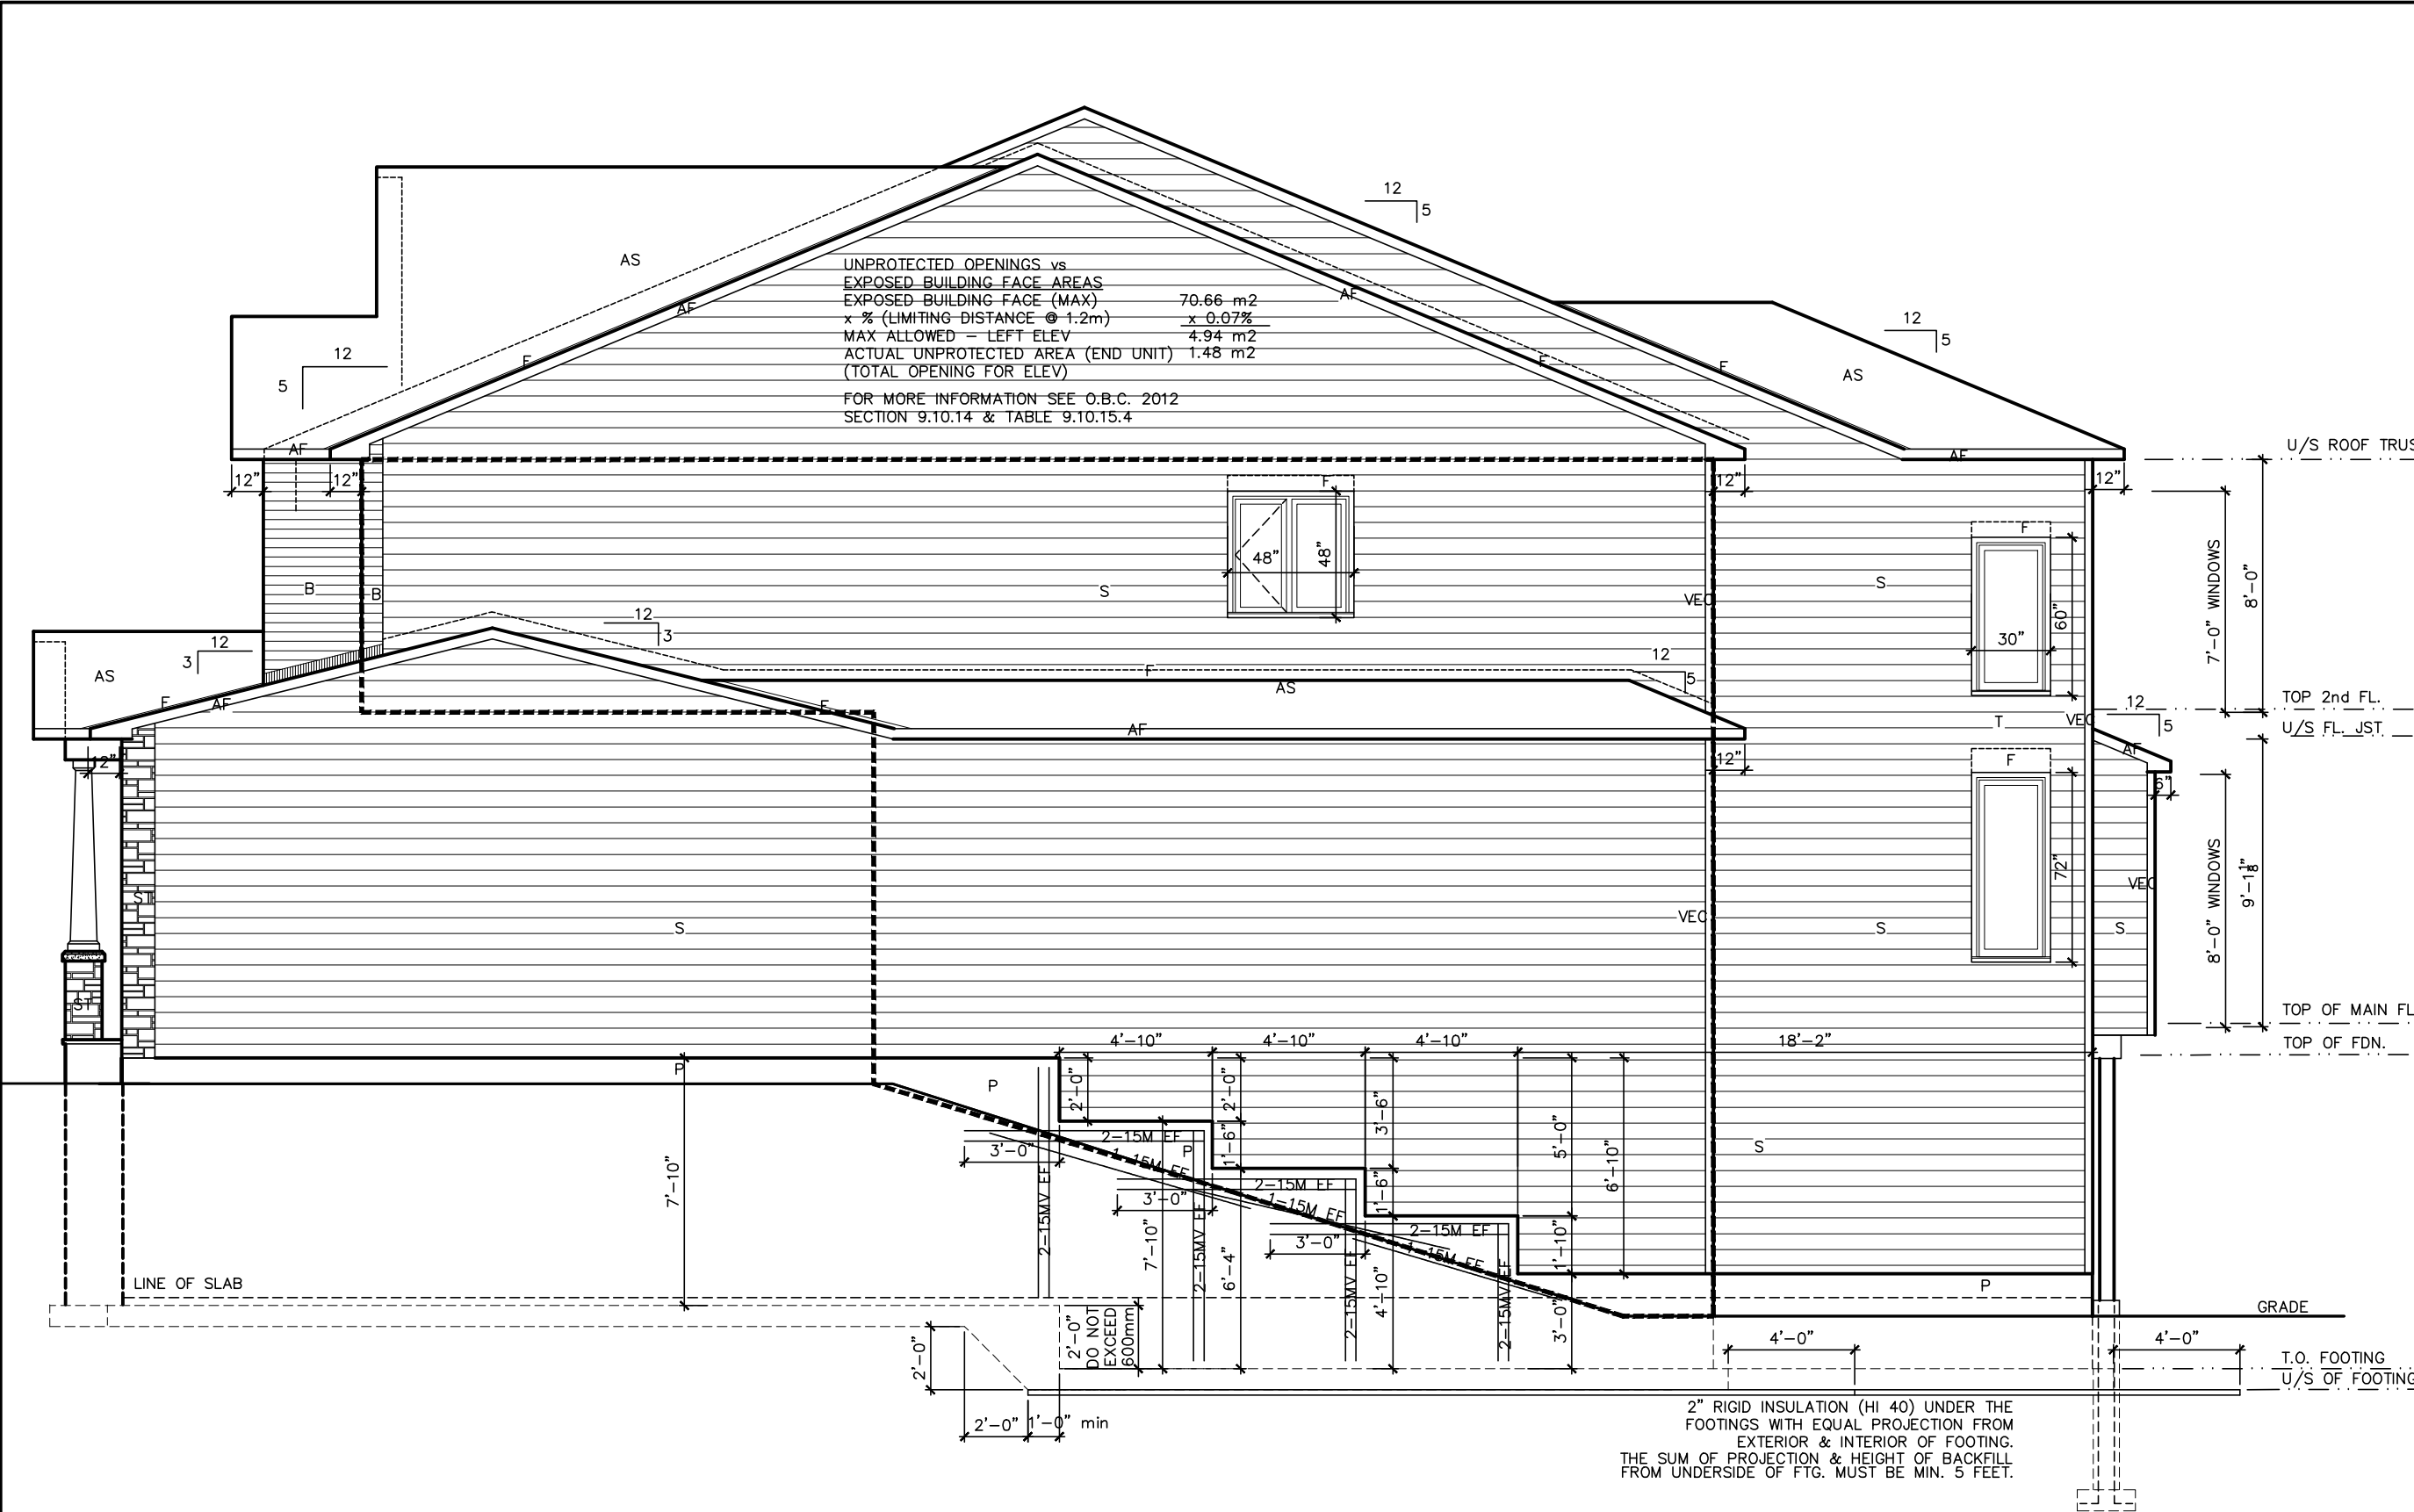

LOT XXxx

DATE XX/XX/XX

THIS DRAWING IS TO BE USED IN CONJUNCTION WITH SCHEDULE B-1A AND MAY SHOW ONLY SOME OF THE CHANGES DETAILED ON THAT DOCUMENT. SHOULD THE DRAWINGS NOT SHOW ALL ITEMS CONTAINED ON A SCHEDULE OR MISS OTHER ITEMS ALTOGETHER, THE SCHEDULE IS CONSIDERED THE GOVERNING DOCUMENT.
FLOORS CONT

TENDER 2017

I SCOTT IRWIN BCIN 20765 HAVE REVIEWED AND TAKE RESPONSIBILITY FOR DESIGN ACTIVITIES RELATING TO, HOUSE & SMALL BUILDINGS.

- EXTERIOR FINISH LEGEND
- B - BRICK (MAIN)
 - B1 - BRICK SOLDIER COURSE (ACCENT)
 - B2 - BRICK SOLDIER COURSE (ACCENT) 20mm PROUD
 - B3 - BRICK SLEEPER COURSE
 - B4 - STACK BOND (ACCENT)
 - B5 - BRICK SILL (ACCENT)
 - B6 - BRICK ROW LOCK (ACCENT)
 - B7 - BRICK CORBELLING
 - B8 - BRICK COINING 20mm PROUD
 - +20 - BRICK 20mm PROUD
 - 20 - BRICK RECESSED 20mm
 - S - SIDING (HORIZONTAL)
 - ST - STONE VENEER
 - T - TRIM 200mm COVE SIDING
 - AF - ALUMINUM FACIA
 - AC - ALUMINUM CLADDING
 - AS - ASPHALT SHINGLES
 - F - FLASHING
 - V - ROOF VENT MAX
 - P - PARGING
 - PC - PRECAST
 - PCH10 - PRECAST HEADER 10"
 - PCH8 - PRECAST HEADER 8"
 - PCS - PRECAST SILL
 - PCB - PRECAST BAND
 - VS - VINYL SHAKES

2012 OBC DRAWINGS

NO	DESCRIPTION	DATE	BY
2.	AS PER STRUCTURAL		
1.	STANDARD DRAWINGS	02/11/15	SI




TITLE: Right Side Elevation A - WOB

ACAD FILE: SCALE: 3/16" = 1'-0"

1086-The Steel 2012 Footprint (STANDARD DRAWINGS) DWG. A-3d

Right Side Elevation A - WOB

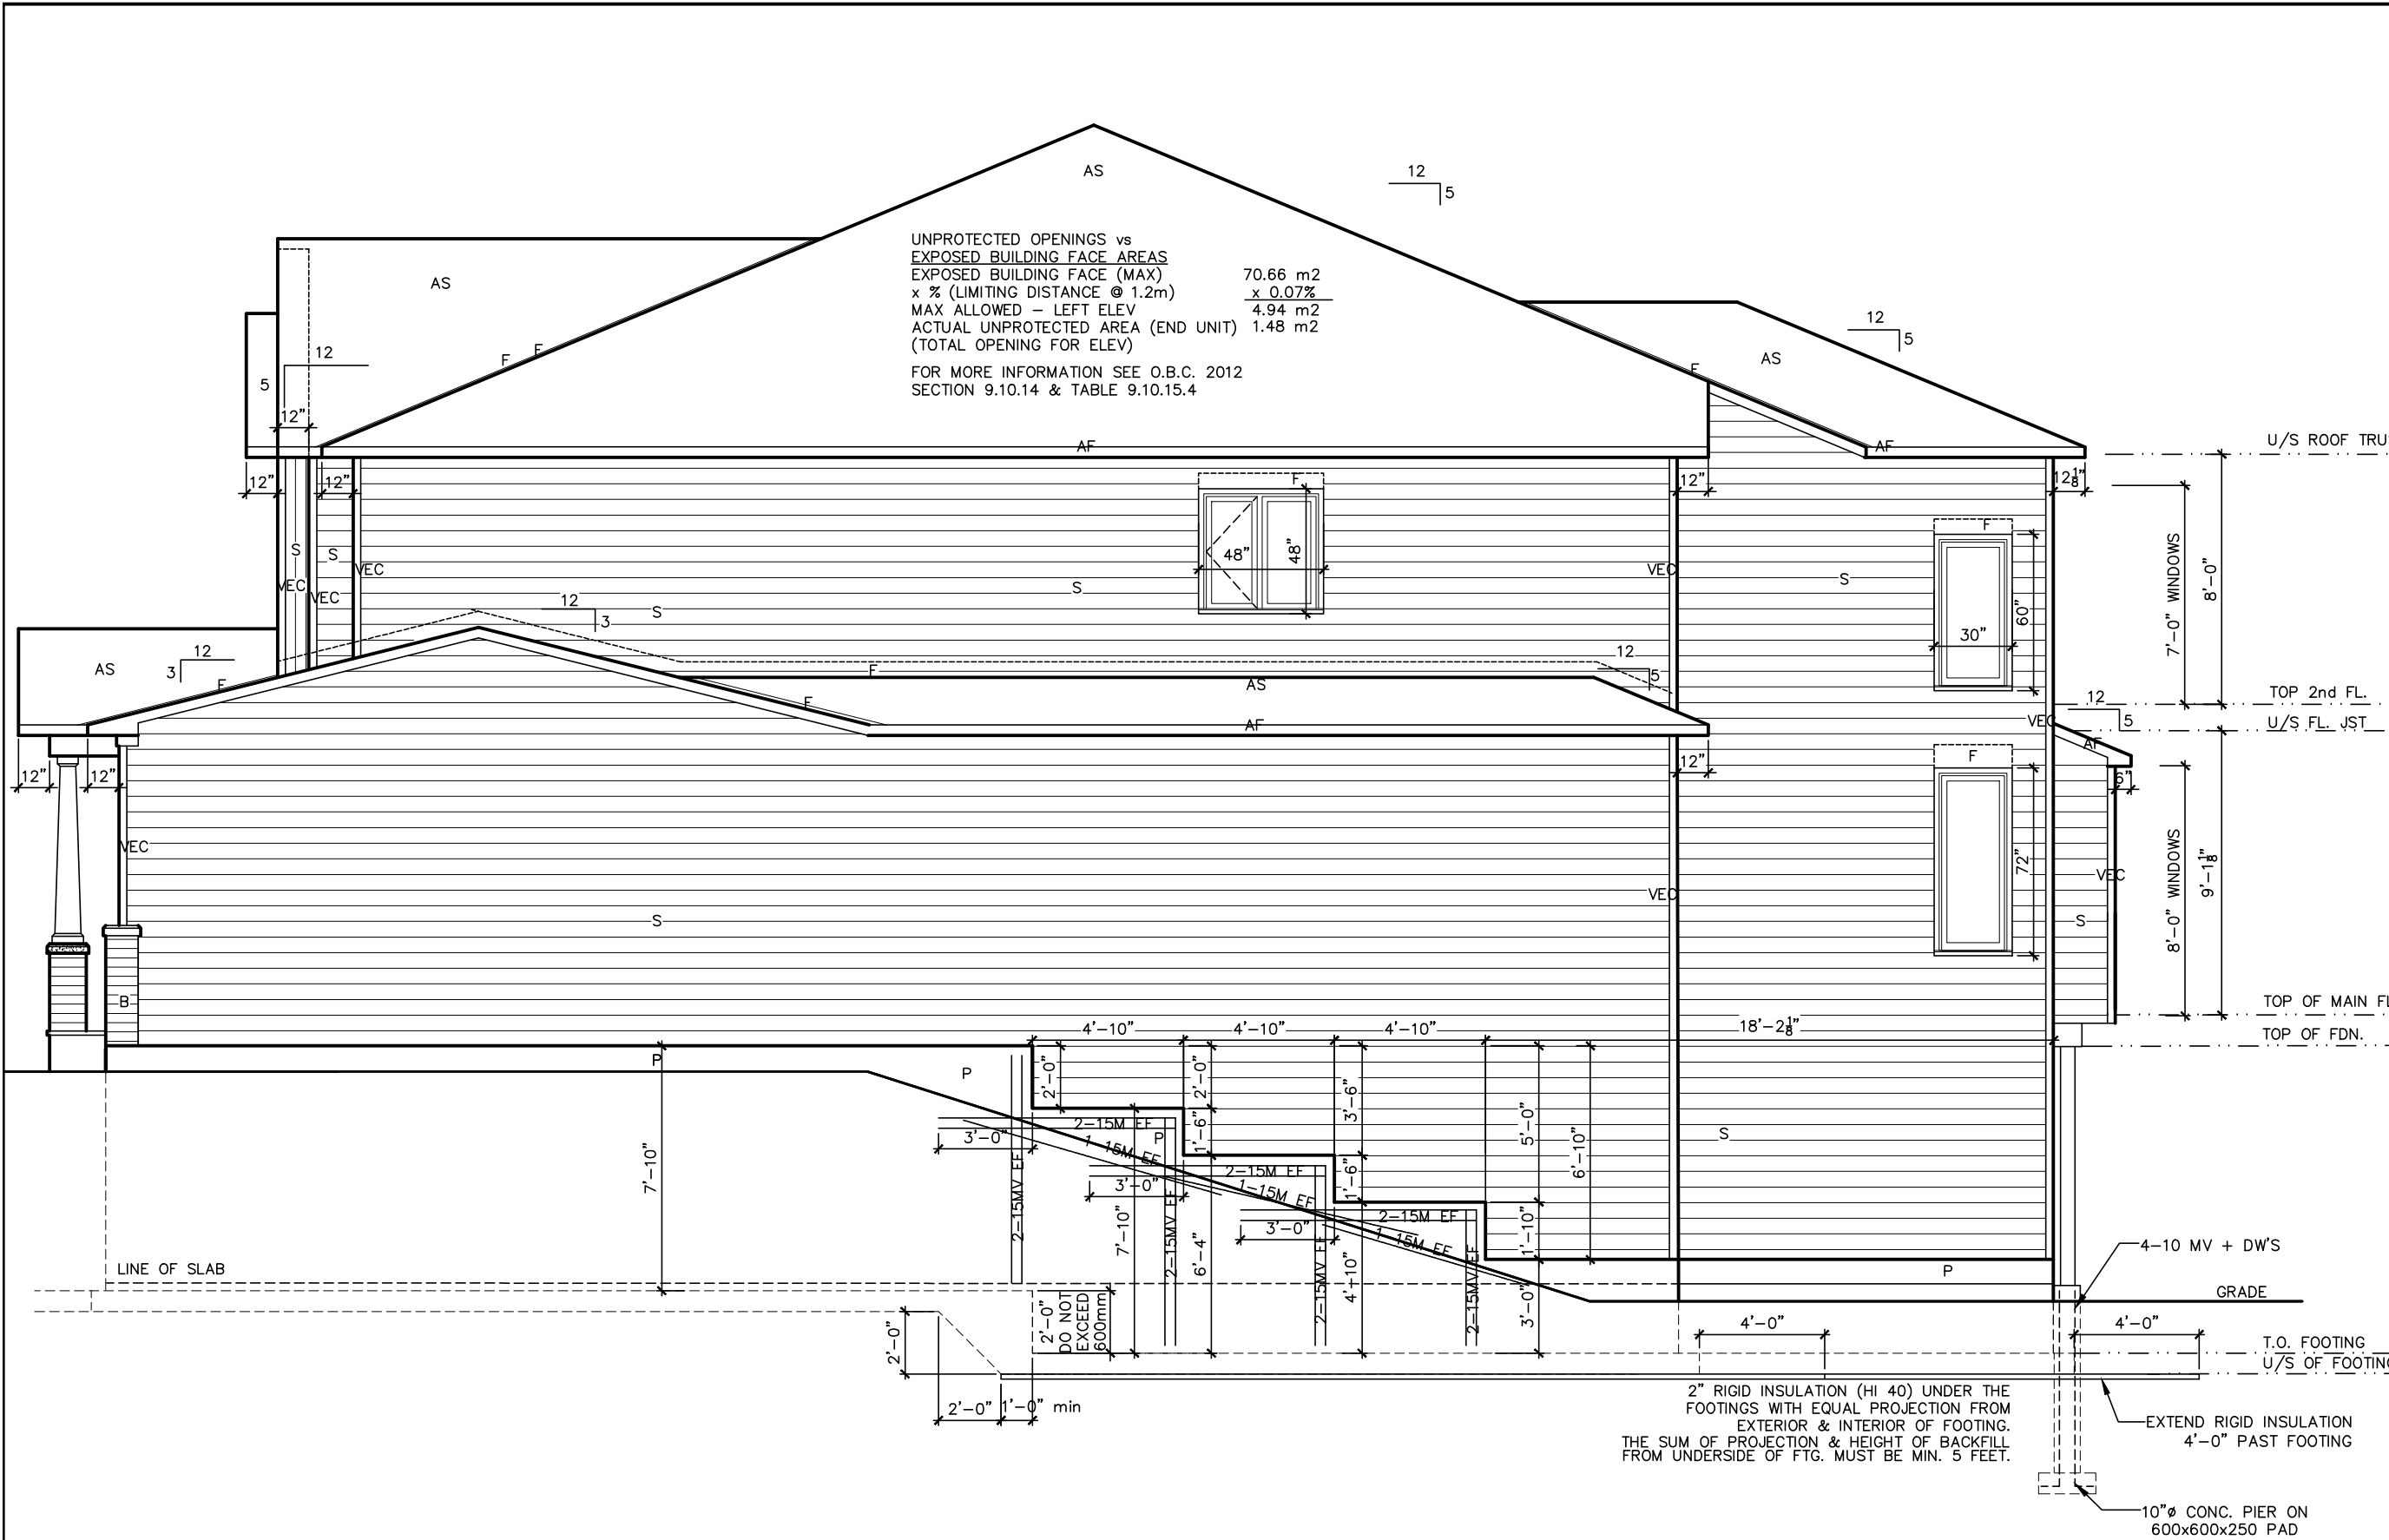

UNPROTECTED OPENINGS vs
EXPOSED BUILDING FACE AREAS
EXPOSED BUILDING FACE (MAX) 70.66 m²
x % (LIMITING DISTANCE @ 1.2m) x 0.07%
MAX ALLOWED - LEFT ELEV 4.94 m²
ACTUAL UNPROTECTED AREA (END UNIT) 1.48 m²
(TOTAL OPENING FOR ELEV)
FOR MORE INFORMATION SEE O.B.C. 2012
SECTION 9.10.14 & TABLE 9.10.15.4

LOT XXxx
DATE XX/XX/XX

THIS DRAWING IS TO BE USED IN CONJUNCTION WITH SCHEDULE B-1A AND MAY SHOW ONLY SOME OF THE CHANGES DETAILED ON THAT DOCUMENT. SHOULD THE DRAWINGS NOT SHOW ALL ITEMS CONTAINED ON A SCHEDULE OR MISS OTHER ITEMS ALTOGETHER, THE SCHEDULE IS CONSIDERED THE GOVERNING DOCUMENT.
FLOORS CONT

TENDER 2017

I SCOTT IRWIN BCIN 20765 HAVE REVIEWED AND TAKE RESPONSIBILITY FOR DESIGN ACTIVITIES RELATING TO, HOUSE & SMALL BUILDINGS.

- EXTERIOR FINISH LEGEND
- B - BRICK (MAIN)
 - B1 - BRICK SOLDIER COURSE (ACCENT)
 - B2 - BRICK SOLDIER COURSE (ACCENT) 20mm PROUD
 - B3 - BRICK SLEEPER COURSE
 - B4 - STACK BOND (ACCENT)
 - B5 - BRICK SILL (ACCENT)
 - B6 - BRICK ROW LOCK (ACCENT)
 - B7 - BRICK CORBELLING
 - B8 - BRICK COINING 20mm PROUD
 - +20 - BRICK 20mm PROUD
 - 20 - BRICK RECESSED 20mm
 - S - SIDING (HORIZONTAL)
 - ST - STONE VENEER
 - T - TRIM 200mm COVE SIDING
 - AF - ALUMINUM FASCIA
 - AC - ALUMINUM CLADDING
 - AS - ASPHALT SHINGLES
 - F - FLASHING
 - V - ROOF VENT MAX
 - P - PARGING
 - PC - PRECAST
 - PCH10 - PRECAST HEADER 10"
 - PCH8 - PRECAST HEADER 8"
 - PCS - PRECAST SILL
 - PCB - PRECAST BAND
 - VS - VINYL SHAKES

2012 OBC DRAWINGS			
2. AS PER STRUCTURAL			
1. STANDARD DRAWINGS	02/11/15	SI	
NO DESCRIPTION	DATE	BY	

Valecraft
Home Ltd.

TITLE: Right Side Elevation C - WOB

ACAD FILE: 1086-The Steel 2012 Footprint (STANDARD DRAWINGS)

SCALE: 3/16" = 1'-0"

DWG. A-3f



Rear Elevation A

LOT XXxx

DATE XX/XX/XX

THIS DRAWING IS TO BE USED IN CONJUNCTION WITH SCHEDULE B-1A AND MAY SHOW ONLY SOME OF THE CHANGES DETAILED ON THAT DOCUMENT. SHOULD THE DRAWINGS NOT SHOW ALL ITEMS CONTAINED ON A SCHEDULE OR MISS OTHER ITEMS ALTOGETHER, THE SCHEDULE IS CONSIDERED THE GOVERNING DOCUMENT.
FLOORS CONT

TENDER 2017

I SCOTT IRWIN BCIN 20765 HAVE REVIEWED AND TAKE RESPONSIBILITY FOR DESIGN ACTIVITIES RELATING TO, HOUSE & SMALL BUILDINGS.

2012 OBC DRAWINGS


2.	AS PER STRUCTURAL		
1.	STANDARD DRAWINGS	02/11/15	SI
NO	DESCRIPTION	DATE	BY



TITLE: Rear Elevation A

ACAD FILE: SCALE: 3/16" = 1'-0"

1086-The Steel 2012 Footprint (STANDARD DRAWINGS) DWG. A-4

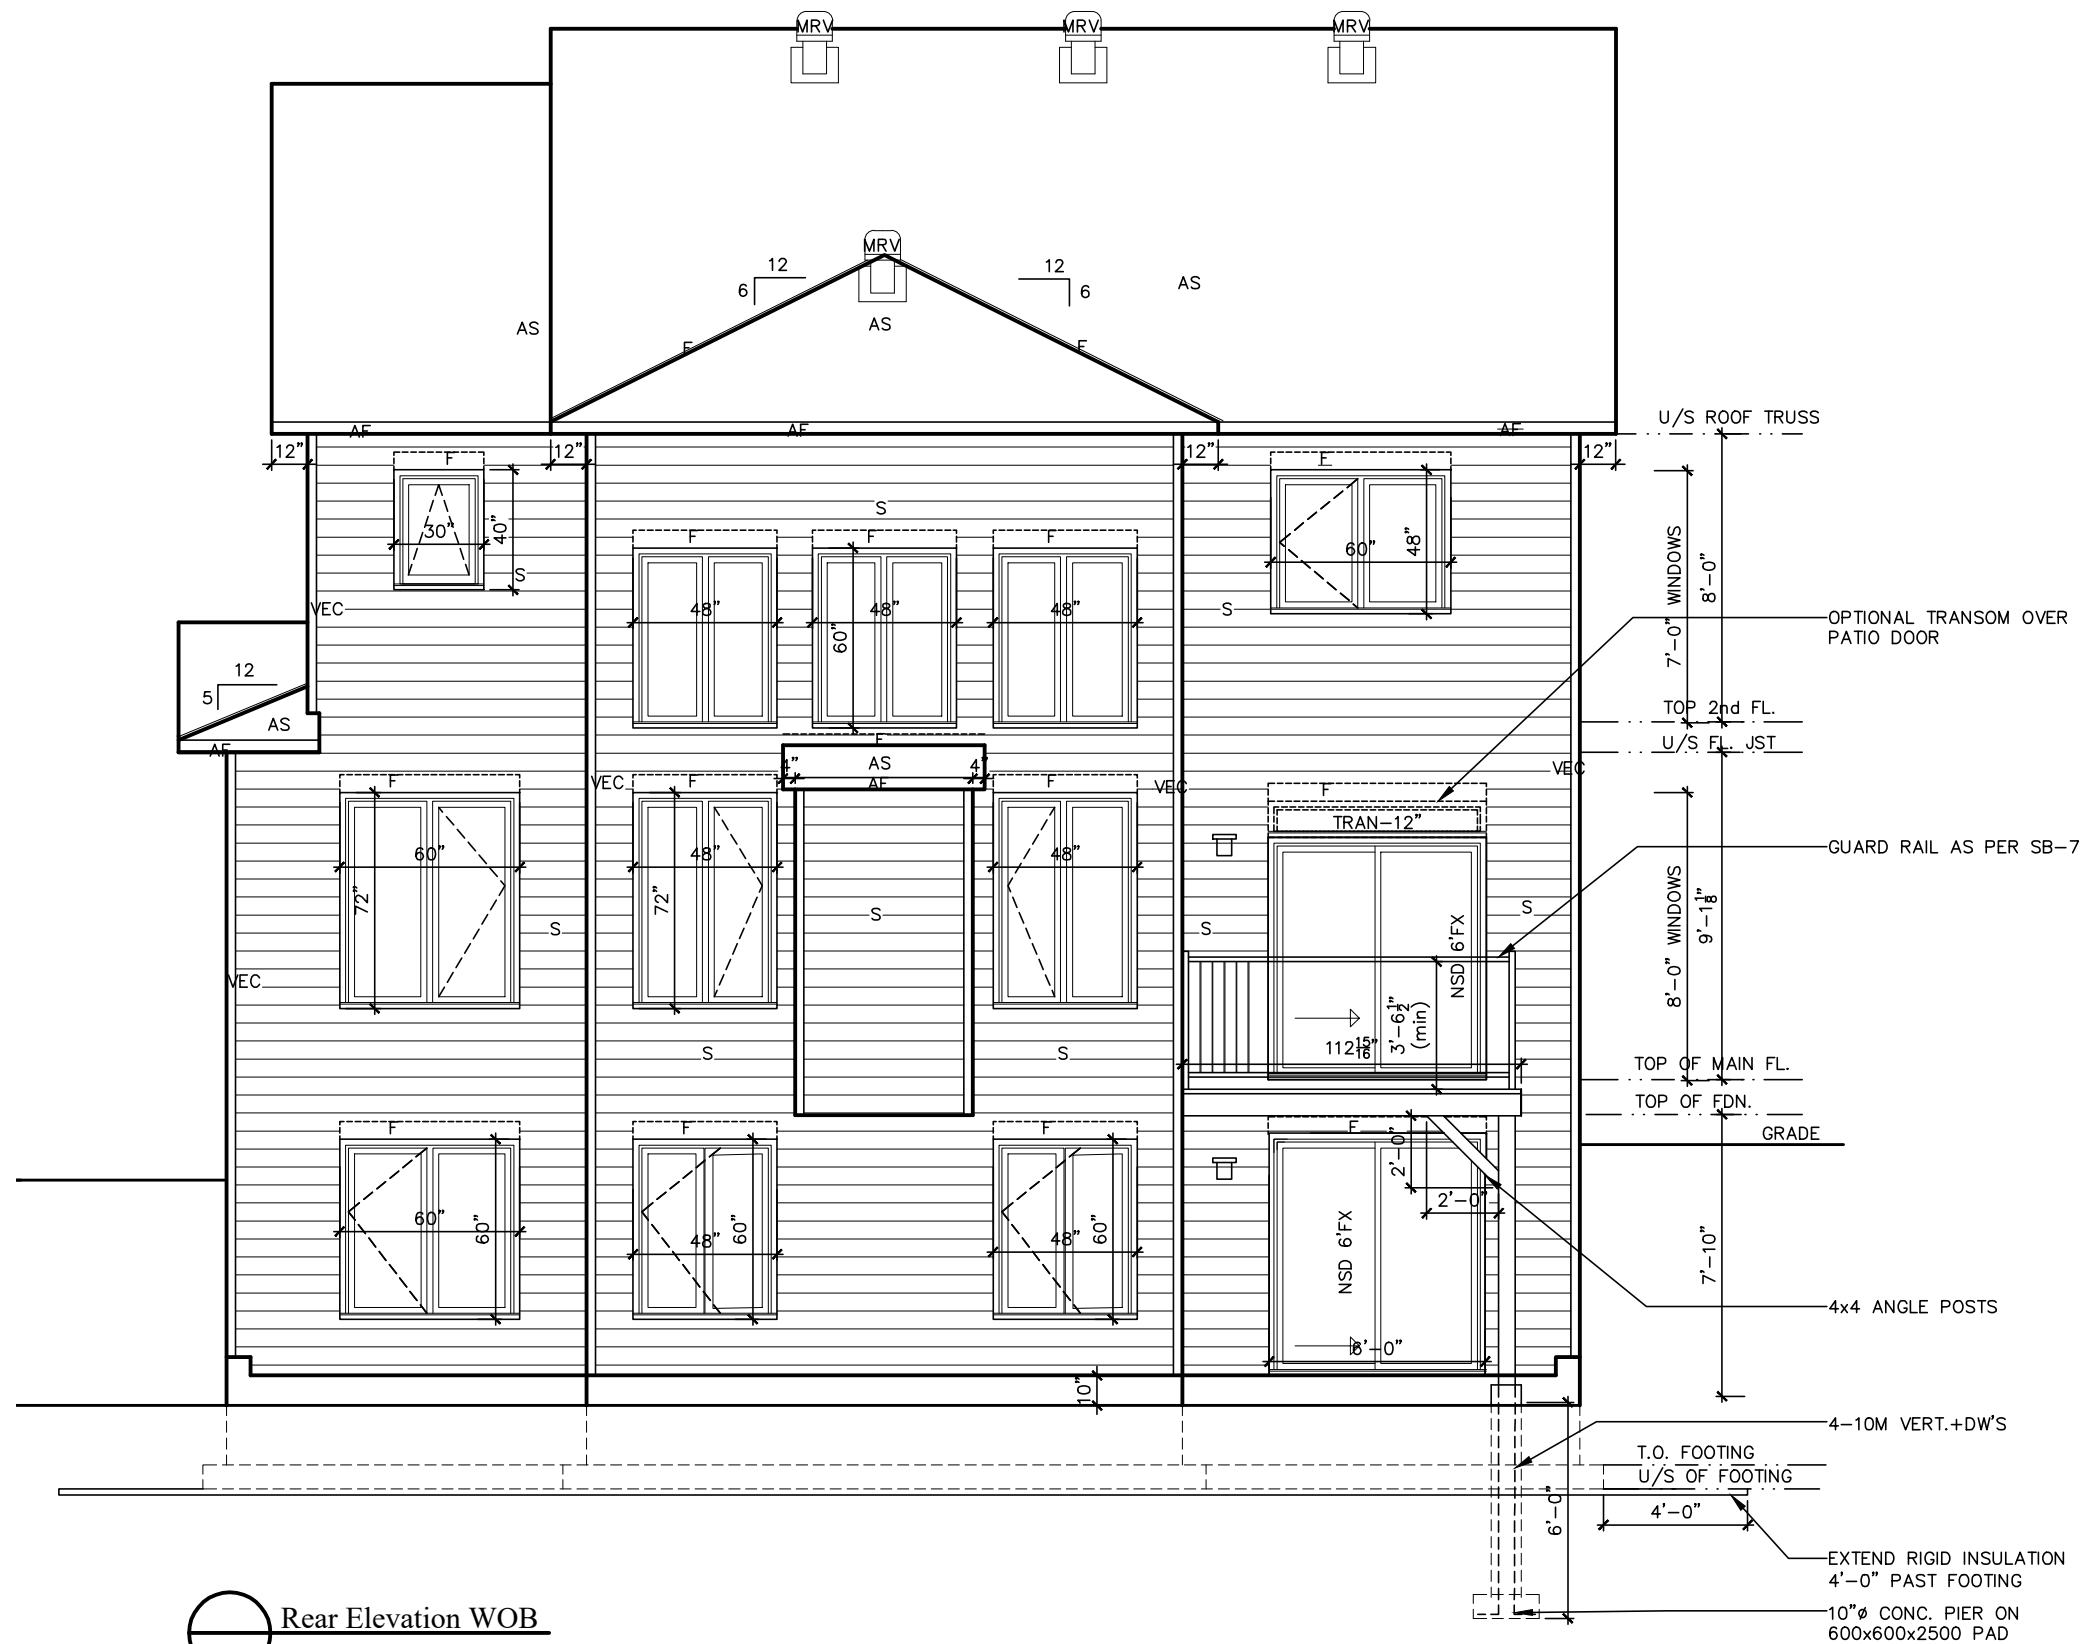

LOT **XXxx**

DATE **XX/XX/XX**

THIS DRAWING IS TO BE USED IN CONJUNCTION WITH SCHEDULE B-1A AND MAY SHOW ONLY SOME OF THE CHANGES DETAILED ON THAT DOCUMENT. SHOULD THE DRAWINGS NOT SHOW ALL ITEMS CONTAINED ON A SCHEDULE OR MISS OTHER ITEMS ALTOGETHER, THE SCHEDULE IS CONSIDERED THE GOVERNING DOCUMENT.

TENDER 2017

I SCOTT IRWIN BCIN 20765 HAVE REVIEWED AND TAKE RESPONSIBILITY FOR DESIGN ACTIVITIES RELATING TO, HOUSE & SMALL BUILDINGS.

2012 OBC DRAWINGS

2. AS PER STRUCTURAL		
1. STANDARD DRAWINGS	02/11/15	SI
NO. DESCRIPTION	DATE	BY

**Valecraft**
Home Ltd.

TITLE:
Rear Elevation WOB

ACAD FILE:
1086-The Steel
2012 Footprint
(STANDARD DRAWINGS)

SCALE:
3/16" = 1'-0"

DWG.
A-4c


LOT _____ XXxx

DATE _____ XX/XX/XX

THIS DRAWING IS TO BE USED IN CONJUNCTION WITH SCHEDULE B-1A AND MAY SHOW ONLY SOME OF THE CHANGES DETAILED ON THAT DOCUMENT. SHOULD THE DRAWINGS NOT SHOW ALL ITEMS CONTAINED ON A SCHEDULE OR MISS OTHER ITEMS ALTOGETHER, THE SCHEDULE IS CONSIDERED THE GOVERNING DOCUMENT.
FLOORS CONT

TENDER 2017

I SCOTT IRWIN BCIN 20765 HAVE REVIEWED AND TAKE RESPONSIBILITY FOR DESIGN ACTIVITIES RELATING TO, HOUSE & SMALL BUILDINGS.

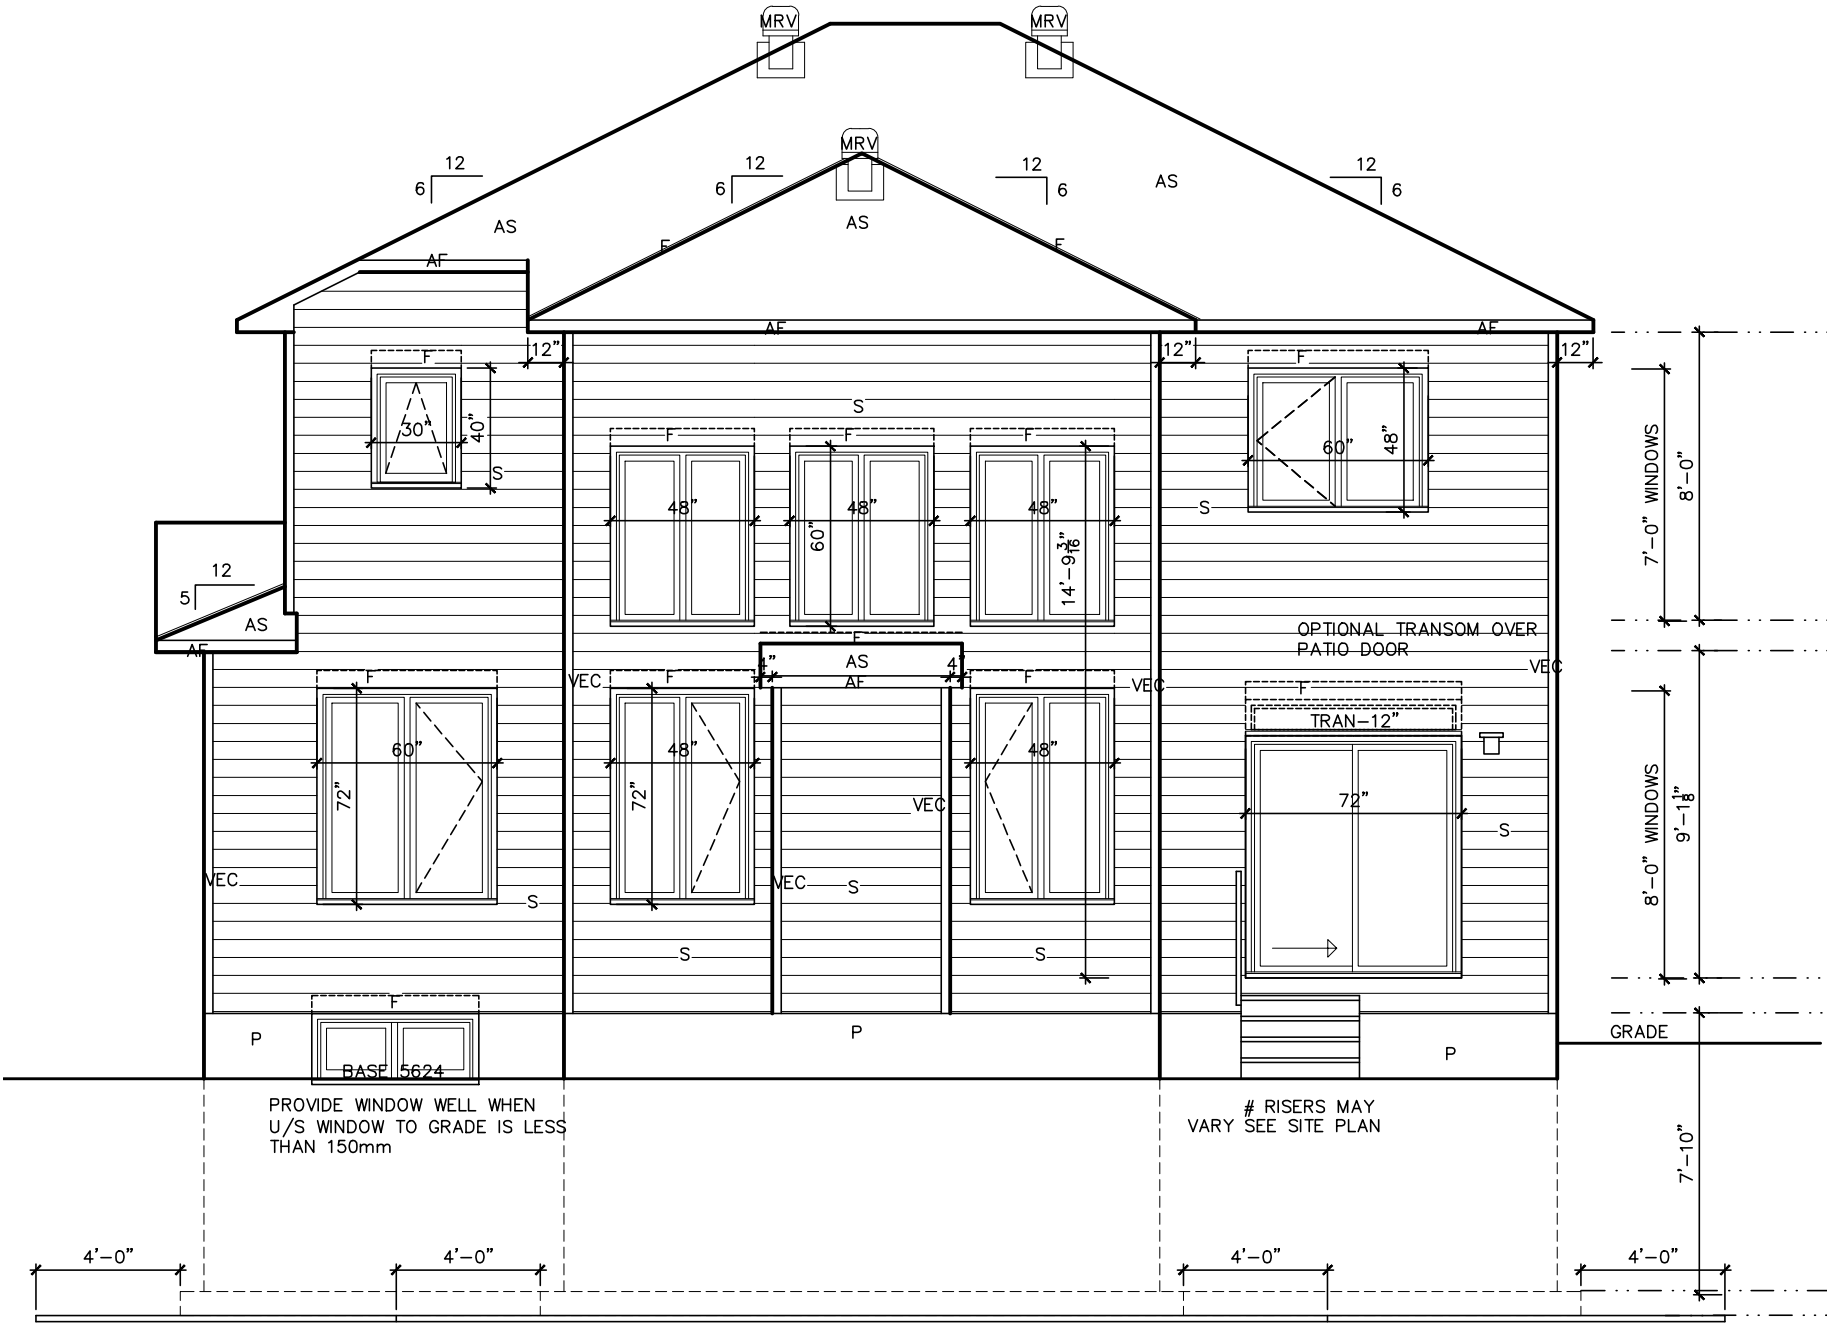

PROVIDE WINDOW WELL WHEN
U/S WINDOW TO GRADE IS LESS
THAN 150mm

RISERS MAY
VARY SEE SITE PLAN

2" RIGID INSULATION (HI 40) UNDER THE
FOOTINGS WITH EQUAL PROJECTION FROM
EXTERIOR & INTERIOR OF FOOTING.
THE SUM OF PROJECTION & HEIGHT OF BACKFILL

Rear Elevation B & C

2012 OBC DRAWINGS

NO	DESCRIPTION	DATE	BY
2.	AS PER STRUCTURAL		
1.	STANDARD DRAWINGS	02/11/15	SI




TITLE: Rear Elevation B & C

ACAD FILE: SCALE: 3/16" = 1'-0"

1086-The Steel
2012 Footprint
(STANDARD DRAWINGS)

A-4b

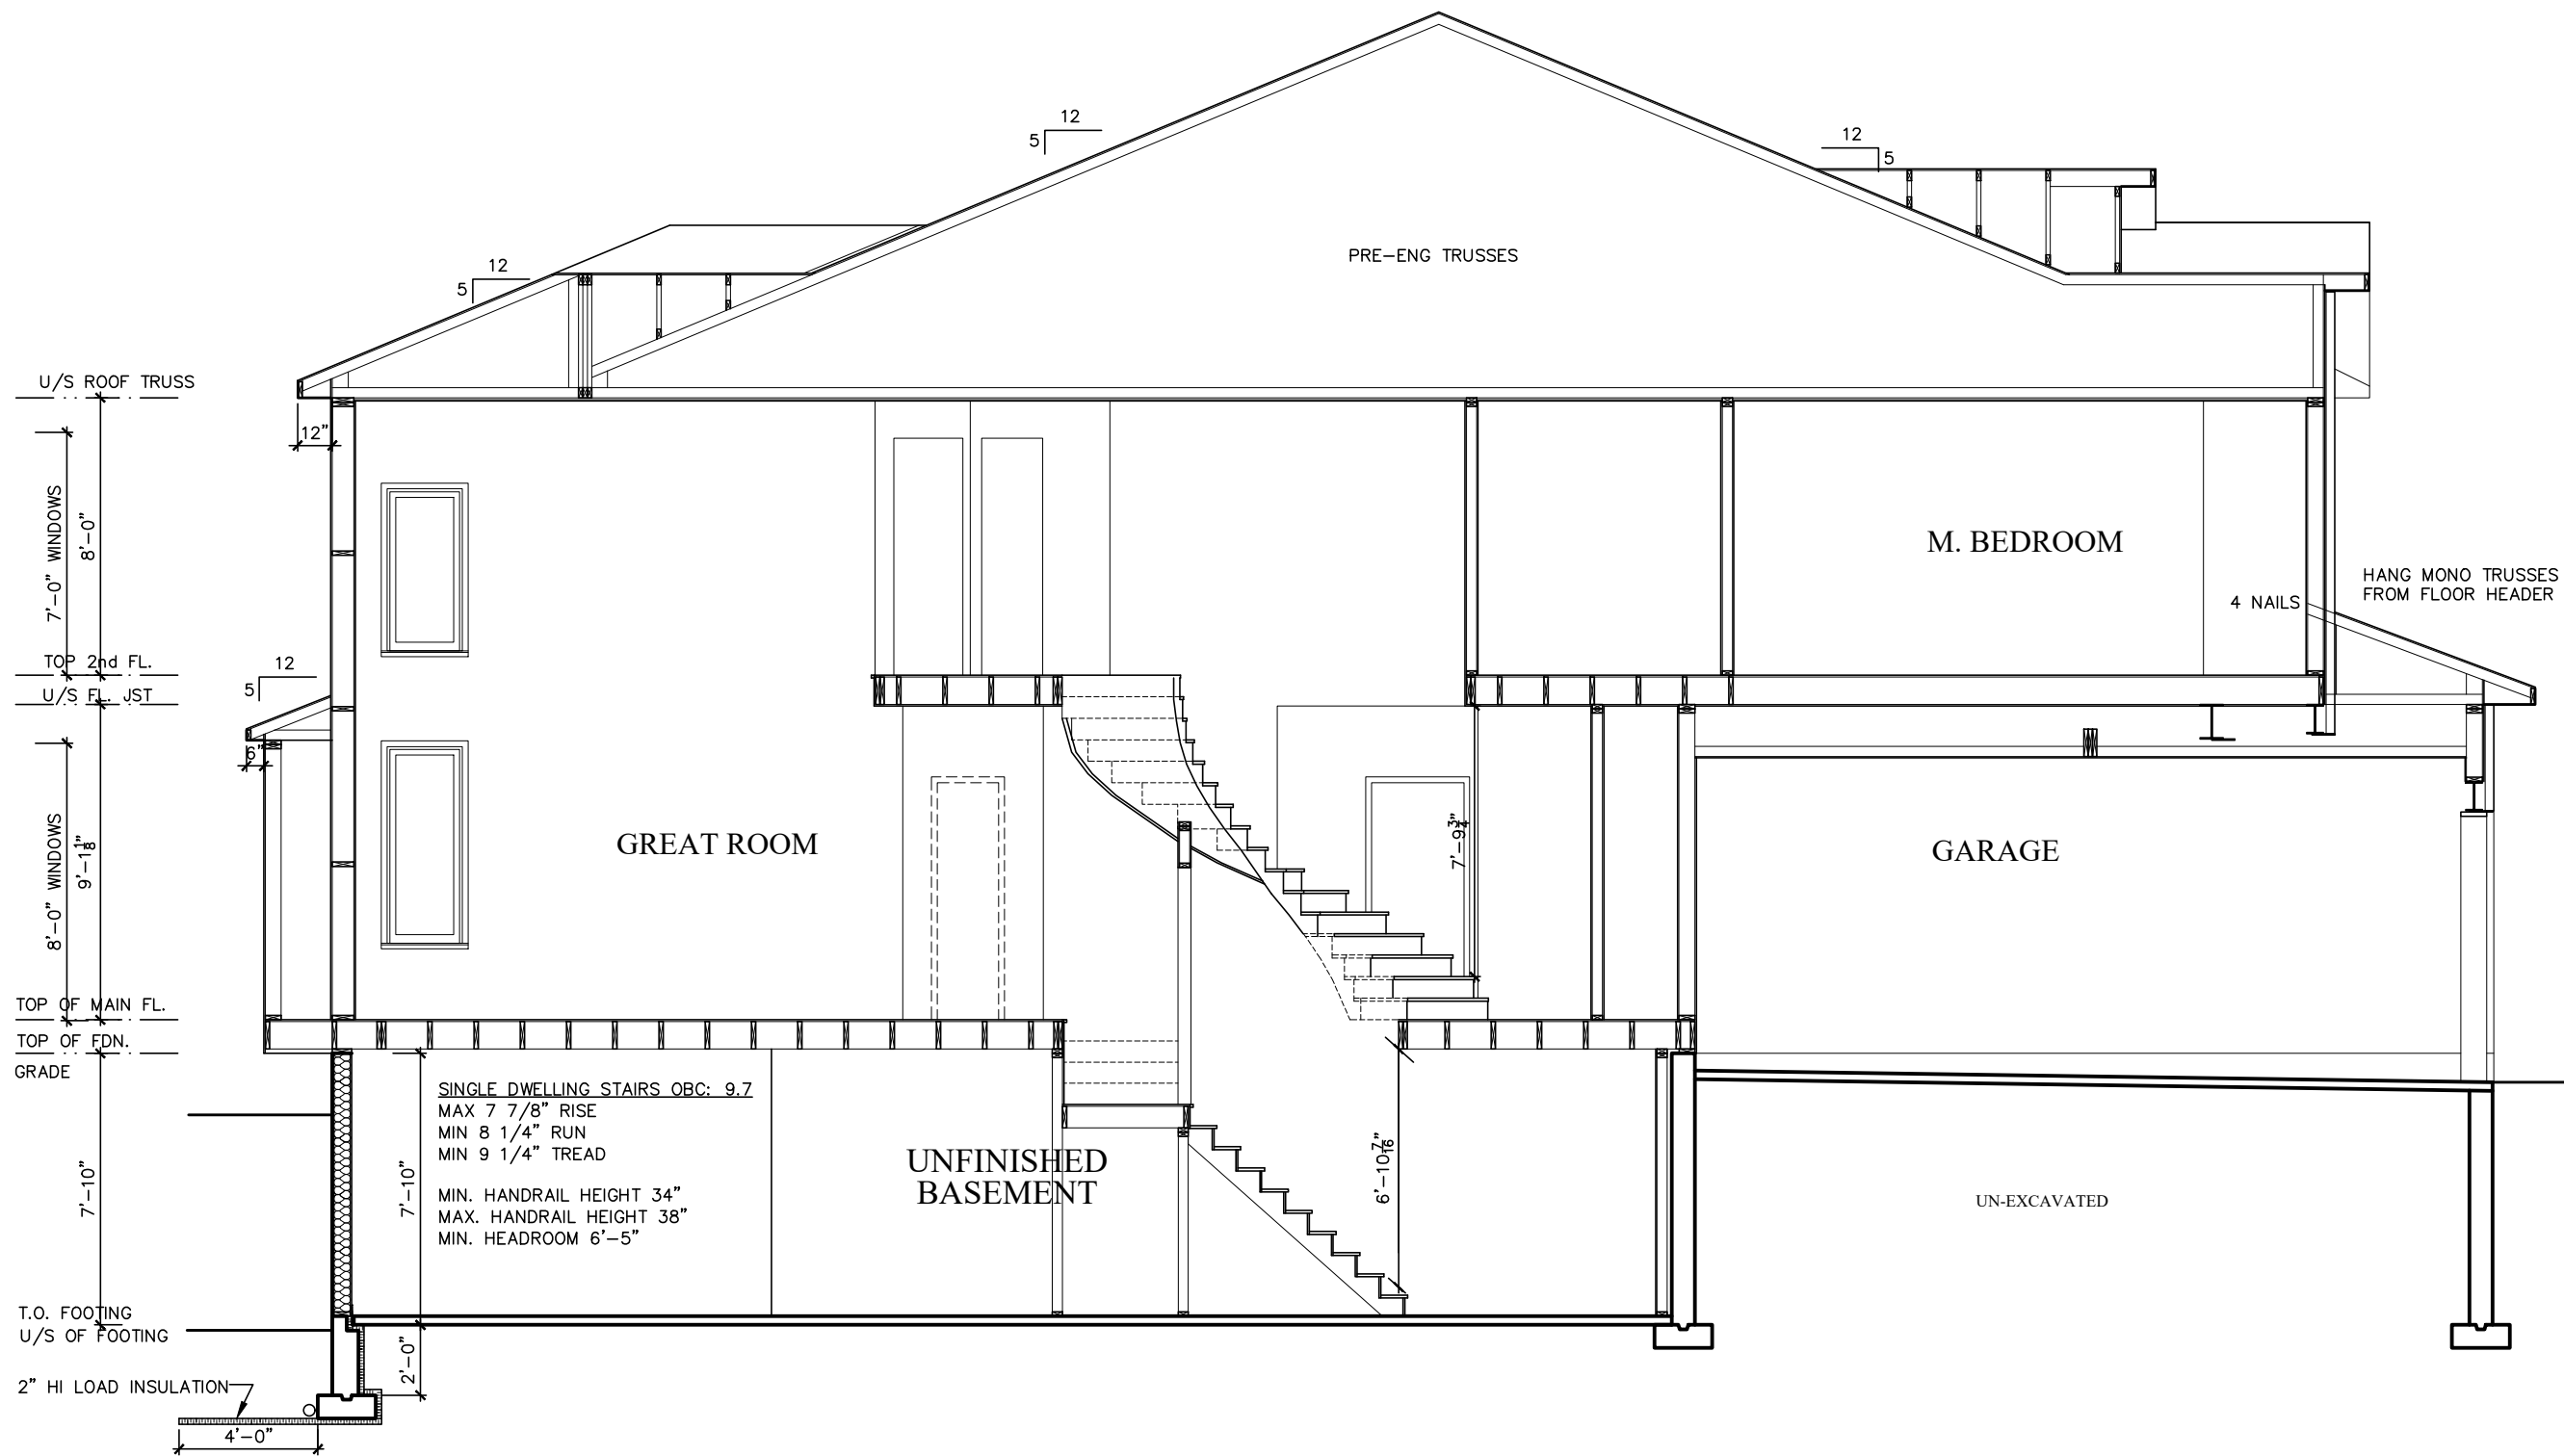

Section WOB

LOT XXxx
DATE XX/XX/XX
THIS DRAWINGS IS TO BE USED IN CONJUNCTION WITH SCHEDULE B-1A AND MAY SHOW ONLY SOME OF THE CHANGES DETAILED ON THAT DOCUMENT. SHOULD THE DRAWINGS NOT SHOW ALL ITEMS CONTAINED ON A SCHEDULE OR MISS OTHER ITEMS ALTOGETHER, THE SCHEDULE IS CONSIDERED THE GOVERNING DOCUMENT.
TENDER 2017
I SCOTT IRWIN BCIN 20765 HAVE REVIEWED AND TAKE RESPONSIBILITY FOR DESIGN ACTIVITIES RELATING TO, HOUSE & SMALL BUILDINGS.

2012 OBC DRAWINGS

2.	AS PER STRUCTURAL		
1.	STANDARD DRAWINGS	02/11/15	SI
NO.	DESCRIPTION	DATE	BY

Valecraft
Home Ld.

TITLE: Section WOB

ACAD FILE:	SCALE: 3/16" = 1'-0"
1086-The Steel 2012 Footprint (STANDARD DRAWINGS)	DWG. A-5B


LOT _____ XXxx

DATE _____ XX/XX/XX

THIS DRAWING IS TO BE USED IN CONJUNCTION WITH SCHEDULE B-1A AND MAY SHOW ONLY SOME OF THE CHANGES DETAILED ON THAT DOCUMENT. SHOULD THE DRAWINGS NOT SHOW ALL ITEMS CONTAINED ON A SCHEDULE OR MISS OTHER ITEMS ALTOGETHER, THE SCHEDULE IS CONSIDERED THE GOVERNING DOCUMENT.
FLOORS CONT

TENDER 2017

I SCOTT IRWIN BCIN 20765 HAVE REVIEWED AND TAKE RESPONSIBILITY FOR DESIGN ACTIVITIES RELATING TO, HOUSE & SMALL BUILDINGS.

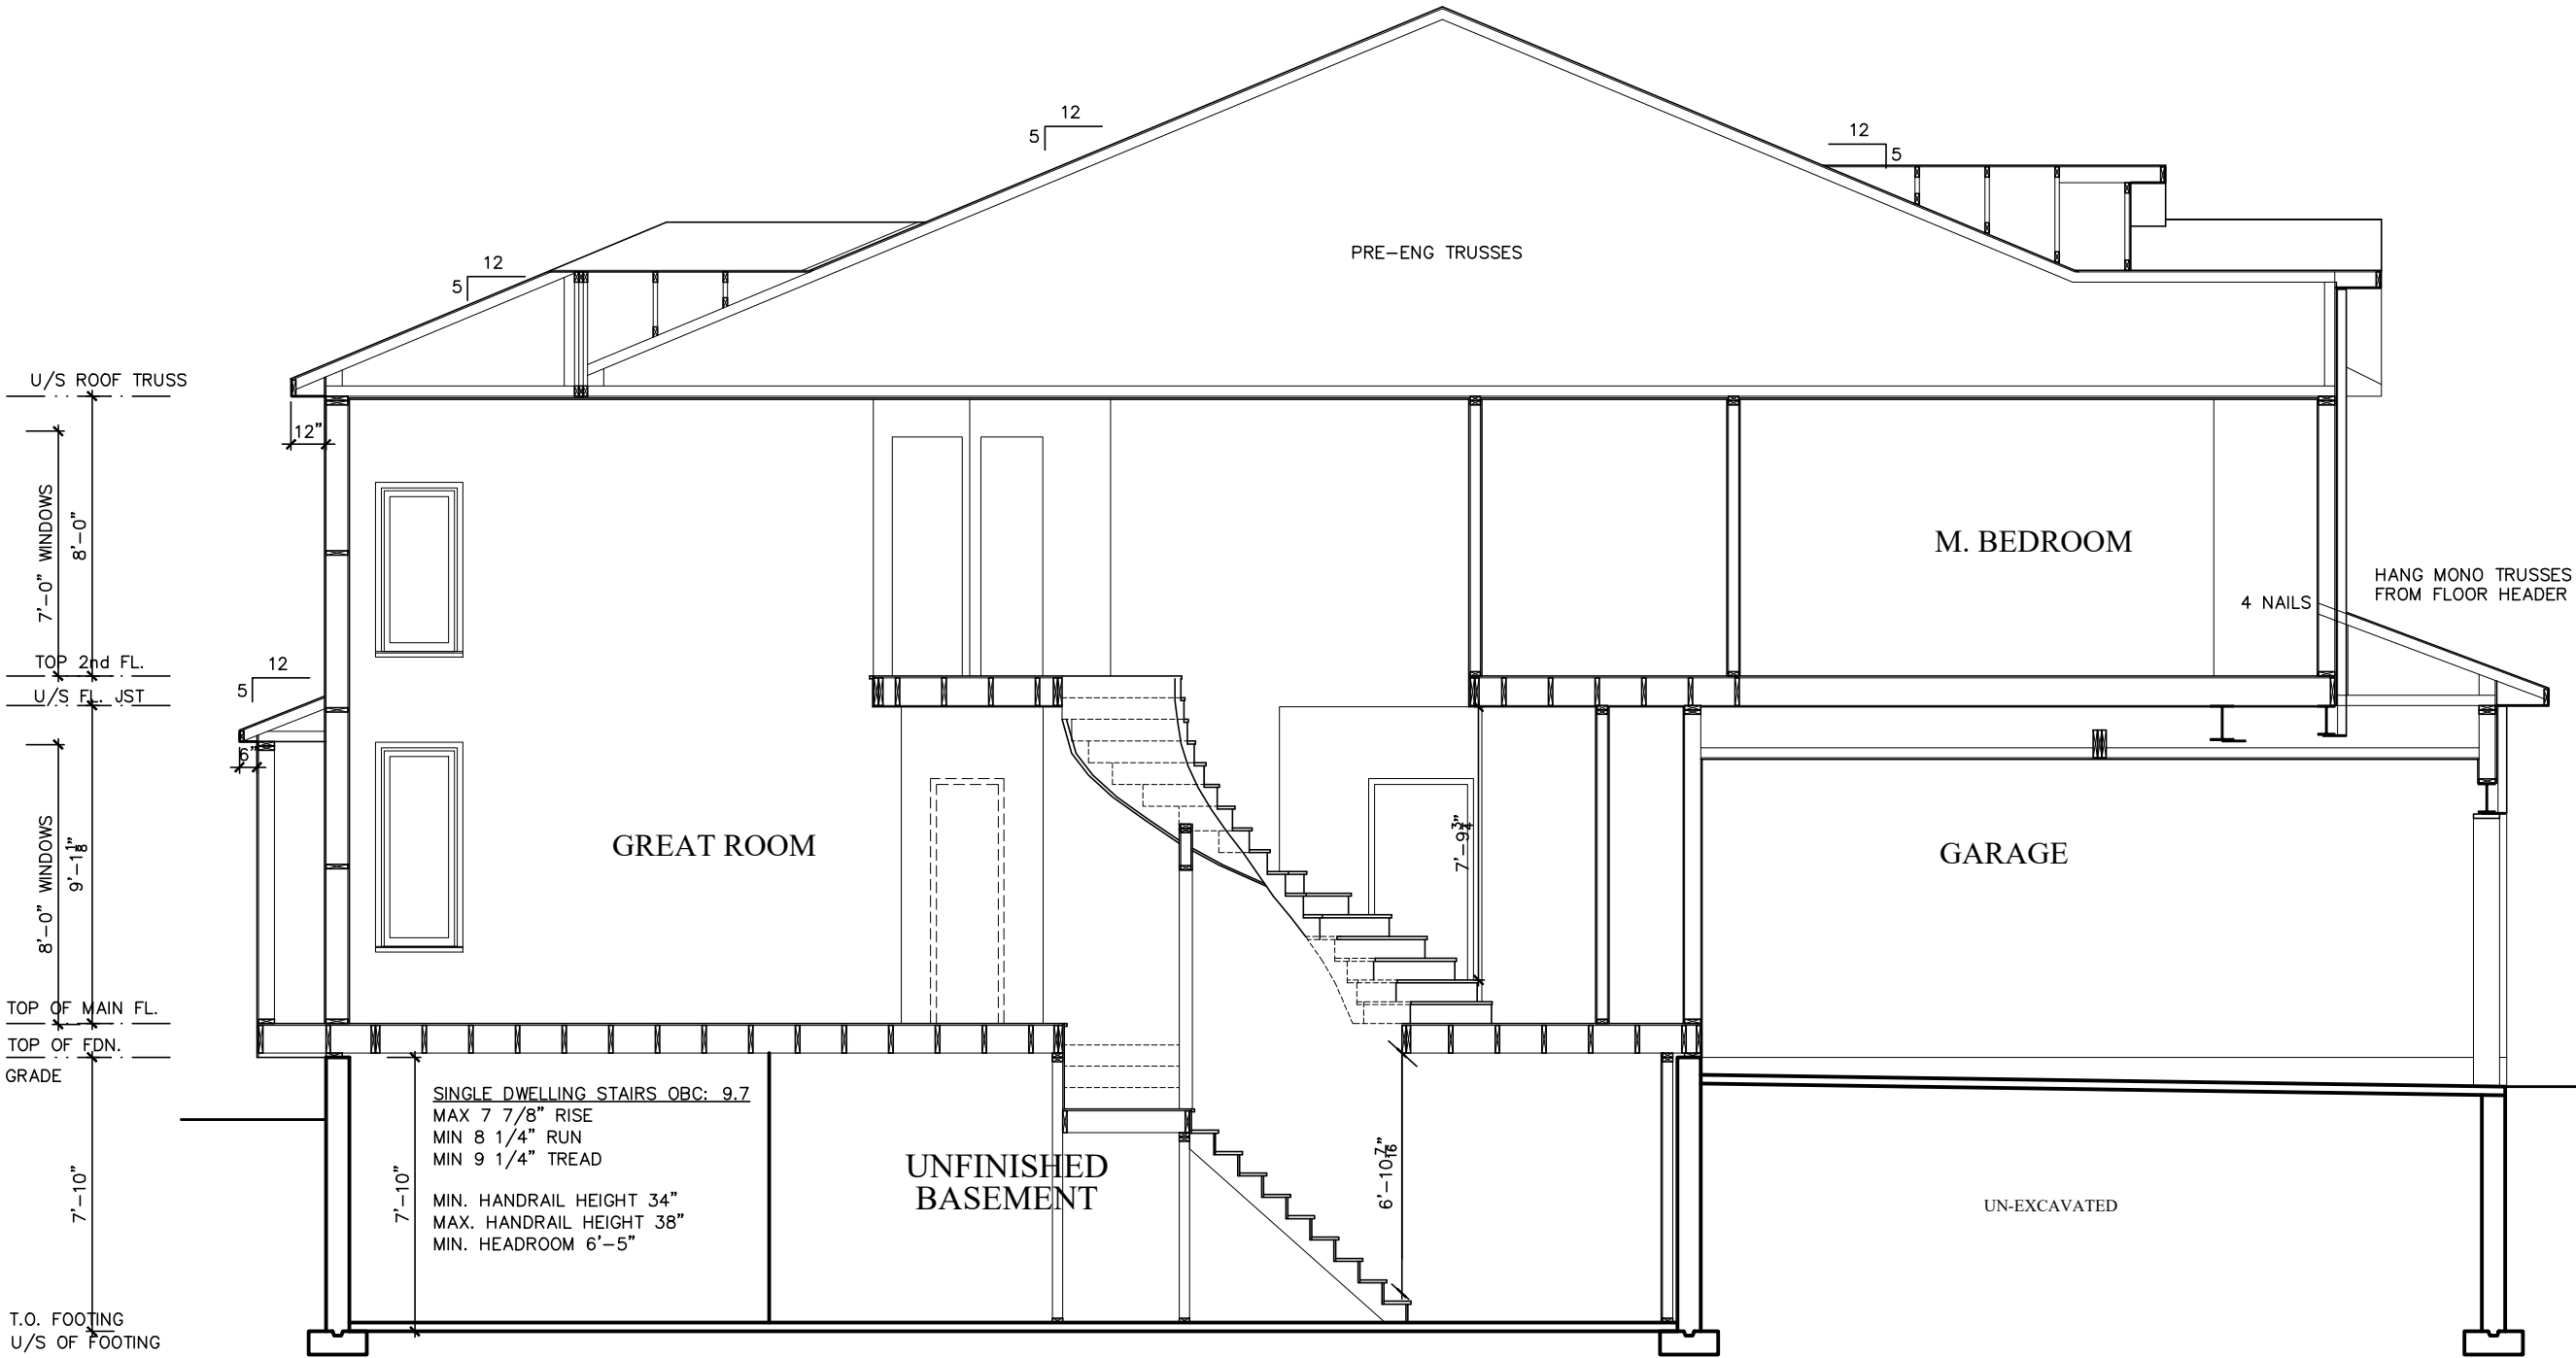

2012 OBC DRAWINGS

2.	AS PER STRUCTURAL		
1.	STANDARD DRAWINGS	02/11/15	SI
NO.	DESCRIPTION	DATE	BY



TITLE: Section

ACAD FILE: SCALE: 3/16" = 1'-0"

1086-The Steel 2012 Footprint (STANDARD DRAWINGS) DWG. A-5

THIS DRAWINGS IS TO BE USED IN CONJUNCTION WITH SCHEDULE B-1A AND MAY SHOW ONLY SOME OF THE CHANGES DETAILED ON THAT DOCUMENT. SHOULD THE DRAWINGS NOT SHOW ALL ITEMS CONTAINED ON A SCHEDULE OR MISS OTHER ITEMS ALTOGETHER, THE SCHEDULE IS CONSIDERED THE GOVERNING DOCUMENT.


TENDER 2017

I SCOTT IRWIN BCIN 20765 HAVE REVIEWED AND TAKE
RESPONSIBILITY FOR DESIGN ACTIVITIES RELATING TO,
HOUSE & SMALL BUILDINGS_____.

STRUCTURAL FRAMING SCHEDULE

STEEL LINTEL

- S1 - L 90x90x6
S2 - L 90x90x8
S3 - L 100x90x8
S4 - L 125x90x8
S5 - L 125x90x8
S6 - L 200x100x12
S7 - L 150x100x1 (200mm BEARING)
- WOOD LINTEL
L1 - (2)38x235 w/ 12.7 PLYWOOD SPACER
L2 - (2)38x235
L3 - (2)38x235
L4 - (2)38x235 w/ 2-12.7 PLYWOOD SPACER
& 2 ROW of 90mm SPIRAL @ 200 o/c
L5 - (2)38x286 w/ 2-12.7 PLYWOOD SPACER
& 2 ROW of 90mm SPIRAL @ 200 o/c 2 SIDE
L6 - (2)45x240 L.L. 2.0e
L7 - (3)45x240 L.L. 2.0e
- POSTS
P1 - 75# STEEL TELEPOST
P2 - (2)38x89 or (2)38x140
P3 - (3)38x89 or (3)38x140
P4 - (4)38x89 or (4)38x140
P5 - (5)38x89 or (5)38x140
P6 - (6)38x89 or (6)38x140
- P13 - HSS 88.9x88.9x3.18 + 100x200x12 T&B PL.
(*)
P14 - HSS 89x89x4.8 + 100x200x12 T&B PL.
(*)
P15 - HSS 76.2x76.2x4.78 + 100x180x12 T&B PL.
(*)
P16 - HSS 76.2x76.2x4.78 + 130x130x12 T&B PL.
(*)
P17 - HSS 73.0 d. 0.4 x 100x180x12PL B. NOT
+ 130x160x10 T PL. (*)
(*) - 200mm ANCH PL. PL USE
- ALL FOOTINGS 600x200 DP. UNLESS NOTED
SOL: 100 KPA

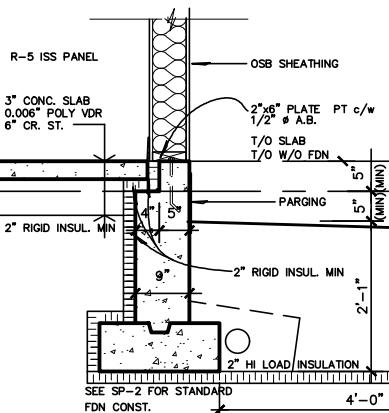

2012 OBC DRAWINGS

2.	AS PER STRUCTURAL		
1.	STANDARD DRAWINGS	11/02/15	SI
NO	DESCRIPTION	DATE	BY




TITLE:

FOOTING PLAN

ACAD FILE:	SCALE: 3/16" = 1'-0"
------------	-------------------------

1086-The Steel
2012 Footprint

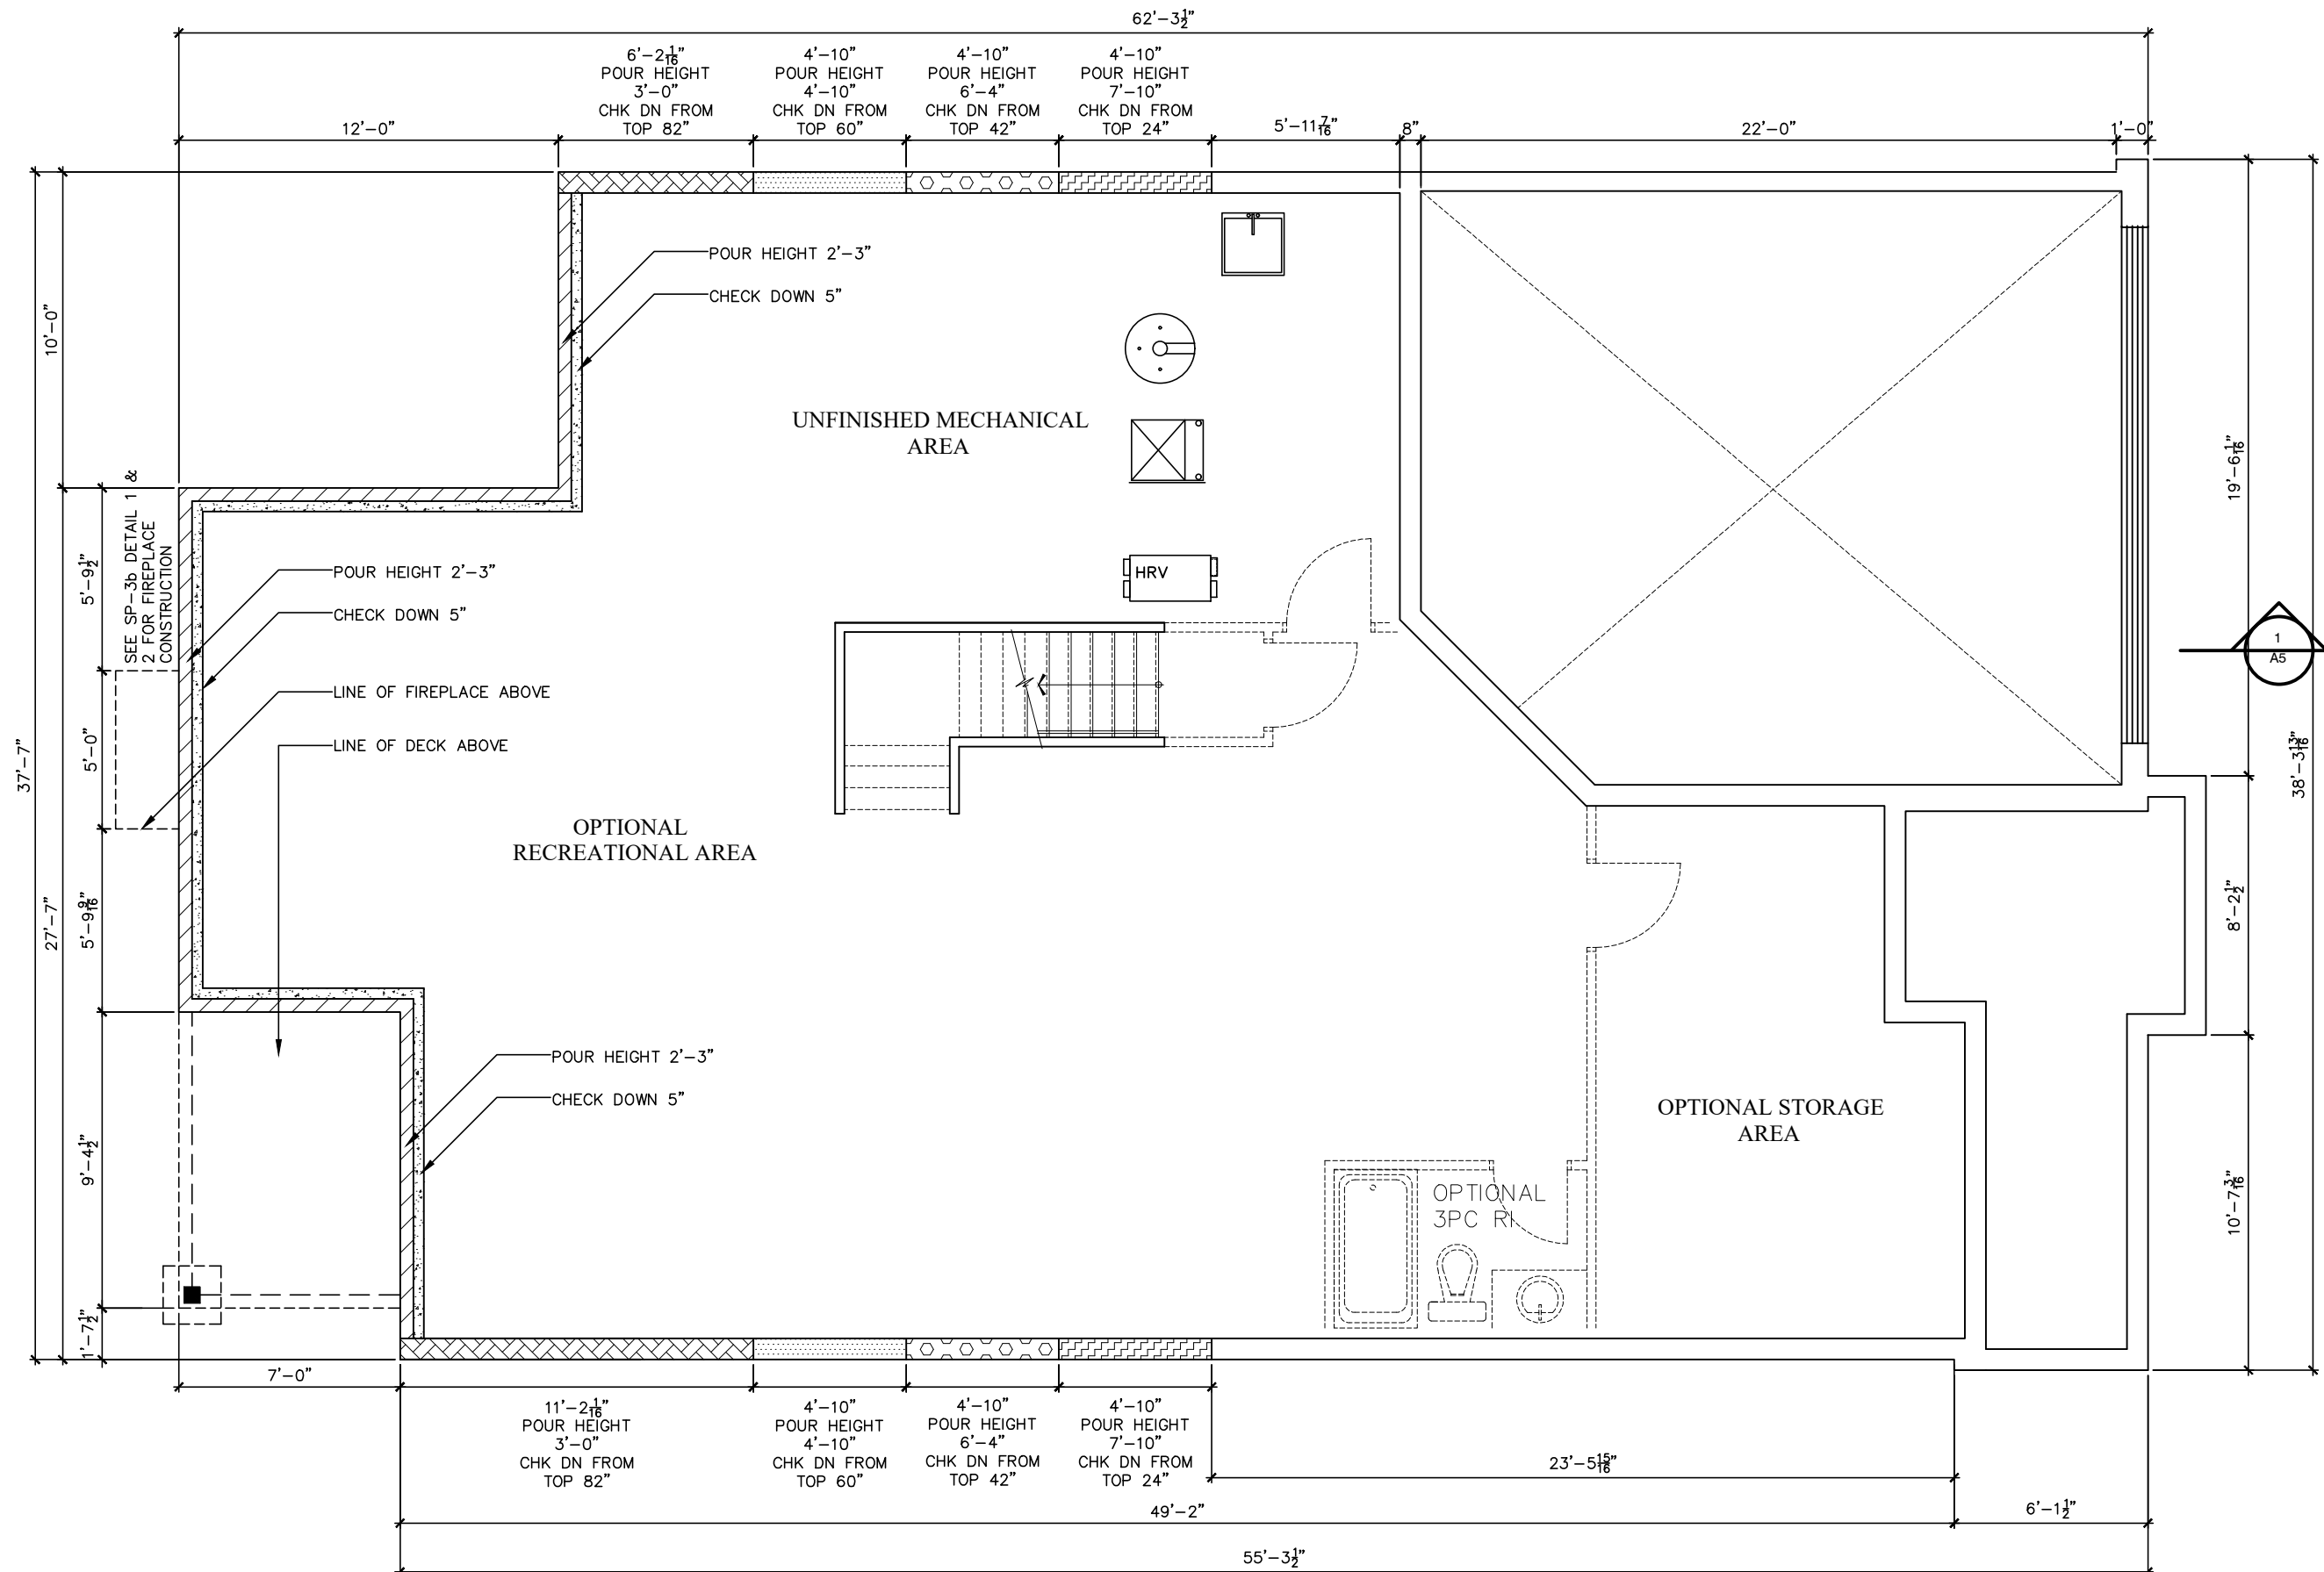

LOT **XXxx**

DATE **XX/XX/XX**

THIS DRAWING IS TO BE USED IN CONJUNCTION WITH SCHEDULE B-1A AND MAY SHOW ONLY SOME OF THE CHANGES DETAILED ON THAT DOCUMENT. SHOULD THE DRAWINGS NOT SHOW ALL ITEMS CONTAINED ON A SCHEDULE OR MISS OTHER ITEMS ALTOGETHER, THE SCHEDULE IS CONSIDERED THE GOVERNING DOCUMENT.
FLOORS CONT

TENDER 2017

I **SCOTT IRWIN BCIN 20765** HAVE REVIEWED AND TAKE RESPONSIBILITY FOR DESIGN ACTIVITIES RELATING TO, HOUSE & SMALL BUILDINGS.

STRUCTURAL FRAMING SCHEDULE

- STEEL LINTEL**
- S1 - 90x90x6
 - S2 - L 90x90x8
 - S3 - L 100x90x8
 - S4 - L 125x90x8
 - S5 - L 125x90x10
 - S6 - L 200x100x12
 - S7 - L 150x100x10 (200mm BEARING)
- WOOD LINTEL**
- L1 - (2)38x235 w/ 12.7 PLYWOOD SPACER
 - L2 - (2)38x235
 - L3 - (3)38x235
 - L4 - (3)38x235 w/ 2-12.7 PLYWOOD SPACER & 2 ROW OF 90mm SPIRAL @ 200 o/c
 - L5 - (3)38x286 w/ 2-12.7 PLYWOOD SPACER & 2 ROW OF 90mm SPIRAL @ 200 o/c 2 SIDE
 - L6 - (2)45x240 L.L. 2.0e
 - L7 - (3)45x240 L.L. 2.0e
- POSTS**
- P1 - 75# STEEL TELEPOST
 - P2 - (2)38x89 or (2)38x140
 - P3 - (3)38x89 or (3)38x140
 - P4 - (4)38x89 or (4)38x140
 - P5 - (5)38x89 or (5)38x140
 - P6 - (6)38x89 or (6)38x140
 - P13 - HSS 88.9x88.9x3.18 + 100x200x12 T&B PL.
 - P14 - HSS 89x89x4.8 + 100x200x12 T&B PL.
 - P15 - HSS 76.2x76.2x4.78 + 100x180x12 T&B PL.
 - P16 - HSS 76.2x76.2x4.78 + 130x130x12 T&B PL.
 - P17 - HSS 73 Q.D. x4.8 + 100x180x12PL B PL. + 130x160x10 T PL. (*)
 - (*) - 2-12# ANCH (WHERE ANCH PL. NOT USED)
- ALL FOOTINGS 600x200 DP. UNLESS NOTED
SOIL: 100 KPA

2012 OBC DRAWINGS

2. AS PER STRUCTURAL		
1. STANDARD DRAWINGS	11/02/15	SI
NO. DESCRIPTION	DATE	BY




TITLE: **BASEMENT FLOOR PLAN WOB**

ACAD FILE: SCALE: **3/16" = 1'-0"**

1086-The Steel
2012 Footprint
(STANDARD DRAWINGS)


A-6C

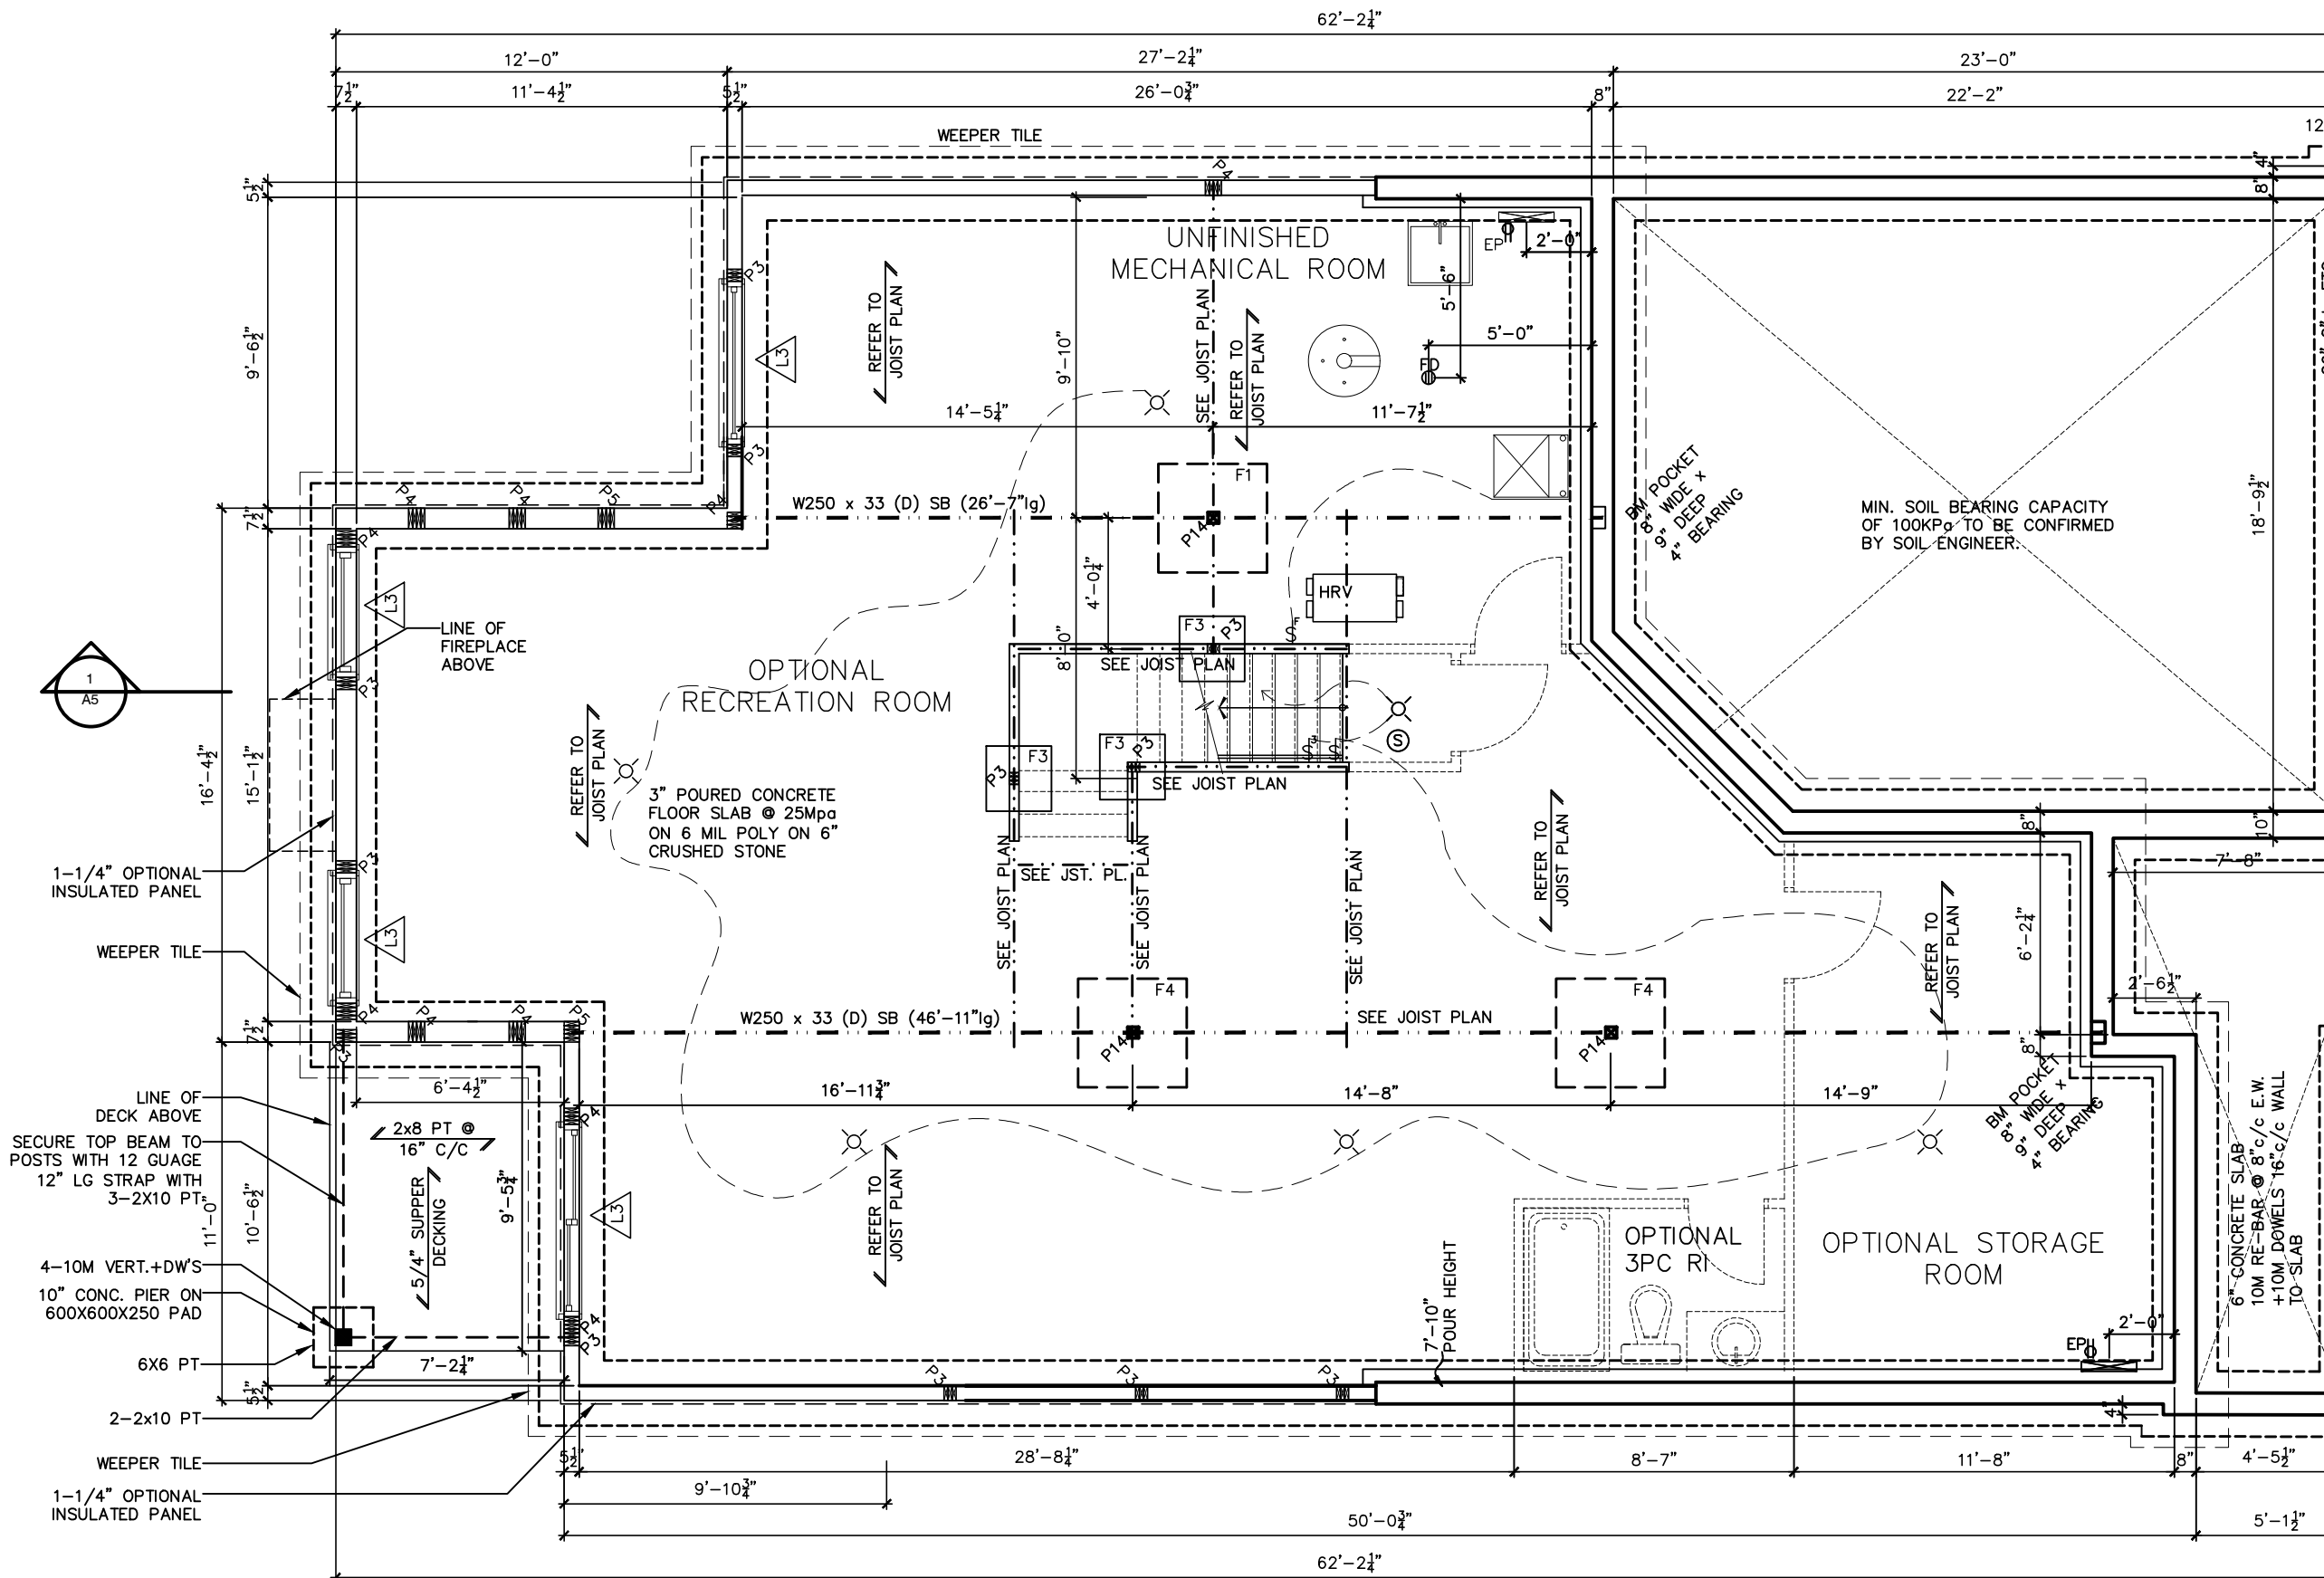

F1:
52"x52"x12"DP
5-15M(B)x45LG E.W.

F2:
48"x48"x10"DP

F3:
24"x24"x8"DP

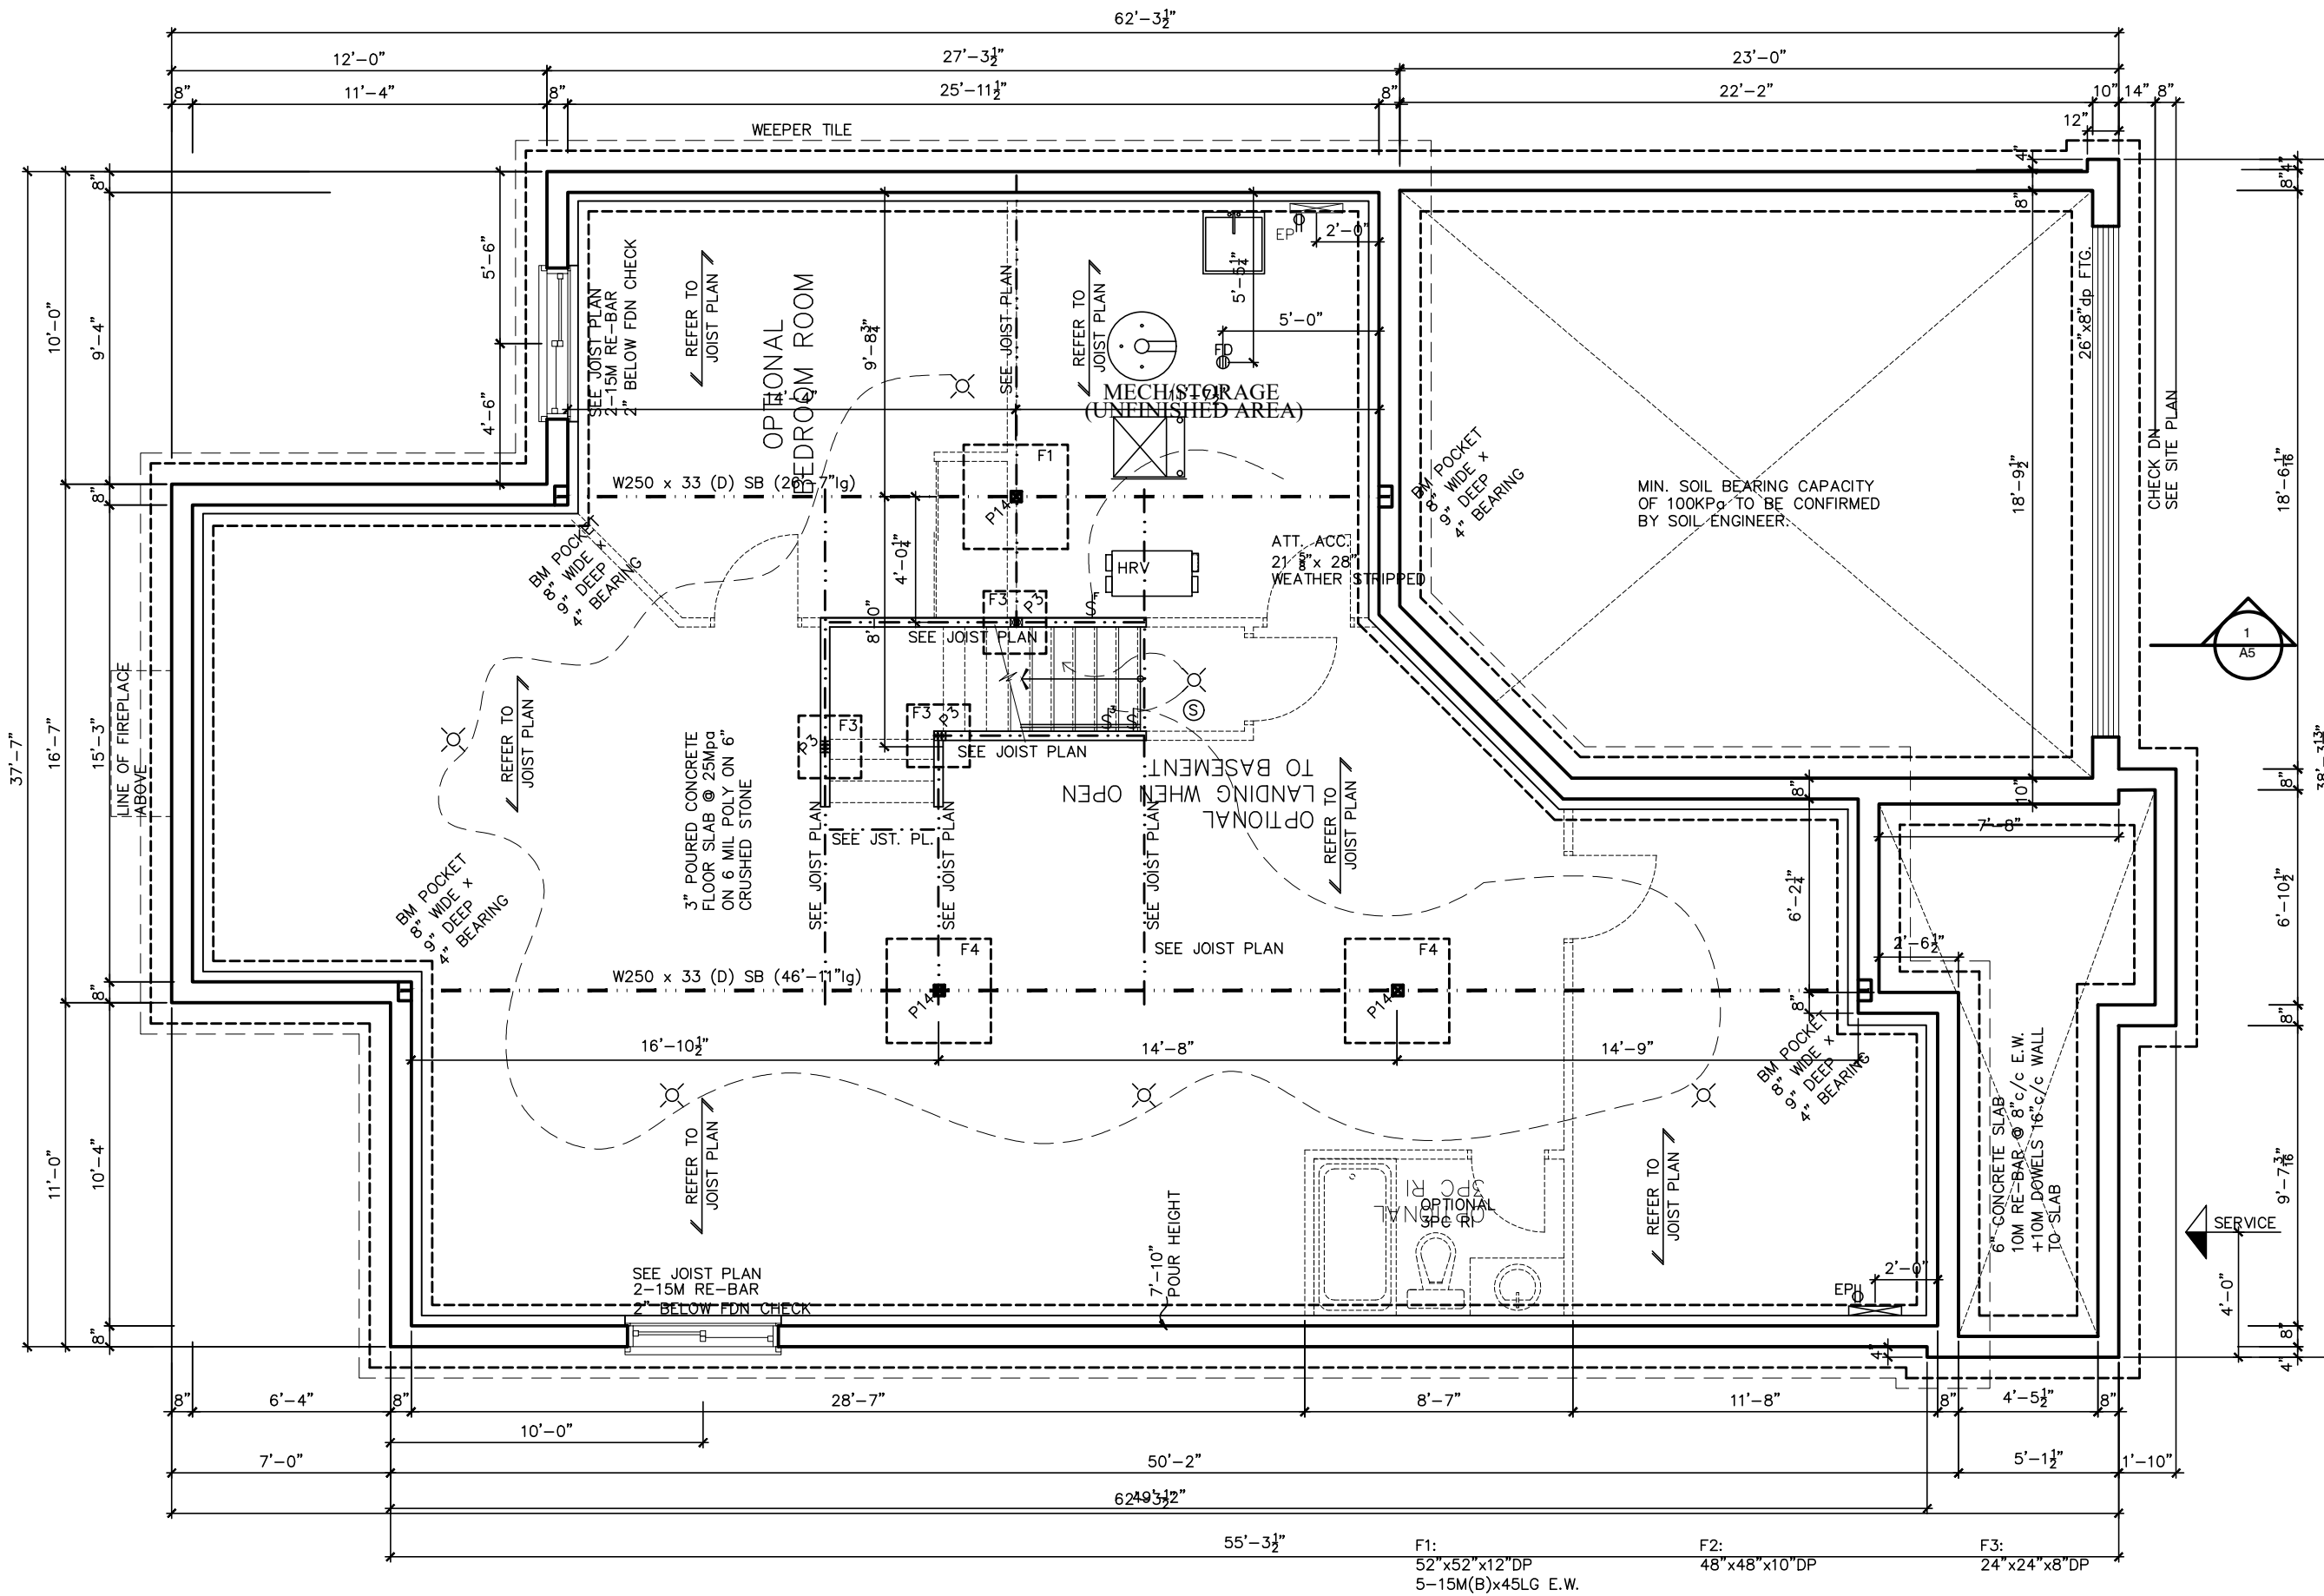

LOT **XXxx**

DATE **XX/XX/XX**

THIS DRAWING IS TO BE USED IN CONJUNCTION WITH SCHEDULE B-1A AND MAY SHOW ONLY SOME OF THE CHANGES DETAILED ON THAT DOCUMENT. SHOULD THE DRAWINGS NOT SHOW ALL ITEMS CONTAINED ON A SCHEDULE OR MISS OTHER ITEMS ALTOGETHER, THE SCHEDULE IS CONSIDERED THE GOVERNING DOCUMENT.
FLOORS CONT

TENDER 2017

I **SCOTT IRWIN BCIN 20765** HAVE REVIEWED AND TAKE RESPONSIBILITY FOR DESIGN ACTIVITIES RELATING TO, HOUSE & SMALL BUILDINGS.

STRUCTURAL FRAMING SCHEDULE

- STEEL LINTEL**
- S1 - 90x90x6
 - S2 - L 90x90x8
 - S3 - L 100x90x8
 - S4 - L 125x90x8
 - S5 - L 125x90x10
 - S6 - L 200x100x12
 - S7 - L 150x100x10 (200mm BEARING)
- WOOD LINTEL**
- L1 - (2)38x235 w/ 12.7 PLYWOOD SPACER
 - L2 - (2)38x235
 - L3 - (3)38x235
 - L4 - (3)38x235 w/ 2-12.7 PLYWOOD SPACER & 2 ROW OF 90mm SPIRAL @ 200 o/c
 - L5 - (3)38x286 w/ 2-12.7 PLYWOOD SPACER & 2 ROW OF 90mm SPIRAL @ 200 o/c 2 SIDE
 - L6 - (2)45x240 L.L. 2.0e
 - L7 - (3)45x240 L.L. 2.0e
- POSTS**
- P1 - 75# STEEL TELEPOST
 - P2 - (2)38x89 or (2)38x140
 - P3 - (3)38x89 or (3)38x140
 - P4 - (4)38x89 or (4)38x140
 - P5 - (5)38x89 or (5)38x140
 - P6 - (6)38x89 or (6)38x140
 - P13 - HSS 88.9x88.9x3.18 + 100x200x12 T&B PL.
 - P14 - HSS 89x89x4.8 + 100x200x12 T&B PL.
 - P15 - HSS 76.2x76.2x4.78 + 100x180x12 T&B PL.
 - P16 - HSS 76.2x76.2x4.78 + 130x130x12 T&B PL.
 - P17 - HSS 73 O.D. x4.8 + 100x180x12PL B PL. + 130x160x10 T PL (*)
 - (*) - 2-12# ANCH (WHERE ANCH PL. NOT USED)
- ALL FOOTINGS 600x200 DP. UNLESS NOTED
SOIL: 100 KPA

2012 OBC DRAWINGS

NO.	DESCRIPTION	DATE	BY
2.	AS PER STRUCTURAL		
1.	STANDARD DRAWINGS	11/02/15	SI




TITLE: **BASEMENT FLOOR PLAN (A & C)**

ACAD FILE: SCALE: 3/16" = 1'-0"

DWG. **A-6**

1086-The Steel
2012 Footprint
(STANDARD DRAWINGS)

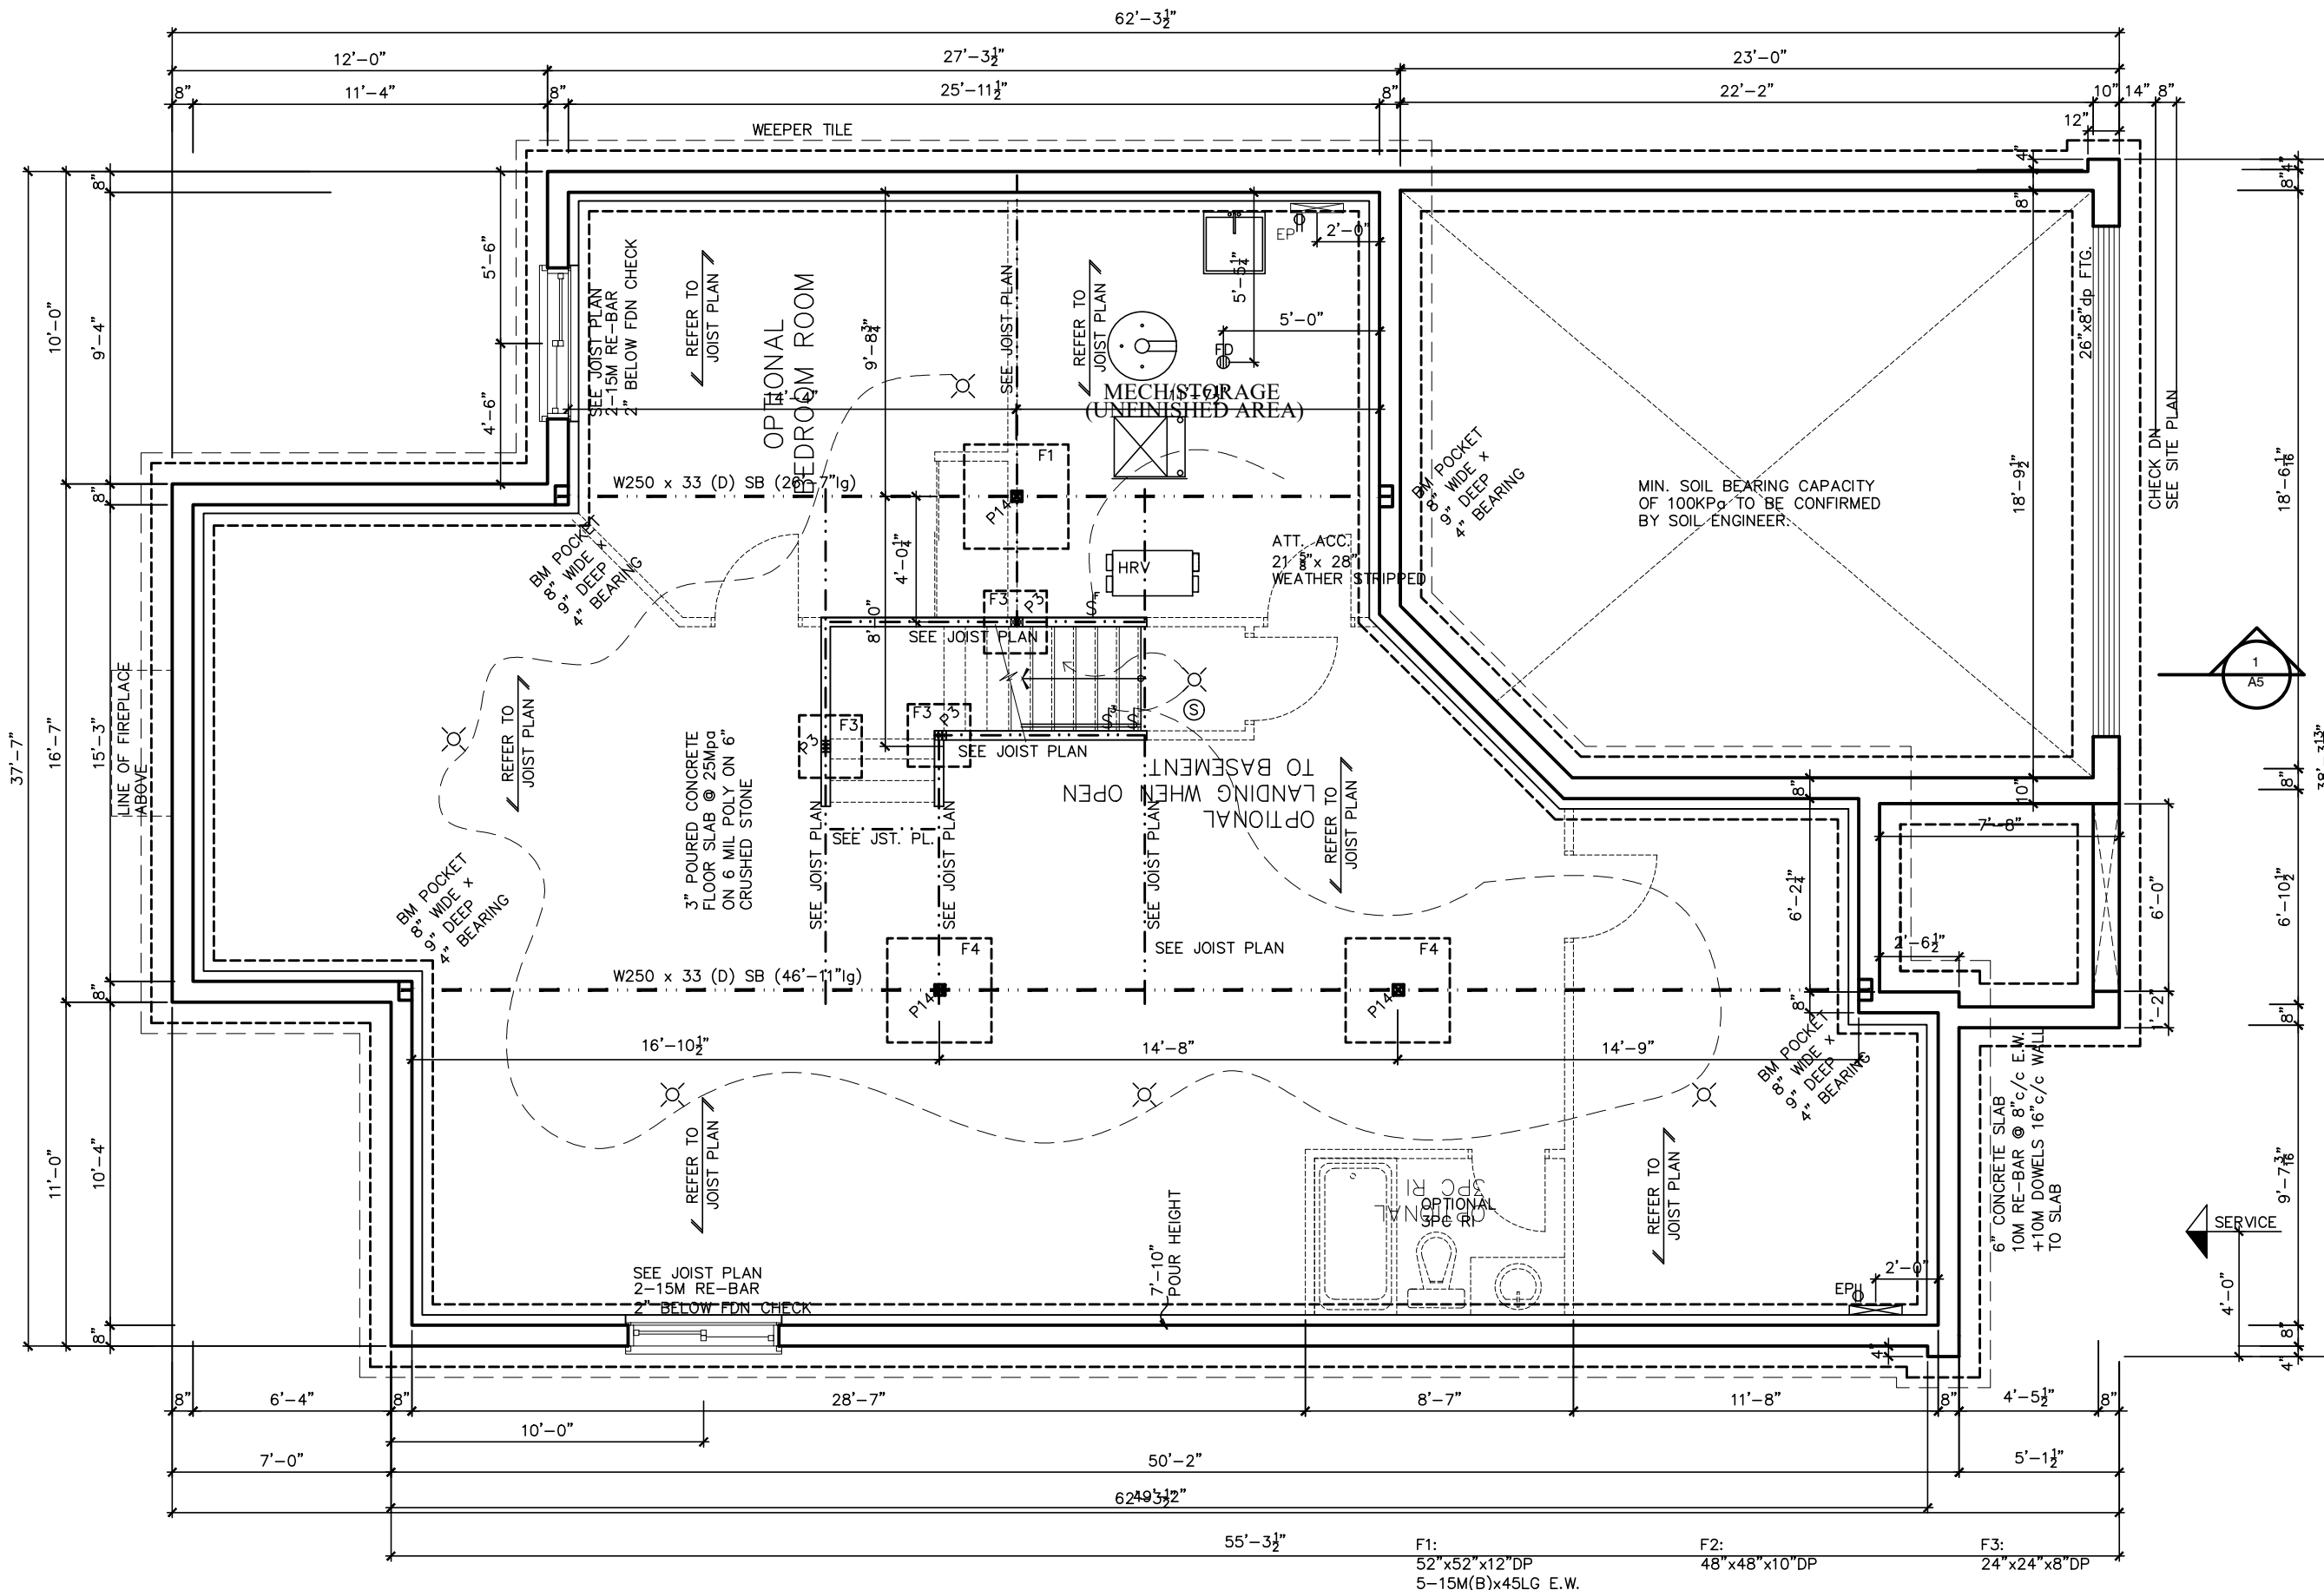

LOT **XXxx**

DATE **XX/XX/XX**

THIS DRAWING IS TO BE USED IN CONJUNCTION WITH SCHEDULE B-1A AND MAY SHOW ONLY SOME OF THE CHANGES DETAILED ON THAT DOCUMENT. SHOULD THE DRAWINGS NOT SHOW ALL ITEMS CONTAINED ON A SCHEDULE OR MISS OTHER ITEMS ALTOGETHER, THE SCHEDULE IS CONSIDERED THE GOVERNING DOCUMENT.
FLOORS CONT: **TENDER 2017**

I **SCOTT IRWIN BCIN 20765** HAVE REVIEWED AND TAKE RESPONSIBILITY FOR DESIGN ACTIVITIES RELATING TO, HOUSE & SMALL BUILDINGS.

- STRUCTURAL FRAMING SCHEDULE**
- STEEL LINTEL**
- S1 - 90x90x6
 - S2 - L 90x90x8
 - S3 - L 100x90x8
 - S4 - L 125x90x8
 - S5 - L 125x90x10
 - S6 - L 200x100x12
 - S7 - L 150x100x10 (200mm BEARING)
- WOOD LINTEL**
- L1 - (2)38x235 w/ 12.7 PLYWOOD SPACER
 - L2 - (2)38x235
 - L3 - (3)38x235
 - L4 - (3)38x235 w/ 2-12.7 PLYWOOD SPACER & 2 ROW OF 90mm SPIRAL @ 200 o/c
 - L5 - (3)38x286 w/ 2-12.7 PLYWOOD SPACER & 2 ROW OF 90mm SPIRAL @ 200 o/c 2 SIDE
 - L6 - (2)45x240 L.L. 2.0e
 - L7 - (3)45x240 L.L. 2.0e
- POSTS**
- P1 - 75# STEEL TELEPOST
 - P2 - (2)38x89 or (2)38x140
 - P3 - (3)38x89 or (3)38x140
 - P4 - (4)38x89 or (4)38x140
 - P5 - (5)38x89 or (5)38x140
 - P6 - (6)38x89 or (6)38x140
 - P13 - HSS 88.9x88.9x3.18 + 100x200x12 T&B PL.
 - P14 - HSS 89x89x4.8 + 100x200x12 T&B PL.
 - P15 - HSS 76.2x76.2x4.78 + 100x180x12 T&B PL.
 - P16 - HSS 76.2x76.2x4.78 + 130x130x12 T&B PL.
 - P17 - HSS 73 Q.D. x4.8 + 100x180x12PL B PL. + 130x160x10 T PL. (*)
 - (*) - 2-12# ANCH (WHERE ANCH PL. NOT USED)
- ALL FOOTINGS 600x200 DP. UNLESS NOTED
SOIL: 100 KPA

2012 OBC DRAWINGS

2. AS PER STRUCTURAL			
1. STANDARD DRAWINGS	11/02/15	SI	
NO. DESCRIPTION	DATE	BY	




TITLE: **BASEMENT FLOOR PLAN (B)**

ACAD FILE: SCALE: **3/16" = 1'-0"**

1086-The Steel
2012 Footprint
(STANDARD DRAWINGS)

DWG. **A-6b**

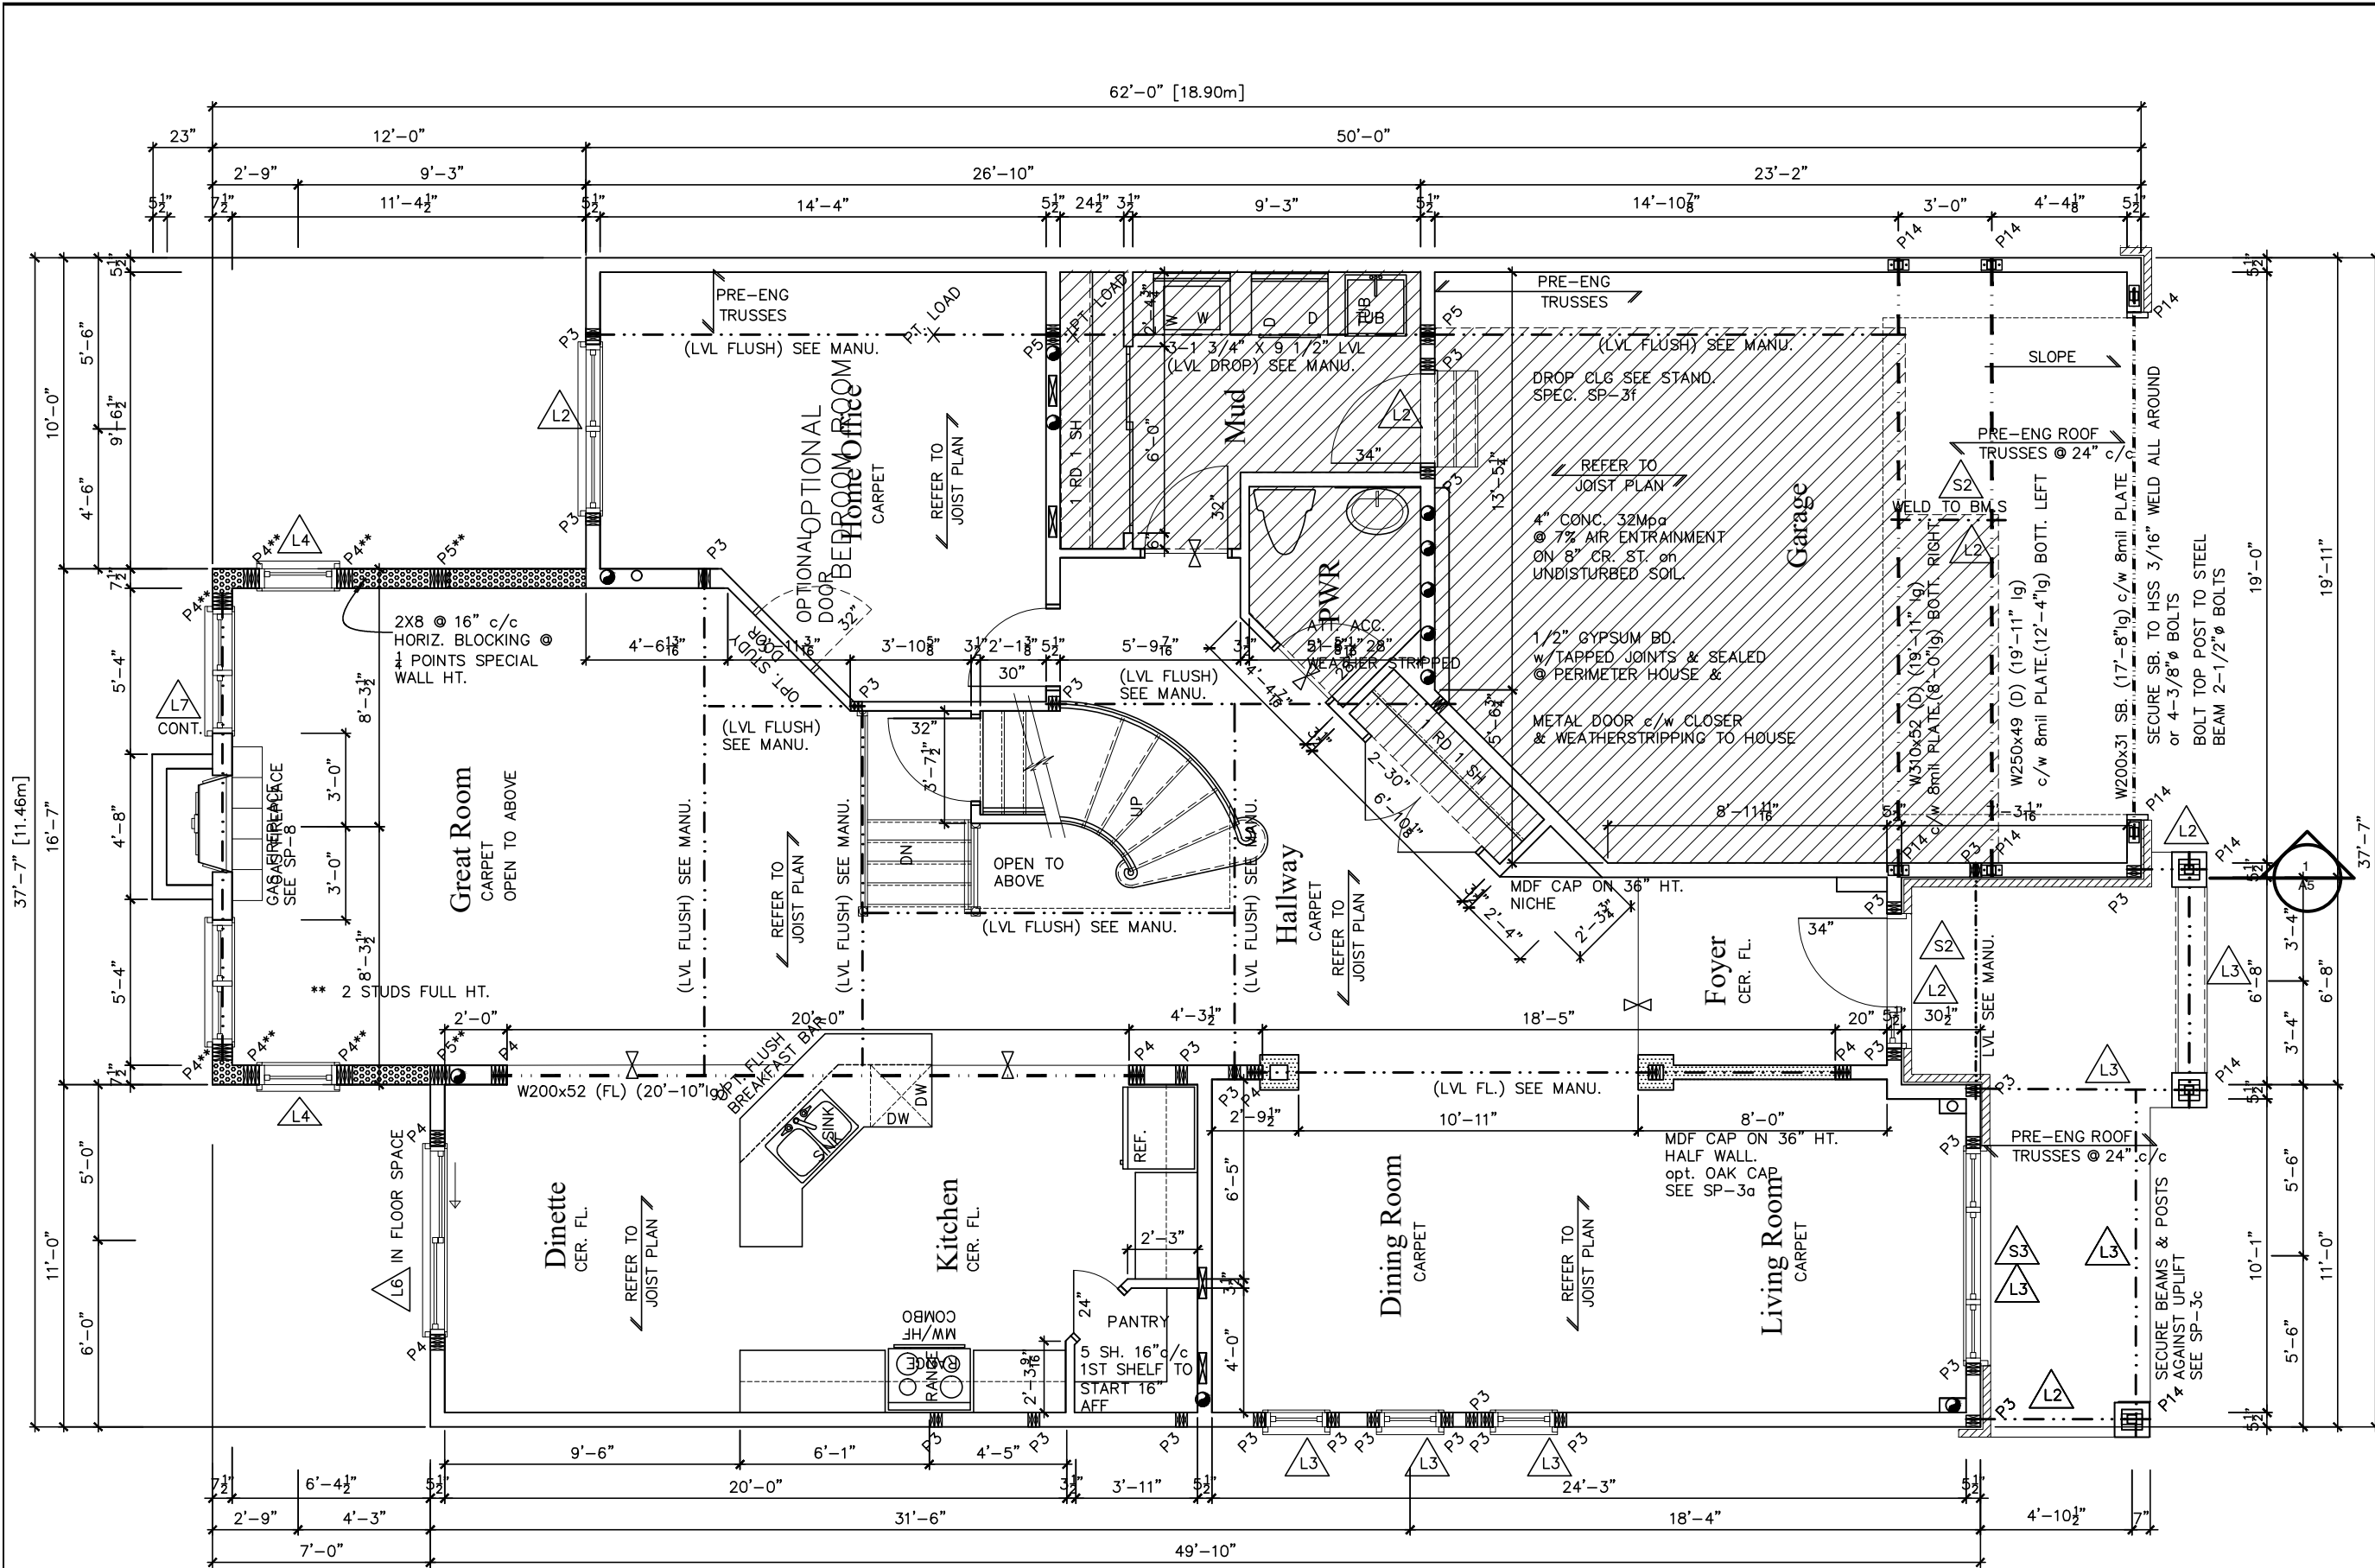

1st Floor Plan Elevation A

LOT

XXxx

DATE

XX/XX/XX

THIS DRAWING IS TO BE USED IN CONJUNCTION WITH SCHEDULE B-1A AND MAY SHOW ONLY SOME OF THE CHANGES DETAILED ON THAT DOCUMENT. SHOULD THE DRAWINGS NOT SHOW ALL ITEMS CONTAINED ON A SCHEDULE OR MISS OTHER ITEMS ALTOGETHER, THE SCHEDULE IS CONSIDERED THE GOVERNING DOCUMENT.

TENDER 2017

I SCOTT IRWIN BCIN 20765 HAVE REVIEWED AND TAKE RESPONSIBILITY FOR DESIGN ACTIVITIES RELATING TO, HOUSE & SMALL BUILDINGS.

STRUCTURAL FRAMING SCHEDULE

STEEL LINTEL

S1 - L 90x90x6

S2 - L 90x90x8

S3 - L 100x90x8

S4 - L 125x90x8

S5 - L 125x90x10

S6 - L 200x100x12

S7 - L 150x100x10 (200mm BEARING)

WOOD LINTEL

L1 - (2) 38x235 w/ 12.7 PLYWOOD SPACER

L2 - (2) 38x235

L3 - (3) 38x235

L4 - (3) 38x235 w/ 2-12.7 PLYWOOD SPACER

L5 - (3) 38x286 w/ 2-12.7 PLYWOOD SPACER

L6 - (2) ROW OF 90mm SPIRAL @ 200 o/c

L7 - (2) 45x240 L.L. 2.0e

POSTS

P1 - 75# STEEL TELEPOST

P2 - (2) 38x89 or (2) 38x140

P3 - (3) 38x89 or (3) 38x140

P4 - (4) 38x89 or (4) 38x140

P5 - (5) 38x89 or (5) 38x140

P6 - (6) 38x89 or (6) 38x140

P13 - HSS 88.9x88.9x3.18 + 100x200x12 T&B PL.

P14 - HSS 89x89x4.8 + 100x200x12 T&B PL.

P15 - HSS 76.2x76.2x4.78 + 100x180x12 T&B PL.

P16 - HSS 76.2x76.2x4.78 + 130x130x12 T&B PL.

P17 - HSS 73 O.D. x4.8 + 100x180x12 PL B PL. + 130x160x10 T PL. (*)

(*) - 2-12# ANCH (WHERE ANCH PL. NOT USED)

ALL FOOTINGS 600x200 DP. UNLESS NOTED

SOIL: 100 KPA

2012 OBC DRAWINGS

NO	DESCRIPTION	DATE	BY
2.	AS PER STRUCTURAL		
1.	STANDARD DRAWINGS	02/11/15	SI

Valecraft

Home Ltd.

TITLE:

1st Floor Plan Elevation A

ACAD FILE:

SCALE:

3/16" = 1'-0"

1086-The Steel 2012 Footprint

DWG.

A-7

THIS DRAWINGS IS TO BE USED IN CONJUNCTION WITH SCHEDULE B-1A AND MAY SHOW ONLY SOME OF THE CHANGES DETAILED ON THAT DOCUMENT. SHOULD THE DRAWINGS NOT SHOW ALL ITEMS CONTAINED ON A SCHEDULE OR MISS OTHER ITEMS ALTOGETHER, THE SCHEDULE IS CONSIDERED THE GOVERNING DOCUMENT.

FLOORS CONT

TENDER 2017

I SCOTT IRWIN BCIN 20765 HAVE REVIEWED AND TAKE
RESPONSIBILITY FOR DESIGN ACTIVITIES RELATING TO,
HOUSE & SMALL BUILDINGS_____.

STRUCTURAL FRAMING SCHEDULE

STEEL LINTEL

- S1 - L 90x90x6
- S2 - L 90x90x8
- S3 - L 100x90x8
- S4 - L 125x90x8
- S5 - L 125x90x10
- S6 - L 200x100x12
- S7 - L 150x100x10 (200mm BEARING)

WOOD LINTEL

WOOD LINTEL

L1	-(2)38x235	w/ 12.7 PLYWOOD SPACER
L2	-(2)38x235	
L3	-(3)38x235	
L4	-(3)38x235	w/ 2-12.7 PLYWOOD SPACER
	& 2 ROW OF	90mm SPIRAL @ 200 o/c
L5	-(3)38x286	w/ 2-12.7 PLYWOOD SPACER
	& 2 ROW OF	90mm SPIRAL @ 200 o/c 2 SIDE
L6	-(2)45x240	L.L 2.0e
L7	-(3)45x240	L.L 2.0e

POSTS
P1 - 75# STEEL TELEPOST
P2 - (2)38x89 or (2)38x140
P3 - (3)38x89 or (3)38x140
P4 - (4)38x89 or (4)38x140
P5 - (5)38x89 or (5)38x140
P6 - (6)38x89 or (6)38x140
P13 - HSS 88.9x88.9x3.18 + 100x200x12 T&B PL.
(*)
P14 - HSS 89x89x4.8 + 100x200x12 T&B PL.
(*)
P15 - HSS 76.2x76.2x4.78 + 100x180x12 T&B PL.
(*)
P16 - HSS 76.2x76.2x4.78 + 130x130x12 T&B PL.
(*)
P17 - HSS 73 O.D. x4.8 + 100x180x12PL B PL.
+ 130x160x10 T PL. (*)
(*) - 2-120 ANCH (WHERE ANCH PL. NOT USED)
ALL FOOTINGS 600x200 DP. UNLESS NOTED
SOIL: 100 KPA

2012 OBC DRAWINGS



2.	AS PER STRUCTURAL		
1.	STANDARD DRAWINGS	02/11/15	SI
NO	DESCRIPTION	DATE	BY



TITLE: 1st FLOOR PLAN ELEV B & C

ACAD FILE:	SCALE: 3/16" = 1'-0"
------------	-------------------------



1086-The Steel 2012 Footprint (STANDARD DRAWINGS)	DWG. A-7b
---	------------------

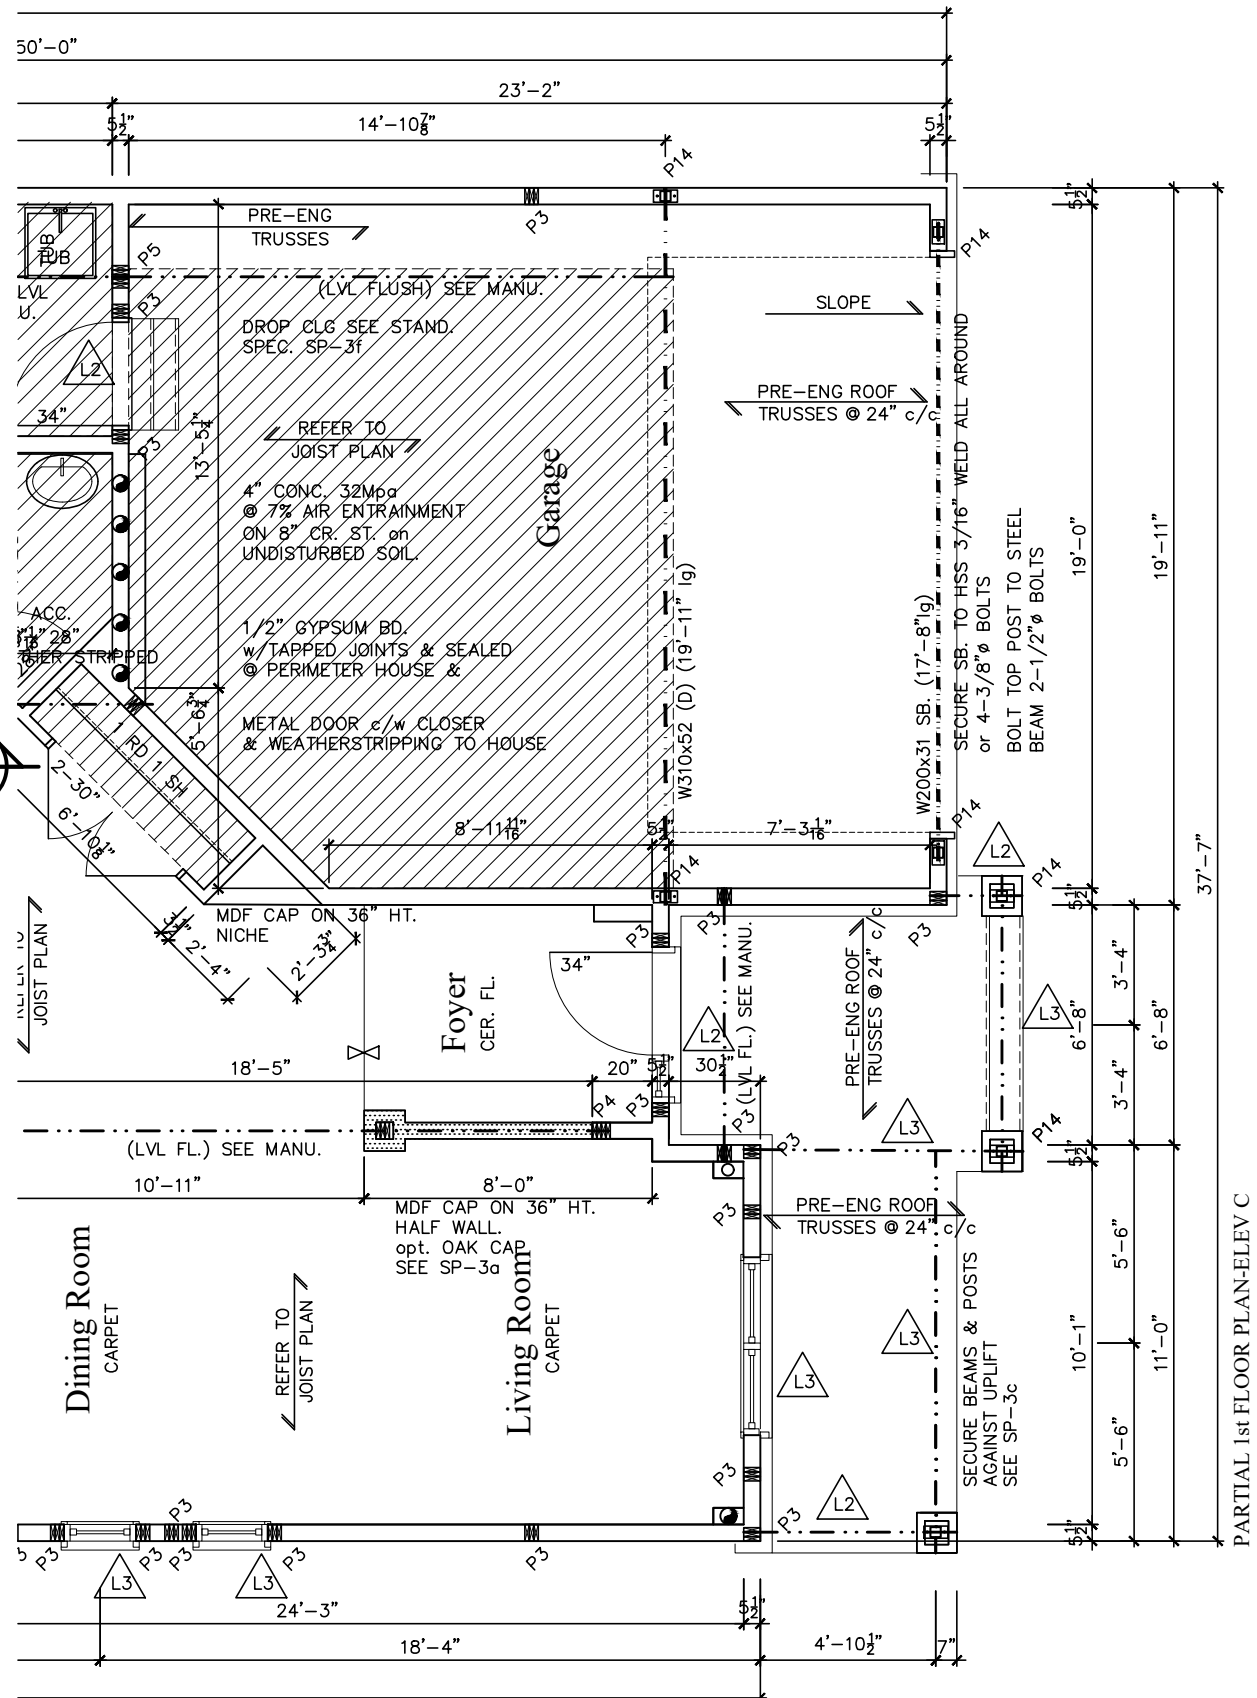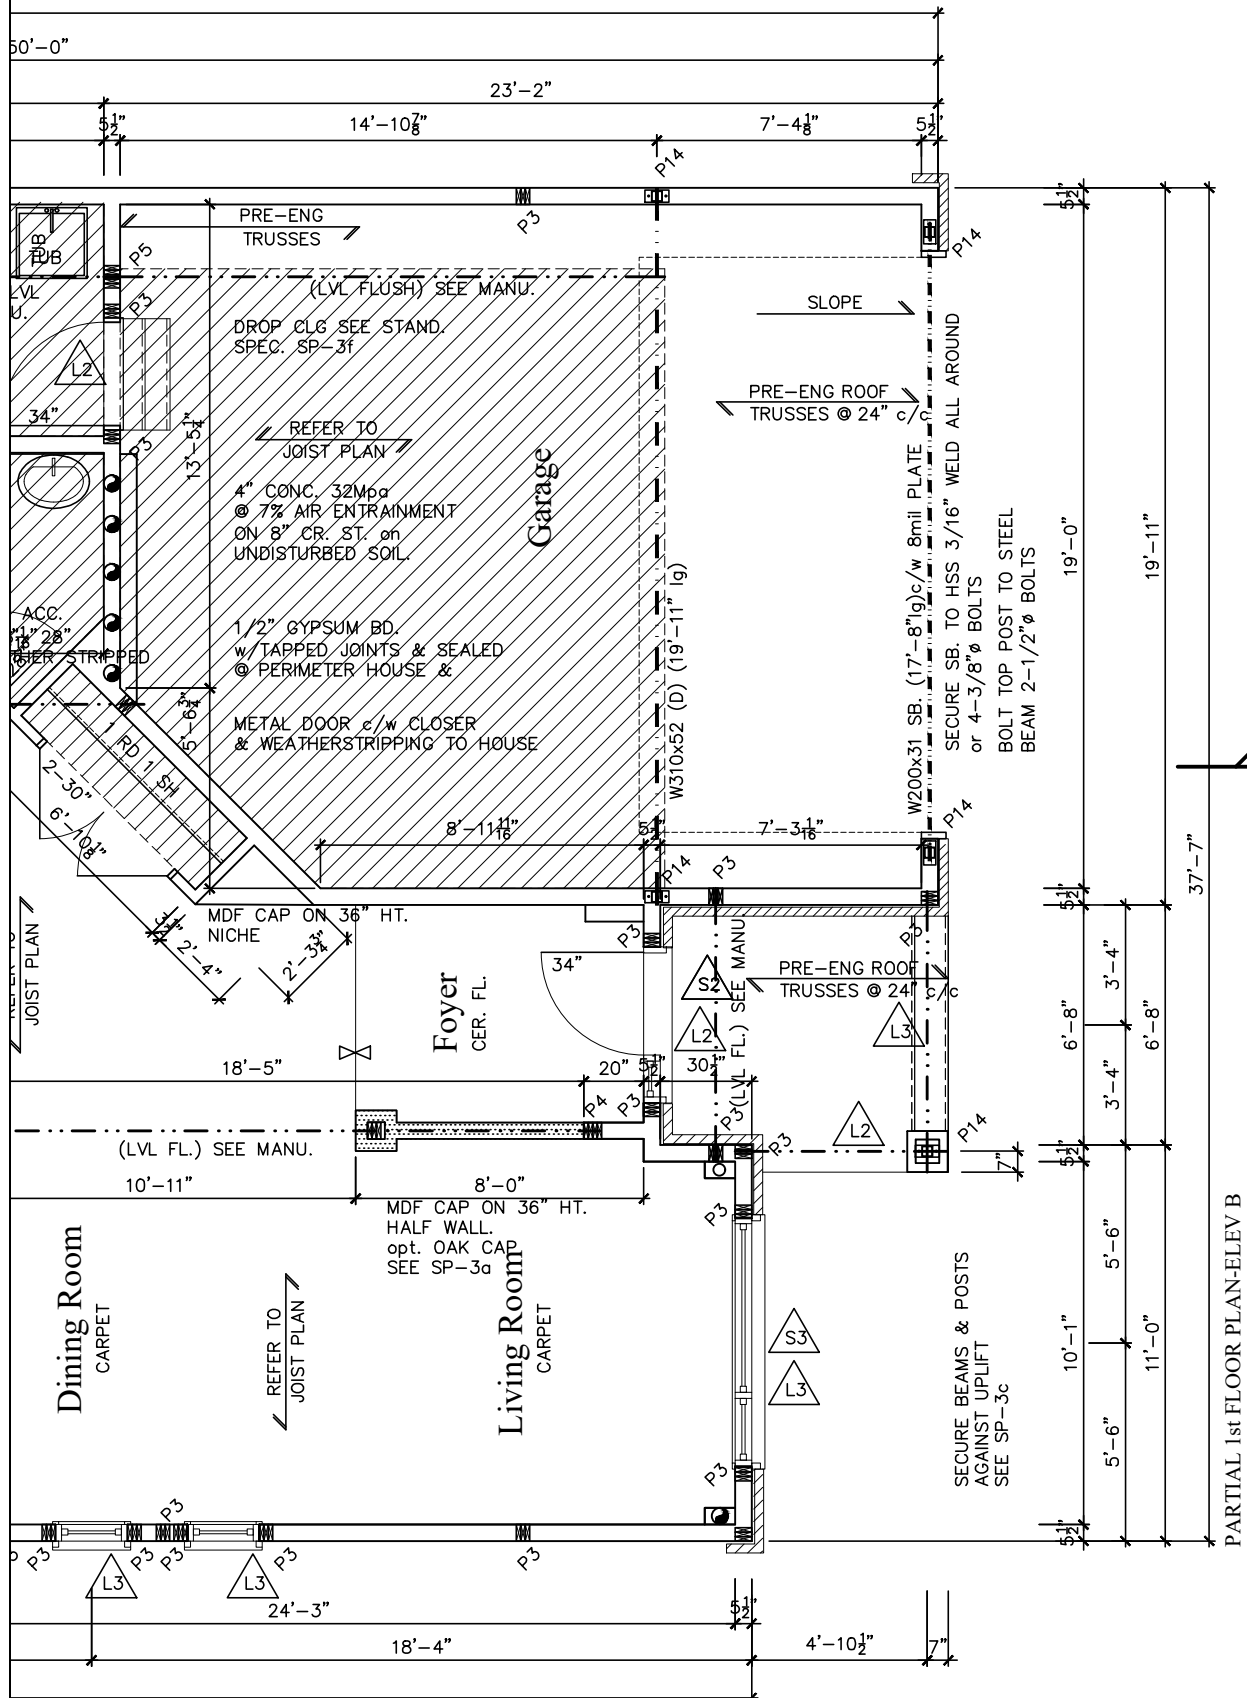


TITLE: 2nd FLOOR PLAN - ELEVATION A	
ACAD FILE:	SCALE: 3/16" = 1'-0"
1086-The Steel 2012 Footprint (STANDARD DRAWINGS)	DWG. A-8

POSTS
P1 - 75# STEEL TELEPOST
P2 - (2)3x8x9 or (2)3x1x40
P3 - (3)3x8x9 or (3)3x1x40
P4 - (4)3x8x9 or (4)3x1x40
P5 - (5)3x8x9 or (5)3x1x40
P6 - (6)3x8x9 or (6)3x1x40
P13 - HSS 88.9x88.9x3.18 + 100x200x12 T&B PL.
(*)
P14 - HSS 89x89x4.8 + 100x200x12 T&B PL.
(*)
P15 - HSS 76.2x76.2x4.78 + 100x180x12 T&B PL.
(*)
P16 - HSS 76.2x76.2x4.78 + 100x130x12 T&B PL.
P17 - HSS 73 O.D. x4.8 + 100x180x12PL B PL.
+ 130x160x10 PL (*)
(*) - 2-12" ANCH (WHERE ANCH PL. NOT USED)
ALL FOOTINGS 600x200 DP. UNLESS NOTED
SOIL: 100 KPA

1086-The Steel 2012 Footprint (STANDARD DRAWINGS)	DWG. A-8b
---	------------------

  

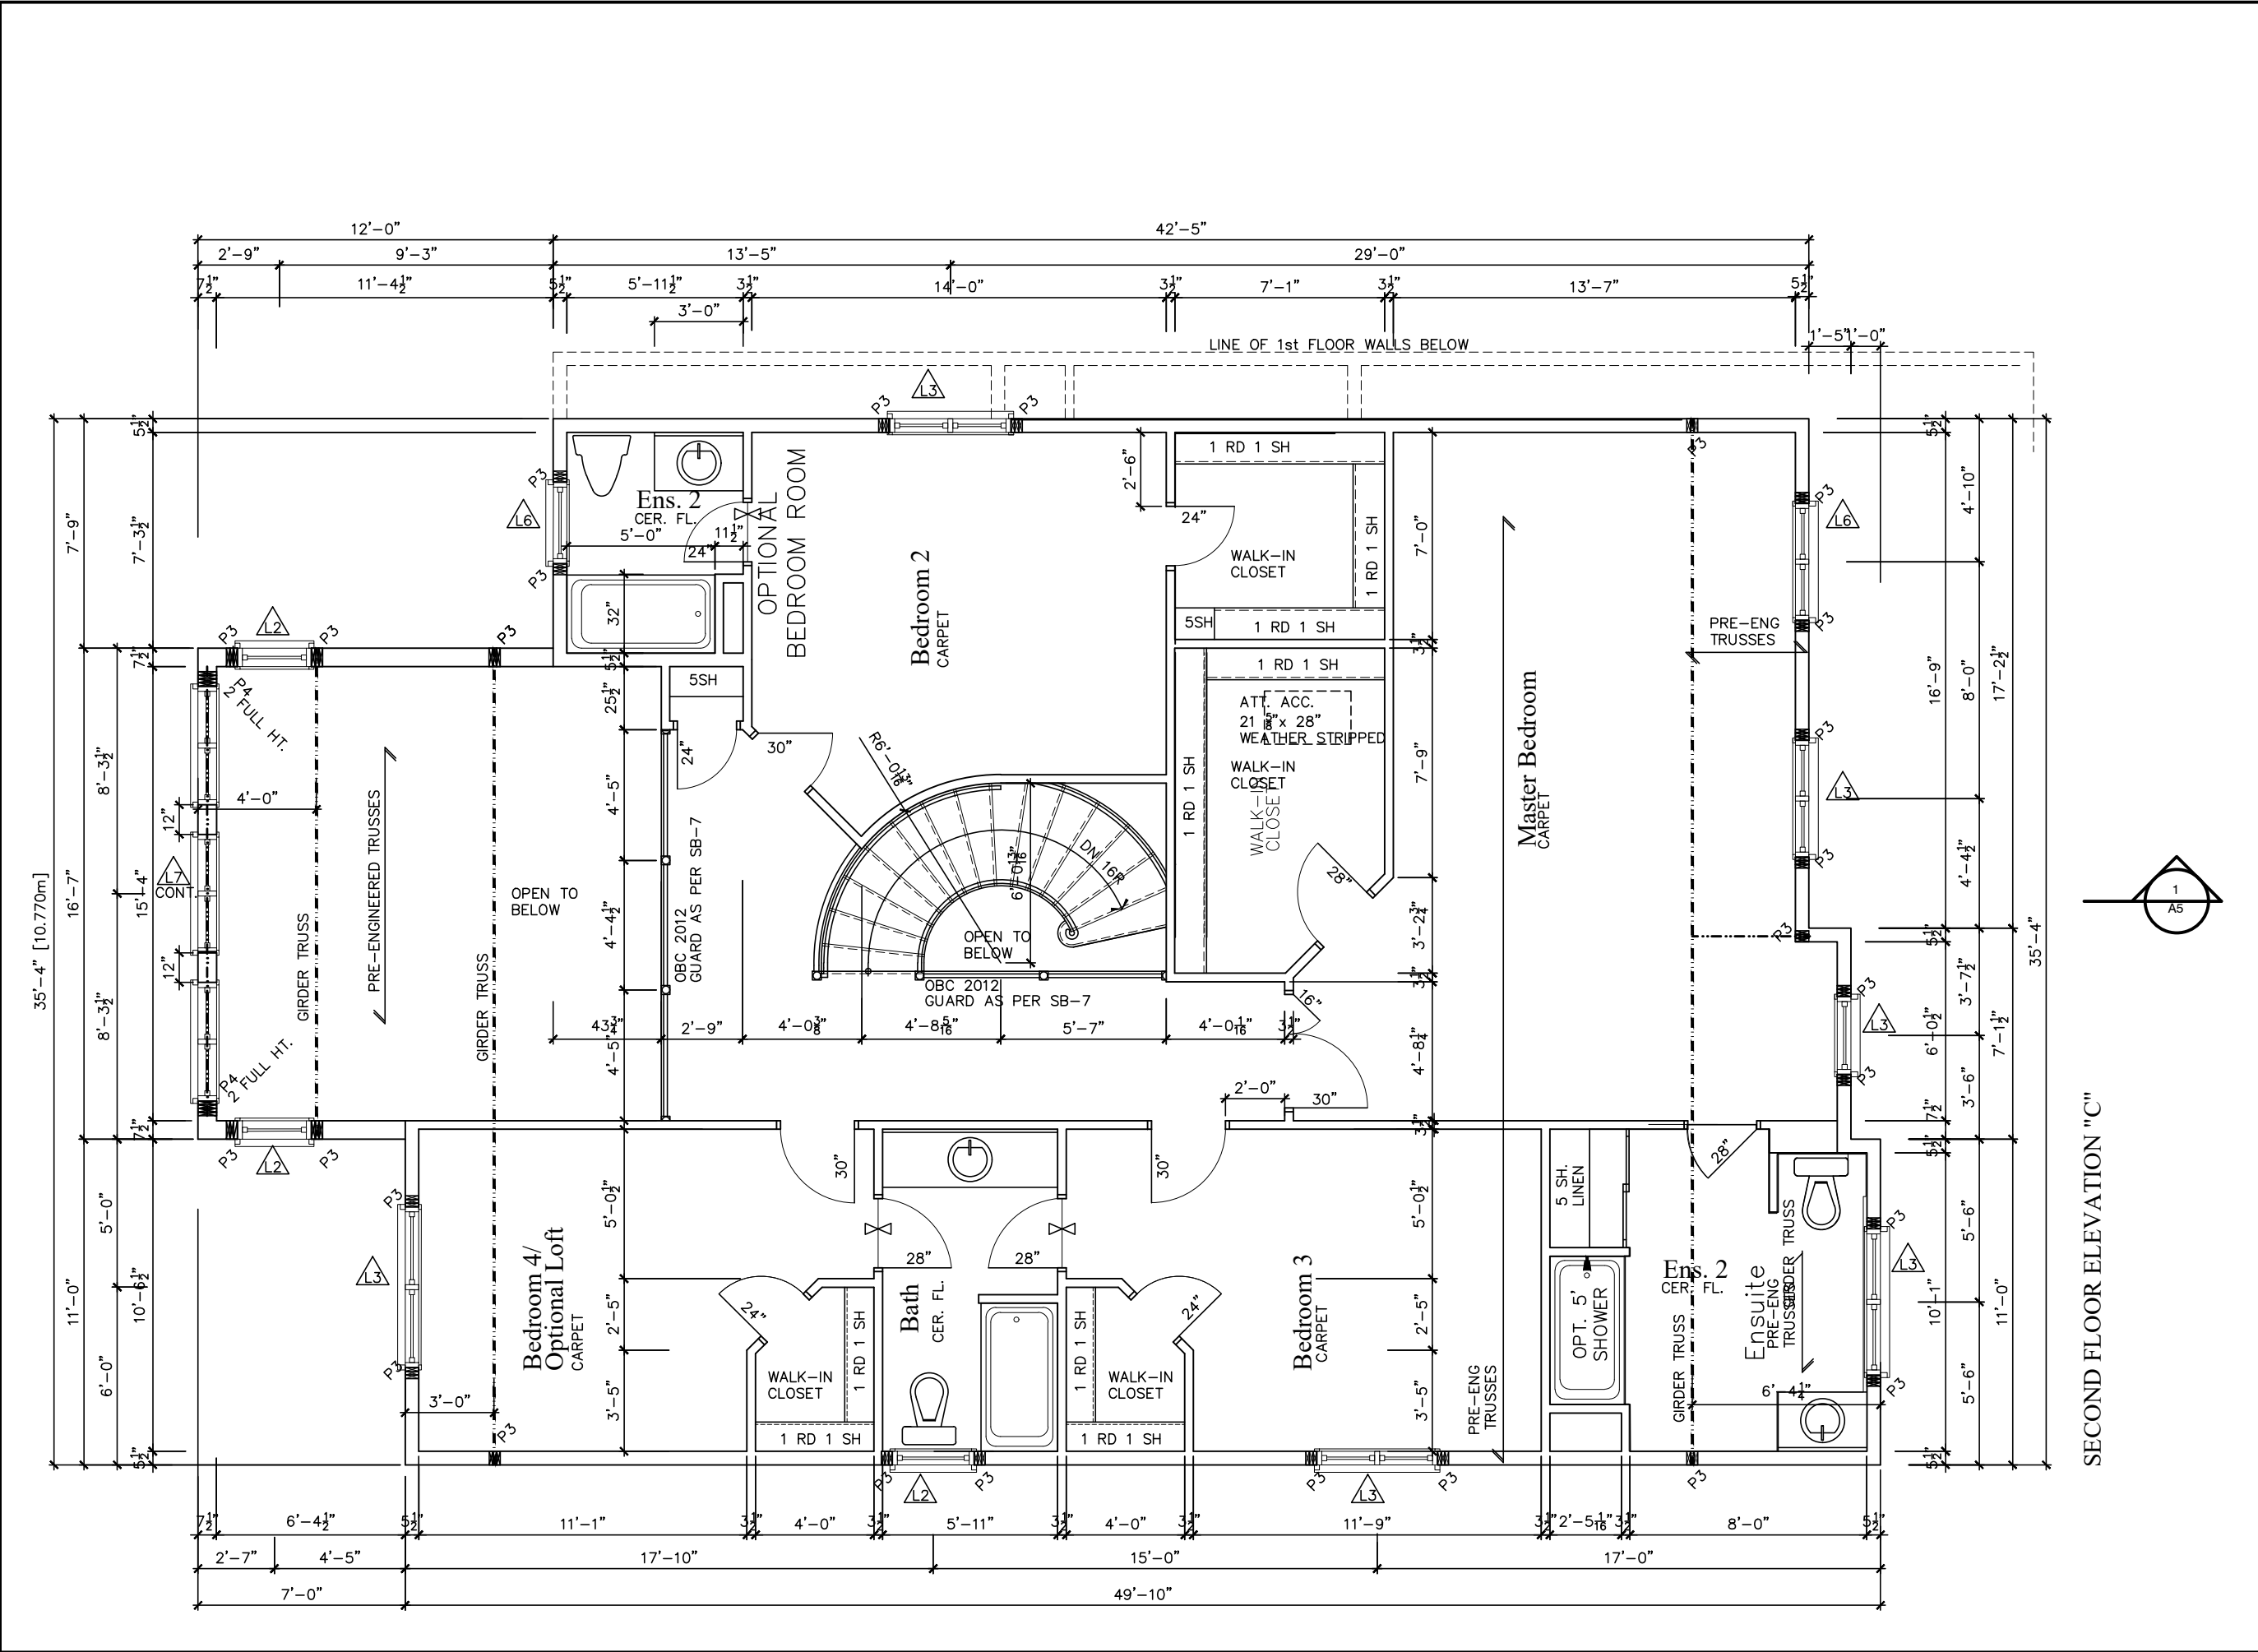

LOT **XXxx**

DATE **XX/XX/XX**

THIS DRAWINGS IS TO BE USED IN CONJUNCTION WITH SCHEDULE B-1A AND MAY SHOW ONLY SOME OF THE CHANGES DETAILED ON THAT DOCUMENT. SHOULD THE DRAWINGS NOT SHOW ALL ITEMS CONTAINED ON A SCHEDULE OR MISS OTHER ITEMS ALTOGETHER, THE SCHEDULE IS CONSIDERED THE GOVERNING DOCUMENT.

TENDER 2017

I **SCOTT IRWIN BCIN 20765** HAVE REVIEWED AND TAKE RESPONSIBILITY FOR DESIGN ACTIVITIES RELATING TO, HOUSE & SMALL BUILDINGS.

STRUCTURAL FRAMING SCHEDULE	
STEEL LINTEL	
S1	- L 90x90x6
S2	- L 90x90x8
S3	- L 100x90x8
S4	- L 125x90x8
S5	- L 125x90x10
S6	- L 200x100x12
S7	- L 150x100x10 (200mm BEARING)
WOOD LINTEL	
L1	(2)38x235 w/ 12.7 PLYWOOD SPACER
L2	(2)38x235
L3	(3)38x235
L4	(3)38x235 w/ 2-12.7 PLYWOOD SPACER
L5	(3)38x286 w/ 2-12.7 PLYWOOD SPACER
	& 2 ROW OF 90mm SPIRAL @ 200 o/c
L6	(3)38x286 w/ 2-12.7 PLYWOOD SPACER
	& 2 ROW OF 90mm SPIRAL @ 200 o/c 2 SIDE
L7	(2)45x240 L.L. 2.0e
L8	(3)45x240 L.L. 2.0e
POSTS	
P1	- 75# STEEL TELEPOST
P2	(2)38x89 or (2)38x140
P3	(3)38x89 or (3)38x140
P4	(4)38x89 or (4)38x140
P5	(5)38x89 or (5)38x140
P6	(6)38x89 or (6)38x140
P13	- HSS 88.9x88.9x3.18 + 100x200x12 T&B PL.
P14	- HSS 89x89x4.8 + 100x200x12 T&B PL.
P15	- HSS 76.2x76.2x4.78 + 100x180x12 T&B PL.
P16	- HSS 76.2x76.2x4.78 + 130x130x12 T&B PL.
P17	- HSS 73 O.D. x4.8 + 100x180x12PL B PL.
	+ 130x160x10 T PL. (*)
(*) - 2-12# ANCH (WHERE ANCH PL. NOT USED)	
ALL FOOTINGS 600x200 DP. UNLESS NOTED	
SOIL: 100 KPA	

2012 OBC DRAWINGS



AS PER STRUCTURAL		
STANDARD DRAWINGS	02/11/15	SI
NO DESCRIPTION	DATE	BY

TITLE:
2nd FLOOR PLAN - ELEVATION C

ACAD FILE:	SCALE: 3/16" = 1'-0"
1086-The Steel 2012 Footprint (STANDARD DRAWINGS)	DWG. A-8c

2012 OBC DRAWINGS			
	AS PER STRUCTURAL		
	STANDARD DRAWINGS	02/11/15	SI
NO	DESCRIPTION	DATE	BY
 Valecraft Homes Ltd.			
TITLE: PARTIAL 2nd FLOOR PLAN - 4pc ENSUITE			
ACAD FILE:		SCALE: 3/16" = 1'-0"	
1086-The Steel 2012 Footprint (STANDARD DRAWINGS)		DWG. A-8d	

  I SCOTT IRWIN BCIN 20765 HAVE REVIEWED AND TAKE
RESPONSIBILITY FOR DESIGN ACTIVITIES RELATING TO,
HOUSE & SMALL BUILDINGS_____.

[illegible]

ACAD FILE:	SCALE: 3/16" = 1'-0"
------------	-------------------------


1086-The Steel 2012 Footprint (STANDARD DRAWINGS)	DWG. J-2
---	-----------------

DATE XX/XX/XX

THIS DRAWING IS TO BE USED IN CONJUNCTION WITH SCHEDULE B-1A AND MAY SHOW ONLY SOME OF THE CHANGES DETAILED ON THAT DOCUMENT. SHOULD THE DRAWINGS NOT SHOW ALL ITEMS CONTAINED ON A SCHEDULE OR MISS OTHER ITEMS ALTOGETHER, THE SCHEDULE IS CONSIDERED THE GOVERNING DOCUMENT.

I SCOTT IRWIN BCIN 20765 HAVE REVIEWED AND TAKE
RESPONSIBILITY FOR DESIGN ACTIVITIES RELATING TO,
HOUSE & SMALL BUILDINGS _____.

TENDER 2017

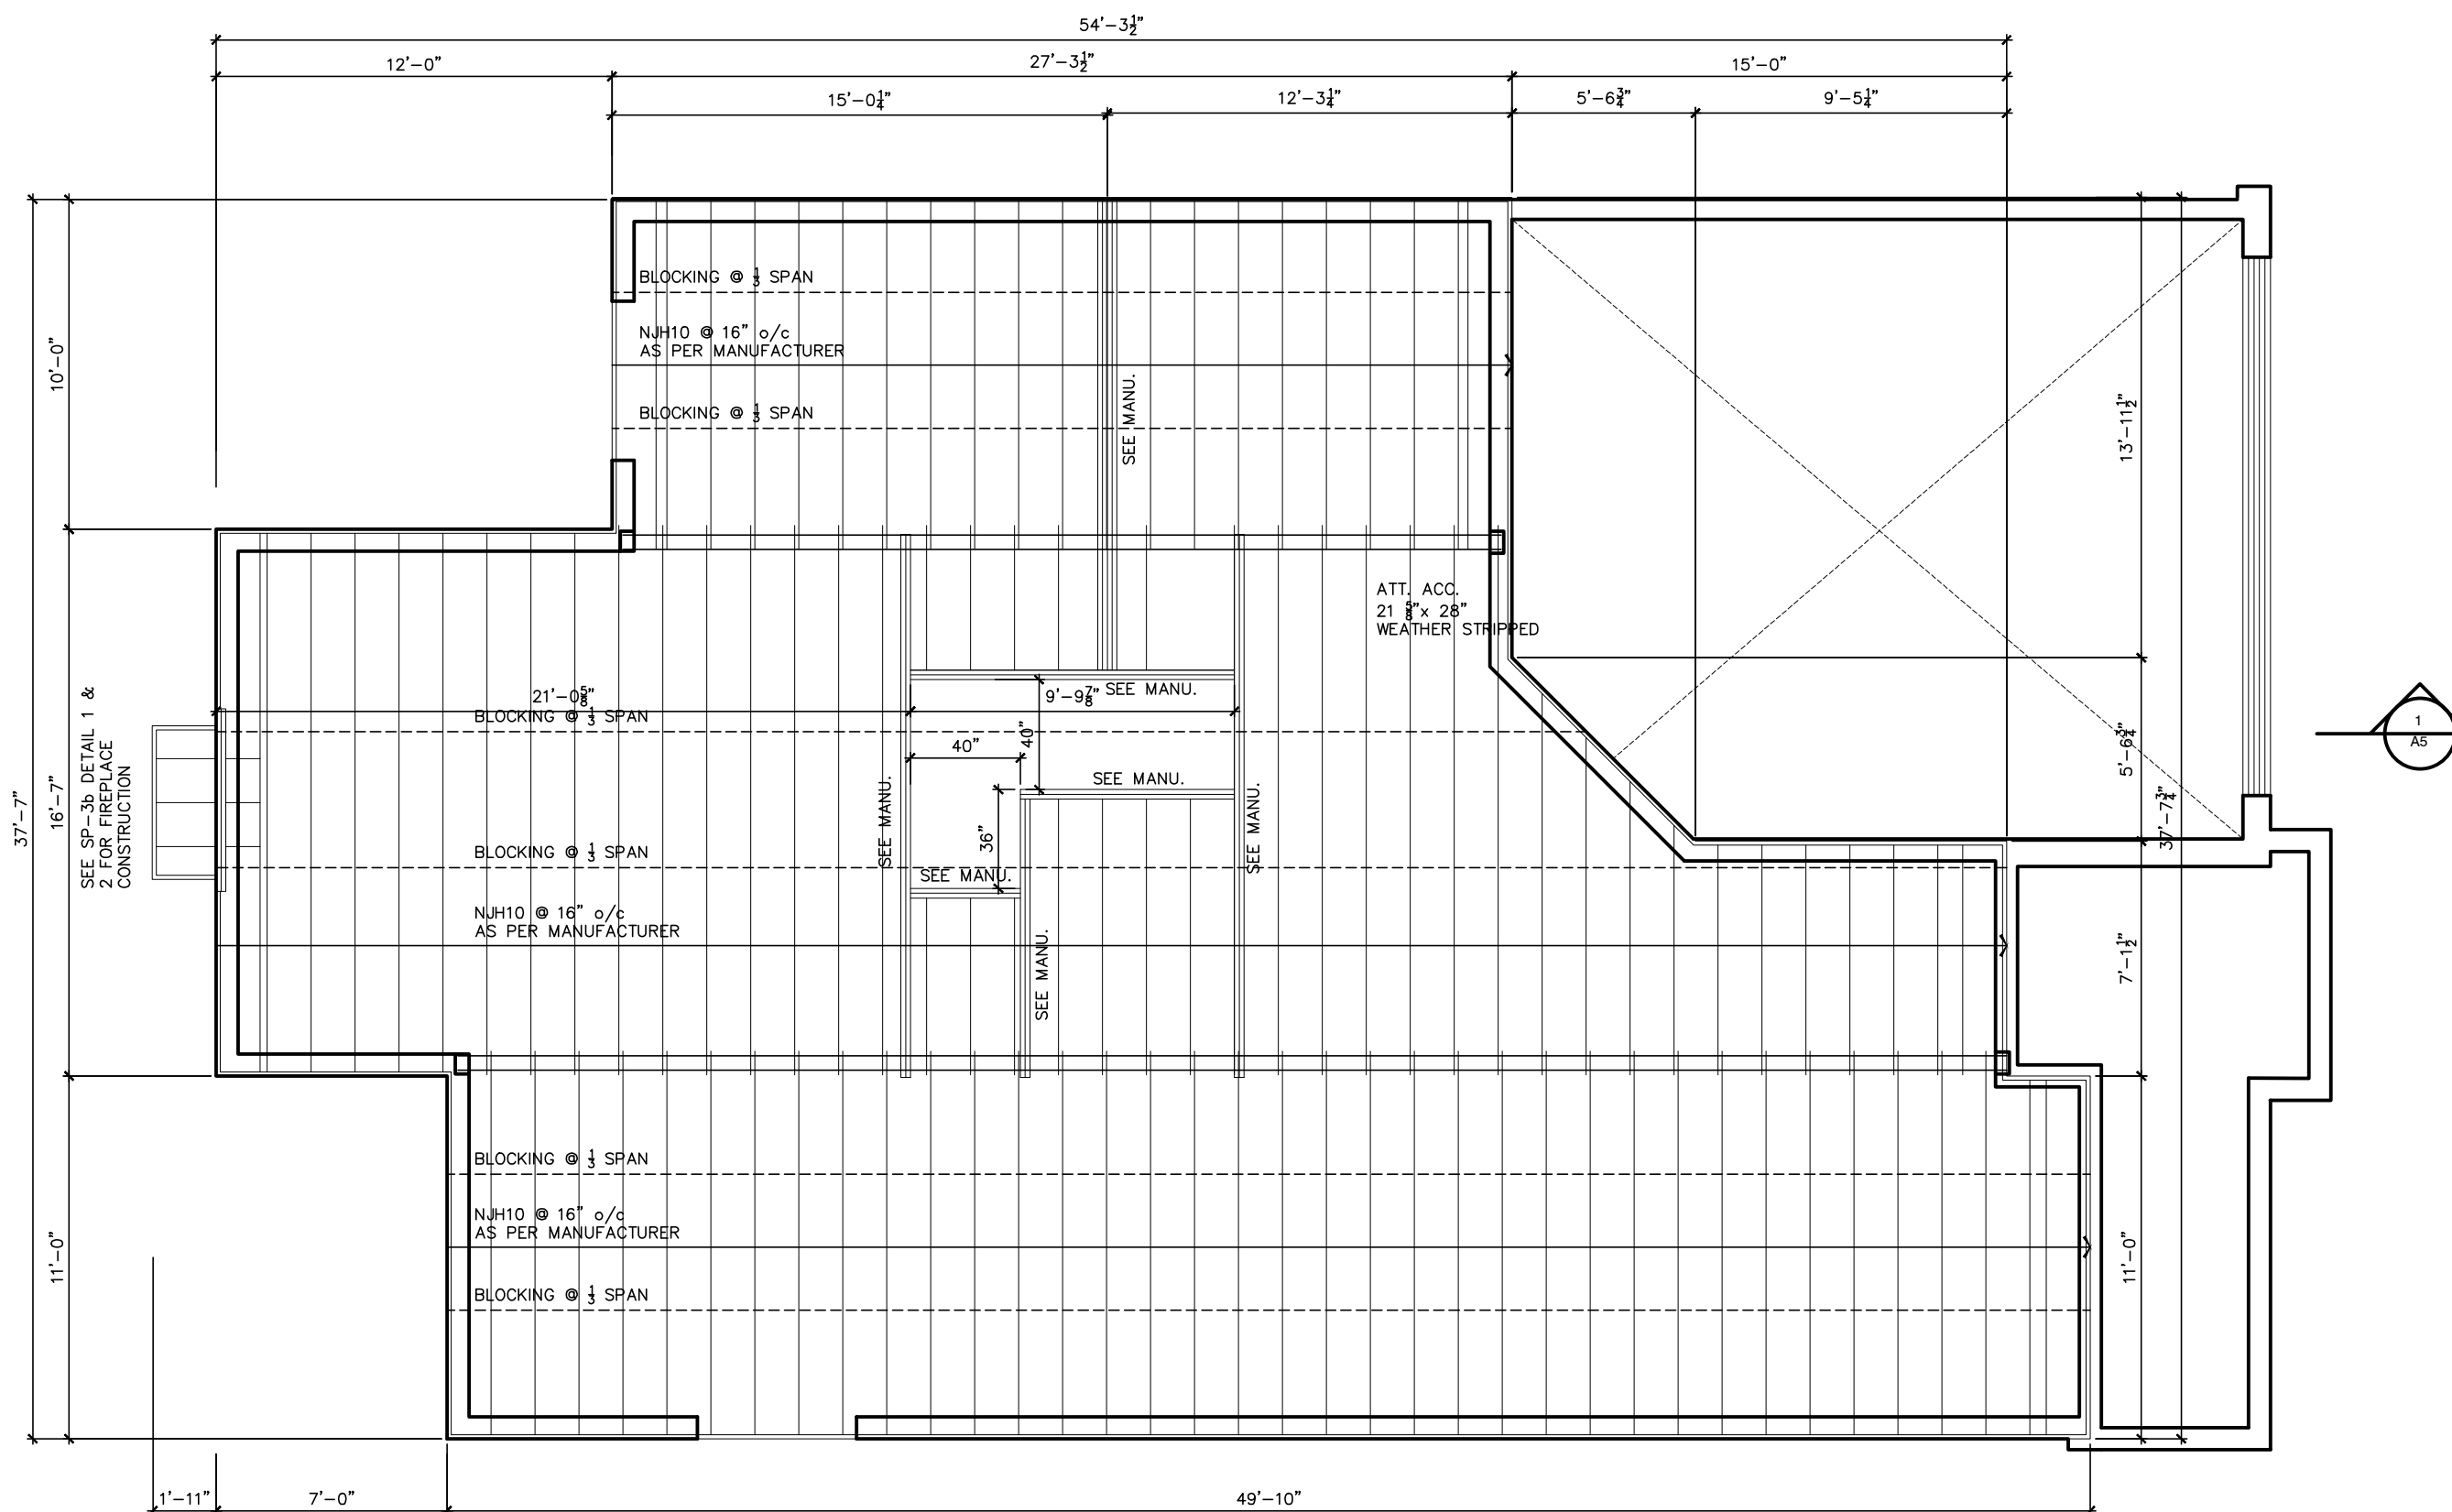

2012 OBC DRAWINGS

[illegible]

TITLE: 1st Floor Joist Plan

ACAD FILE:	SCALE: 3/16" = 1'-0"
------------	-------------------------

1086-The Steel 2012 Footprint (STANDARD DRAWINGS)	DWG. J-1
---	-----------------

THIS DRAWING IS TO BE USED IN CONJUNCTION WITH SCHEDULE B-1A AND MAY SHOW ONLY SOME OF THE CHANGES DETAILED ON THAT DOCUMENT. SHOULD THE DRAWINGS NOT SHOW ALL ITEMS CONTAINED ON A SCHEDULE OR MISS OTHER ITEMS ALTOGETHER, THE SCHEDULE IS CONSIDERED THE GOVERNING DOCUMENT.

TENDER 2017

I SCOTT IRWIN BCIN 20765 HAVE REVIEWED AND TAKE
RESPONSIBILITY FOR DESIGN ACTIVITIES RELATING TO,
HOUSE & SMALL BUILDINGS_____.

ELECTRICAL SYMBOLS

- | | |
|---|---|
|  | Duplex Outlet (G.F.I. in all bathrooms) |
|  | 220 V Outlet |
|  | Duplex Outlet (Upper half switched) |
|  | Split Duplex Outlet |
|  | Weather proof Duplex Outlet |
|  | Single pole switch |
|  | 3 way switch |
|  | Double gang switch |
|  | Triple gang switch |
|  | Double gang 3 way switch |
|  | 4 way switch |
|  | Furnace switch |
|  | Ceiling light fixture |
|  | Standard pot light |
|  | Wall mounted light fixture |
|  | Carbon Monoxide detector |
| | interconnected with smoke alarms |
|  | Carbon Monoxide detector |
| | interconnected with smoke alarms |
|  | Electrical panel |
|  | Mechanical vent |
|  | Dryer |
|  | Washer |
|  | Thermostat |
|  | Standard telephone jack |
|  | Cable television outlet. |
|  | Central vacuum location (Optional) |
|  | Ceiling light fixture |
|  | Pull Chain |

2012 OBC DRAWINGS


2.	AS PER STRUCTURAL		
1.	STANDARD DRAWINGS	02/11/15	SI
NO	DESCRIPTION	DATE	BY



TITLE: 1st Floor Electrical Plan

ACAD FILE:	SCALE: 3/16" = 1'-0"
------------	-------------------------

1086-The Steel 2012 Footprint (STANDARD DRAWINGS)	DWG. E-2
---	-----------------

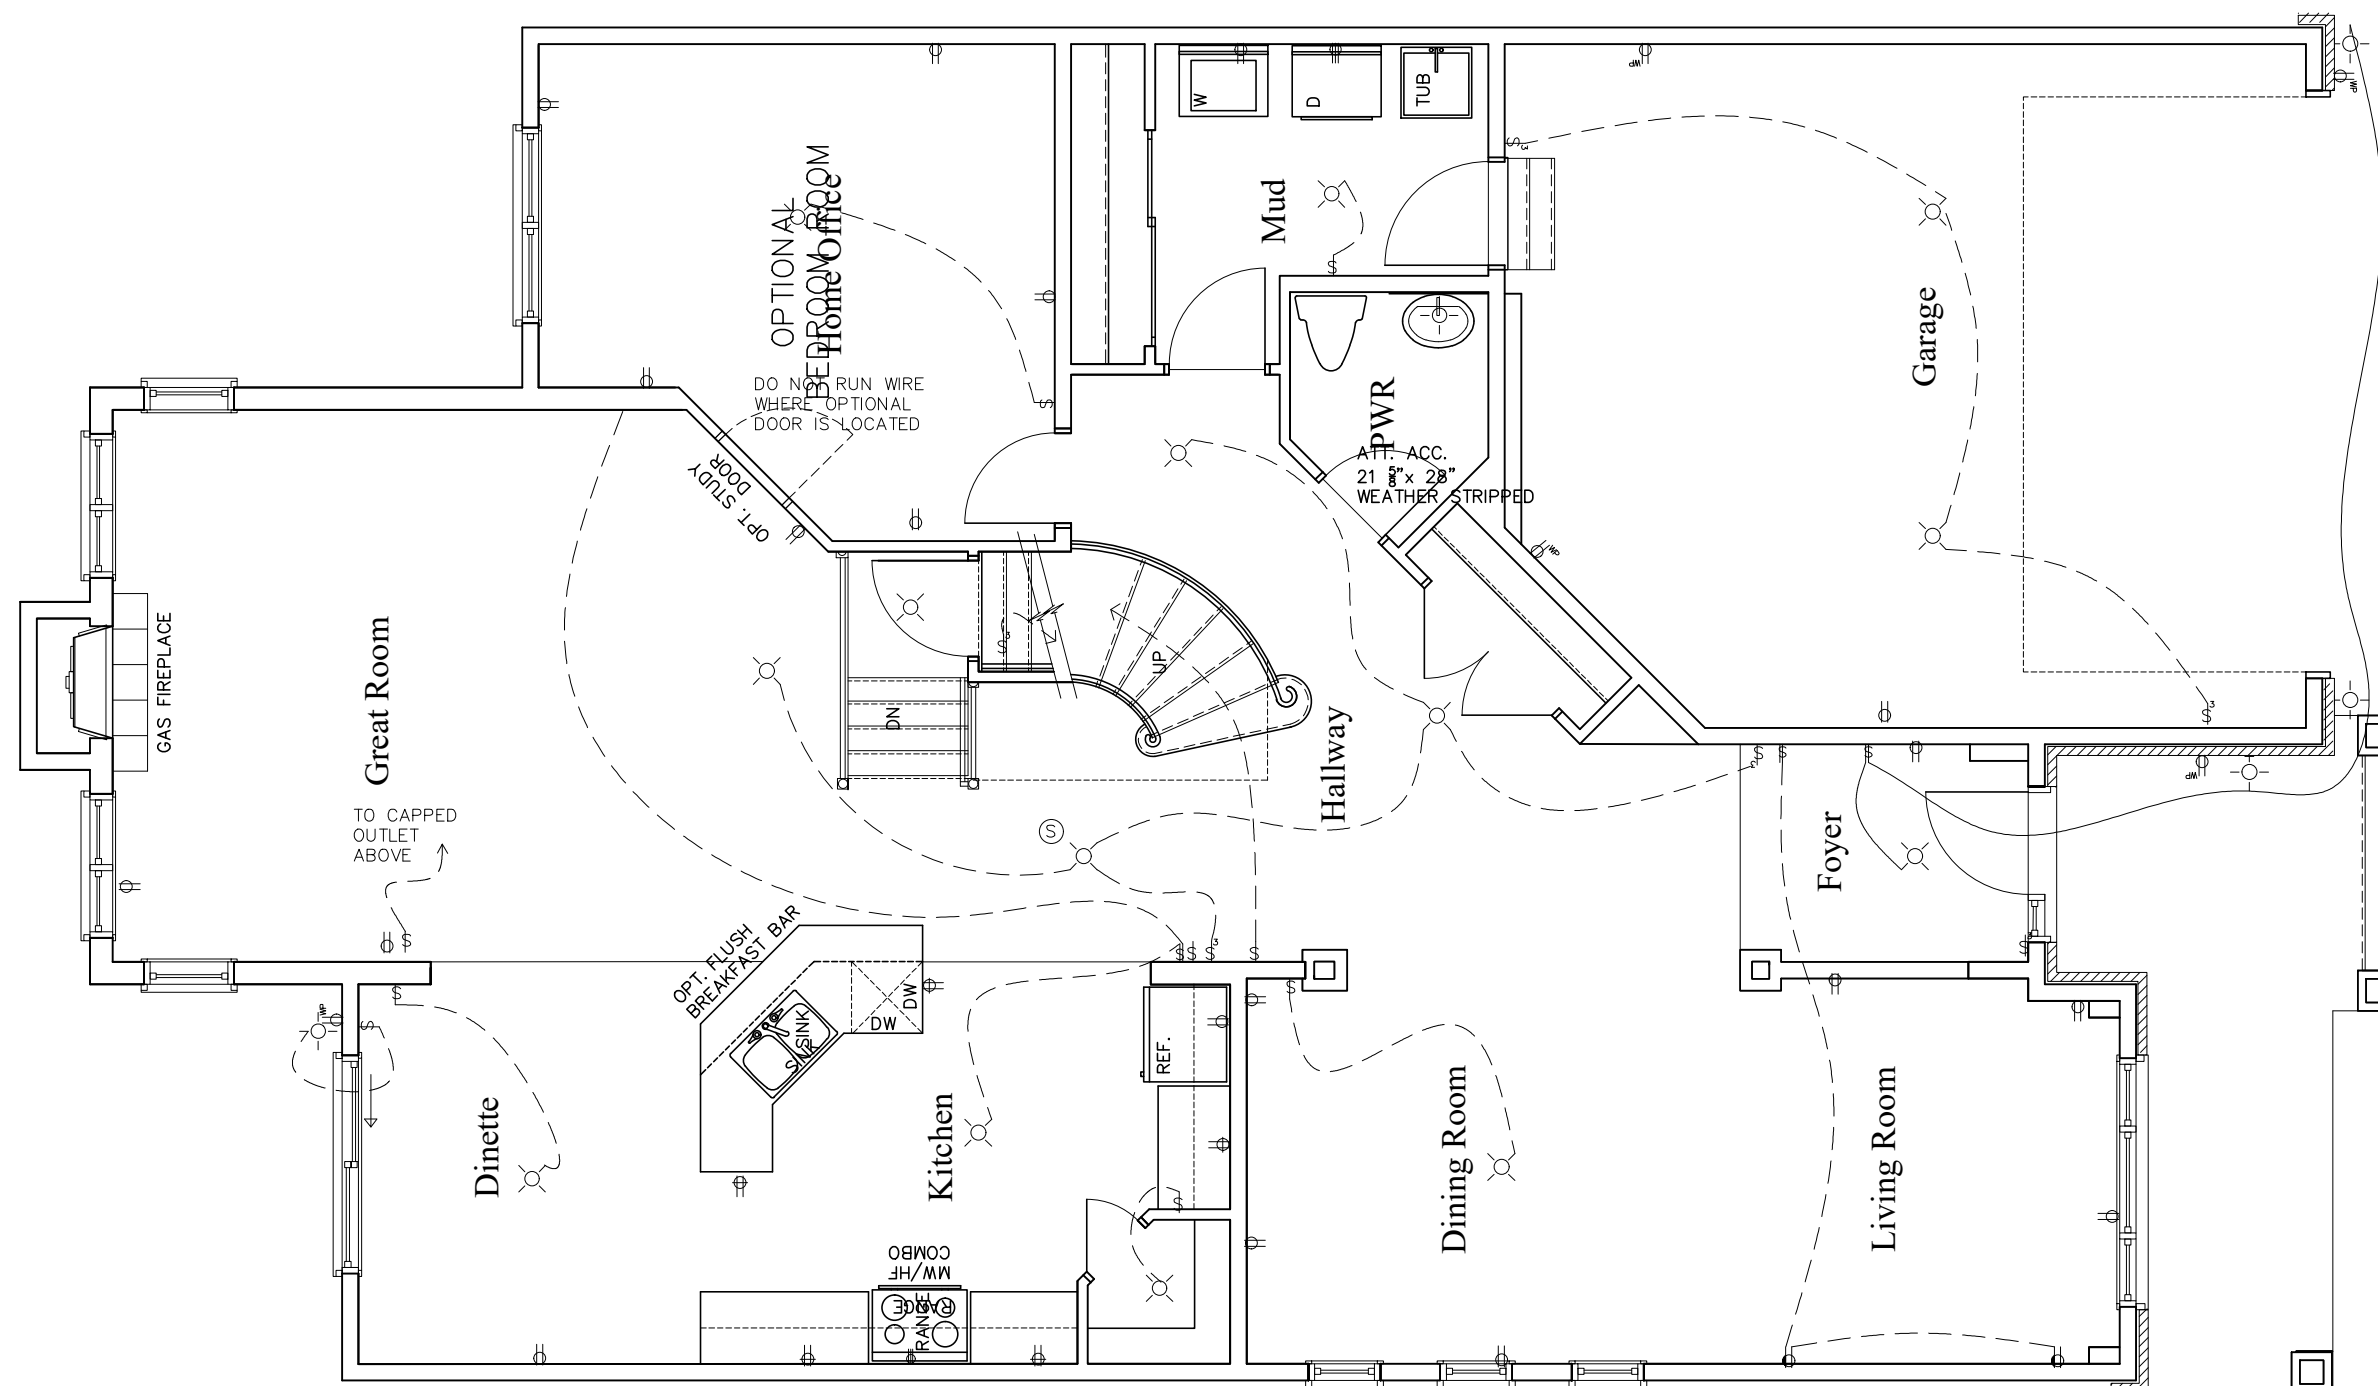

- | | | | |
|---|---|---|--|
|  | Duplex Outlet (G.F.I. in all bathrooms) |  | Wall mounted light fixture |
|  | 220 V Outlet |  | Carbon Monoxide detector
interconnected with smoke alarms |
|  | Duplex Outlet (Upper half switched) |  | Carbon Monoxide detector
interconnected with smoke alarms |
|  | Split Duplex Outlet |  | Electrical panel |
|  | Weather proof Duplex Outlet |  | Mechanical vent |
|  | Single pole switch |  | Dryer |
|  | 3 way switch |  | Washer |
|  | Double gang switch |  | Thermostat |
|  | Triple gang switch |  | Standard telephone jack |
|  | Double gang 3 way switch |  | Cable television outlet. |
|  | 4 way switch |  | Central vacuum location (Optional) |
|  | Furnace switch |  | Ceiling light fixture |
|  | Ceiling light fixture |  | Pull Chain |
|  | Standard pot light | | |



- | | |
|---|--|
|  | Duplex Outlet (G.F.I. in all bathrooms) |
|  | 220 V Outlet |
|  | Duplex Outlet (Upper half switched) |
|  | Split Duplex Outlet |
|  | Weather proof Duplex Outlet |
|  | Single pole switch |
|  | 3 way switch |
|  | Double gang switch |
|  | Triple gang switch |
|  | Double gang 3 way switch |
|  | 4 way switch |
|  | Furnace switch |
|  | Ceiling light fixture |
|  | Standard pot light |
|  | Wall mounted light fixture |
|  | Carbon Monoxide detector
interconnected with smoke alarms |
|  | Carbon Monoxide detector
interconnected with smoke alarms |
|  | Electrical panel |
|  | Mechanical vent |
|  | Dryer |
|  | Washer |
|  | Thermostat |
|  | Standard telephone jack |
|  | Cable television outlet. |
|  | Central vacuum location (Optional) |
|  | Ceiling light fixture |
|  | Pull Chain |

- | | | | |
|---|---|---|---|
|  | Duplex Outlet (G.F.I. in all bathrooms) |  | Wall mounted light fixture |
|  | 220 V Outlet |  | Carbon Monoxide detector interconnected with smoke alarms |
|  | Duplex Outlet (Upper half switched) |  | Carbon Monoxide detector interconnected with smoke alarms |
|  | Split Duplex Outlet |  | Electrical panel |
|  | Weather proof Duplex Outlet |  | Mechanical vent |
|  | Single pole switch |  | Dryer |
|  | 3 way switch |  | Washer |
|  | Double gang switch |  | Thermostat |
|  | Triple gang switch |  | Standard telephone jack |
|  | Double gang 3 way switch |  | Cable television outlet. |
|  | 4 way switch |  | Central vacuum location (Optional) |
|  | Furnace switch |  | Ceiling light fixture |
|  | Ceiling light fixture |  | Pull Chain |
|  | Standard pot light | | |

2012 OBC DRAWINGS			
	AS PER STRUCTURAL		
	STANDARD DRAWINGS	02/11/15	SI
NO	DESCRIPTION	DATE	BY



Valecraft

Home Ltd.

TITLE:

2nd Floor Electrical Plan

ACAD FILE:

1086-The Steel
2012 Blueprint

(STANDARD DRAWINGS)

SCALE:
3/16" = 1'-0"

DWG.

E-3